
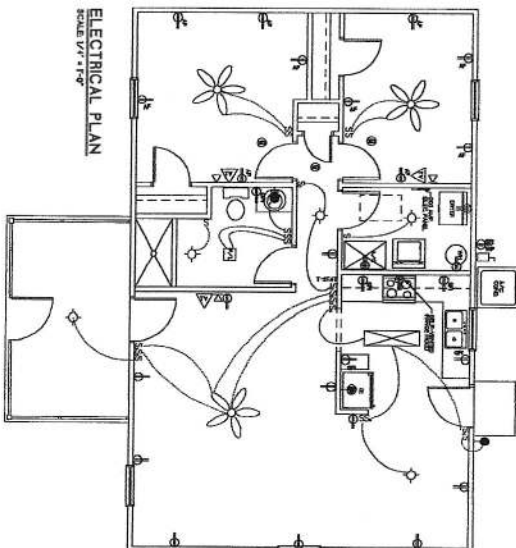
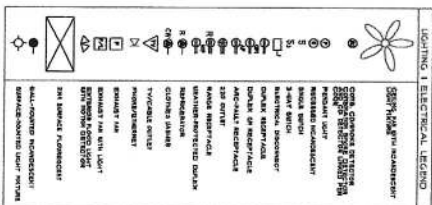
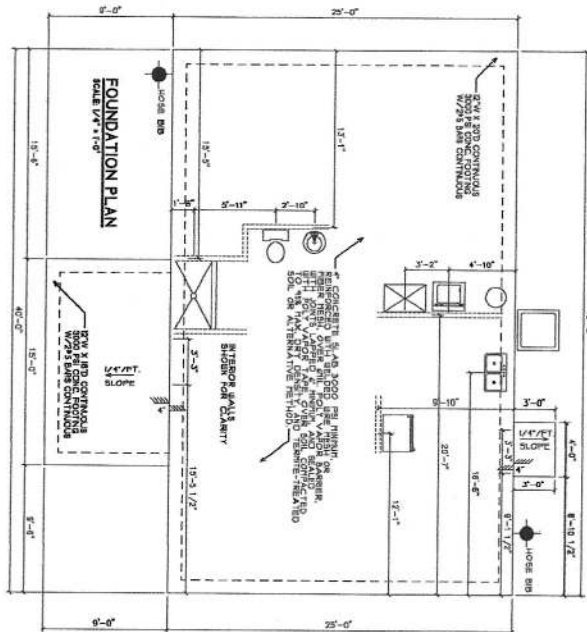


Virginia B. May
Willie modest
Dan Cannon Jr.

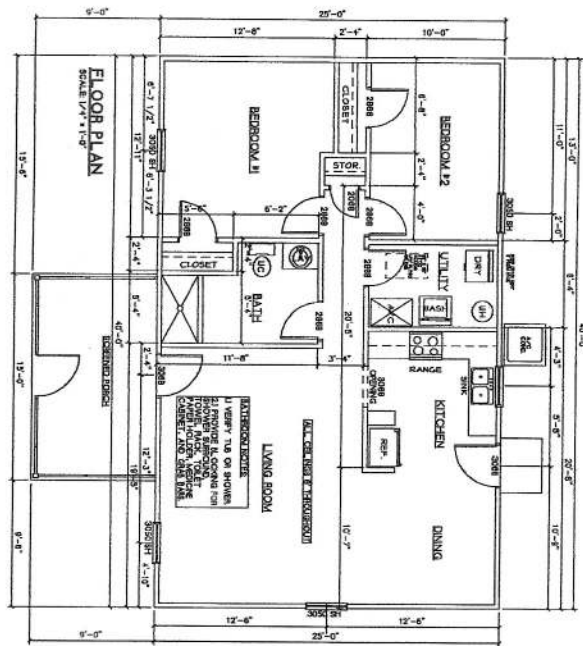

CUSTOMER NAME:

FLA HOMES, INC. R/C

13919 NW 145TH AVENUE, ALACHUA, FLORIDA 32515
(386) 416-4063 flahome@aol.com LICENSE #: CGC 052065

REVISION DATE

JUNE 29, 2020

SUBDIVISION

LOT#

PAGE CONTENT:

**FLOOR PLAN
ELECTRICAL PLAN
FOUNDATION PLAN
KITCHEN CABINET LAYOUT**

PLAN NAME:
Bay V Model

SCALE: 1/4" = 1'-0"
UNLESS OTHERWISE

AREA SUMMARY

HIC:

FRONT PORCH:

© 2000 Blackwell Science Ltd

[illegible]

CUSTOMER NAME:

FLA HOMES, INC. R/C

12919 NW 145TH AVENUE, ALACHUA, FLORIDA 32015
(904) 919-6833
Sales@flahomes.com
LICENSE # CFC 002022


PAGE CONTINUED:
WALL SECTION
ROOF PLAN

PLAN NAME:
Bay V Model
SCALE: 1/4" = 1'-0"
SHEET NUMBER:
2 of 2


AREA SUMMARY	1000
FINISH PORCH	105
TOTAL	1105

FOR MORE INFORMATION:
THIS DRAWING IS THE PROPERTY OF FLA HOMES, INC. AND IS NOT TO BE REPRODUCED OR TRANSMITTED IN ANY FORM OR BY ANY MEANS, ELECTRONIC OR MECHANICAL, WITHOUT PERMISSION IN WRITING FROM FLA HOMES, INC.
THIS DRAWING IS THE PROPERTY OF FLA HOMES, INC. AND IS NOT TO BE REPRODUCED OR TRANSMITTED IN ANY FORM OR BY ANY MEANS, ELECTRONIC OR MECHANICAL, WITHOUT PERMISSION IN WRITING FROM FLA HOMES, INC.


REVISION DATE	JUNE 29, 2025
SUBVISION	
LOT #	
REVISION	
DATE	
BY	
CHKD	
APP'D	

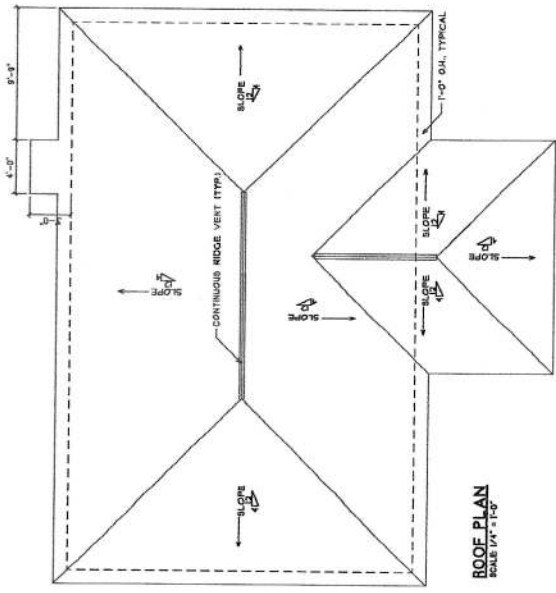


ROOF PLAN
SCALE 1/4" = 1'-0"

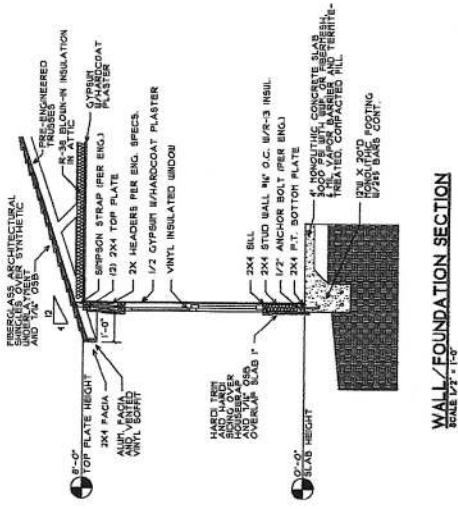


WALL / FOUNDATION SECTION
SCALE 1/4" = 1'-0"

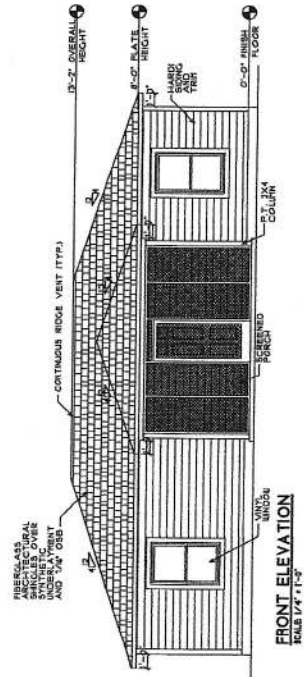


FRONT ELEVATION
SCALE 1/4" = 1'-0"

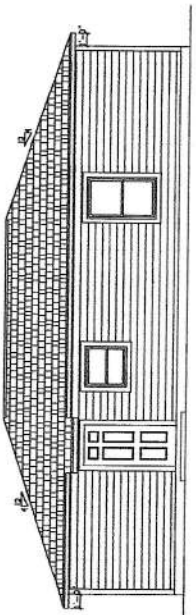

REAR ELEVATION
SCALE 1/4" = 1'-0"

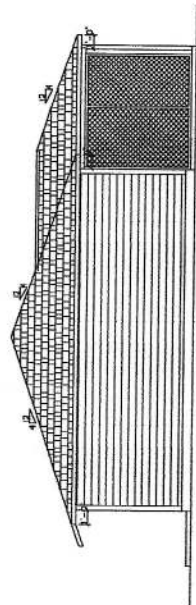

LEFT ELEVATION
SCALE 1/4" = 1'-0"

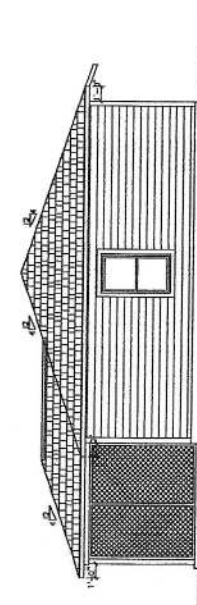

RIGHT ELEVATION
SCALE 1/4" = 1'-0"