



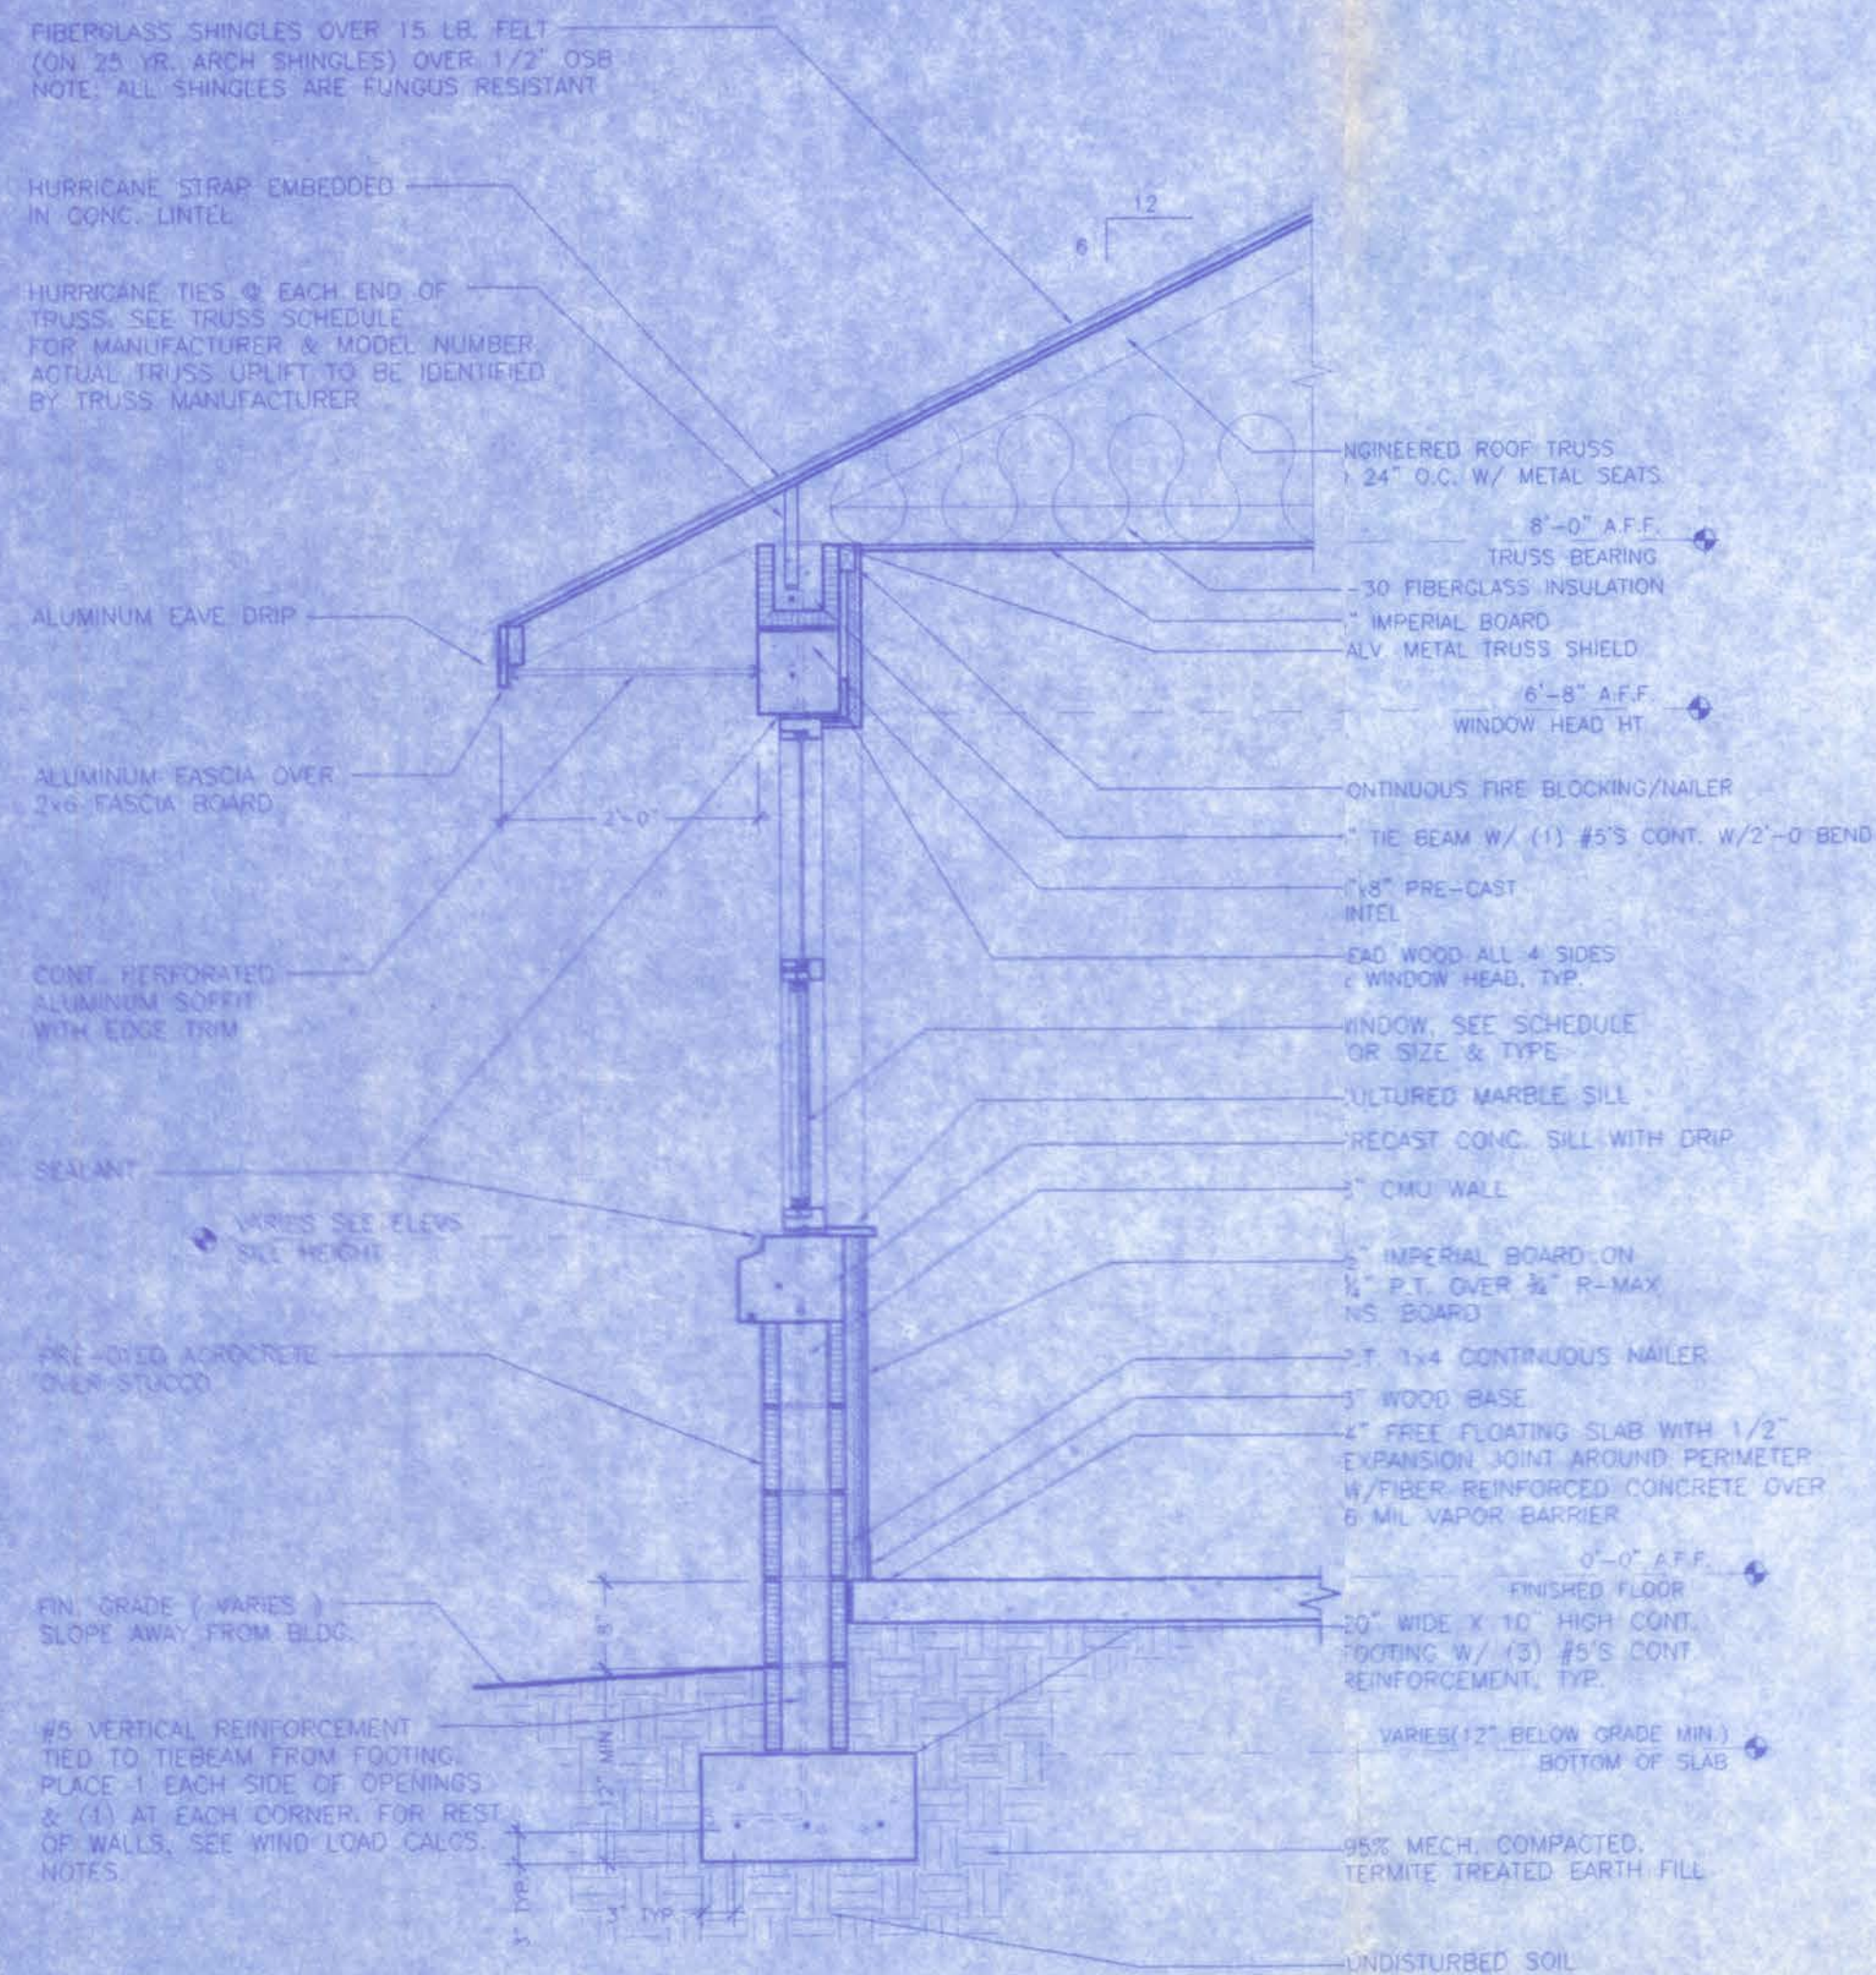

TYPICAL WALL SECTION

SCALE: 3/4"=1'-0"

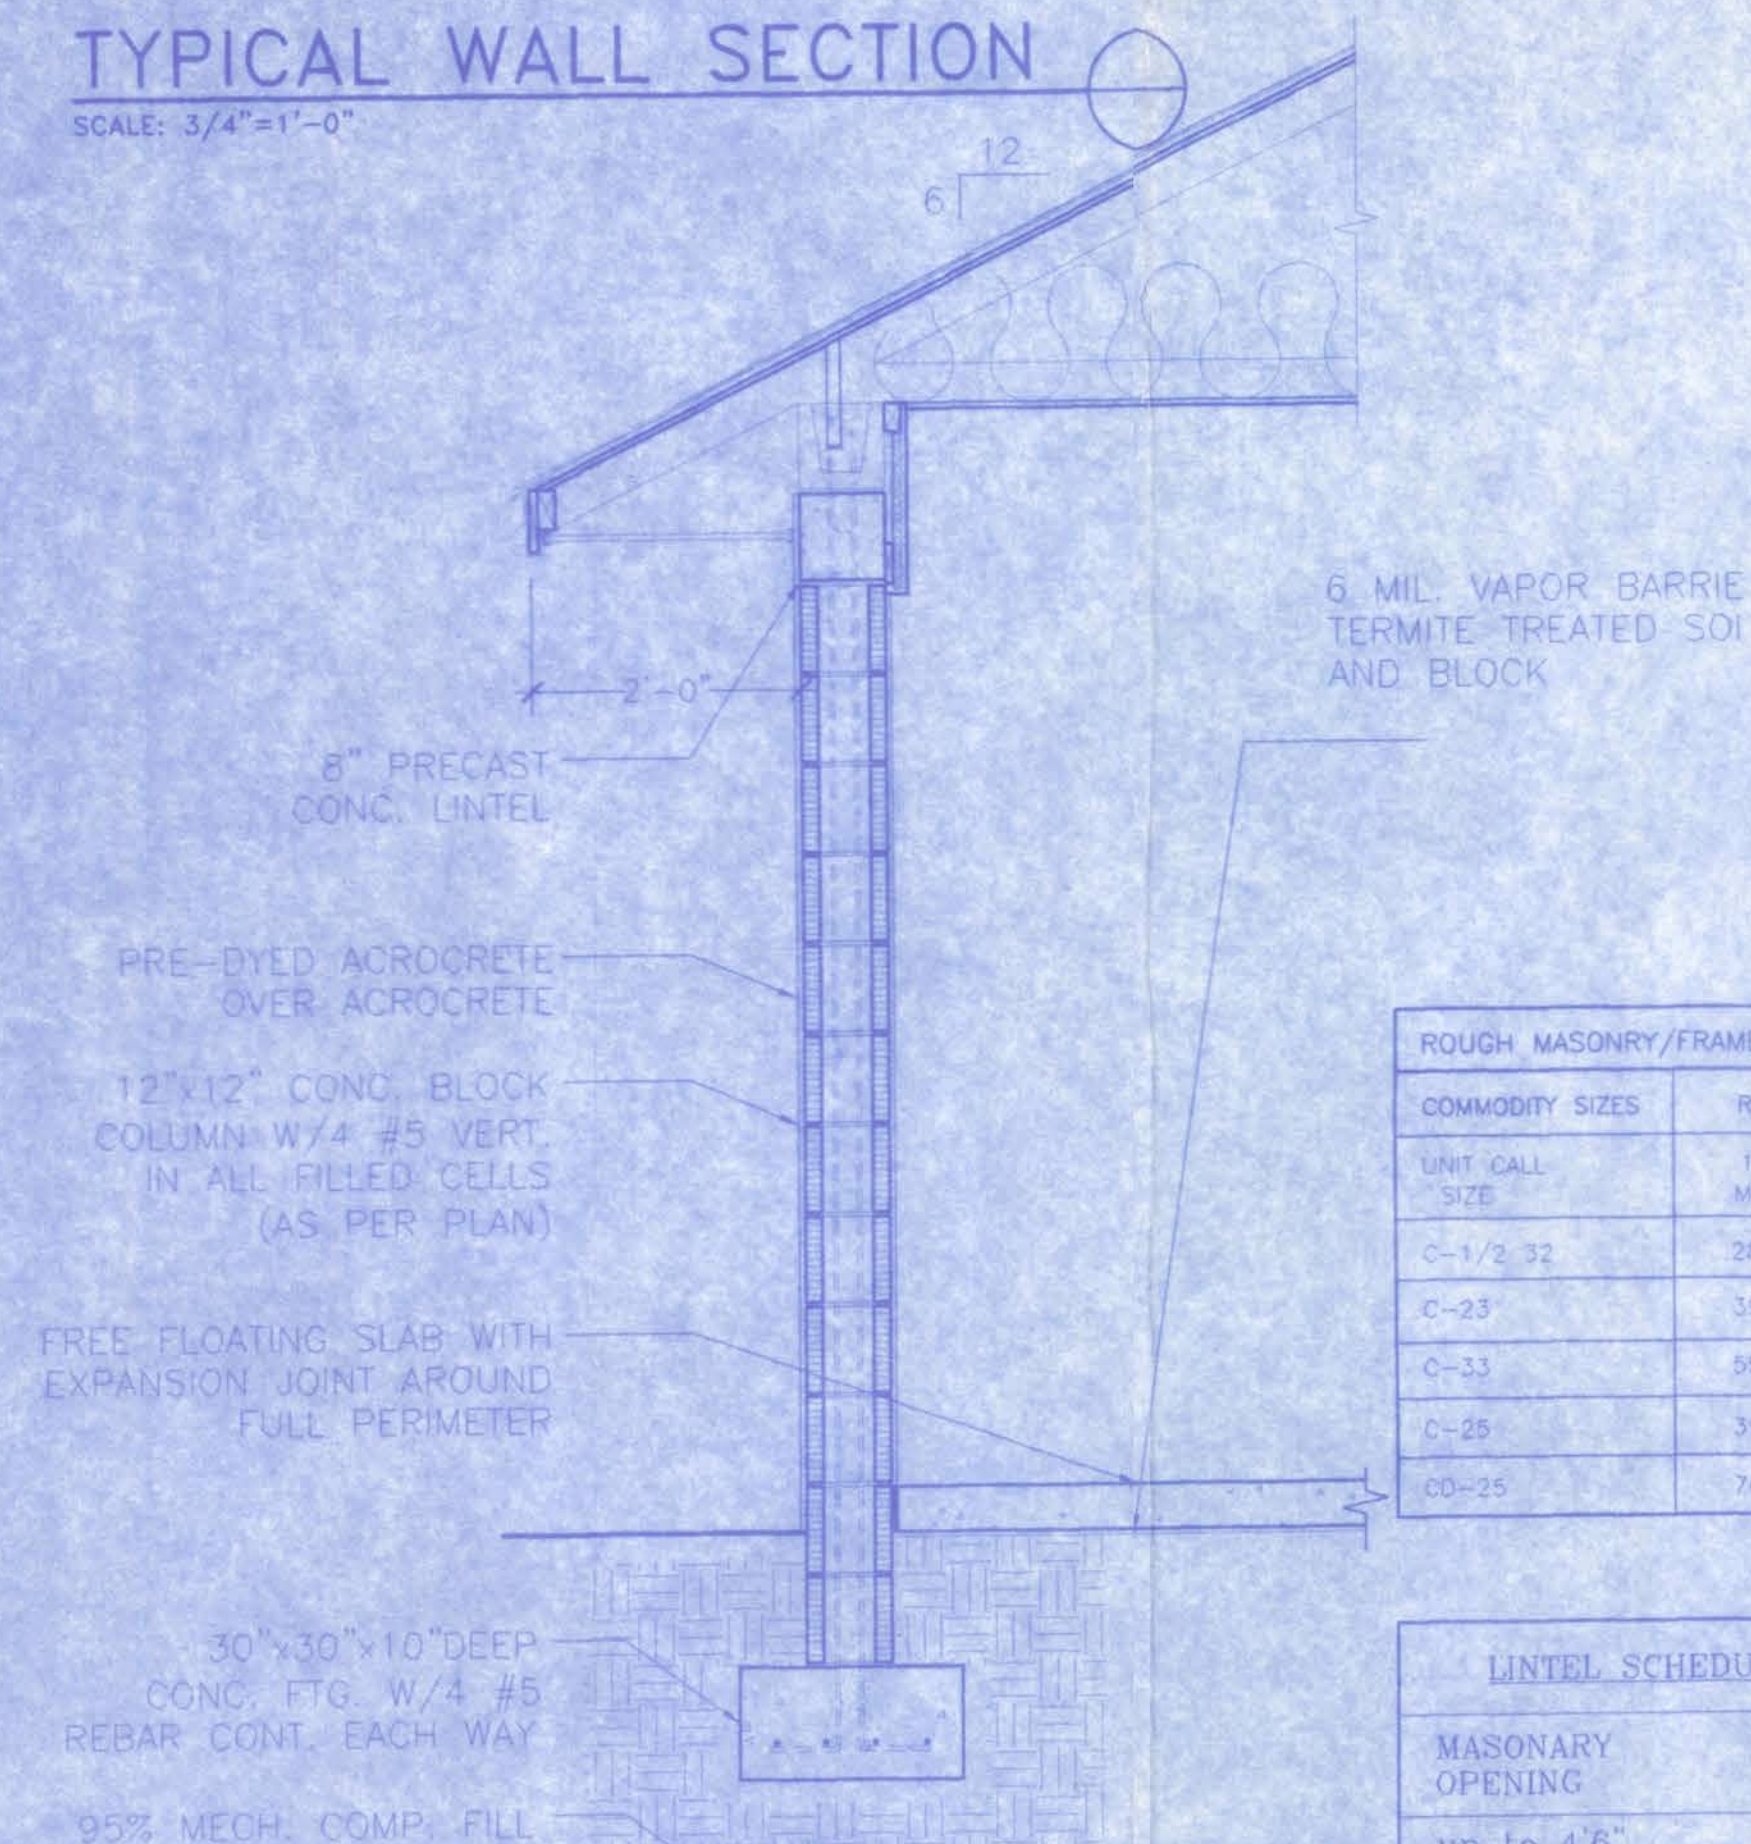


TYPICAL WALL SECTION

SCALE: 3/4"=1'-0"

COMMODITY SIZES	ROUGH OPENING (WxH)
UNIT CALL SIZE	1/2" FLANGE MASONRY (2BY)
C-1/2 32	28-3/4x26-7/8
C-23	39-1/4x30-1/8
C-33	56-3/8x39-1/8
C-25	39-1/4x53-7/8
CD-25	76-1/4x63-7/8

MASONRY OPENING	LINTEL MARK	LINTEL WIDTH	LINTEL HEIGHT	TOP BARS	BOTTOM BARS
up to 4'6"	A	7' 5/8"	16"	none	(2) #3
up to 9'	B	7' 5/8"	16"	(2) #2	(2) #4
9' Front Window	*B	7' 5/8"	16"	(2) #4	(2) #6
16' Garage Door	*B	7' 5/8"	16"	(2) #4	(2) #6

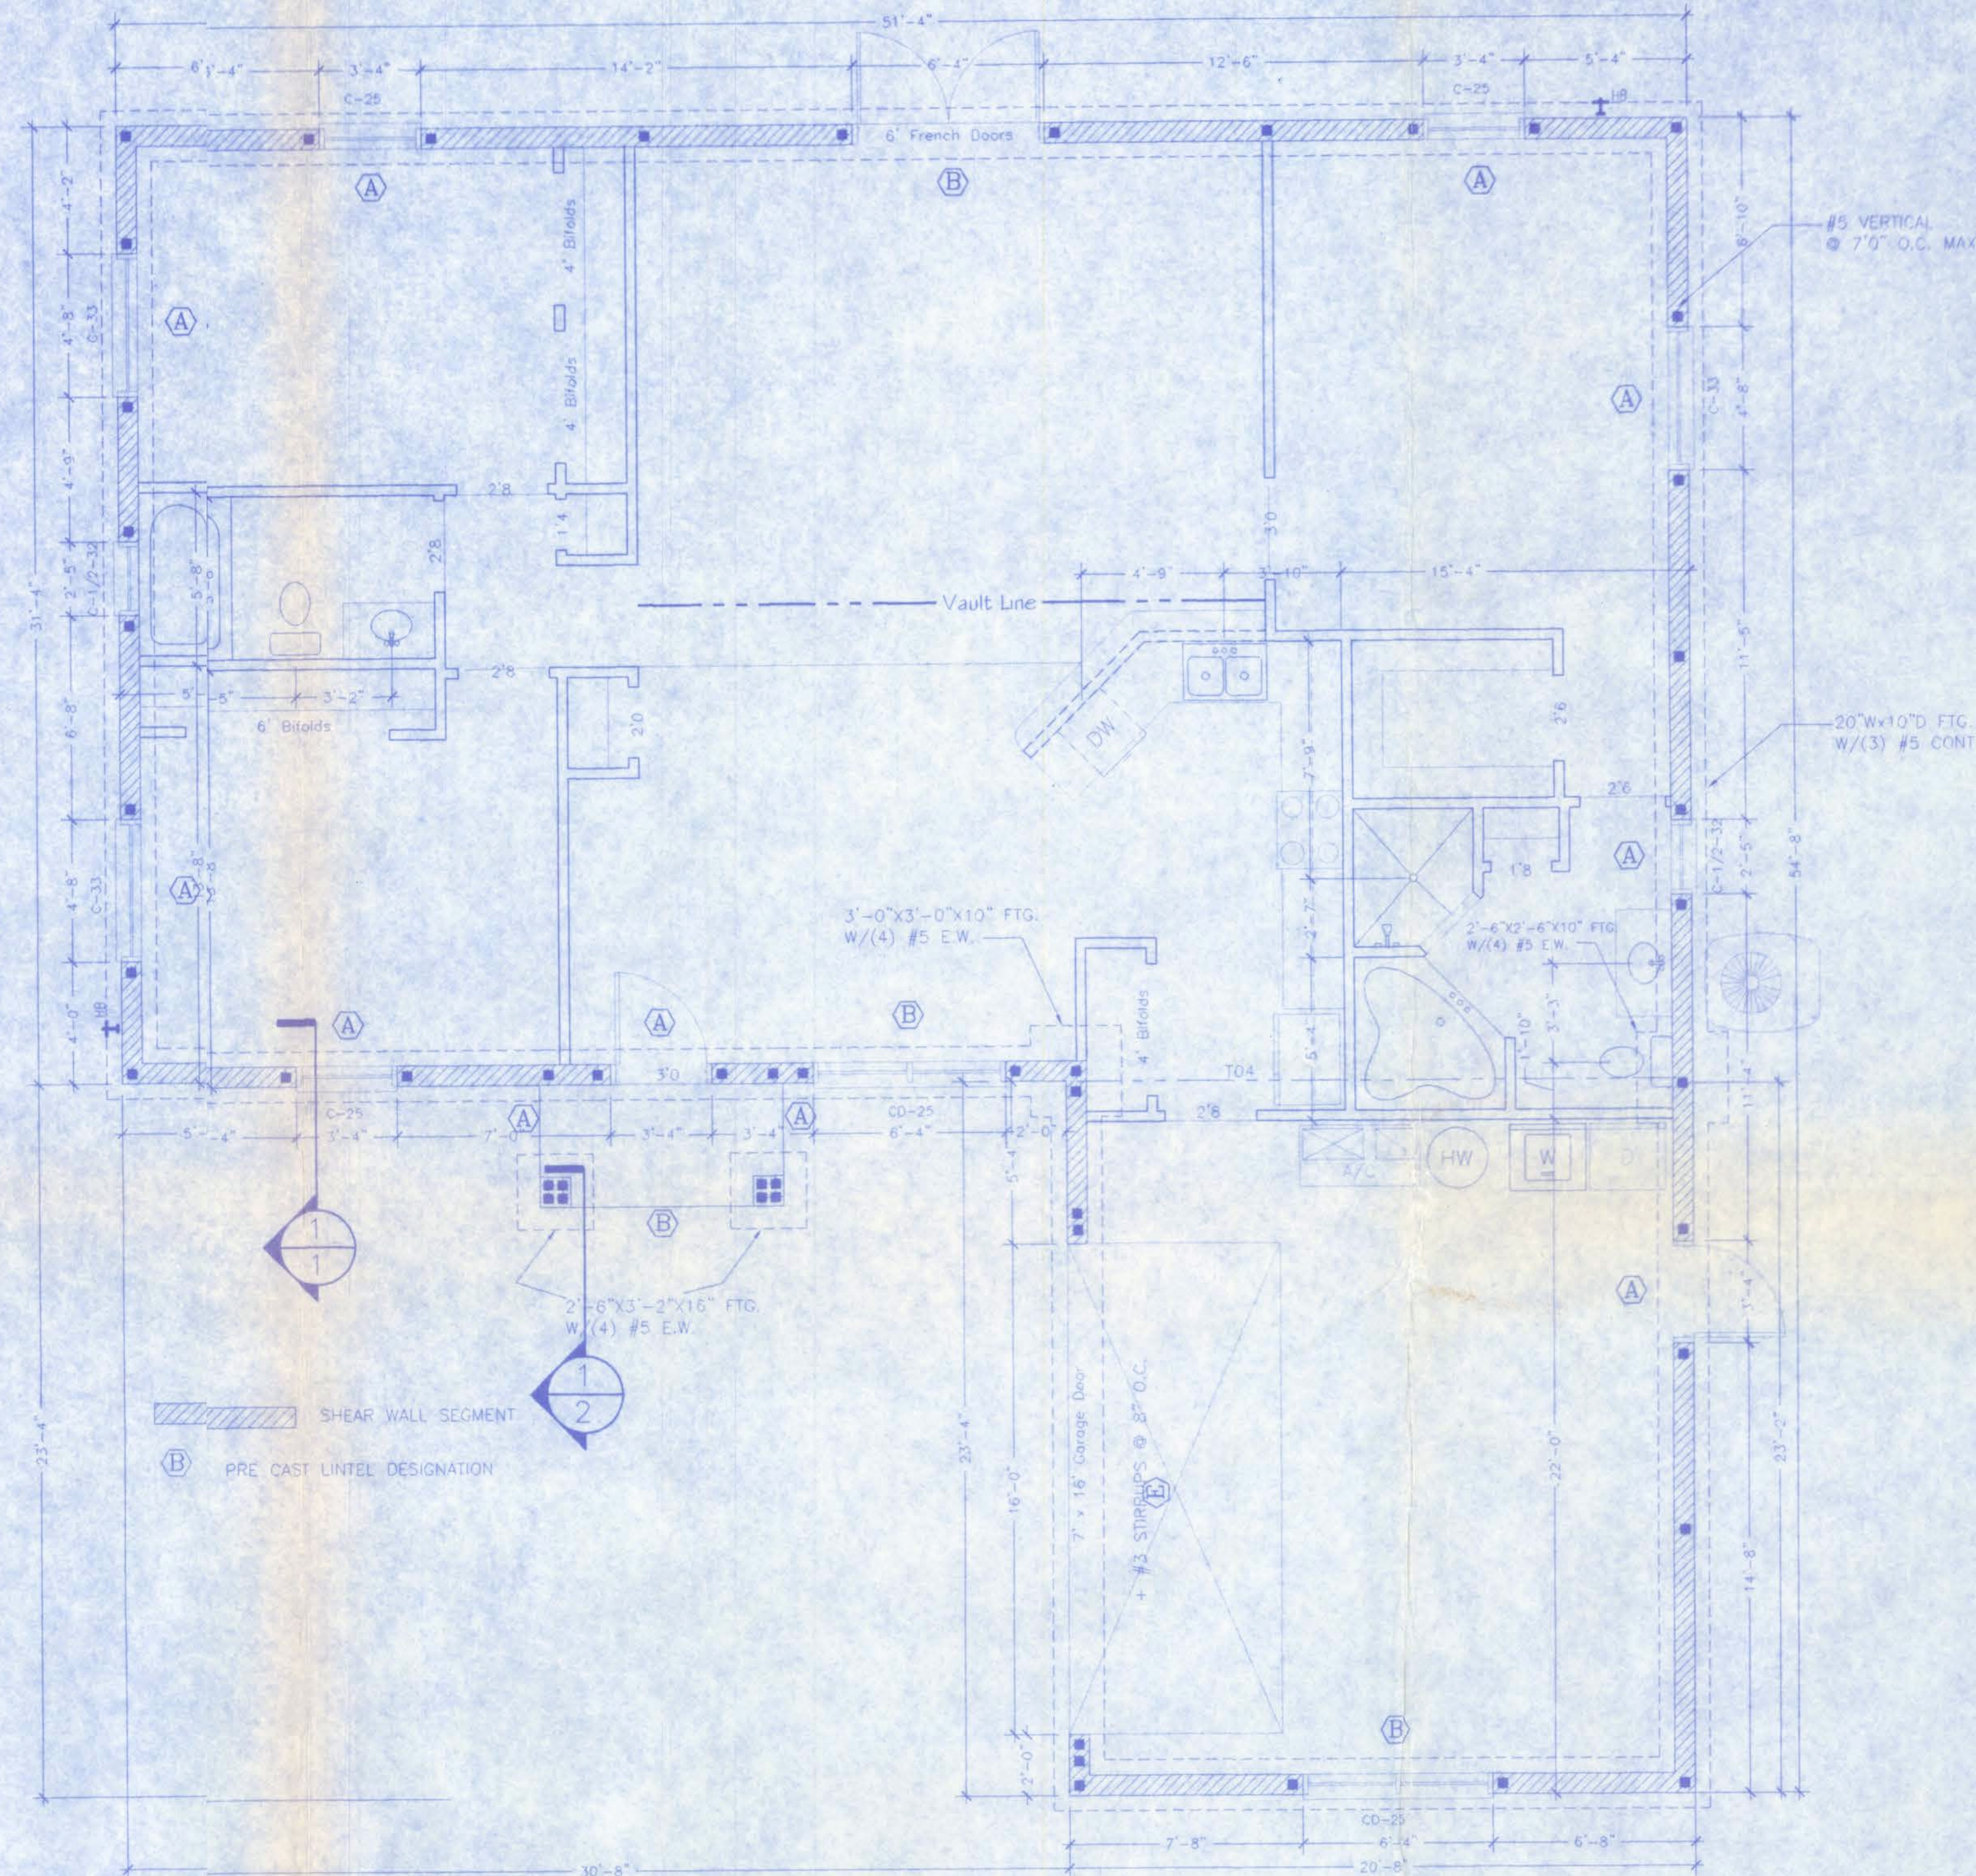

FOUNDATION PLAN

SCALE: 1/4"=1'-0"

SHEAR WALLS QUANTITY
 TRANSVERSAL SHEARWALLS = 71'-0"
 LONGITUDINAL SHEARWALLS = 65'-0"

EQUIPMENT	TYPE	SIZE/RATING
AIR COND.	ELEC	36 CAP./13 SEER
HEATING	ELEC	36 CAP./7.7 SEER
WATER HEATER	ELEC	40 GAL./0.92 EFF.

HOUSE CRAFT HOMES, L.L.C.
 12501 NW U.S. Hwy. 441 - Alachua, FL 32616
 Phone: (386) 462-5323/FAX: (386) 462-1609

Job name: **BUTLER**
 Model: **MONROE** Type: **ELEVATIONS**
 Location: **COLUMBIA COUNTY** Drawn By: **J.D.H.**
 Checked By: **J.D.H.** Revision Date: **8/18/07**
 Scale: 1/4"=1' Date: 8/18/07 Sheet: 4 of 5

Client Name: _____ Model: _____

BANK: _____ LOAN TYPE: (X) Cash
() Conventional
() F.H.A.
() V.A.

CABINET COLOR SELECTIONS:

Kitchen:	Toilets:	Color:
Countertop _____	Master _____	
Cabinet Base _____	Hall _____	
Master Bath:	Other _____	
Countertop _____		
Cabinet Base _____		
Hall Bath:		
Countertop _____		
Cabinet Base _____		

NOTES: _____

BATHROOM TILE SELECTION:

Master Bath:	Color:	Tub Choices:	Pum:
Shower _____	_____	Style _____	_____
Shower Floor _____	_____	CORNER _____	_____
Grout _____	_____	STEEL _____	_____
Hall Bath:	Both 3 _____		
Tub Surround _____	Tub Surround _____		
Tile Selection _____	Tile Selection _____		
Grout _____	Tile Selection _____		

VAULTS:

GREAT ROOM, KITCHEN, DINING, FOYER

CARPET _____ VINYL/FLOOR TILE _____

PAINT SELECTIONS:

Interior Wall Color: STD _____

Interior Trim: STD _____

Window Sills:

() Wood

(X) Flatcut Marble

() Hardiplank Siding Wood Sill

RANGE SELECTIONS:

Range/Color: STD WHITE _____

Hood/Color: STD WHITE _____

EXTERIOR FEATURE SELECTIONS:

Acrocrete/Main House: _____

Trim Package: MONROE _____

Trim Color: _____

Exterior Door Colors: _____

Siding: _____

Soffit: _____

Shingles: _____

Style/Color: _____

Window Color: _____

Trim Type Colonial w/Classique Doors Std.

Colonial Grills Front Windows Standard

BATH WINDOWS:

Master (X) Obscure () Clear Glass

Hall (X) Obscure () Clear Glass

SUPER Energy Pac: Yes () No (X)

Well Allowance Yes () No (X)

Septic Allowance Yes () No ()

Extras:


Power Company: _____ () Overhead (X) Underground

Fireplace: N/A Screenroom Color: N/A

We have reviewed this plan and all notes on it. All items we have discussed with House Crt and its representatives are indicated on this "Master Copy". We understand that any additional items that are not on this print can be done for a \$250.00 plan change fee plus the cost of the change.

Purchaser: _____ Date: _____

REV.	DESCRIPTION	NOTE

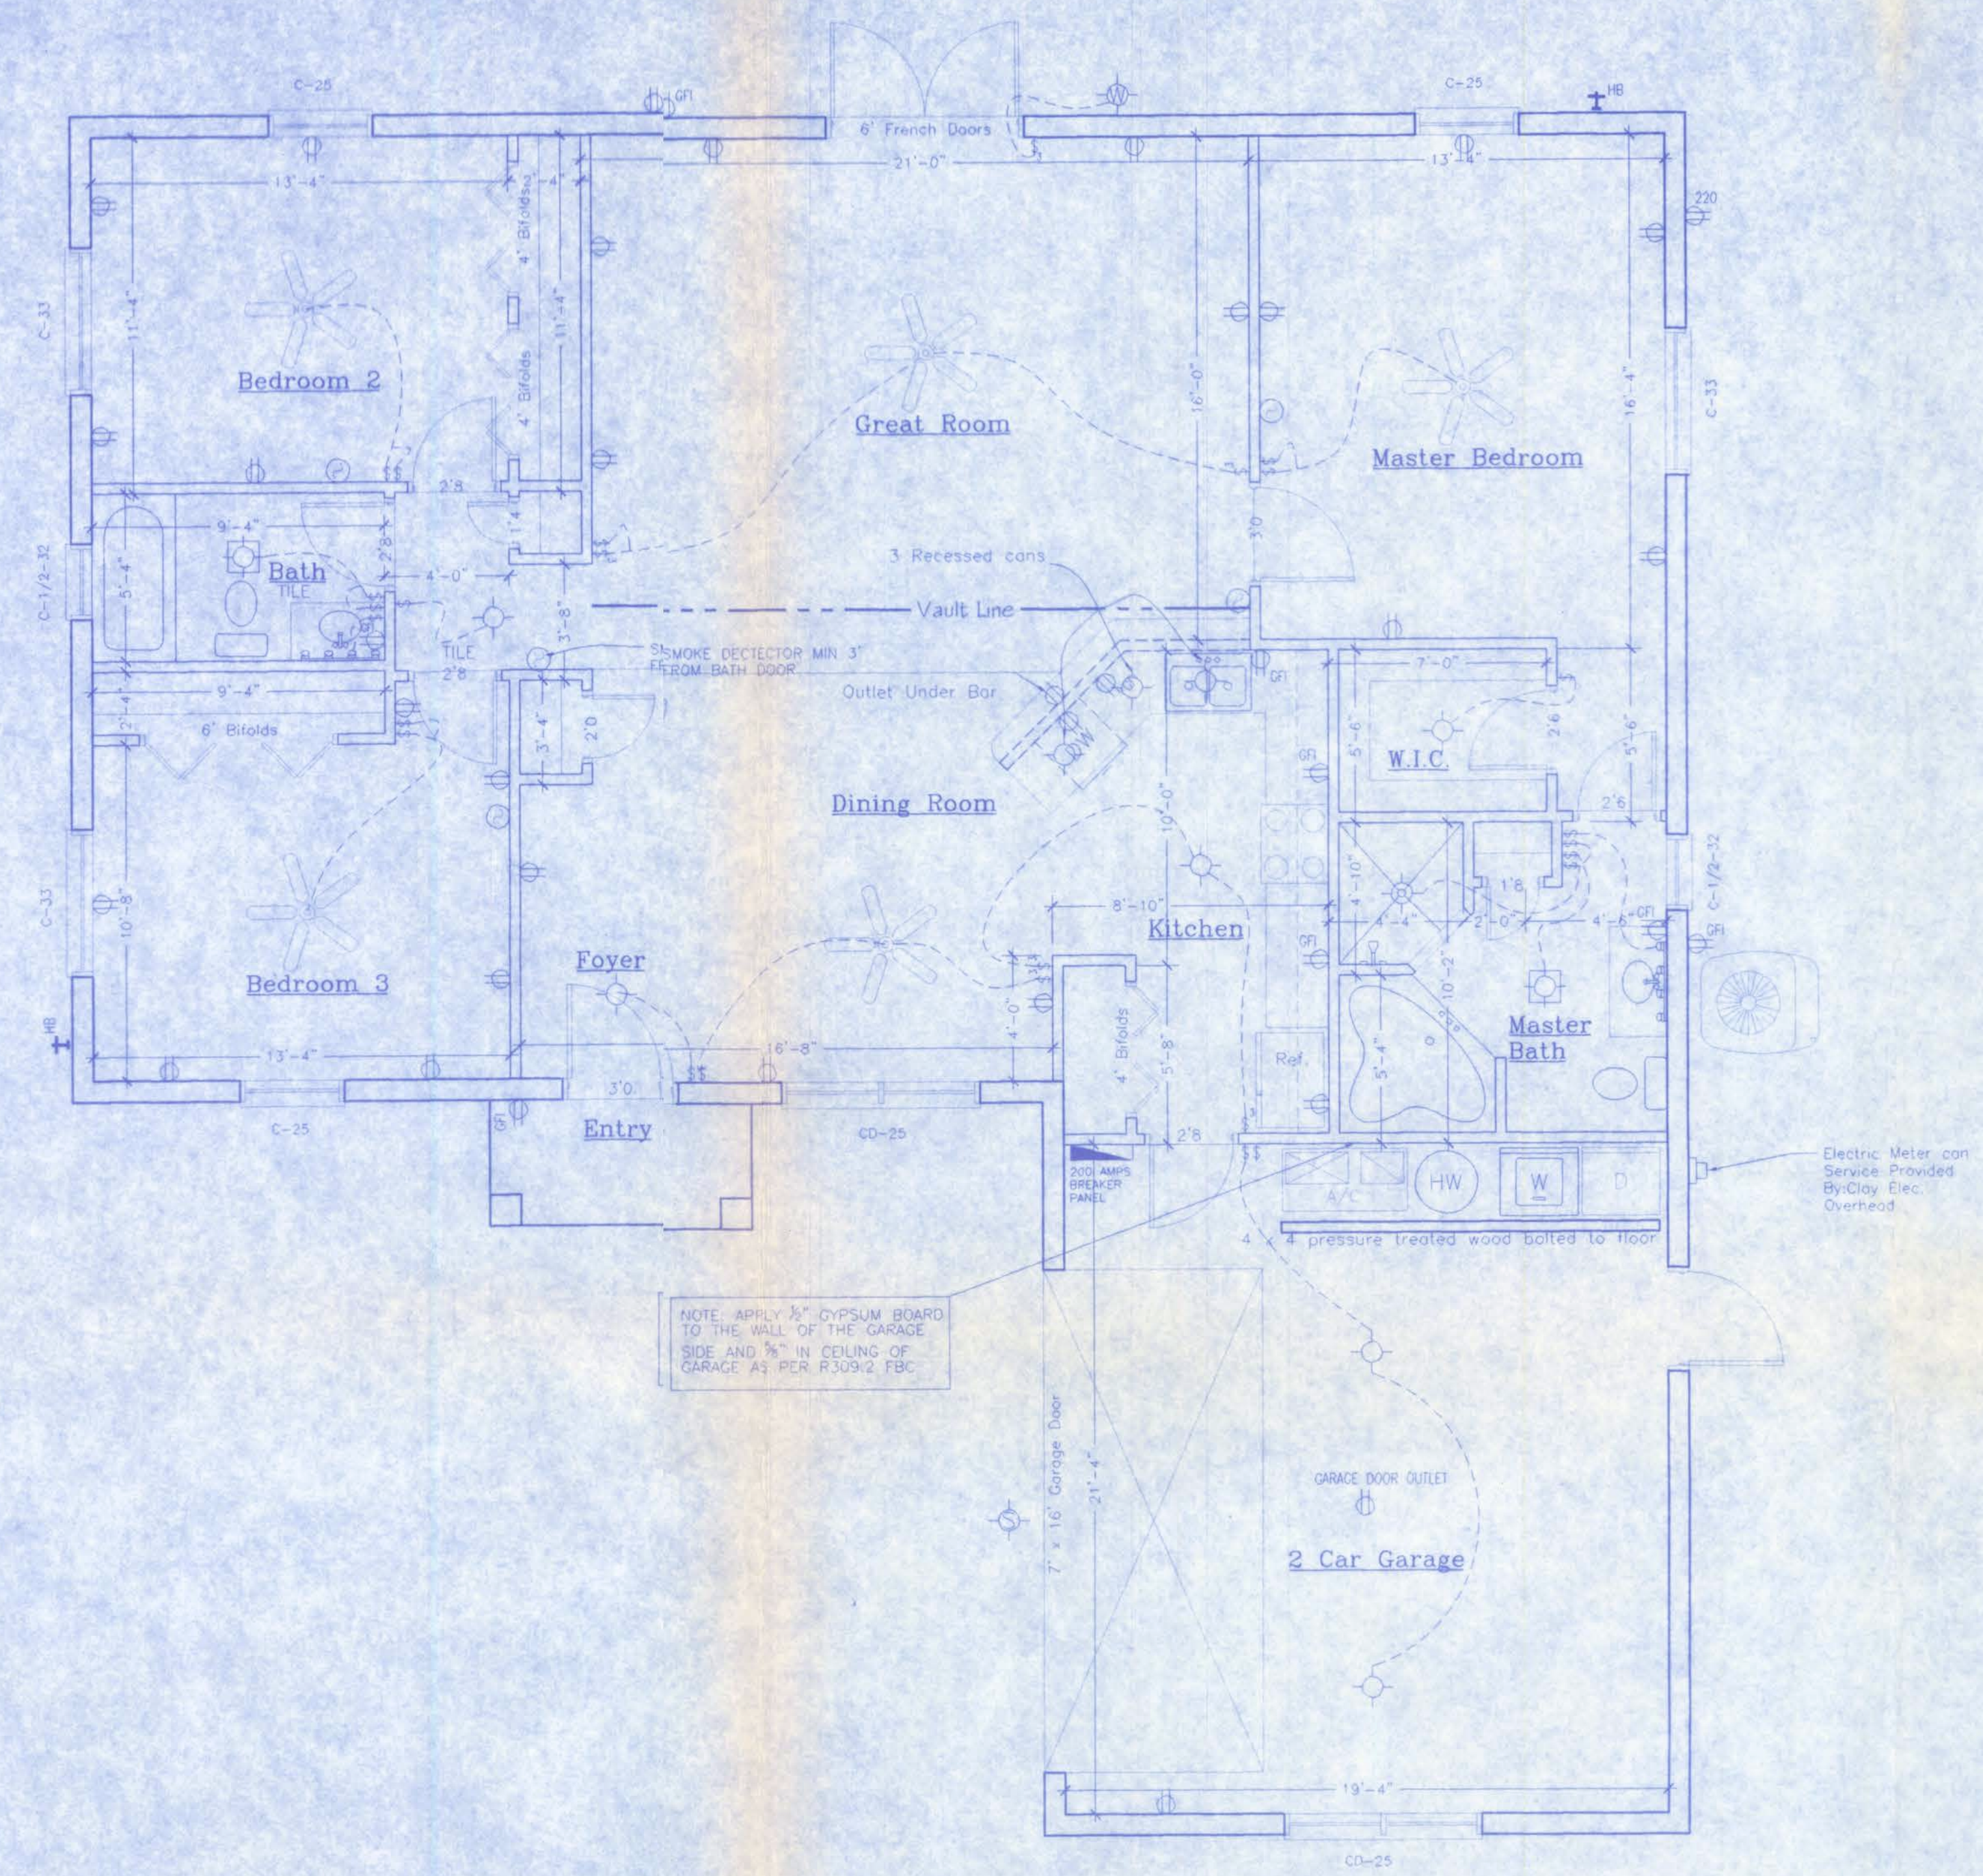

NOTE: APPLY 1/2" GYPSUM BOARD TO THE WALL OF THE GARAGE SIDE AND 1/2" IN CEILING OF GARAGE AS PER R309.2 FBC

FLOOR PLAN

SCALE: 1/4"=1'-0"

FIXTURE	DESCRIPTION
	SURFACE MOUNTED INCANDESCENT FIXTURE
	PRE-WIRED CEILING FAN
	DOUBLE FLOOD LIGHT FIXTURE
	FAN LIGHT VENTED TO EXTERIOR
	SURFACE MOUNTED INCANDESCENT FIXTURE

TYPICAL SPECIAL CIRCUIT ELECTRIC SCHEDULE

TWO GFI'S CIRCUITS IN KITCHEN

ONE OR TWO GFI'S IN BATHS LOOPED TOGETHER

GFI IN GARAGE, FRONT ENTRY, AND REAR PORCH LOOPED TOGETHER

ONE GFI FOR JETTED TUB (OPTIONAL)

TWO AFI CIRCUITS PROVIDED FOR BEDROOMS

CODE COMPLIANCE: This building is designed in compliance with the requirements of the Florida Building Code, 2004. Structural members, cladding, fasteners and systems providing for the structural integrity of the building are designed to resist gravity loads prescribed Chapter 16 and wind loads prescribed in Section 16 and wind loads prescribed in Section 1609.6 Simplified Provisions for Low Rise Building

DESIGN LOADS			
a. Uniformly Distributed Live Loads (Section 1604.1)			
Floor Live Load	na	psf	
b. Roof Live Loads (Section 1604.6)			
6:12 Pitch	16	psf	
c. Wind Loads (Section 1609.6)			
1.) Enclosure Classification	Enclosed		
2.) Basic Wind Speed (3 second gust)	110	mph	
3.) Wind Importance Factor, Iw	1.0		
4.) Exposure Category	B		
5.) Internal Pressure Coefficients:	+0.18, -0.18		
6.) Design Wind Pressures for Doors and Windows	Opening Area (sf)	Inward Pressure (psf)	Outward Pressure (psf)
	0-10	21.8	-29.1
	11-20	20.8	-27.2
	21-50	19.5	-24.6
	51-100	18.5	-22.6

ELECTRICAL LEGEND	
	DUPLEX CONVENIENCE RECEPTACLE WITH GROUND (AA" DENOTES HEIGHT ABOVE FIN. IF OTHER THAN STD.) (GFI/DFI DENOTES GROUND FAULT (CIRCUIT INTERRUPTER) (WP DENOTES WEATHER PROOF)
	SPECIAL RECEPTACLE WITH GROUND, SEE SPECIFICATIONS
	SINGLE POLE SWITCH AT STANDARD HEIGHT
	THREE WAY SWITCH AT STANDARD HEIGHT
	TELEPHONE OUTLET
	CEILING MOUNTED EXHAUST FAN VENTED TO EXTERIOR
	CABLE TV OUTLET
	ELECTRICAL DISTRIBUTION PANEL
	SMOKE DETECTOR
	THERMOSTAT

Square Footage

Living...	1,636
Garage...	455
Entry...	32
Porch...	2,123
Total...	2,104

HOUSE CRAFT HOMES, L.L.C.

12501 NW U.S. Hwy. 441 - Alachua, FL 32015

Phone: (386) 462-5323/FAX: (386) 462-509

Job name: BUTLER

Model: MONROE Type: PLAN

Location: COLUMBIA COUNTY Drawn By: J.D.H.


Cheched By: J.D.H. Revision Date: 8/18/07

Scale: 1/4"=1' Date: 8/18/07 Sheet: 3 of 5




FRONT ELEVATION

SCALE: 1/4"=1'-0"

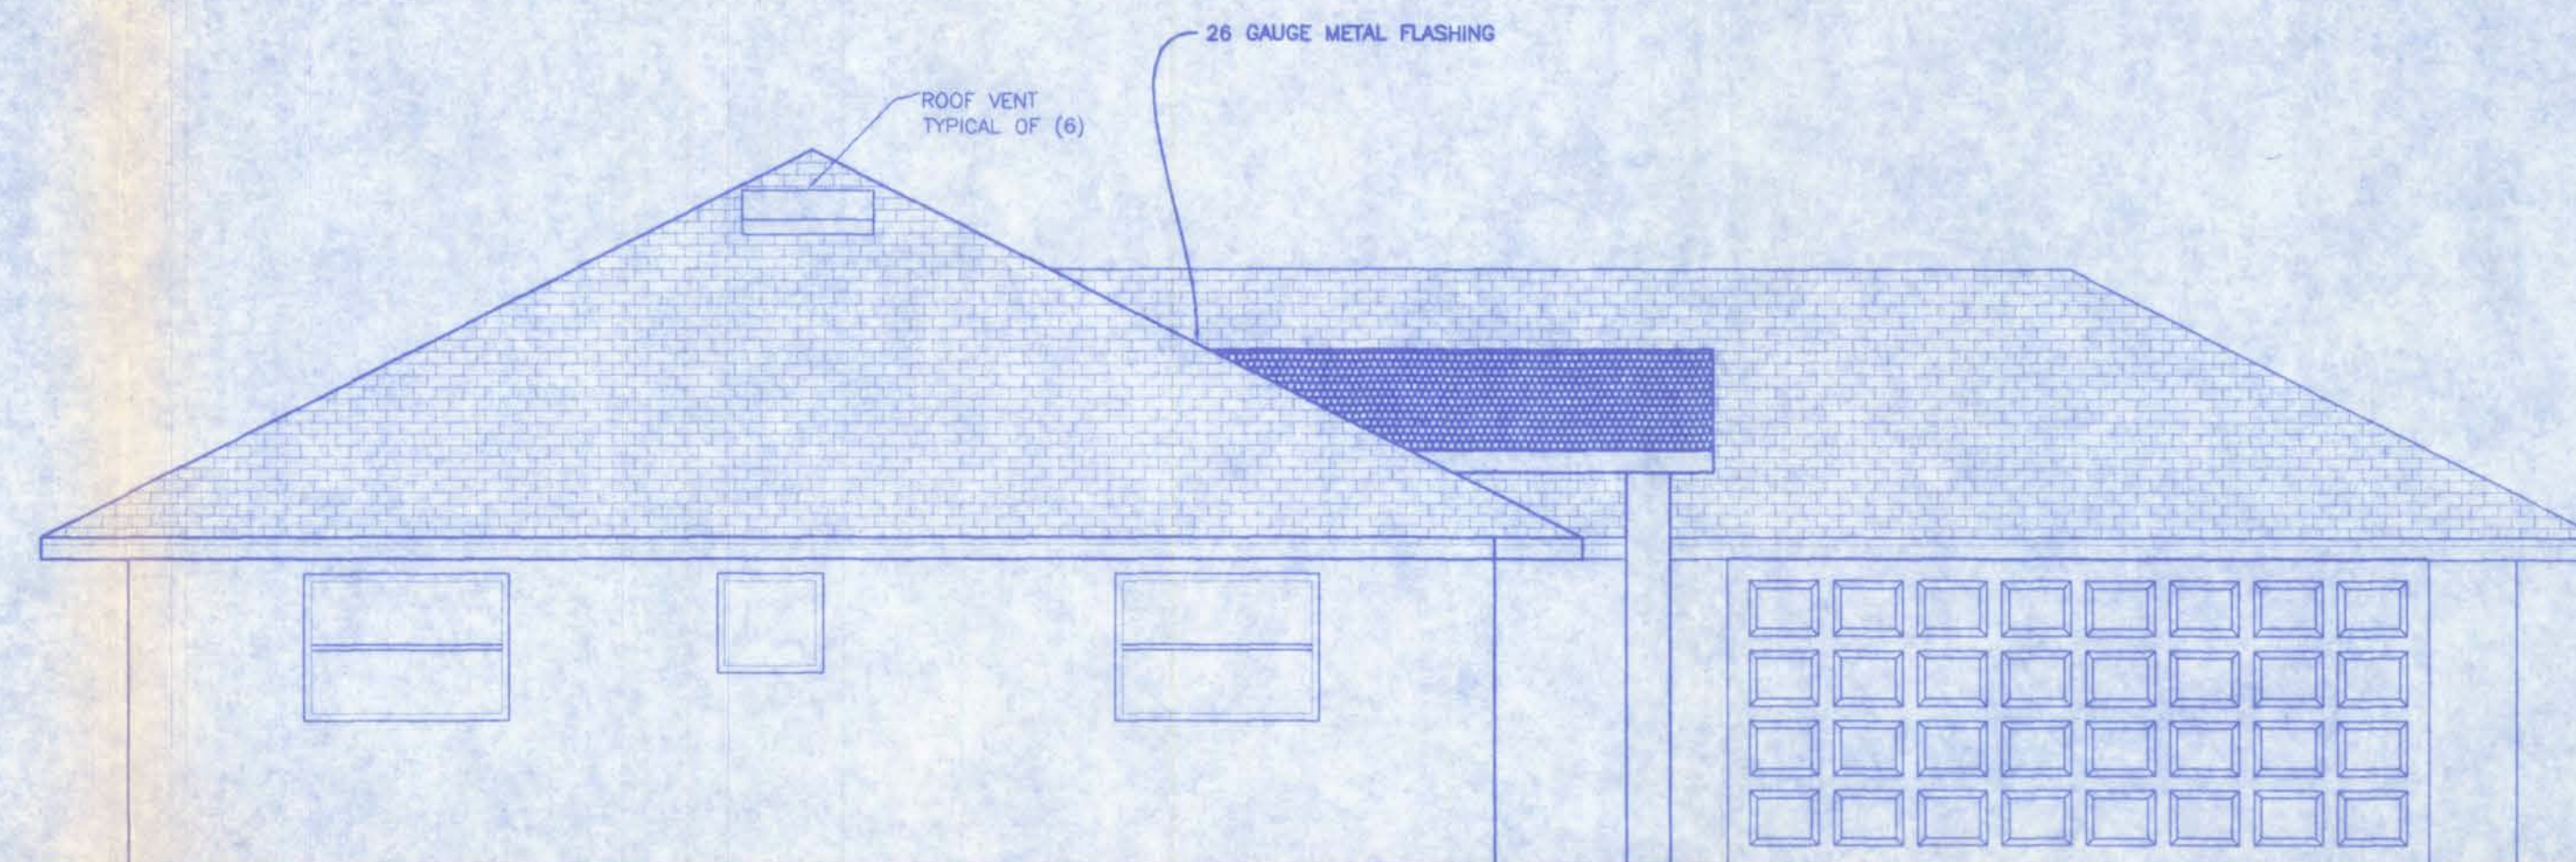


LEFT ELEVATION

SCALE: 1/4"=1'-0"

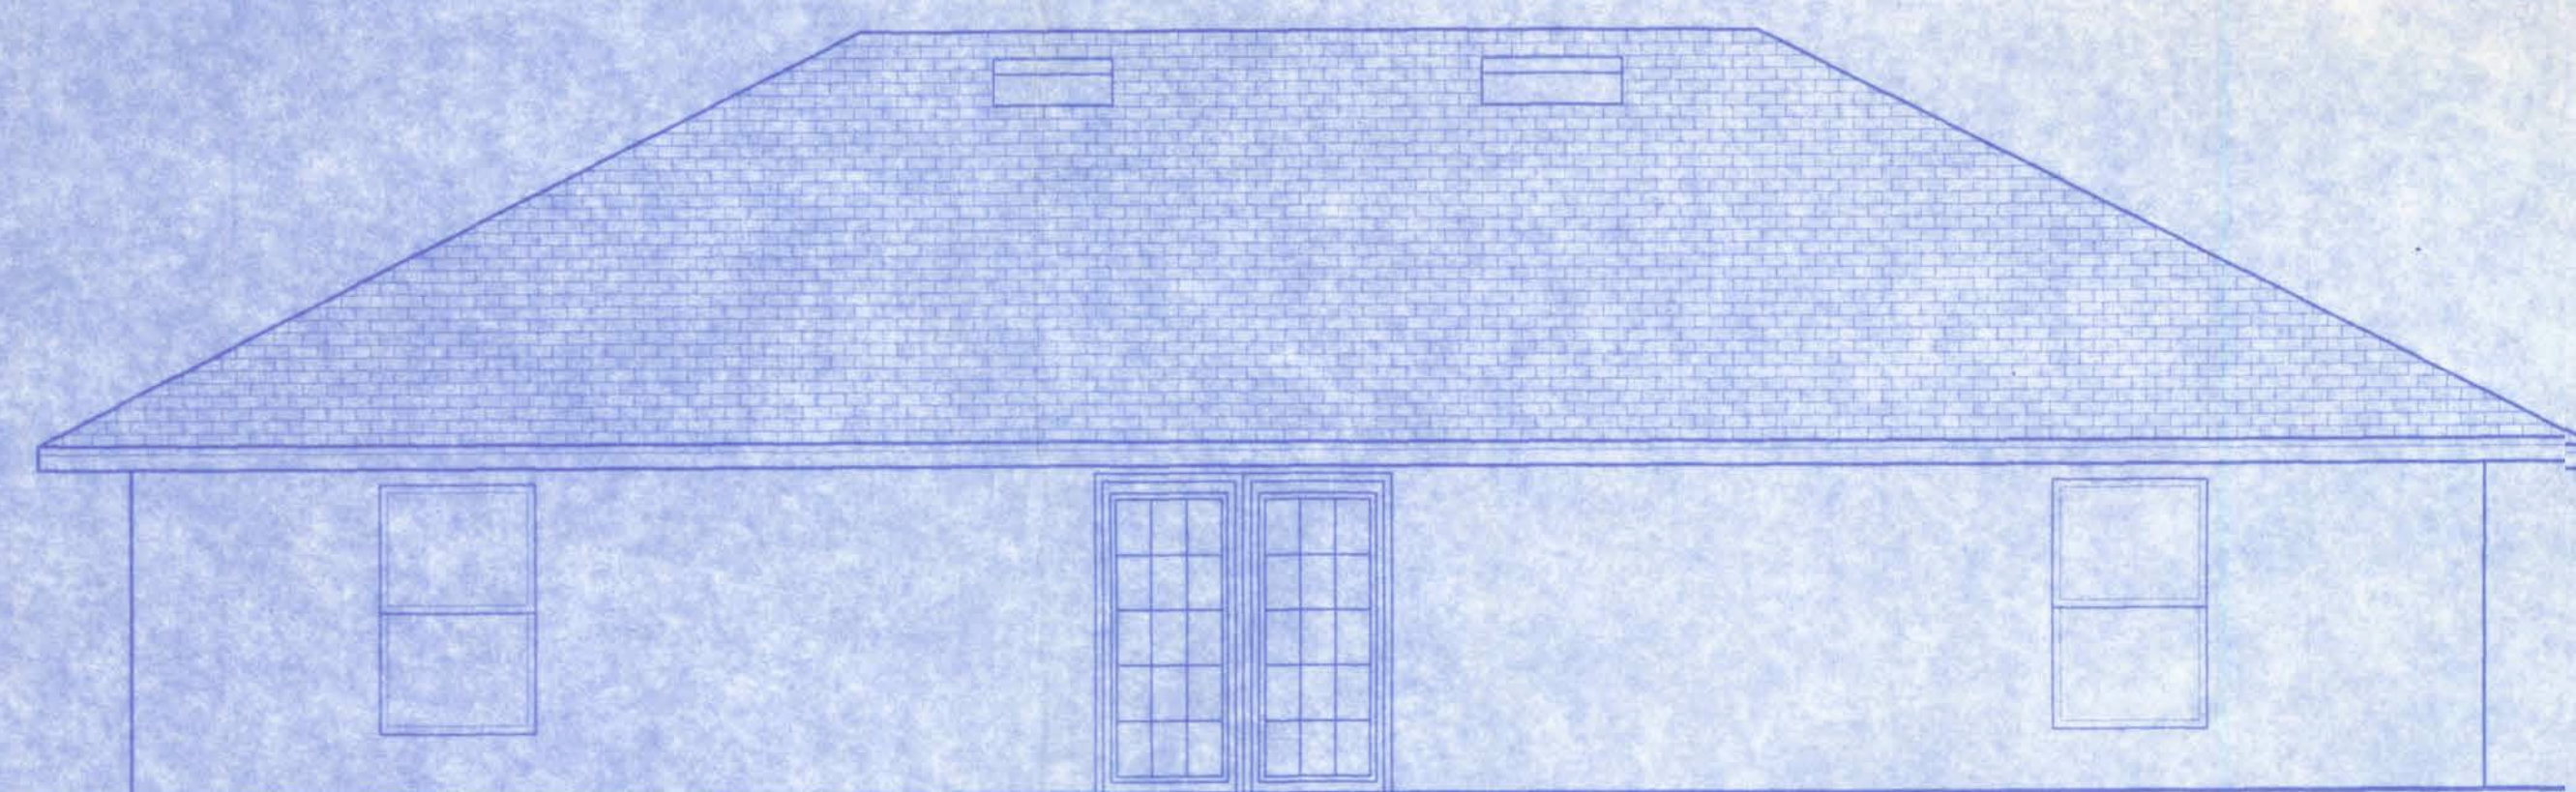

BACK ELEVATION

SCALE: 1/4"=1'-0"

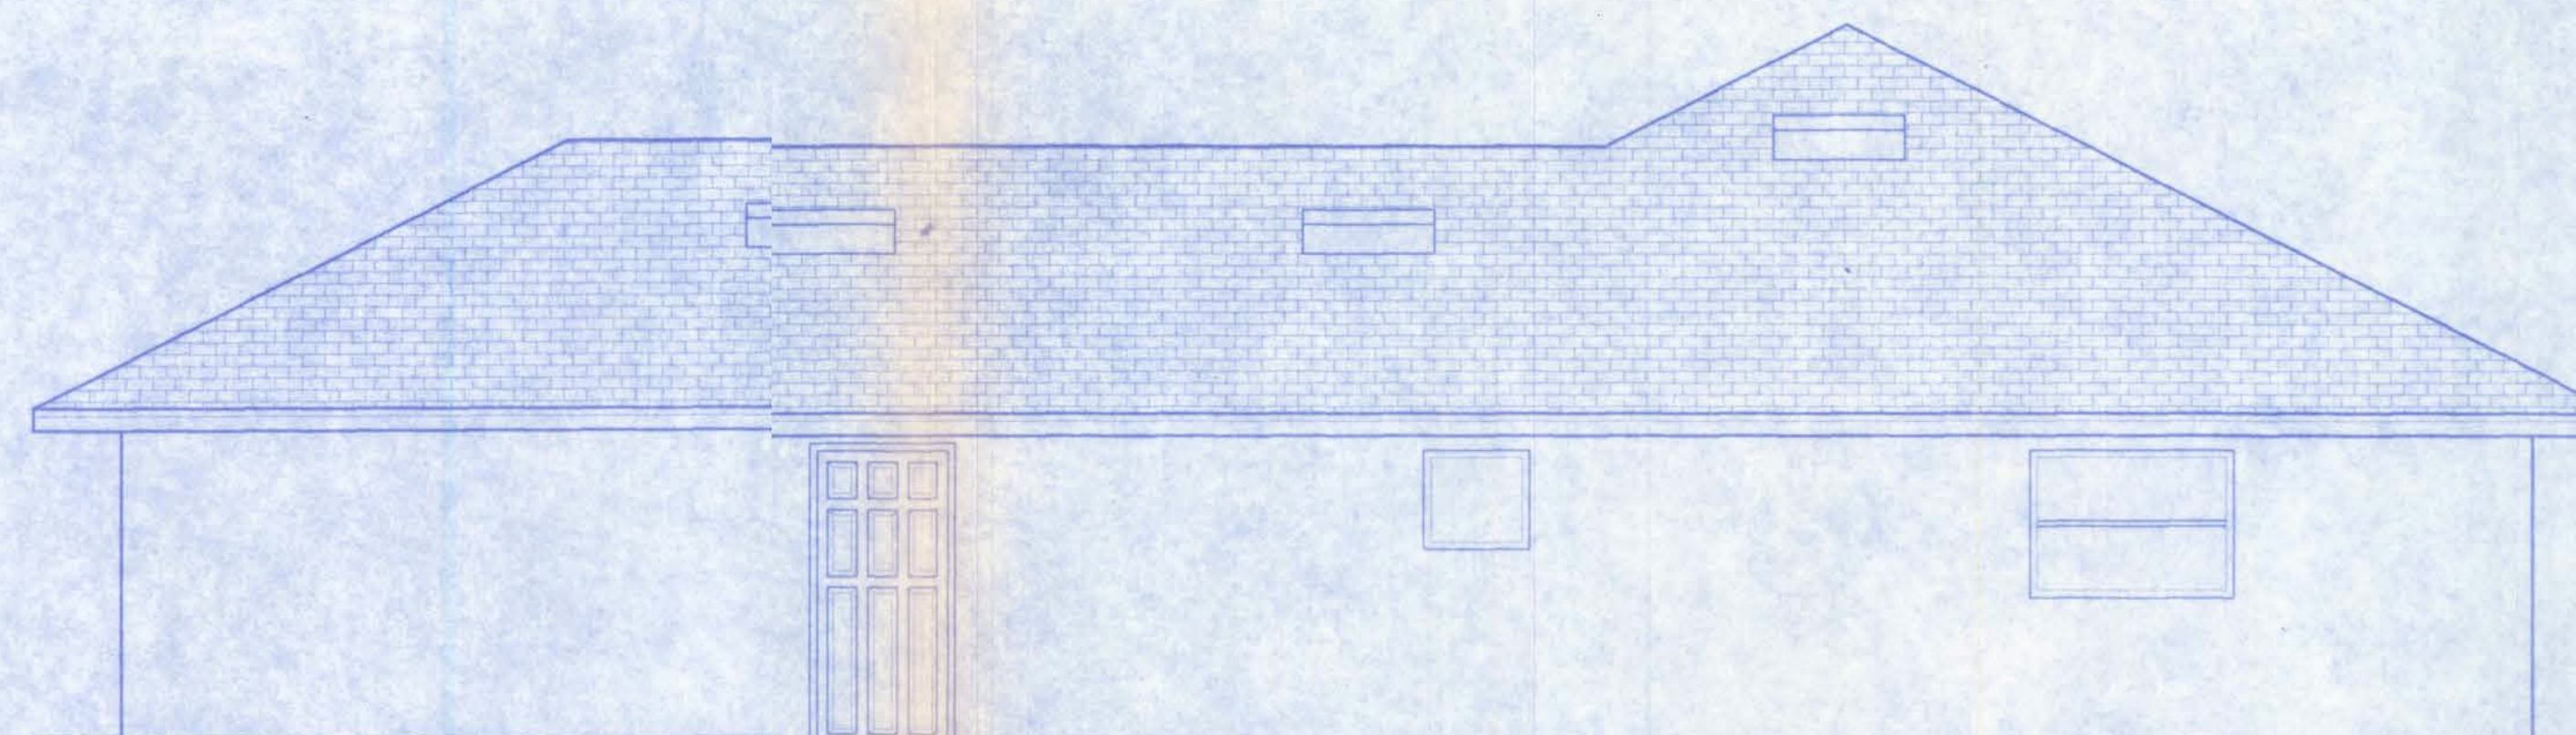

RIGHT ELEVATION


SCALE: 1/4"=1'-0"

ROOF VENT SCHEDULE

2,104 SQ. FT./300 = 7.01 SQ. FT. VENT REQUIRED
 214.67 L. FT. x2/35 = 12.26 SQ. FT. VENT PROVIDED
 6 STANDARD ROOF VENTS x 0.72 = 4.32 SQ. FT. PROVIDED
 7.01 REQUIRED = 16.58 PROVIDED

HOUSE CRAFT HOMES, L.L.C.
 12501 NW U.S. Hwy. 441 - Alachua, FL 32815
 Phone: (386) 462-5323/FAX: (386) 462-1509

Job name: **BUTLER**
 Model: **MONROE** Type: **ELEVATIONS**
 Location: **COLUMBIA COUNTY** Drawn By: **J.D.H.**
 Checked By: **J.D.H.** Revision Date: **8/18/07**
 Scale: **1/4"=1'** Date: **8/18/07** Sheet: **4 of 5**

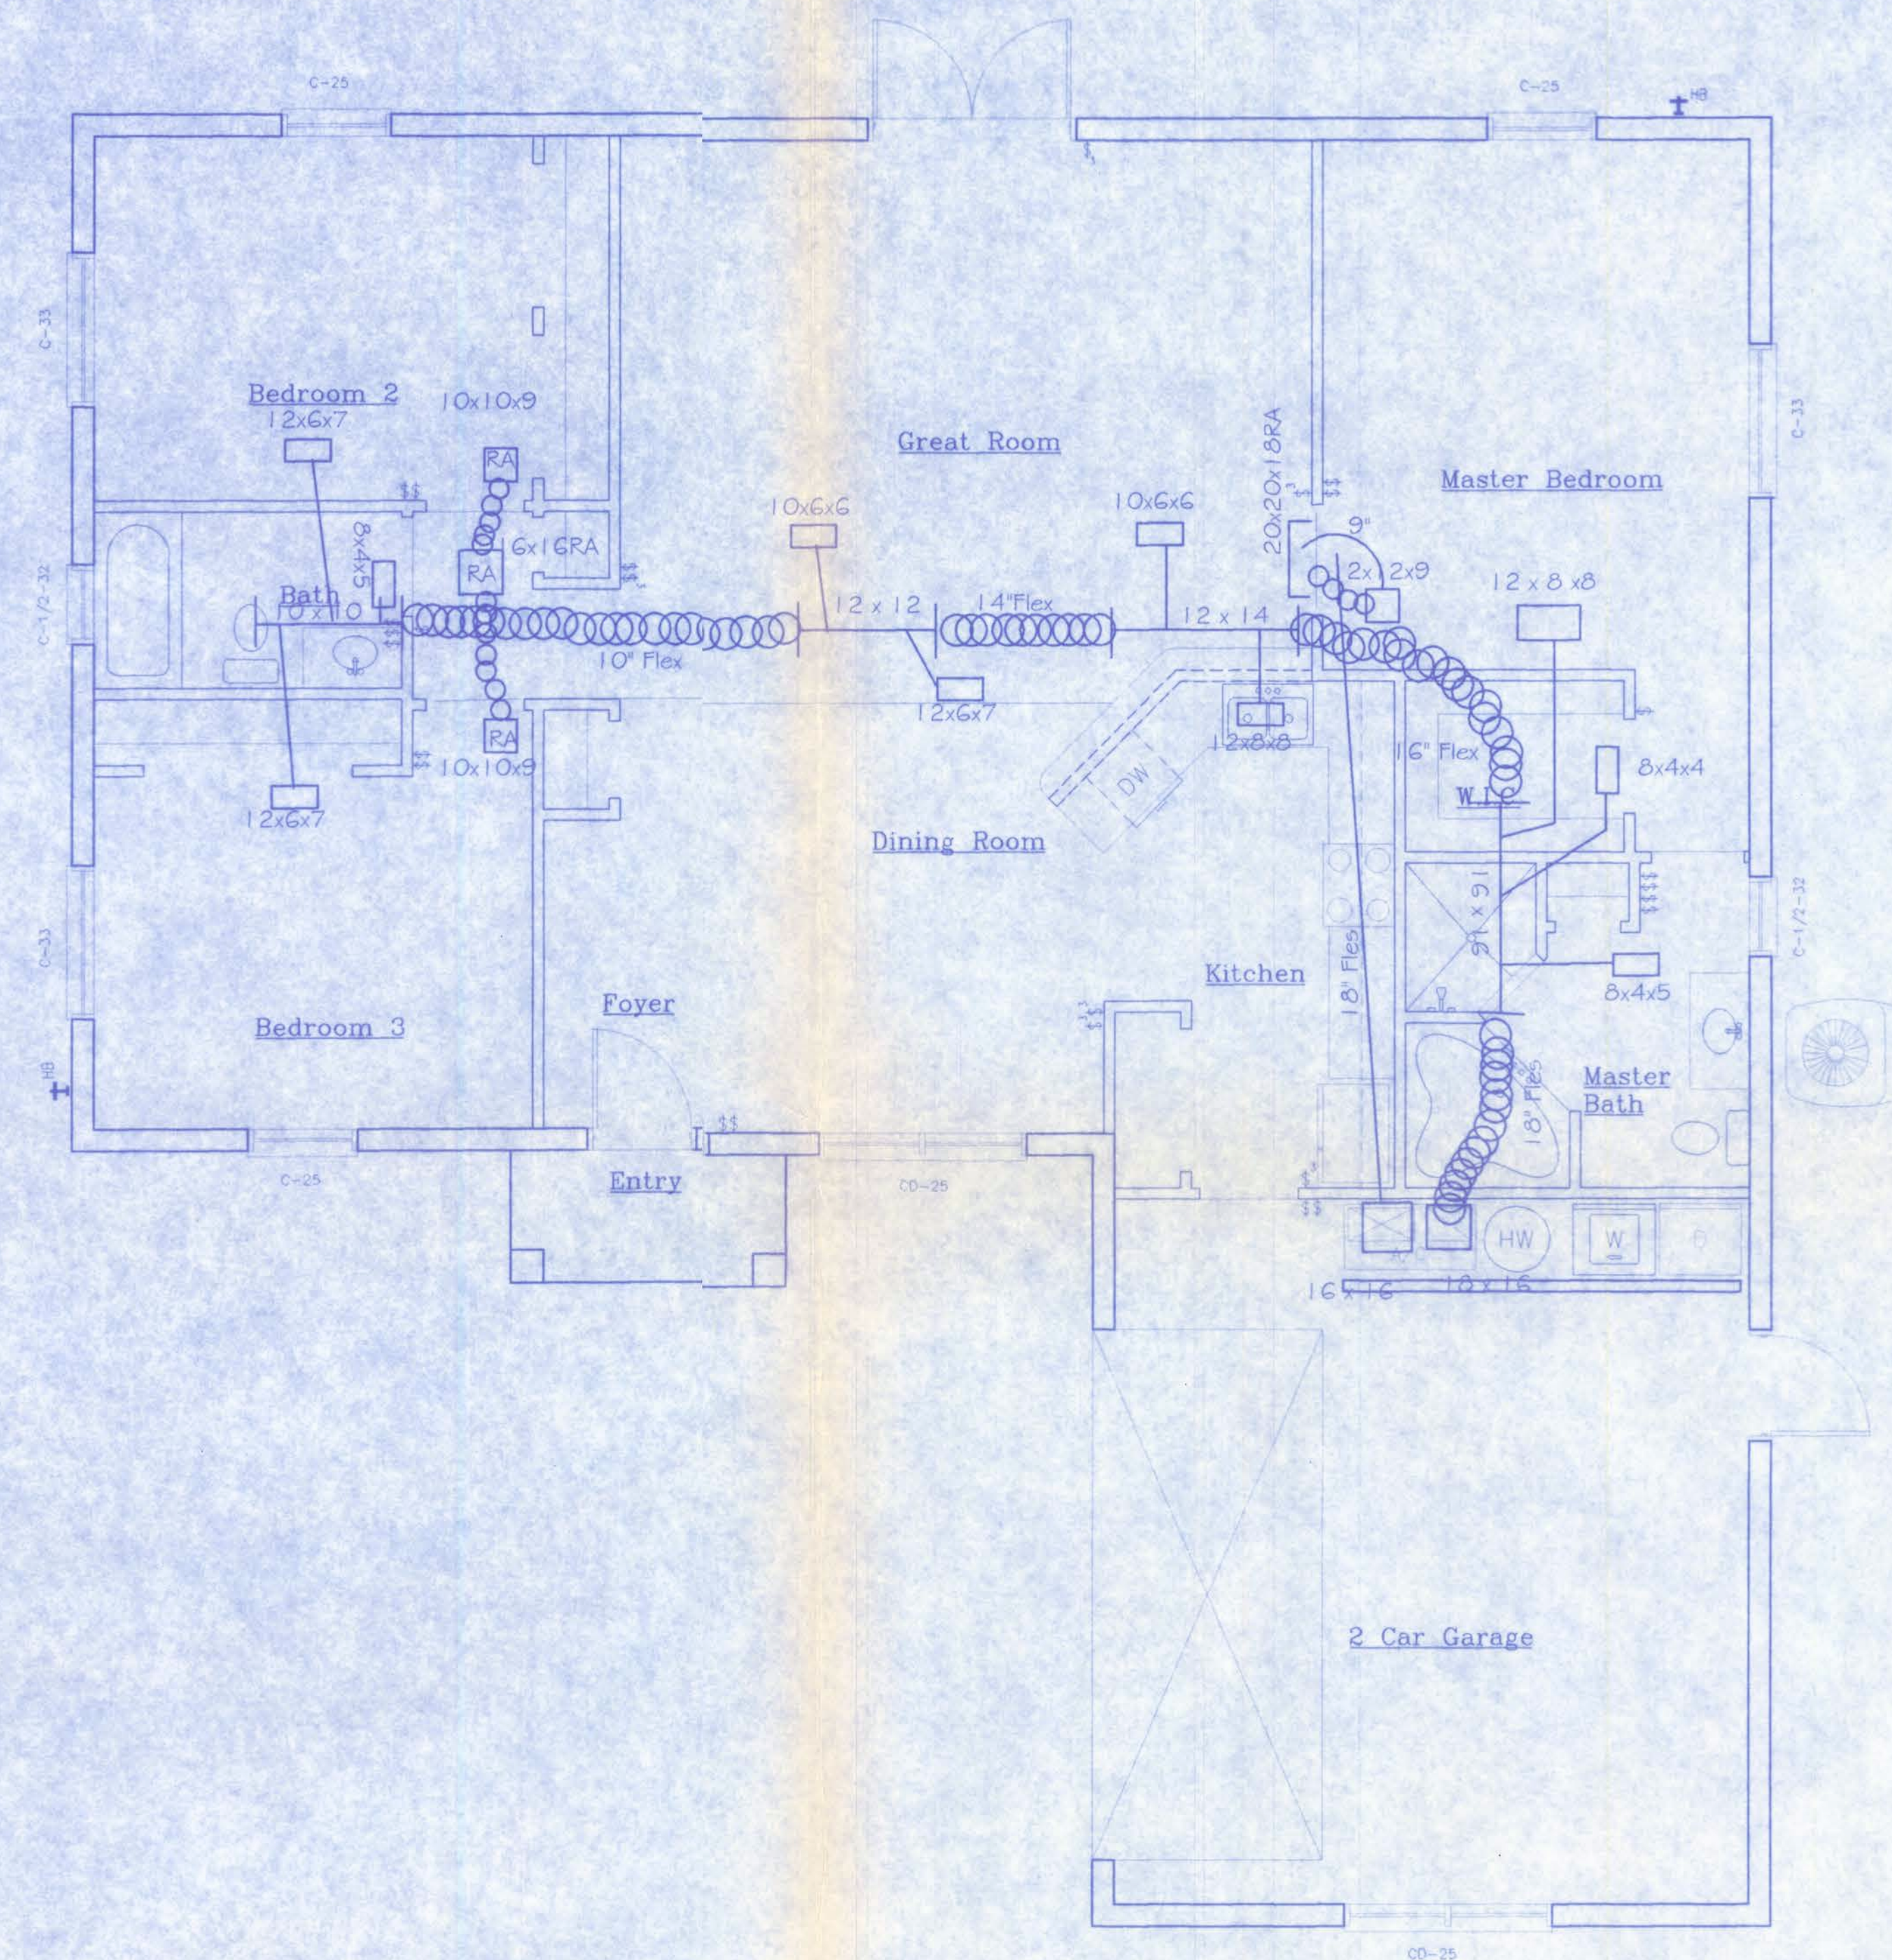

AC LAYOUT
NTS

Square Footage	
Living...	1,636
Garage...	455
Entry...	32
Porch...	
Total...	2,104

HOUSE CRAFT HOMES, L.L.C.
 12501 NW U.S. Hwy. 441 - Alachua, FL 32615
 Phone: (386) 462-5323/FAX: (386) 462-1509

Job name: BUTLER	
Model: MONROE	Type: ACLAYOUT
Location: X	Drawn By: JDH
Checked By: JDH	Revision Date: 8/18/07
Scale: NTS	Date: 8/18/07 Sheet: 4 of 4

REV.	DESCRIPTION	DATE



Client Name: BUTLER Model: CUSTOM

BANK: LAFAYETTE STATE BANK LOAN TYPE: (X) Cash
() Conventional
() F.H.A.
() V.A.

Kitchen:		Toilets	Color
Countertop		Master	
Cabinet Base		Hall	
Master Bath:		Other	
Countertop		NOTES:	
Cabinet Base			
Hall Bath:			
Countertop			
Cabinet Base			

Master Bath:		Color	Style	Pump
Shower X	Master		CORNER	
Shower Floor	Hall		STEEL	
Grout				
Hall Bath:		Bath 3		
Tub Surround		Tub Surround	+	
Tile Selection		Tile Selection		
Grout		Tile Selection		

GREAT ROOM, KITCHEN, DINING, FOYER	
CARPET	VINYL/FLOOR TILE

Interior Wall Color STU ☐ Wood
Interior Trim STU ☒ Flatcut Marble
☐ Hardplank Siding Woods

Range/Color STD WHITE
Hood/Color STD WHITE

Accrocrete/Main House _____ X _____
 Trim Package _____ MONROE _____
 Trim Color _____
 Exterior Door Colors _____
 Siding _____
 Soffit _____
 Shingles _____
 Style/Color _____
 Window Color _____

 Trim Type Colonial w/Classique Doors Skd.
 Colonial Grills Front Windows Standard

Master	(X) Obscure	() Clear Glass		
Hall	(X) Obscure	() Clear Glass	N/A	FRENCH DOOR


SUPER Energy Pac: Yes () No (X)

Well Allowance Yes () No (X)

Septic Allowance Yes (X) No ()

Power Company: X () Overhead (X) Underground

REV.	DESCRIPTION	DATE

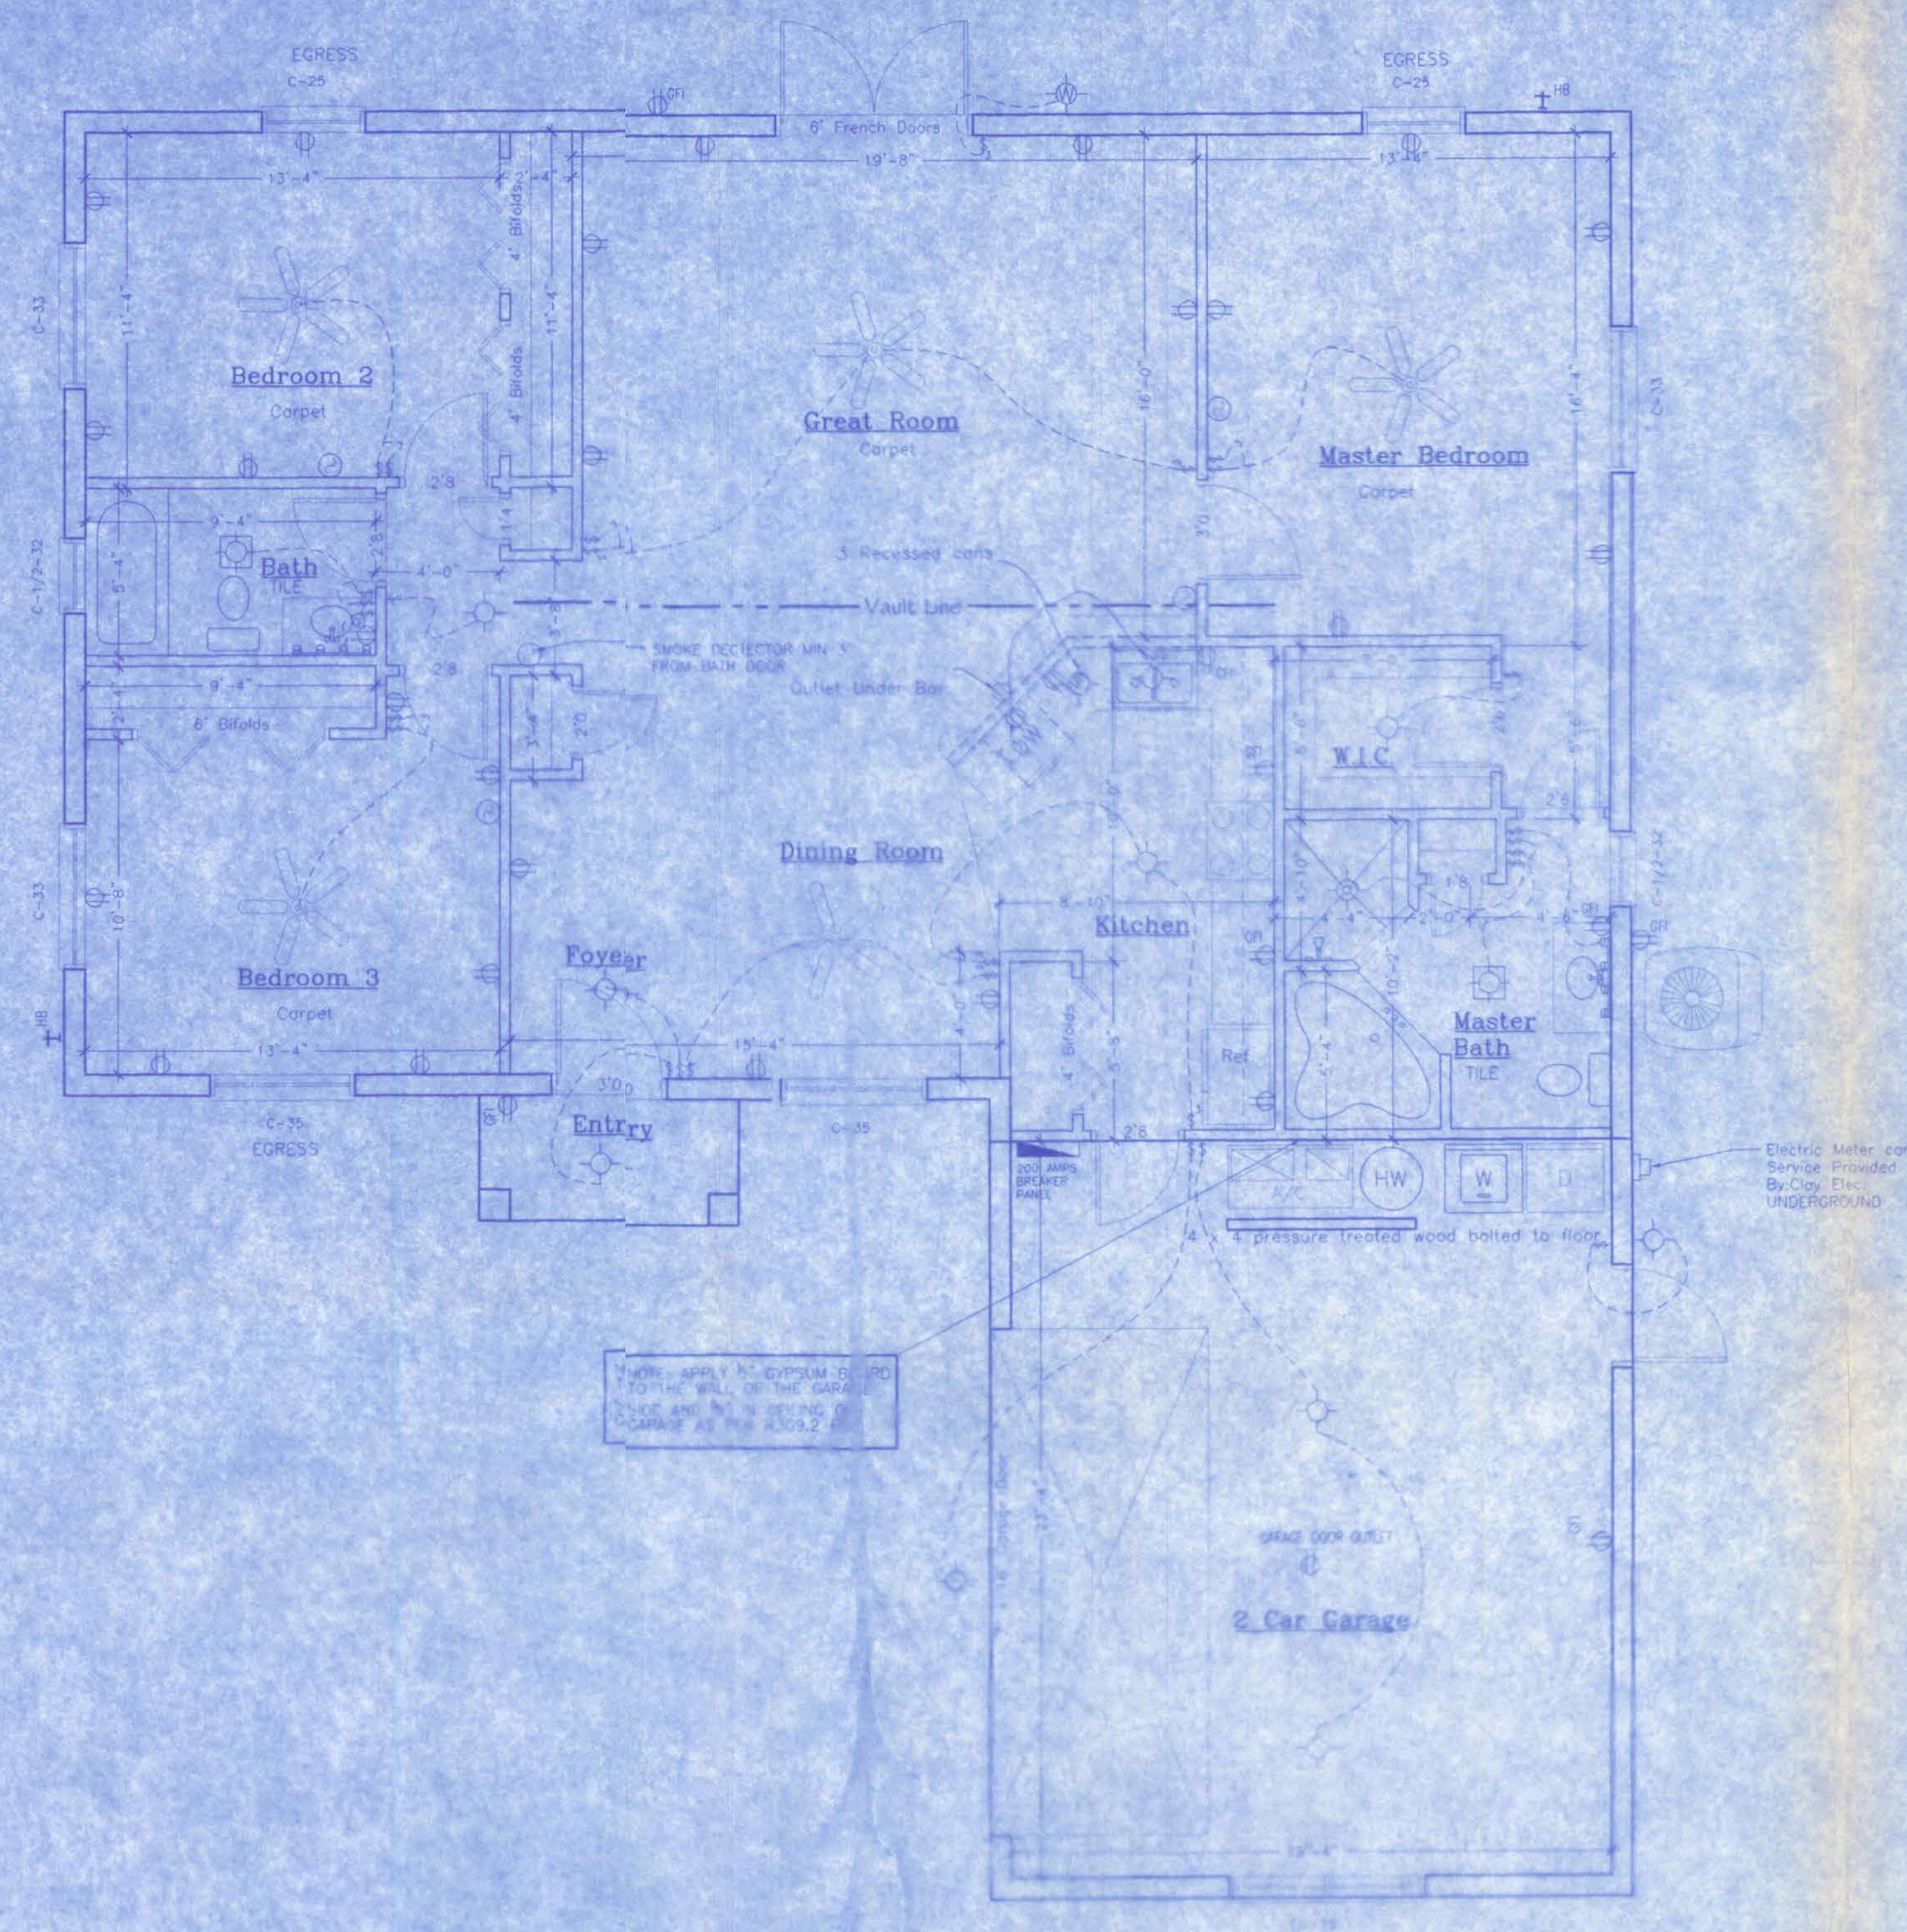

FLOOR PLAN

SCALE: 1/4" = 1'-0"

	FLUSH MOUNT DOUBLE FLUSH LIGHT FIXTURE
	DOUBLE FLUSH LIGHT FIXTURE
	PAN LIGHT VENTED TO EXTERIOR
	SURFACE MOUNTED INCANDESCENT FIXTURE

TWO OFF-DRIVEWAYS IN REAR
ONE OR TWO OFF-YS IN REAR, LOOED TOGETHER
OFF IN GARAGE, FRONT ENTRY, AND REAR PORCH LOOED TOGETHER
ONE OR TWO OFF-DRIVEWAYS IN REAR
TWO OFF-DRIVEWAYS PROVIDED FOR REAR

CODE COMPLIANCE - This building is designed to comply with the requirements of the 2004 International Building Code, which is the minimum code required for all buildings in the state of California. The building is designed to comply with the requirements of the 2004 International Building Code, which is the minimum code required for all buildings in the state of California.

a. Uniformly Distributed Live Loads	(Section 1604.1)		
Floor Live Loads	psf	psf	
b. Roof Live Loads	(Section 1604.6)		
S12 Pitch	18	psf	
c. Wind Loads	(Section 1609.6)		
1.) Enclosure Classification	Enclosed		
2.) Basic Wind Speed (3 second gust)	110	mph	
3.) Wind Impedance Factor, I_w	1.0		
4.) Exposure Category	B		
5.) Internal Pressure Coefficients:	+0.18, -0.18		
6.) Design Wind Pressures for Doors and Windows	Opening Area (sf)	Import Pressure (psf)	Outward Pressure (psf)
	0-10	21.5	-29.1
	11-20	20.8	-27.2
	21-50	19.5	-24.6
	51-100	18.6	-23.0

- 24. DUPLEX CONVENIENCE RECEPTACLE WITH GROUND (ALL DENOTES HEIGHT A.F.F. IF OTHER THAN STD.) (TO/FC/PO/PC DENOTES GROUND FAULT CIRCUIT INTERRUPTER (W/ DENOTES WEATHER PROOF))
- 25. SPECIAL RECEPTACLE WITH GROUND, SEE SPECIFICATIONS
- 26. SINGLE POLE SWITCH AT STANDARD HEIGHT
- 27. THREE WAY SWITCH AT STANDARD HEIGHT
- 28. TELEPHONIC OUTLET
- 29. CEILING MOUNTED EXHAUST FAN VENTED TO EXTERIOR
- 30. CABLE TV OUTLET
- 31. ELECTRICAL DISTRIBUTION PANEL
- 32. SMOKE DETECTOR
- 33. SUMP PUMP


Square Footage

Living...	1,594
Garage...	496
Entry...	32
Porch...	
Total...	2,122




12501 NW U.S. Hwy. 441 - Alachua, FL 32615
Phone: (386) 462-5323/FAX: (386) 462-1509


Job name:		BUTLER	
Model:	MONROE	Type:	PLAN
Location: SUWANNEE COUNTY		Drawn By: J.D.H.	
Checked By: J.D.H.		Revision Date: 2/6/08	
Scale: 1/4" = 1'	Date: 10/28/07	Sheet: 2 of 4	

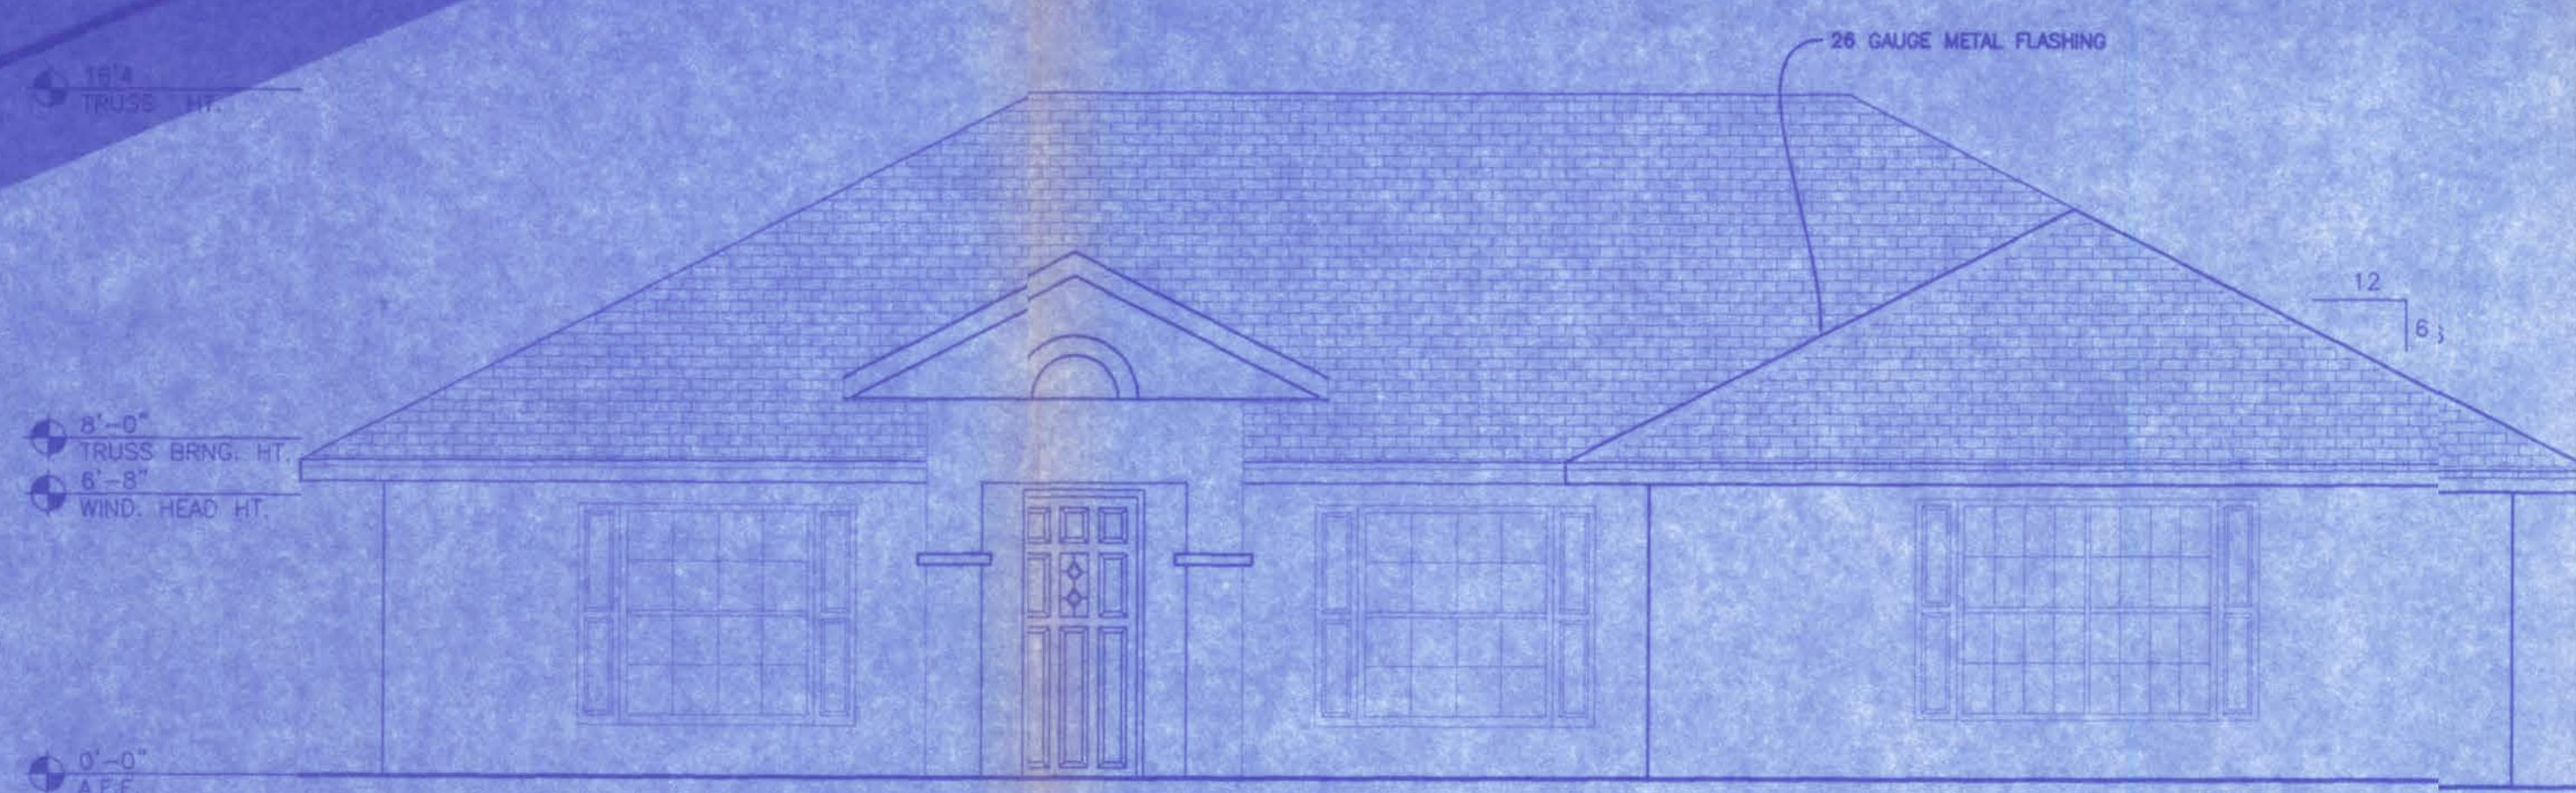


FRONT ELEVATION
SCALE: 1/4"=1'-0"

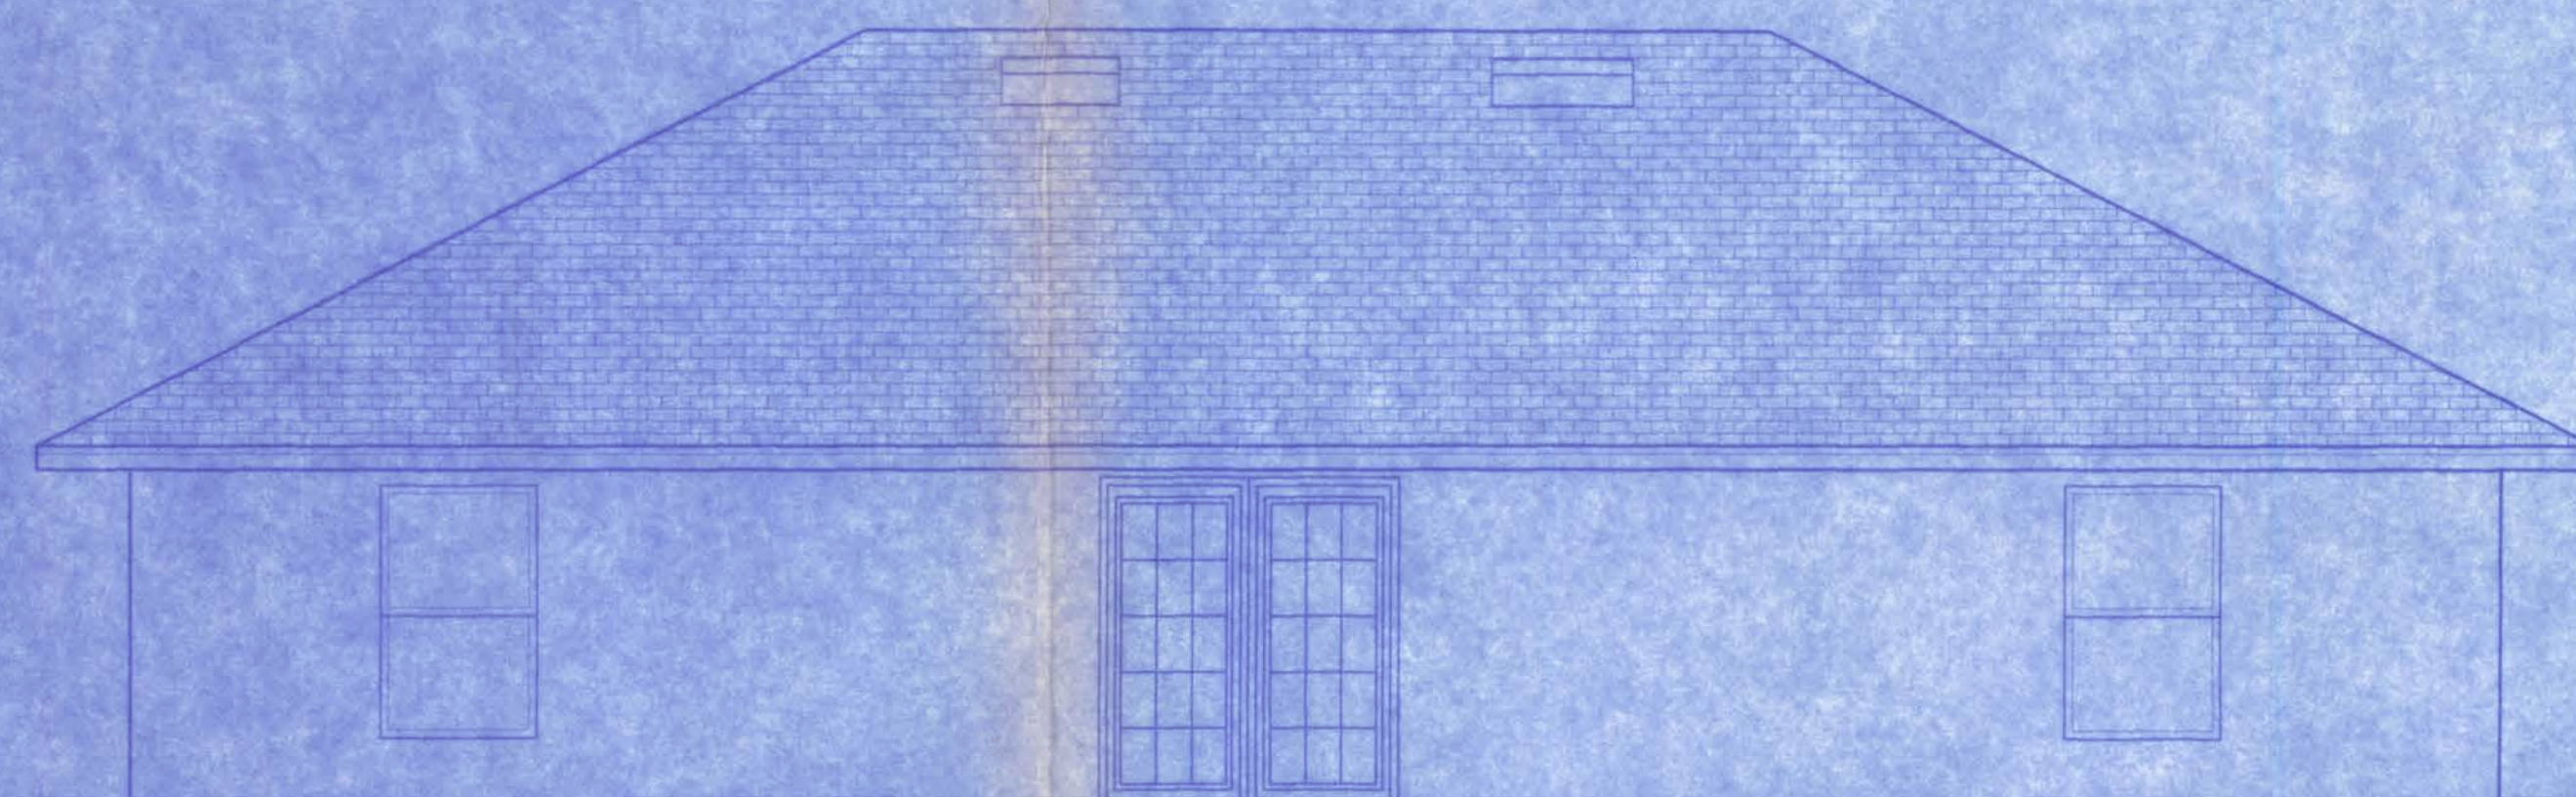

BACK ELEVATION
SCALE: 1/4"=1'-0"

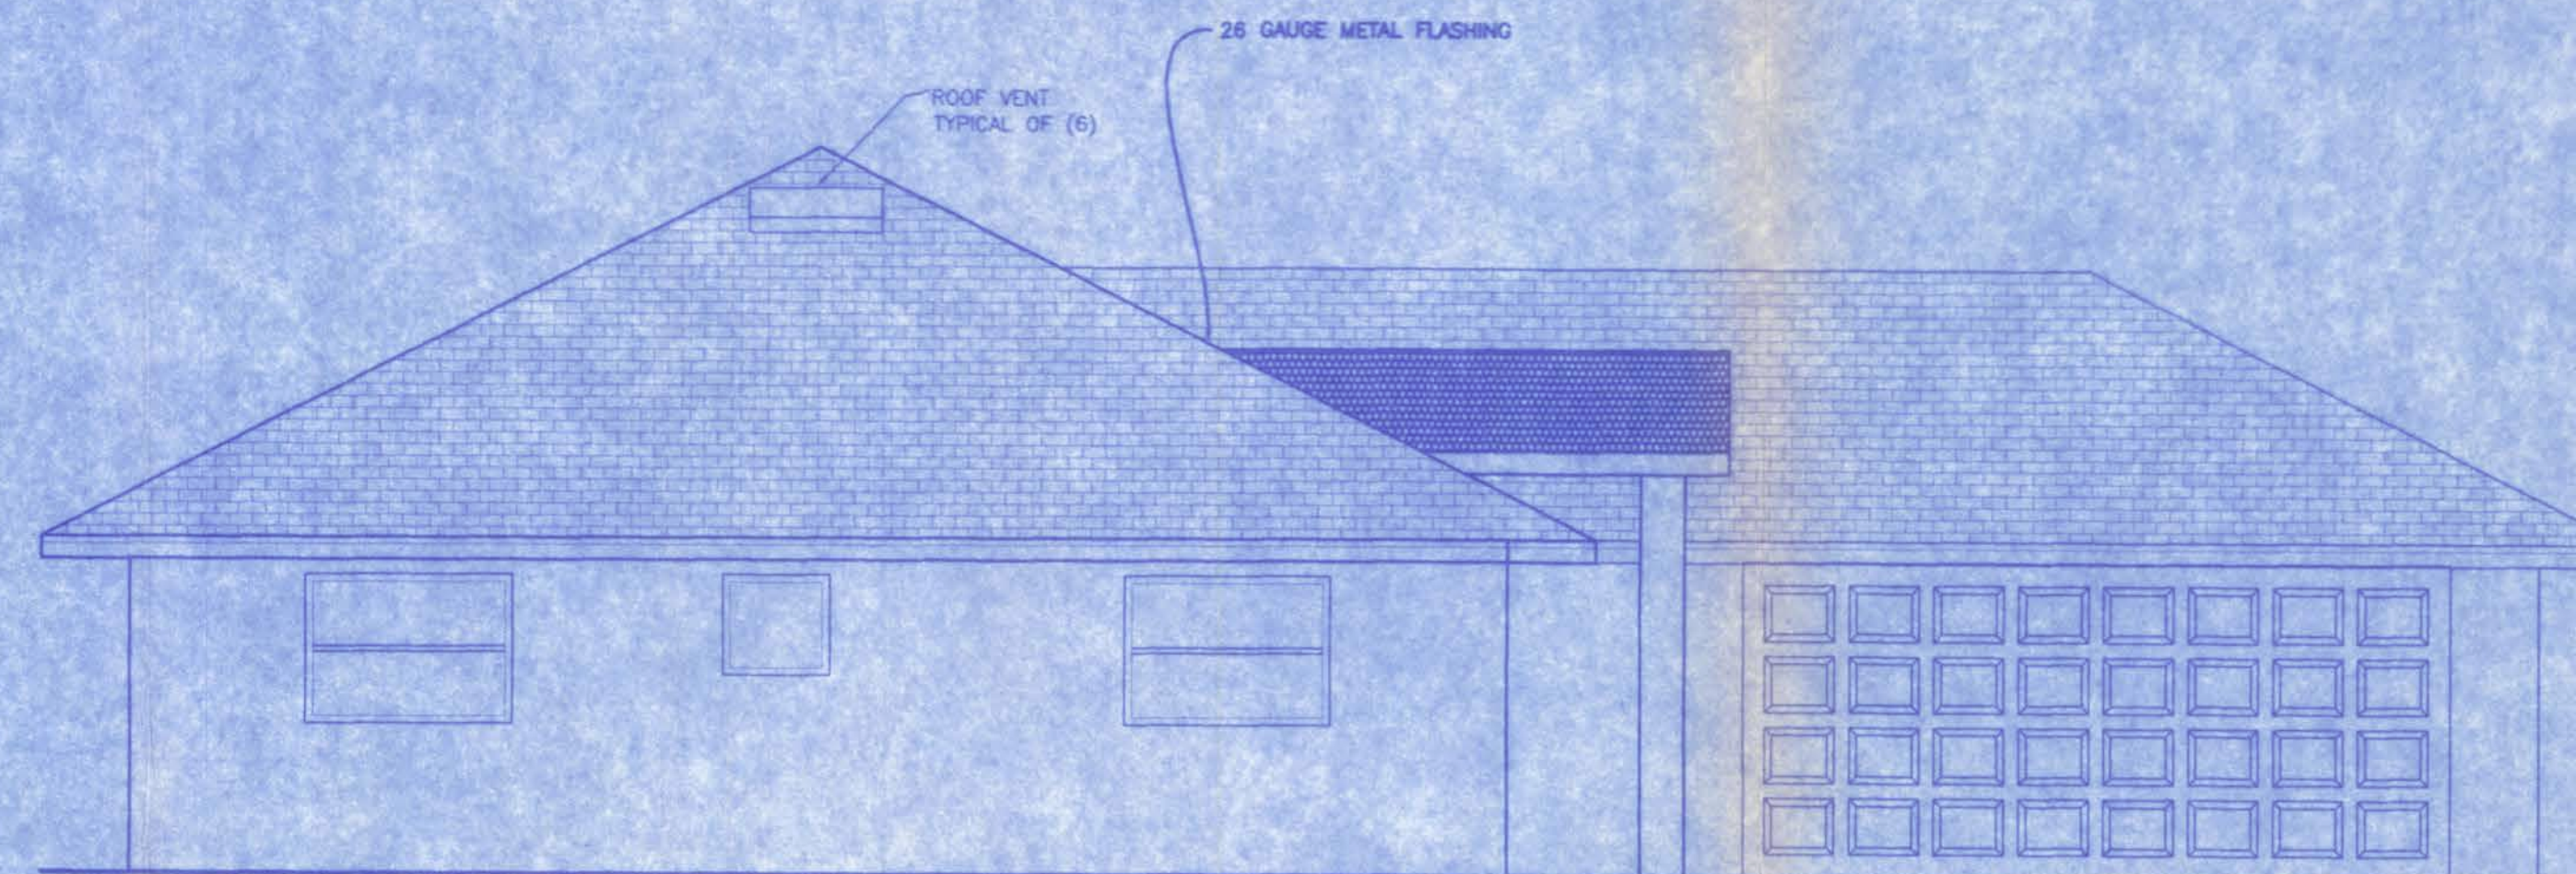

LEFT ELEVATION
SCALE: 1/4"=1'-0"

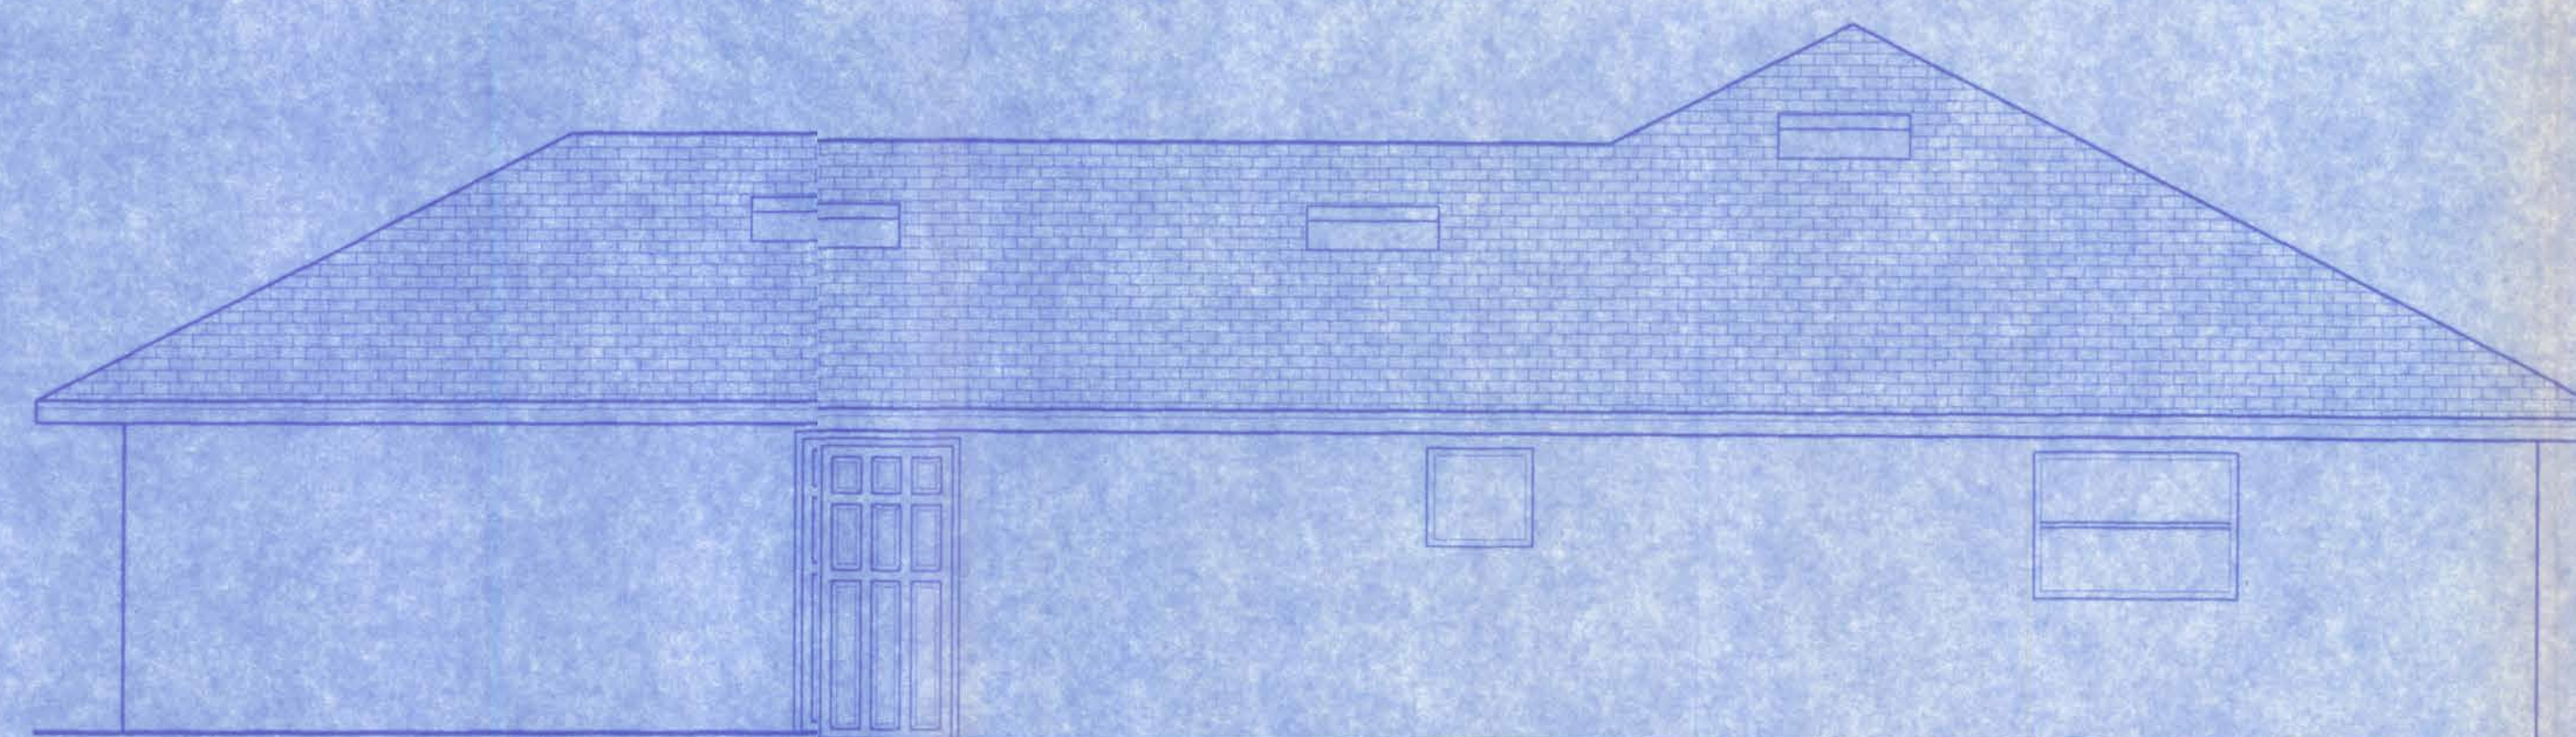

RIGHT ELEVATION
SCALE: 1/4"=1'-0"

ROOF VENT SCHEDULE

2,104 SQ. FT./300 = 7.01 SQ. FT. VENT REQUIRED
214.67 L. FT. x2/35 = 12.26 SQ. FT. VENT PROVIDED
6 STANDARD ROOF VENTS x 0.72 = 4.32 SQ. FT. PROVIDED
7.01 REQUIRED = 16.58 PROVIDED

HOUSE CRAFT HOMES, L.L.C.
12501 NW U.S. Hwy. 441 - Alachua, FL 32615
Phone: (386) 462-5323/FAX: (386) 462-1509

Job name: **BUTLER**
Model: **MONROE** Type: **ELEVATIONS**
Location: **SUWANNEE COUNTY** Drawn By: **J.D.H.**
Checked By: **J.D.H.** Revision Date: **2/6/06**
Scale: **1/4"=1'** Date: **10/28/07** Sheet: **3** of **4**