


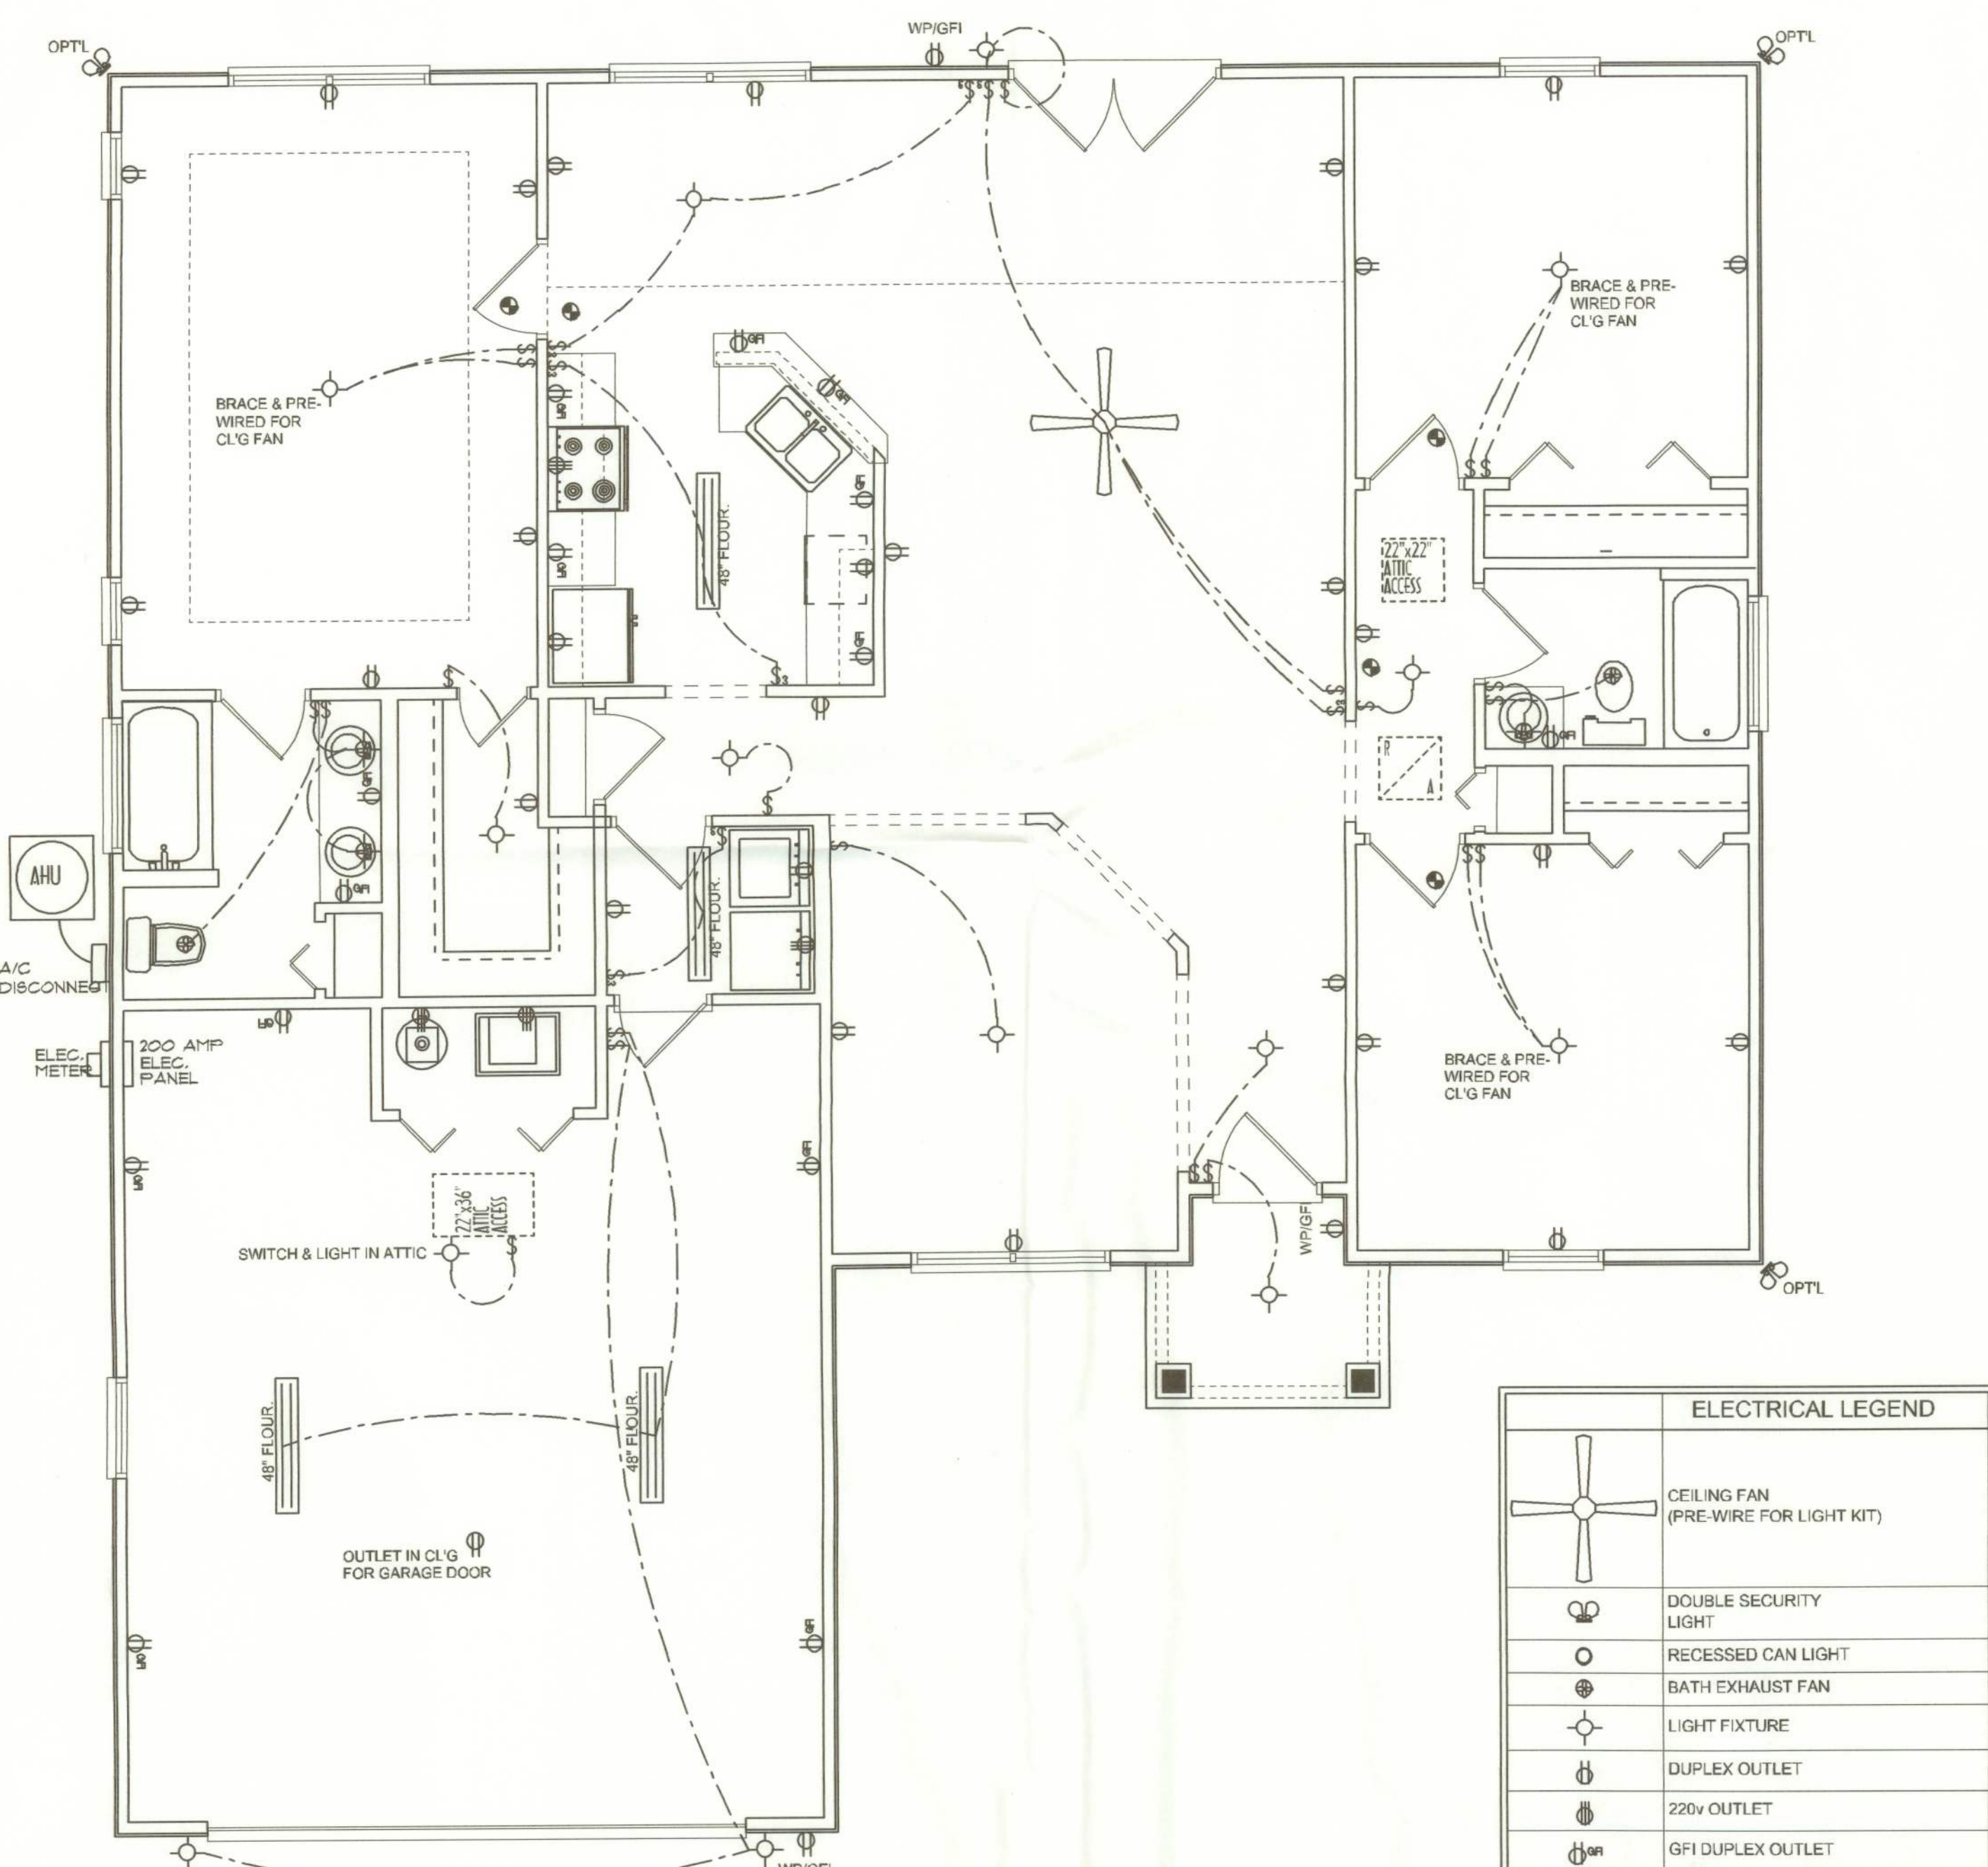


ELECTRICAL PLAN
SCALE: 1/4" = 1'-0"

ELECTRICAL LEGEND	
	CEILING FAN (PRE-WIRE FOR LIGHT KIT)
	DOUBLE SECURITY LIGHT
	RECESSED CAN LIGHT
	BATH EXHAUST FAN
	LIGHT FIXTURE
	DUPLEX OUTLET
	220v OUTLET
	GFI DUPLEX OUTLET
	SMOKE DETECTOR (see note below)
	WALL SWITCH
	3 WAY WALL SWITCH
	WATER PROOF GFI OUTLET
	2 OR 4 TUB FLUORESCENT FIXTURE

NOTE:
ALL BEDROOM RECEPTACLES SHALL BE AFCI
(ARC FAULT CIRCUIT INTERRUPT)

ALL SMOKE DETECTORS SHALL HAVE BATTERY BACKUP POWER
AND ALL WIRED TOGETHER SO IF ANY ONE UNIT IS ACTUATED THEY
ALL ACTIVATE.

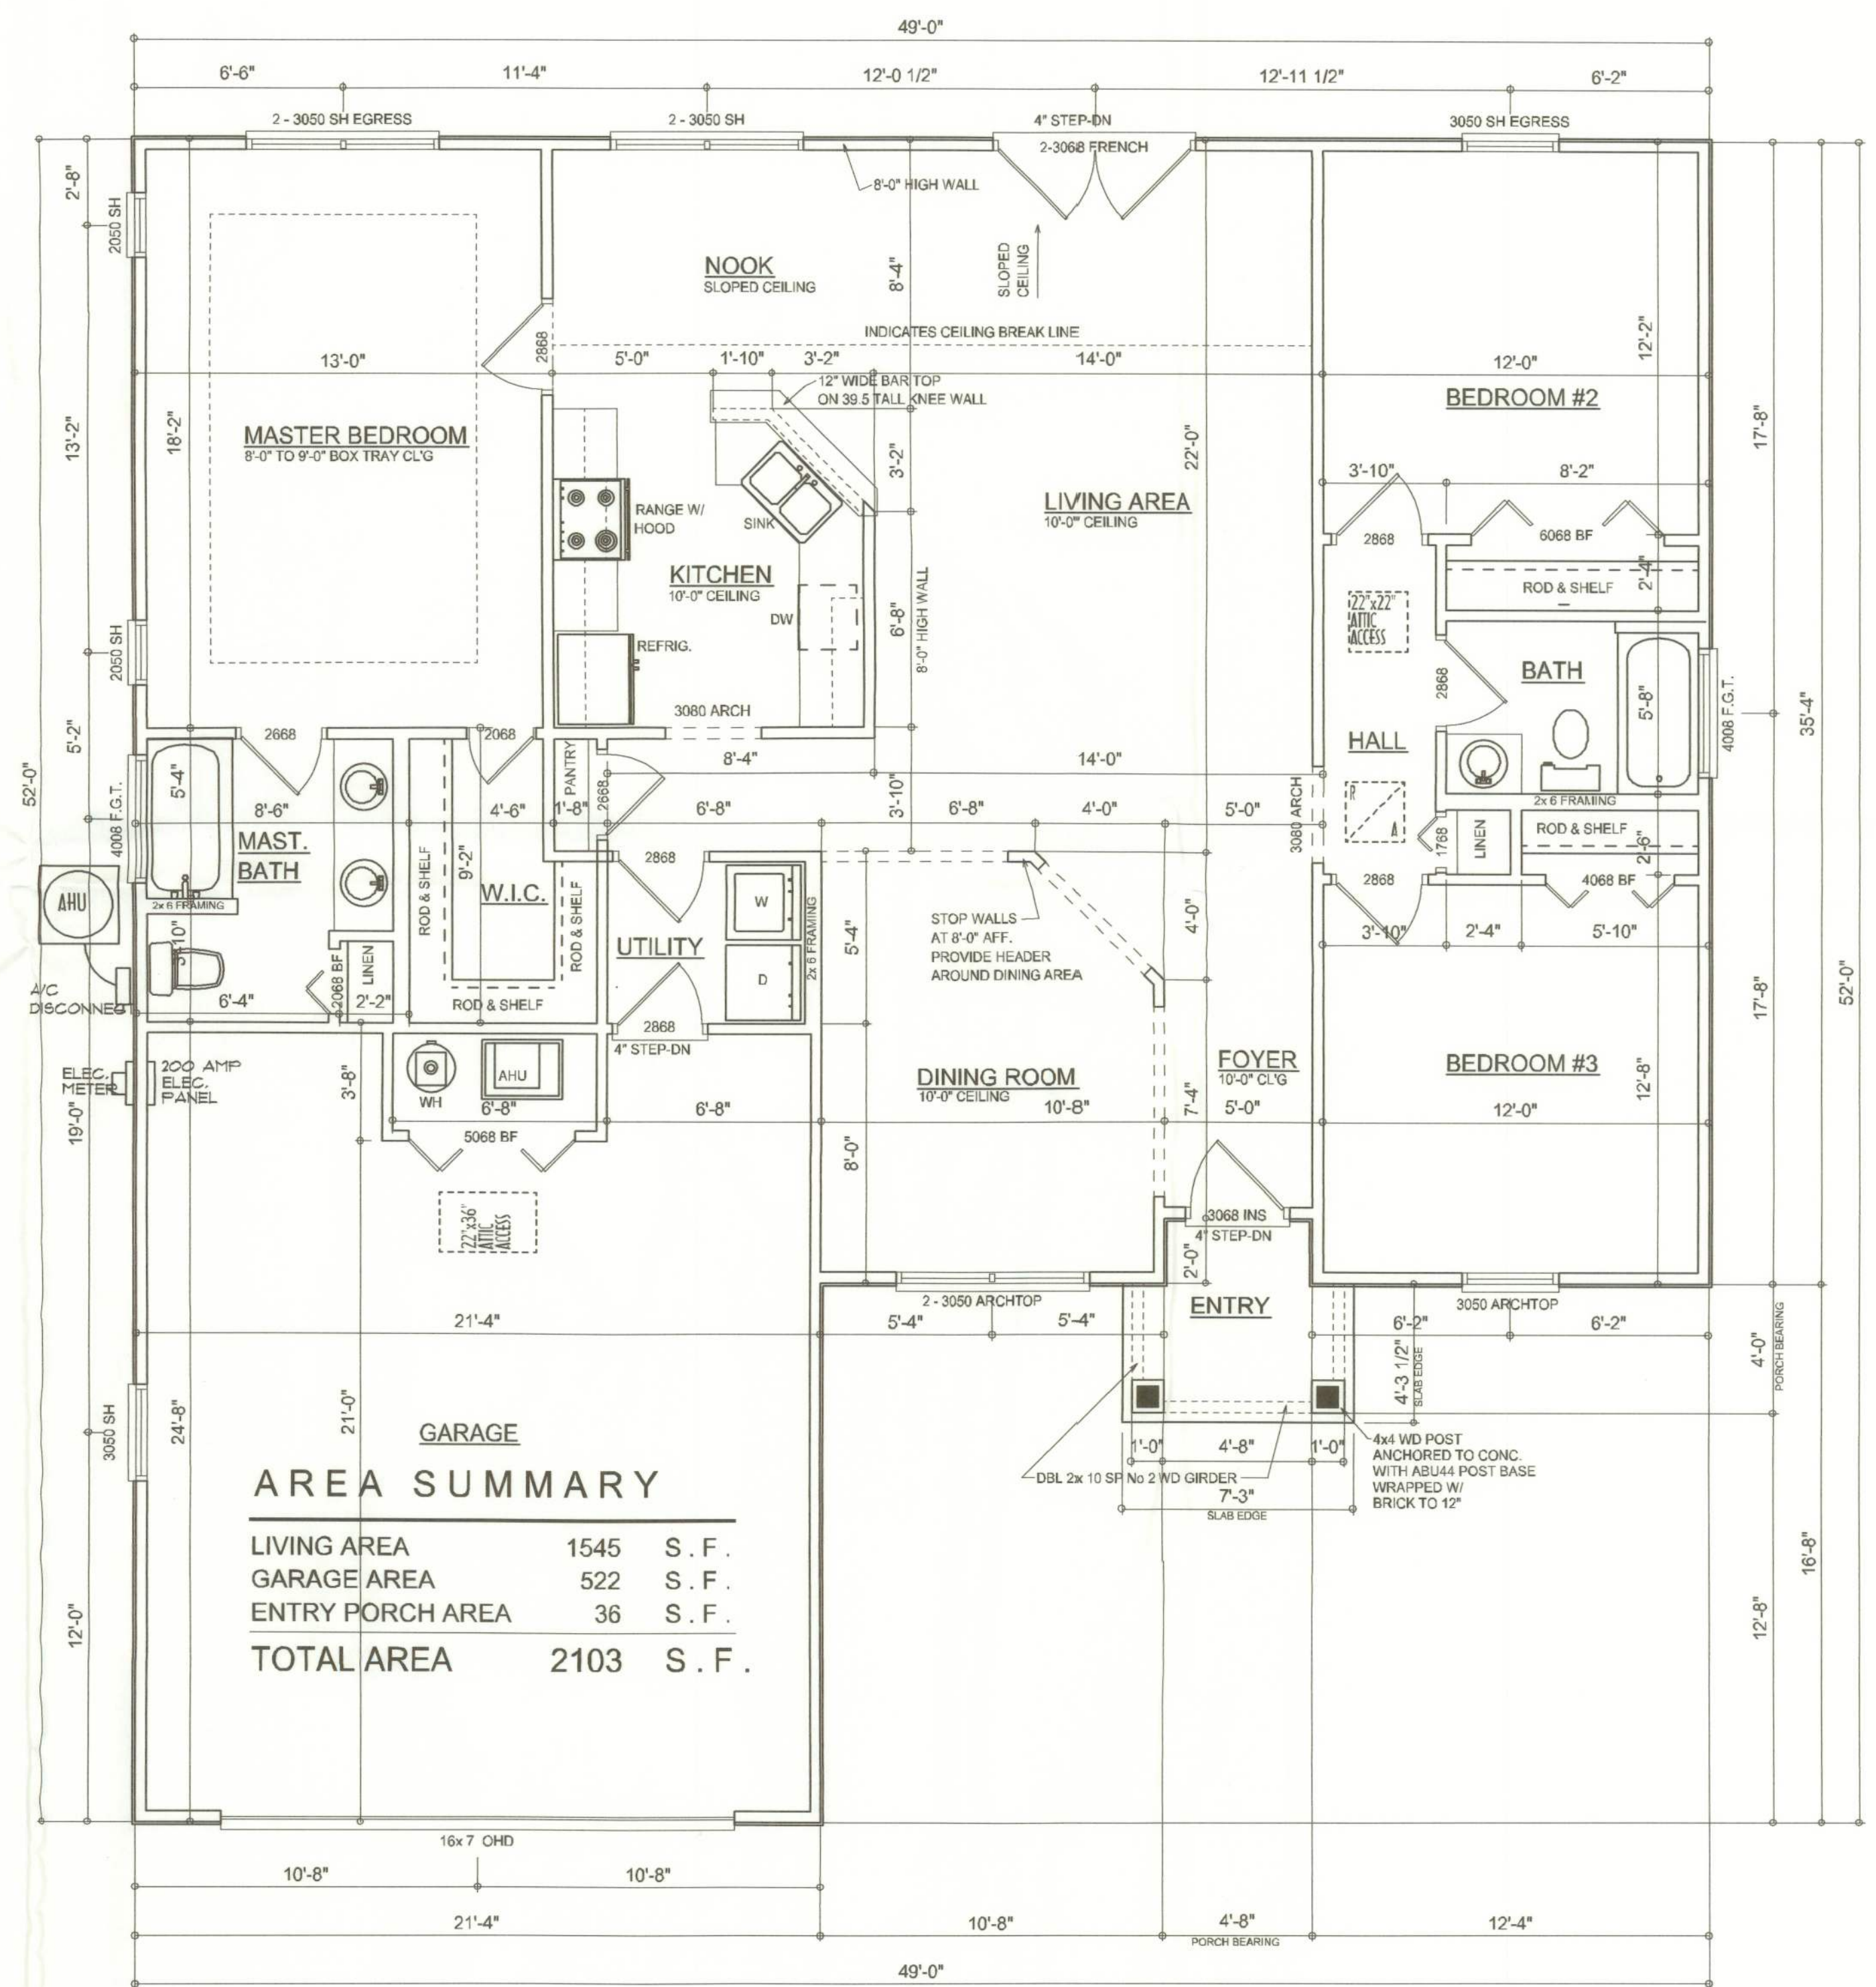

AREA SUMMARY		
LIVING AREA	1545	S. F.
GARAGE AREA	522	S. F.
ENTRY PORCH AREA	36	S. F.
TOTAL AREA	2103	S. F.

FLOOR PLAN
SCALE: 1/4" = 1'-0"
NOTE: CEILING HEIGHTS SHALL BE 8'-0" UNLESS OTHERWISE NOTED

REVISIONS
September 07, 2005



FLOOR PLAN
SCALE: 1/4" = 1'-0"

ELECTRICAL PLAN
SCALE: 1/4" = 1'-0"

THE 1545 MODEL FOR:
LOT 37, CANNON CREEK PLACE
ROB STEWART, LC. P.O. BOX 3001, LAKE CITY, FLORIDA 32056

©WILLIAM MYERS
DESIGN
P.O. BOX 1613
LAKE CITY, FL 32056
(386) 758-8406
will@willmyers.net



JOB NUMBER
050903

SHEET NUMBER
A.3
OF 3 SHEETS

Wm Myers