




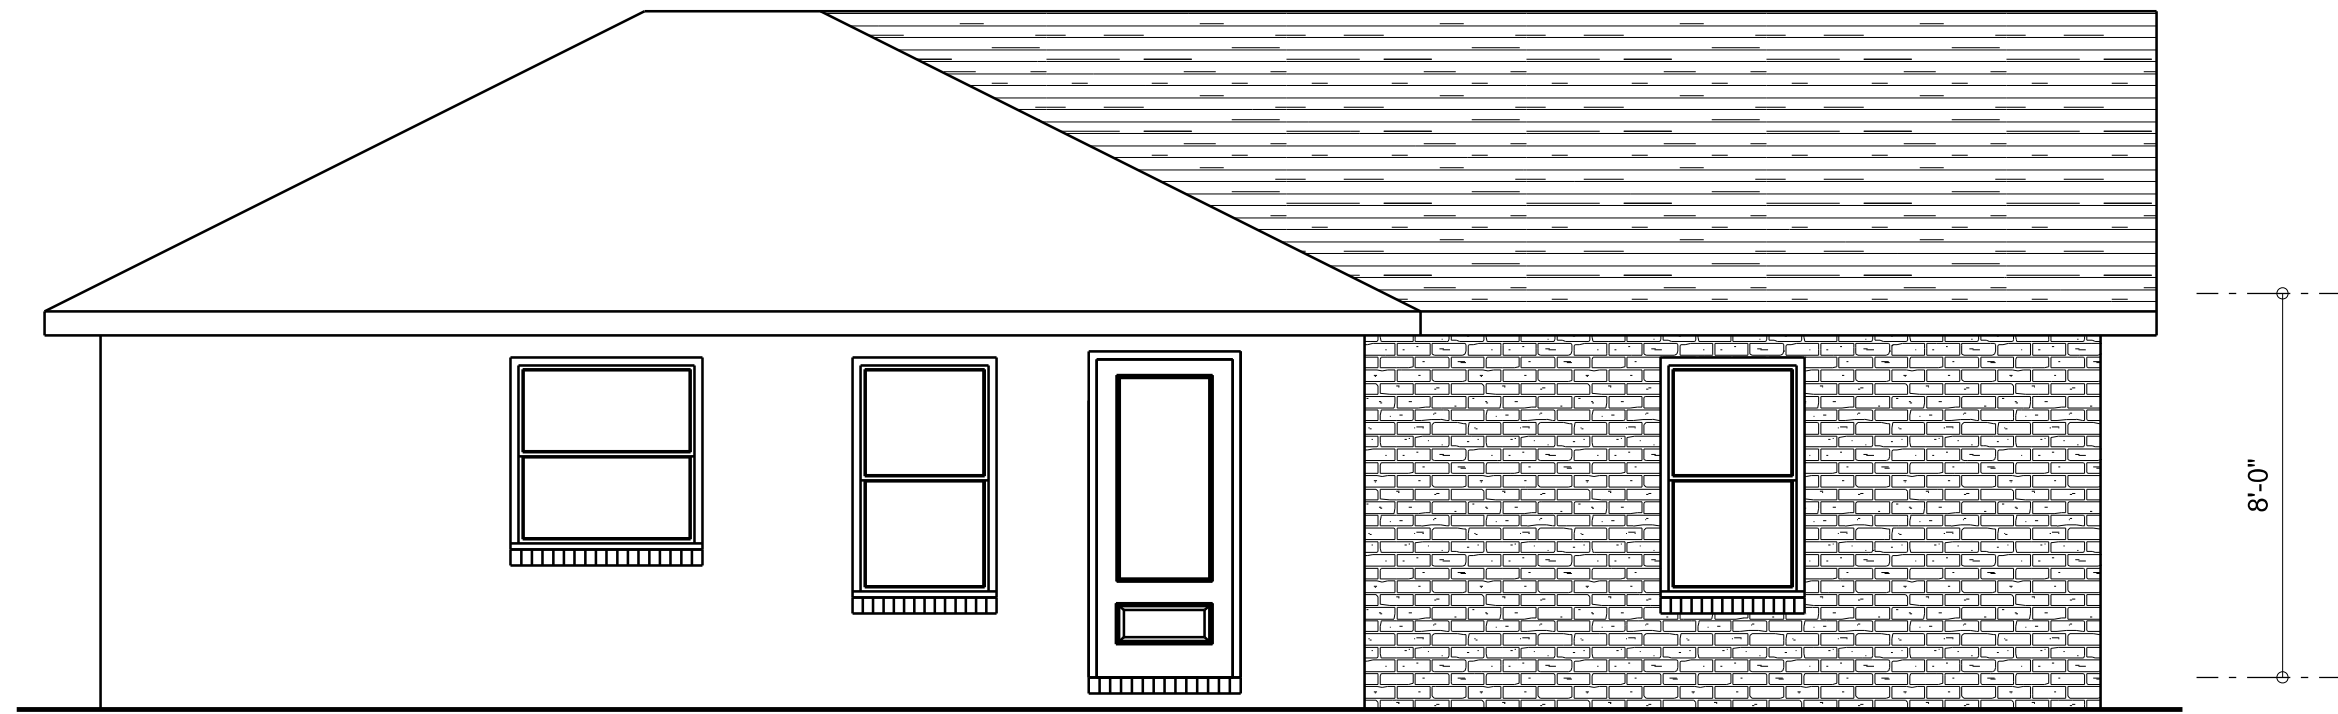


LEFT ELEVATION
SCALE: 1/4" = 1'-0"

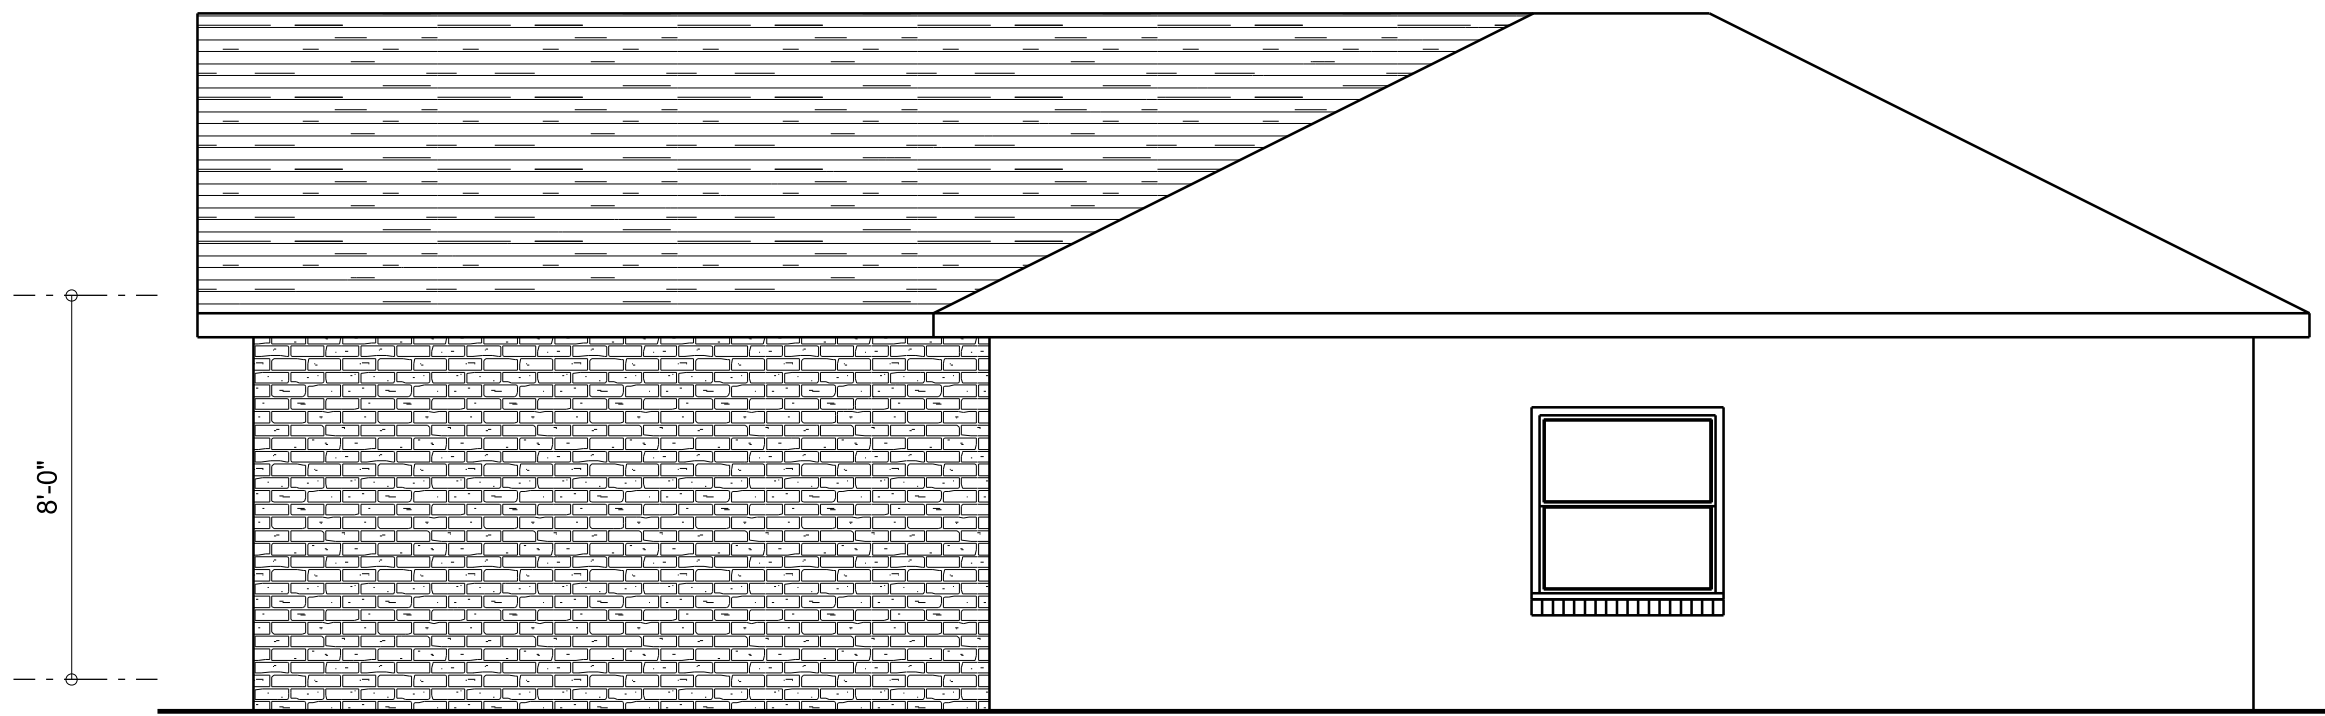

RIGHT ELEVATION
SCALE: 1/4" = 1'-0"

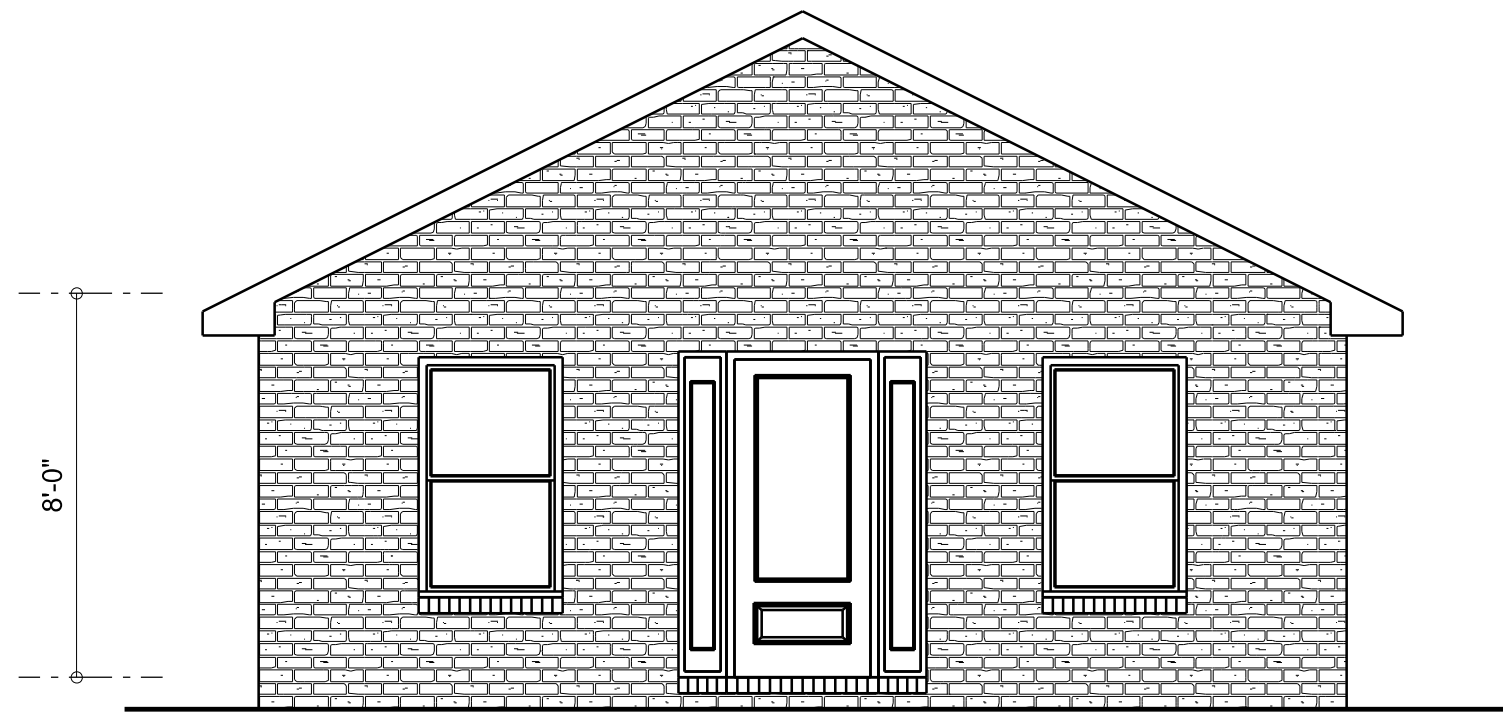

FRONT ELEVATION
SCALE: 1/4" = 1'-0"

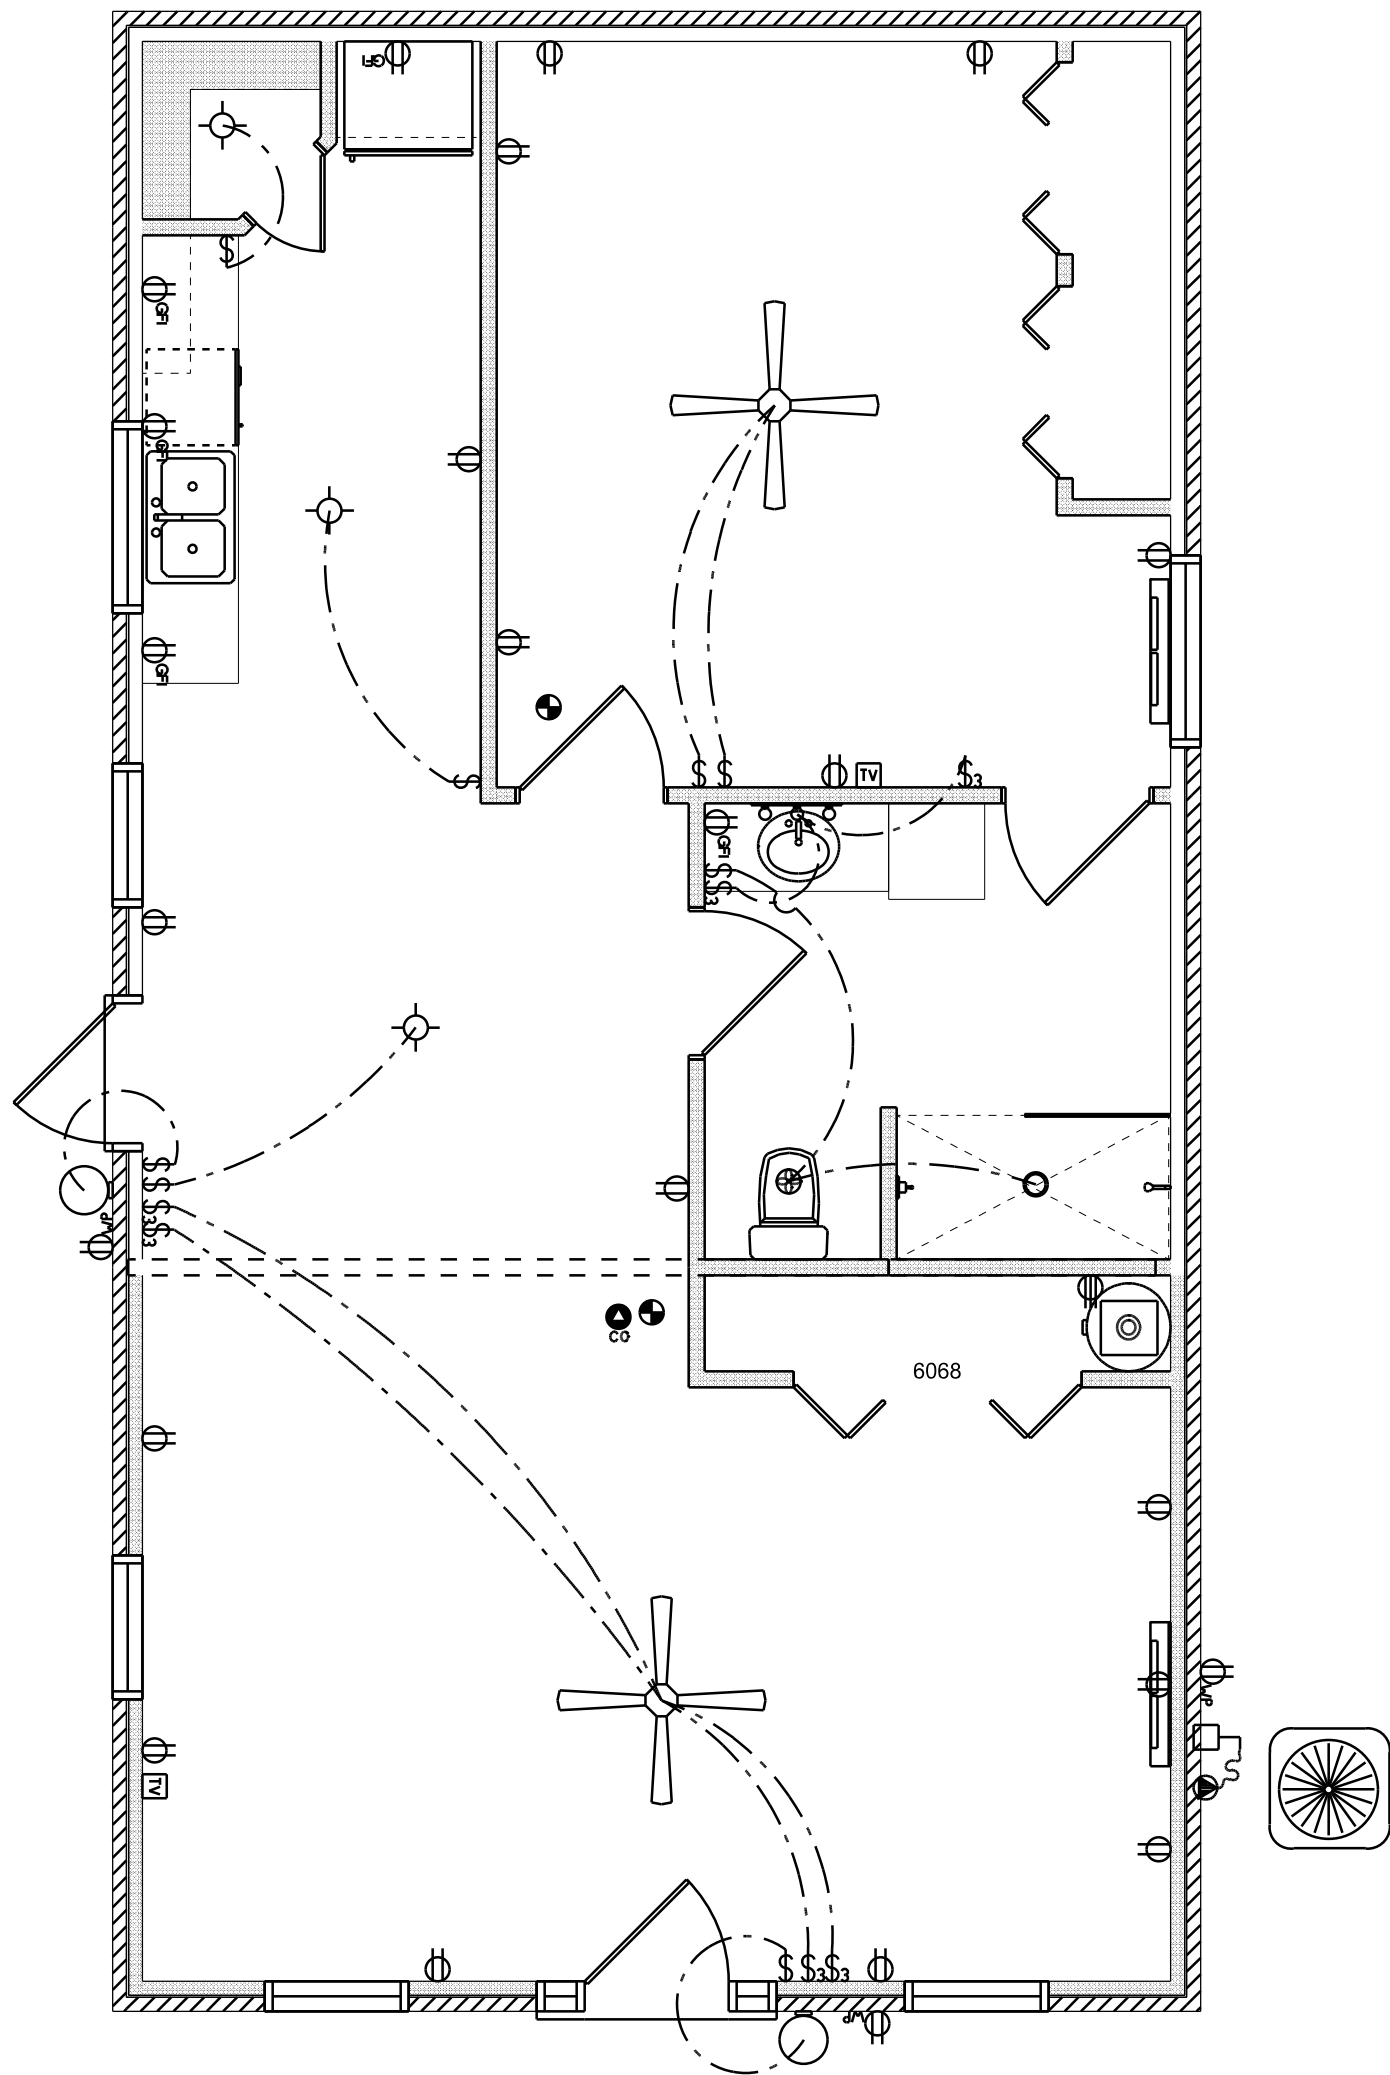

ELECTRICAL PLAN
SCALE: 1/4" = 1'-0"


ELECTRICAL PLAN NOTES:

INSTALLATION SHALL BE PER LATEST NAT'L. ELECTRIC CODE.
WIRE ALL APPLIANCES, HVAC UNITS AND OTHER EQUIPMENT PER MANUF. SPECIFICATIONS
CONSULT WITH THE OWNER FOR THE NUMBER OF SEPERATE TELEPHONE LINES TO BE INSTALLED
ALL SMOKE DETECTORS SHALL BE 120V W/ BATTERY BACKUP OR THE PHOTOELECTRIC TYPE, AND SHALL BE INTERLOCKED TOGETHER. INSTALL INSIDE AND NEAR ALL BEDROOMS
LOCATION(S)/ROUTING / DEPTH, RISER DIA. SHALL INCLUDE WIRE SIZES/TYPE & EQUIPMENT TYPE W/ RATINGS & LOADS.
ALL RECEPTALS IN WET AREAS SHALL BE GROUND FAULT INTERRUPTER TYPE (GFI)
ALL EXTERIOR RECEPTALS SHALL BE WEATHERPROOF GROUND FAULT INTERRUPTER TYPE (WP/GFI)


ELECTRICAL LEGEND		
ELECTRICAL	COUNT	SYMBOL
CEILING FAN	2	
CAN LIGHT 6inch	1	
EXTERIOR SCONCE	2	
CABLE TV OUTLET	2	
CARBON DETECTOR	1	
EXHAUST FAN	1	
OUTLET	2	
SMOKE DETECTOR	2	
STANDARD LIGHT	3	
SWITCH	8	
SWITCH 3 WAY	6	
outlet	16	
outlet gfi	5	
outlet wp	3	
VANITY BAR LIGHT - SMALL	1	
AC DISCONNECT	1	
OUTLET 220v	1	

AREA SUMMARY		
EXISTING	470	S.F.
ADDITION	330	S.F.
NEW TOTAL	800	S.F.

RENOVATED FLOOR PLAN
SCALE: 1/4" = 1'-0"

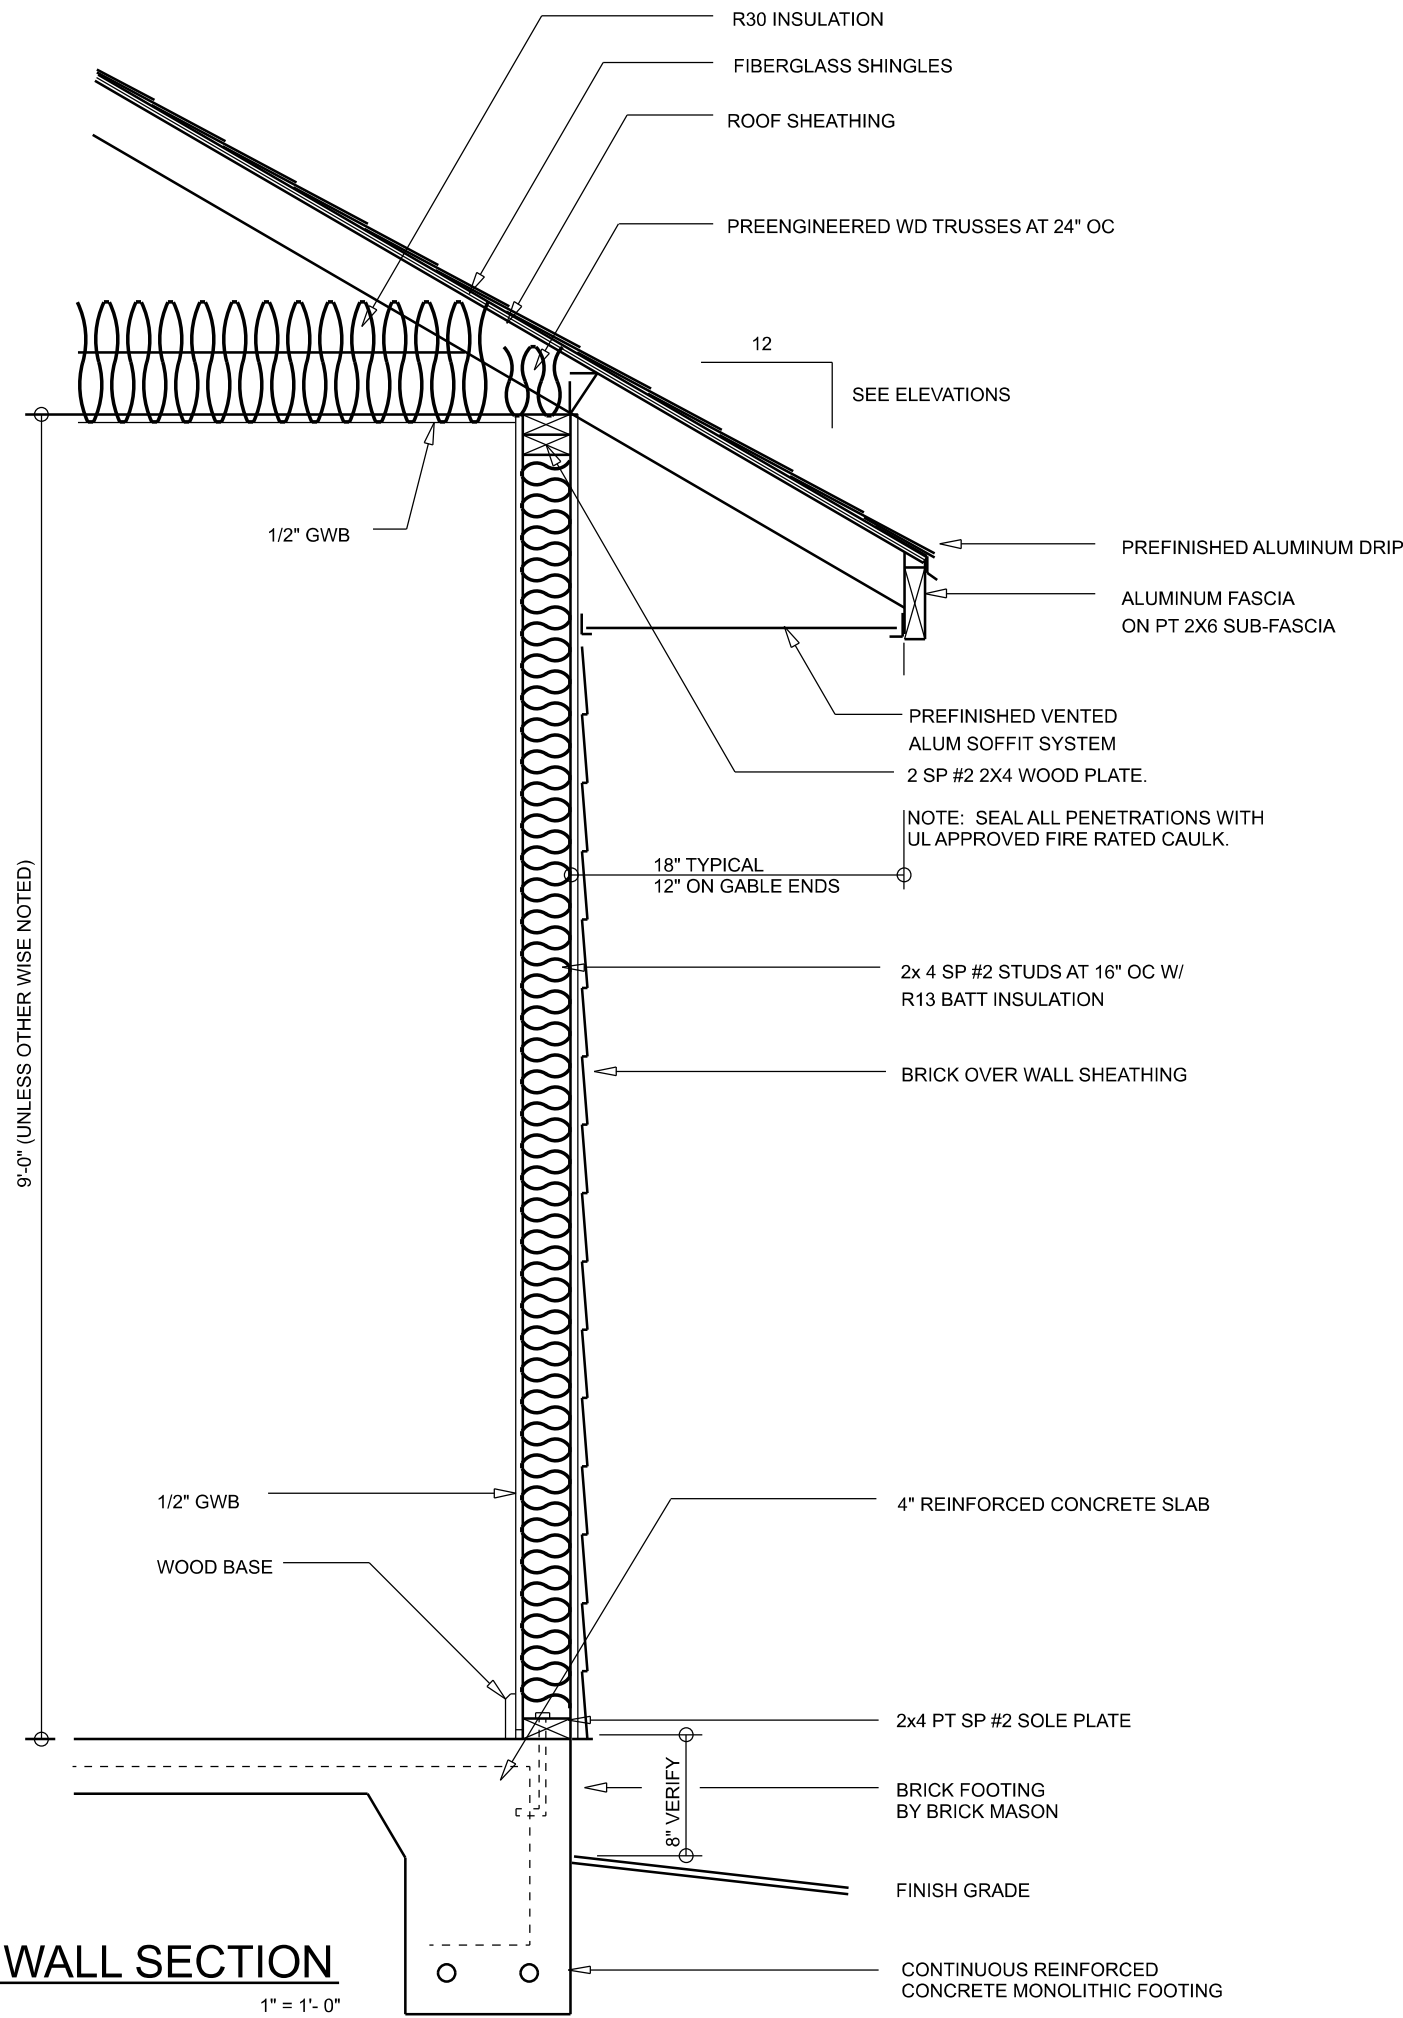

TYPICAL WALL SECTION
SCALE: 1" = 1'-0"

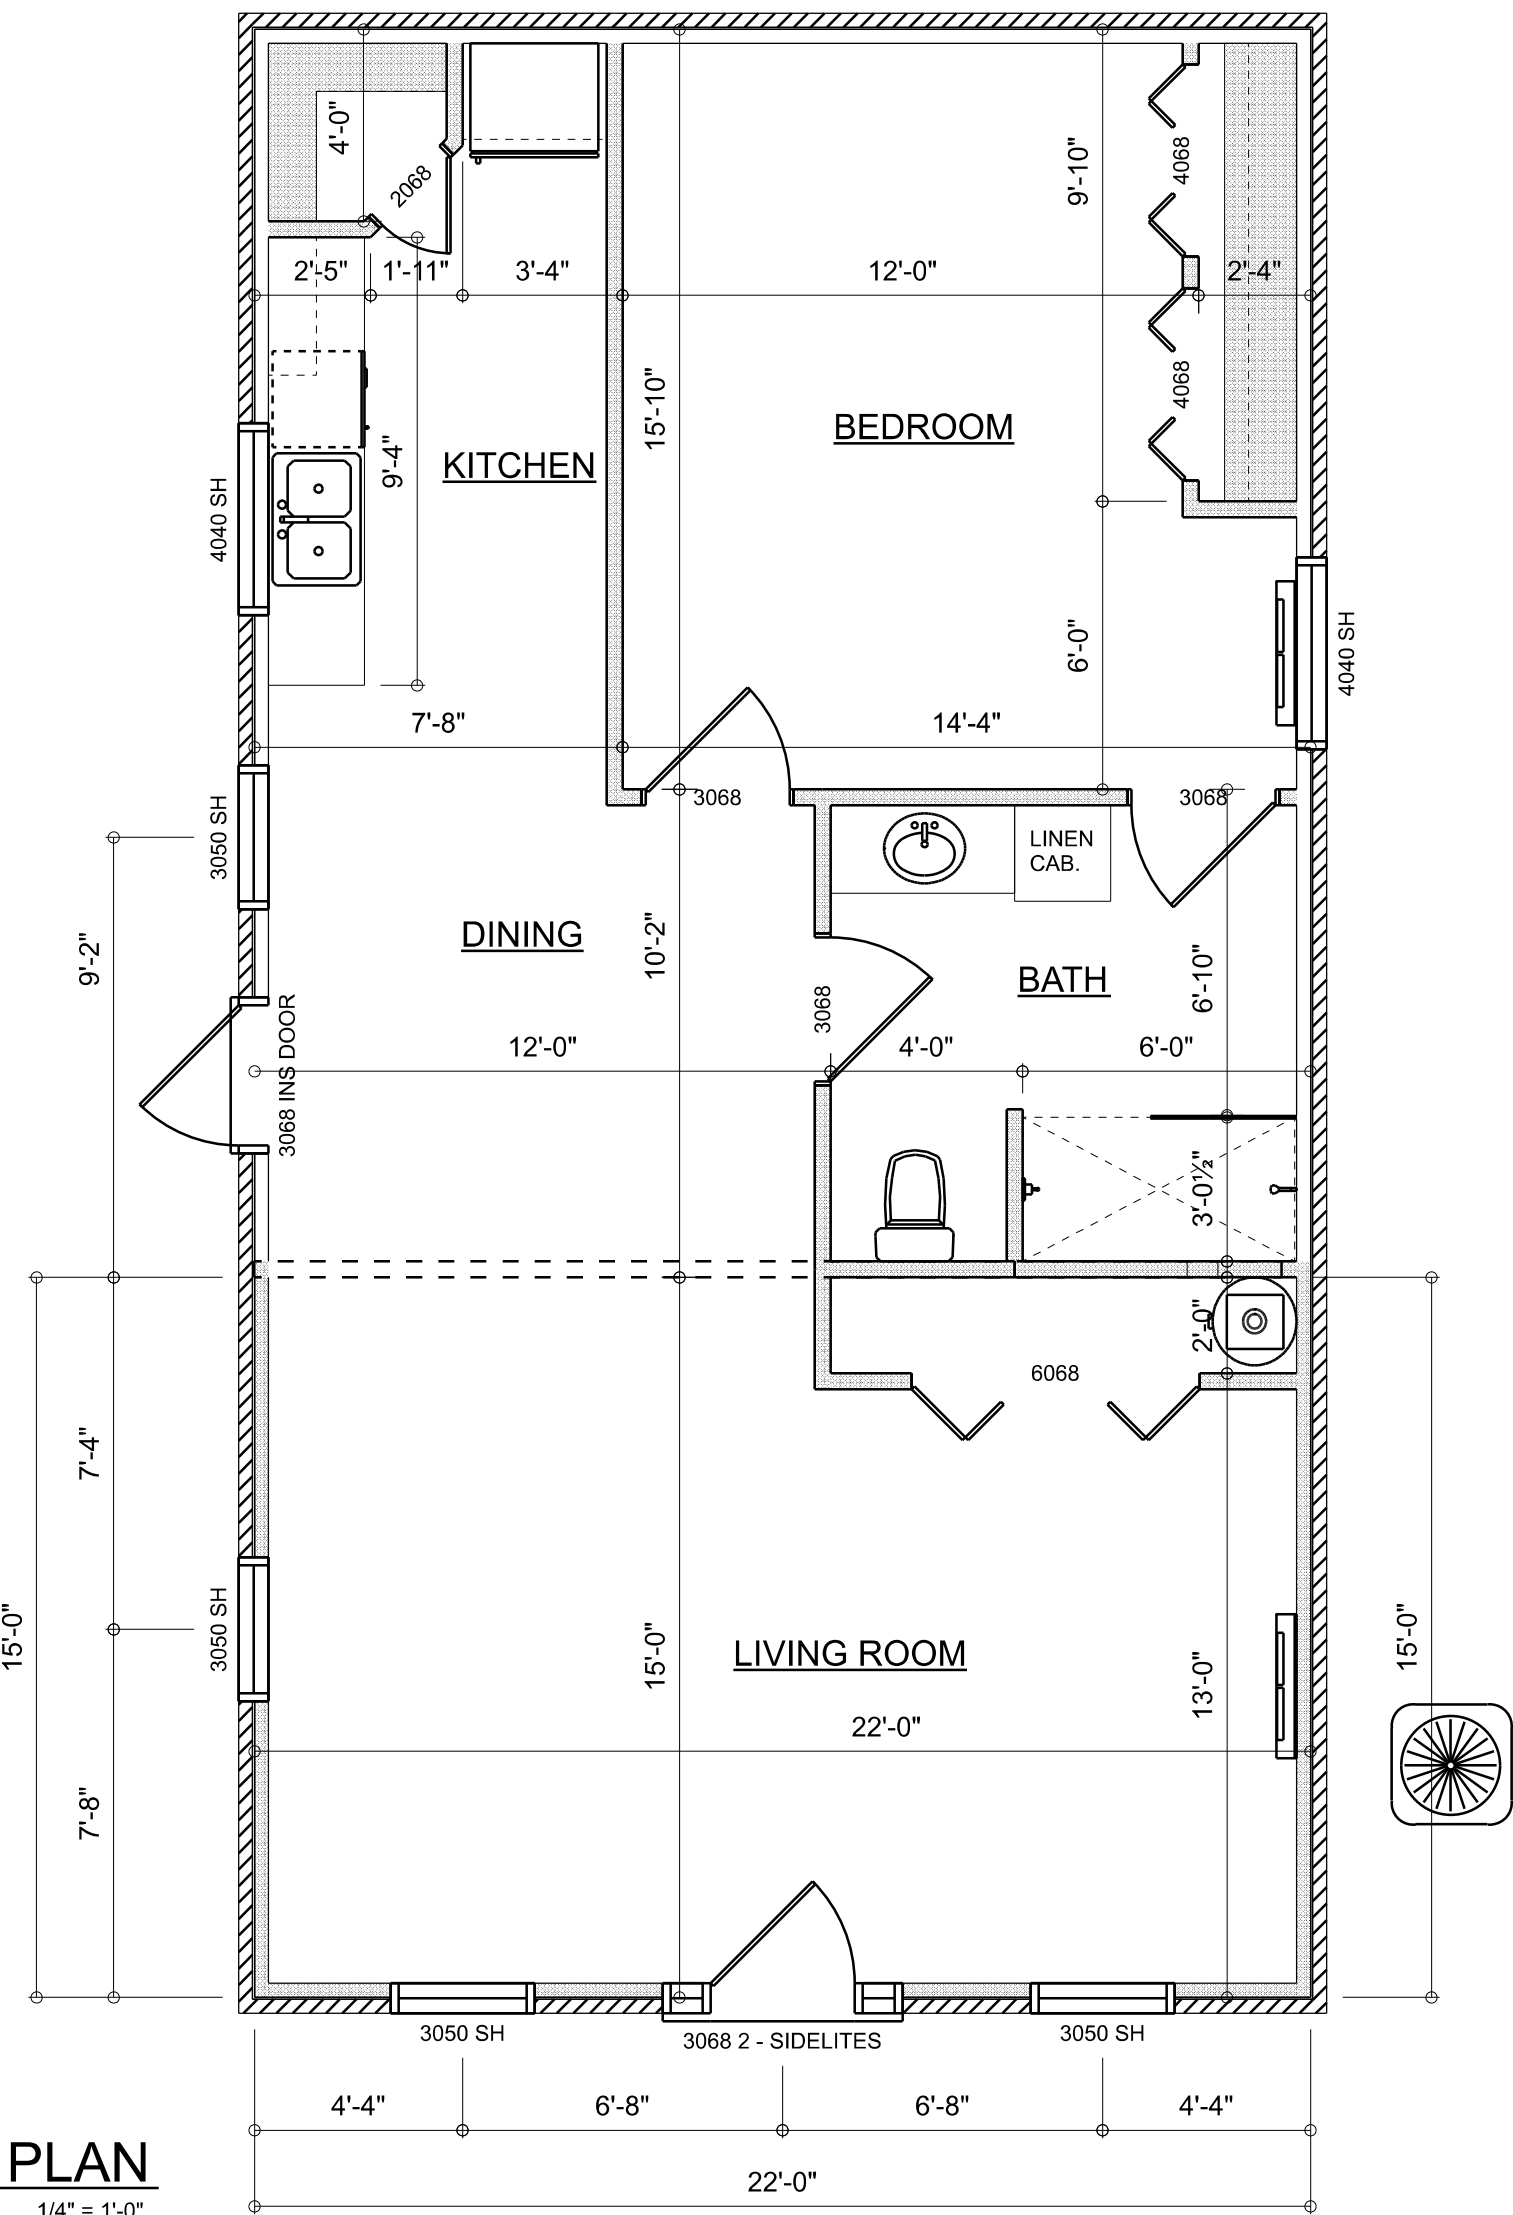

EXISTING RENOVATION FOR:

EASOM RESIDENCE

150 SW BETHANY PLACE, LAKE CITY, FL 32024



SHEET NUMBER

A.1

OF 1 SHEETS