



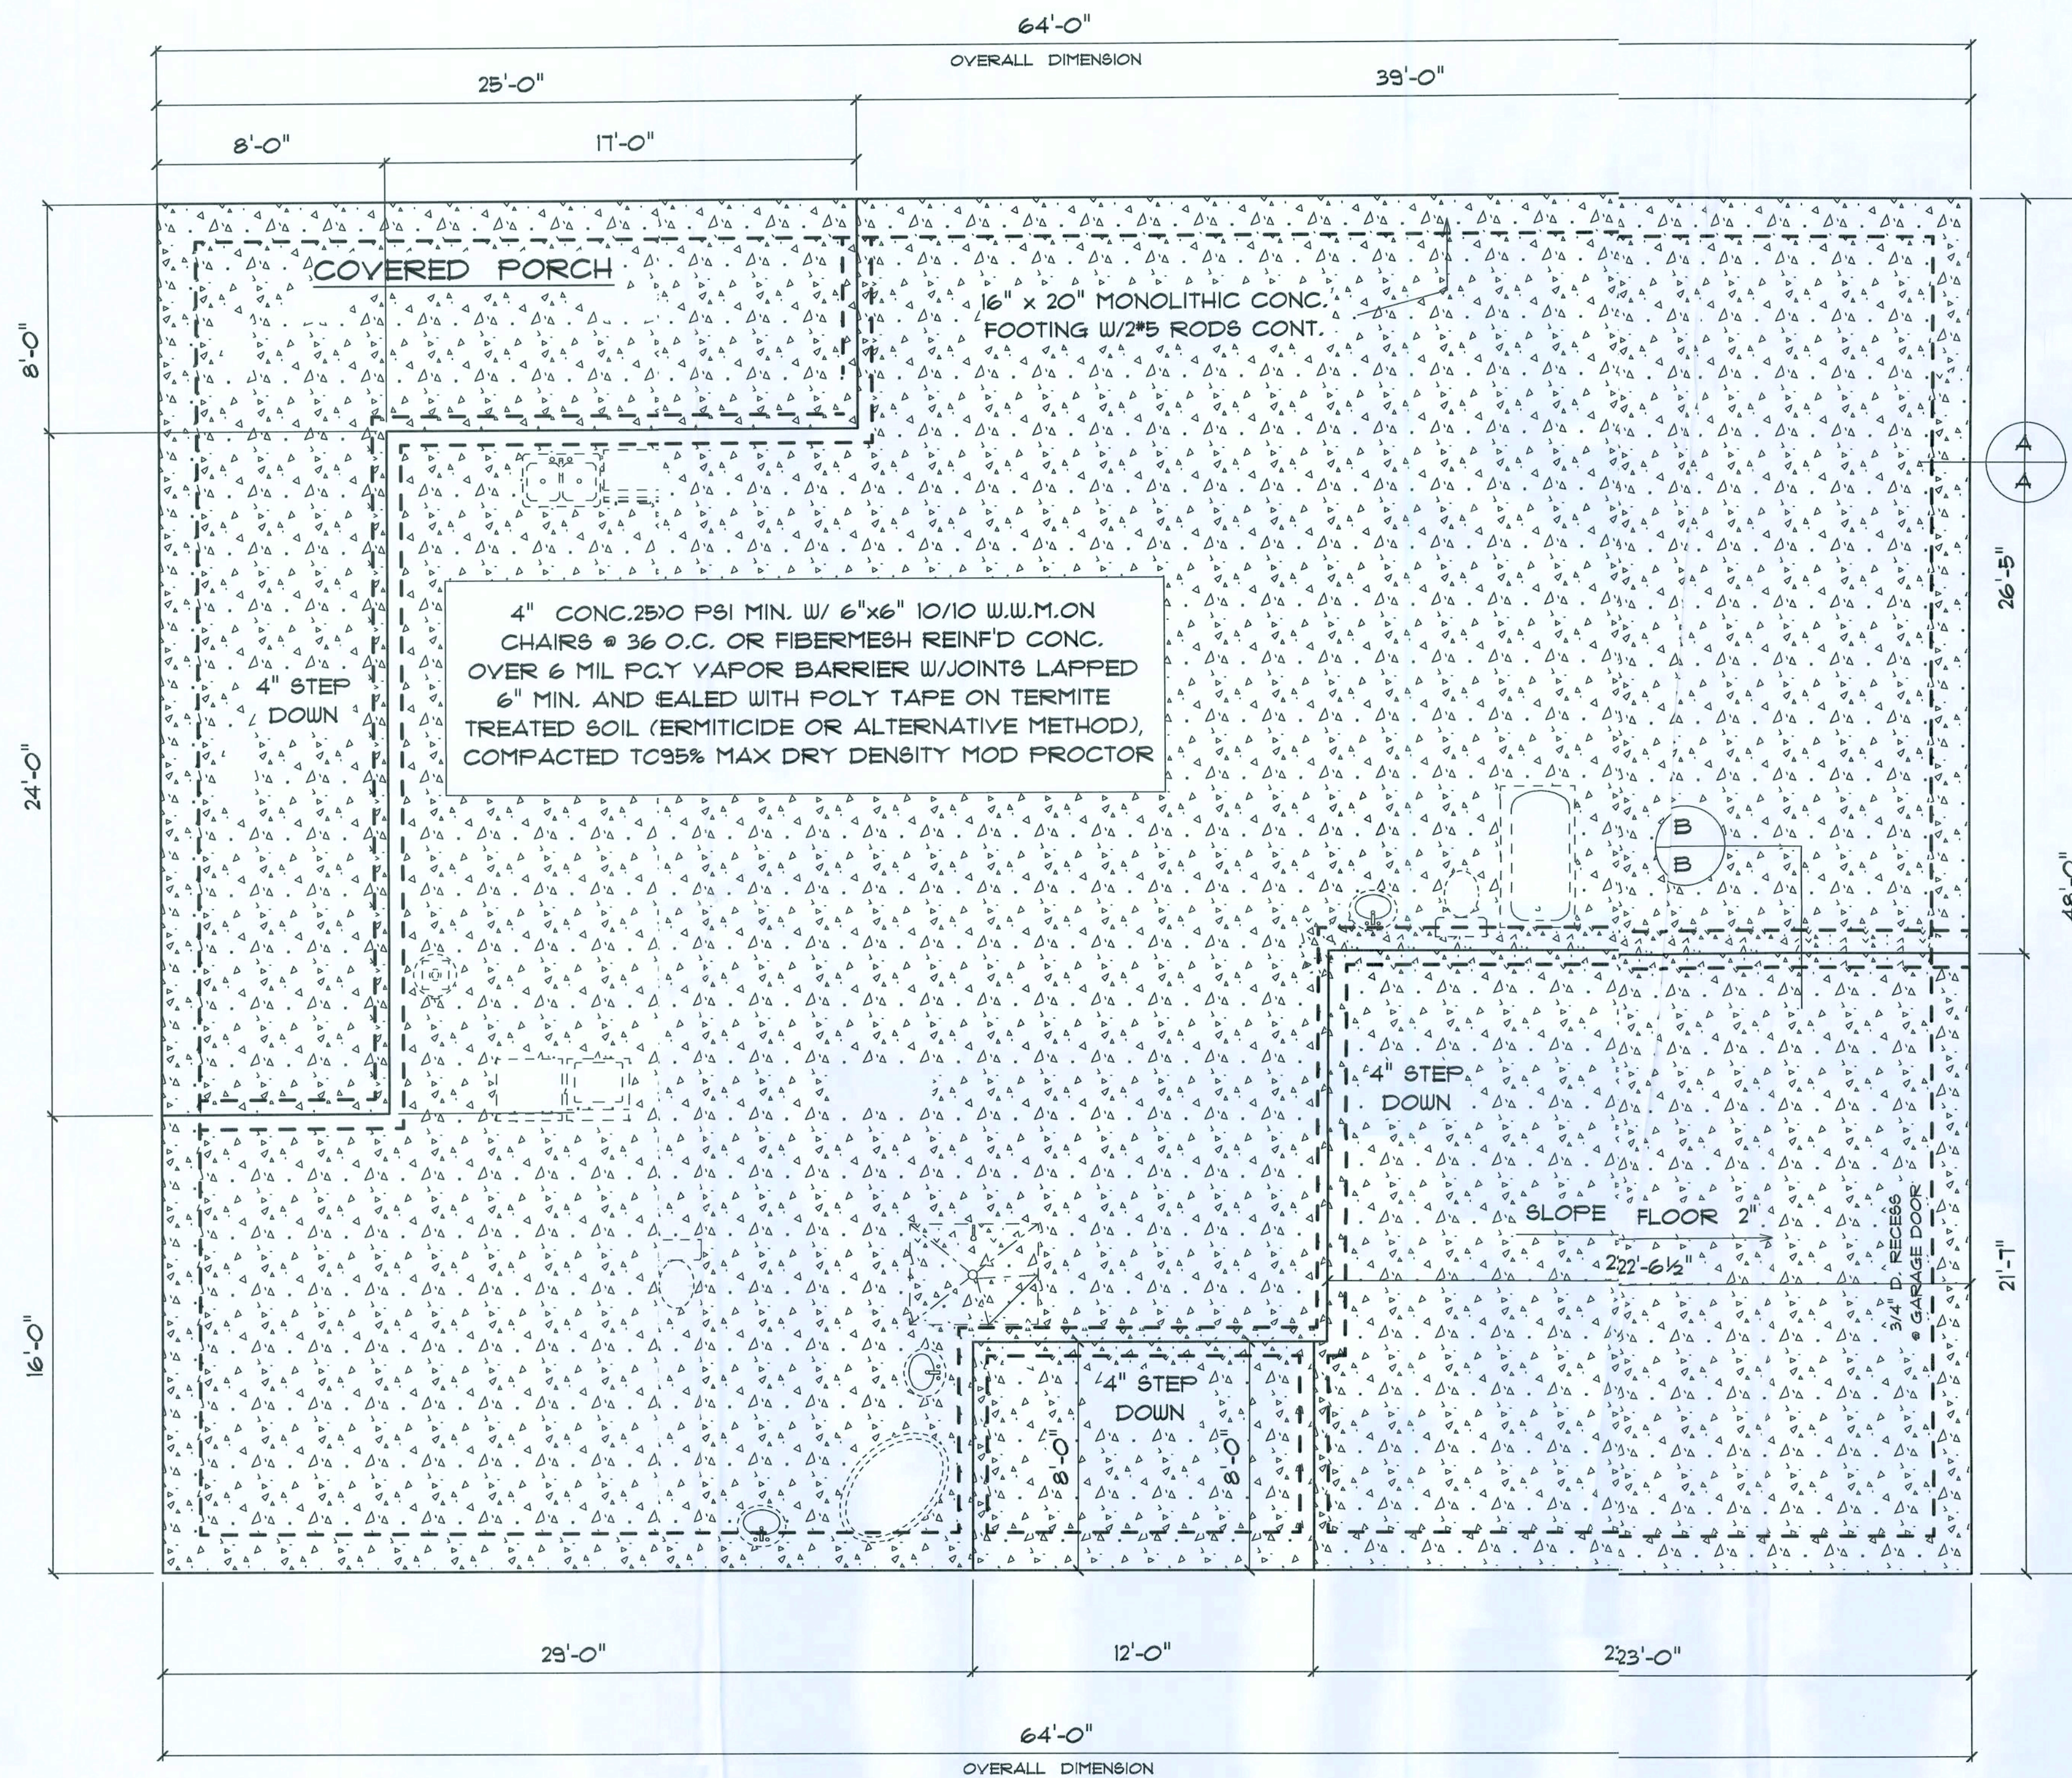


*** FOUNDATION PLAN ***
SCALE : 1/4" = 1'-0"

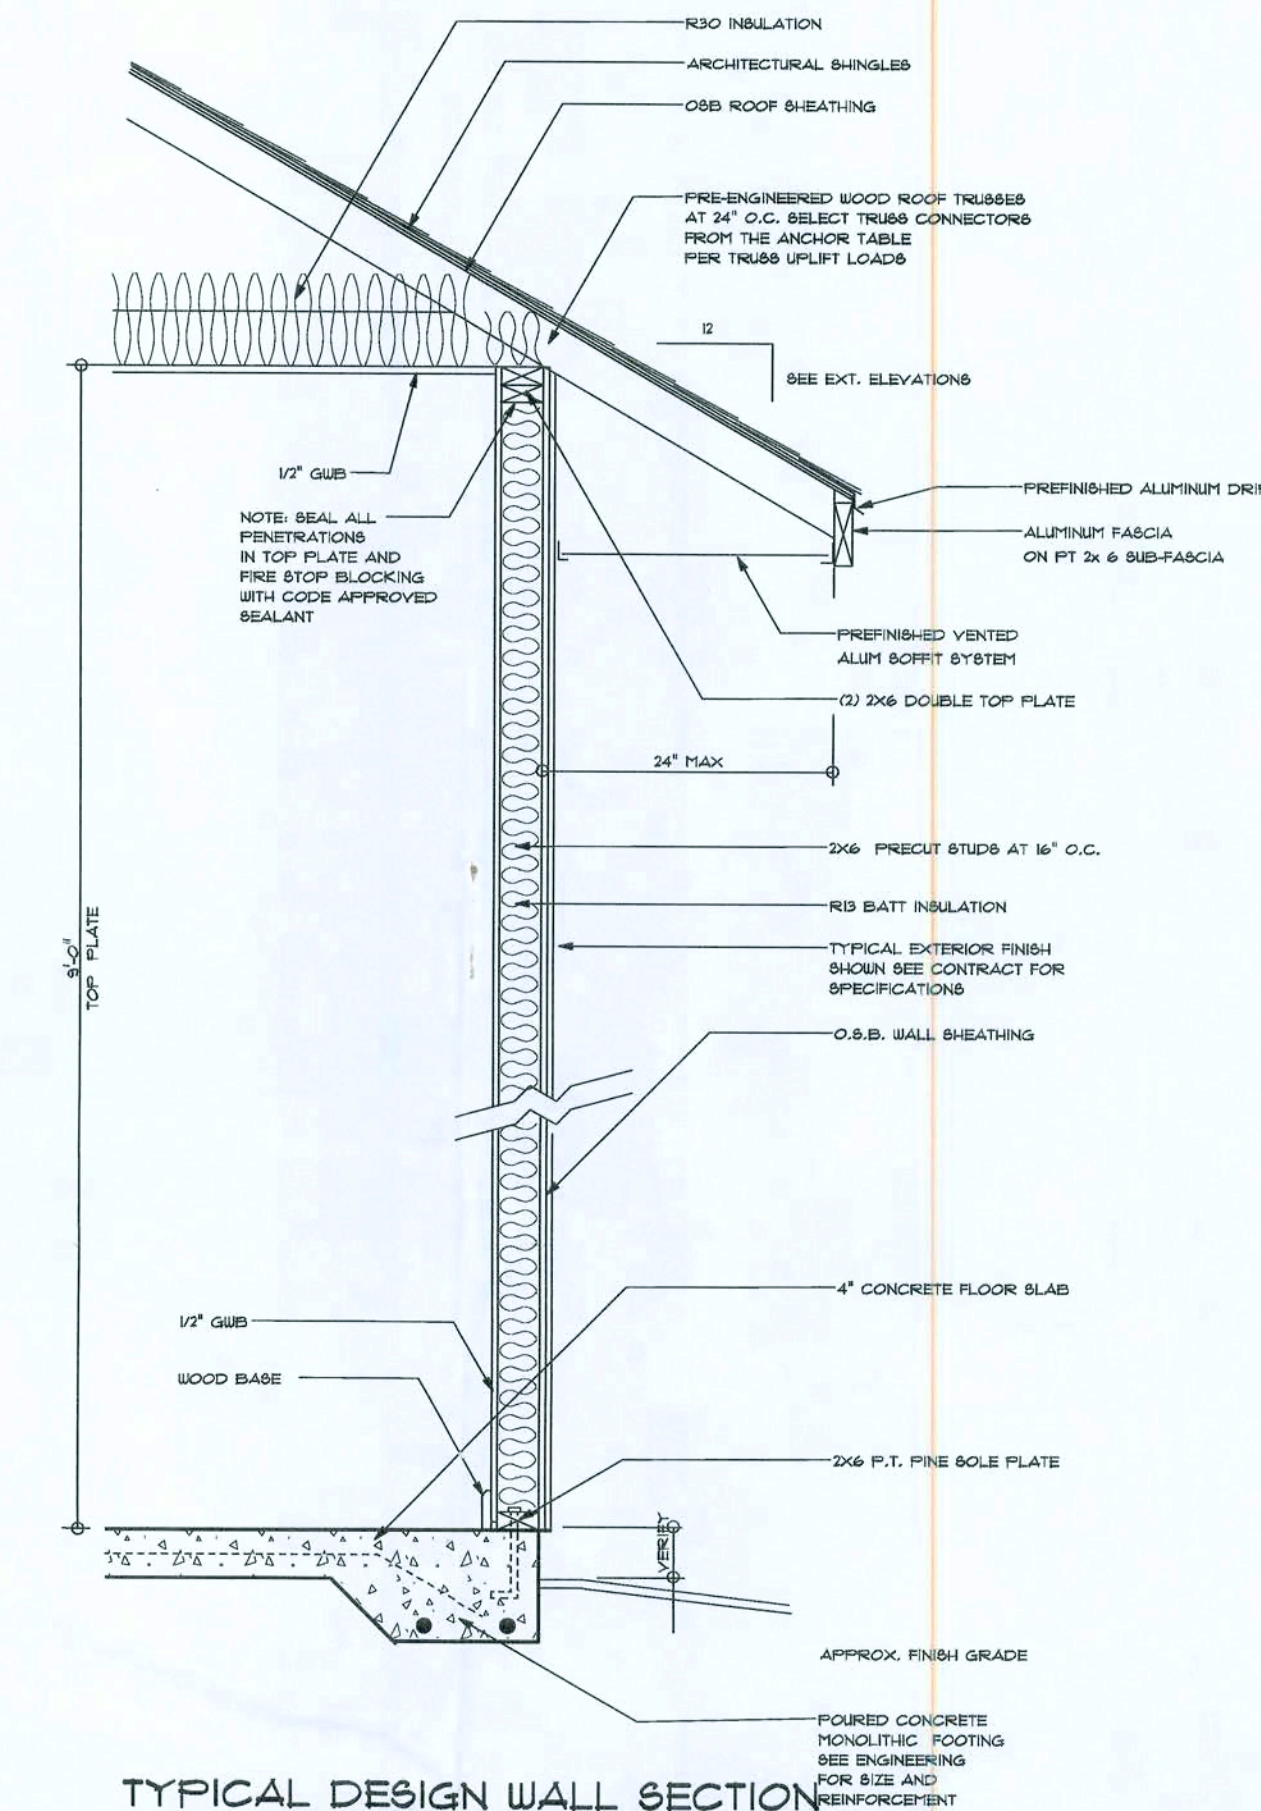

TYPICAL DESIGN WALL SECTION
NON - STRUCTURAL DATA

SCALE : N.T.S.

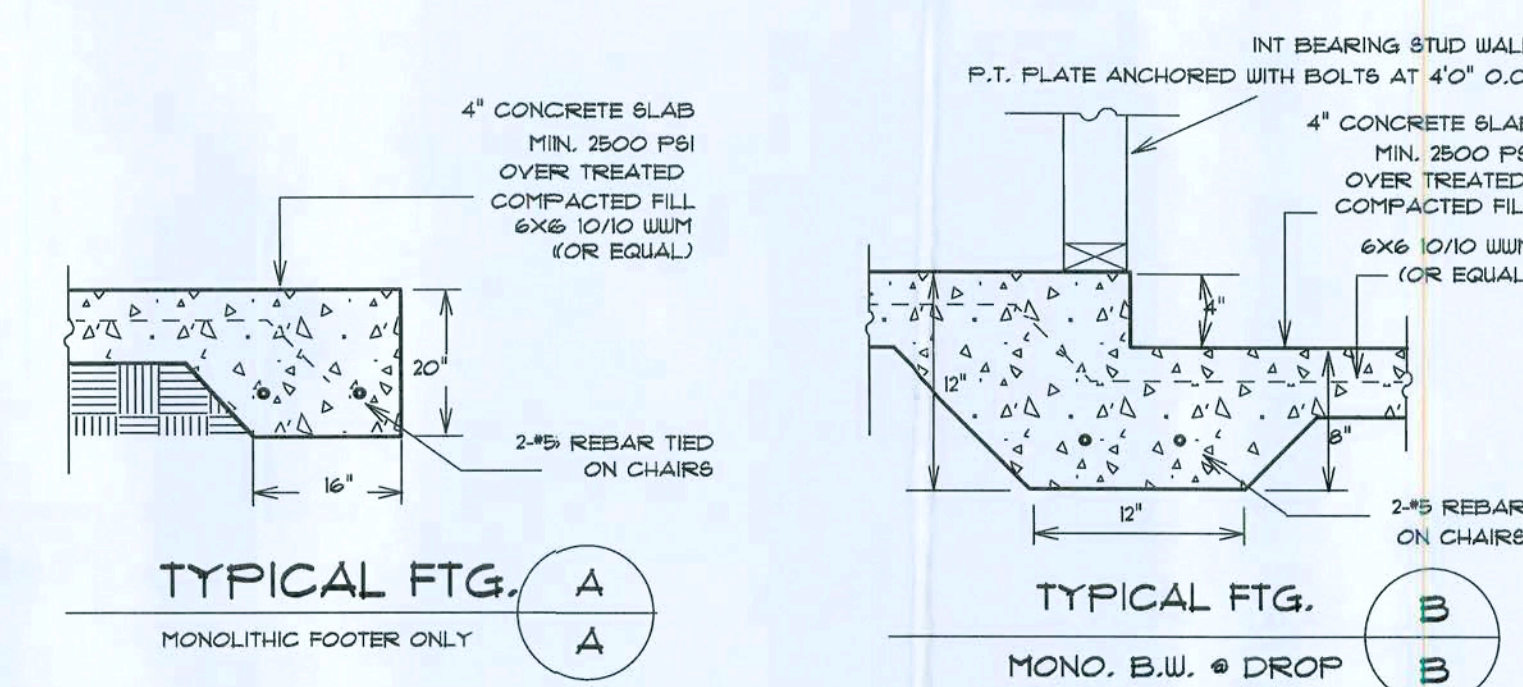

RESIDENCE
FOR
LEE & ANGIE
BLATER

Teresa H. Ruffo
6429 NW LAKE JEFFERY ROAD
Lake City, Florida 32025
Phone: (386) 719 - 4944
Cell: (386) 861 - 1181
Email: rarchsigns@lani.net

PRINTED DATE:
August 31, 2007

DRAWN BY: *Teresa H. Ruffo* CHECKED BY:


BUILDING CONTRACTOR

FINAL DATE:
AUGUST 2007

JOB NUMBER:

DRAWING NUMBER

A-1
OF 4 SHEETS

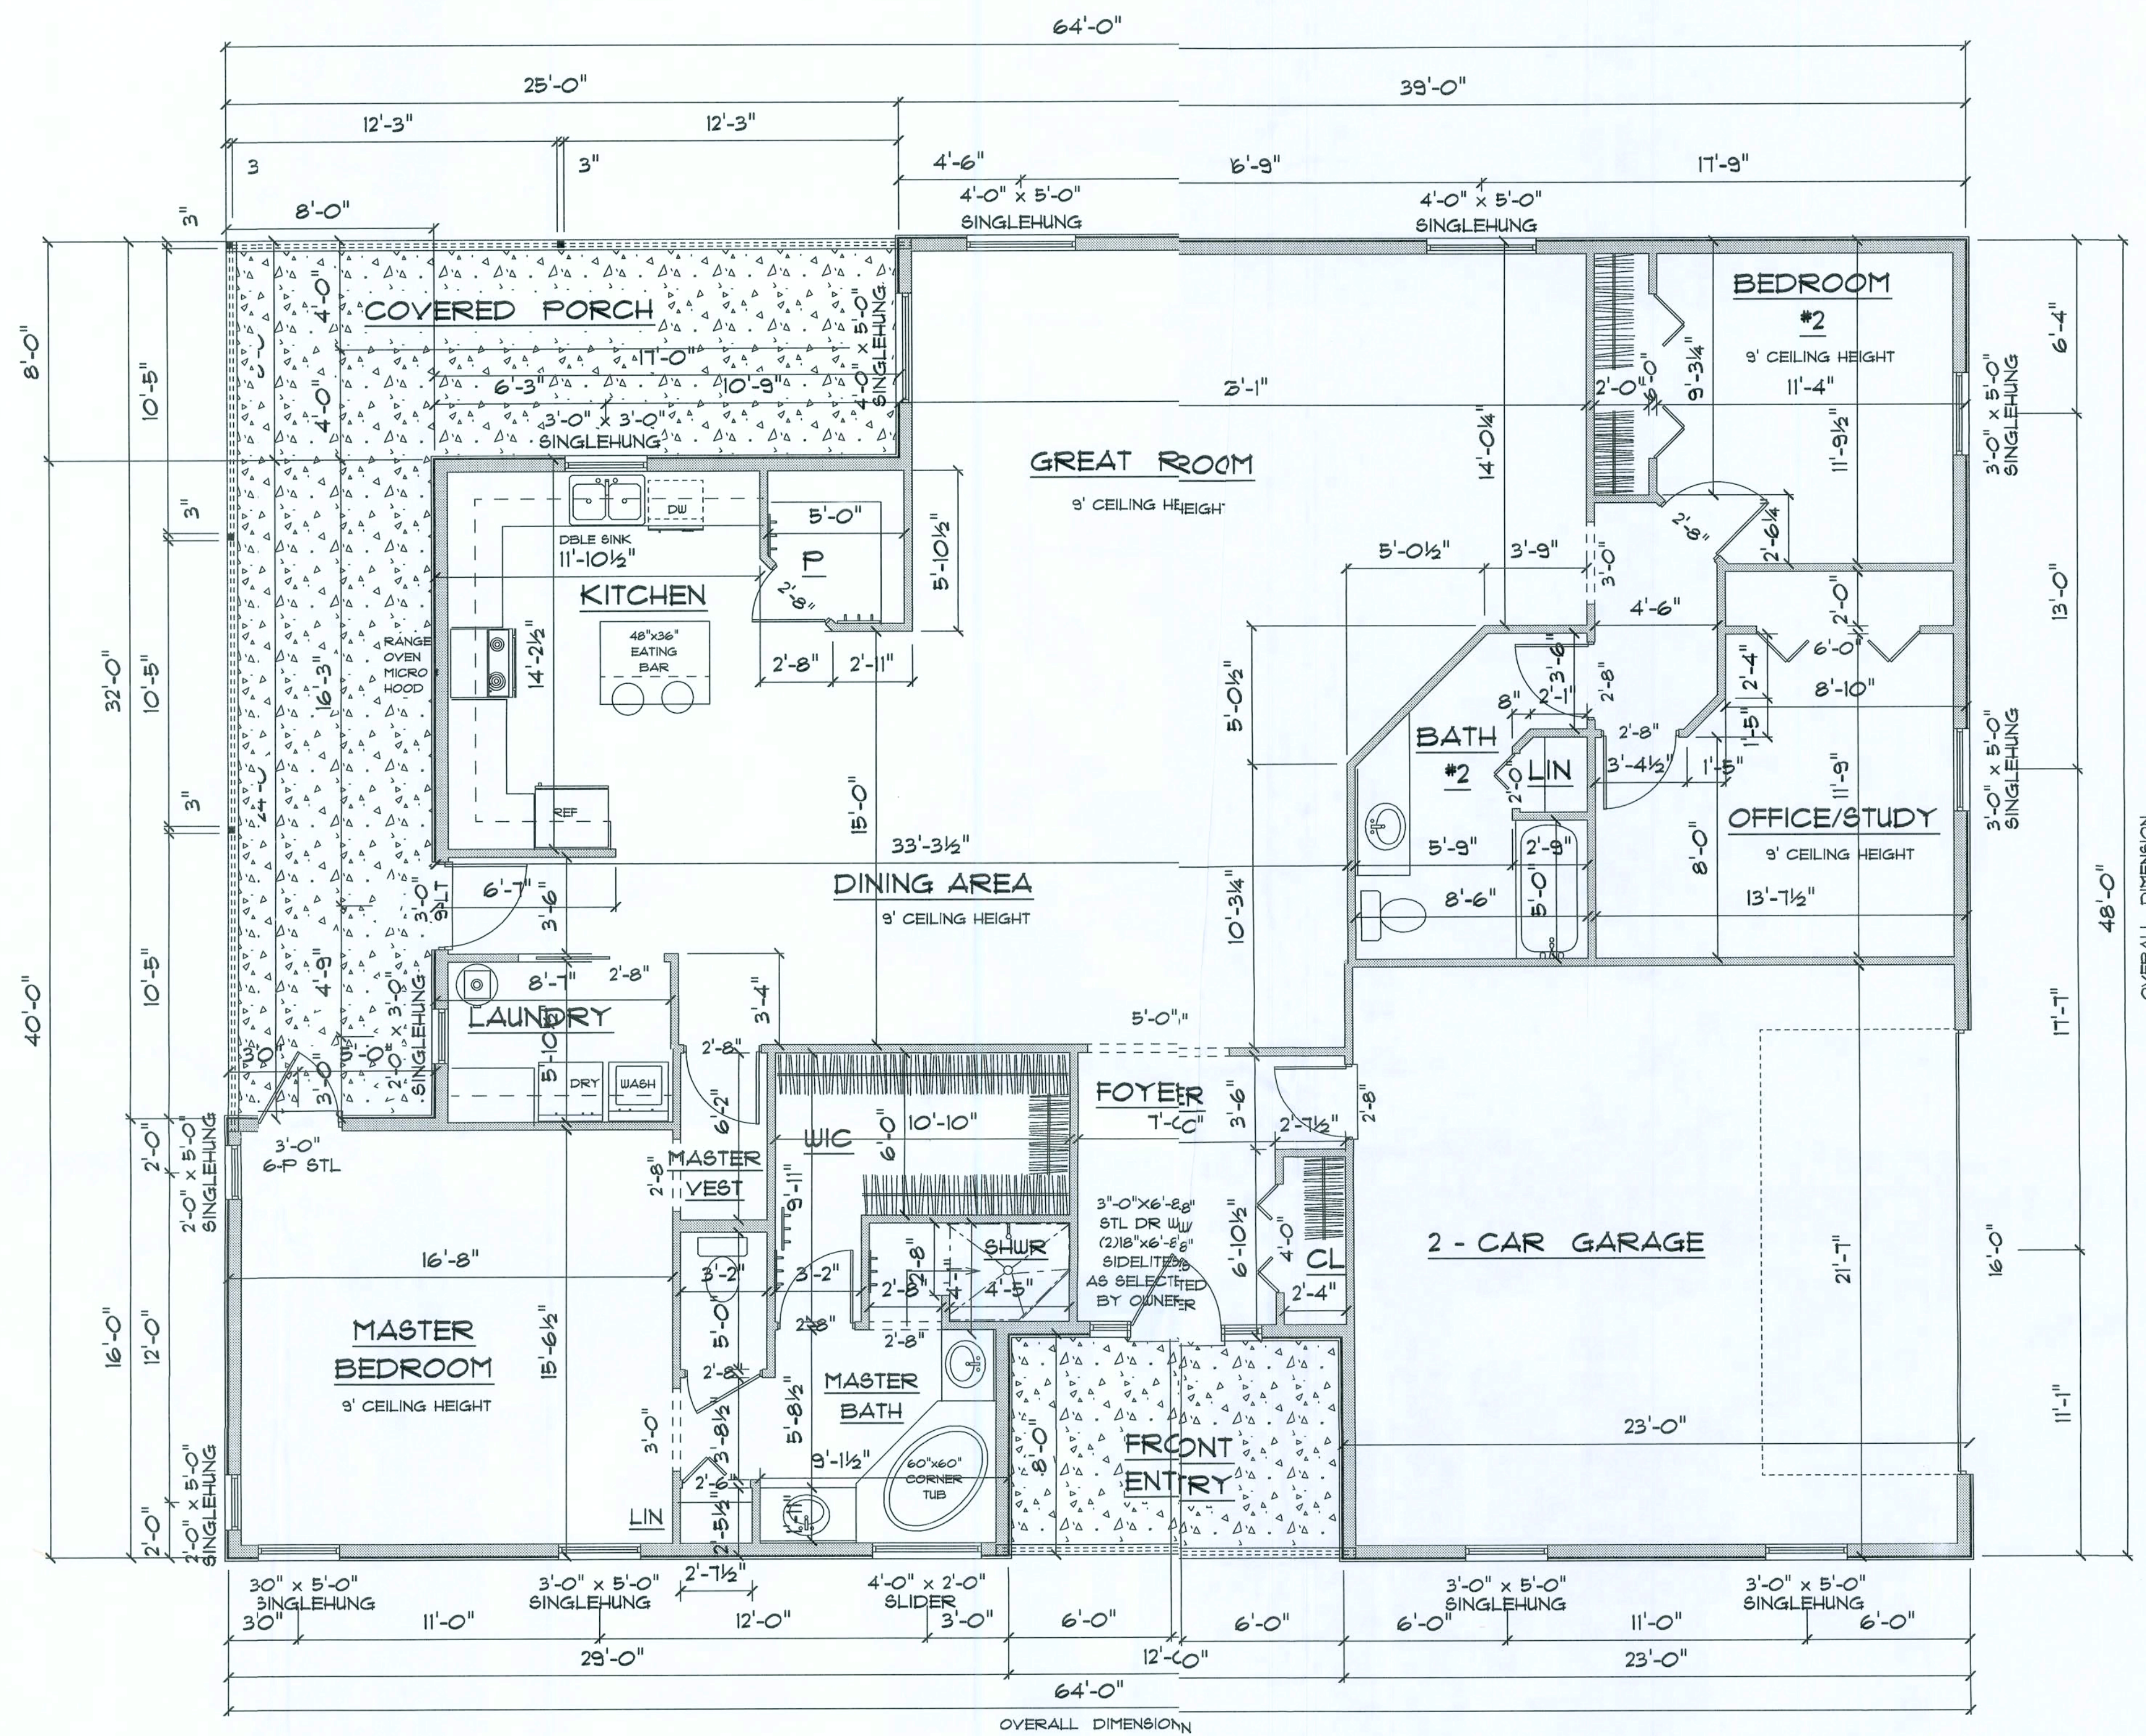

* FLOOR PLAN *

SCALE : 1/4" = 1'-0"

NOTE: ALL BATHROOMS ARE
HANDICAP ACCESSABLE

A/C LIVING AREA	2084 = S.F.
ENTRANCE	98 = S.F.
GARAGE	502 = S.F.
COVERED PORCH	392 = S.F.
TOTAL AREA UNDER ROOF	3076 = S.F.

IMPORTANT NOTE:

1. IT IS THE BUILDERS RESPONSIBILITY TO VERIFY ALL GEOMETRY AND DIMENSIONS BEFORE ORDERING ANY MATERIALS OR BEGINNING CONSTRUCTION.
2. THESE PLANS ARE FOR LAYOUT AND DESIGN PURPOSES ONLY ALL STRUCTURAL NOTES AND DETAILS TO BE PROVIDED BY AN ENGINEER.

RESIDENCE
FOR
LEE & ANGIE
BLATTER

Team M. Ruffo
6428 NW LAKE JEFFERY ROAD
Lake City, Florida 32025
Phone: (886) 715 - 4344
Cell: (886) 867 - 1151
Email: mfruchde@msplan.net

PRINTED DATE:

August 30, 2007

DRAWN BY:

Team M. Ruffo

CHECKED BY:

BUILDING CONTRACTOR

FINALS DATE:


AUGUST 2007

JOB NUMBER:

DRAWING NUMBER

4-2

OF 4 SHEETS

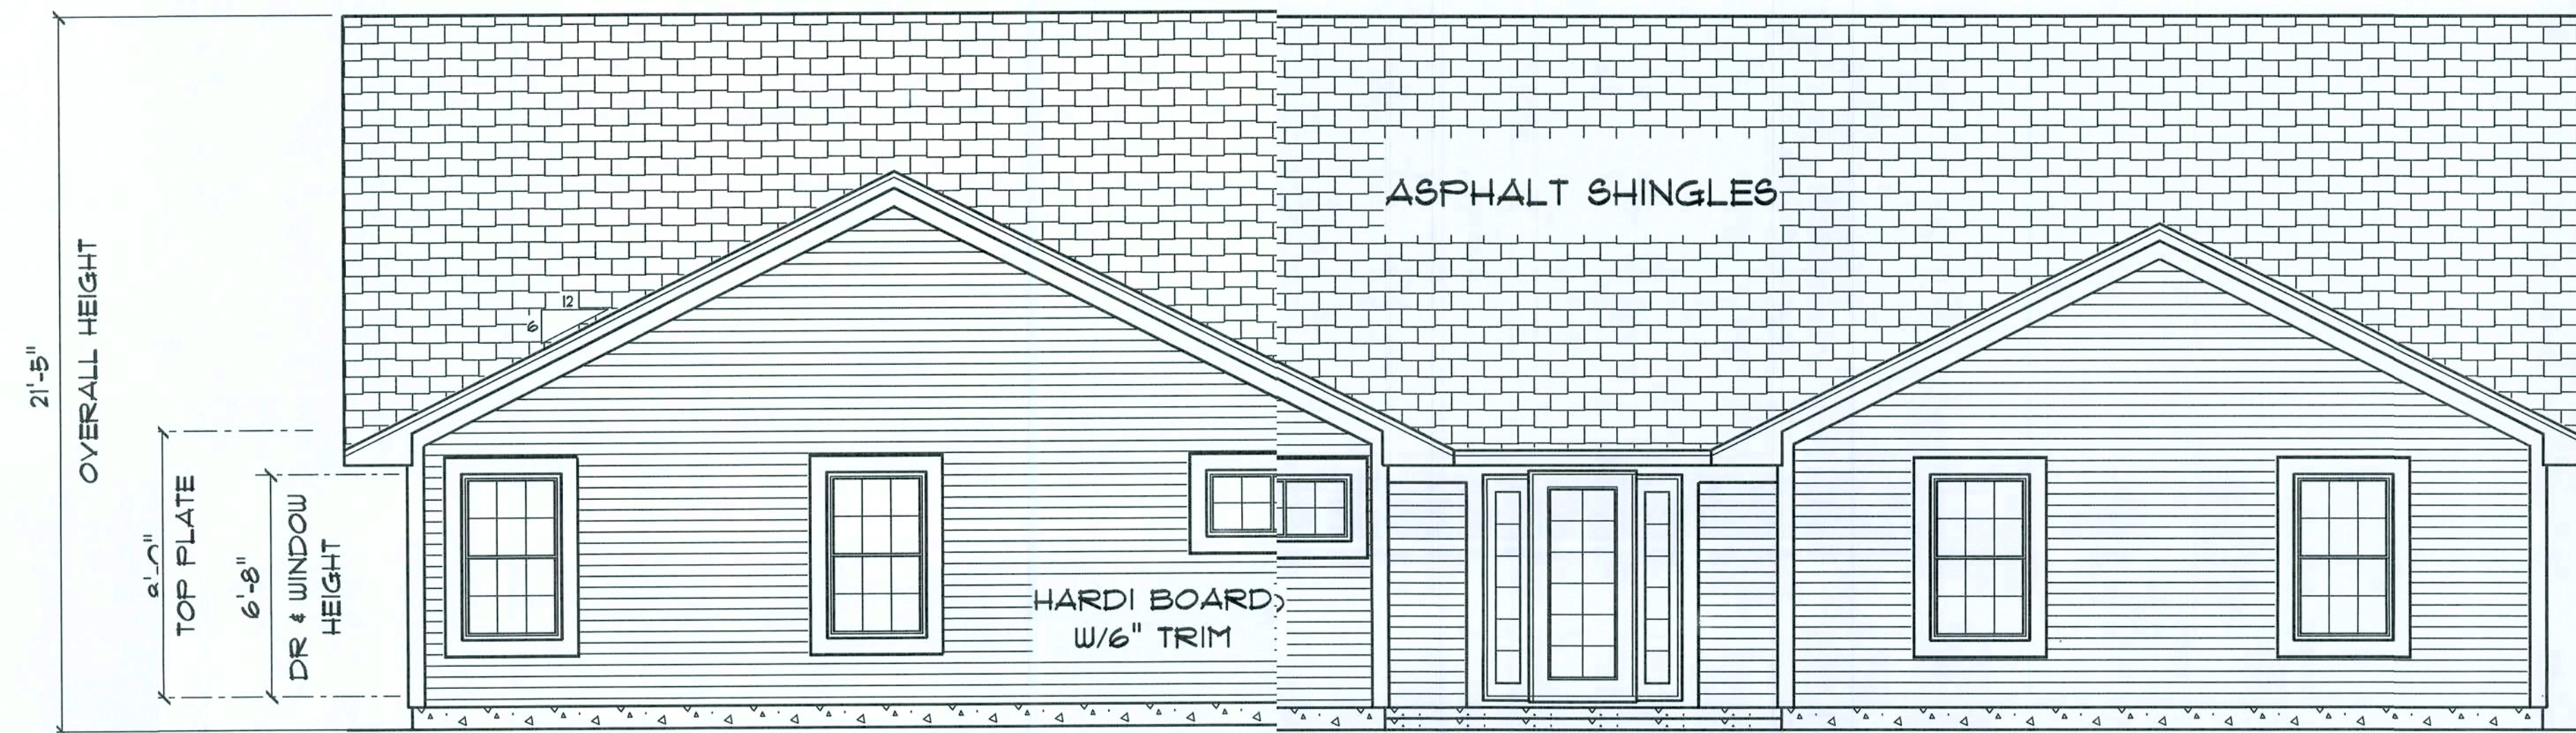

* FRONT ELEVATION *

SCALE: 1/4"=1'-0"

24" OVERHANG ON ALL EAVES




* RIGHT SIDE ELEVATION *

SCALE: 1/4"=1'-0"



* LEFT SIDE ELEVATION *

SCALE: 1/4"=1'-0"

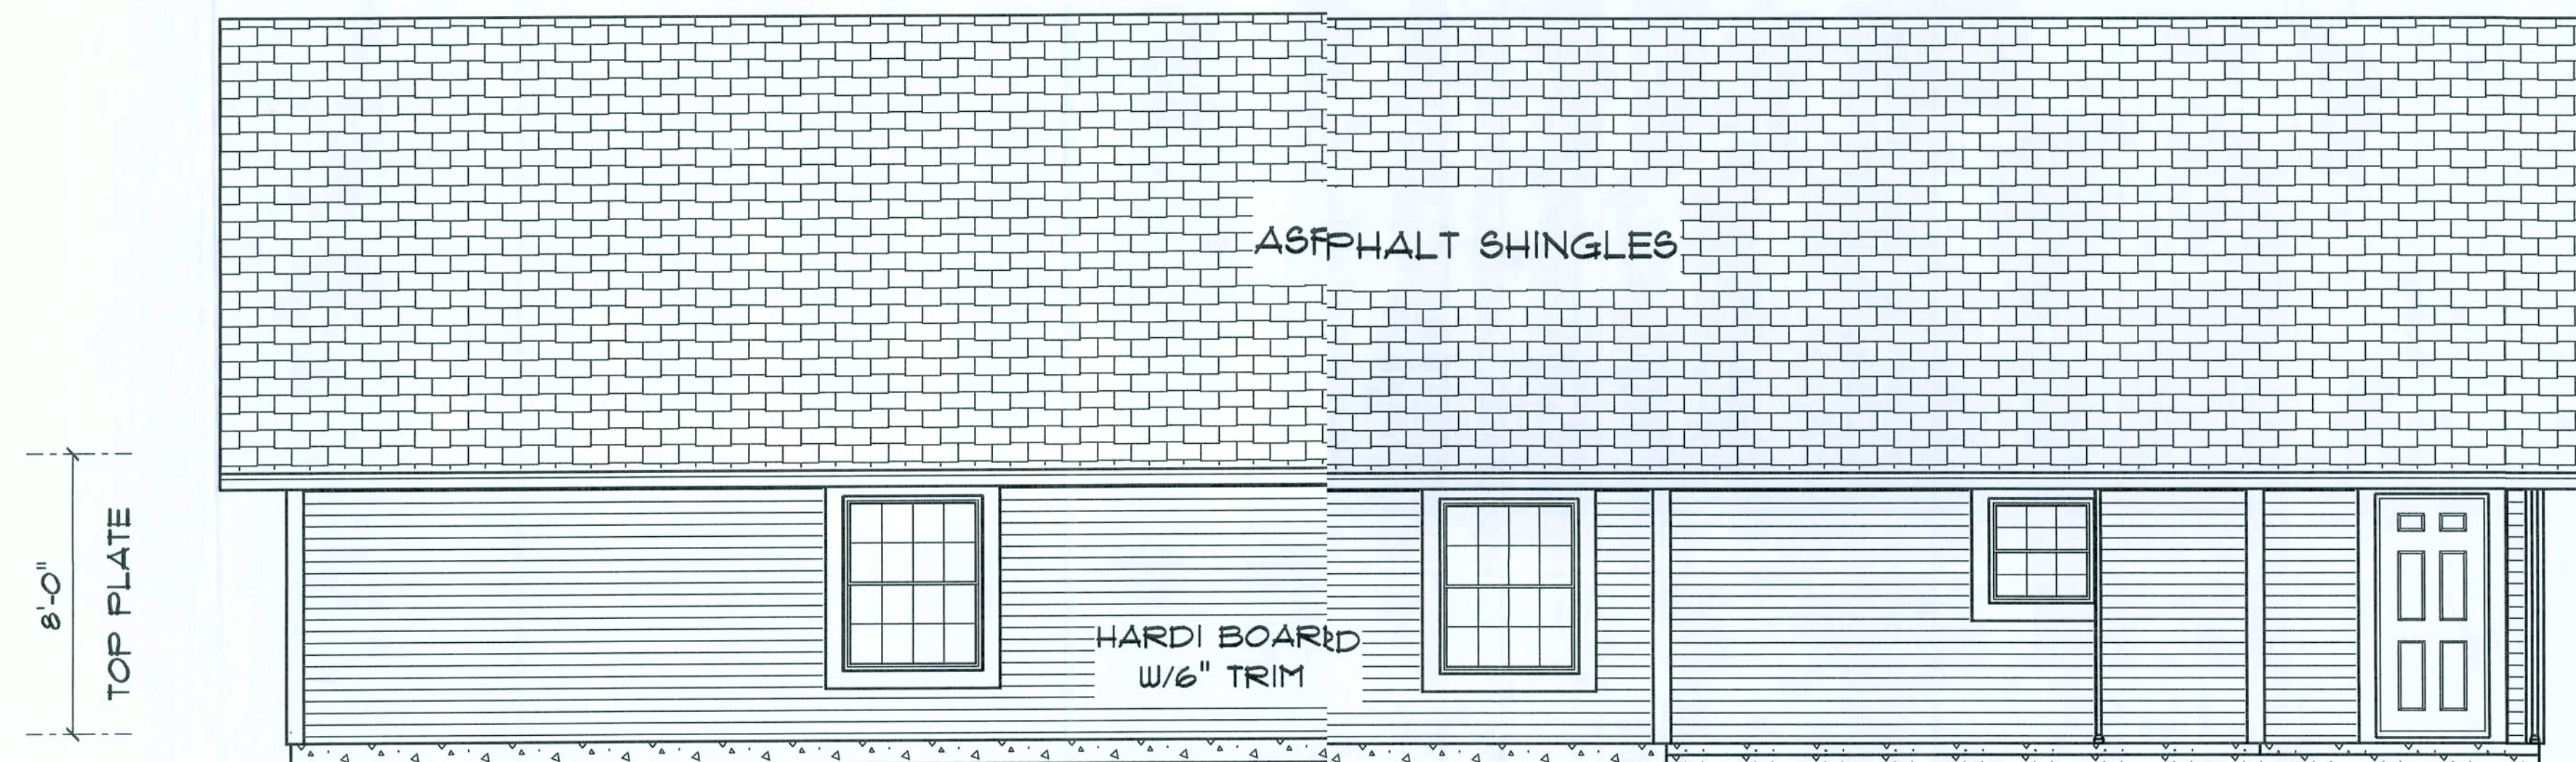

* REAR ELEVATION *

SCALE: 1/4"=1'-0"

RESIDENCE
FOR
LEE & ANGIE
BLATTER

Trent M. Ruffo
6425 NW LAKE JEFFERY ROAD
Lake City, Florida 32025
Phone: (386) 715 - 4544
Cell: (386) 861 - 1151
Email: tr@ruffodesigns.com

PRINTED DATE:
August 30, 2007

DRAWN BY: Trent M. Ruffo CHECKED BY:
BUILDING CONTRACTOR

 
 
 
 
 
FINAL DATE:
AUGUST 2007


JOB NUMBER:

DRAWING NUMBER

A-3

OF 4 SHEETS

ELECTRICAL	COUNT	SYMBOL
ceiling fan	6	
12 x 48 fluorescent lt fixture	2	
200 amp service panel	1	
automatic garage dr opener	1	
cable tv outlet	1	
electric meter	1	
garage dr opener	1	
gfi waterproof outlet	10	
light	32	
outlet	32	
outlet 220v	3	
outlet gfi	17	
recessed can light	1	
smoke detector	5	
switch	33	
switch 3 way	8	
telephone	1	
vent light combo	2	

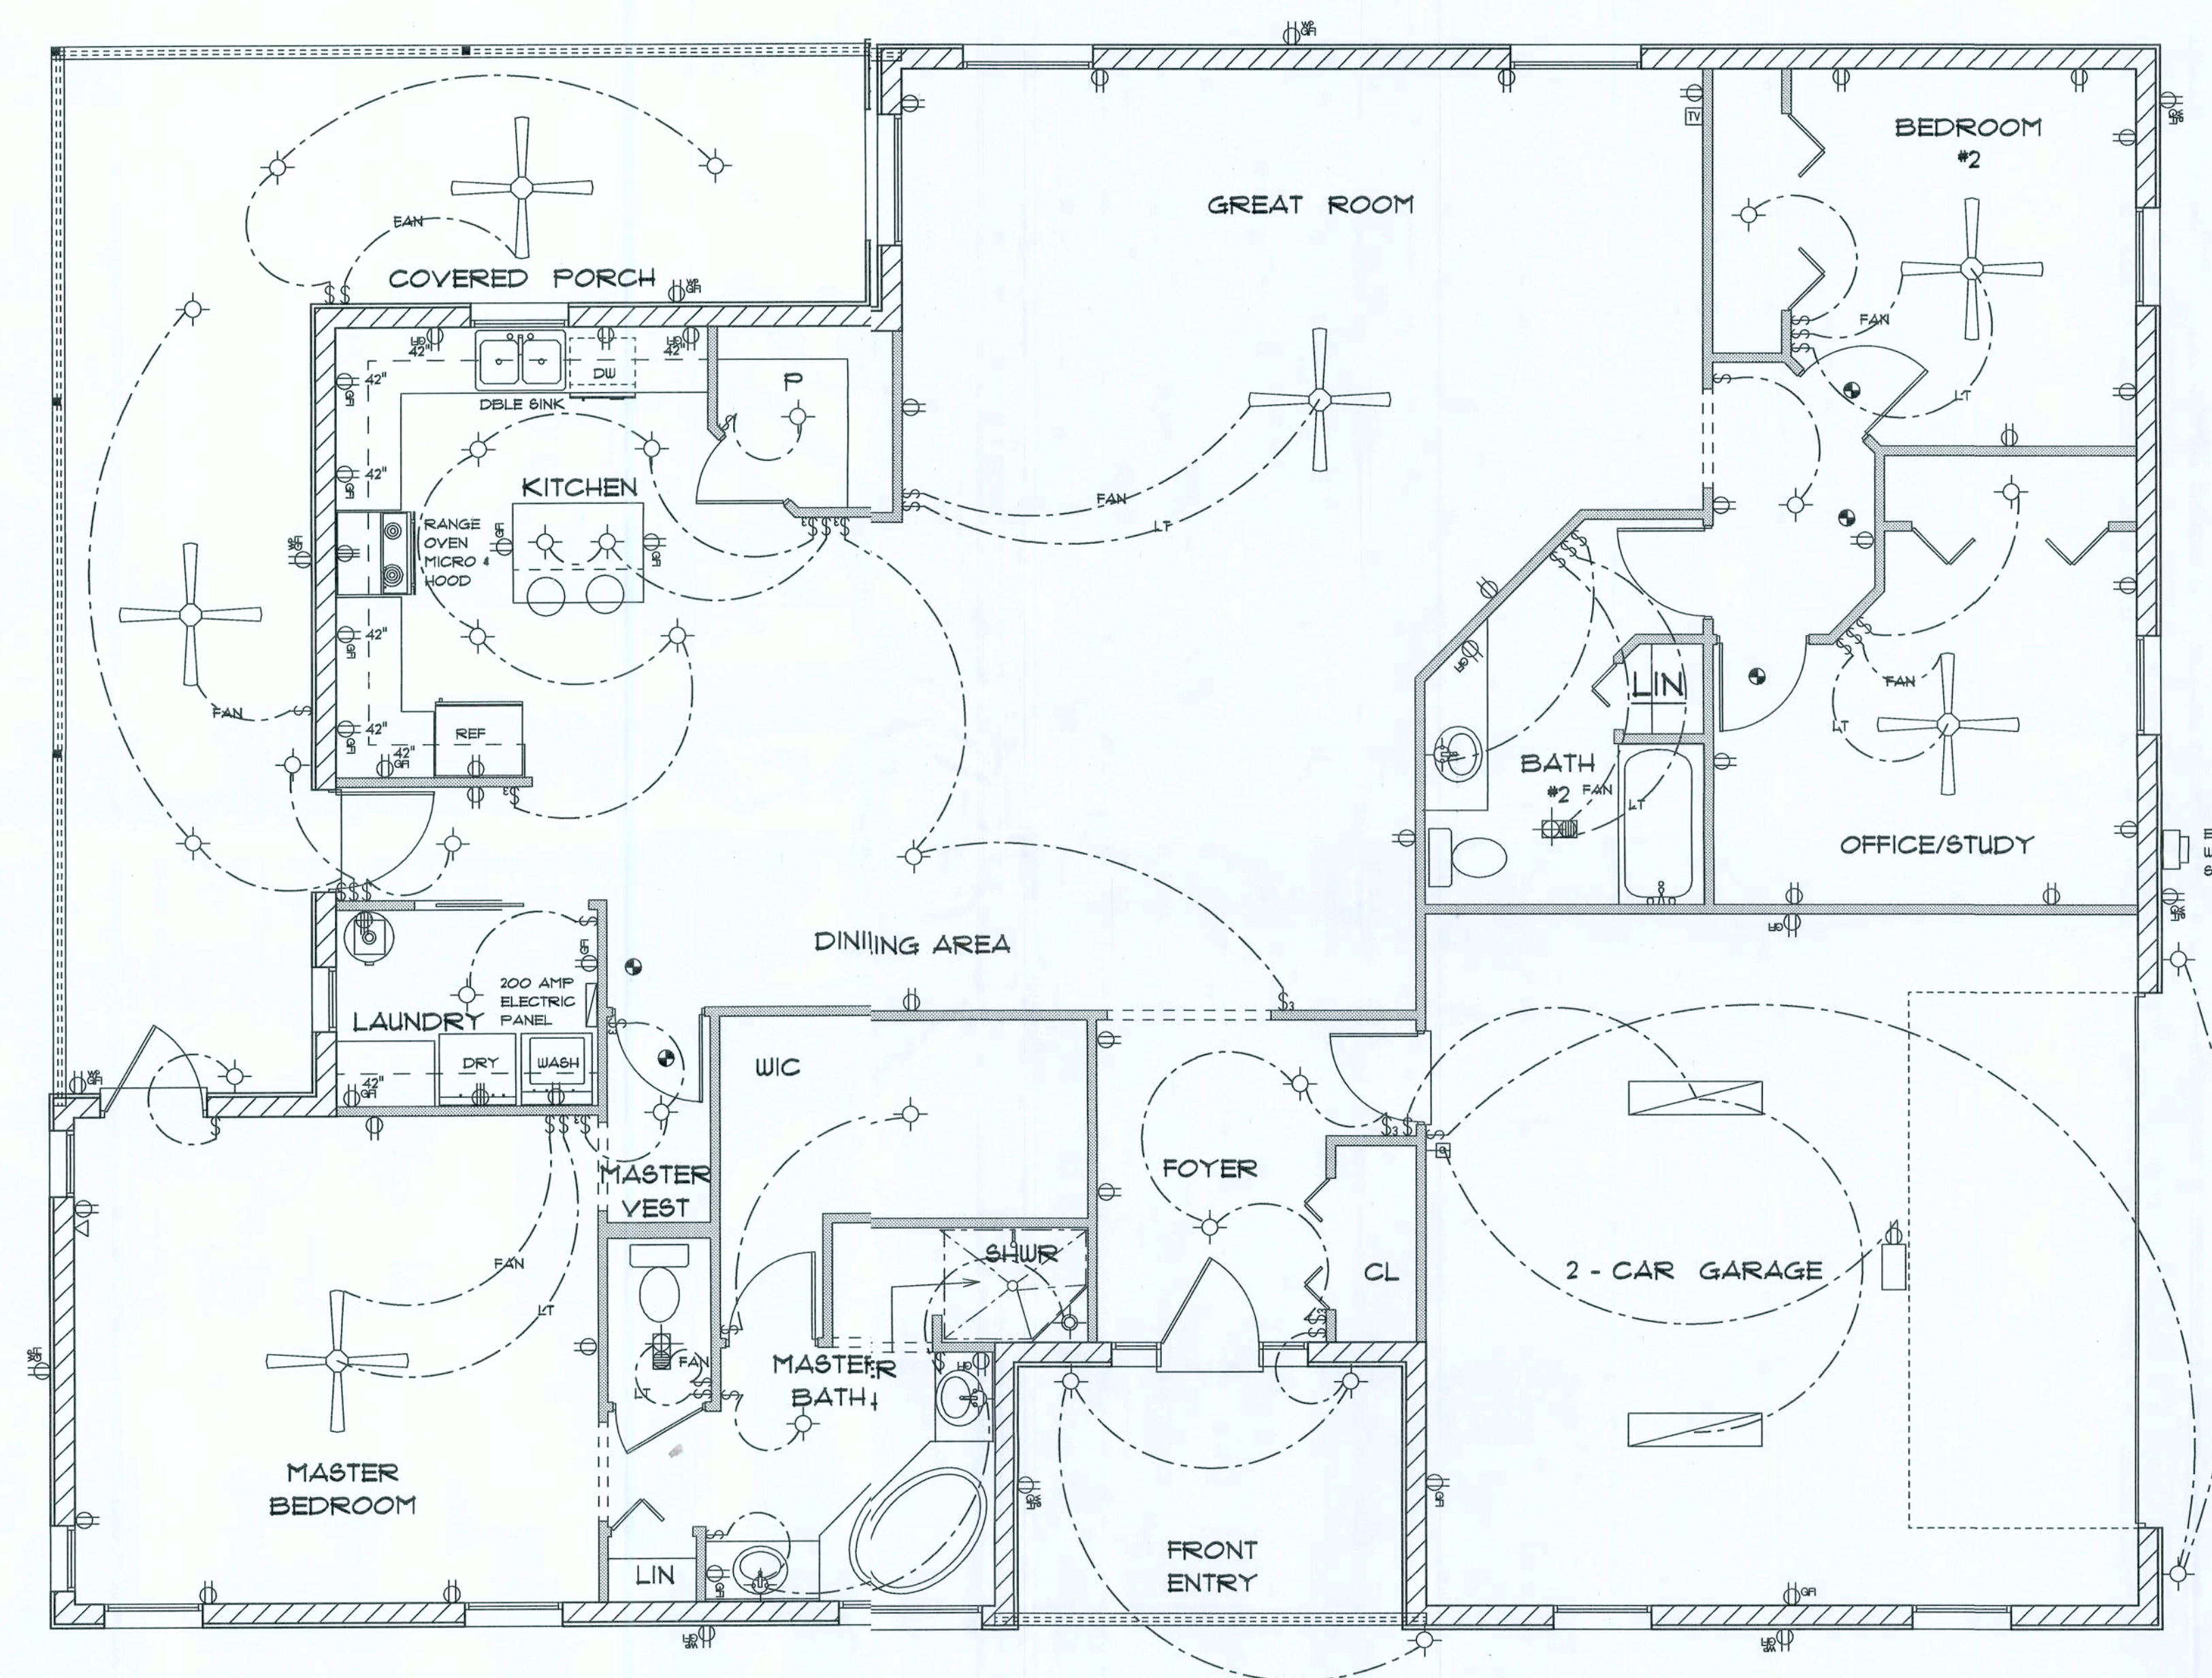

ELECTRICAL PLAN NOTES

- E-1 WIRE ALL APPLIANCES, HVAC UNITS AND OTHER EQUIPMENT PER MANUFACTURER'S SPECIFICATIONS.
- E-2 CONSULT THE OWNER FOR THE NUMBER OF SEPARATE TELEPHONE LINES TO BE INSTALLED.
- E-4 ALL INSTALLATIONS SHALL BE PER NATIONAL ELECTRIC CODE.
- E-3 ALL SMOKE DETECTORS SHALL BE 120V W/BATTERY BACKUP OF THE PHOTOELECTRIC TYPE, AND SHALL BE INTERLOCKED TOGETHER. INSTALL INSIDE AND NEAR ALL BEDROOMS.
- E-5 TELEPHONE, TELEVISION AND OTHER LOW VOLTAGE DEVICES OR OUTLETS SHALL BE AS PER THE OWNER'S DIRECTION AND IN ACCORDANCE WITH APPLICABLE SECTIONS OF NATIONAL ELCT. CODE LATEST EDITION.
- E-6 ELECTRICAL CONTRACTOR SHALL BE RESPONSIBLE FOR THE DESIGN AND SIZING OF ELECTRICAL SERVICE AND CIRCUITS.
- E-7 ENTRY OF SERVICE UNDERGROUND OR OVERHEAD) IS TO BE DETERMINED BY THE POWER COMPANY.
- E-8 ALL BEDROOM RECEPTALS ARE TO BE AFCI (ARC FAULT CIRCUIT INTERRUPT)

* ELECTRIC PLAN *

SCALE : 1/4" = 1'-0"

RESIDENCE
FOR
LEE & ANGIE
BLATTER

Teresa M. Ruffo
6425 NW LAKE EFFERY ROAD
Lake City, Florida 32025
Phone: (386) 718 - 4344
Cell: (386) 861 - 1151
Email: trarchdesigns@att.net

PRINTED DATE:
August 31, 2007
DRAWN BY: Teresa M. Ruffo
CHECKED BY:
BUILDING CONTRACTOR

FINALS DATE:
AUGUST 2007


JOB NUMBER:

DRAWING NUMBER


A-4
OF 4 SHEETS

REVISIONS	


SOFTPLAN
ARCHITECTURAL DESIGN SOFTWARE

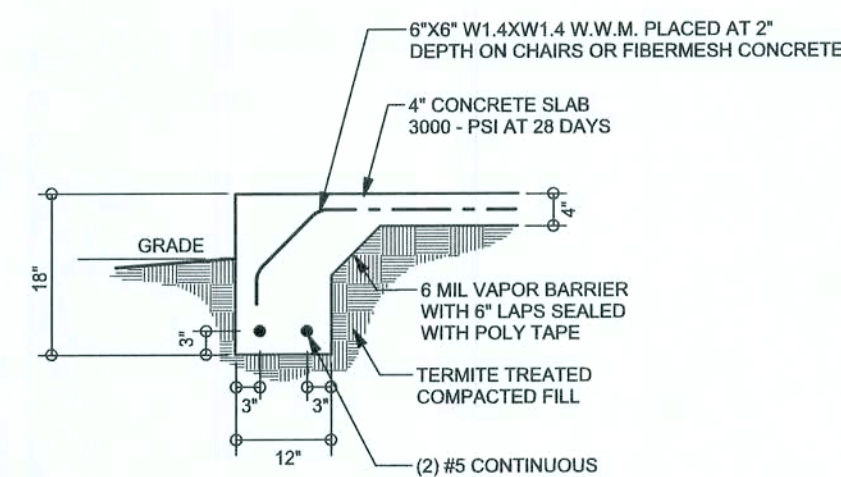


F1 MONOLITHIC FOOTING
SCALE: 1/2" = 1'-0"

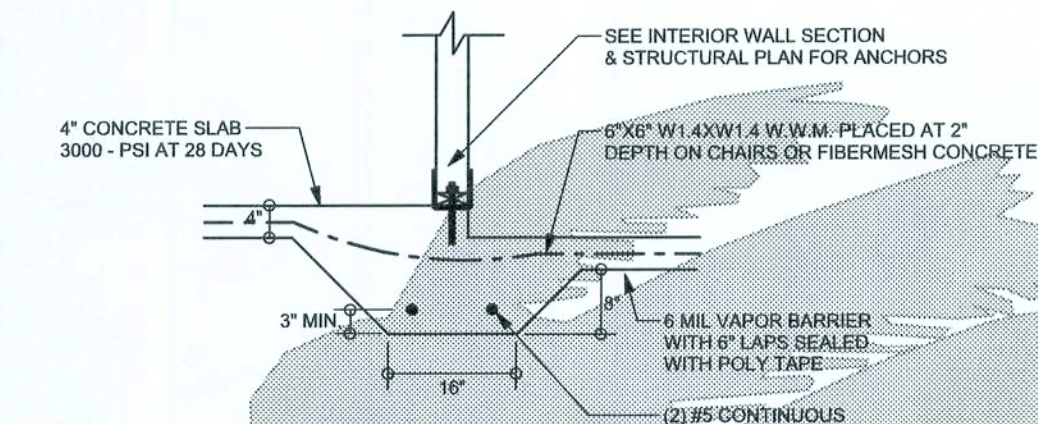


F3 INTERIOR BEARING STEP FOOTING
SCALE: 1/2" = 1'-0"

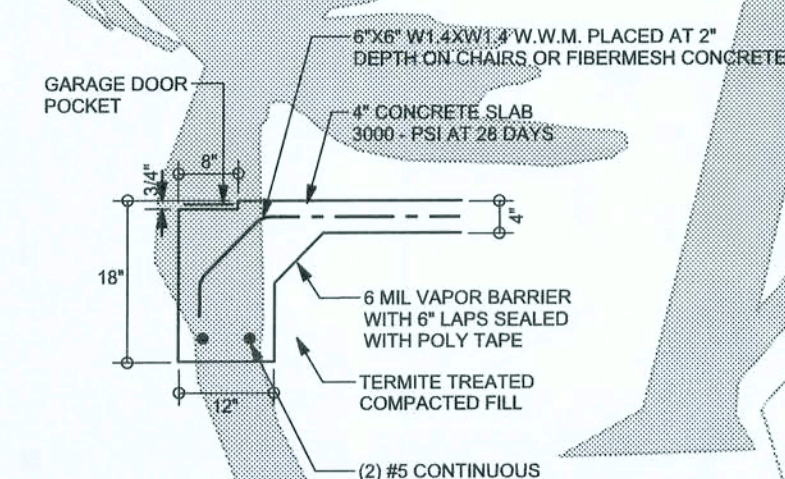


F4 GARAGE DOOR FOOTING
SCALE: 1/2" = 1'-0"

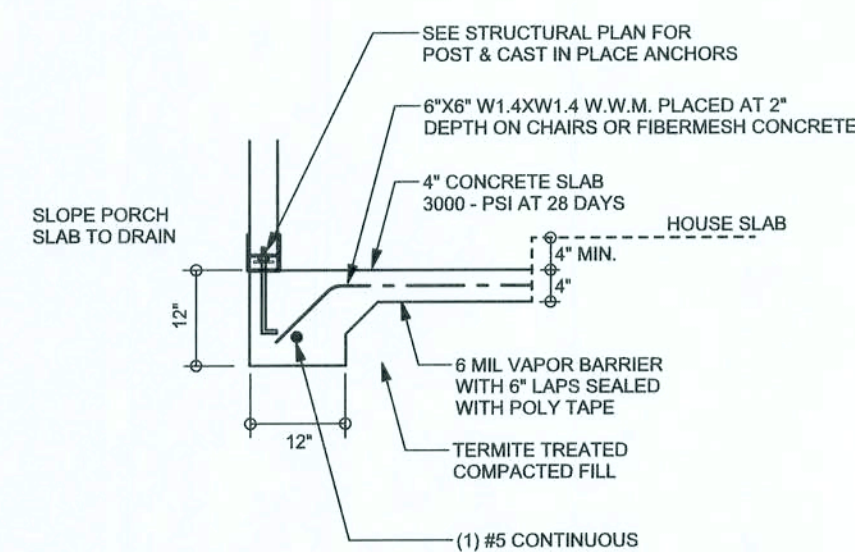

F5 PORCH FOOTING
SCALE: 1/2" = 1'-0"

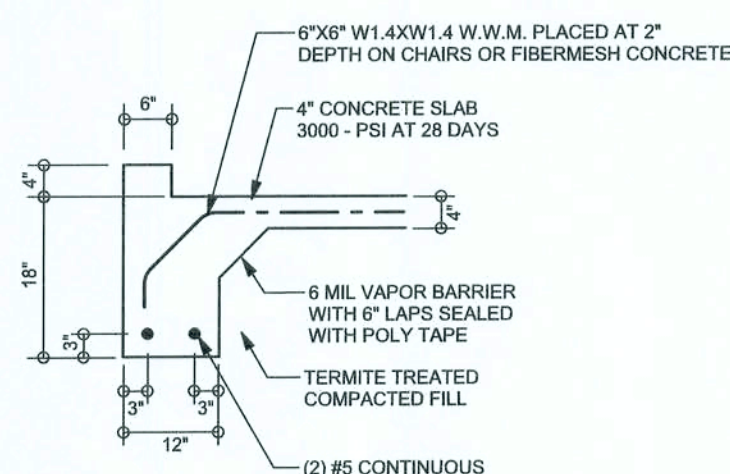

F8 GARAGE CURB FOOTING
SCALE: 1/2" = 1'-0"

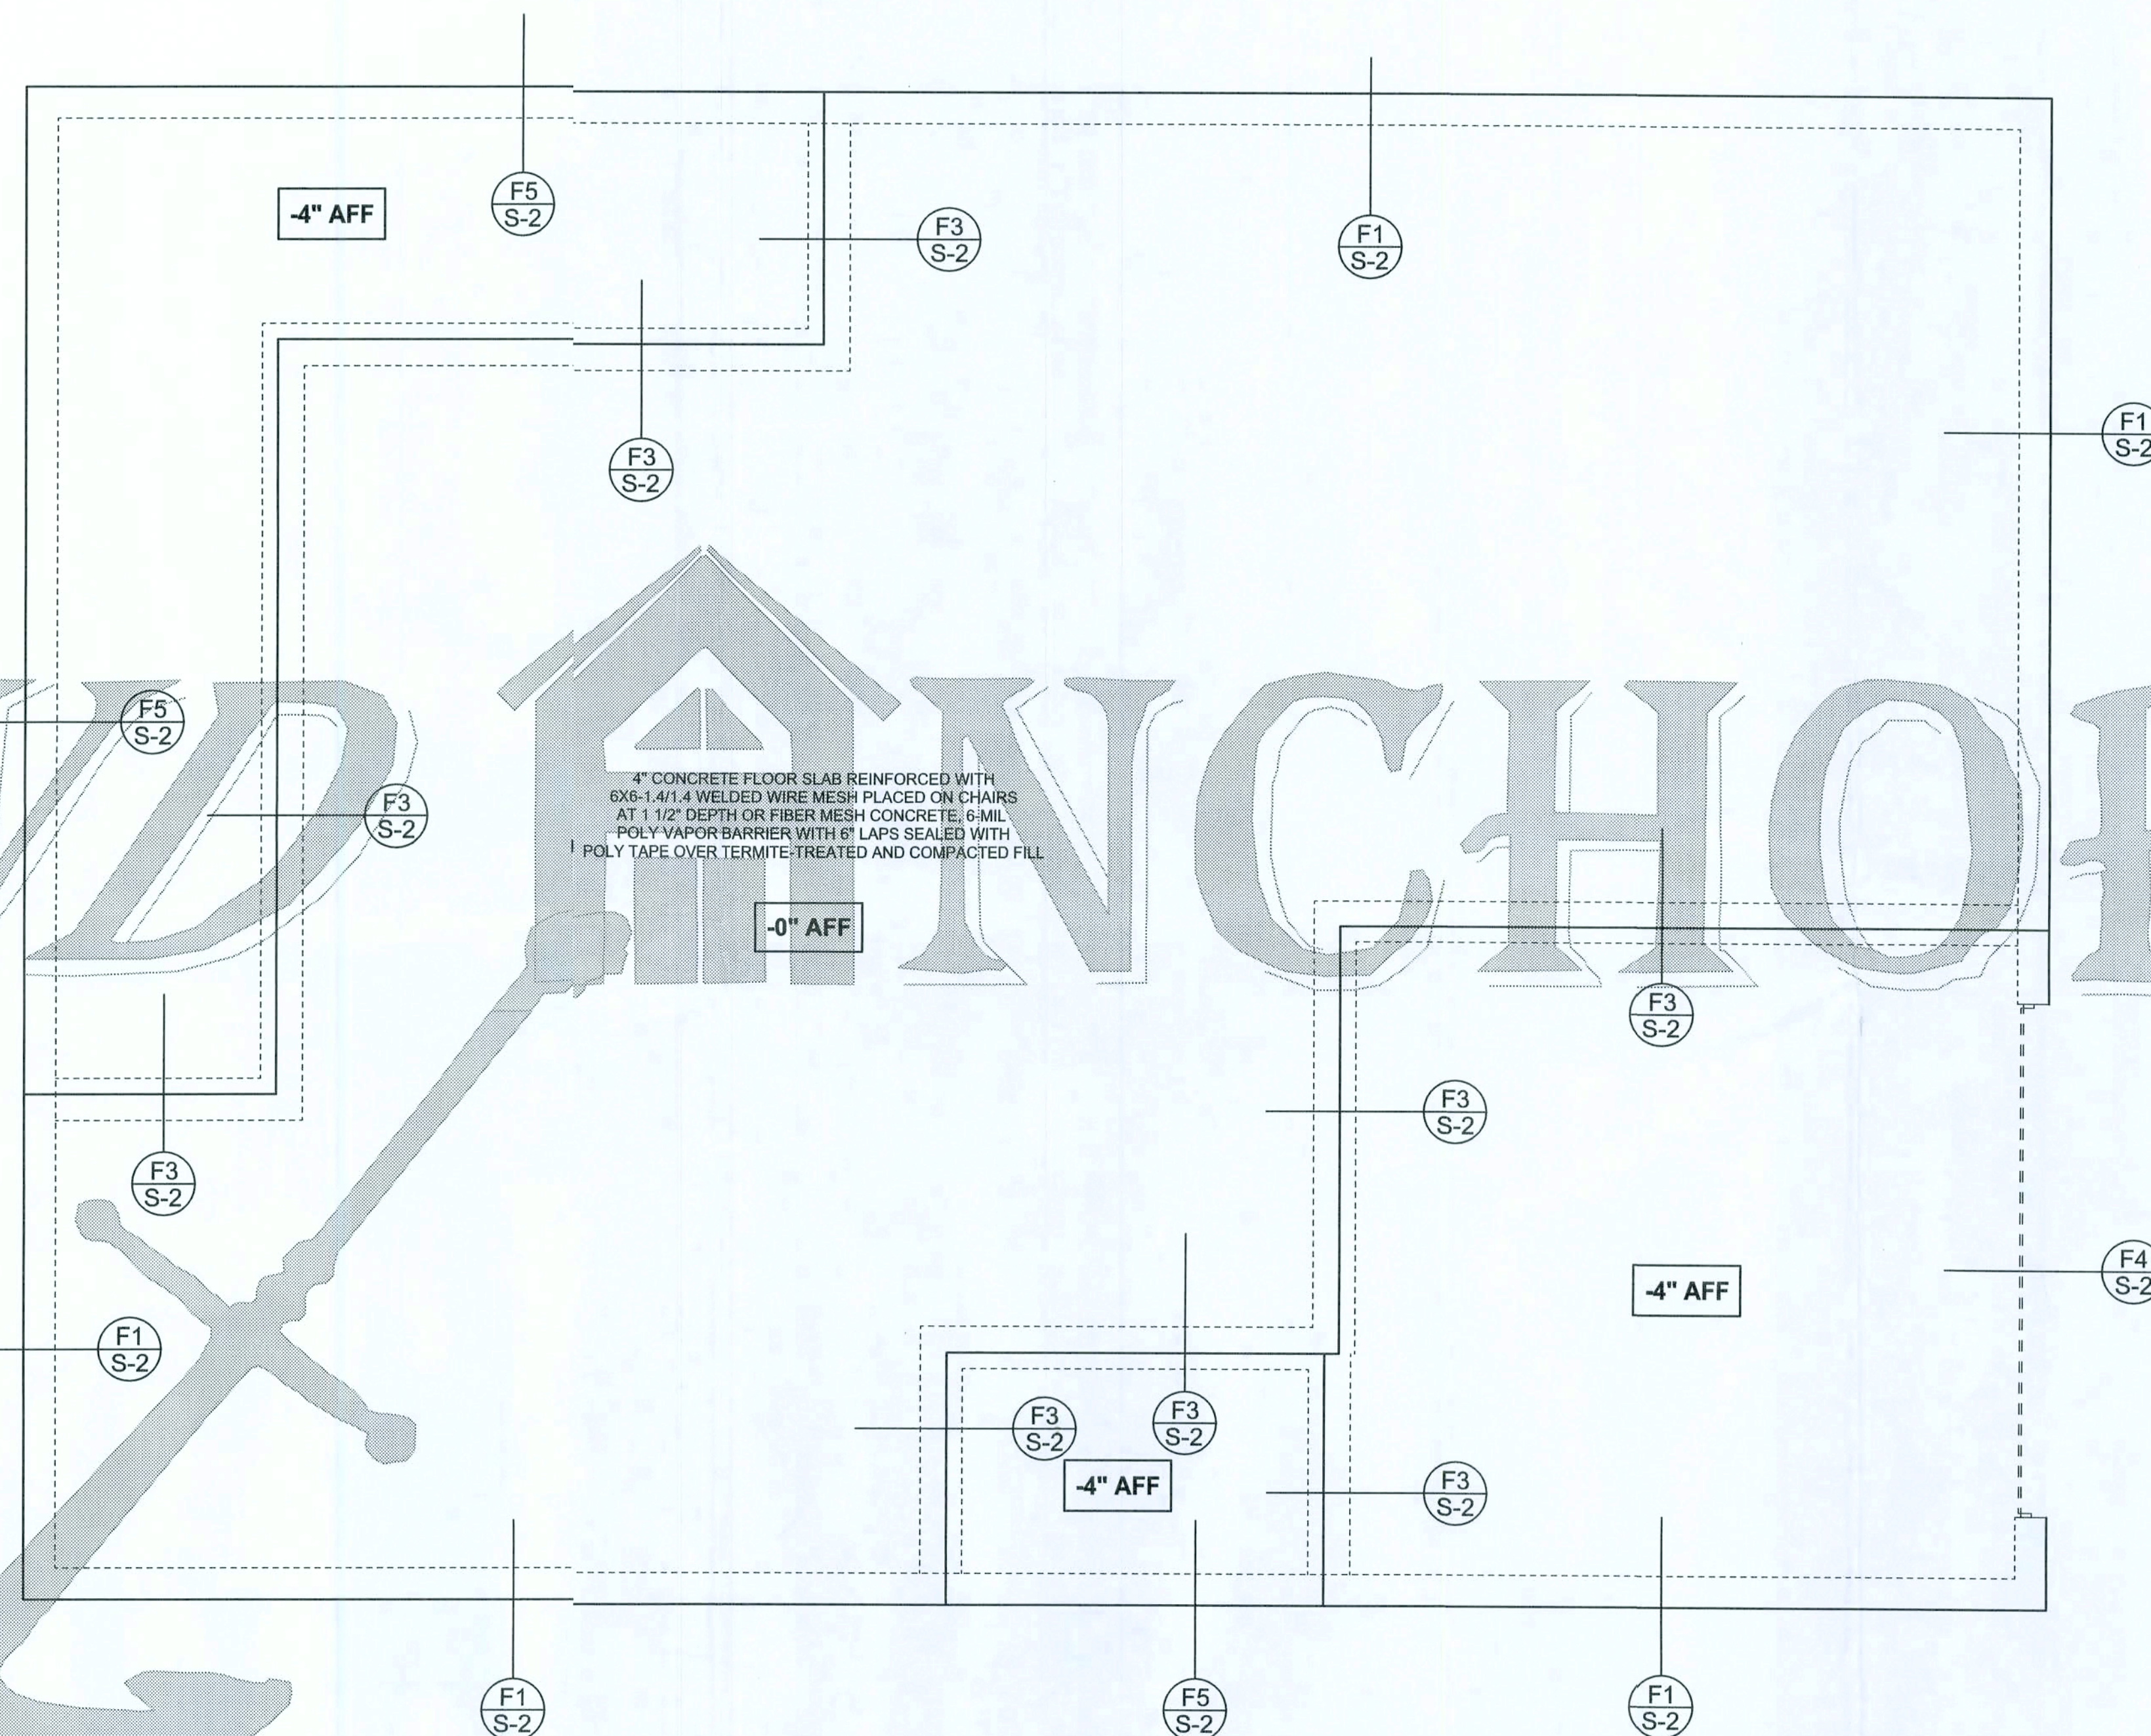

FOUNDATION PLAN
SCALE: 1/4" = 1'-0"
DIMENSIONS ON STRUCTURAL SHEETS ARE NOT EXACT. REFER TO ARCHITECTURAL FLOOR PLAN FOR ACTUAL DIMENSIONS

WINDLOAD ENGINEER: Mark Disosway,
PE No. 53915, P.O. Box 868, Lake City, FL
32056, 386-754-5419

DIMENSIONS:
Stated dimensions supersede scaled dimensions. Refer all questions to Mark Disosway, P.E. for resolution. Do not proceed without clarification.

COPYRIGHTS AND PROPERTY RIGHTS:
Mark Disosway, P.E. hereby expressly reserves its common law copyrights and property right in these instruments of service. This document is not to be reproduced, altered or copied in any form or manner without first the express written permission and consent of Mark Disosway.

CERTIFICATION: I hereby certify that I have examined this plan, and that the applicable portions of this plan, relating to wind engineering comply with section F301.2.1, Florida building code residential 2004, to the best of my knowledge.

LIMITATION: This design is valid for one building, at specified location.

MARK DISOSWAY
P.E. 53915

Mark Disosway
30 AUG 07
SEAL

Lee & Angie
Blatter Residence

ADDRESS:
17 SW Velma Glen
Lake City, Florida 32024

Mark Disosway P.E.
P.O. Box 868
Lake City, Florida 32056
Phone: (386) 754 - 5419
Fax: (386) 269 - 4871

PRINTED DATE:
August 30, 2007

DRAWN BY: CHECKED BY:

FINAL DATE:
30 / Aug / 07

JCB NUMBER:
708298


DRAWING NUMBER

S-2

OF 3 SHEETS

REVISIONS	

SOFTPLAN
ARCHITECTURAL DESIGN SOFTWARE

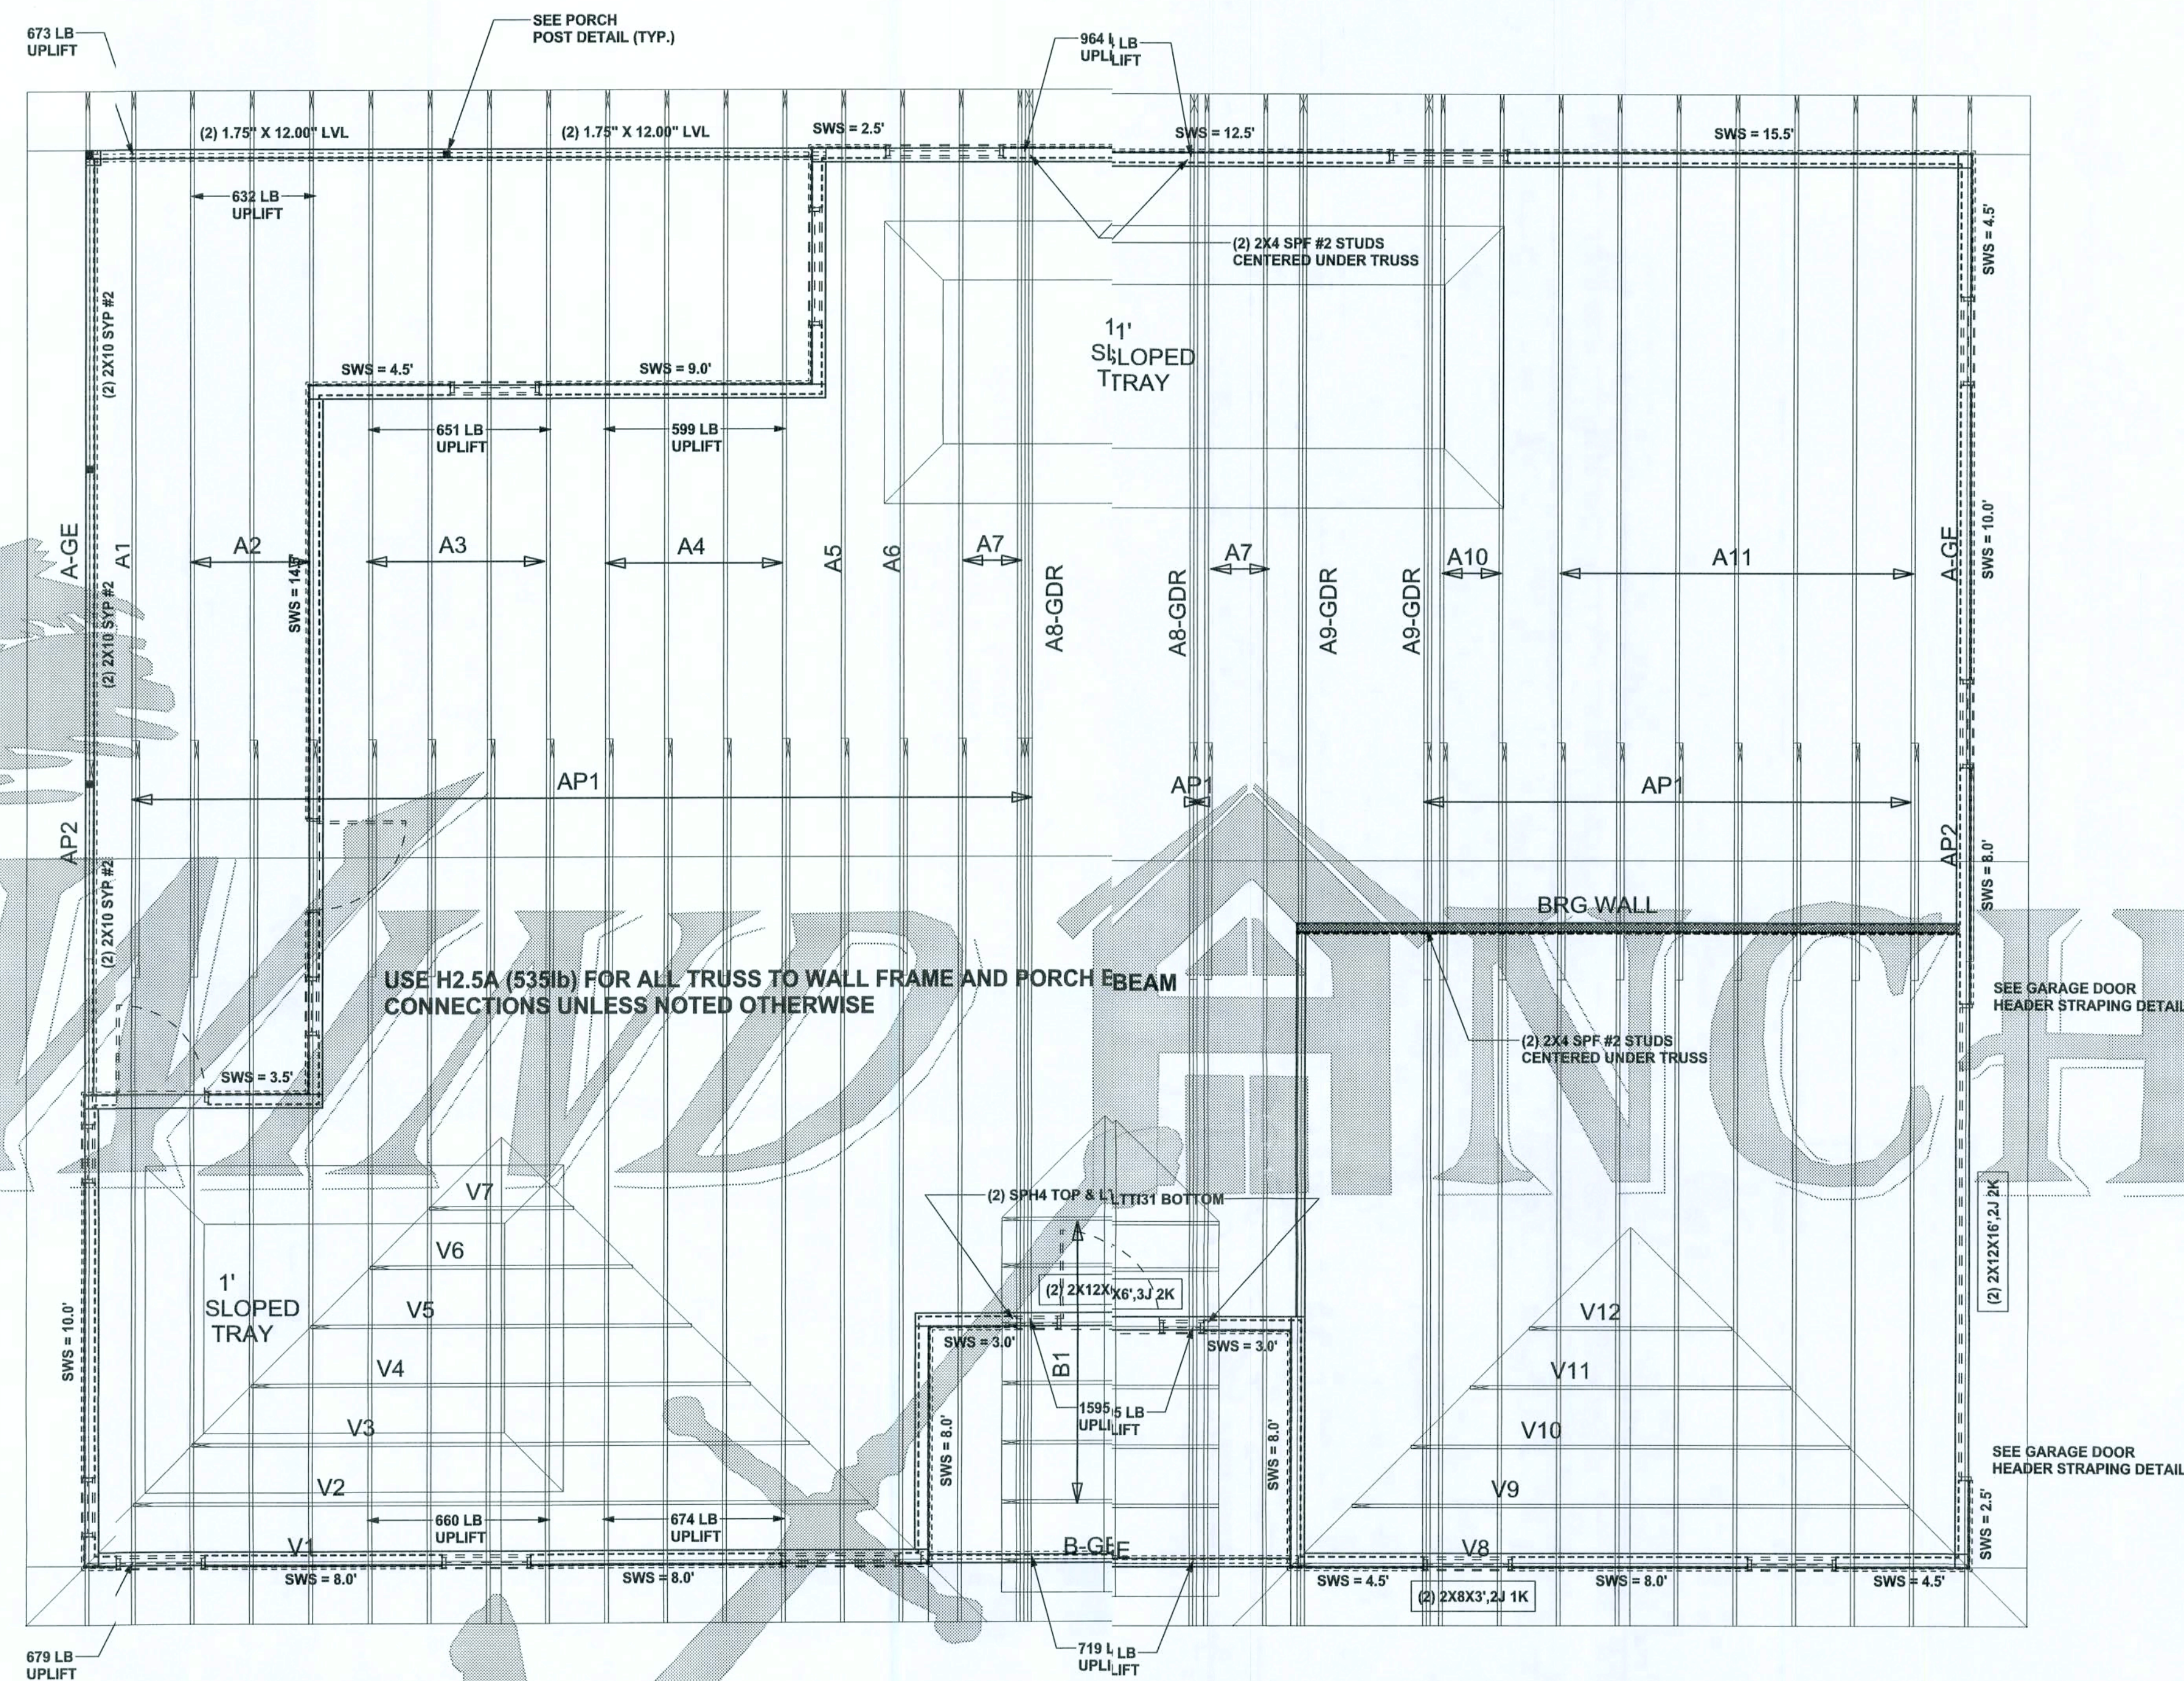

STRUCTURAL PLAN
SCALE: 1/4" 1'-0"


STRUCTURAL PLAN NOTES

- SN-1 A. LOAD BEARING FRAME WALL & PORCH HEADERS SHALL BE A MINIMUM OF (2) 2X8 SYP #2 (U.N.O.)
- SN-2 A. LOAD BEARING FRAME WALL HEADERS SHALL HAVE (1) JACK STUD & (1) KING STUD EACH SIDE (U.N.O.)
- SN-3 DIMENSIONS ON STRUCTURAL SHEETS ARE NOT EXACT. REFER TO ARCHITECTURAL FLOOR PLAN FOR ACTUAL DIMENSIONS
- SN-4 PERMANENT TRUSS BRACING IS TO BE INSTALLED AT LOCATIONS AS SHOWN ON THE SEALED TRUSS DRAWINGS. LATERAL BRACING IS TO BE RESTRAINED PER BCSI-03, B31-B1, BCSI-B2, & BCSI-B3. BCSI-B1, BCSI-B2, & BCSI-B3 ARE FURNISHED BY THE TRUSS SUPPLIER, WITH THE SEALED TRUSS PACKAGE

WALL LEGEND

SWS = 0.0'	1ST FLOOR EXTERIOR WALL
SWS = 0.0'	2ND FLOOR EXTERIOR WALL
IBW	1ST FLOOR INTERIOR BEARING WALL
IBW	2ND FLOOR INTERIOR BEARING WALL

HEADER LEGEND

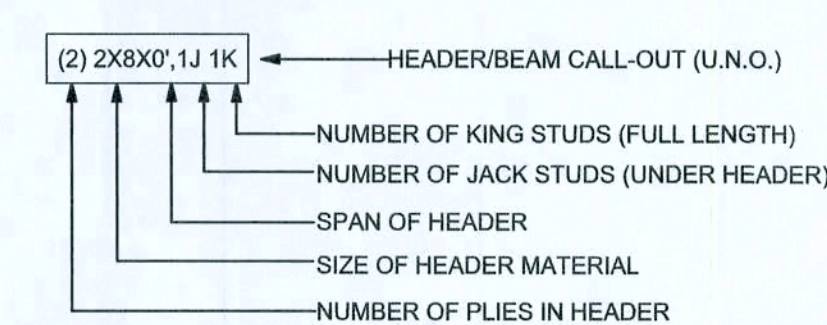

TOTAL SHEAR WALL SEGMENTS

SWS = 0.0' INDICATES SHEAR WALL SEGMENTS

	REQUIRED	ACTUAL
TRANSVERSE	36.9'	65.5'
LONGITUDINAL	34.2'	80.5'

CONNECTIONS, WALL, & HEADER DESIGN IS BASED ON REACTIONS & UPLIFTS FROM TRUSS ENGINEERING FURNISHED BY BUILDER, ANDERSON TRUSS
JOB #Blatter

WINDLOAD ENGINEER: Mark Disosway,
P.E. No. 5315, P.O. Box 868, Lake City, FL
32056, 387-5419

DIMENSIONS:
Stated dimensions supercede scaled
dimensions. Refer all questions to
Mark Disosway, P.E. for resolution.
Do not proceed without clarification.

COPYRIGHTS AND PROPERTY RIGHTS:
Mark Disosway, P.E. hereby expressly reserves
its common law copyrights and property right in
these instruments of service. This document is
not to be reproduced, altered or copied in any
form or manner without first the express written
permission and consent of Mark Disosway.

CERTIFICATION: I hereby certify that I have
examined this plan, and that the applicable
portions of the plan, relating to wind engineering
comply with section F301.2.1, Florida building
code residential 2004, to the best of my
knowledge.

LIMITATION: This design is valid for one
building, at specified location.

MARK DISOSWAY
P.E. 5315

30 AUG 07
SEAL

Lee & Angie
Blatter Residence

ADDRESS:
187 SW Velma Glen
Lake City, Florida 32024

Mark Disosway P.E.
P.O. Box 868
Lake City, Florida 32056
Phone: (386) 754 - 5419
Fax: (386) 269 - 4871

PRINTED DATE:
August 30, 2007

DRAWN BY: CHECKED BY:

FINAL DATE:
30 / Aug / 07

JOB NUMBER:
708298

DRAWING NUMBER

S-3

OF 3 SHEETS