



REVISIONS SCHEDULE		
Sep 21st, 2022	PROPOSAL	
Feb. 13th, 2023	PROPOSAL	

SCOTT & KIM MORRIS RESIDENCE



COLUMBIA COUNTY, FLORIDA

**RIDGEPOINT
DESIGN, INC**
496 SW RING CT, LAKE CITY, FLORIDA 32025
P: 386-288-1188
E: RIDGEPOINTDESIGN@GMAIL.COM

SHEET NUMBER

A.1

OF 4 SHEETS

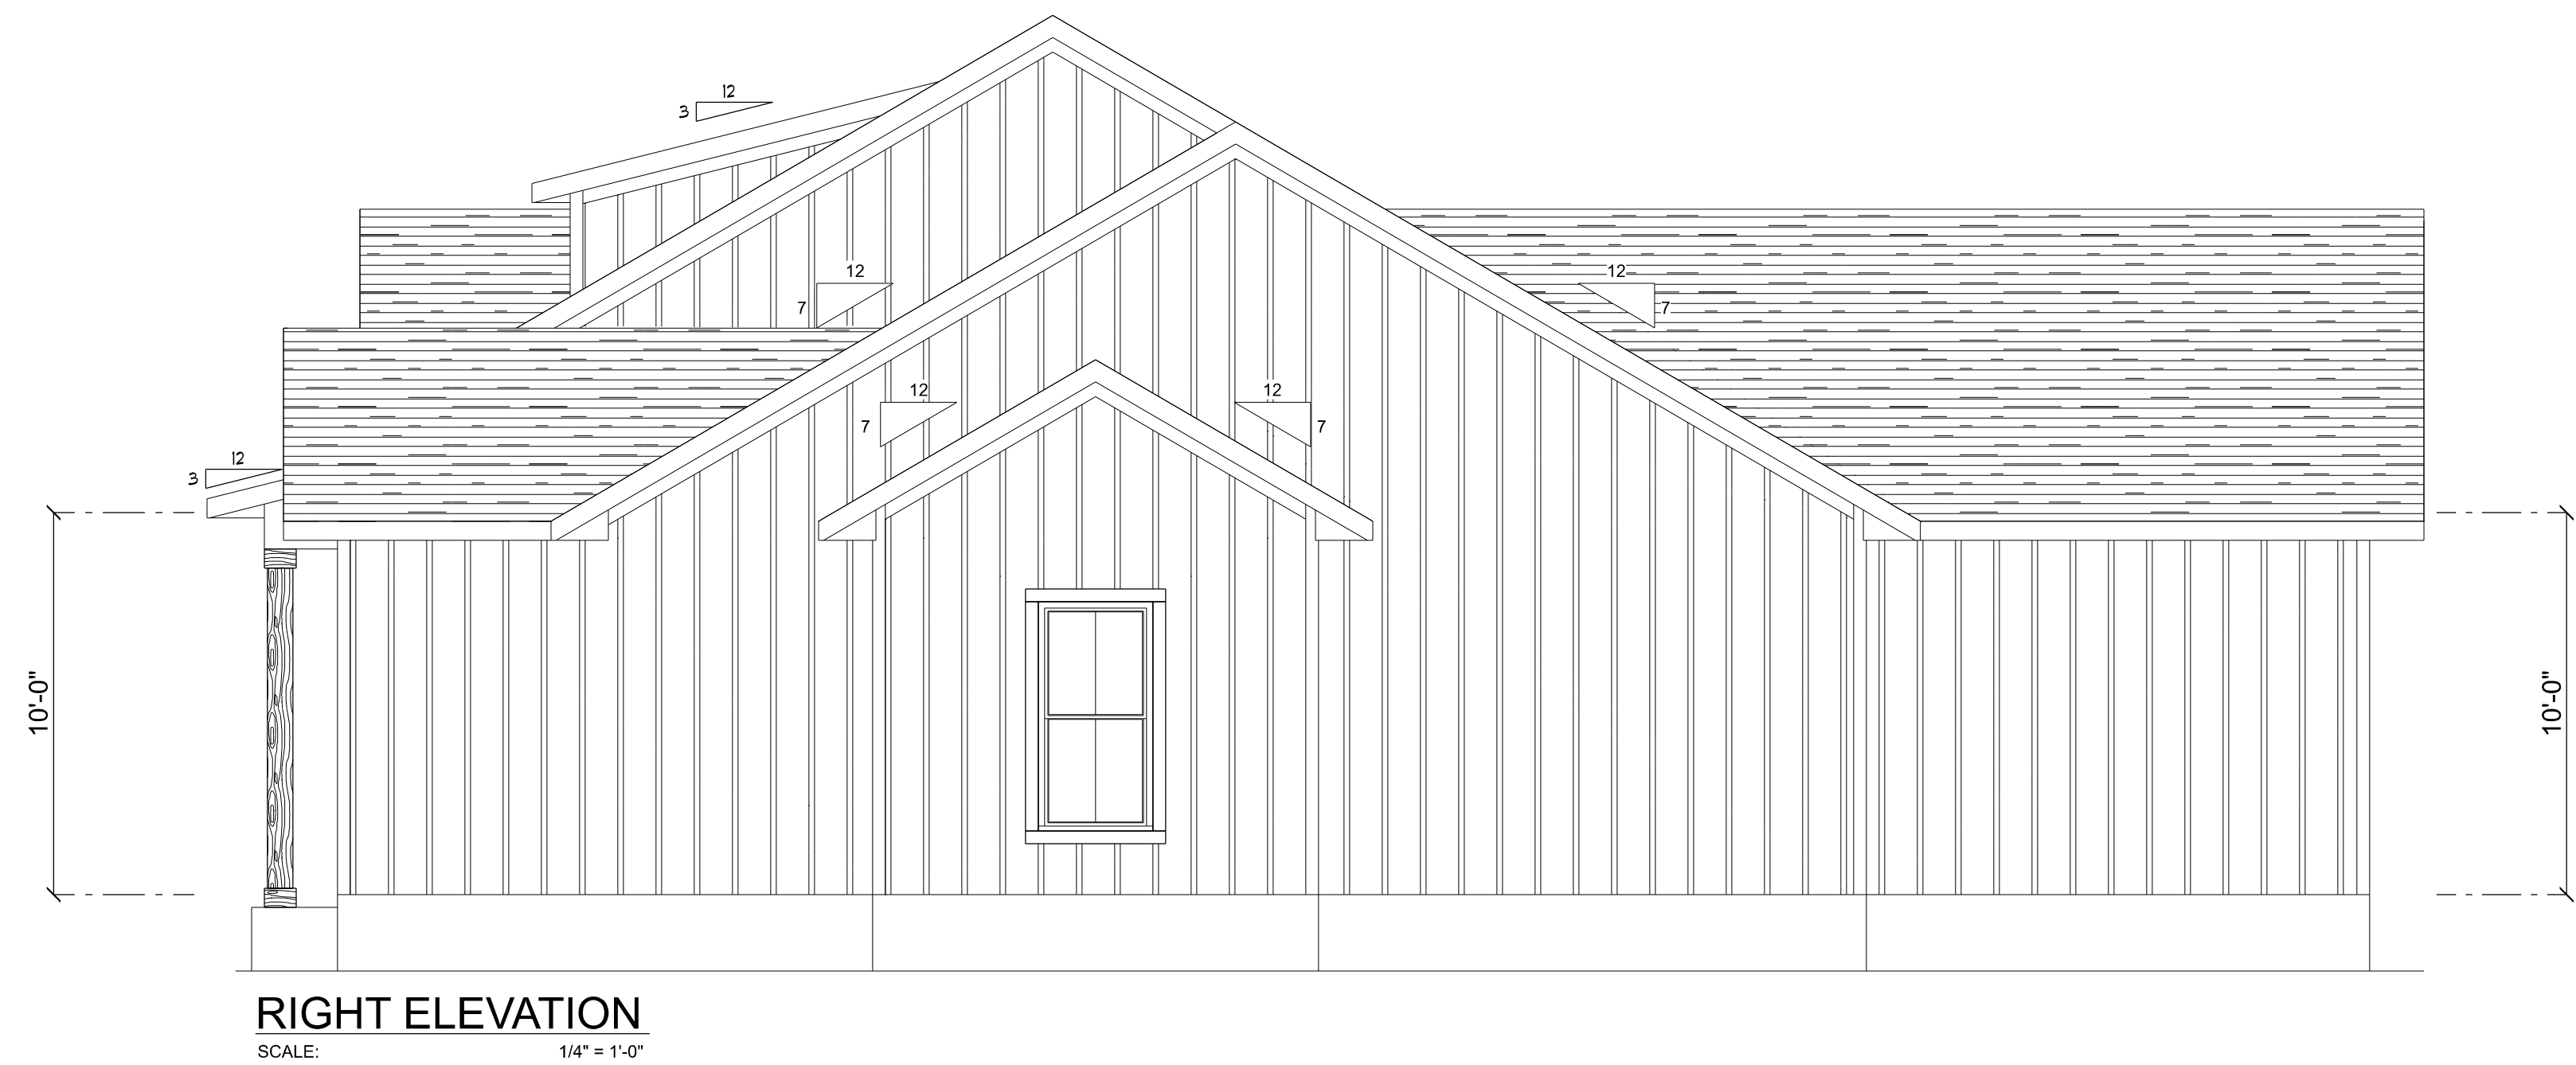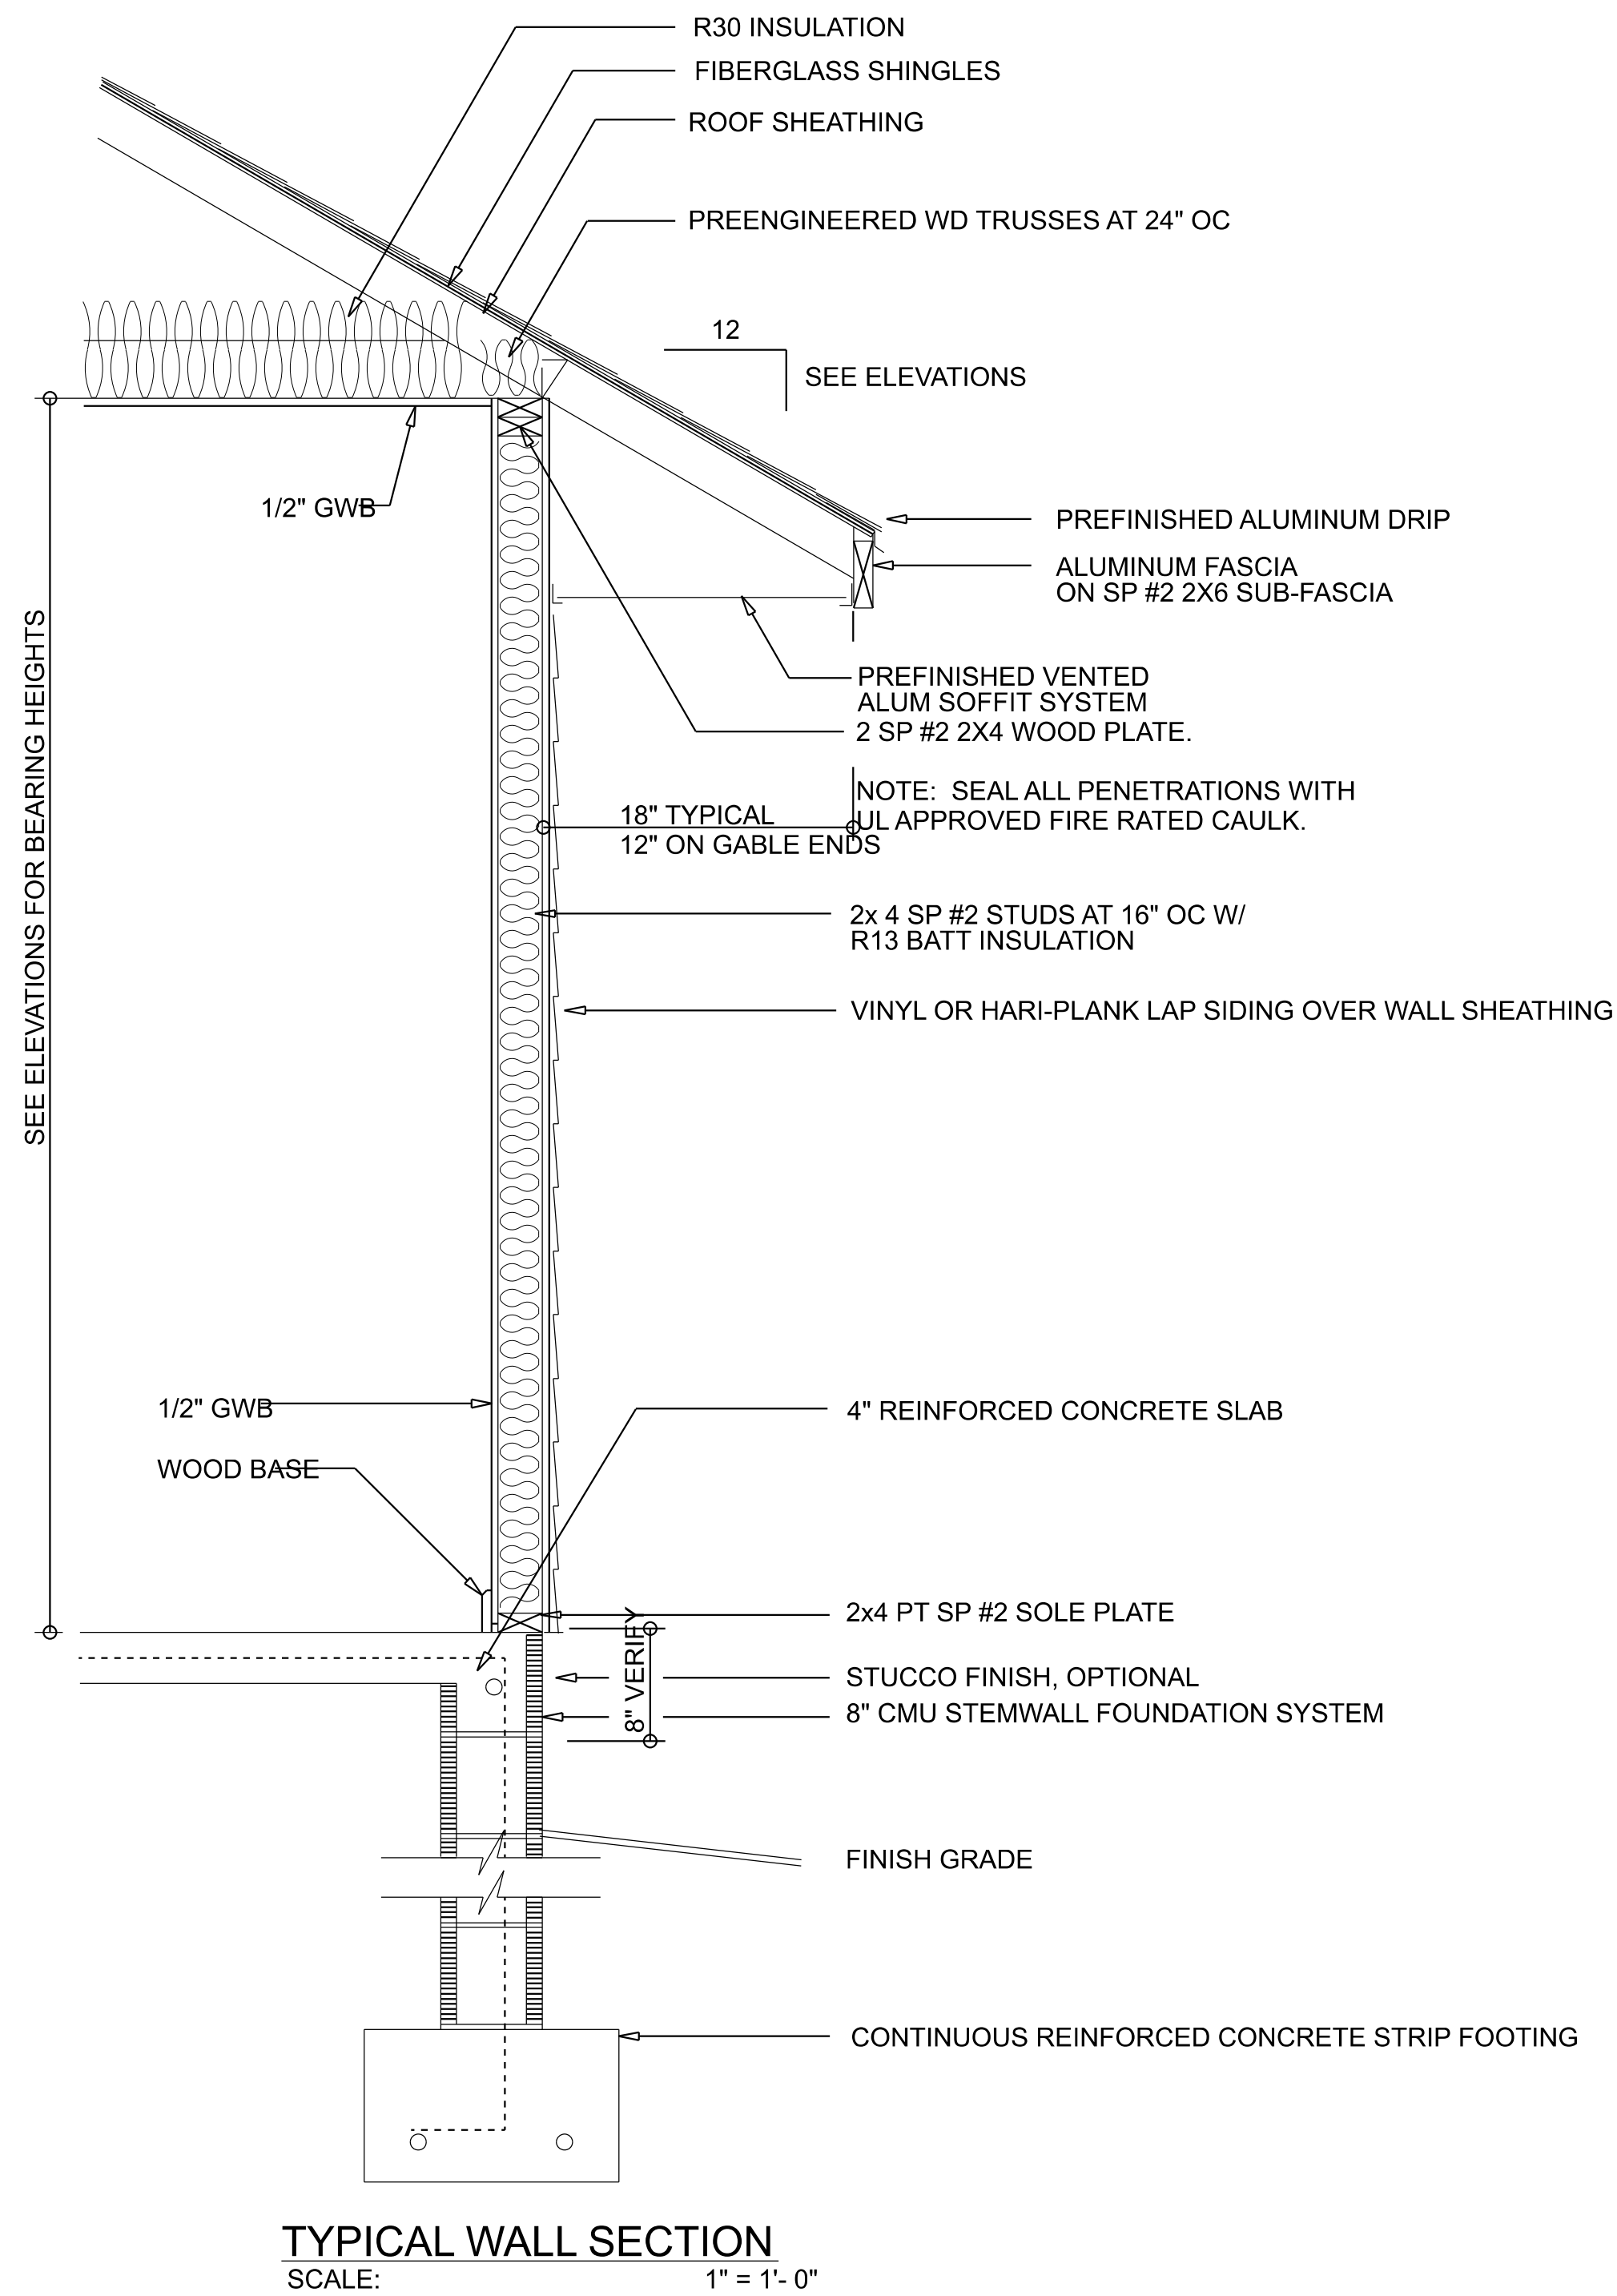

REVISIONS SCHEDULE	
Sep 21st, 2022	PROPOSAL
Feb. 13th, 2023	PROPOSAL

SCOTT & KIM MORRIS RESIDENCE
COLUMBIA COUNTY, FLORIDA


**RIDGEPOINT
DESIGN, INC**
496 SW RING CT, LAKE CITY, FLORIDA 32025
P: 386-288-1188
E: RIDGEPOINTDESIGN@GMAIL.COM

Garage fire separations shall comply with the following:

1. The private garage shall be separated from the dwelling unit and its attic area by means of a minimum 1/2-inch (12.7 mm) gypsum board applied to the garage side. Garages beneath habitable rooms shall be separated from all habitable rooms above by not less than 5/8-inch Type X gypsum board or equivalent. Door openings between a private garage and the dwelling unit shall be equipped with either solid wood doors, or solid or honeycomb core steel doors not less than 13/8 inches (34.9 mm) thick, or doors in compliance with Section 715.3.3. Openings from a private garage directly into a room used for sleeping purposes shall not be permitted.
2. Ducts in a private garage and ducts penetrating the walls or ceilings separating the dwelling unit from the garage shall be constructed of a minimum 0.019-inch (0.48 mm) sheet steel and shall have no openings into the garage.
3. A separation is not required between a Group R-3 and U carport provided the carport is entirely open on two or more sides and there are not enclosed areas above.
4. When installing an attic access and/or pull-down stair unit in the garage, devise shall have a minimum 20 min. fire rating.

DIMENSIONED FLOOR PLAN


SCALE: 1/4" = 1'-0"

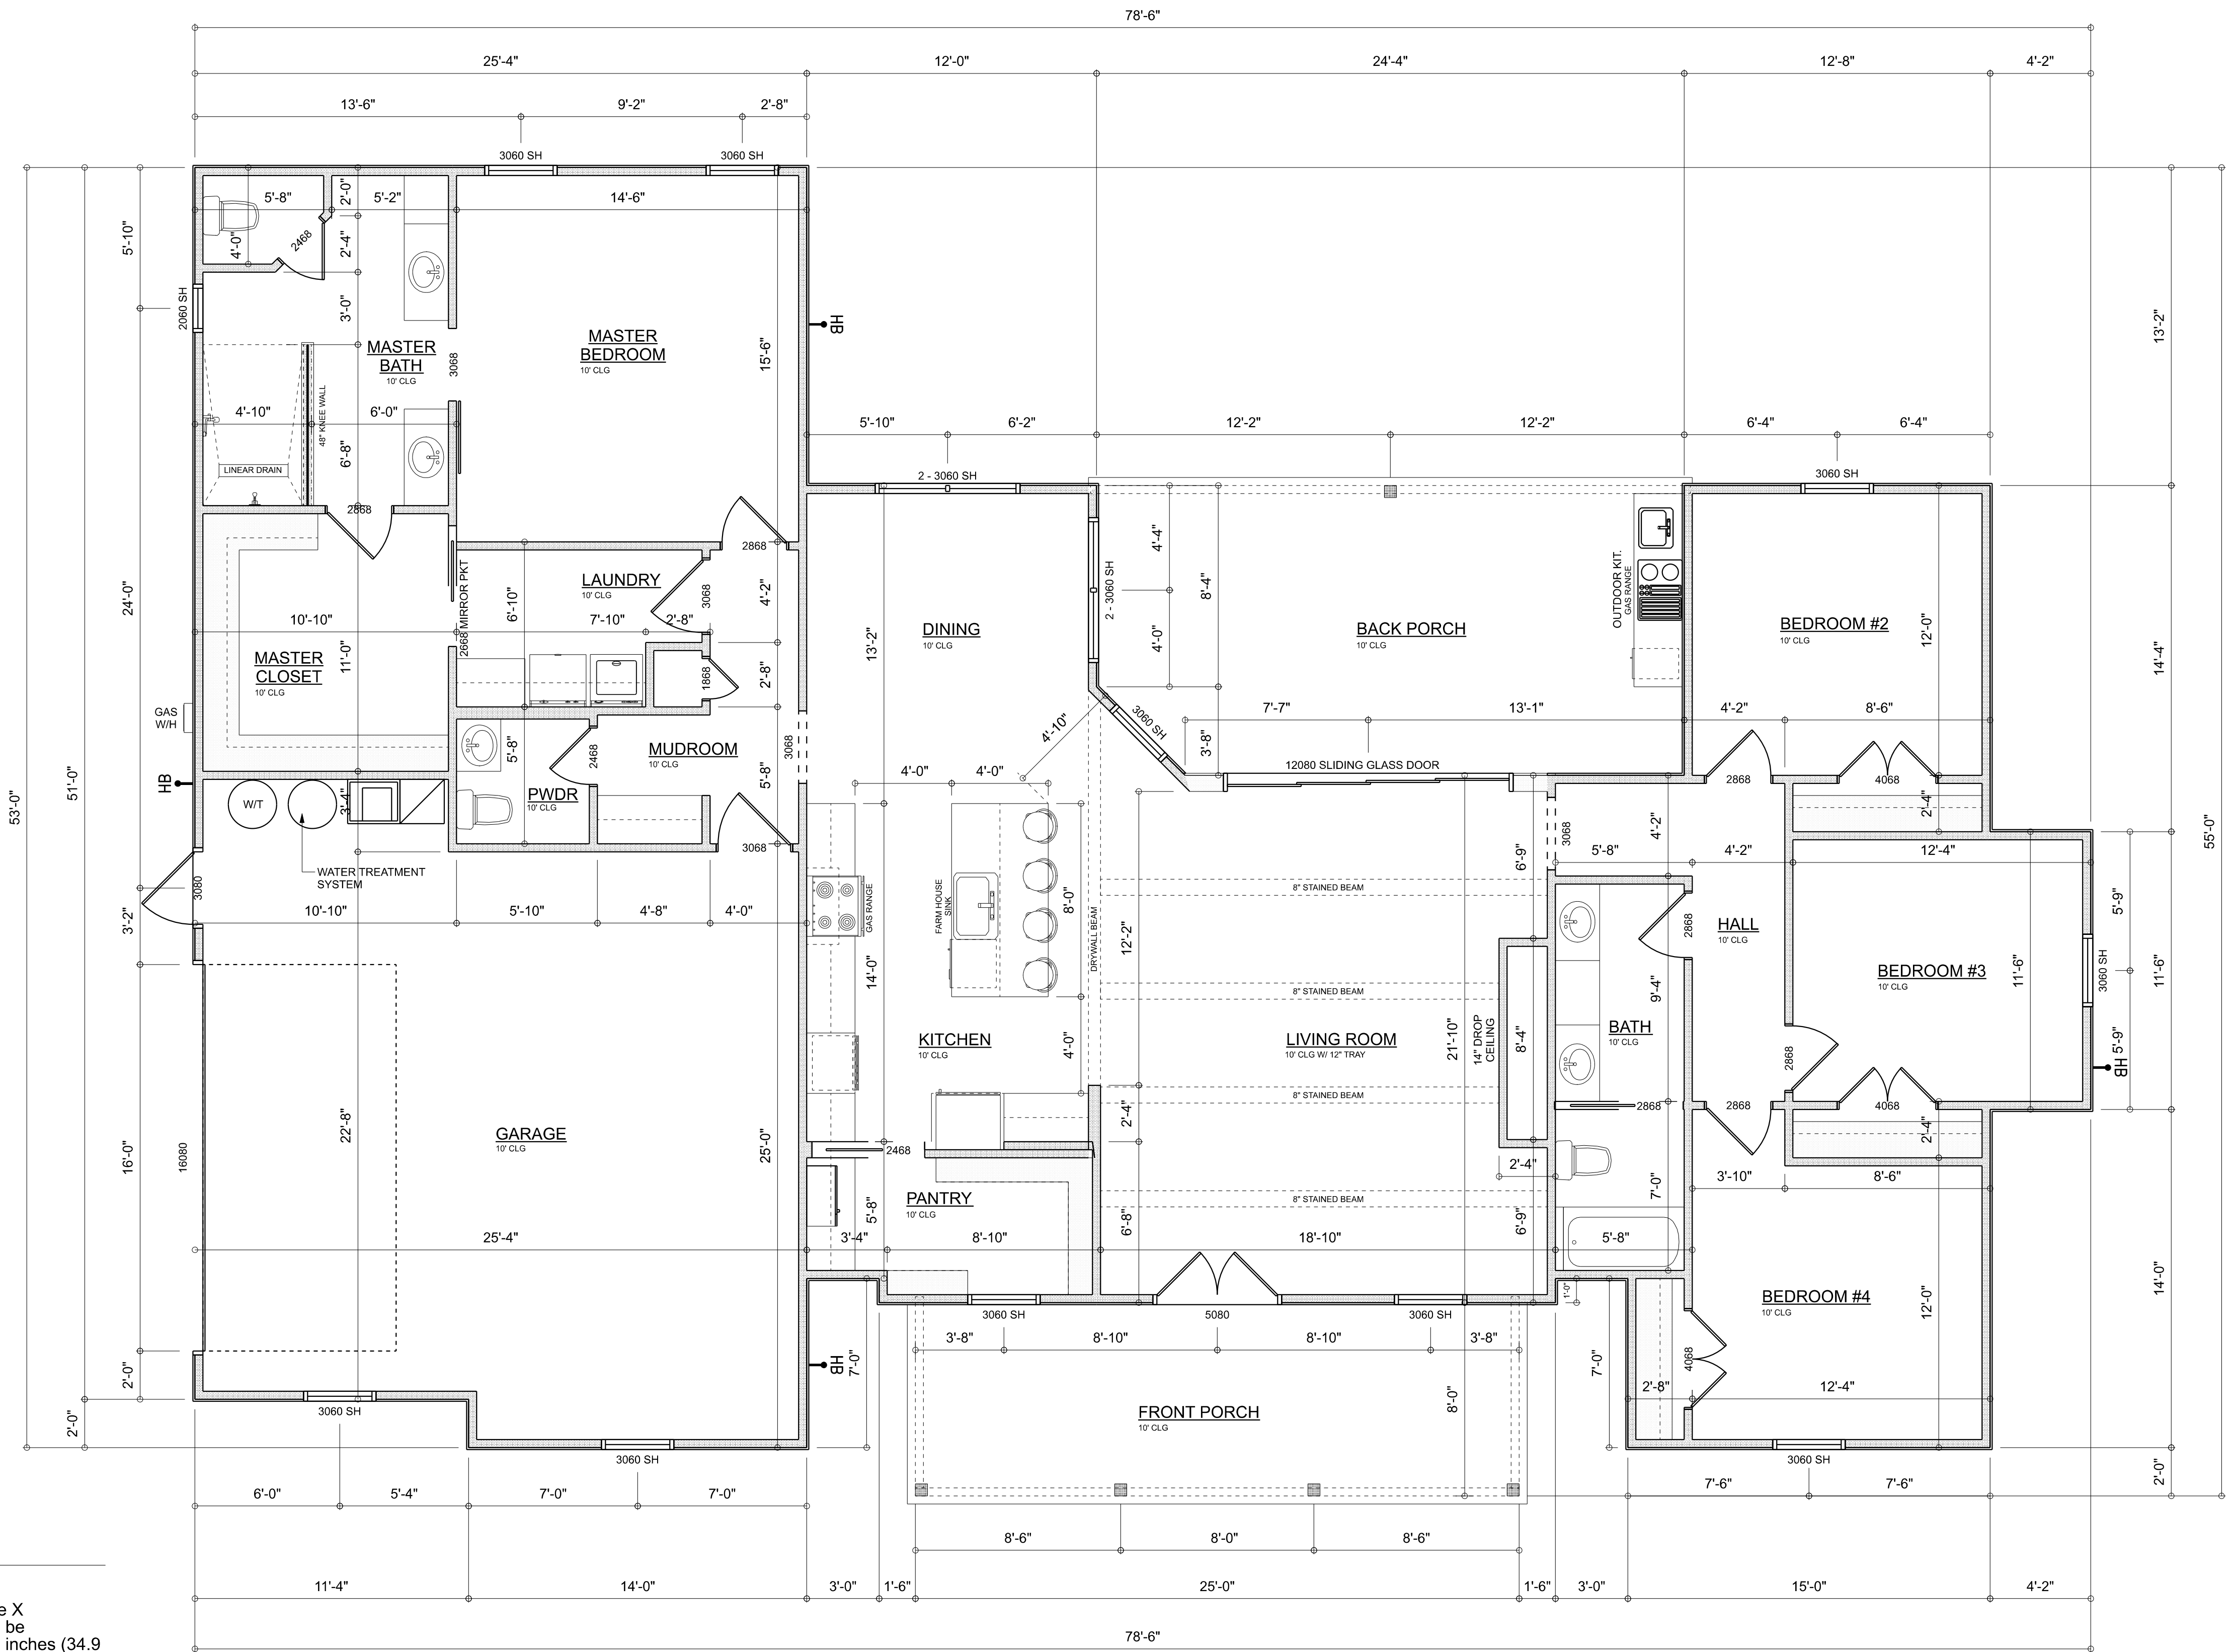

AREA SUMMARY

LIVING	2,189	S.F.
FRONT PORCH	200	S.F.
BACK PORCH	285	S.F.
GARAGE	627	S.F.
TOTAL AREA	3,301	S.F.
TOTAL CUBIC SQ. FOOTAGE OF CONDITIONED SPACE: 21,890		

REVISIONS SCHEDULE	
Sep 21st, 2022	PROPOSAL
Feb. 13th, 2023	PROPOSAL

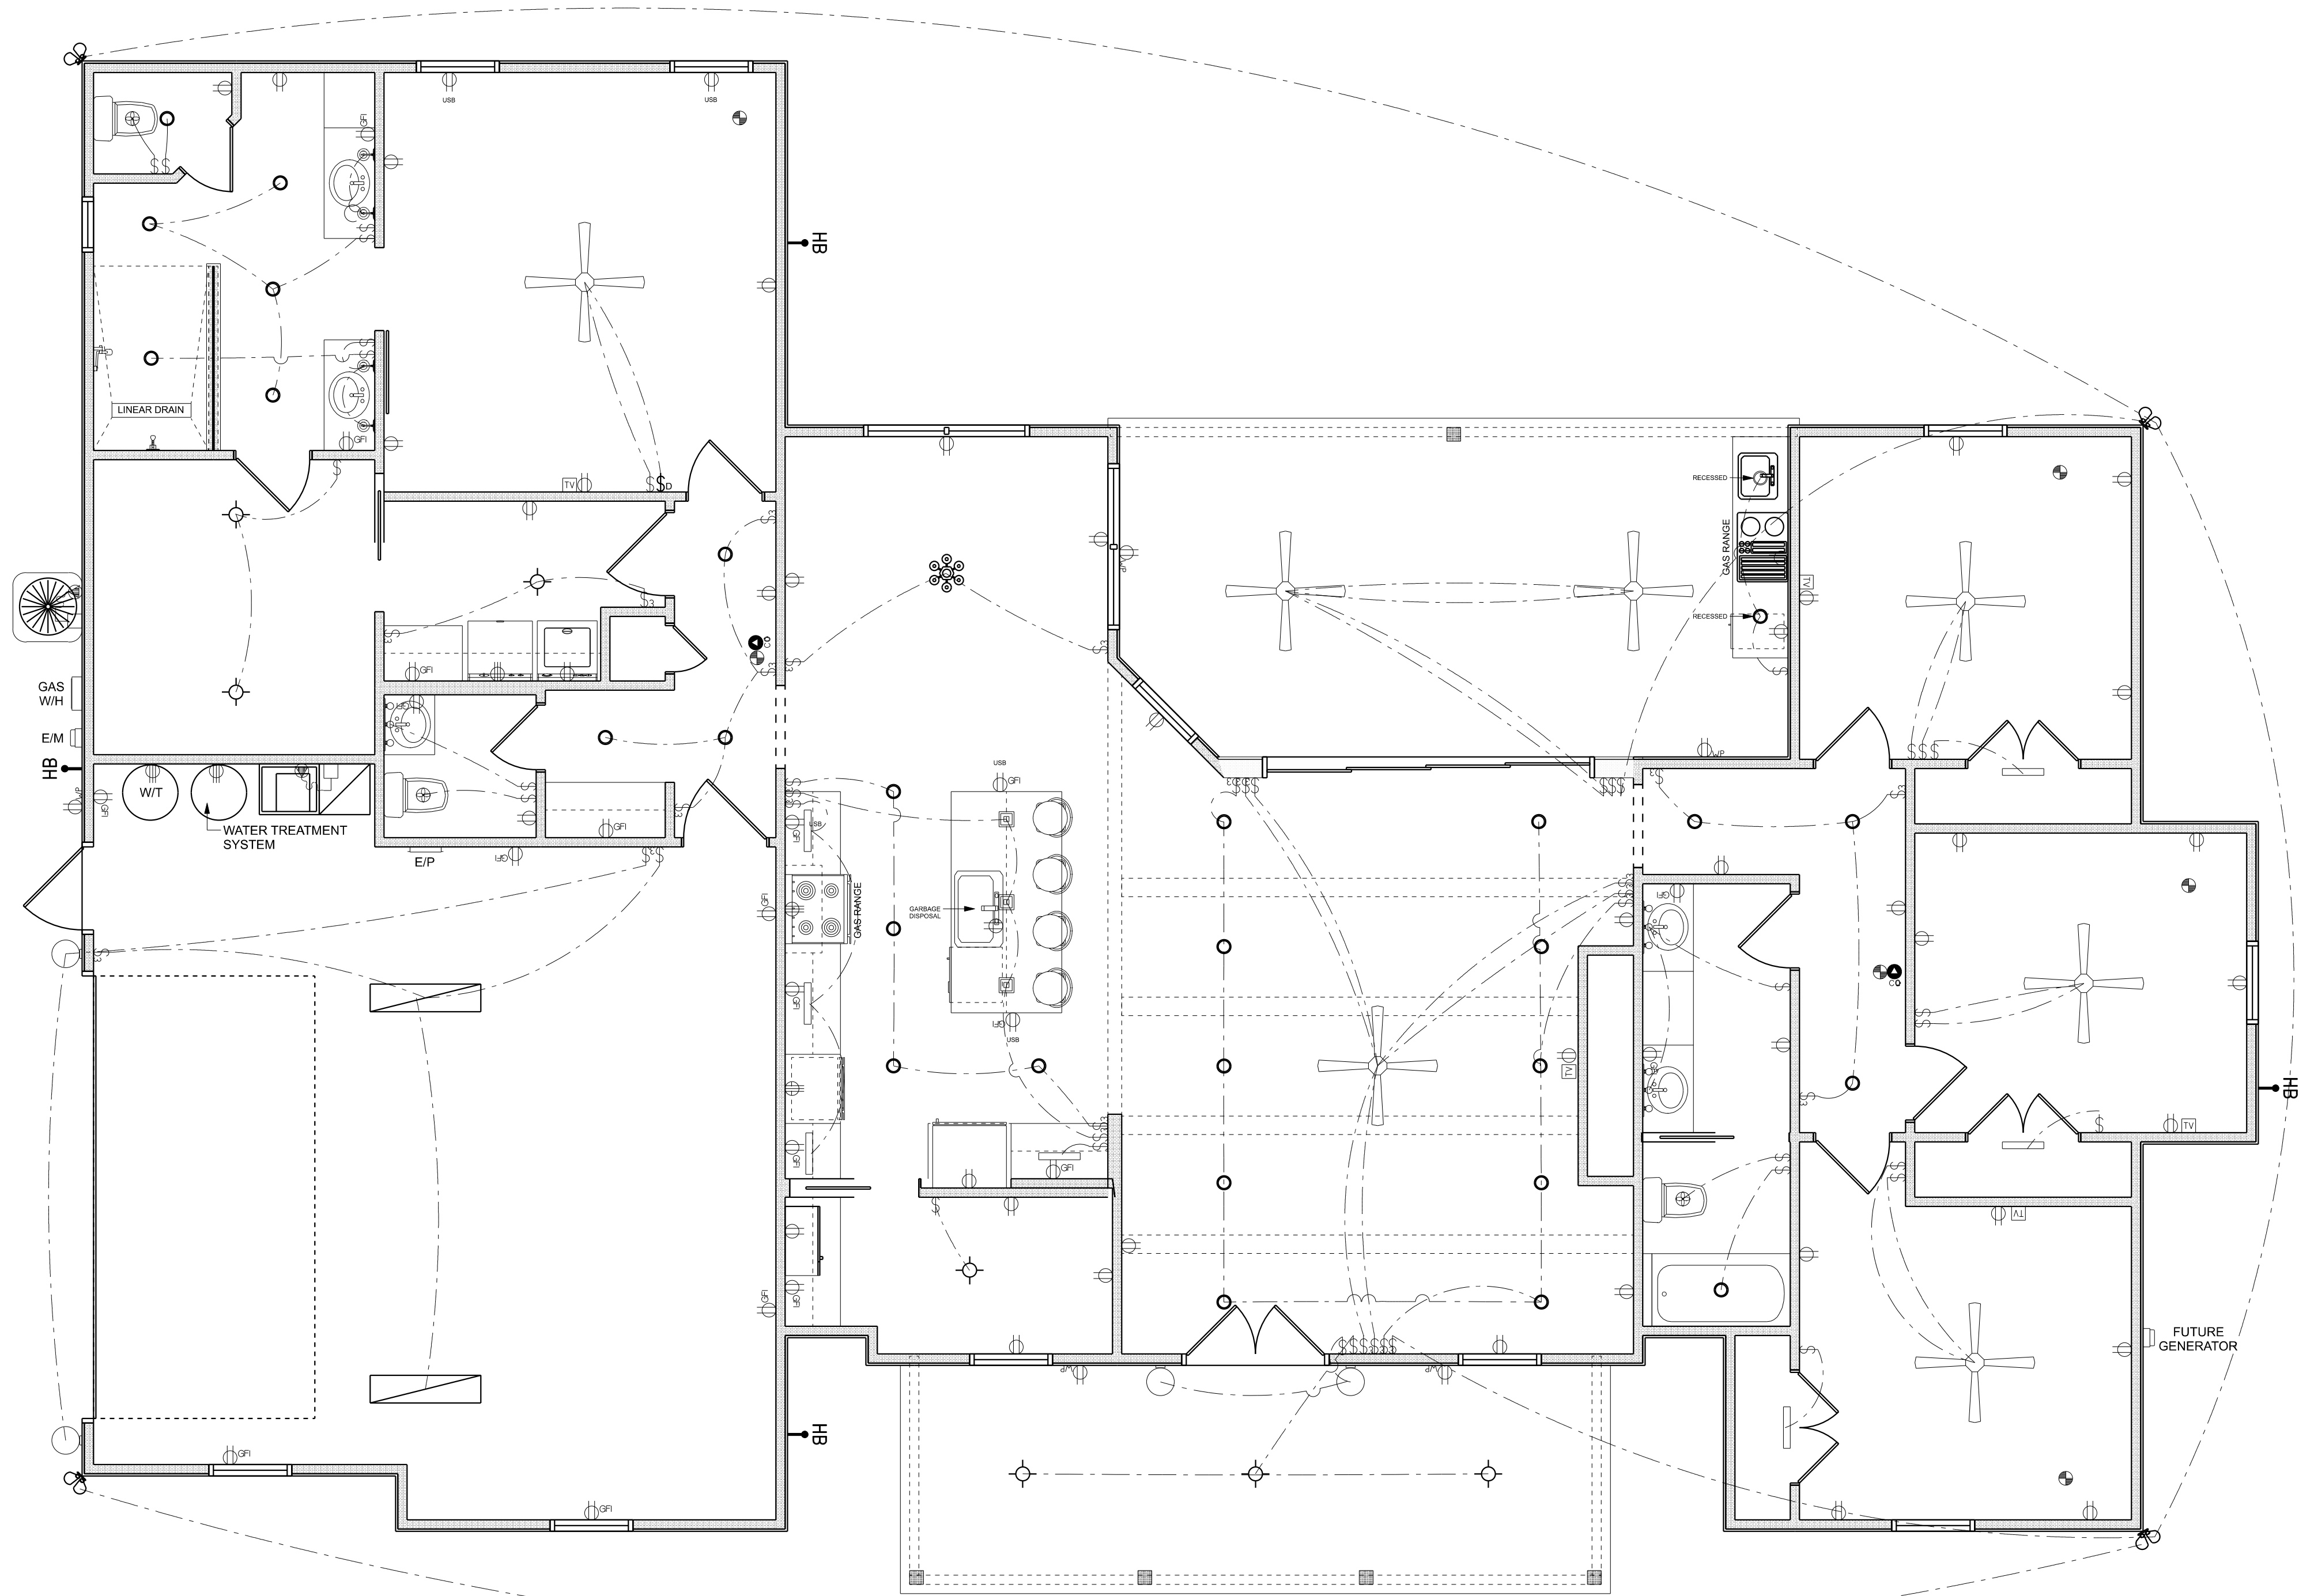

ELECTRICAL FLOOR PLAN
SCALE: 1/4" = 1'-0"

ELECTRICAL LEGEND		
ELECTRICAL	COUNT	SYMBOL
CEILING FAN	7	
CAN LIGHT 6inch	29	
CHANDELIER	1	
LED CEILING LIGHT 1x4	2	
uplight	7	
EXTERIOR SCONCE	4	
MOTION SECURITY LIGHT	4	
AC DISCONNECT	2	
CABLE TV OUTLET	5	
CARBON DETECTOR	2	
EXHAUST FAN	3	
OUTLET	45	
OUTLET 220v	6	
OUTLET GFI	20	
OUTLET WP	5	
SMOKE DETECTOR	6	
STANDARD LIGHT	7	
SWITCH	33	
SWITCH 3 WAY	25	
VANITY BAR LIGHT - SMALL	3	
VANITY WALL SCONCE	4	
ELECTRIC PANEL	1	
PENDANT LIGHT	3	
SWITCH DIMMER	1	

ELECTRICAL PLAN NOTES:

INSTALLATION SHALL BE PER LATEST NAT'L ELECTRIC CODE.

WIRE ALL APPLIANCES, HVAC UNITS AND OTHER EQUIPMENT PER MANUF. SPECIFICATIONS

CONSULT WITH THE OWNER FOR THE NUMBER OF SEPERATE TELEPHONE LINES TO BE INSTALLED

ALL SMOKE DETECTORS SHALL BE 120v W/ BATTERY BACKUP OF THE PHOTOELECTRIC TYPE, AND SHALL BE INTERLOCKED TOGETHER. INSTALL INSIDE AND NEAR ALL BEDROOMS

TELEPHONE, TELEVISION AND OTHER LOW VOLTAGE DEVICES OR OUTLETS SHALL BE AS PER THE OWNER'S DIRECTIONS, & IN ACCORDANCE W/ APPLICABLE SECTIONS OF NEC-LATEST EDITION.

ALL RECEPTICALS, NOT OTHERWISE NOTED, SHALL BE ARC FAULT INTERRUPTER TYPE, EXCEPT DEDICATED OUTLETS

ALL RECEPTICALS IN WET AREAS SHALL BE GROUND FAULT INTERRUPTER TYPE (GFI)

ALL EXTERIOR RECEPTICALS SHALL BE WEATHERPROOF GROUD FAULT INTERRUPTER TYPE (WP/GFI)

NOTE:
ELECTRICAL CONTR SHALL PREPARE "AS-BUILT" SHOP DWGS INDICATING ALL ELECTRICAL WORK, INCLUDING ANY CHANGES TO THE ELEC. PLAN, ADD'NS TO THE ELEC. PLAN, RISER DIAGRAM, AS-BUILT PANEL SCHEDULE W/ ALL CKTS IDENTIFIED W/ CKT N°. DESCRIPTION & BRKR. SERVICE ENT. & ALL UNDERGROUND WIRE LOCATIONS/ROUTING / DEPTH. RISER DIA. SHALL INCLUDE WIRE SIZES/TYPE & EQUIPMENT TYPE W/ RATINGS & LOADS.
CONTRACTOR SHALL PROVIDE 1 COPY OF AS-BUILT DWGS TO OWNER & 1 COPY TO THE PERMIT ISSUING AUTHORITY

REVISIONS SCHEDULE	
Sep 21st, 2022	PROPOSAL
Feb. 13th, 2023	PROPOSAL

SCOTT & KIM MORRIS RESIDENCE

COLUMBIA COUNTY, FLORIDA

RIDGEPOINT
DESIGN, INC

496 SW RING CT, LAKE CITY, FLORIDA 32025
P: 386-288-1188
E: RIDGEPOINTDESIGN@GMAIL.COM

SHEET NUMBER

A.4

OF 4 SHEETS