
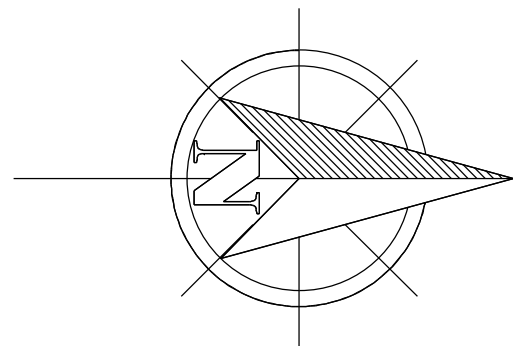


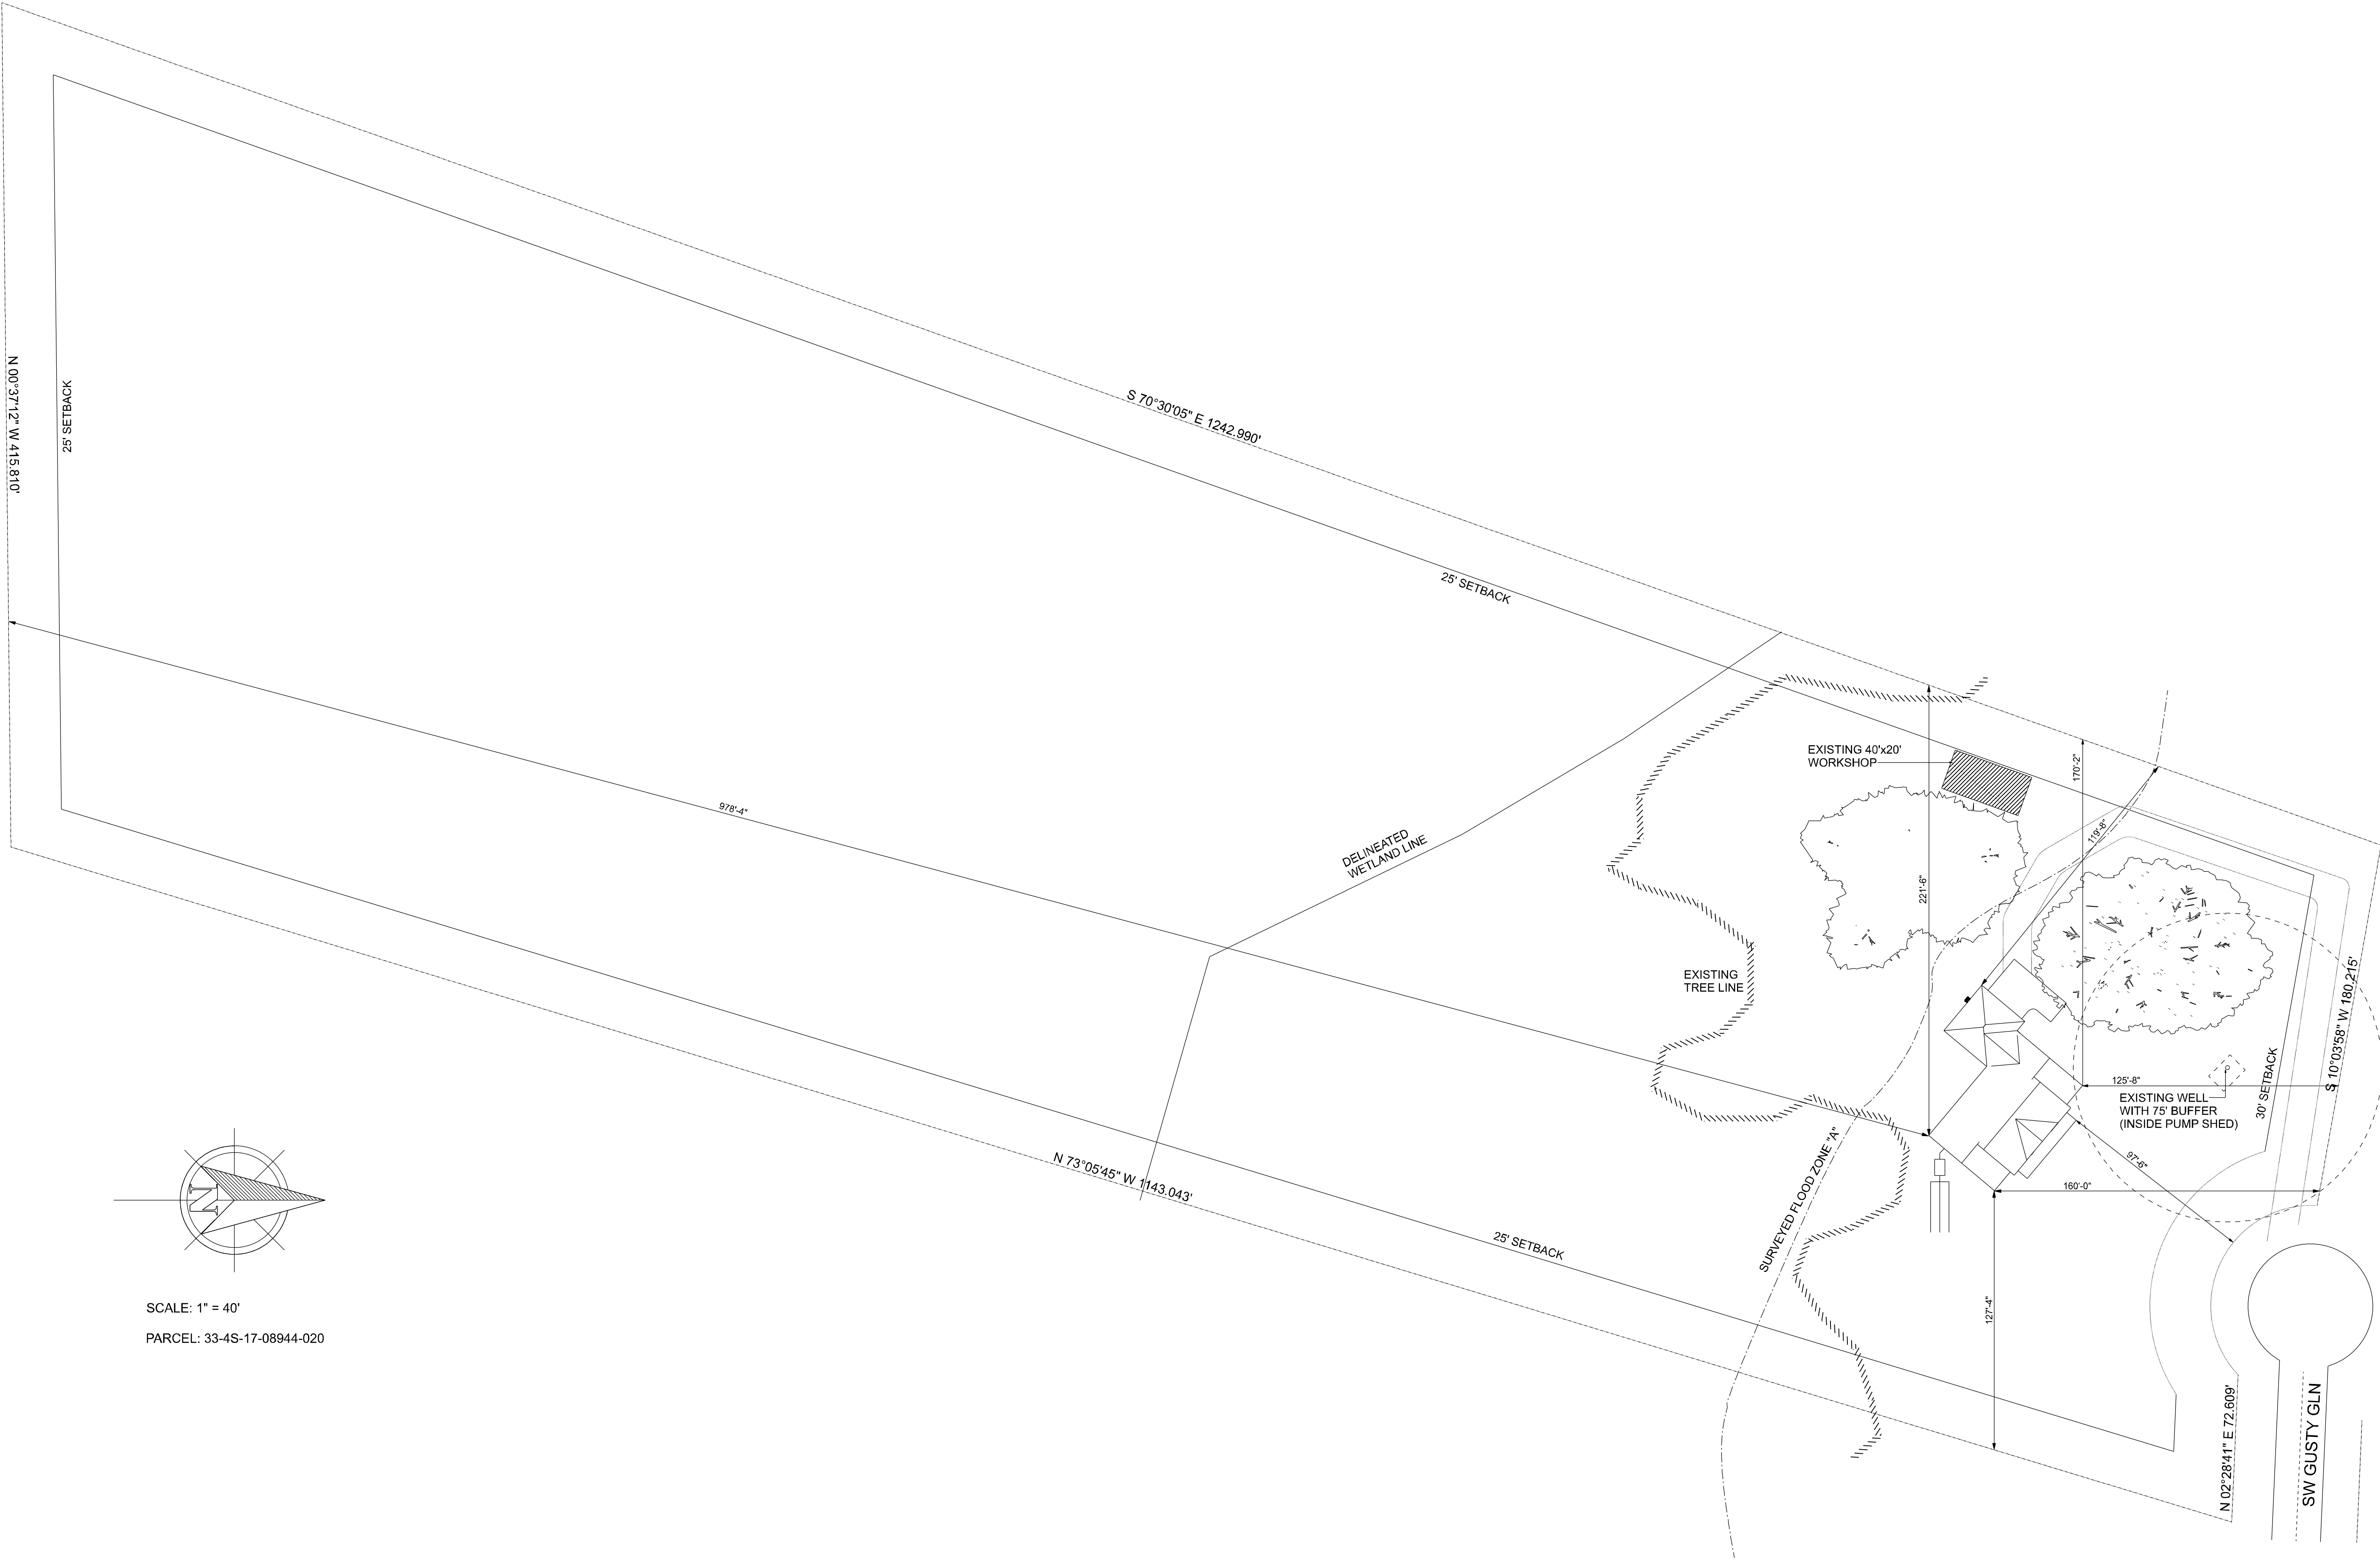

SCALE: 1" = 40'

PARCEL: 33-4S-17-08944-020

REVISIONS			DESIGN BY:	CERTIFIED GENERAL CONTRACTOR CGC1514780	CES Crews Engineering Services, LLC	CERTIFICATE OF AUTHORIZATION NO. 28022 P.O. BOX 970 LAKE CITY, FL 32056 PHONE: 386.754.4085	DRAWN BY: TM APPROVED BY: BC	PROJECT NO.: R22.001 SHEET: S-1
DATE	BY	DESCRIPTION						

SELLERS RESIDENCE

SITE PLAN

Brett A. Crews, P.E. 65592