




EQUIPMENT PAD DETAIL NTS DET 1 M3

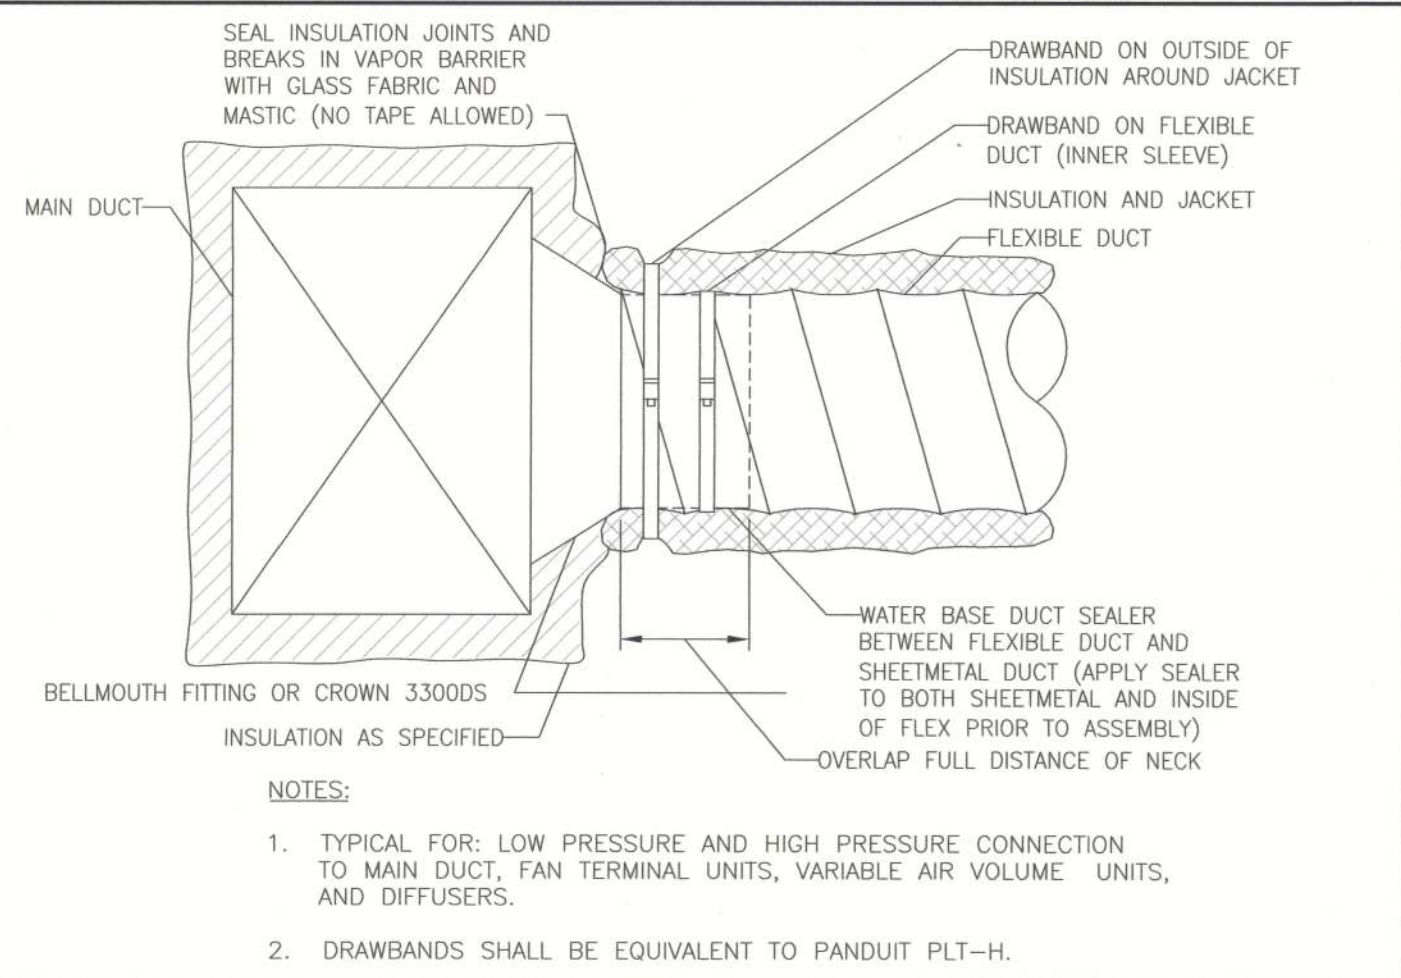


FLEXIBLE DUCT TAKEOFF DETAIL DET 2 M3

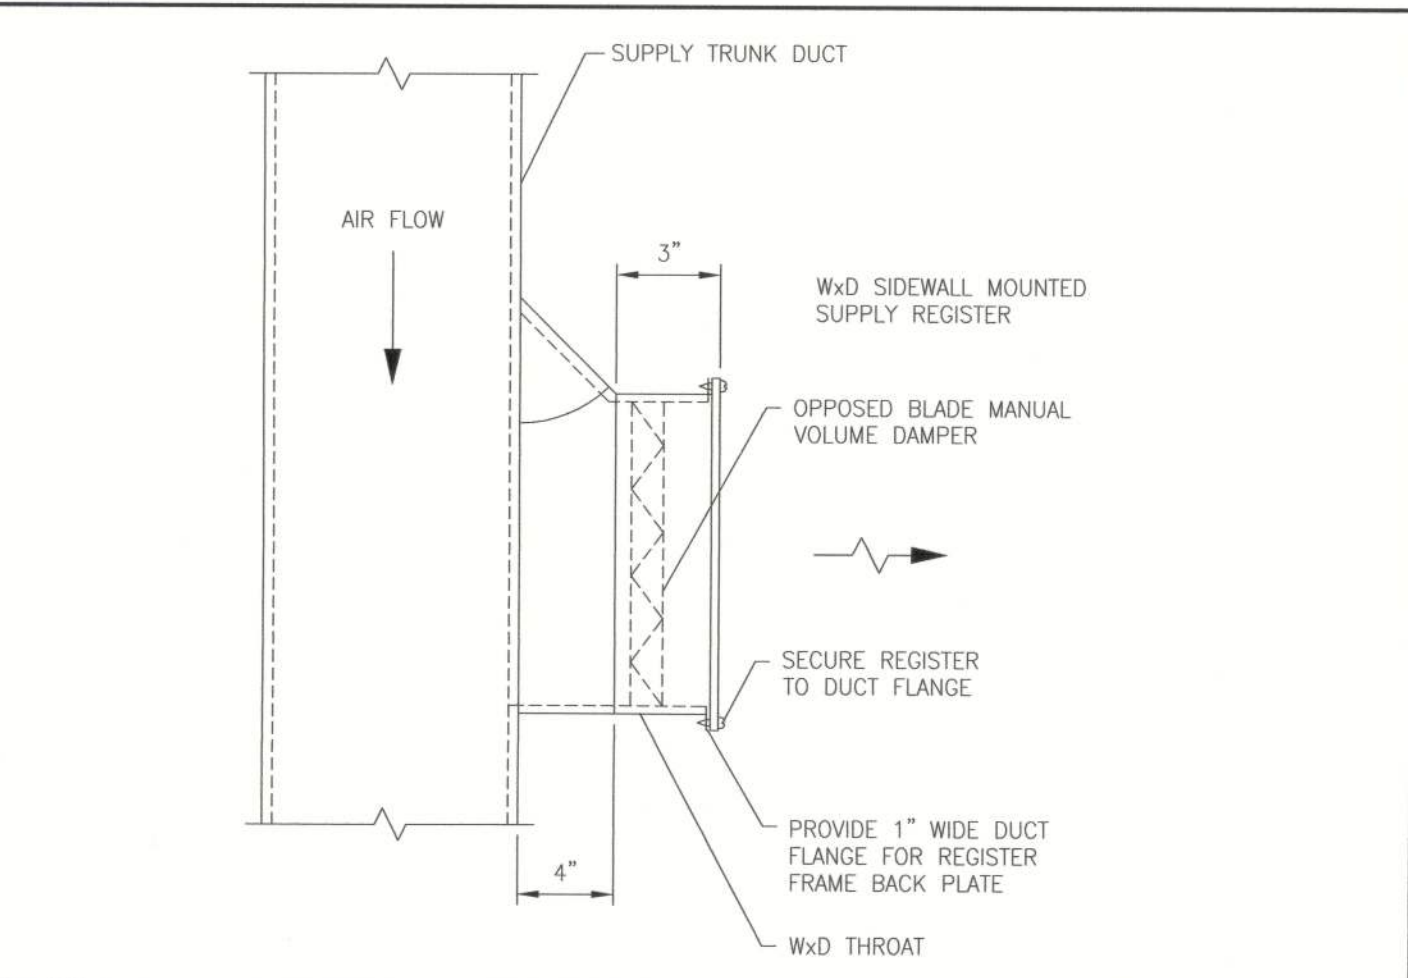


RECTANGULAR DUCT TAKEOFF DETAIL DET 3 M3

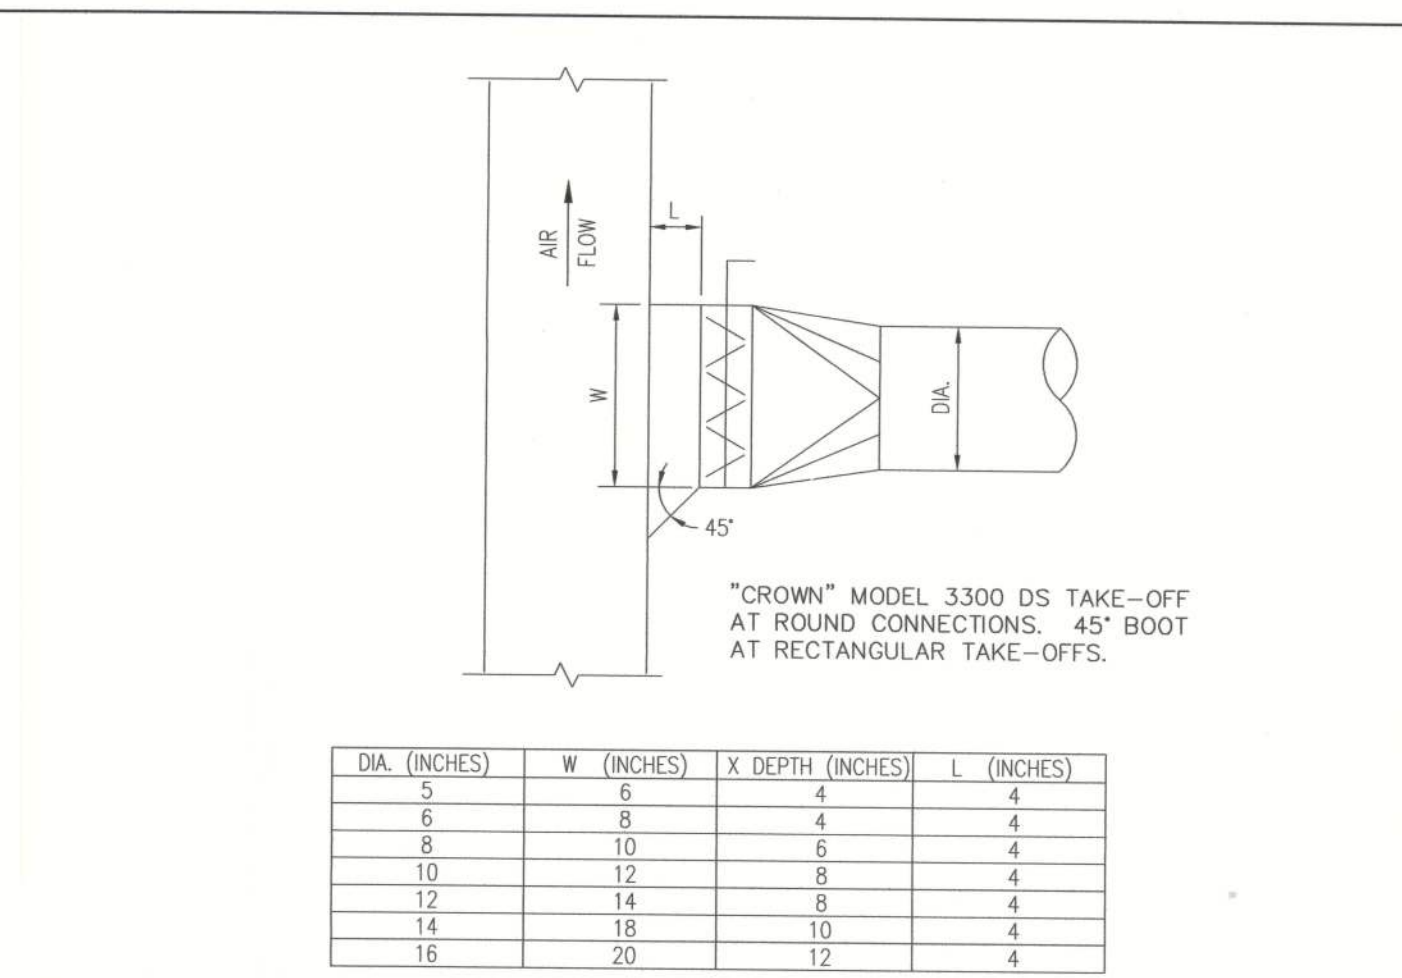


ROUND DUCT TAKEOFF DETAIL DET 4 M3

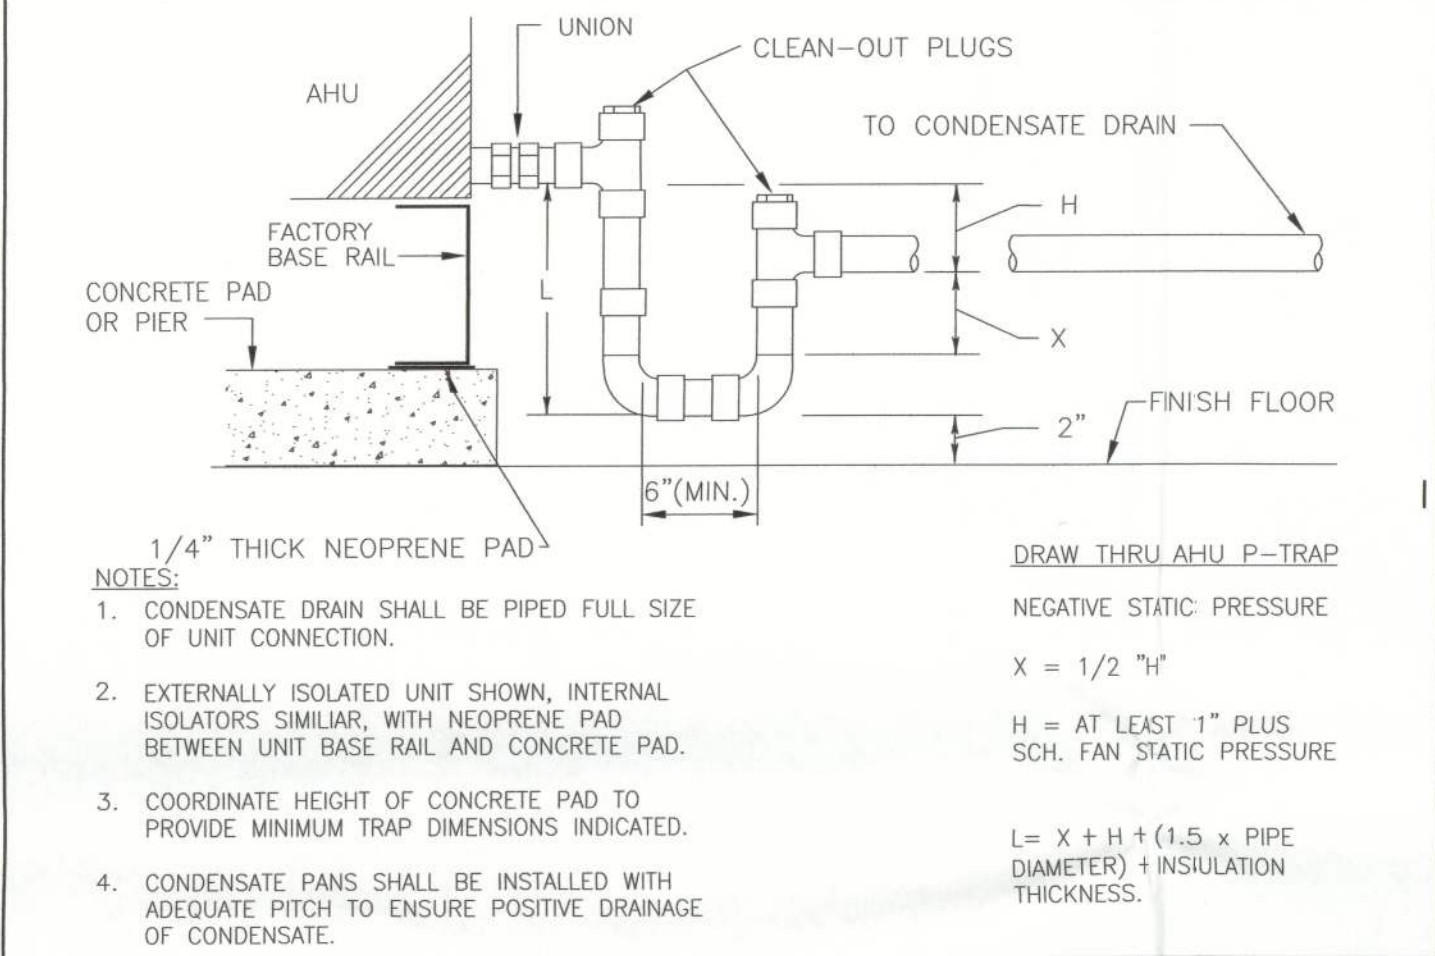


AHU CONDENSATE DRAIN DETAIL NTS DET 5 M3

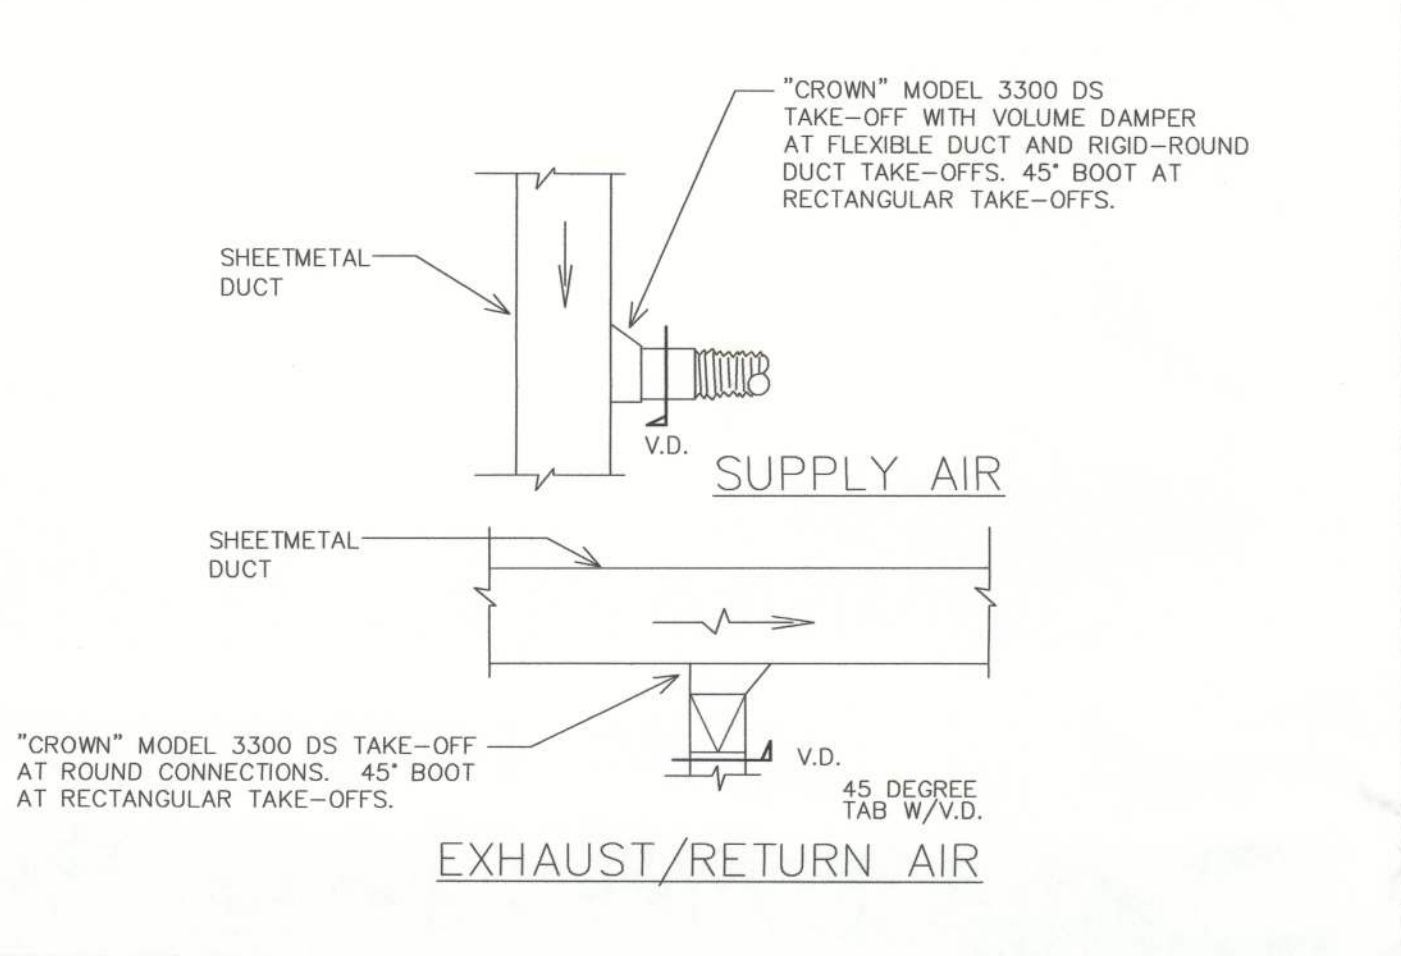


AIR DUCT DETAILS DET 6 M3

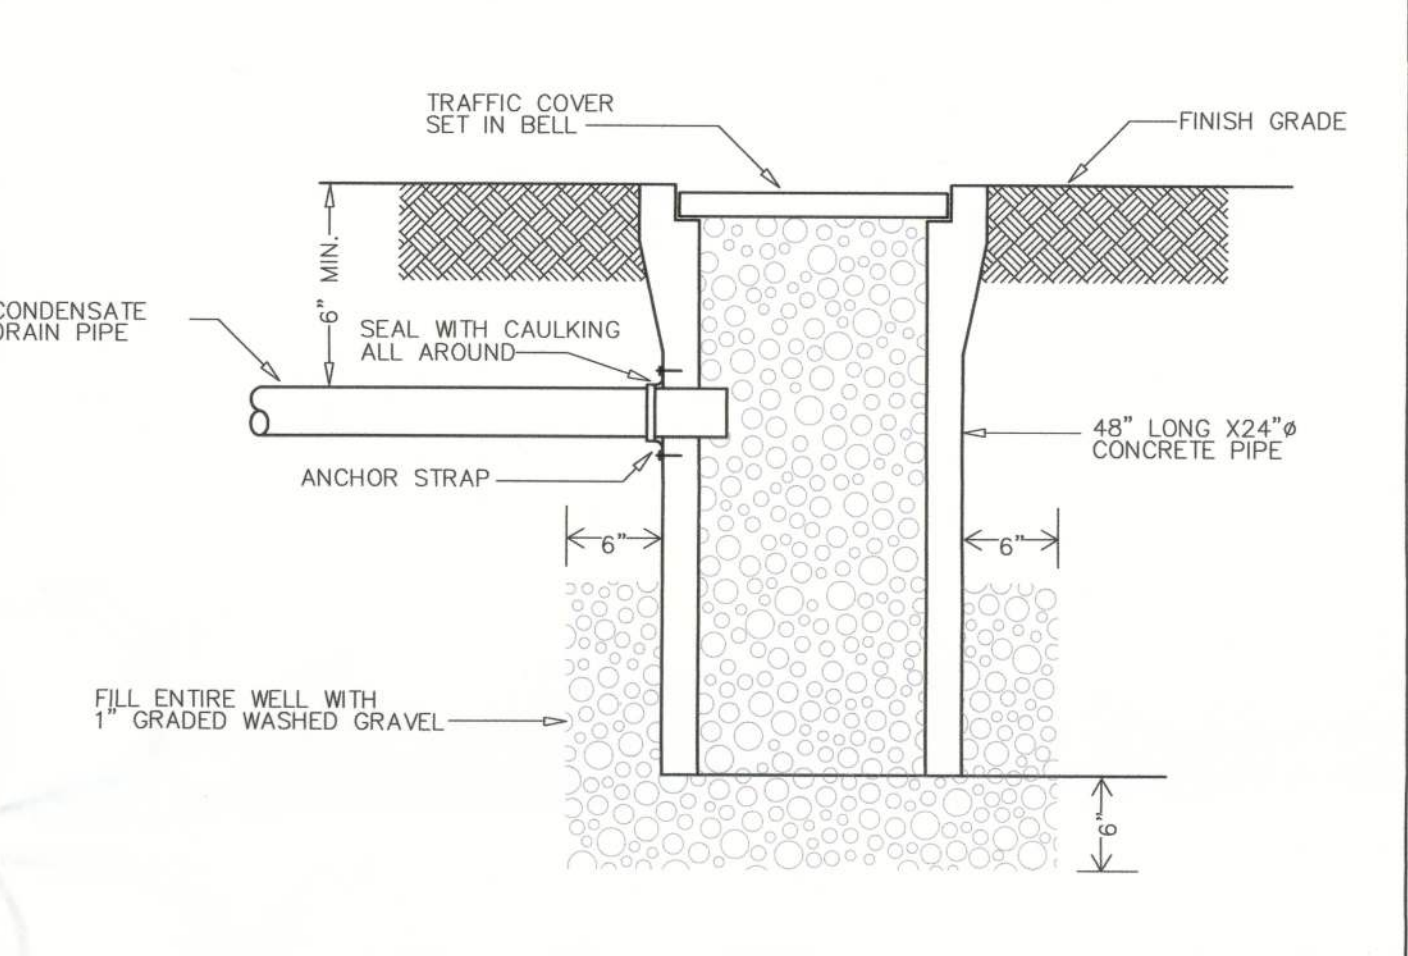

DRYWELL DETAIL DET 7 M3

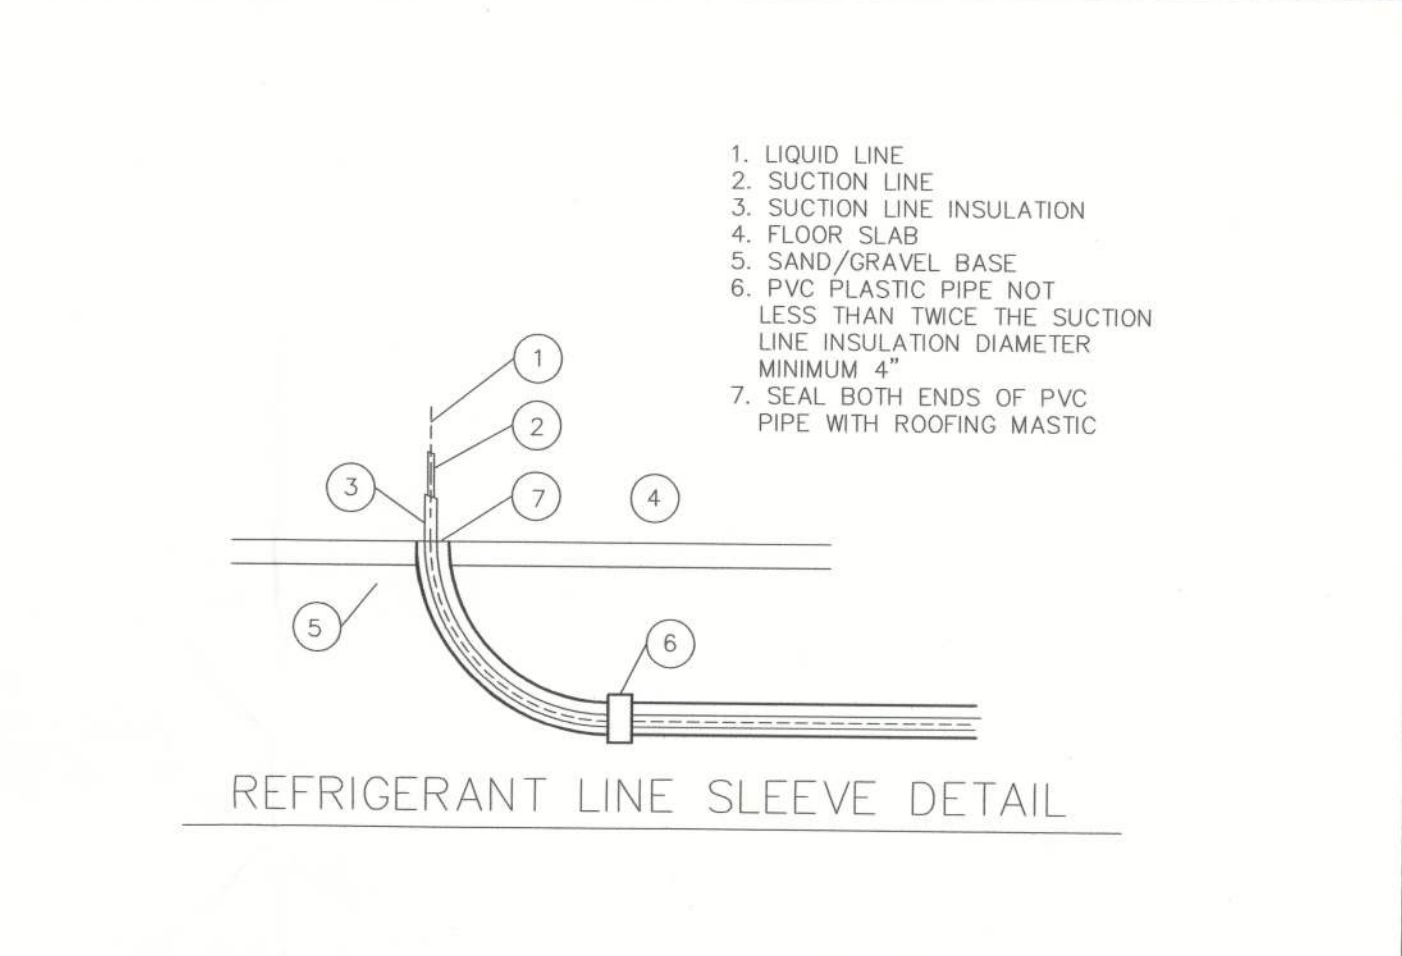

ROUND DUCT TAKEOFF DETAIL DET 8 M3

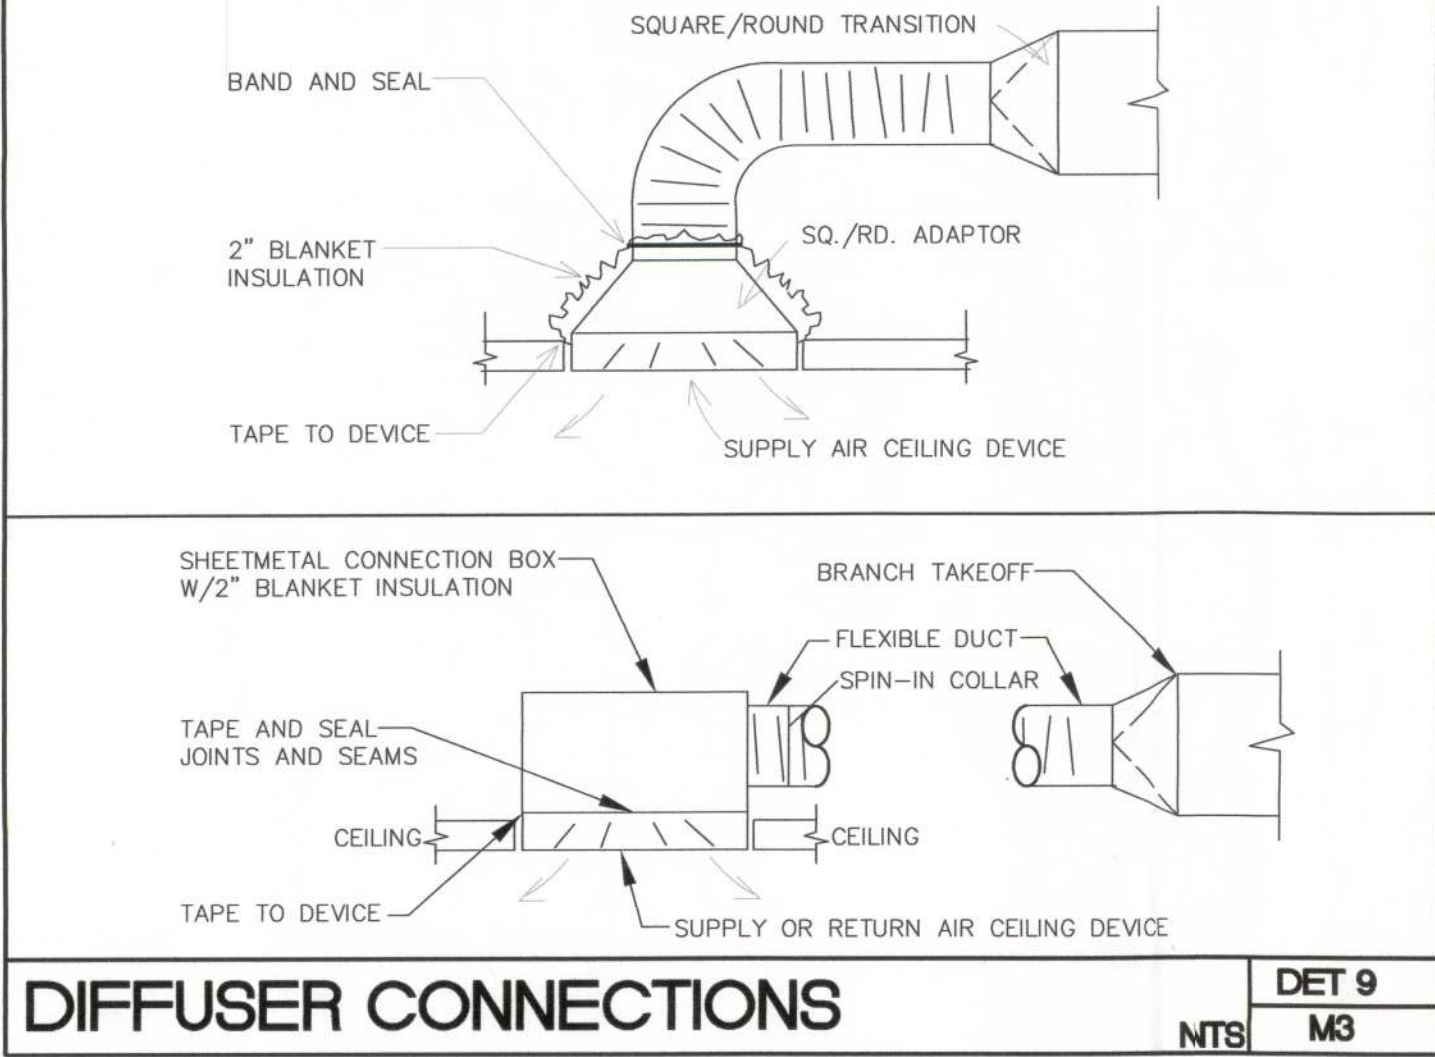

DIFFUSER CONNECTIONS NTS DET 9 M3

MECHANICAL DETAILS
NTS

Freeman Design Group Inc.
128 SW NASSAU STREET
LAKE CITY, FL 32025
(386) 758-4209
CERTIFICATE OF AUTHORIZATION # 00008701

Coburn and Associates, Inc.
P. O. BOX 577
HIGH SPRINGS, FLORIDA 32643-0577
(386) 454-3748 FAX (386) 454-3652
FLORIDA LICENSED ENGINEERS ED 0003687
RICHARD E. COBURN P.E. 42827 E39830
CA JOB NO. 10936

DATE 11/9/10
DRAWN BY MES
APPROVED REC
REVISIONS
SHEET OF M3
PROJECT NO. 09.C037

WEST SIDE COMMUNITY CENTER

P.E. # 55001