


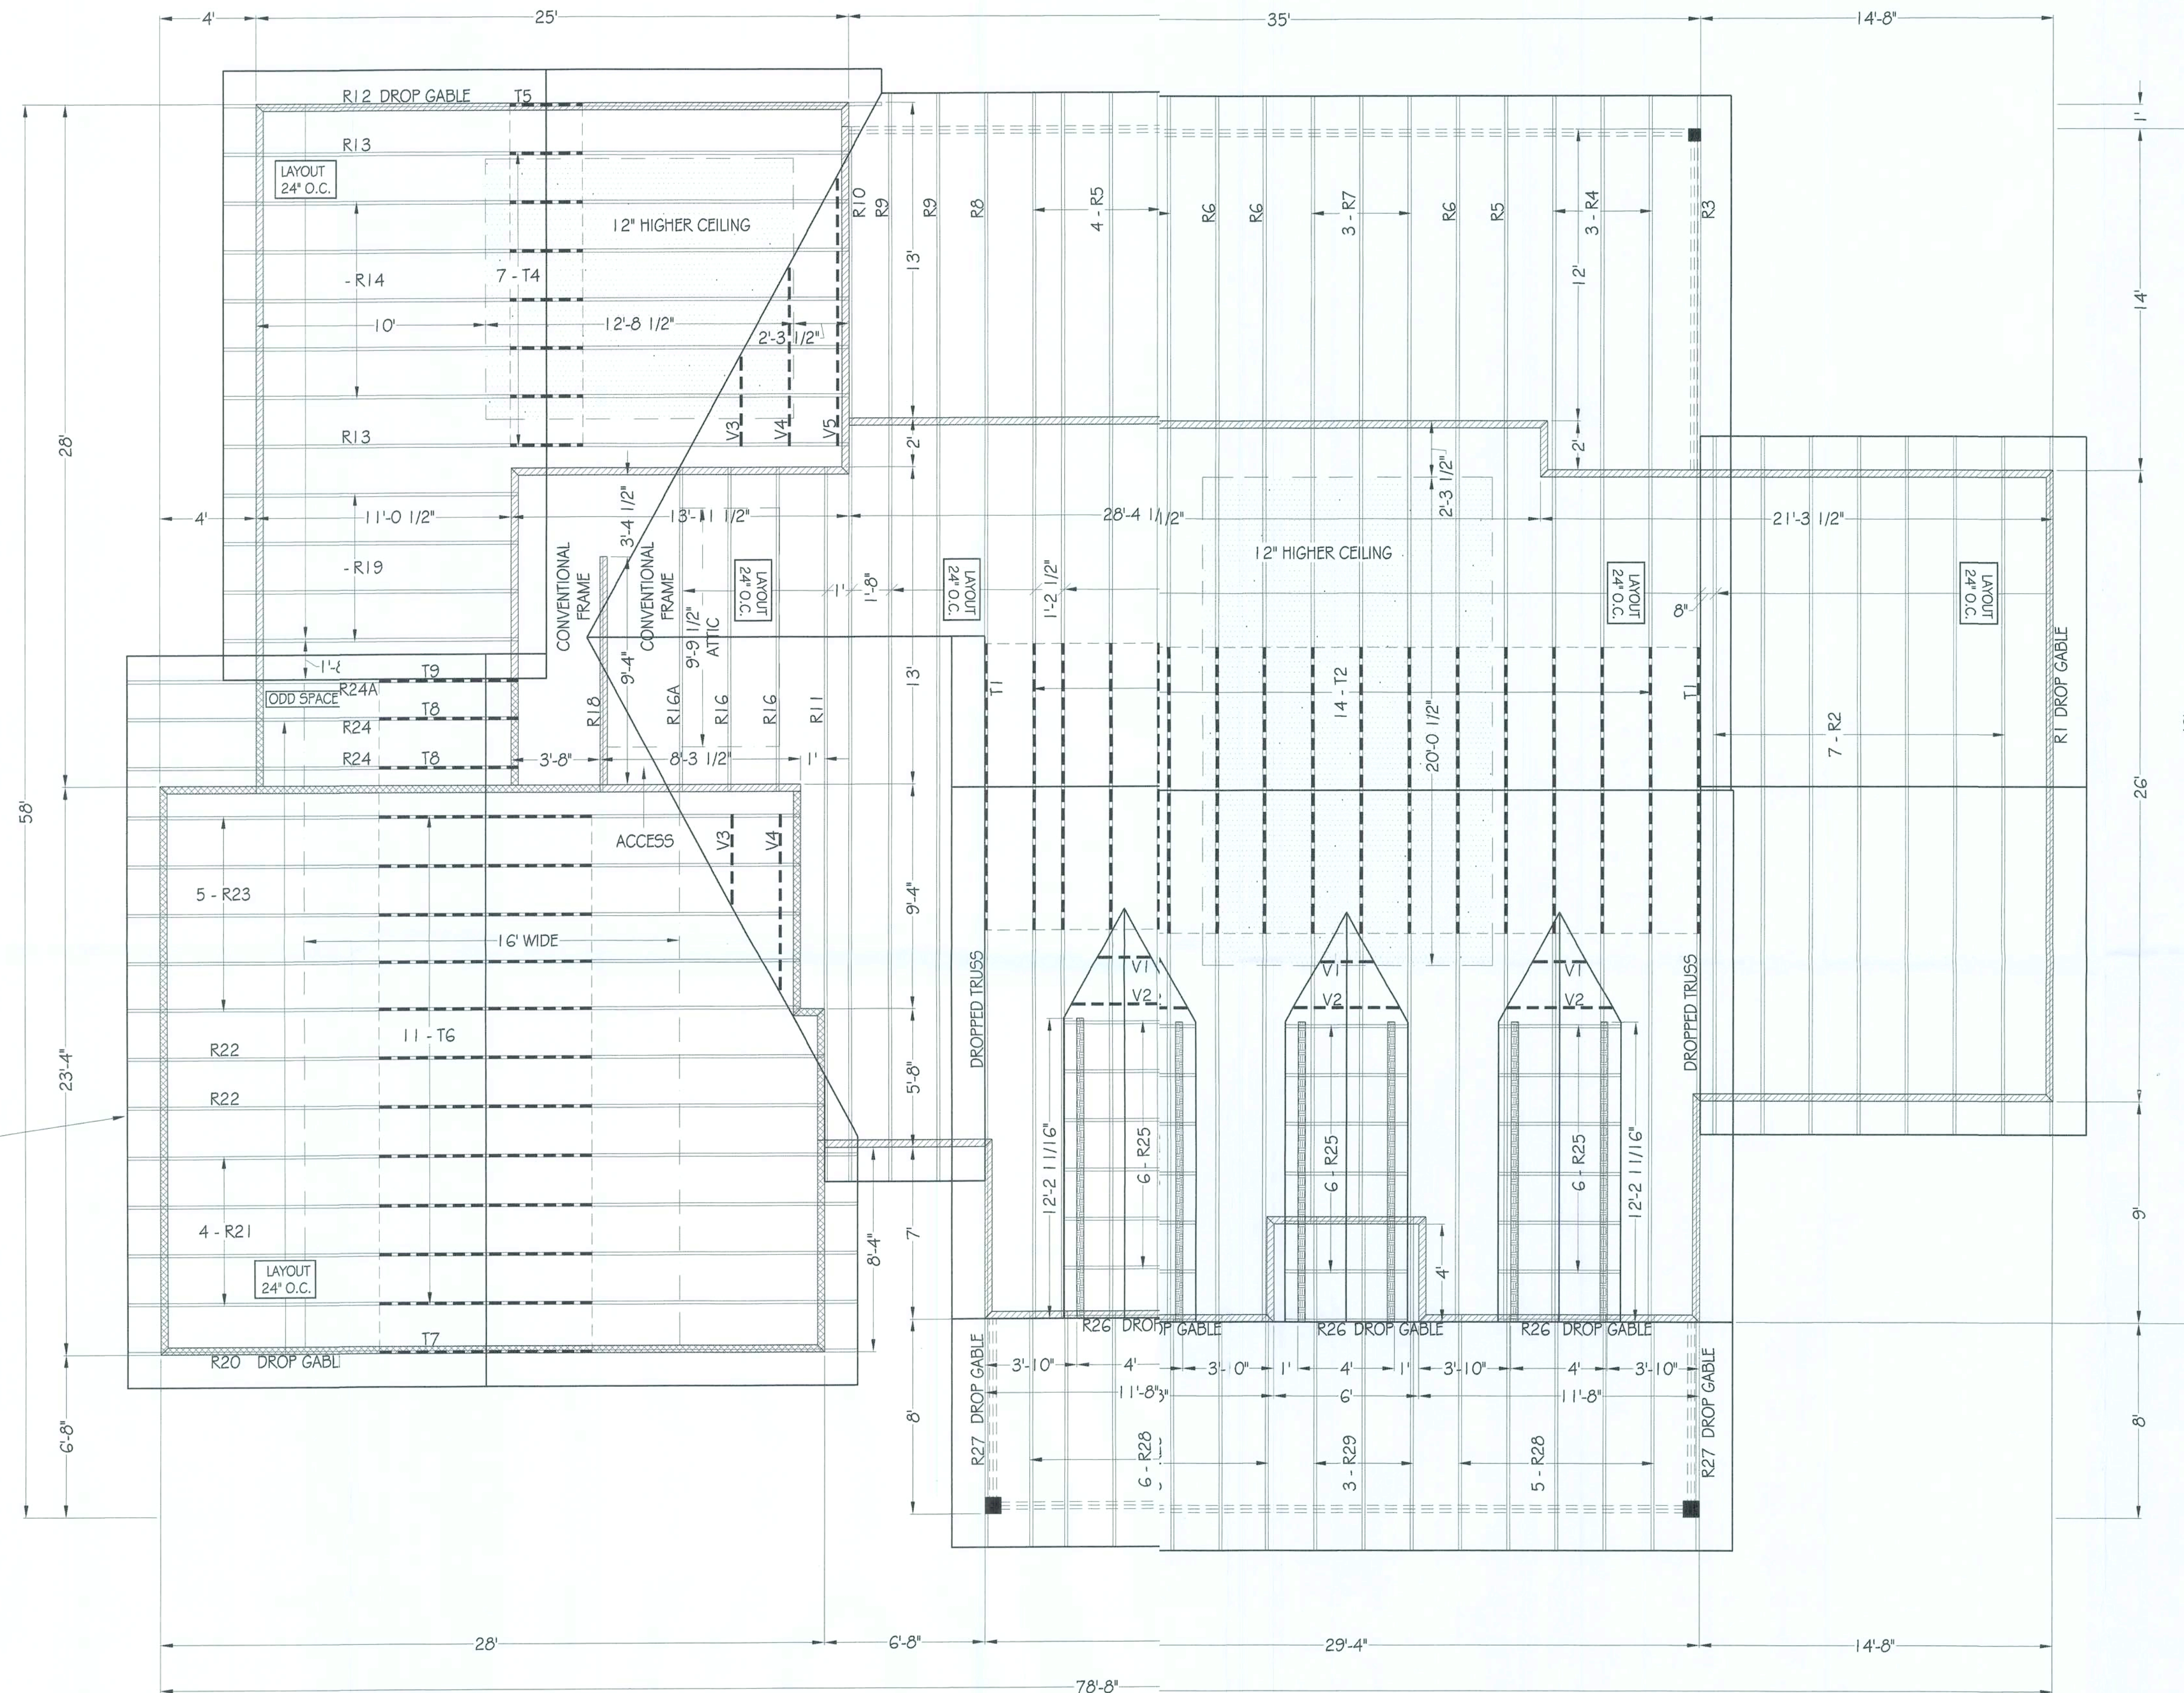
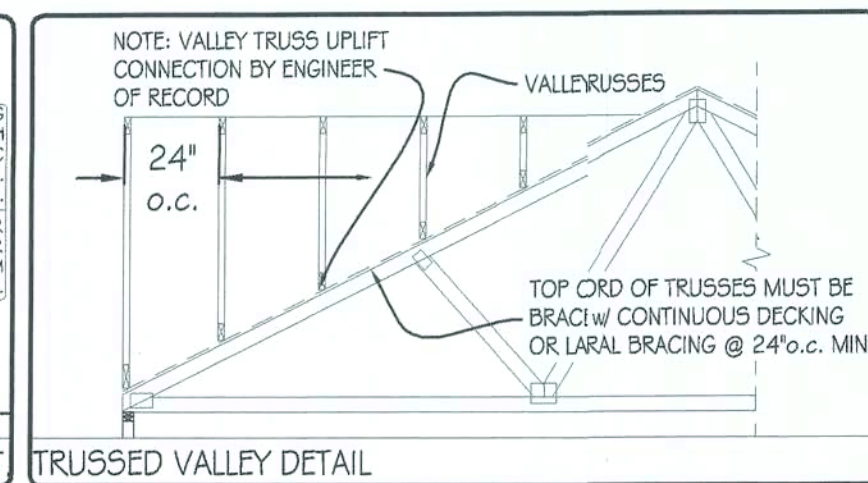
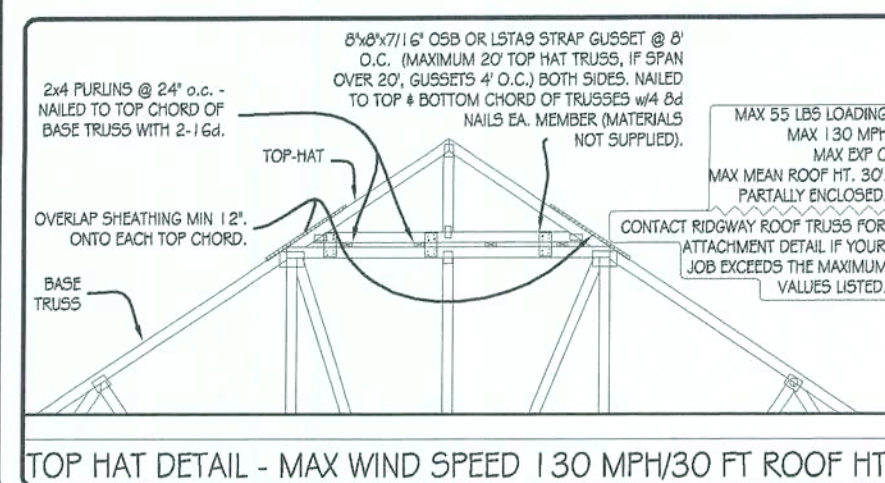


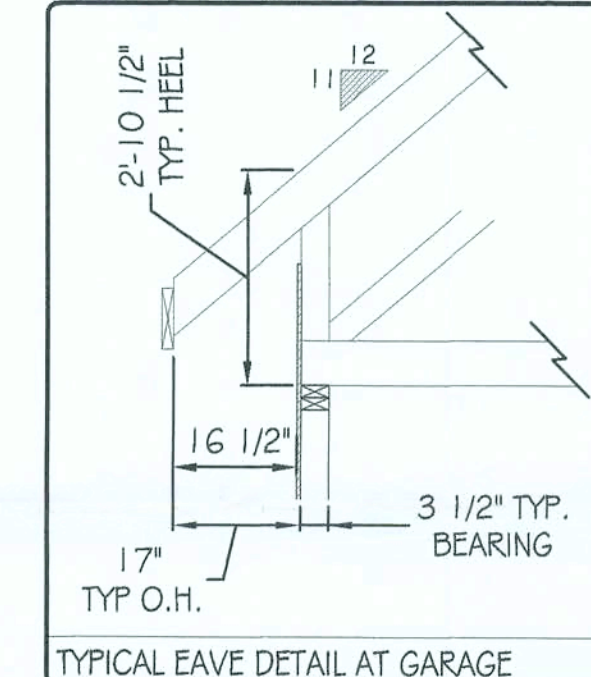

POOL TABLE LOADING MUST BE
CONFIRMED. WEIGHT AND LOCATION
REQUIRES A B.C. SCAB.

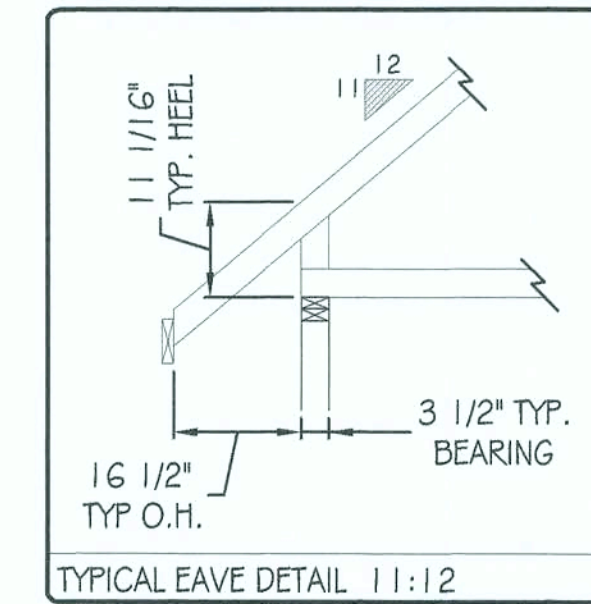

LEDGEND	
	BEAM BY OTHERS
	SUPPLIED BEAM
	VALLEY/FIELD FRAME
	PLUMBING DROP
	SLOPED CEILING
	RAISED CEILING
	9'-0" BEARING HT.
	9'-0" BEARING HT.
	8'-0" BEARING HT.
	18'-2 1/4" BEARING HT.

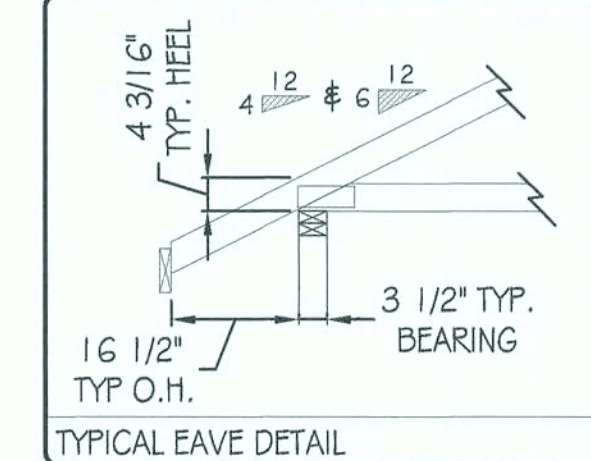

"DISCLAIMER"

PLUMBING / HVAC OPENINGS ARE THE RESPONSIBILITY OF THE CONTRACTOR OR OWNER TO VERIFY ALL LOCATIONS BEFORE BUILDING TRUSSES AND SETTING TRUSSES.

"ATTENTION"

1. LIMITED RESPONSIBILITY OF ROOF TRUSS MANUFACTURER. SEE WTCA 1-1995, SECTION 6.0, FOUND IN DESIGN MANUAL.
2. WARNING FAILURE TO FOLLOW RECOMMENDATIONS IN "BCSI-B1" MAY RESULT IN SERIOUS INJURY, LOSS OF LIFE, OR PROPERTY DAMAGE.
3. CUSTOMER TO VERIFY ALL DIMENSIONS, BEARING HEIGHTS, PITCHES AND ALL INFORMATION REGARDING THE DESIGN AND FABRICATION OF TRUSS SYSTEM.
4. DO NOT OVERLOAD TRUSSES w/ SHEETROCK / SHEATHING OR OTHER BUILDING MATERIALS.
5. TRUSSES ARE NOT MARKED IN ANY WAY TO IDENTIFY THE FREQUENCY, OR LOCATION OF TEMPORARY ERECTION BRACING. ALL TEMPORARY BRACING SHALL COMPLY WITH THE LATEST EDITION OF BCSI-B1 PUBLISHED BY THE TRUSS PLATE INSTITUTE FOUND IN THE DESIGN MANUAL.
6. NON-LOAD BEARING WALLS TO BE SINGLE TOP PLATED, TO PREVENT LOAD TRANSFER TO THESE WALLS. A 1x4 MAY BE USED AS SECOND TOP PLATE.

ROOF
TRUSS
LAYOUT


SCALE:
1/4" = 1'-0"

DWC CONTRACTING
PEDEN RESIDENCE


Ridgway Roof Truss Company
P.O. Box 1309 Gainesville, Florida 32602
Telephone (352) 376-4436 FAX (352) 371-3316
E-Mail: Sales@RidgwayTruss.com

Page	Salesman: MIKE WELDON		REVISION DATE: REVISION	REV BY: CHK BY:
	Initial Check:		1	
	Design: BRUCE CAD: ILR		2	
	Job # 030117 Date: 4/7/09		3	
	Est. BILL-BOB WOODLIZ			

STAIR INFO.
TOTAL RISE 9' 1-1/4"
15 RISERS @ 7-5/16"
14 TREADS @ 10"

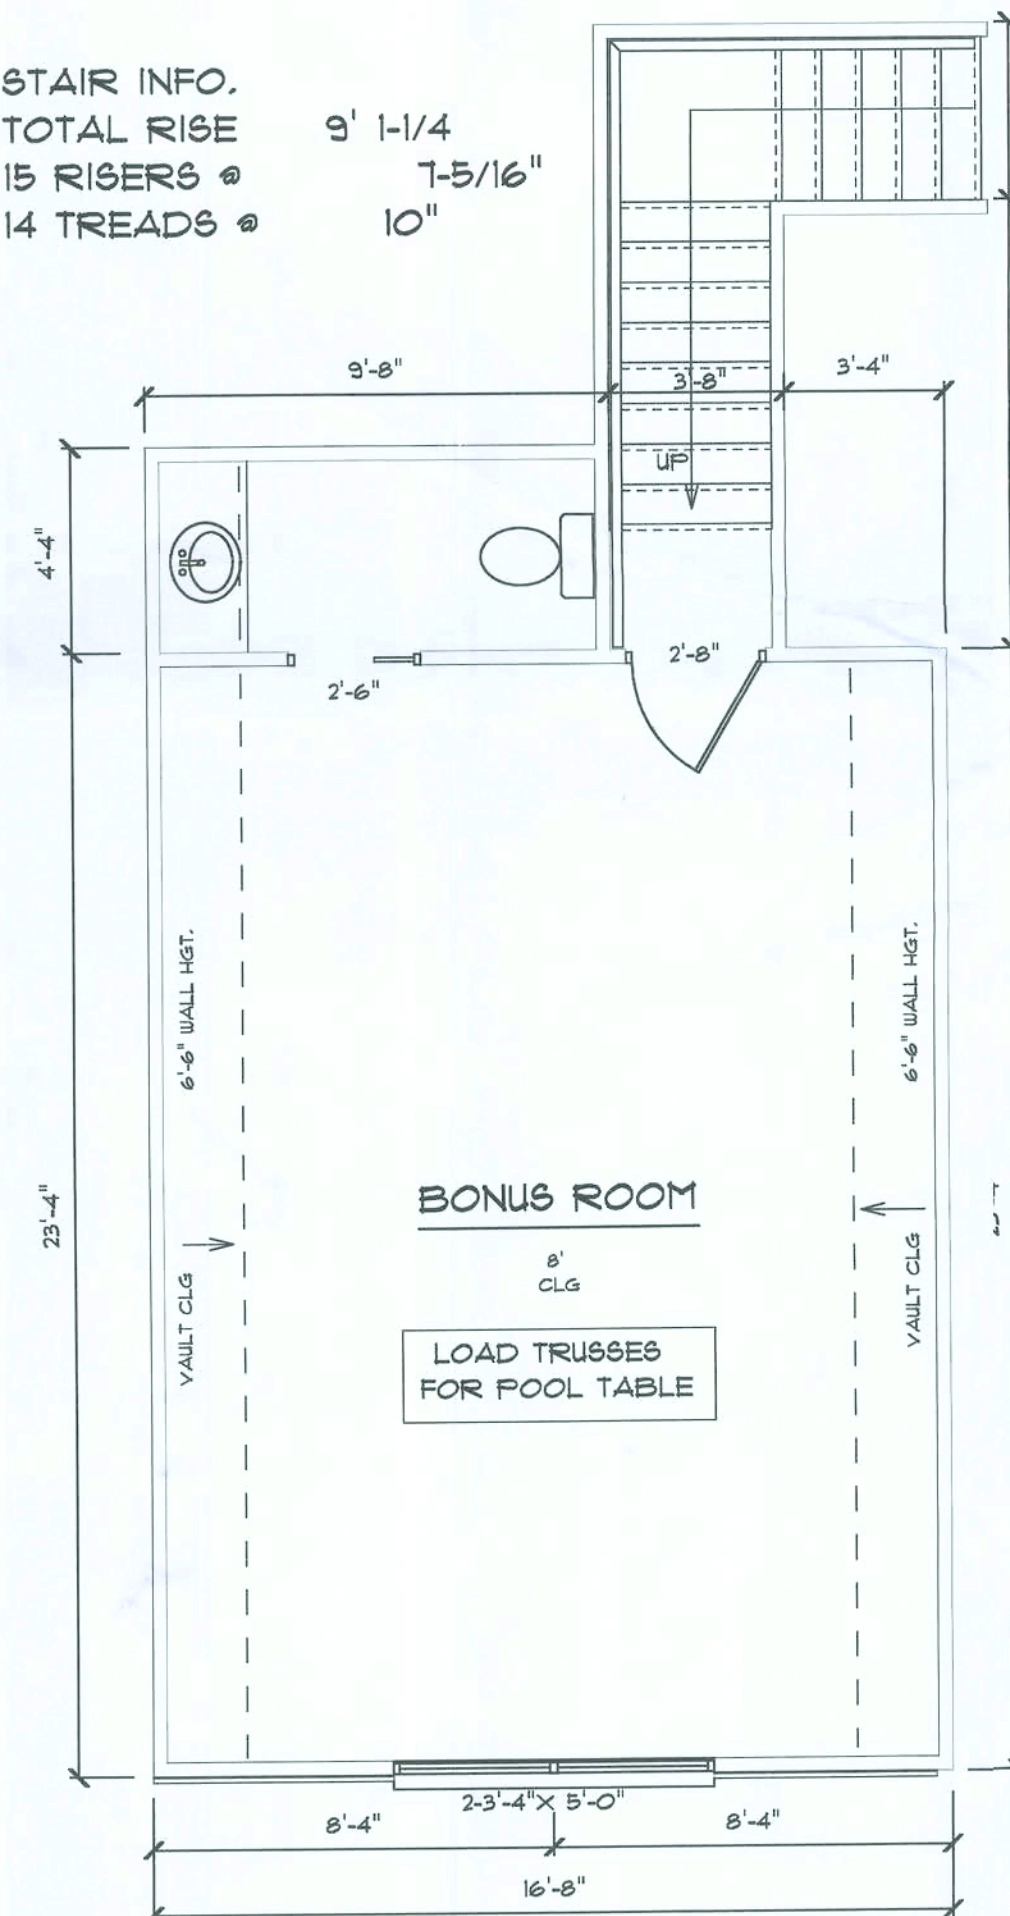


BONUS ROOM

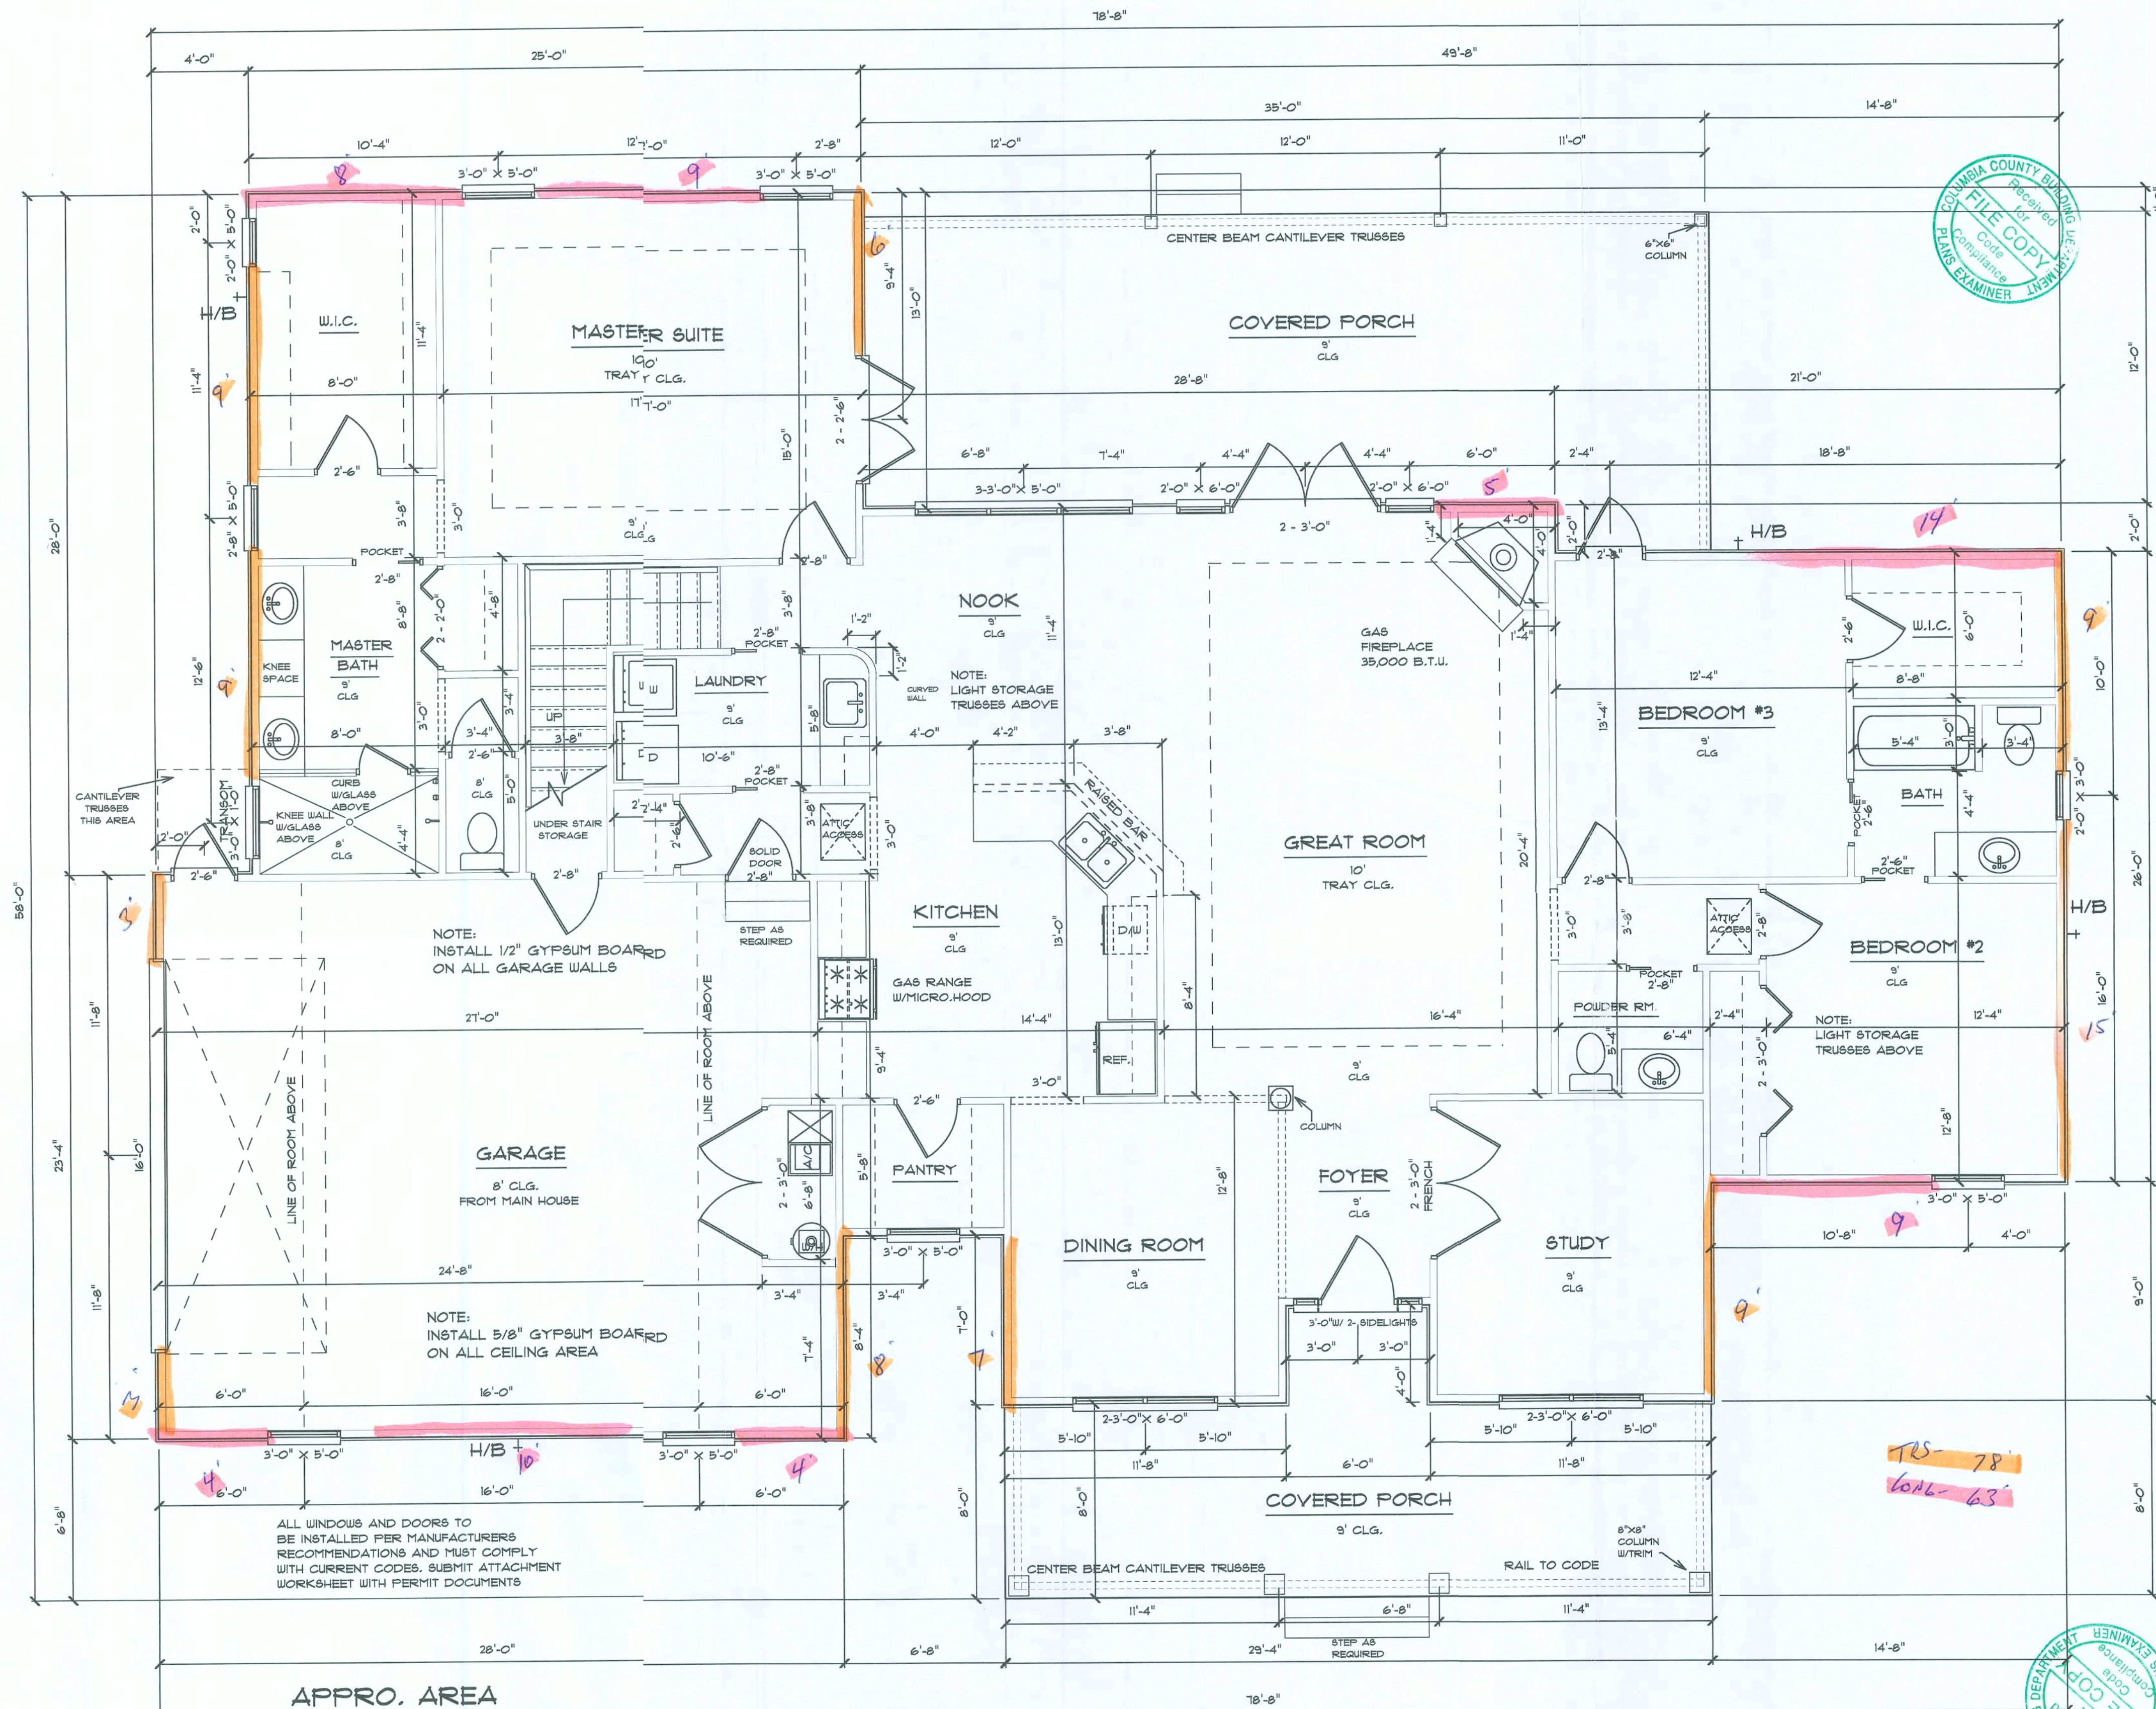

APPRO. AREA	
LIVING	2339
BONUS ROOM	405
GARAGE	636
FRONT PORCH	259
REAR PORCH	432
TOTAL	4071

MAIN FLOOR PLAN

IT IS THE OWNER AND OR THE CONTRACTORS RESPONSIBILITY TO VERIFY ALL STRUCTURAL ASPECTS OF THESE DRAWINGS. THIS INCLUDES BUT NOT LIMITED TO DIMENSIONS, WALL HEIGHTS AND MATERIAL, WINDOW SIZE AND LOCATION. ALSO ALL STATE AND LOCAL CODES MUST BE FOLLOWED BY ACCEPTING THESE PLANS OWNER ACCEPTS ALL RESPONSIBILITY AND DOES NOT HOLD COLACINO DRAFTING AND DESIGN LIABLE FOR ANY ERRORS OR OMISSIONS


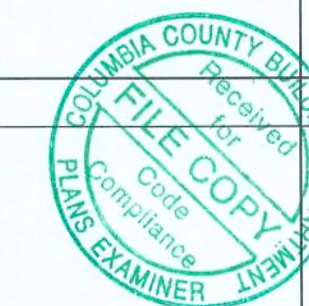


PEDEN RESIDENCE

COLACINO
DRAFTING&DESIGN
PH. 352-472-3462

DATE 1/29/09
REVISION 2/10/09

SCALE 1/4" = 1'
DRAWN BY R.A.C.
APPROVED

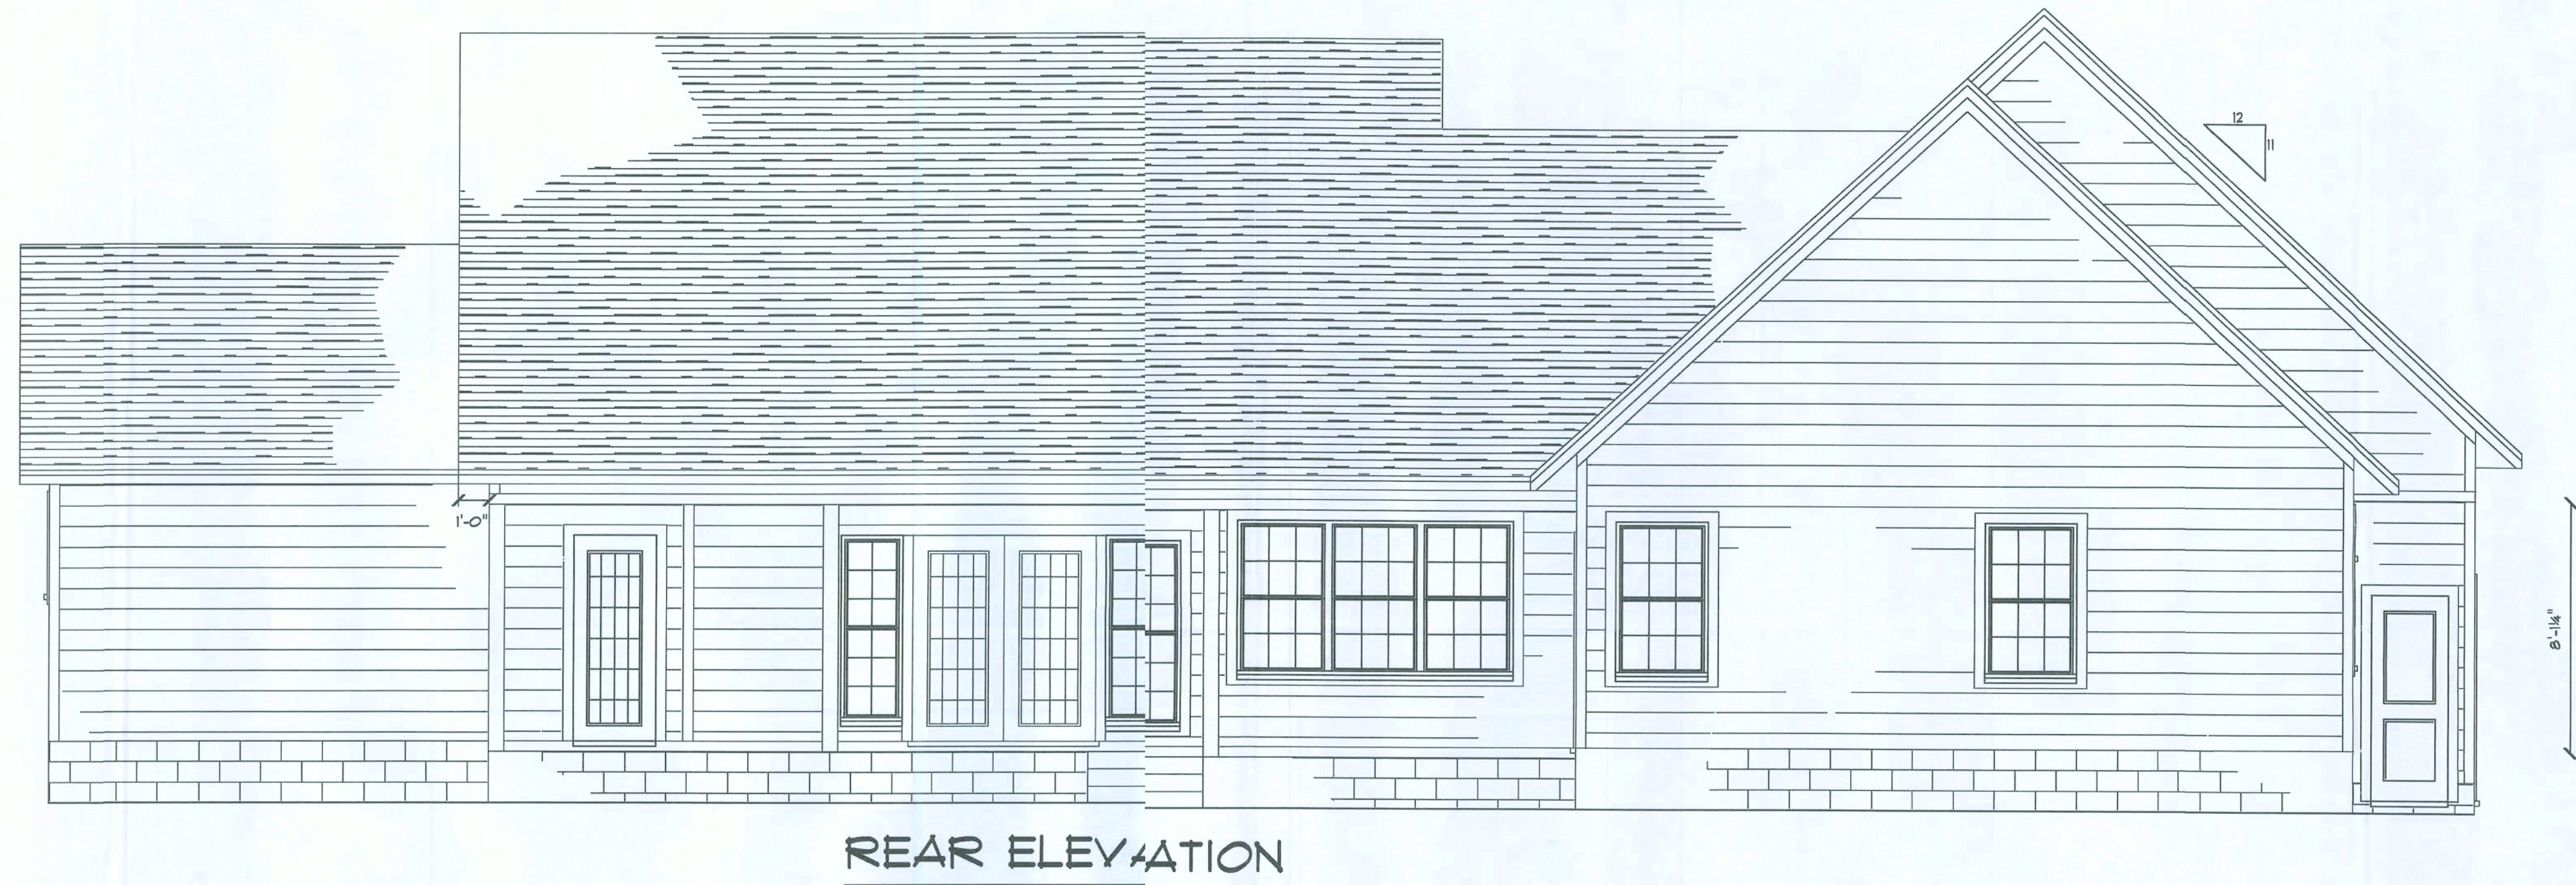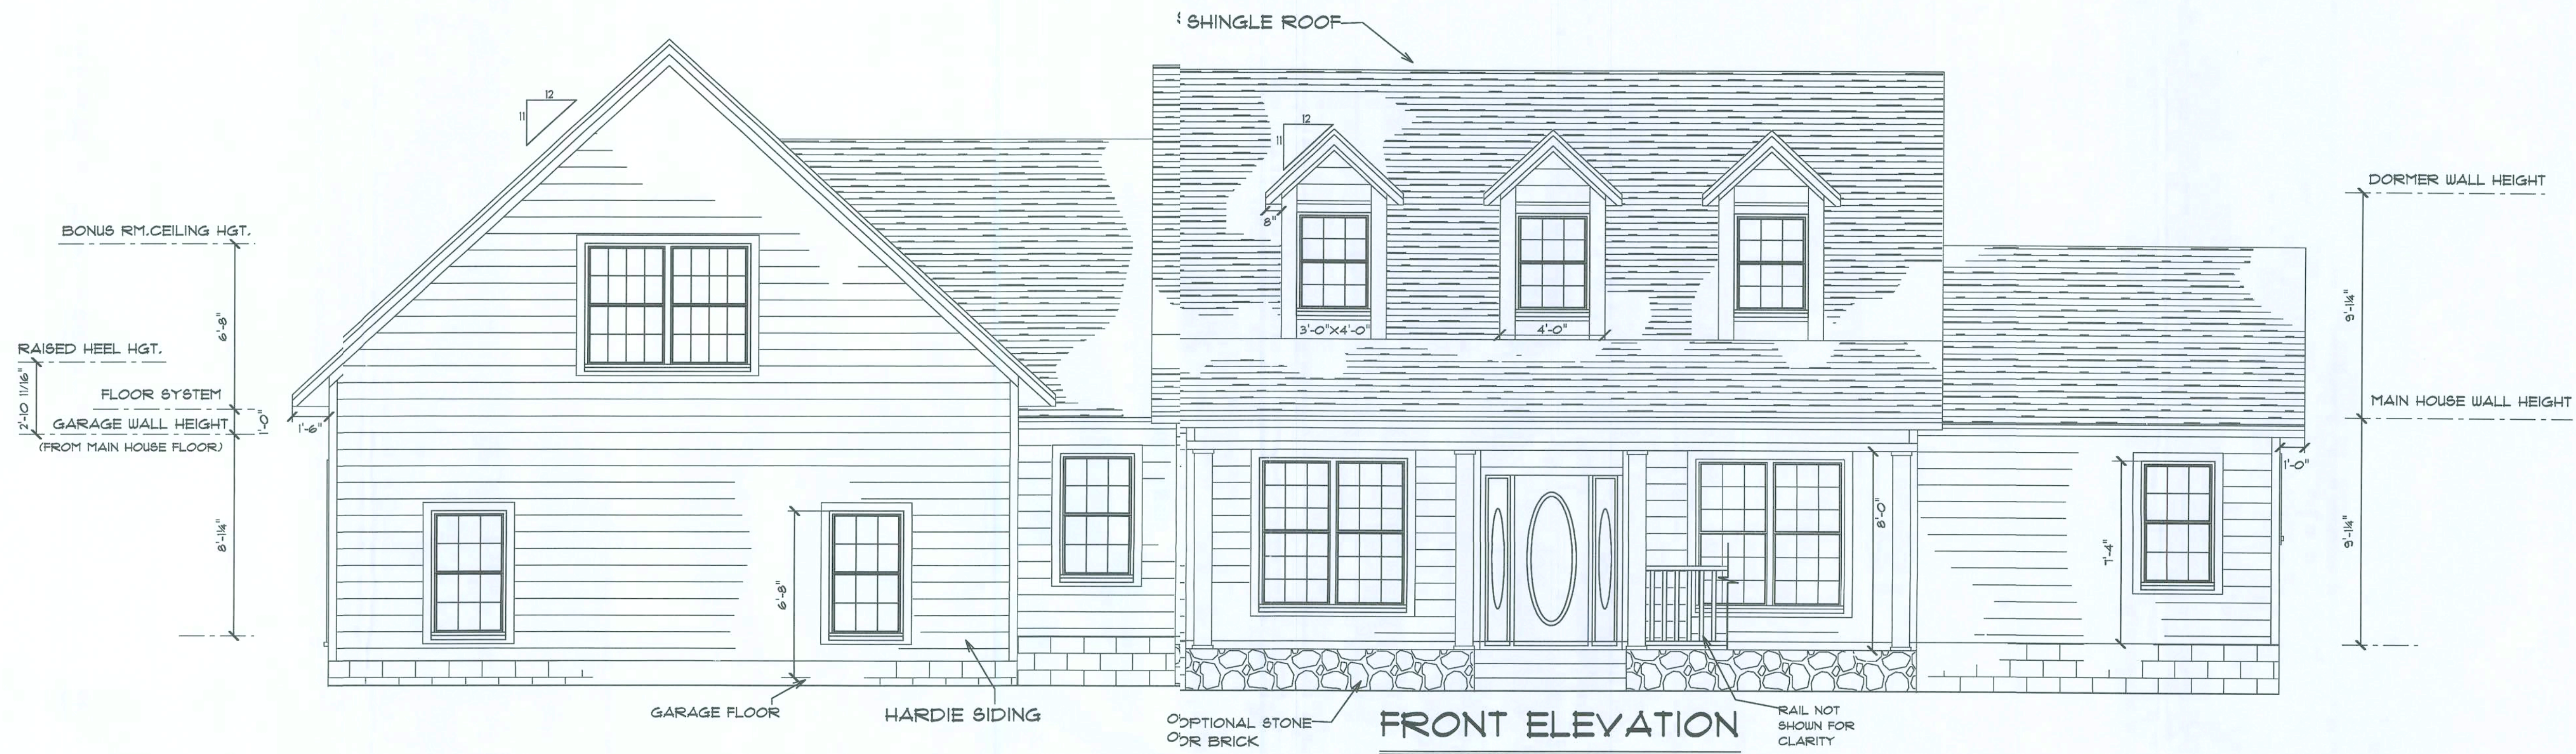

PEDEN RESIDENCE

SCALE 1/4" = 1'
DRAWN BY P.A.C.
APPROVED

COLACINO
DRAFTING&DESIGN
PH. 352-472-3462

DATE 1/29/09
REVISION 2/16/09
REVISION




3



DATE 1/29/09
REVISED 2/18/09
REVISED

COLACINO
DRAFTING&DESIGN
PH. 352-472-3462

SCALE 1/4" = 1'
P.A.C.
APPROVED

PEDEN RESIDENCE

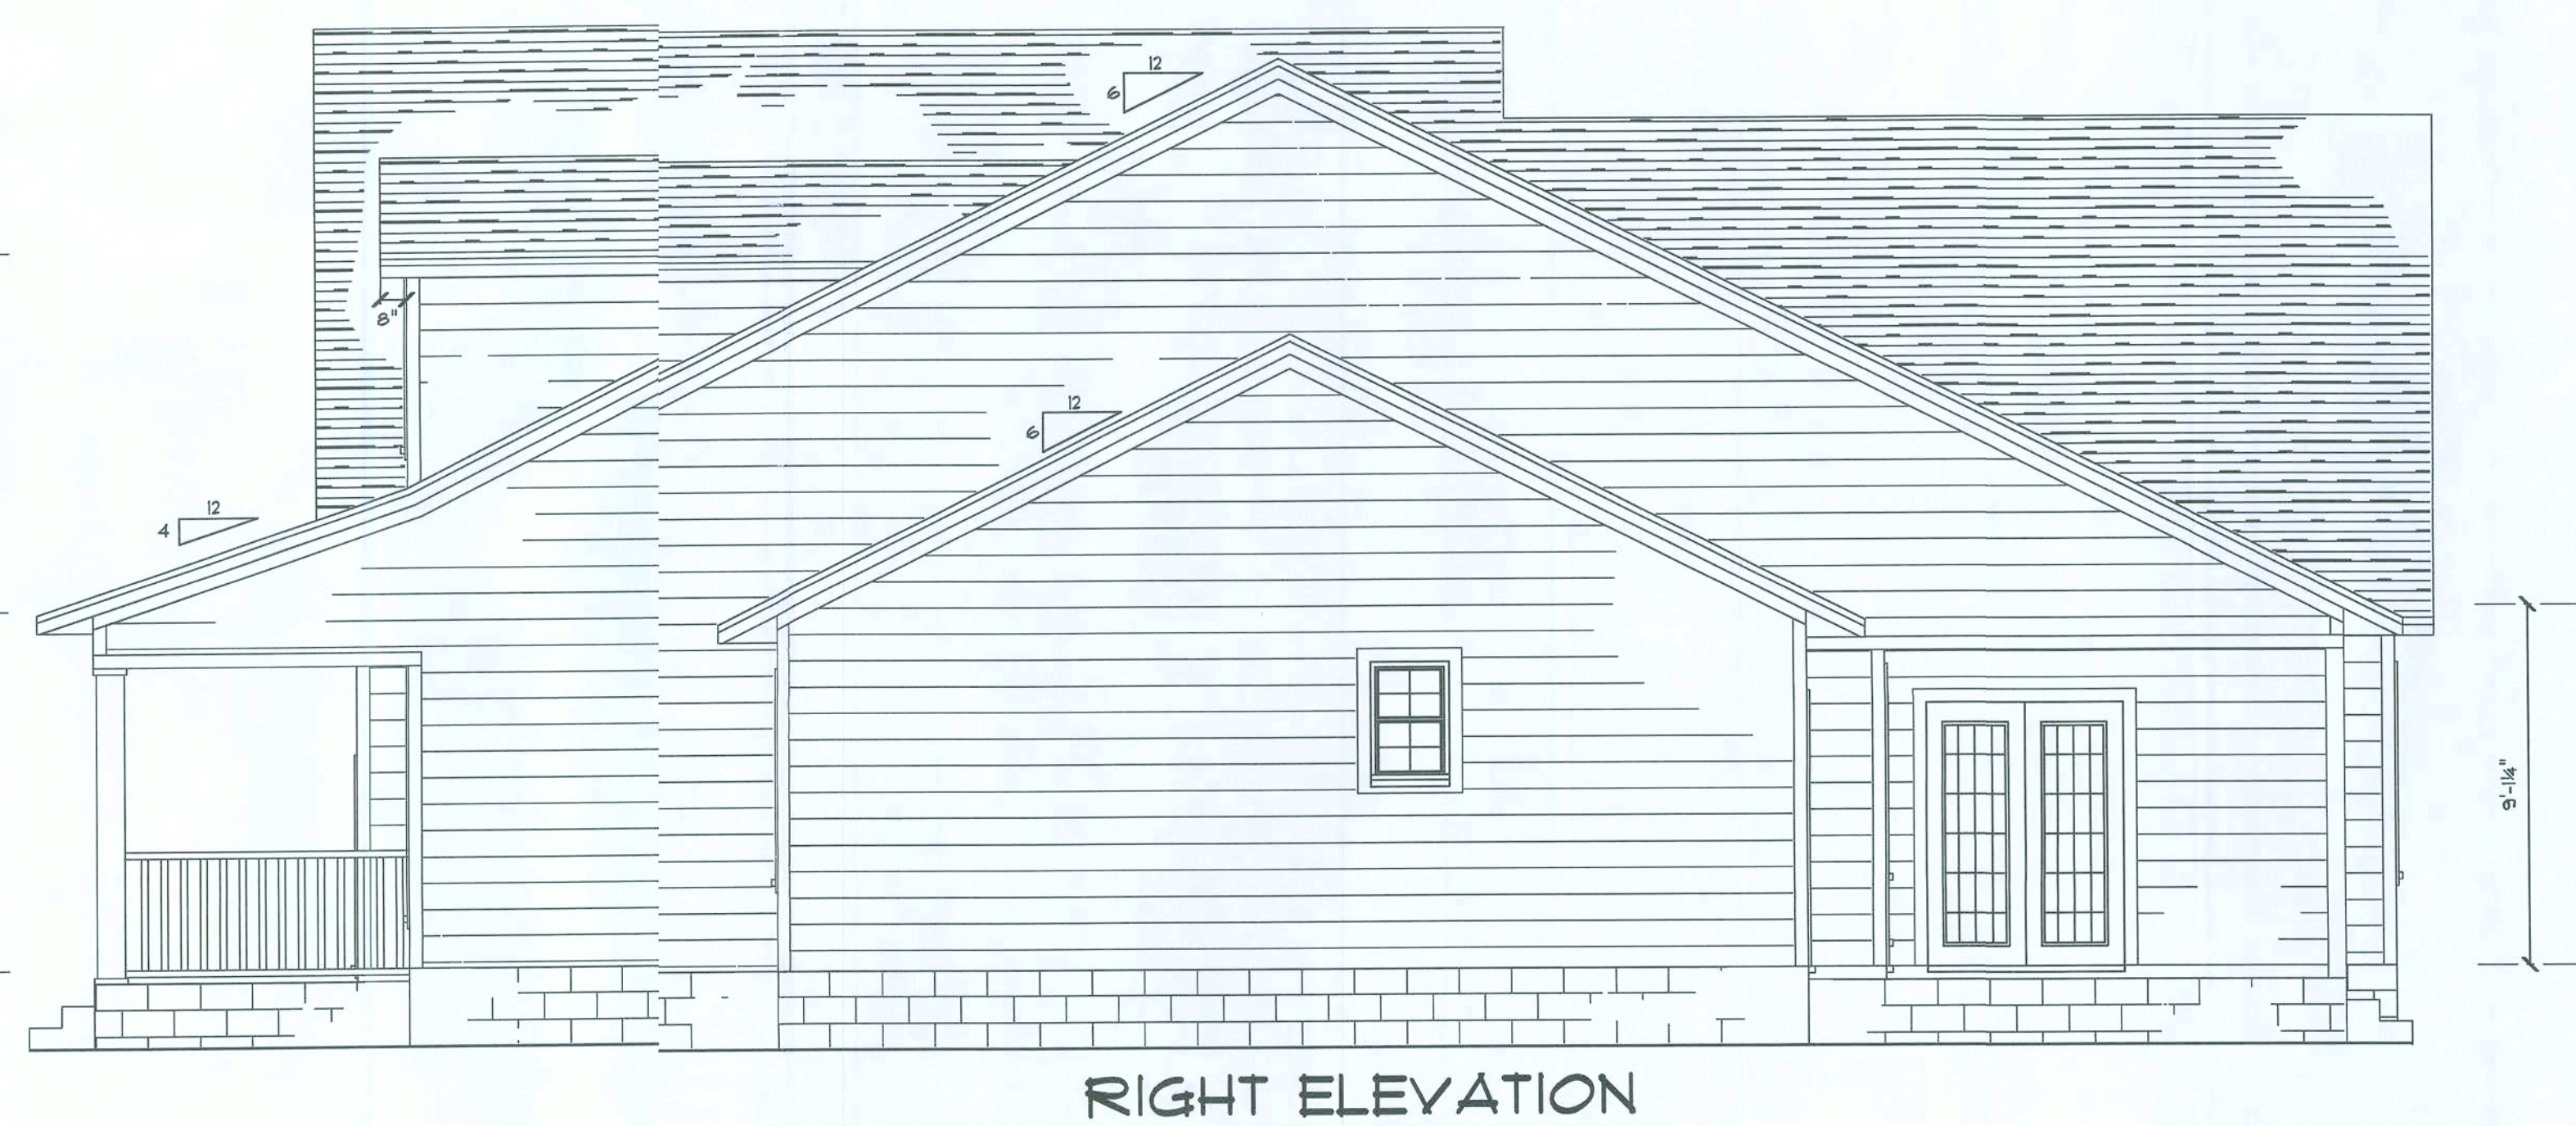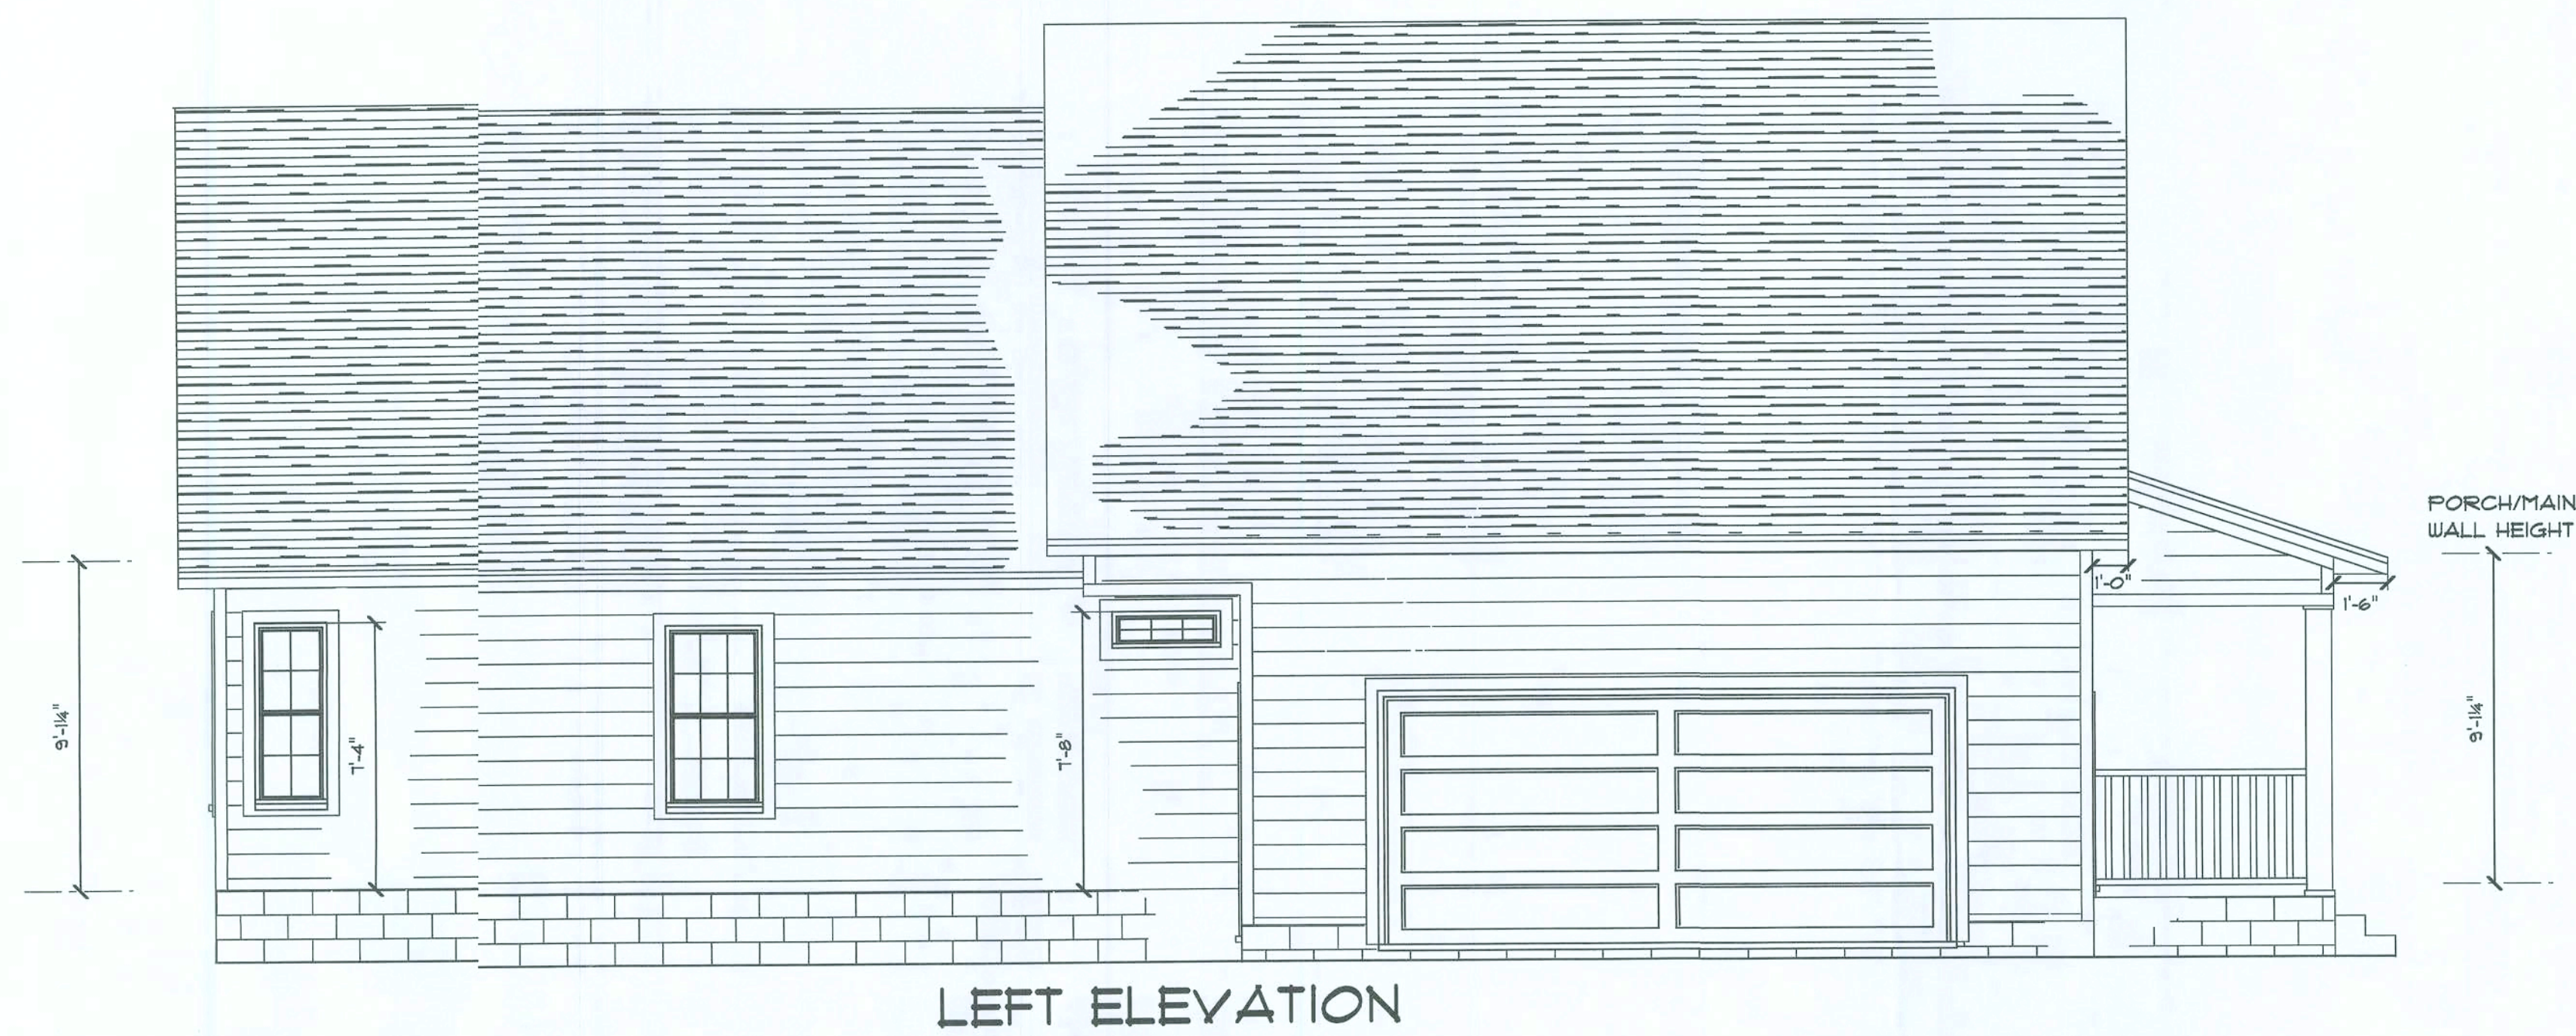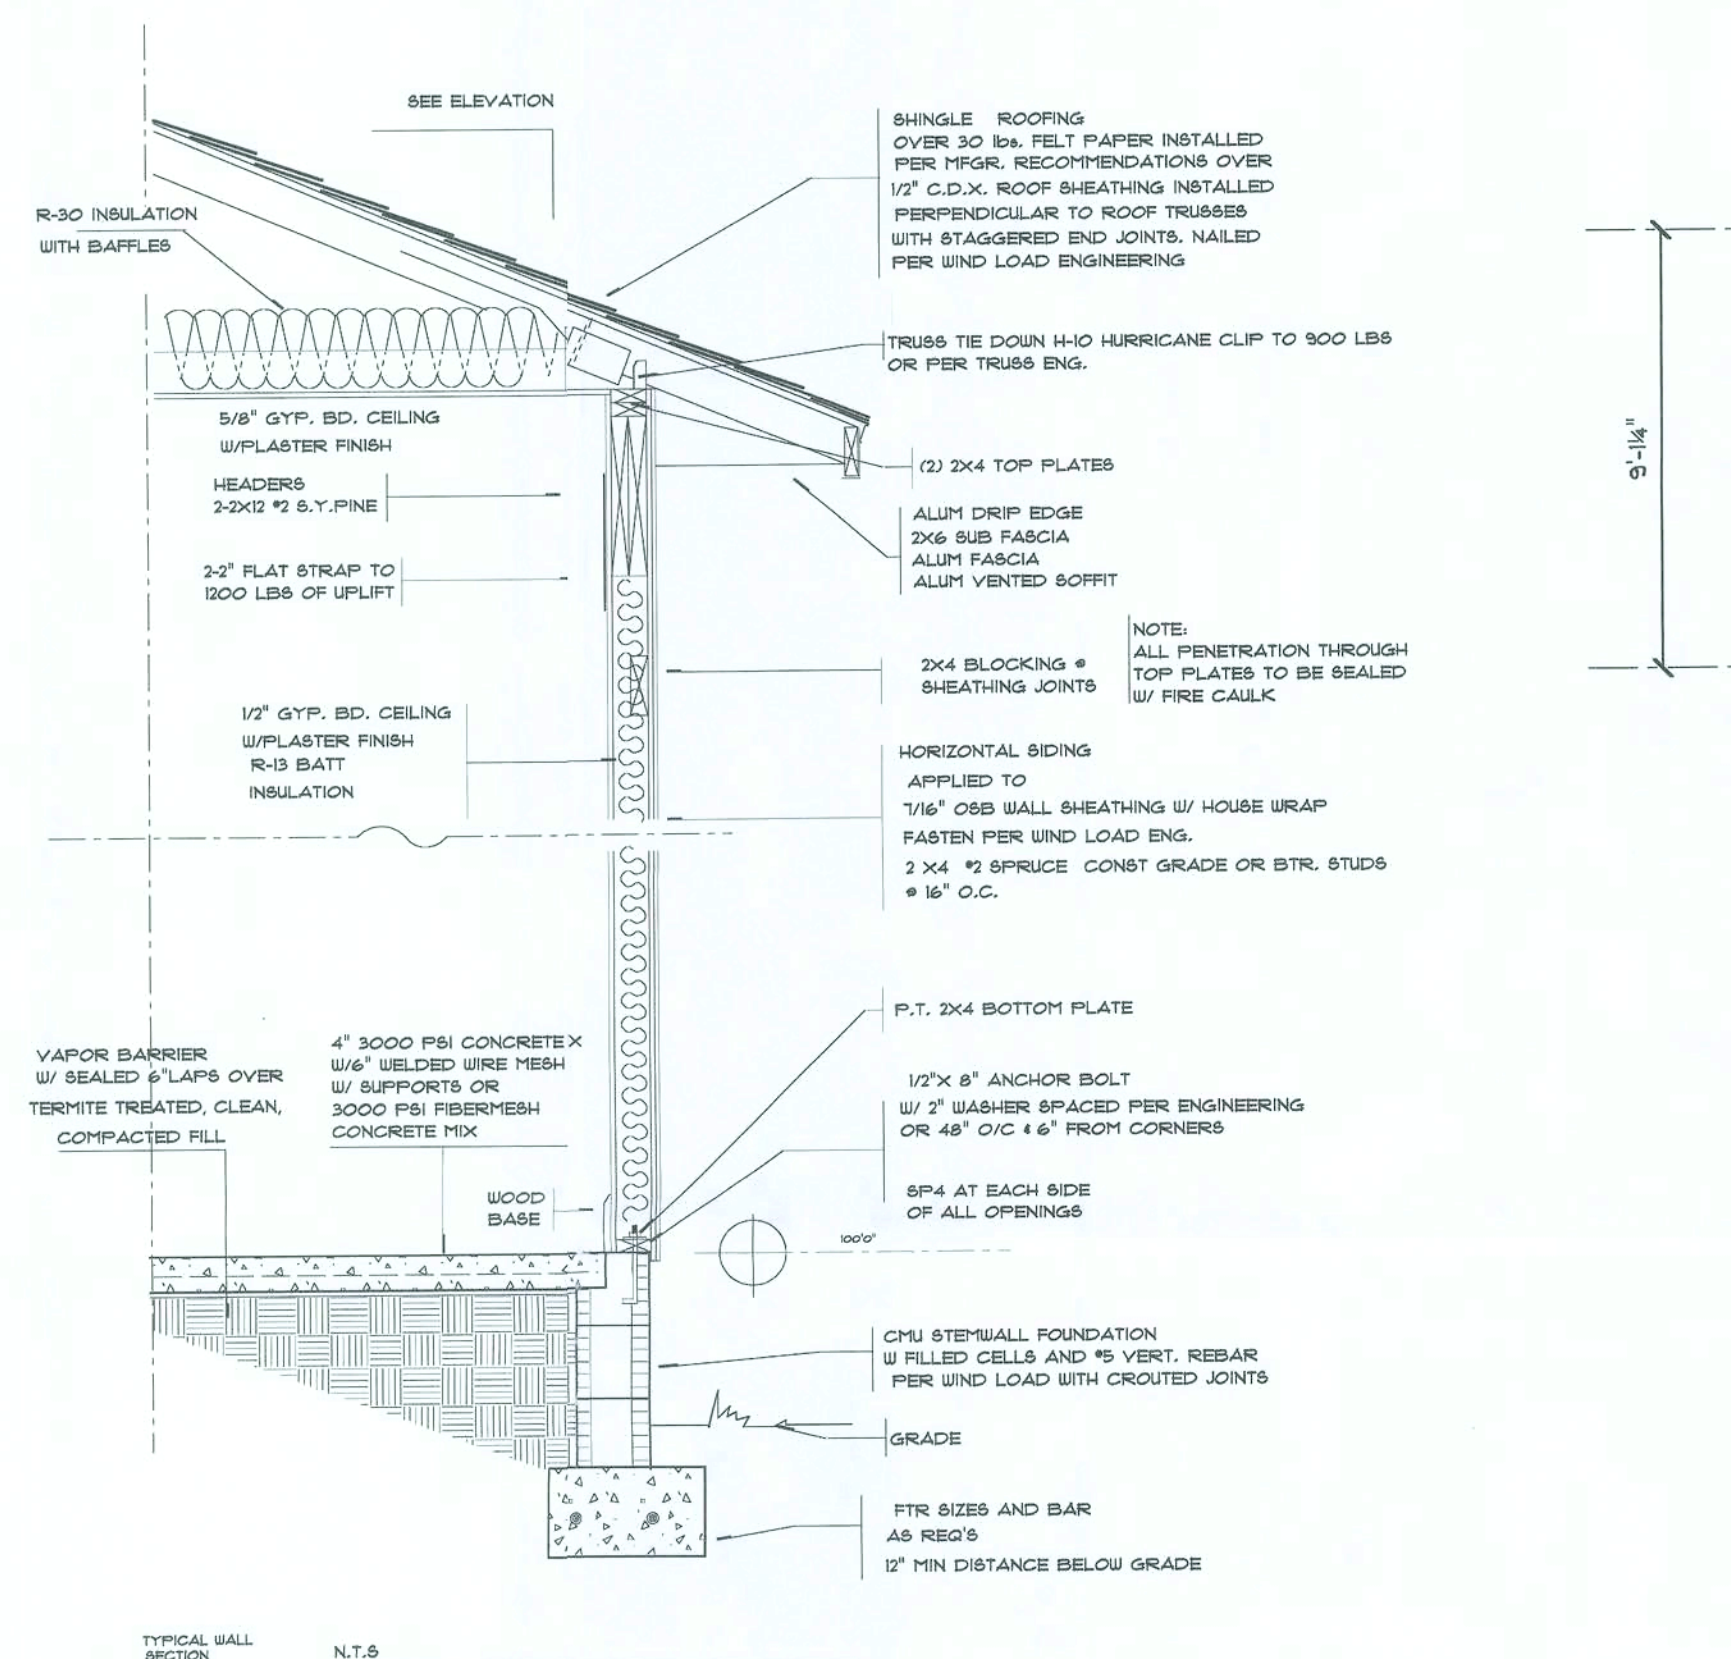

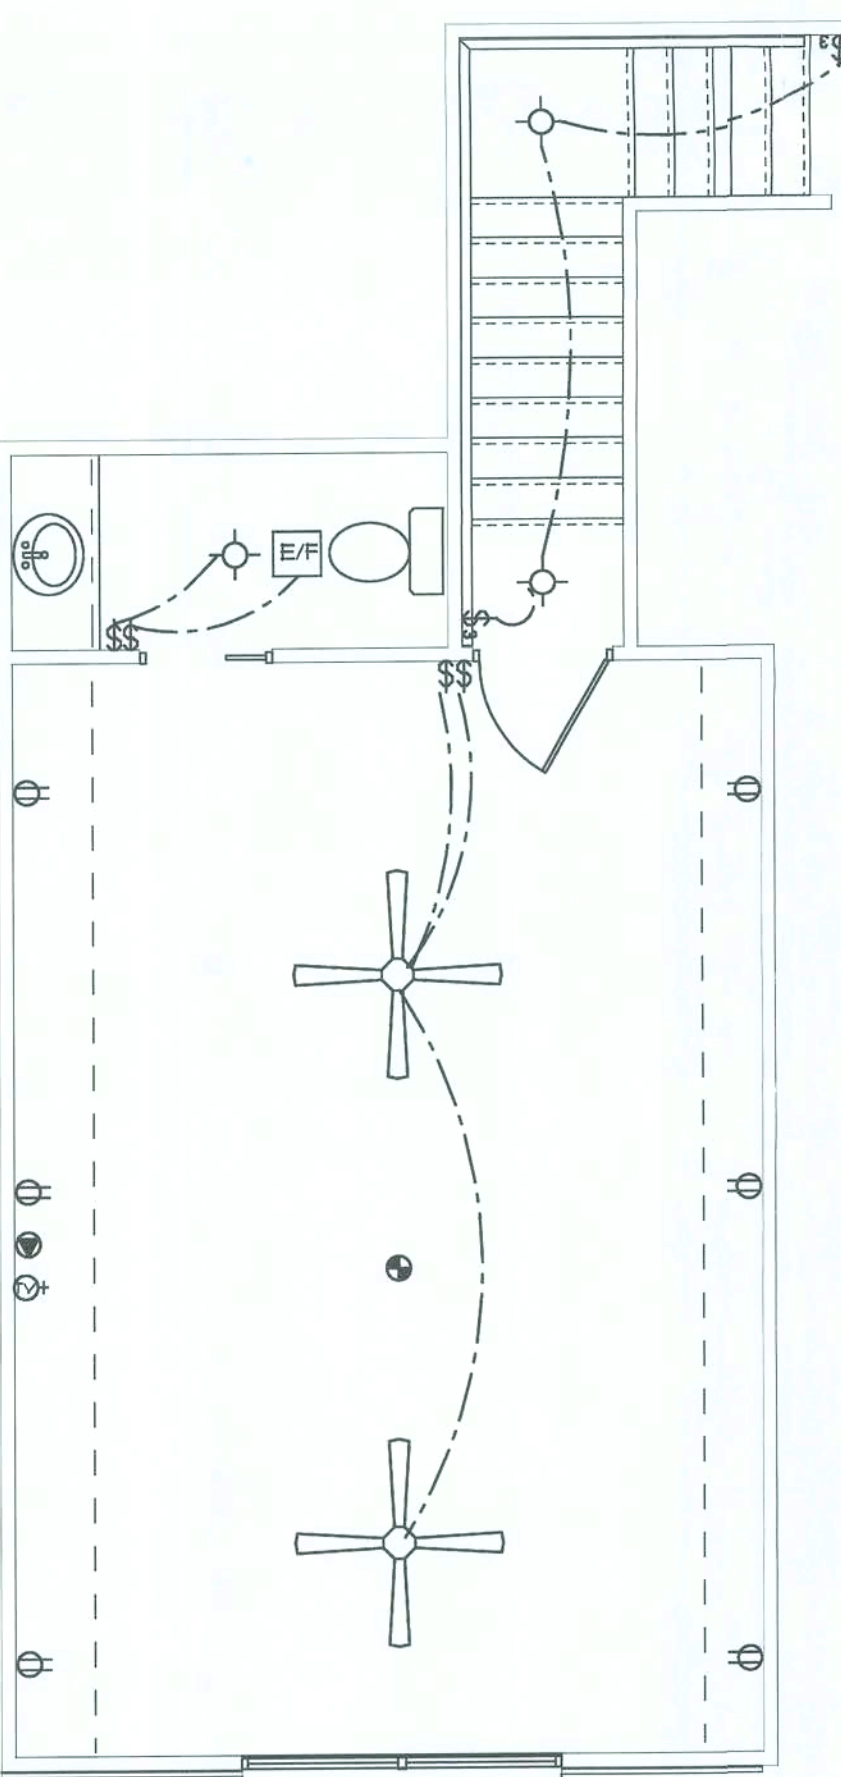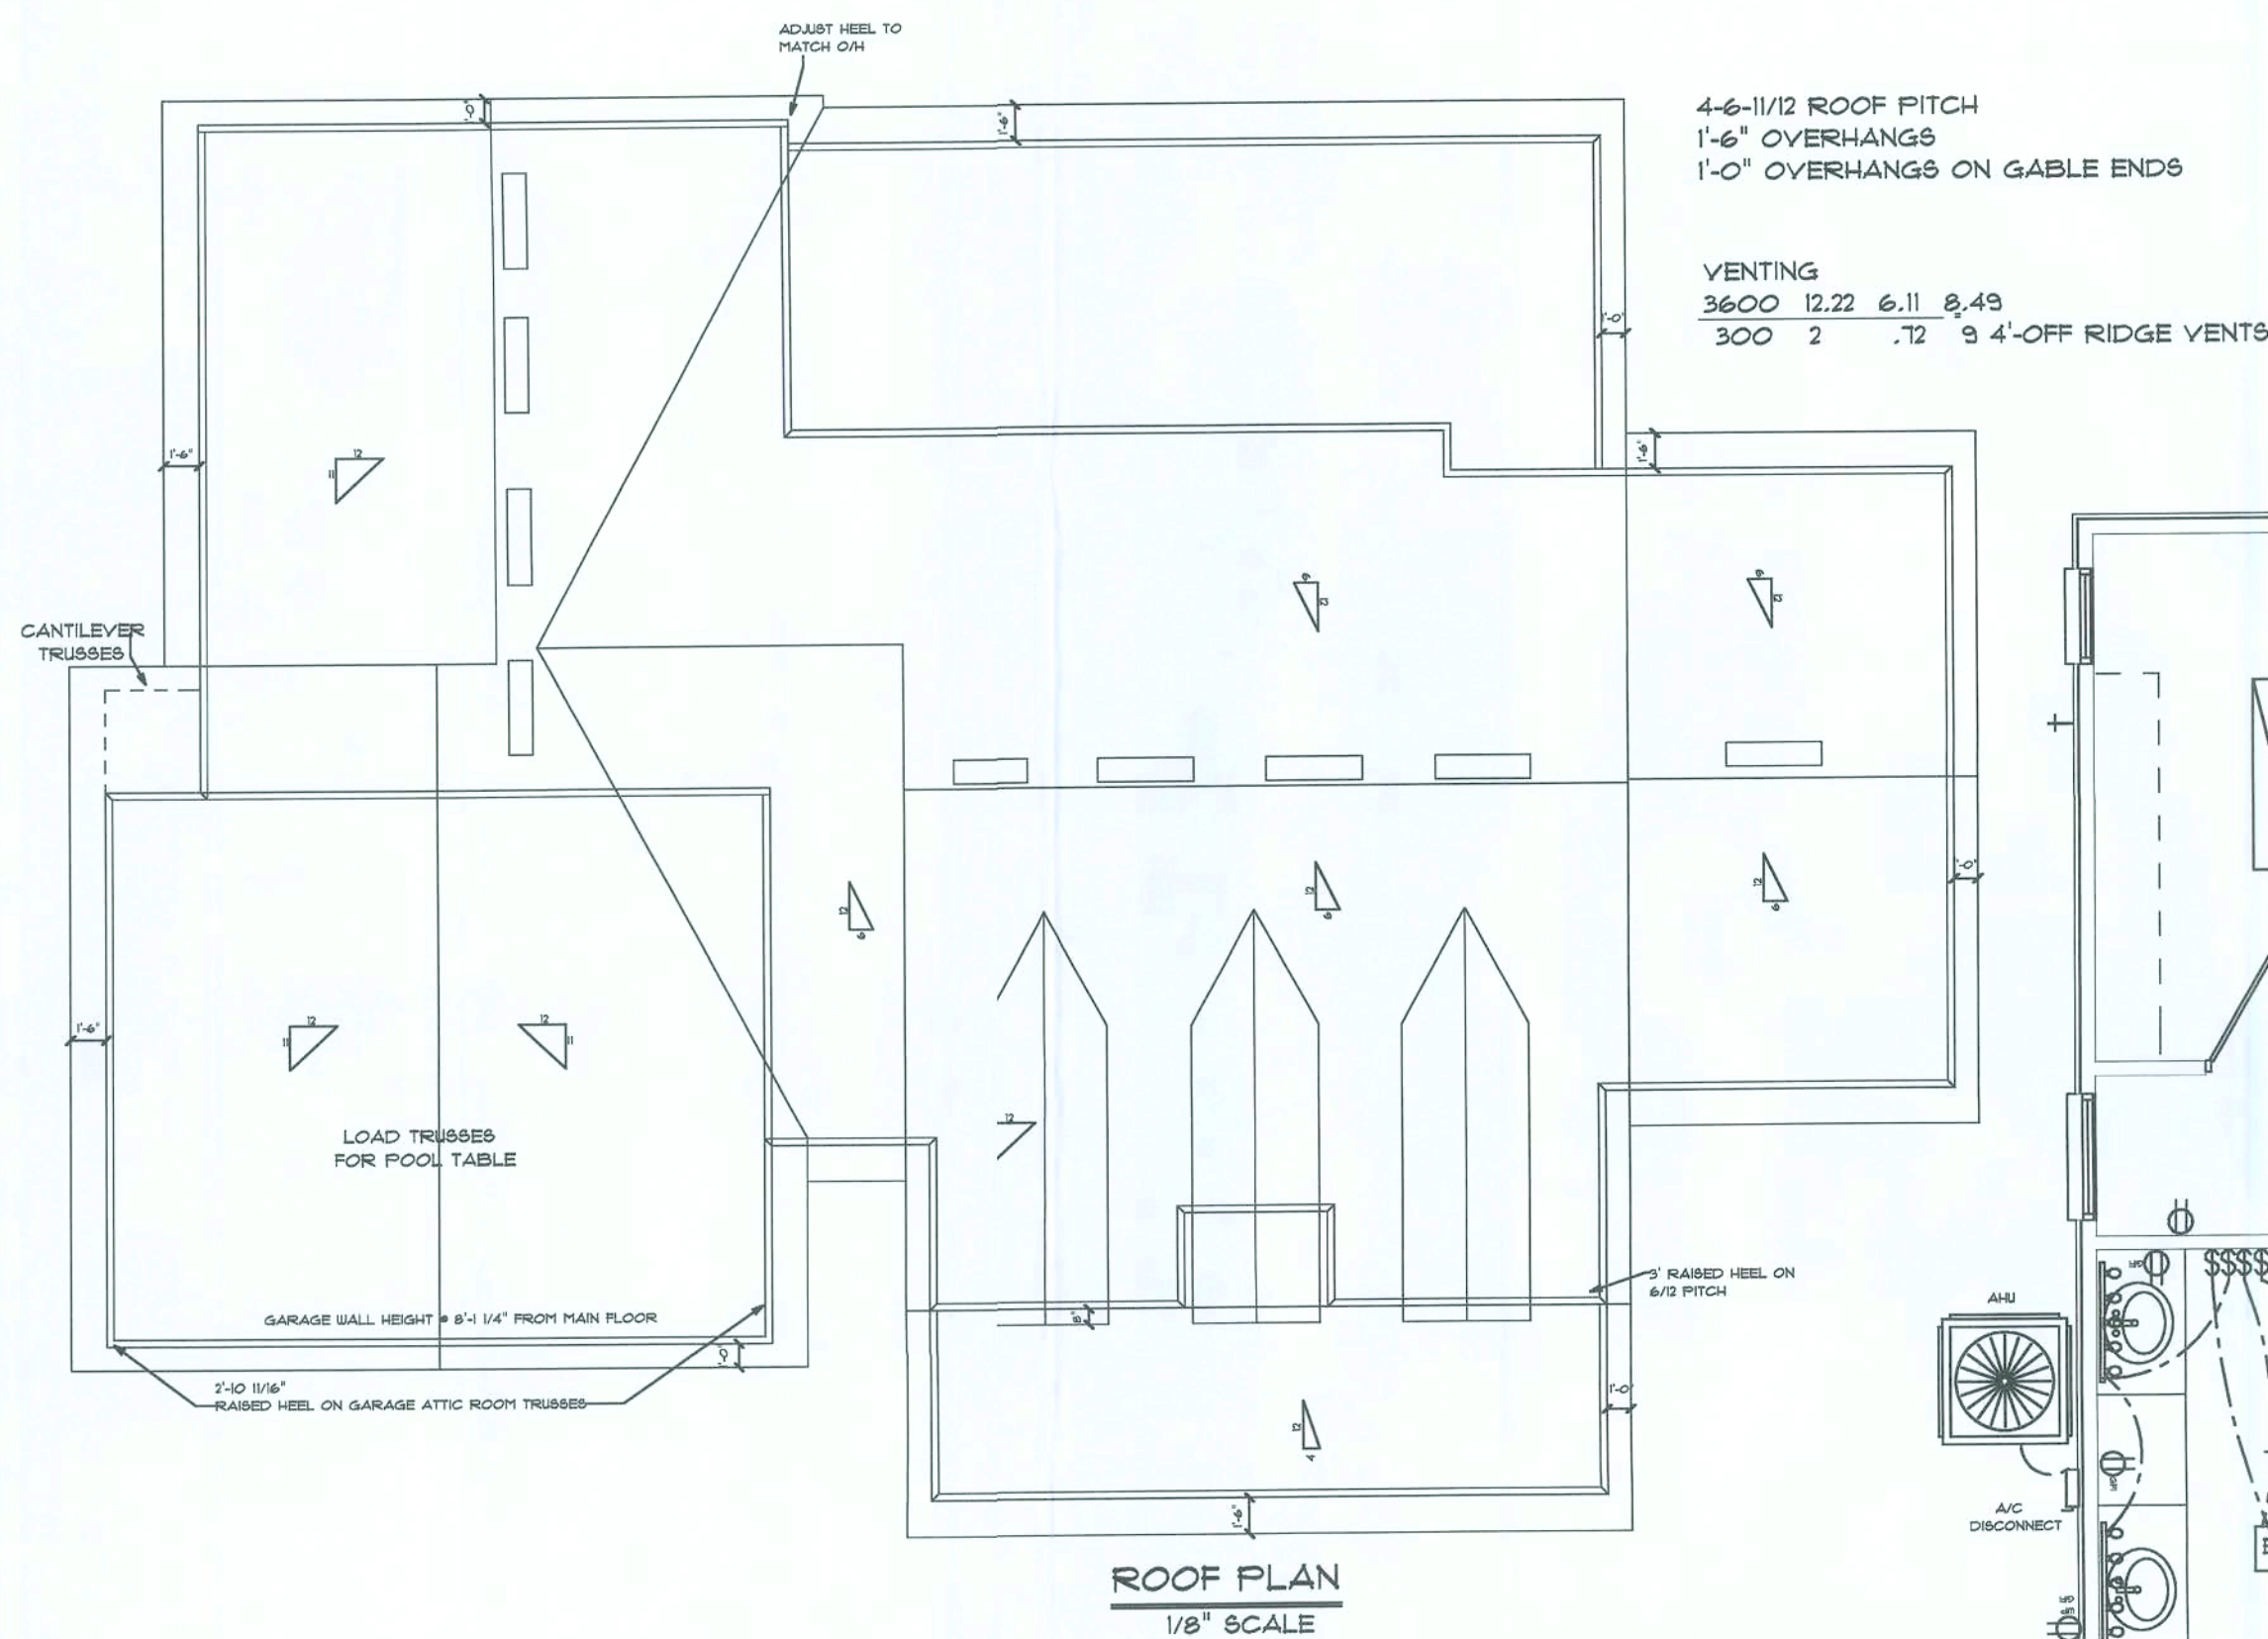

POWER METER
LOCATION T.B.D.
POWER PROVIDED
BY CLAY ELECTRIC

SMOKE DETECTORS TO BE 110 WIRELESS
W/ BATTERY BACK UP AS REQUIRED BY CODE

ALL BEDROOMS OUTLETS TO BE
ARC FAULT PROTECTED CIRCUIT

ALL RECEPTACLES
NEAR WATER TO
BE GFI

ALL EXTERIOR OUTLETS
TO BE WATERPROOF GFI

PHONE AND TV
OUTLETS PER
OWNERS

ELECTRIC PLAN IS A SUGGESTED LOCATION
FOR SWITCHES PLUGS AND LIGHTS
IT IS THE OWNER AND OR THE
CONTRACTORS RESPONSIBILITY
TO FOLLOW ALL STATE AND LOCAL CODES.

ELECTRICAL PLAN

ELECTRICAL SYMBOLS	
OUTLET	⊕
220 OUTLET	⊕⊕
SWITCH	\$
LIGHT	⊙
RECESS LIGHT	⊙⊕
FULL CHAIN	⊕PC
FLUORESCENT	⊕
CEILING FAN	⊕
WALL MOUNT LIGHT	⊕
VANITY LIGHT	⊕⊕⊕⊕
FLOOD LIGHT	⊕
CLG. LITE/FAN	⊕
PANEL	⊕
SMOKE DETECTOR	⊕
PHONE	⊕
TV/CABLE/INTERNET	⊕

PEDEN RESIDENCE

SCALE 1/4" = 1'
DRAWN BY F.A.C.
APPROVED

COLACINO
DRAFTING&DESIGN
PH. 352-472-3462

DATE 1/29/09
REVISED 2/10/09
REVISED

U