

KERMIT HUGHES, ARCHITECT



ARCHITECTURE, DESIGN
& OTHER SERVICES
COMMERCIAL & RESIDENTIAL

kermitchitect@gmail.com

971 NE 71 LANE
OCALA, FL 34479
(352) 875-3461

8/15/2022

Greetings,

This letter is to address the revisions to the Irma Model.

The garage was turned to a side entry garage and the front porch was extended slightly which changed the look of the entry. Some material changes were made on the front elevation. These revisions are to address the Home Owner's Association's requirements.

Sincerely,

Kermit Hughes



Kermit Hughes
c=US, st=Florida,
l=Ocala, o=Kermit
James Hughes,
cn=Kermit
Hughes
2022.08.15
08:36:06 -04'00'

GENERAL NOTES


ALL DRAWINGS AND SPECS ARE INSTRUMENTS OF SERVICE AND ARE THE PROPERTY OF KERMIT HUGHES ARCHITECT. THESE PLANS AND SPECS SHALL NOT BE DUPLICATED, REPRODUCED OR REVISED IN ANY WAY WITHOUT THE WRITTEN CONSENT OF KERMIT HUGHES ARCHITECT ANY REVISION, ADDITION OR DELETION TO THE SCOPE, DESIGN, OR INTENT BY ANYONE OTHER THAN KERMIT HUGHES ARCHITECT WILL ABSOLVE KERMIT HUGHES ARCHITECT FROM ANY RESPONSIBILITY, SUITS, LITIGATION, OR LIABILITY CLAIMS RELATED TO THE PROJECT.

CONTRACTOR / OWNER SHALL INSPECT AND VERIFY THE SCOPE OF WORK AND CHECK ALL DIMENSIONS PRIOR TO CONSTRUCTION. ANY ADDITIONAL WORK APPARENT DURING FIELD INSPECTION BUT NOT SPECIFICALLY NOTED ON THE DRAWINGS SHALL BE CONSIDERED AS PART OF THE SCOPE OF WORK.

ALL MATERIALS SHALL BE INSTALLED IN ACCORDANCE WITH MANUFACTURERS INSTRUCTIONS.

BOUNDARY SURVEY IN SECTION 16, TOWNSHIP 4 SOUTH,
RANGE 16 EAST, COLUMBIA COUNTY, FLORIDA.

DESCRIPTION:
LOT 7, KIMBERLY OAKS, A SUBDIVISION ACCORDING TO THE PLAT THEREOF AS RECORDED IN
PLAT BOOK 7, PAGES 198-199 OF THE PUBLIC RECORDS OF COLUMBIA COUNTY, FLORIDA.

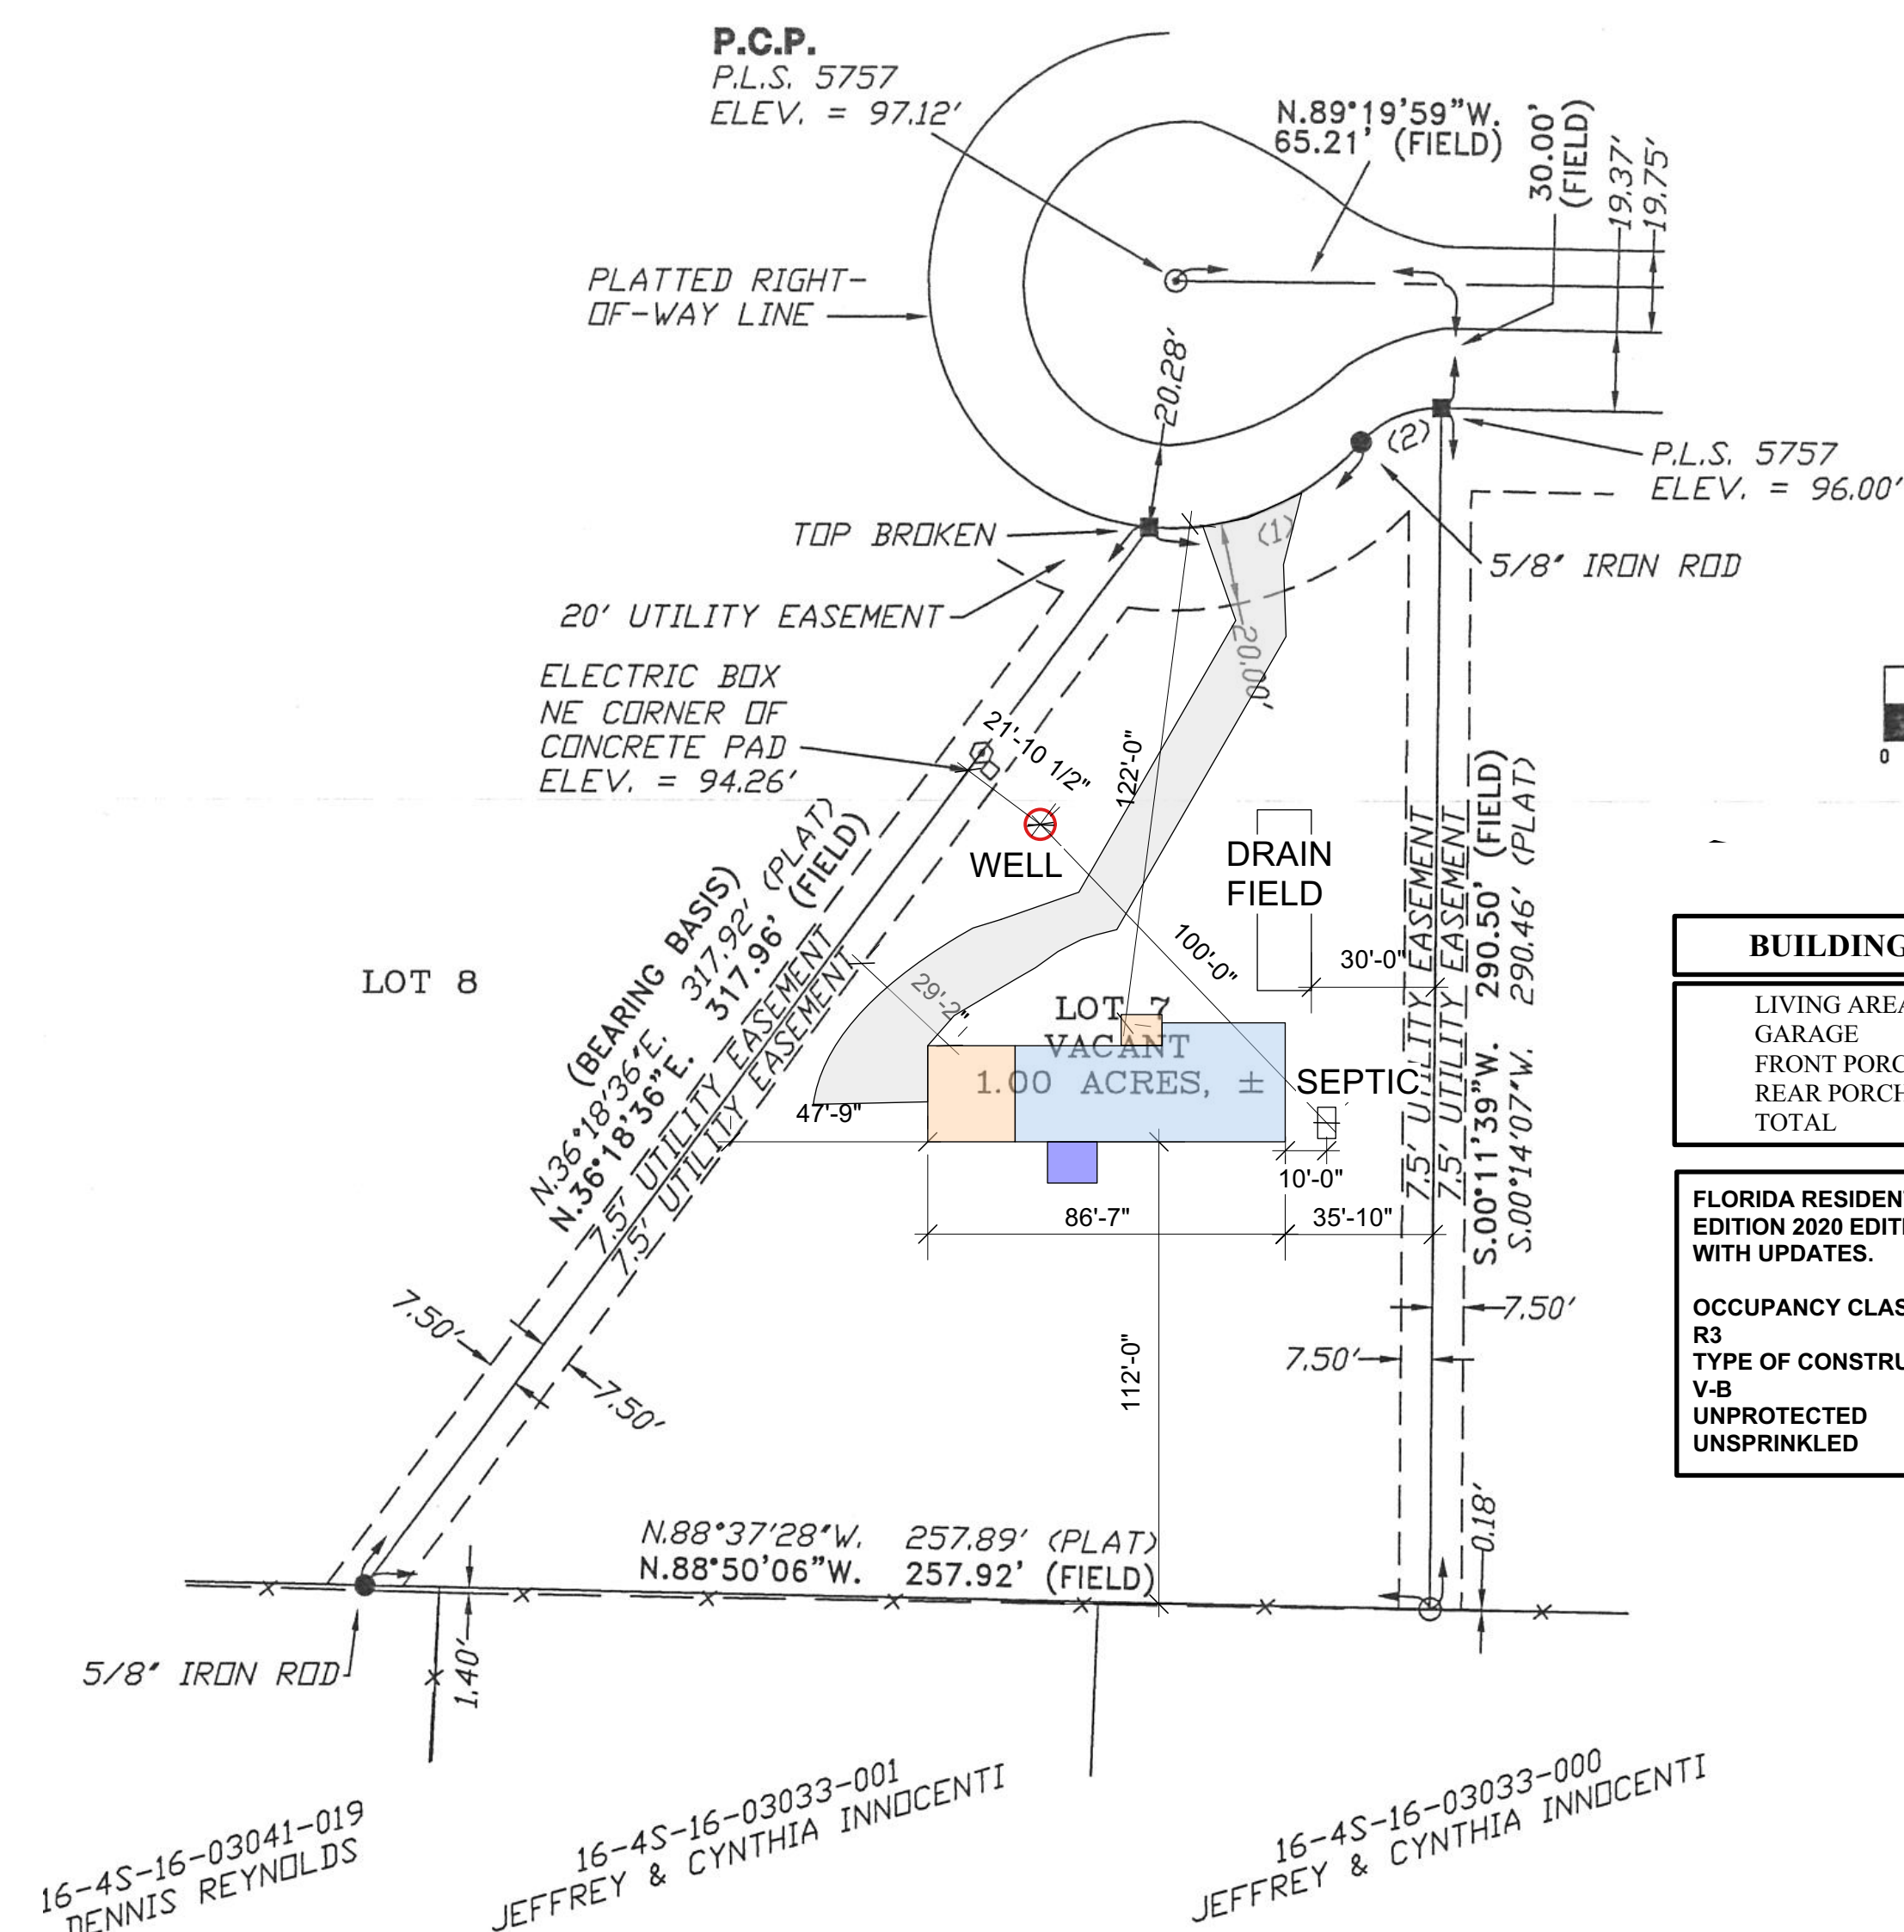

BUILDING AREA	
LIVING AREA	1689
GARAGE	492
FRONT PORCH	72
REAR PORCH	120
TOTAL	2373

FLORIDA RESIDENTIAL CODE 7TH
EDITION 2020 EDITION
WITH UPDATES.


OCCUPANCY CLASS RESIDENTIAL
R3
TYPE OF CONSTRUCTION
V-B
UNPROTECTED
UNSPRINKLED

SITE PLAN

1 SITE LOCATION
Scale: 1" = 40'-0"

KERMIT HUGHES
ARCHITECT

TELEPHONE (352)875-3461
E-MAIL kermitchitect@gmail.com

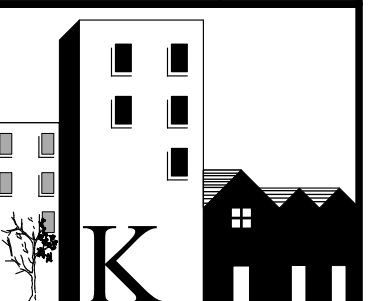

R92098

ermit Hughes
 =US, st=Florida,
 =Ocala, o=Kermit
 ames Hughes,
 n=Kermit Hughes
 022.08.15 08:13:50
 04'00'

04-21-2022

JBSCM

DATE ISSUED	08-15-2022
REVISED	

ELEVATIONS





FRONT, RIGHT, LEFT
AND REAR ELEVATIONS

KERMIT HUGHES
ARCHITECT

971 NE 71ST LN OCALA, FL 34479
TELEPHONE (352)875-3461
E-MAIL kermitarchitect@gmail.com

Kermit Hughes
c=US, st=Florida,
l=Ocala, o=Kermit
James Hughes,
cn=Kermit Hughes
2022.08.15 08:16:50
-04'00'

SHEET NO.

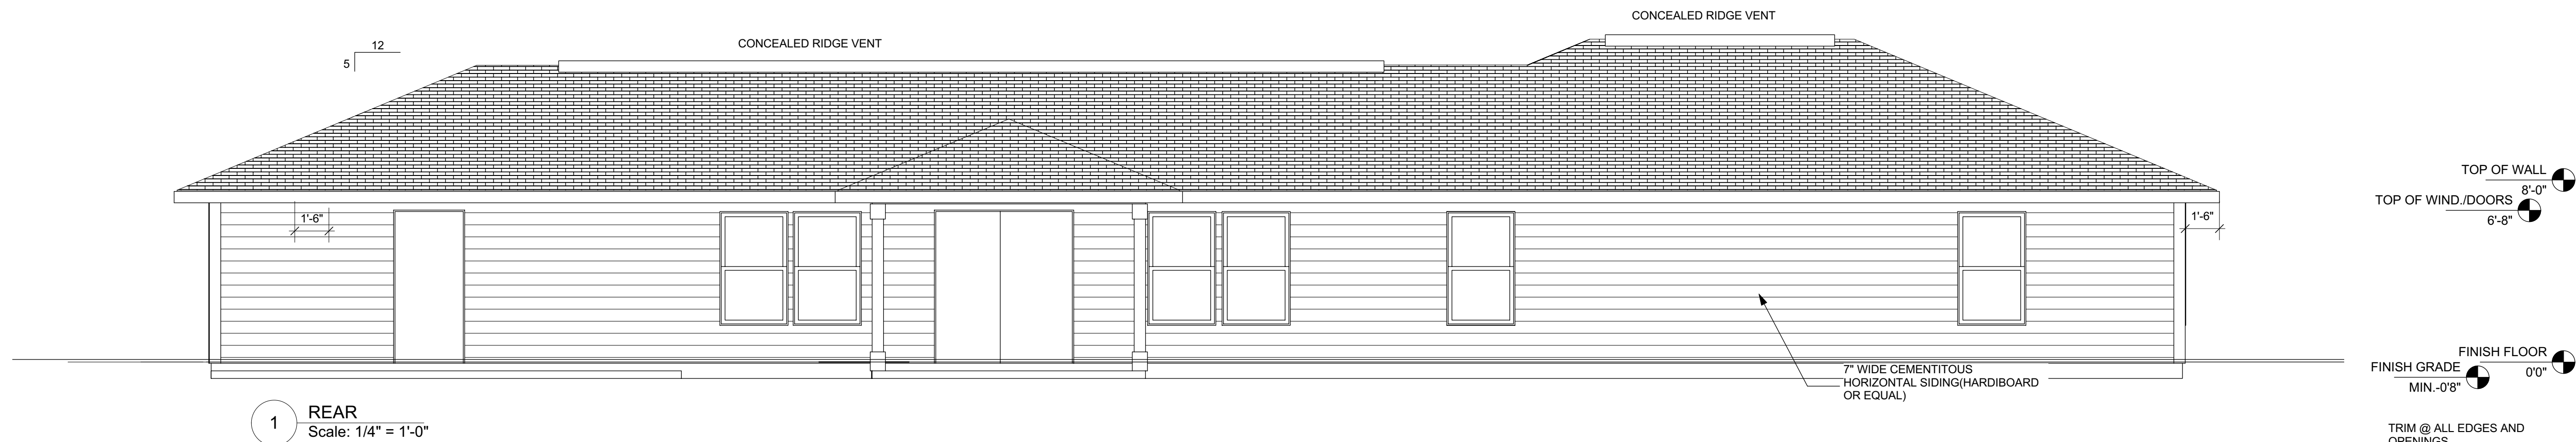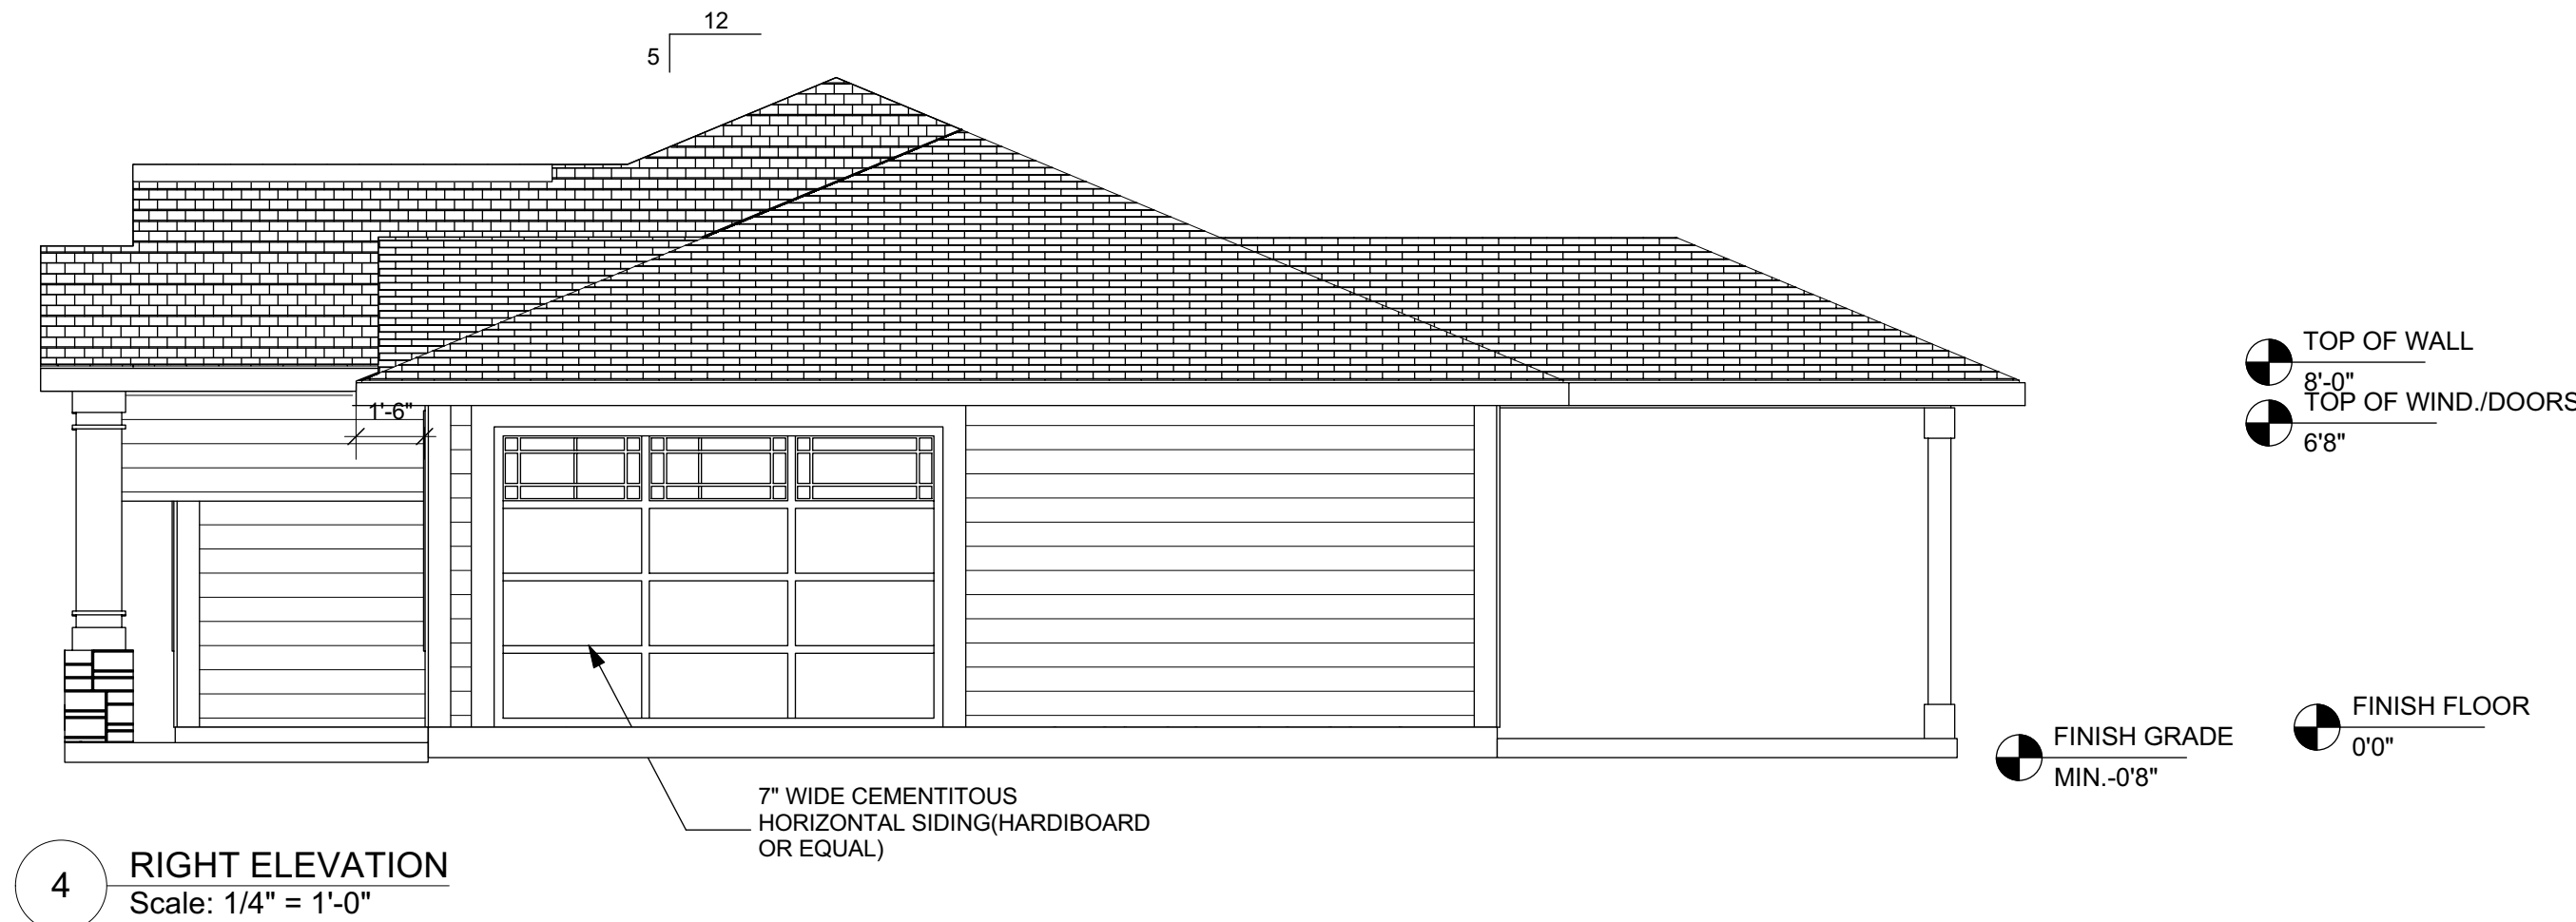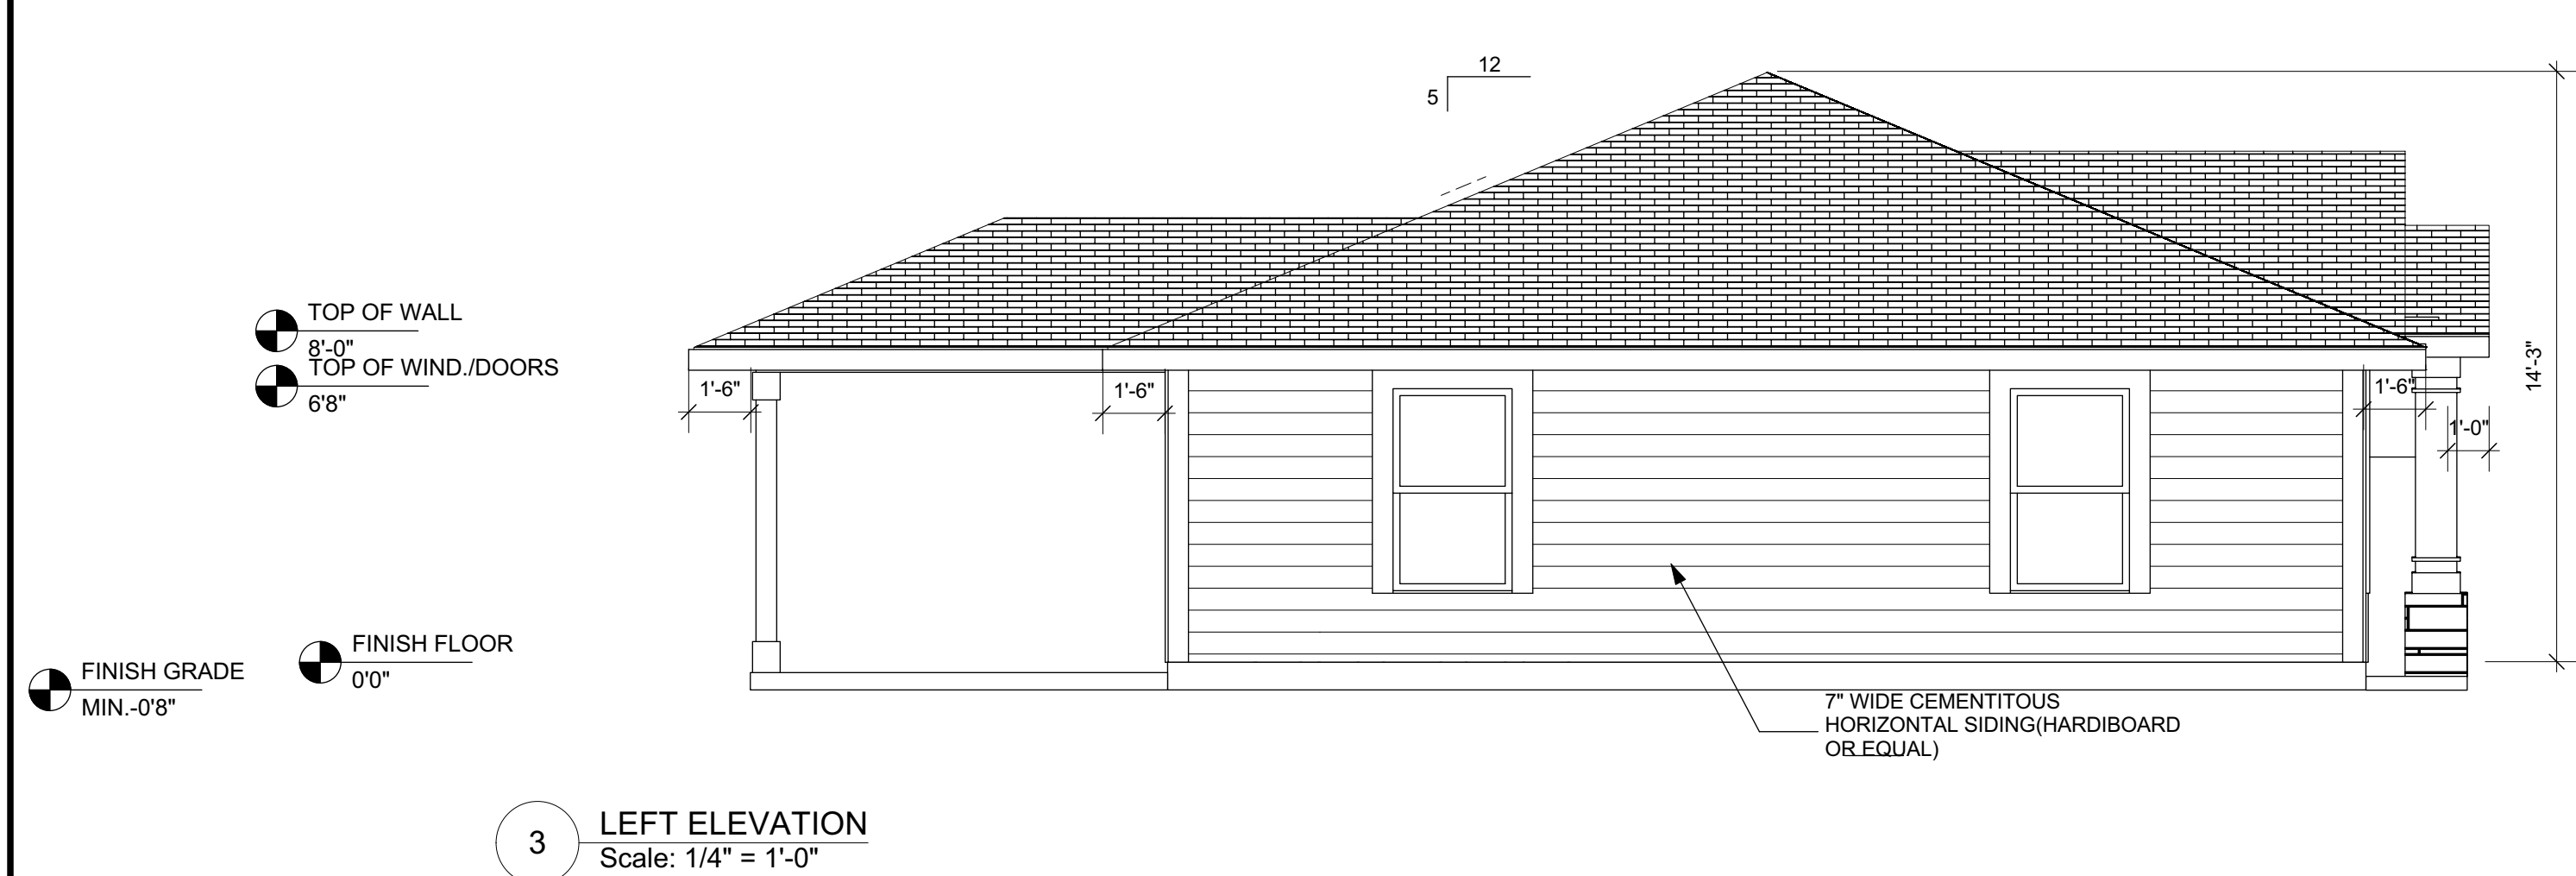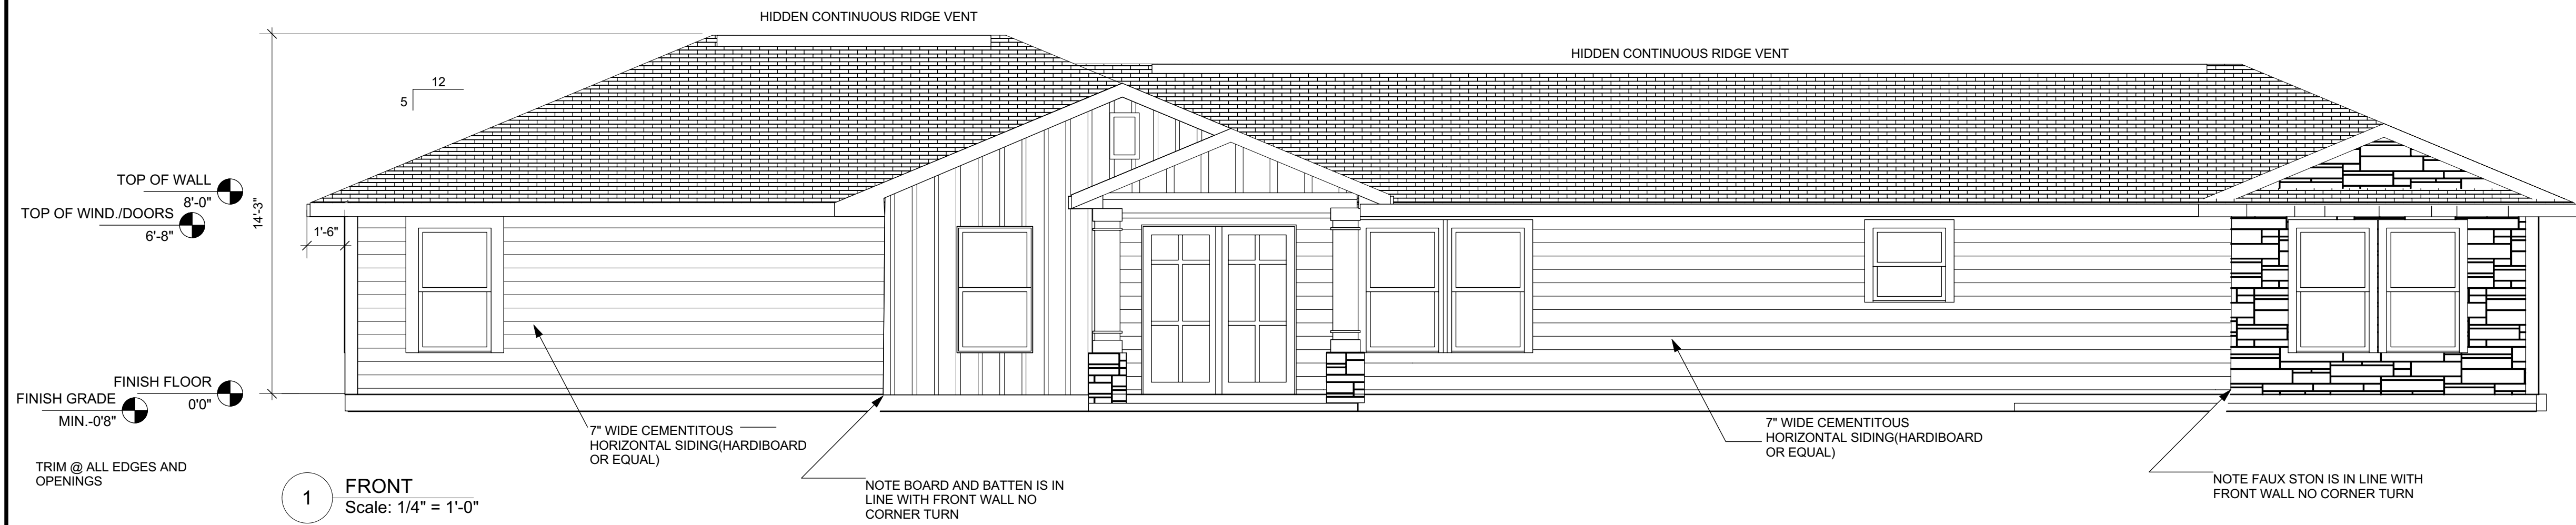

**SEE FOUNDATION PLAN
FOR FOOTER SIZES**

CELL TREATED MACHINED
LIFT IN 8" LIFTS COMPACTED
TO 95% DRY DENSITY.

1 TYPICAL WALL SECTION
Scale: 3/4" = 1'-0"

2 FOUNDATION PLAN
Scale: 1/4" = 1'-0"

USE SIMPSON LGT2 @ GIRDER TO1

LGT2 = 2,000LB UPLIFT
RESISTANCE

FOOTER DETAILS

3 TYPICAL MONOLITHIC FOOTING

3A MONOLITHIC FOOTING AT GARAGE

9

6

 THICKENED EDGE

MONOLITHIC FOOTING AT LIVING AREA/GARAGE

MONOLITHIC FOOTING AT LIVING AREA/GARAGE ALTERNATIVE

9771 NE 71ST LN OCALA, FL 34479
TELEPHONE (352)875-3461
E-MAIL kernitarchitect@gmail.com




```
Kermit Hughes
c=US, st=Florida,
l=Ocala, o=Kermit
James Hughes,
cn=Kermit Hughes
2022.08.15
08:16:00 -04'00'
```

SHEET NO.

\$100

3 OF 4

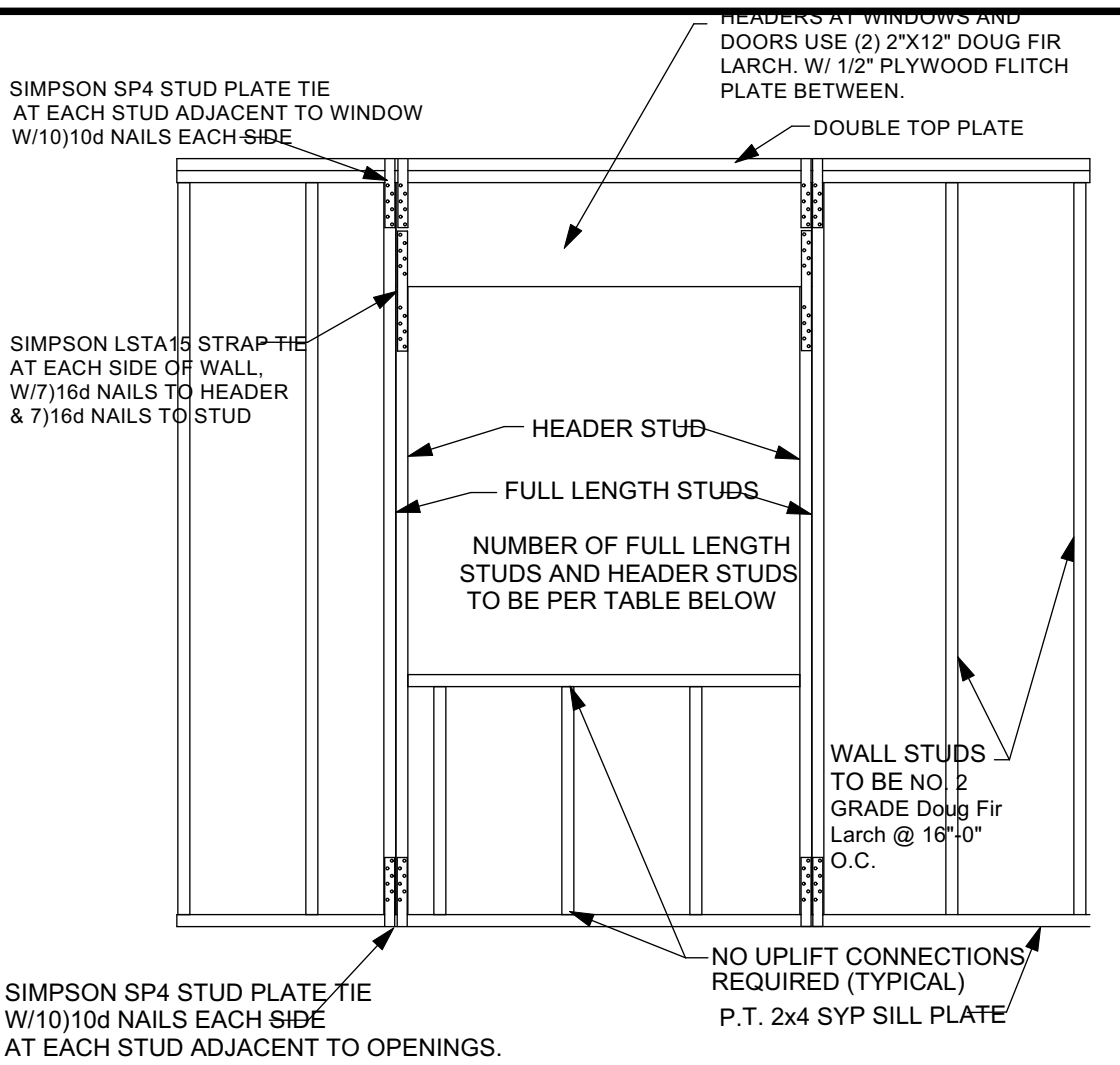

MAXIMUM HEADER SPAN IN FEET						
3'	6'	9'	12'	15'	16'	
NUMBER OF FULL LENGTH STUDS SUPPORTING END OF HEADER						
1	1	2	2	2	2	
NUMBER OF FULL LENGTH STUDS AT EACH END OF HEADER						
UNSUPPORTED STUD WALL HEIGHT	10 FT. OR LESS	16 IN.	1	2	2	2
GREATER THAN 10 FT.	16 IN.	1	2	2	3	3

FRAMING DETAILS FOR OPENINGS

COMPONENT & CLADDING DESIGN PRESSURES:


COMPONENT & CLADDING DESIGN PRESSURE LOADS: SUPPLIERS / MANUFACTURERS OF ALL CLADDING AND COMPONENTS (INCLUDING, BUT NOT LIMITED TO: SIDING, ROOFING, DOORS, WINDOWS, AWNINGS, ETC.) WILL SUBMIT REPORTS & DATA SIGNED AND SEALED BY A LICENSED STRUCTURAL ENGINEER IN THE STATE OF FLORIDA DOCUMENTING COMPLIANCE WITH THIS PROVISION OF THE FLORIDA BUILDING CODE, 2020 7th EDITION WITH SUPPLEMENTS

BASIC WIND SPEED 140 MPH ROOF SLOPE 20°-27° INTERNAL PRESSURE COEFFICIENT .18
*A' DIMENSION = 4'

COMPONENT & CLADDING

COMPONENT AND CLADDING WIND LOADS FOR A BUILDING WITH A MEAN ROOF HEIGHT OF 30 FEET LOCATED IN EXPOSURE B (psf) RISK CATEGORY II

	ZONE	EFFECTIVE WIND AREA	POS		NEG
			POS	NEG	
HIP ROOF >20 TO 27 DEGREES	1	10	15.8	-28.3	
	1	20	13.6	-25.1	
	1	50	10.8	-20.8	
	1	100	10.0	-17.6	
	2e, 2r, 3	10	15.8	-39.1	
	2e, 2r, 3	20	13.6	-34.9	
	2e, 2r, 3	50	10.8	-29.4	
	2e, 2r, 3	100	10.0	-25.3	
WALLS	4	10	21.2	-22.9	
	4	20	20.2	-22.0	
	4	50	19.0	-20.7	
	4	100	18.0	-19.8	
	4	500	15.8	-17.6	
	5	10	21.2	-28.3	
	5	20	20.2	-26.4	
	5	50	19.0	-23.9	
	5	100	18.0	-22.0	
	5	500	15.8	-17.6	
	4	10	21.2	-22.9	
	4	20	20.2	-22.0	

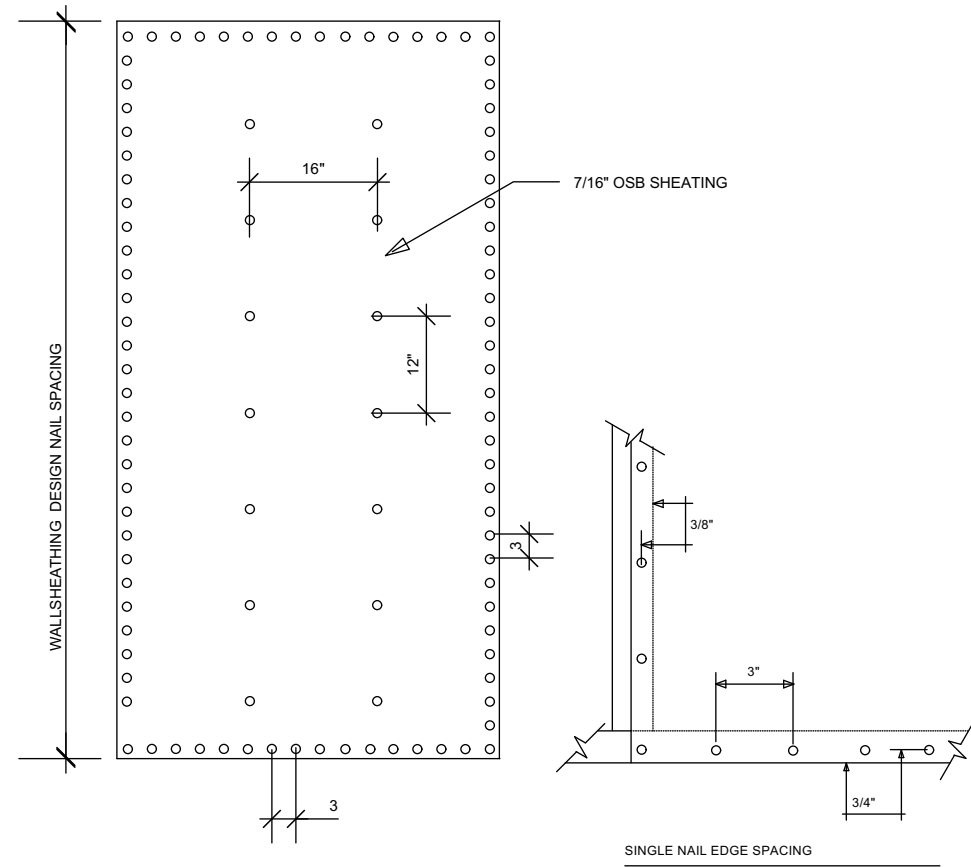




SHEATHING NAILING PATTERN

WOOD FRAME CONSTRUCTION

MANUFACTURER: SIMPSON HOLD DOWN		
TRUSS/GIRDER	HOLD DOWN	NAILS
UPLIFT		
O-995	H10	8-8d
995-2200	H10 and H15	8-8d 4-10d4-10d 12-10d
2200-3965	MGT	22-10d
INTERIOR FRAME BEARING WALL UP TO 995	H10	TRUSS 8 8d TOP PLATE 8 8d

EQUAL OR SUPERIOR STRAPS MAY BE USED IN EACH CONDITION UPLIFT INDICATED IN POUNDS

TRUSS HOLD DOWN SCHEDULE

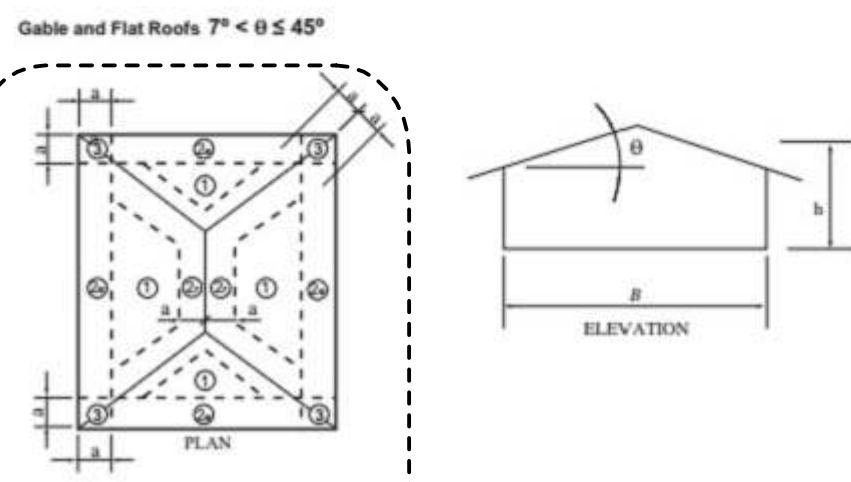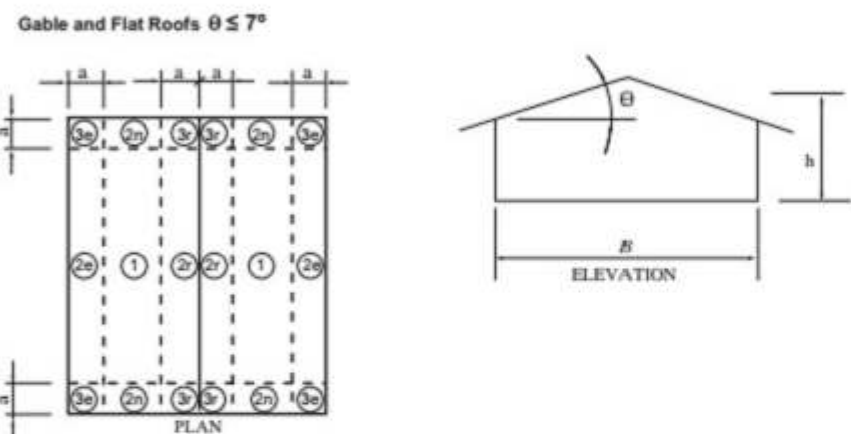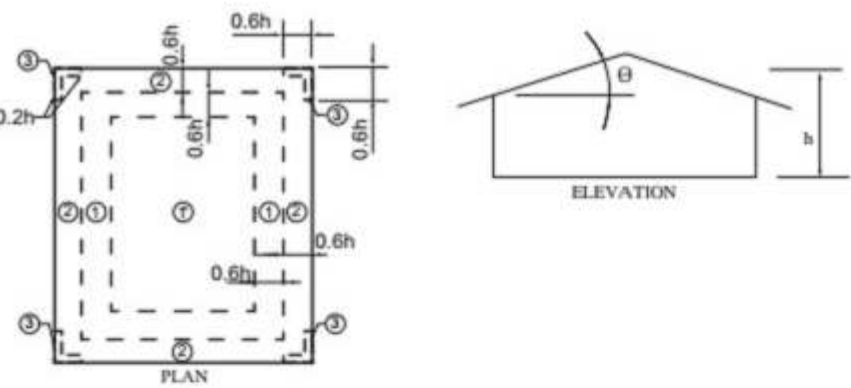


For SI: 1 foot = 304.8 mm, 1 degree = 0.0175 rad. Note: a = 4 feet in all cases.

SHEATHING SHALL BE FASTENED TO ROOF W/ 8D COMMON, 8D HOT DIPPED GALVANIZED BOX NAILS OR 10 1/4 GAGE X 2" MINIMUM LENGTH POWER NAILS @ 4" O.C. ON SHEET EDGES AND 12" O.C. IN SHEET FIELD EXCEPT AS NOTED BELOW.


- ZONE 2e, 2r & 3 USE FASTENERS @ 4" O.C. ON SHEET EDGES AND 4" O.C. IN SHEET FIELD
- SPACE FASTENERS 4" O.C. MIN. @ GABLE ENDWALL OR GABLE TRUSS.

SHINGLE INSTALLATION DETAILS


APPLY TO SHINGLES MADE BY THE FOLLOWING MANUFACTURERS WHICH HAVE BEEN APPROVED FOR 110 MPH WIND RESISTANCE
MARQUIS/MARQUIS WEATHER MAX
SLATELINE
COUNTRY MANSION
COUNTRY ESTATES
TIMBERLINE 30
TIMBERLINE SELECT
TIMBERLINE ULTRA SENTINEL
GRAND CANYON
GRAND SEQUOIA
IF CONTRACTOR USES ANOTHER BRAND, CONTRACTOR SHALL PROVIDE INSTALLATION DETAILS

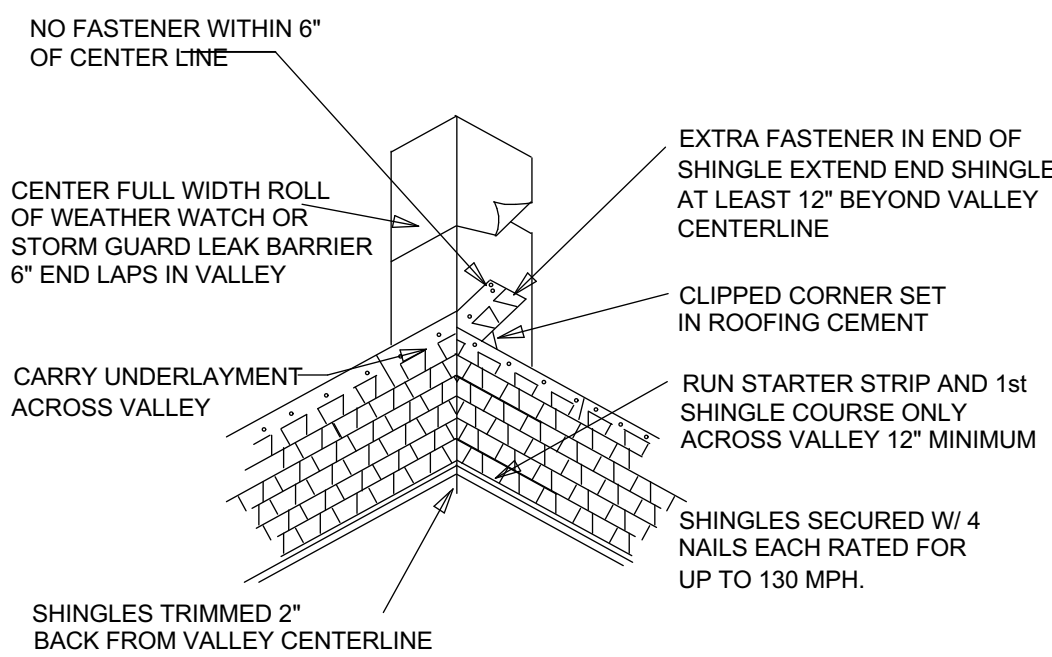


VALLEY CONSTRUCTION CLOSED CUT

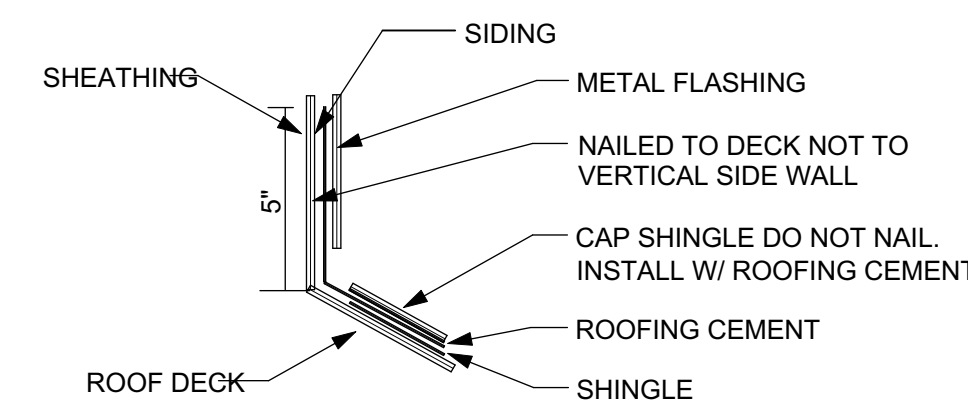

WALL FLASHING (SLOPED ROOF TO VERTICAL WALL)

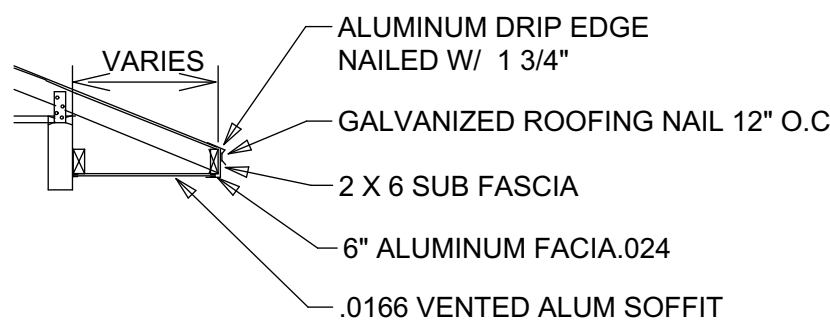

SOFFIT AND FACIA INSTALLATION

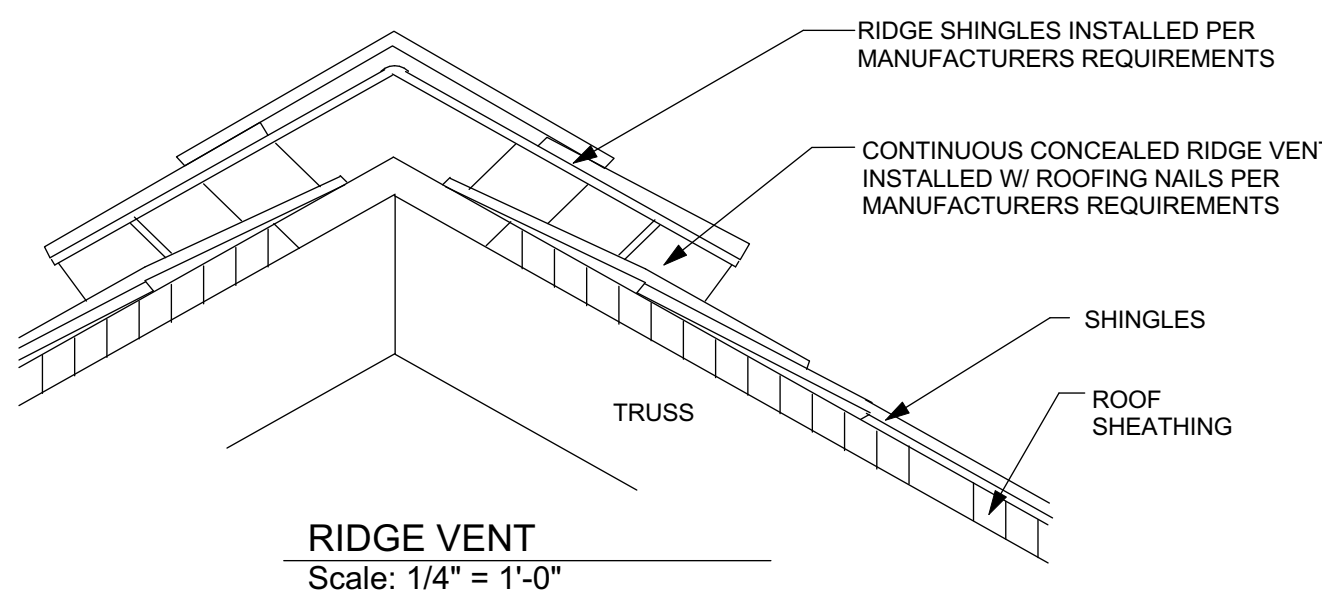

ROOF COVERING DETAIL

THESE PLANS ARE NOT TO BE REVISED, REPRODUCED OR DUPLICATED IN ANY WAY WITHOUT WRITTEN CONSENT OF KERMIT HUGHES ARCHITECT. ANY REVISIONS OF THESE PLANS WITHOUT WRITTEN CONSENT OF KERMIT HUGHES ARCHITECT SHALL ENDEAVOR TO BE RESPONSIBILITY RELATED TO THE PROJECT.

DATE ISSUED 08-15-2022

REVISION

DRAWN BY: KERMIT
APPROVED BY: KERMIT

ARCHITECTURAL DETAILS

ROOFING DETAILS, GARAGE DOOR BUCK

JBCM
IRMA MODEL
LAKE CITY FLORIDA

KERMIT HUGHES
ARCHITECT
971 NE 71ST LN OCALA, FL 34479
TELEPHONE (352)875-3461
E-MAIL: kermitarchitect@gmail.com





Kermit Hughes
c=US, st=Florida,
l=Ocala, o=Kermit
James Hughes, cn=Kermit Hughes
2022.08.15
08:15:20 -04'00'

SHEET NO.

S101

4 OF 4

08-15-2022

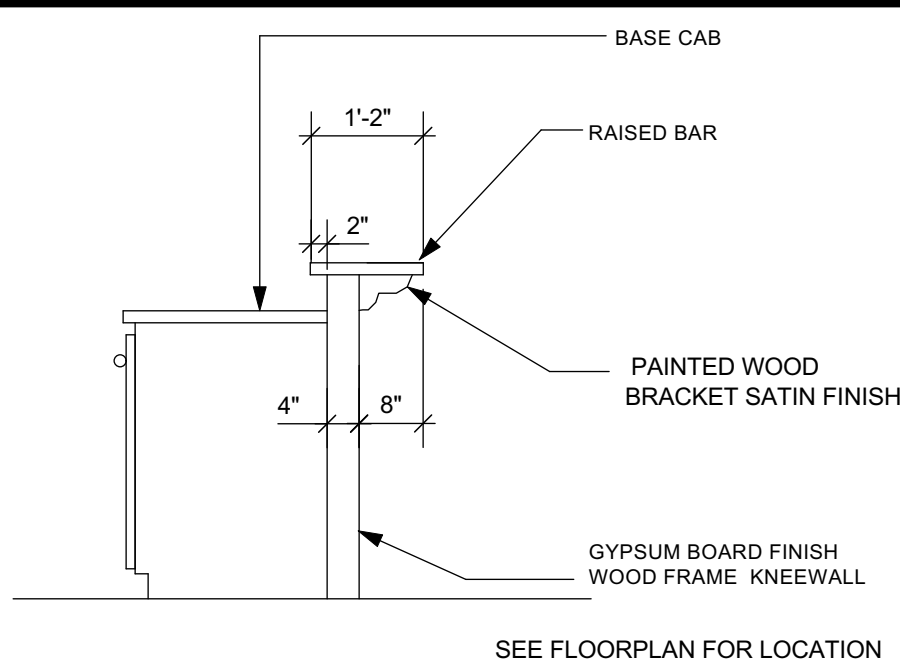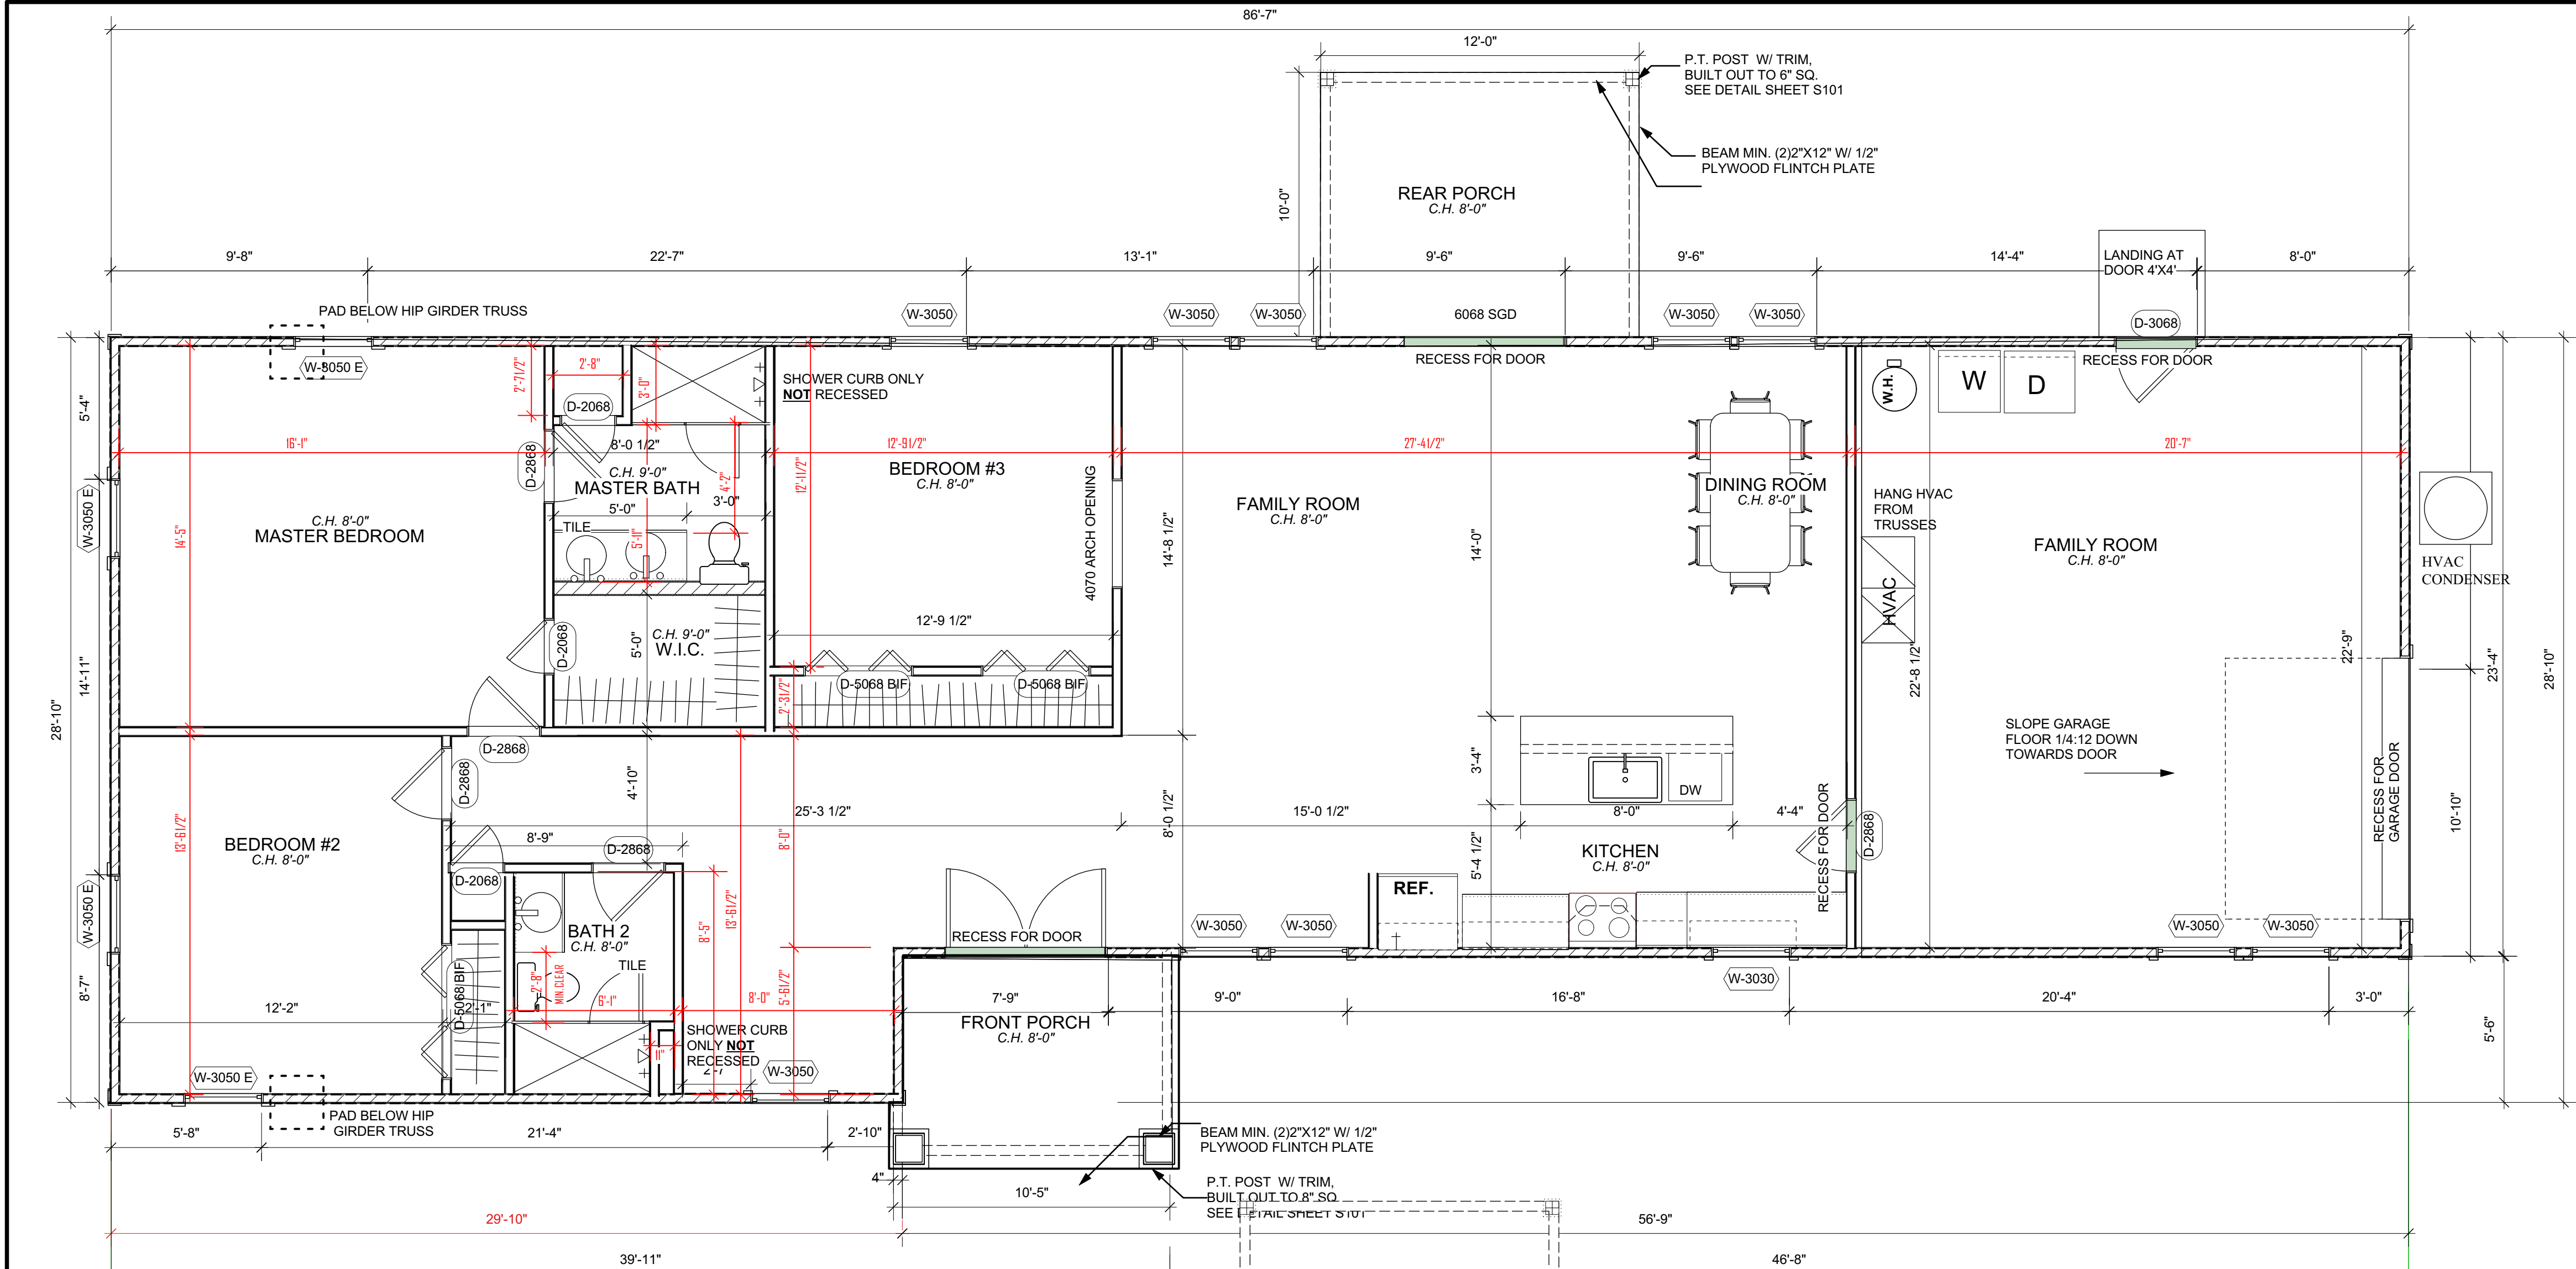

4 RAISED BAR DETAIL
Scale: 1/2" = 1'-0"

GENERAL CONSTRUCTION NOTES


- A. ALL DIMENSIONS ARE TO THE FACE OF STUD UNLESS NOTED OTHERWISE.
- B. FIELD VERIFY ALL DIMENSIONS.
- C. PROVIDE 2X4 BLOCKING BEHIND ALL WALL MOUNTED CABINETS.
- D. PROVIDE MOISTURE RESISTANT GYPSUM BOARD OR CEMENT BOARD, BEHIND ALL SINKS AND IN WET AREAS.
- E. COORDINATE INTERIOR FINISHES WITH OWNER
- F. ALL GROUND FLOOR PLANS SHALL BE 8' CEILING UNLESS OTHERWISE NOTED.
- G. PROVIDE R-30 (MIN.) INSULATION ABOVE CEILING, IN ATTIC. PROVIDE R-13 INSULATION @ ALL WOOD FRAME WALLS
- H. FIELD VERIFY ALL CABINETS DIMENSIONS BEFORE MANUFACTURING.

BUILDING AREA	
LIVING AREA	1689
GARAGE	492
FRONT PORCH	72
REAR PORCH	120
TOTAL	2373

FLORIDA RESIDENTIAL CODE 7TH EDITION 2020 EDITION WITH UPDATES.	
OCCUPANCY CLASS RESIDENTIAL R3	
TYPE OF CONSTRUCTION V-B	
UNPROTECTED UNSPRINKLED	

WALL SCHEDULE

- LOAD BEARING INTERIOR WALL
- PARTITION WALL
- 6" INTERIOR WALL
- LOAD BEARING EXTERIOR WALL

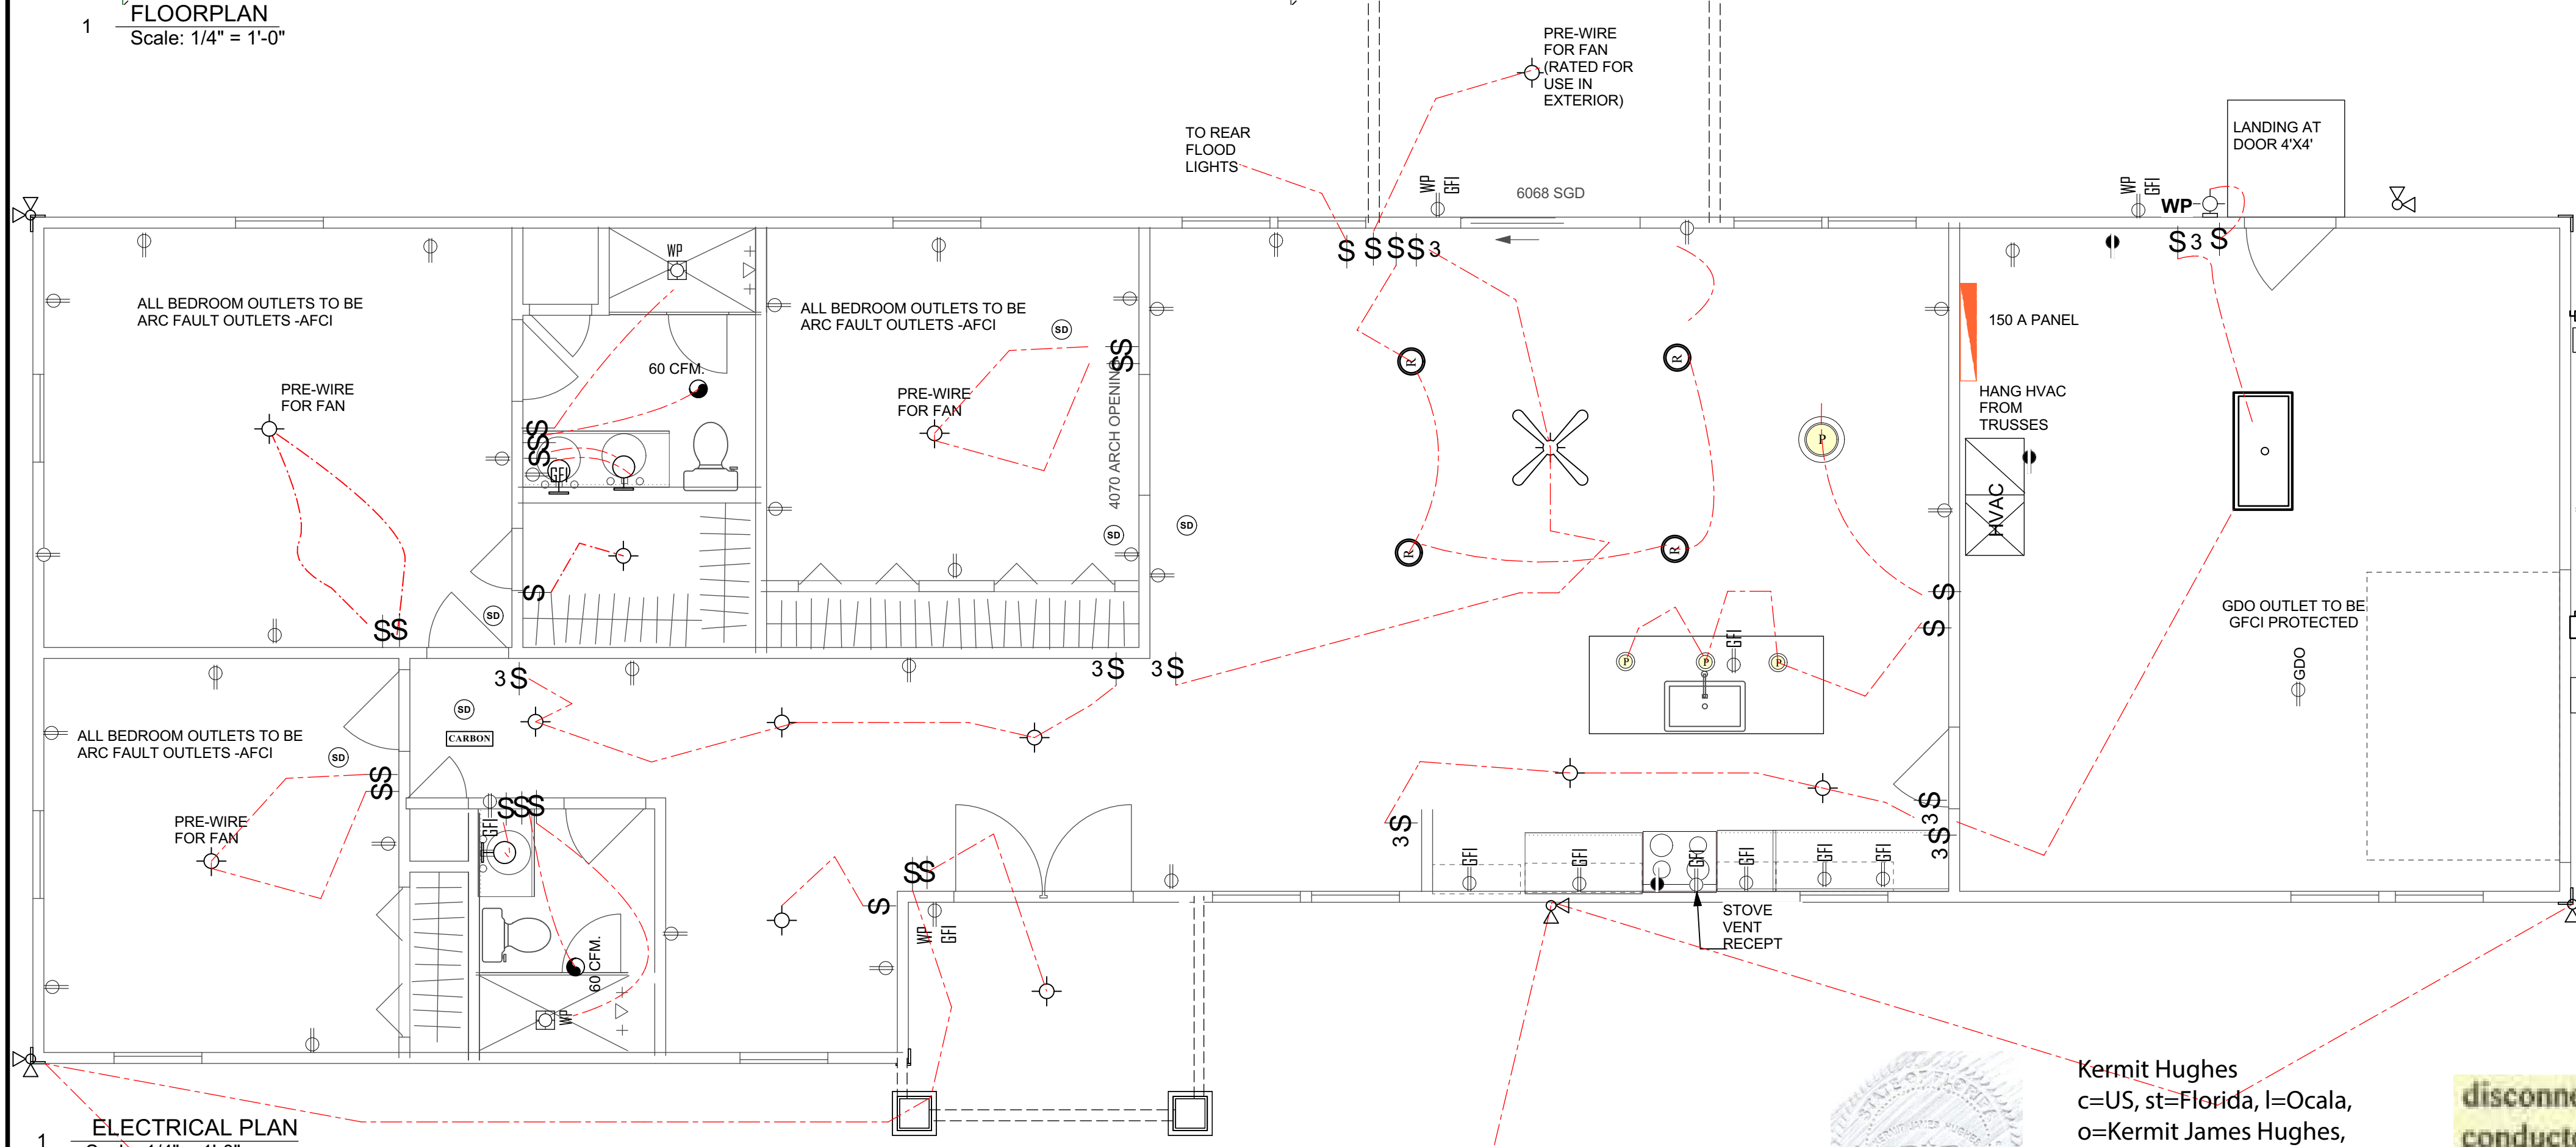

ELECTRICAL LEGEND

SYMBOL	DESCRIPTION	SYMBOL	DESCRIPTION
WP	WALL MOUNTED LIGHT, STYLE BY OWNER		DUPLEX FLOOR RECEPTACLE COORDINATE LOCATION IN FIELD
	MOISTURE RESISTANT EXTERIOR GRADE WALL MOUNTED LIGHT, STYLE BY OWNER		110 DUPLEX RECEPTACLE MOUNTED 18" A.F.F.
	DECORATIVE WALL SCONCE, STYLE BY OWNER		220 DUPLEX RECEPTACLE
	WALL MOUNTED LIGHT		110 RECEPTACLE GROUND FAULT
	EXTERIOR FLOOD LIGHT		110 RECEPTACLE GROUND FAULT AND WATER PROOF.
	DIRECTIONAL RECESSED CAN LIGHT		110 RECEPTACLE W/GROUND FAULT MOUNTED 48" AFF
	RECESSED CAN		110 RECEPTACLE CEILING MOUNTED FOR GARAGE DOOR OPENER
	SMALL PENDANT LIGHT		SWITCHED RECEPT MOUNTED IN EXTERIOR SOFFIT
	CHANDELIER /PENDANT LIGHT		TELEPHONE/DATA OUTLET
	WATER PROOF CAN LIGHT		SWITCH
	CEILING FAN WITH LIGHT KIT, STYLE BY OWNER		3 WAY SWITCH
	12"x48" FLUORESCENT LIGHT		EXHAUST FAN 50 CFM UNLESS NOTED OTHERWISE
	24"x48" FLUORESCENT LIGHT		CABLE OUTLET, COORDINATE LOCATION AND AMOUNT W/ OWNER.
	12"x24" FLUORESCENT LIGHT		SMOKE DETECTOR
	SMALL FLUORESCENT UNDER CABINET LIGHT		A/C DISCONNECT
	CARBON MONOXIDE DETECTOR		MAIN DISCONNECT
			JUNCTION BOX
			METER
			PANEL BOX

conductors used from the exterior disconnecting means to a panel or sub panel shall have four-wire conductors, of which one conductor shall be used as an equipment ground. Indicate if the utility company service entrance cable will be of the overhead or underground type.

THESE PLANS ARE NOT TO BE REVISED, REPRODUCED OR DUPLICATED IN ANY WAY WITHOUT WRITTEN CONSENT OF KERMIT HUGHES ARCHITECT. ANY REVISIONS OF THESE PLANS WITHOUT WRITTEN CONSENT OF KERMIT HUGHES ARCHITECT SHALL ENDEAVOR TO BE THE PROPERTY OF KERMIT HUGHES ARCHITECT.

DATE ISSUED	08-15-2022
REVISED	

DRAWN BY: KERMIT
APPROVED BY: KERMIT

FLOOR PLAN/ ELECTRICAL
FLOOR PLAN NOTES/ELECTRICAL PLAN

JBCM
IRMA MODEL
LAKE CITY FLORIDA

KERMIT HUGHES
ARCHITECT

971 NE 71ST LN OCALA, FL 34479
TELEPHONE (352)875-3461
E-MAIL kermithughesarchitect@gmail.com

AR92098

SHEET NO.
A100
1 OF 4