


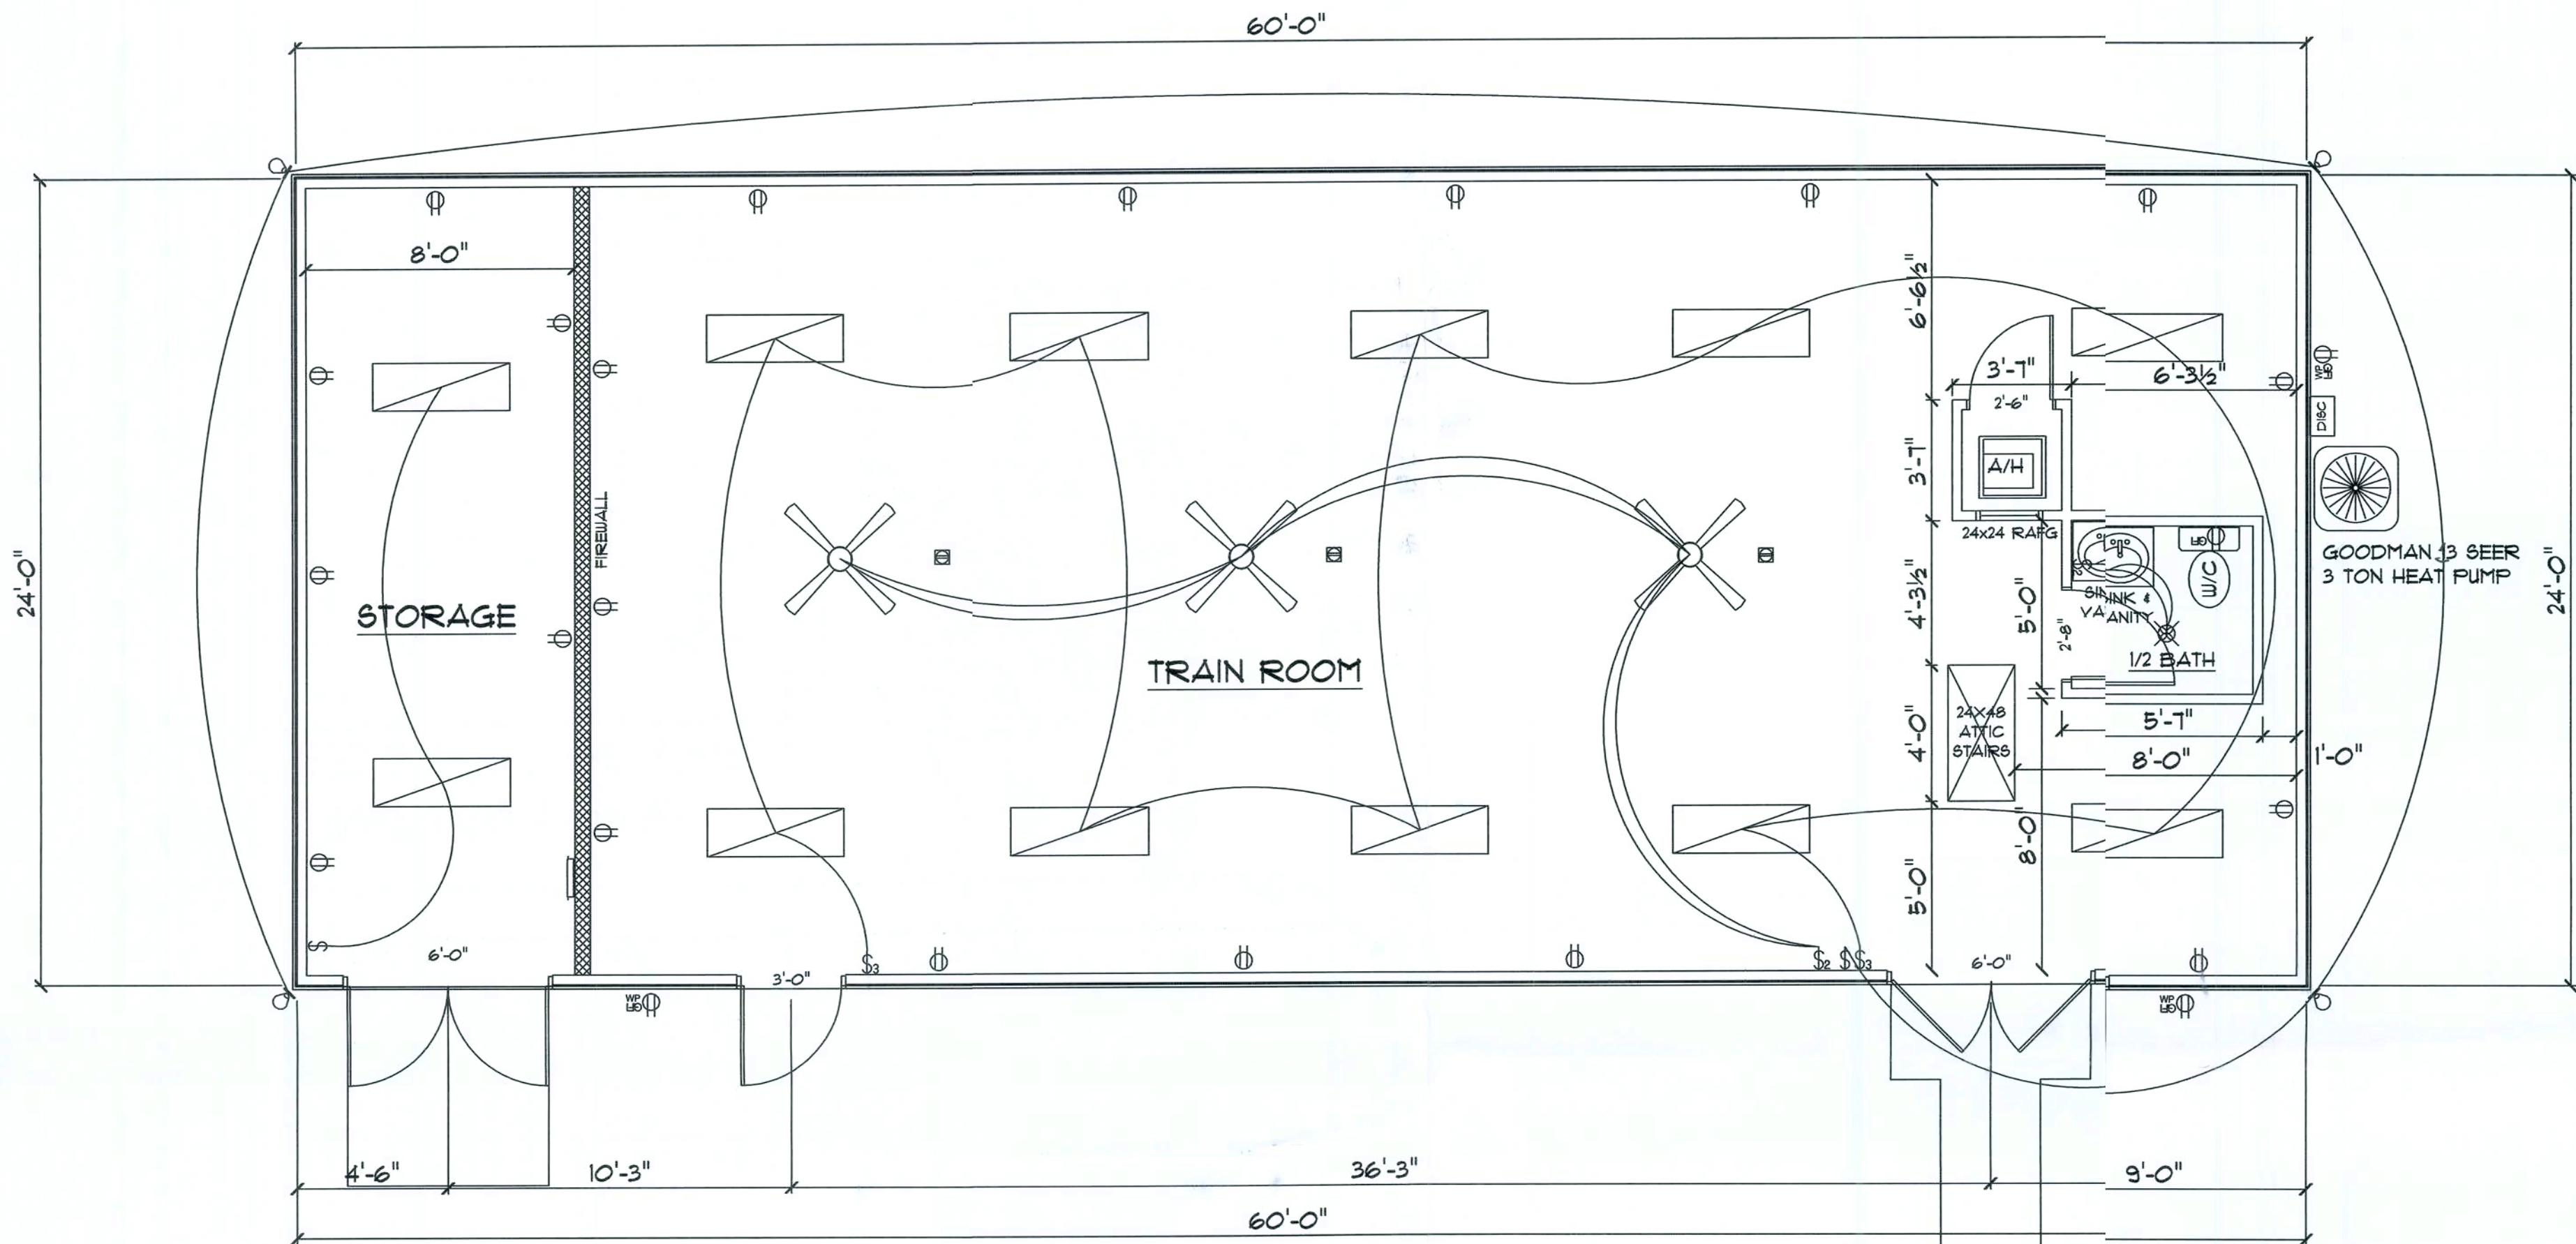

ELECTRICAL LEGEND

ELECTRICAL	COUNT	SYMBOL
future ceiling fan	3	
ceiling lamp large	12	
fan light combo	1	
single spotlight	4	
100 amp electrical panel	1	
outlet wp	3	
outlet	20	
outlet floor	3	
outlet gfi	1	
switch	2	
switch 3 way	2	
switch double	2	

NOTE:

1. OUTLET LOCATED IN BATH SHALL BE A MINIMUM OF 4'-0" A.F.F.
2. ALL OTHER OUTLETS SHALL BE A MINIMUM OF 12" A.F. UNLESS OTHERWISE SPECIFIED.
3. PLACE SWITCH PLATES A MINIMUM OF 2 1/2" FROM DOR TRIM
4. ALL PHONE/MULTIMEDIA OUTLETS SHALL BE PLACED PER OWNER
5. SMOKE ALARMS SHALL BE BATTERY OPERATED AND HARDWIRED INTO THE ELECTRICAL SYSTEM (ONE CIRCUIT CONNECTION TO PANEL) OR TO BE PLUG-IN LARM
6. TOILET ROOMS AND BATHROOMS REQUIRE OUTDOOR VENTILATION AREA-50 CFM (INTERMITTENT) OR 20 CM (CONTINUOUS)
7. LOCATE ADDITIONAL OUTLETS AND FLOOR OUTLETS PER OWNER

AREA TABULATION

TRAIN ROOM AREA:	1,230 SF
STORAGE AREA:	210 SF
TOTAL PROJECT AREA:	1,440 SF

OPENING SCHEDULE


PRODUCT CODE	SIZE	COUNT
36X80 STEEL EXTERIOR	3'-0"	1
12X80 STEEL EXTERIOR	6'-0"	2
30X80 COLONIAL A 1	2'-6"	1
32X80 COLONIAL A 1	2'-8"	1
24x24 RAFG	2'-0" x 2'-0"	1

HE IS THE
CHIEF
CORNERSTONE

SKY DESIGNS
January S. Jernigan
115 5th John Street
Live Oak, FL 32064
Phone: 386-208-1340
E-Mail: skydesigns@att.net

A PROJECT FOR:
DOMINGO MAGNATTI

GTC DESIGN GROUP
Gary Gill, P.E.
License# 12474
130 West Howard Street
Live Oak, FL 32064
Phone: 386-362-3618

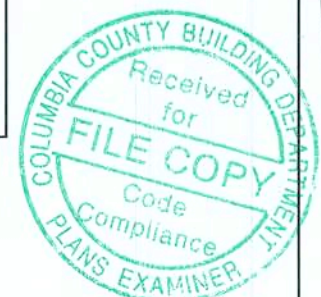

FLOOR PLAN
ELECTRICAL PLAN


Date: 8/2008

Sheet Number:

1

Drawn By: JBJ

Scale: 1/4" = 1'

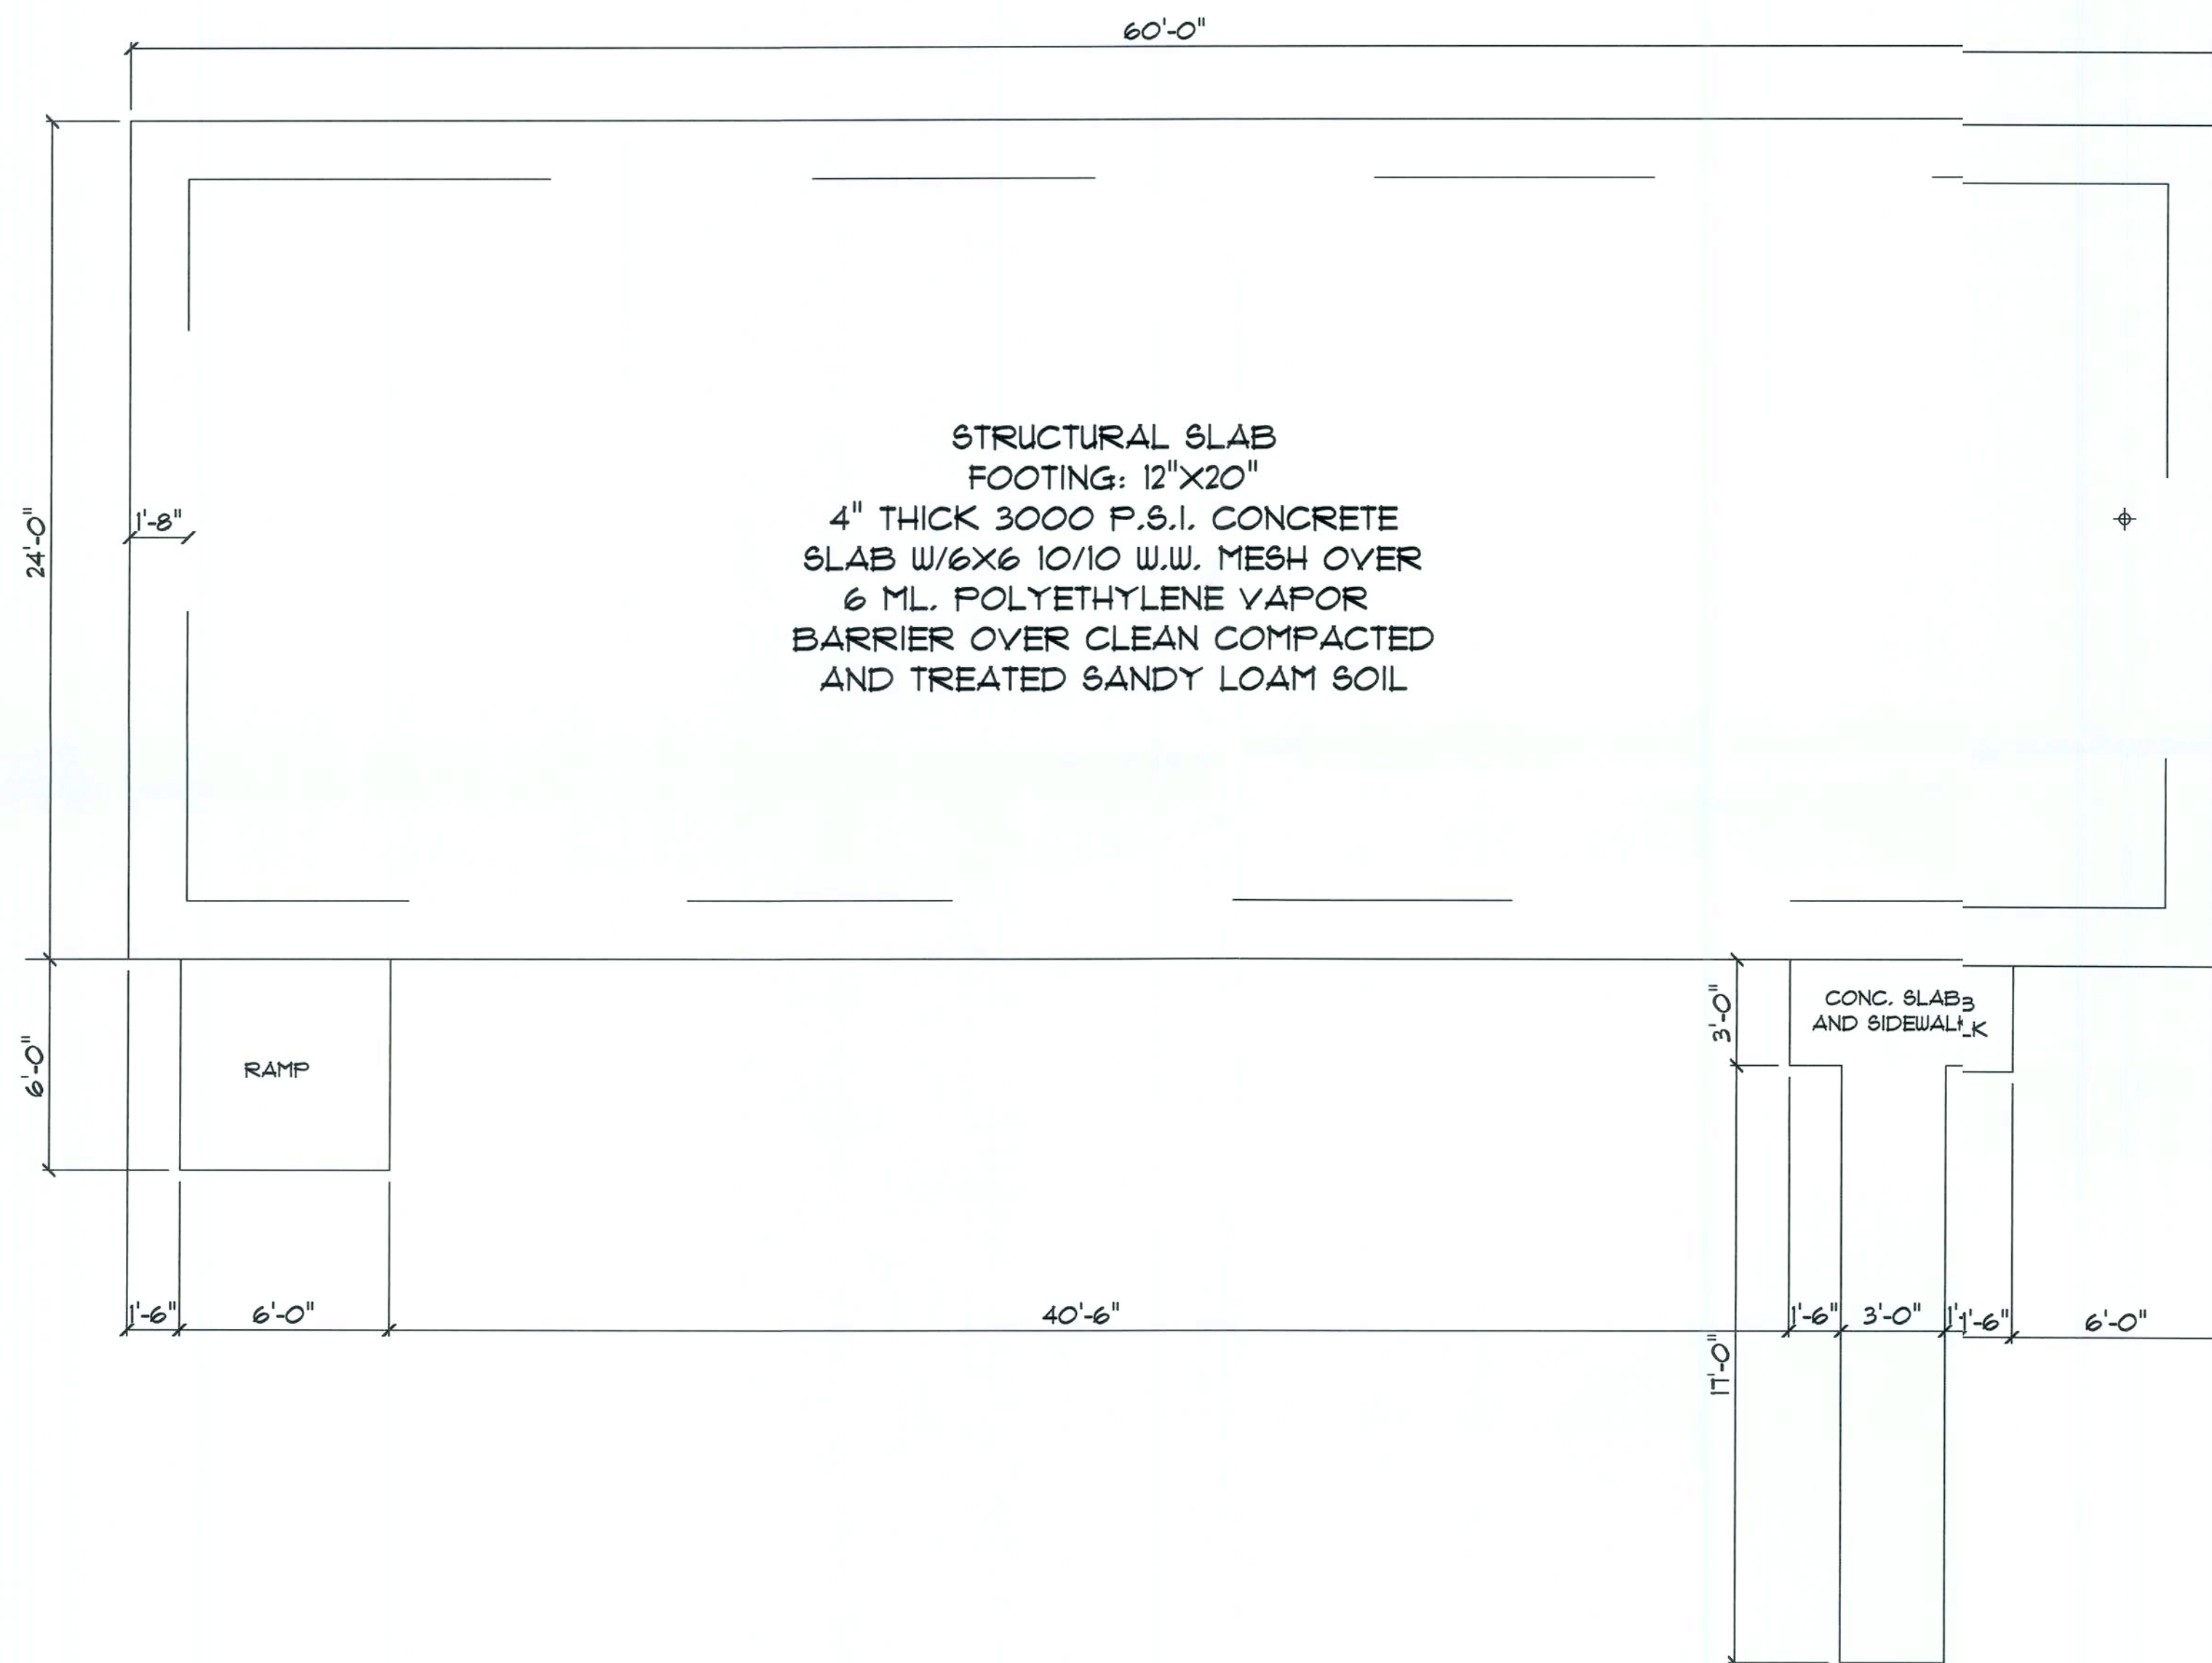

HE IS THE
CHIEF
CORNERSTONE

SKY DESIGNS

January S. Jernigan
118 SW 2nd Street
Live Oak, FL 32064
Phone: 386-362-3240
E-Mail: skydesigns@aol.com

A PROJECT FOR:
DOMINGO MAGNATTI

GTC
DESIGN GROUP

Gary Gill, P.E.
Lic#151842 Auth#15461
150 West Howard Street
Live Oak, FL 32064
Phone: 386-362-3678

FOUNDATION PLAN


Date: 8/2008

Sheet Number:


2

Drawn By: JSJ


Scale: 1/4" = 1'

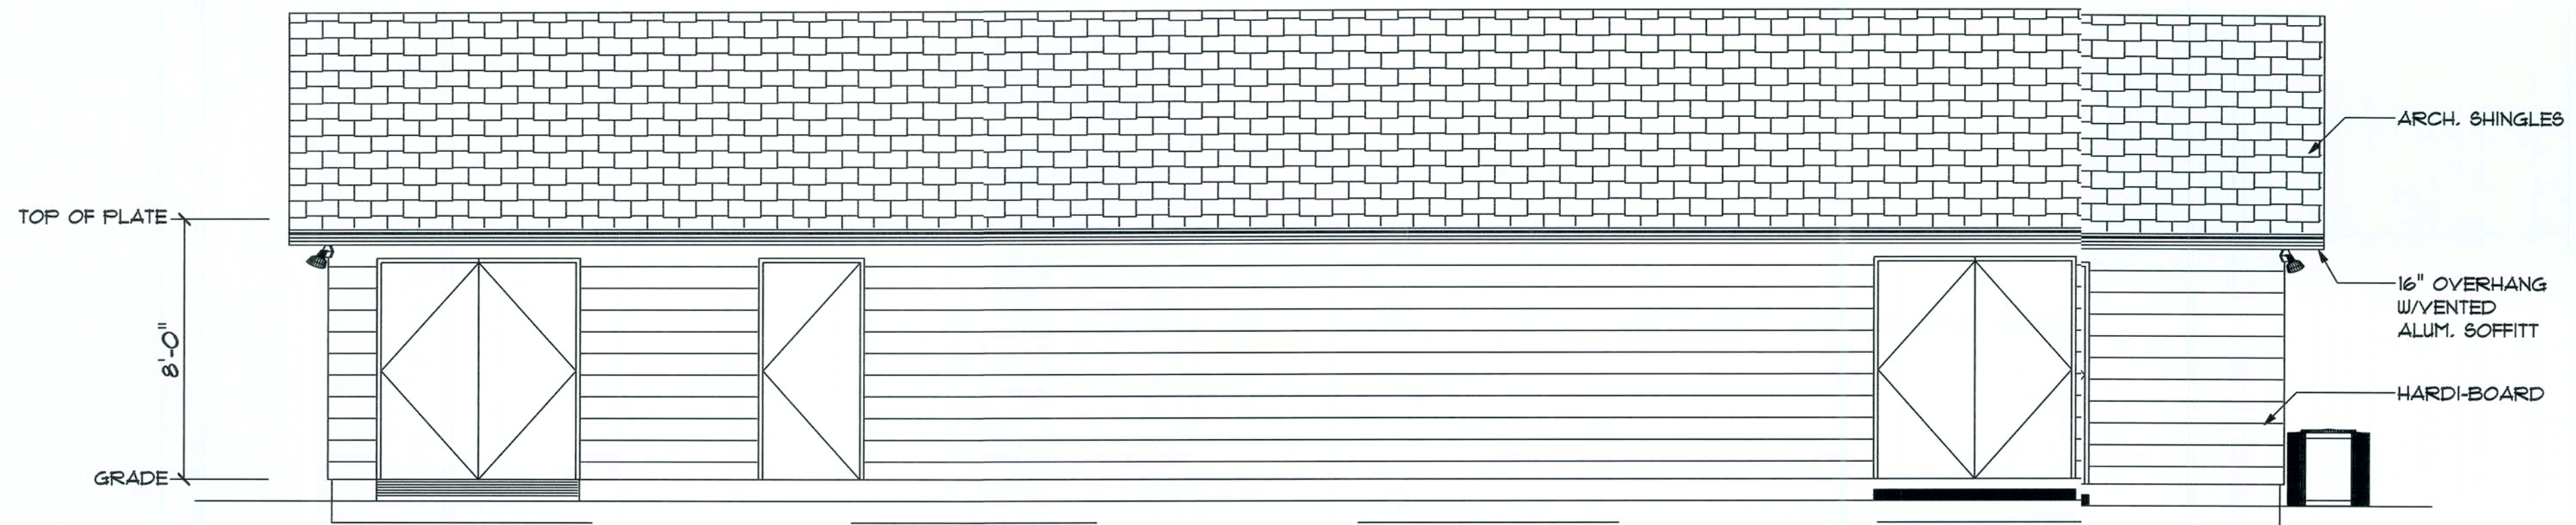


FRONT ELEVATION

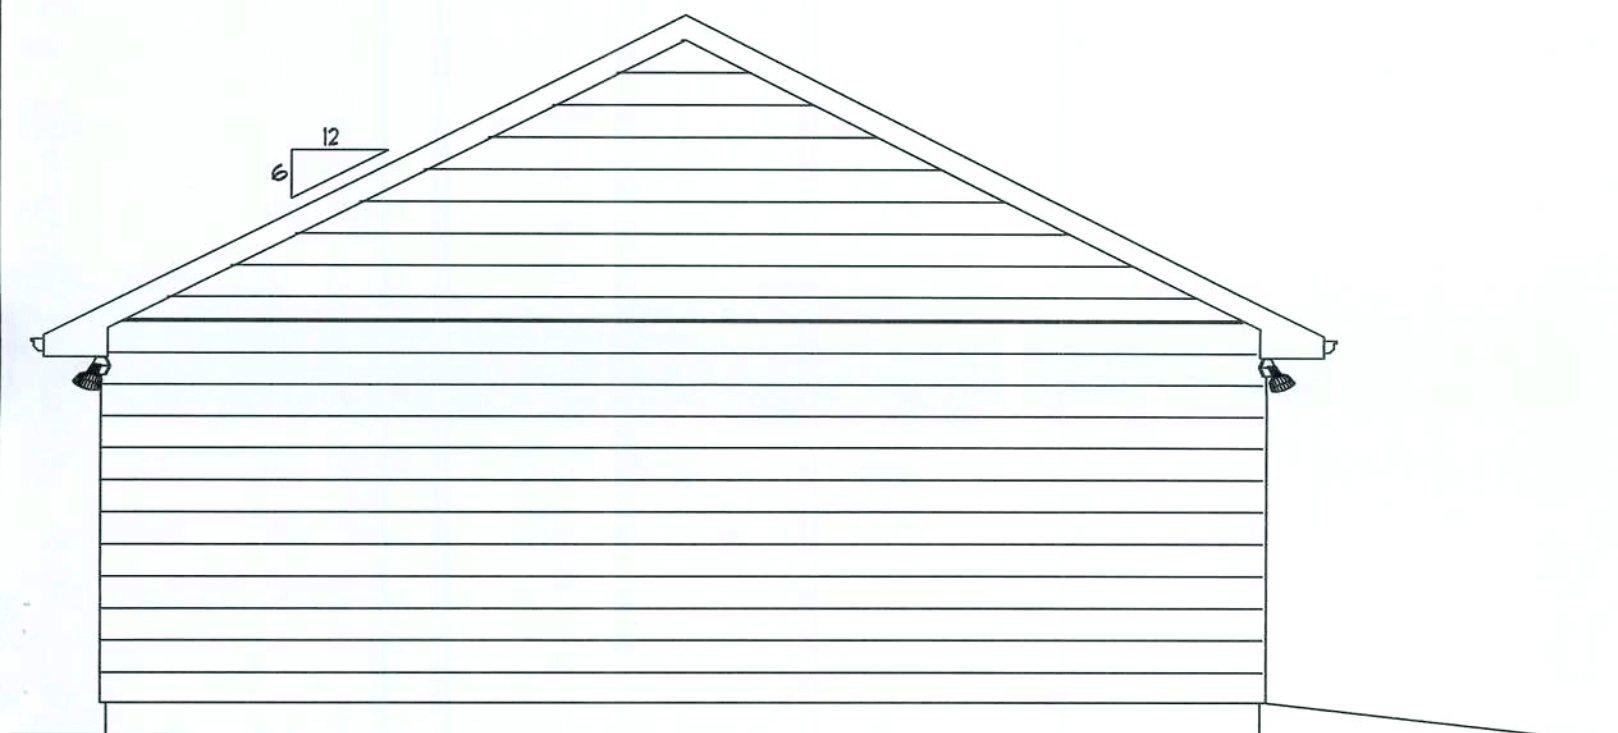

LEFT ELEVATION

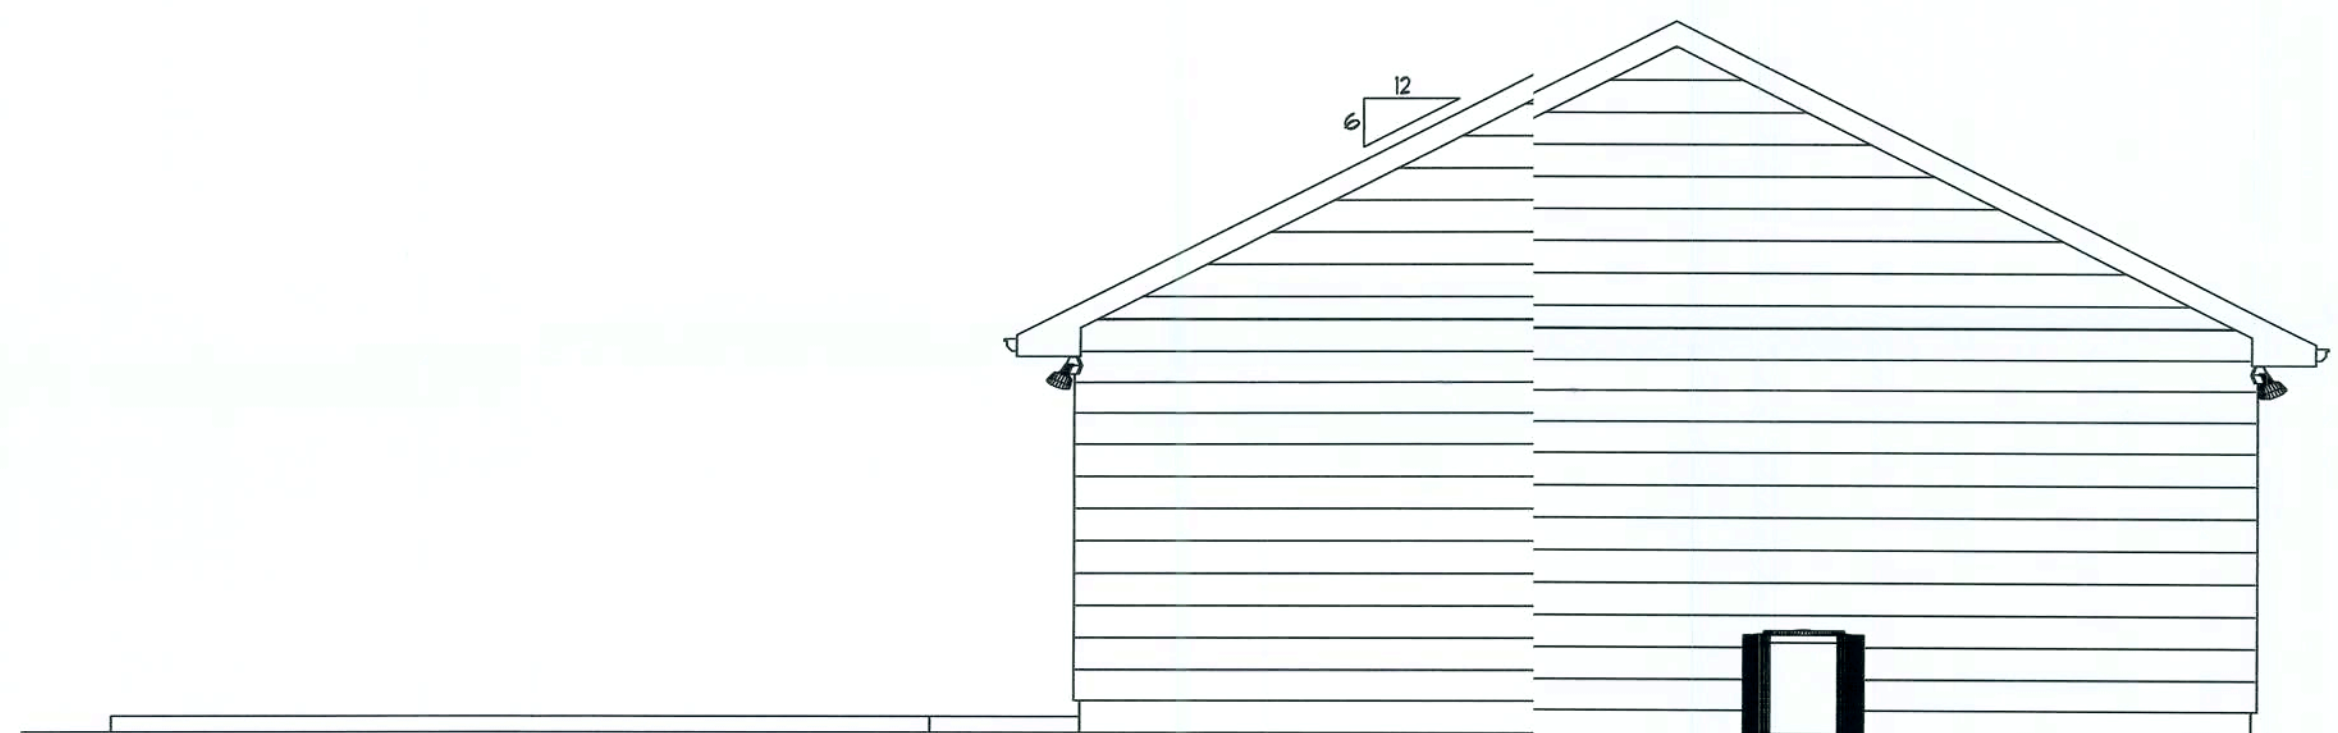

RIGHT ELEVATION

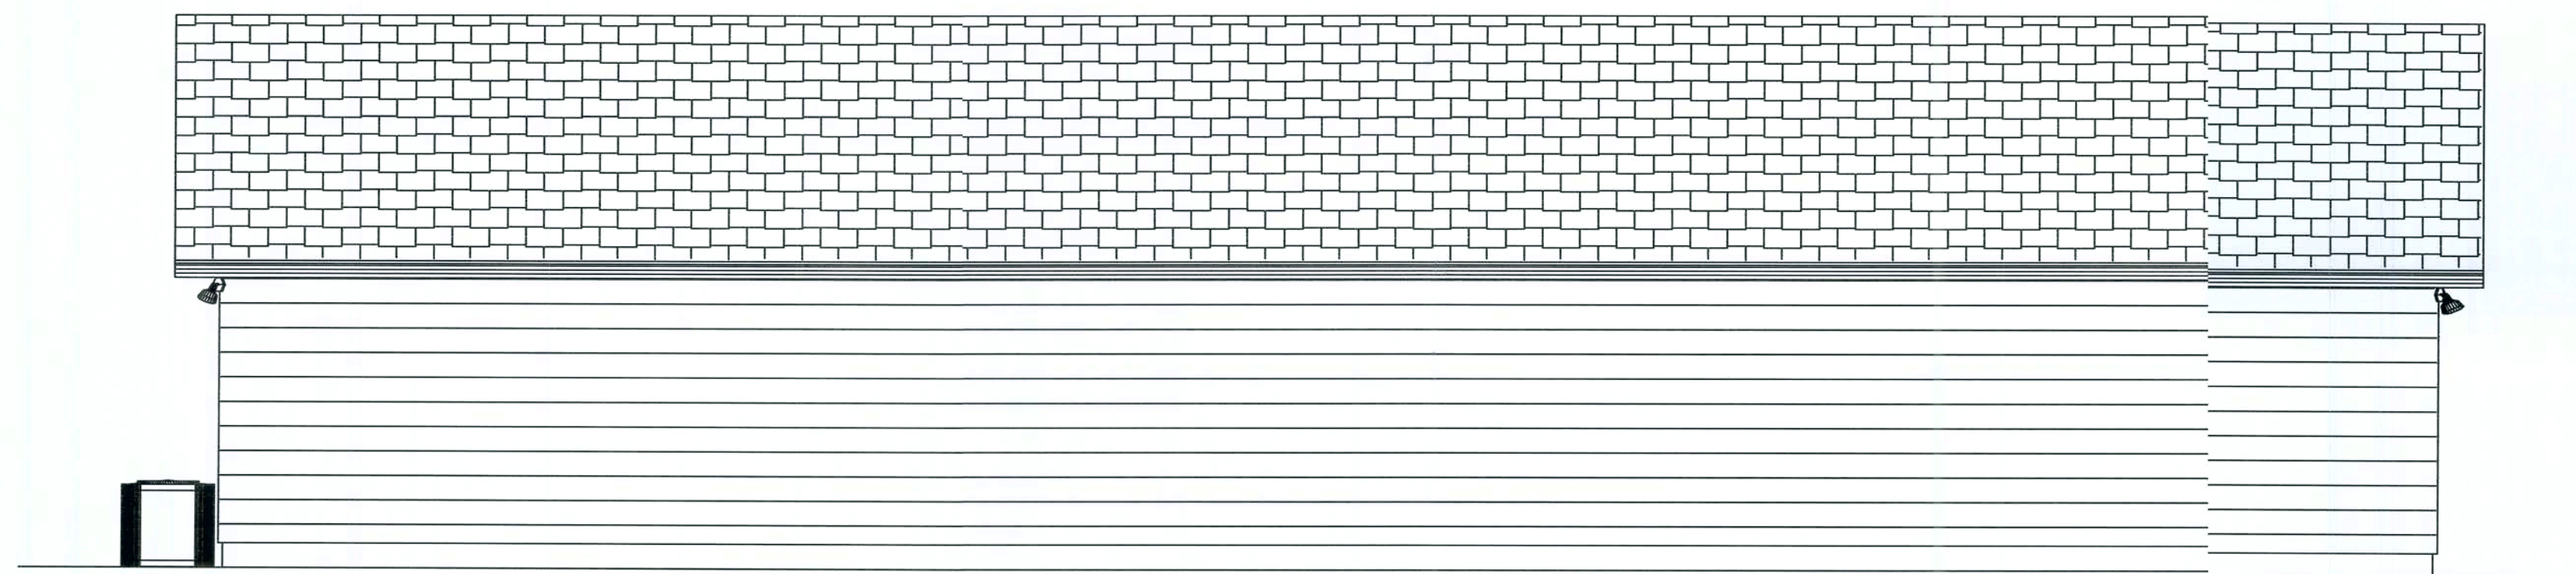

REAR ELEVATION

HE IS THE
CHIEF
CORNERSTONE

SKY DESIGNS
January S. Jernigan
119 8th John Street
Live Oak, FL 32064
Phone: 386-208-1340
E-Mail: skydesigns@att.net

A PROJECT FOR:
DOMINGO MAGNATTI

**GTC
DESIGN GROUP**
Gary Gill, P.E.
Lic#15842, Auth#1461
130 West Howard Street
Live Oak, FL 32064
Phone: 386-362-3678

ELEVATIONS
Date: 8/2008

Sheet Number:
3

Drawn By: JSJ
Scale: 1/4" = 1'

