




OCCUPANCY: AS PER TABLE 7.3.1.2			
USE	SQ.FT./PERSON	AREA (SQ.FT.)	OCCUPANTS
RESTAURANTS: (DINING AREAS)	15	2,200	147
MERCANTILE: (SALES AREA ON STREET)	30	2,300	77
STORAGE: (LOW HAZARD)	NR	1,200	NR
RESTAURANTS: KITCHENS	100	2,500	25
BUSINESS: (OTHER) GYMS & PLAYS	100	3,500	35
TOTAL OCCUPANCY			284

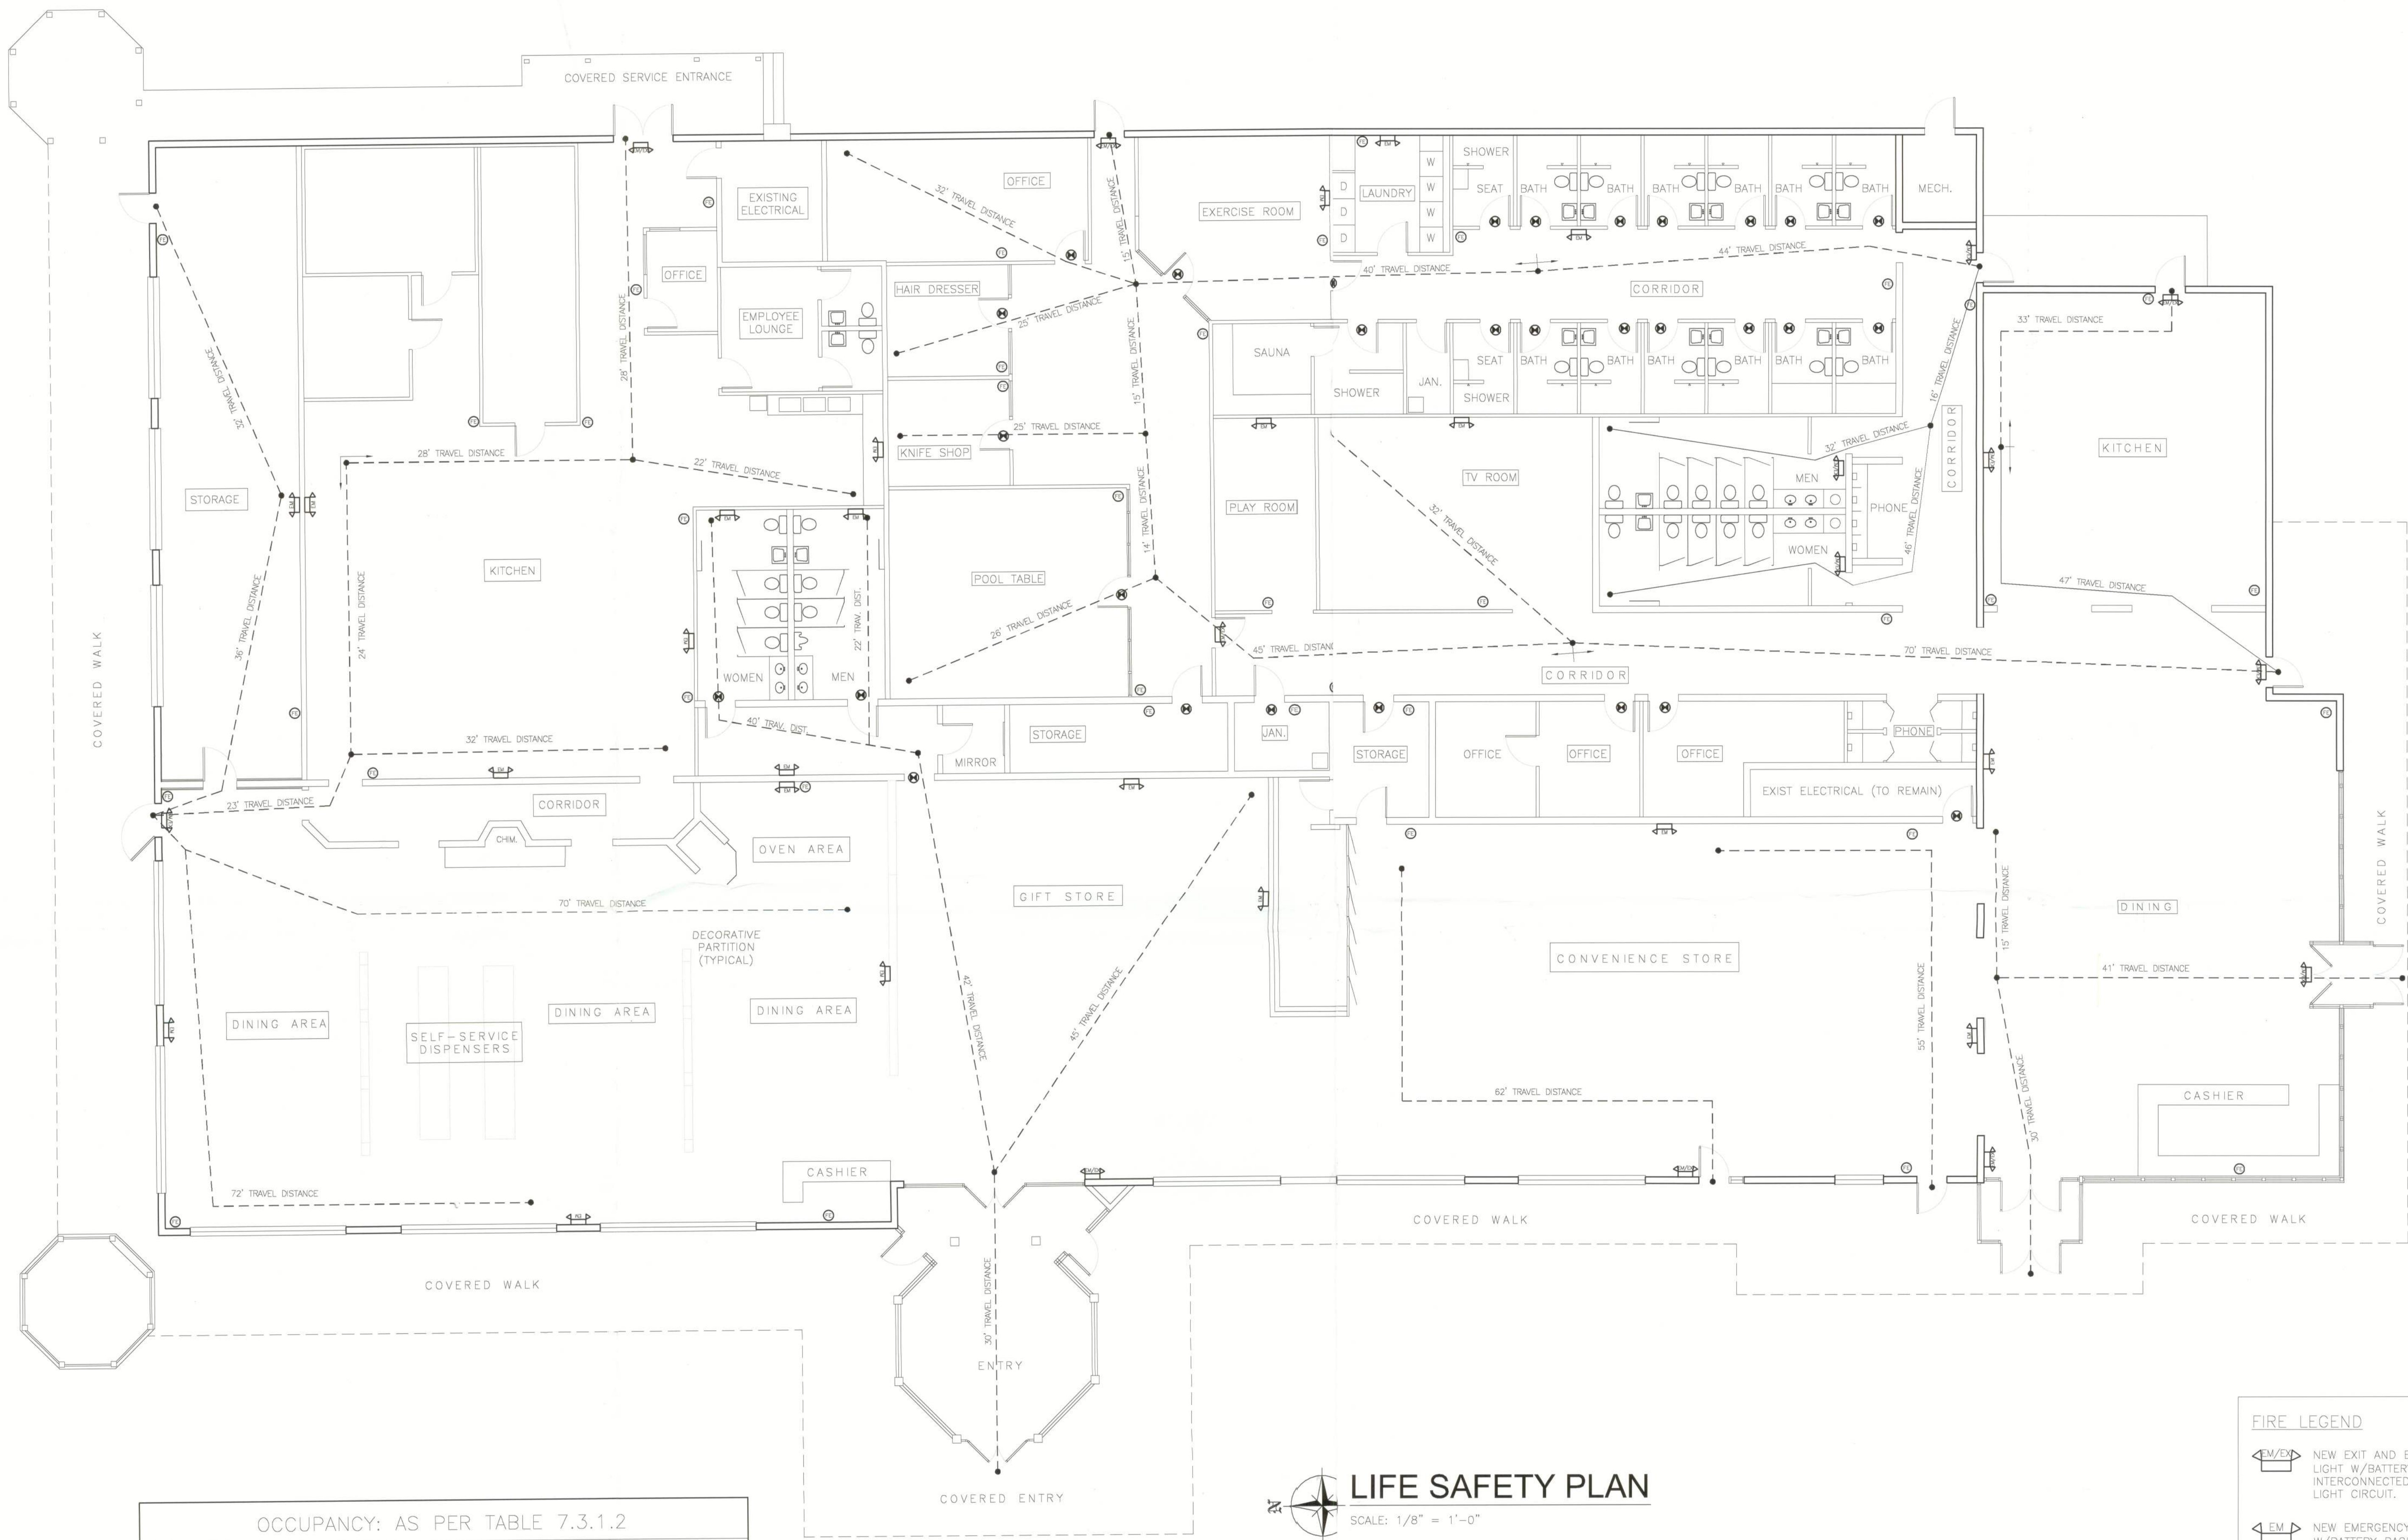

LIFE SAFETY PLAN

SCALE: 1/8" = 1'-0"

NFPA 101 TABLE A.7.6. TRAVEL DISTANCE LIMIT		
OCCUPANCY	WITHOUT SPRINKLER SYSTEM (feet)	WITH SPRINKLER SYSTEM (feet)
BUSINESS (EXISTING)	200	300
STORAGE (LOW HAZARD)	NR	NR


FIRE LEGEND

- NEW EXIT AND EMERGENCY LIGHT W/BATTERY BACK UP INTERCONNECTED TO NEAREST LIGHT CIRCUIT.
- NEW EMERGENCY LIGHT W/BATTERY BACK UP INTERCONNECTED TO NEAREST LIGHT CIRCUIT.
- ILLUMINATED EXIT SIGN INTERCONNECT WITH BATTERY BACKUP EM LIGHTING.
- NEW FIRE EXTINGUISHER.
- TRAVEL DISTANCE

*NON SPRINKLED BUILDING
*NON FIRE ALARM SYSTEM

REVISIONS	By
△	
△	
△	
△	

JOB NUMBER
12119

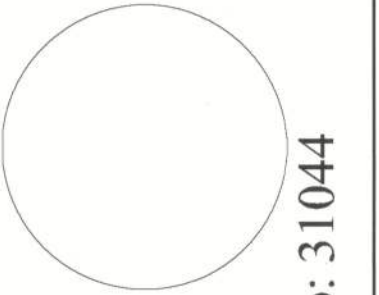

Freeman's Construction & Engineering Group Inc.
Phone: 786-337-0665 e-mail: freeman@nobelconstructions.com
14956 SW 34th Street, Miami Florida 33185
Professional Engineering P.E. No. 66341 CA LIC. No: 31044

LIFE SAFETY PLAN FOR:

TRUCK STOP

14197 S US HIGHWAY, LAKE CITY, FL 32024

ENGINEER IN RECORD:
EMILIANO OROZCO

DRAWING TITLE:

FLOOR PLAN
SAFETY PLAN
NOTES - TABLES

DRAWN: F.F.
CHECKED: E.O.
DATE: AUG.16
SCALE: AS SHOWN
JOB No.: FF-12019

sheet:

F-1

As shown and unless noted, all dimensions are in feet and inches. All dimensions shall be to the center of the object unless otherwise noted.