



NOTE:
ALL WORK SHALL COMPLY WITH LATEST GOVERNING CODES, LIFE SAFE CODES, ADA CODES, NEC CODES, AND ALL APPLICABLE CITY AND COUNTY CODES.
DIMENSIONS ON PLANS TO BE CONFIRMED IN FIELD. DETAIL DIMENSIONS SUPERSEDES SMALLER SCALE DRAWINGS.

ELECTRICAL NOTES
1.) ALL WORK SHALL BE IN ACCORDANCE WITH THE 2008 NEC AND ANY LOCAL CODES.
2.) ELECTRICAL CONTRACTOR SHALL COORDINATE WITH LOCAL UTILITY, H.V.A.C. & PLUMBING CONTRACTORS.

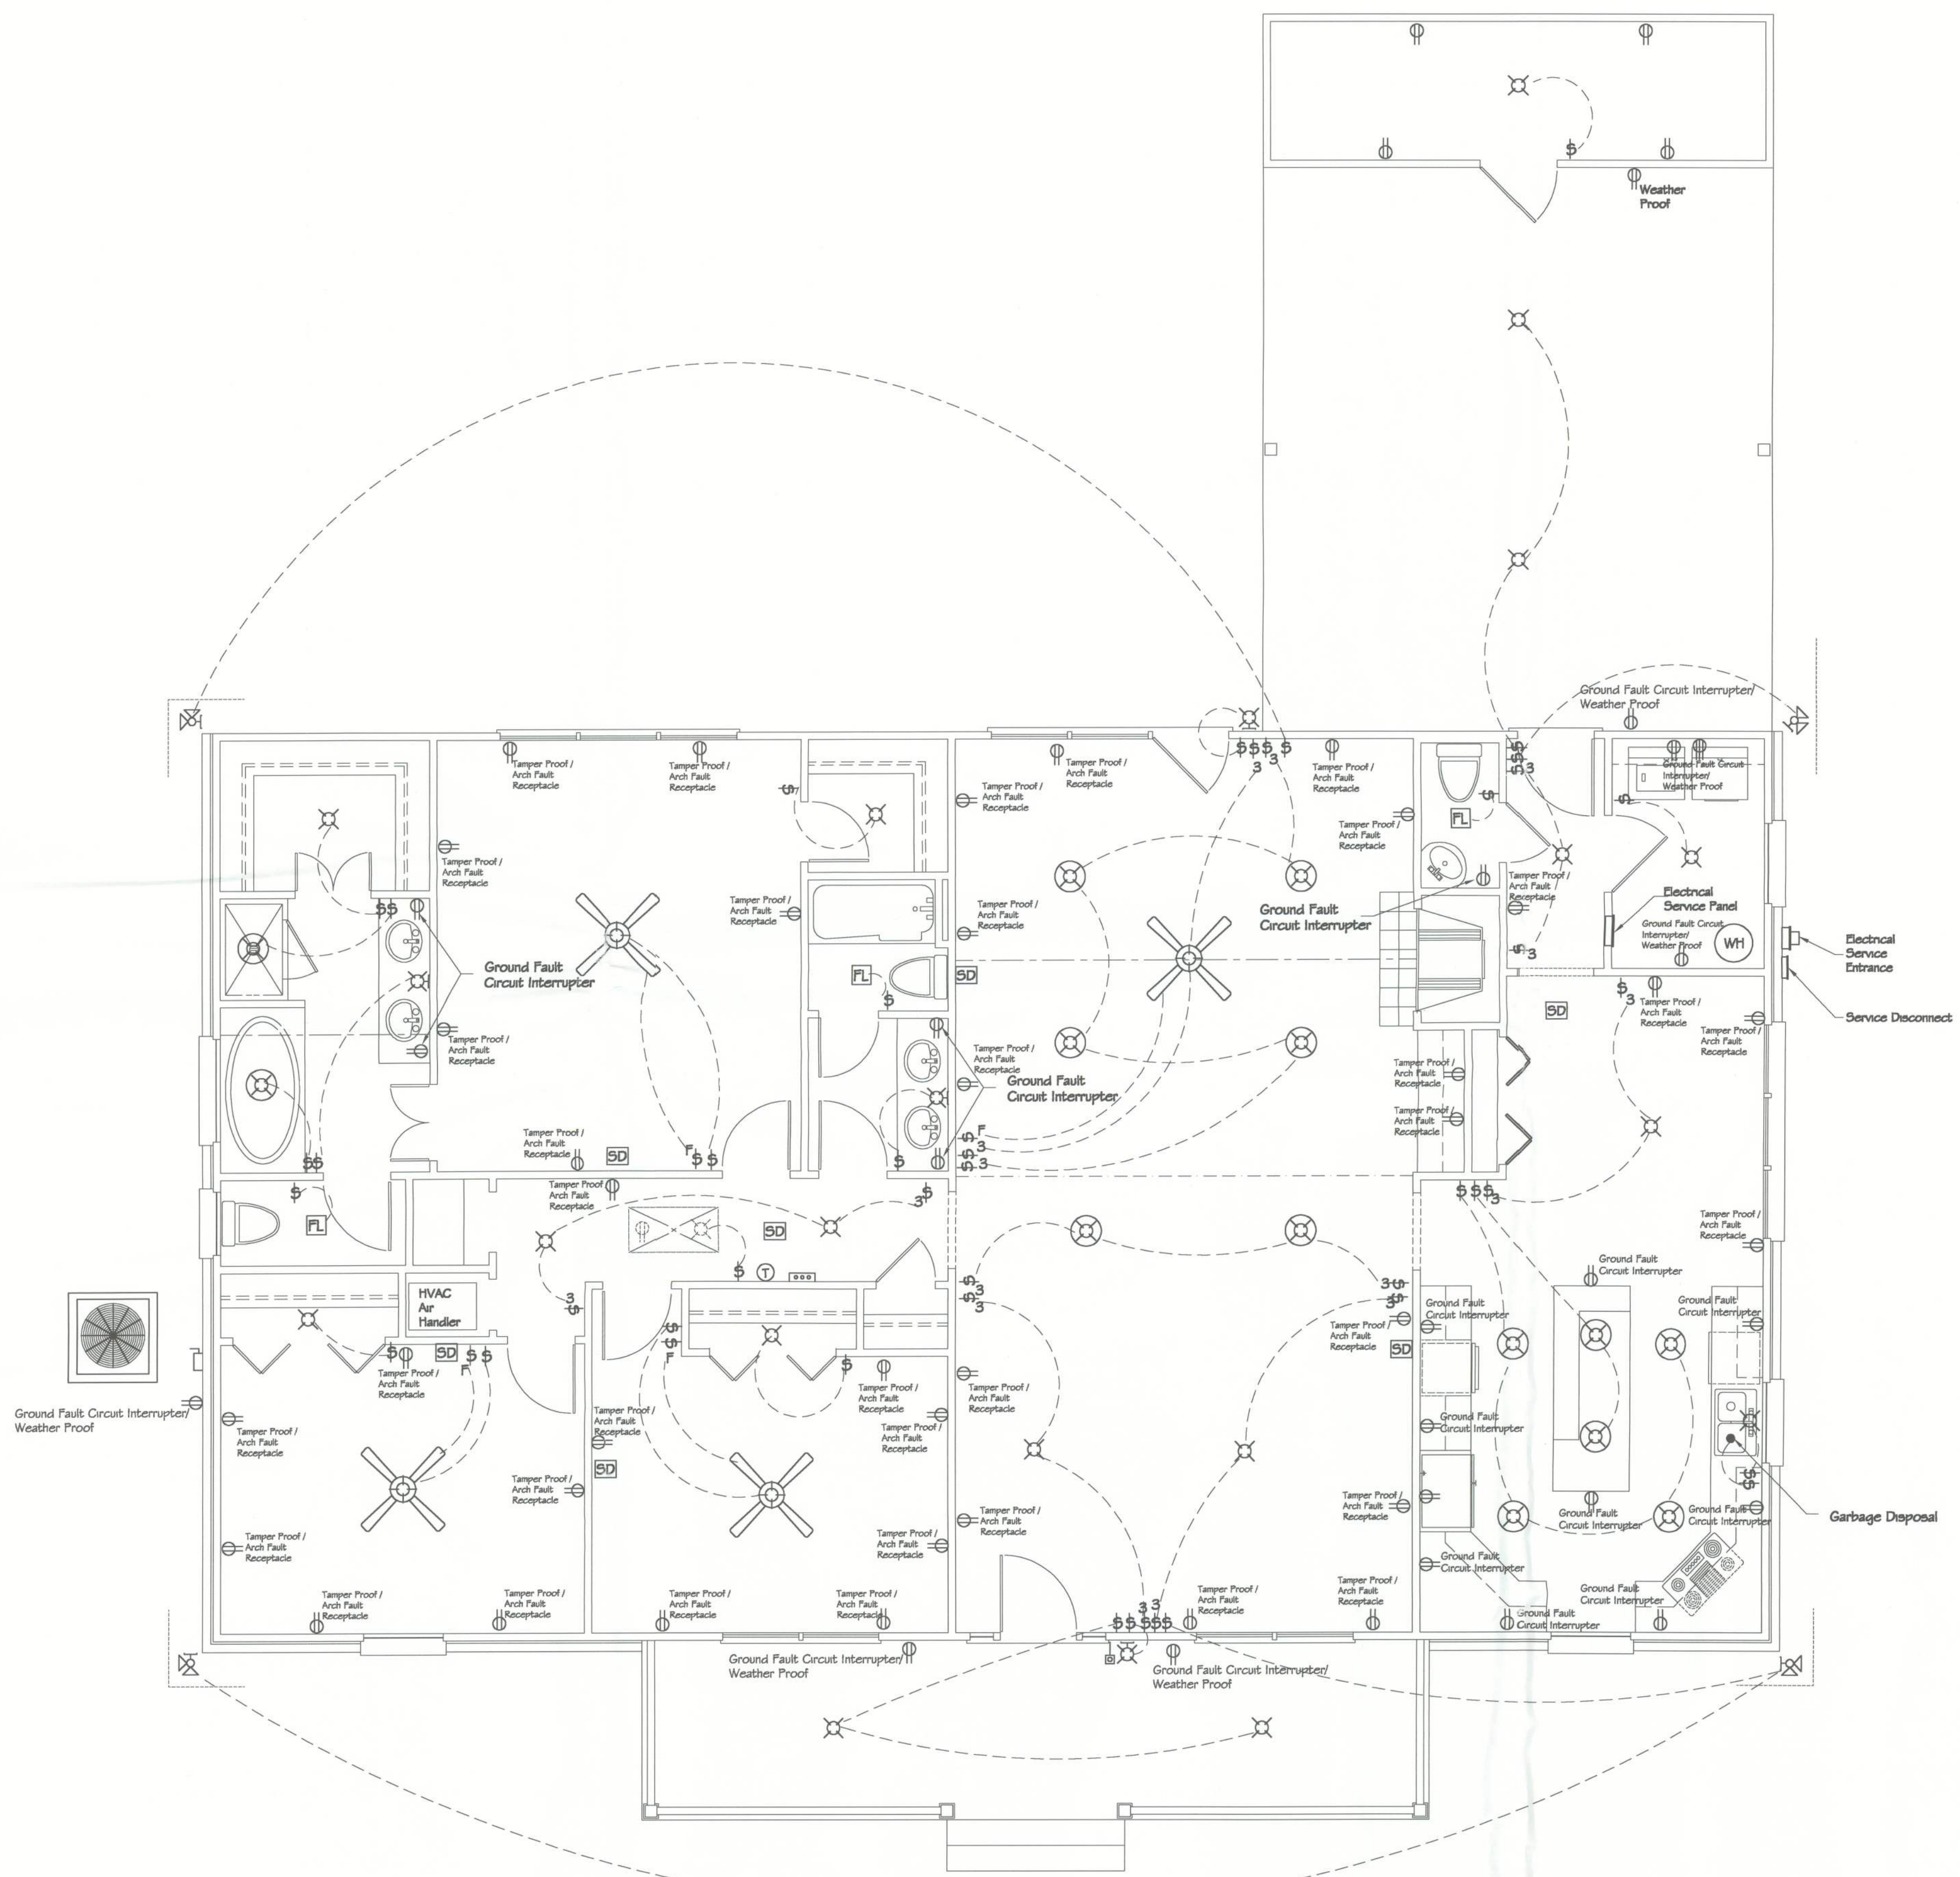

ELECTRICAL PLAN
SCALE: 1/4" = 1'-0"

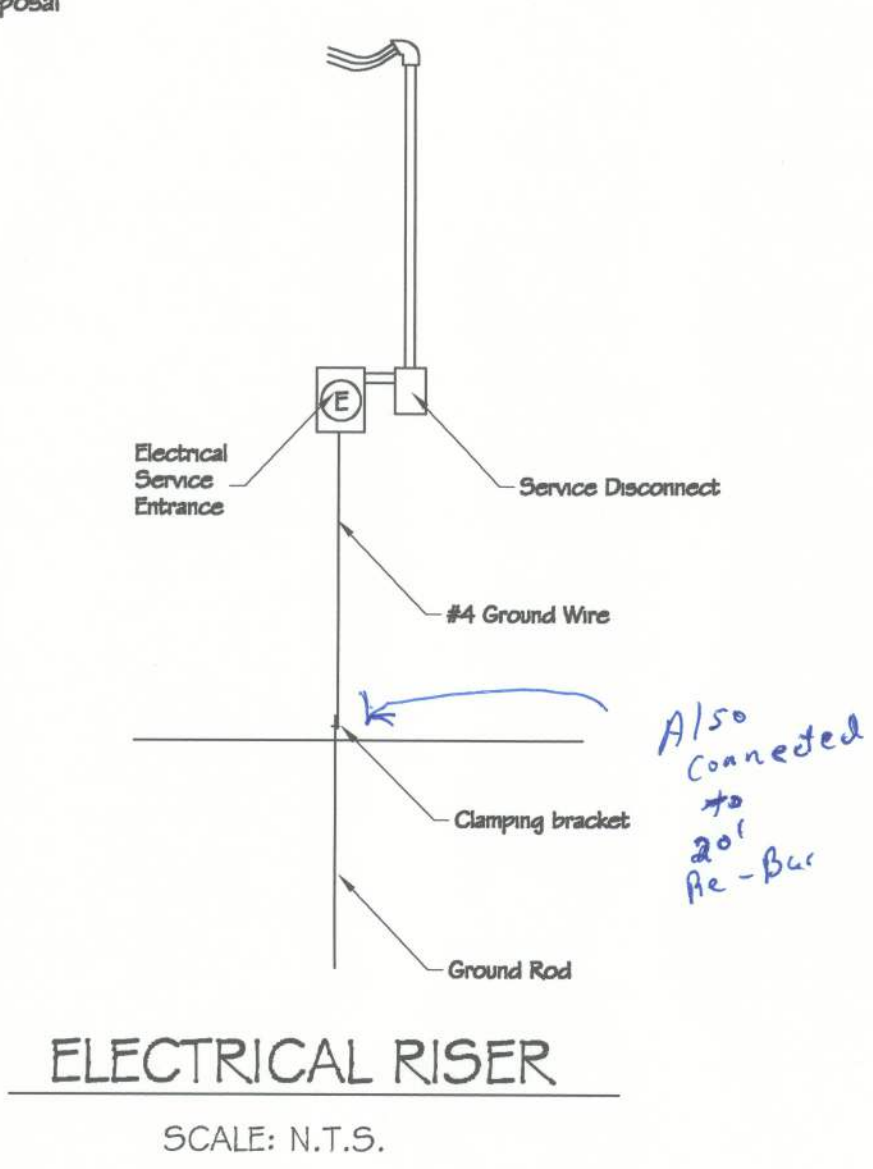

ELECTRICAL RISER
SCALE: N.T.S.

ELECTRICAL LEGEND		
1.	⌚	= SINGLE POLE SWITCH
2.	⌚ 3	= THREE-WAY SWITCH
3.	⌚ 4	= FOUR-WAY SWITCH
4.	⌚ D	= DIMMER LIGHT SWITCH
5.	⌚ F	= FAN CONTROL SWITCH
6.	⌚	= DUPLEX OUTLET 110 VOLT
7.	⌚ GFI	= GROUND FAULT INTERRUPTER OUTLET 110 VOLT
8.	⌚ W.P.	= WEATHERPROOF OUTLET 110 VOLT
9.	⌚	= 220 VOLT OUTLET
10.	⌚	= 110 VOLT FLOOR OUTLET
11.	⌚	= 110 VOLT CEILING OUTLET
12.	⌚	= 110 VOLT SWITCHED OUTLET
13.	⌚	= OVERHEAD LIGHT FIXTURE
14.	⌚	= WALL MOUNT LIGHT FIXTURE
15.	⌚	= PULL CHAIN LIGHT FIXTURE
16.	⌚	= 1' X 4' FLUORESCENT LIGHT FIXTURE
17.	⌚	= 1' X 8' FLUORESCENT LIGHT FIXTURE
18.	⌚	= 2' X 4' FLUORESCENT LIGHT FIXTURE
19.	⌚	= RECESSED CAN LIGHT FIXTURE
20.	⌚	= FLOOD LIGHT FIXTURE
21.	⌚	= SPOT LIGHT FIXTURE
22.	⌚	= EXHAUST FAN
23.	⌚	= CEILING FAN / LIGHT FIXTURE
24.	⌚	= CEILING FAN FIXTURE
25.	⌚	= FAN / LIGHT FIXTURE
26.	⌚	= FAN / LIGHT / HEATER FIXTURE
27.	⌚	= CHIMES
28.	⌚	= DOORBELL
29.	⌚	= SMOKE DETECTOR
30.	⌚	= THERMOSTAT
31.	⌚	= PANEL BOX 200 AMP
32.	⌚	= CABLE OUTLET BOX
33.	⌚	= WALL CLOCK
34.	⌚	= INTERCOM SYSTEM
35.	⌚	= TELEPHONE OUTLET
36.	⌚	= TELEVISION OUTLET