


200 AMP METER
OVERCURRENT PROTECTED
UNDERGROUND SERVICE

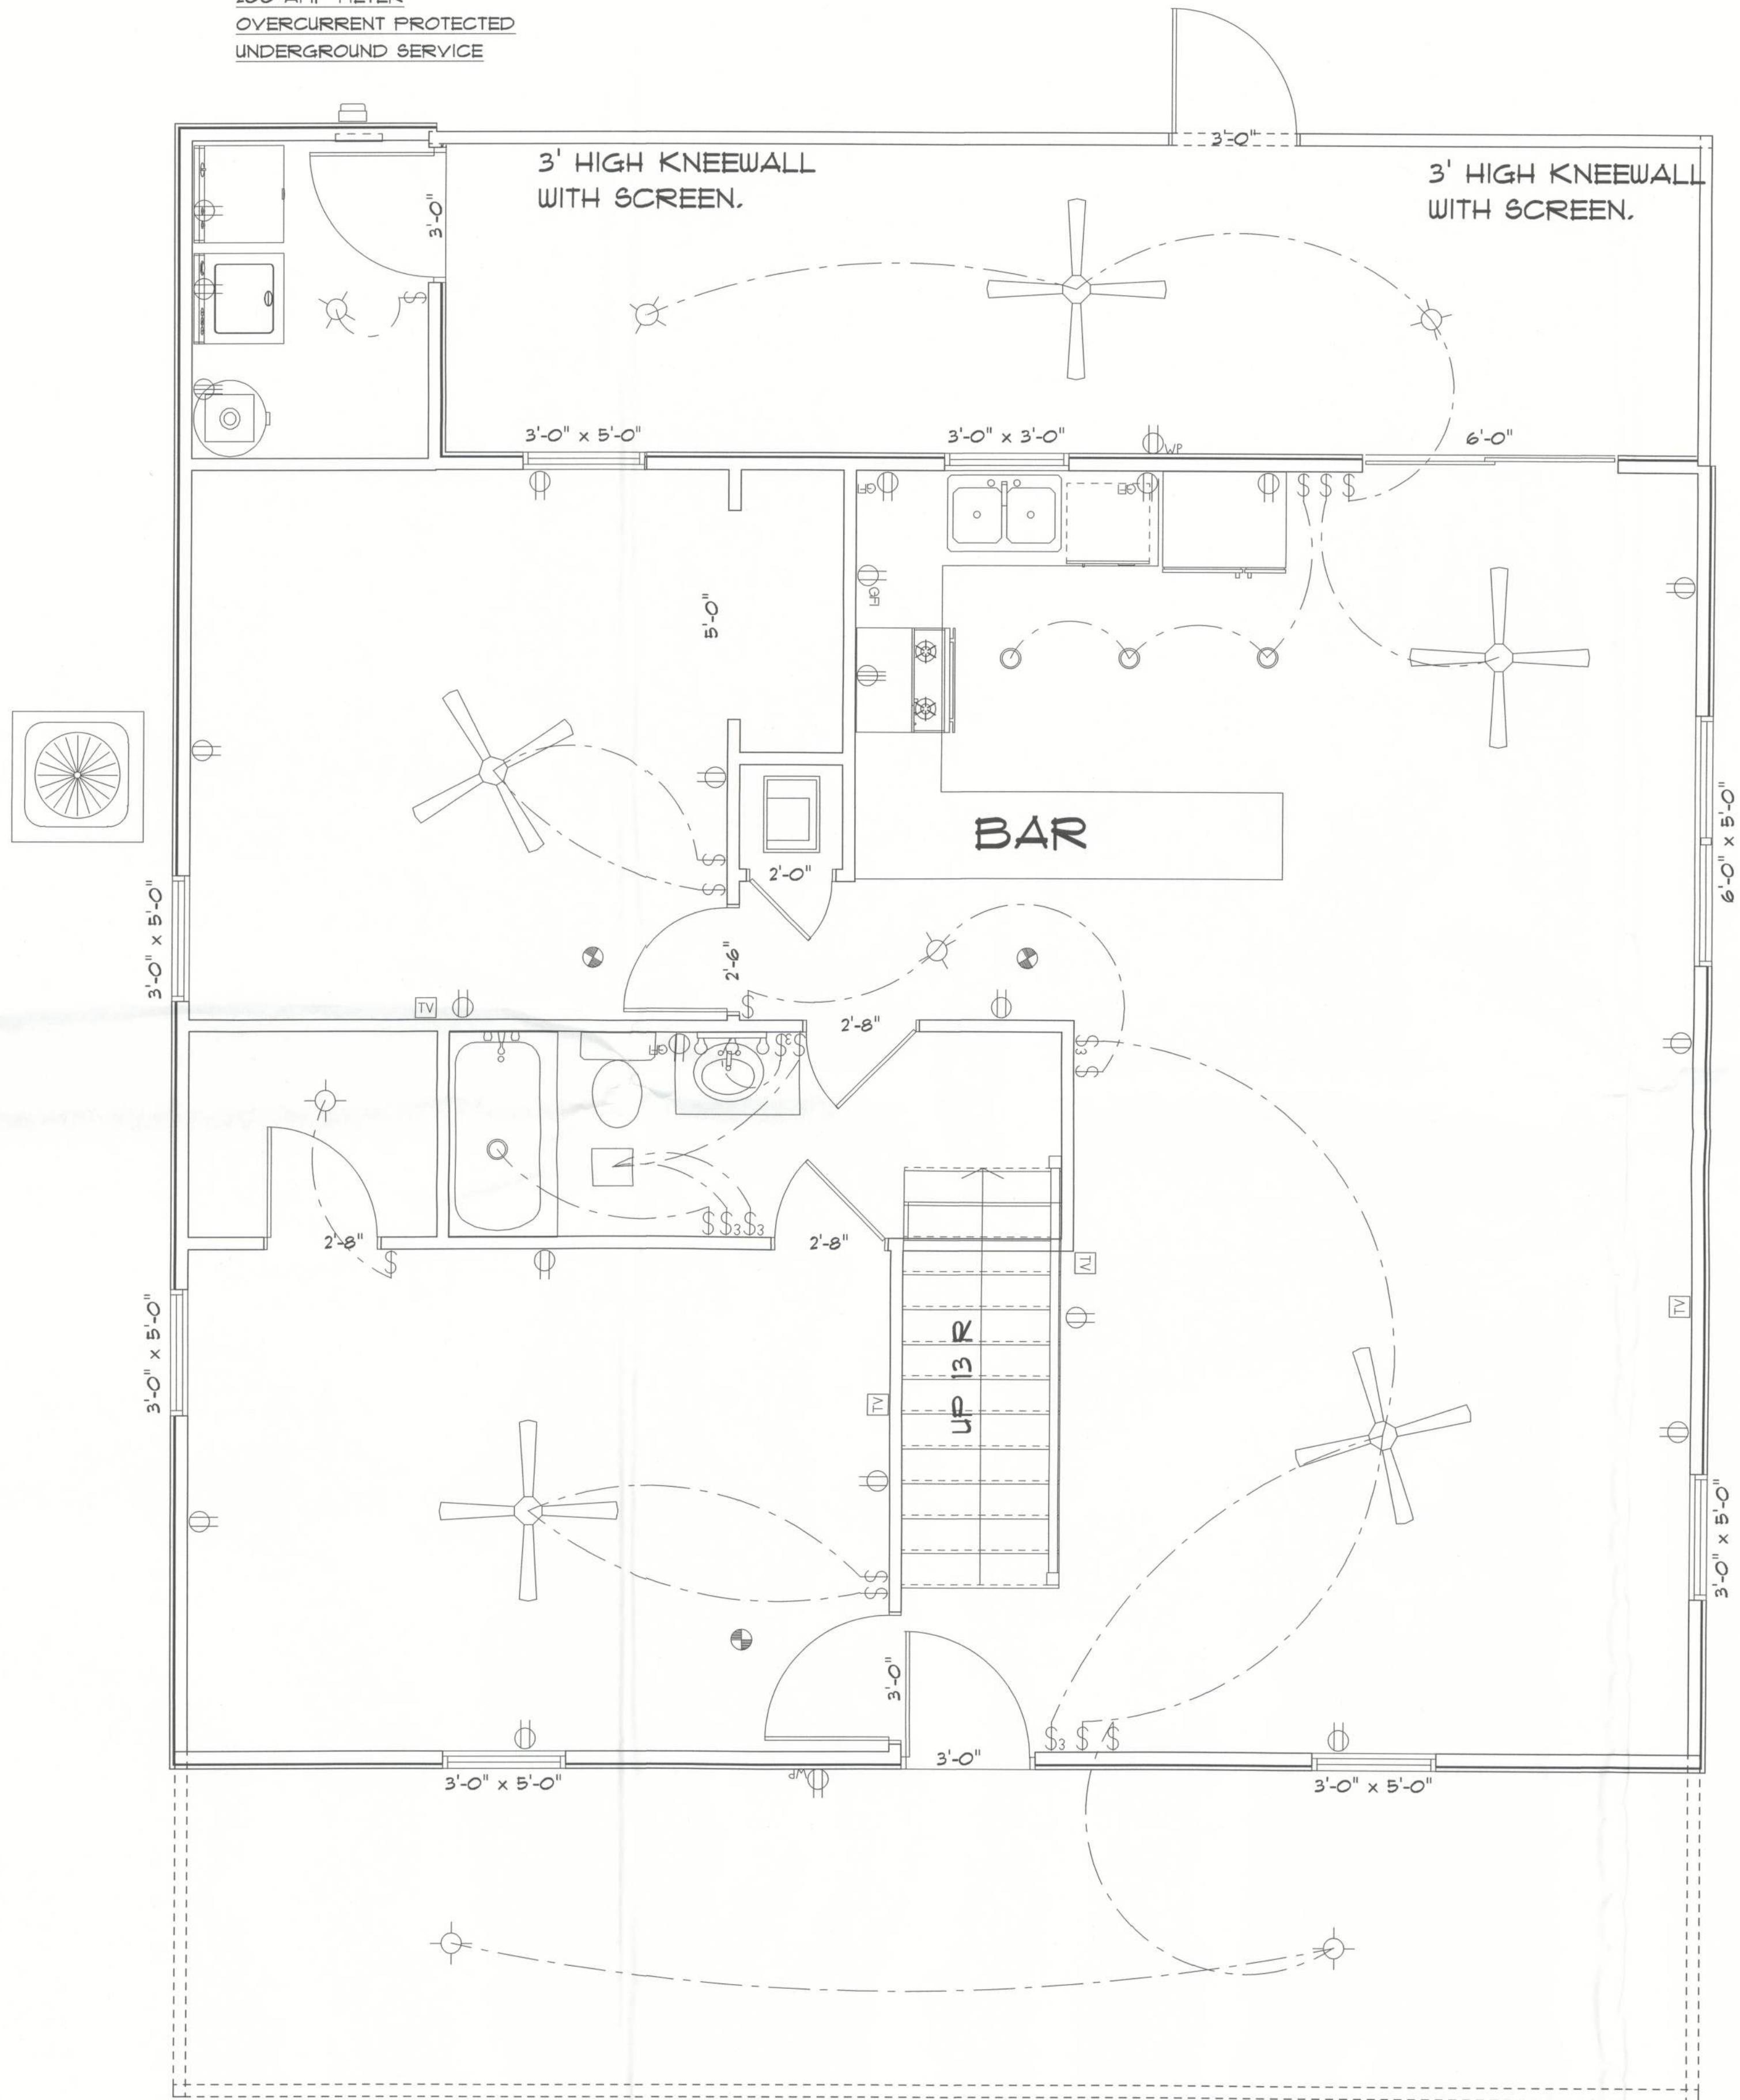

ELECTRICAL PLAN

ELECTRICAL NOTES

- E-1 WIRE ALL APPLIANCES, HVAC UNITS AND OTHER EQUIPMENT PER MANUFACTURER SPECS
- E-2 CONSULT THE OWNER FOR THE NUMBER OF SEPERATE TELEPHONE LINES TO BE INSTALLED
- E-3 ALL INSTALATIONS SHALL BE PER NATIONAL ELECTRIC CODE
- E-4 ALL SMOKE DETECTORS SHALL BE 120V W/BATTERY BACKUP OF THE P-O ELECTRIC TYPE, AND SHALL BE INTERLOCKED TOGETHER INSTALL INSIDE AND NEAR BEDROOMS
- E-5 TELEPHONE TEVELVISION AND OTHER LOW DEVICES OR OUTLETS SHALL BE AS PER THE OWNERS DIRECTION AND IN ACCORDANCE WITH APPLICABLE SECTIONS ON NATIONAL ELECTRIC CODE LATEST ADDITION
- E-6 ELECTRICAL CONTRACTOR SHALL BE RESPONSIBLE FOR THE DESIGN AND SIZING OF ELECTRICAL SERVICE AND CIRCUITS
- E-7 ENTRY OF SERVICE UNDERGROUND OR OVERHEAD TO BE DETERMINED BY THE POWER COMPANY
- E-8 ALL BEDROOMS RECEPTICALS ARE TO BE A.F.C.I.

ELECTRICAL	SYMBOL
ceiling fan	
can light 6inch	
ceiling light vent square	
track light	
electrical meter	
electrical panel	
cable tv outlet	
light	
outlet	
outlet 220v	
outlet gfi	
outlet wp	
smoke detector	
switch	
switch 3 way	

REVISIONS

SOFTPLAN
ARCHITECTURAL DESIGN SOFTWARE

HOME TOWN
HOMES, Inc.
MR & MRS
MCALL
RIVER CABIN

ADDRESS:

County, Florida

PRINTED DATE:
January 20, 2012

DRAWN BY:
JOHN BENZ

CHECKED BY:
JOHN BENZ

DESIGNED BY:

MR. MCALL

FINALS DATE:

JOB NUMBER:

DRAWING NUMBER

A3 ELECTRIC