




POWER PLAN
SCALE: 1/4" = 1'-0"

ELECTRICAL LEGEND	
ELECTRICAL	SYMBOL
Emergency Light	⬇
LAN CONNECTION	⬇
OUTLET	⊕
OUTLET WP	⊕ _{WP}
SWITCH	\$
SWITCH 3 WAY	\$ ₃
SWITCH 4 WAY	\$ ₄

EXISTING BUILDING RENOVATIONS FOR:
KINGDOM CULTURE ACADEMY
COLUMBIA COUNTY, FLORIDA

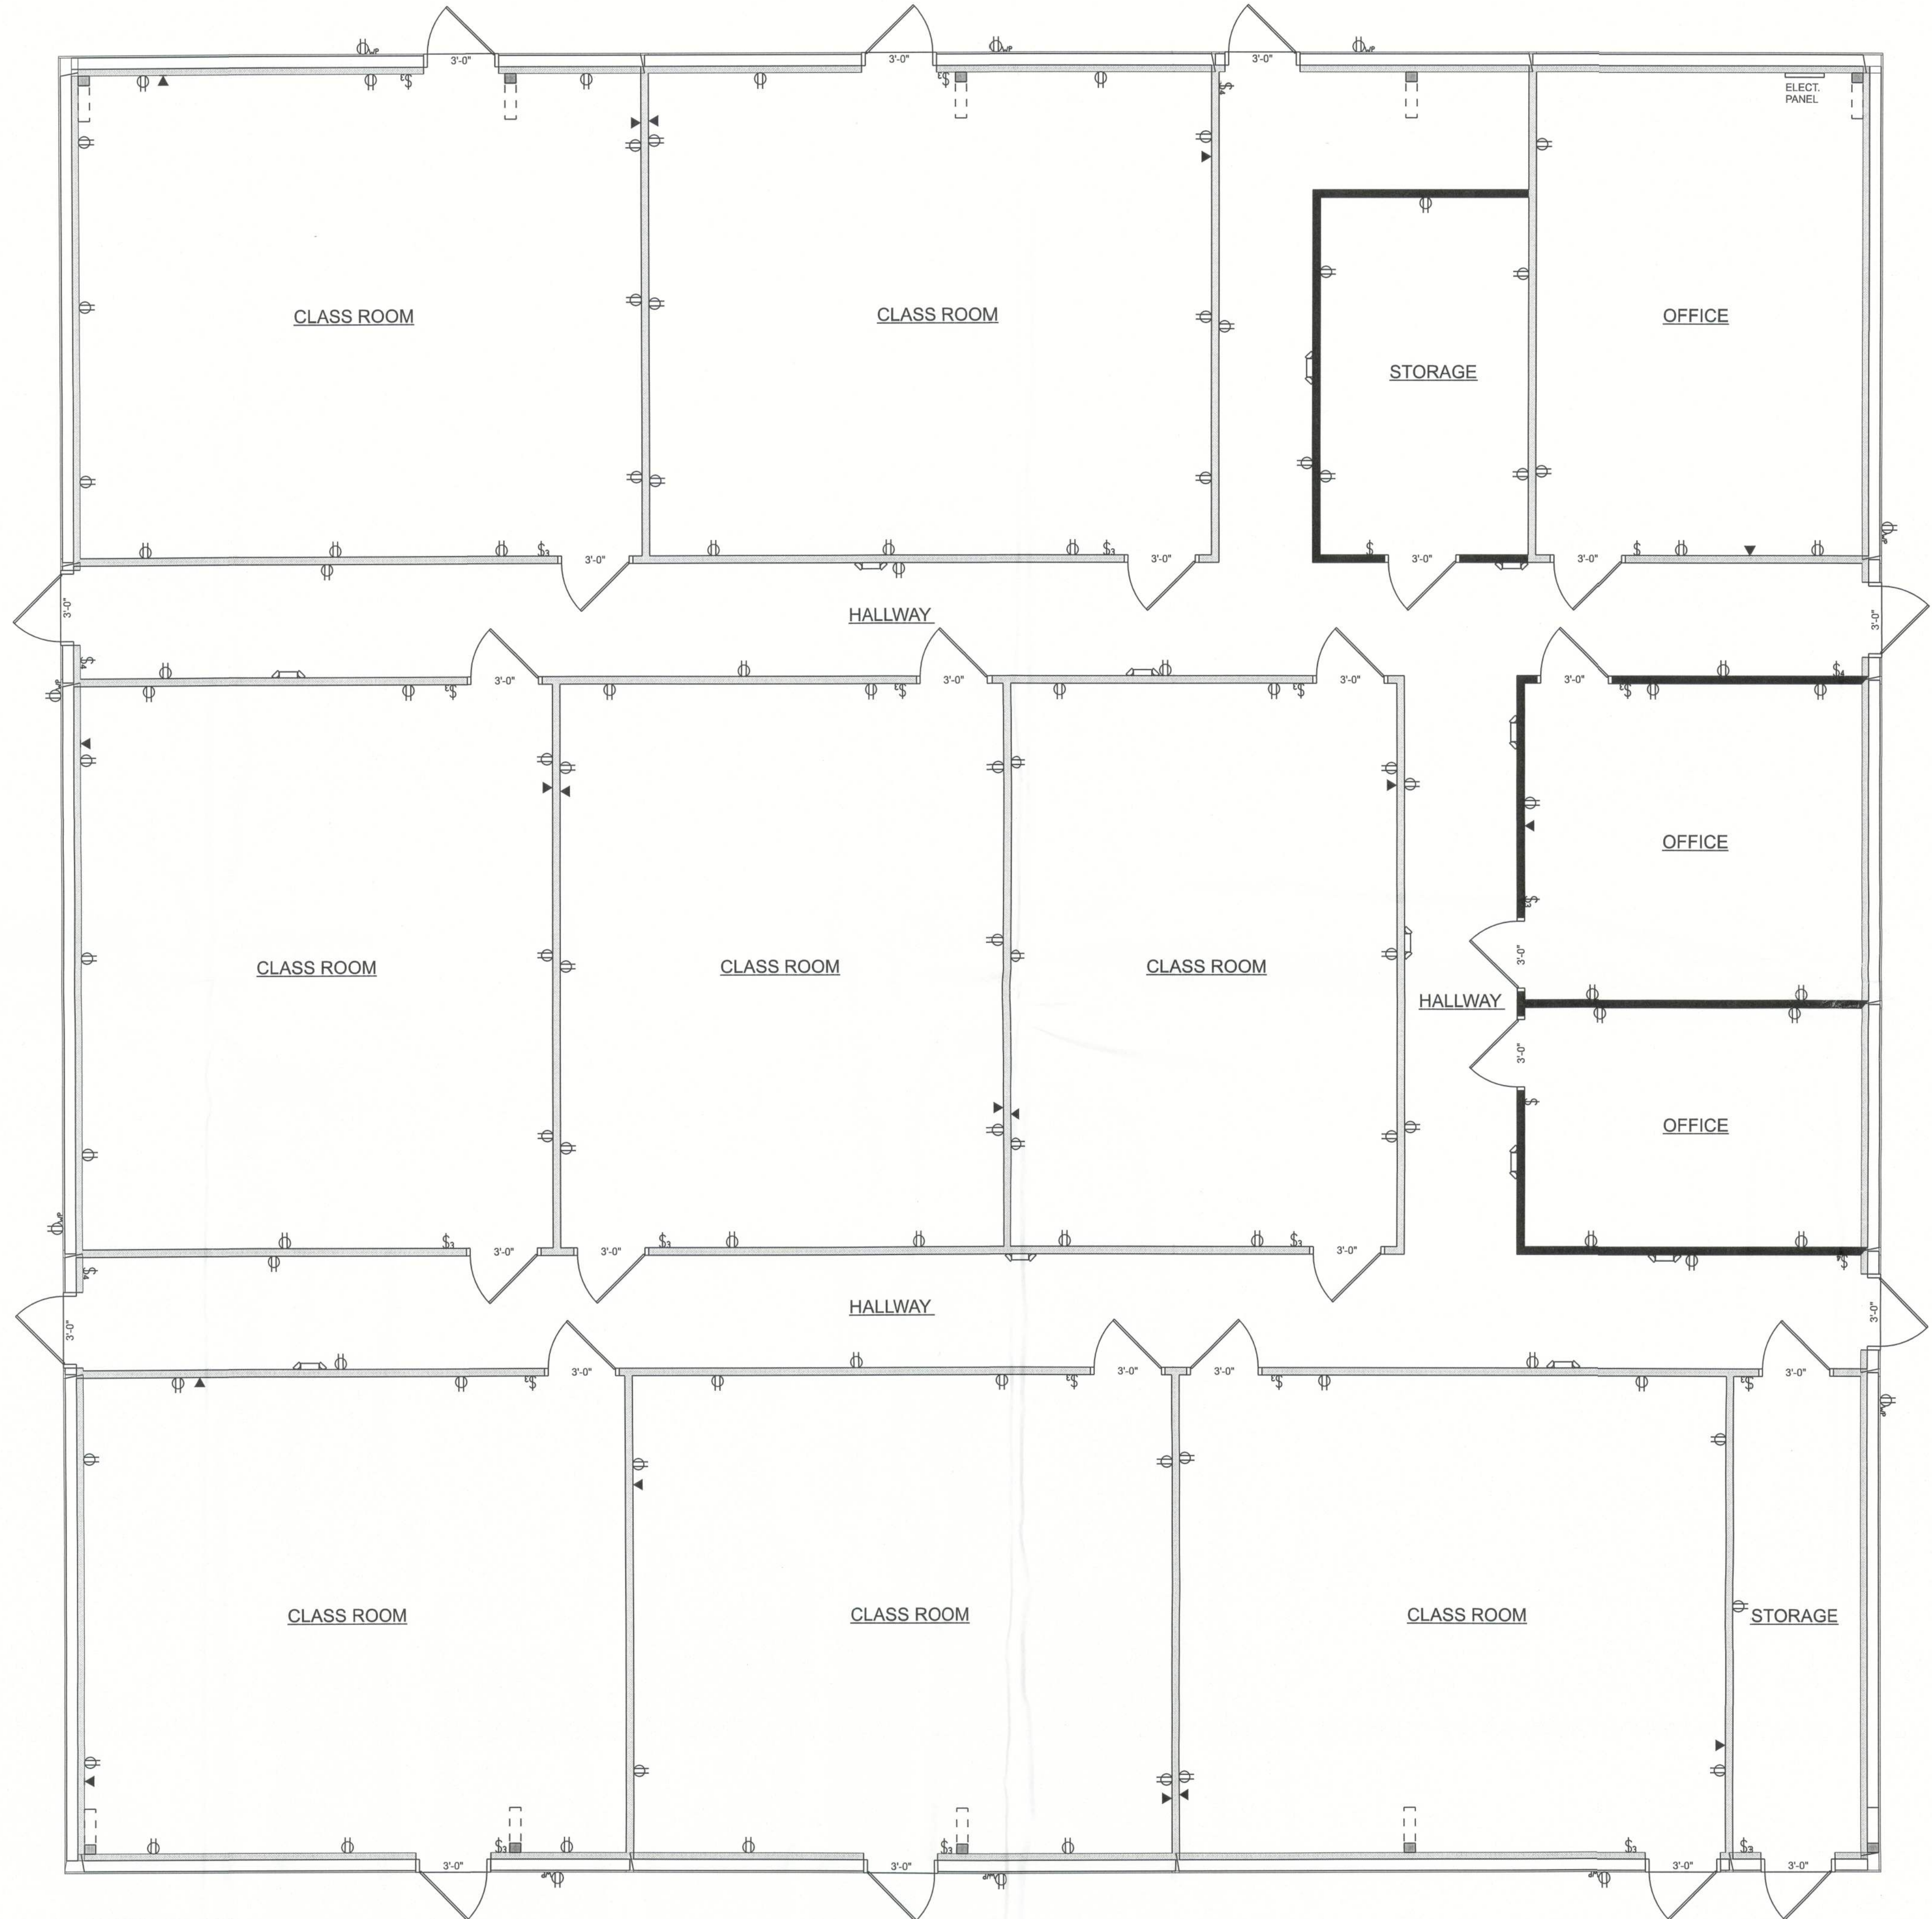

RIDGEPOINT DESIGN
RIDGEPOINTDESIGNPAUL.COM | 386-288-1888



**NICHOLAS
GEISLER
ARCHITECT**
1759 NW Brown Rd.
Largo, FL 33025
NCA#163, Certified

JOINT VENTURED WITH

SHEET NUMBER
A.3
OF 4 SHEETS

Handwritten signature and date
09 Apr 2024
AR0007005