


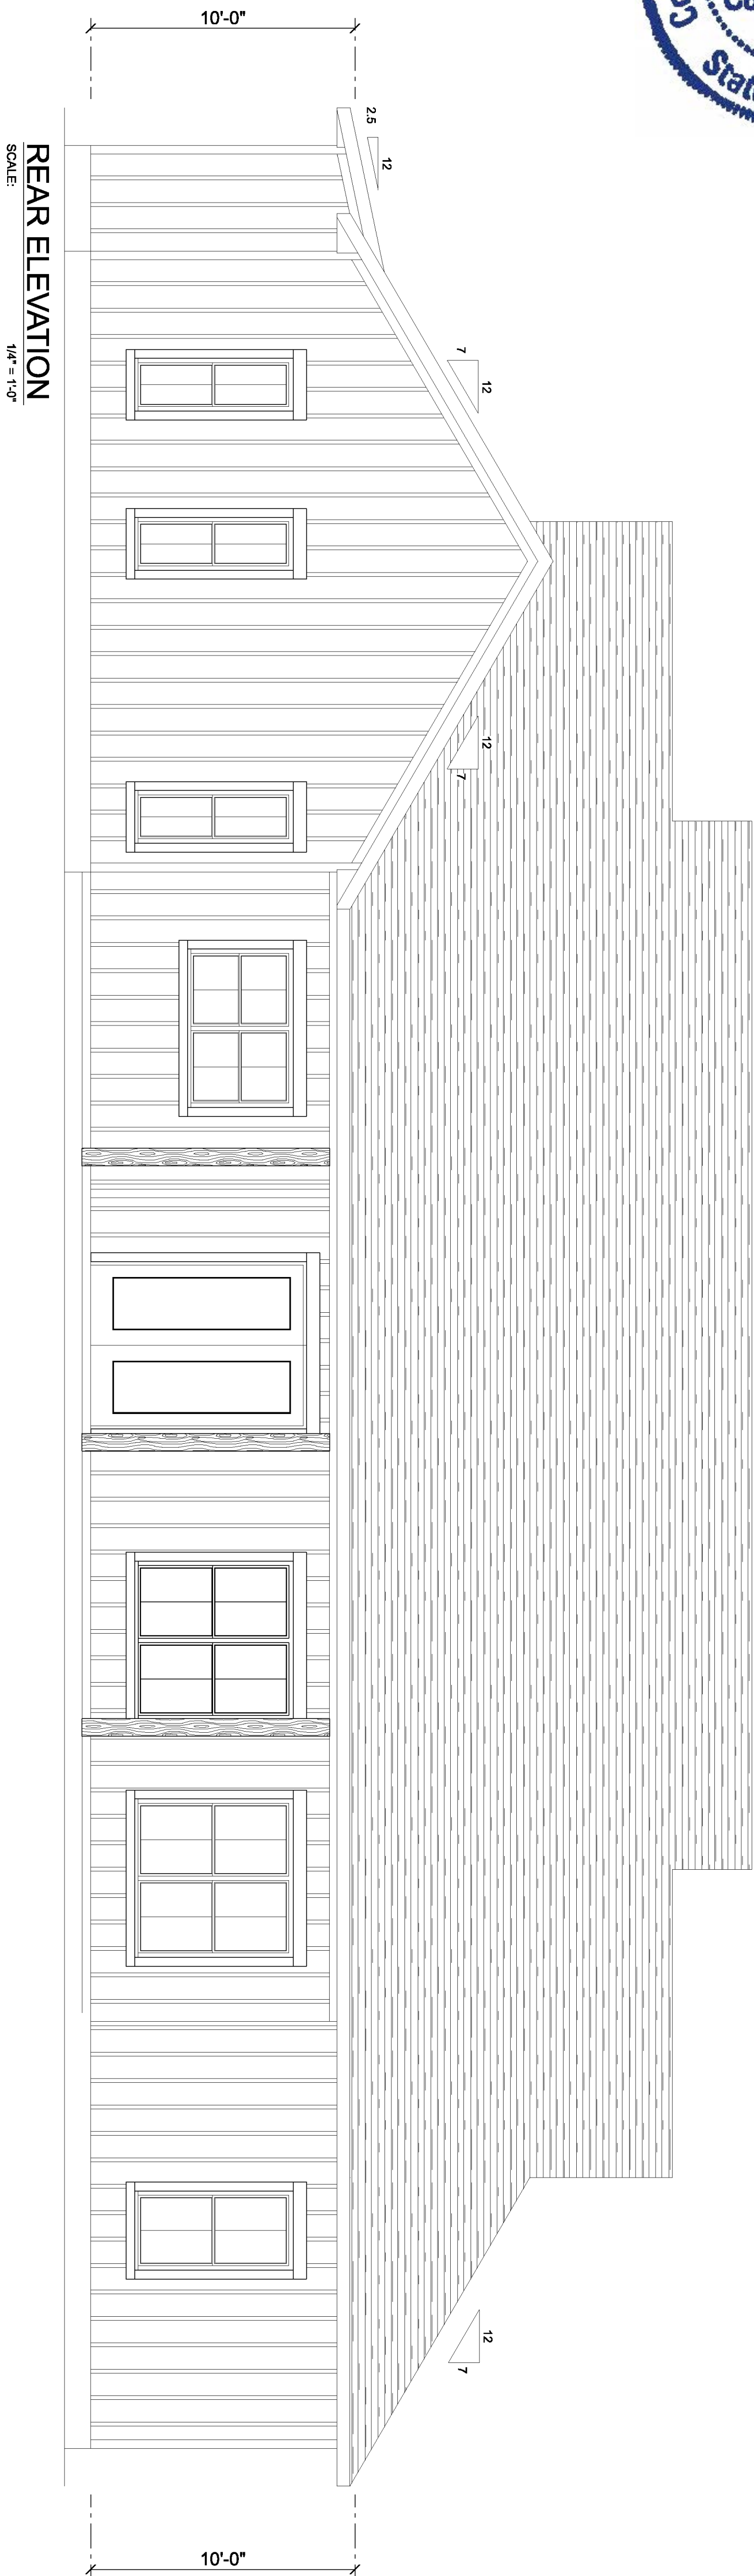
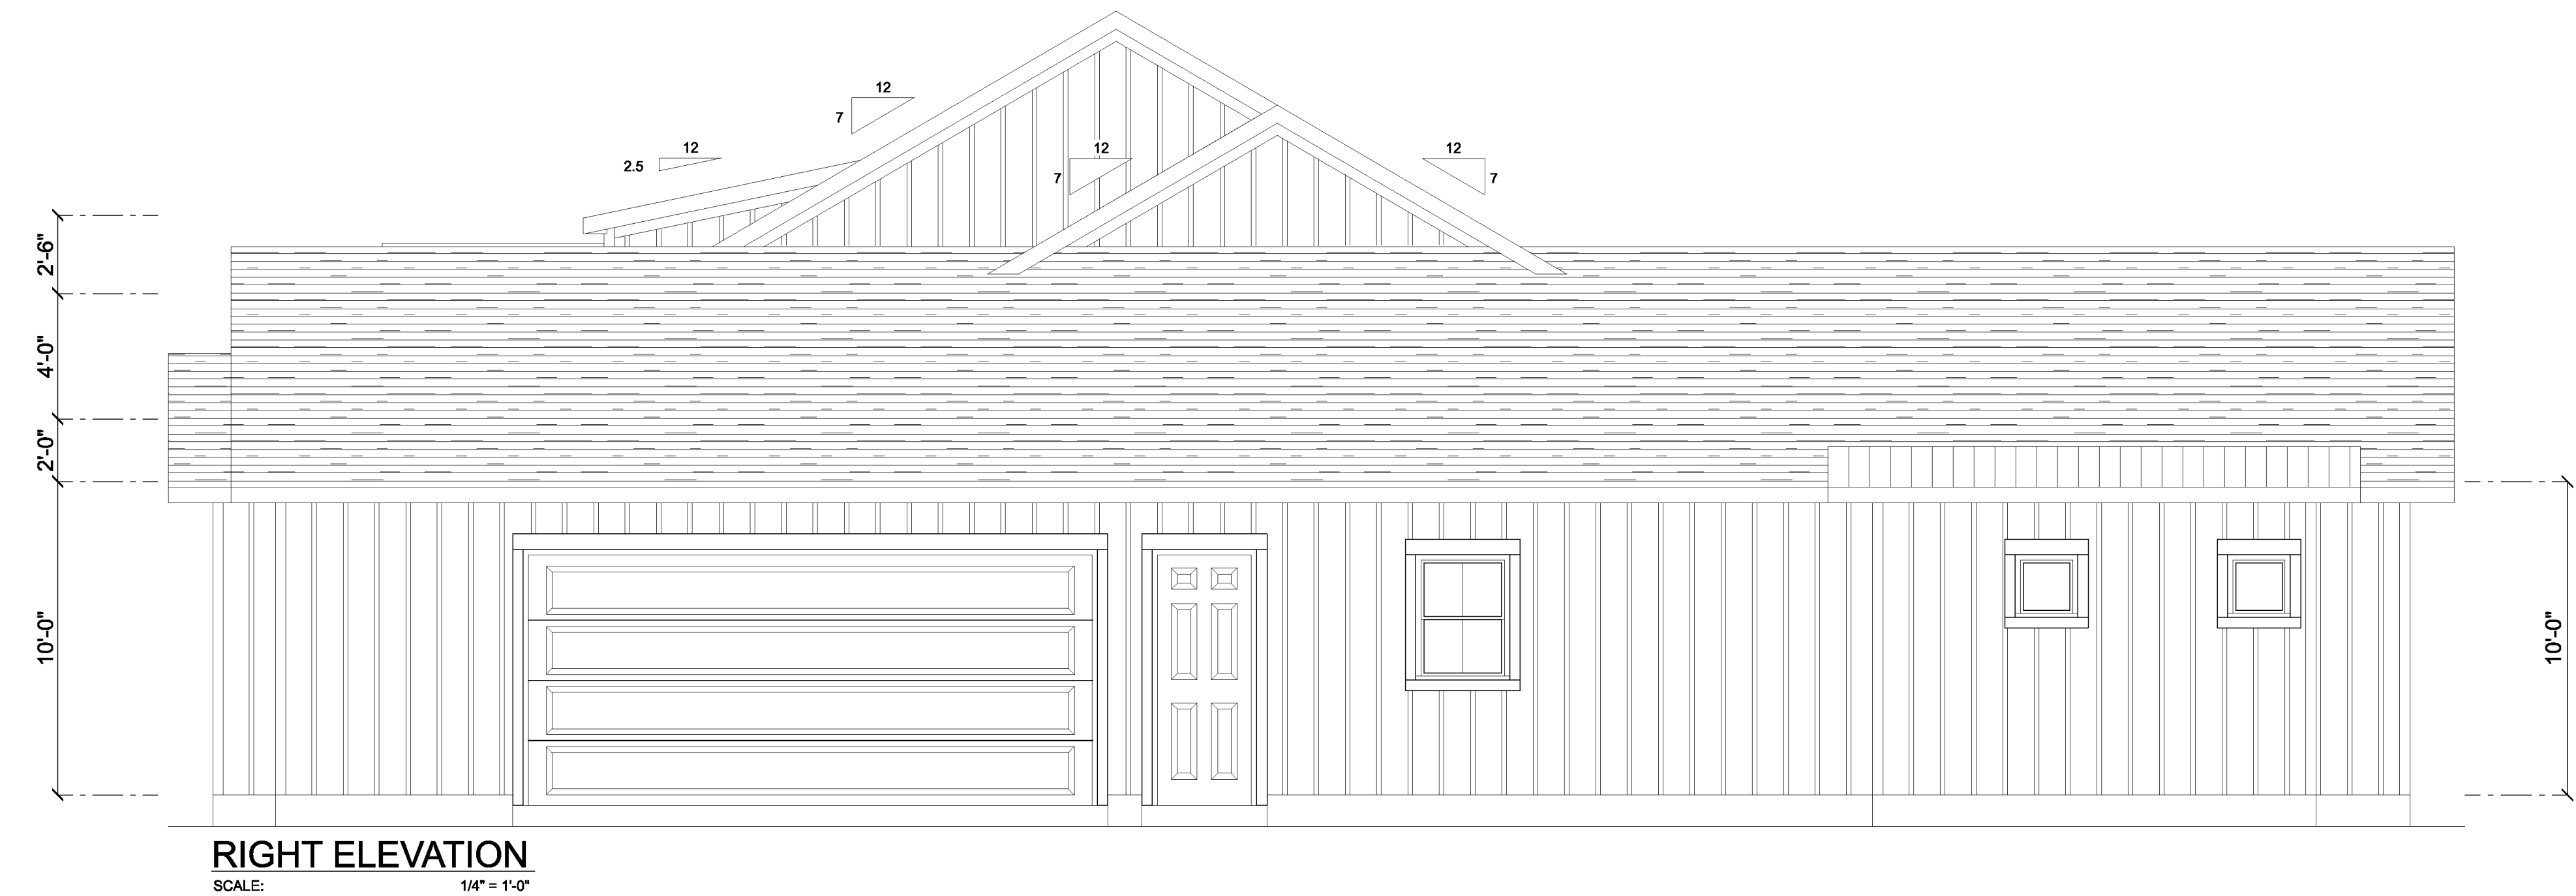
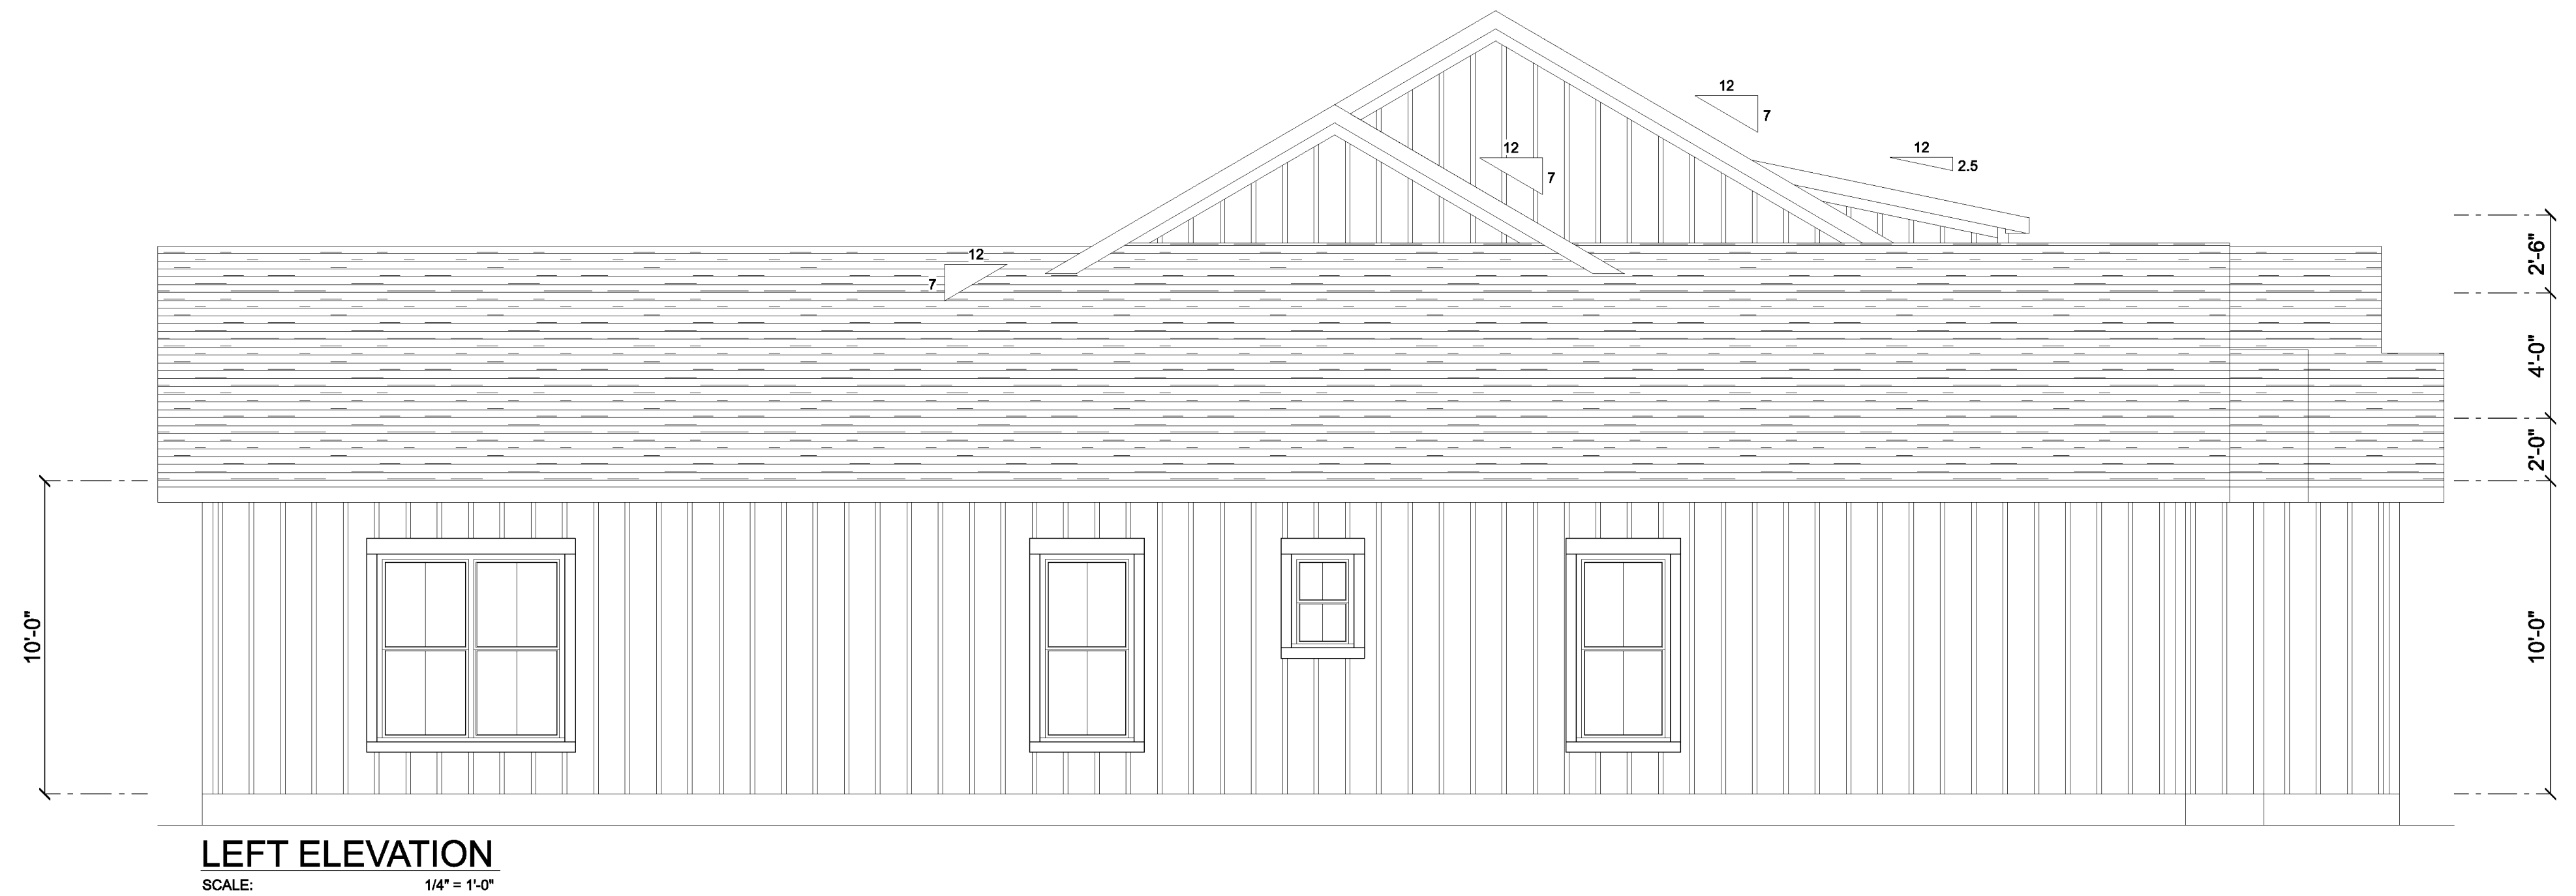


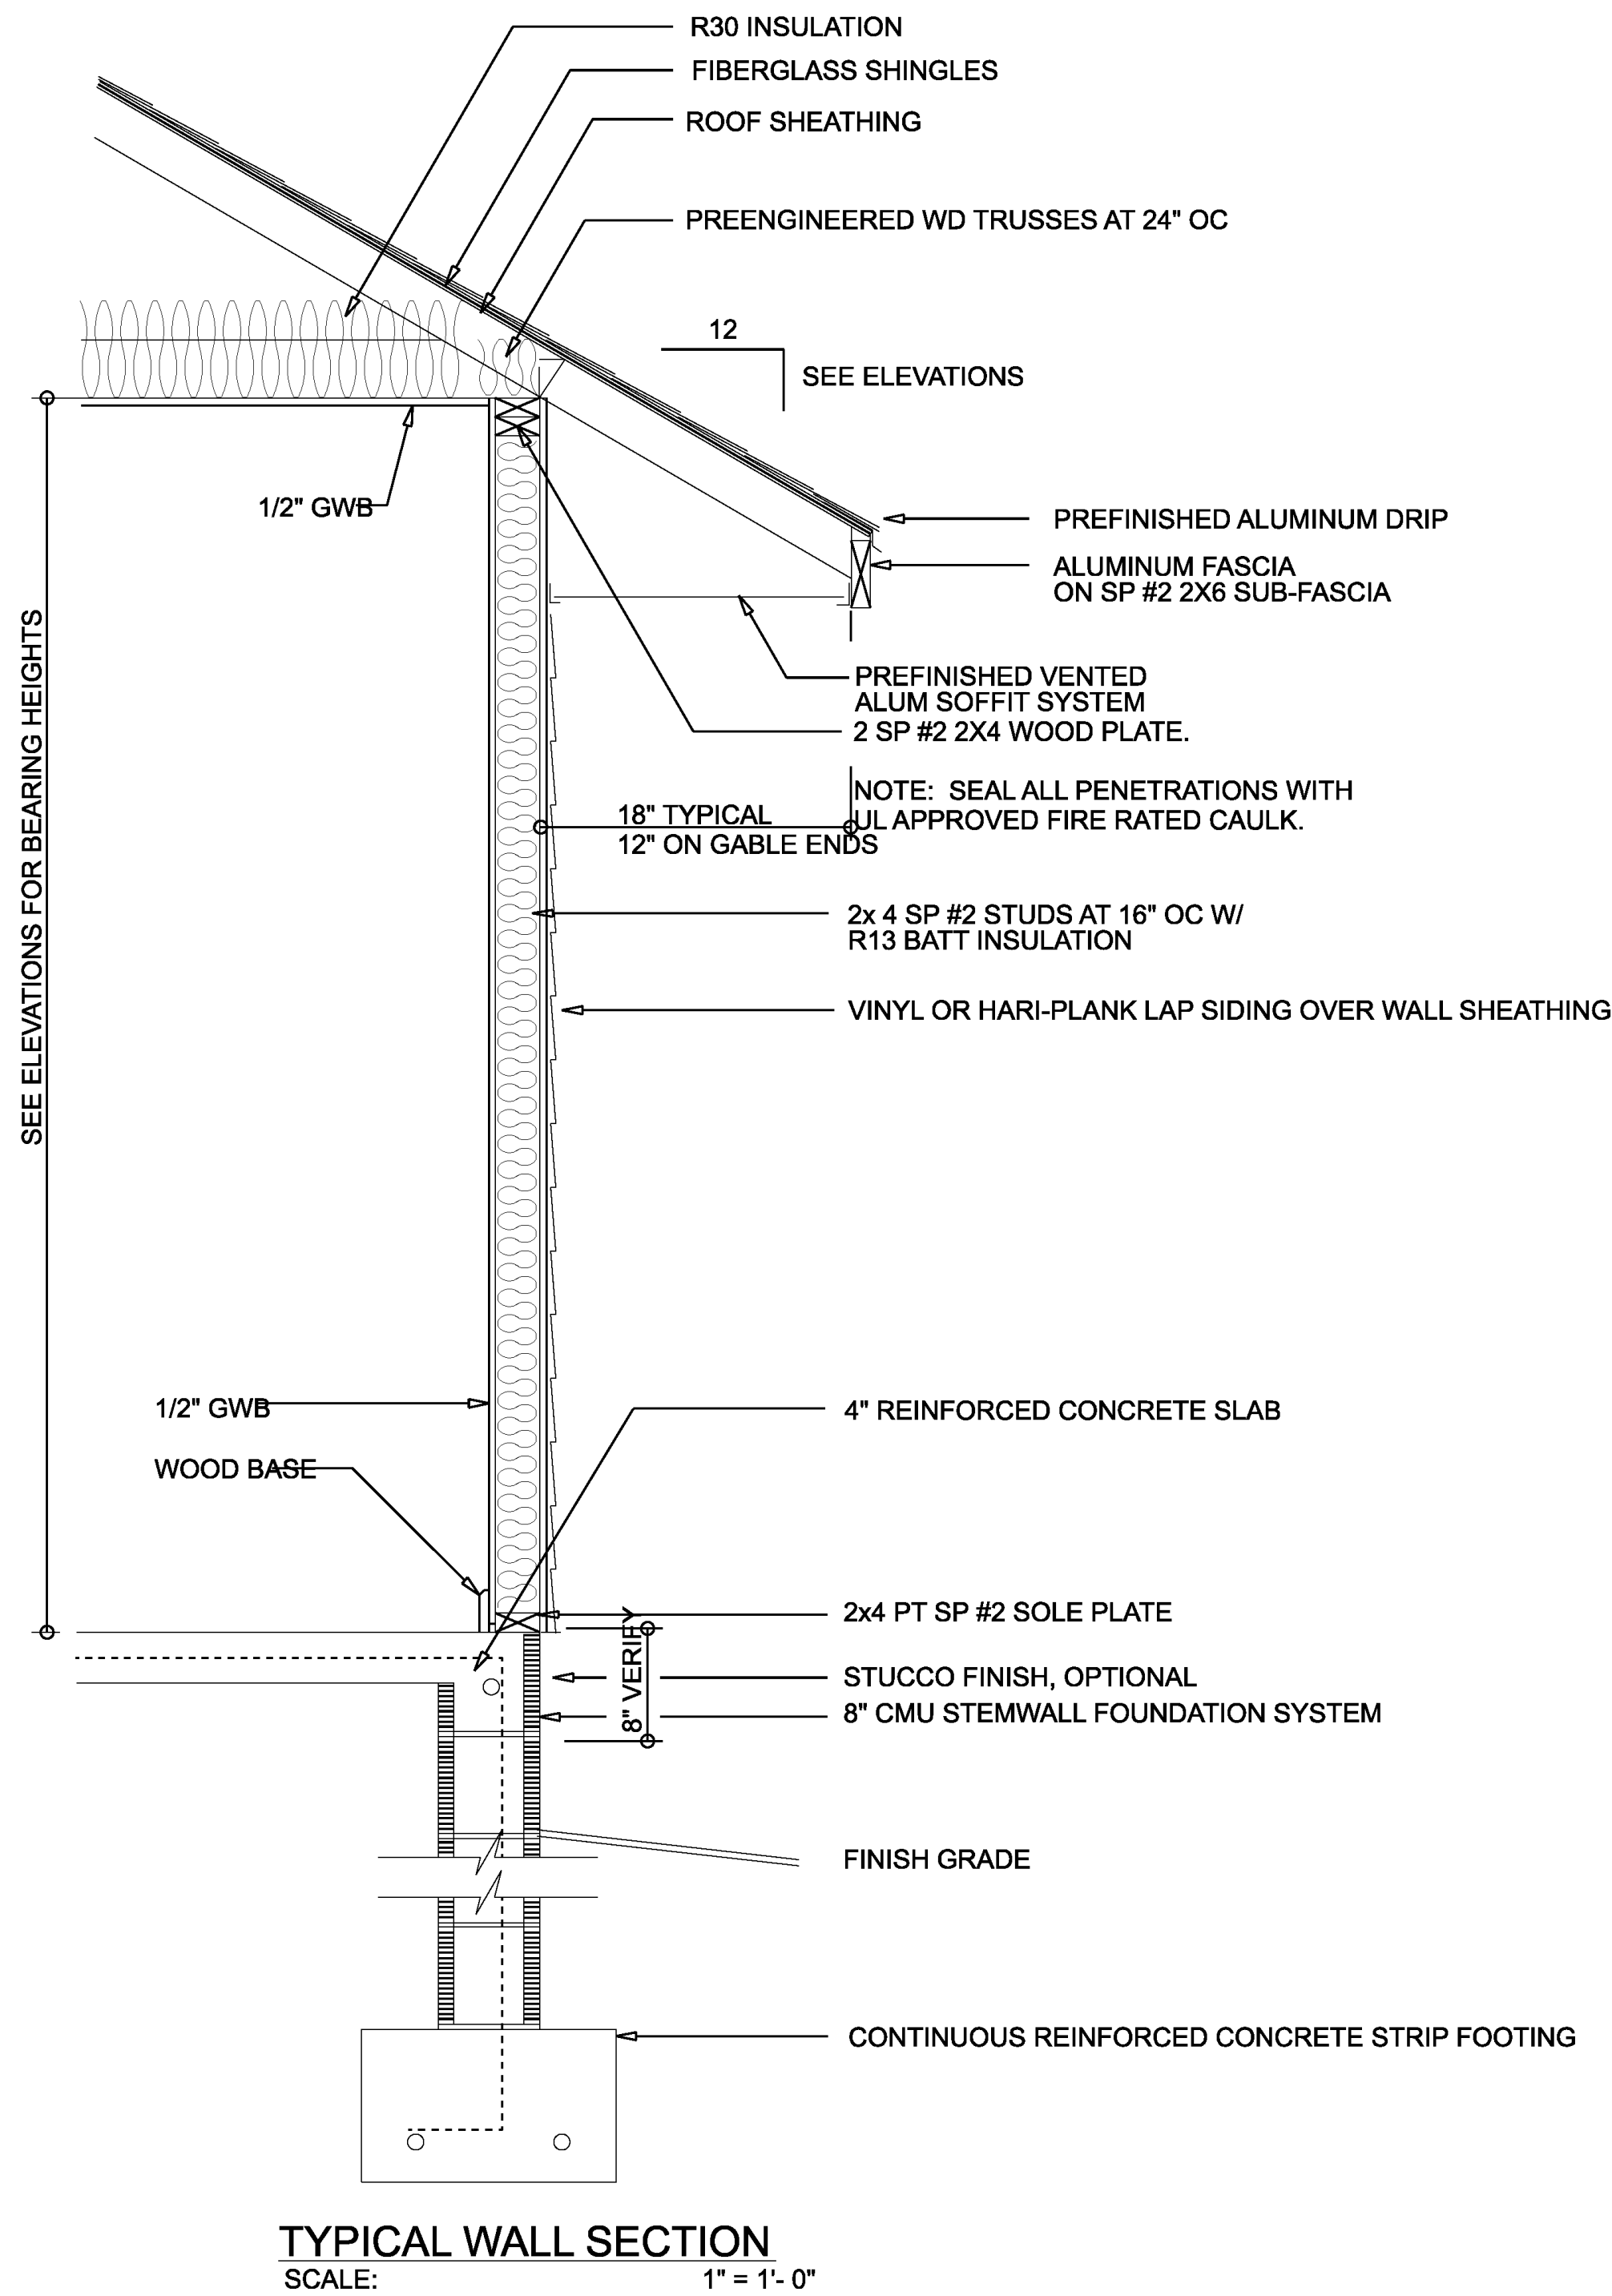


REVISIONS SCHEDULE	
Aug. 18th, 2023	Proposal Drawing
Nov. 7th, 2023	Revisions

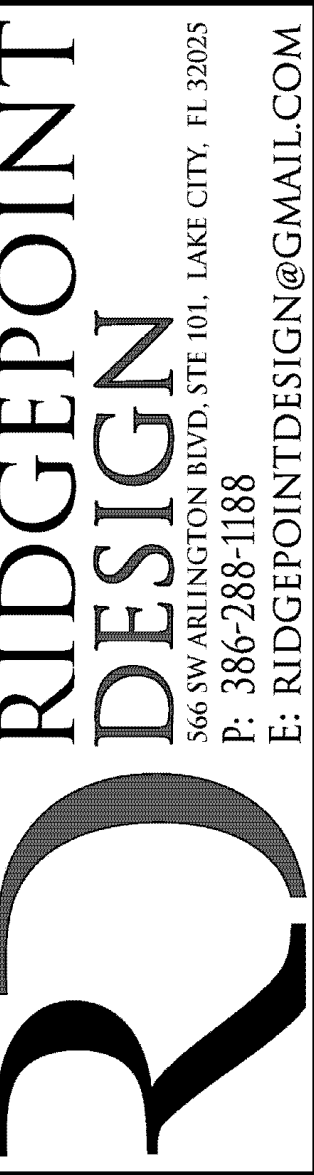

REVISIONS SCHEDULE			
Aug. 18th, 2023	Proposal Drawing		
Nov. 7th, 2023	Revisions		

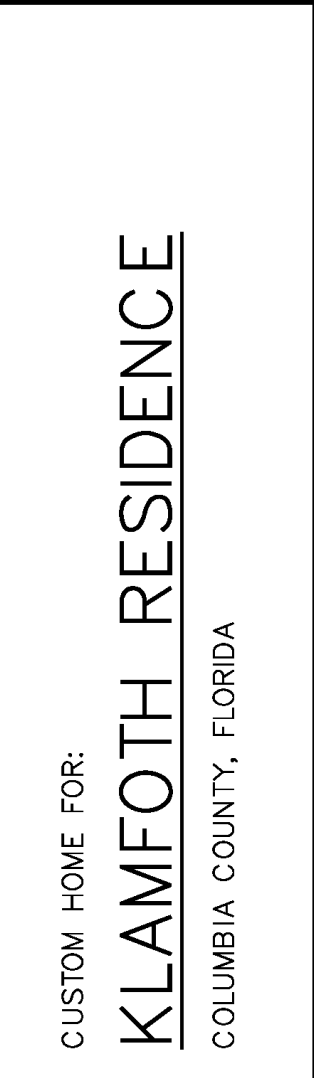

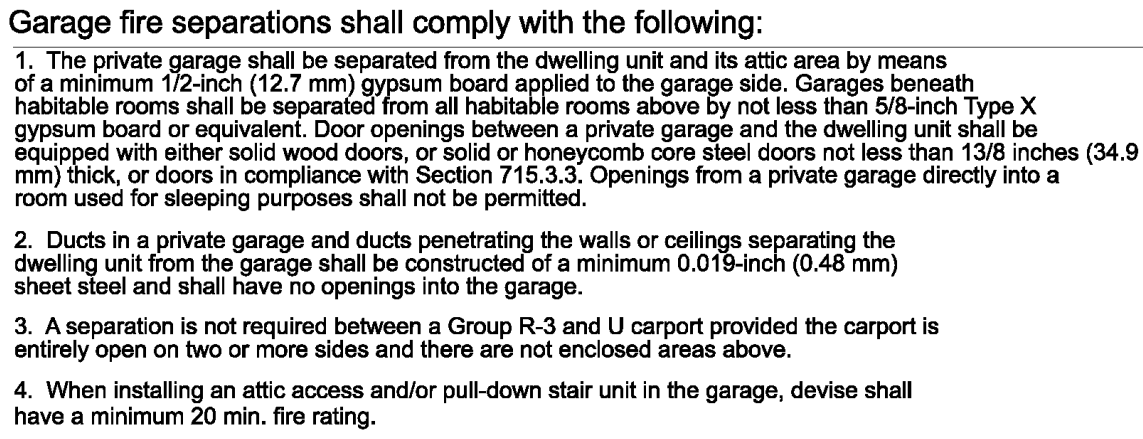


SCALE: $1/4" = 1'-0"$

LIVING	2,954	S.F.
FRONT PORCH	252	S.F.
BACK PORCH	487	S.F.
GARAGE	775	S.F.
TOTAL AREA	4,468	S.F.


REVISIONS SCHEDULE	
Aug. 18th, 2023	Proposal Drawing
Nov. 7th, 2023	Revisions



CUSTOM HOME FOR:
KLAMFOTH RESIDENCE
COLUMBIA COUNTY, FLORIDA

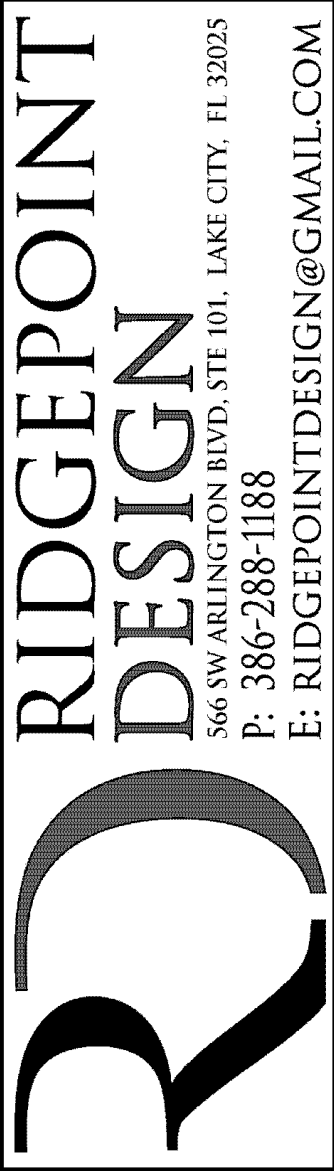

SHEET NUMBER
A.3
OF 4 SHEETS

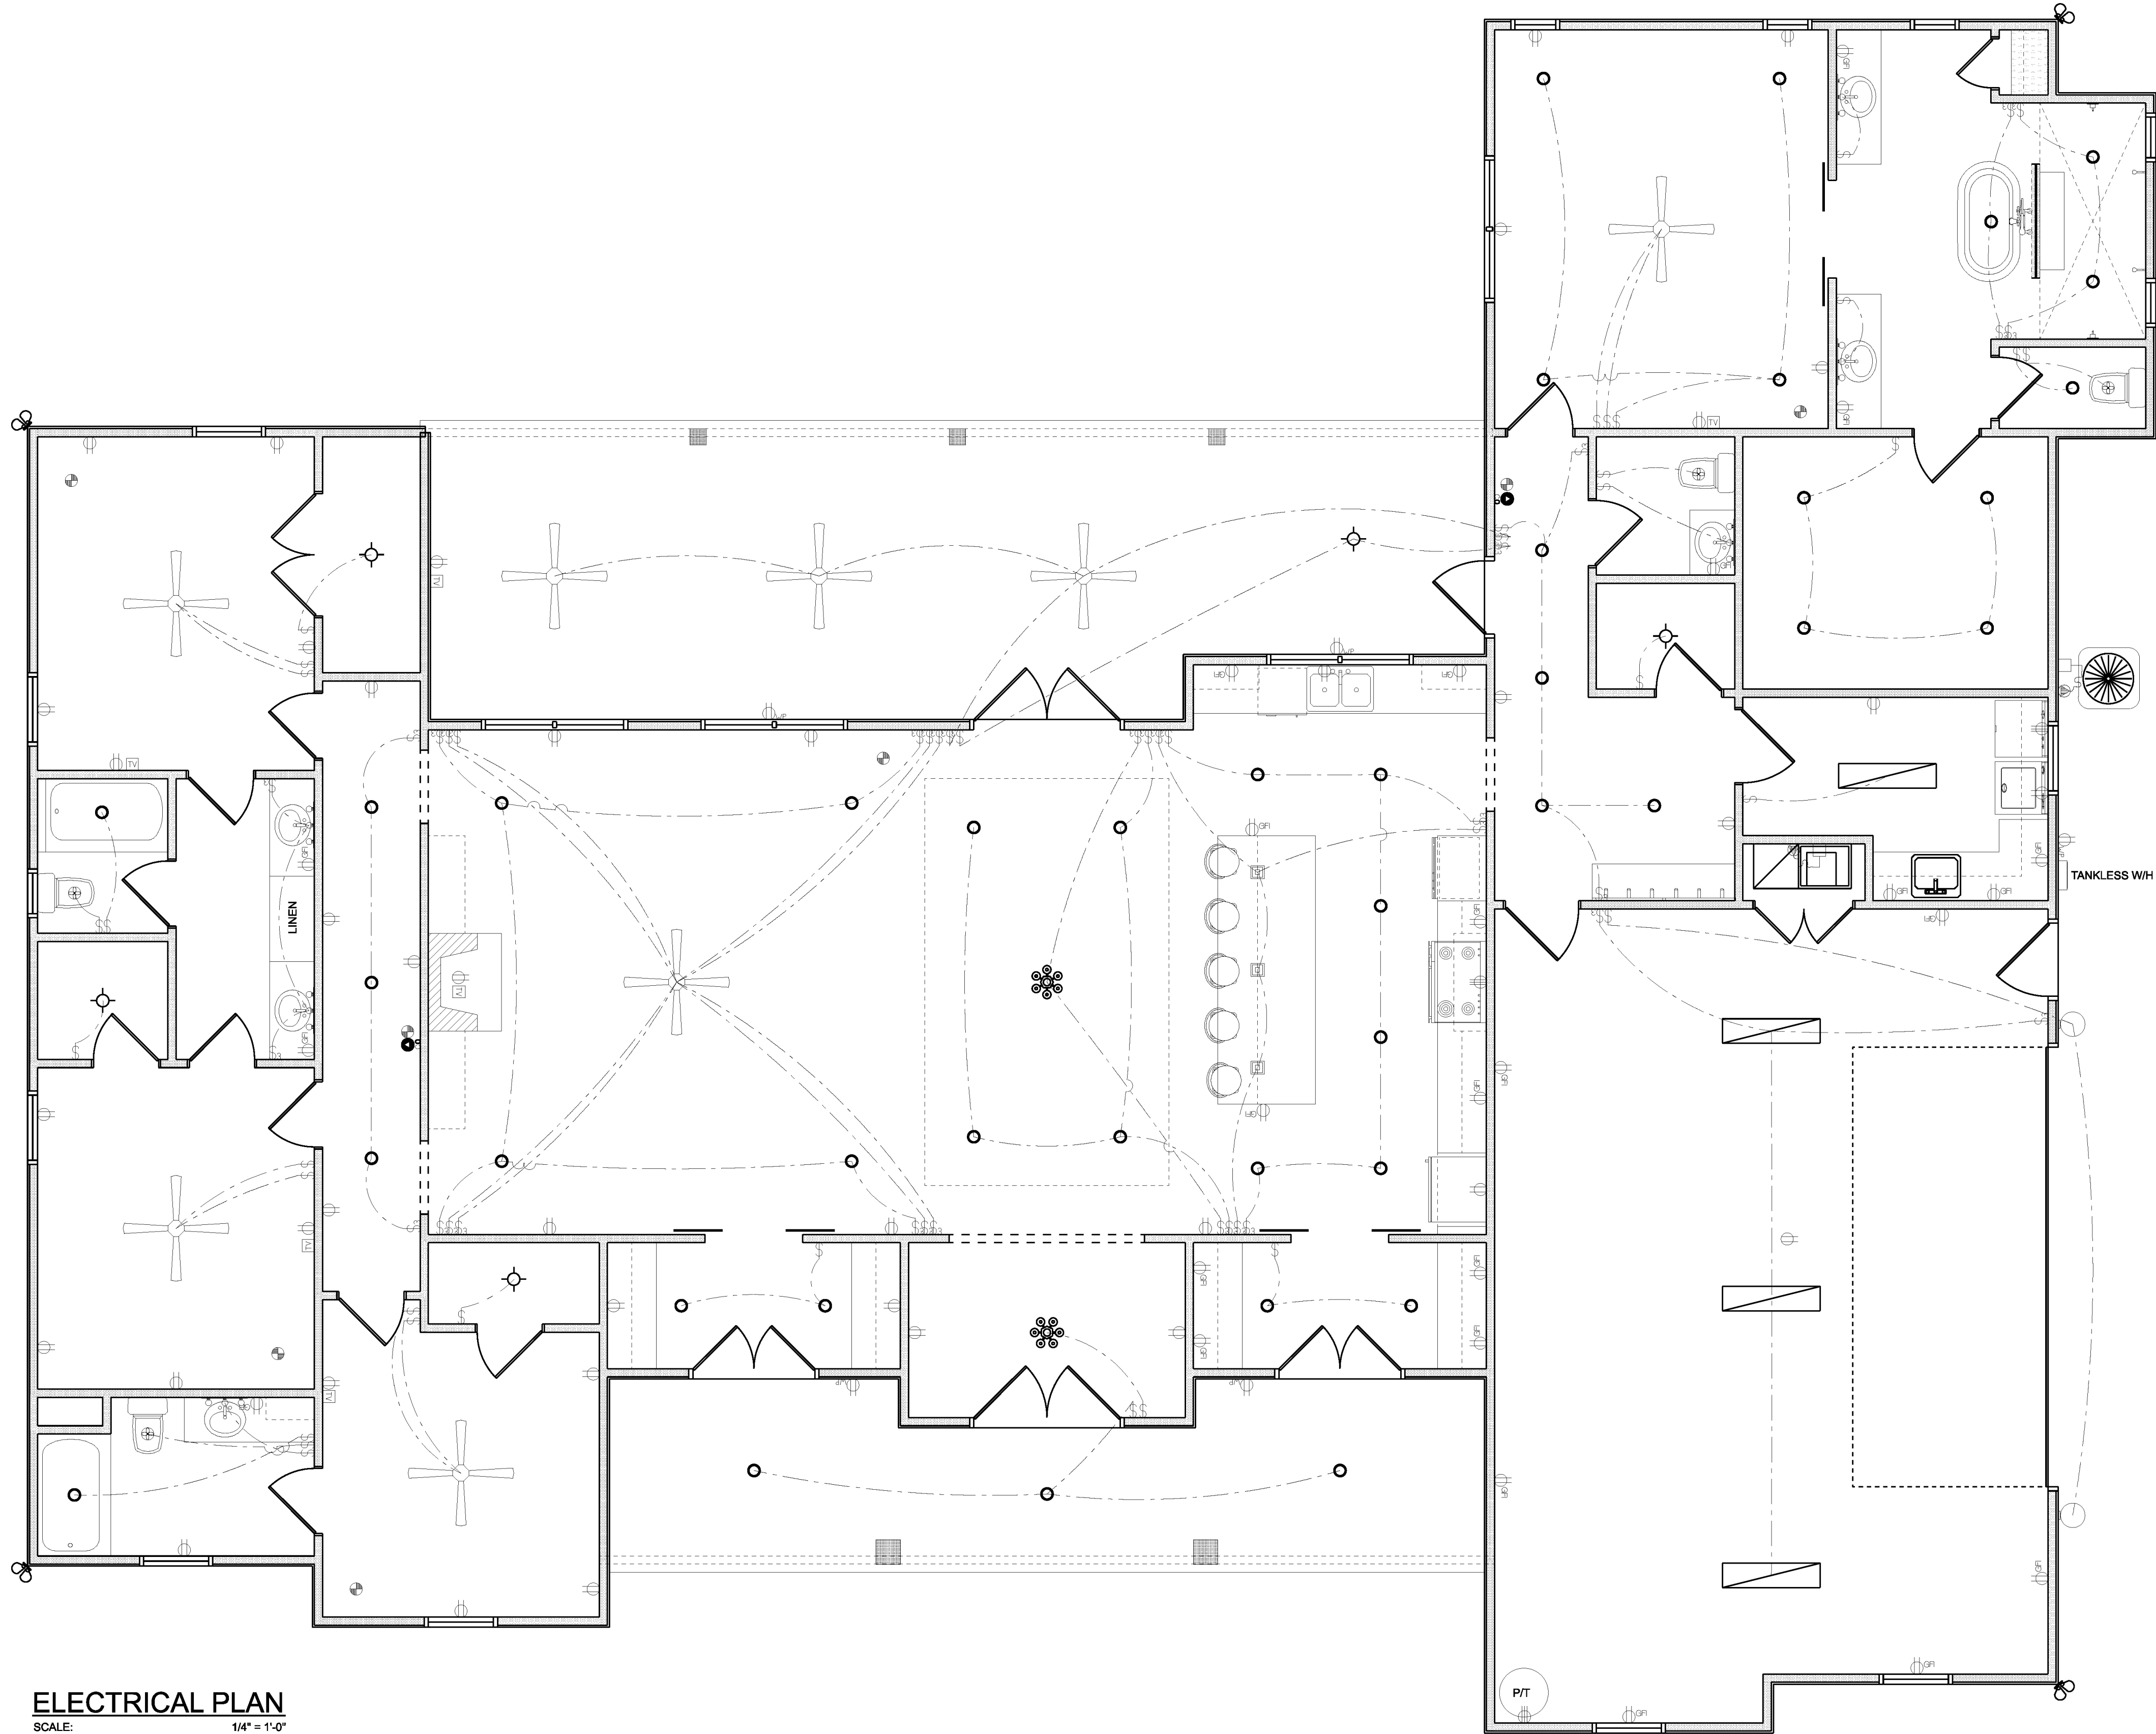

ELECTRICAL PLAN
SCALE: 1/4" = 1'-0"

ELECTRICAL LEGEND		
ELECTRICAL	COUNT	SYMBOL
CEILING FAN	8	
CAN LIGHT 6inch	42	
CHANDELIER	2	
LED CEILING LIGHT 1x4	4	
PENDANT LIGHT	3	
EXTERIOR SCONCE	2	
MOTION SECURITY LIGHT	4	
AC DISCONNECT	2	
CABLE TV OUTLET	6	
CARBON DETECTOR	2	
EXHAUST FAN	4	
OUTLET	41	
OUTLET 220v	3	
OUTLET GFI	25	
OUTLET WP	5	
SMOKE DETECTOR	7	
STANDARD LIGHT	5	
SWITCH	31	
SWITCH 3 WAY	39	
VANITY BAR LIGHT - SMALL	6	

ELECTRICAL PLAN NOTES:

- INSTALLATION SHALL BE PER LATEST NAT'L ELECTRIC CODE.
- WIRE ALL APPLIANCES, HVAC UNITS AND OTHER EQUIPMENT PER MANUF. SPECIFICATIONS
- CONSULT WITH THE OWNER FOR THE NUMBER OF SEPERATE TELEPHONE LINES TO BE INSTALLED
- ALL SMOKE DETECTORS SHALL BE 120V W/ BATTERY BACKUP OF THE PHOTOELECTRIC TYPE, AND SHALL BE INTERLOCKED TOGETHER. INSTALL INSIDE AND NEAR ALL BEDROOMS
- TELEPHONE, TELEVISION AND OTHER LOW VOLTAGE DEVICES OR OUTLETS SHALL BE AS PER THE OWNER'S DIRECTIONS, & IN ACCORDANCE W/ APPLICABLE SECTIONS OF NEC-LATEST EDITION.
- ALL RECEPTICALS, NOT OTHERWISE NOTED, SHALL BE ARC FAULT INTERRUPTER TYPE, EXCEPT DEDICATED OUTLETS
- ALL RECEPTICALS IN WET AREAS SHALL BE GROUND FAULT INTERRUPTER TYPE (GFI)
- ALL EXTERIOR RECEPTICALS SHALL BE WEATHERPROOF GROUD FAULT INTERRUPTER TYPE (WP/GFI)

NOTE:
ELECTRICAL CONTR SHALL PREPARE "AS-BUILT" SHOP DWGS INDICATING ALL ELECTRICAL WORK, INCLUDING ANY CHANGES TO THE ELEC. PLAN, ADD'NS TO THE ELEC. PLAN, RISER DIAGRAM, AS-BUILT PANEL SCHEDULE W/ ALL CKTS IDENTIFIED W/ CKT Nr. DESCRIPTION & BRKR. SERVICE ENT. & ALL UNDERGROUND WIRE LOCATIONS/ROUTING / DEPTH. RISER DIA. SHALL INCLUDE WIRE SIZES/TYPE & EQUIPMENT TYPE W/ RATINGS & LOADS.
CONTRACTOR SHALL PROVIDE 1 COPY OF AS-BUILT DWGS TO OWNER & 1 COPY TO THE PERMIT ISSUING AUTHORITY

REVISIONS SCHEDULE	
Aug. 18th, 2023	Proposal Drawing
Nov. 7th, 2023	Revisions




CONSTRUCTION LLC
818 W DUVAL ST, LAKE CITY, FL 32055

CUSTOM HOME FOR:

KLAMFOTH RESIDENCE

COLUMBIA COUNTY, FLORIDA

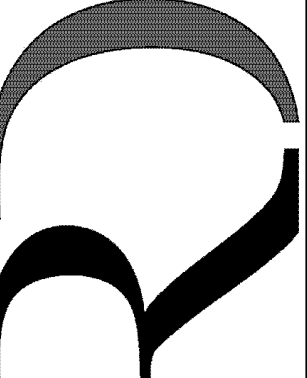

**RIDGEPOINT
DESIGN**

566 SW ARLINGTON BLVD, STE 101, LAKE CITY, FL 32025
P: 386-288-1188
E: RIDGEPOINTDESIGN@GMAIL.COM

SHEET NUMBER

A.4

OF 4 SHEETS