
 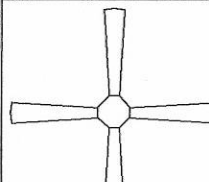



ELECTRICAL LEGEND	
	CEILING FAN (PRE-WIRE FOR LIGHT KIT)
	DOUBLE SECURITY LIGHT
	RECESSED CAN LIGHT
	BATH EXHAUST FAN
	LIGHT FIXTURE
	DUPLEX OUTLET
	220v OUTLET
	GFI DUPLEX OUTLET
	SMOKE DETECTOR (see note below)
	WALL SWITCH
	3 WAY WALL SWITCH
	WATER PROOF GFI OUTLET
	2 OR 4 TUB FLUORESCENT FIXTURE

NOTE:
ALL BEDROOM RECEPTACLES SHALL BE AFCI
(ARC FAULT CIRCUIT INTERRUPT)

ALL SMOKE DETECTORS SHALL HAVE BATTERY BACKUP POWER
AND ALL WIRED TOGETHER SO IF ANY ONE UNIT IS ACTUATED THEY
ALL ACTIVATE.

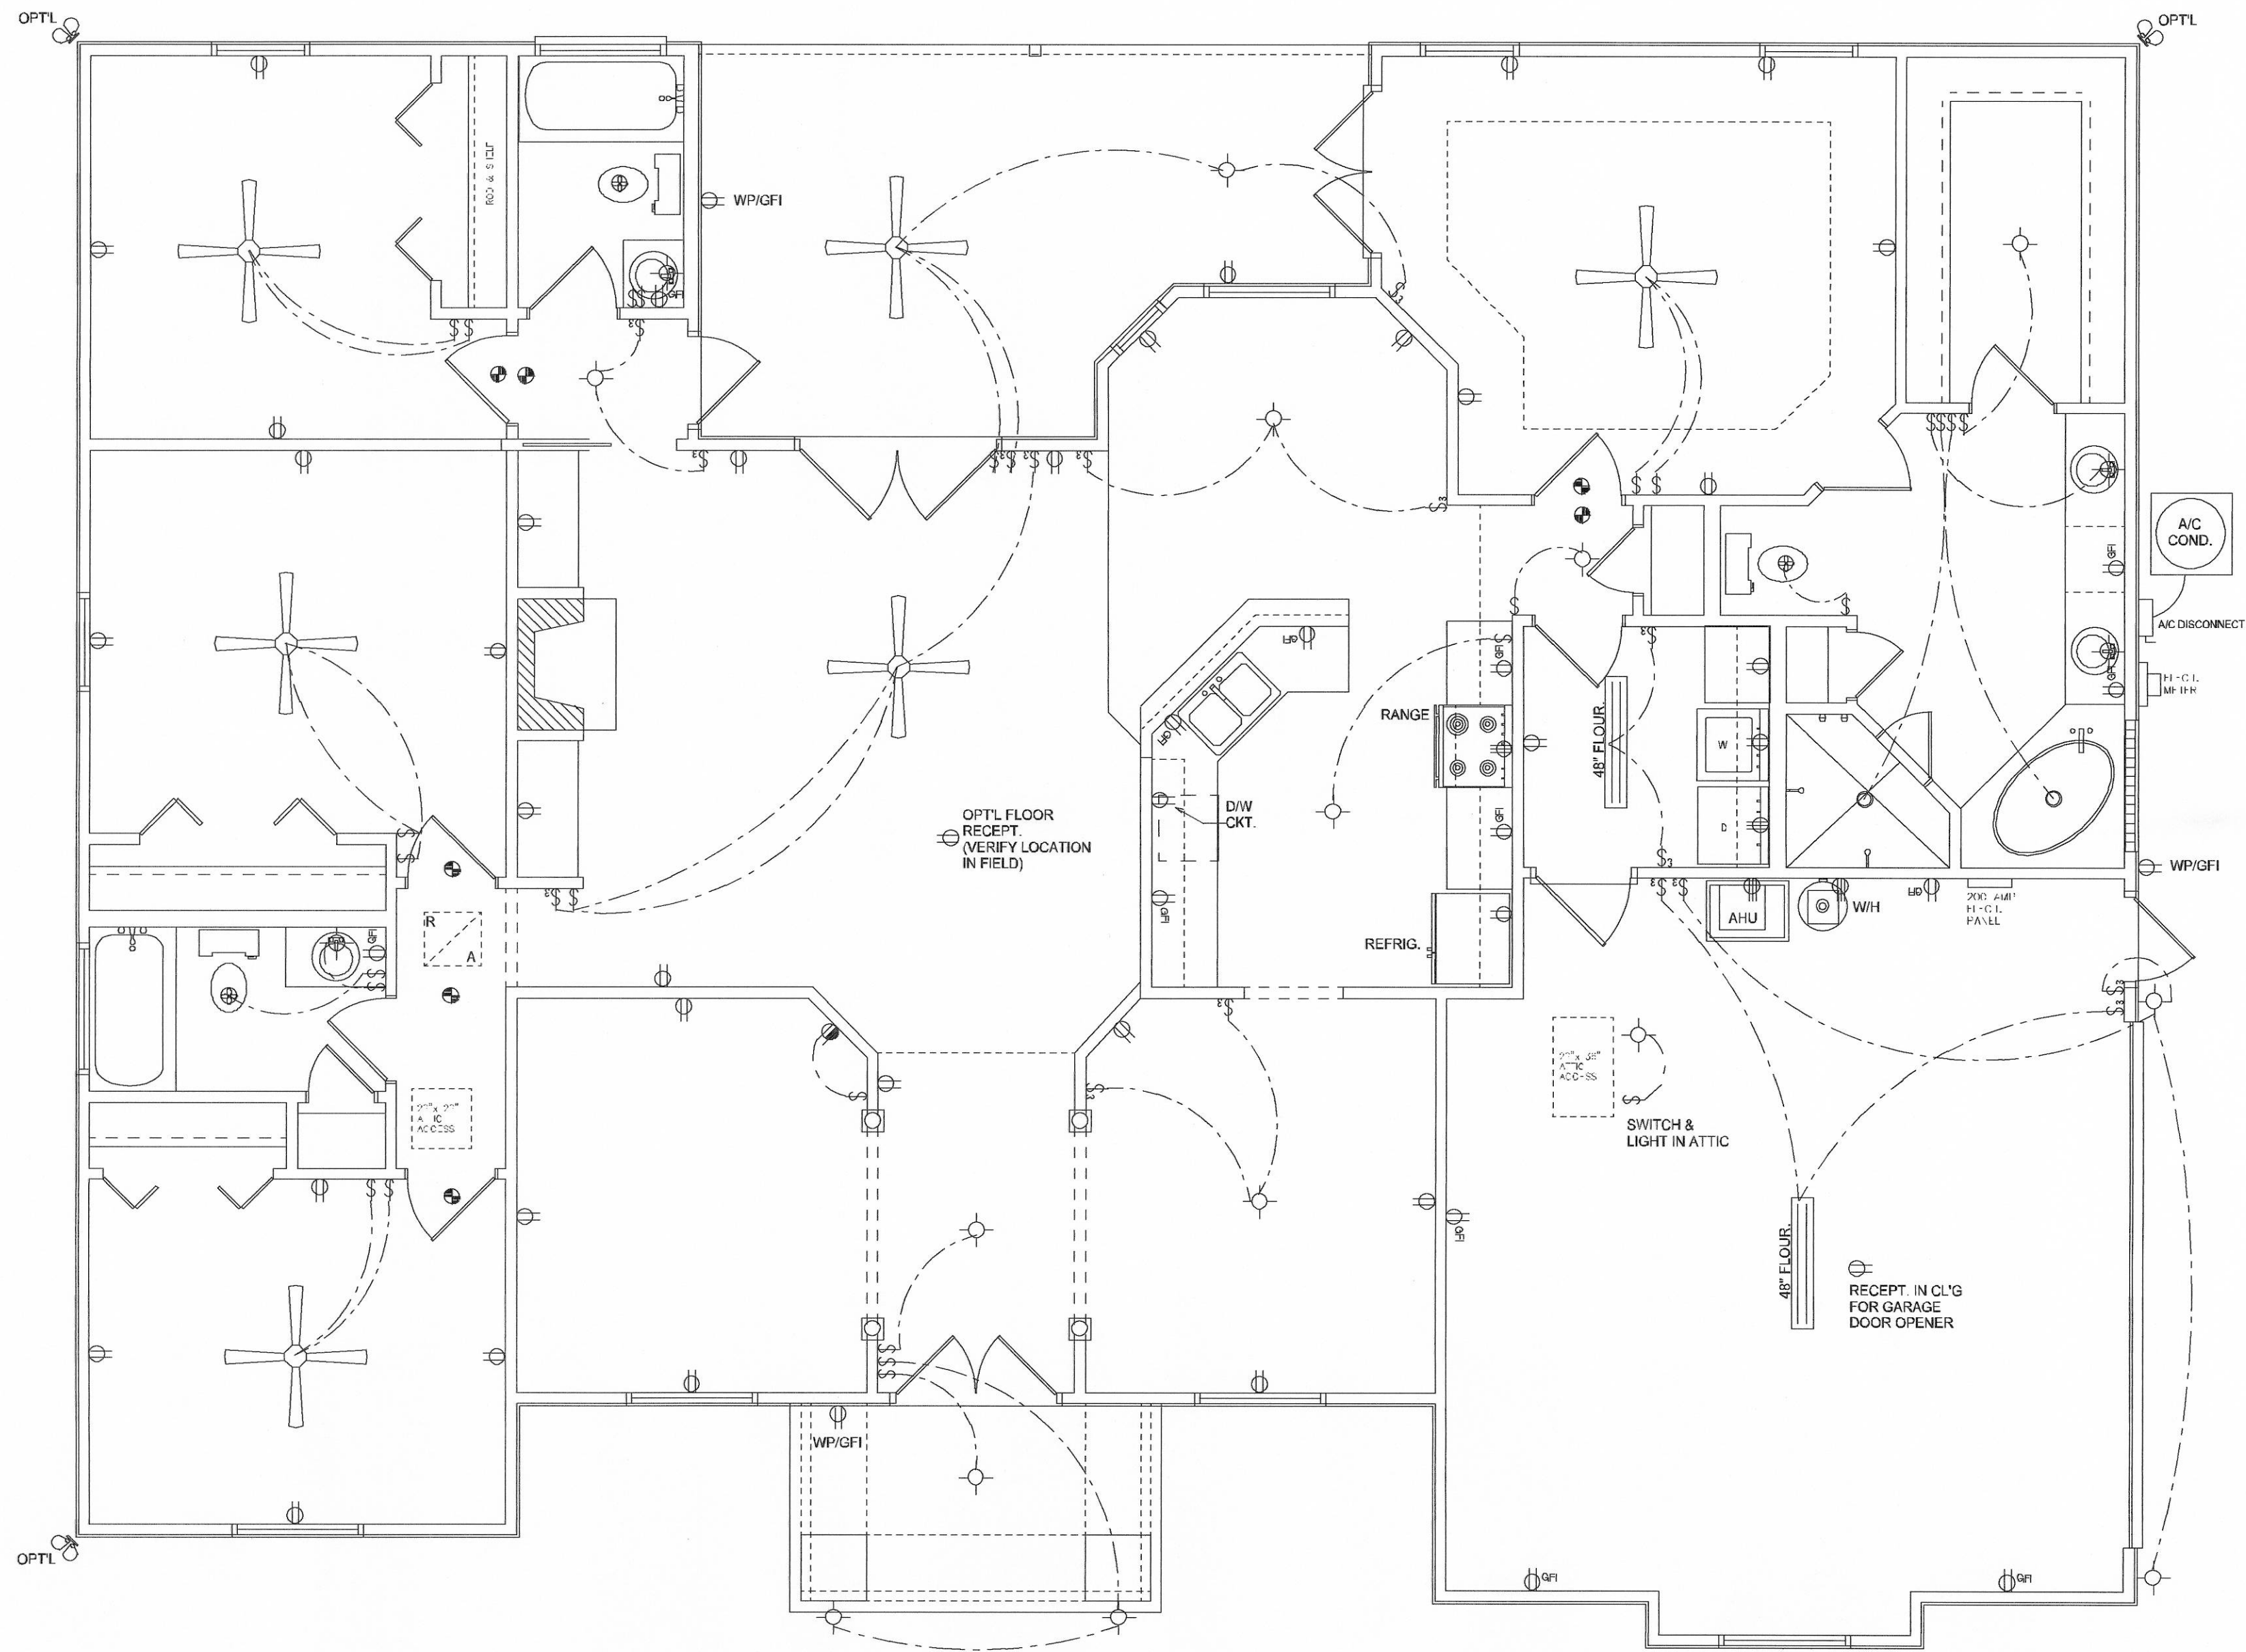

ELECTRICAL PLAN
SCALE: 1/4" = 1'-0"


REVISIONS
February 24, 2004



ELECTRICAL PLAN
SCALE: 1/4" = 1'-0"

ASPEN MODEL FOR:
AARON SIMQUE HOMES, INC.
PROJECT ADDRESS: LOT 68 CALLAWAY PHASE III

©WILLIAM MYERS
DESIGN
P.O. BOX 1613
LAKE CITY, FL 32066
(386) 758-8406
will@willmyers.net

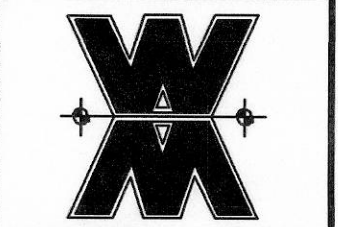

JOB NUMBER
040212

SHEET NUMBER
A4
OF 4 SHEETS

Will C. Myers