


*** REAR ELEVATION ***

SCALE : 1/4" = 1'-0"

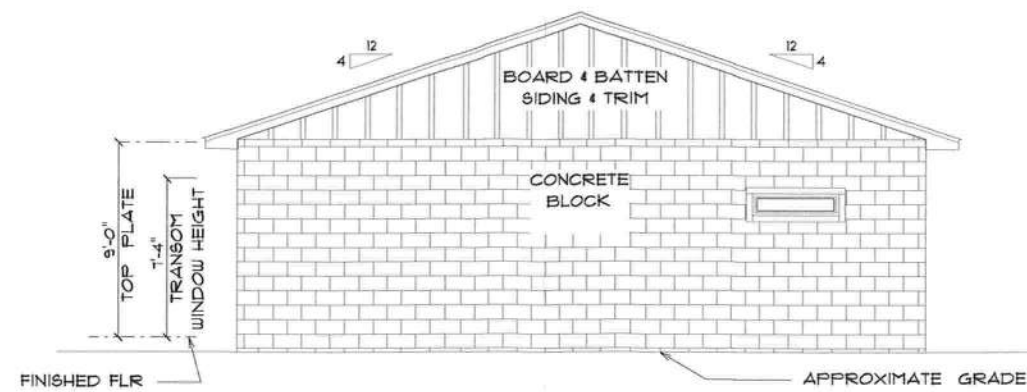

*** LEFT ELEVATION ***

SCALE : 1/4" = 1'-0"

**RESIDENCE
for
CHRIS & WEIDUS
SHOUSE**

OAK HAMMOCK
LOT #4
LAKE CITY, FLORIDA

Tsana M. Ruffo
2829 SW 5th St
Lake City, Florida, 32025
Cell: (386) 861-1191
Email: tsanaruffo@gmail.com

PRINTED DATE:
Wednesday, June 22, 2022

DRAWN BY: Tsana M. Ruffo CHECKED BY:

BUILDING CONTRACTOR:
GLENWOOD KING

FINALS DATE:

JOB NUMBER:

DRAWING NUMBER


A-5

OF 6 SHEETS

ELECTRICAL LEGEND		
ELECTRICAL	COUNT	SYMBOL
ceiling fan globe 01	3	+
pendant large	5	■
spotlight double	4	⊙
wall mount savoy	2	⊙
Smoke Detector	4	⊙
dimmer switch	2	⌞
light	10	⬠
outlet	27	○
outlet 220v	3	⊕
outlet gfi	17	⊕
outlet wp	7	⊕
switch	20	⌞
switch 3 way	4	⌞
vent light combo	2	⌞
vanity bar light 02	3	⌞
Cable Ethernet Wall Plate	3	⌞

ELECTRICAL PLAN NOTES

- E-1 WIRE ALL APPLIANCES, HVAC UNITS AND OTHER EQUIPMENT PER MANUFACTURERS SPECIFICATIONS.
- E-2 ALL INSTALLATIONS SHALL BE PER NATIONAL ELECTRIC CODE.
- E-3 ALL SMOKE /CARBON MONOXIDE DETECTORS SHALL BE 120V W/BATTERY BACKUP OF THE PHOTOELECTRIC TYPE, AND SHALL BE INTERLOCKED TOGETHER. INSTALL INSIDE AND NEAR ALL BEDROOMS AS PER CODE.
- E-4 TELEPHONE, TELEVISION AND OTHER LOW VOLTAGE DEVICES OR OUTLETS SHALL BE AS PER THE OWNERS DIRECTION AND IN ACCORDANCE WITH APPLICABLE SECTIONS OF NATIONAL ELCT. CODE LATEST EDITION.
- E-5 ELECTRICAL CONTRACTOR SHALL BE RESPONSIBLE FOR THE DESIGN AND SIZING OF ELECTRICAL SERVICE AND CIRCUITS.
- E-6 ENTRY OF SERVICE UNDERGROUND OR OVERHEAD) IS TO BE DETERMINED BY THE POWER COMPANY.
- ALL BEDROOM RECEPTALS ARE TO BE AFCI (ARC FAULT CIRCUIT INTERRUPT)
- 75% OF ALL PERMANENT LIGHTS TO BE ENERGY EFFICIENT.

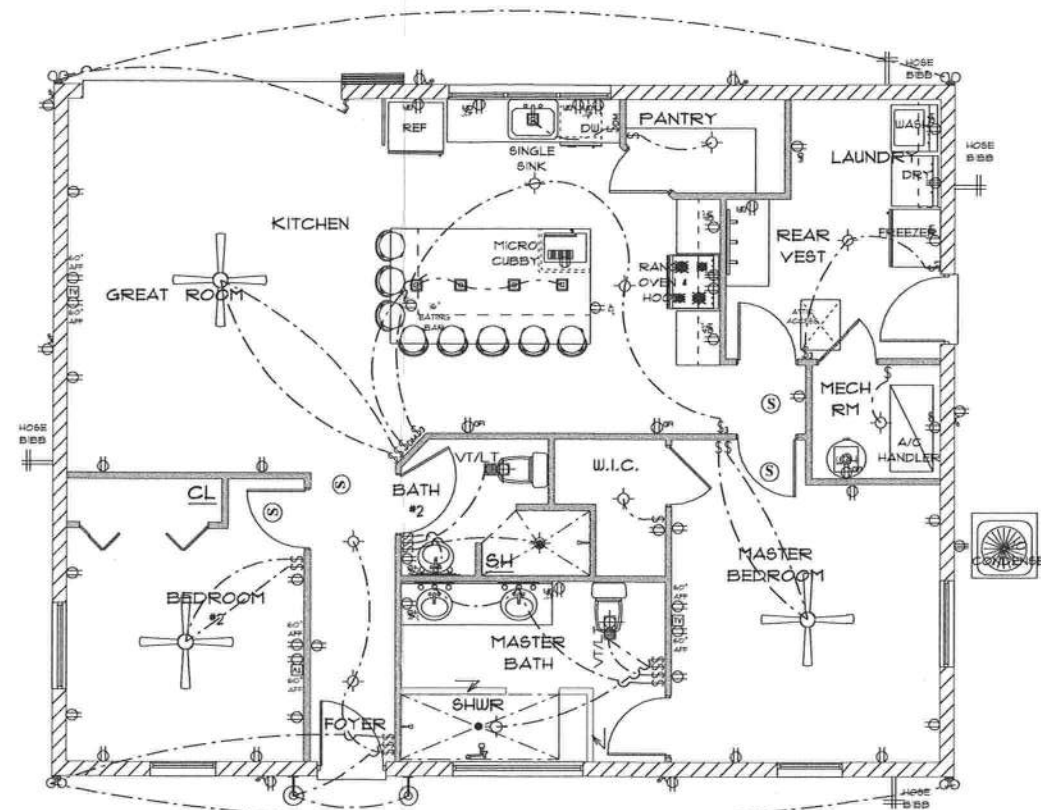

* ELECTRIC PLAN *

SCALE : 1/4" = 1'-0"

RESIDENCE
for
CHRIS & WEIDUS
SHOUSE
OAK HAMMOCK
LOT #4
LAKE CITY, FLORIDA

Teresa M. Ruffo
2025 SW 8R 41
Lake City Florida, 33025
Cell: (386) 867-1151
Email: terraruffo@gmail.com

PRINTED DATE:
Wednesday, June 22, 2022

DRAWN BY: Teresa M. Ruffo
CHECKED BY:

BUILDING CONTRACTOR:
GLENWOOD KING

FINALS DATE:

JOB NUMBER:

DRAWING NUMBER:

A-6
OF 6 SHEETS