


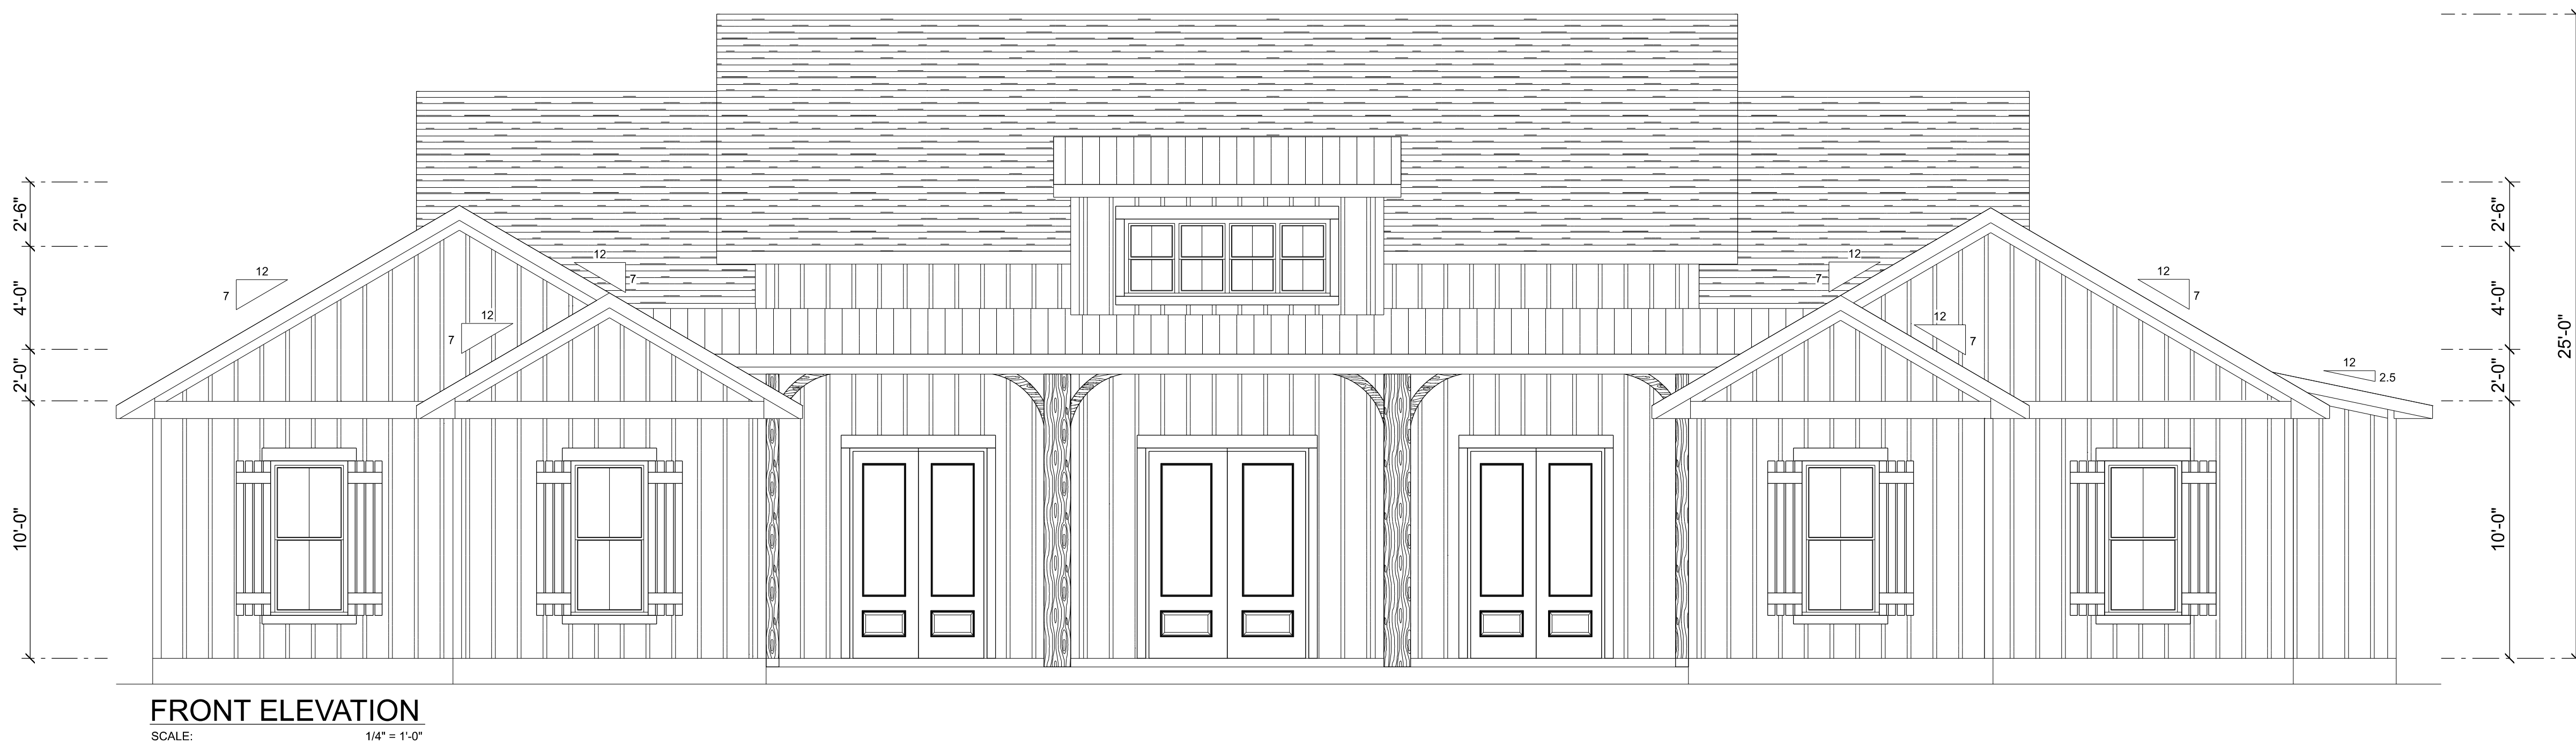

FRONT ELEVATION

SCALE: 1/4" = 1'-0"




REAR ELEVATION

SCALE: 1/4" = 1'-0"

REVISIONS SCHEDULE	
Aug. 18th, 2023	Proposal Drawing
Nov. 7th, 2023	Revisions


CONSTRUCTION LLC
818 W DUVAL ST, LAKE CITY, FL 32055

CUSTOM HOME FOR:
KLAMFOTH RESIDENCE
COLUMBIA COUNTY, FLORIDA

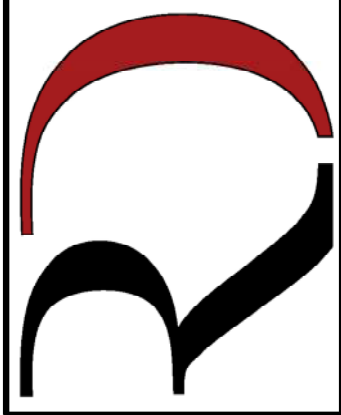
**RIDGEPOINT
DESIGN**
566 SW ARLINGTON BLVD, STE 101, LAKE CITY, FL 32025
P: 386-288-1188
E: RIDGEPOINTDESIGN@GMAIL.COM

SHEET NUMBER
A.1
OF 4 SHEETS



REVISIONS SCHEDULE	
Aug. 18th, 2023	Proposal Drawing
Nov. 7th, 2023	Revisions



CUSTOM HOME FOR:
KLAMFOTH RESIDENCE
COLUMBIA COUNTY, FLORIDA




SHEET NUMBER
A.2
OF 4 SHEETS



AREA		SUMMARY	
LIVING	2,954	S.F.	
FRONT PORCH	252	S.F.	
BACK PORCH	487	S.F.	
GARAGE	775	S.F.	
TOTAL AREA	4,468	S.F.	

SHEET NUMBER
A.3
OF 4 SHEETS

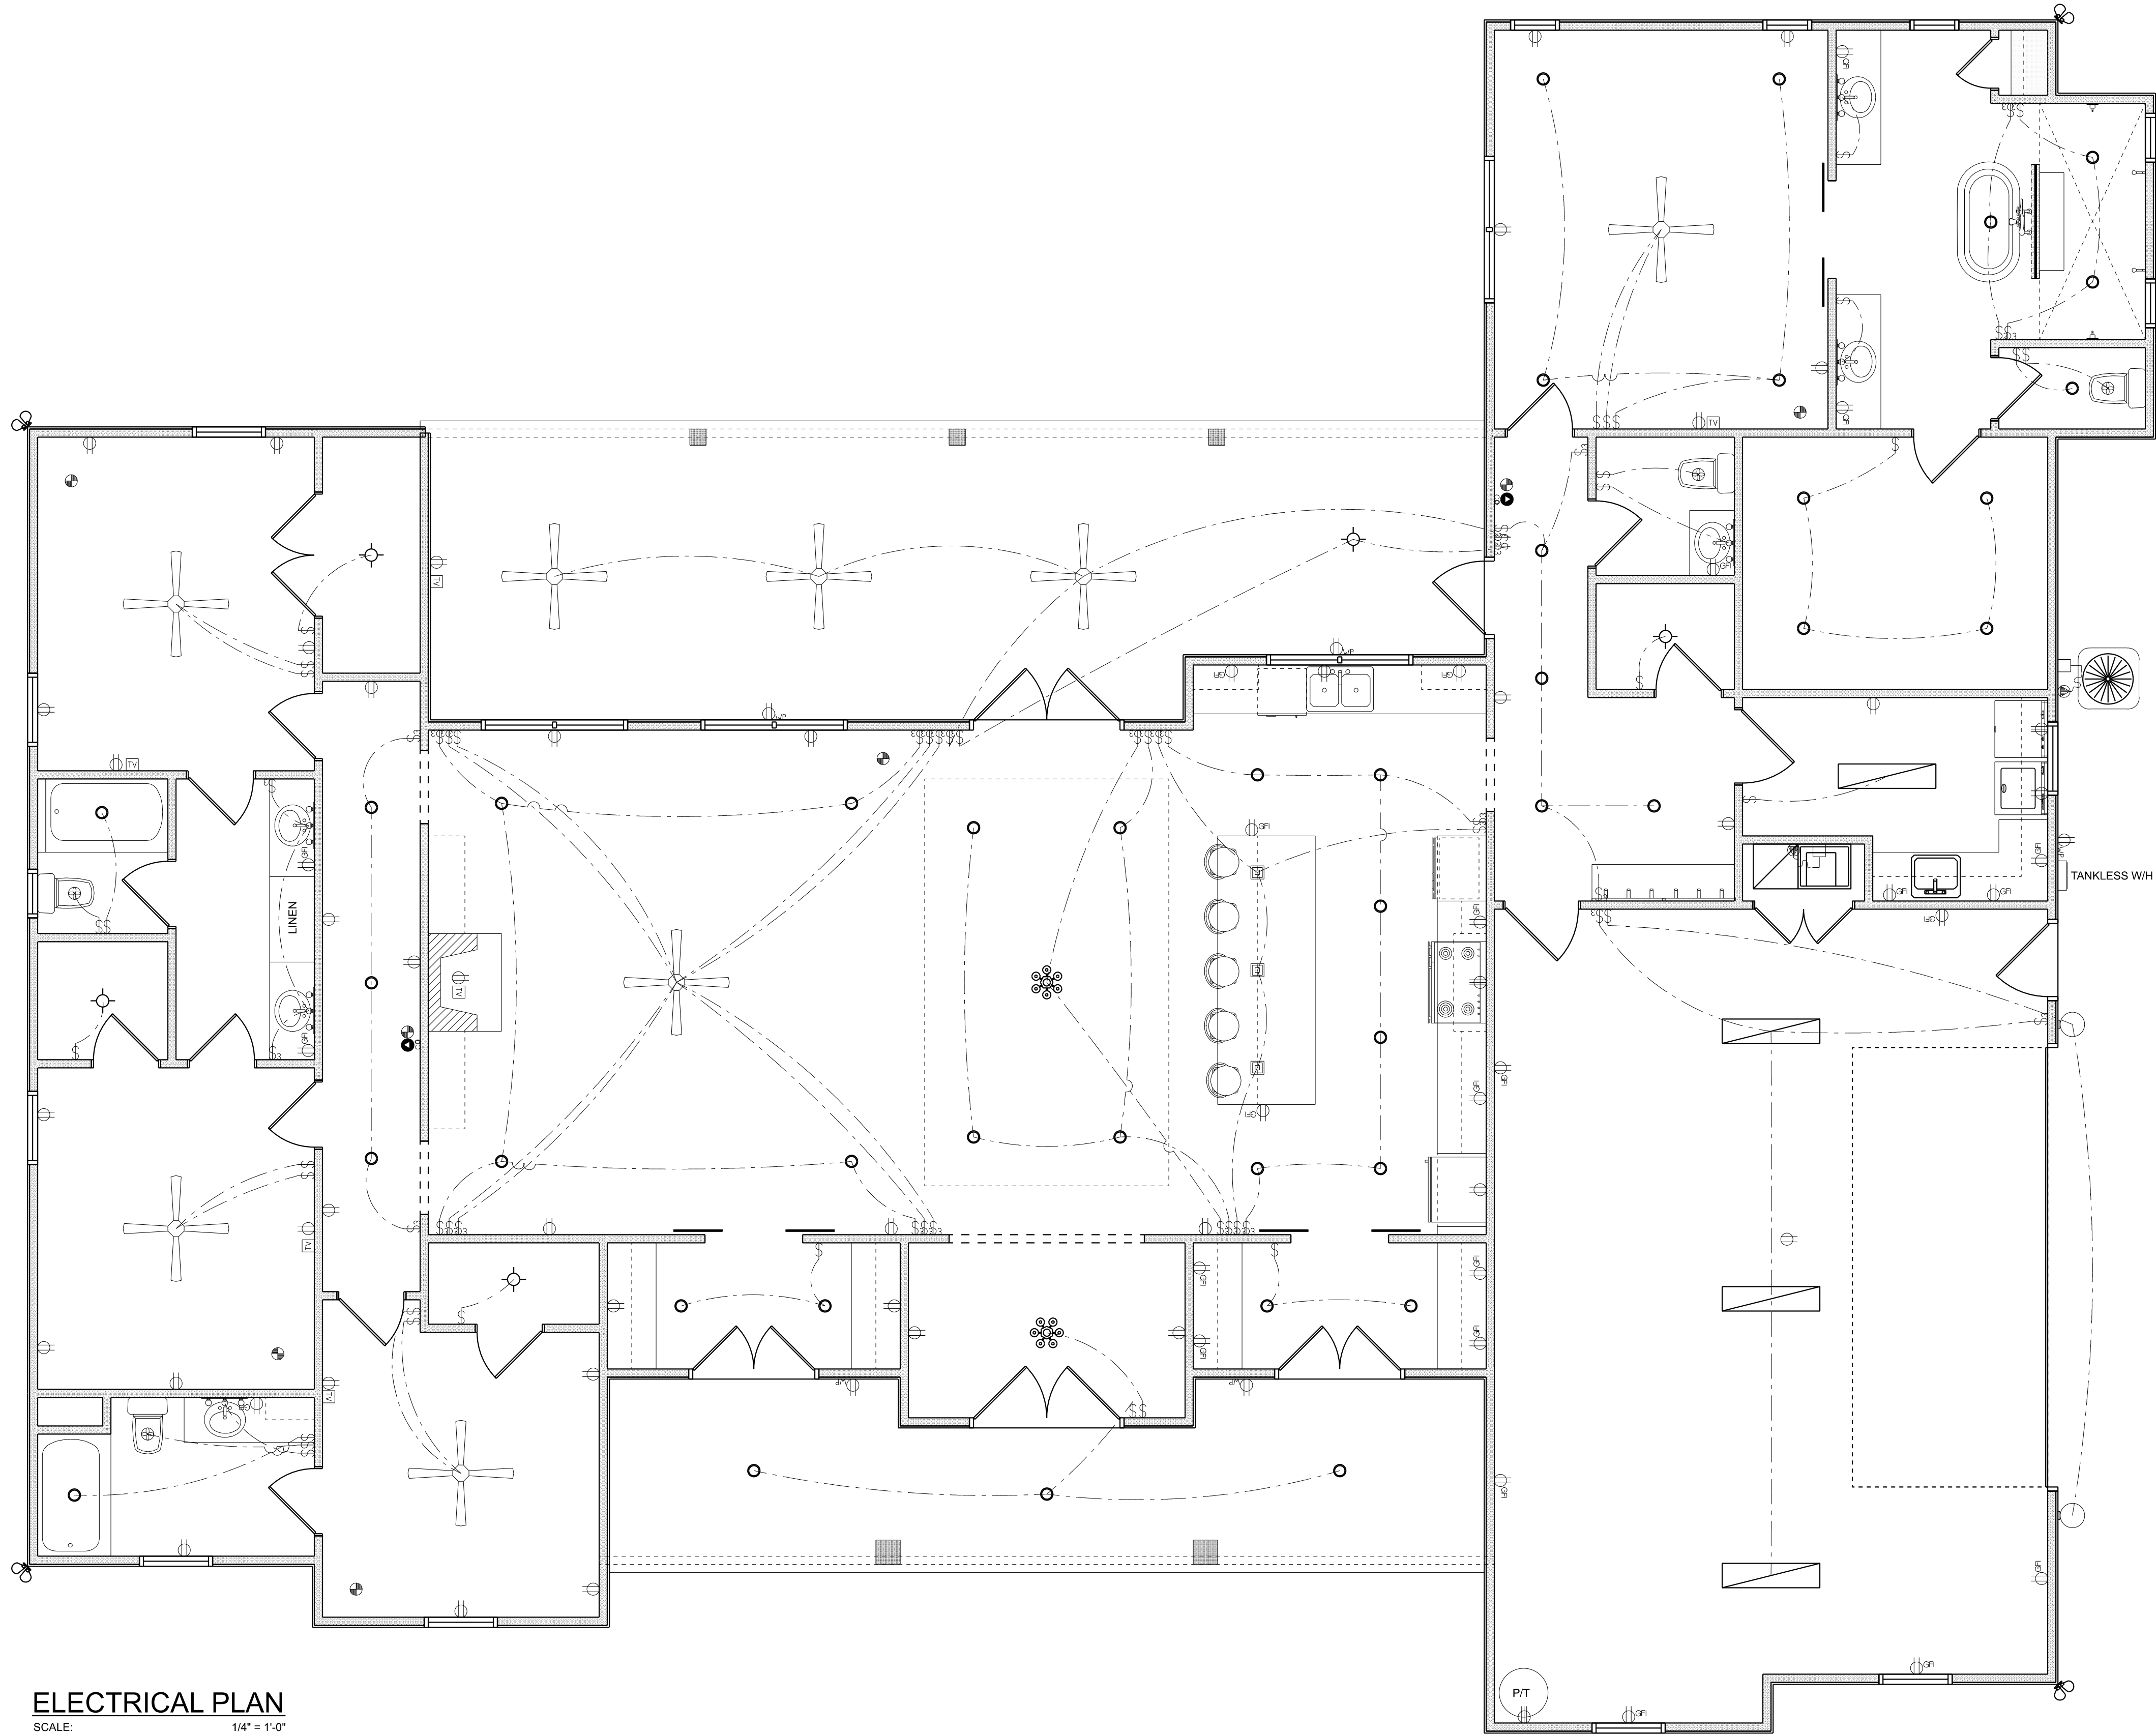

ELECTRICAL PLAN
SCALE: 1/4" = 1'-0"

ELECTRICAL LEGEND		
ELECTRICAL	COUNT	SYMBOL
CEILING FAN	8	
CAN LIGHT 6inch	42	
CHANDELIER	2	
LED CEILING LIGHT 1x4	4	
PENDANT LIGHT	3	
EXTERIOR SCONCE	2	
MOTION SECURITY LIGHT	4	
AC DISCONNECT	2	
CABLE TV OUTLET	6	
CARBON DETECTOR	2	
EXHAUST FAN	4	
OUTLET	41	
OUTLET 220v	3	
OUTLET GFI	25	
OUTLET WP	5	
SMOKE DETECTOR	7	
STANDARD LIGHT	5	
SWITCH	31	
SWITCH 3 WAY	39	
VANITY BAR LIGHT - SMALL	6	

ELECTRICAL PLAN NOTES:

- INSTALLATION SHALL BE PER LATEST NAT'L ELECTRIC CODE.
- WIRE ALL APPLIANCES, HVAC UNITS AND OTHER EQUIPMENT PER MANUF. SPECIFICATIONS
- CONSULT WITH THE OWNER FOR THE NUMBER OF SEPERATE TELEPHONE LINES TO BE INSTALLED
- ALL SMOKE DETECTORS SHALL BE 120v W/ BATTERY BACKUP OF THE PHOTOELECTRIC TYPE, AND SHALL BE INTERLOCKED TOGETHER. INSTALL INSIDE AND NEAR ALL BEDROOMS
- TELEPHONE, TELEVISION AND OTHER LOW VOLTAGE DEVICES OR OUTLETS SHALL BE AS PER THE OWNER'S DIRECTIONS. & IN ACCORDANCE W/ APPLICABLE SECTIONS OF NEC-LATEST EDITION.
- ALL RECEPTICALS, NOT OTHERWISE NOTED, SHALL BE ARC FAULT INTERRUPTER TYPE, EXCEPT DEDICATED OUTLETS
- ALL RECEPTICALS IN WET AREAS SHALL BE GROUND FAULT INTERRUPTER TYPE (GFI)
- ALL EXTERIOR RECEPTICALS SHALL BE WEATHERPROOF GROUD FAULT INTERRUPTER TYPE (WP/GFI)

NOTE:
ELECTRICAL CONTR SHALL PREPARE "AS-BUILT" SHOP DWGS INDICATING ALL ELECTRICAL WORK, INCLUDING ANY CHANGES TO THE ELEC. PLAN, ADDNS TO THE ELEC. PLAN, RISER DIAGRAM, AS-BUILT PANEL SCHEDULE W/ ALL CKTS IDENTIFIED W/ CKT Nr. DESCRIPTION & BRKR. SERVICE ENT. & ALL UNDERGROUND WIRE LOCATIONS/ROUTING / DEPTH. RISER DIA. SHALL INCLUDE WIRE SIZES/TYPE & EQUIPMENT TYPE W/ RATINGS & LOADS.
CONTRACTOR SHALL PROVIDE 1 COPY OF AS-BUILT DWGS TO OWNER & 1 COPY TO THE PERMIT ISSUING AUTHORITY

REVISIONS SCHEDULE	
Aug. 18th, 2023	Proposal Drawing
Nov. 7th, 2023	Revisions


CONSTRUCTION LLC
818 W DUVAL ST, LAKE CITY, FL 32055

CUSTOM HOME FOR:
KLAMFOTH RESIDENCE
COLUMBIA COUNTY, FLORIDA


RIDGEPOINT DESIGN
566 SW ARLINGTON BLVD, STE 101, LAKE CITY, FL 32025
P: 386-288-1188
E: RIDGEPOINTDESIGN@GMAIL.COM

SHEET NUMBER
A.4
OF 4 SHEETS