



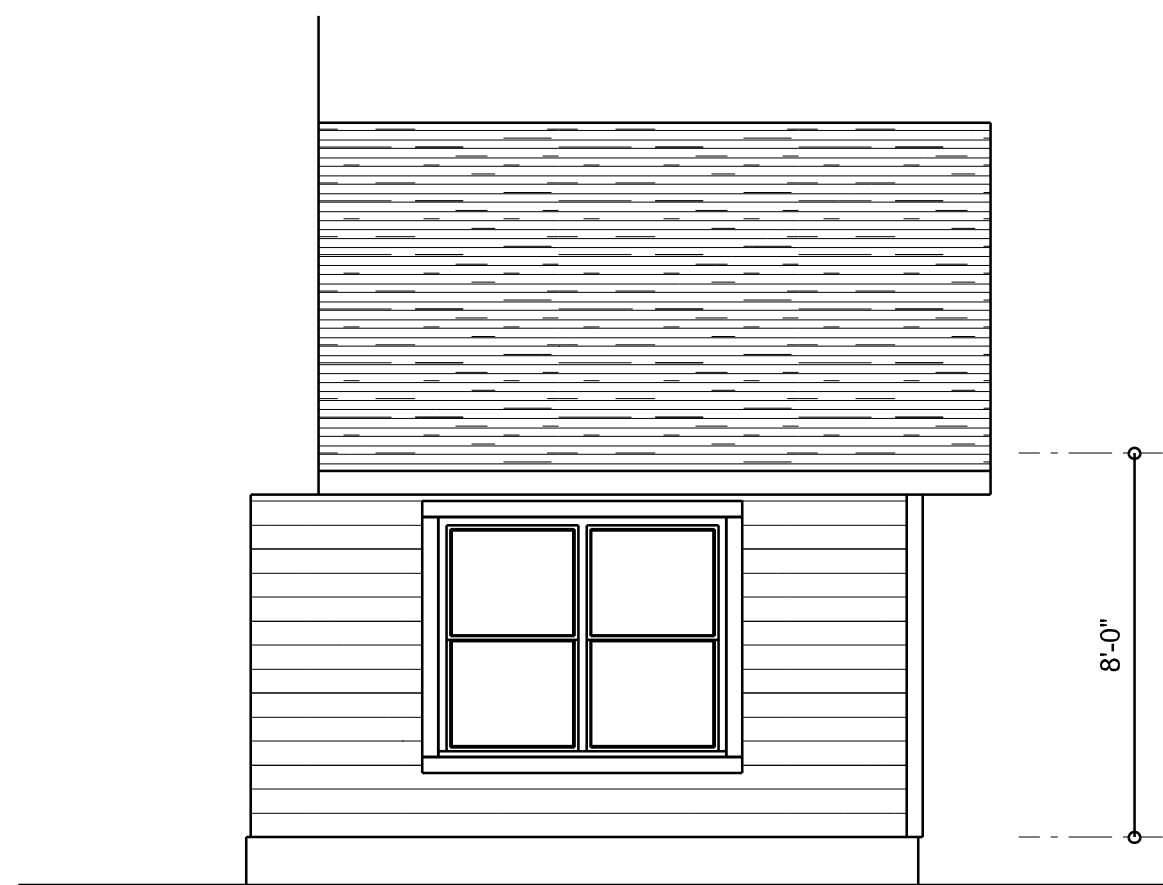


LEFT ELEVATION
SCALE: 1/4" = 1'-0"

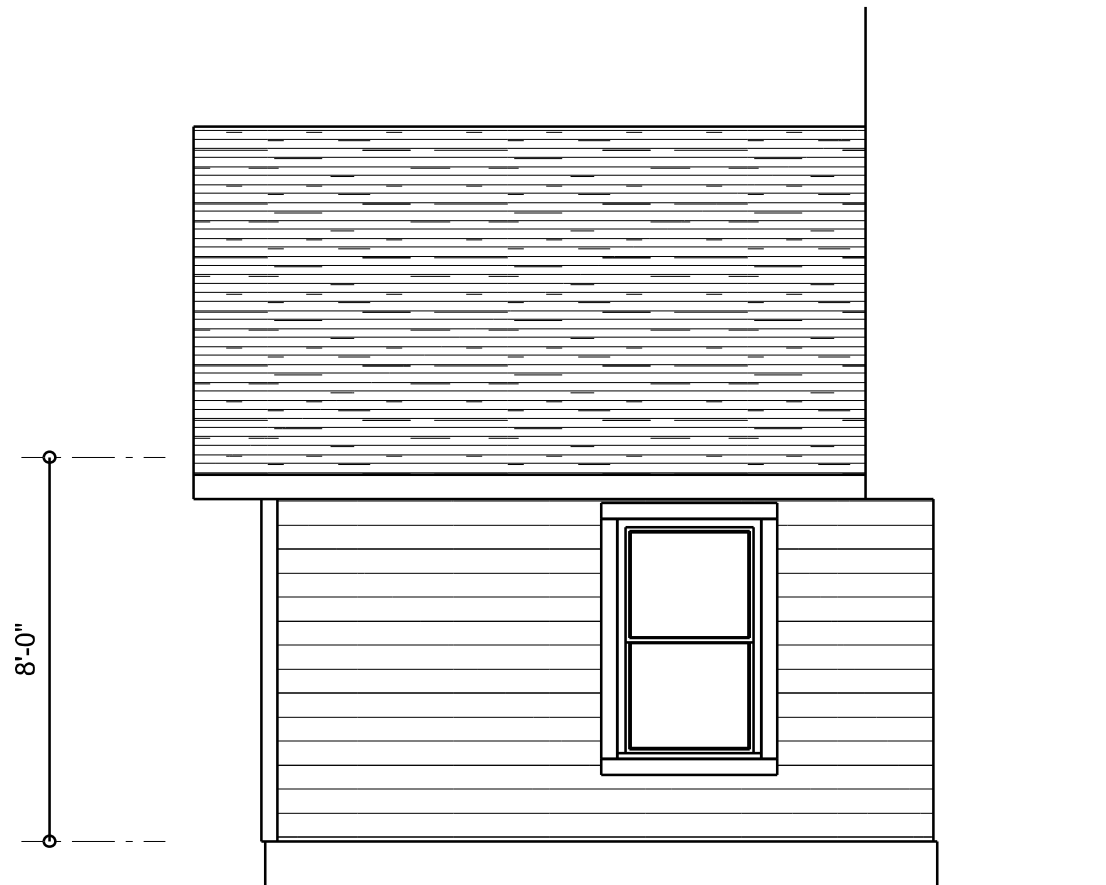


RIGHT ELEVATION
SCALE: 1/4" = 1'-0"


ELECTRICAL LEGEND		
ELECTRICAL	COUNT	SYMBOL
CEILING FAN	1	
CAN LIGHT 6inch	2	
CABLE TV OUTLET	1	
CAT6 OUTLET	1	
EXHAUST FAN	1	
EXHAUST FAN & LIGHT COMBO	1	
OUTLET	5	
OUTLET GFI	2	
SMOKE DETECTOR	1	
SWITCH	7	
VANITY BAR LIGHT - SMALL	2	

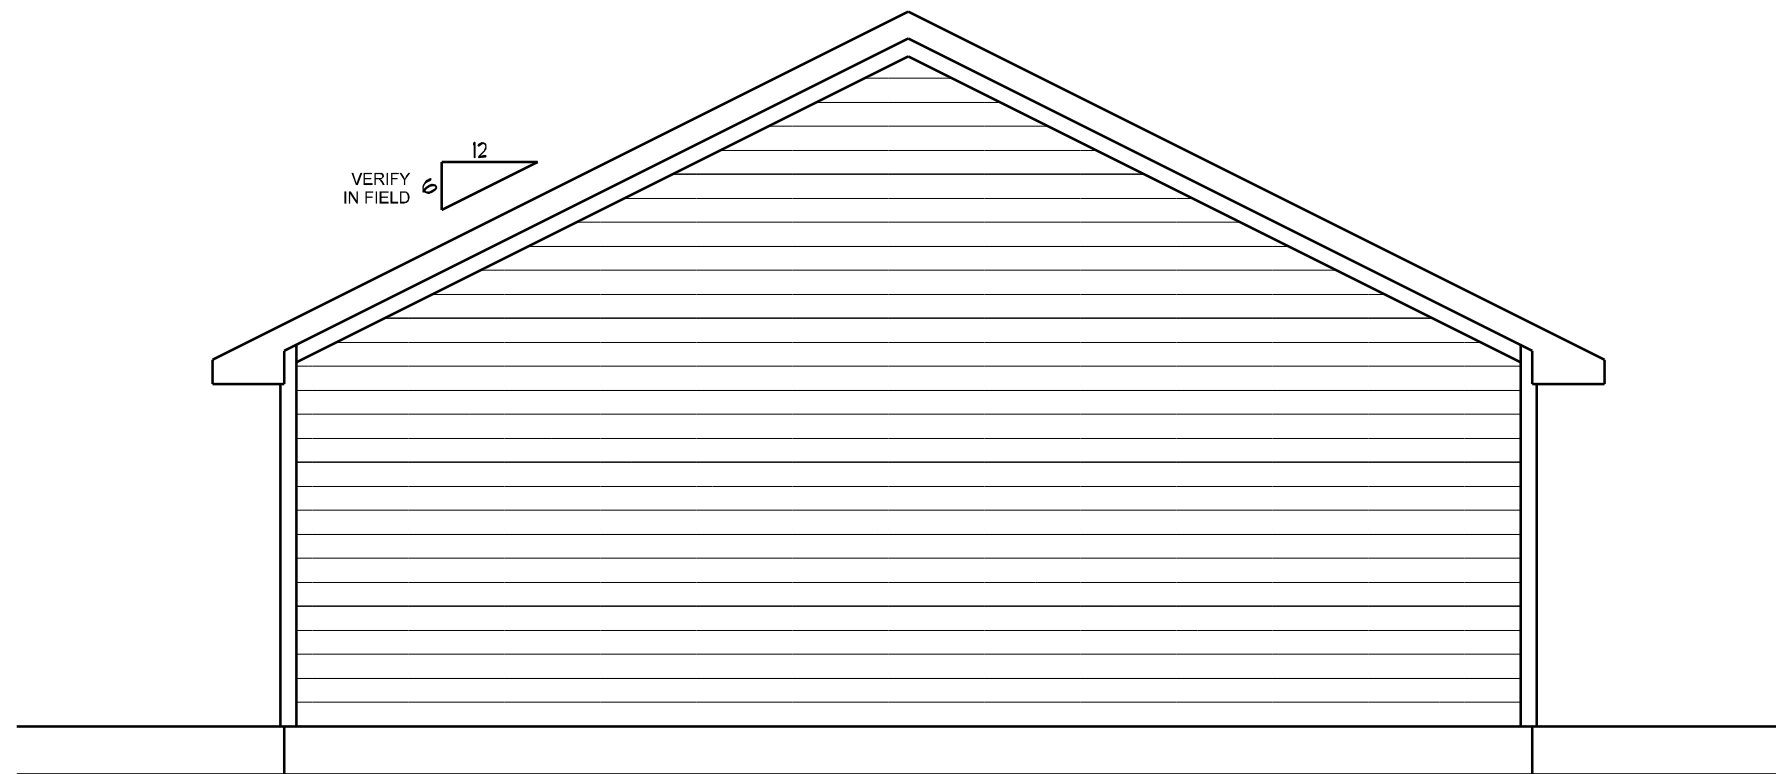

REAR ELEVATION
SCALE: 1/4" = 1'-0"

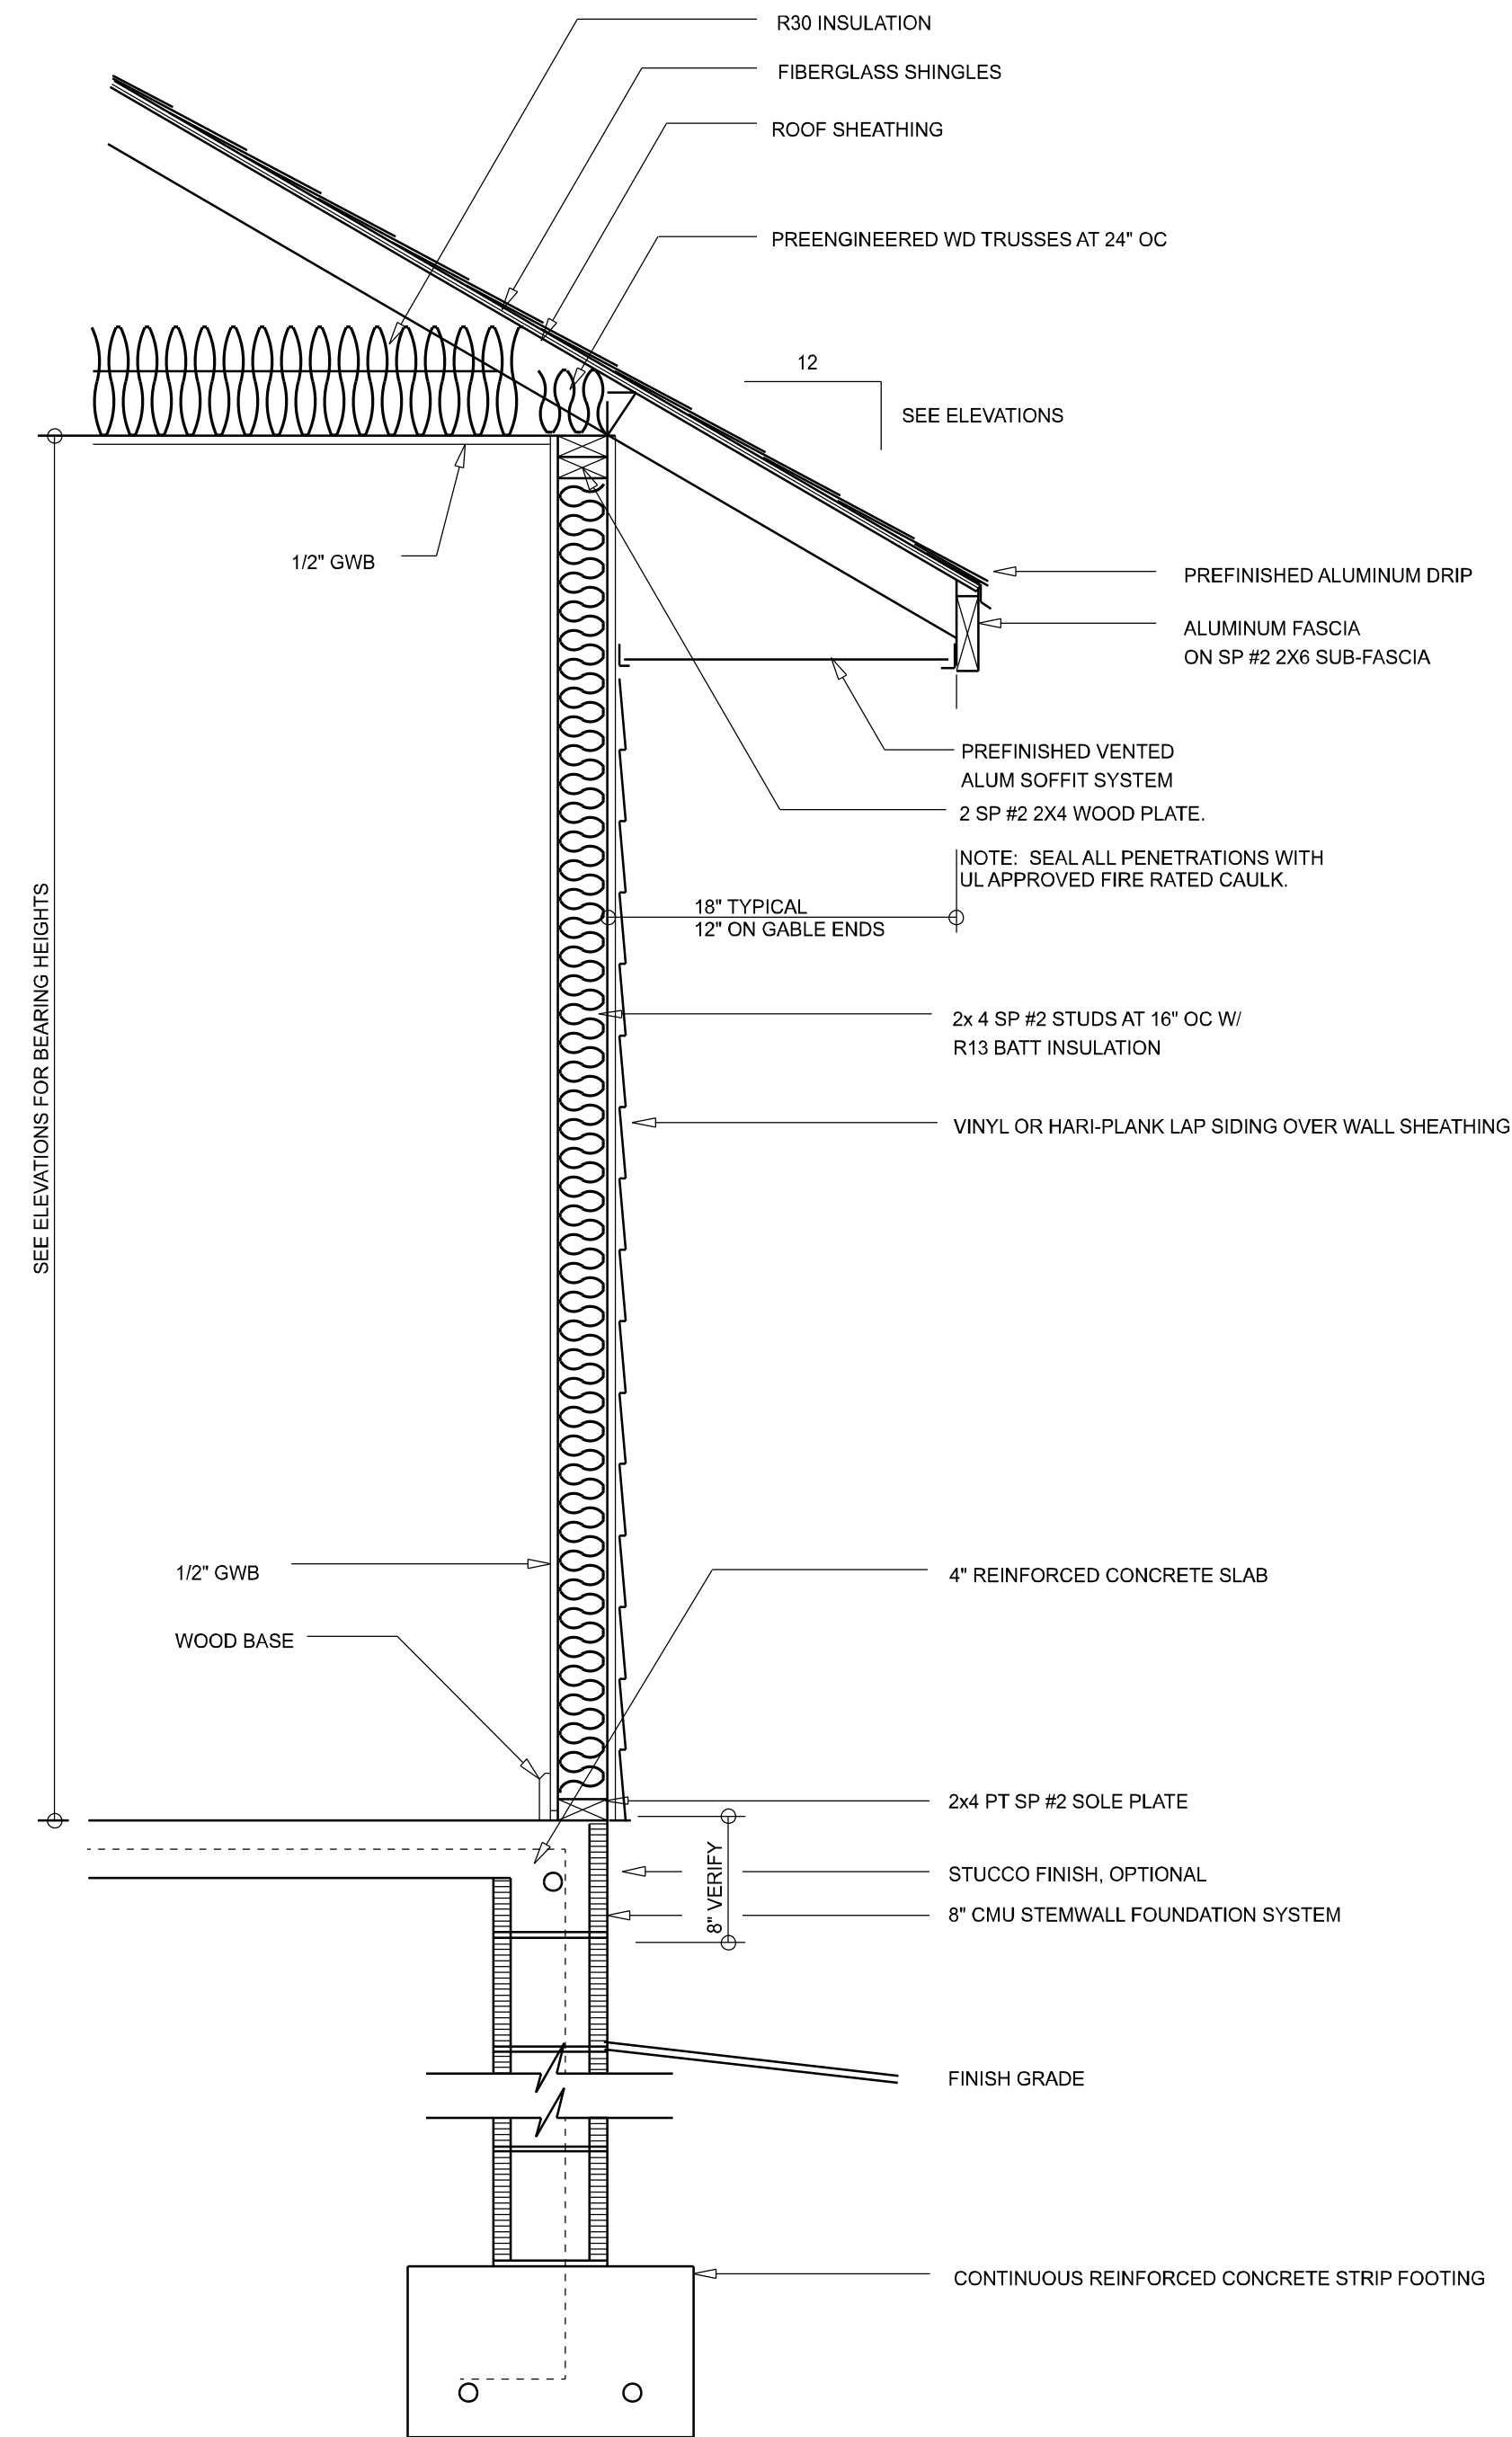


TYPICAL WALL SECTION
SCALE: 1" = 1'-0"

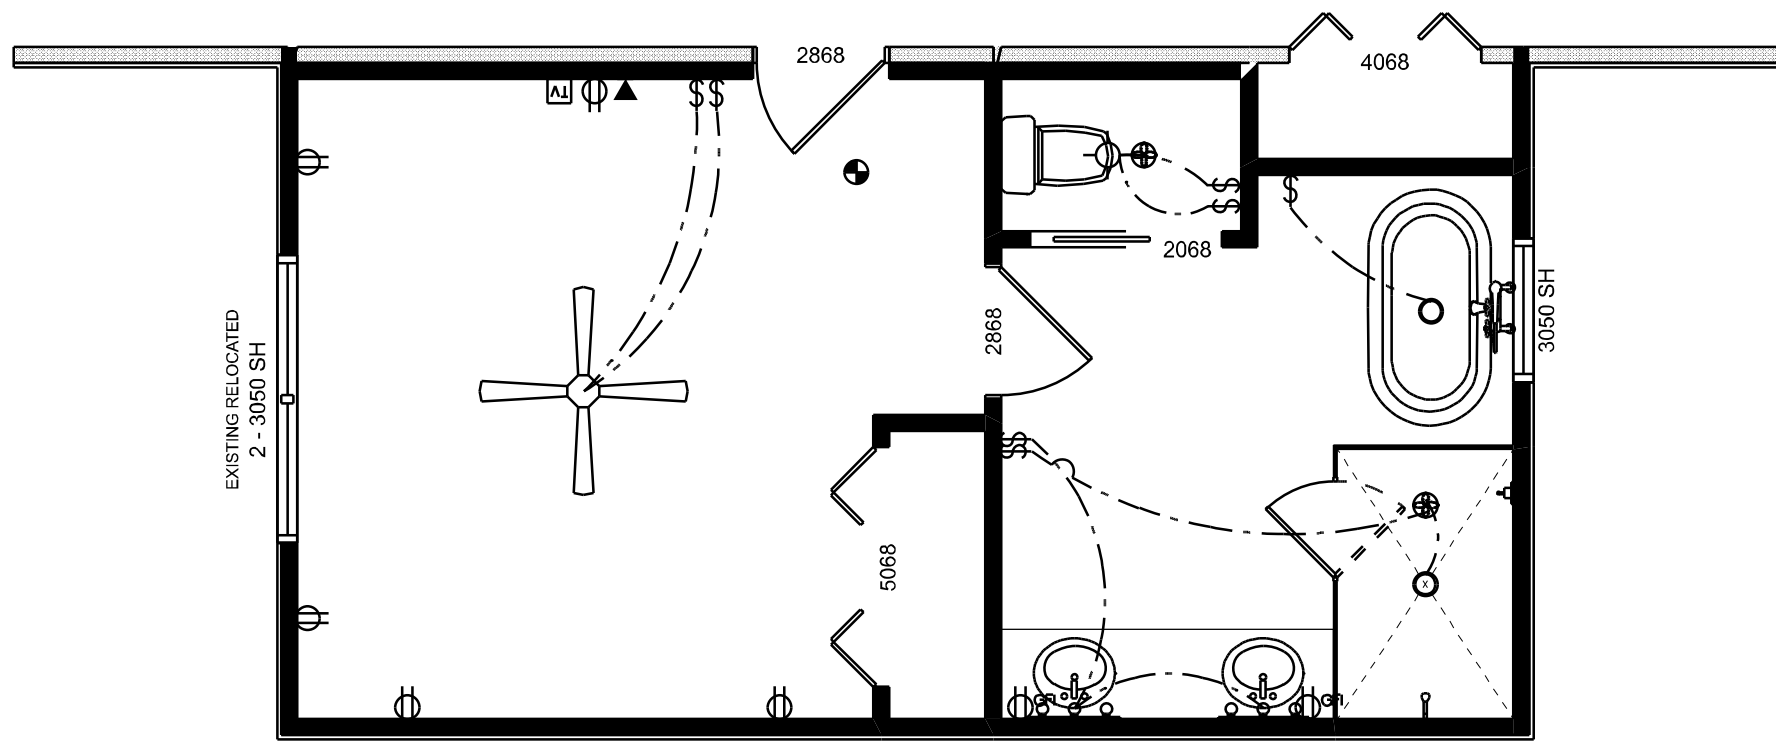

ELECTRICAL PLAN
SCALE: 1/4" = 1'-0"

AREA SUMMARY		
LIVING	364	S.F.
TOTAL AREA	364	S.F.

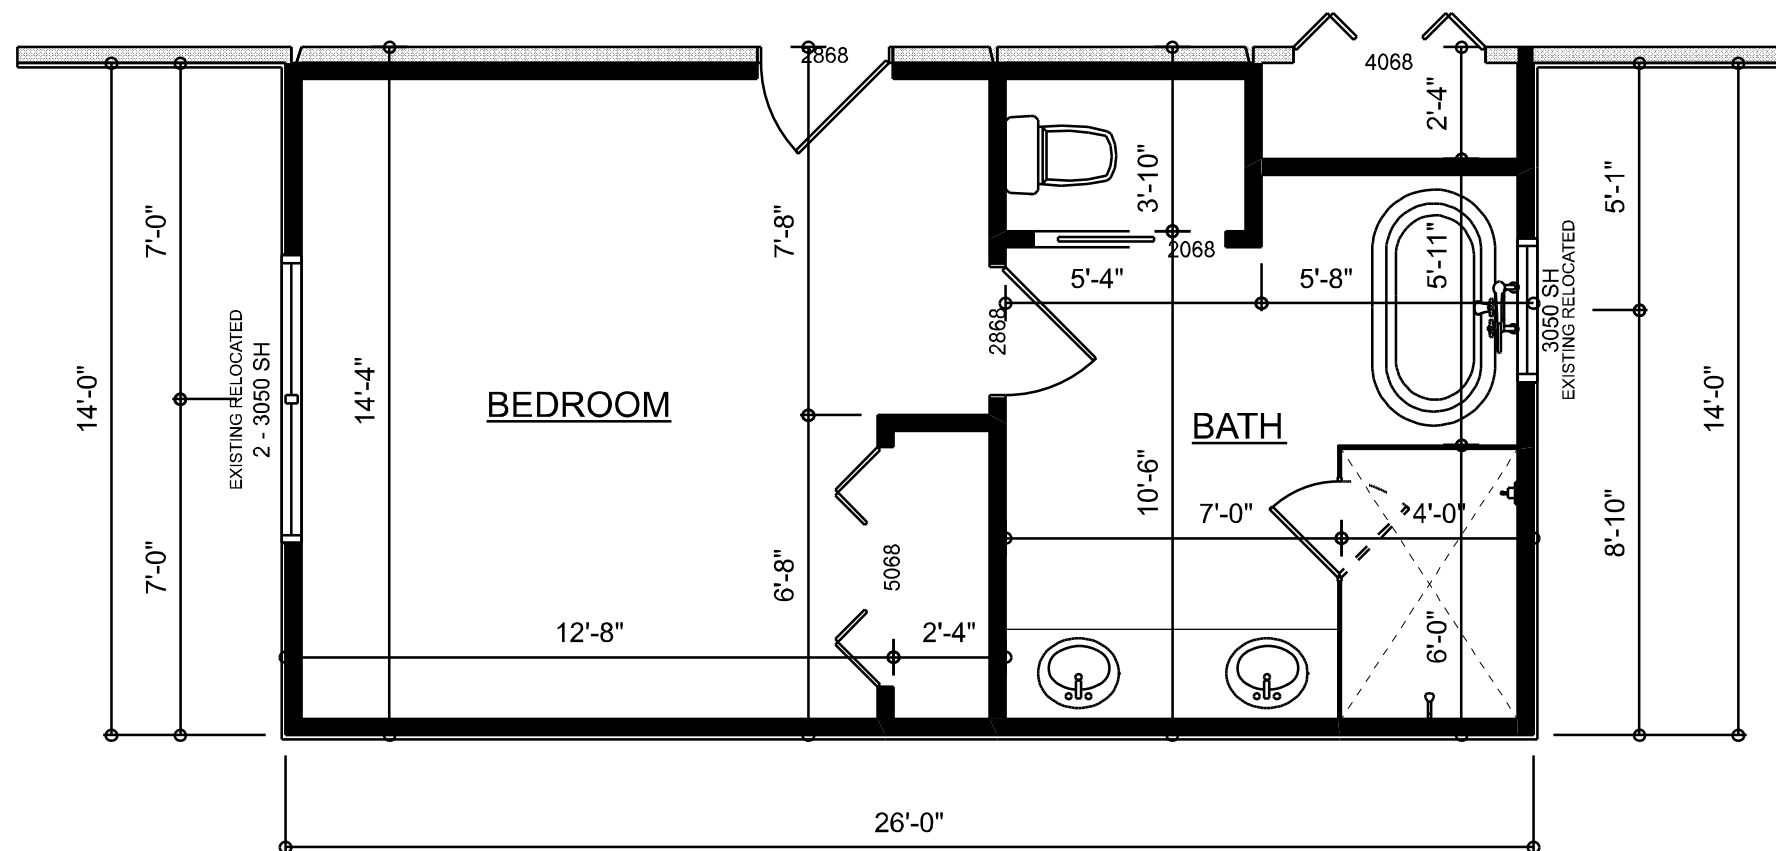

ADDITION FLOOR PLAN
SCALE: 1/4" = 1'-0"

REVISIONS SCHEDULE

PROPOSAL June 5th, 2024

REVISIONS June 24th, 2024

AN ADDITION FOR:
FRANKLIN RESIDENCE

COLUMBIA COUNTY, FLORIDA



SHEET NUMBER

A.1
OF 5 SHEETS