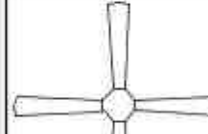


 

 
 
 
 


 
 


 


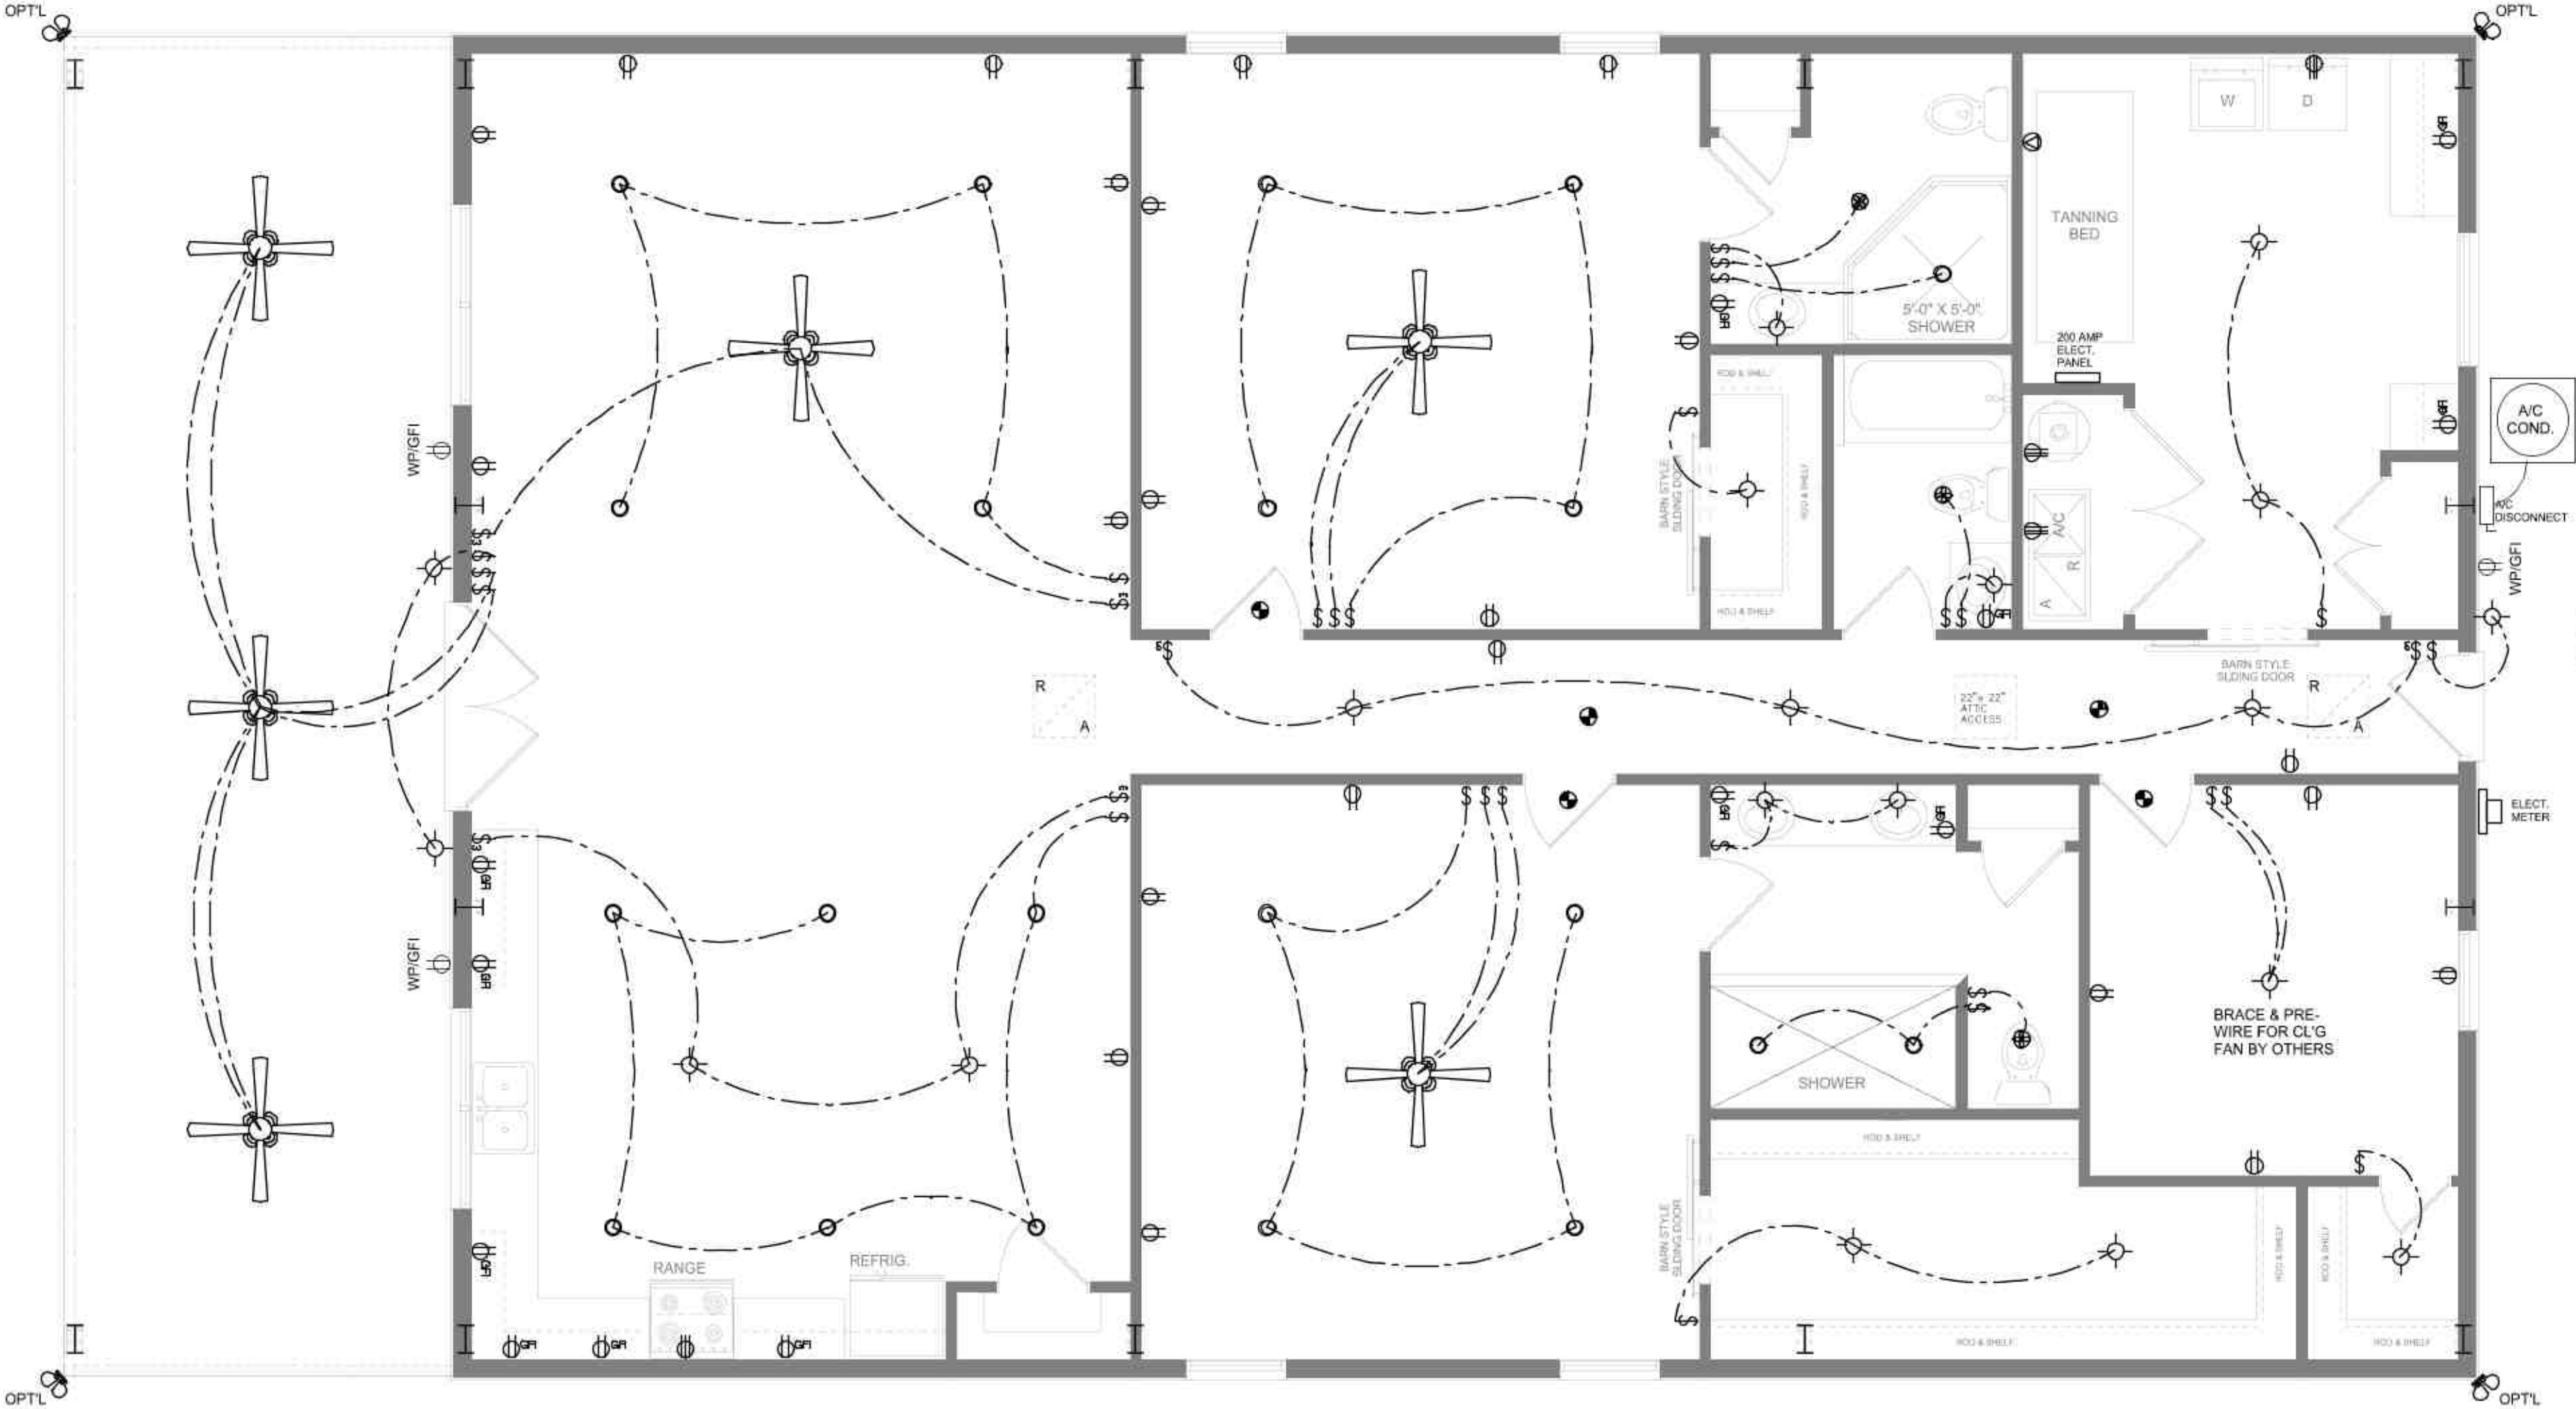
ELECTRICAL LEGEND	
	CEILING FAN (PRE-WIRE FOR LIGHT KIT)
	DOUBLE SECURITY LIGHT
	RECESSED CAN LIGHT
	BATH EXHAUST FAN
	LIGHT FIXTURE
	DUPLEX OUTLET (AFCI & TAMPER RESISTANT)
	220v OUTLET
	GFI DUPLEX OUTLET (PER NEC 406.8)
	TELEVISION JACK
	TELEPHONE JACK
	SMOKE / CARBON MONOXIDE DETECTOR (see note below)
	WALL SWITCH
	3 WAY WALL SWITCH
	WATER PROOF GFI OUTLET
	48" FLOOR
	2 OR 4 TUB FLUORESCENT FIXTURE

NOTE:  
ALL INTERIOR RECEPTACLES SHALL BE AFCI  
(ARC FAULT CIRCUIT INTERRUPT) PER NEC 210.12 & TAMPER RESISTANT PER  
NEC 406.11

ALL SMOKE DETECTORS BE A COMBO SMOKE & CARBON MONOXIDE DETECTOR  
AND SHALL HAVE BATTERY BACKUP POWER  
AND ALL WIRED TOGETHER SO IF ANY ONE UNIT IS ACTUATED THEY  
ALL ACTIVATE.

THE ELECTRICAL SERVICE OVERCURRENT PROTECTION DEVICE SHALL BE  
INSTALLED ON THE EXTERIOR OF STRUCTURES TO SERVE AS A DISCONNECT MEANS.  
CONDUCTORS USED FROM THE EXTERIOR DISCONNECTING MEANS TO A PANEL OR SUB  
PANEL SHALL HAVE FOUR-WIRE CONDUCTORS, OF WHICH ONE CONDUCTOR  
SHALL BE USED AS AN EQUIPMENT GROUND.

IT IS THE LICENSED ELECTRICAL CONTRACTORS RESPONSIBILITY TO INSURE THAT ALL  
WORK PERFORMED AND EQUIPMENT INSTALLED MEETS OR EXCEEDS THE NFPA70 2014 NATIONAL  
ELECTRIC CODE AND ALL OTHER LOCAL CODES AND ORDINANCES.



ELECTRICAL PLAN  
SCALE: 1/4" = 1'-0"

NOTE: ALL DRAWINGS NOT TO BE SCALED, WRITTEN DIMENSIONS TAKE PRECEDENCE OVER SCALED DIMENSIONS

REVISIONS  
April 24, 2020

  
Wm C Myers

A CUSTOM HOME FOR:  
**MIKE & JODI BOYKO**  
PROJECT ADDRESS: 110 JOEL GLEN, WHITE SPRINGS, FLORIDA 32055  
(COLUMBIA COUNTY)

  
Digitally signed by: N. P. GEISLER  
DN: cn=N. P. GEISLER, o=US  
O=AR0007005 OU=ARCHITECT  
Date: 2020.04.27 16:52:40 -0500

  
NICHOLAS PAUL  
GEISLER  
ARCHITECT  
N.C.A.A.B. Certified  
1758 NW Brown Rd.  
Lake City, FL 32055  
(386) 365-4355

JOINT VENTURED WITH  
  
© WM DESIGN &  
ASSOCIATES, INC.  
428 SW COMMERCE DR., STE. 130  
LAKE CITY, FL 32025  
(386) 758-8406  
wm@wmymyers.net

  
JOB NUMBER  
20200214  
DATE:  
April 24, 2020  
SHEET NUMBER  
**A.3**