



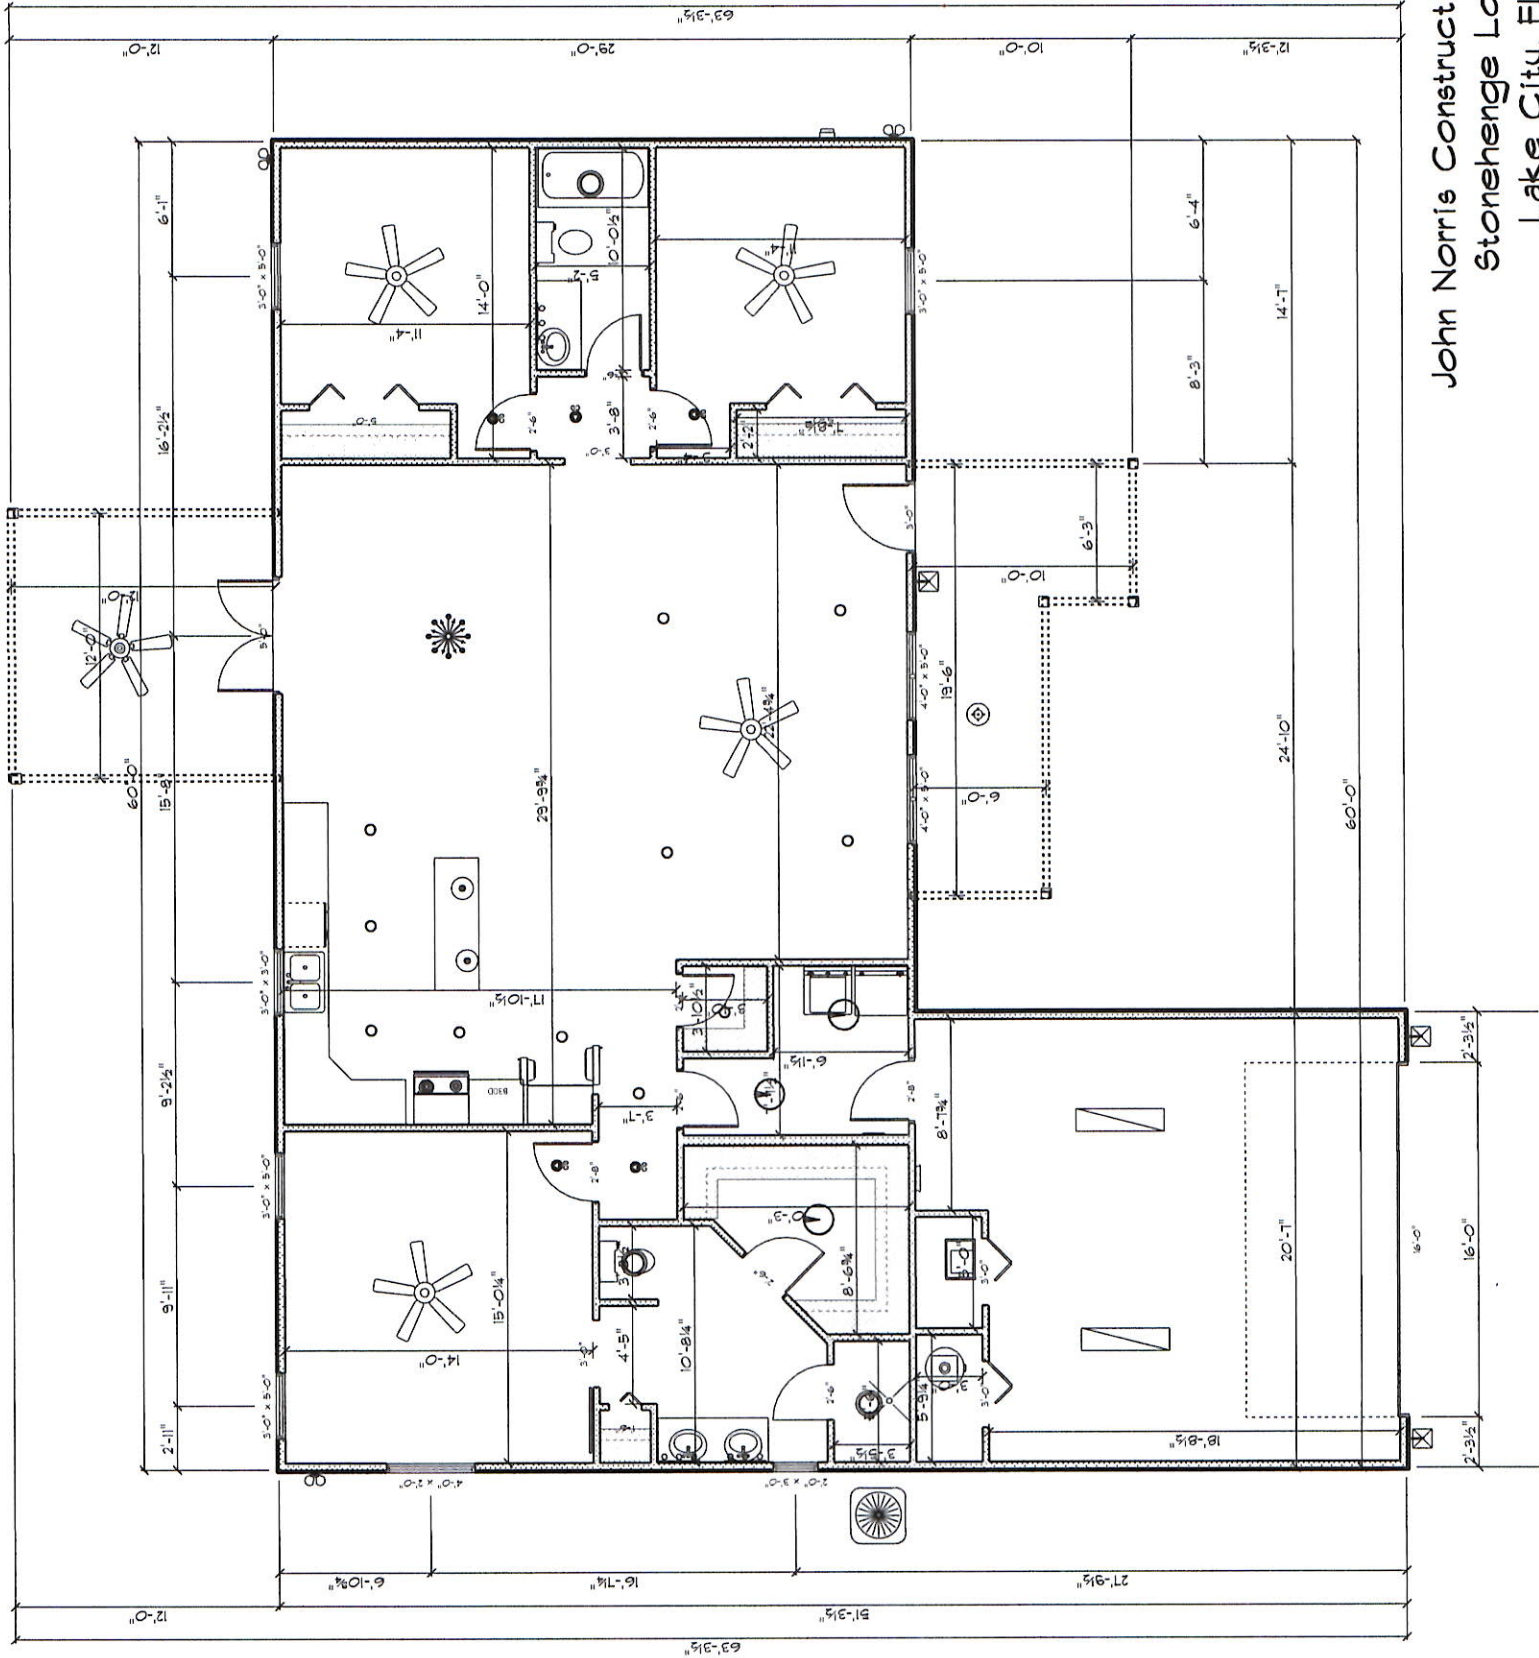


| ELECTRICAL LEGEND                |       |        |
|----------------------------------|-------|--------|
| ELECTRICAL                       | COUNT | SYMBOL |
| Interior 52" ceiling fan         | 4     |        |
| Exterior 52" ceiling fan         | 1     |        |
| Can light Grinch ceiling classic | 11    |        |
| Pendant lights                   | 2     |        |
| Interior ceiling lights          | 3     |        |
| exterior ceiling light           | 1     |        |
| Can light w/ exhaust fan         | 3     |        |
| Fluorescent light 1 x 4          | 2     |        |
| exterior craftsman light fixture | 3     |        |
| motion sensed flood lights       | 3     |        |
| electrical panel                 | 1     |        |
| smoke/ CO detectors              | 5     |        |
| vanity light                     | 3     |        |

| AREA SCHEDULE   |               |
|-----------------|---------------|
| NAME            | AREA          |
| Heat/ Cool SqFt | 1762.3 sq ft. |
| Porches         | 293.1 sq ft.  |
| Garage          | 464.4 sq ft.  |
| Total SqFt      | 2519.8 sq ft. |


John Norris Construction, L.L.C.  
Stonehenge Lot 6  
Lake City, FL

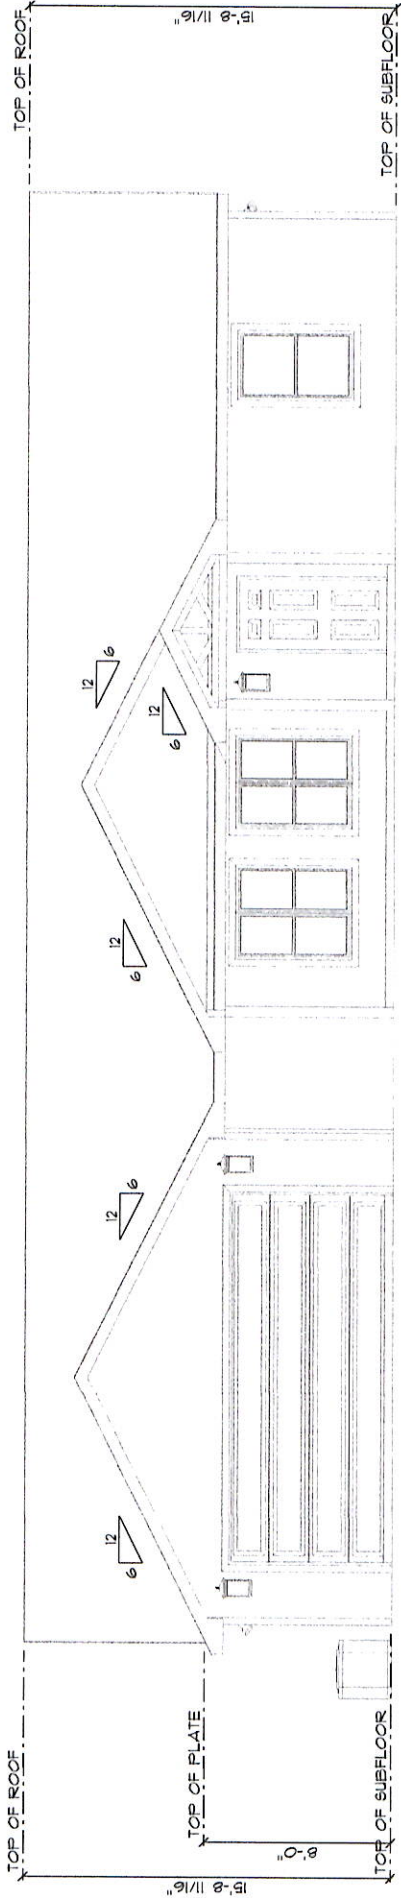

**Front Elevation**  
SCALE: 1/8" = 1'-0"

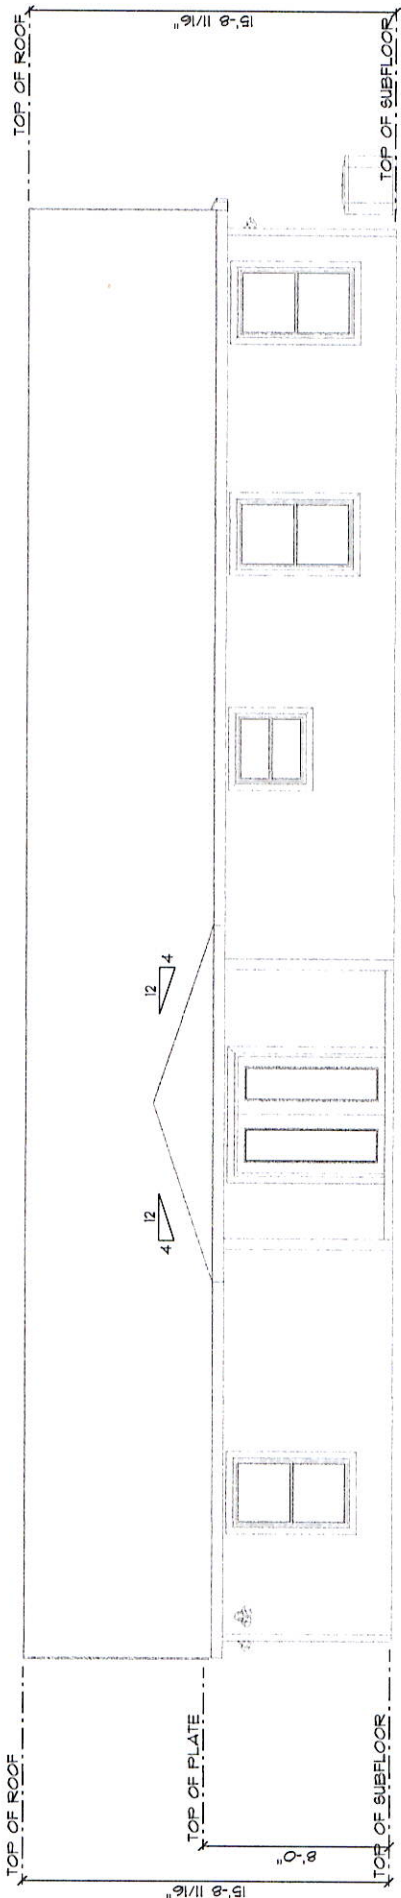


**Rear Elevation**  
SCALE: 1/8" = 1'-0"

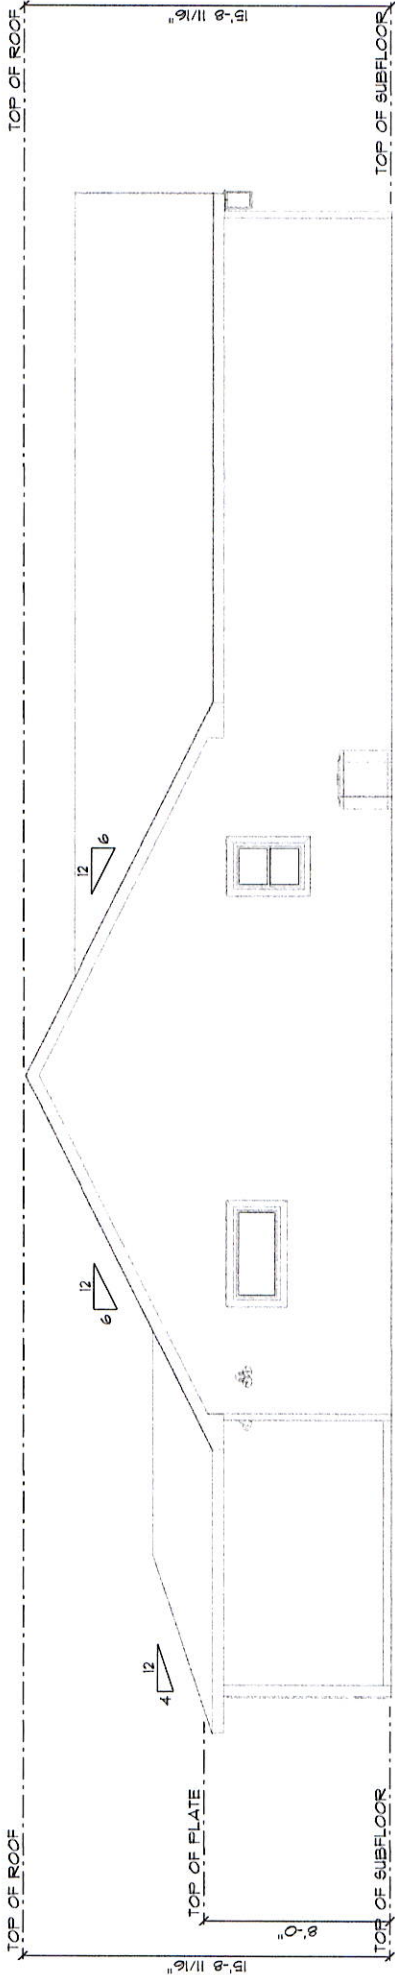

# Left Elevation

SCALE: 1/8" = 1'-0"

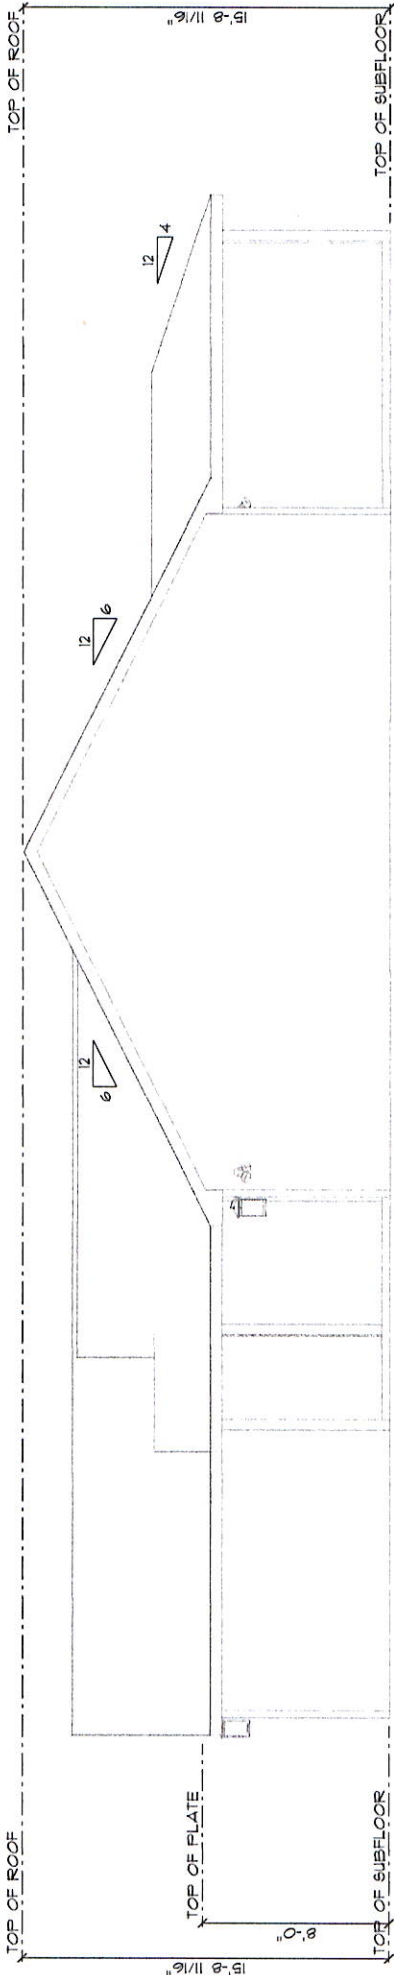

# Right Elevation

SCALE: 1/8" = 1'-0"