


BEARING WOOD INTERIOR WALL SCHEDULE					
MARK	STUD SPACING	CONNECTION & FASTENERS	LUMBER SPECIES	UPLIFT CAP (PIF)	
		TOP	BOTTOM		
[BW1]	16"	(2) 16d TOENAILS	(2) 16d TOENAILS	SPF	0
[BW2]	16"	SP2 W/ (6)10d NAILS	SP1 W/ (6)10d NAILS	SPF	402
[BW3]	16"	SP4 W/ (6) 10d X 1 1/2" NAILS	SP4 W/ (6) 10d X 1 1/2" NAILS	SPF	571
[BW4]	16"	(2) 16d TOENAILS	(2) 16d TOENAILS	SYP	0
[BW5]	16"	SP2 W/ (6)10d NAILS	SP1 W/ (6)10d NAILS	SYP	439
[BW6]	16"	SP4 W/ (6) 10d X 1 1/2" NAILS	SP4 W/ (6) 10d X 1 1/2" NAILS	SYP	665
[BW7]	12"	(2) 16d TOENAILS	(2) 16d TOENAILS	SPF	0
[BW8]	12"	SP2 W/ (6)10d NAILS	SP1 W/ (6) 10d NAILS	SPF	535
[BW9]	12"	SP4 W/ (6) 10d X 1 1/2" NAILS	SP4 W/ (6) 10d X 1 1/2" NAILS	SPF	760
[BW10]	12"	(2) 16d TOENAILS	(2) 16d TOENAILS	SYP	0
[BW11]	12"	SP2 W/ (6)10d NAILS	SP1 W/ (6) 10d NAILS	SYP	585
[BW12]	12"	SP4 W/ (6) 10d X 1 1/2" NAILS	SP4 W/ (6) 10d X 1 1/2" NAILS	SYP	885

NOTE: 2 x 4 WALLS ARE ASSUMED U.N.O. ON FLOOR PLANS
* ALL LUMBER TO BE GRADE #2
** CONNECTIONS TO BE INSTALLED TO EACH STUD AS INDICATED
*** SPFS & SPFS CAN BE SUB. TOP SPFS W/ RESPECT TO STUD SIZE

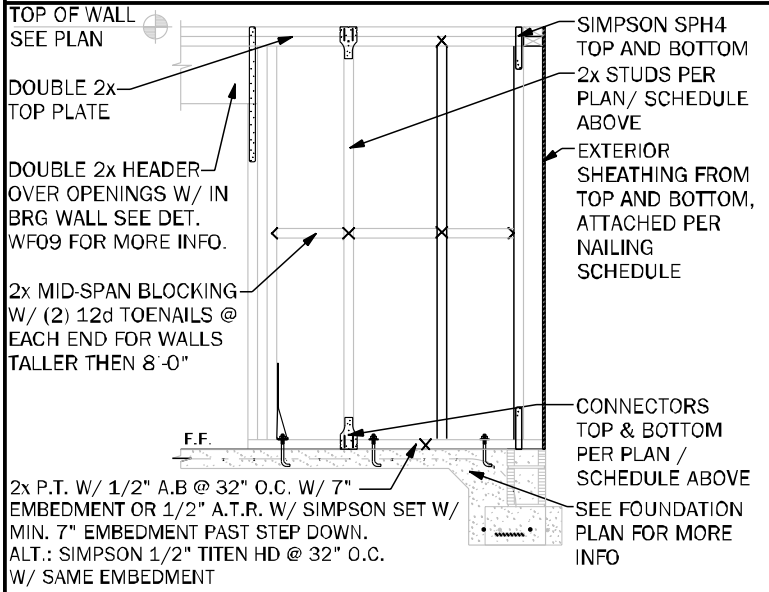

BEARING INTERIOR WALL DETAIL

GENERAL NOTES

- SEE FLOOR PLAN FOR WALL SIZE. ASSUME 2x4 STUDS USED UNO.
- ALL STRUCTURAL LUMBER TO BE SYP #1 OR SPF #2 UNO ON PLAN.
- CONNECTIONS TO BE INSTALLED TO EACH STUD AS INDICATED.
- CONTACT E.O.R. IF SP4'S SPFS OR SPFS'S CONNECTORS ARE SUBSTITUTED, TO VERIFY THEY MEET THE STRUCTURAL REQUIREMENTS.
- IF "BW" IS INDICATED ON SECOND FLOOR BASE CONNECTION TO IGNORED. SEE WORK/S.S. FOR INDICATED DETAIL FOR PROPER CONNECTIONS FOR 2nd FLOOR TO FIRST FLOOR CONNECTIONS. (NOTE: THIS IS FOR 2 STORY PROJECTS ONLY).
- IF "SW" IS INDICATED THE WALL IS CONSIDERED A SHEARWALL AND REQUIRES MIN. 1/4" OSB PLYWOOD W/ 8d AND EDGE 4" O.C. IN FIELD AND EDGE TO (1) SIDE OF WALL.
- ALL 2x EXTERIOR WALLS W/ EXTERIOR SHEATHING ATTACHED PER NAILING SCHEDULE ACT AS SHEARWALLS. SEE PLAN AND WALLS SECTIONS FOR STUD SPACING AND GRADE.
- IF THE BEARING WALL IS INDICATED WITH THE BW1, BW4, BW7, BW10 THESE WALLS ARE ONLY SUPPORTING THE FLOOR LOAD AND DO NOT HAVE UPLIFT. THE STUDS ARE TOE NAILS TO THE PLATE AND THE 2x PLATE CAN BE ATTACHED WITH HARD Cased NAILS (GUN NAILS) AND WILL NOT REQUIRE THE ANCHOR BOLT ATTACHMENT INDICATED IN THE BEARING WALL SCHEDULE.

MARK	COLUMN SIZE	(BASE) CONN. & FASTENER	UPLIFT(Lb)
[C1]	(3) 2 x 4 #2 SPF	(4) 16d TOENAILS	0
[C2]	(3) 2 x 4 #2 SPF	DT122 W/ 1/2" WEDGE ANCHOR* & (8) 1/4" X 1 1/2" SDS SCREWS	2145
[C3]	(3) 2 x 4 SYP #1 GR.	(4) 16d TOENAILS	0
[C4]	(4) 2 x 4 SPF #2	DT122 W/ 1/2" WEDGE ANCHOR* & (8) 1/4" X 1 1/2" SDS SCREWS	2145
[C5]	4 x 4 P.T.#2 SYP POST	ABU44 W/ 5/8" ATR** & (12) 16d NAILS	G = 6685 U = 2200
[C6]	6 x 6 P.T.#2 SYP POST	ABU66 W/ 5/8" ATR** & (12) 16d NAILS	G = 12000 U = 2280
[C7]	8 x 8 P.T.#2 SYP POST	ABU88 W/ (2) 5/8" ATR** & (18) 16d NAILS	G = 24335 U = 2320
[C8]	3.5 x 3.5 P.L. 1.8E Rb-2400 PSI (WOLMANIZED IF EXT.)	HDUS-SDS2.5 W/ (14) 1/4" X 2 1/2" SDS WS & 5/8" EPOXY ANCHOR, OR ATR**	5645
[C9]	3.5 x 5.25 P.L. 1.8E Rb-2400 PSI (WOLMANIZED IF EXT.)	HDUS-SDS2.5 W/ (14) 1/4" X 2 1/2" SDS WS & 5/8" EPOXY ANCHOR, OR ATR**	5645
[C10]	3.5 x 7 P.L. 1.8E Rb-2400 PSI (WOLMANIZED IF EXT.)	HDUS-SDS2.5 W/ (20) 1/4" X 2 1/2" SDS WS & 7/8" EPOXY ANCHOR, OR ATR**	6970
[C11]	5.25 x 5.25 P.L. 1.8E Rb-2400 PSI (WOLMANIZED IF EXT.)	HDUS-SDS2.5 W/ (20) 1/4" X 2 1/2" SDS WS & 7/8" EPOXY ANCHOR, OR ATR**	7870
[C12]	7 x 7 P.L. 1.8E Rb-2400 PSI (WOLMANIZED IF EXT.)	HDUS-SDS2.5 W/ (20) 1/4" X 2 1/2" SDS WS & 7/8" EPOXY ANCHOR, OR ATR**	7870
[C13]	5.25" x 7" P.L. 1.8E Rb-2400 PSI (WOLMANIZED IF EXT.)	HDUS-SDS2.5 W/ 7/8" ATR AND (20) 1/4" x 1/4" SDS WOOD SCREWS	7870

GENERAL COLUMN NOTES

- SEE FLOOR PLAN FOR WALL WIDTH. STUD PICKS TO MATCH WALL WIDTH UNO.
- ALL STRUCTURAL LUMBER TO BE SYP #1 OR SPF #2 UNO ON PLAN.
- NAIL BUILD UP STUDS PER DETAIL WFS7
- MINIMUM BOLT EMBEDMENT:
 - 5" EMBEDMENT FOR 1/2" ATR
 - 6" EMBEDMENT FOR 5/8" ATR
 - 8" EMBEDMENT FOR 7/8" ATR
- IF (C) COLUMN IS INDICATED ON SECOND FLOOR, THE BASE CONNECTION IS NOT REQUIRED. (SEE INDICATED CALL OUT ON PLAN FOR ATTACHMENT)
- SEE WOOD CONSTRUCTION NOTE #4 ON COVER SHEET FOR CORROSION INFORMATION
- SAVE NOMINAL SIZE PARALLEL COLUMNS (L.S.E) MAY BE SUBSTITUTED FOR ANY P.T. SYP POST NOTED IN THE PLANS

COMMON NAIL vs. PNEUMATIC GUN NAILS:

COMMON NAIL	DIA. / LENGTH	PNEUMATIC GUN NAIL DIA. LENGTH	COMMON vs. GUN NAIL DIA. LENGTH	APPLICATION
8d	0.131" X 2 1/2"	0.131" X 2 1/2"		SEE PLAN RING SHANK ON ROOF
10d OR 12d	0.148" X 3"	0.131" X 3"		SEE PLAN
12d	0.148" X 3 1/4"	0.131" X 3 1/4"		SEE PLAN
12d	0.148" X 3 1/4"	0.131" X 3 1/4"	8" O.C. (COMMON)	STUD WALL CORNERS
10d	0.148" X 3"	0.131" X 3"	8" O.C. (COMMON)	STUD WALL COLUMNS
16d	0.162" X 3 1/2"	0.131" X 3 1/2"	(2) 16d (COMMON)	SEE PLAN

MARK	HEADER SIZE	REMARKS
[H1]	(2) - 2X6 #2 SYP W/ 1/2" FLITCH PLATE	SEE GENERAL HEADER NOTE #5 THIS SHEET
[H2]	(2) - 2X8 #2 SYP W/ 1/2" FLITCH PLATE	SEE GENERAL HEADER NOTE #5 THIS SHEET
[H3]	(2) - 2X10 #2 SYP W/ 1/2" FLITCH PLATE	SEE GENERAL HEADER NOTE #5 THIS SHEET
[H4]	(2) - 2X12 #2 SYP W/ 1/2" FLITCH PLATE	SEE GENERAL HEADER NOTE #5 THIS SHEET
[H5]	(2) - 1 3/4" X 11 1/4" LVL 2.0E Fb-2600 PSI	ATTACH TOGETHER W/ (2) ROWS 14" X 3 1/2" SDS WD SCREWS @ 16" O.C. TYP. EACH SIDE
[H6]	(2) - 1 3/4" X 9 1/4" LVL 2.0E Fb-2600 PSI	ATTACH TOGETHER W/ (3) ROWS 14" X 3 1/2" SDS WD SCREWS @ 16" O.C. TYP. EACH SIDE

HEADER SUPPORT NO. OF JACKS & STUDS REQ. AT OPENINGS				
OPENING SIZE	2x4 WALL JACKS EA. END	2x6 OR 2x8 WALL JACKS EA. END	2x6 OR 2x8 WALL JACKS EA. END	2x6 OR 2x8 WALL JACKS EA. END
1'-0" - 3'-11"	(1)	(2)	(1)	(2)
4'-0" - 9'-11"	(2)	(3)	(2)	(3)
10'-0" - 16'-0"	(3)	(4)	(3)	(4)


GENERAL HEADER NOTES

- VERIFY W/ PLAN CORRECT LENGTH OF HEADER REQUIRED
- IF HEADER IS ON THE 1st FLOOR SEE PLAN FOR BEARING WALL TYPE AND FOLLOW INSTRUCTIONS WITHIN BEARING WALL SCHEDULE FOR REQUIRED CORRECTIONS UNO ON PLAN
- IF HEADER IS ON THE 2nd FLOOR SEE PLAN FOR INDICATED HEADER CONNECTION FOR REQUIRED CONNECTIONS
- ALL HEADER JACK AND KING STUDS SHALL BE FASTENED TO EACH PER DETAIL WFS7
- FASTEN ALL MULTI-PLY HEADERS TOGETHER W/ (2) ROWS 12d COMMON NAILS AT 12" o.c. ALONG EACH EDGE OR (3) ROWS IF 2x10 OR LARGER.
- FASTEN ALL HEADERS TO KING STUDS WITH (3) 12d TOENAILS PER SIDE
- IF HEADER IS NOT SPECIFIED CONTACT E.O.R.

MARK	BEAM SIZE	CONNECTIONS
[BM1]	(2) 2 x 8 #2 SYP W/ 7/16" OSB FLITCH PLATE, NAIL BEAM TOGETHER USING (2) ROWS OF 12d NAILS @ 12" O.C. TYP. EACH SIDE	CONNECTION: PROVIDE (2) SIMPSON LSTA24 OR (2) SIMPSON HTS20 TO WOOD POST OR (2) SIMPSON HETA16 TO CMU COL. U.N.O. ON ROOF PLAN.
[BM2]	(2) 2 x 10 #2 SYP W/ 7/16" OSB FLITCH PLATE, NAIL BEAM TOGETHER USING (2) ROWS OF 12d NAILS @ 12" O.C. TYP. EACH SIDE	CONNECTION: PROVIDE (2) SIMPSON LSTA24 OR (2) SIMPSON HTS20 TO WOOD POST OR (2) SIMPSON HETA16 TO CMU COL. U.N.O. ON ROOF PLAN.
[BM3]	(2) 2 x 12 #2 SYP W/ 7/16" OSB FLITCH PLATE, NAIL BEAM TOGETHER USING (2) ROWS OF 12d NAILS @ 12" O.C. TYP. EACH SIDE	CONNECTION: PROVIDE (2) SIMPSON LSTA24 OR (2) SIMPSON HTS20 TO WOOD POST OR (2) SIMPSON HETA16 TO CMU COL. U.N.O. ON ROOF PLAN.
[BM4]	(2) 1 3/4" x 11 1/4" LVL 2.0E Fb-2600 PSI. NAIL BEAM TOGETHER USING (2) ROWS 1/4" X 3 1/2" SDS WOOD SCREWS @ 16" O.C. TYP. EACH SIDE	CONNECTION: PROVIDE (2) SIMPSON LSTA24 OR (2) SIMPSON HTS20 TO WOOD POST OR (2) SIMPSON HETA16 TO CMU COL. U.N.O. ON ROOF PLAN.
[BM5]	(2) 1 3/4" x 11 7/8" LVL 2.0E Fb-2600 PSI. NAIL BEAM TOGETHER USING (2) ROWS 1/4" X 3 1/2" SDS WOOD SCREWS @ 16" O.C. TYP. EACH SIDE	CONNECTION: PROVIDE (2) SIMPSON LSTA24 OR (2) SIMPSON HTS20 TO WOOD POST OR (2) SIMPSON HETA16 TO CMU COL. U.N.O. ON ROOF PLAN.
[BM6]	(2) 1 3/4" x 16" LVL 2.0E Fb-2600 PSI. NAIL BEAM TOGETHER USING (2) ROWS 1/4" X 3 1/2" SDS WOOD SCREWS @ 16" O.C. TYP. EACH SIDE	CONNECTION: PROVIDE (2) SIMPSON LSTA24 OR (2) SIMPSON HTS20 TO WOOD POST OR (2) SIMPSON HETA16 TO CMU COL. U.N.O. ON ROOF PLAN.

GENERAL BEAM NOTES

- VERIFY WITH PLAN CORRECT LENGTH OF BEAMS REQUIRED (MIN. 4" BEARING EACH END)
- SEE PLAN FOR TOP OR BOTTOM OF BEAM INDICATIONS
- BEAMS ARE NOT TO BE DRILLED OR NOTCHED IN ANY WAY WITHOUT WRITTEN APPROVAL FROM THE E.O.R.

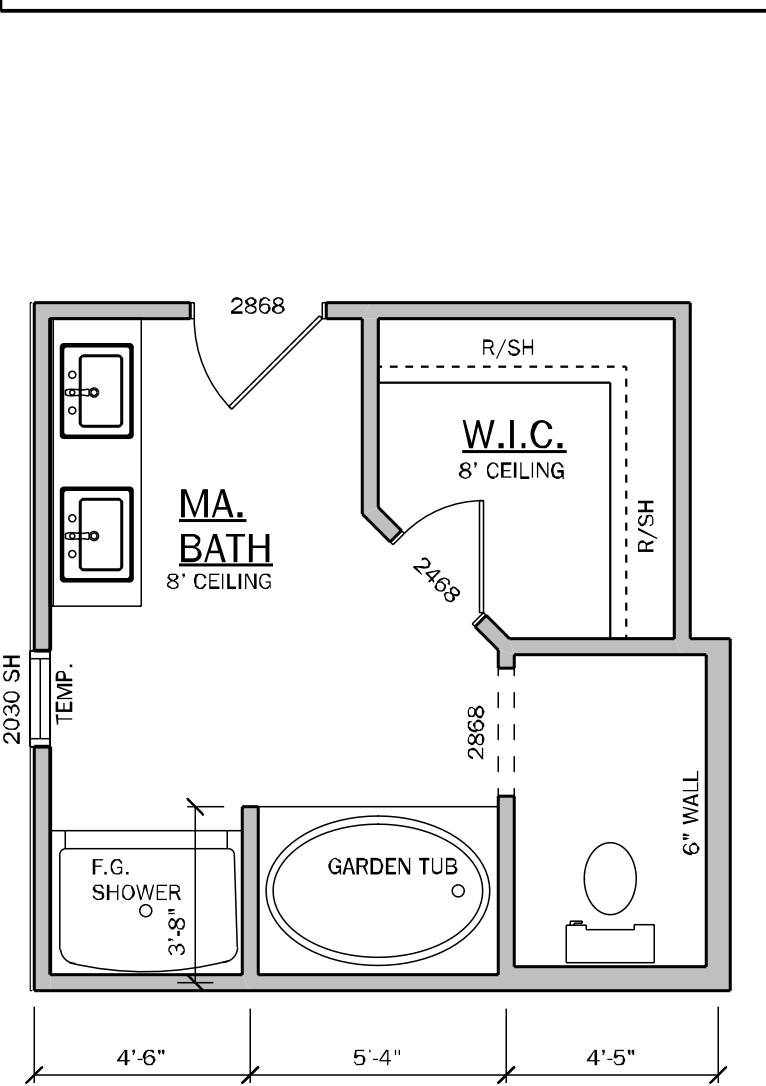


MASTER BA. OPTIONS

3040 TILE SHOWER IN LIEU OF LINEN CLOSET W/ (1) L.E.D. DISC LT.

OPT. MASTER BATH

SCALE: 1/4" = 1'-0"

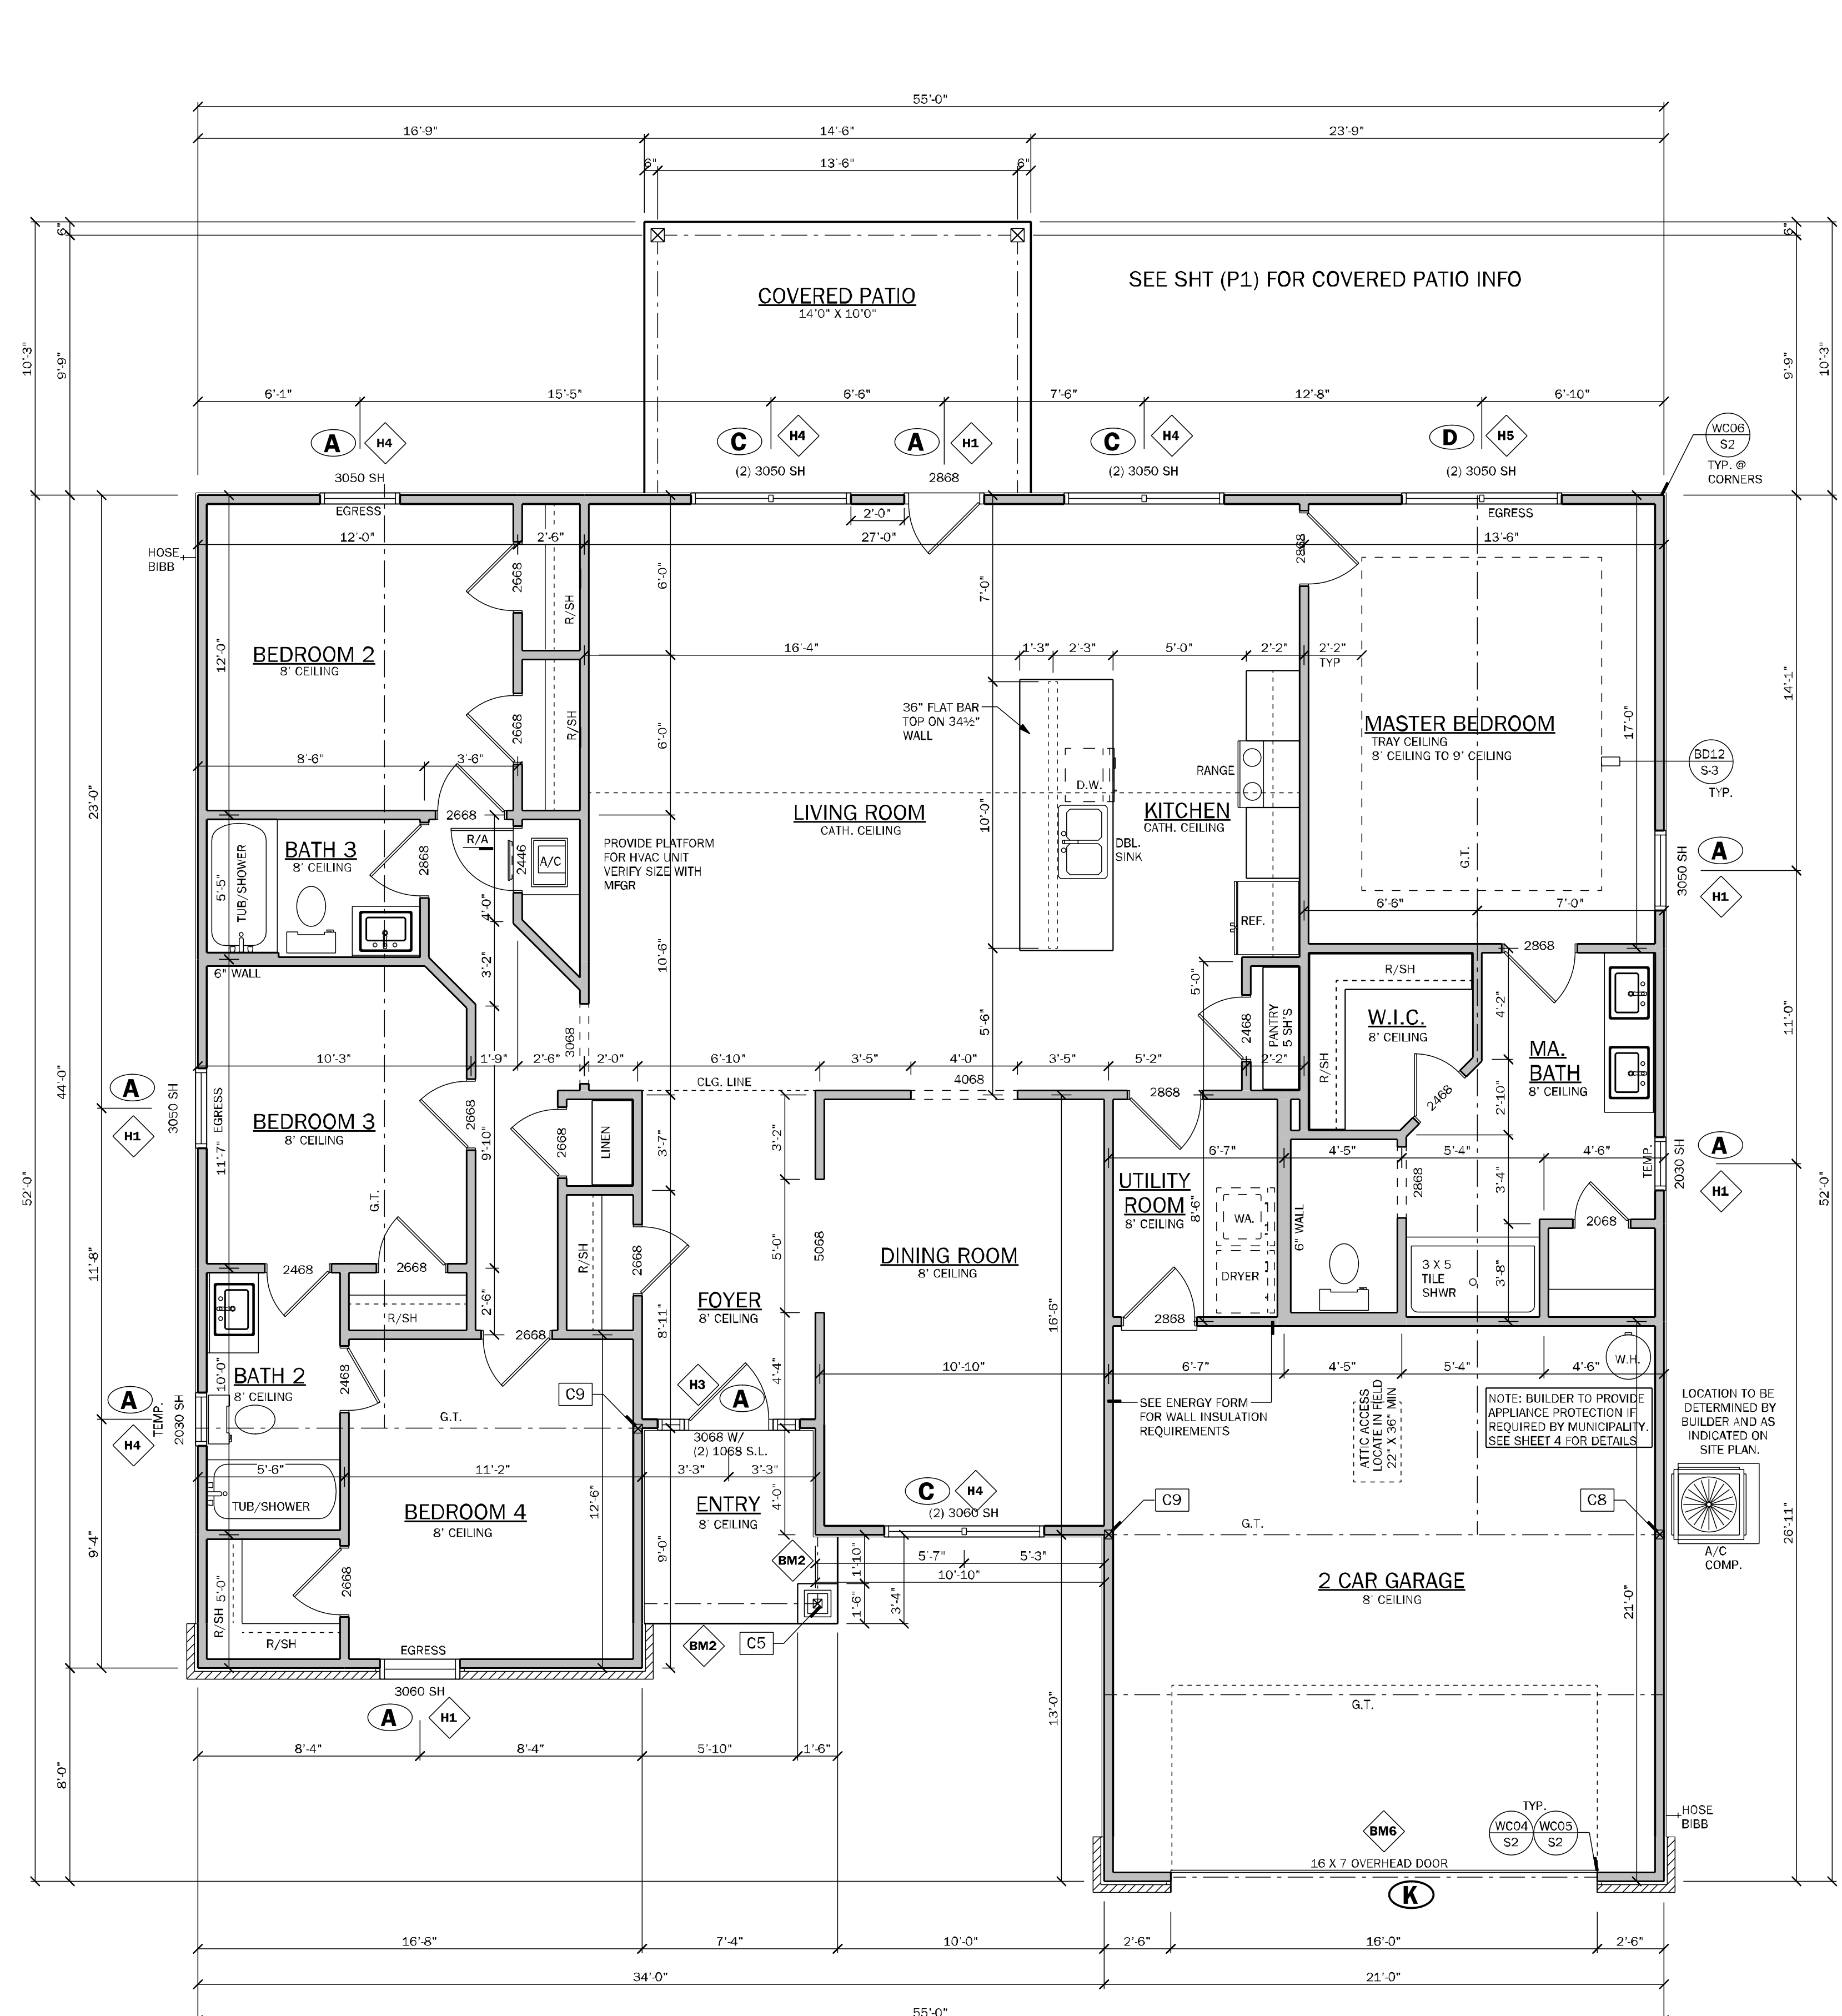

FLOOR PLAN

SCALE: 1/4" = 1'-0"
ELEVATION "A" & "CR"

NOTE:

INDICATES OPENINGS WIND PRESSURES. SEE WIND LOADING CRITERIA ON COVER SHEET FOR INFORMATION.

WALL LEGEND

- FRAMED WALL
- BEARING FRAME WALL
- FRAMED WALL W/ BRICK VENEER
- FRAMED WALL W/ SIDING OR STUCCO

GENERAL NOTES

- R302.6 (table 302.6) If water based ceiling texture material is used, Provide 1/2" gypsum board for 16" O.C. Framing, or 5/8" gypsum board for 24" O.C. Framing. Note 1/2" sag-resistant gypsum board may be used I.L.O. 5/8" gypsum board. 5/8" type "X" gypsum board must be installed on garage ceiling beneath habitable room(s).
- R302.5.2 Duct Penetration. Ducts in the garage and ducts penetrating the walls or ceilings separating the dwelling from the garage shall be constructed of a minimum No. 26 gage (0.48 mm) sheet steel, 1 inch minimum rigid nonmetallic class 0 or class 1 duct board, or other approved material and shall not have openings into the garage.
- R302.5.1 Door from garage into house must be a minimum 1 3/8" solid wood door, solid or honeycomb core steel door, or 20 Minute fire rated door.
- R302.7 Enclosed space under stairs that is accessed by a door or access panel shall have walls, under-stair surfaces and any soffits protected on the enclosed side with 1/2" gypsum board.
- Outdoor swimming pools shall be provided with a barrier complying with R4501.17.1.1 through R4501.17.1.14.
- Bathroom exhaust fans must vent to the exterior of the building. Exhaust to attic space and soffits is not acceptable. Ventilation shall be permitted to exit through the soffit if solid soffit is installed 5'-0" on each side of the venting.
- R302.6 The garage shall be separated from the residence and its attic as required by Table R302.6. From the residence and attics by not less than 1/2-inch (12.7mm) gypsum board applied to the garage side. Garage beneath rooms shall be separated from all habitable rooms above by not less than 5/8 inch (15.9mm) type X gypsum board or equivalent. Where the separation is a floor-ceiling assembly, the structure supporting the separation shall also be protected by not less than 1/2 inch (12.7mm) gypsum board or equivalent.
- R312.1 Window sills. In dwelling units, where the bottom of the clear opening of an operable window opening is located less than 24 inches (610 mm) above the finished floor and greater than 72 inches (1829 mm) above the finished grade or other surface below or the exterior of the building, the operable window shall comply with one of the following:
 - Operable windows with openings that will not allow a 4-inch diameter (102 mm) sphere to pass through the opening where the opening is in its largest opened position.
 - Operable windows that are provided with window fall prevention devices that comply with ASTM F2090.
 - Operable windows that are provided with window opening control devices that comply with Section R312.2.2.
- R308.4.2 All windows within 2'-0" of doors and in shower or tub areas will be safety tempered glass.
- EC: R402.2.4 Vertical or horizontal access doors from conditioned spaces to unconditioned spaces such as attics and crawl spaces shall be weatherstripped and insulated to a level equivalent to the insulation on the surrounding surfaces.
- M1502.4.5 Duct length. The maximum allowable exhaust duct length shall be determined by one of the methods specified in sections M1502.4.5.1 through M1502.4.5.3.
 - M1502.4.5.1 Duct termination. Exhaust ducts shall terminate on the outside of the building. Exhaust duct terminations shall be in accordance with the dryer manufacturer's installation instructions. If the manufacturer's instructions do not specify a termination location, the exhaust duct shall terminate not less than 3 feet (914 mm) in any direction from openings into buildings, including openings in ventilated soffits. Exhaust duct terminations shall be equipped with a backdraft damper. Screens shall not be installed at the duct termination.
 - M1502.4.5.2 Porch Ceilings. (See plan for the following options)
 - Option 1: Gypsum: 1/2" exterior gypsum soffit board shall be attached to all framing members with 2x blocking provided at perimeter and panel edges.
 - The gypsum board shall be attached w/ Type "W" 1x4" drywall screws at 8" O.C. in field and edges.
 - Option 2: Plaster: Plaster shall be applied to all framing members with 2x blocking provided at perimeter and panel edges. The OSB shall be attached w/ 8d nails at 6" O.C. field and 4" O.C. at edges or 7d screw shank 3" O.C. field and 4" edges.
 - Energy Code Compliance Path is Performance Based Path. Code cycle is FBC 2023 8th Edition.

* ALL INTERIOR AND EXTERIOR WALL FRAMING, INCLUDING FLOORING STRIPS ON CMU WALLS, TO BE SPACED AND 16" O.C. (U.N.O.)

AREA CALCULATIONS

TOTAL LIVING (AC)	2117 S.F.
GARAGE	458 S.F.
COVERED ENTRY	40 S.F.
PATIO	140 S.F.
TOTAL AREA UNDER ROOF	2755 S.F.

COUNTY SEAL

To the best of the Engineer's knowledge, information and belief, the structural plans and specifications contain within these drawings comply with the 2023 Florida Building Code- Residential 8th Edition. Engineer's signature and seal is only for the structural engineering portions of the drawing pages bearing engineer's signature and seal.

CA No. 9161 AA26003115

TOTAL SOLUTIONS GROUP
258 Southhall Lane, Suite 200
Maitland, Florida, 32751
(407) 880 2333

100% Employee Owned
myTSGhome.com

FLORIDA CONTRACTORS LICENSE NO. CRC1330146

100 WEST GARDEN STREET
PENSACOLA FL 32502

DIVISION LOCATION:
GAINESVILLE

Job Information:

INVENTORY

LOT: 12
BLK:
SEC:
SUB: PRESERVE AT LAUREL LAKE
133 SW BELLFLOWER DR.
LAKE CITY

Model Name / Number:


2117

Plan Issue Date:
Wednesday, March 19, 2025


KA PROJECT NUMBER:
25-02684

Sheet: **2** Of:


FLOOR PLAN

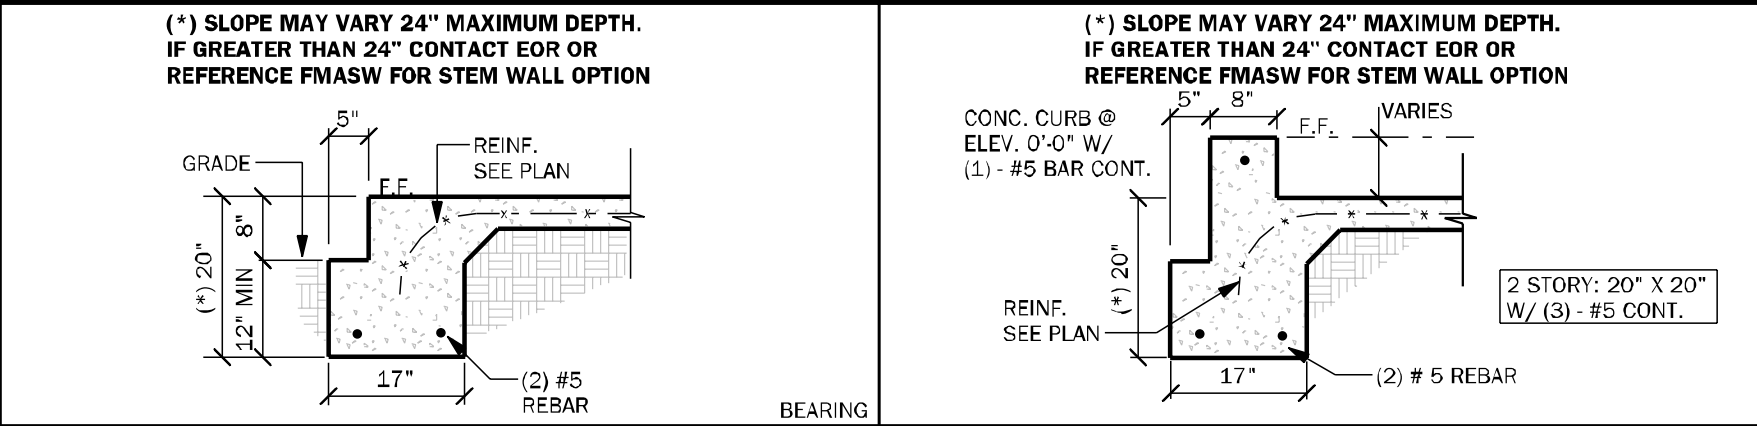


FM01 SINGLE STORY FTG 1/2" = 1'-0"

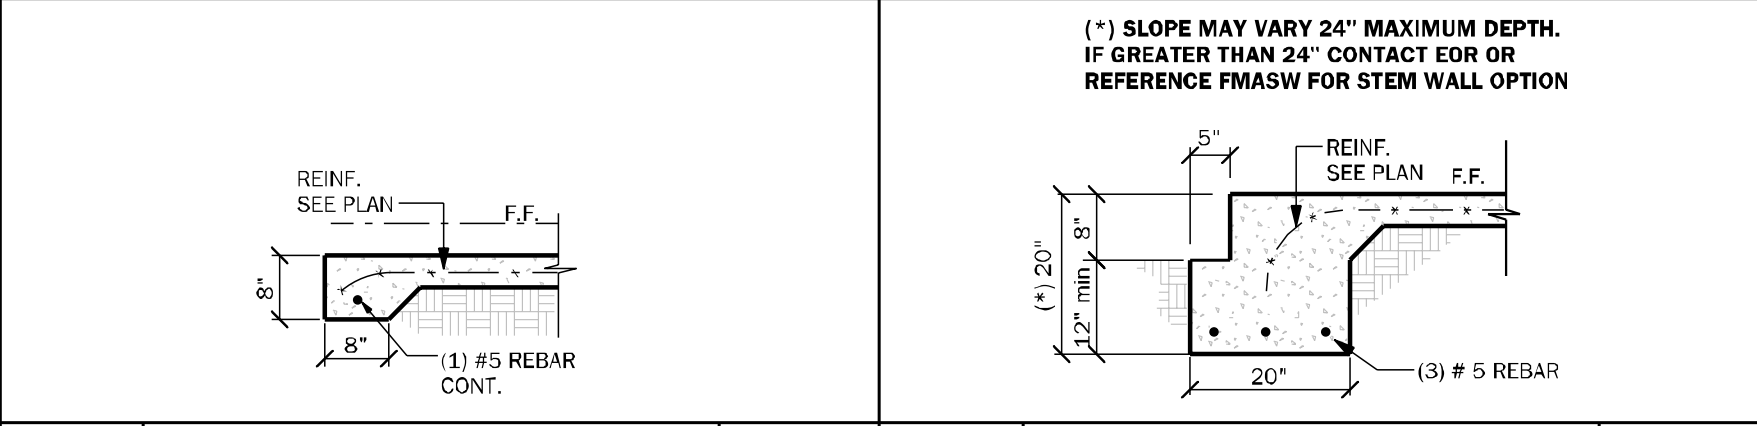


FM02 SECTION @ GARAGE 1/2" = 1'-0"

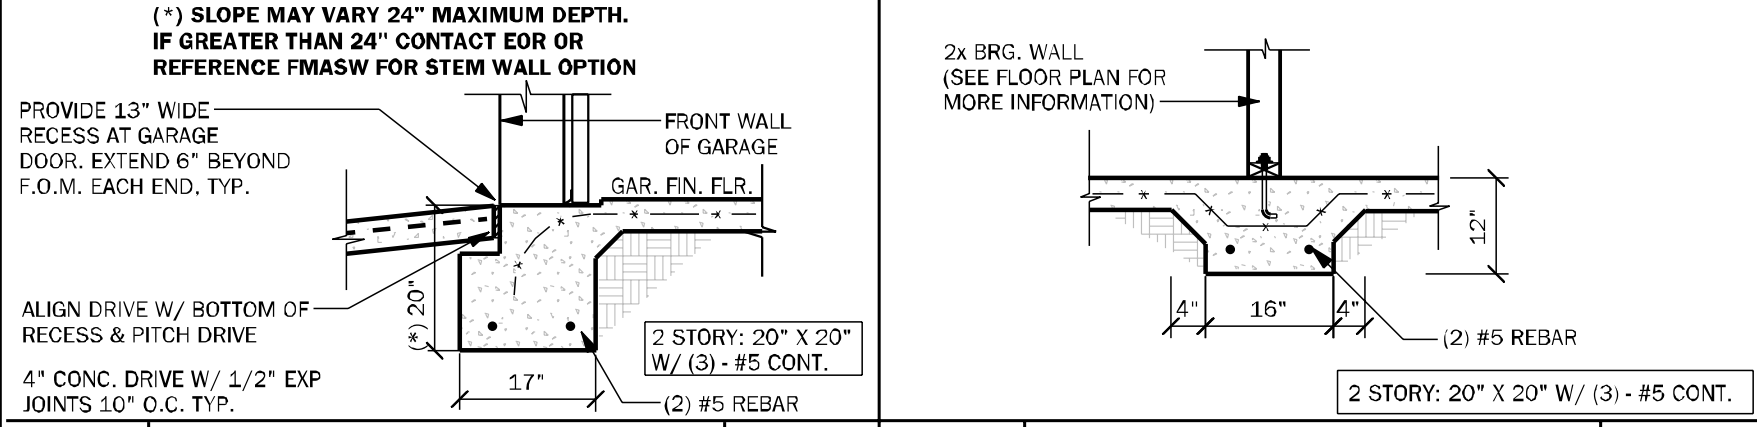


FM03 THICKENED EDGE 1/2" = 1'-0"

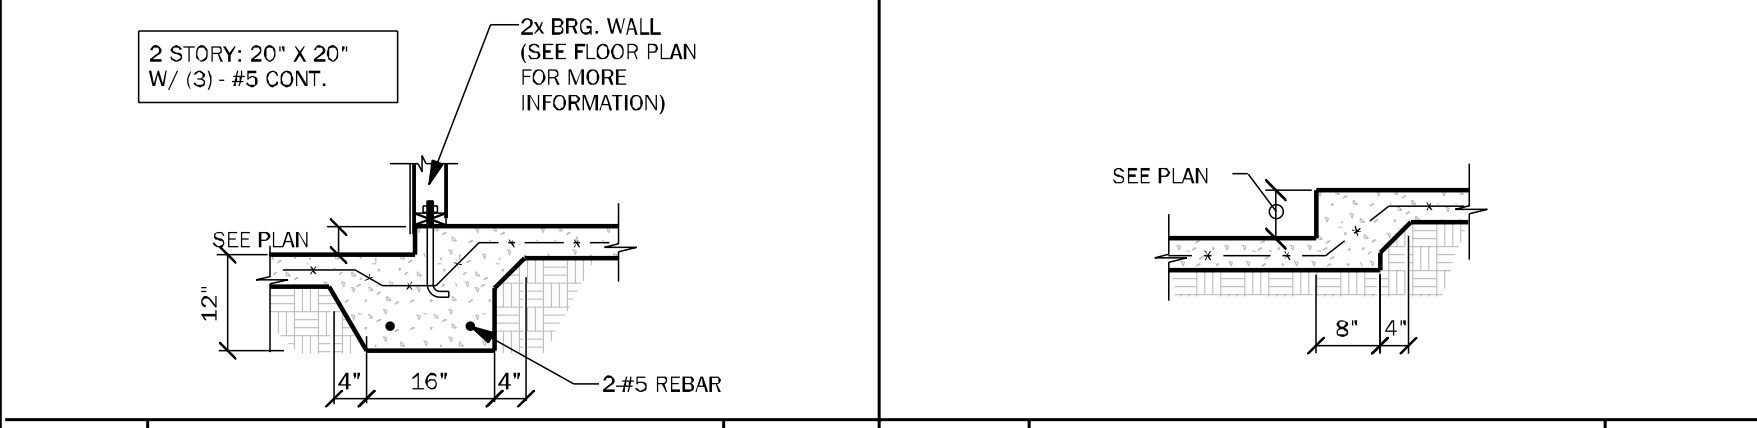


FM09 SECTION @ GAR. DOOR 1/2" = 1'-0"

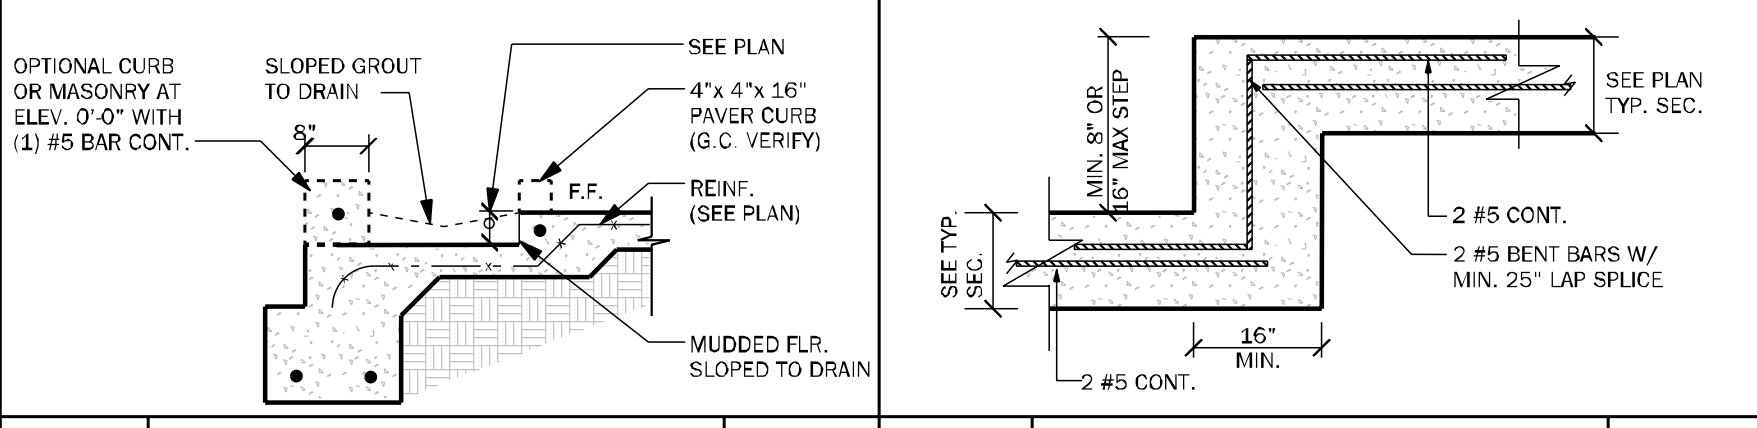


FM11 STEP DOWN BRG. 1/2" = 1'-0"

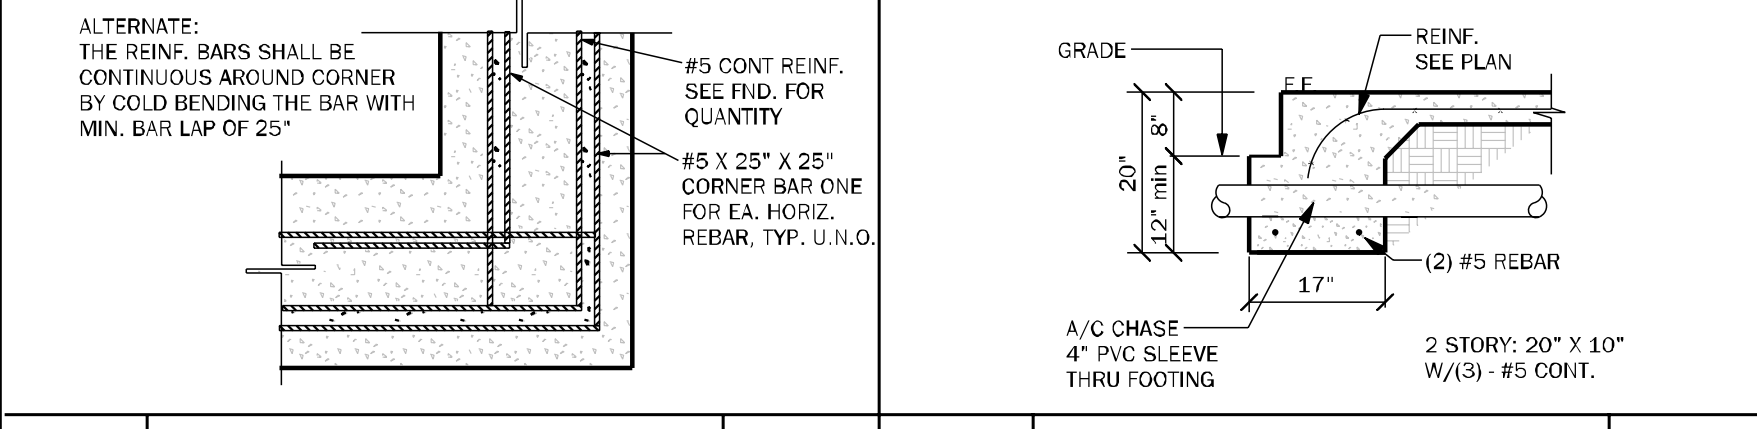

FM14 SECTION @ RECESS SHOWER 1/2" = 1'-0"

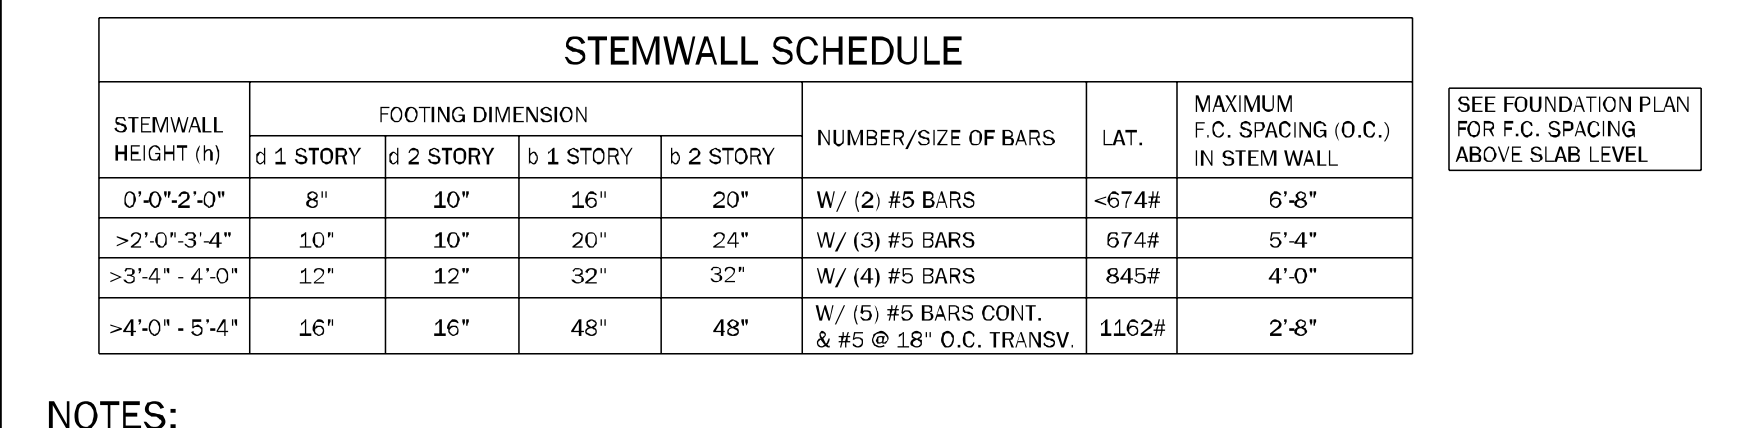


FM19 TYP. CORNER BAR DETAIL 1 1/2" = 1'-0"

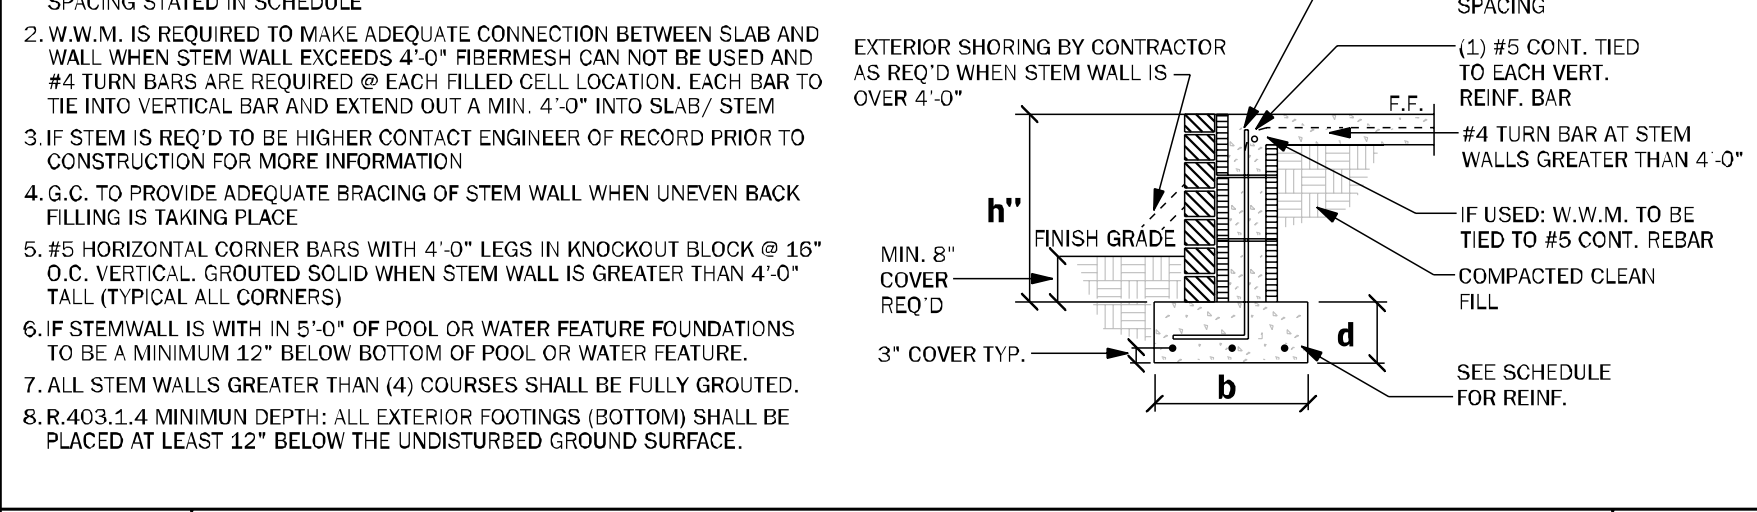


FM23 TYP. FND PENETRATION 1/2" = 1'-0"

FMASW ALTERNATE STEM WALL FOOTING SCHEDULE 1/2" = 1'-0"

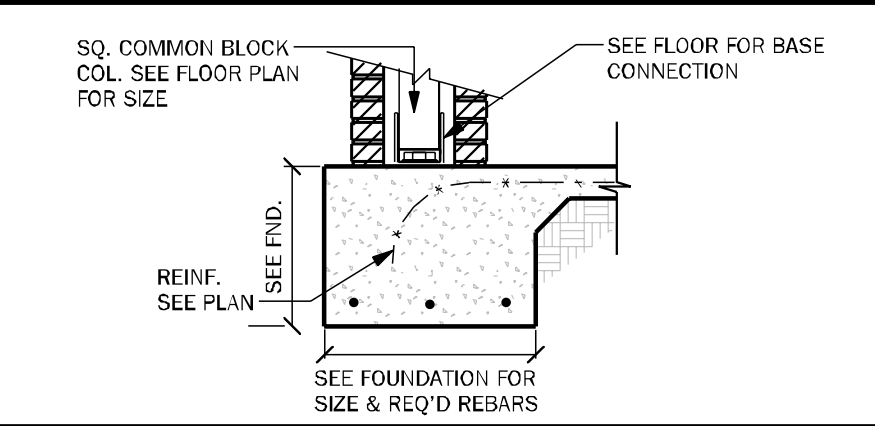


FM25 PORCH COLUMN W/ BRICK 1/2" = 1'-0"

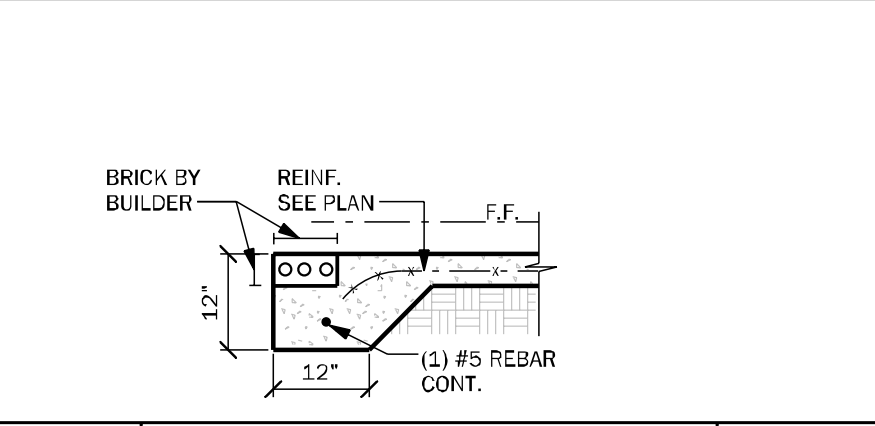


FM26 THICKENED EDGE W/ BRICK 1/2" = 1'-0"




FM08 2-STORY FTG. 1/2" = 1'-0"

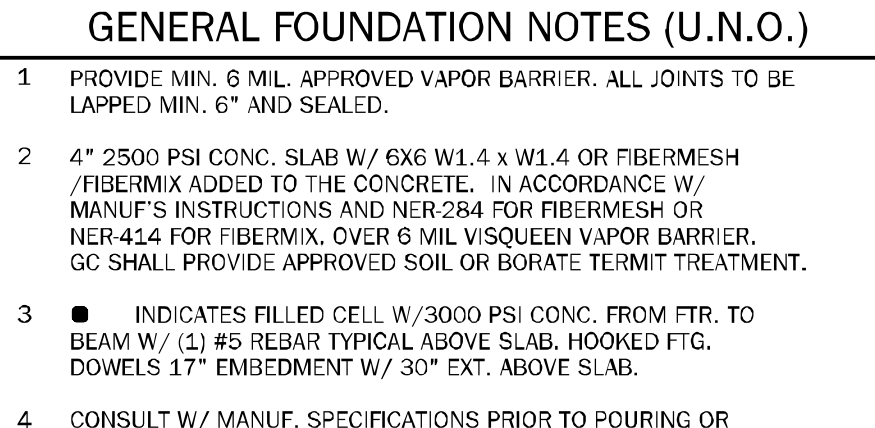

FM10 INTERIOR BRG WALL 1/2" = 1'-0"

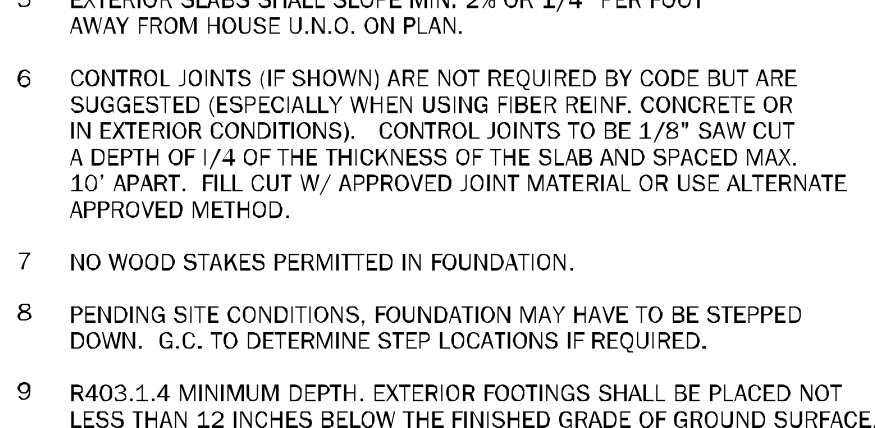


FM18 TYP. STEP FTG. DETAIL 1/2" = 1'-0"

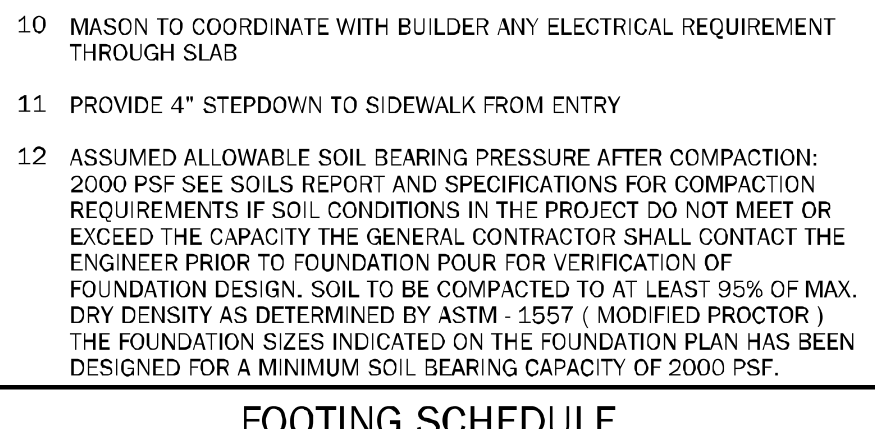

FM23 TYP. FND PENETRATION 1/2" = 1'-0"

FOOTING SCHEDULE				
MARK	SIZE	DEPTH	REINFORCING	GRAVITY CAP. (lbs)
F1.0	1'-0" X CONT.	1'-0"	2 #5 E.W. BOT.	2000
F2.0	2'-0" X 2'-0"	1'-0"	3 #5 E.W. BOT.	7200
F2.5	2'-6" X 2'-6"	1'-0"	3 #5 E.W. BOT.	11000
F3.0	3'-0" X 3'-0"	1'-0"	4 #5 E.W. BOT.	15600
F3.5	3'-6" X 3'-6"	1'-0"	4 #5 E.W. BOT.	21500
F4.0	4'-0" X 4'-0"	1'-0"	5 #5 E.W. BOT.	28000
F4.5	4'-6" X 4'-6"	1'-4"	5 #5 E.W. BOT.	34500
F5.0	5'-0" X 5'-0"	1'-4"	6 #5 E.W. BOT.	42500
F5.0	5'-0" X 6'-0"	1'-4"	7 #5 E.W. BOT.	61500

LEGEND	
	- INDICATES SINGLE-STORY FOOTING
	- INDICATES TWO-STORY FOOTING
	- INDICATES PAD FOOTING

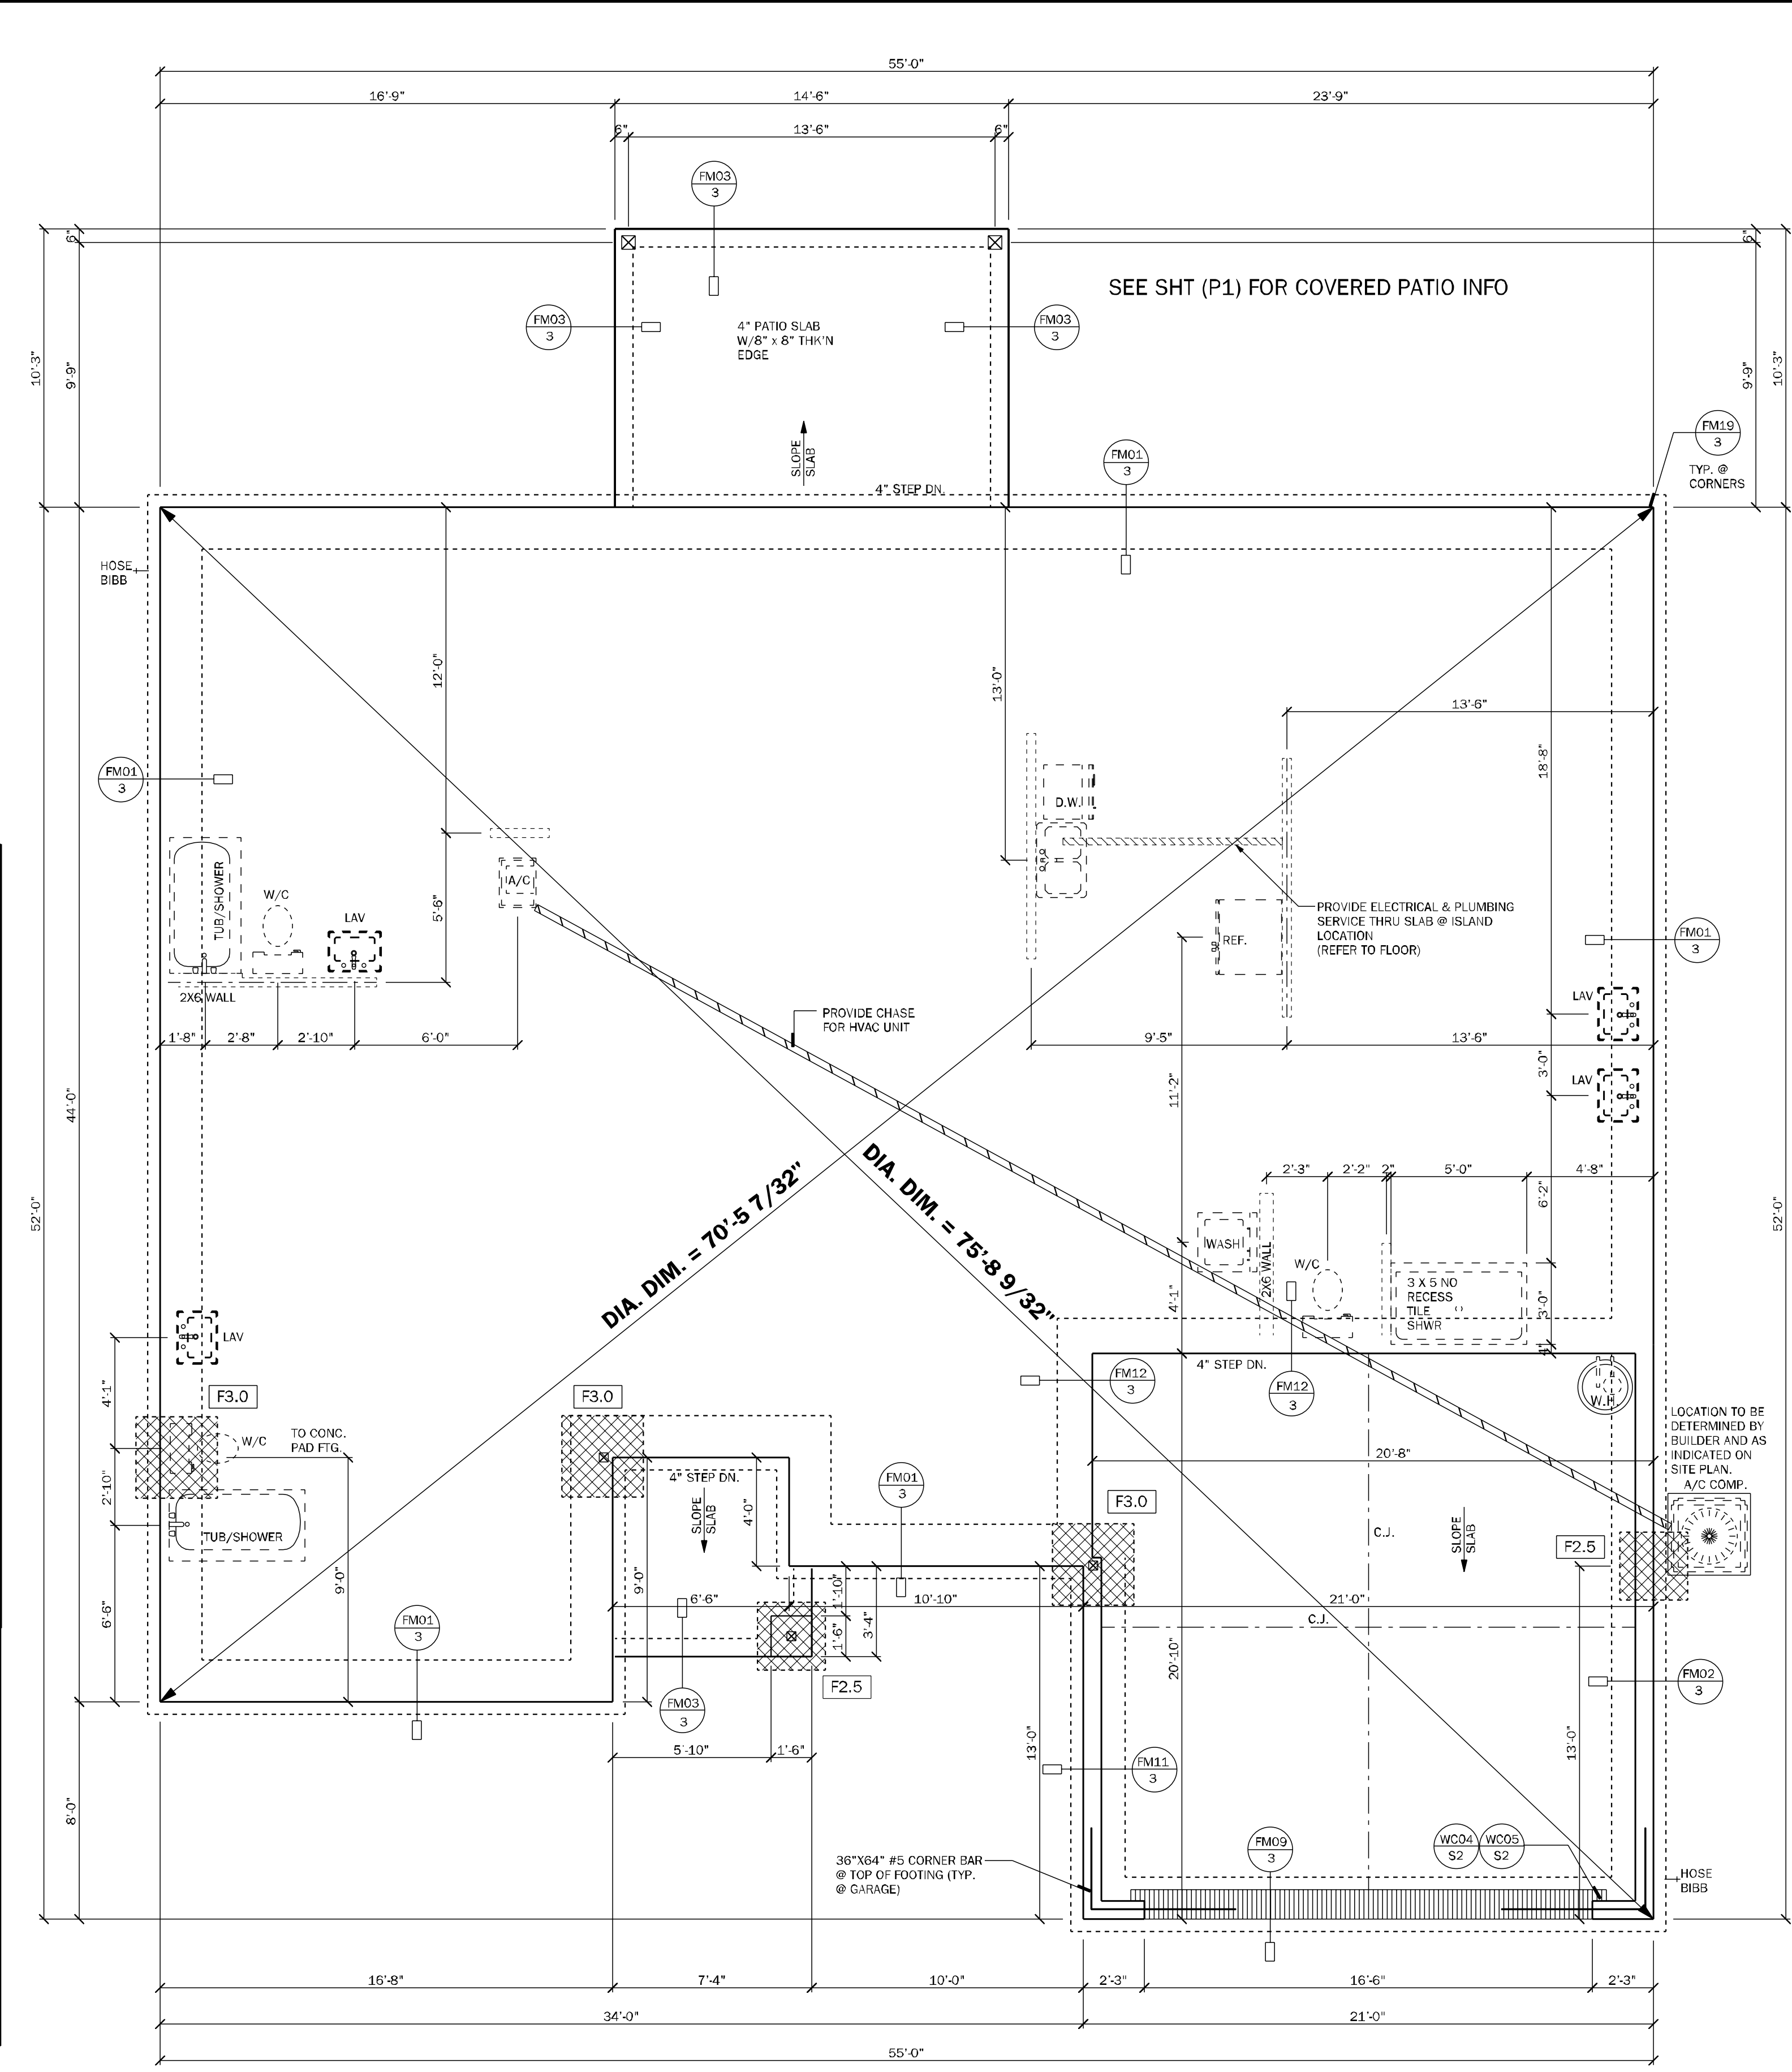

FOUNDATION PLAN
SCALE: 1/4" = 1'-0"

COUNTY SEAL

To the best of the Engineer's knowledge, information and belief, the structural plans and specifications contain within these drawings comply with the 2023 Florida Building Code- Residential 8th Edition. Engineer's signature and seal is only for the structural engineering portions of the drawing pages bearing engineer's signature and seal.

CA No. 9161 AA26003115

TS
CA No. 9161
Making Dreams Come True

TOTAL SOLUTIONS GROUP
258 Southall Lane, Suite 200
Maitland, Florida, 32751
(407) 880 2333

100% Employee Owned
myTSGhome.com

FLORIDA CONTRACTORS LICENSE NO. CRC1330146
**100 WEST GARDEN STREET
PENSACOLA FL 32502**

DIVISION LOCATION:
GAINESVILLE

Job Information:

INVENTORY
LOT: 12
BLK: 12
SEC: 12
SUB: PRESERVE AT LAUREL LAKE
133 SW BELLFLOWER DR.
LAKE CITY

Model Name / Number:
2117

Plan Issue Date:
Wednesday, March 19, 2025

KA PROJECT NUMBER:
25-02684

Sheet: **3** Of:

FOUNDATION PLAN

3 WATTS PER SQUARE FOOT OF LIVING
S.F. LIVING = $\frac{2117 \times 3}{6351}$

$$\begin{array}{r} \text{GEN LIGHT'G \& RECEPT. + APP. CIR.} = \underline{34,901} \\ \text{SUBTRACT 100 \% OF FIRST 10,000} \quad - \underline{10,000} \\ \mathbf{A} = 24,901 \end{array}$$

A/C (AIR HANDLER & COMP.)	10,000
A/C (AUXILIARY HEAT STRIP)	<u>10,000</u>
B=	20,000

FIRST 10,000 AMPS @ 100%	= 10,000
+ 40% OF "A" = (.40 x 24,901)	= 9,960
+ 100% OF "B" = (20,000)	= <u>20,000</u>
TOTAL WATTAGE	= 39,960
WATTS DIVIDED BY 240 = AMPS	
CALCULATED SERVICE AMPS	= 166



N.T.S.

W/ COVERED PORCH OPT. ADD CLG. LIGHT
LOCATION CENTER OF PORCH AREA AND
BRACE FOR POSSIBLE FAN PRE-WIRE



ELECTRICAL NOTES: UNLESS OTHERWISE NOTED.

1. ELECTRICAL OUTLET HEIGHTS AS MEASURED FROM FINISHED FLOOR TO CENTER LINE OF THE BOX TO BE: 16" AFF. (GENERAL), IN A FLOOD ZONE, ALL ELECTRICAL EQUIPMENT TO BE AT OR ABOVE DECK.
2. KITCHEN 16" AFF.
3. BATHROOM 39" AFF.
4. LAUNDRY ROOM 36" AFF.
5. EXTERIOR WATERPROOF 12" AFF.
6. GARAGE 16" AFF.
7. GENERAL PURPOSE 42" AFF.
8. RANGE 2" AFF.
9. WITH THE EXCEPTIONS AND DEVICES TO BE GANGED, WHERE POSSIBLE:
 - a. ELECTRICAL SWITCHES TO BE AT 42" CENTERLINE ABOVE FINISHED FLOOR.
 - b. ELECTRICAL PLAN IS INTENDED FOR BID PURPOSES ONLY. ALL WORK SHALL BE DONE IN STRICT ACCORDANCE WITH THE NATIONAL ELECTRICAL CODE (NEC), LATEST EDITION, BY A LICENSED ELECTRICAL CONTRACTOR WHO SHALL BE RESPONSIBLE FOR THE INSTALLATION & SIZING OF ALL ELECTRICAL WIRING & ACCESSORIES.
 - c. SMOKE ALARMS SHALL COMPLY WITH NFPA 72 AND SECTION R314.4 AND SHALL BE LISTED IN ACCORDANCE WITH UL 217. COMBINATION SMOKE AND CARBON MONOXIDE ALARMS SHALL BE LISTED IN ACCORDANCE WITH UL 217.
 - d. PROVIDE ARC-Fault (AFCI) CIRCUIT INTERRUPTERS/ COMBINATION TYPE INSTALLED TO PROVIDE PROTECTION OF THE CIRCUIT CIRCUITS IN ALL DWELLING UNITS PER NFPA 70 (CURRENT EDITION) AND THE NEC AND AS DEFINED IN 1999.
 - e. PROVIDE TAMPOR RESISTANT RECEPTACLES AS REQUIRED BY THE NFPA 70 (CURRENT EDITION).
 - f. CARBON MONOXIDE PROTECTION: CARBON MONOXIDE ALARMS OR DETECTORS SHALL BE INSTALLED IN ALL DWELLING UNITS IN ACCORDANCE WITH FBC R313.4 AND NFPA 70. SUCH DEVICES SHALL BE LISTED BY THE APPROPRIATE STANDARD, EITHER ANSI/UL 2034, STANDARD FOR SINGLE AND MULTIPLE STATION CO ALARMS OR UL 217. GAS AND VAPOR DETECTOR SENSOR, ACCORDING TO THE INSTALLATION.
 - g. FOR COMBINATION SMOKE AND CARBON MONOXIDE ALARMS SHALL BE LISTED AND LABELED BY A NATIONALLY RECOGNIZED TESTING LABORATORY.
 - h. KEEP ALL SMOKE DETECTORS MINIMUM OF 36" FROM BATHROOM DOORS.
 - i. FOR NEW CARBON MONOXIDE ALARMS, DETECTORS SHALL BE DIVIDED INTO AN A/C ELECTRICAL POWER SOURCE AND SHALL BE EQUIPPED WITH A MONITORED BATTERY BACKUP.
 - j. EXHAUST SMOKE DETECTORS SHALL BE INSTALLED OUTSIDE THE BUILDING.
 - k. BATHROOM EXHAUST FANS MUST VENT TO THE EXTERIOR OF THE BUILDING, VENTILATION TO ATTIC SPACE AND EXHAUST INTO ACCEPTABLE VENT.
10. CHAPTER 45 PRIVATE SWIMMING POOLS -- OUTDOOR SWIMMING POOLS SHALL BE PROVIDED WITH A BARRIER COMPLYING WITH R40501.1.7.1 THROUGH R40501.1.7.1.4.
11. FOR COUNTERTOPS IN LAUNDRY ROOMS AND UTILITY ROOMS OF DWELLINGS WHERE INSTALLED WITHIN 6" OF THE OUTSIDE EDGE OF A SINK, THIS WOULD INCLUDE THE RECEPTACLE INSTALLED FOR A WASHING MACHINE. RECEPTACLE OUTLETS SHALL NOT BE REQUIRED ON A WALL DIRECTLY BEHIND A RANGE OR ON AN ADJACENT WALL. RECEPTACLE OUTLET EVERY 24" OF WIDTH OF THE SINK OR RANGE IS NOT TO BE INCLUDED IN THE SPACING OF THE OUTLETS UNLESS THE DISTANCE FROM THE SINK OR RANGE IS GREATER THAN 12" FOR STRAIGHT COUNTER TOPS AND 18" FOR SINKS AND RANGES INSTALLED IN CORNER COUNTERTOPS.
12. ALL ELECTRICAL OUTLETS REQUIRED TO BE INSTALLED WITHIN AN INDIVIDUAL DWELLING UNIT IN ACCORDANCE WITH SECTION R314.3.4. THE ALARM DEVICES SHALL BE INTERCONNECTED IN SUCH A MANNER THAT THE ACTIVATION OF ONE ALARM WILL ACTIVATE ALL OF THE ALARMS IN THE INDIVIDUAL DWELLING UNIT. PHYSICAL INTERCONNECTING OF THE ALARMS IS NOT REQUIRED WHERE LISTED WIRELESS ALARMS ARE INSTALLED AND ALL ALARMS SOUND UPON ACTIVATION OF ONE ALARM.
13. FOR ONE- AND TWO-FAMILY DWELLING UNITS, ALL SERVICE CONDUCTORS SHALL TERMINATE IN DISCONNECTING DEVICES. DISCONNECTING DEVICES SHALL BE INSTALLED IN EACH DWELLING UNIT AND SHALL BE INSTALLED IN A READY ACCESSIBLE OUTDOOR LOCATION. EACH DISCONNECT SHALL BE ONE OF THE FOLLOWING:
 - (1) SERVICE DISCONNECTS MARKED AS FOLLOWS:
 - a. EMERGENCY DISCONNECT
 - b. SERVICE DISCONNECT
 - (2) METER DISCONNECTS INSTALLED PER 230.82(3) AND MARKED AS FOLLOWS:
 - a. EMERGENCY DISCONNECT
 - b. METER DISCONNECT
 - (3) SERVICE DISCONNECT
14. NOT SERVICE EQUIPMENT
15. ON OTHER THAN DISCONNECT SWITCHES OR CIRCUIT BREAKERS ON THE SUPPLY SIDE OF EACH SERVICE DISCONNECT THAT ARE SUITABLE FOR USE AS SERVICE EQUIPMENT AND MARKED AS FOLLOWS:
 - a. EMERGENCY DISCONNECT
 - b. NOT SERVICE EQUIPMENT
16. MARKINGS SHALL COMPLY WITH 110.21(B).
17. ALL PERMANENTLY INSTALLED LUMINAIRES, EXCLUDING THOSE IN KITCHEN APPLIANCES, SHALL HAVE AN EFFICACY OF AT LEAST 45 LUMENS/PER-WATT OR SHALL UTILIZE LAMPS WITH AN EFFICACY OF NOT LESS THAN 65 LUMENS/PER-WATT.

\$	SINGLE POLE SWITCH		CARBON MONOXIDE / SMOKE DETECTOR
\$2	DOUBLE POLE SWITCH		COMBO UNIT
\$3	THREE-WAY SWITCH		FLOOD LIGHT
\$4	FOUR-WAY SWITCH		FLUORESCENT LIGHTING
\$DM	DIMMER SWITCH		TRACK LIGHTING
	CEILING MOUNTED FIXTURE		CEILING FAN
	SCOUNCE (WALL MOUNTED) FIXTURE		CHIMES
	110 VOLT DUPLEX OUTLET		DOOR BELL
	110 VOLT SPLIT SWITCHED OUTLET		DISPOSAL
	GROUND FAULT INTERRUPT		DISCONNECT SWITCH
	WATER PROOF W/ GROUND FAULT		PREWIRE SPEAKER
	220 VOLT OUTLET		JUNCTION BOX
	SPECIAL SERVICES OUTLET		THERMOSTAT
	T.V. CABLE OUTLET		LOW VOLTAGE LIGHTING
	TELEPHONE CABLE OUTLET		INTERCOM SYSTEM
	RECESSED LIGHTING		GARAGE DOOR PUSH BUTTON
	WATER PROOF RECESSED LIGHTING		
	BATH FAN		
	BATH FAN W/ LIGHT		
	L.E.D. DISC LIGHT		



NOTE:
ELECTRICAL MATERIAL AND INSTALLATIONS SHALL COMPLY WITH APPLICABLE PROVISIONS AS
STATED ON STRUCTURAL NOTES SHEET LOCAL CODES AND THE LOCAL POWER CO.

To the best of the Engineer's knowledge, information and belief, the structural plans and specifications contain within these drawings comply with the 2023 Florida Building Code- Residential 8th Edition. Engineer's signature and seal is only for the structural engineering portions of the drawing pages bearing Engineer's signature and seal.

CA No. 9161 AA26003115



100% Employee Owned
myTSGhome.com

DAMS HOMES
FLORIDA CONTRACTORS LICENSE NO. CRC1330146
**100 WEST GARDEN STREET
PENSACOLA FL 32502**

DIVISION LOCATION:
GAINESVILLE

▼ Job Information:

INVENTORY

LOT: 12

BLK:
SEC:

SUB: PRESERVE AT LAUREL LAKE

▼ Model Name / Number:

2117

▼ Plan Issue Date:

Wednesday, March 19, 2025

▼	KA PROJECT NUMBER:
---	--------------------


25-02684

Sheet: **4**


4	
---	--

ELECTRICAL


Wednesday, March 19, 2025

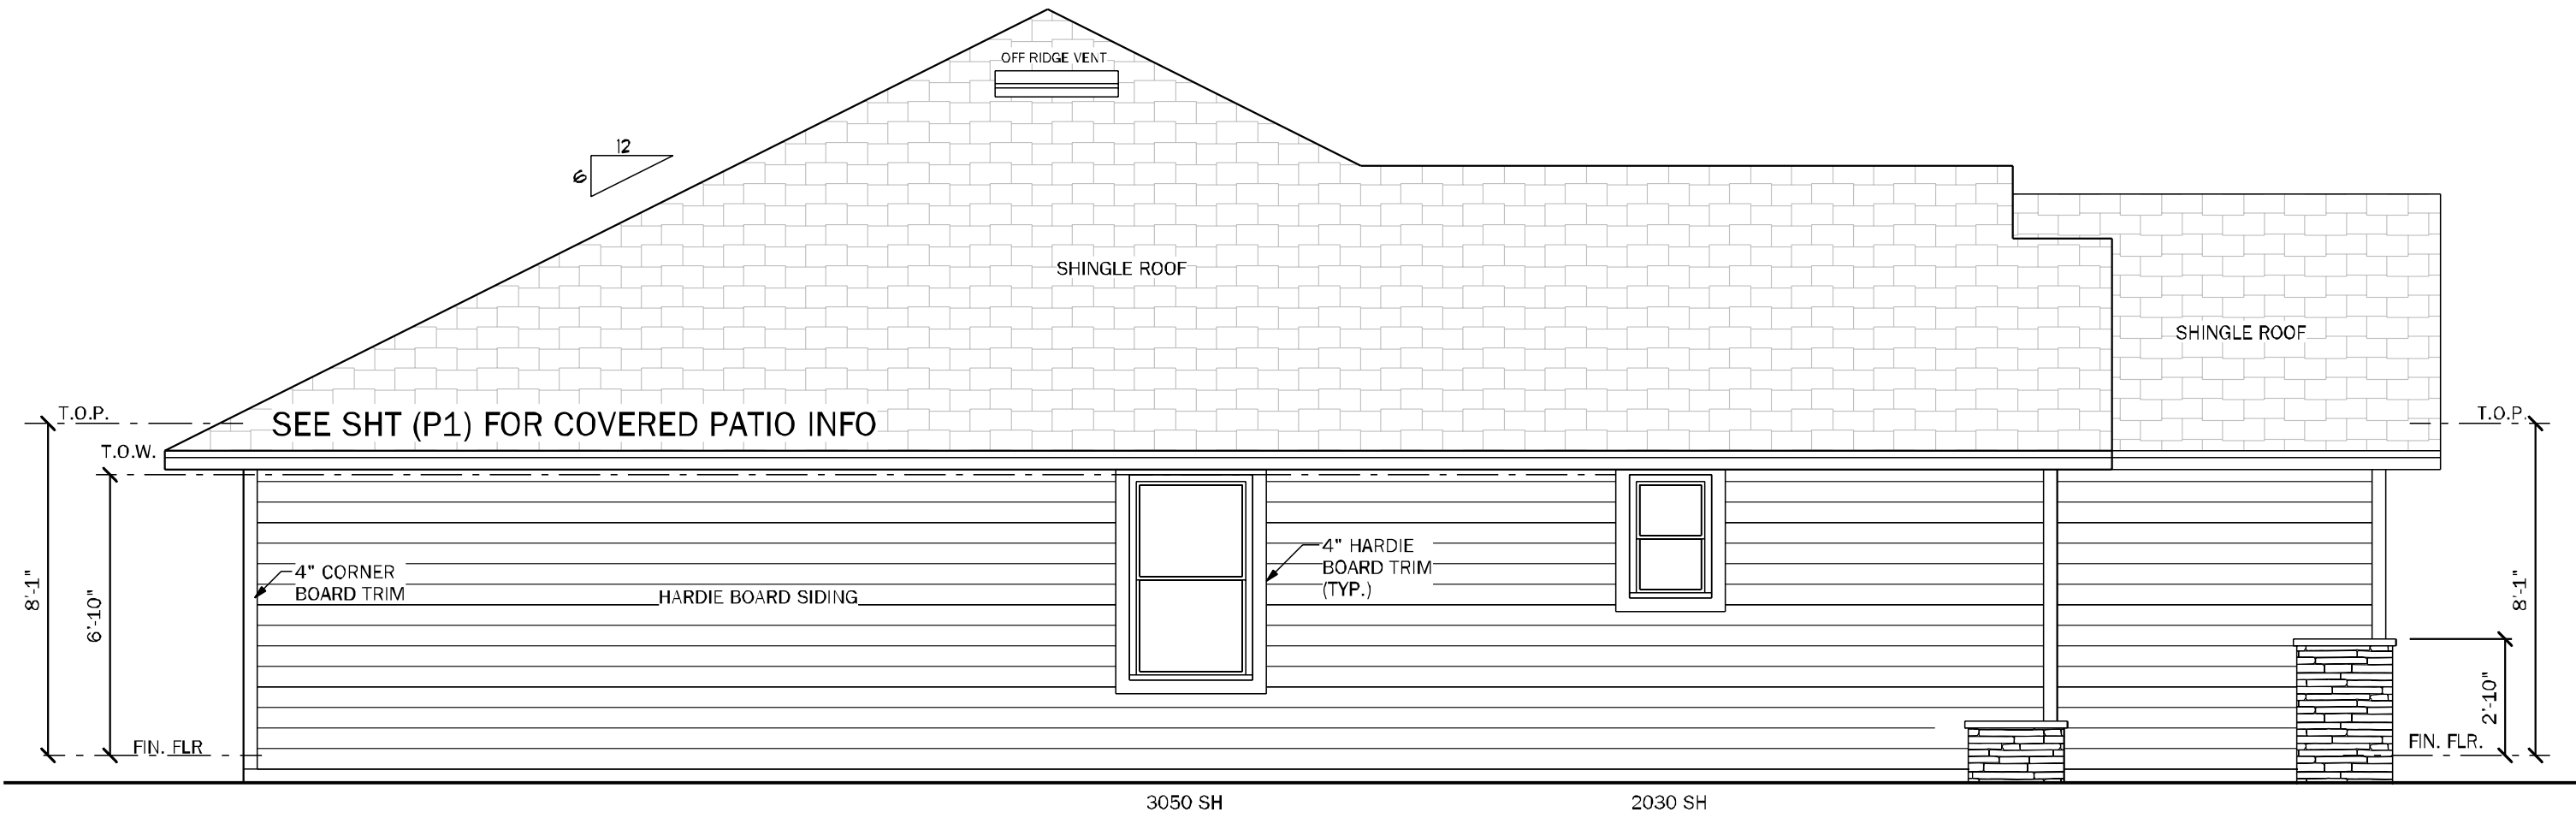

LEFT ELEVATION "A" & "CR"
SCALE:1/4"=1'-0"

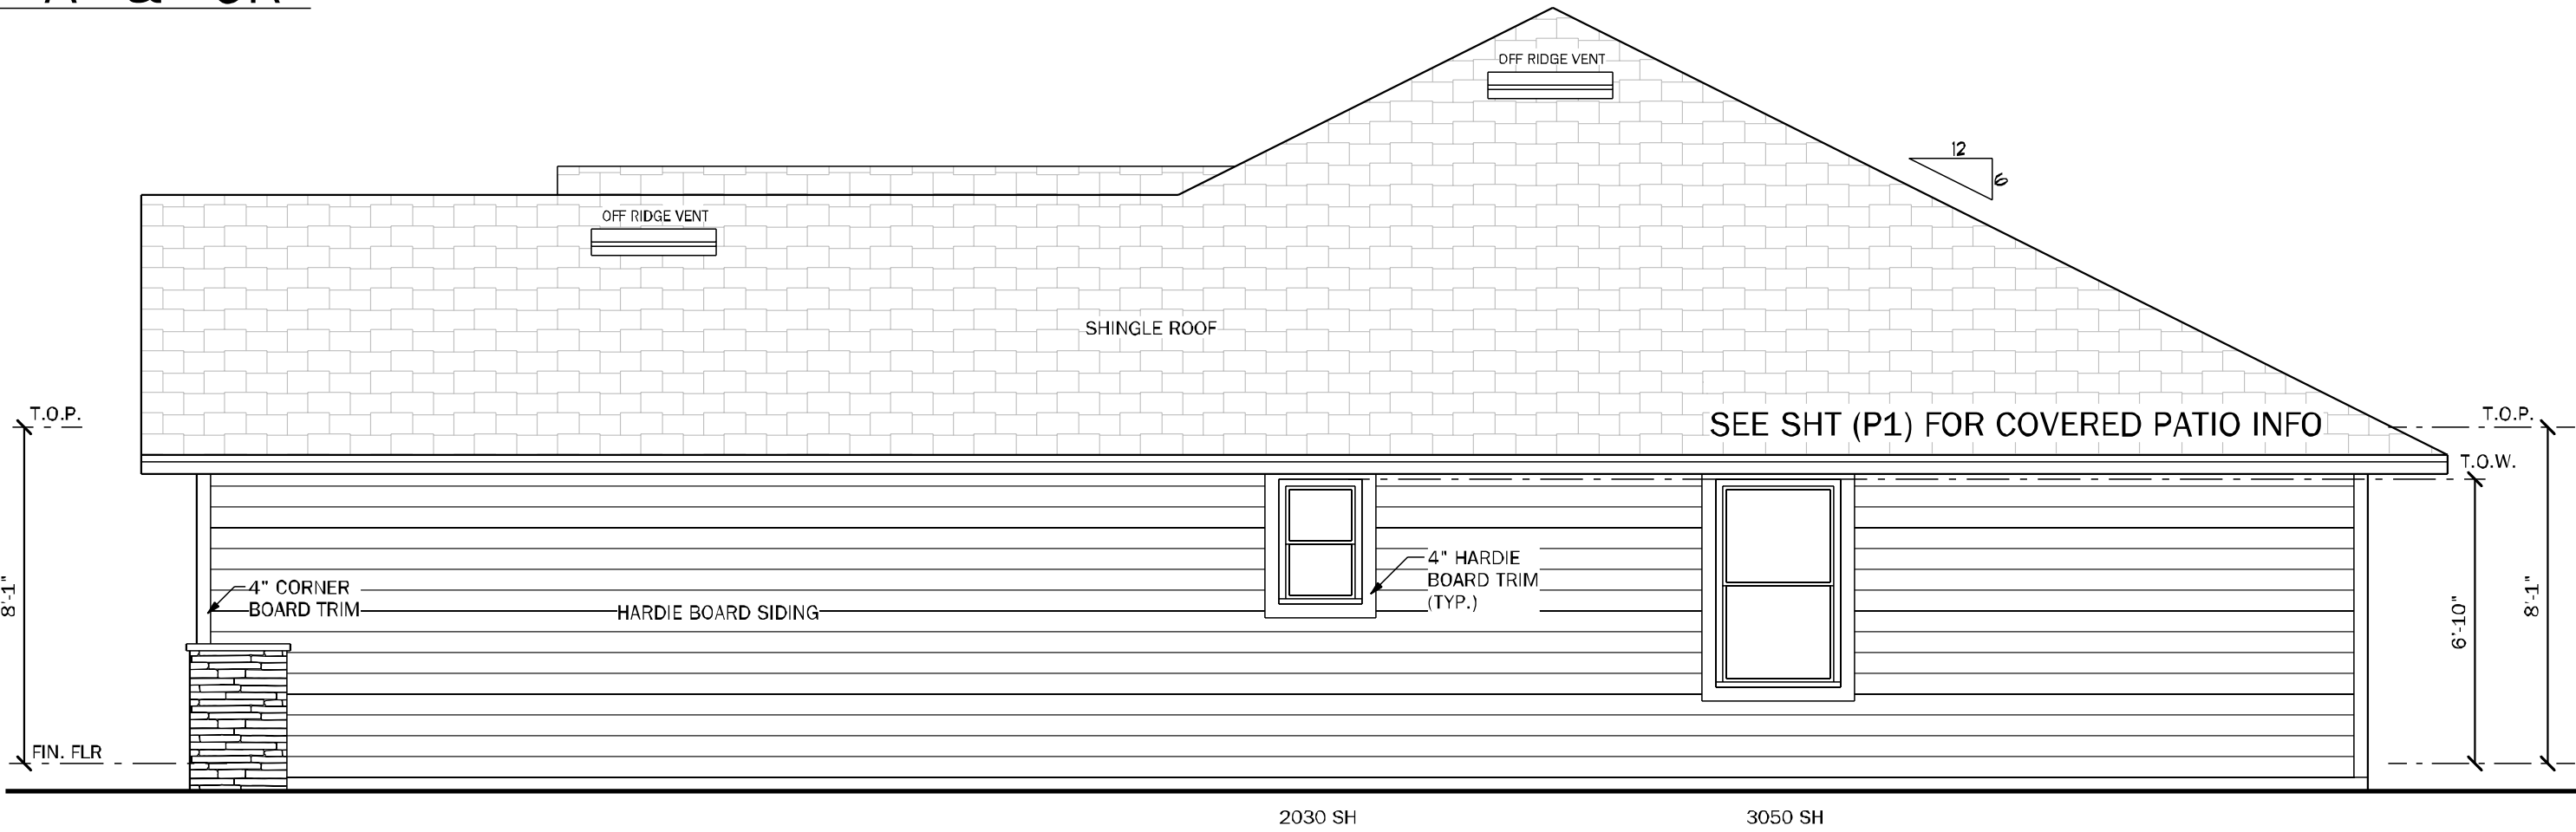

RIGHT ELEVATION "A" & "CR"
SCALE:1/4"=1'-0"

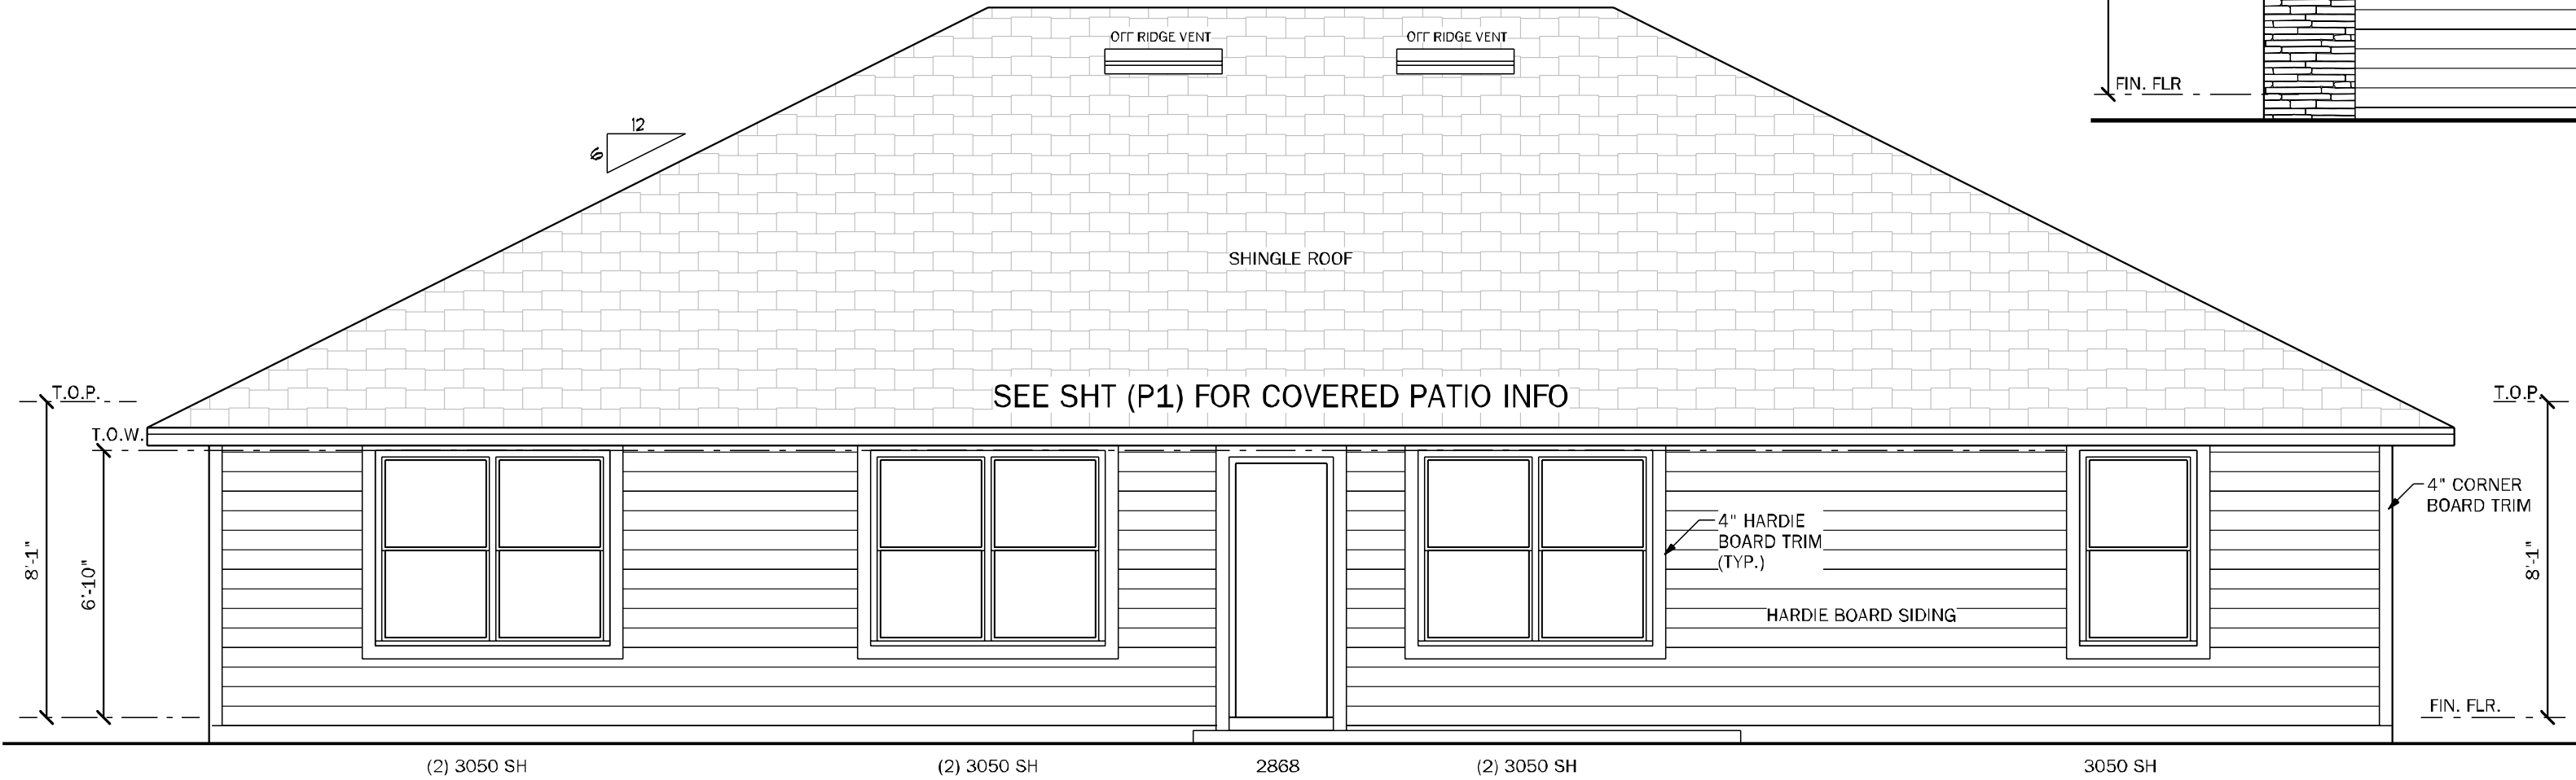

REAR ELEVATION ALL
SCALE:1/4"=1'-0"



FRONT ELEVATION "CR"
SCALE:1/4"=1'-0"

VENTILATION CALCULATION

Calculations shown below are for both, off ridge and ridge vent systems. Only ONE system is required. See builder's specs for product used. Formula = $Sf / 300 * 144$ = net sq. inches of venting needed. (Based on the 1/300 exception for the minimum vent area).	
S.F. of Area to be vented (SF)	2753
Total needed for exhaust for upper 1/3 Upper = 45% approx.	595 net sq inches
Total needed for intake (soffit area, lower) Lower = 55% approx.	727 net sq inches
Total needed combined to be no less than 40% and no more than 50%	1322 Upper 1/3= 45%
Soffit product provides	6.97 net sq in / sf
Overhang distance	2.00 ft
Net sq in per linear feet of soffit	13.14 sq in / lf
Linear Feet of Soffit needed to meet required	56
Linear Feet of Soffit provided by plan	169
Option one (Ridge vents)	
Ridge vent provides	18.00 net sq in / lf
L.F. of Ridge Vent needed	34
Option two (Off ridge vents)	
Off ridge vent provides	138.00 net sq in / sf
Number of Off Ridge Vents for upper 1/3	5

COUNTY
SEAL

Wednesday, March 19, 2025

To the best of the Engineer's knowledge, information and belief, the structural plans and specifications contain within these drawings comply with the 2023 Florida Building Code: Residential 8th Edition. Engineer's signature and seal is only for the structural engineering portions of the drawing pages bearing engineer's signature and seal.

CA No. 9161 AA26003115



TOTAL SOLUTIONS GROUP
258 Southhall Lane, Suite 200
Maitland, Florida, 32751
(407) 880 2333

100% Employee Owned
myTSGhome.com

DAMS HOMES
FLORIDA CONTRACTORS LICENSE NO. CRC1330146
**100 WEST GARDEN STREET
PENSACOLA FL 32502**

DIVISION LOCATION:
GAINESVILLE

Job Information:

INVENTORY

LOT: 12
BLK:
SEC:
SUB: PRESERVE AT LAUREL LAKE
133 SW BELFLOWER DR.
LAKE CITY

Model Name / Number:

2117

Plan Issue Date:

Wednesday, March 19, 2025

KA PROJECT NUMBER:


25-02684


Sheet:

5


Of:

ELEVATIONS-A

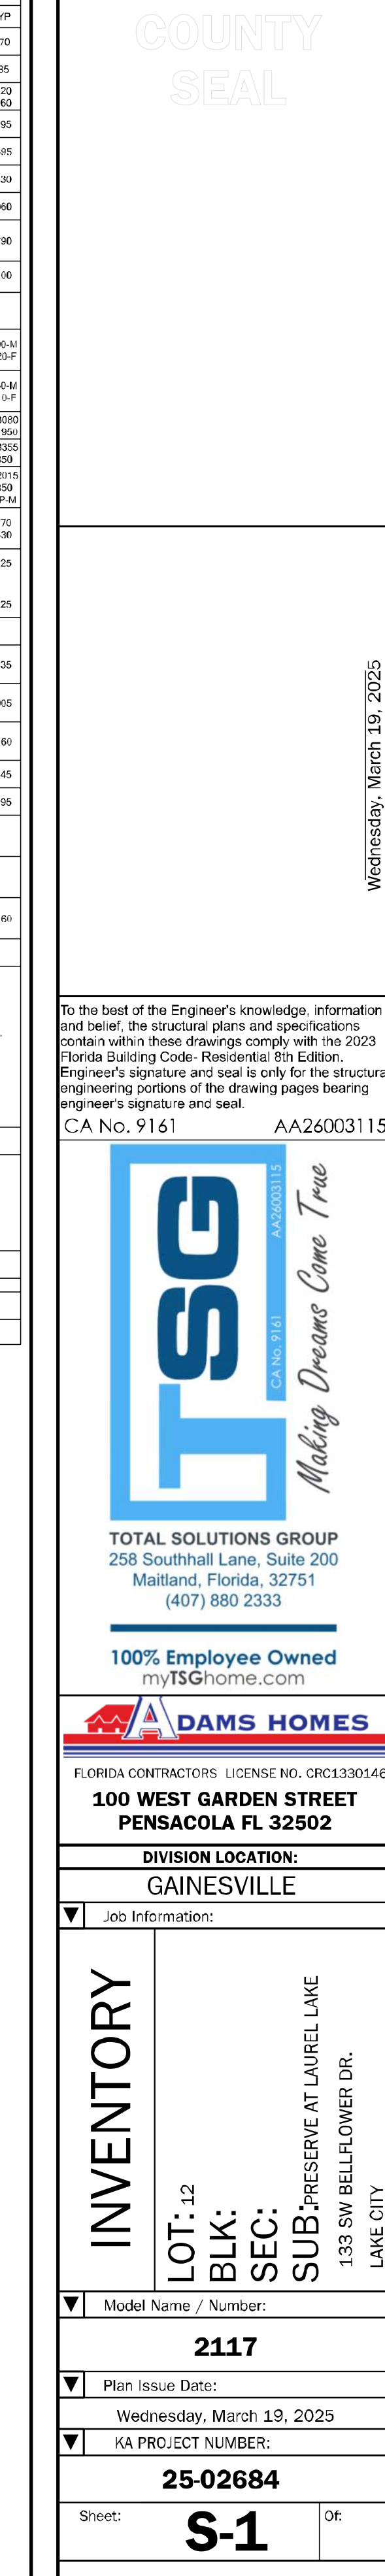


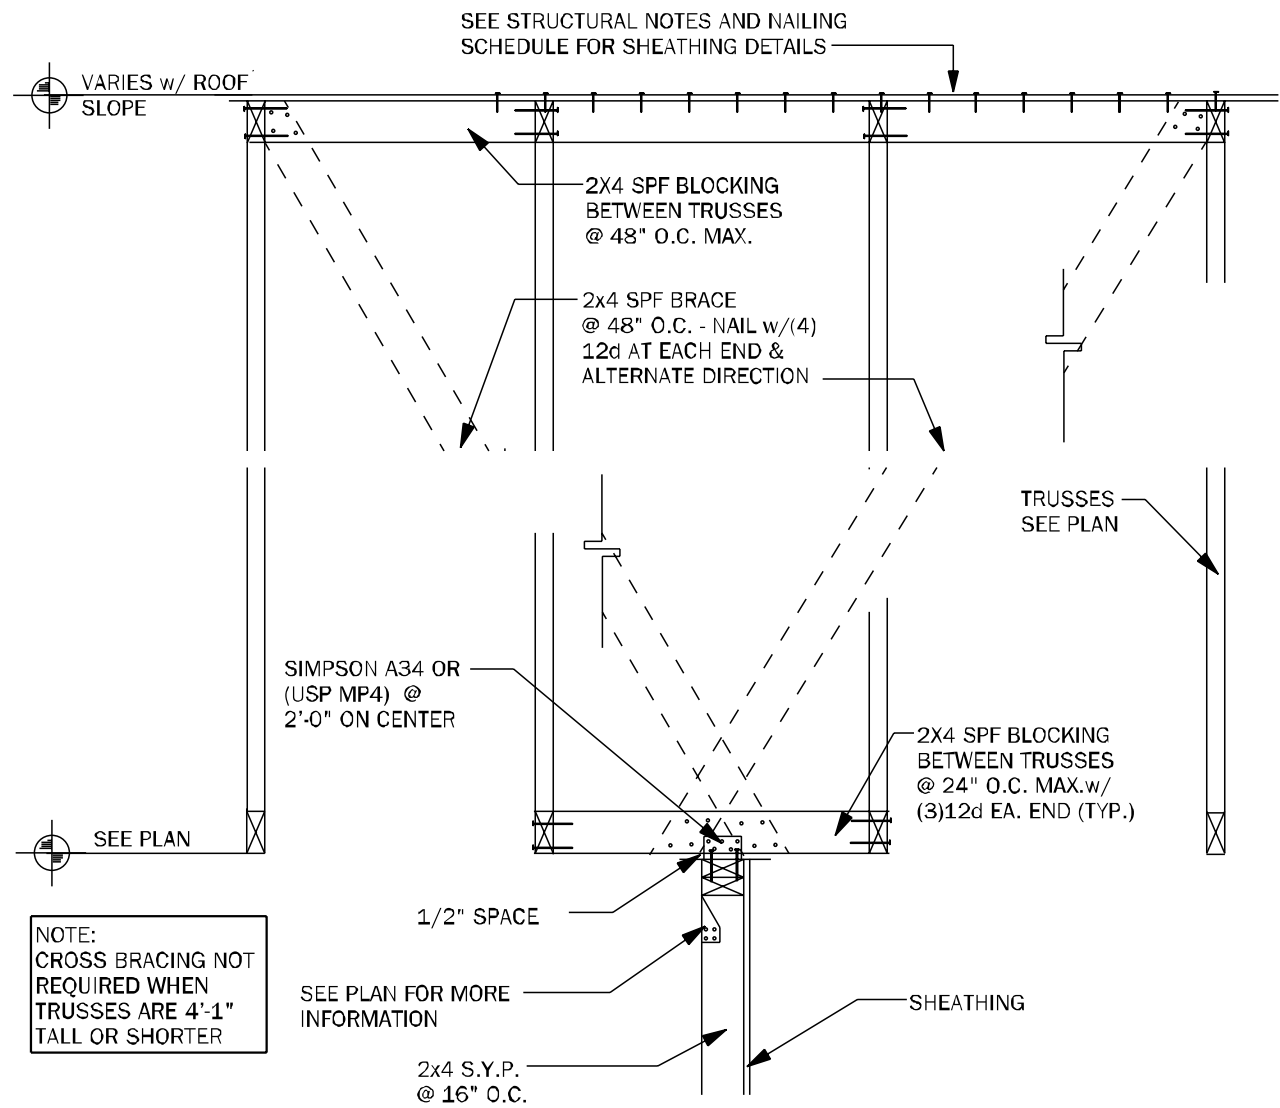


TB15 EXTERIOR NON-BEARING WALL DETAIL N.T.S.

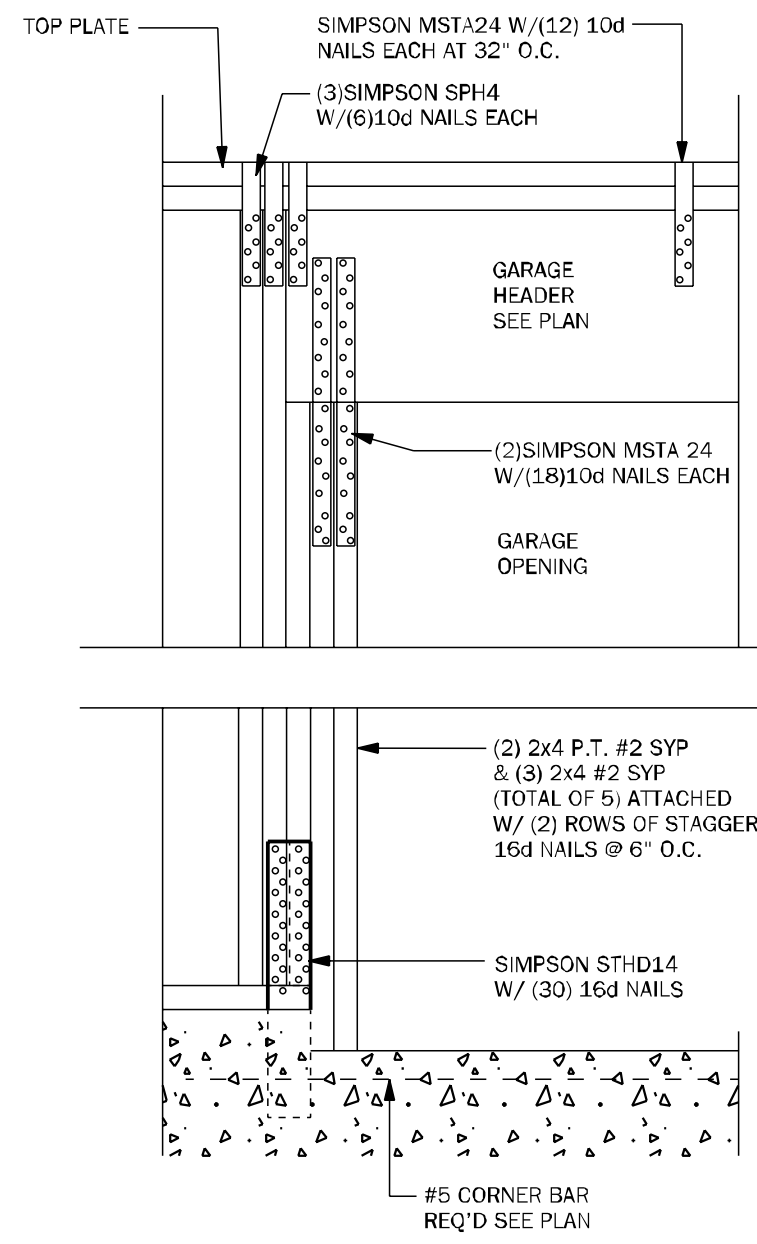


WC04 GARAGE HEADER ANCHOR 3/4" = 1'-0"

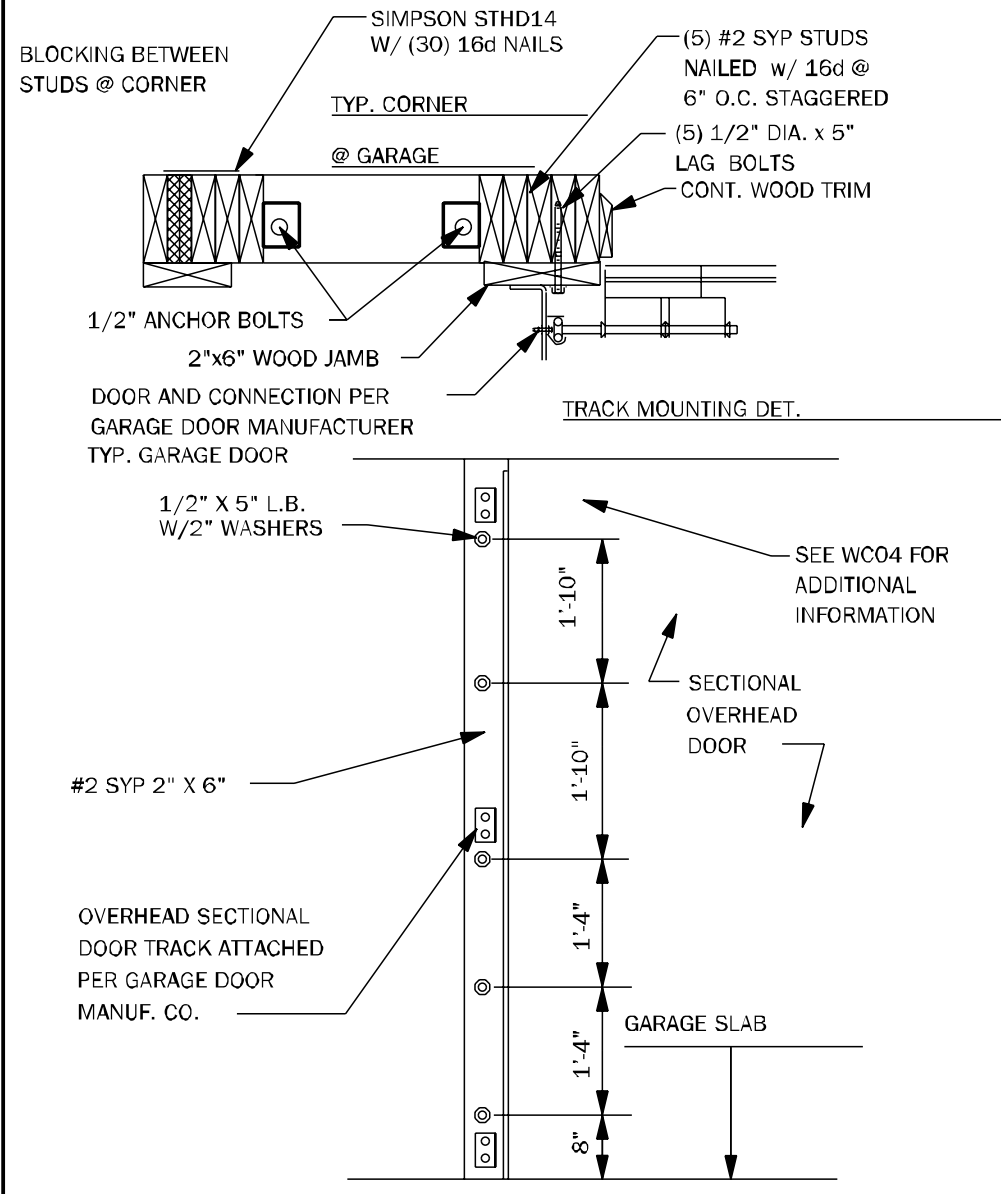


WC05 SECT. OVERHEAD GAR. DOOR INSTALL N.T.S.

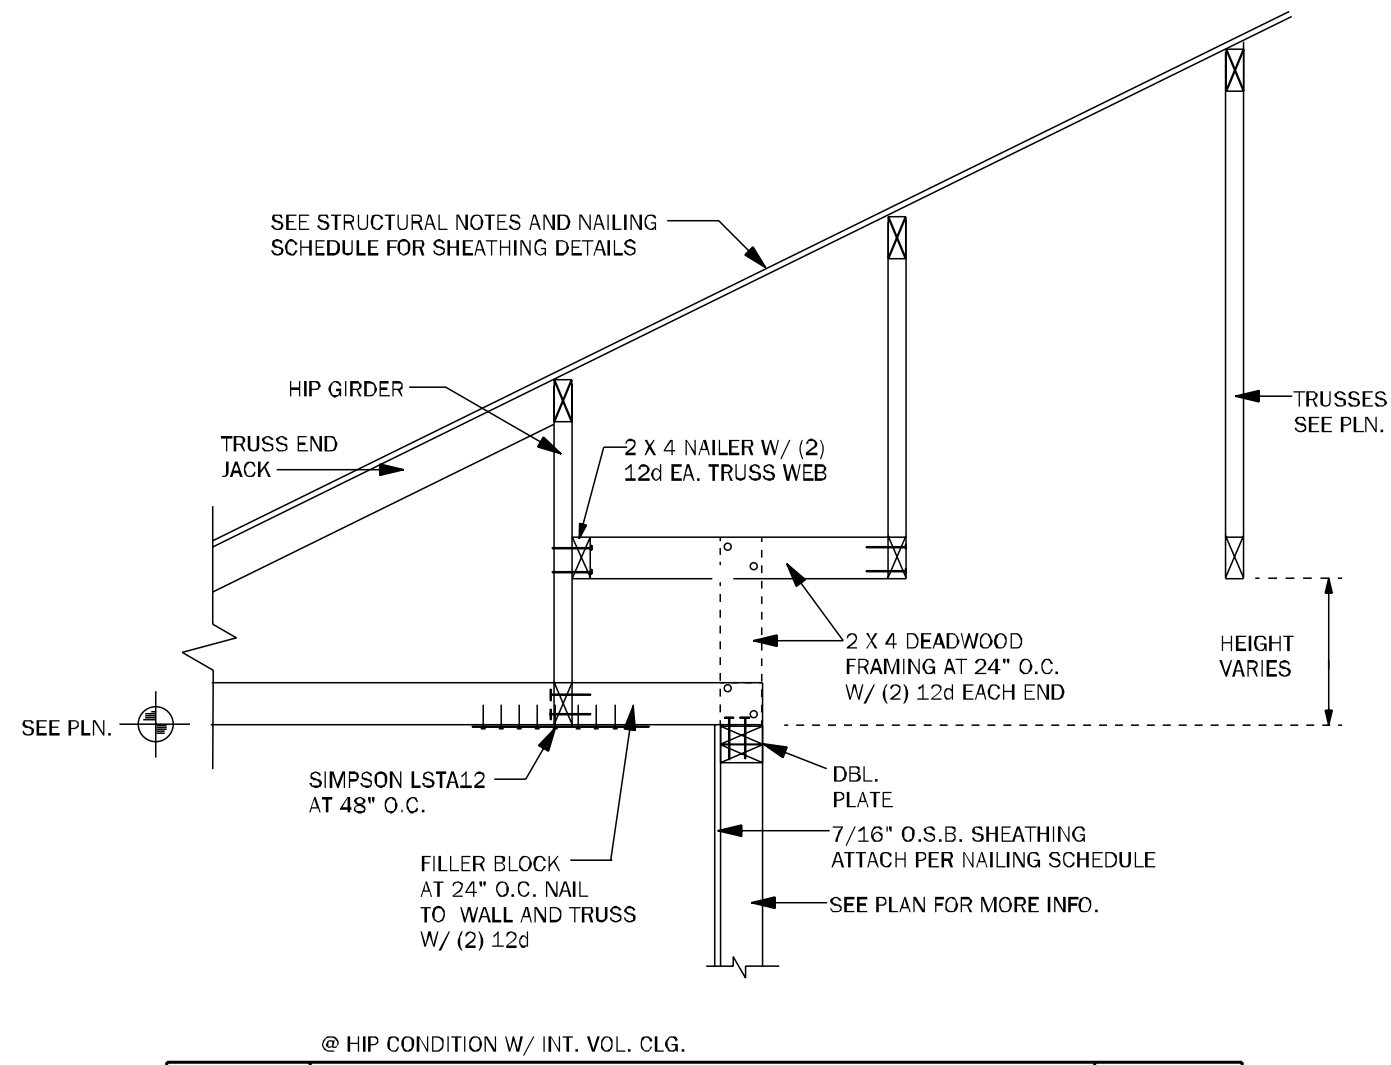


WF64 EXTERIOR NON BRG. WALL DETAIL N.T.S.

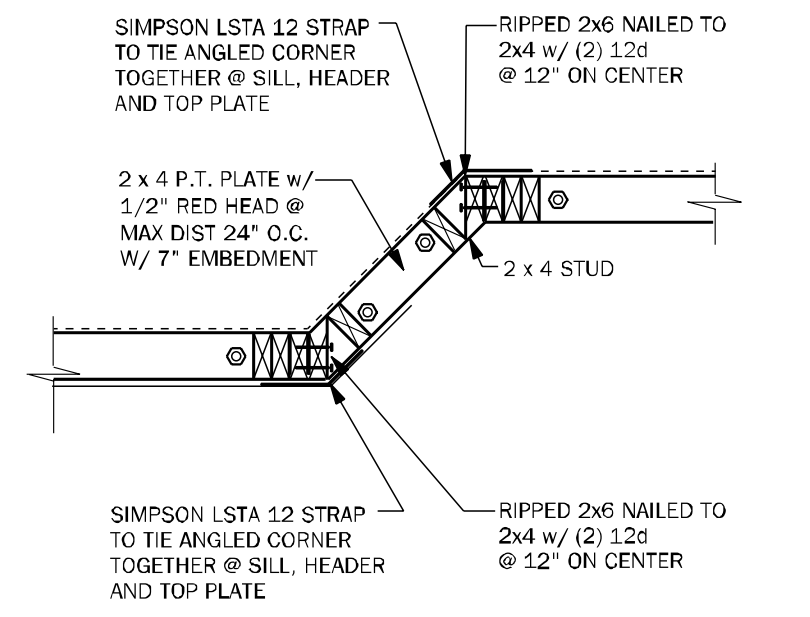


WF43 EXTERIOR ANGLED WALL DETAIL N.T.S.

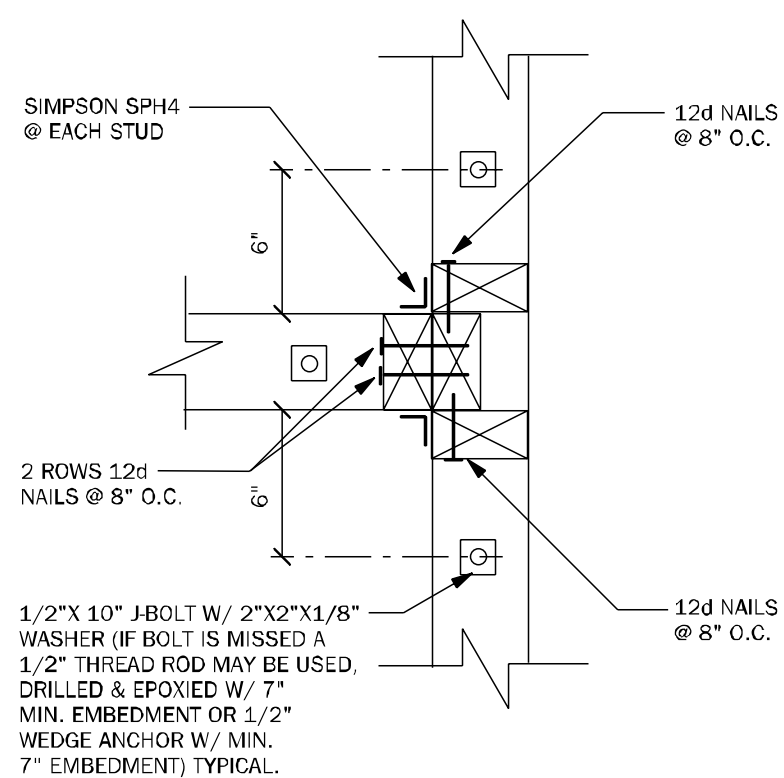


WC03 WALL TO WALL CONN. @ END OF SHEARWALL 1 1/2" = 1'-0"

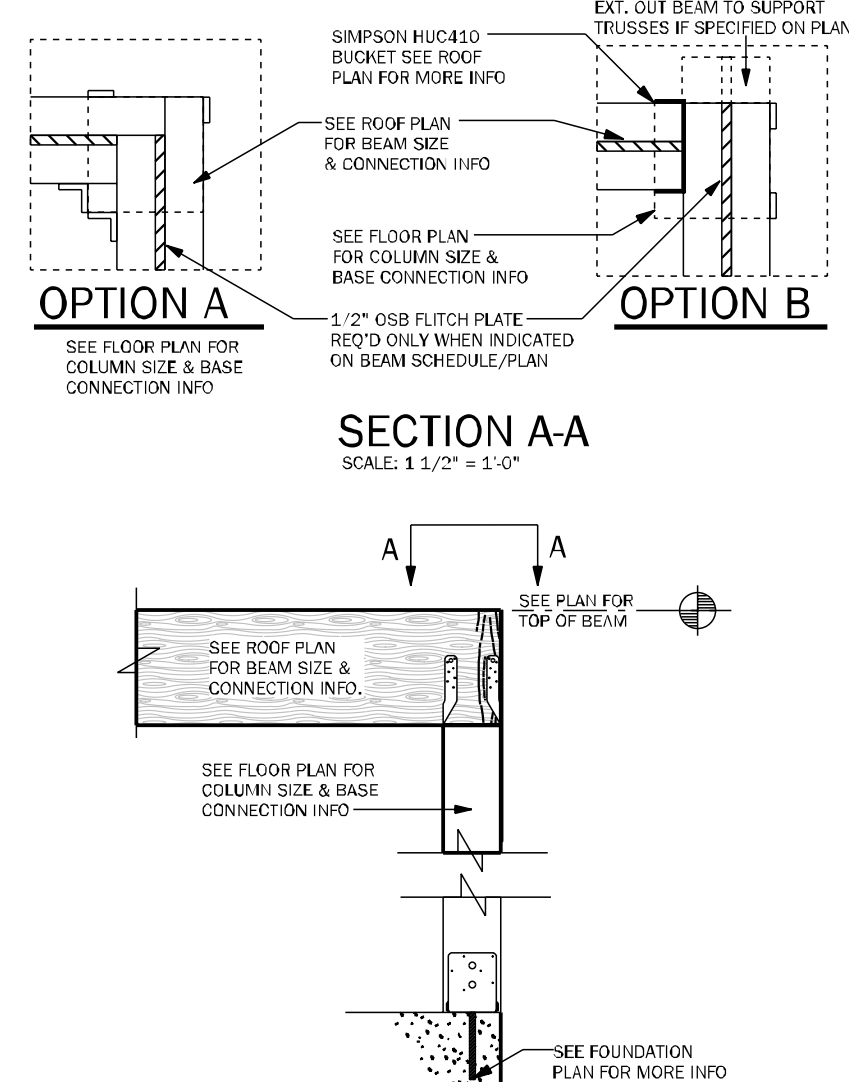


CD11 COMMON BEAM ATTACHMENT N.T.S.

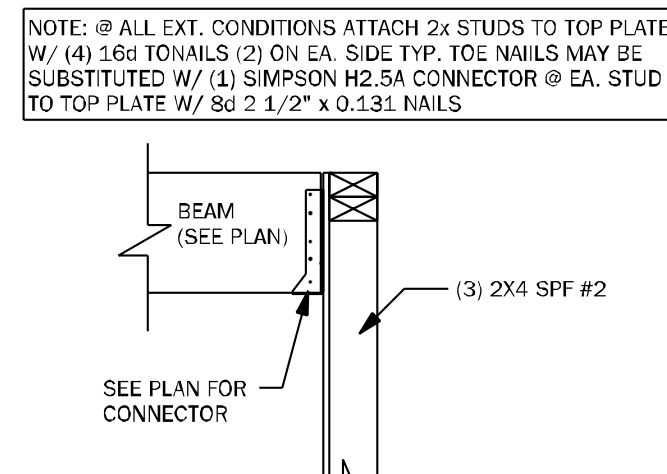


CD25 BEAM TO WALL CONNECTION N.T.S.

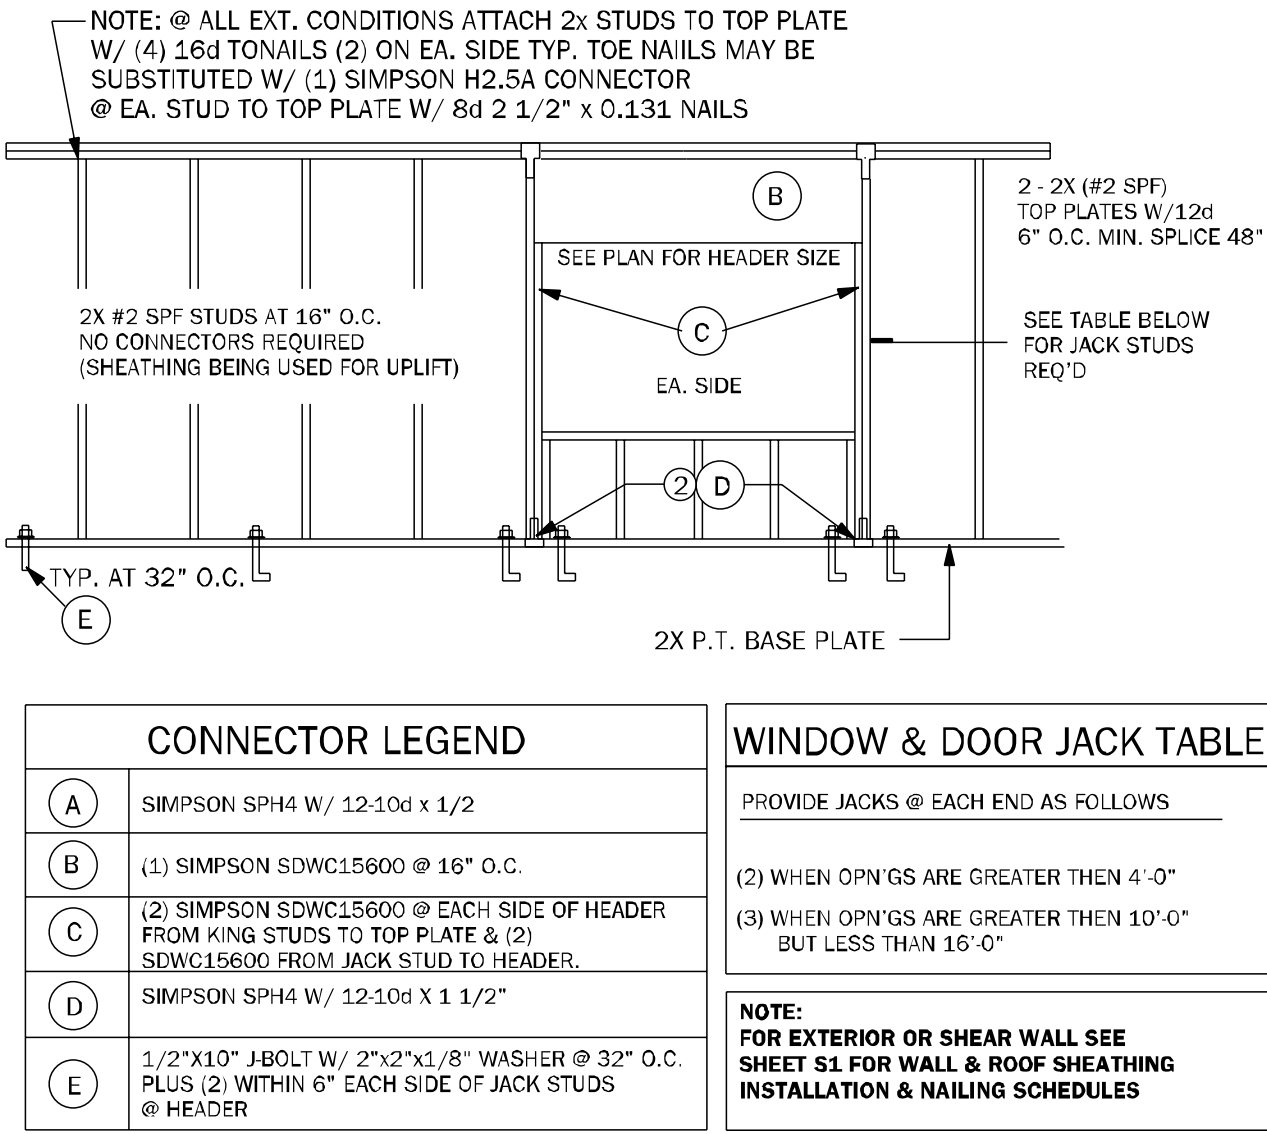


WF66 TYPICAL BEARING WALL N.T.S.

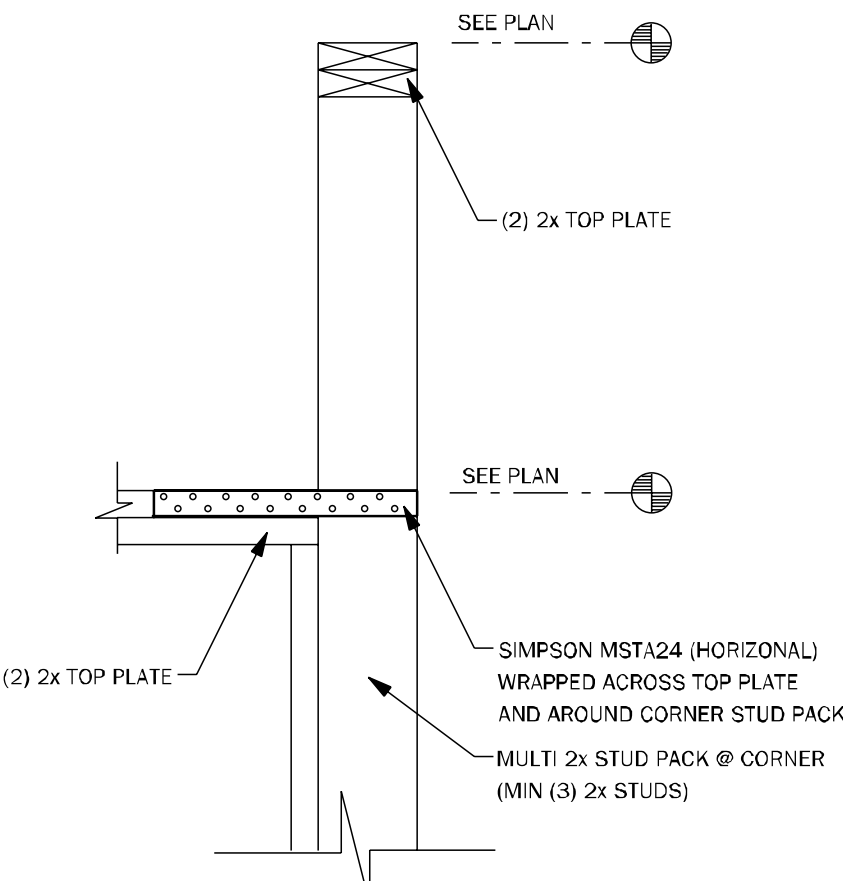


WC09 WALL STEP @ CORNER N.T.S.

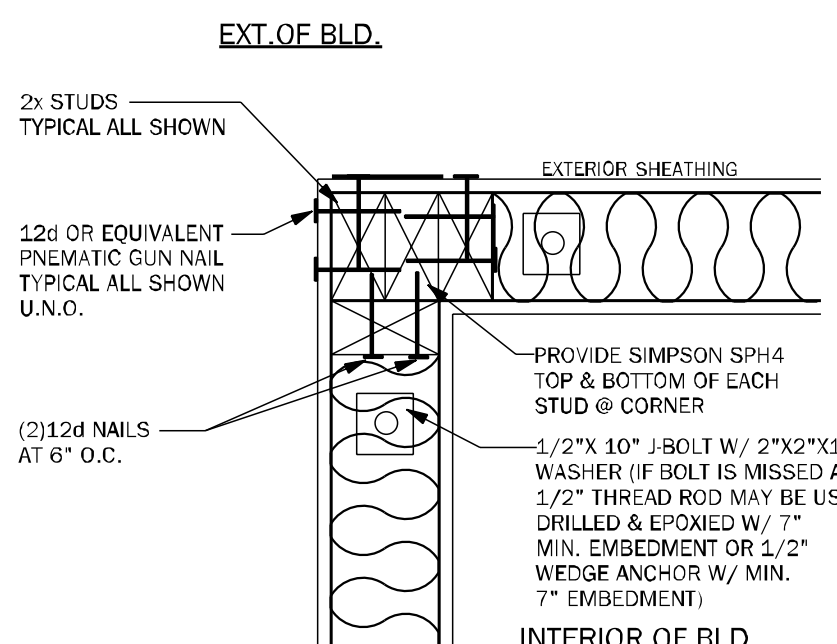


WC06 EXTERIOR FRAME CORNER 3/4" = 1'-0"

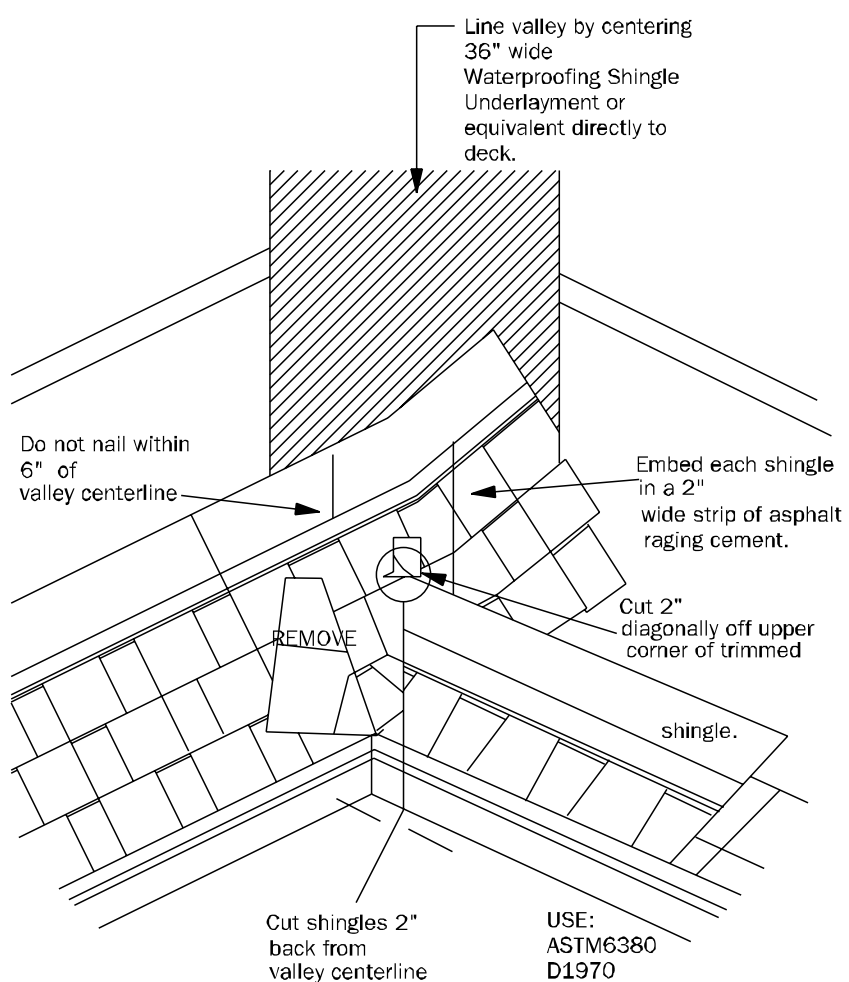

RD01 VALLEY FLASHING DETAIL N.T.S.

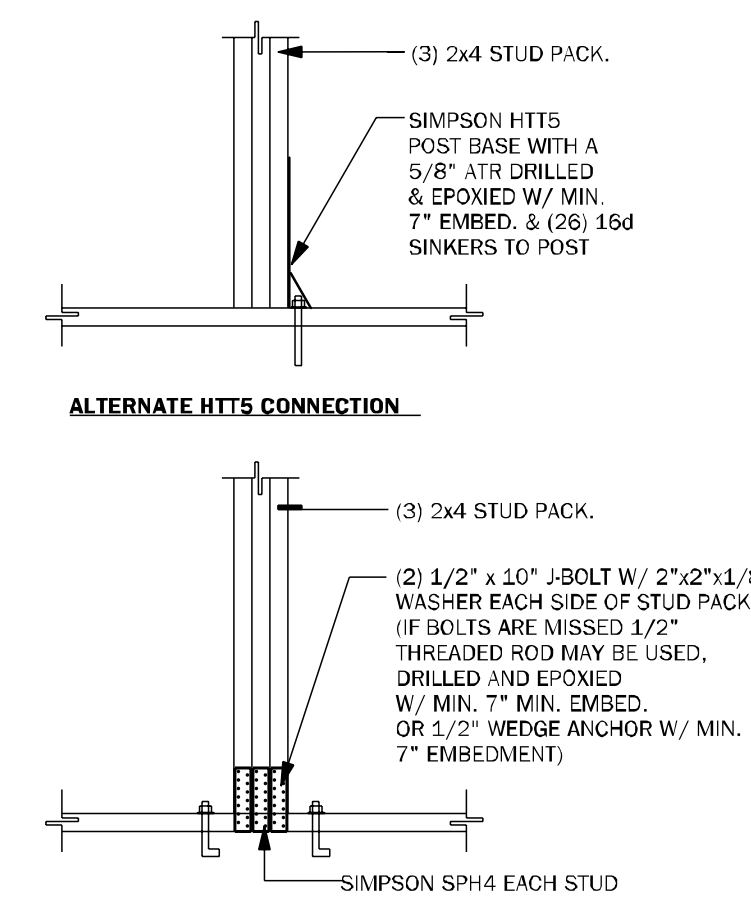

CD26 GIRDER BASE CONNECTION 1/2" = 1'-0"

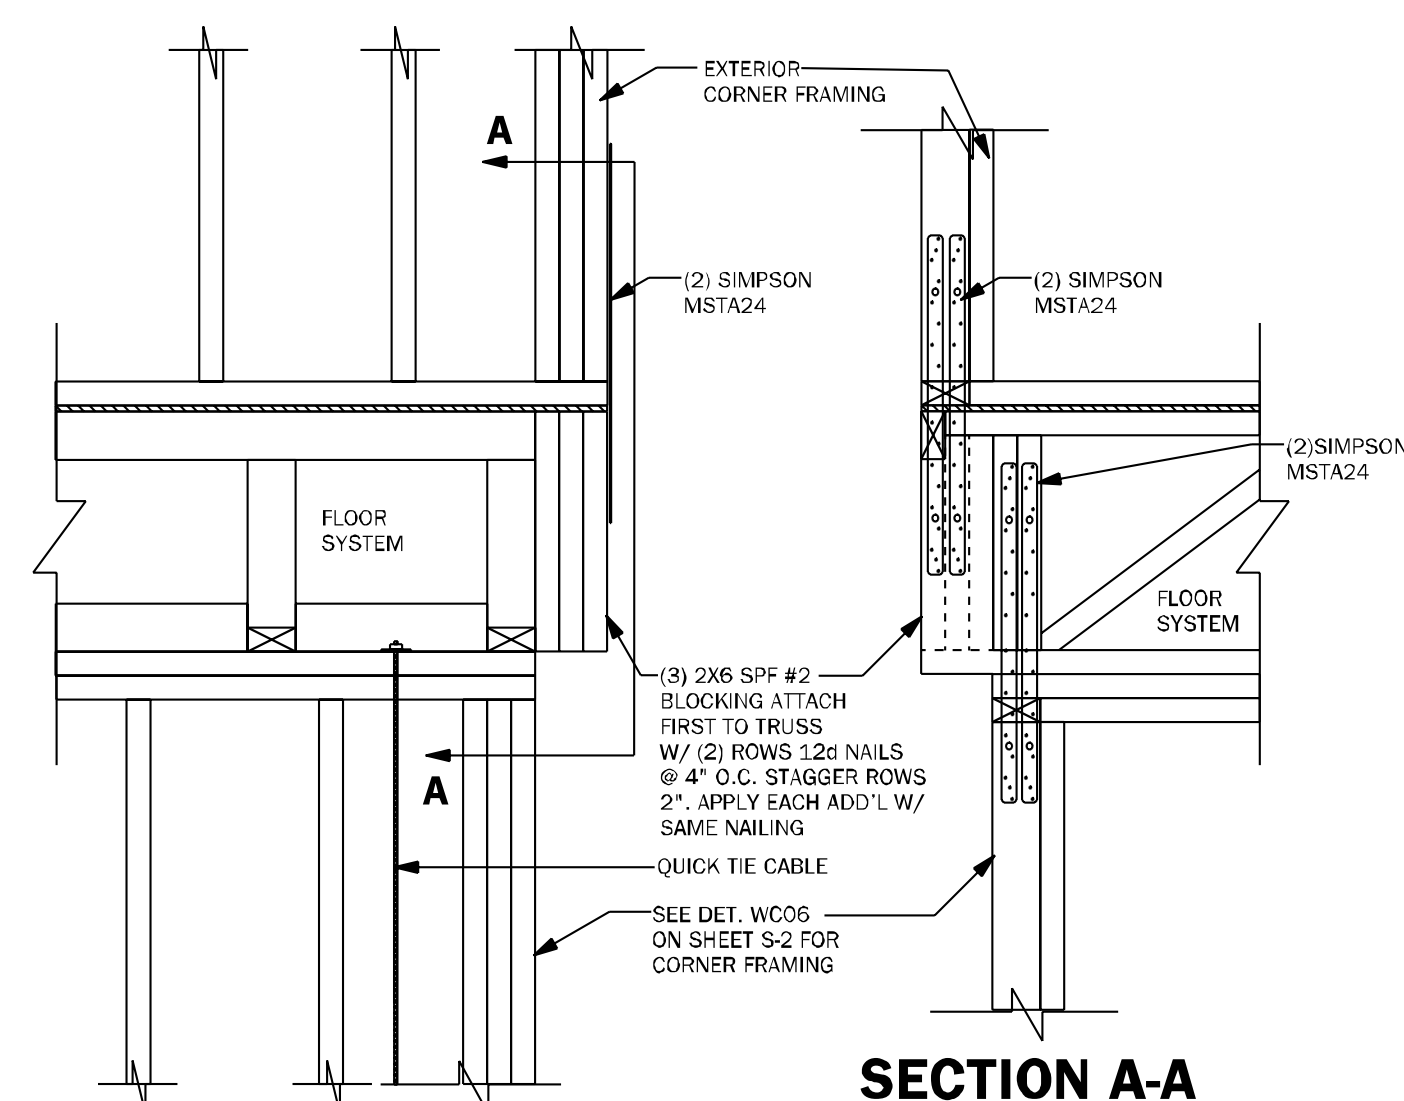

WF68 CORNER CONNECTION N.T.S.

COUNTY SEAL

Wednesday, March 19, 2025

To the best of the Engineer's knowledge, information and belief, the structural plans and specifications contain within these drawings comply with the 2023 Florida Building Code- Residential 8th Edition. Engineer's signature and seal is only for the structural engineering portions of the drawing pages bearing engineer's signature and seal.

CA No. 9161 AA26003115



TOTAL SOLUTIONS GROUP
258 Southhall Lane, Suite 200
Maitland, Florida, 32751
(407) 880 2333

100% Employee Owned
myTSGhome.com



FLORIDA CONTRACTORS LICENSE NO. CRC1330146
**100 WEST GARDEN STREET
PENSACOLA FL 32502**

DIVISION LOCATION:
GAINESVILLE

Job Information:

INVENTORY

LOT: 12
BLK:
SEC:
SUB: PRESERVE AT LAUREL LAKE
133 SW BELLFLOWER DR.
LAKE CITY

Model Name / Number:

2117


Plan Issue Date:
Wednesday, March 19, 2025

KA PROJECT NUMBER:


25-02684

Sheet: **S-2** of:


TYPICAL FRAMING DETAILS

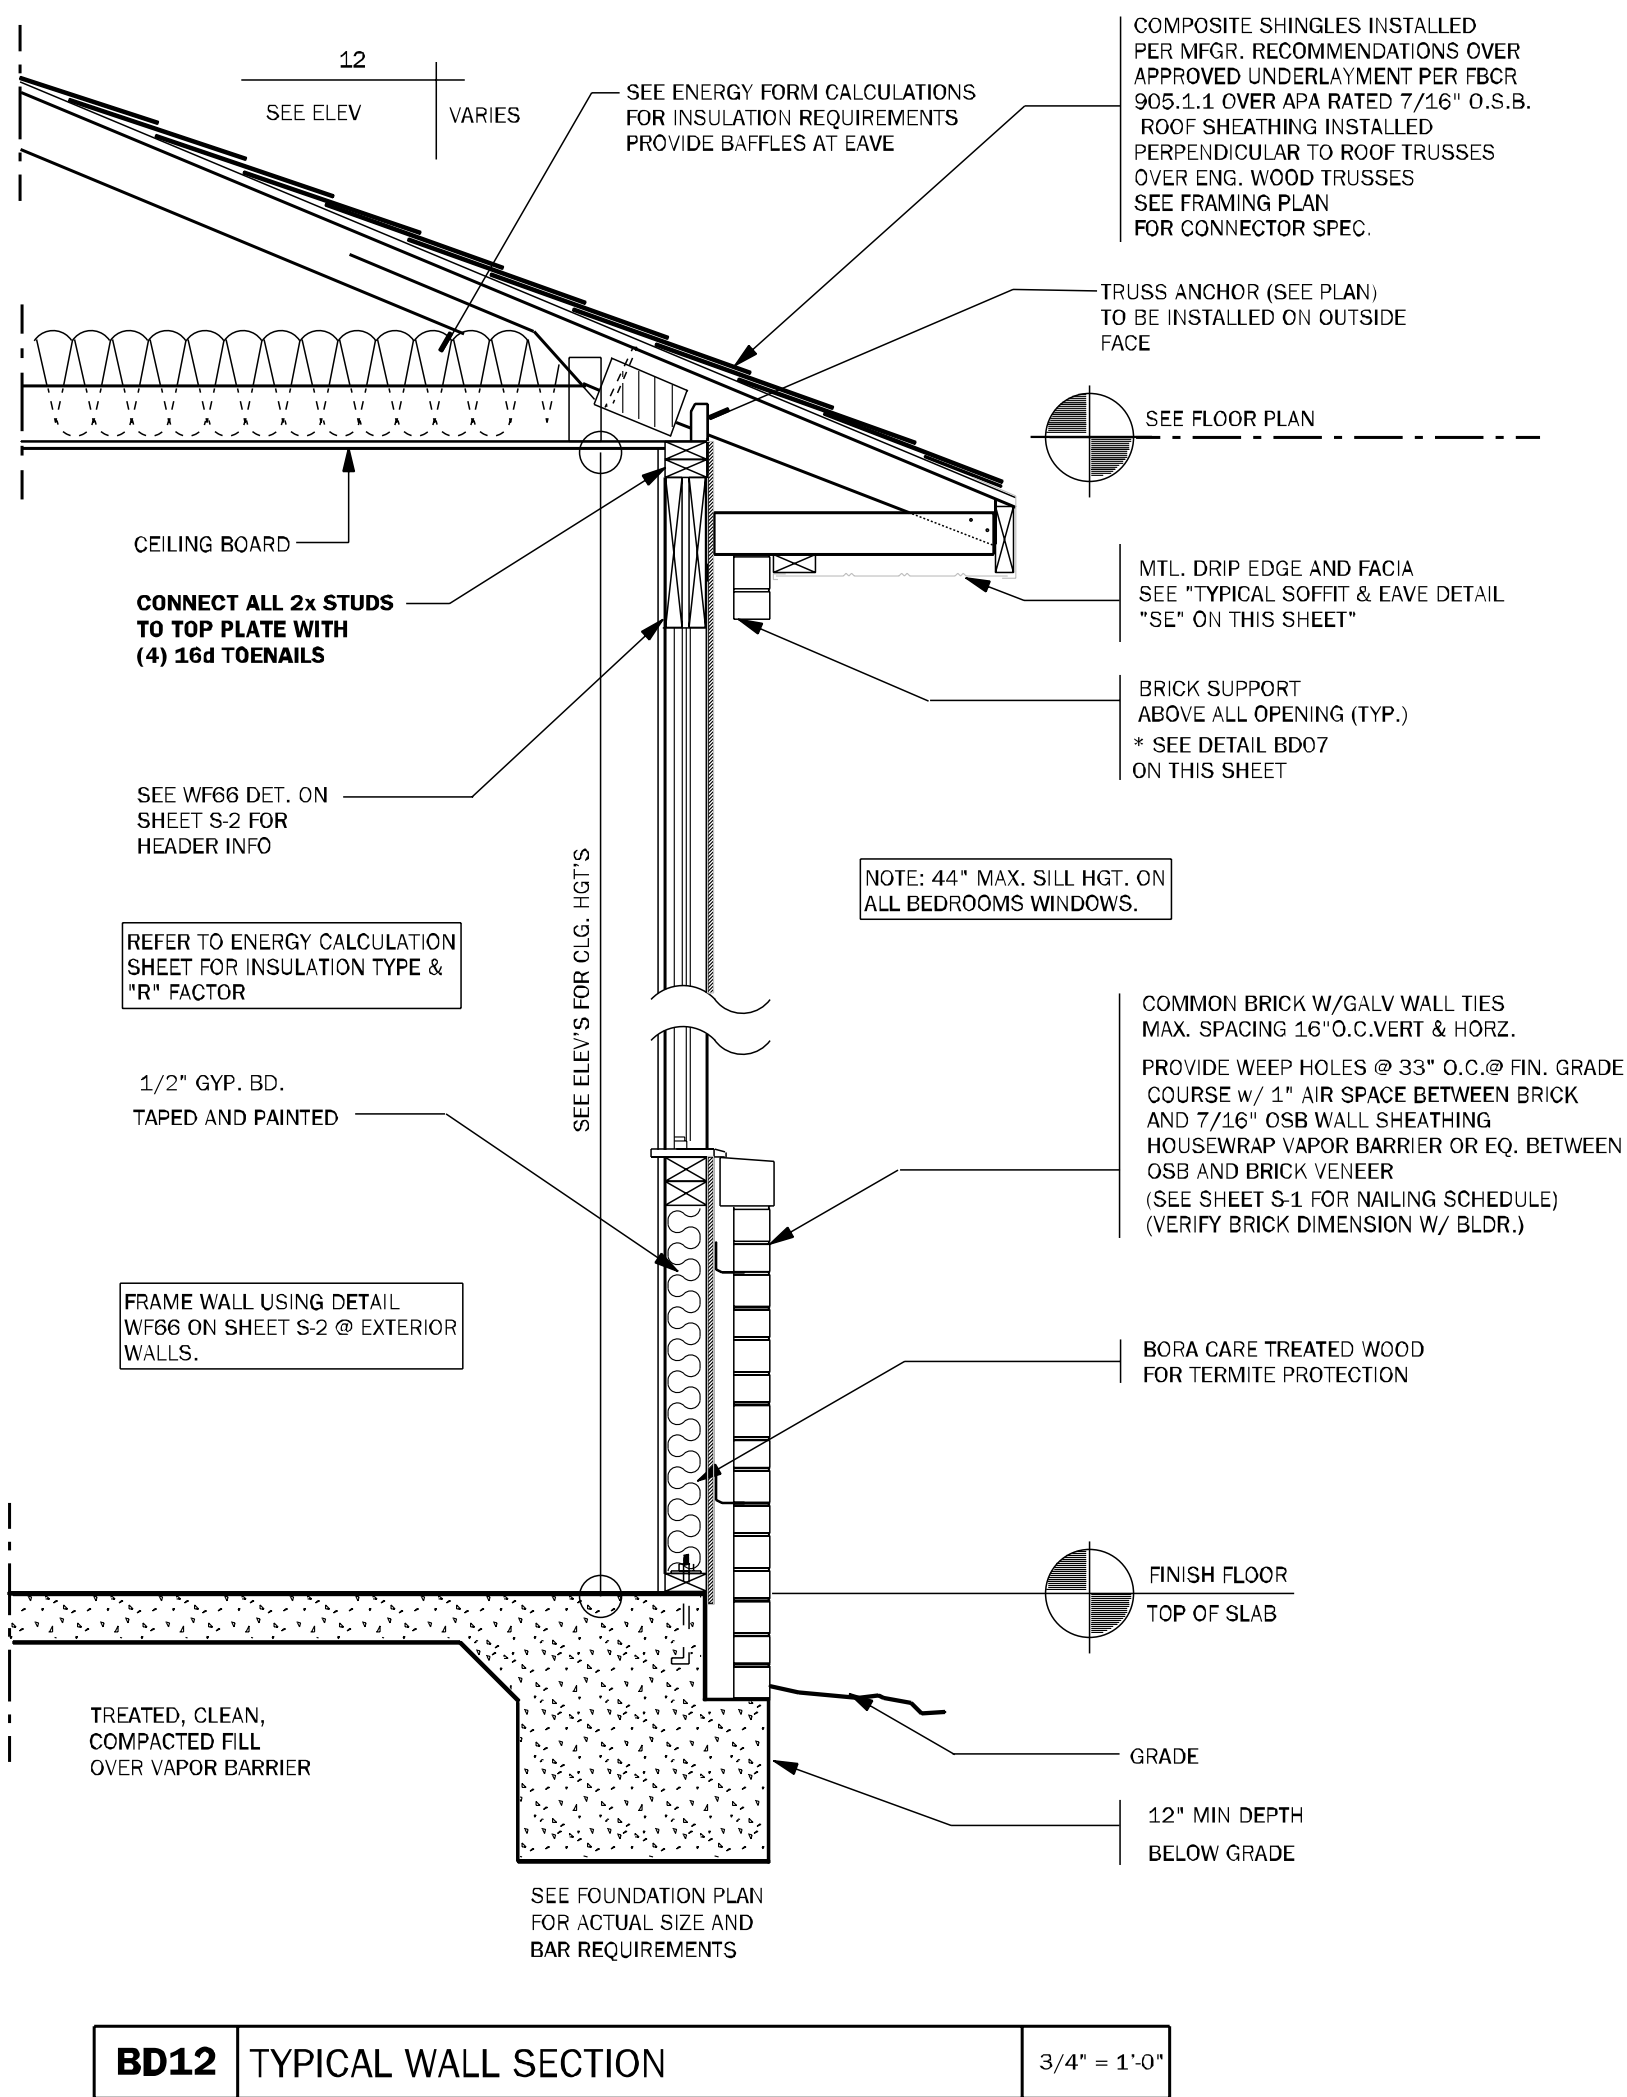


BD12 TYPICAL WALL SECTION 3/4" = 1'-0"

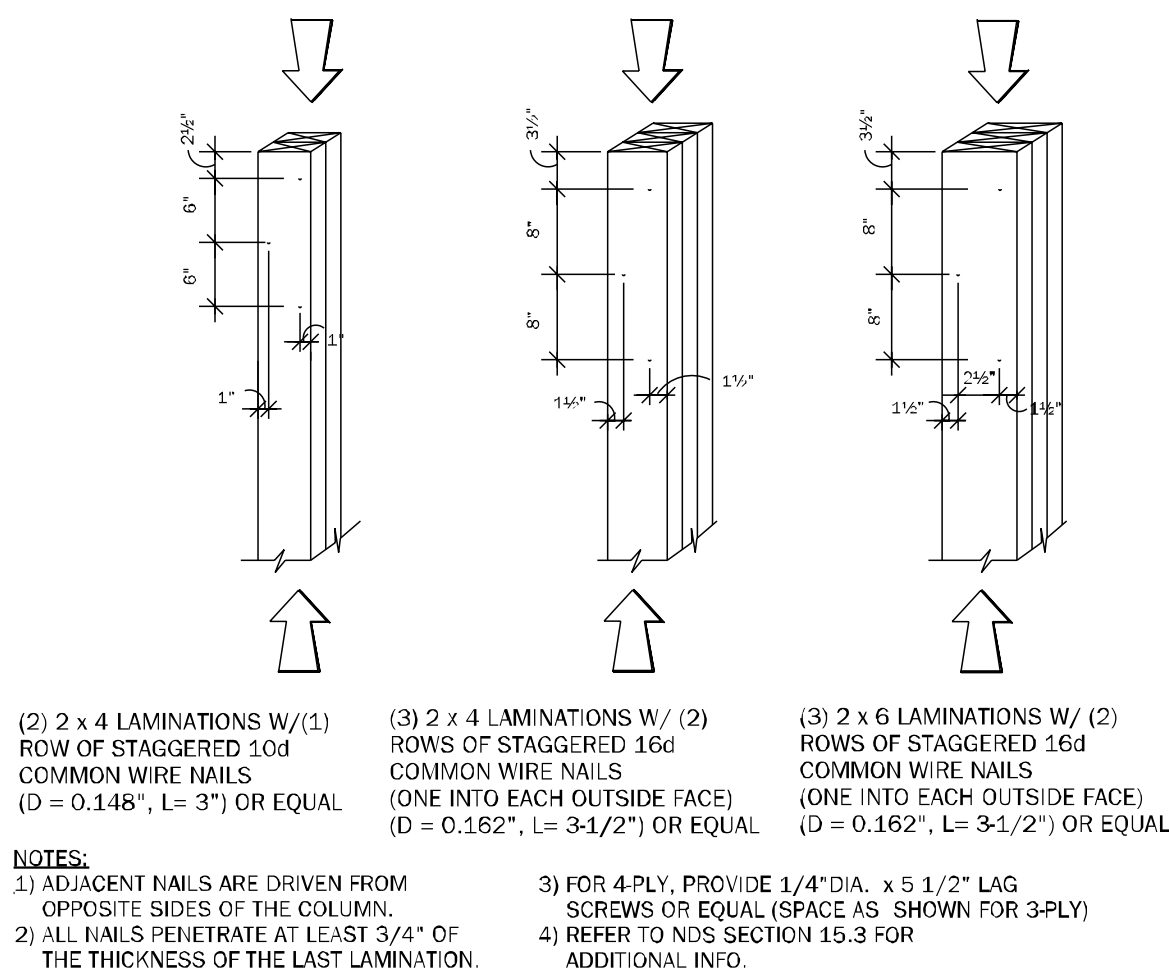


WF37 TYPICAL COLUMNS DETAILS N.T.S.

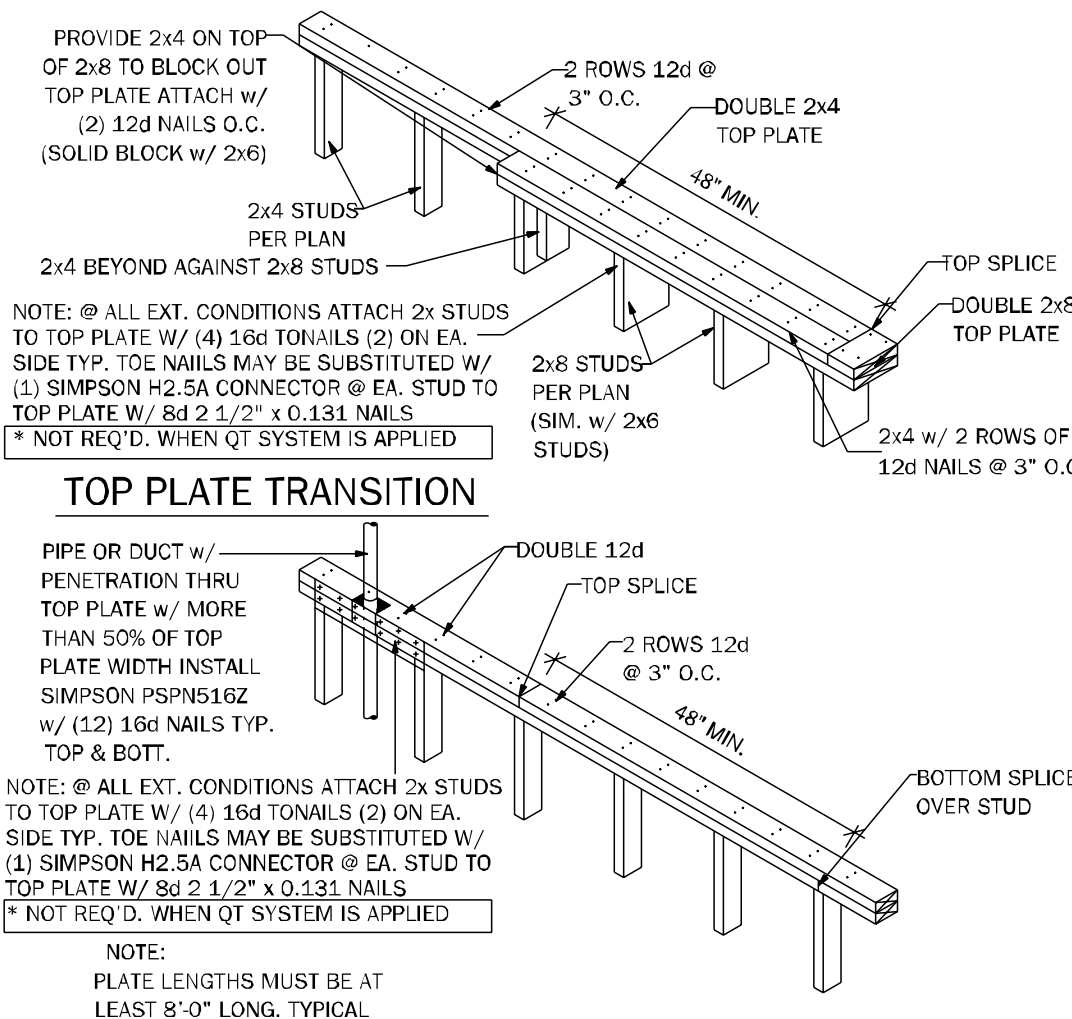


WF17 TOP PLATE SPLICE DETAIL 3/4" = 1'-0"

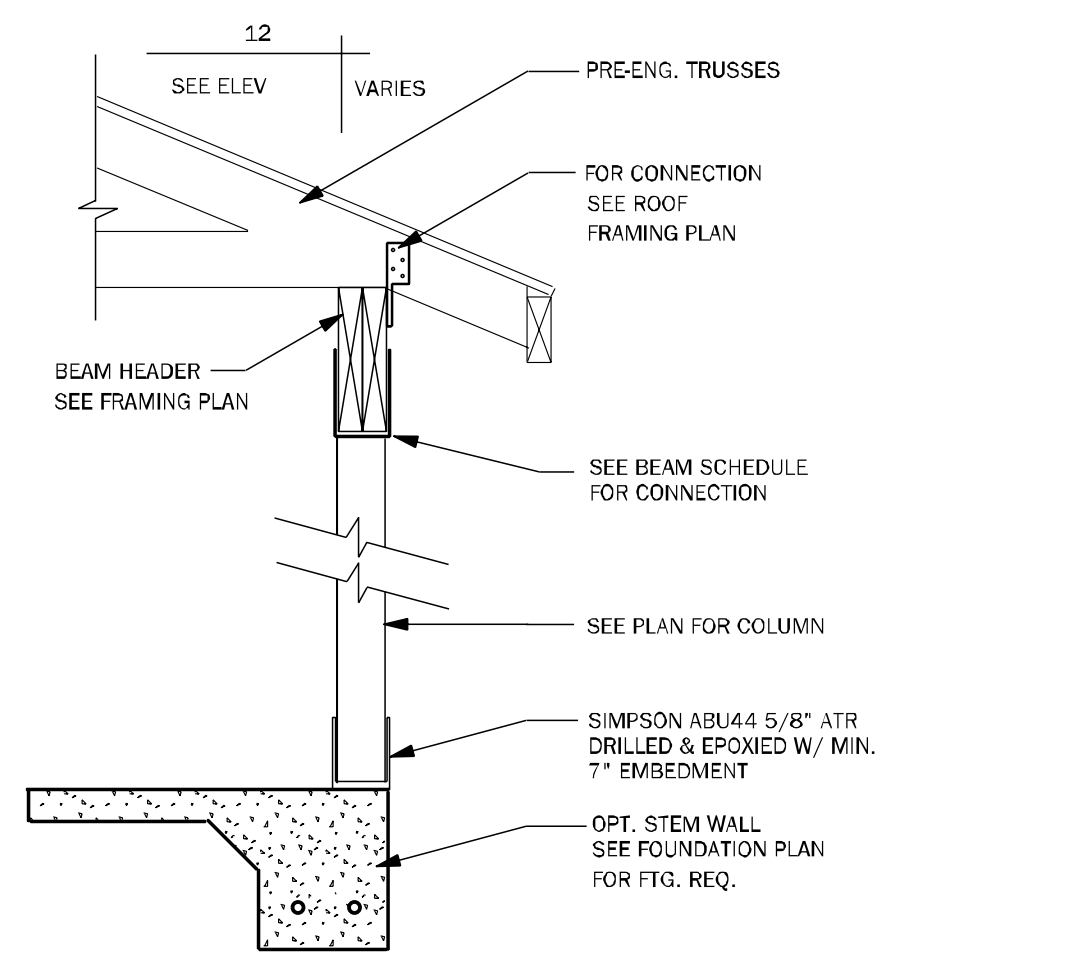


CD24 POST & BEAM DETAIL 1/2" = 1'-0"

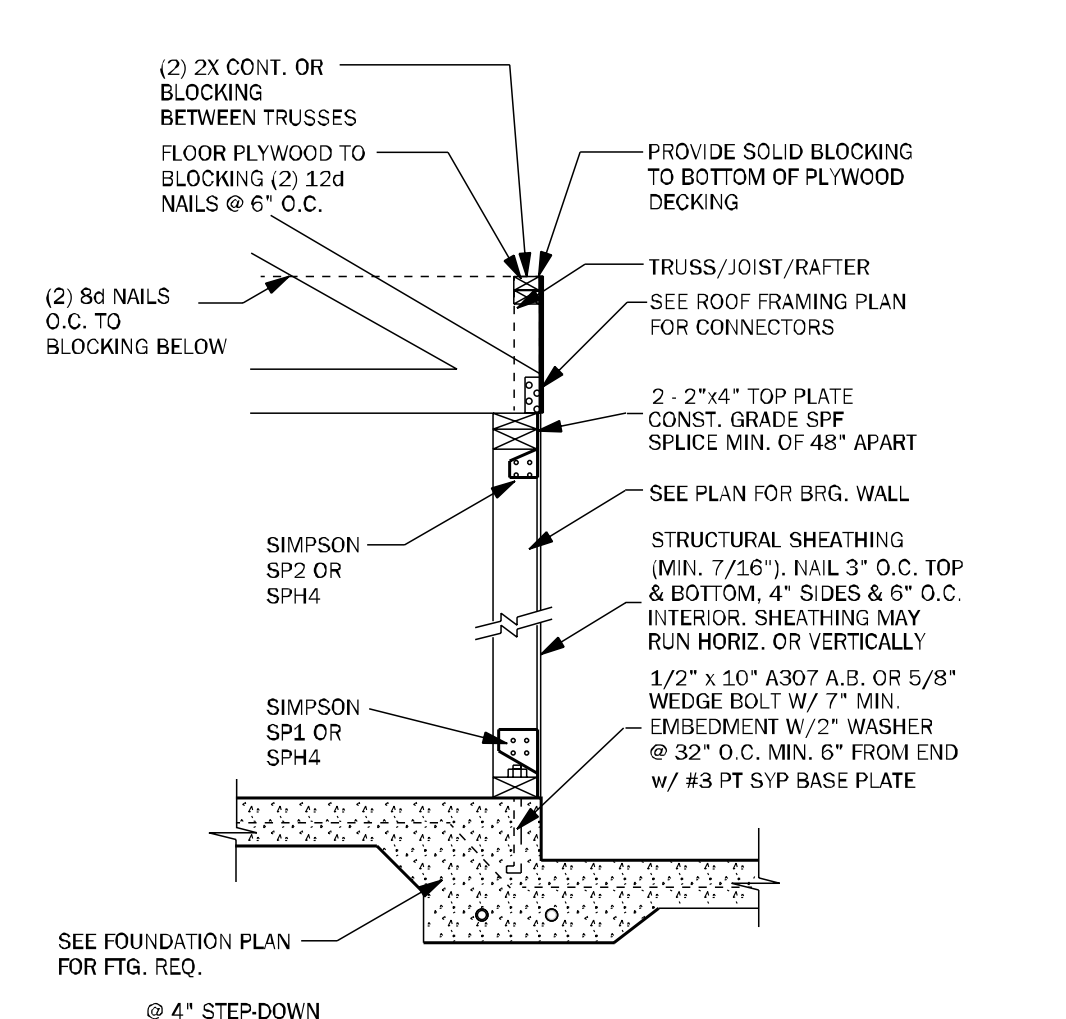


SW01 INTERIOR BEARING SHEARWALL w/UPLIFT N.T.S.

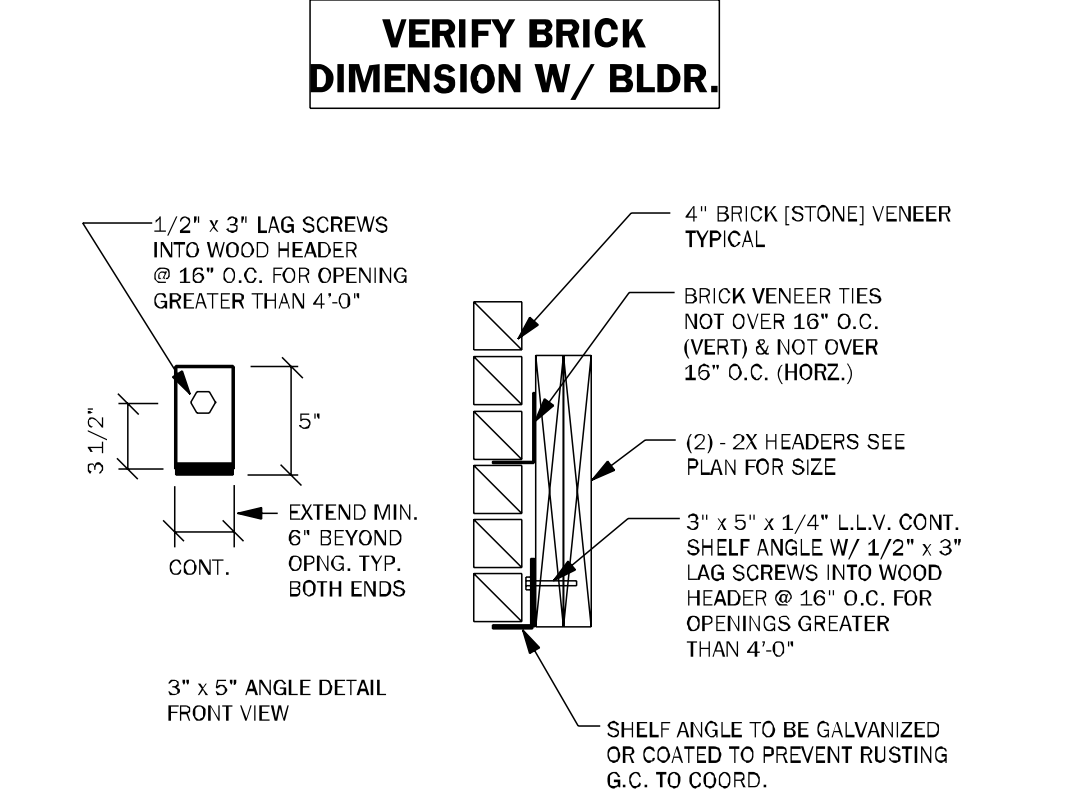


BD07 BRICK SHELF DETAIL N.T.S.

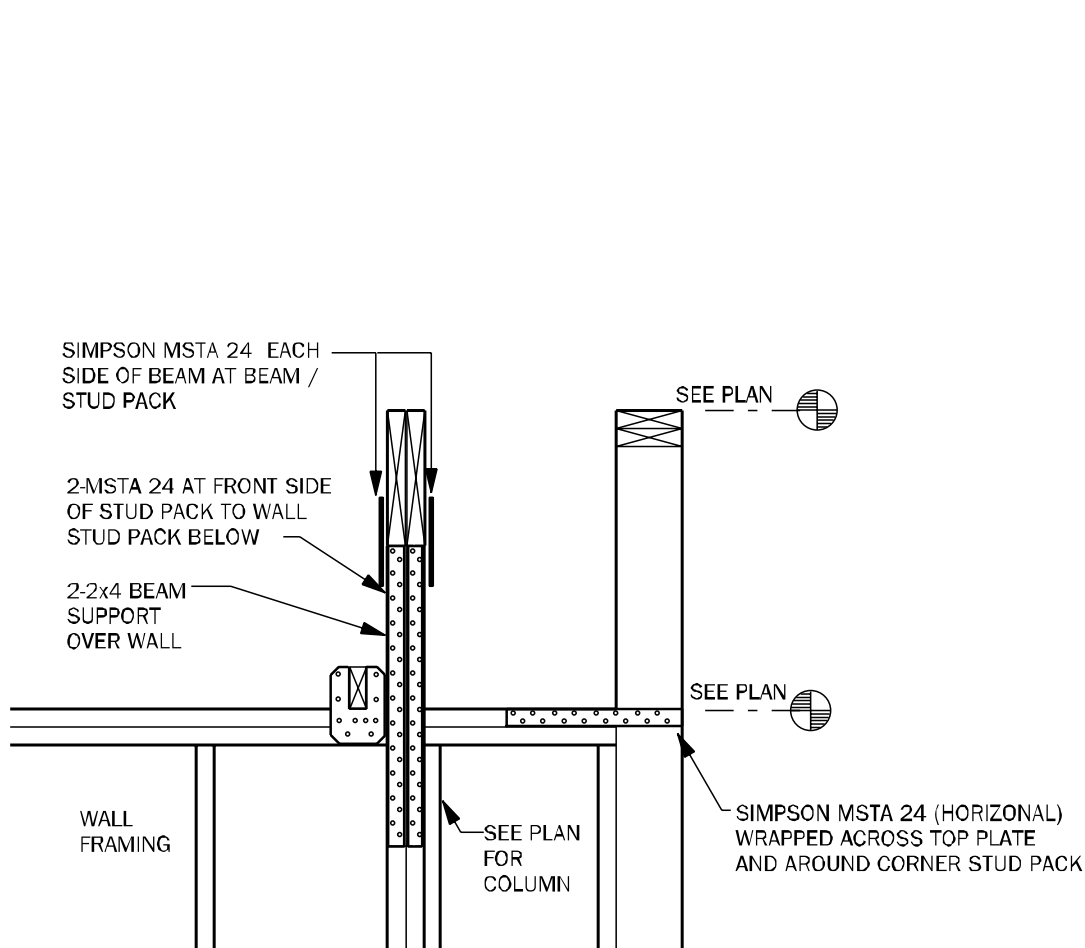


WC08 STEP UP @ CORNER & RAISED BEAM N.T.S.

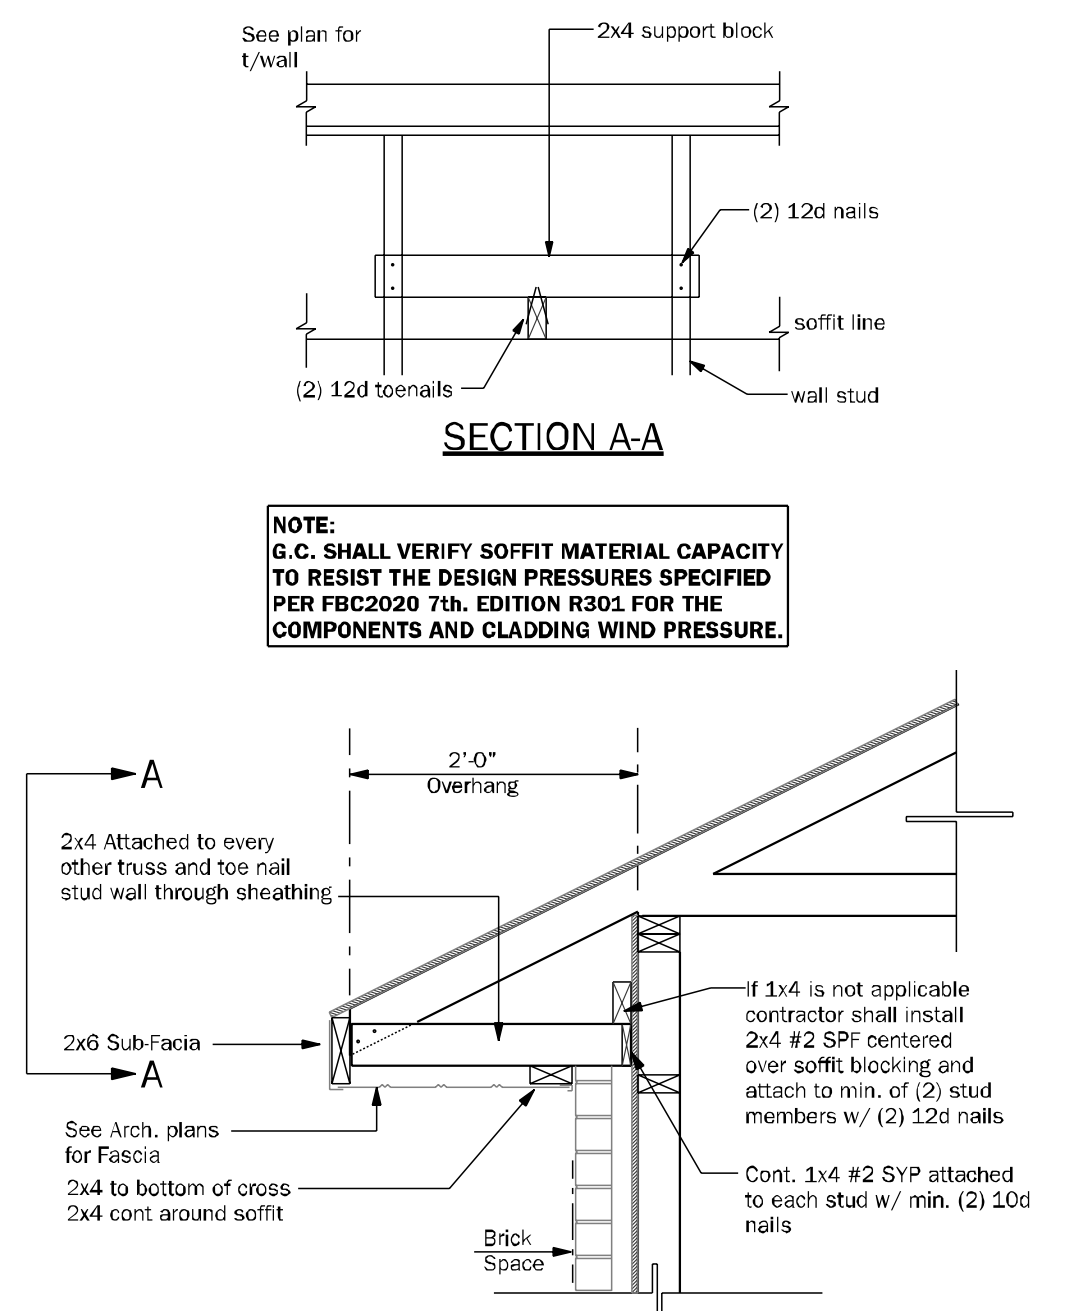


SE TYPICAL SOFFIT AND EAVE DETAIL 3/4" = 1'-0"

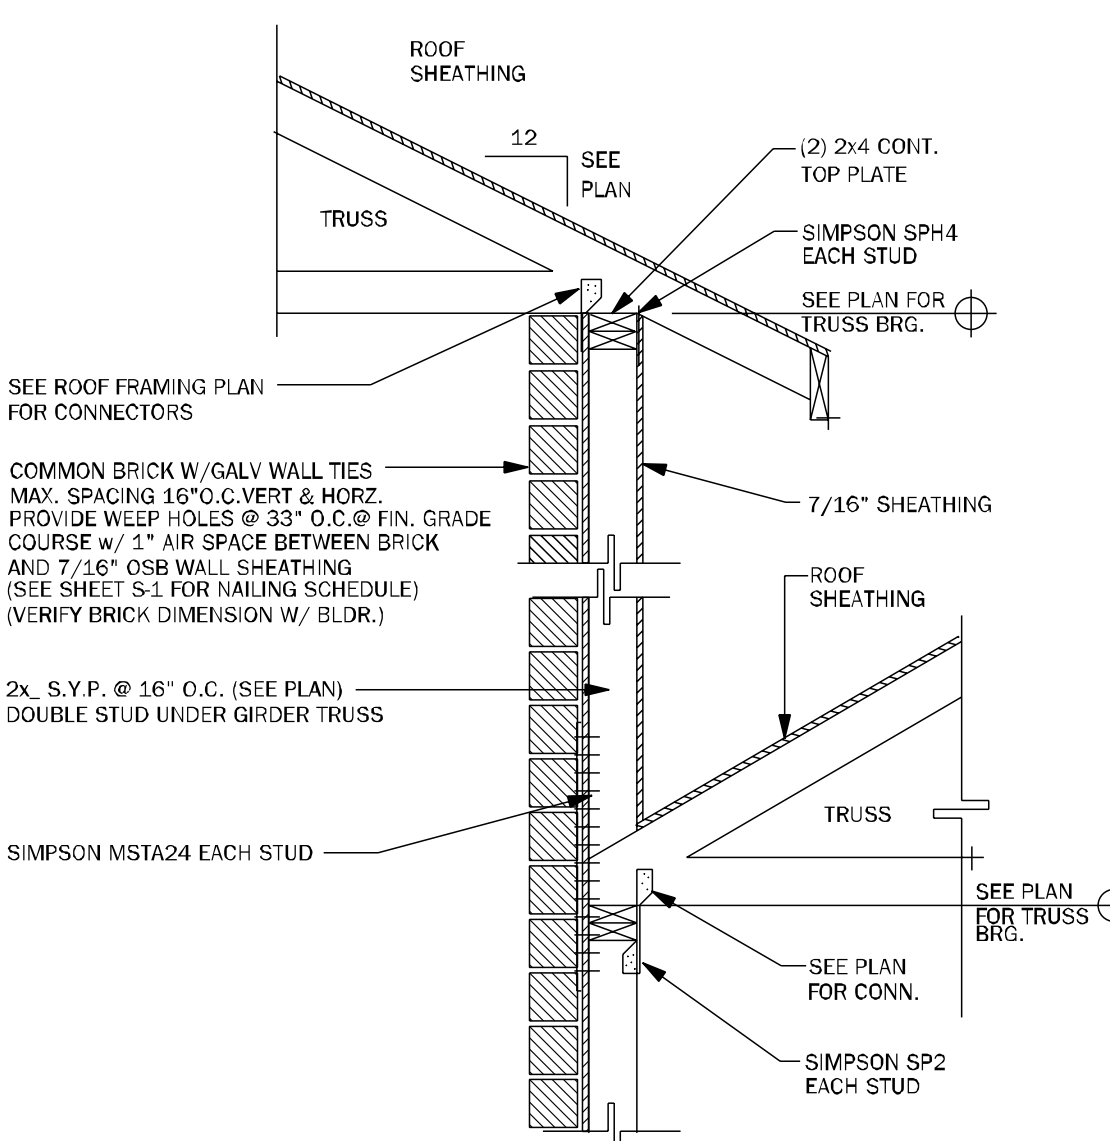

WF63 SECTION AT DOUBLE BEARING N.T.S.

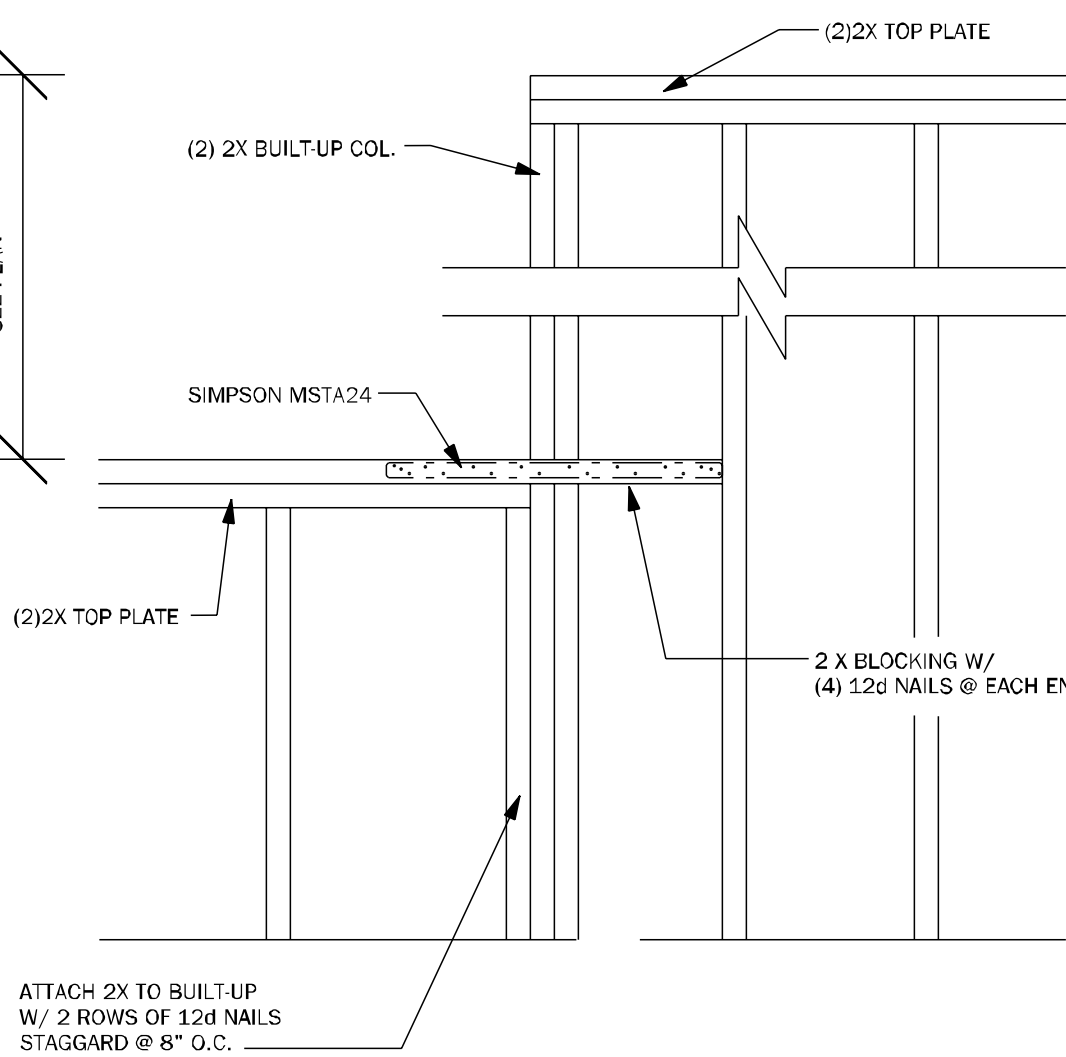

WC07 STEP UP @ CORNER & RAISED BEAM 1/2" = 1'-0"

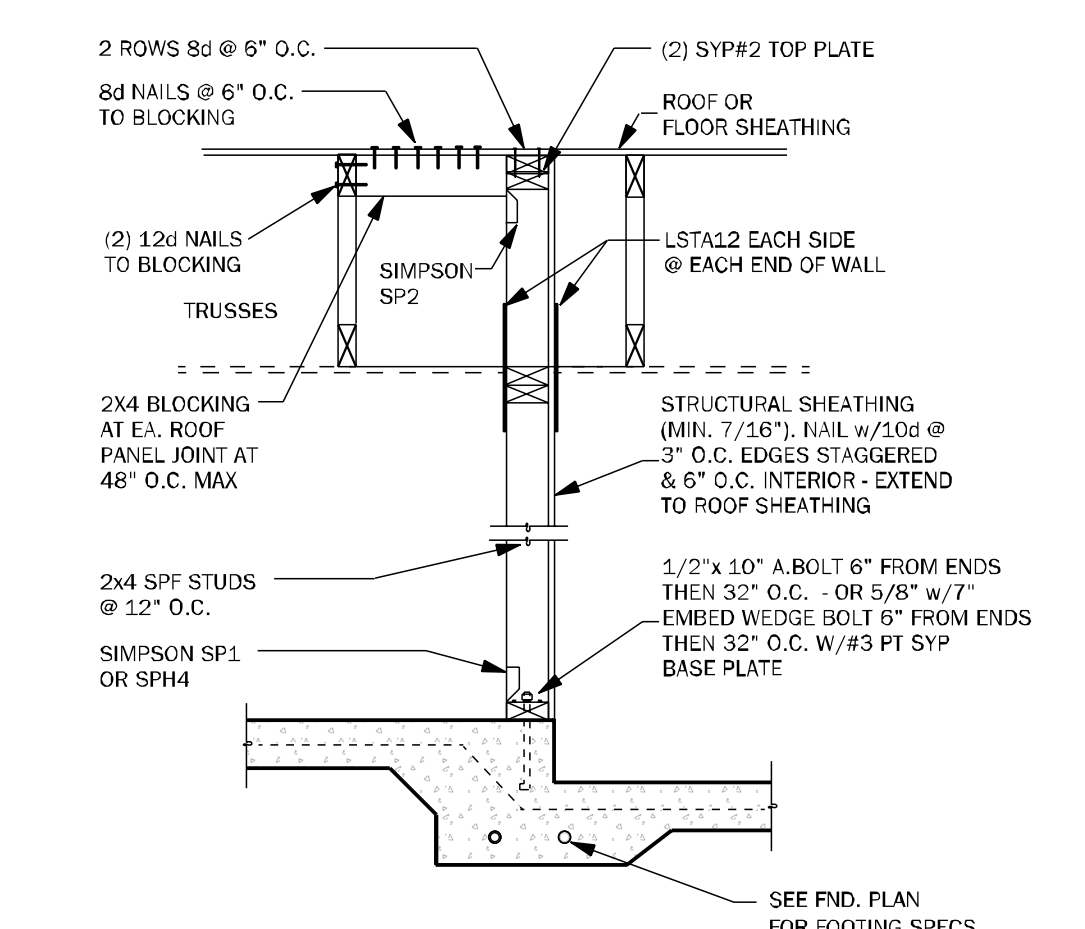

SW04 INTERIOR SHEARWALL @ TRUSSES 3/4" = 1'-0"

COUNTY SEAL

To the best of the Engineer's knowledge, information and belief, the structural plans and specifications contain within these drawings comply with the 2023 Florida Building Code- Residential 8th Edition. Engineer's signature and seal is only for the structural engineering portions of the drawing pages bearing engineer's signature and seal.
CA No. 9161 AA26003115


TS
CA No. 9161 AA26003115
Making Dreams Come True
TOTAL SOLUTIONS GROUP
258 Southhall Lane, Suite 200
Maitland, Florida, 32751
(407) 880 2333
100% Employee Owned
myTSGroup.com

DAMS HOMES
FLORIDA CONTRACTORS LICENSE NO. CRC1330146
100 WEST GARDEN STREET
PENSACOLA FL 32502


DIVISION LOCATION:
GAINESVILLE

INVENTORY
LOT: 12
BLK: SEC:
SUB: PRESERVE AT LAUREL LAKE
133 SW BELFLOWER DR.
LAKE CITY
Model Name / Number:
2117
Plan Issue Date:
Wednesday, March 19, 2025
KA PROJECT NUMBER:
25-02684
Sheet: **S-3** Of:
TYPICAL WALL DETAILS

Wednesday, March 19, 2025

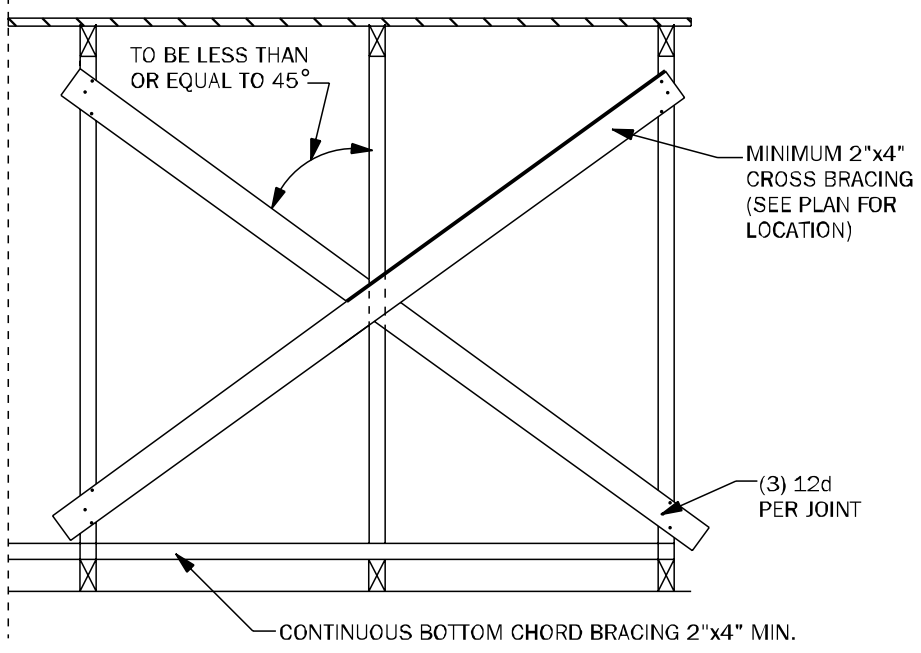


TB01 TYPICAL CROSS BRACING DETAIL N.T.S.

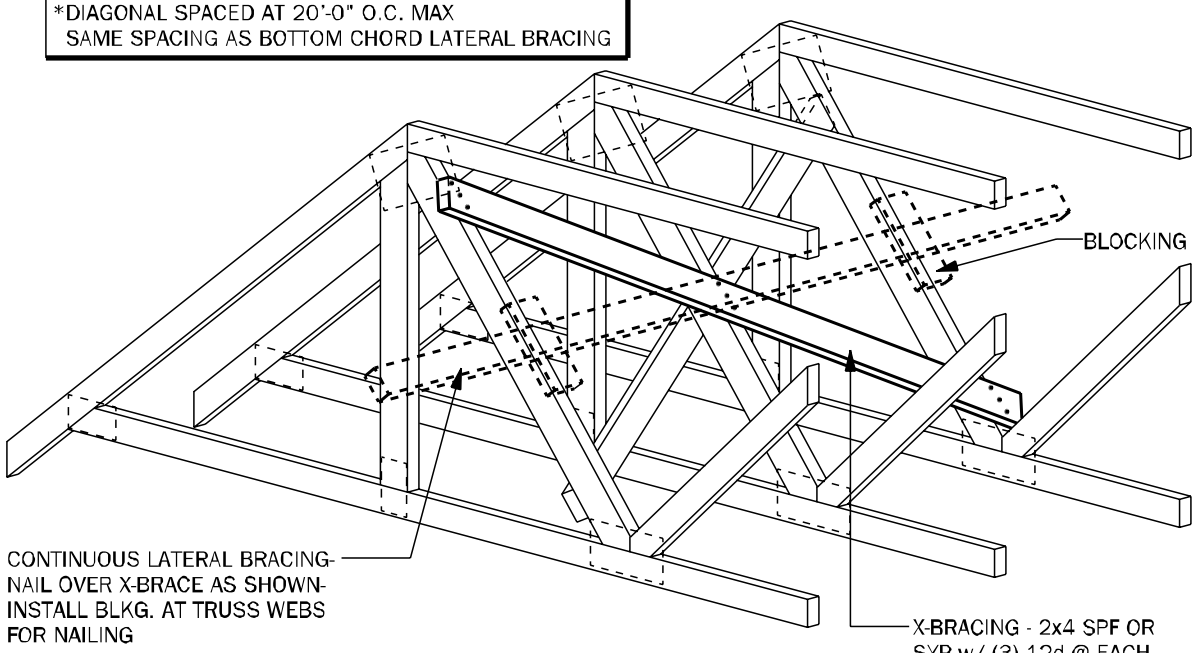


TB02 TYPICAL CROSS BRACING DETAIL N.T.S.

THE HEIGHT OF THE CHIMNEY SHOULD EXTEND 2' ABOVE THE POINT WHERE THE CHIMNEY IS 10' FROM THE NEAREST BUILDING SURFACE.

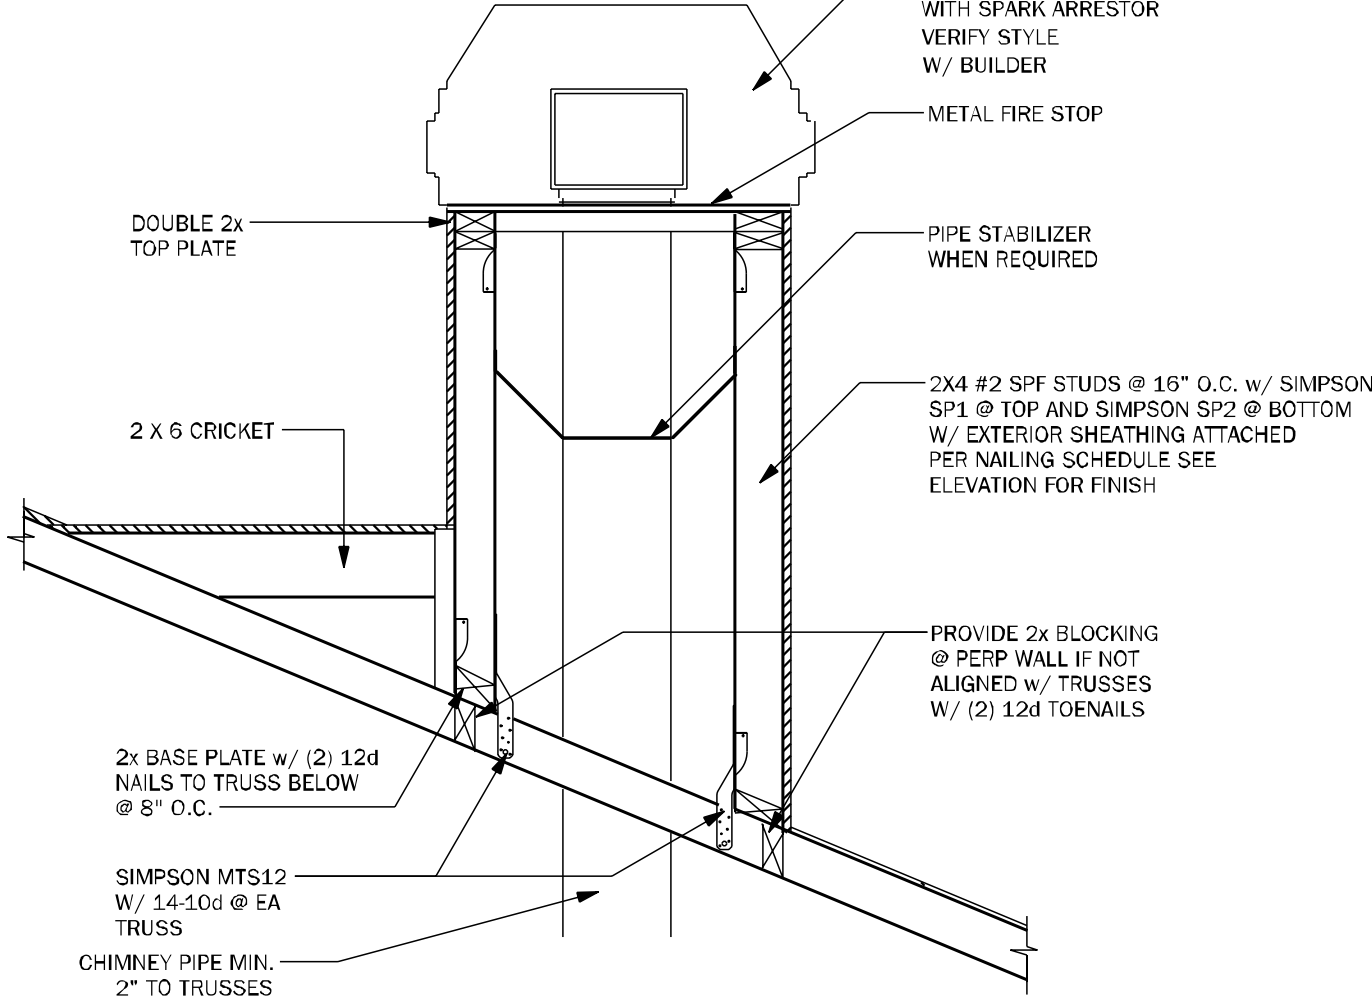


CH01 TYPICAL CHIMNEY FRAME DETAIL 3/4" = 1'-0"


RAFTER SIZE	
0'-8" SPAN -	2"x6" W/4-12d EACH END
8'-12" SPAN -	2"x8" W/4-12d EACH END
12'-15" SPAN -	2"x10" W/ SIMPSON A 34 @ EA. END
15'-18" SPAN -	2"x12" W/ SIMPSON A 34 @ EA. END

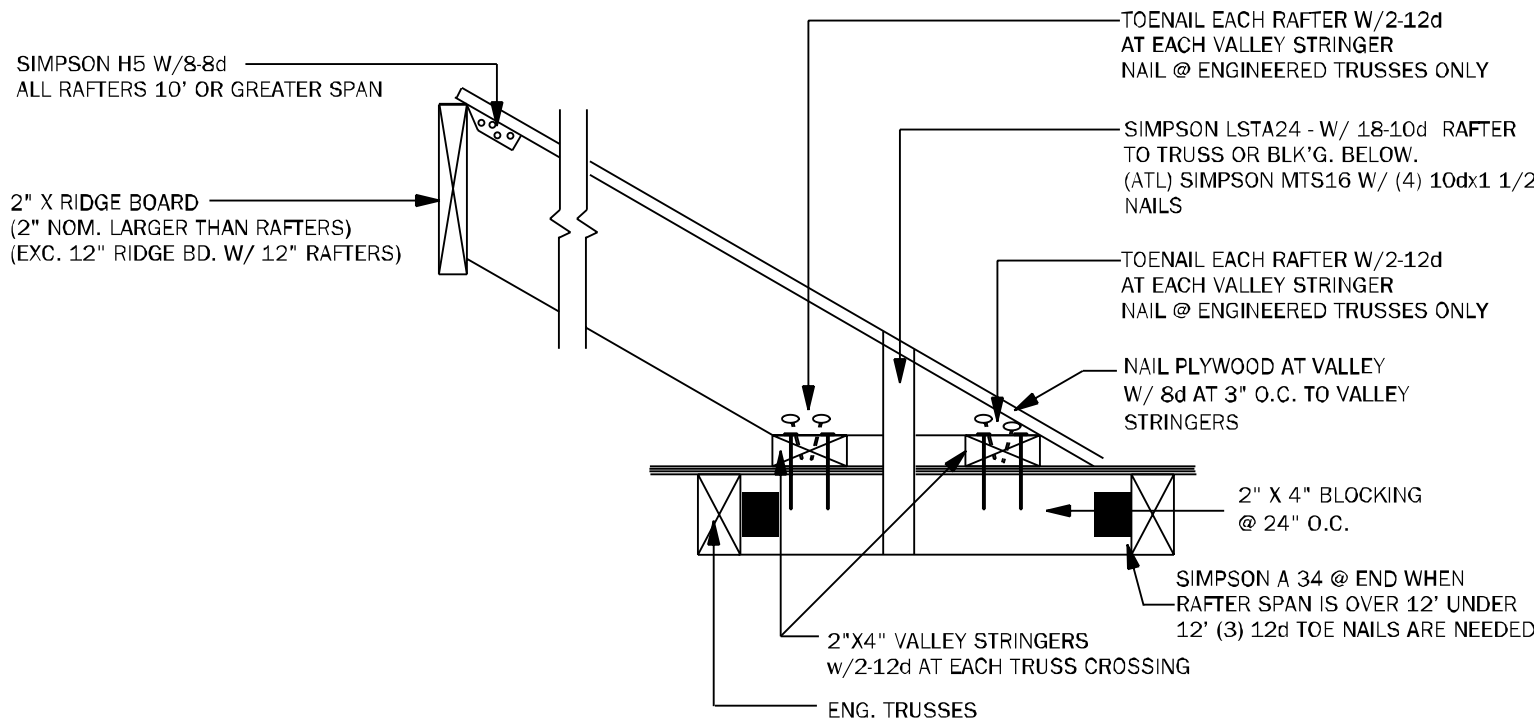


TB17 CONV. FRAMING & VALLEY FRAMING N.T.S.

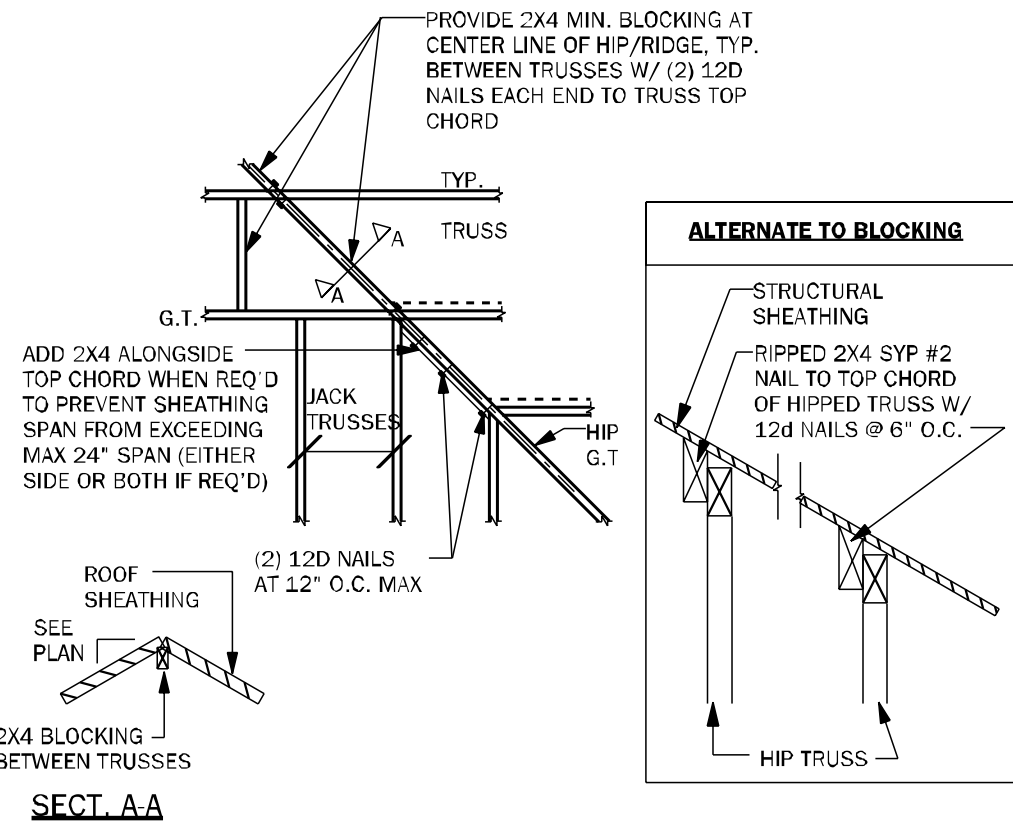


TB03 HIP / RIDGE BLOCKING DETAIL N.T.S.

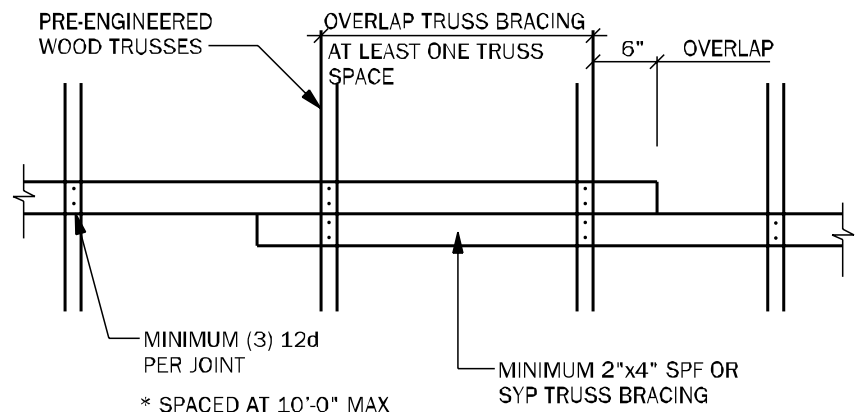

TB04 TRUSS BRACING OVERLAP DETAIL (TYP) N.T.S.

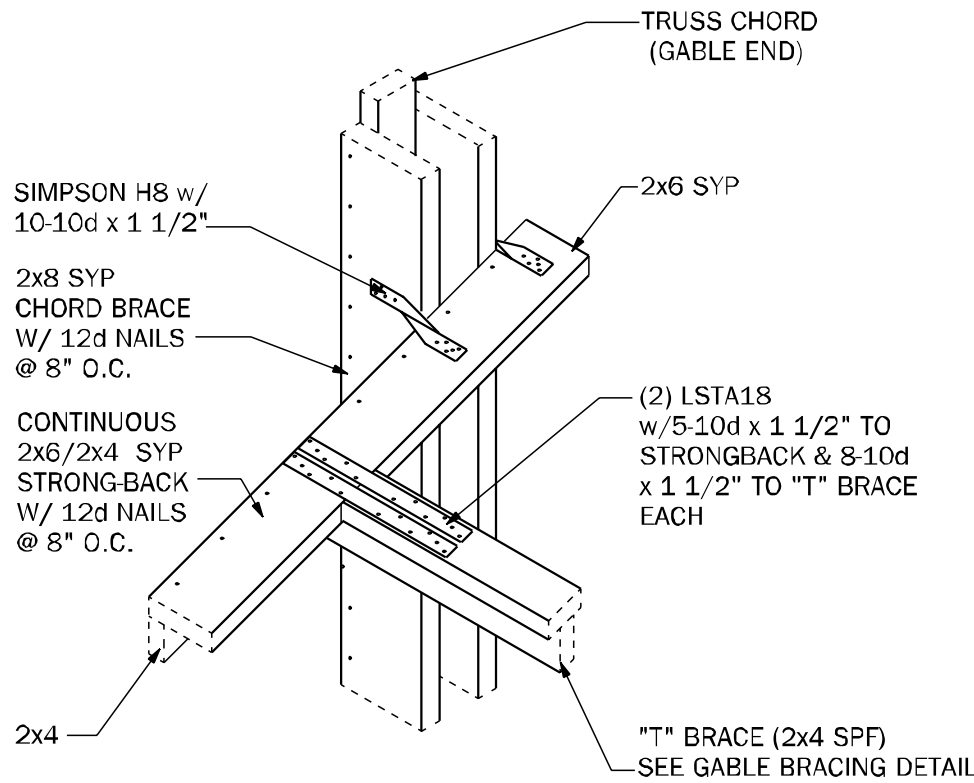




GE04 "T" BRACE CONNECTION @ GABLE END W/ VOLUME CEILING 3/4" = 1'-0"

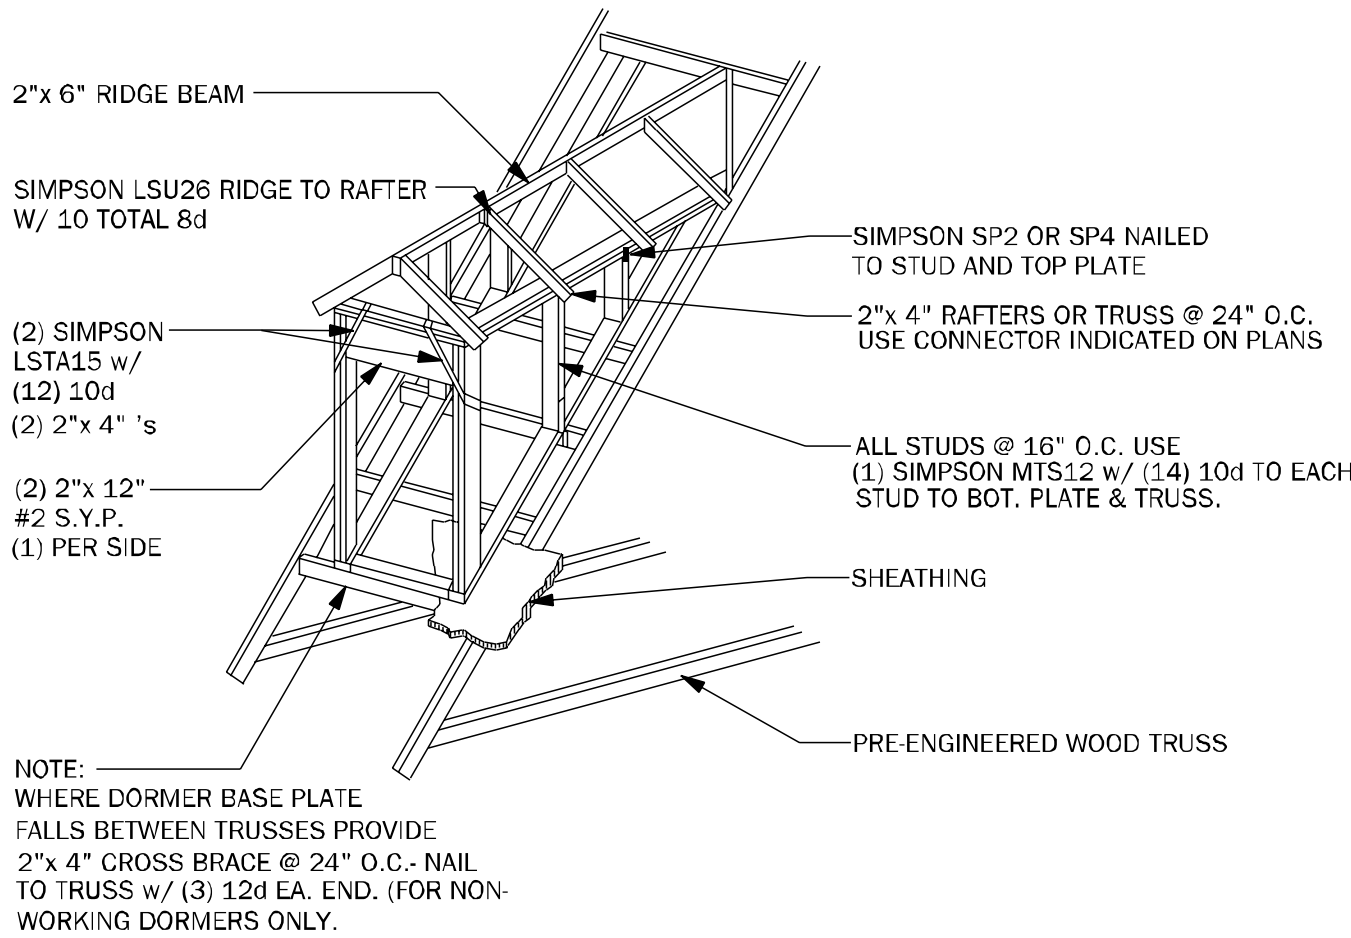

WF05 DORMER FRAMING DETAIL N.T.S.

TRUSS NOTES:

- WOOD TRUSS ERECTOR SHALL PROVIDE BRACING ACCORDING TO ANSI/TPI-2014 (TRUSS PLATE INSTITUTE) NOTE THAT THE COMBINED WIND AREA IS GREATER BEFORE THE ROOF SHEATHING IS APPLIED, AND BRACING SHALL THEREFORE BE INSTALLED AS THE TRUSSES ARE ERECTED. INADEQUATE BRACING IS THE MOST COMMON CAUSE OF ACCIDENT IN WOOD TRUSS CONSTRUCTION. FULL BUNDLES OF SHEATHING SHALL NOT BE PLACED ON TRUSSES. THIS CONSTRUCTION LOAD SHOULD BE LIMITED TO 8 SHEETS OF SHEATHING ON ANY PAIR OF TRUSSES & SHALL BE LOCATED ADJACENT TO THE SUPPORTS. NO EXCESS CONCENTRATION OF ANY CONSTRUCTION MATERIAL (SUCH AS GRAVEL OR SHINGLES) SHALL BE PLACED ON THE TRUSSES IN ANY ONE AREA THEY SHALL BE SPREAD OUT EVENLY OVER A LARGE AREA SO AS TO AVOID OVERLOADING ANY ONE TRUSS.
- ALL BRACING (DB, CB, BB) SHOWN ABOVE SHALL BE IN ADDITION TO CONTINUOUS LATERAL BRACING SPECIFIED BY THE TRUSS MANUFACTURER. ALL LATERAL BRACING SPECIFIED BY TRUSS MANUF. SHALL HAVE ADDITIONAL DIAGONAL BRACES AT 20'-0" O.C. MAXIMUM.
- ALL BRACES SHALL BE 2x4 NOMINAL DIMENSION LUMBER & SHALL BE ATTACHED W/ (3) 12d NAILS AT EACH TRUSS INTERSECTION.
- ADDITIONAL BOTTOM CHORD BRACING SHALL BE INSTALLED AS REQUIRED BY TRUSS DESIGN WHEREVER ADEQUATE STRUCTURAL CEILING ARE NOT ATTACHED DIRECTLY TO THE BOTTOM CHORD OF THE TRUSS.
- PROVIDE TRUSS BLOCKING AT ALL TRUSS BEARING SUPPORTS WHERE TRUSS DEPTH EXCEEDS STANDARD HEEL HEIGHT. SEE TYP. TRUSS BLOCKING DETAILS.

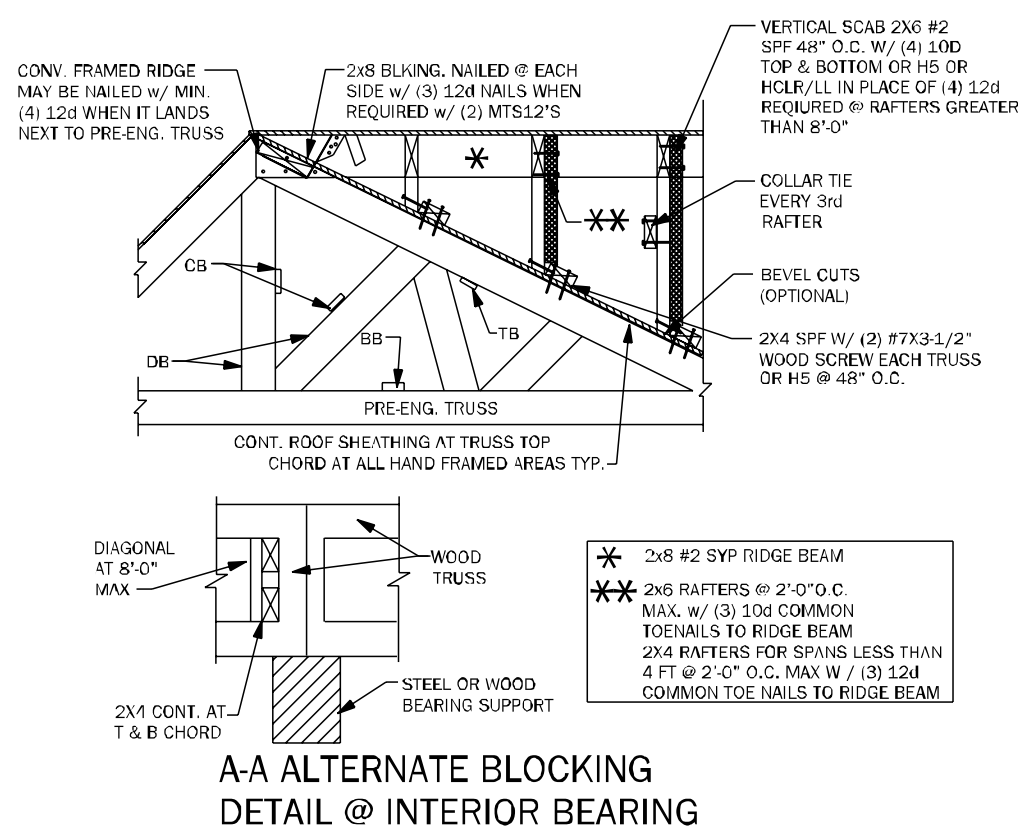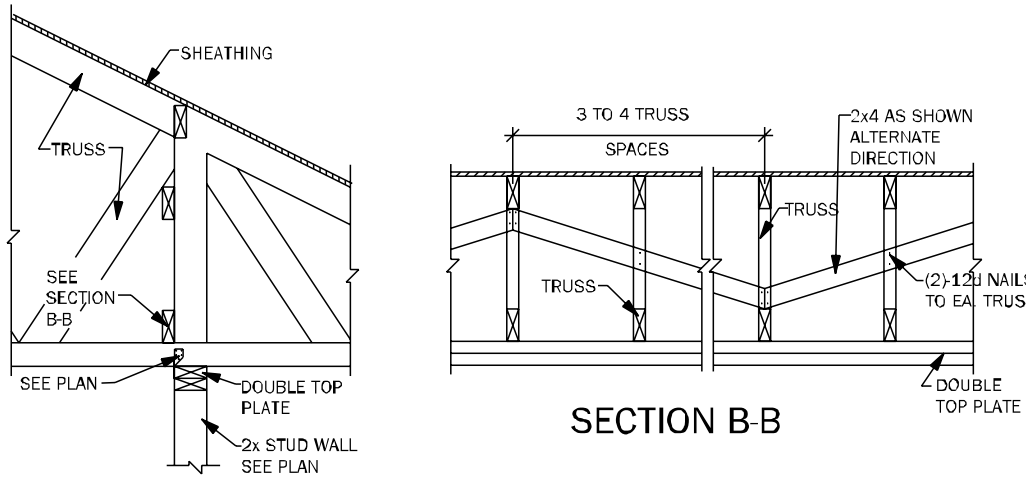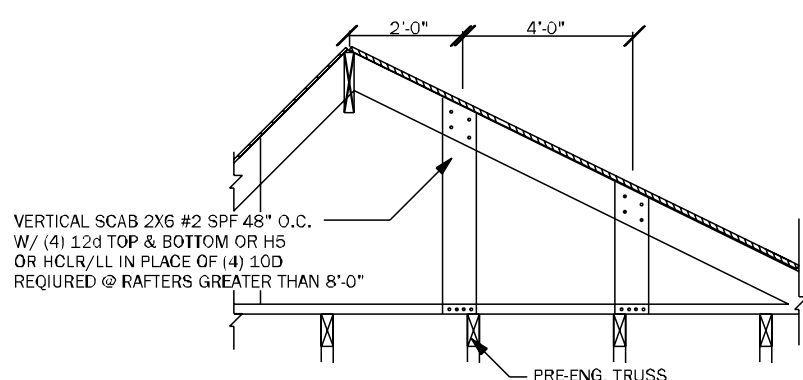

TYP. WOOD TRUSS BLOCKING @ RAISED HEEL DETAIL

A-A ALTERNATE BLOCKING DETAIL @ INTERIOR BEARING

TB06 BLOCKING AND CONVENTIONAL FRAME DETAILS 3/4" = 1'-0"

COUNTY SEAL

Wednesday, March 19, 2025

To the best of the Engineer's knowledge, information and belief, the structural plans and specifications contain within these drawings comply with the 2023 Florida Building Code- Residential 8th Edition. Engineer's signature and seal is only for the structural engineering portions of the drawing pages bearing engineer's signature and seal.
CA No. 9161 AA26003115



TOTAL SOLUTIONS GROUP
258 Southhall Lane, Suite 200
Maitland, Florida, 32751
(407) 880 2333

100% Employee Owned
myTSGhome.com

DAMS HOMES
FLORIDA CONTRACTORS LICENSE NO. CRC1330146
**100 WEST GARDEN STREET
PENSACOLA FL 32502**

DIVISION LOCATION:
GAINESVILLE

Job Information:

INVENTORY

LOT: 12
BLK:
SEC:
SUB: PRESERVE AT LAUREL LAKE
133 SW BELFLOWER DR.
LAKE CITY

Model Name / Number:

2117

Plan Issue Date:

Wednesday, March 19, 2025

KA PROJECT NUMBER:


25-02684

Sheet:


S-4

Of:


ROOF FRAMING
AND BRACING DETAILS

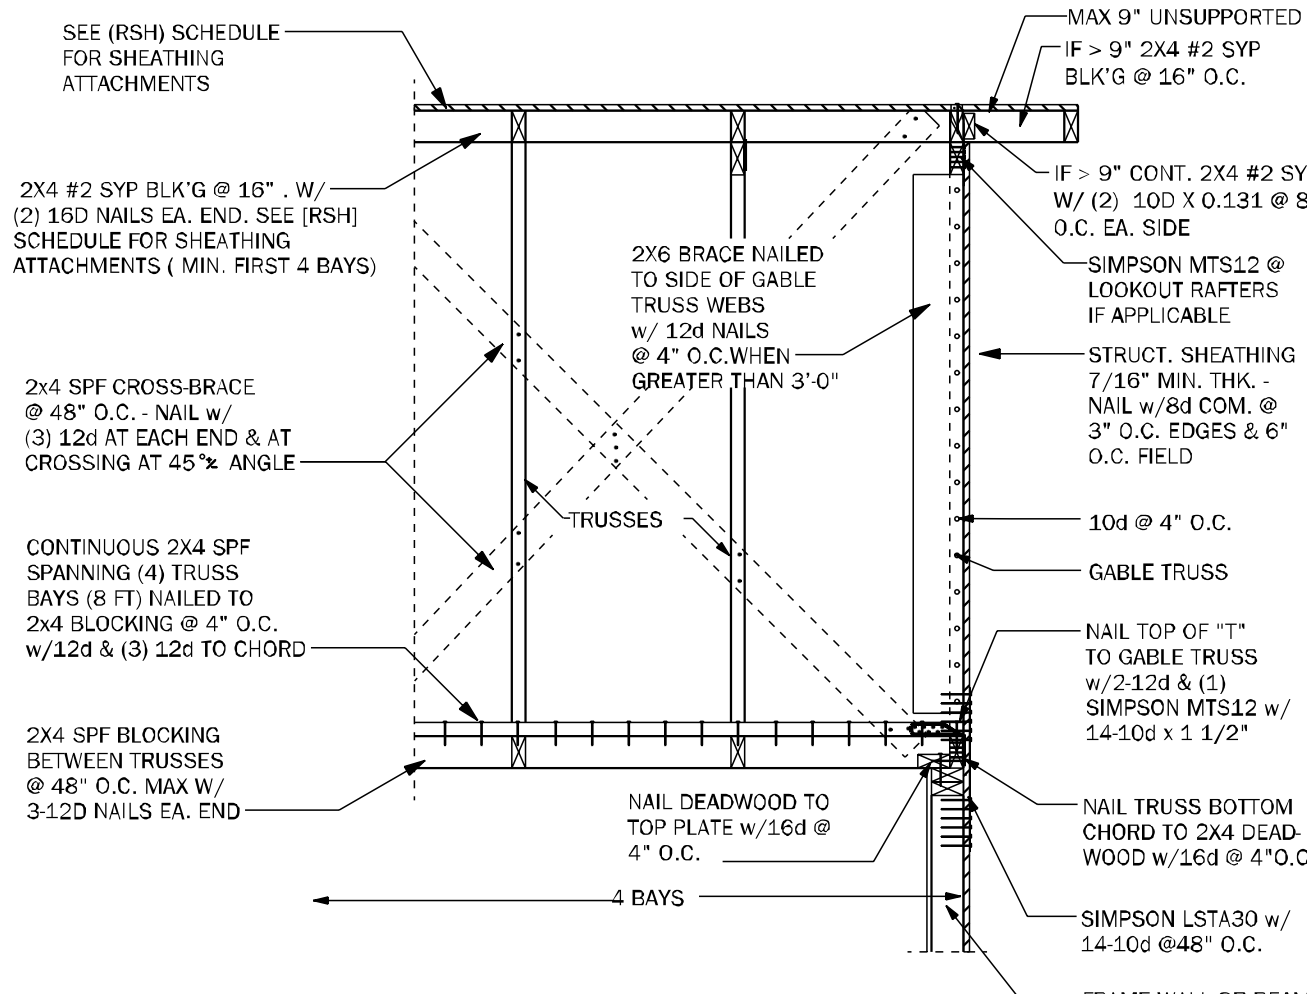


GE05 GABLE END BRACING - FRAME WALL N.T.S.

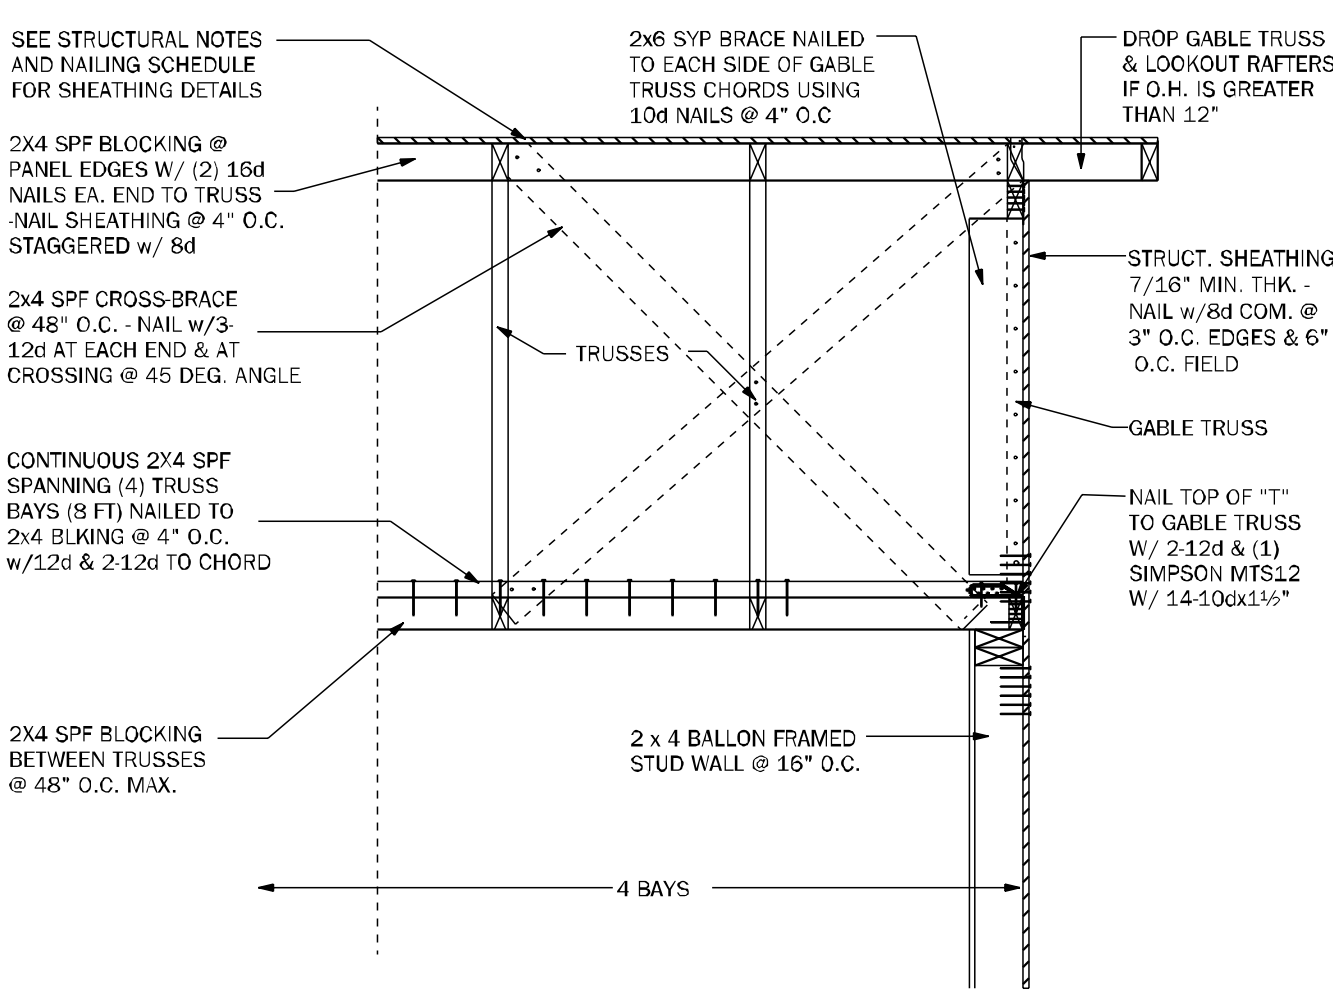


GE22 GABLE END BRACING w/ VOL CEILING 1/2"=1'-0"

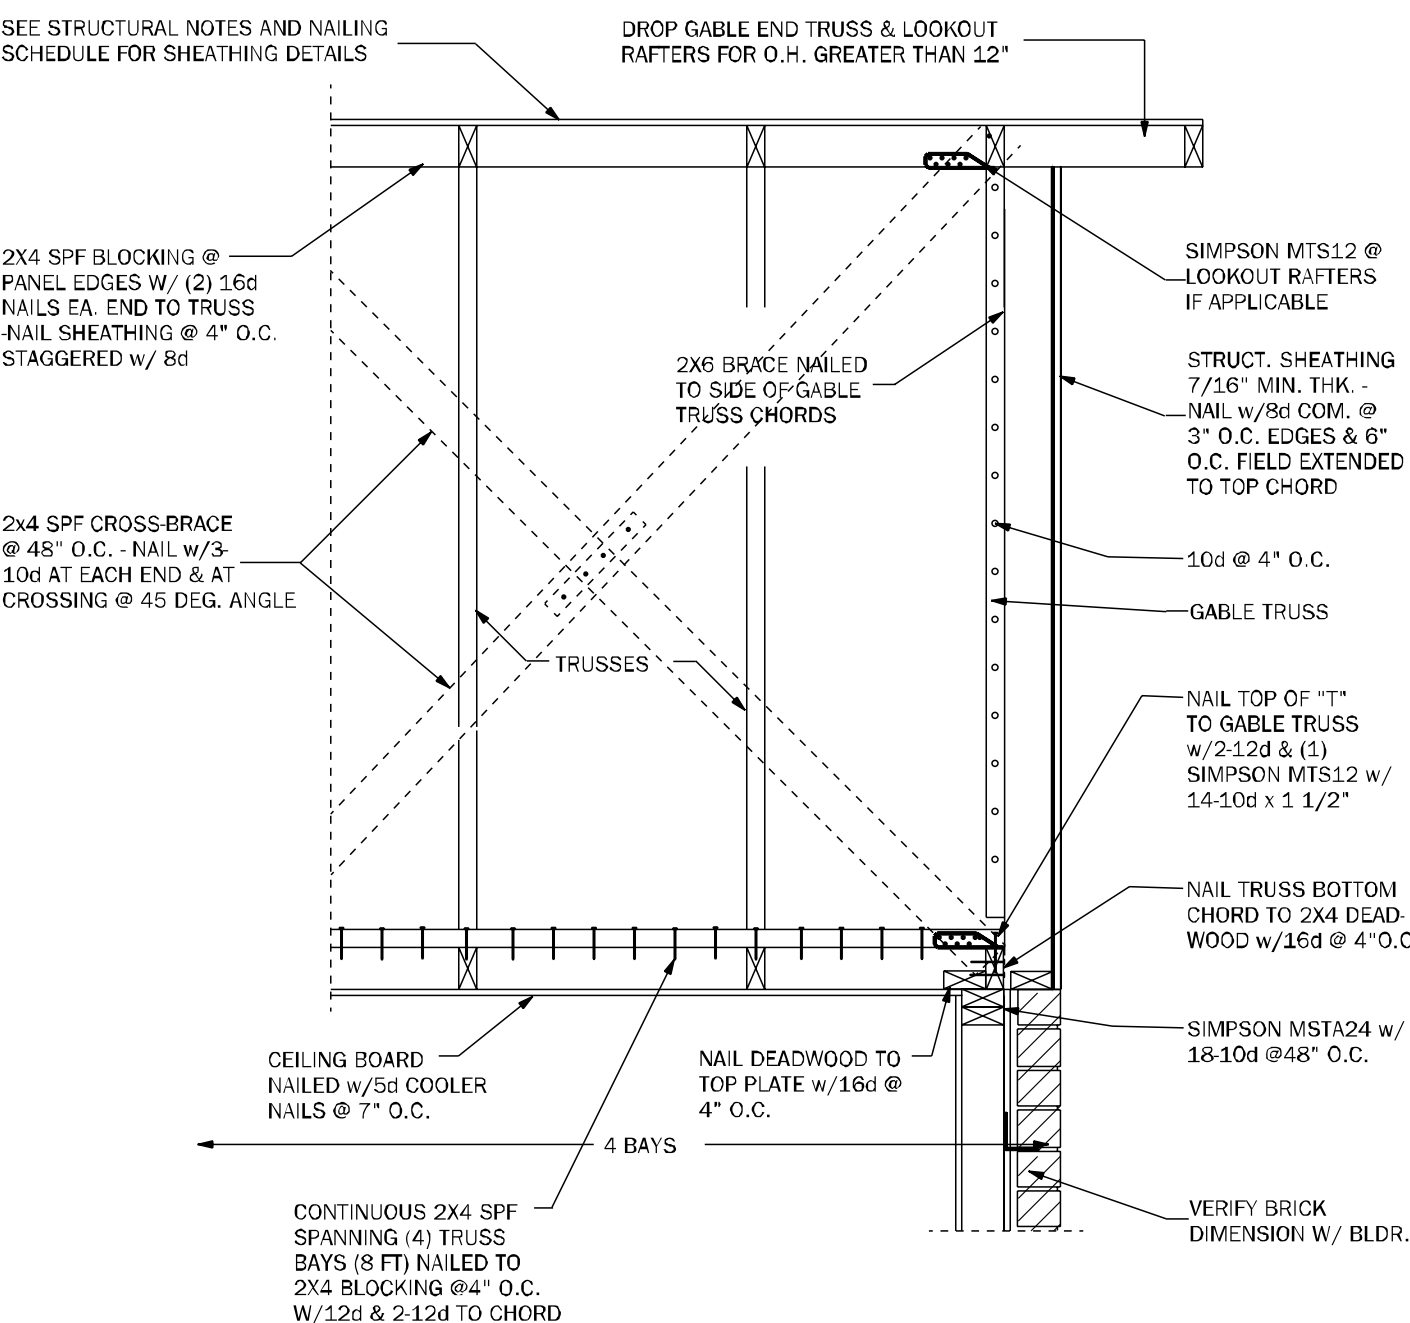


GE23 GABLE END BRACING w/o VOLUME CEILING 1/2"=1'-0"

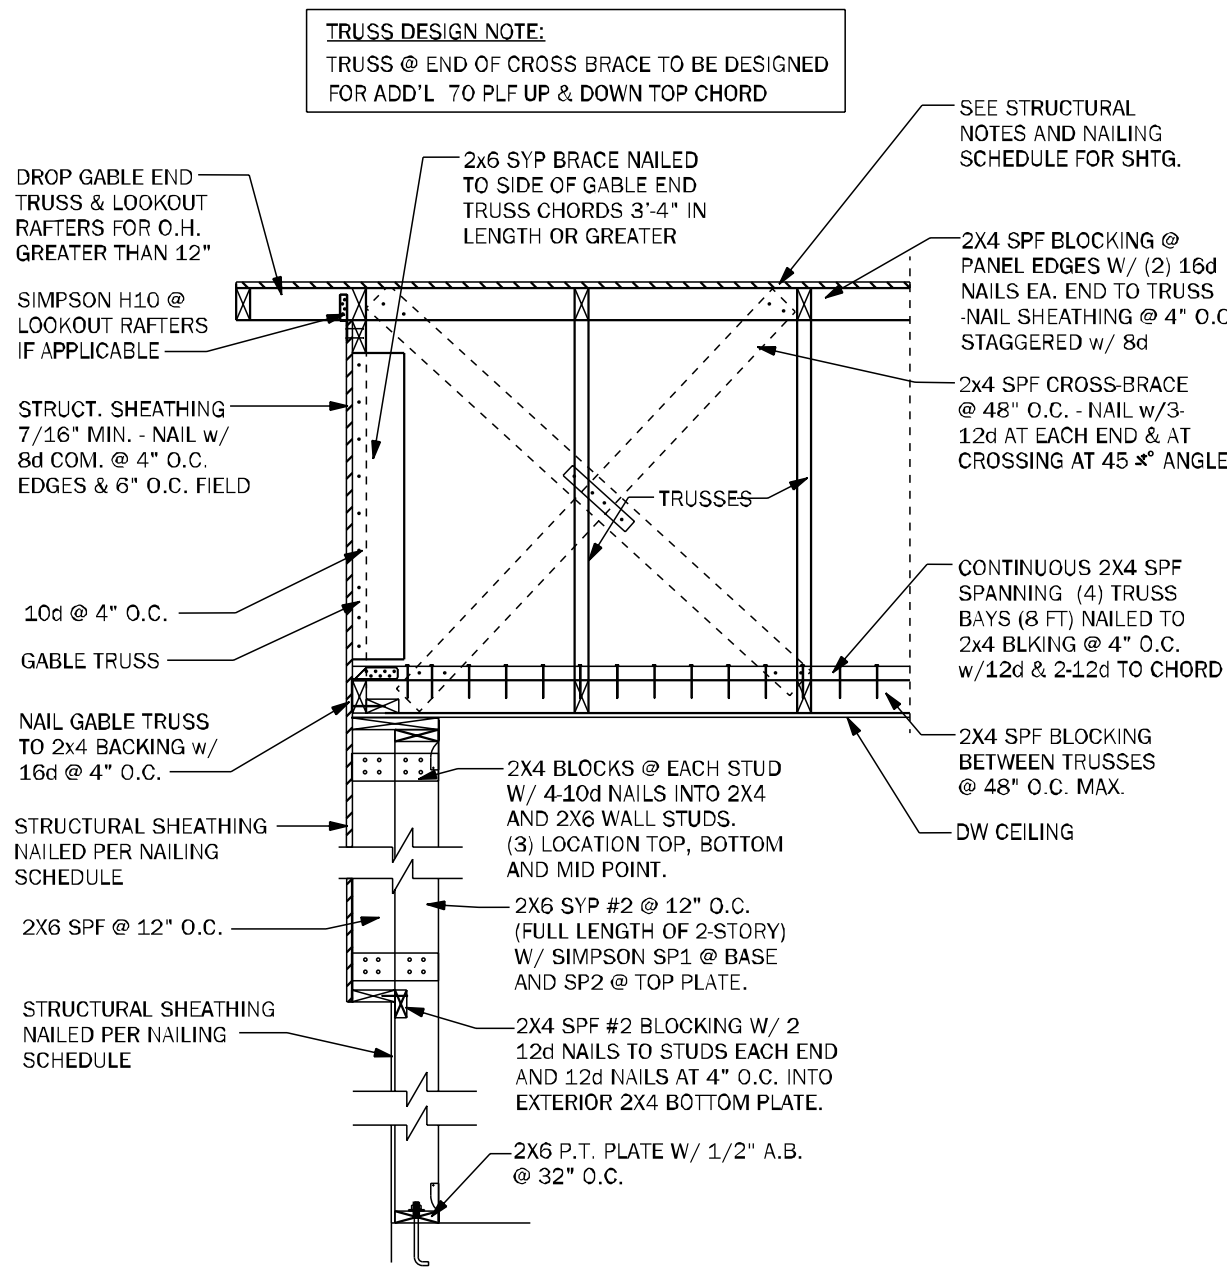


GE24 GABLE @ VAULT N.T.S.

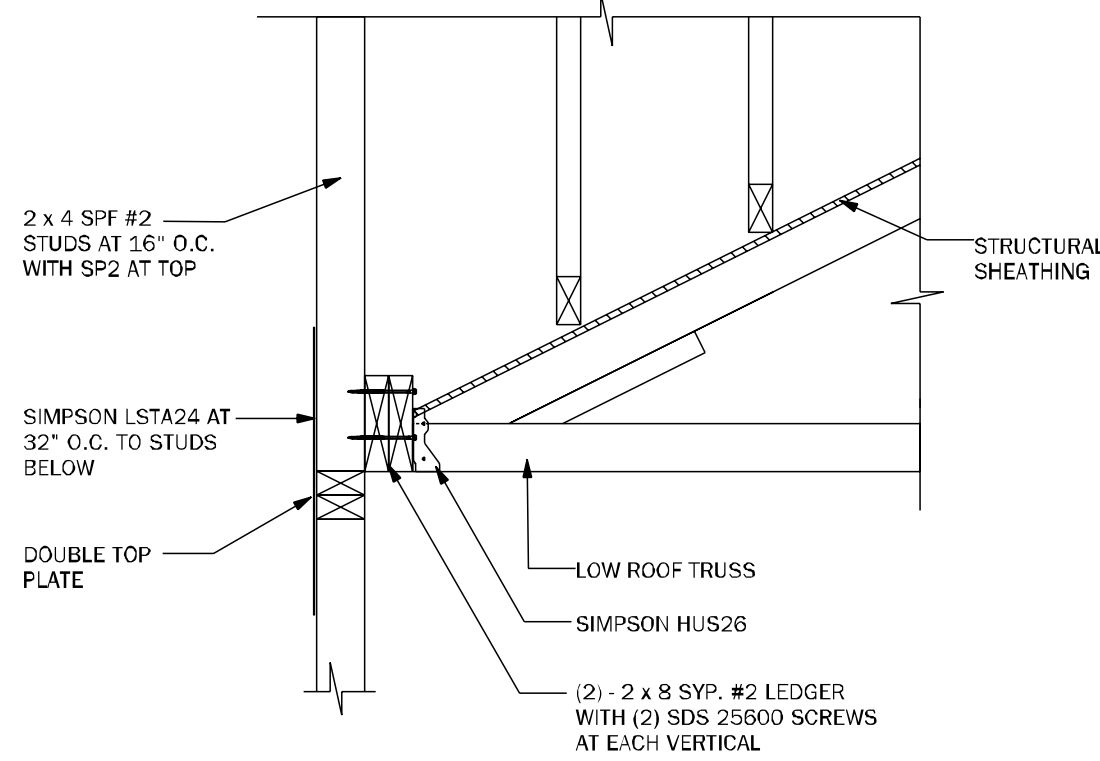


WF72 LEDGER N.T.S.

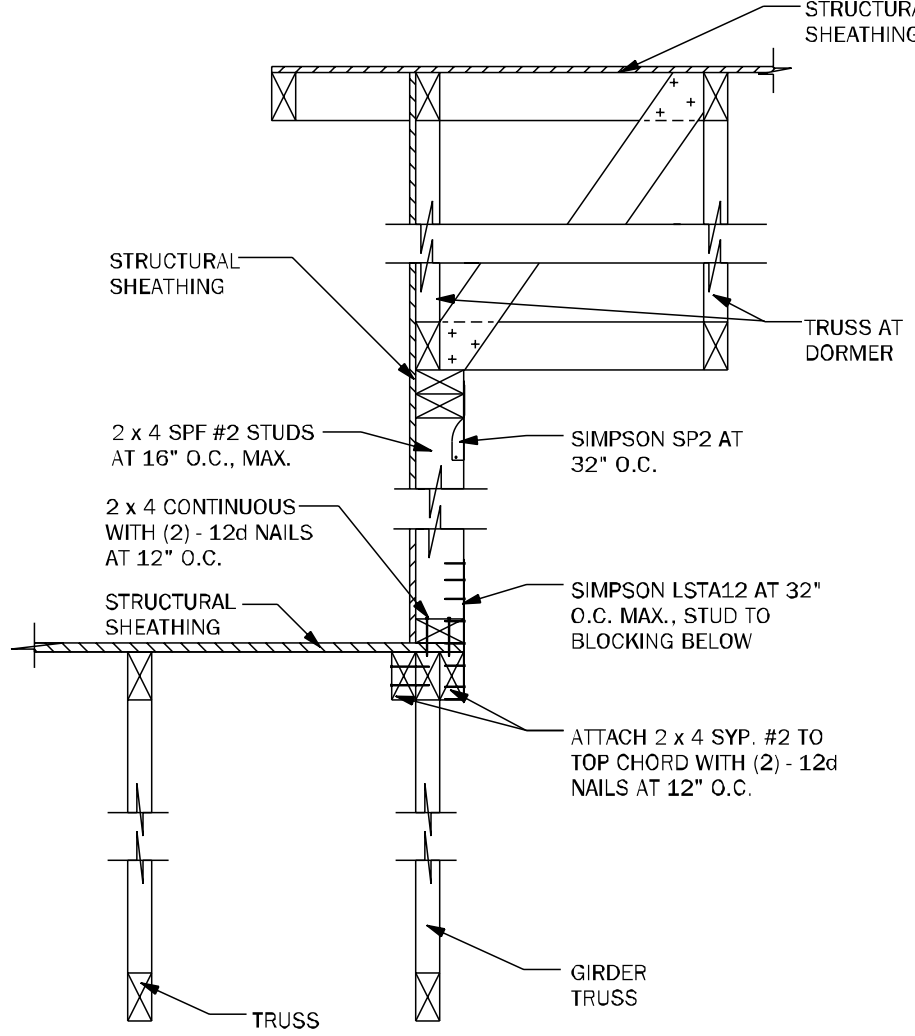


WF73 KNEEWALL @ DORMER N.T.S.

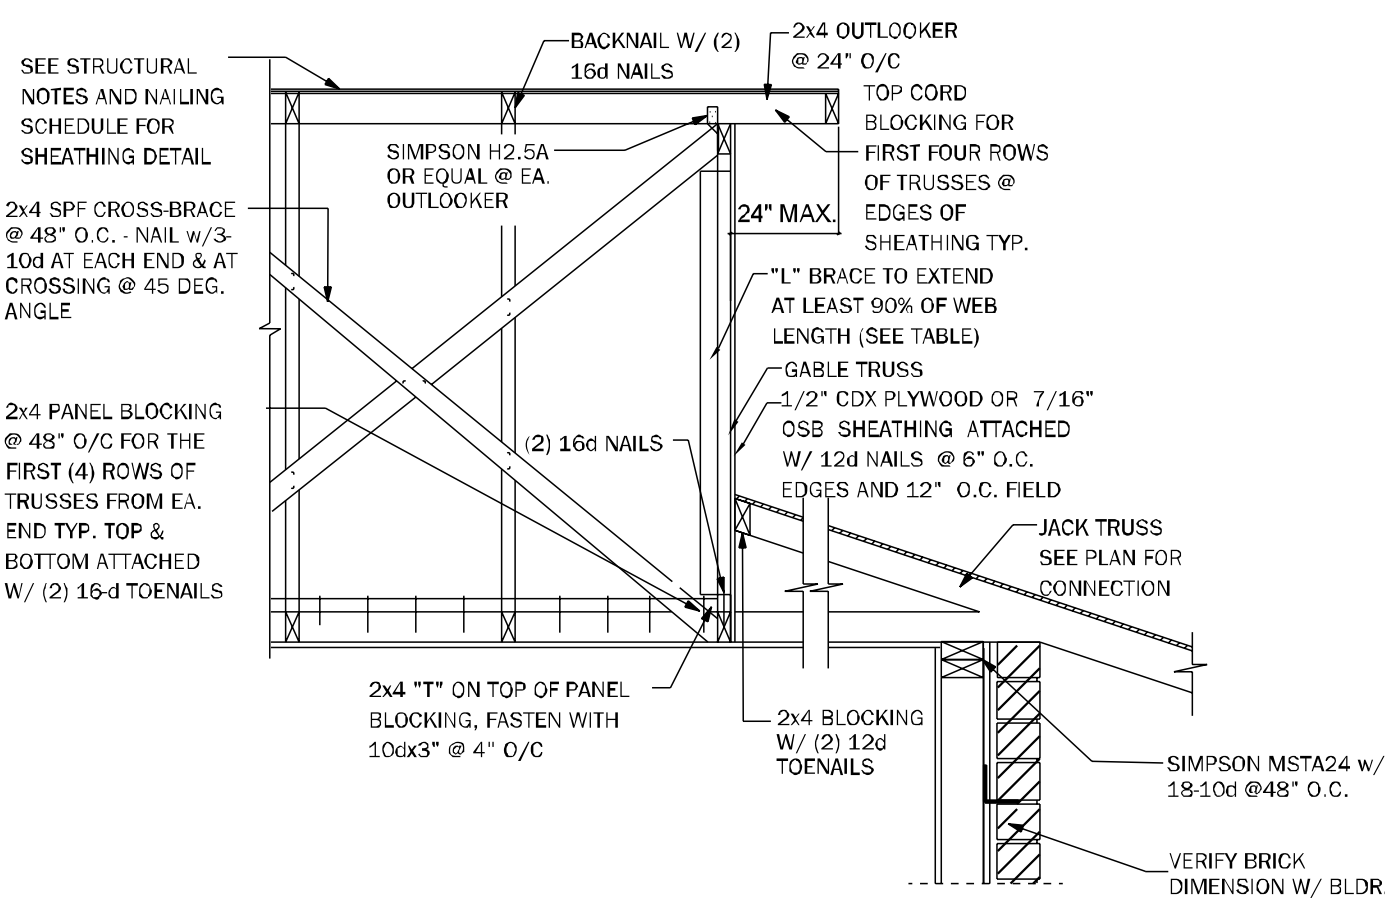



GE21 SECTION @ DUTCH GABLE 3/4"=1'-0"

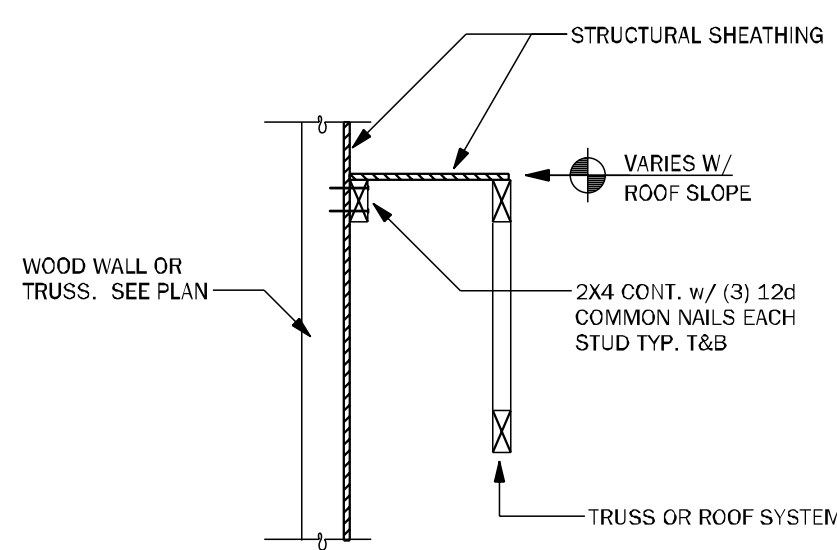

LD02 SHEAR TRANSFER EXTERIOR WALL N.T.S.

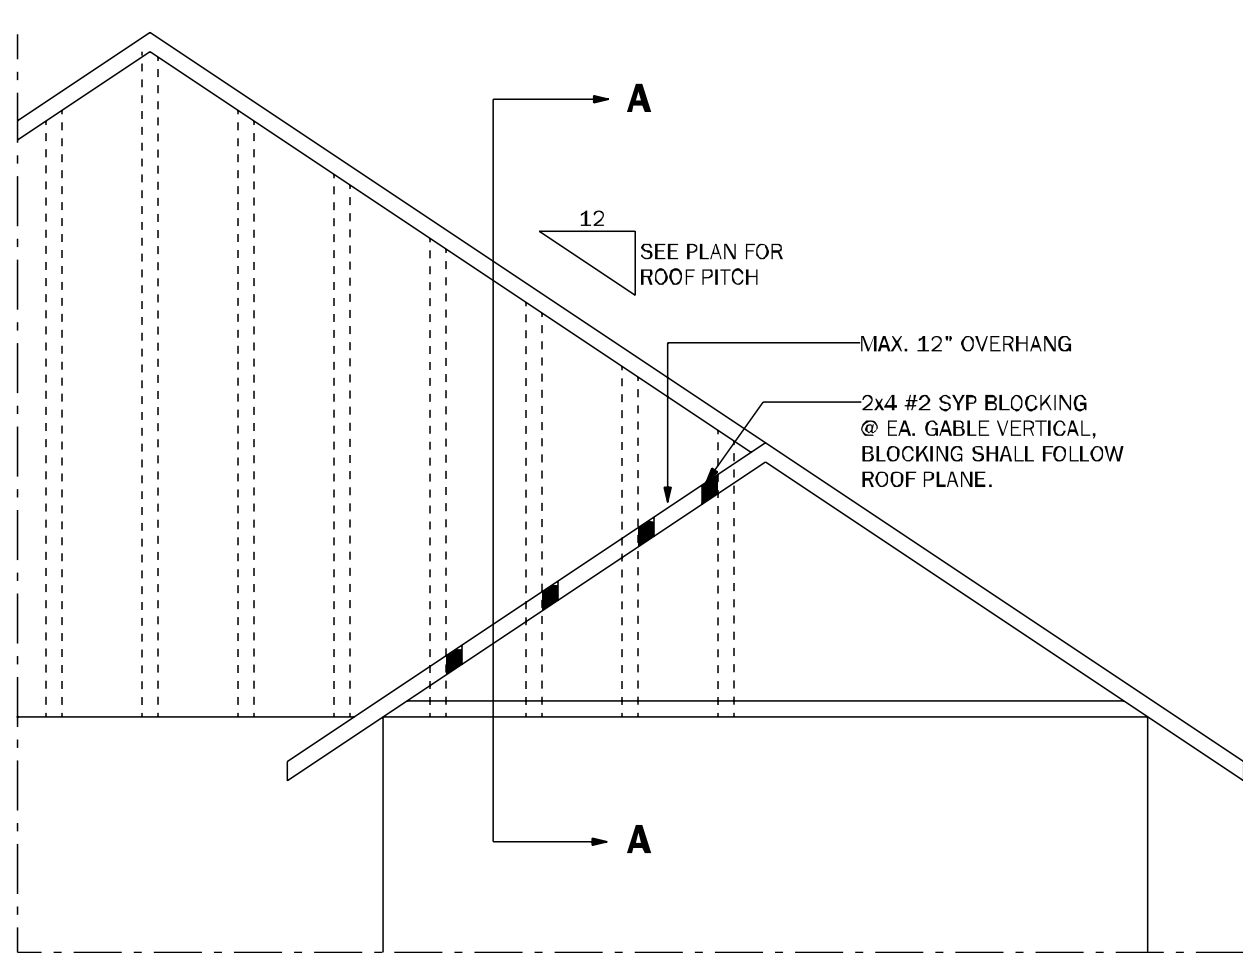

GE23.1 GABLE END OVERHANG 1/2"=1'-0"

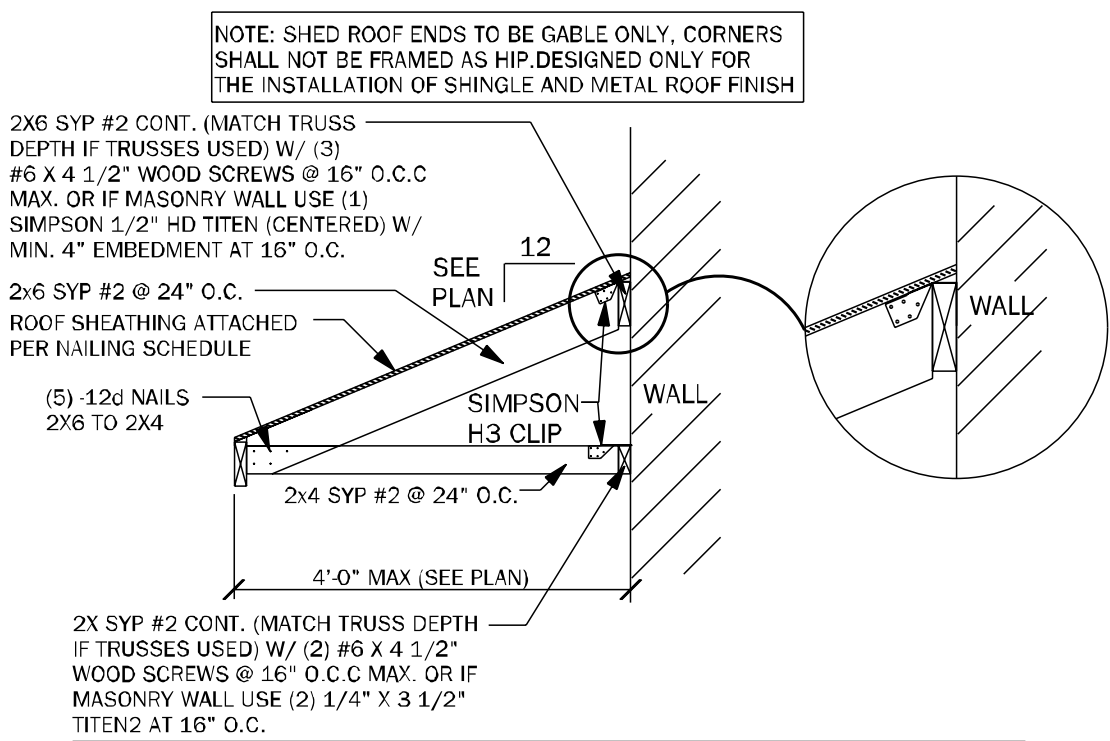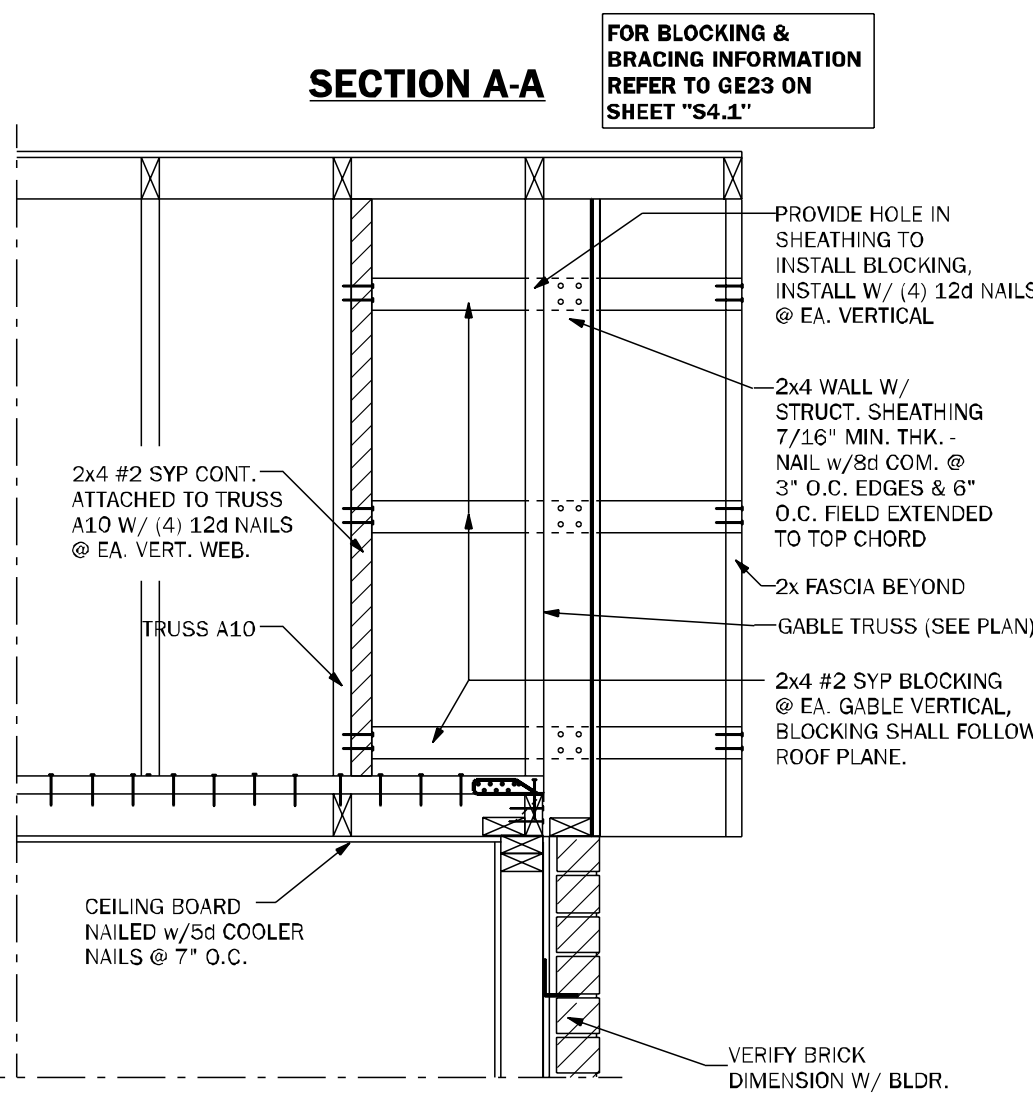

SR01 SECTION AT SHED ROOF 3/4"=1'-0"

COUNTY
SEAL

Wednesday, March 19, 2025

To the best of the Engineer's knowledge, information and belief, the structural plans and specifications contain within these drawings comply with the 2023 Florida Building Code- Residential 8th Edition.
Engineer's signature and seal is only for the structural engineering portions of the drawing pages bearing engineer's signature and seal.
CA No. 9161 AA26003115



TOTAL SOLUTIONS GROUP
258 Southhall Lane, Suite 200
Maitland, Florida, 32751
(407) 880 2333

100% Employee Owned
myTSGhome.com




FLORIDA CONTRACTORS LICENSE NO. CRC1330146
100 WEST GARDEN STREET
PENSACOLA FL 32502

DIVISION LOCATION:
GAINESVILLE

Job Information:

INVENTORY	LOT: 12
	BLK: SEC:
	SUB: PRESERVE AT LAUREL LAKE
	133 SW BELFLOWER DR.
Model Name / Number:	
2117	
Plan Issue Date:	
Wednesday, March 19, 2025	
KA PROJECT NUMBER:	
25-02684	
Sheet:	S-4.1
Of:	

ROOF FRAMING
AND BRACING DETAILS

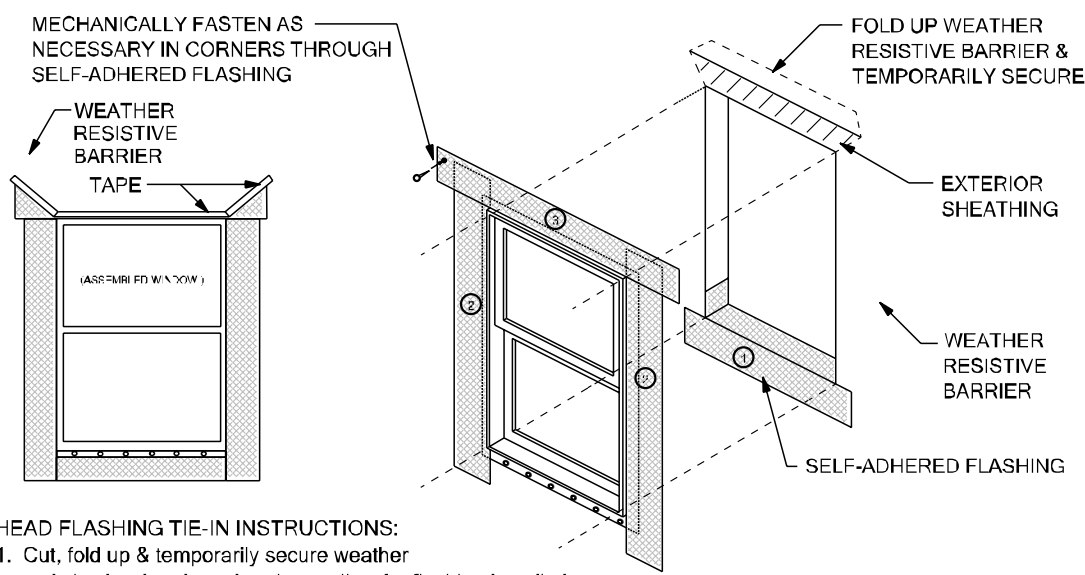


- HEAD FLASHING TIE-IN INSTRUCTIONS:
1. Cut, fold up & temporarily secure weather resistive barrier above header to allow for flashing installation
 2. Self-adhered flashing plus head flashing under weather resistive barrier
 3. Fold weather resistive barrier back over head flashing and seal with tape

SELF-ADHERED FLASHING
FLASHING INSTALLATION AFTER WEATHER RESISTIVE BARRIER


Scale: NTS

WP01

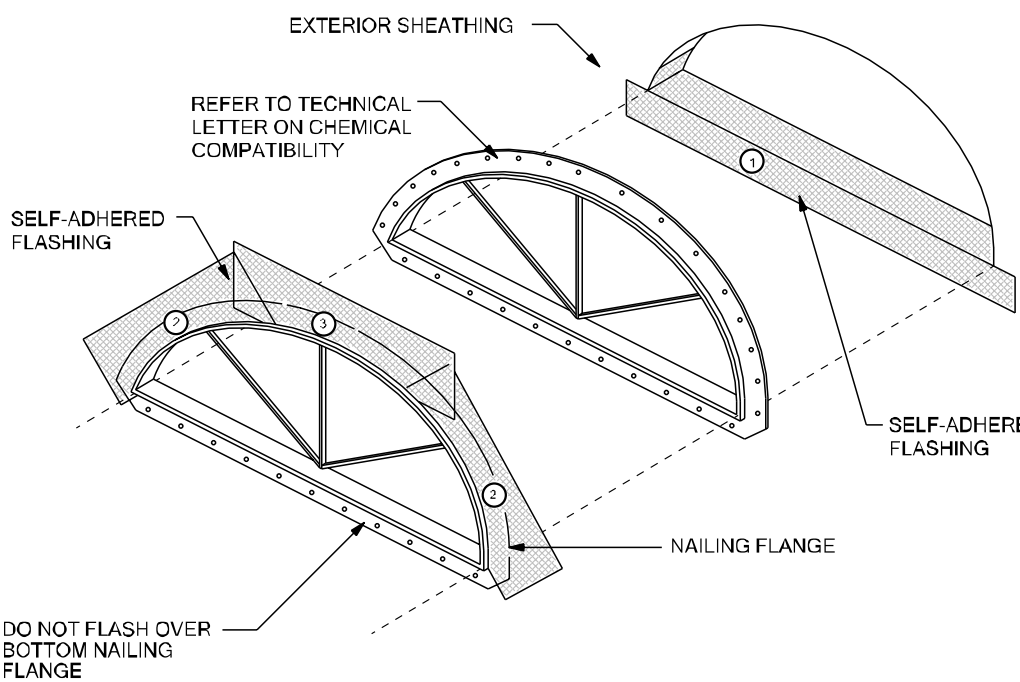


SELF-ADHERED FLASHING
HALF ROUND WINDOW

WP04

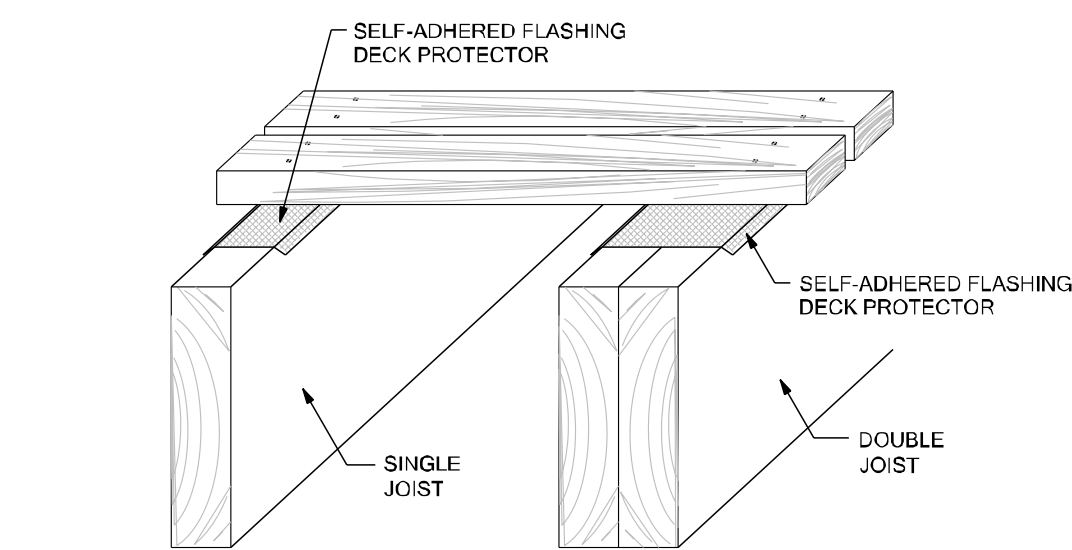

SELF-ADHERED FLASHING
W0.8362x;DECK JOIST


WP07

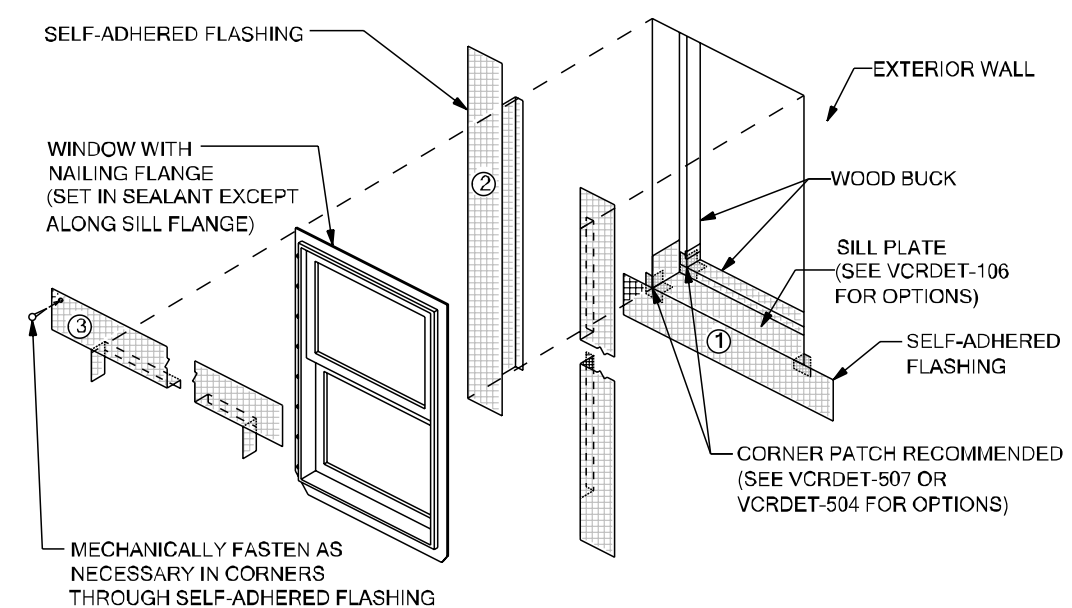

- NOTES:
1. INSTALL WINDOW PER MANUFACTURER'S RECOMMENDATION AND USE APPROPRIATE SEALANT FOR WINDOW AND WOOD BUCK
 2. WEATHER RESISTIVE BARRIER TO FORM WATER-SHEDDING LAPS.


RECESSED WINDOW

WP10

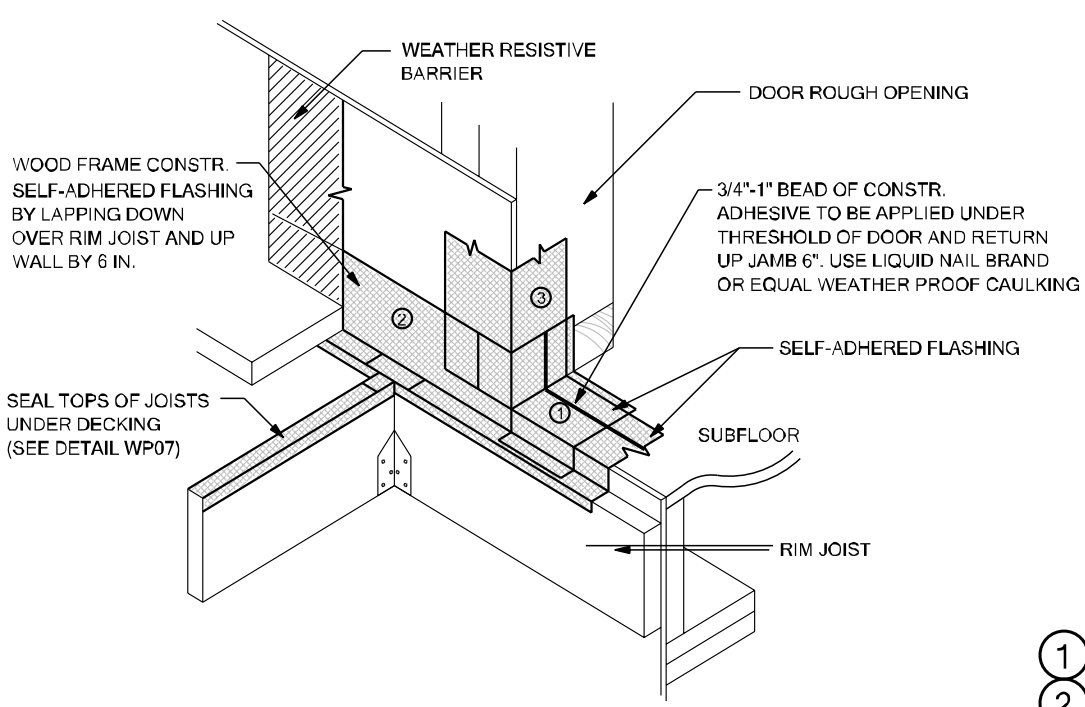


SELF-ADHERED FLASHING
EXTERIOR DOOR WITH DECK - SECTION A

WP02

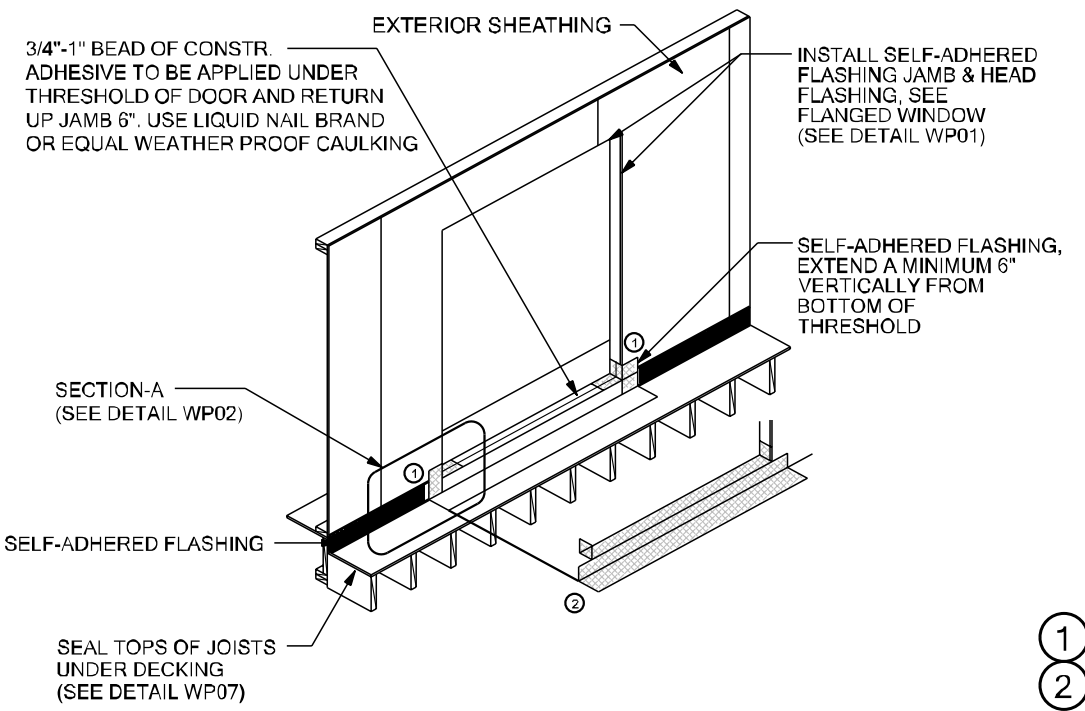


SELF-ADHERED FLASHING
EXTERIOR DOOR WITH DECK

WP05

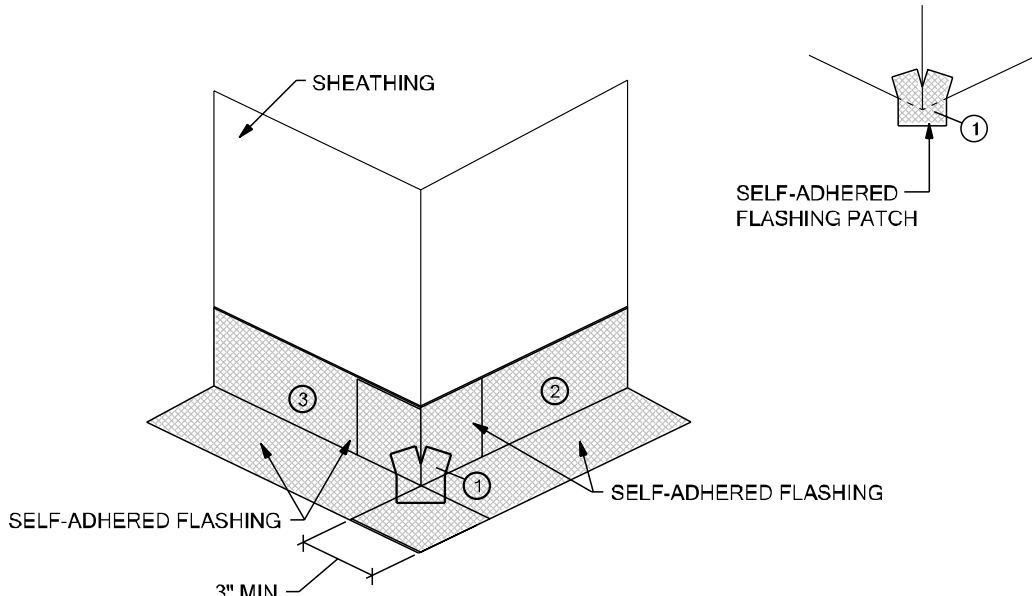

SELF-ADHERED FLASHING
OUTSIDE CORNER


WP08

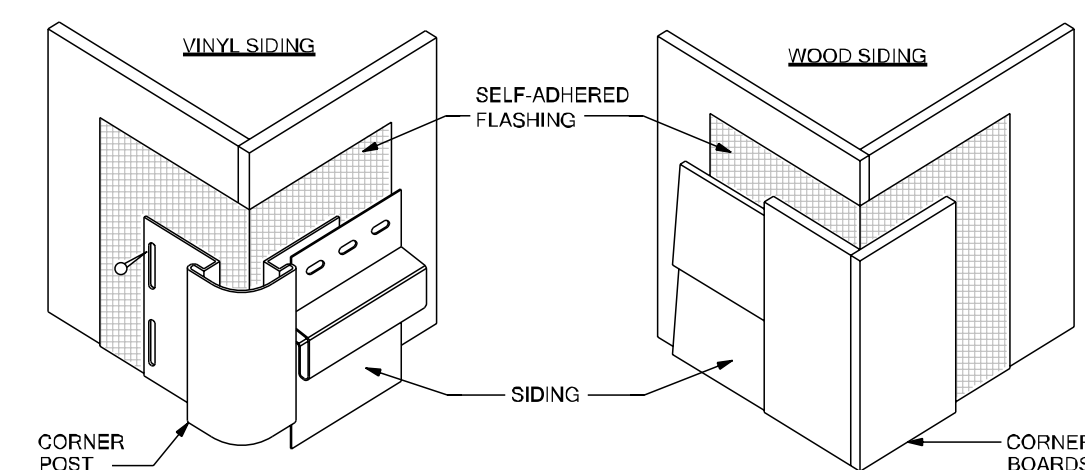

- NOTES:
1. EXTEND SELF-ADHERED FLASHING BEYOND JOINT BETWEEN SIDING AND CORNER POST/BOARDS.
 2. INSTALL SELF-ADHERED FLASHING ON OUTSIDE CORNER FOR THE HEIGHT OF THE WALL.


WALL-TO-WALL OUTSIDE CORNER

WP11

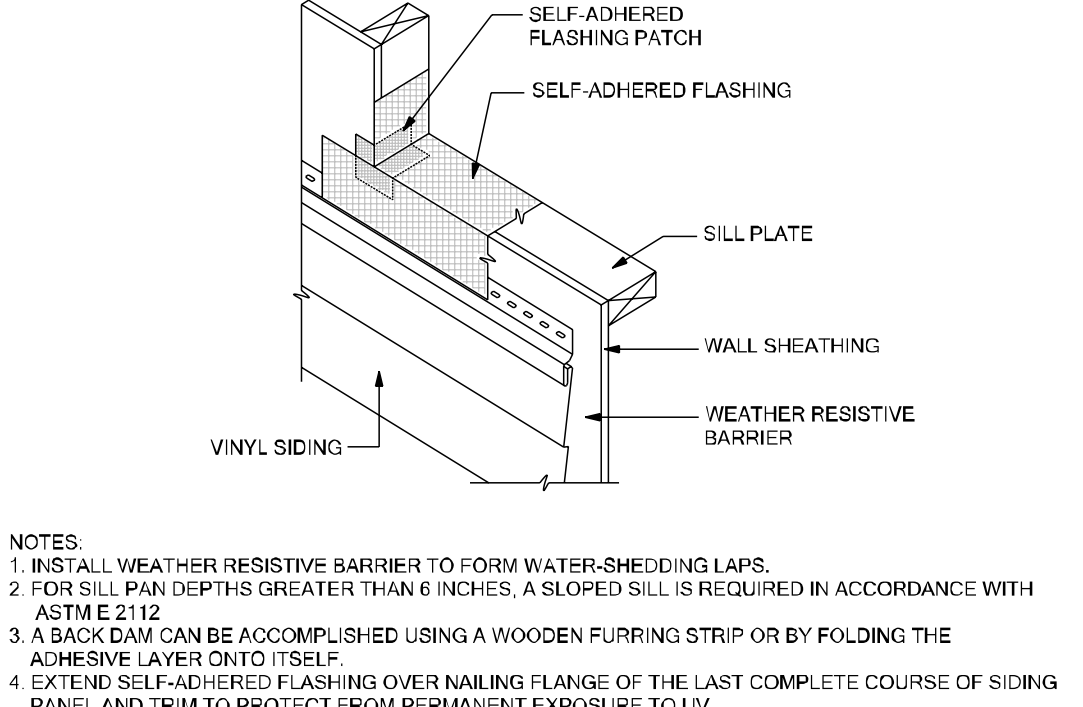

TIE-IN WITH VINYL SIDING
AT WINDOW SILL

WP03

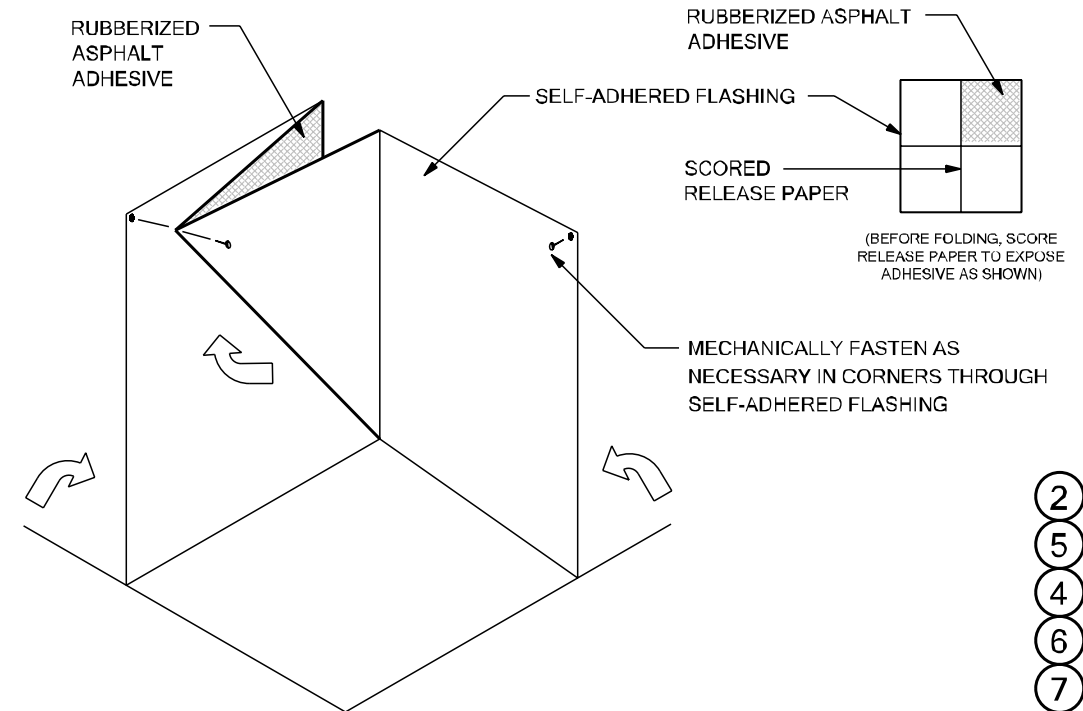

SELF-ADHERED FLASHING
INSIDE CORNER

WP06



WALL-TO-WALL INSIDE CORNER

WP12

THESE DETAILS ARE GENERIC AND MEANT TO SHOW
GENERAL FLASHING AND WATERPROOFING METHODS
TO BE USED.

SELF-ADHERED FLASHING PRODUCTS DETAILS

TWO LAYERS OF FELT OR ONE LAYER OF HOUSE WRAP AND
ONE LAYER OF FELT ARE REQUIRED BEHIND STUCCO. FBC R703.2

DETAIL INSTRUCTIONS

REFER TO THE NUMBER MARKED AS (#) IN EACH DETAIL THAT
CORRESPONDS TO THE NUMBERED ITEMS IN THE LIST OF
INSTRUCTIONS BELOW:

1. INSTALL SELF-ADHERED FLASHING IN ORDER AS SHOWN BY NUMBERS.
2. INSTALL FLASHING AND WEATHER RESISTIVE BARRIER TO FORM WATER-SHEDDING LAPS.
3. SELF-ADHERED FLASHING CAN BE SUBSTITUTED FOR BUILDING PAPER.
4. SPLIT THE RELEASE PAPER USING THE RIPCORD (SPLIT RELEASE ON DEMAND, EMBEDDED IN THE ADHESIVE LAYER) - FOR EASE OF INSTALLATION AND TO MINIMIZE SCORING CUTS.
5. REMOVE ALL RELEASE PAPER PER STANDARD INSTALLATION INSTRUCTIONS AND ADHERE TO SUBSTRATE USING A SQUARE PIECE OF FLASHING MATERIAL (6" X 6" MINIMUM).
6. FOLD AS SHOWN BY ARROWS.
7. ANGLE OF CORNER MAY VARY, ADJUST FOLDING OF THE FLASHING ACCORDINGLY TO FIT TIGHT TO CORNER.
8. MECHANICALLY FASTEN AS NECESSARY.

FLASHING REQUIREMENTS

R703.1 GENERAL. EXTERIOR WALLS SHALL PROVIDE THE BUILDING WITH A WEATHER-RESISTANT EXTERIOR WALL ENVELOPE. THE EXTERIOR WALL ENVELOPE SHALL INCLUDE FLASHING AS DESCRIBED IN SECTION R703.4. A WATER-RESISTIVE BARRIER IS DESCRIBED AS A MATERIAL, BEHIND AN EXTERIOR WALL COVERING THAT IS INTENDED TO RESIST LIQUID WATER THAT HAS PENETRATED BEHIND THE EXTERIOR COVERING FROM FURTHER INTRUDING INTO THE EXTERIOR WALL ASSEMBLY. AN EXTERIOR WALL COVERING IS DESCRIBED AS A MATERIAL OR ASSEMBLY OF MATERIALS APPLIED ON THE EXTERIOR SIDE OF EXTERIOR WALLS FOR THE PURPOSE OF PROVIDING A WEATHER-RESISTIVE BARRIER, INSULATION, OR FOR AESTHETICS, INCLUDING BUT NOT LIMITED TO, VENEERS, SIDING, EXTERIOR INSULATION AND FINISH SYSTEMS, ARCHITECTURAL TRIM AND EMBELLISHMENTS SUCH AS CORNICES, SOFFITS, AND FASCIA.

R703.2 WATER-RESISTIVE BARRIER. ONE LAYER OF NO. 15 ASPHALT FELT, FREE FROM HOLES AND BREAKS, COMPLYING WITH ASTM D228 FOR TYPE I FELT OR OTHER APPROVED WATER-RESISTIVE BARRIER SHALL BE APPLIED OVER STUDS OR SHEATHING OF ALL EXTERIOR WALLS. SUCH FELT OR MATERIAL SHALL BE APPLIED HORIZONTALLY, WITH THE UPPER LAYER LAPPED OVER THE LOWER LAYER NOT LESS THAN 2 INCHES (51 MM) WHERE JOINTS OCCUR. FELT SHALL BE LAPPED NOT LESS THAN 6 INCHES (152 MM). THE FELT OR OTHER APPROVED MATERIAL SHALL BE CONTINUOUS TO THE TOP OF WALLS AND TERMINATED AT PENETRATIONS AND BUILDING APPENDAGES IN A MANNER TO MEET THE REQUIREMENTS OF THE EXTERIOR WALL ENVELOPE AS DESCRIBED IN SECTION R703.1.

R703.3 WATER-RESISTIVE BARRIERS SHALL BE INSTALLED AS REQUIRED IN SECTION R703.2 AND, WHERE APPLIED OVER WOOD-BASED SHEATHING, SHALL INCLUDE A WATER-RESISTIVE VAPOR-PERMEABLE BARRIER WITH A PERFORMANCE AT LEAST EQUIVALENT TO TWO LAYERS OF GRADE D PAPER. THE INDIVIDUAL LAYERS SHALL BE INSTALLED INDEPENDENTLY SUCH THAT EACH LAYER PROVIDES A SEPARATE CONTINUOUS PLANE AND ANY FLASHING (INSTALLED IN ACCORDANCE WITH SECTION R703.4) INTENDED TO DRAIN TO THE WATER-RESISTIVE BARRIER IS DIRECTED BETWEEN THE LAYERS.

EXCEPTION: WHERE THE WATER-RESISTIVE BARRIER THAT IS APPLIED OVER WOOD-BASED SHEATHING HAS A WATER RESISTANCE EQUAL TO OR GREATER THAN THAT OF 60-MINUTE GRADE D PAPER AND IS SEPARATED FROM THE STUCCO BY AN INTERVENING, SUBSTANTIALLY NONWATER-ABSORBING LAYER OR DESIGNED DRAINAGE SPACE.

R703.4 FLASHING. APPROVED CORROSION-RESISTANT FLASHING SHALL BE APPLIED SHINGLE-FASHION IN A MANNER TO PREVENT ENTRY OF WATER INTO THE WALL CAVITY OR PENETRATION OF WATER TO THE BUILDING STRUCTURAL FRAMING COMPONENTS. SELF-ADHERED MEMBRANES USED AS FLASHING SHALL COMPLY WITH AAMA 711. ALL EXTERIOR PENETRATION PRODUCTS SHALL BE SEALED AT THE JUNCTURE WITH THE BUILDING WALL WITH A SEALANT COMPLYING WITH AAMA 800 OR ASTM C920 CLASS 25 GRADE NS OR GREATER FOR PROPER JOINT EXPANSION AND CONTRACTION. ASTM C1281, AAMA 812, OR OTHER APPROVED STANDARD AS APPROPRIATE FOR THE TYPE OF SEALANT. FLUID-APPLIED MEMBRANES USED AS FLASHING IN EXTERIOR WALLS SHALL COMPLY WITH AAMA 714. THE FLASHING SHALL EXTEND TO THE SURFACE OF THE EXTERIOR WALL FINISH. APPROVED CORROSION-RESISTANT FLASHINGS SHALL BE INSTALLED AT THE FOLLOWING LOCATIONS:

1. EXTERIOR WINDOW AND DOOR OPENINGS. FLASHING AT EXTERIOR WINDOW AND DOOR OPENINGS SHALL EXTEND TO THE SURFACE OF THE EXTERIOR WALL FINISH OR TO THE WATER-RESISTIVE BARRIER COMPLYING WITH SECTION R703.2 FOR SUBSEQUENT DRAINAGE. MECHANICALLY ATTACHED FLEXIBLE FLASHINGS SHALL COMPLY WITH AAMA 712. FLASHING AT EXTERIOR WINDOW AND DOOR OPENINGS SHALL BE INSTALLED IN ACCORDANCE WITH ONE OR MORE OF THE FOLLOWING:
 - 1.1 THE FENESTRATION MANUFACTURER'S INSTALLATION AND FLASHING INSTRUCTIONS, OR FOR APPLICATIONS NOT ADDRESSED IN THE FENESTRATION MANUFACTURER'S INSTRUCTIONS, IN ACCORDANCE WITH THE FLASHING MANUFACTURER'S INSTRUCTIONS, WHERE FLASHING INSTRUCTIONS OR DETAILS ARE NOT PROVIDED. PAN FLASHING SHALL BE INSTALLED AT THE SILL OF EXTERIOR WINDOW AND DOOR OPENINGS. PAN FLASHING SHALL BE SEALED OR SLOPED IN SUCH A MANNER AS TO DIRECT WATER TO THE SURFACE OF THE EXTERIOR WALL FINISH OR TO THE WATER RESISTIVE BARRIER FOR SUBSEQUENT DRAINAGE. OPENINGS USING PAN FLASHING SHALL INCORPORATE FLASHING OR PROTECTION AT THE HEAD AND SIDES.
 - 1.2. IN ACCORDANCE WITH THE FLASHING DESIGN OR METHOD OF A REGISTERED DESIGN PROFESSIONAL.
 - 1.3. IN ACCORDANCE WITH OTHER APPROVED METHODS.
 - 1.4. IN ACCORDANCE WITH FMA/AAMA 100, FMA/AAMA 200, FMA/WDMA 250, FMA/AAMA/WDMA 300 OR FMA/AAMA/WDMA 400.
2. AT THE INTERSECTION OF CHIMNEYS OR OTHER MASONRY CONSTRUCTION WITH FRAME OR STUCCO WALLS, WITH PROJECTING LIPS ON BOTH SIDES UNDER STUCCO CORNICES.
3. UNDER AND AT THE ENDS OF MASONRY, WOOD OR METAL COPINGS AND SILLS.
4. CONTINUOUSLY ABOVE ALL PROJECTING WOOD TRIM.
5. WHERE EXTERIOR PORCHES, DECKS OR STAIRS ATTACH TO A WALL OR FLOOR ASSEMBLY OF WOOD-FRAME CONSTRUCTION.
6. AT WALL AND ROOF INTERSECTIONS.
7. AT BUILT-IN GUTTERS.

FIGURE 1: FLASHING INSTALLATION

ASPHALT SEALANT:
EXTEND MIN. OF 6"
OUTSIDE OF FLASHING


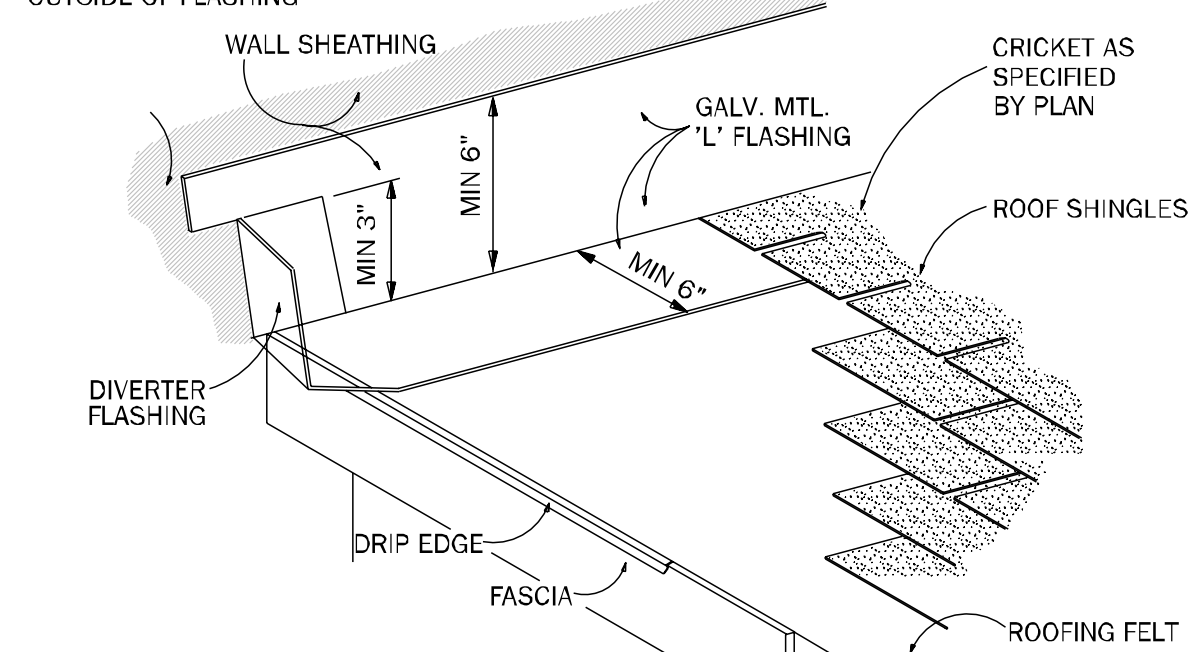



FIGURE 2: WALL FINISH

TEXTURED, PAINTED
EXTERIOR WALL FINISH

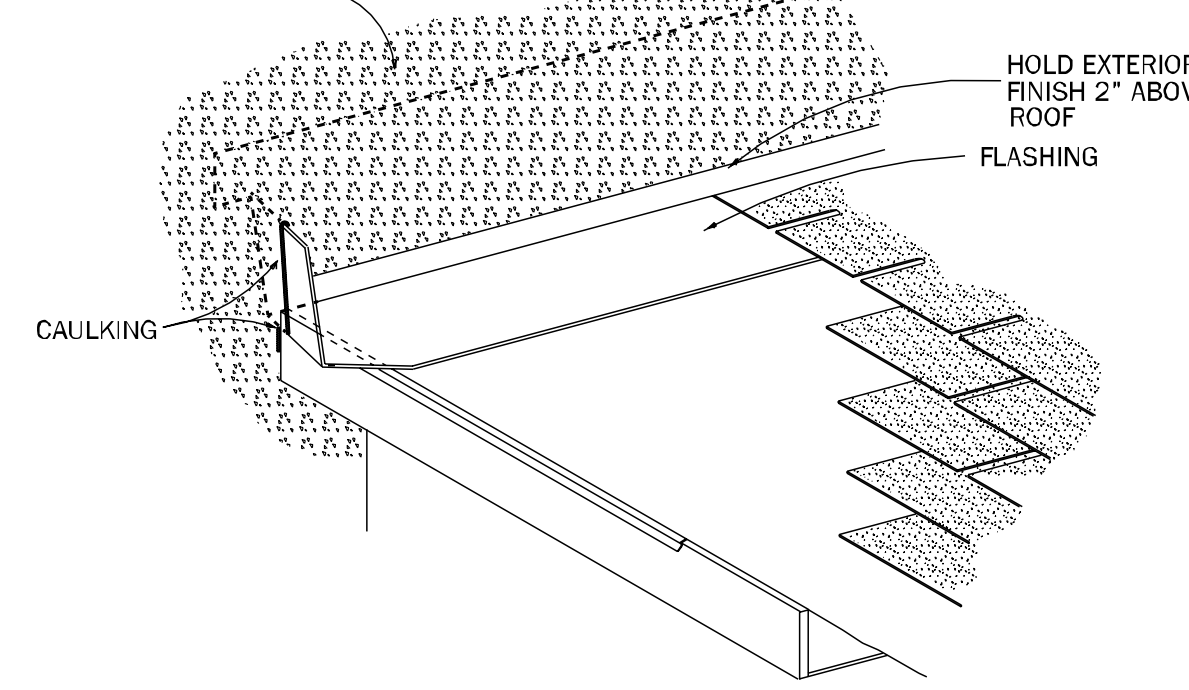

FLASHING INSTALLATION
WHERE ROOF MEETS VERTICAL WALL

FIGURE 3: CORNER DETAIL

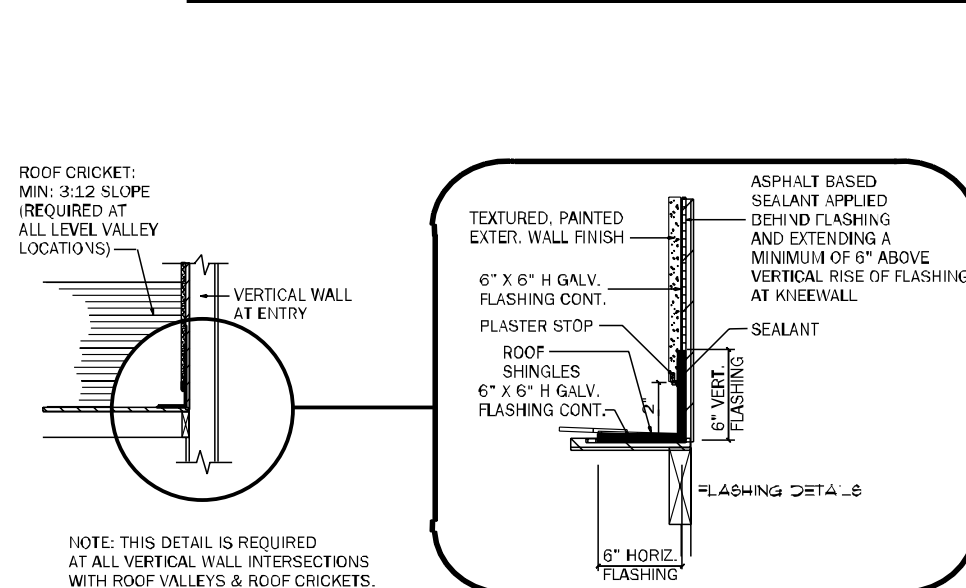

FLASHING DETAIL AT CRICKET
/ KNEEWALL INTERSECTION

COUNTY
SEAL

Wednesday, March 19, 2025

To the best of the Engineer's knowledge, information and belief, the structural plans and specifications contain within these drawings comply with the 2023 Florida Building Code-Residential 8th Edition. Engineer's signature and seal is only for the structural engineering portions of the drawing pages bearing engineer's signature and seal.

CA No. 9161 AA26003115

TOTAL SOLUTIONS GROUP
258 Southhall Lane, Suite 200
Maitland, Florida, 32751
(407) 880 2333

100% Employee Owned
myTSGhome.com

DAMS HOMES

FLORIDA CONTRACTORS LICENSE NO. CRC1330146
100 WEST GARDEN STREET
PENSACOLA FL 32502

DIVISION LOCATION:
GAINESVILLE

Job Information:

INVENTORY

LOT: 12
BLK:
SEC:
SUB: PRESERVE AT LAUREL LAKE
133 SW BELFLOWER DR.
LAKE CITY


Model Name / Number:
2117

Plan Issue Date:
Wednesday, March 19, 2025

KA PROJECT NUMBER:
25-02684


Sheet: WP Of:

WATER PROOF
DETAILS

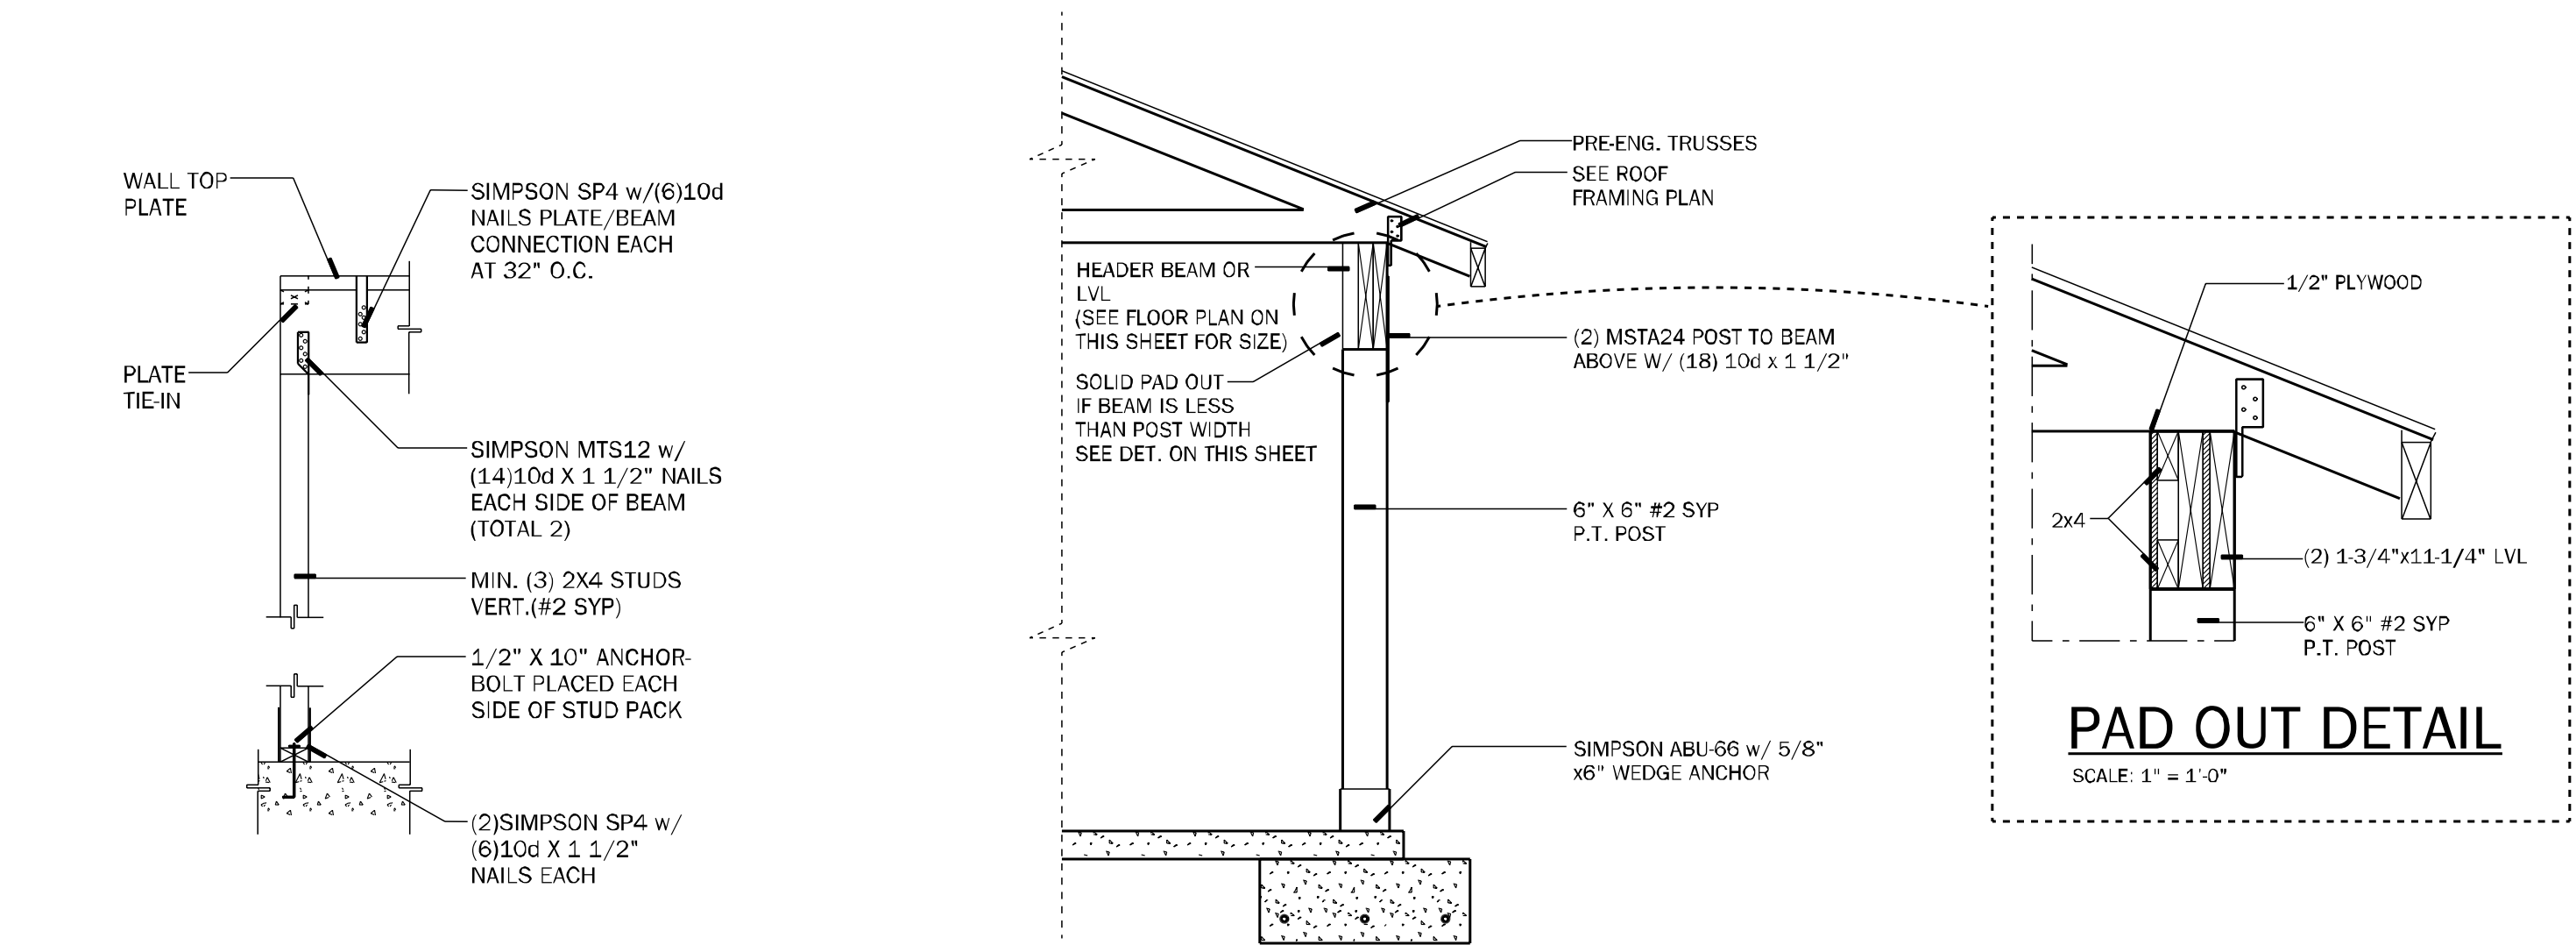


7 BEAM/WALL CONNECTION
SCALE: N.T.S.


POST SECTION
SCALE: 1/2" = 1'-0"

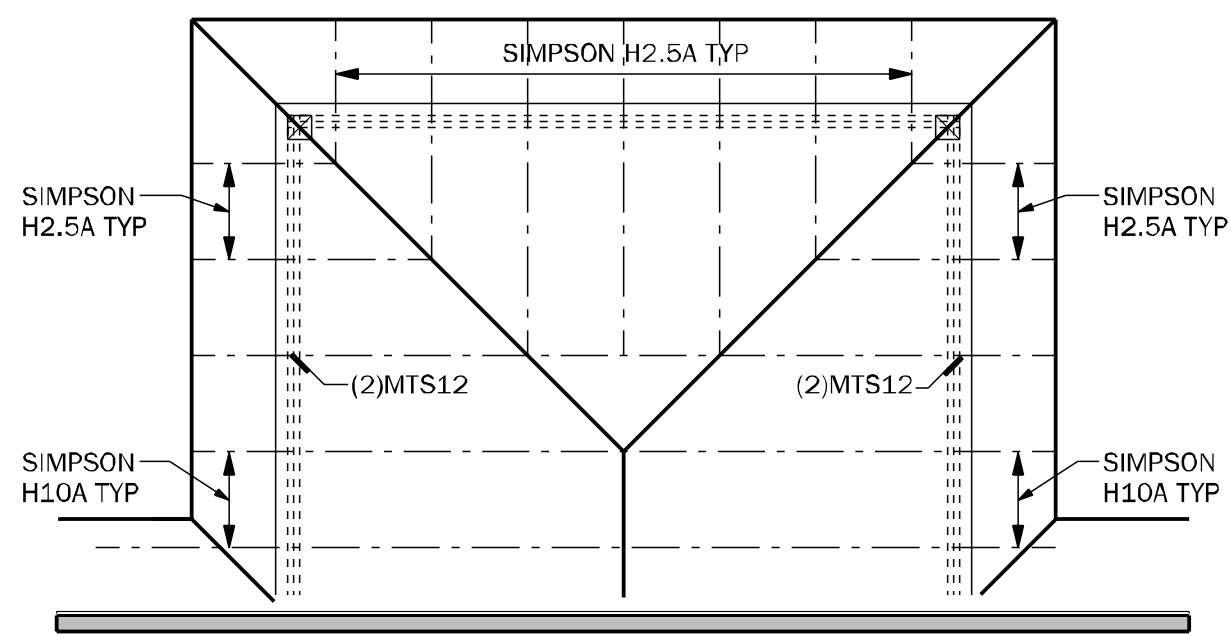


ROOF PLAN
SCALE: 1/4" = 1'-0"

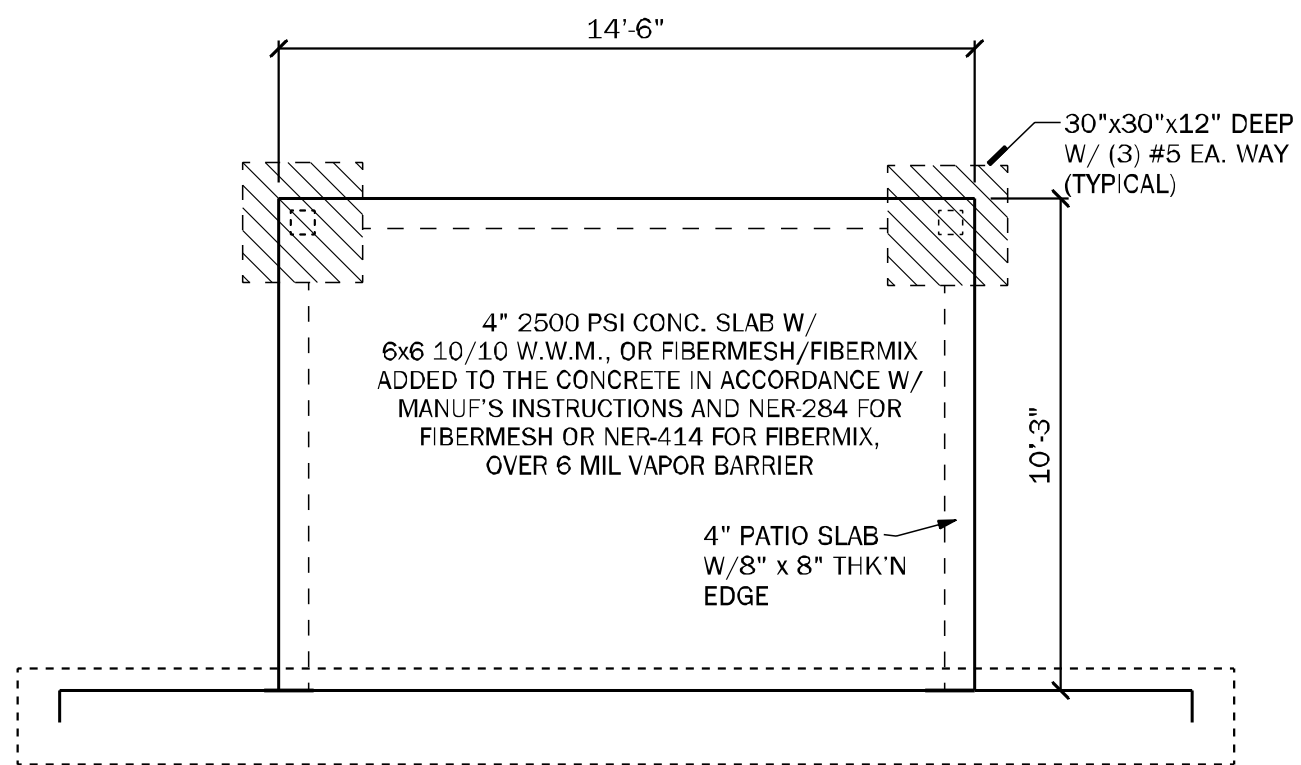

FOUNDATION PLAN
SCALE: 1/4" = 1'-0"

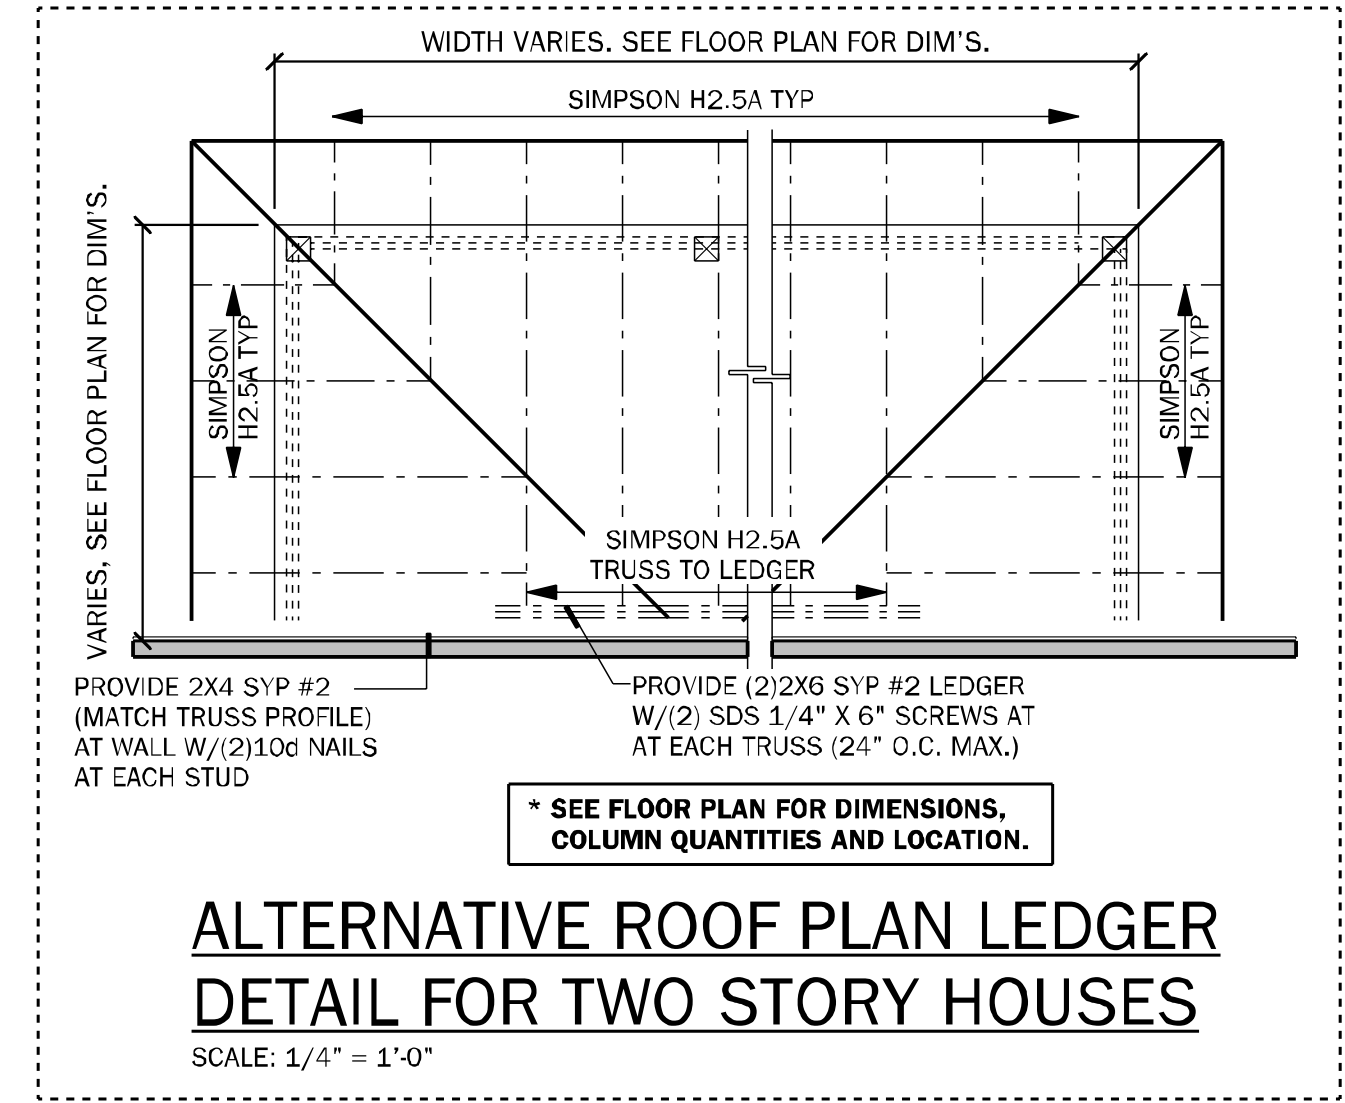

ALTERNATIVE ROOF PLAN LEDGER
DETAIL FOR TWO STORY HOUSES
SCALE: 1/4" = 1'-0"

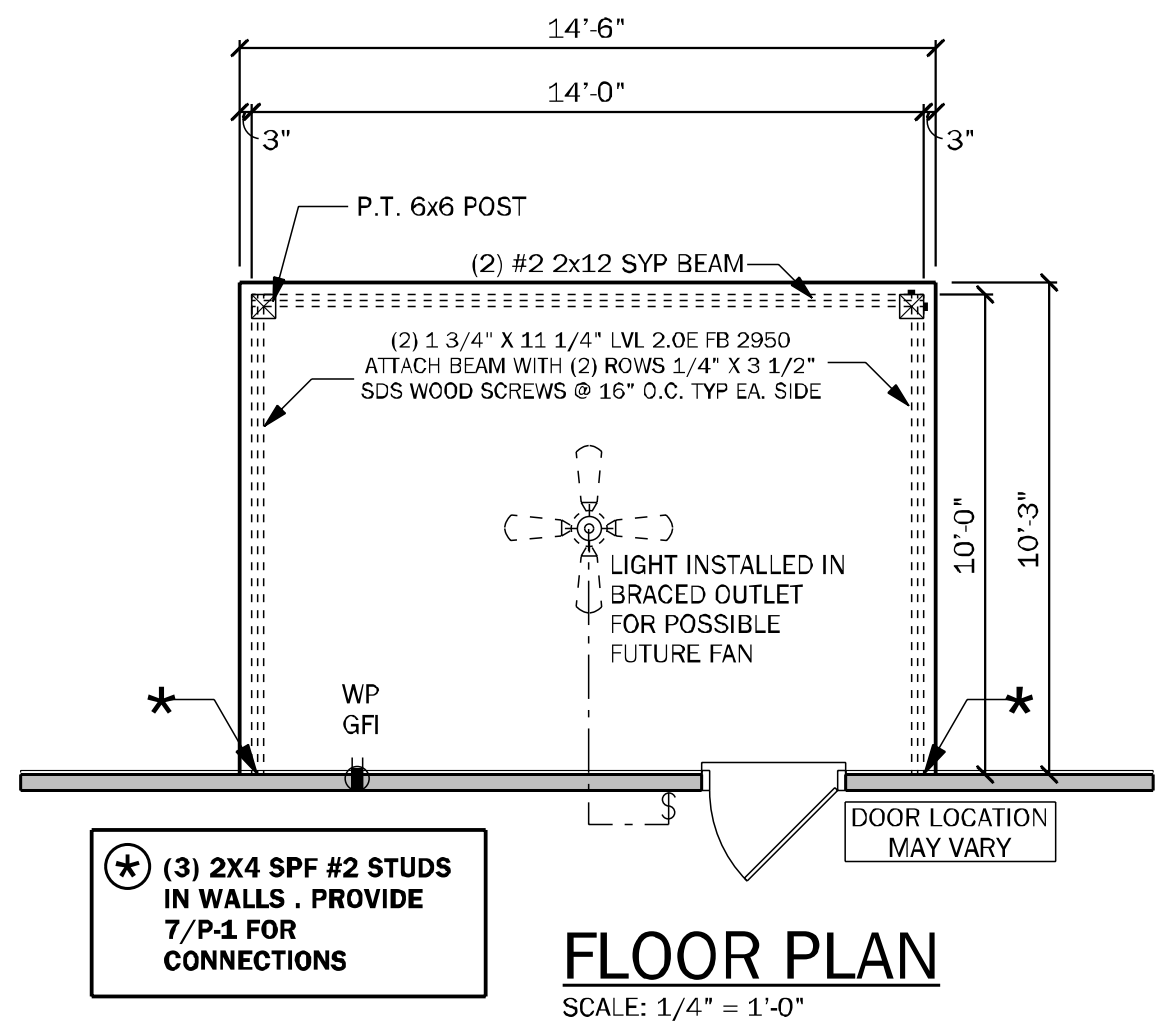

FLOOR PLAN
SCALE: 1/4" = 1'-0"

COUNTY
SEAL

Wednesday, March 19, 2025

To the best of the Engineer's knowledge, information and belief, the structural plans and specifications contain within these drawings comply with the 2023 Florida Building Code- Residential 8th Edition.
Engineer's signature and seal is only for the structural engineering portions of the drawing pages bearing engineer's signature and seal.
CA No. 9161 AA26003115



TOTAL SOLUTIONS GROUP
258 Southhall Lane, Suite 200
Maitland, Florida, 32751
(407) 880 2333

100% Employee Owned
myTSGhome.com



FLORIDA CONTRACTORS LICENSE NO. CRC13302146
100 WEST GARDEN STREET
PENSACOLA FL 32502

DIVISION LOCATION:
GAINESVILLE

Job Information:

INVENTORY
LOT: 12
BLK:
SEC:
SUB: PRESERVE AT LAUREL LAKE
133 SW BELLFLOWER DR.
LAKE CITY

Model Name / Number:

2117

Plan Issue Date:

Wednesday, March 19, 2025

KA PROJECT NUMBER:

25-02684

Sheet: P1 Of:

14x10 PORCH