



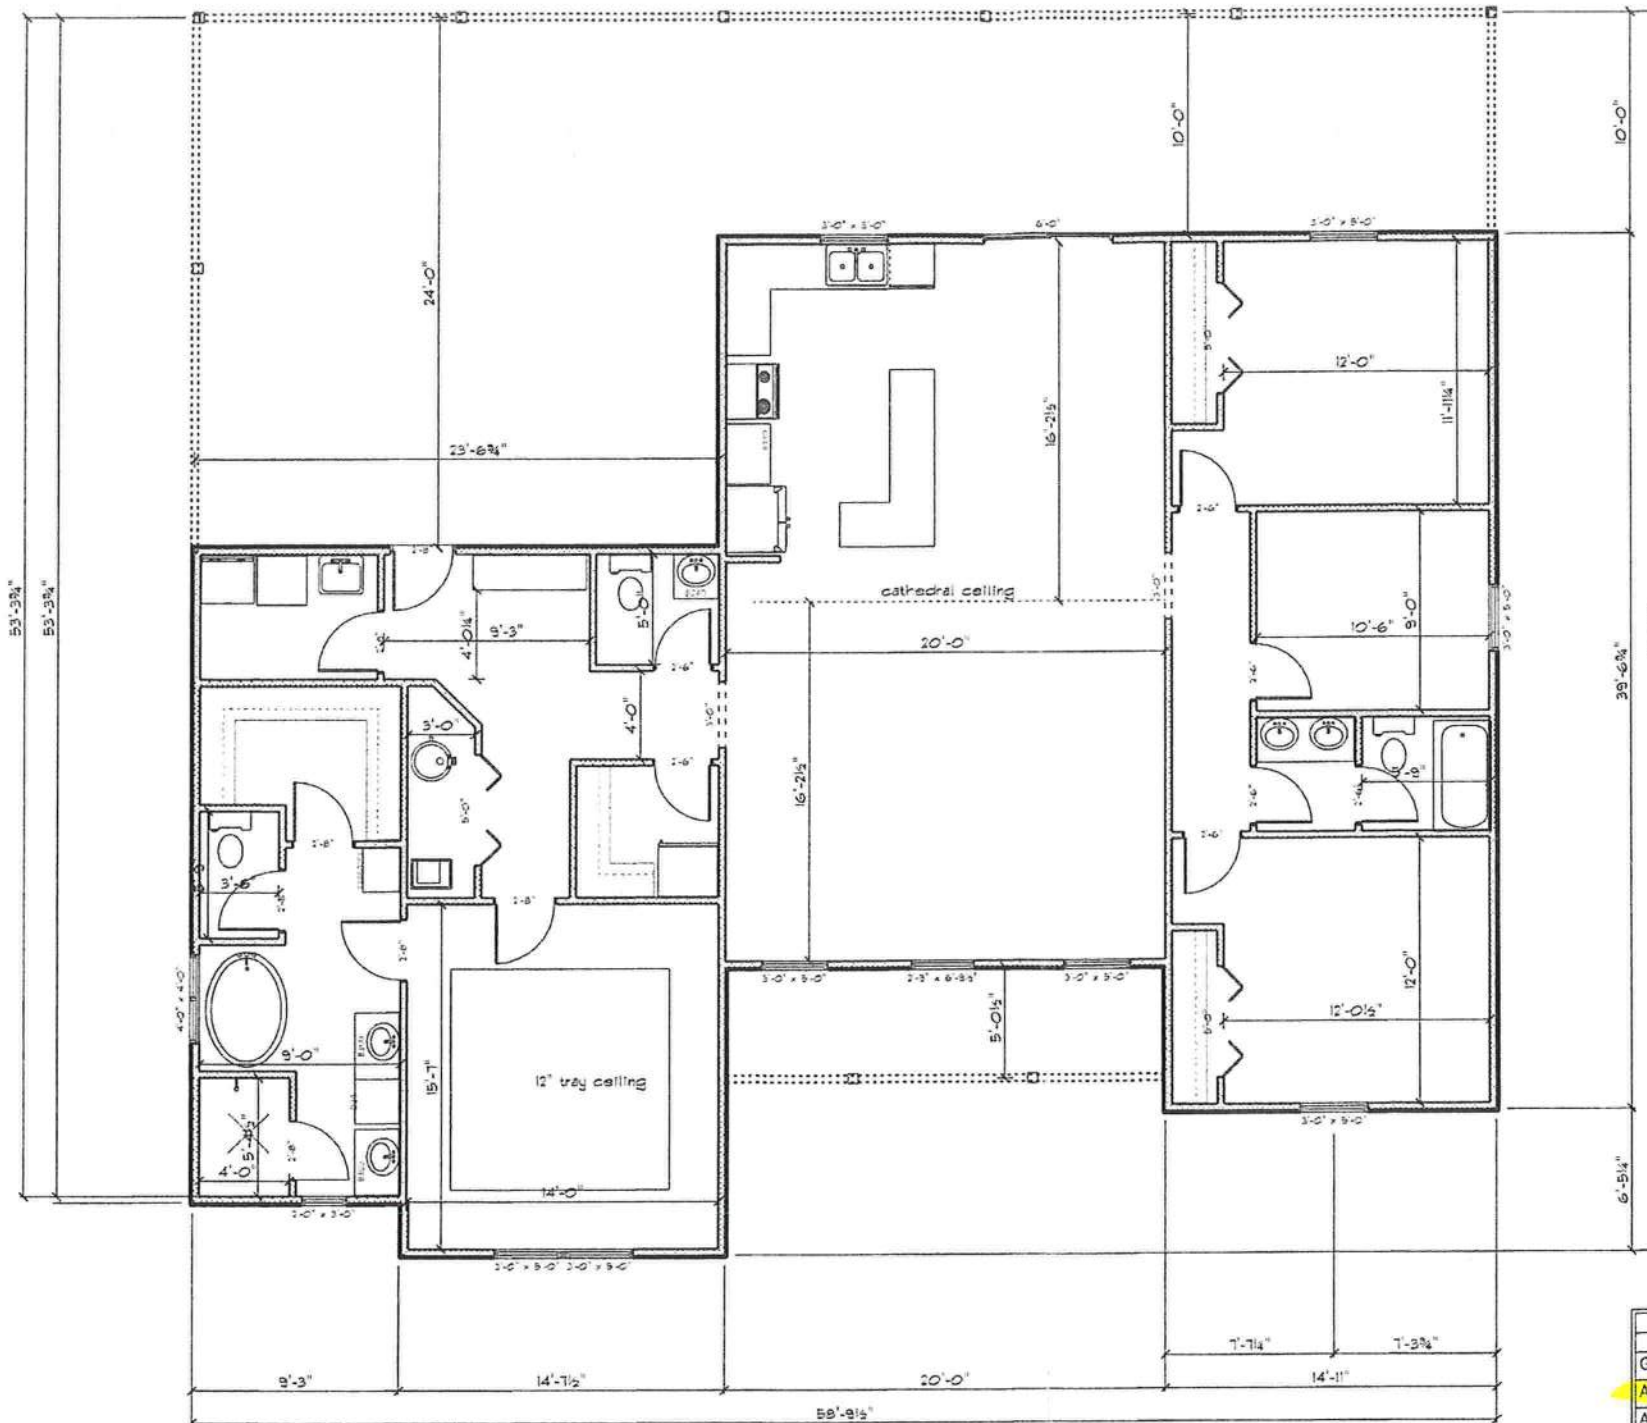

AREA SCHEDULE	
NAME	AREA
Gross Floor Area	3045.5 sq ft.
Area 2	2023.7 sq ft.
Area 3	1020.5 sq ft.

John Norris Construction, LLC
 Clayton Residence
 Columbia County, FL




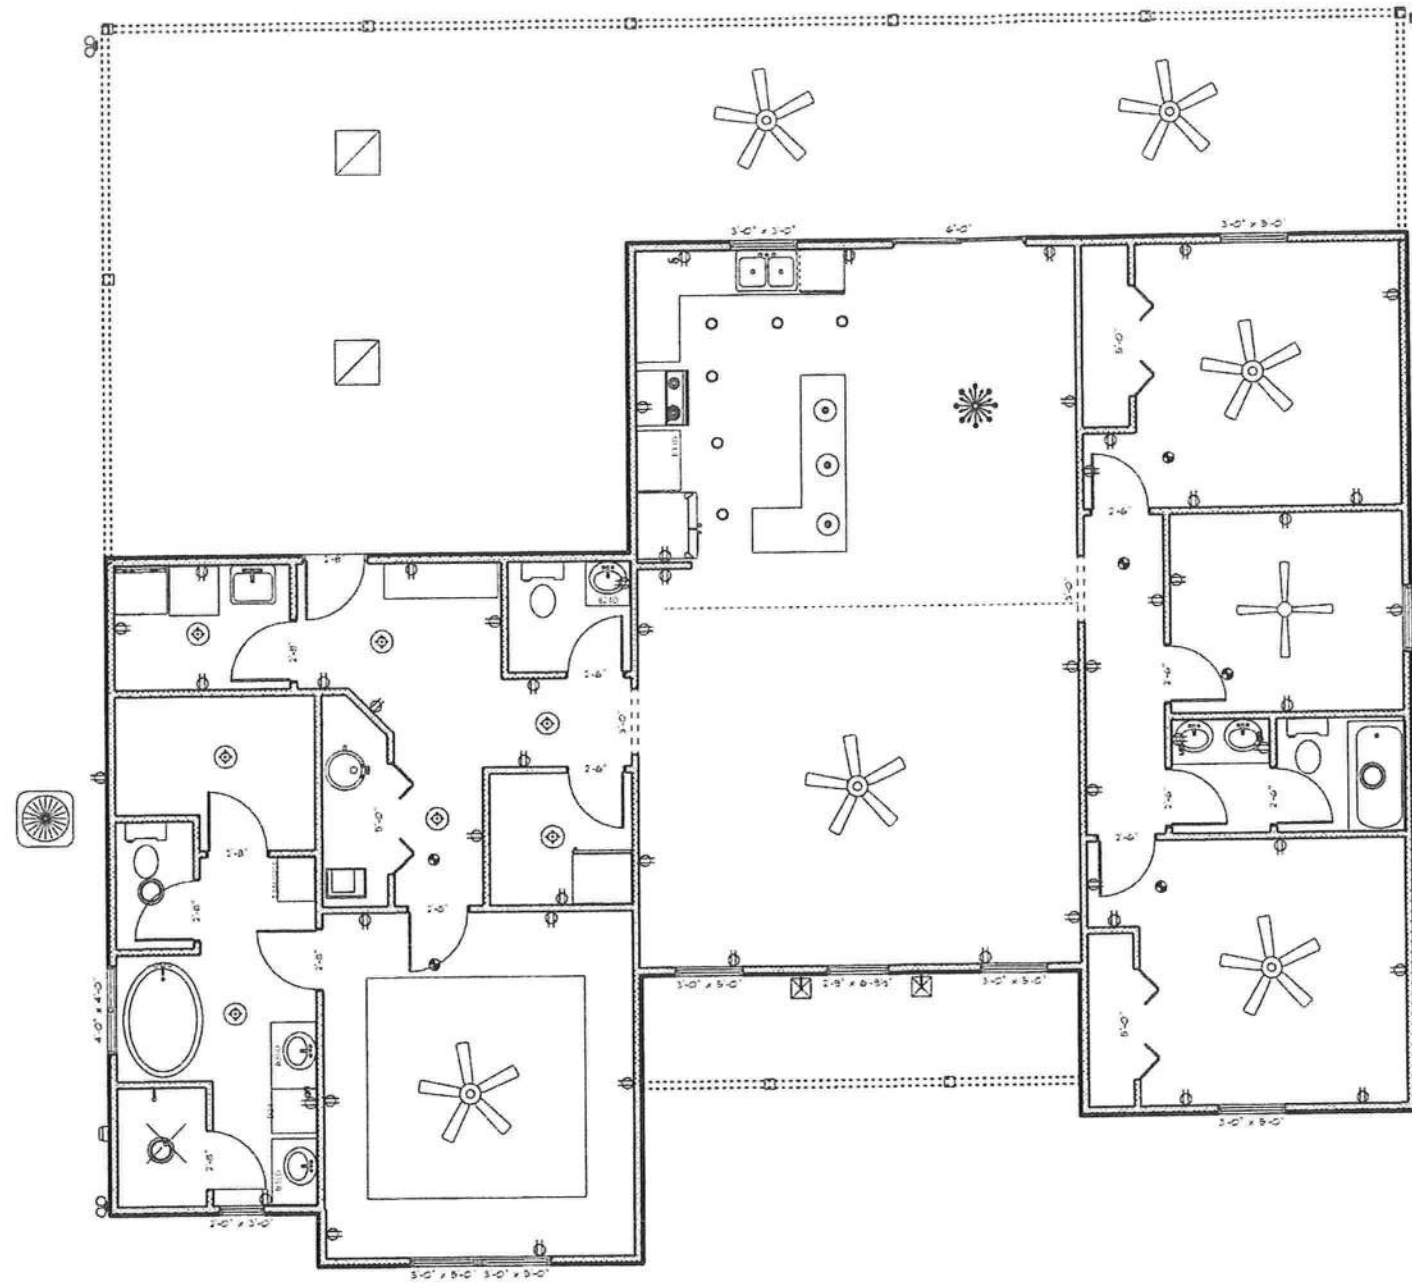

ELECTRICAL LEGEND		
ELECTRICAL	COUNT	SYMBOL
ceiling fan 48"	1	
ceiling fan 52"	0	
ceiling light 48"	0	
ceiling light 52"	1	
island pendants	3	
12" flat LED lights	7	
combination fan and light round	3	
entrance craftsman light fixture	2	
spot light double	4	
outlet	52	
outlet gfi	4	
smoke detector	6	


AREA SCHEDULE	
NAME	AREA
Gross Floor Area	3045.5 sq ft.
Area 2	2023.7 sq ft.
Area 3	1020.5 sq ft.

John Norris Construction, LLC
 Clayton Residence
 Columbia County, FL

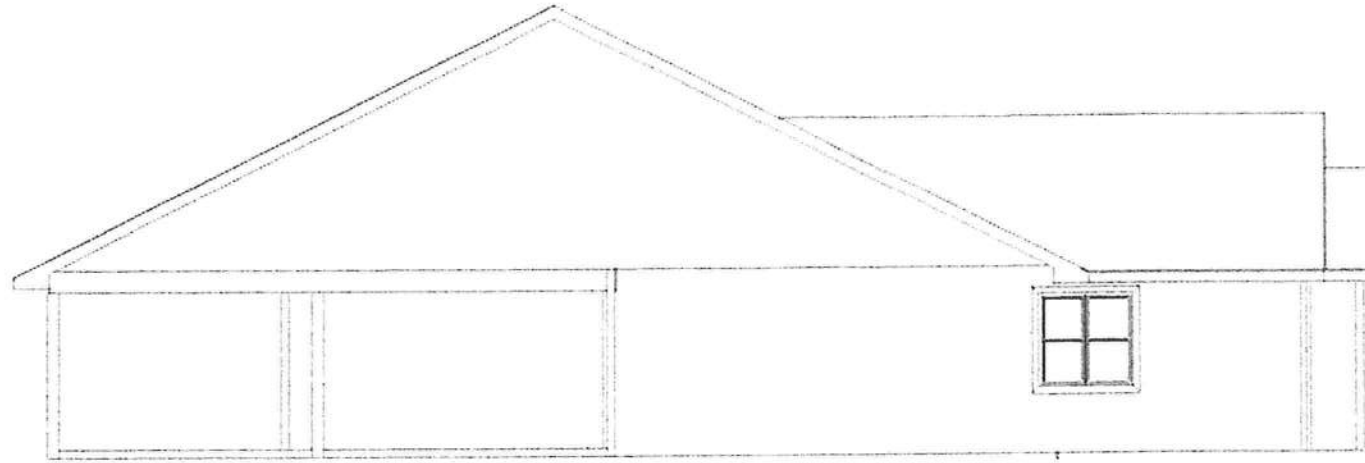


LEFT ELEVATION

SCALE: $\frac{1}{8}" = 1'-0"$

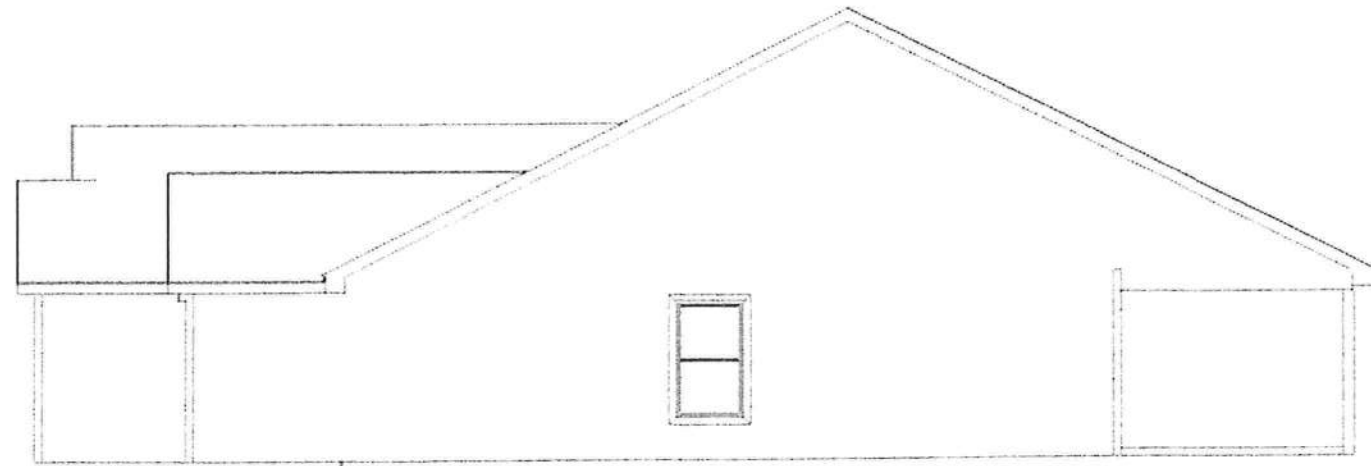


RIGHT ELEVATION

SCALE: $\frac{1}{8}" = 1'-0"$

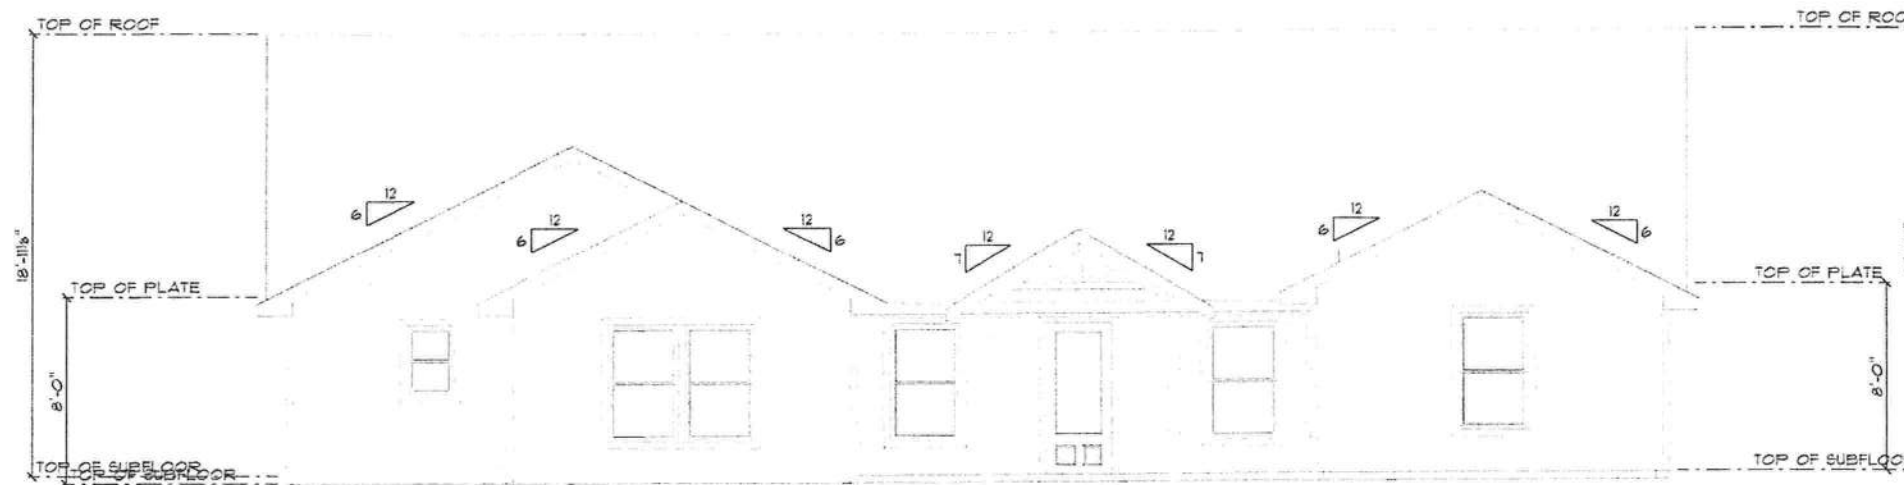

FRONT ELEVATION

SCALE: 1/8" = 1'-0"

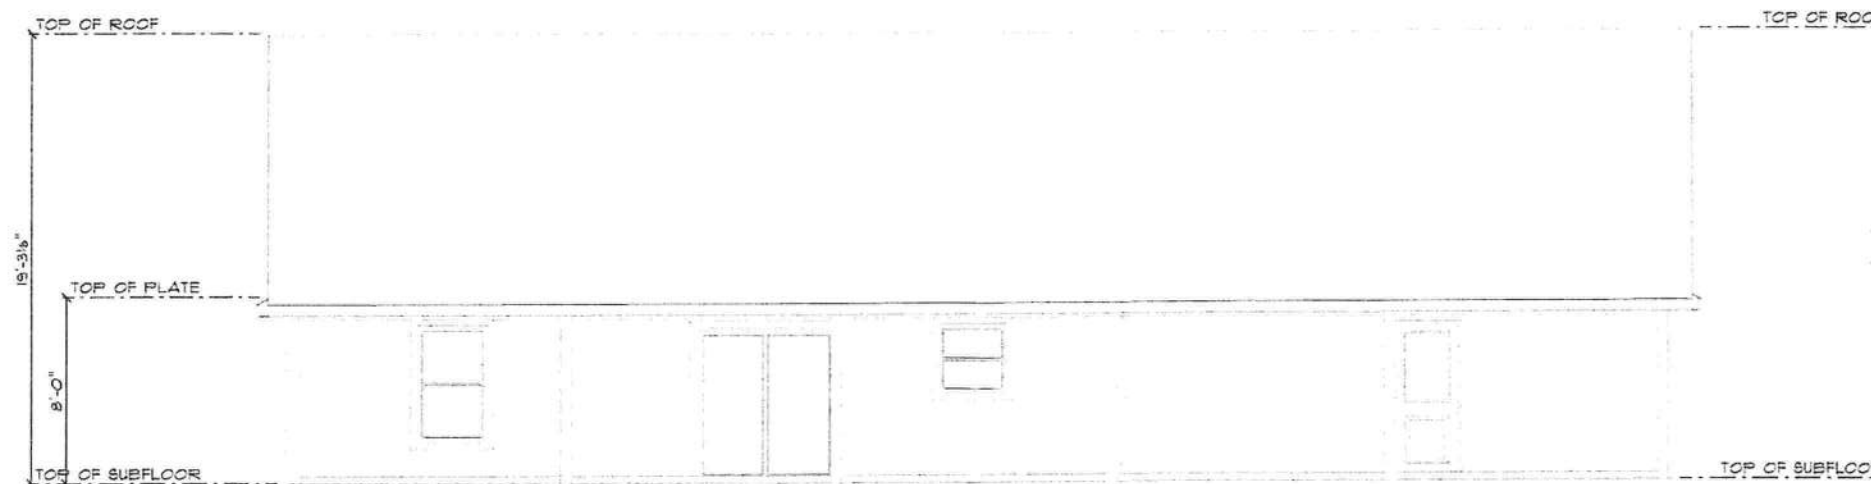

REAR ELEVATION

SCALE: 1/8" = 1'-0"