



CONSTRUCTION DOCUMENTS FOR:
LAKE CITY MINI STORAGE EXPANSION
COLUMBIA COUNTY, FL
SECTION 18, TOWNSHIP 4S, RANGE 17E

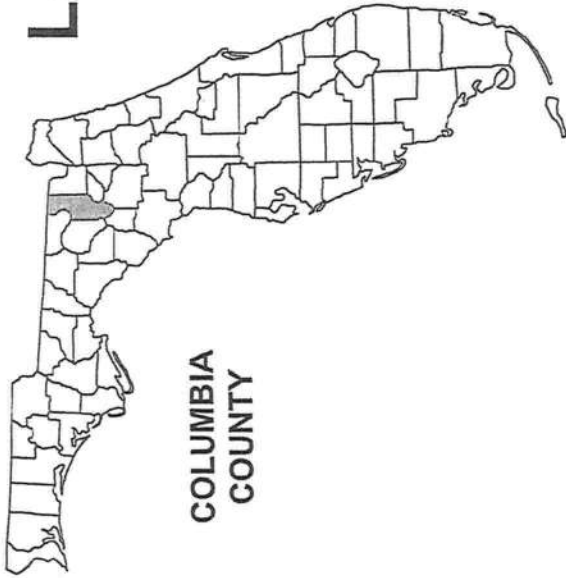

COLUMBIA
COUNTY

SHEET INDEX

- | | |
|---|---|
| COVER SHEET | 1 |
| GENERAL NOTES | 2 |
| ELECT. - FIREWALL PLAN BLDG NOS. 900 & 1000 | 3 |

 

BUILDING NOS. 900 & 1000 ELEVATIONS

PLANS PREPARED FOR:
MINI STORAGE & RECORD
STORAGE OF LAKE CITY
442 SW SAINT MARGARET ST
LAKE CITY, FL 32025
386-752-7092



6/13/2022


COVER SHEET

North Florida Professional Services, Inc.
P.O. BOX 160936
Tallahassee, FL 32316
Ph. 907-339-1525
Fax. 386-752-4674
Eng. Lic. 23011




REVISIONS:
JOB NUMBER: L180115MIN
DESIGNED BY: DRAFTED BY: CHECKED BY:
RB RB RB
DATE: 02/2020
SHEET NO. 1
P.E. NO.: 38546
ROBERT PHILLIP BISHOP JR.
ENGINEER OF RECORD


Architectural floor plan of a building section. The plan is divided into three main sections by two vertical firewalls. The dimensions of the sections are 80'-0" for the left and middle sections, and 40'-1 1/2" for the right section. The firewalls are labeled "3HR. FIREWALL @ METAL BUILDING FRAME LINE 49 SEE DETAILS 1 & 2", "3HR. FIREWALL @ METAL BUILDING FRAME LINE 33 SEE DETAILS 1 & 2", and "3HR. FIREWALL @ METAL BUILDING FRAME LINE 17 SEE DETAILS 1 & 2". The plan also shows a "60A. DISCONNECT" and a "TO MAIN ELECT. PANEL" connection. The plan is oriented with a dashed line indicating the connection to the main electrical panel.

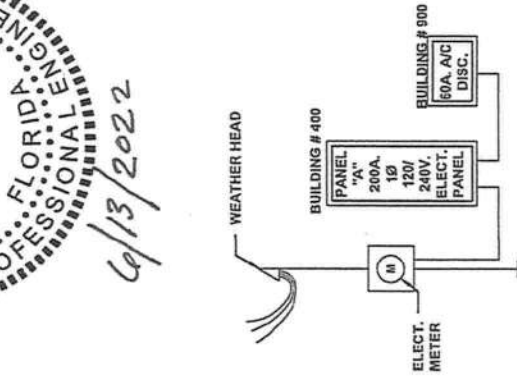

ELECTRIC RISER DIAGRAM
SCALE: NTS

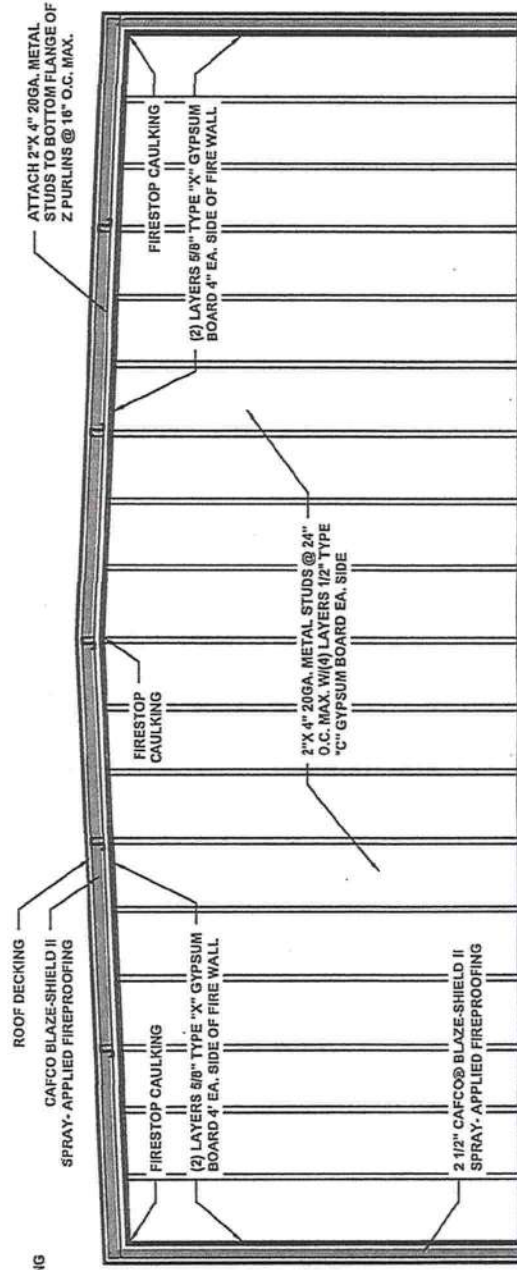

② FIREWALL SECTION
SCALE: 1/4" = 1'-0"

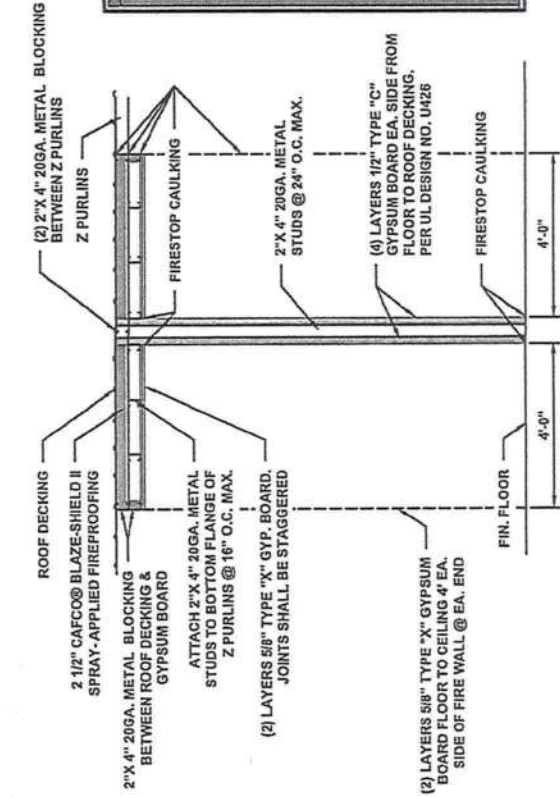

① FIREWALL SECTION
SCALE: 1/4" = 1'-0"