



REAR ELEVATION
SCALE: 1/4" = 1'-0"



FRONT ELEVATION
SCALE: 1/4" = 1'-0"

REVISIONS SCHEDULE		
APR. 14th, 2021	PROPOSAL	
APR. 16th, 2021	REVISIONS	

Scheffler Residence

LAKE CITY, FLORIDA

RIDGEPOINT

DESIGN

566 SW ARLINGTON BLVD. STE 101, LAKE CITY, FL 32025
P: 386-288-1188
E: RIDGEPOINTDESIGN@GMAIL.COM

SHEET NUMBER

A.1

OF 4 SHEETS



A R E A S U M M A R Y		
HEATED & COOLED	2,168	S.F.
GARAGE	815	S.F.
FRONT PORCH	168	S.F.
SCREENED PORCH	180	S.F.
TOTAL AREA	3,331	S.F.

REVISIONS SCHEDULE	
APR. 14th, 2021	PROPOSAL
APR. 16th, 2021	REVISIONS

Scheffler Residence
LAKE CITY, FLORIDA

 RIDGEPOINT
DESIGN
566 SW ARLINGTON BLVD. STE. 101, LAKE CITY, FL 32025
P: 386-288-1188
E: RIDGEPOINTDESIGN@GMAIL.COM

SHEET NUMBER
A.3
OF 4 SHEETS

ELECTRICAL LEGEND		
ELECTRICAL	COUNT	SYMBOL
CEILING FAN	6	
CAN LIGHT 6inch	15	
CHANDELIER	2	
FLUORESCENT LIGHT 1x4	4	
PENDANT LIGHT	2	
EXTERIOR SCONCE	3	
MOTION SECURITY LIGHT	4	
ELECTRIC METER	1	
ELECTRIC PANEL	1	
CABLE TV OUTLET	6	
EXHAUST FAN	2	
FLOOR OULET DUPLEX	2	
LAN CONNECTION	5	
OUTLET	38	
OUTLET 220v	6	
OUTLET GFI	22	
OUTLET WP	3	
SMOKE DETECTOR	4	
STANDARD LIGHT	8	
SWITCH	30	
SWITCH 3 WAY	12	
ceiling receptacle duplex	2	
VANITY BAR LIGHT - SMALL	4	

ELECTRICAL PLAN NOTES:

INSTALLATION SHALL BE PER 2017 NAT'L ELECTRIC CODE.

WIRE ALL APPLIANCES, HVAC UNITS AND OTHER EQUIPMENT PER MANUF. SPECIFICATIONS

CONSULT WITH THE OWNER FOR THE NUMBER OF SEPERATE TELEPHONE LINES TO BE INSTALLED

ALL SMOKE DETECTORS SHALL BE 120v W/ BATTERY BACKUP OF THE PHOTOELECTRIC TYPE, AND SHALL BE INTERLOCKED TOGETHER. INSTALL INSIDE AND NEAR ALL BEDROOMS


TELEPHONE, TELEVISION AND OTHER LOW VOLTAGE DEVICES OR OUTLETS SHALL BE AS PER THE OWNER'S DIRECTIONS. & IN ACCORDANCE W/ APPLICABLE SECTIONS OF NEC-LATEST EDITION.

ALL RECEPTICALS, NOT OTHERWISE NOTED, SHALL BE ARC FAULT INTERRUPTER TYPE, EXCEPT DEDICATED OUTLETS

ALL RECEPTICALS IN WET AREAS SHALL BE GROUND FAULT INTERRUPTER TYPE (GFI)

ALL EXTERIOR RECEPTICALS SHALL BE WEATHERPROOF GROUD FAULT INTERRUPTER TYPE (WP/GFI)

NOTE:
ELECTRICAL CONTR SHALL PREPARE "AS-BUILT" SHOP DWGS INDICATING ALL ELECTRICAL WORK, INCLUDING ANY CHANGES TO THE ELEC. PLAN, ADD'NS TO THE ELEC. PLAN, RISER DIAGRAM, AS-BUILT PANEL SCHEDULE W/ ALL CKTS IDENTIFIED W/ CKT Nr. DESCRIPTION & BRKR. SERVICE ENT. & ALL UNDERGROUND WIRE LOCATIONS/ROUTING / DEPTH. RISER DIA. SHALL INCLUDE WIRE SIZES/TYPE & EQUIPMENT TYPE W/ RATINGS & LOADS.
CONTRACTOR SHALL PROVIDE 1 COPY OF AS-BUILT DWGS TO OWNER & 1 COPY TO THE PERMIT ISSUING AUTHORITY

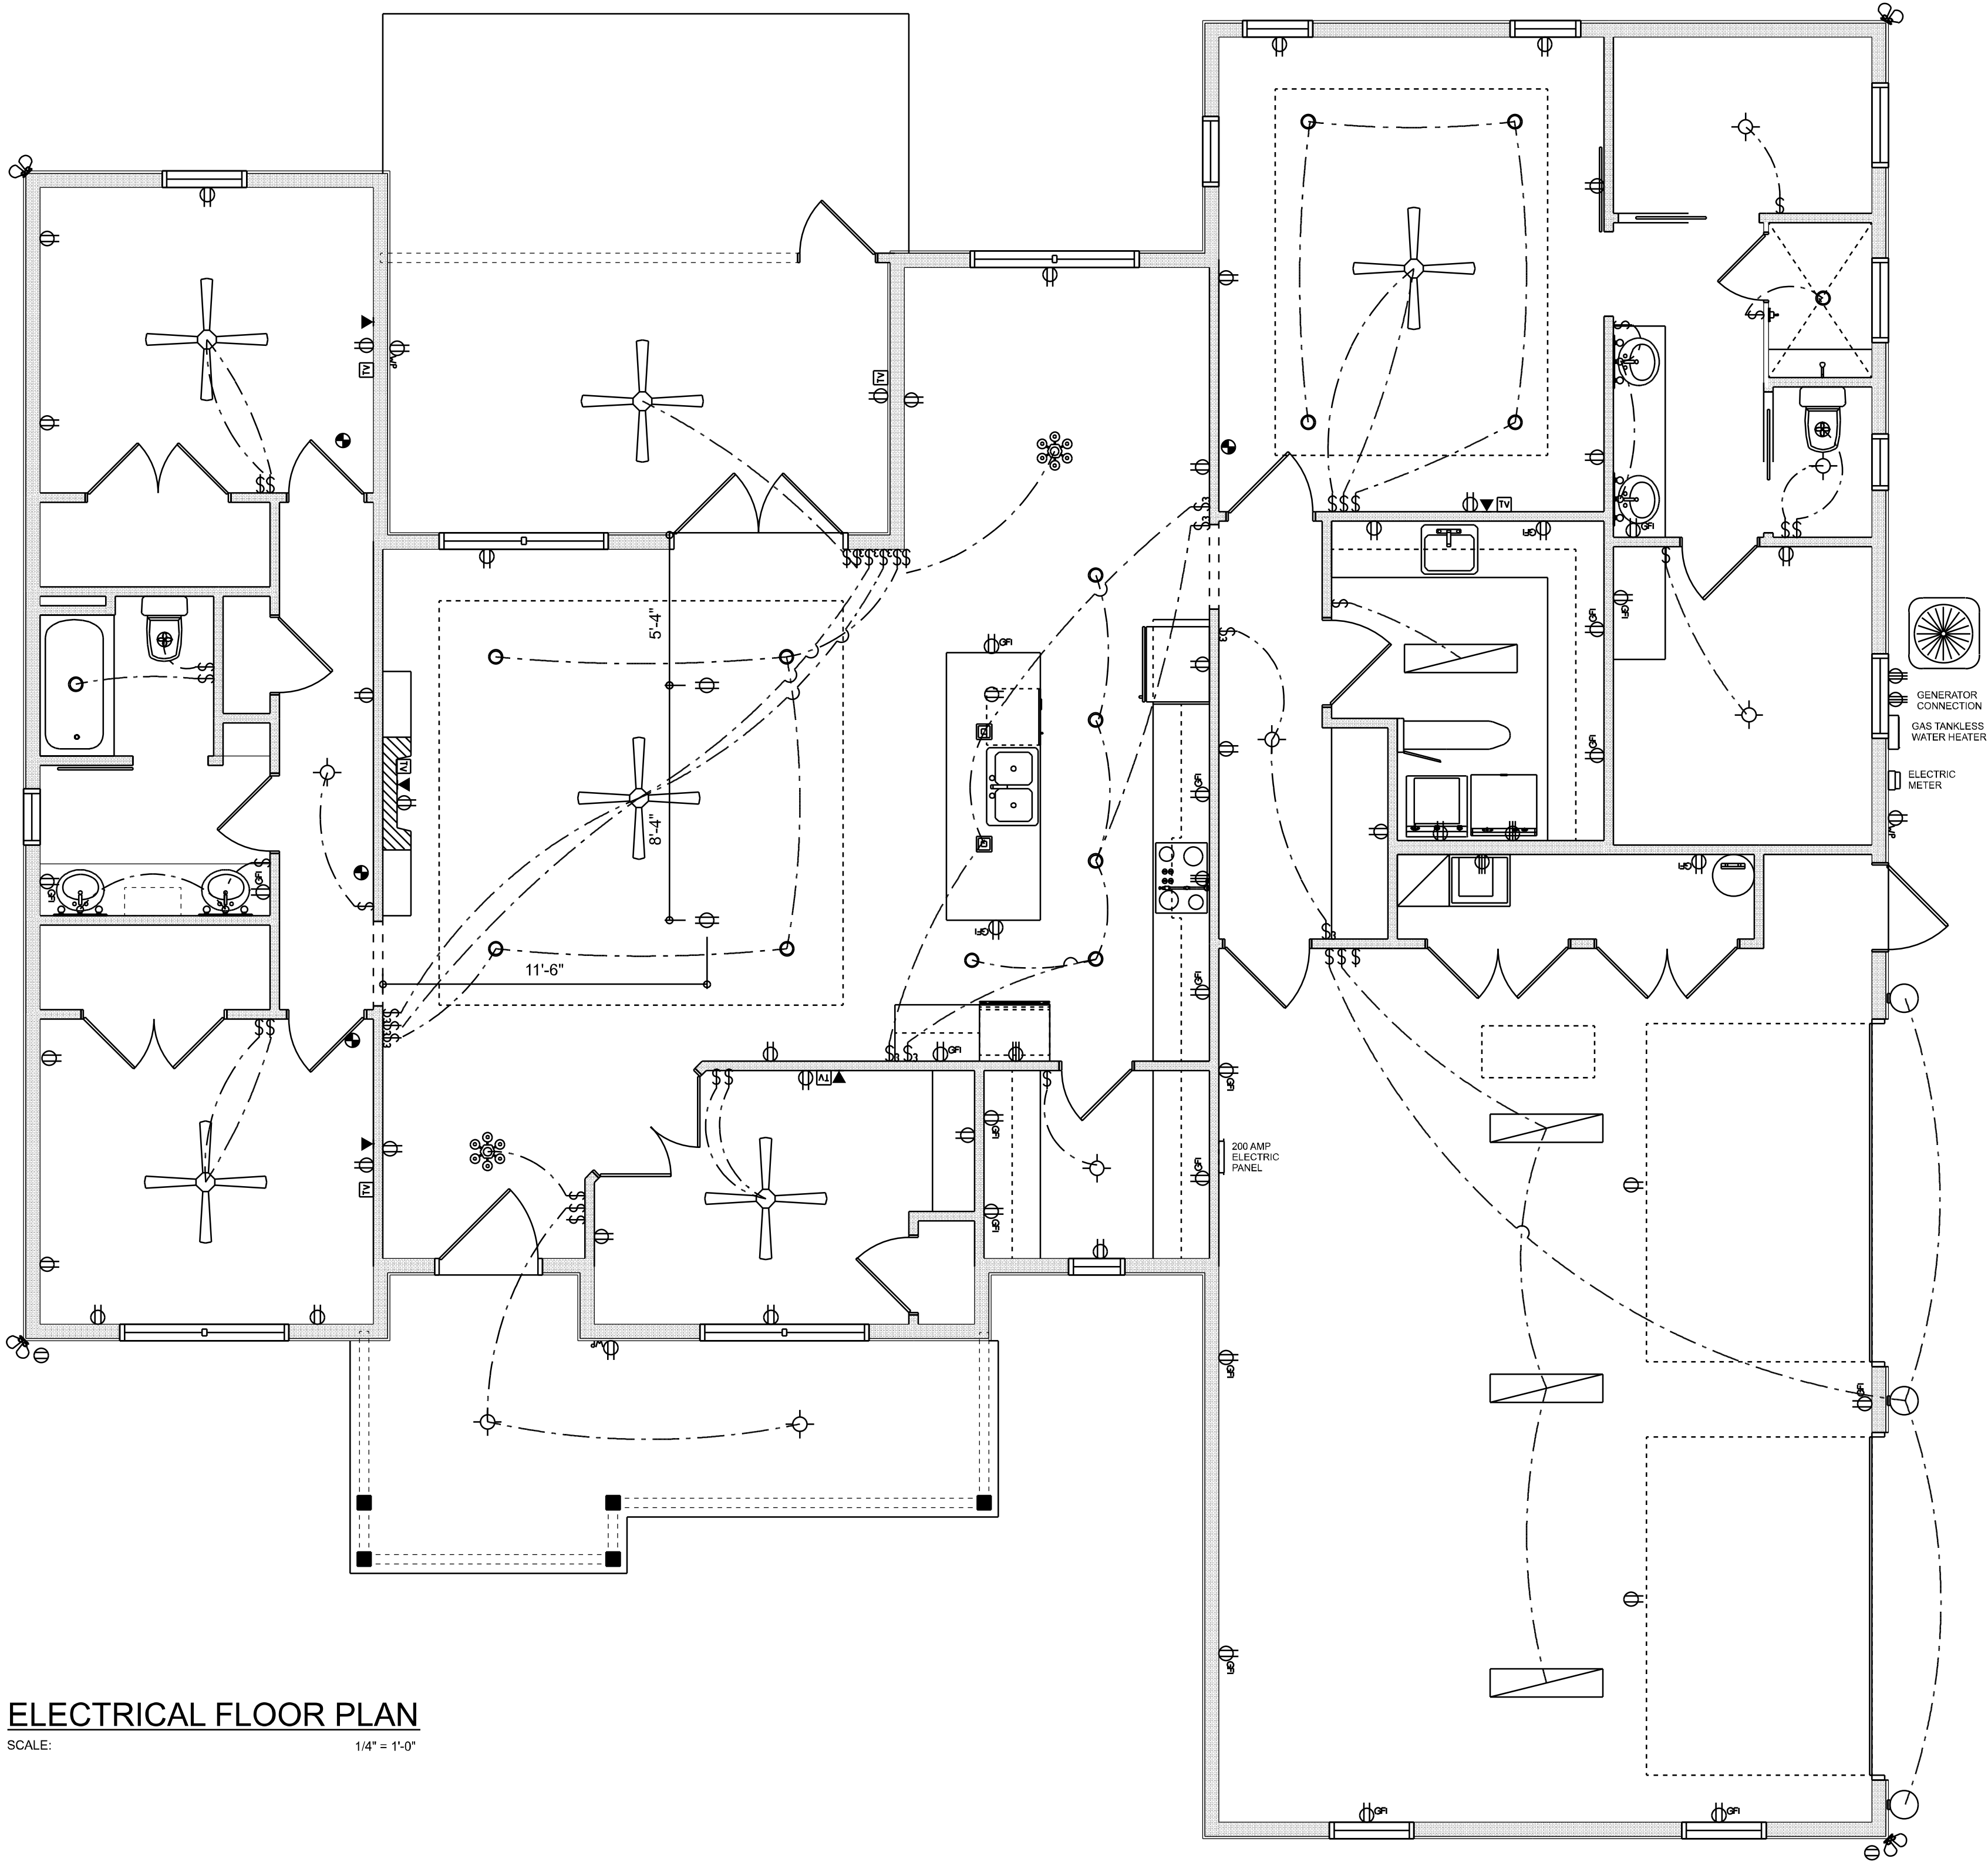


ELECTRICAL FLOOR PLAN
SCALE: 1/4" = 1'-0"

REVISIONS SCHEDULE	
APR. 14th, 2021	PROPOSAL
APR. 16th, 2021	REVISIONS

Scheffler Residence

LAKE CITY, FLORIDA

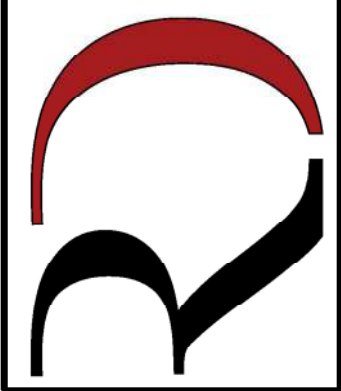**RIDGEPOINT
DESIGN**

566 SW ARLINGTON BLVD. STE 101, LAKE CITY, FL 32025
P: 386-288-1188
E: RIDGEPOINTDESIGN@GMAIL.COM