
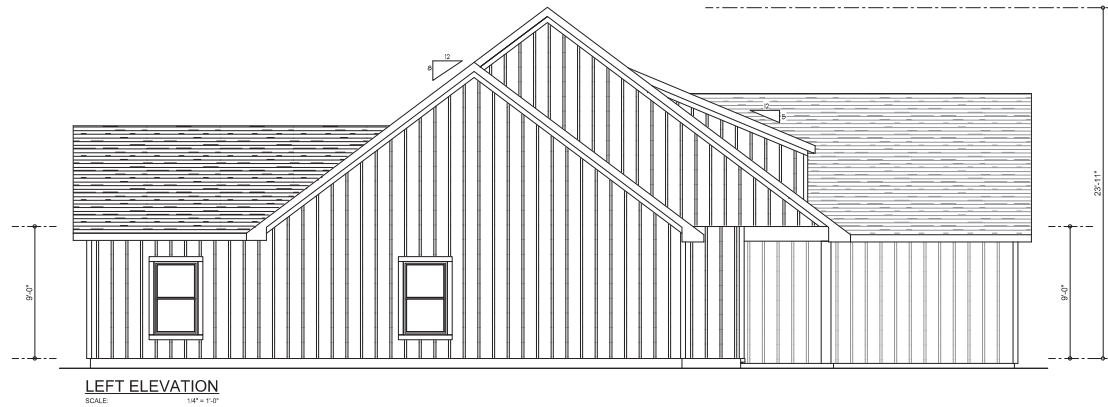


NOTE: ALL DRAWINGS NOT TO BE SCALED, WRITTEN DIMENSIONS TAKE PRECEDENCE OVER SCALED DIMENSIONS

<b>REVISIONS</b> August 25, 2020	
<b>SOFTPLAN</b>	
<b>FRONT &amp; REAR ELEVATIONS</b> SCALE: 1/8" = 1'-0" <b>TYPICAL WALL SECTION</b> SCALE: AS NOTED	<b>LOT 3, FOREST COUNTRY</b> PROJECT ADDRESS: FOREST COUNTRY S/D, LAKE CITY, FLORIDA
A HOME DESIGN FOR <b>WILKINSON &amp; ASSOCIATES, INC.</b> 426 SW COMMERCE OR RTE 150 LAKE CITY, FL 33509 (386) 758-8406 www.wilkinsoninc.com	
	
JOB NUMBER 20200815	
SHEET NUMBER <b>A.1</b>	

*W.C.M.*

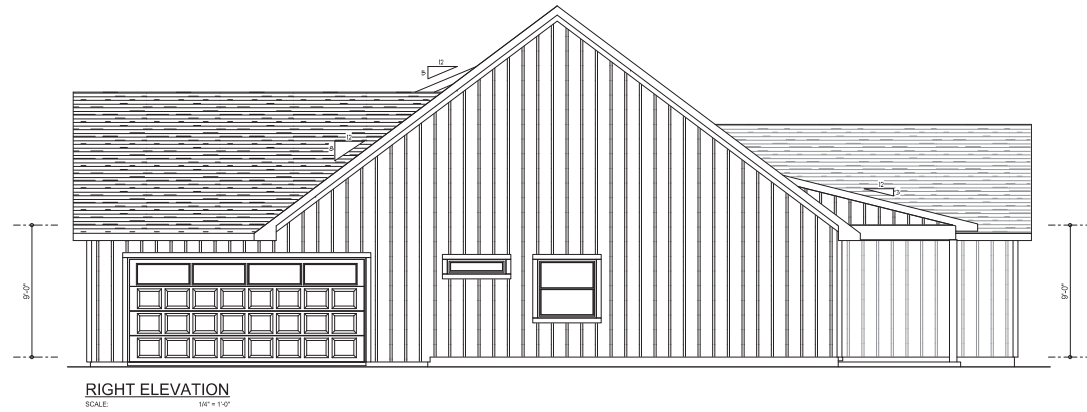

NOTE: ALL DRAWINGS NOT TO BE SCALED, WRITTEN DIMENSIONS TAKE PRECEDENCE OVER SCALED DIMENSIONS

<b>REVISIONS</b> August 25, 2020 _____ _____ _____
<b>SOFTPLAN</b>
<b>LEFT &amp; RIGHT ELEVATIONS</b> SCALE: 1/8" = 1'-0"
A HOME DESIGN FOR <b>LOT 3, FOREST COUNTRY</b> PROJECT ADDRESS: FOREST COUNTRY SQ. LAKE CITY, FLORIDA
© WM DESIGN & ASSOCIATES, INC. 428 SIX COMMERCE DR. STE 130 LAKE CITY, FL 33509 (386) 758-8406 info@wmdesign.net

JOB NUMBER 20200815
SHEET NUMBER <b>A.2</b>

*Wm C. M.*



SOFTPLAY

**ELECTRICAL PLAN**  
SCALE: 1/8" = 1'-0"

A HOME DESIGN FOR:  
**LOT 3, FOREST COUNTRY**  
PROJECT ADDRESS: FOREST COUNTRY S/D, LAKE CITY, FLORIDA


© WM DESIGN &  
ASSOCIATES, INC.  
426 SW COMMERCE DR. STE 130  
LAKE CITY, FL 32025  
(386) 758-8406  
will@willmyers.net



JOB NUMBER  
20200815

SHEET NUMBER

## A.4

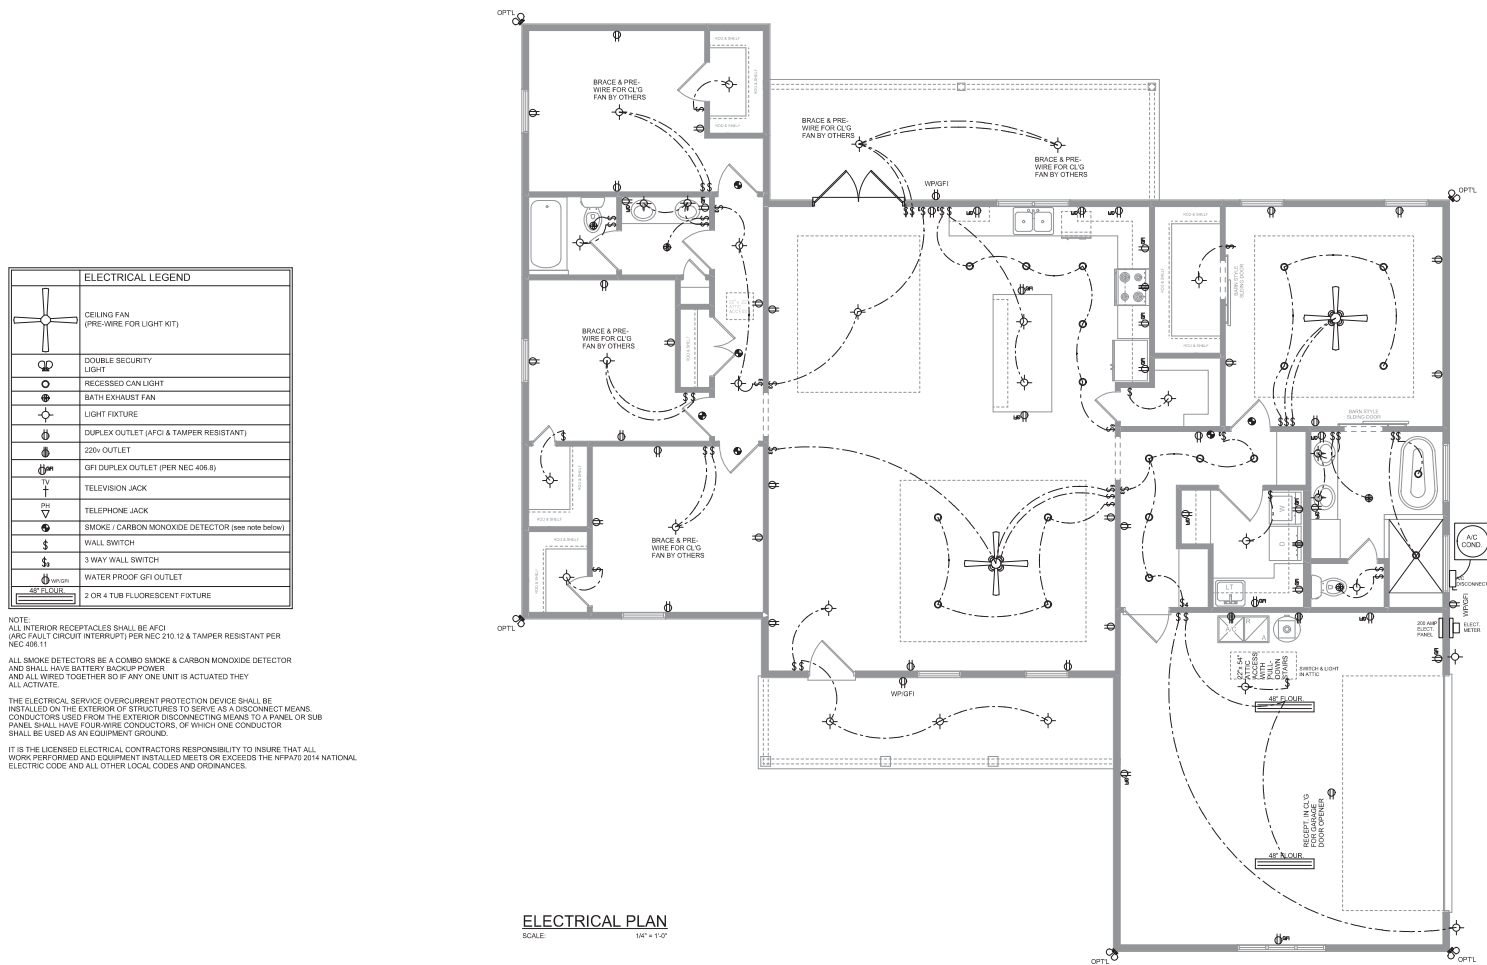

NOTE: ALL DRAWINGS NOT TO BE SCALED, WRITTEN DIMENSIONS TAKE PRECEDENCE OVER SCALED DIMENSIONS

Wall C-Mg