



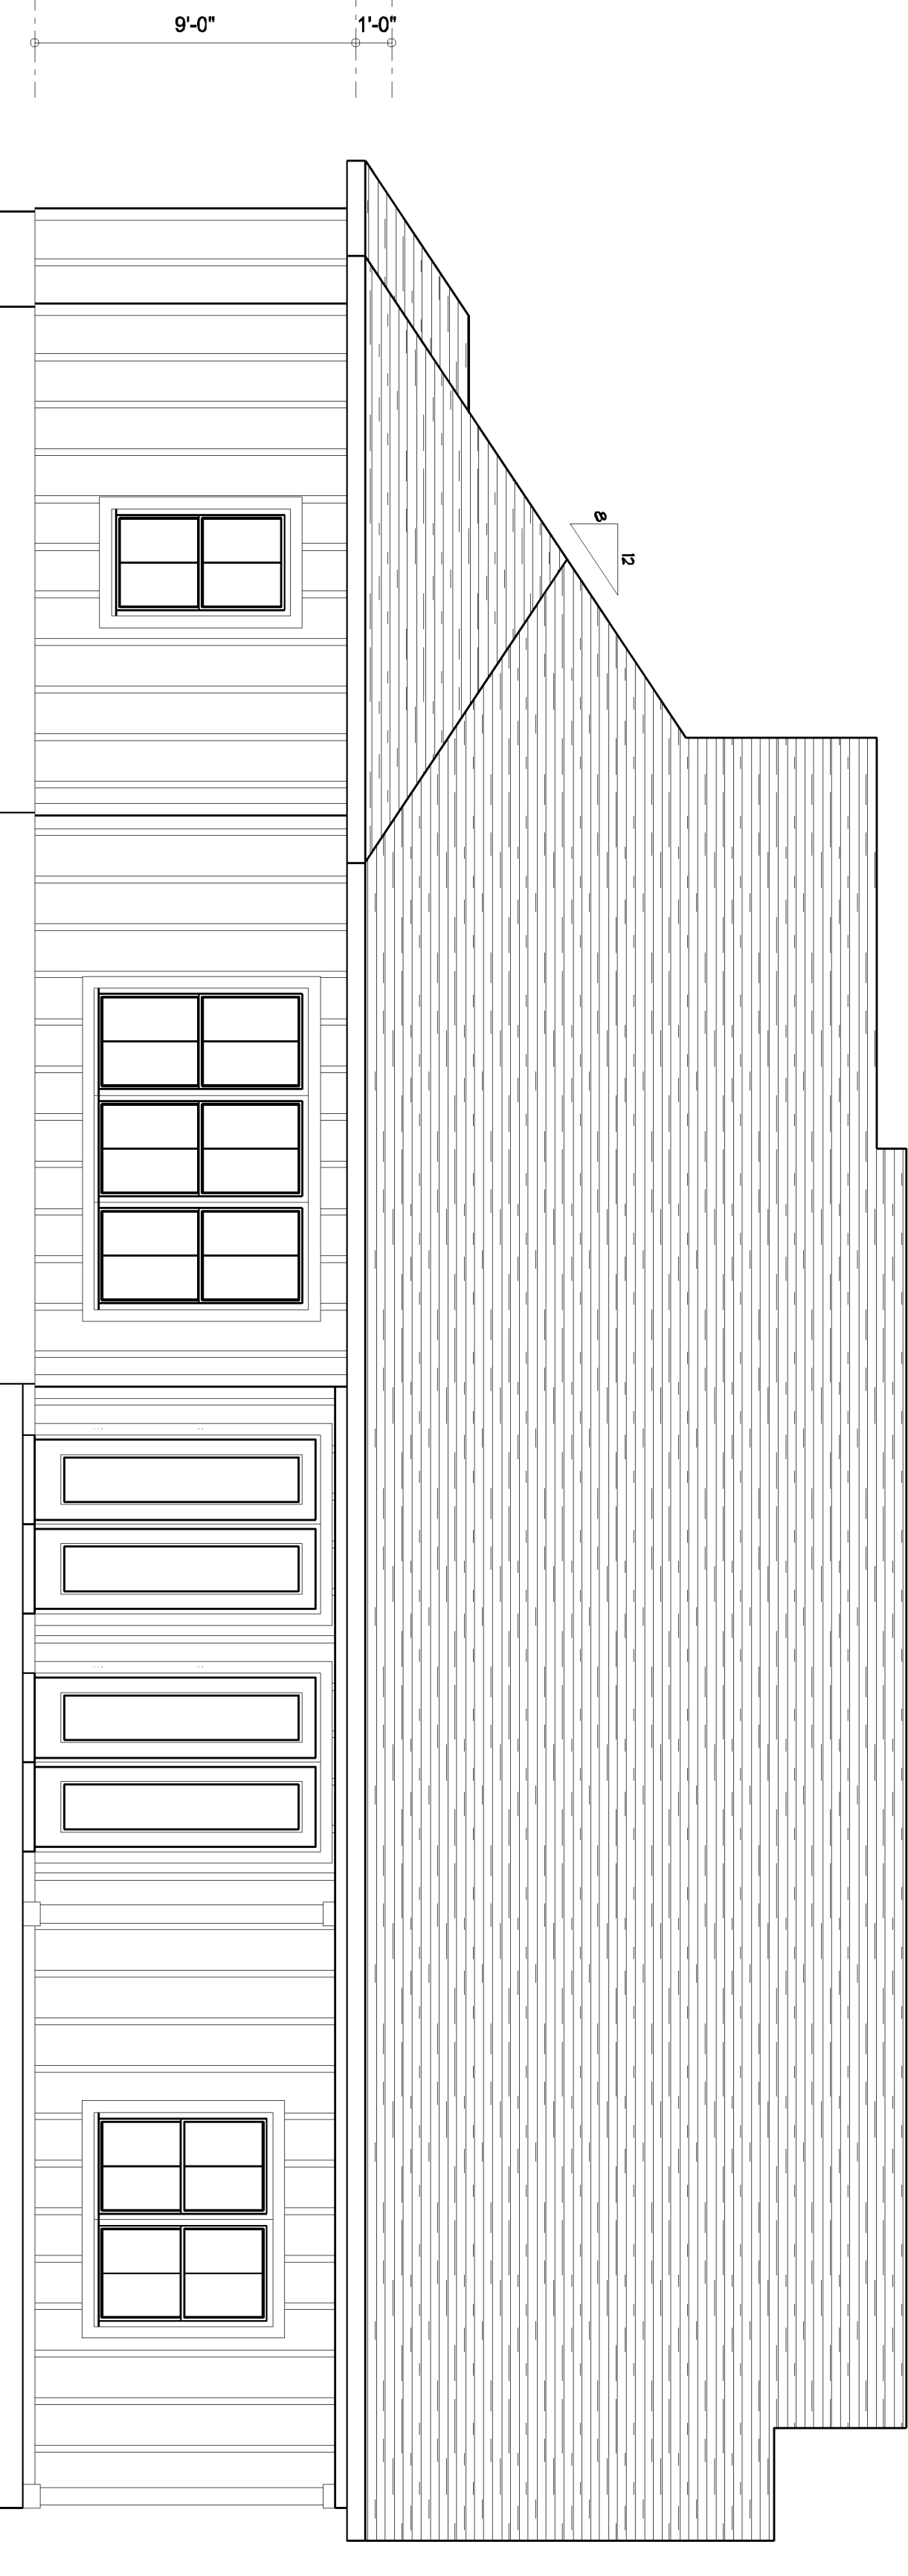

REAR ELEVATION
SCALE: 1/4" = 1'-0"

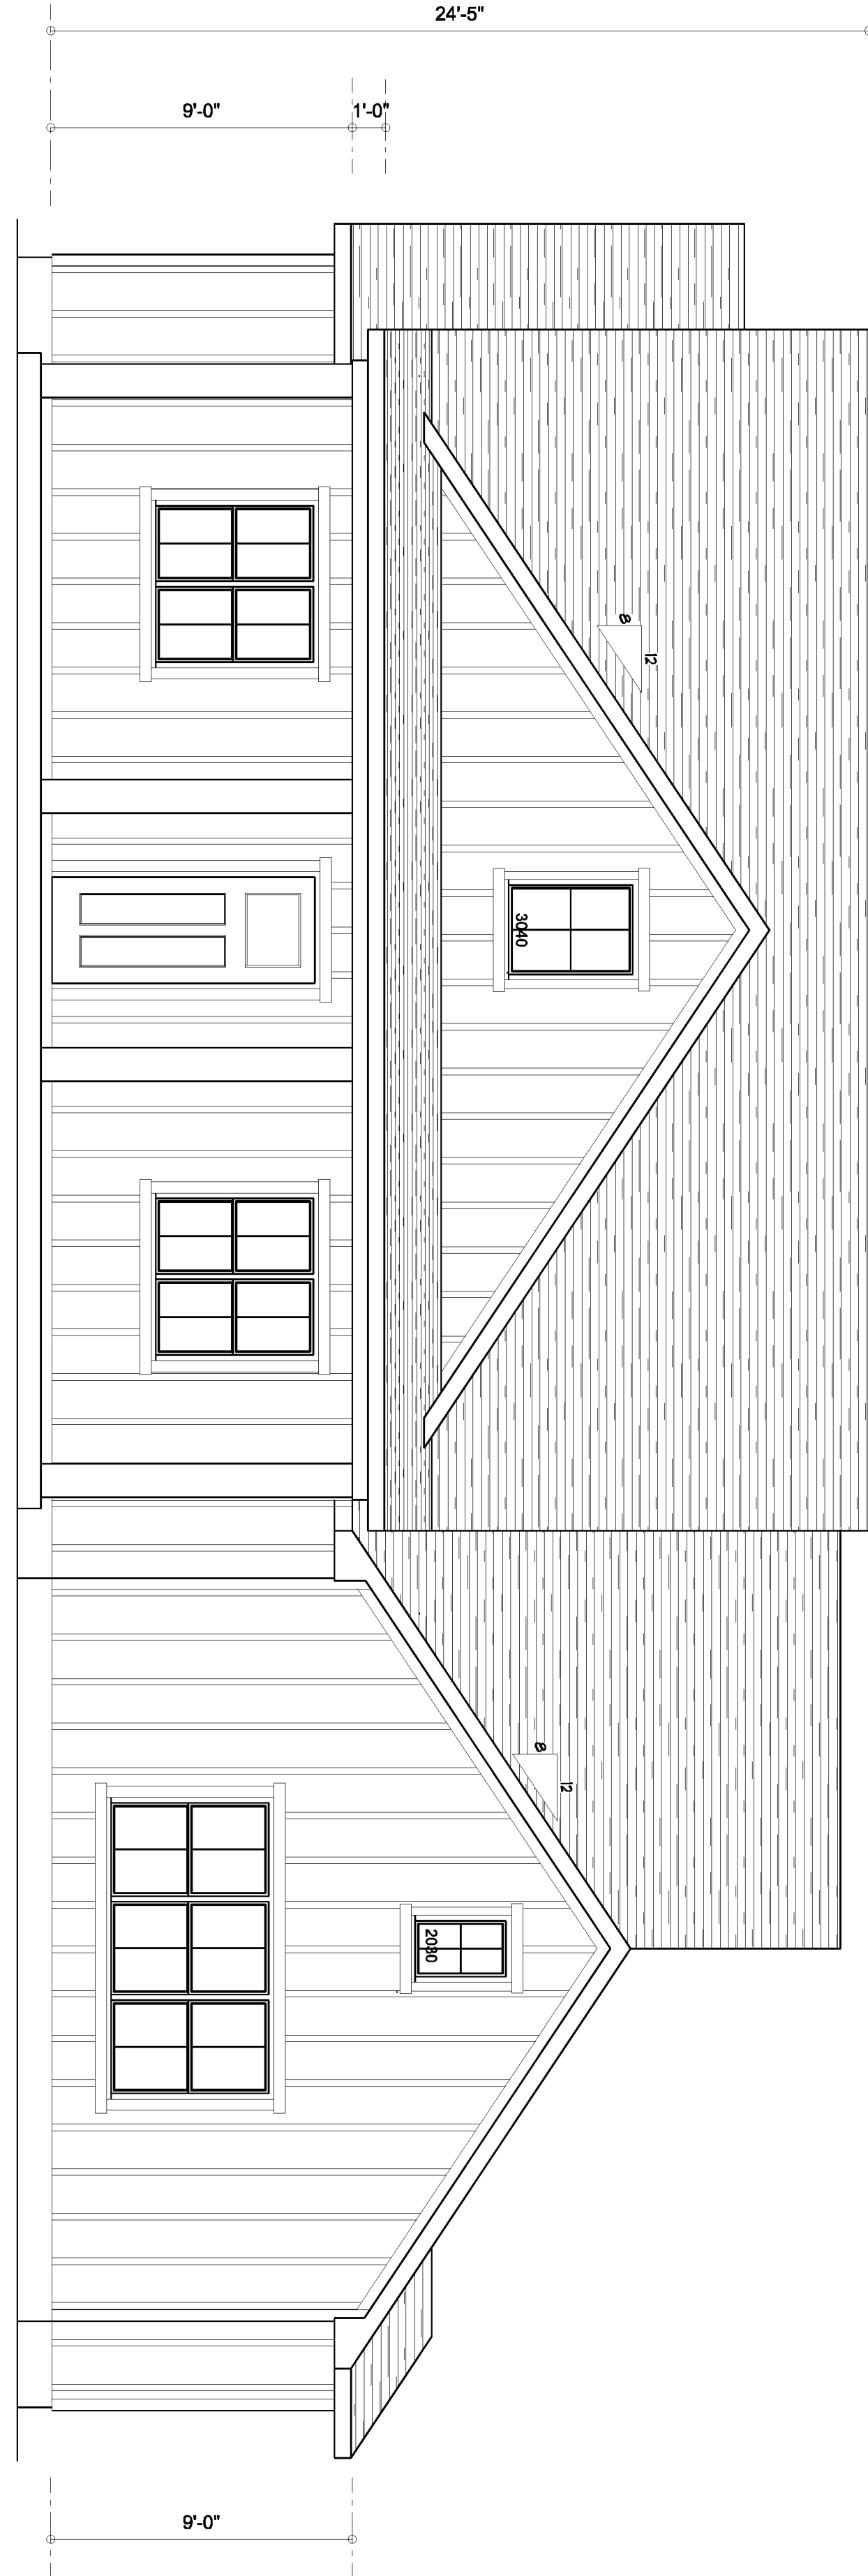

FRONT ELEVATION
SCALE: 1/4" = 1'-0"



R

RIDGEPOINT
DESIGN

566 SW ARLINGTON BLVD., STE 101, LAKE CITY, FL 32025
P: 386-288-1188
E: RIDGEPOINTDESIGN@GMAIL.COM

SHEET NUMBER
A.1
OF 4 SHEETS


MILLER RESIDENCE

The Cove at Rose Creek S/D, Columbia County, FL 32024

IC CONSTRUCTION


818 W Duval St, Lake City, FL 32055

REVISIONS SCHEDULE	
MAY 21st, 2020	PROPOSAL
JUNE 1st, 2020	REVISIONS

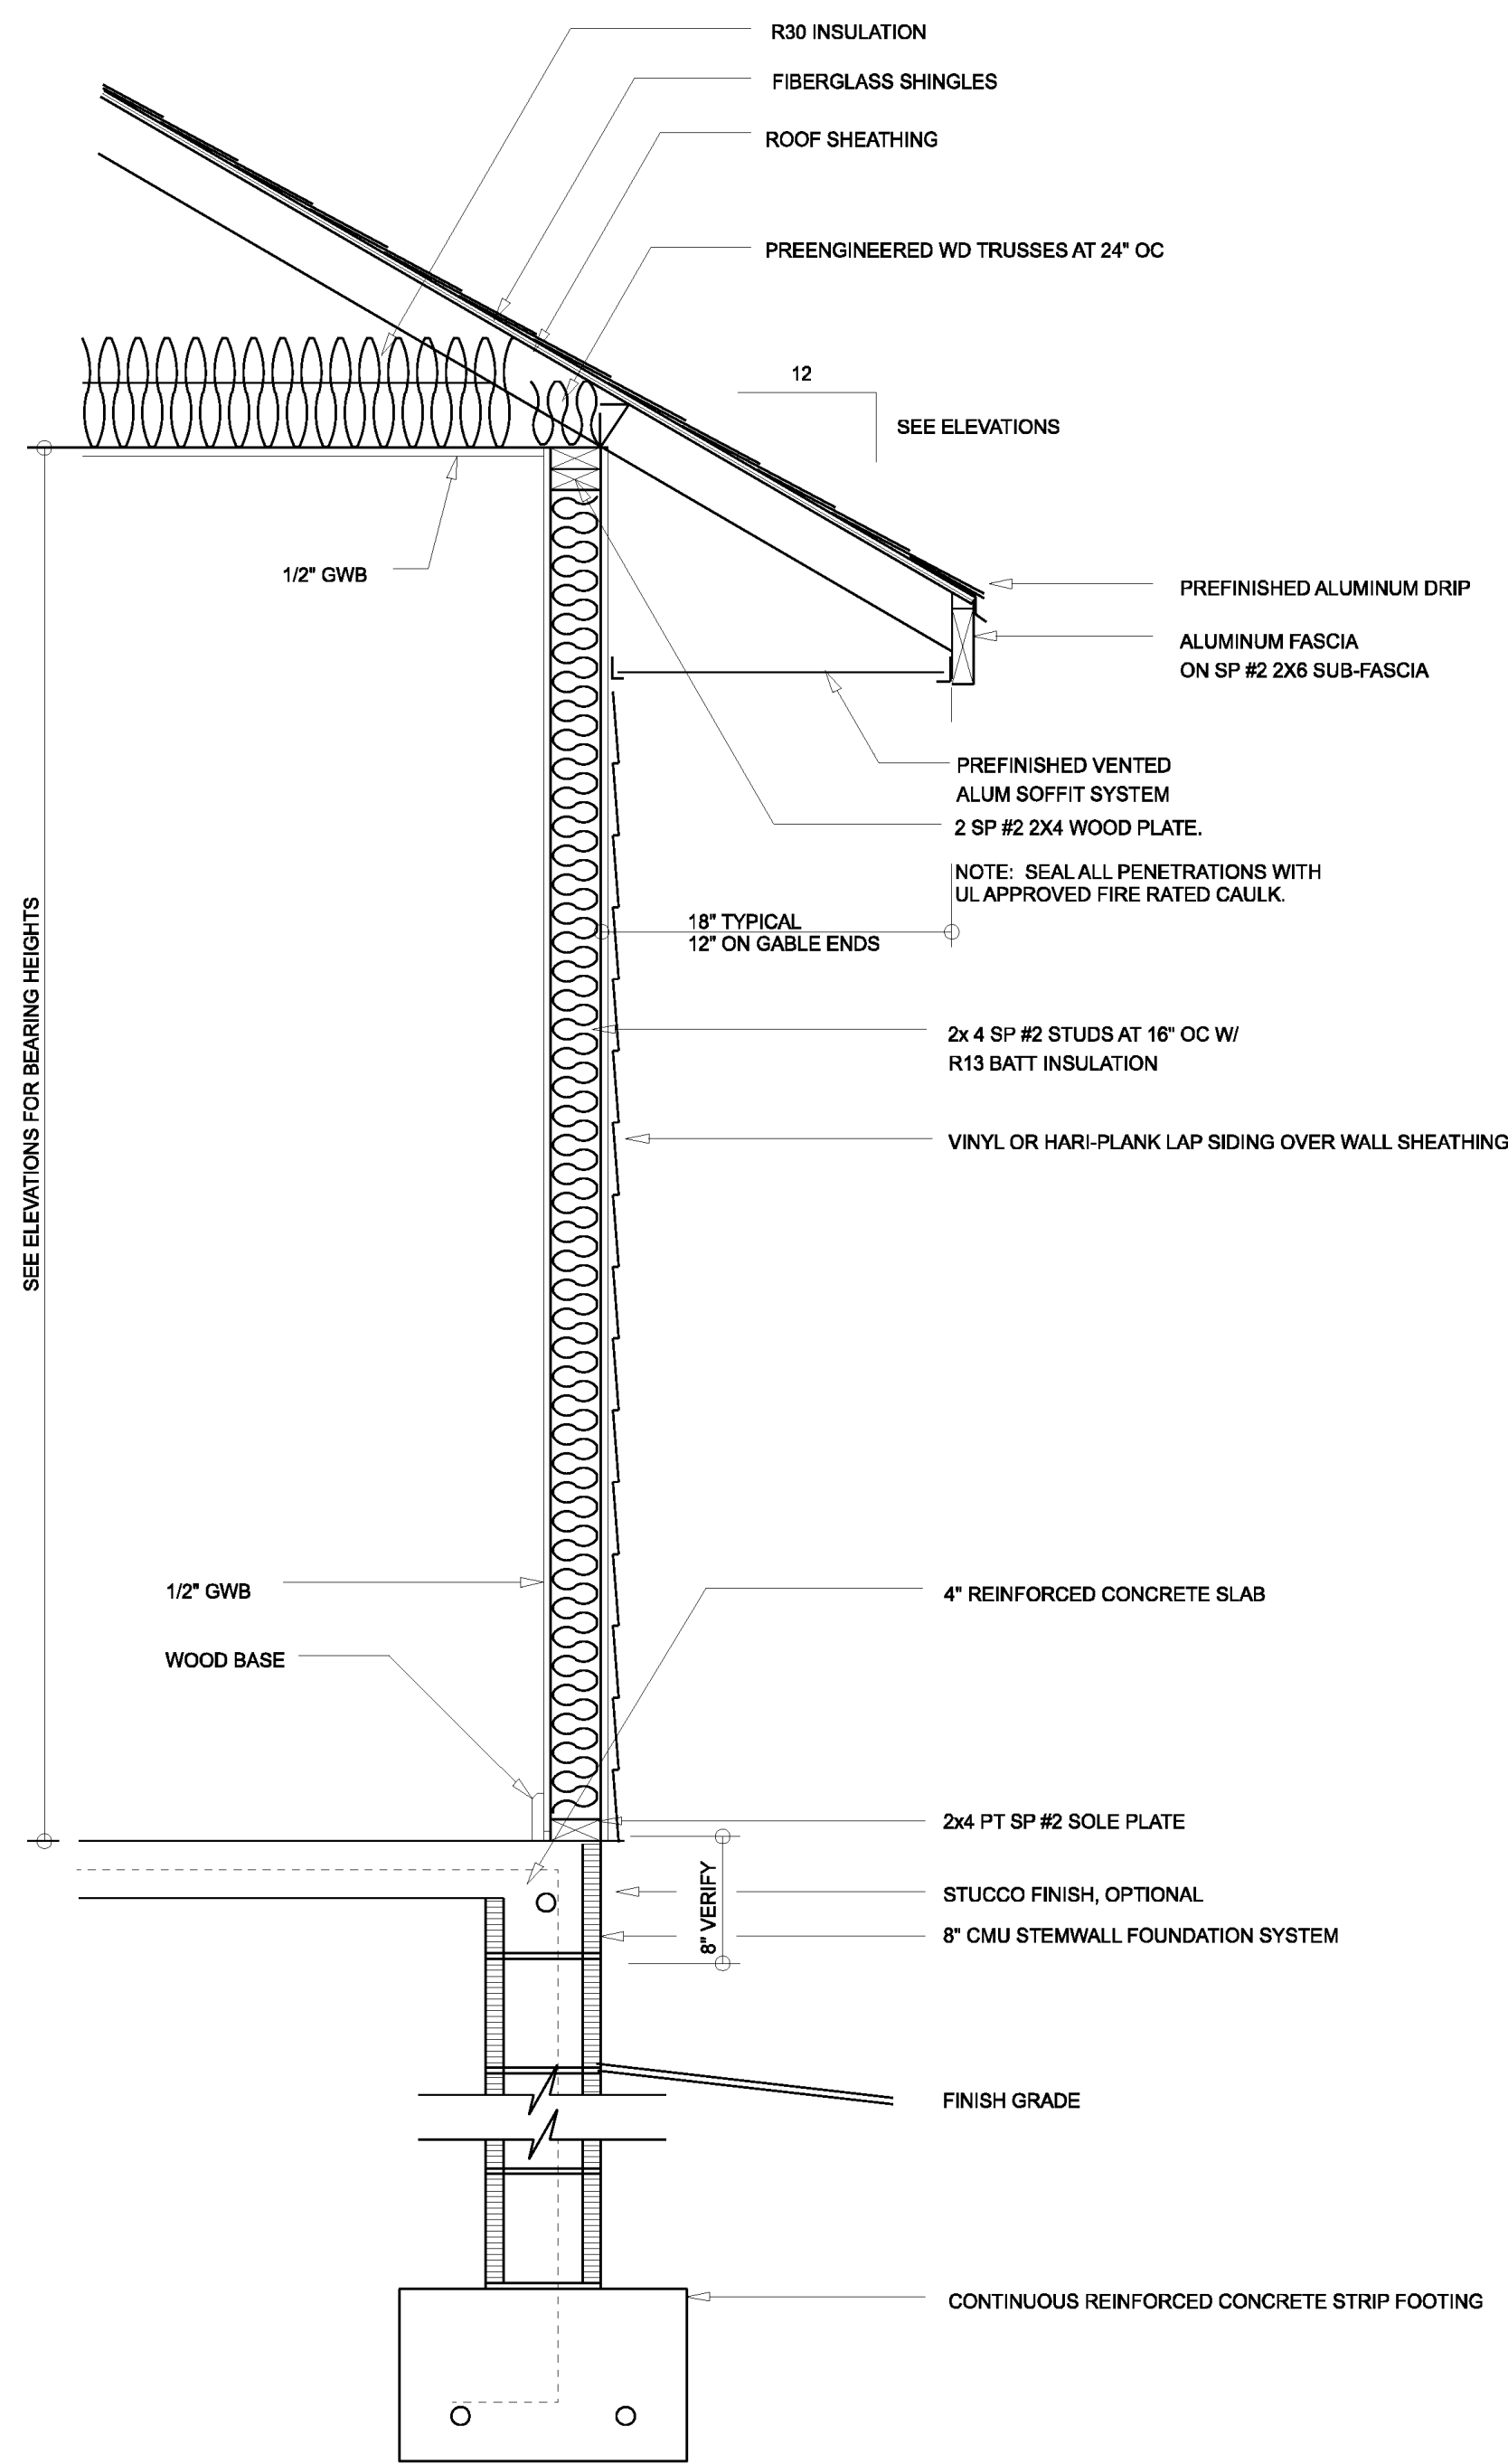


TYPICAL WALL SECTION

SCALE: 1" = 1'-0"

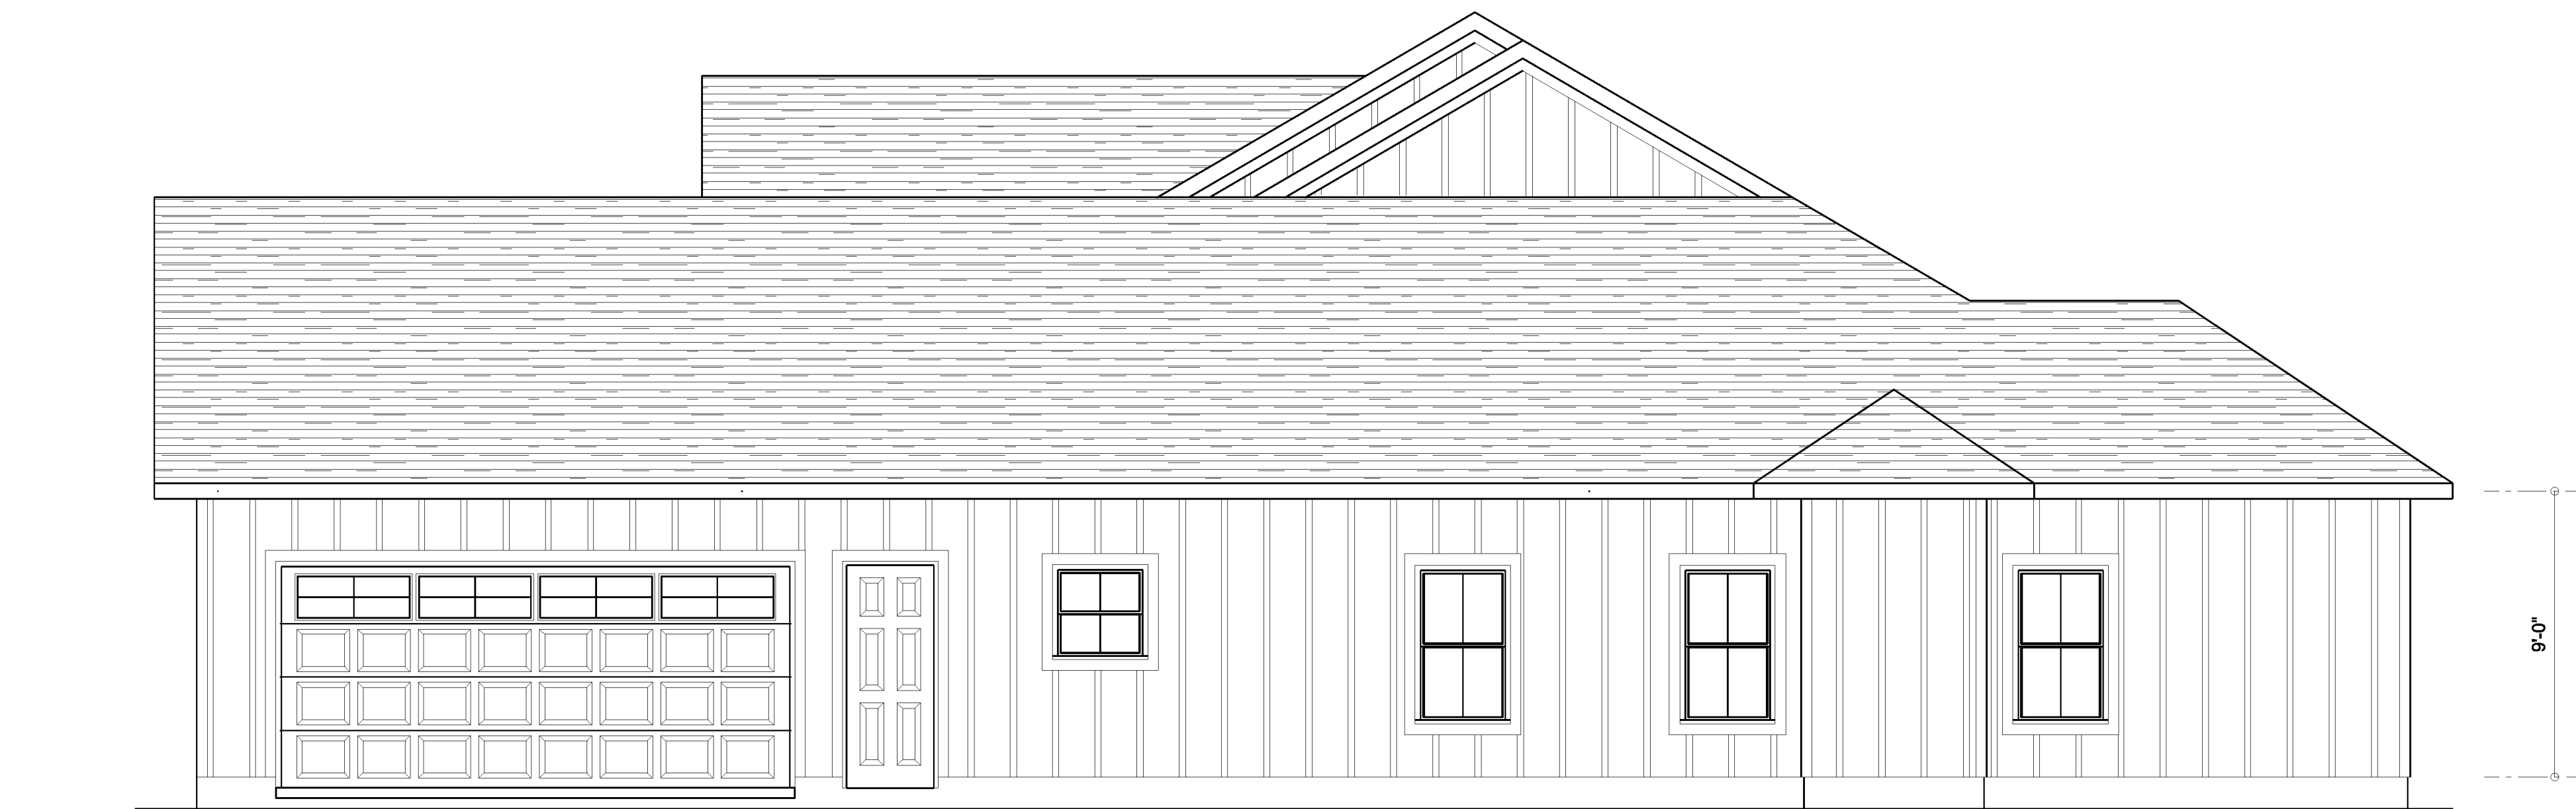

RIGHT ELEVATION

SCALE: 1/4" = 1'-0"

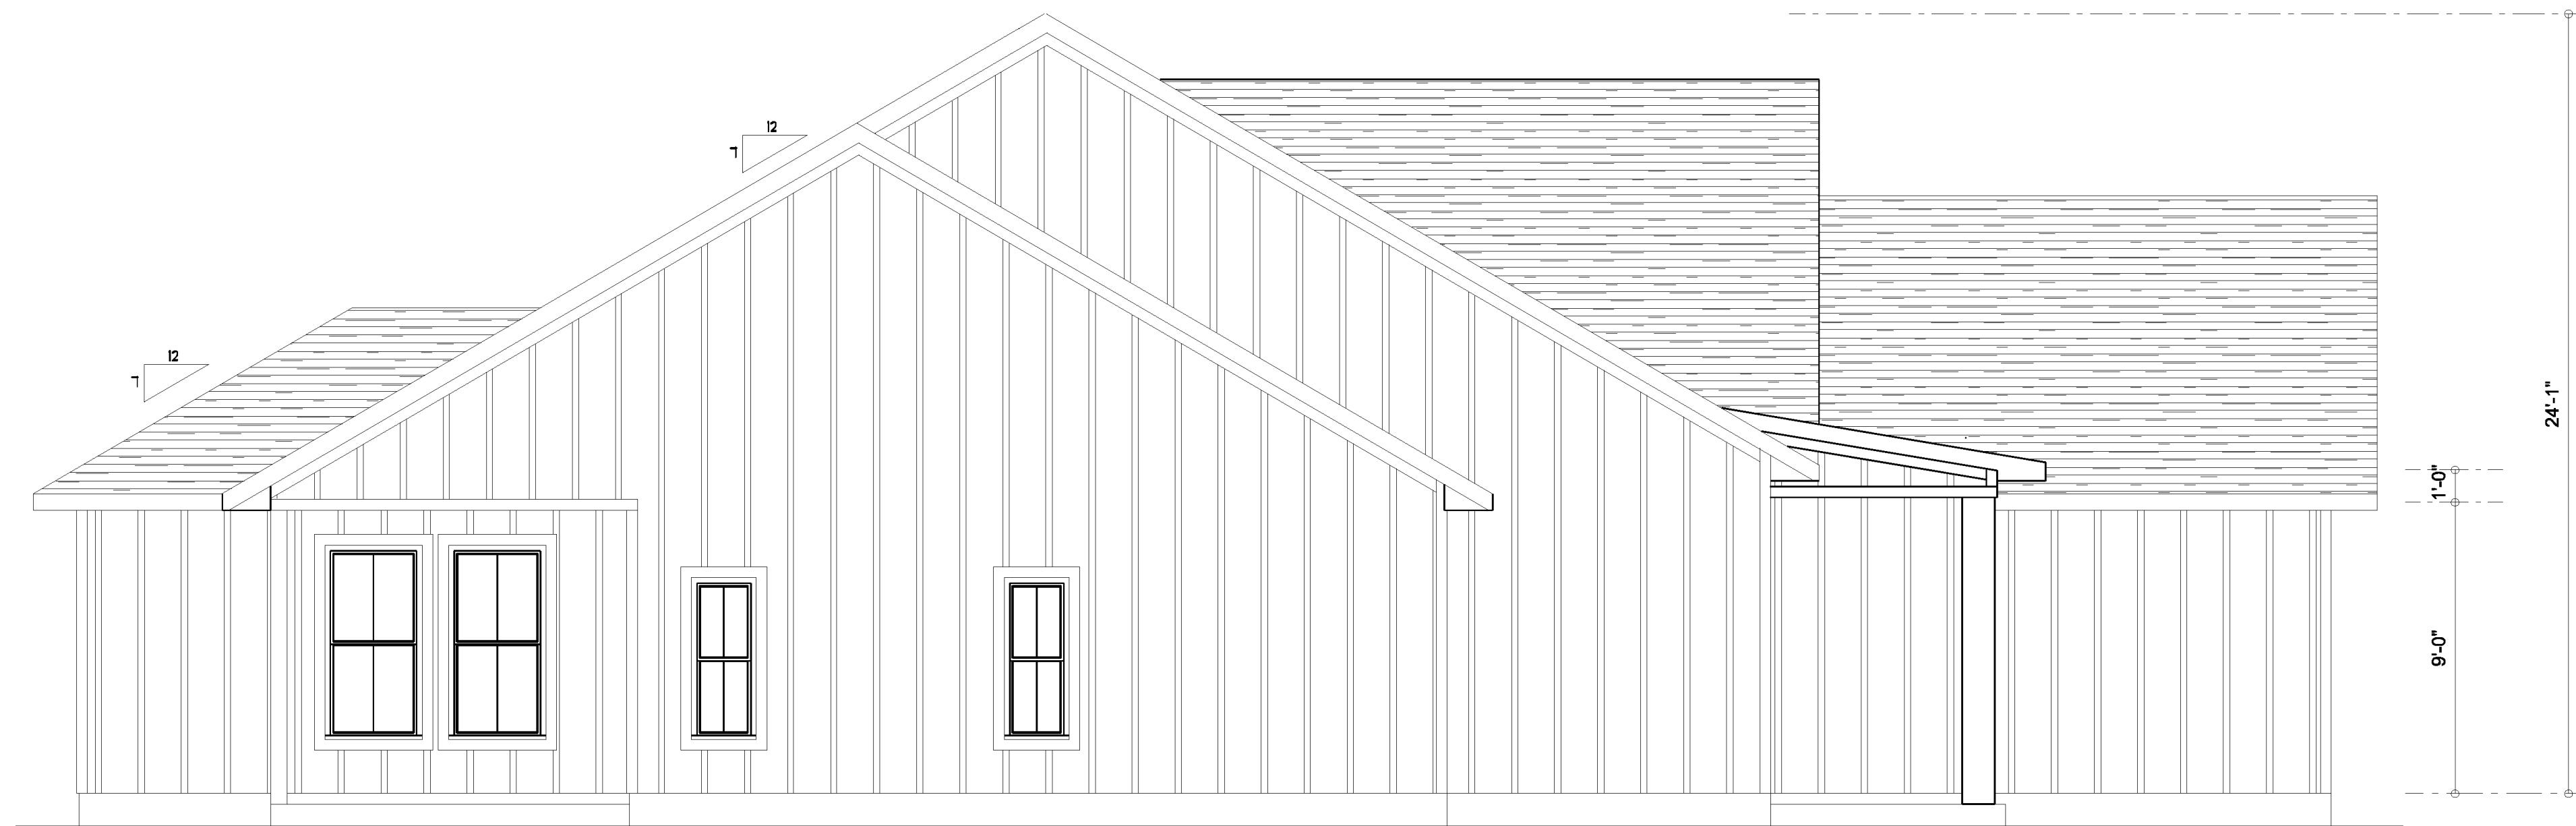


LEFT ELEVATION

SCALE: 1/4" = 1'-0"

REVISIONS SCHEDULE			
MAY 21st, 2020	PROPOSAL		
JUNE 1st, 2020	REVISIONS		

MILLER RESIDENCE
The Cove at Rose Creek S/D, Columbia County, FL 32024
IC CONSTRUCTION
818 W Duval St, Lake City, FL 32055

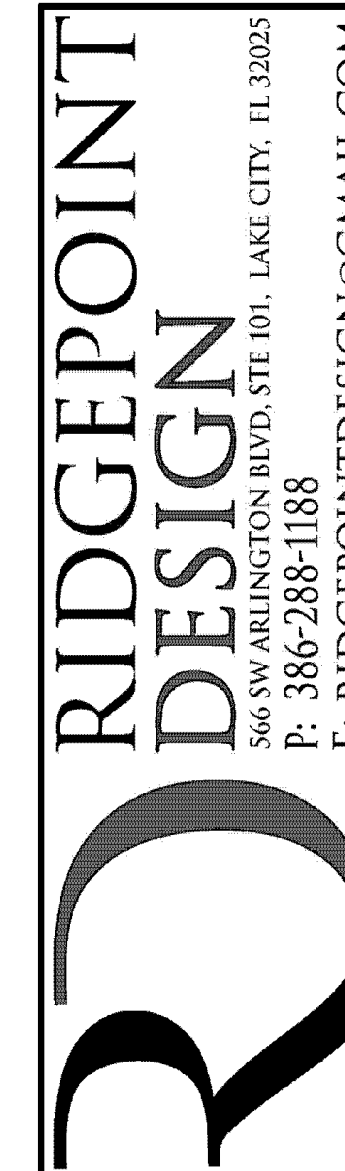

SHEET NUMBER
A.2
OF 4 SHEETS

LIVING	2,385	S.F.
ENTRY PORCH	266	S.F.
COVERED PORCH	345	S.F.
GARAGE	541	S.F.
TOTAL AREA	3,537	S.F.

Garage fire separations shall comply with the following:

1. The private garage shall be separated from the dwelling unit and its attic area by means of a minimum 1/2-inch (12.7 mm) gypsum board applied to the garage side. Garages beneath habitable rooms shall be separated from all habitable rooms above by not less than 5/8-inch Type X gypsum board or equivalent. Door openings between a private garage and the dwelling unit shall be equipped with either solid wood doors, or solid or honeycomb core steel doors not less than 13/8 inches (34.9 mm) thick, or doors in compliance with Section 715.3.3. Openings from a private garage directly into a room used for sleeping purposes shall not be permitted.

2. Ducts in a private garage and ducts penetrating the walls or ceilings separating the dwelling unit from the garage shall be constructed of a minimum 0.019-inch (0.48 mm) sheet steel and shall have no openings into the garage.

3. A separation is not required between a Group R-3 and U carport provided the carport is entirely open on two or more sides and there are not enclosed areas above.

4. When installing an attic access and/or pull-down stair unit in the garage, devise shall have a minimum 20 min. fire rating.



REVISIONS SCHEDULE	
MAY 21st, 2020	PROPOSAL
JUNE 1st, 2020	REVISIONS

MILLER RESIDENCE
The Cove at Rose Creek S/D, Columbia County, FL 32024

The Cove at Rose Creek S/D, Columbia County, FL 32024

IC CONSTRUCTION


 
818 W Duval St, Lake City, FL 32055

**RIDGEPOINT
DESIGN**
566 SW ARINGTON BLVD, STE 101, LAKE CITY, FL 32025
P: 386-288-1188
E: RIDGEPOINTDESIGN@GMAIL.COM

SHEET NUMBER

A.3

F 4 SHEETS

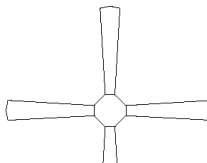ELECTRICAL LEGEND		
ELECTRICAL	COUNT	SYMBOL
CEILING FAN	7	
CAN LIGHT 6inch	19	
LED CEILING LIGHT 1x4	3	
PENDANT LIGHT	3	
EXTERIOR SCONCE	2	
MOTION SECURITY LIGHT	5	
ELECTRIC METER	1	
ELECTRIC PANEL	1	
CABLE TV OUTLET	6	
EXHAUST FAN	3	
FLOOR OULET DUPLEX	2	
OUTLET	39	
OUTLET 220v	7	
OUTLET GFI	17	
OUTLET WP	3	
SMOKE DETECTOR	6	
STANDARD LIGHT	13	
SWITCH	34	
SWITCH 3 WAY	16	
VANITY BAR LIGHT - SMALL	5	

ELECTRICAL PLAN NOTES:

INSTALLATION SHALL BE PER 2017 NAT'L ELECTRIC CODE.

WIRE ALL APPLIANCES, HVAC UNITS AND OTHER EQUIPMENT PER MANUF. SPECIFICATIONS

CONSULT WITH THE OWNER FOR THE NUMBER OF SEPERATE TELEPHONE LINES TO BE INSTALLED

ALL SMOKE DETECTORS SHALL BE 120v W/ BATTERY BACKUP OF THE PHOTOELECTRIC TYPE, AND SHALL BE INTERLOCKED TOGETHER. INSTALL INSIDE AND NEAR ALL BEDROOMS

TELEPHONE, TELEVISION AND OTHER LOW VOLTAGE DEVICES OR OUTLETS SHALL BE AS PER THE OWNER'S DIRECTIONS, & IN ACCORDANCE W/ APPLICABLE SECTIONS OF NEC-LATEST EDITION.

ALL RECEPTALS, NOT OTHERWISE NOTED, SHALL BE ARC FAULT INTERRUPTER TYPE, EXCEPT DEDICATED OUTLETS

ALL RECEPTALS IN WET AREAS SHALL BE GROUND FAULT INTERRUPTER TYPE (GFI)

ALL EXTERIOR RECEPTALS SHALL BE WEATHERPROOF GROUD FAULT INTERRUPTER TYPE (WP/GFI)

NOTE:
ELECTRICAL CONTR SHALL PREPARE "AS-BUILT" SHOP DWGS INDICATING ALL ELECTRICAL WORK, INCLUDING ANY CHANGES TO THE ELEC. PLAN, ADDNS TO THE ELEC. PLAN, RISER DIAGRAM, AS-BUILT PANEL SCHEDULE W/ ALL CKTS IDENTIFIED W/ CKT Nr. DESCRIPTION & BRKR, SERVICE ENT. & ALL UNDERGROUND WIRE LOCATIONS/ROUTING / DEPTH. RISER DIA. SHALL INCLUDE WIRE SIZES/TYPE & EQUIPMENT TYPE W/ RATINGS & LOADS.
CONTRACTOR SHALL PROVIDE 1 COPY OF AS-BUILT DWGS TO OWNER & 1 COPY TO THE PERMIT ISSUING AUTHORITY



REVISIONS SCHEDULE		
MAY 21st, 2020	PROPOSAL	
JUNE 1st, 2020	REVISIONS	

MILLER RESIDENCE
The Cove at Rose Creek S/D, Columbia County, FL 32024

IC CONSTRUCTION
818 W Duval St, Lake City, FL 32055

RIDGEPOINT
DESIGN

566 SW ARLINGTON BLVD, STE. 101, LAKE CITY, FL 32025
P: 386-288-1188
E: RIDGEPOINTDESIGN@GMAIL.COM