


FRONT ELEVATION
SCALE: 1/4" = 1'-0"

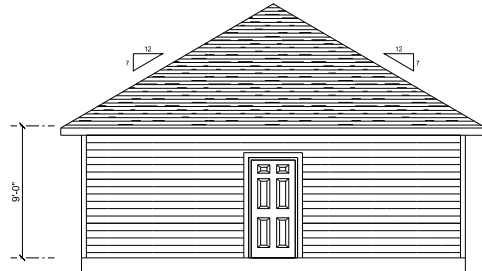

REAR ELEVATION
SCALE: 1/4" = 1'-0"



LEFT ELEVATION
SCALE: 1/4" = 1'-0"



RIGHT ELEVATION
SCALE: 1/4" = 1'-0"

ELECTRICAL PLAN NOTES:

INSTALLATION SHALL BE PER LATEST NATEL ELECTRIC CODE.
WIRE ALL APPLIANCES, HVAC UNITS AND OTHER EQUIPMENT
PER MANUF. SPECIFICATIONS

CONSULT WITH THE OWNER FOR THE NUMBER OF SEPERATE
TELEPHONE LINES TO BE INSTALLED

ALL SMOKE DETECTORS SHALL BE 120V W/ BATTERY
BACKUP OF THE PHOTOELECTRIC TYPE AND SHALL
BE INTERLOCKED TOGETHER. INSTALL INSIDE AND NEAR
ALL BEDROOMS


TELEPHONE, TELEVISION AND OTHER LOW VOLTAGE
DEVICES OR OUTLETS SHALL BE AS PER THE OWNERS
DIRECTIONS, & IN ACCORDANCE W/ APPLICABLE
SECTIONS OF NECA/NEC-1 EDITION

ALL RECEPTICALS, NOT OTHERWISE NOTED, SHALL BE ARC
FAULT INTERRUPTER TYPE, EXCEPT DEDICATED OUTLETS

ALL RECEPTICALS IN WET AREAS SHALL BE GROUND
FAULT INTERRUPTER TYPE (GFI)


ALL EXTERIOR RECEPTICALS SHALL BE WEATHERPROOF
GROUND FAULT INTERRUPTER TYPE (WP/GFI)

NOTE:
ELECTRICAL CONTR. SHALL PREPARE "AS-BUILT" SHOP
DRAWING INDICATING ALL ELECTRICAL WORK INCLUDING ANY
CHANGES TO THE ELEC. PLAN, ADDED TO THE ELEC. PLAN.
RISER DIAGRAM, SCHEDULE, WIRE SCHEDULE, W/ ALL COTS
IDENTIFIED W/ COT NO. DESCRIPTION & BRKR. SERVICE ENT.
& ALL UNDERGROUND WIRE LOCATIONS (ROUTING & DEPTH).
RISER DIA. SHALL INCLUDE WIRE SIZE, TYPE & EQUIPMENT
TYPE W/ BRINGS & LOADS.
CONTRACTOR SHALL PROVIDE: 1 COPY OF AS-BUILT DWGS
TO OWNER & 1 COPY TO THE PERMIT ISSUING AUTHORITY

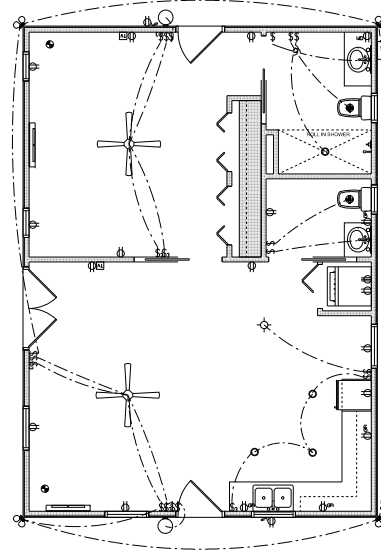

ELECTRICAL FLOOR PLAN
SCALE: 1/4" = 1'-0"

ELECTRICAL LEGEND		
ELECTRICAL	COUNT	SYMBOL
CEILING FAN	2	
CAN LIGHT 6inch	4	
EXTERIOR SCONCE	2	
MOTION SECURITY LIGHT	4	
CABLE TV OUTLET	2	
EXHAUST FAN	2	
OUTLET	13	
OUTLET 220v	1	
OUTLET GFI	5	
OUTLET WP	2	
SMOKE DETECTOR	2	
STANDARD LIGHT	1	
SWITCH	10	
SWITCH 3 WAY	10	
VANITY BAR LIGHT - SMALL	2	

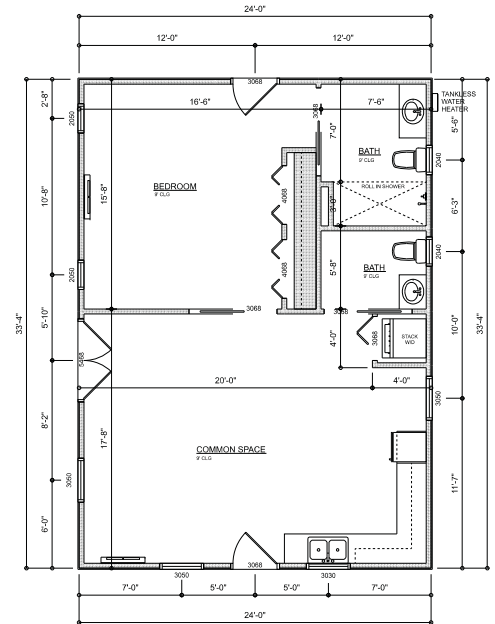

DIMENSIONED FLOOR PLAN
SCALE: 1/4" = 1'-0"

AREA SUMMARY		
LIVING	800	S.F.
TOTAL AREA	800	S.F.

REVISIONS SCHEDULE	
Feb 08, 2021	Proposal Drawing

SPARKS
CONSTRUCTION
Sue Sparks, P.E.
Suite 100, Lake City, FL 32025
License# CBC252260

MOTHER IN-LAW SUITE FOR:
SUSAN KATZKER
COLUMBIA COUNTY, FLORIDA

RIDGEPOINT
DESIGN
3605 ARABIAN DR. STE. 101, LAKE CITY, FL 32025
P: 386-788-1188
E: RIDGEPOINTDESIGN@GMAIL.COM

SHEET NUMBER
A.1
OF 4 SHEETS