



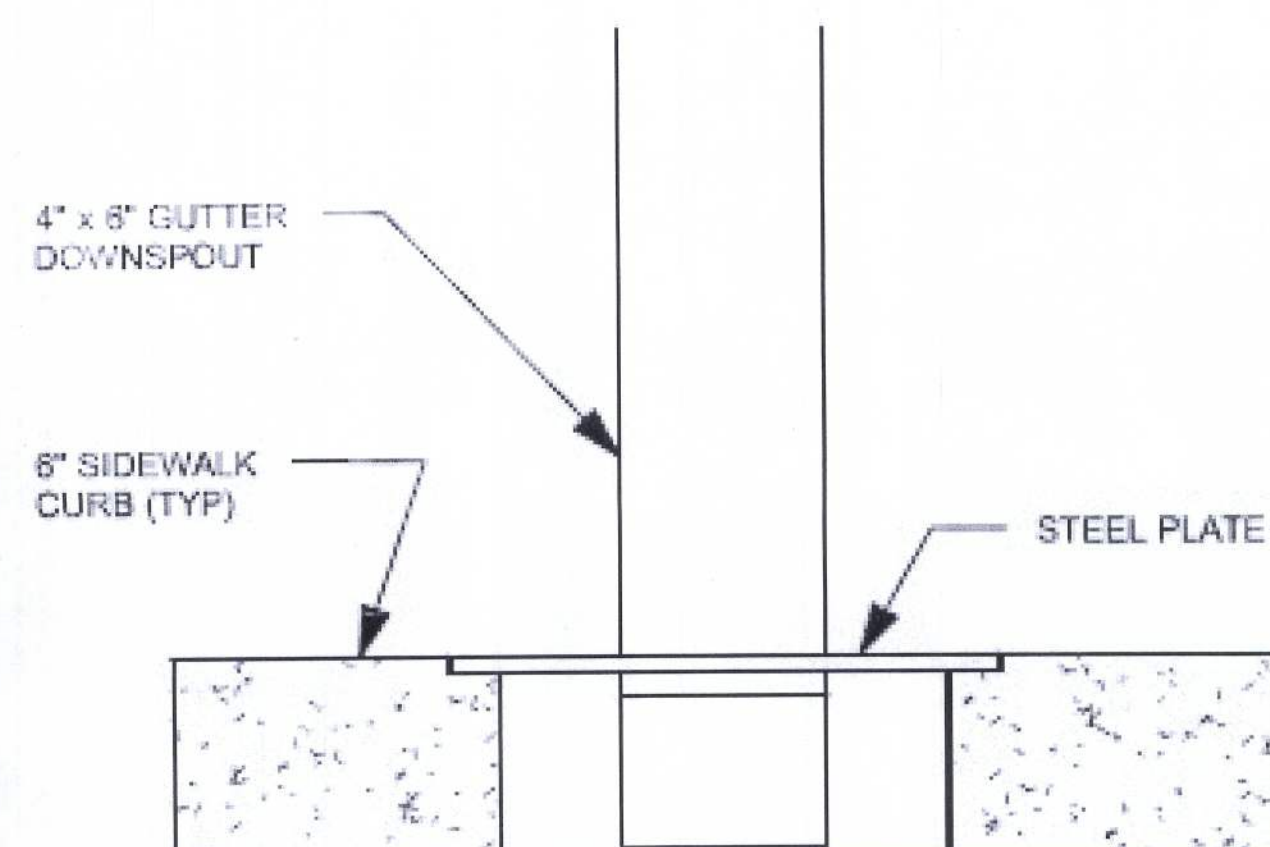

GUTTER DOWNSPOUT DETAIL AT
SIDEWALK
N.T.S.

CONTRACTOR IS RESPONSIBLE FOR ALL PUBLIC UTILITY CONNECTIONS (ELECTRIC, WATER, GAS, SEPTIC, SEWER) AS WELL AS PROVIDING ALL INFRASTRUCTURES REQUIRED BY UTILITY COMPANY


STRIPING LEGEND	
YELLOW CURBING AND BOLLARDS - PARKING LOT	SURFACES SHOULD BE CLEAN, DRY AND METAL SURFACES FREE OF HEAVY RUST 2 COATS SHERWIN WILLIAMS - KEM 4000 ACRYLIC ALKYD ENAMEL SAFETY YELLOW B55Y300
STRIPING - PARKING LOT	SURFACES SHOULD BE CLEAN, DRY. TOP COAT SHERWIN WILLIAMS - PRO MAR TRAFFIC MARKING PAINT YELLOW TM5495
HANDICAP STRIPING - PARKING LOT	SURFACES SHOULD BE CLEAN, DRY. TOP COAT SHERWIN WILLIAMS - PRO MAR TRAFFIC MARKING PAINT "H.C." BLUE

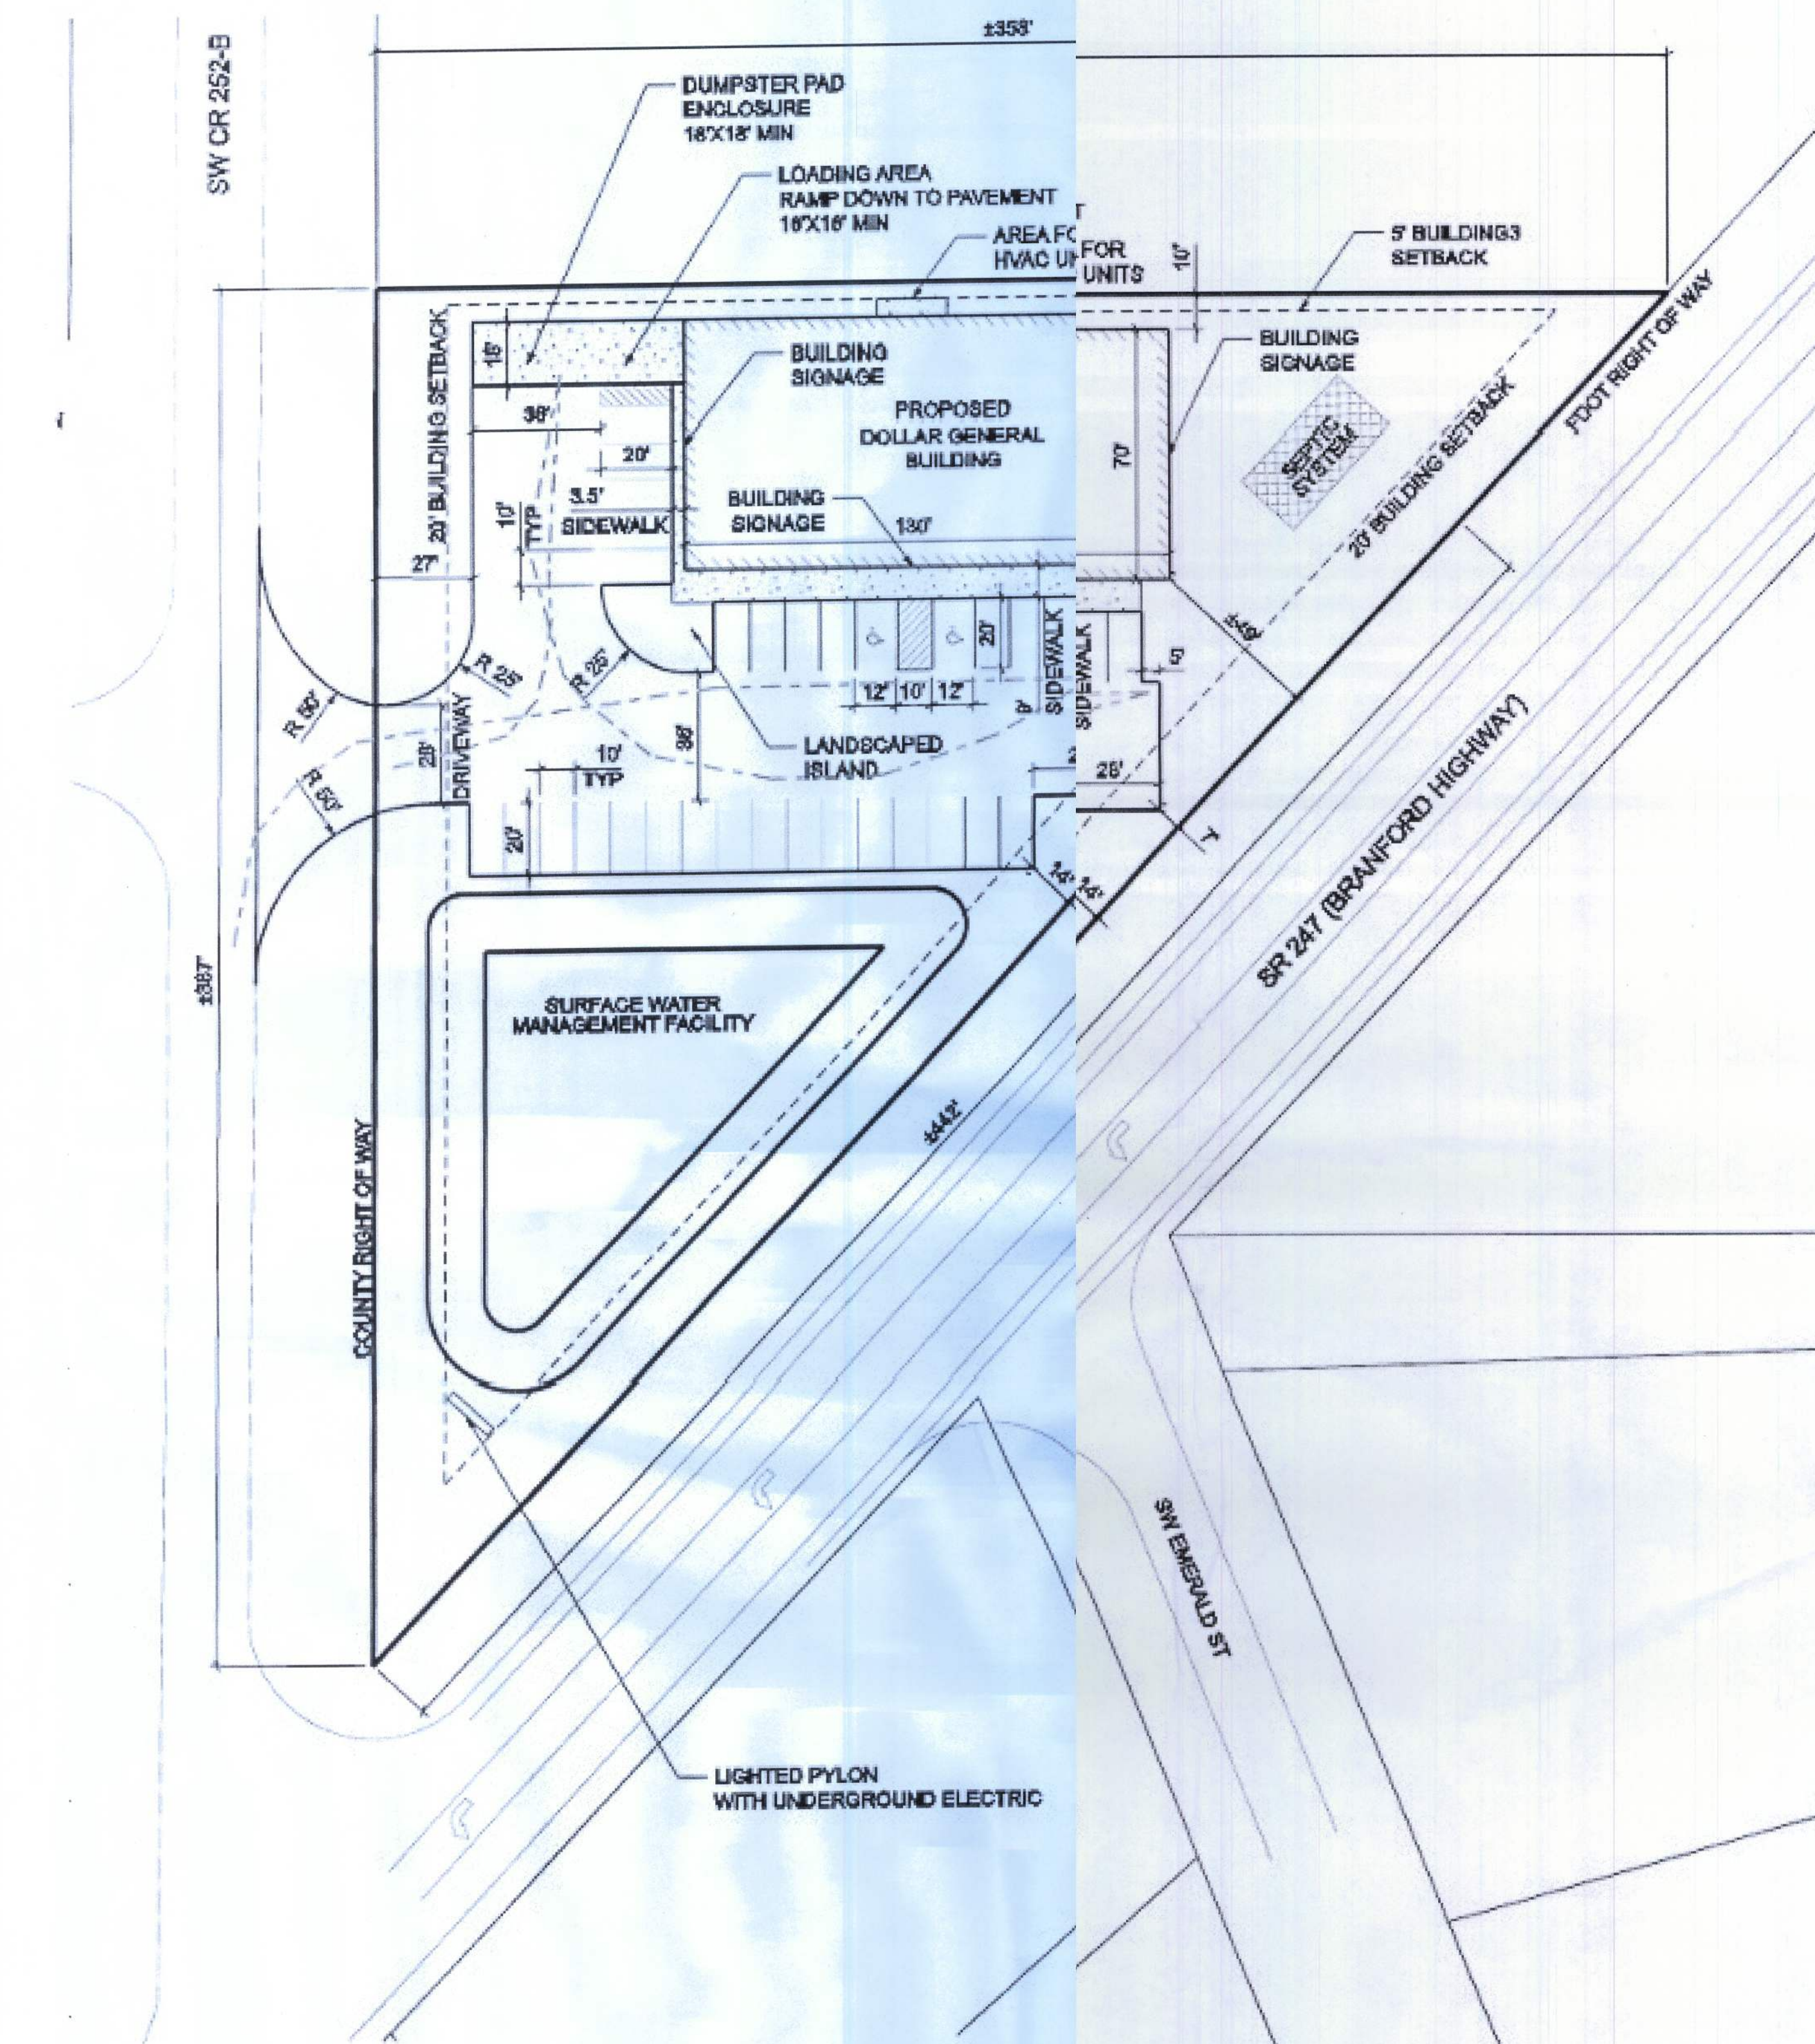

1 SITE PLAN OPTION "C"
1.C N.T.S.



NOTE: SITE PLAN IS FOR
INFORMATIONAL PURPOSES
ONLY. CONSULT SIGNED AND
SEALED CIVIL DOCUMENTS.

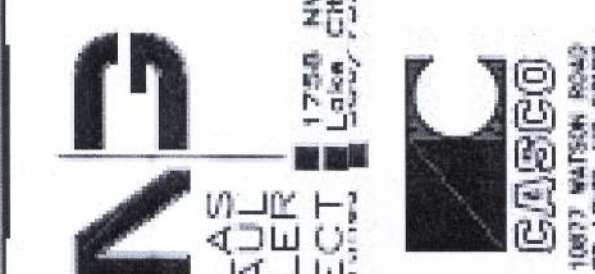

**NICHOLAS
PAUL
GEISLER
ARCHITECT**

1756 NW Brown Road
Fort Collins, CO 80525
970/225-1234

 **CASCO**
10077 WATSON ROAD

DATE:

0, "KWA"
AR0007005



CONCEPT CONSTRUCTION

License#: CGC515491
ph: 386-755-8887
fx: 386-755-1919

295 NW Commons Loop
Suite 115-323
Lake City, FL 2055

www.conceptconstruction.net

DOLLAR GENERAL®

LAKE CITY, FLORIDA
COUNTY RD 247, LAKE CITY, FL

247, LAKE CITY
STORE # 17851

STORE # 12851
2010 PROTOTYPE - PLAN "C" 9,100

DATE	30 MAR 2010
Design	JFB 06/10/10
Revisions	JFB 10/20/10

SHEET NUMBER

C1.C

OVERALL SITE LAYOUT