

F
E
D
C
B
A

1 FIRST FLOOR LIGHTING PLAN - AREA C
Scale: 1/8" = 1'-0"

- PLAN NOTES:
1. CONNECTION TO PRE-WIRED MODULAR CELL LIGHT FIXTURES. COORDINATE EXACT LOCATION WITH MODULAR CELL SHOP DRAWINGS PRIOR TO ROUGH IN.
 2. UP TO CONNECTION FOR PRE-WIRED MODULAR CELL LIGHT FIXTURES FOR UPPER TIER CELLS. COORDINATE EXACT LOCATION WITH MODULAR CELL SHOP DRAWINGS PRIOR TO ROUGH IN.
 3. INDICATES LIGHTING CONTROL ZONE. LIGHT FIXTURES IN THIS AREA ARE CIRCUITED THROUGH LIGHTING CONTROL RELAY PANEL, CONTROLLED THROUGH SECURITY SYSTEMS. SEE SHEET E-801 FOR ASSOCIATED PANEL AND RELAYS.
 4. DAYROOM SECURE VESTIBULE TO BE ELIMINATED AS PART OF DEDUCTIVE ALTERNATE 2. DELETE LIGHTING AND ASSOCIATED CIRCUITING AND CONTROLS FOR THIS AREA IF DEDUCTIVE ALTERNATE 2 IS ACCEPTED BY OWNER.

- GENERAL NOTES:
1. CIRCUITS ADJACENT TO LIGHT FIXTURES ARE TO PANEL, TOP, UNLESS OTHERWISE NOTED.
 2. WHERE SWITCHED ARE SHOWN GROUPED TOGETHER, PROVIDE COMMON FACEPLATE FOR THESE SWITCHES, WITH EACH SWITCHED LABELED WITH A DESCRIPTION OF LIGHT FIXTURES CONTROLLED.
 3. FIXTURES ON LIFE SAFETY CIRCUIT INDICATED WITH "NL" ADJACENT TO SYMBOL ARE UNSWITCHED NIGHT LIGHT CIRCUITS TO BE WIRED AHEAD OF ANY LIGHTING CONTROLS.
 4. EXIT LIGHTS AND INTEGRAL EMERGENCY BATTERY PACKS ARE TO BE WIRED AHEAD OF ANY LIGHTING CONTROLS.
 5. WHERE A COLOR NAME "RED", "ORANGE", ETC. IS INDICATED WITHIN AN AREA OR ROOM, THIS REFERS TO SPECIFIC LIGHTING CONTROL PROGRAMMING COMPONENT REQUIREMENTS FOR THE ROOM, AREA OR ZONE INDICATED ON SHEET E-801. THE LINES AROUND THE AREA AND THE COLOR NAME ARE IN THE CORRESPONDING COLOR FOR THE PURPOSES OF ENABLING PRINTING TO PDF IN COLOR.
 6. REFERENCE EP-111 FOR AREAS DESIGNATED AS DESIGN ALTERNATES, WHERE ELECTRICAL WORK IS SHOWN IN THESE AREAS, EXCLUDE FROM THESE AREAS AS PART OF DESIGN ALTERNATE PRICING.

Dewberry®
800 North Magnolia Ave.
Suite 1000, Orlando, FL 32803-3251
t +1 407 843 5120
f +1 407 649 8664

Ajax
10365 Hood Road South Suite 203
Jacksonville, FL 32257
t +1 904-262-8660
f +1 904-262-8623



TLC ENGINEERING SOLUTIONS
255 S. Orange Avenue
Suite 1600
Orlando, FL 32801
P 407 841 9050
COA 15
www.tlcsolutions.com
TLC No. 120018
THINK. LISTEN. CREATE.

Professional Seals

Wayne Edward Allred, P.E.
State of Florida
Professional Engineer
License No. 45800

This item has been electronically signed and sealed by the individual named above, using a dated Digital Signature in the space below, per F.A.C. Rule 61G15-23.004. Printed copies of this document are not considered signed and sealed, and the signature must be verified on any electronic copies.

Wayne E. Allred

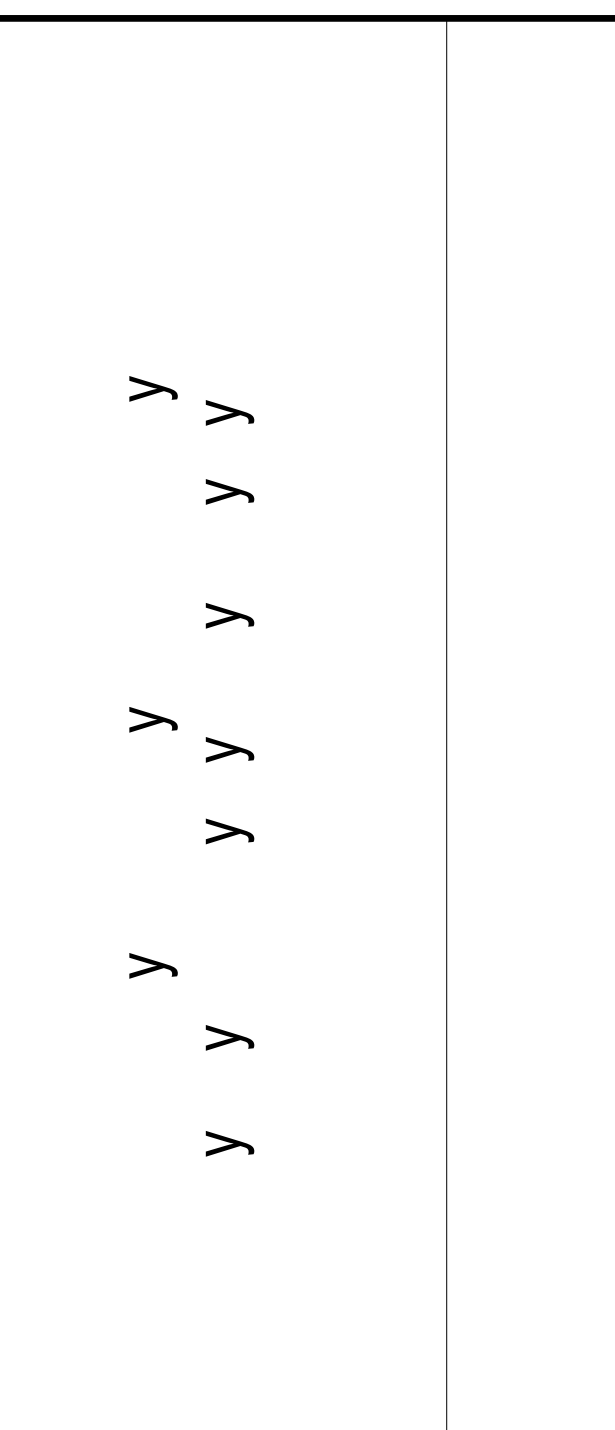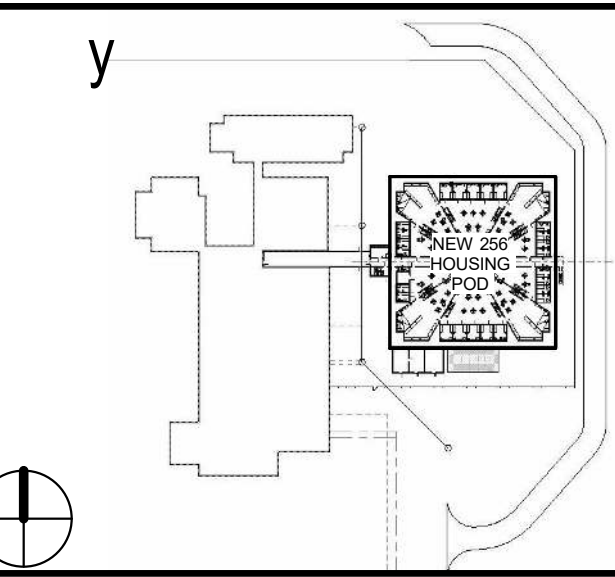

SCALE 1/8" = 1'-0"

No.	Description	Date

REVISIONS

DRAWN BY	O DORIA
APPROVED BY	W ALLRED
CHECKED BY	L WOLFE
DATE	JULY 24, 2020

TITLE

FIRST FLOOR
LIGHTING PLAN -
AREA C

PROJECT NO. 50101397

EL-111C

SHEET NO.

DESTROY AFTER USE

0' 4' 8' 16'
SCALE: 1/8" = 1'-0"