


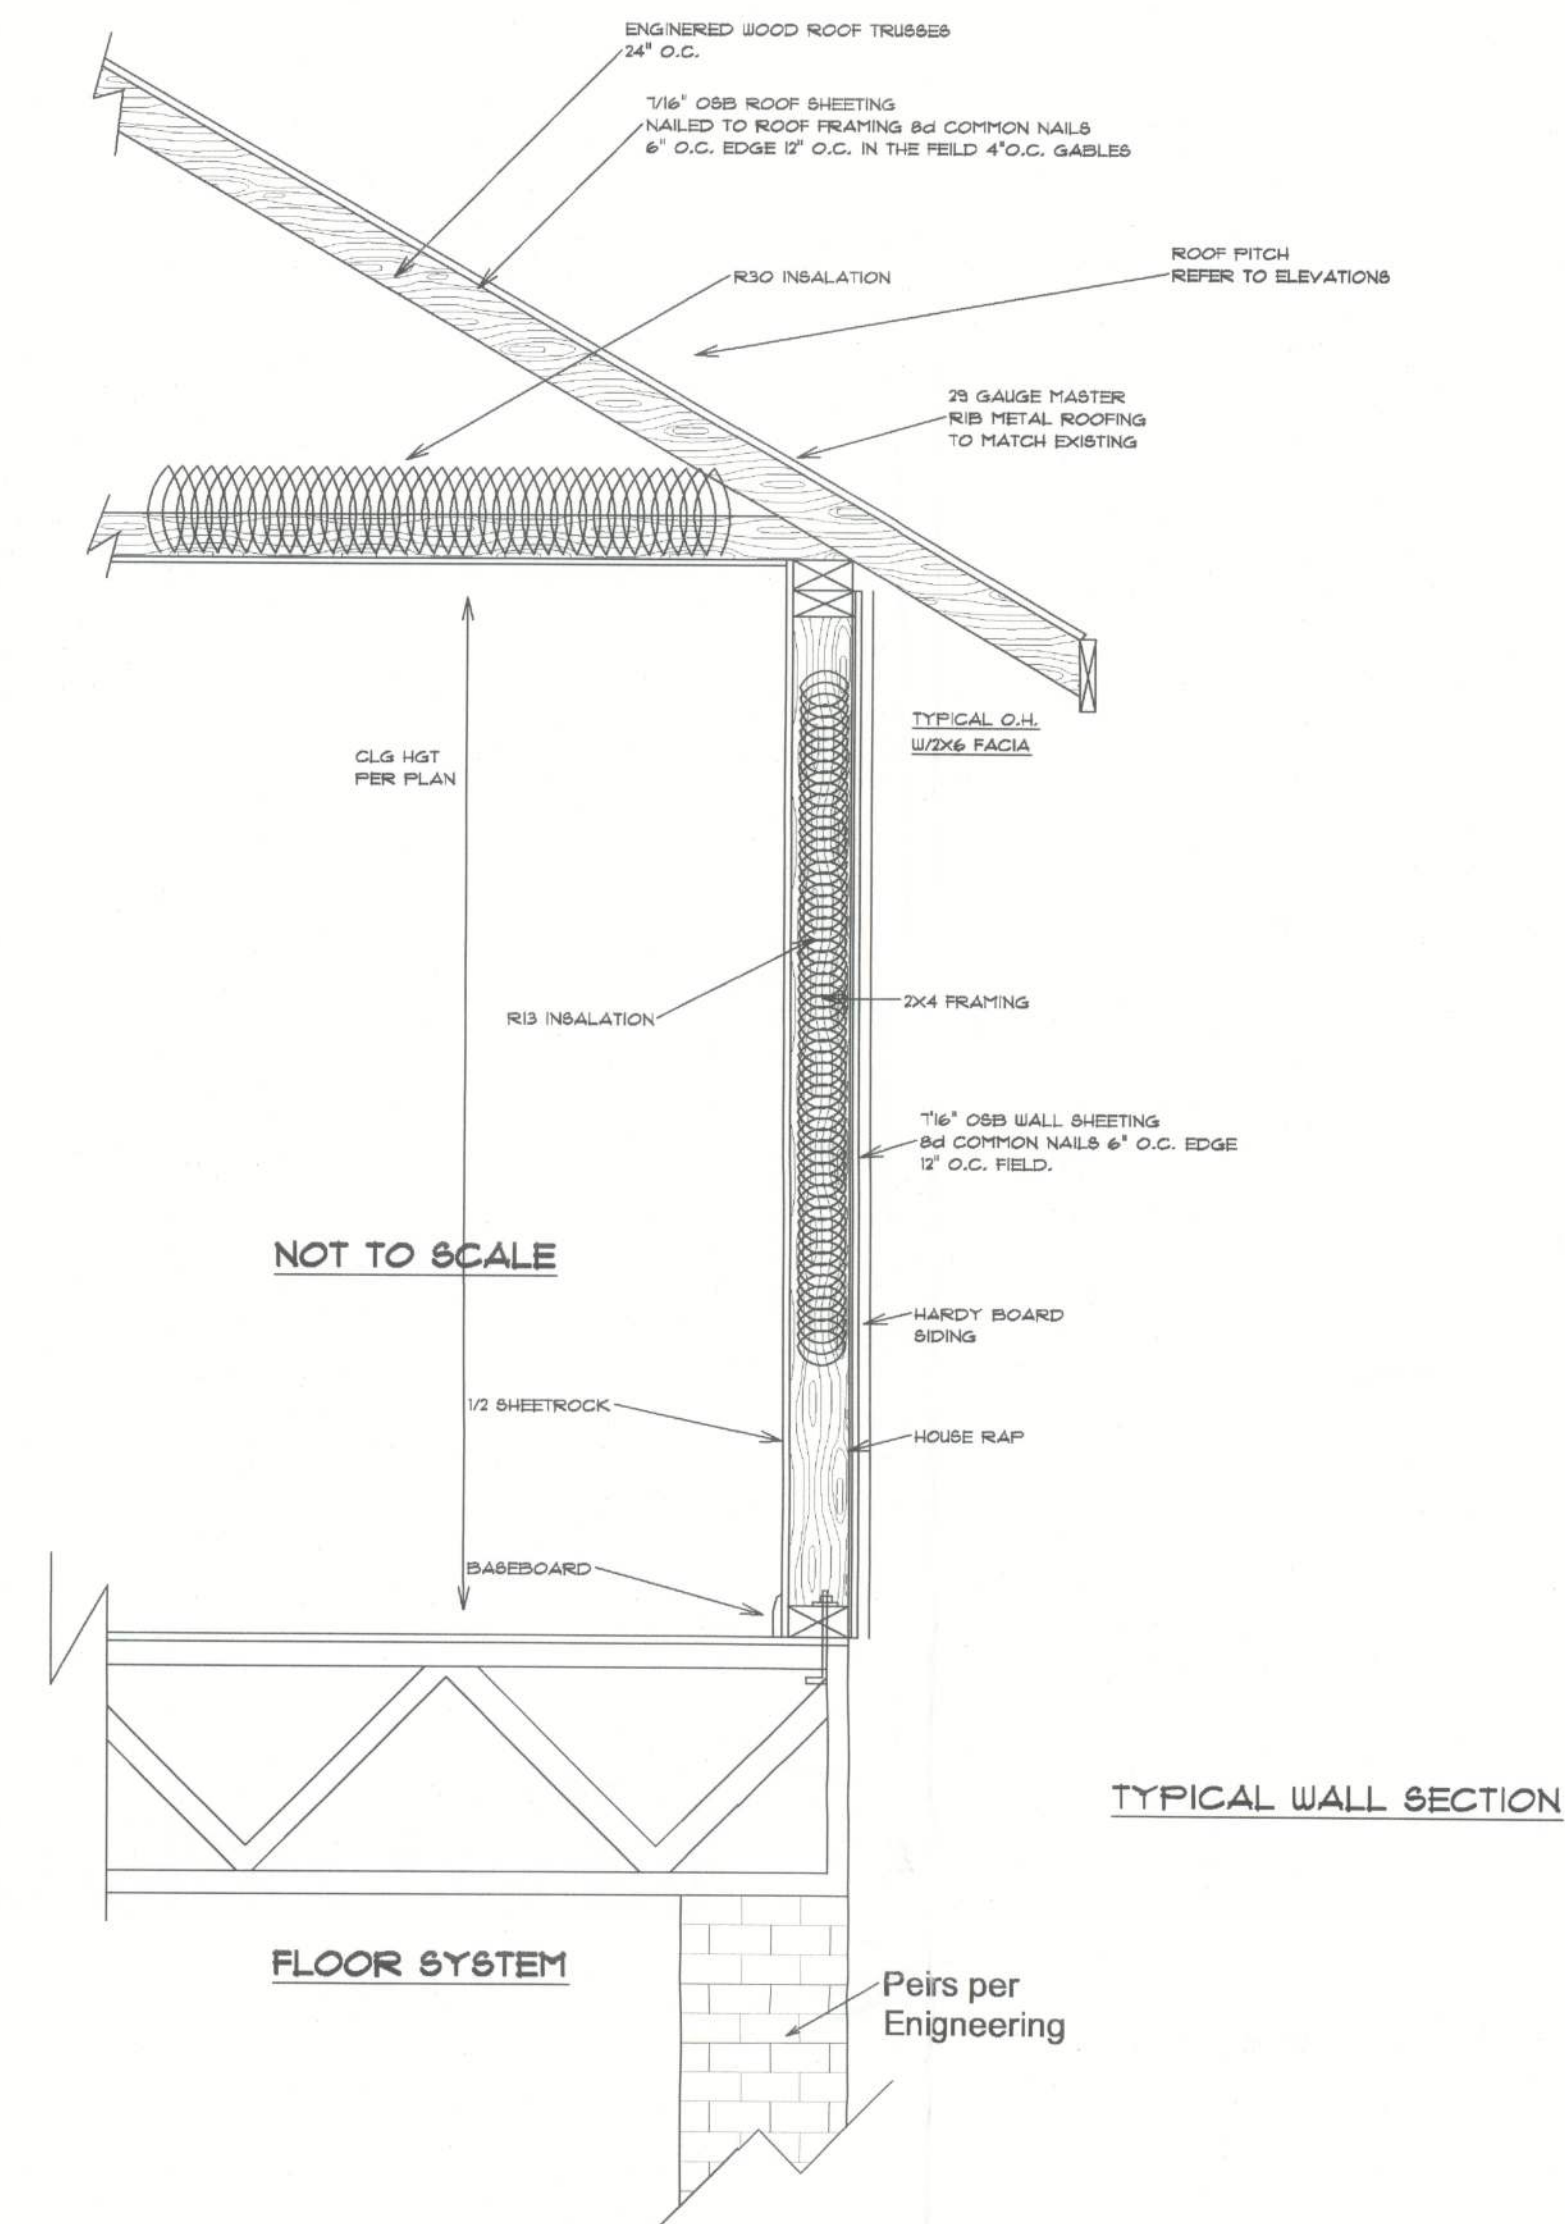

REVISIONS	
	JFB

SOFTPLAN
ARCHITECTURAL DESIGN SOFTWARE

NOTE: SOME CHANGES IN
EXISTING HOME


NOTE: ALL INTERIOR WALLS
TO BE ISULATED

ELECTRICAL NOTES


- E-1 WIRE ALL APPLIANCES, HVAC UNITS AND OTHER EQUIPMENT PER MANUFACTURER SPECIFICATIONS
- E-2 CONSULT THE OWNER FOR THE NUMBER OF SEPARATE TELEPHONE LINES TO BE INSTALLED
- E-3 ALL INSTALLATIONS SHALL BE PER NATIONAL ELECTRICAL CODE
- E-4 ALL SMOKE DETECTORS SHALL BE 10V BATTERY BACKUP OF THE P-WO ELECTRIC TYPE AND SHALL BE INTERLOCKED TOGETHER IN NEAR INSIDE AND NEAR BEDROOMS
- E-5 TELEPHONE TELEVISION AND OTHER LOW DEVICES OR OUTLETS SHALL BE AS PER THE OWNERS DIRECTION AND IN ACCORDANCE WITH APPLICABLE SECTIONS ON NATIONAL ELECTRICAL CODE LATEST EDITION
- E-6 ELECTRICAL CONTRACTOR SHALL BE RESPONSIBLE FOR THE DESIGN AND SIZING OF ELECTRICAL SERVICE AND CIRCUITS
- E-7 ENTRY OF SERVICE UNDERGROUND OR OVERHEAD TO BE DETERMINED BY THE POWER COMPANY
- E-8 ALL BEDROOMS RECEPTALS ARE TO BE A.C.I.

2008 NEC Registered
AFCI Proof Rec.
Children

200 AMP METER
OVERCURRENT PROTECTED
SERVICE FROM EXISTING SERVICE

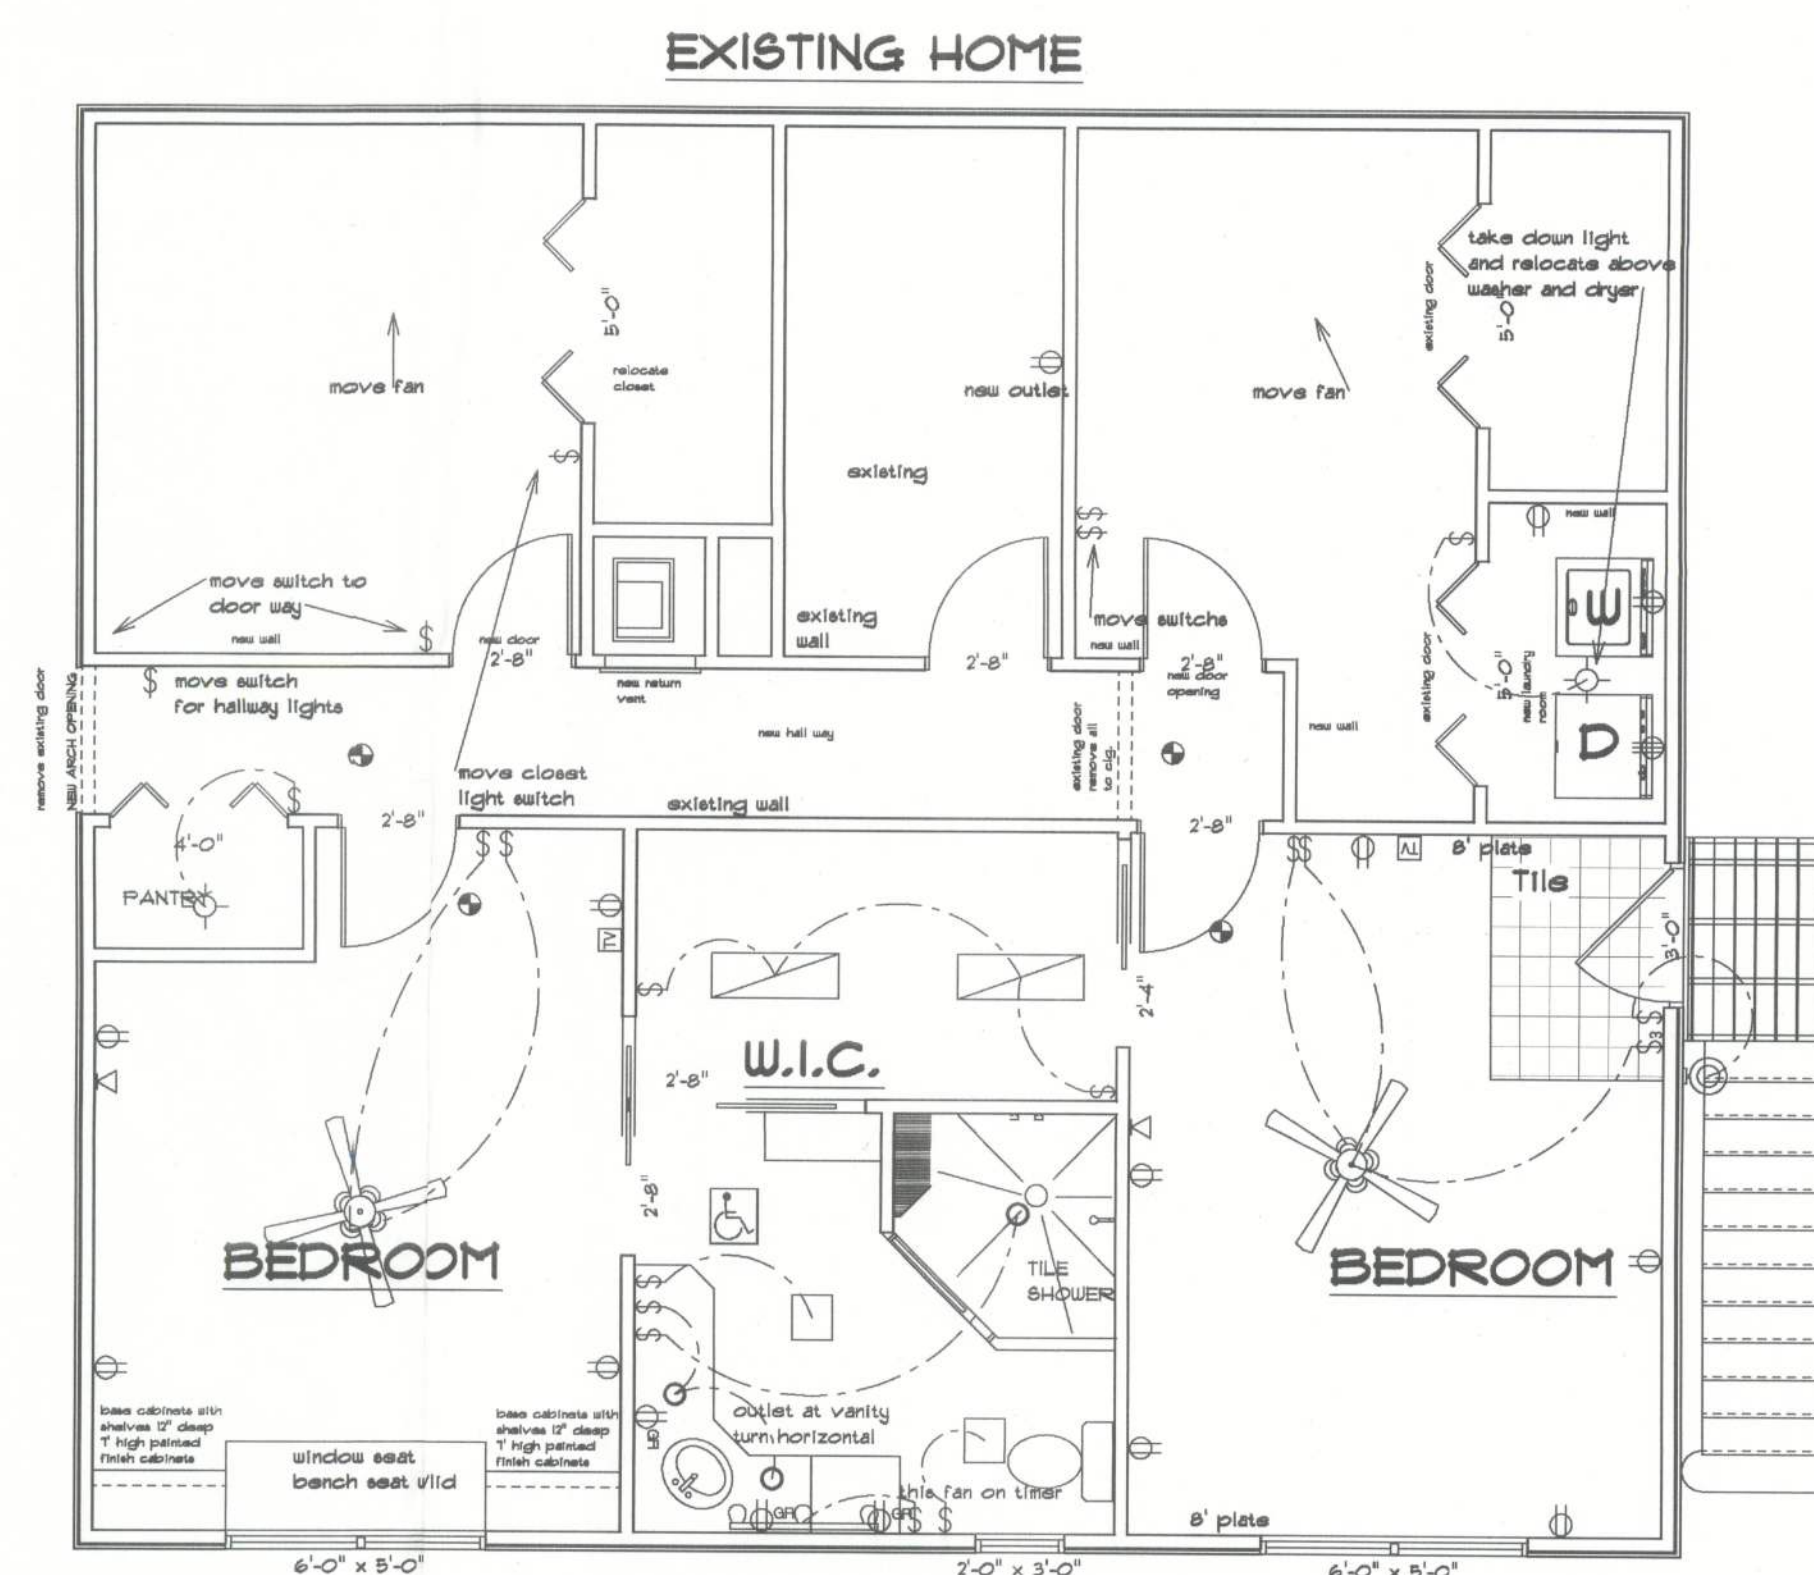

NEW ADDITION

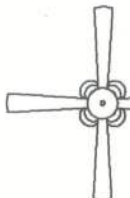ELECTRICAL	SYMBOL
ceiling fan spotlights 1	
can light 6 inch	
ceiling light vent square	
fluorescent light 1 x 4	
track light	
exterior light 5	
cable tv outlet	
light	
outlet	
outlet 220v	
outlet gfi	
smoke detector	
switch	
switch 3 way	
telephone	

Bryan Zecher
Construction, Inc.

ROOKS ADDITION

County, Florida

PRINTED DATE:
January 26, 2010

DRAWN BY:
JOHN BENZ 386-266-0746

DESIGNED BY:
Bryan Zecher Const.

FINALS DATE:	CHECKED BY:
06 / Dec / 05	

05/Dec/05	
JOB NUMBER:	

ROOKS ADDITION

A1 Floor Plan
& Electric Plan

28435