


MERCED ADDITION  
(POST CONSTRUCTION PERMIT SET)  
618 INDIAN RIDGE LANE  
LAKE CITY, FLORIDA 32055



| Area Tabulations |                                     |
|------------------|-------------------------------------|
| Existing         | Carport to Living Conversion 888 sf |
| Addition         | Storage 300 sf                      |
| Total Area:      | 1188 sf                             |

INDEX OF DRAWINGS  
SHEET NO. DRAWING TITLE  
A1 CODE & COVER SHEET,  
ORIGINAL PERMITTED STRUCTURE  
EXISTING CONDITIONS  
A2 PROPOSED CONDITIONS  
A3 & ELEVATIONS  
A4 ELECTRICAL FIXTURE LAYOUT

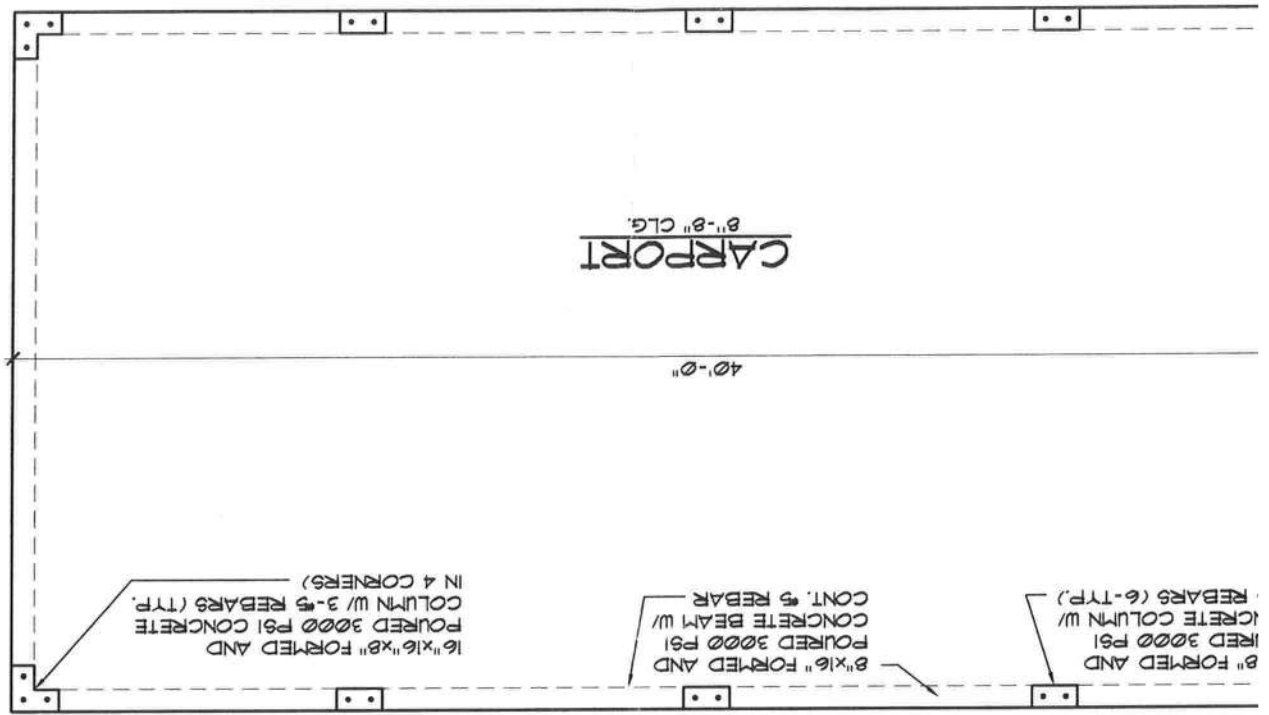


|                                 |
|---------------------------------|
| Seal                            |
| GILL ENGINEERING SERVICES, INC. |
| AUTH # 30824                    |
| GARY GILL PE #51942             |
| 426 SW COMMERCE DR              |
| LAKE CITY, FL 32025             |
| 386-590-1242                    |
| Job no                          |
| MERCED 040221                   |
| drawn by                        |
| checked                         |
| DA                              |
| date                            |
| 04/02/21                        |
| scale                           |
| AS NOTED                        |

MERCED ADDITION  
(POST CONSTRUCTION PERMIT SET)  
426 HIDDEN ACRES DRIVE  
NEW BETHUNA BEACH, FLORIDA

| Revisions |  |
|-----------|--|
| by        |  |
|           |  |
|           |  |
|           |  |
|           |  |
|           |  |
|           |  |
|           |  |

THE FINAL PL  
WWW.THEFINALPLA  
TEL. 352.410.2  
CUSTOM DESIGNS, SPACE PI  
TENANT BUILD OUTS, ADDITI

!?!ons

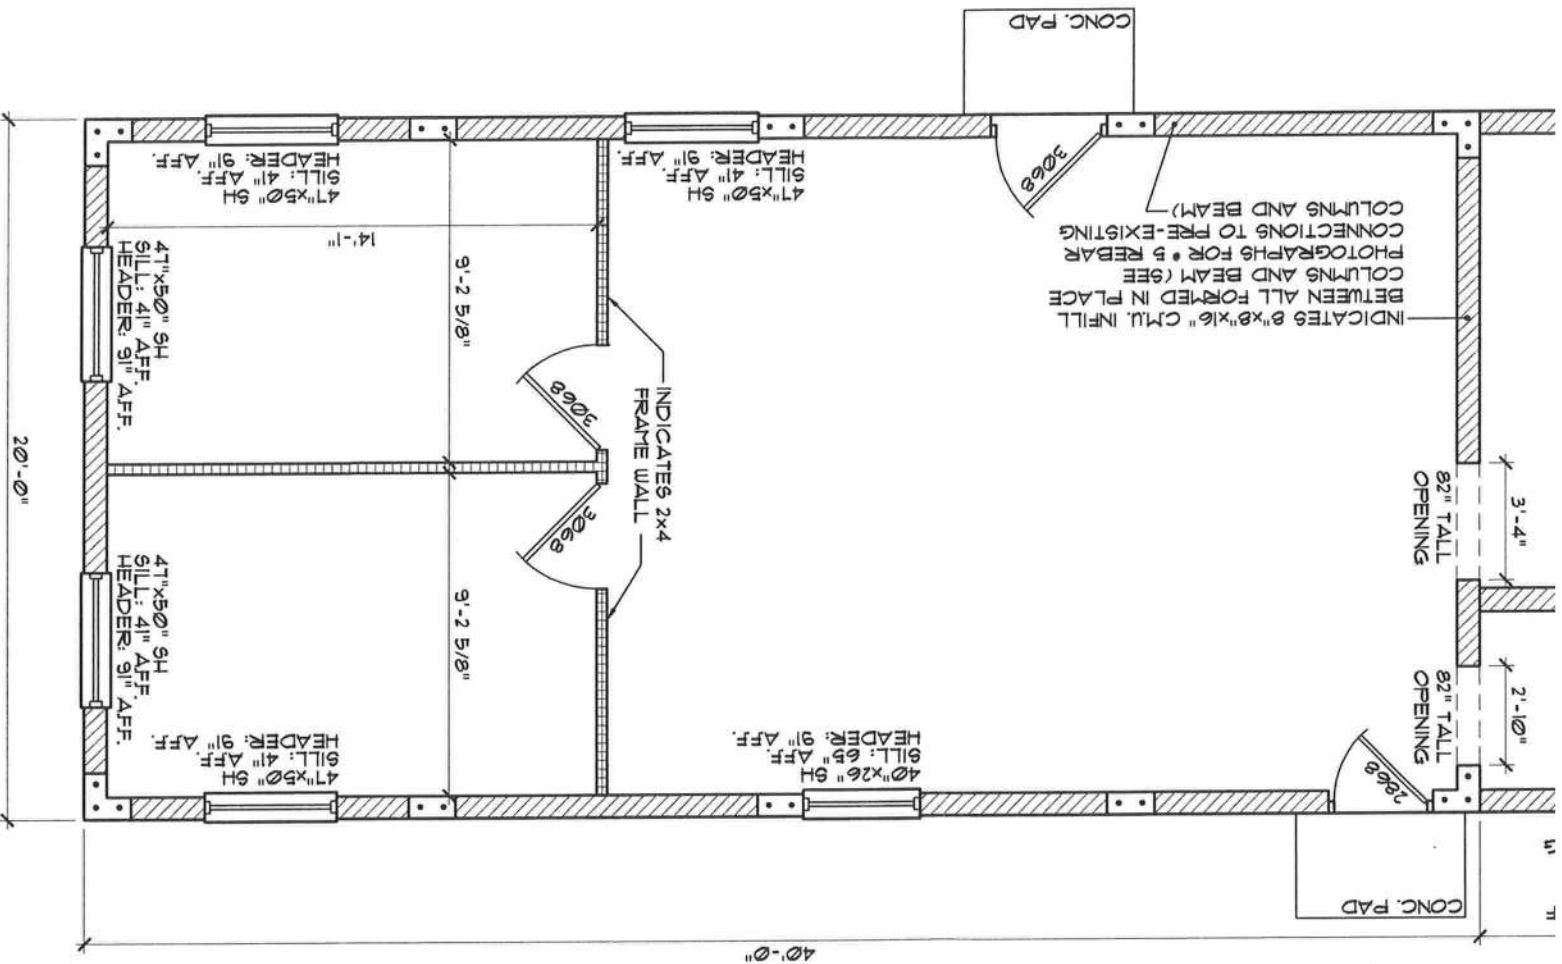

GARY GILL  
LICENSE  
No 51942

GILL ENGINEERING  
SERVICES, INC  
AUTH # 30824  
GARY GILL PE #51942  
426 SW COMMERCE DR  
130-M  
LAKE CITY, FL 32025  
386-590-1242

**MERCED ADDITION**  
(POST CONSTRUCTION PERMIT SET)

4620 HIDDEN ACRES DRIVE  
NEW SMYRNA BEACH, FLORIDA


|    |           |
|----|-----------|
| by | revisions |
|    |           |
|    |           |
|    |           |
|    |           |
|    |           |

**THE FINAL PL**


WWW.THEFINALPL  
TEL. 352.410.2

TEL. 352.410.2


CUSTOM DESIGNS, SPACE P  
TENANT BUILD OUTS, ADDIT

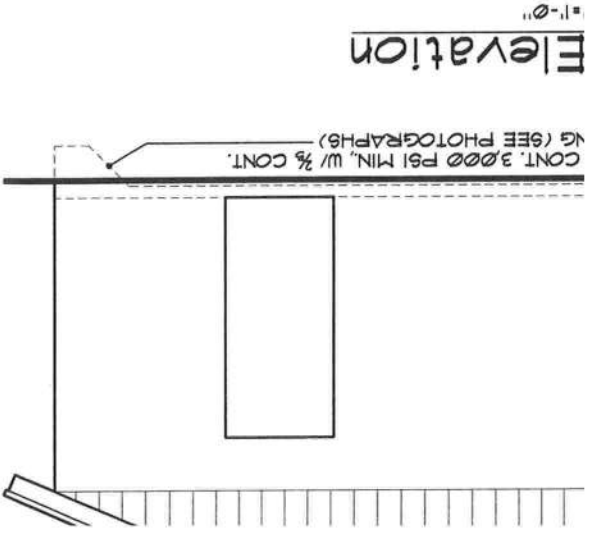

Elevation  
1'-0"

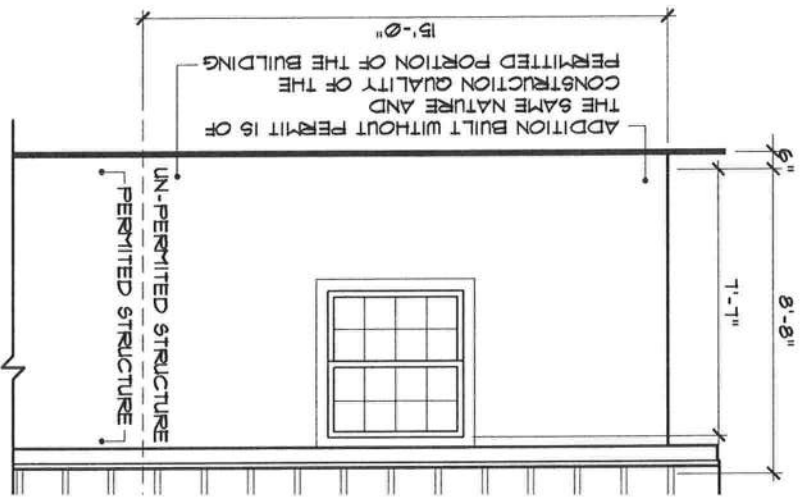

B  
A3  
SCALE: 3/16"=1'-0"  
Front Elevation

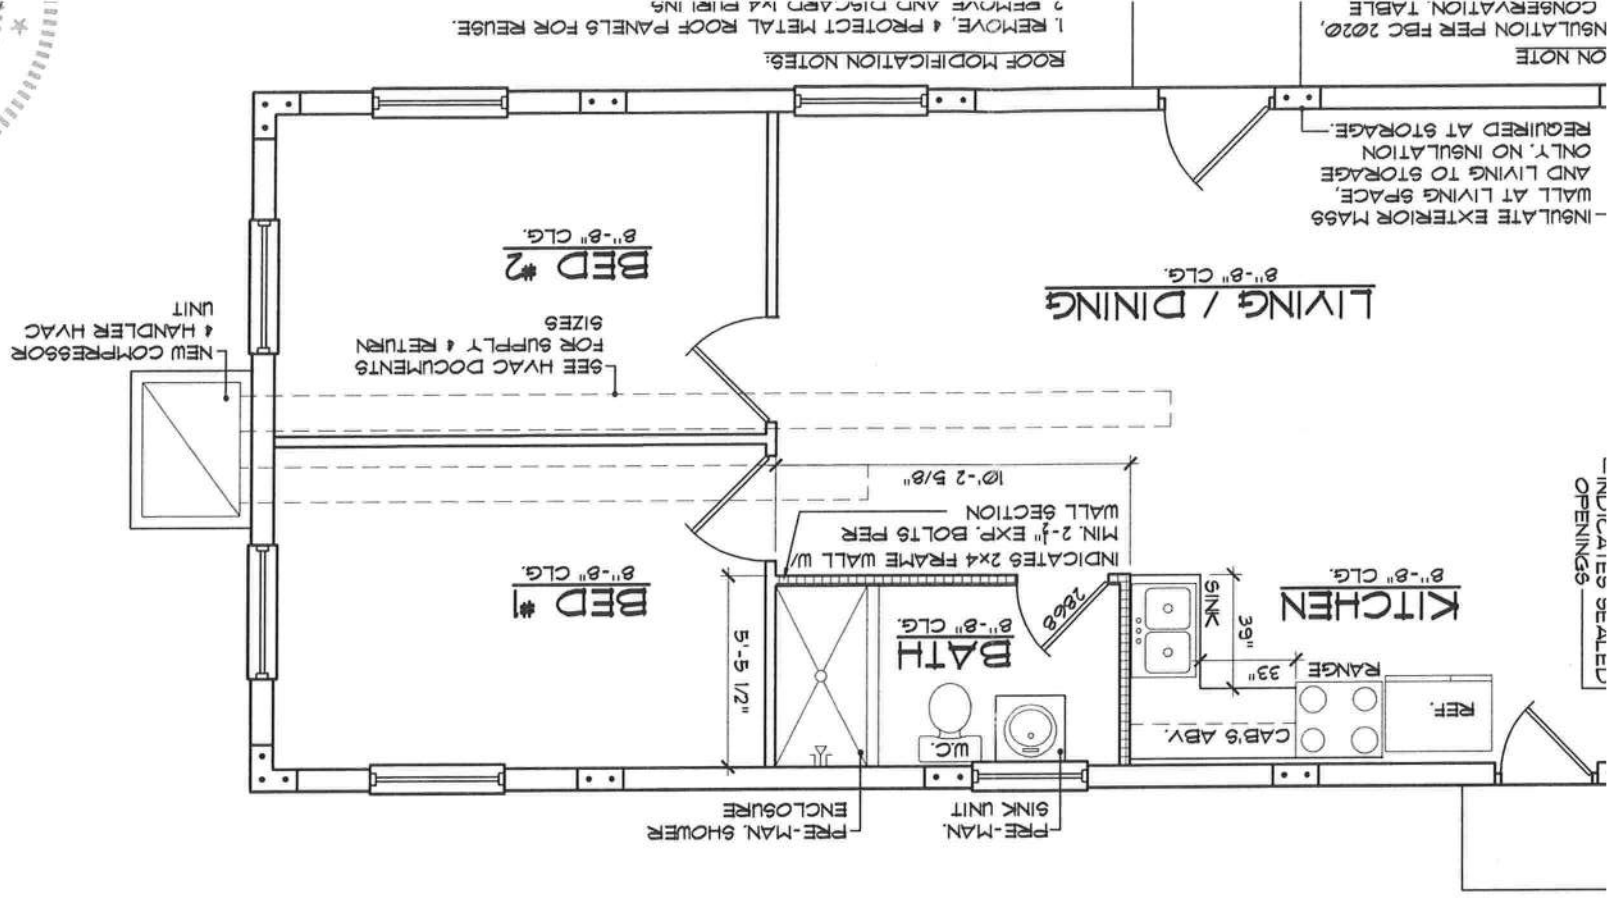

|               |                                 |
|---------------|---------------------------------|
| seal          | GILL ENGINEERING SERVICES, INC. |
| job no        | 386-590-1242                    |
| MERCED 040221 | LAKE CITY, FL 32025             |
| drawn by      | DA                              |
| checked       | DA                              |
| date          | 04/02/21                        |
| scale         | AS NOTED                        |

**MERCED ADDITION**  
(POST CONSTRUCTION PERMIT SET)  
4612 HIDDEN ACRES DRIVE  
NEW BETHUNA BEACH, FLORIDA

|           |    |
|-----------|----|
| revisions | by |
|           |    |
|           |    |
|           |    |
|           |    |
|           |    |
|           |    |
|           |    |


**THE FINAL PL**  
WWW.THEFINALPLA  
TEL. 352.410.2  
CUSTOM DESIGNS, SPACE PI  
TENANT BUILD OUTS, ADDITI



|                                 |
|---------------------------------|
| seal                            |
| GILL ENGINEERING SERVICES, INC. |
| AUTH # 30824                    |
| GARY GILL PE #51942             |
| 130-M                           |
| 426 SW COMMERCE DR              |
| LAKE CITY, FL 32025             |
| 386-590-1242                    |
| job no                          |
| MERCED 040221                   |
| drawn by                        |
| DA                              |
| checked                         |
| DA                              |
| date                            |
| 04/02/21                        |
| scale                           |
| AS NOTED                        |

# ELECTRICAL LEGEND

- Ceiling Mounted Light
- Wall Mounted Light
- Duplex Receptacle
- 220 V Receptacle
- 1/2 hot, 1/2 switched
- Water Proof Receptacle
- Ground Fault Interrupt
- Wall Switch
- 3-Way Switch
- Ethernet
- Cable Jack
- Electrical Panel
- Chime
- Door Bell/Garage Door Switch
- Disconnect Switch
- Electrical Meter
- Smoke Detector
- Ceiling Fan
- Spot Light
- Garbage Disposal Motor

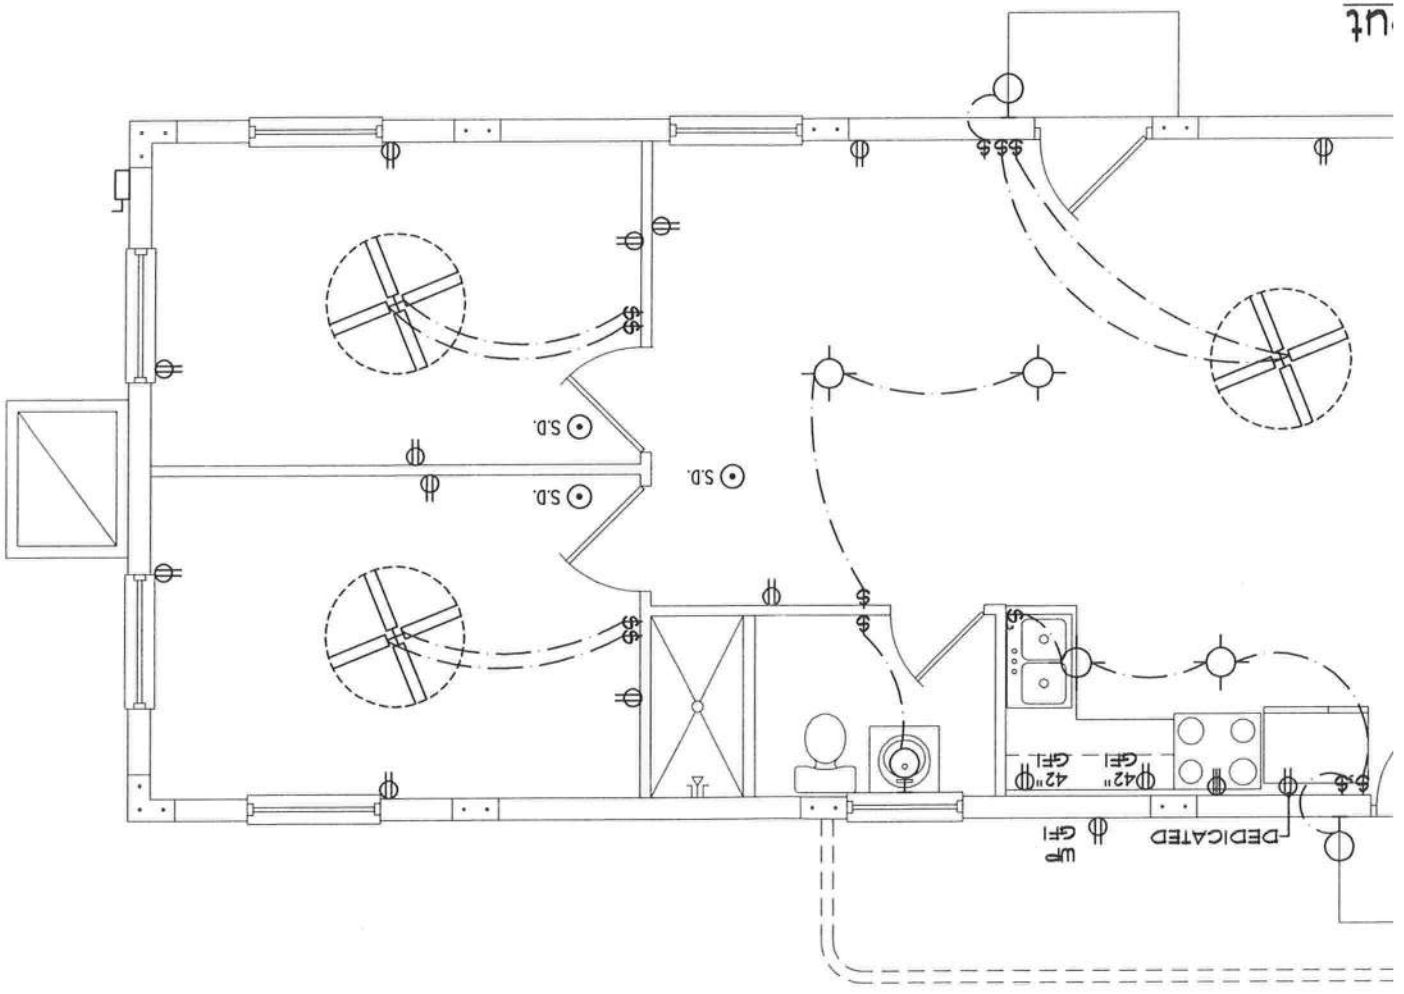

## MERCED ADDITION (POST CONSTRUCTION PERMIT SET)

4630 HIDDEN ACRES DRIVE  
NEW SMYRNA BEACH, FLORIDA

| revisions | by |
|-----------|----|
|           |    |
|           |    |
|           |    |
|           |    |
|           |    |
|           |    |

**THE FINAL PL**  
www.THEFINALPLA  
TEL. 352.410.21

CUSTOM DESIGNS, SPACE PL  
TENANT BUILD OUTS, ADDITI