


Office Copy

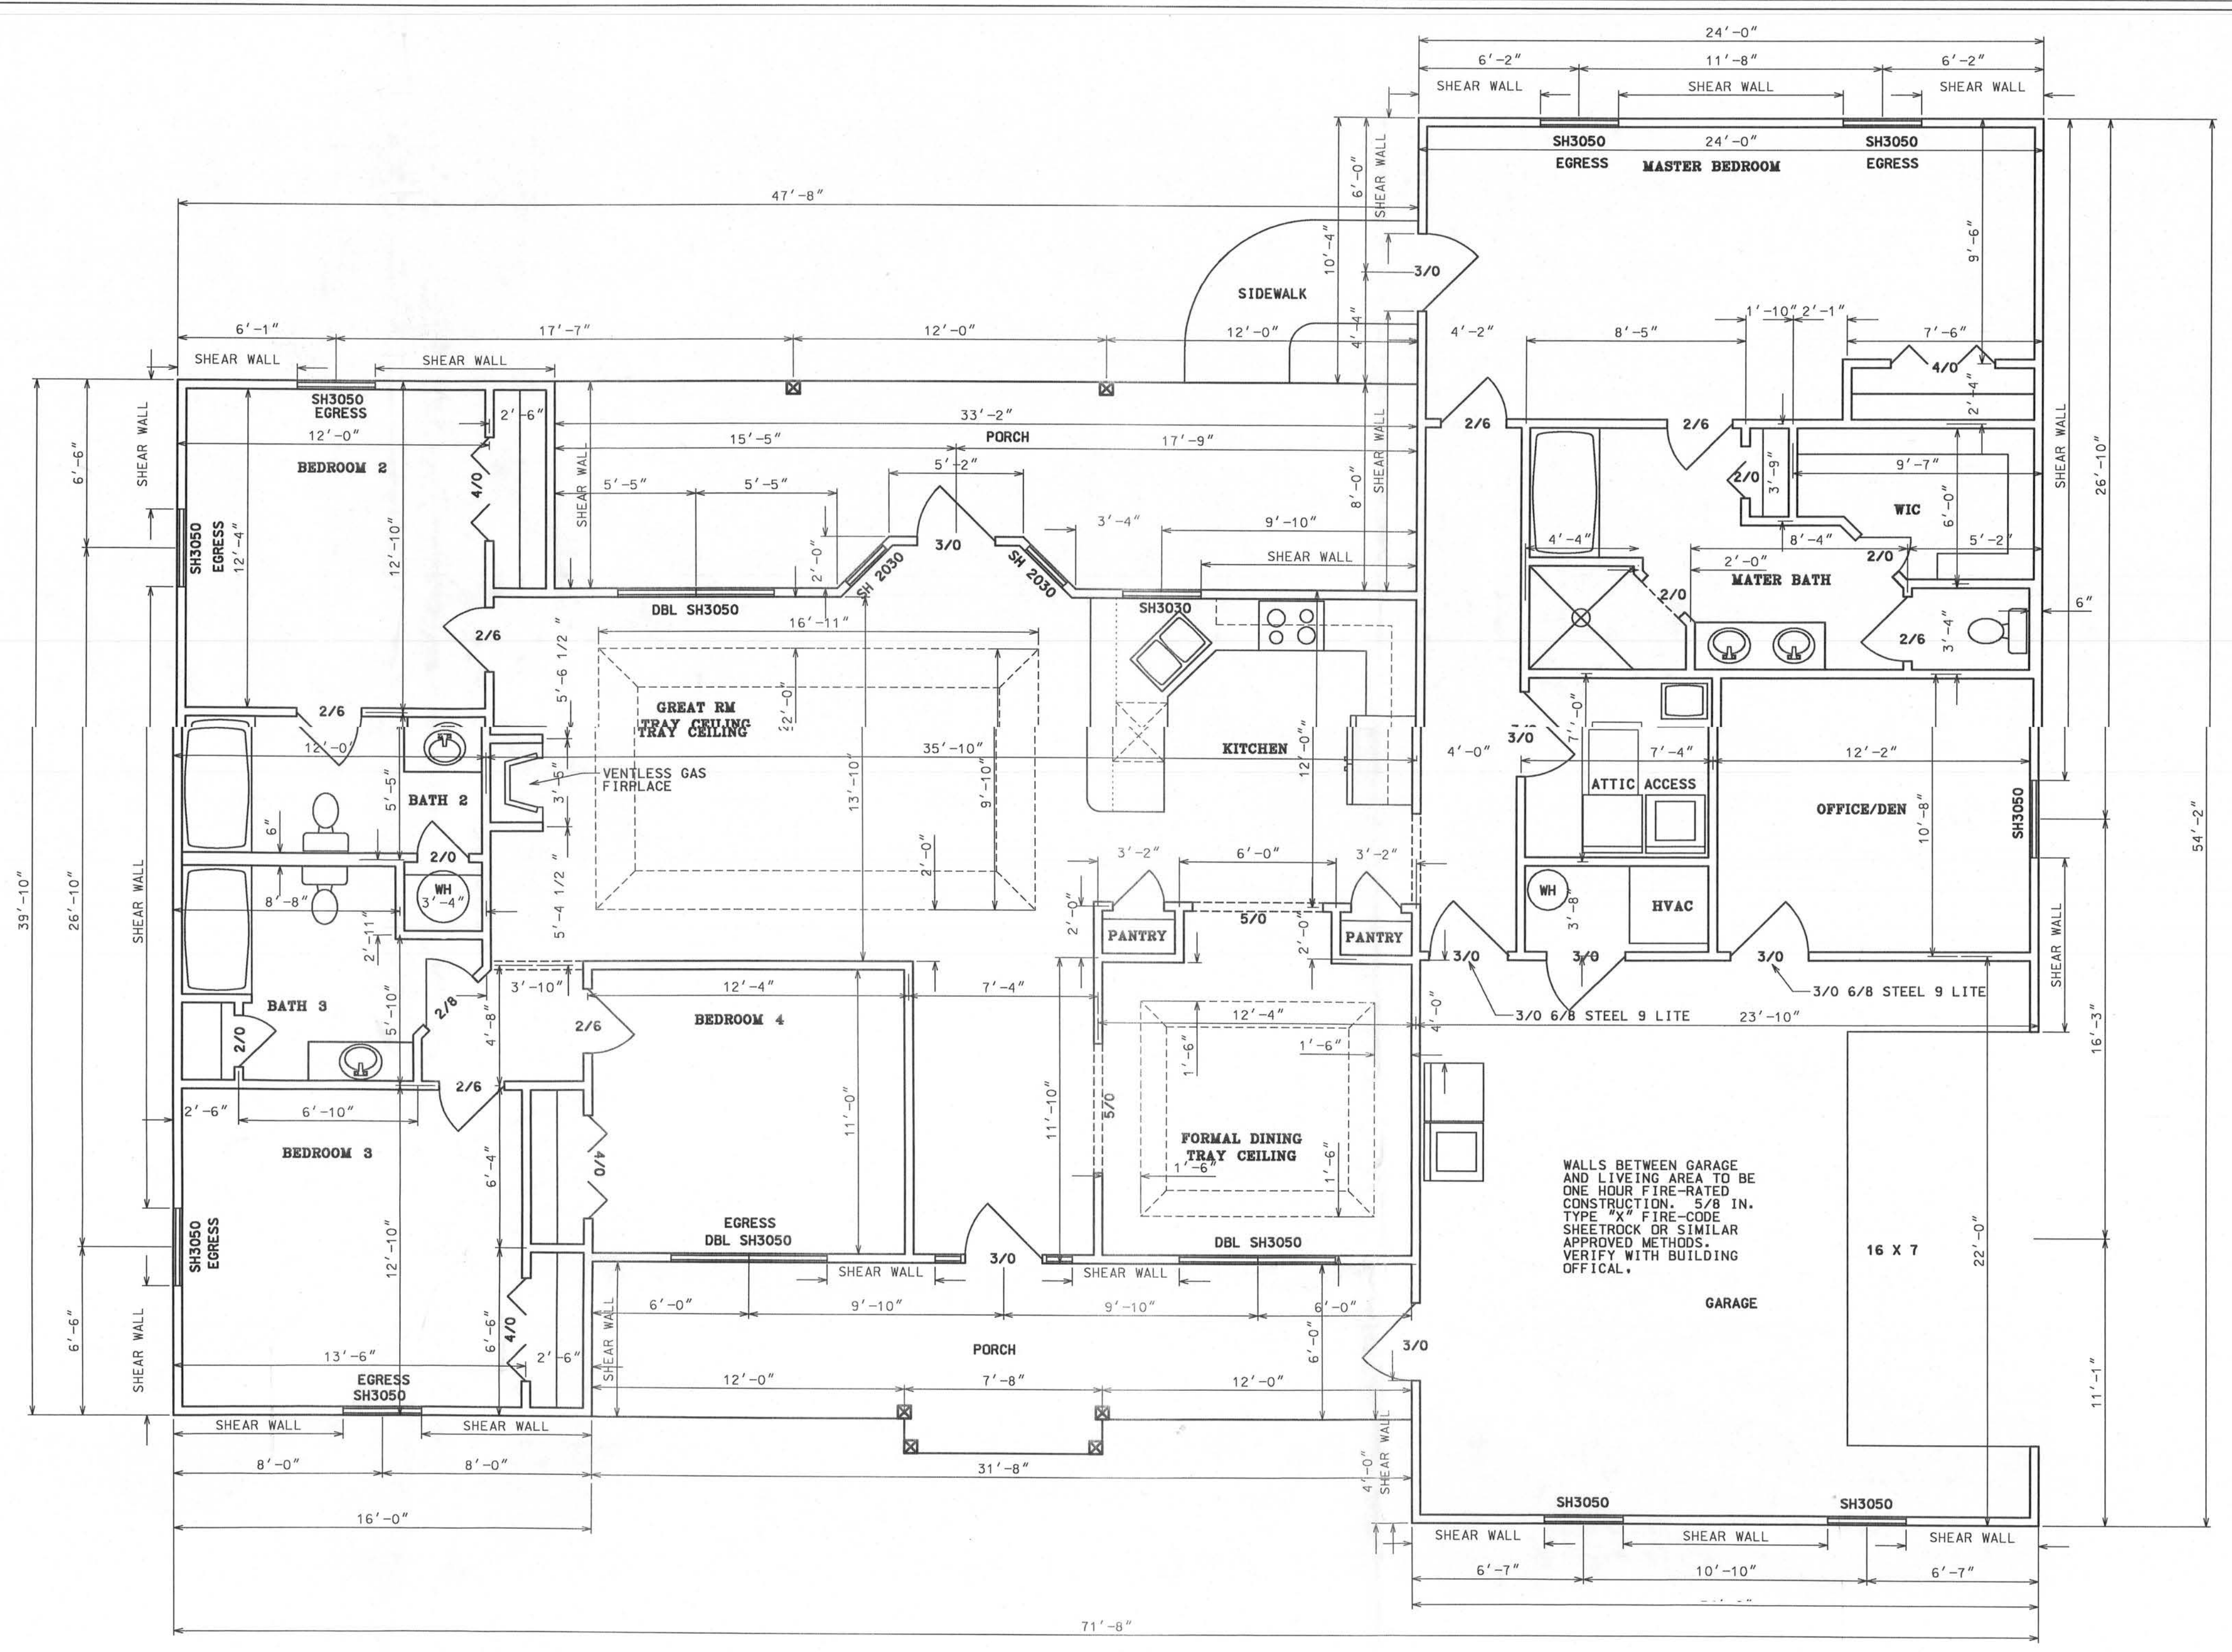

DOOR SCHEDULE	
No.	SIZE & TYPE
1	3' - 0" METAL FRONT ENTRY EXTERIOR
2	3' - 0" METAL FRENCH EXTERIOR
2	3' - 0" 9 LITE ENTRY DOOR EXTERIOR
2	3' - 0" ENTRY DOOR EXTERIOR
1	3' - 0" COLONIAL INTERIOR
1	2' - 8" COLONIAL INTERIOR
7	2' - 6" COLONIAL INTERIOR
3	2' - 0" COLONIAL INTERIOR
4	4' - 0" BIFOLD COLONIAL INTERIOR

WINDOW SCHEDULE	
No.	SIZE & TYPE
3	3' 0" - 5' 0" DBL SINGLE HUNG ALUMINUM
9	3' 0" - 5' 0" SINGLE HUNG ALUMINUM
1	3' 0" - 3' 0" ALUMINUM
2	2' 0" - 3' 0" ALUMINUM

HEATE AREA	2238 SF
GARAGE AREA	524 SF
PORCH AREA	439 SF
TOTAL AREA	3201 SF

THERES DRAWINGS, AS INSTRUMENTS OF SERVICE, ARE THE SOLE PROPERTY OF HAYGOOD HOMES, INC., AND ARE MAY NOT BE USED, COPIED OR REPRODUCED IN WHOLE OR IN PART FOR USE ON OR INCORPORATED WITHIN ANY OTHER JOB WITHOUT SPECIFIC AND INDIVIDUAL AUTHORIZATION BY HAYGOOD HOMES, INC.,.



HAYGOOD HOMES INC.

12592 So. U.S. HWY 441
LAKE CITY FL 32025
OFFICE (386) 752-3496
MOBILE (386) 303-1981
CR-C1326715


DERICK AND VICKI TUELL

LAKE CITY FLORIDA

FLOOR PLAN

PLAN No.	SCALE	DATE	SHEET NO.
P 0607	1/4" = 1'	04/02/06	3

...Project\tsuall\l00p1\wp2.dgn 6/20/2006 2:08:29 PM

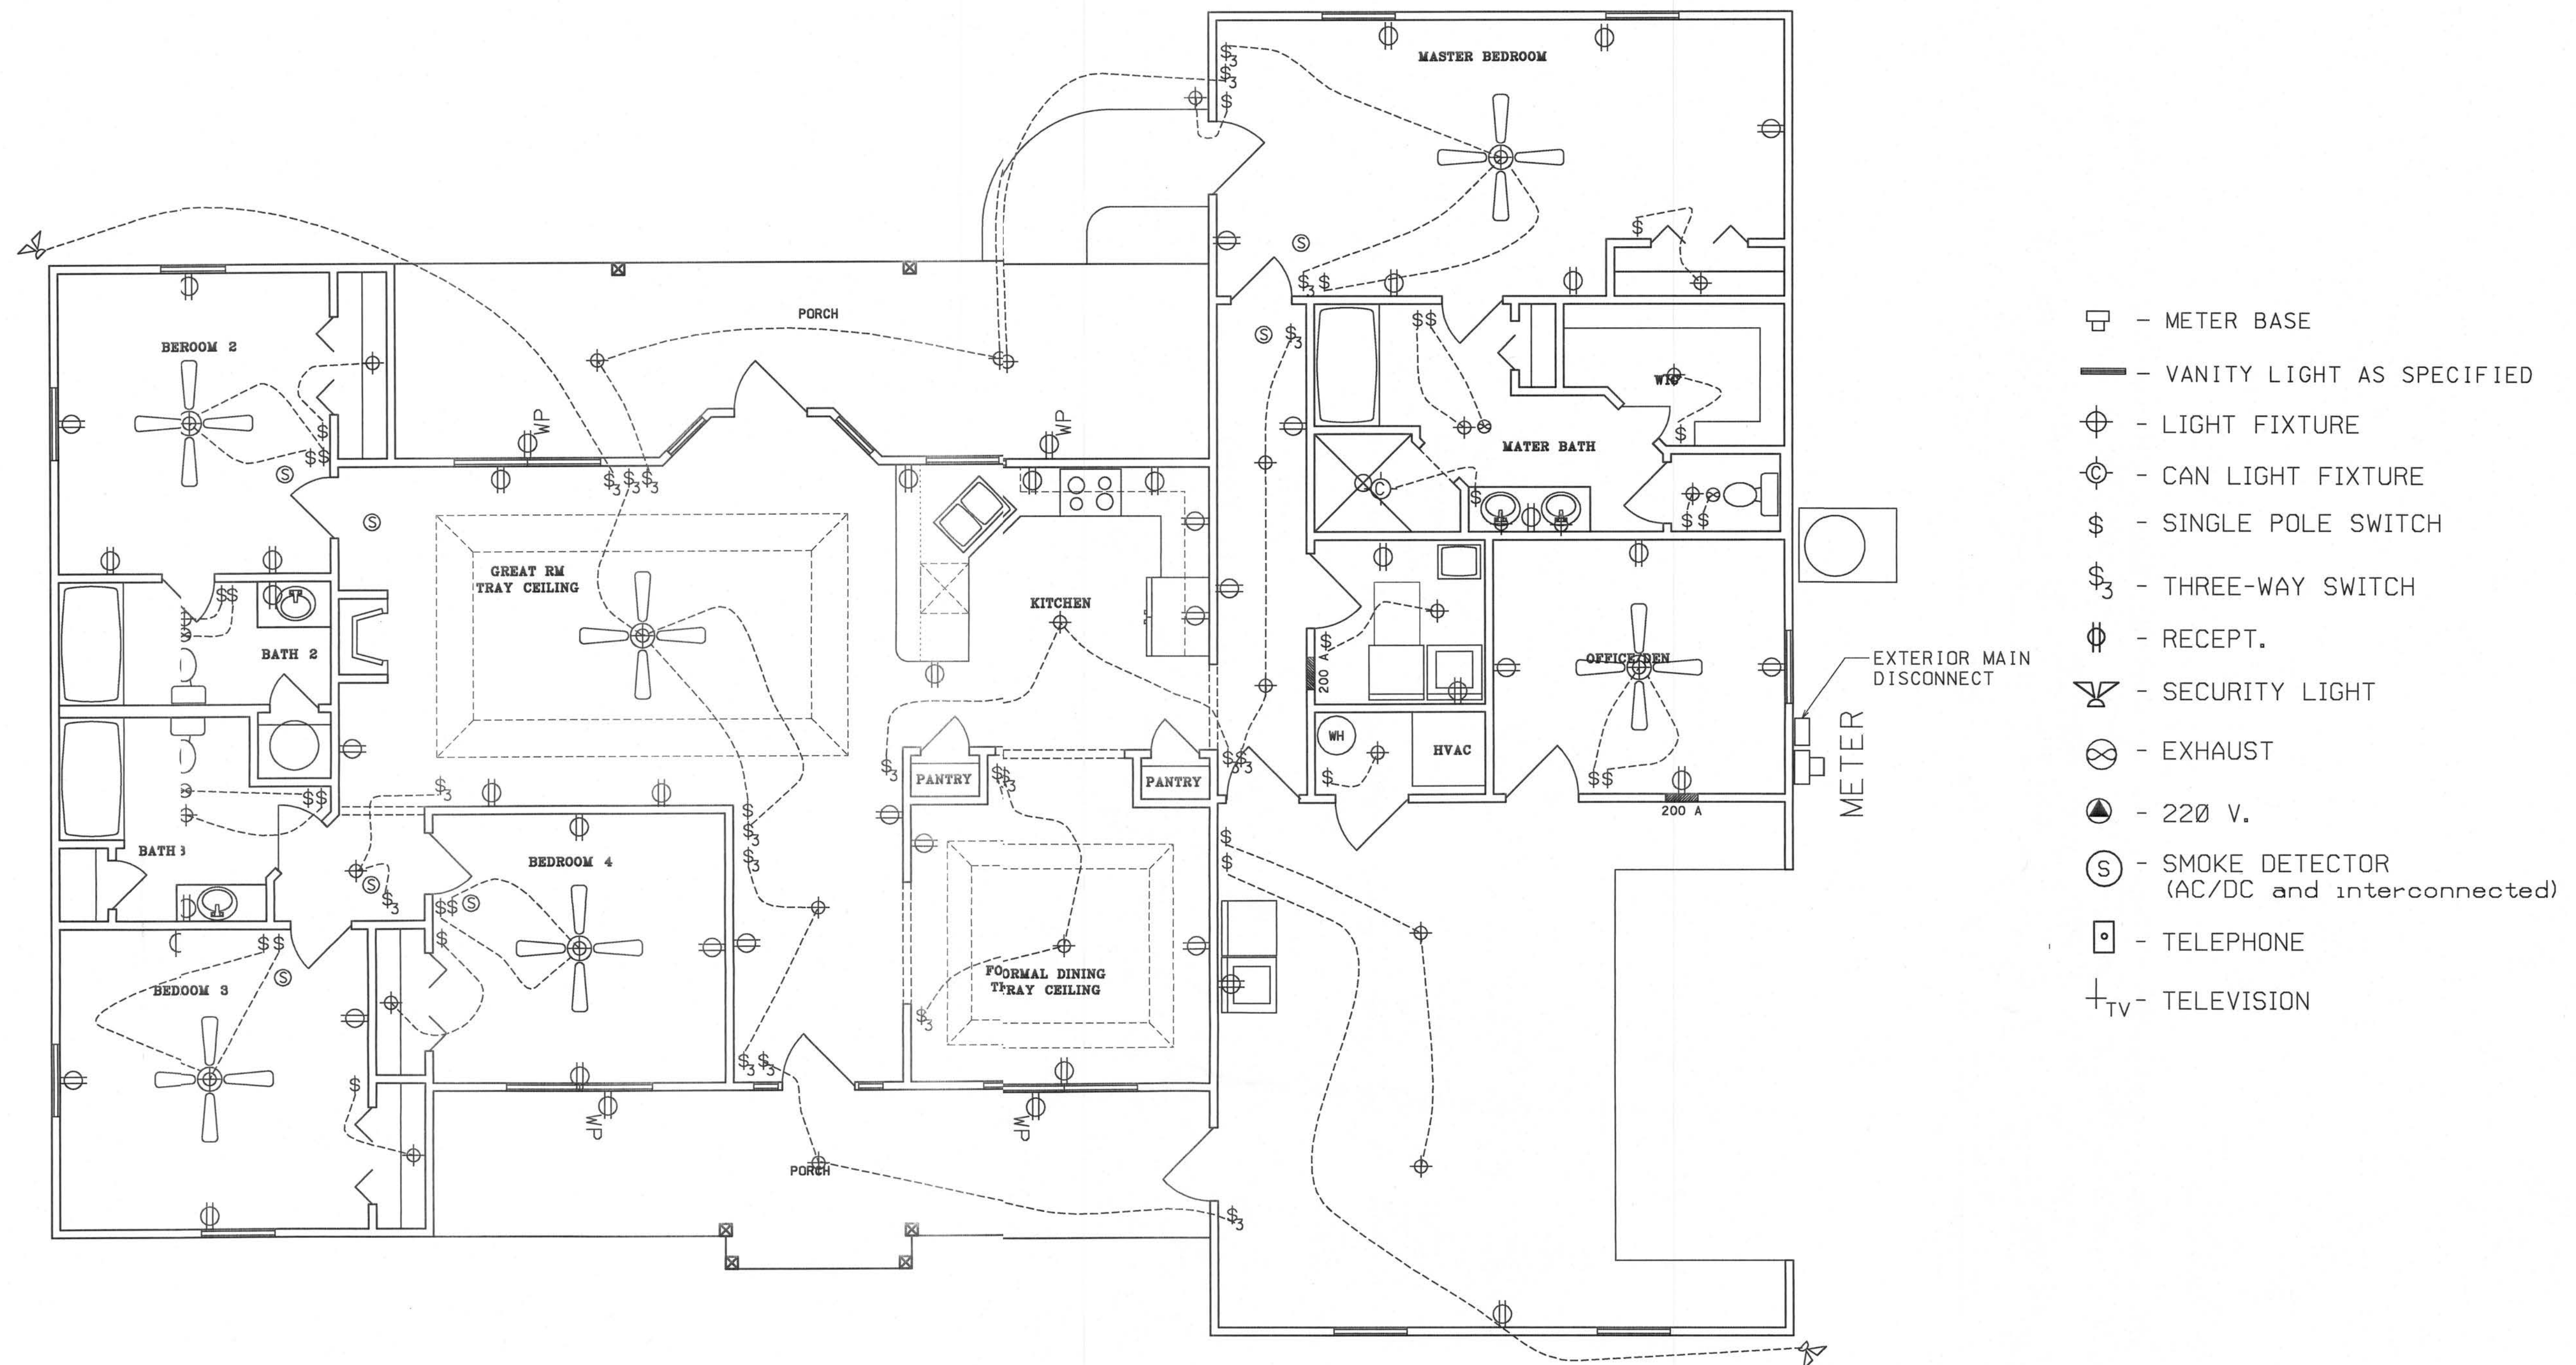

NOTE:

THE ELECTRICAL PLAN IS INTENDED TO SHOW SCHEMATICALLY THE LAYOUT OF THE ELECTRICAL COMPONENTS. FINAL LOCATIONS AND SIZING OF THE COMPONENTS SHALL BE THE RESPONSIBILITY OF A LICENSED ELECTRICAL CONTRACTOR. ALL WORK SHALL BE PERFORMED IN ACCORDANCE WITH ALL APPLICABLE CODES.

NOTES:

- 1.) PULL HOMERUNS OF TELEPHONE CABLE AND COAX CABLE TO COMMUNICATION PANEL (NO JUNCTIONS ALLOWED IN ATTIC)
- 2.) ALL EXTERIOR RECEPTACLES SHALL EITHER BE GFI RECPTS OR PART OF A GFI CIRCUIT. ALL EXTERIOR RECEPTACLES SHALL BE WEATHERPROOF.
- 3.) ALL BATHROOM, KITCHEN, AND GARAGE RECEPTS SHALL BE PART OF A GFI CIRCUIT.
- 4.) ALL BEDROOM RECEPTS SHALL BE PART OF AN AFI CIRCUIT.

THESE DRAWINGS, AS INSTRUMENTS OF SERVICE, ARE THE SOLE PROPERTY OF HAYGOOD HOMES, INC., AND ARE NOT TO BE USED, COPIED OR REPRODUCED IN WHOLE OR IN PART FOR USE ON OR INCORPORATED WITHIN ANY OTHER JOB WITHOUT SPECIFIC AND INDIVIDUAL AUTHORIZATION BY HAYGOOD HOMES, INC..



HAYGOOD HOMES INC.

12592 So. U.S. HWY 441
LAKE CITY FL 32025
OFFICE (386) 752-3496
MOBILE (386) 303-1981
CR-C1326715

DERRICK AND VICKI TUELL


LAKE CITY FLORIDA

ELECTRICAL PLAN


PLAN No.	SCALE	DATE	SHEET NO.
P 0607	1/4" = 1'	04/02/06	4

...Project\Auto\Elect.dgn 6/20/2006 2:08:59 PM

Office copy

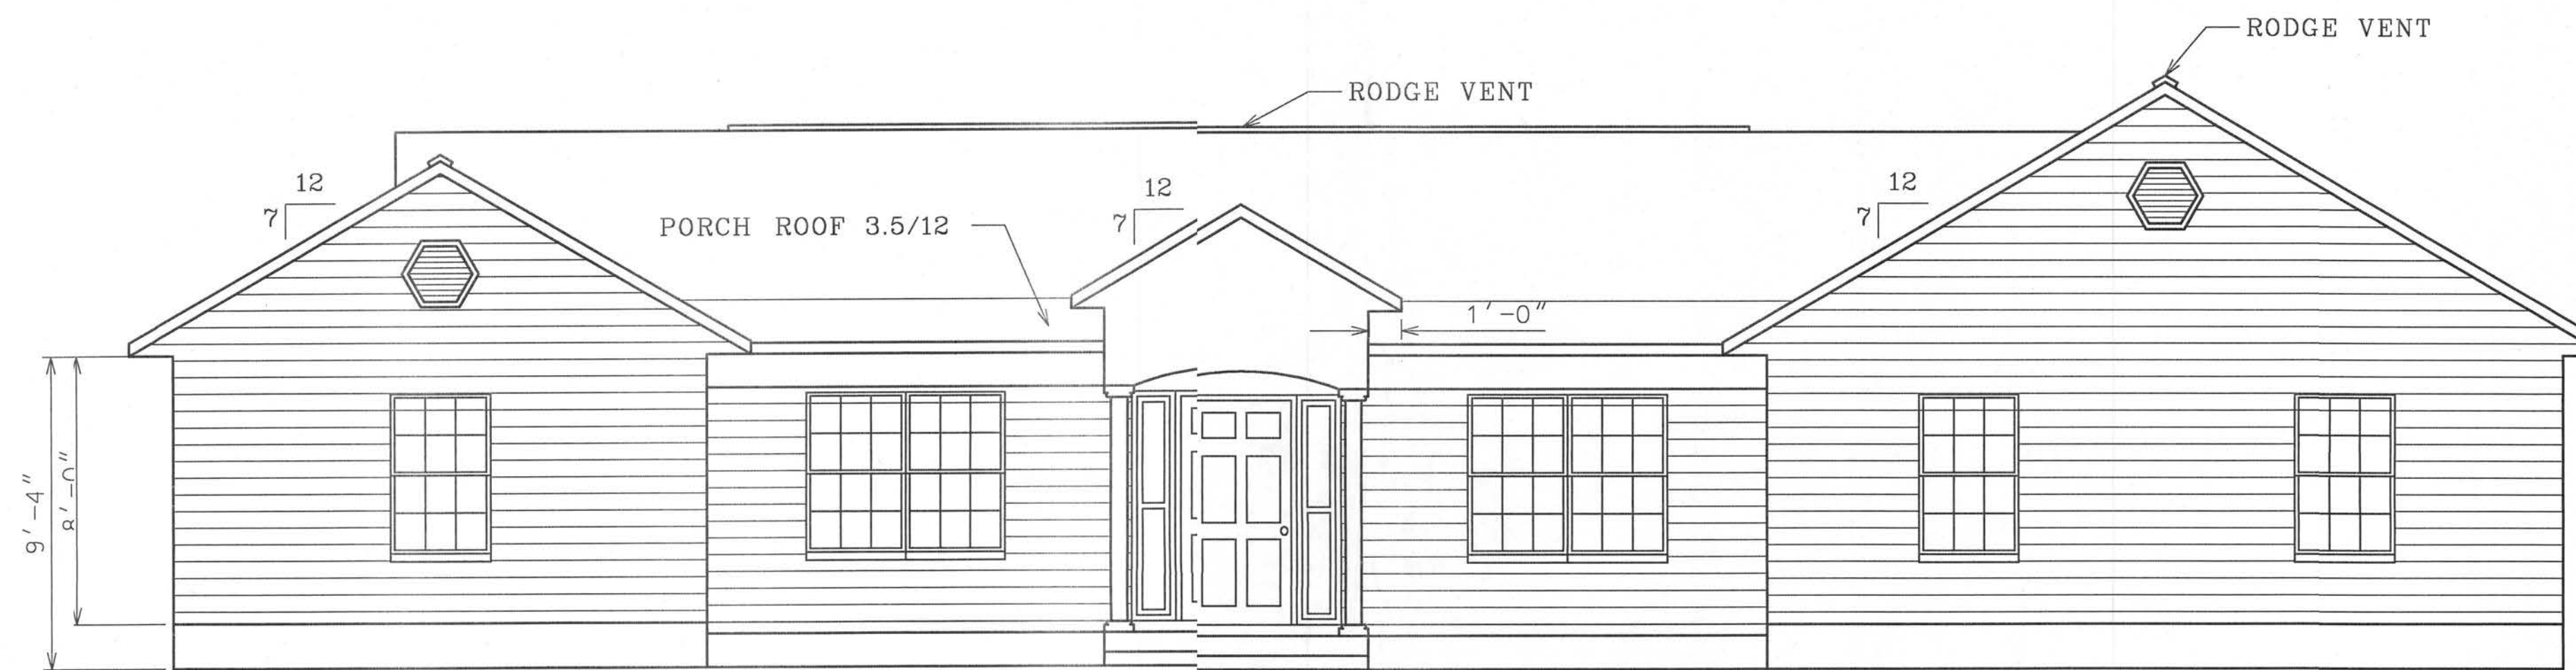

FRONT ELEVATION

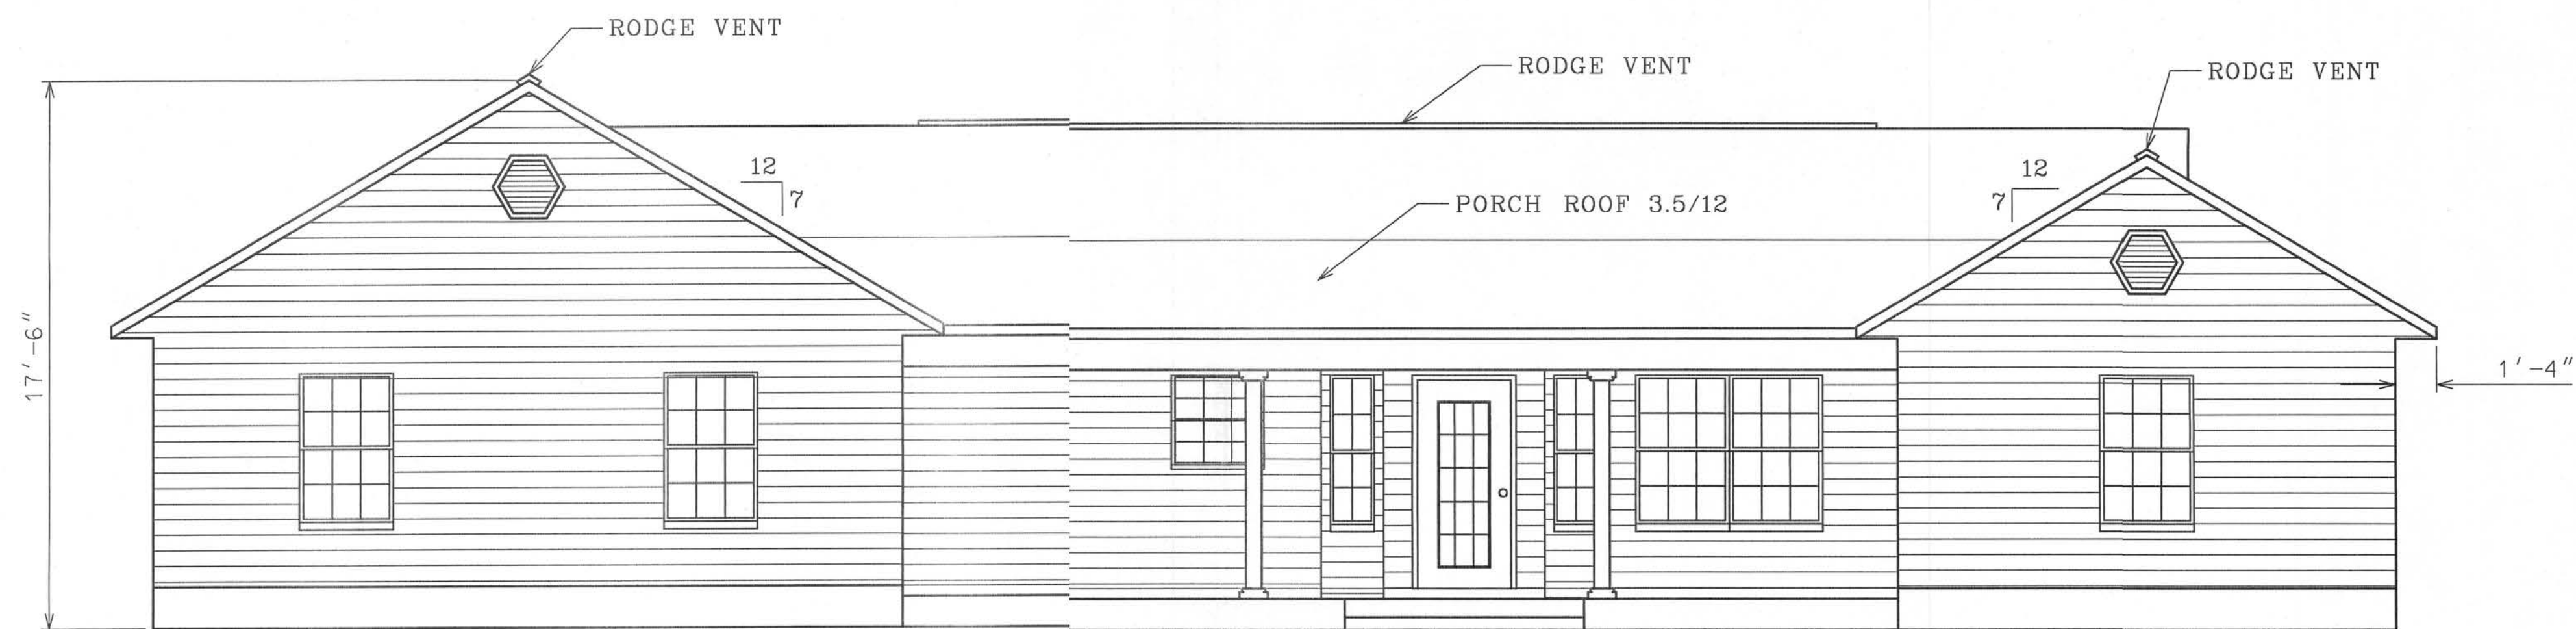

REAR ELEVATION

THESE DRAWINGS, AS INSTRUMENTS OF SERVICE, ARE THE SOLE PROPERTY OF HAYGOOD HOMES, INC., AND ARE NOT TO BE USED, COPIED OR REPRODUCED IN WHOLE OR IN PART FOR USE ON OR INCORPORATED WITHIN ANY OTHER JOB WITHOUT SPECIFIC AND INDIVIDUAL AUTHORIZATION BY HAYGOOD HOMES, INC.



HAYGOOD HOMES INC.


12592 So. U.S. HWY 441
LAKE CITY FL. 32025
OFFICE (386) 752-3496
MOBILE (386) 303-1981
CR-C1326715

DERICK AND VICKI TUELL
XXXXXXXXXXXXXXXXXX
LAKE CITY FLORIDA


ELEVATION

PLAN No.	SCALE	DATE	SHEET NO.
P 0607	1/4" = 1'	04/07/06	1

Projects\Tuell\Tuell.dgn 6/13/2006 8:57:56 PM

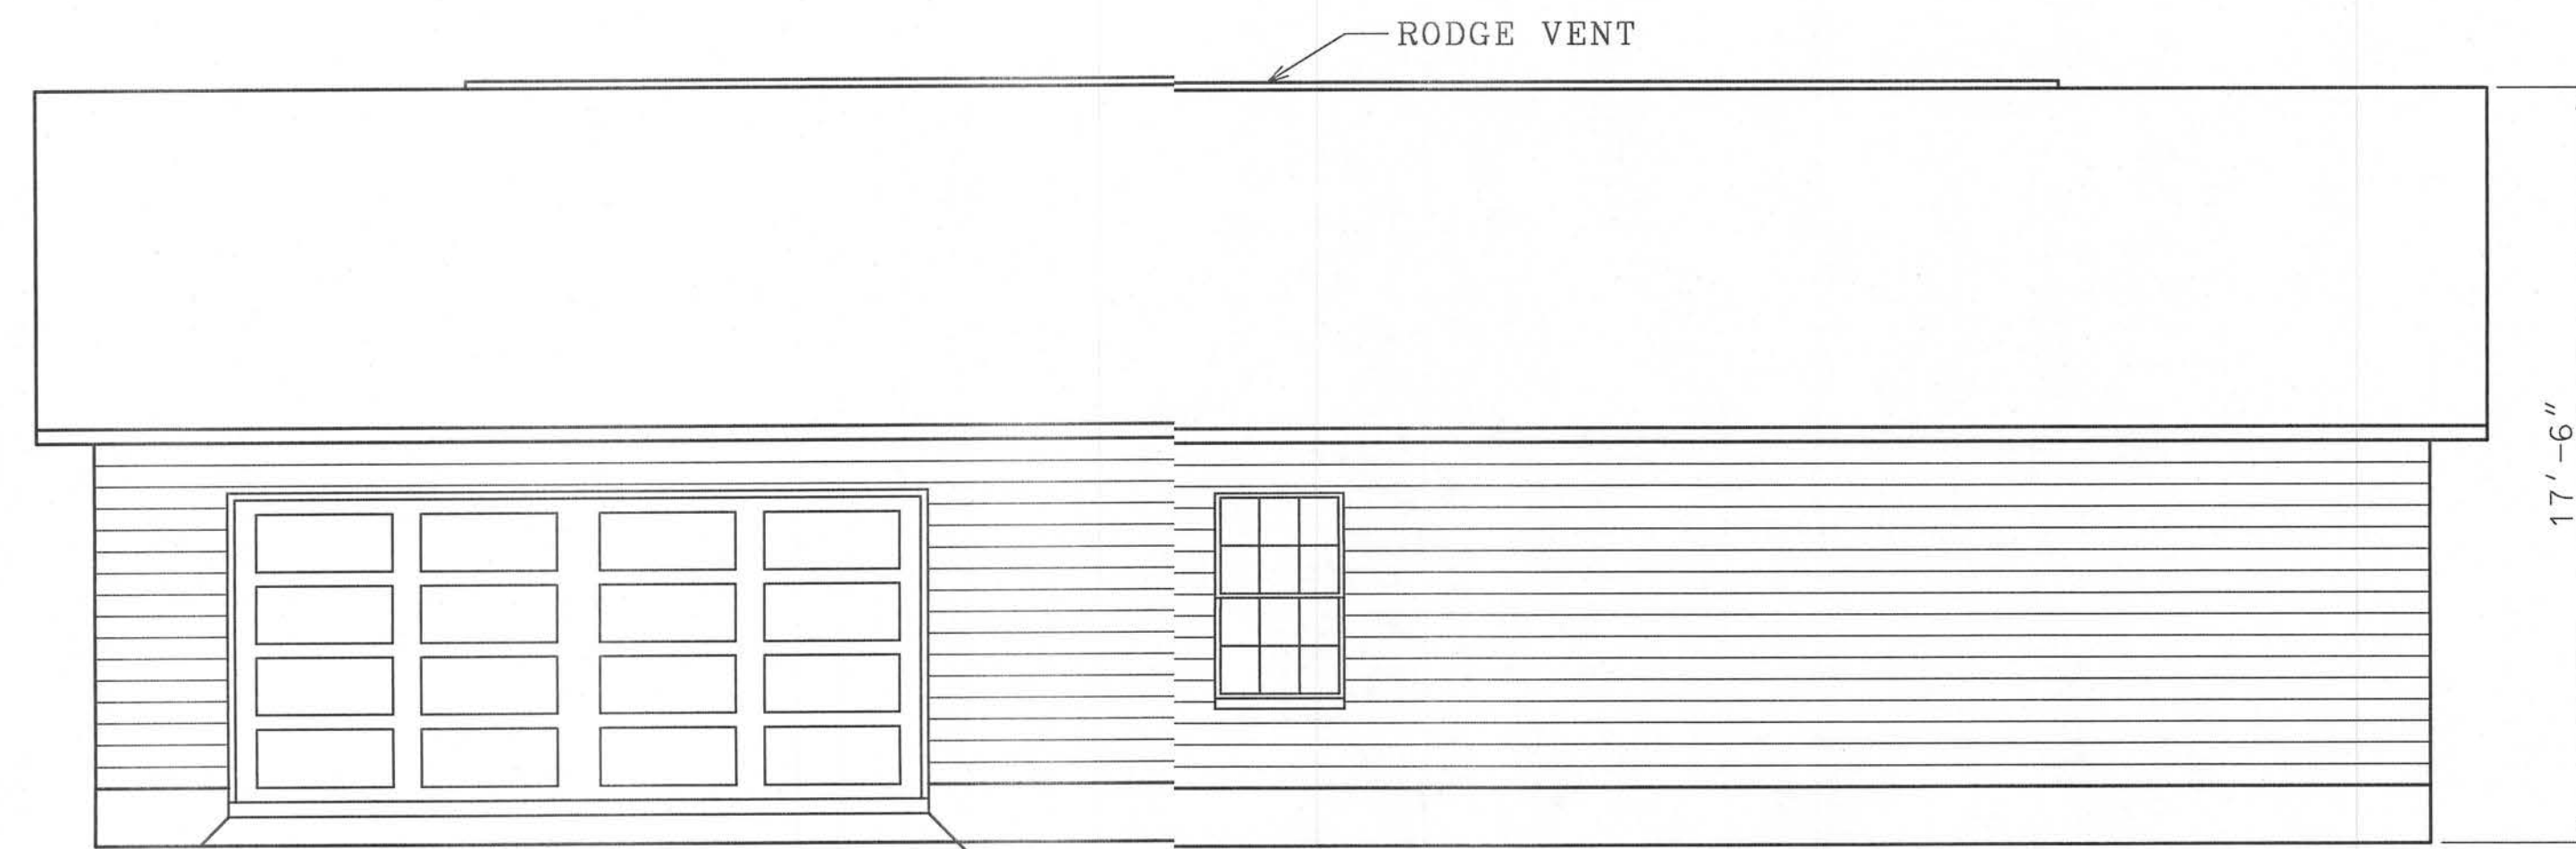

RIGHT ELEVATION

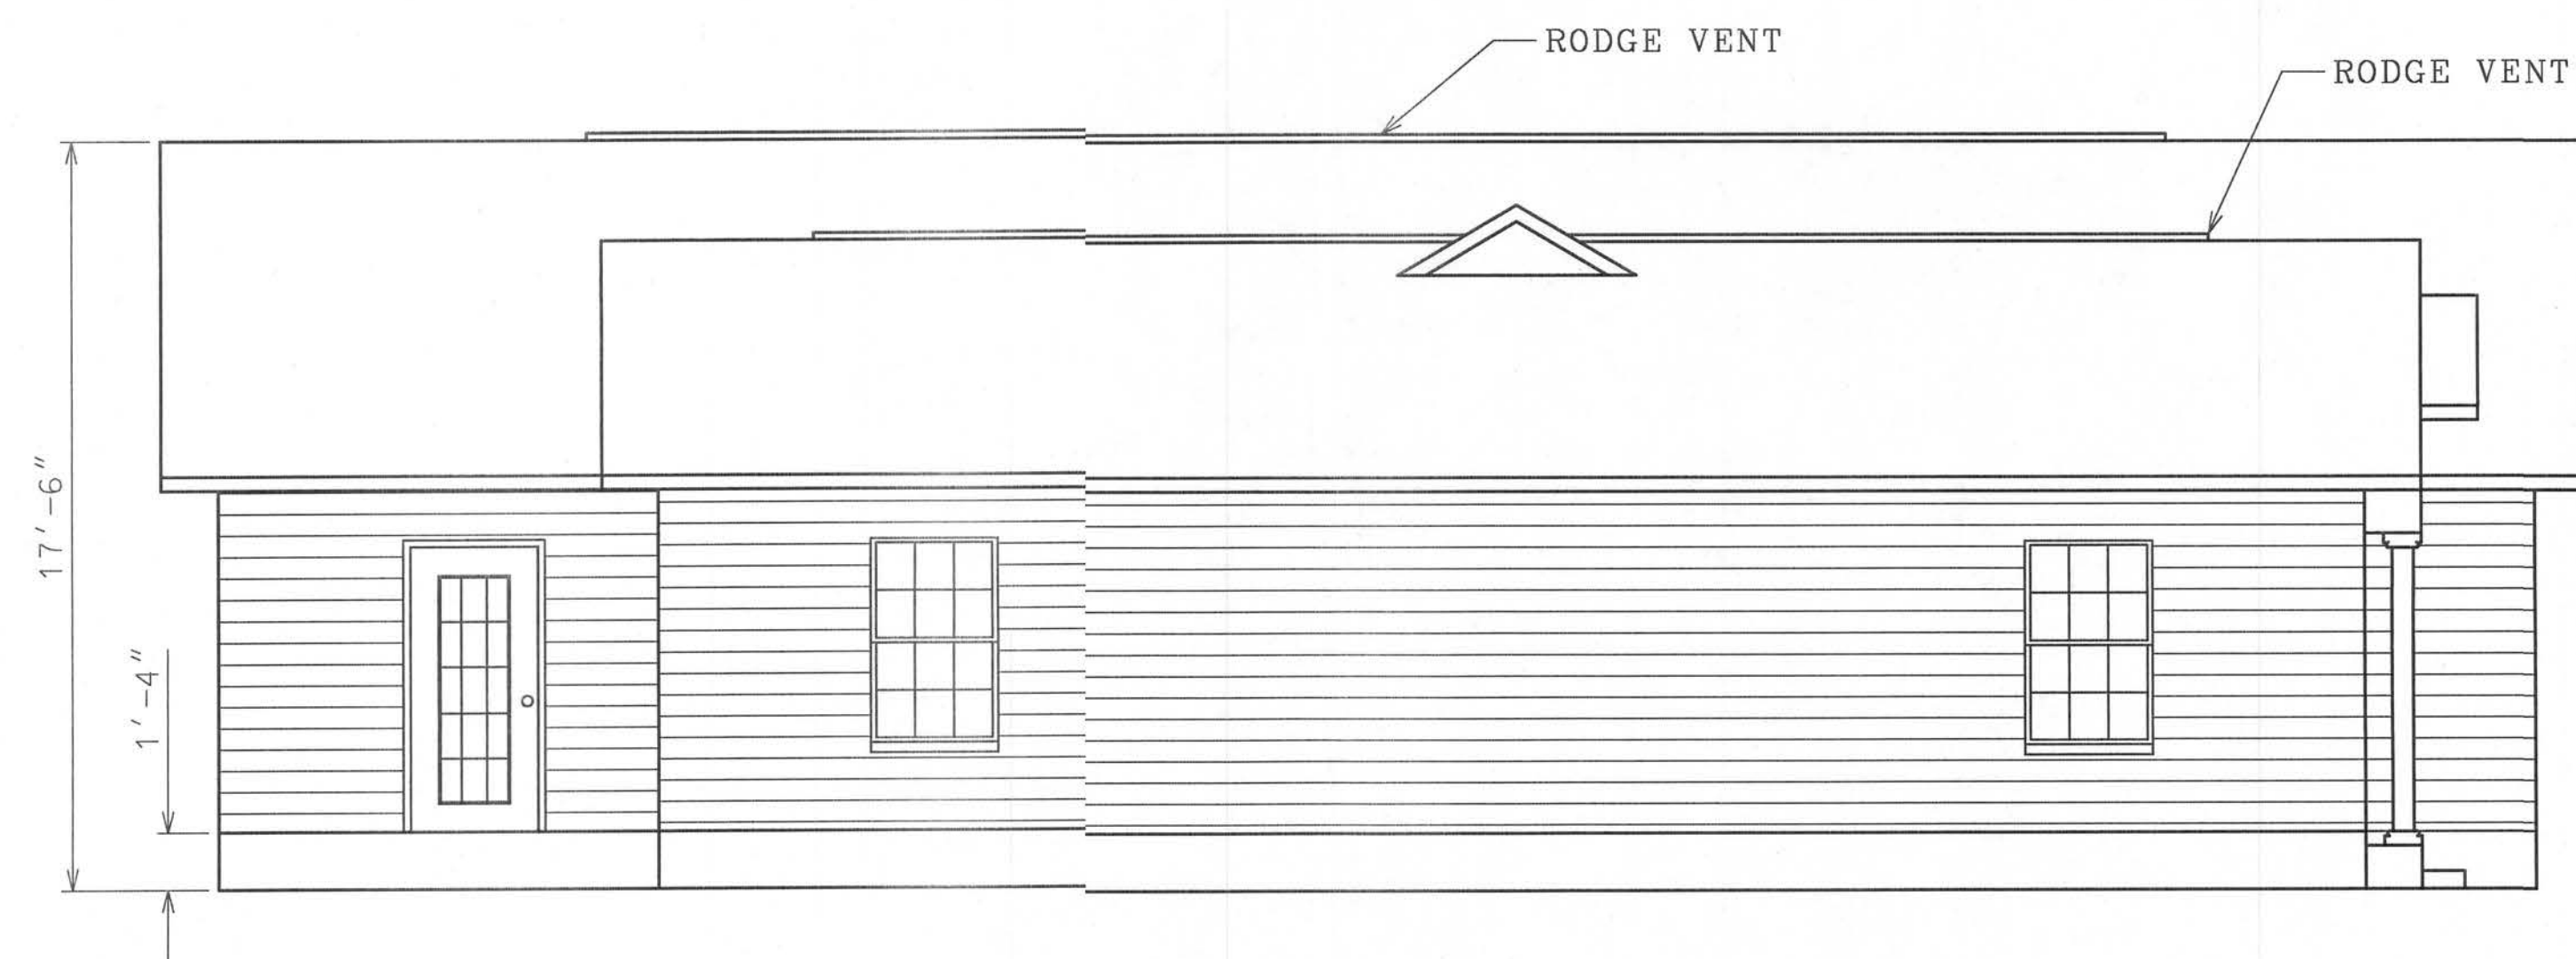

LEFT ELEVATION

THERES DRAWINGS, AS INSTRUMENTS OF SERVICE, ARE THE SOLE PROPERTY OF HAYGOOD HOMES, INC., AND ARE NOT TO BE USED, COPIED OR REPRODUCED IN WHOLE OR IN PART FOR USE ON OR INCORPORATED WITHIN ANY OTHER JOB WITHOUT SPECIFIC AND INDIVIDUAL AUTHORIZATION BY HAYGOOD HOMES, INC..




HAYGOOD HOMES INC.

12592 So. U.S. HWY 441
LAKE CITY FL 32025
OFFICE (386) 752-3496
MOBILE (386) 303-1981
CR-C1326715

DERICK AND VICKI TUELL
XXXXXXXXXXXXXXXXXX
LAKE CITY FLORIDA

ELEVATION

PLAN No.	SCALE	DATE	SHEET NO.
P 0607	1/4" = 1'	04/07/06	2

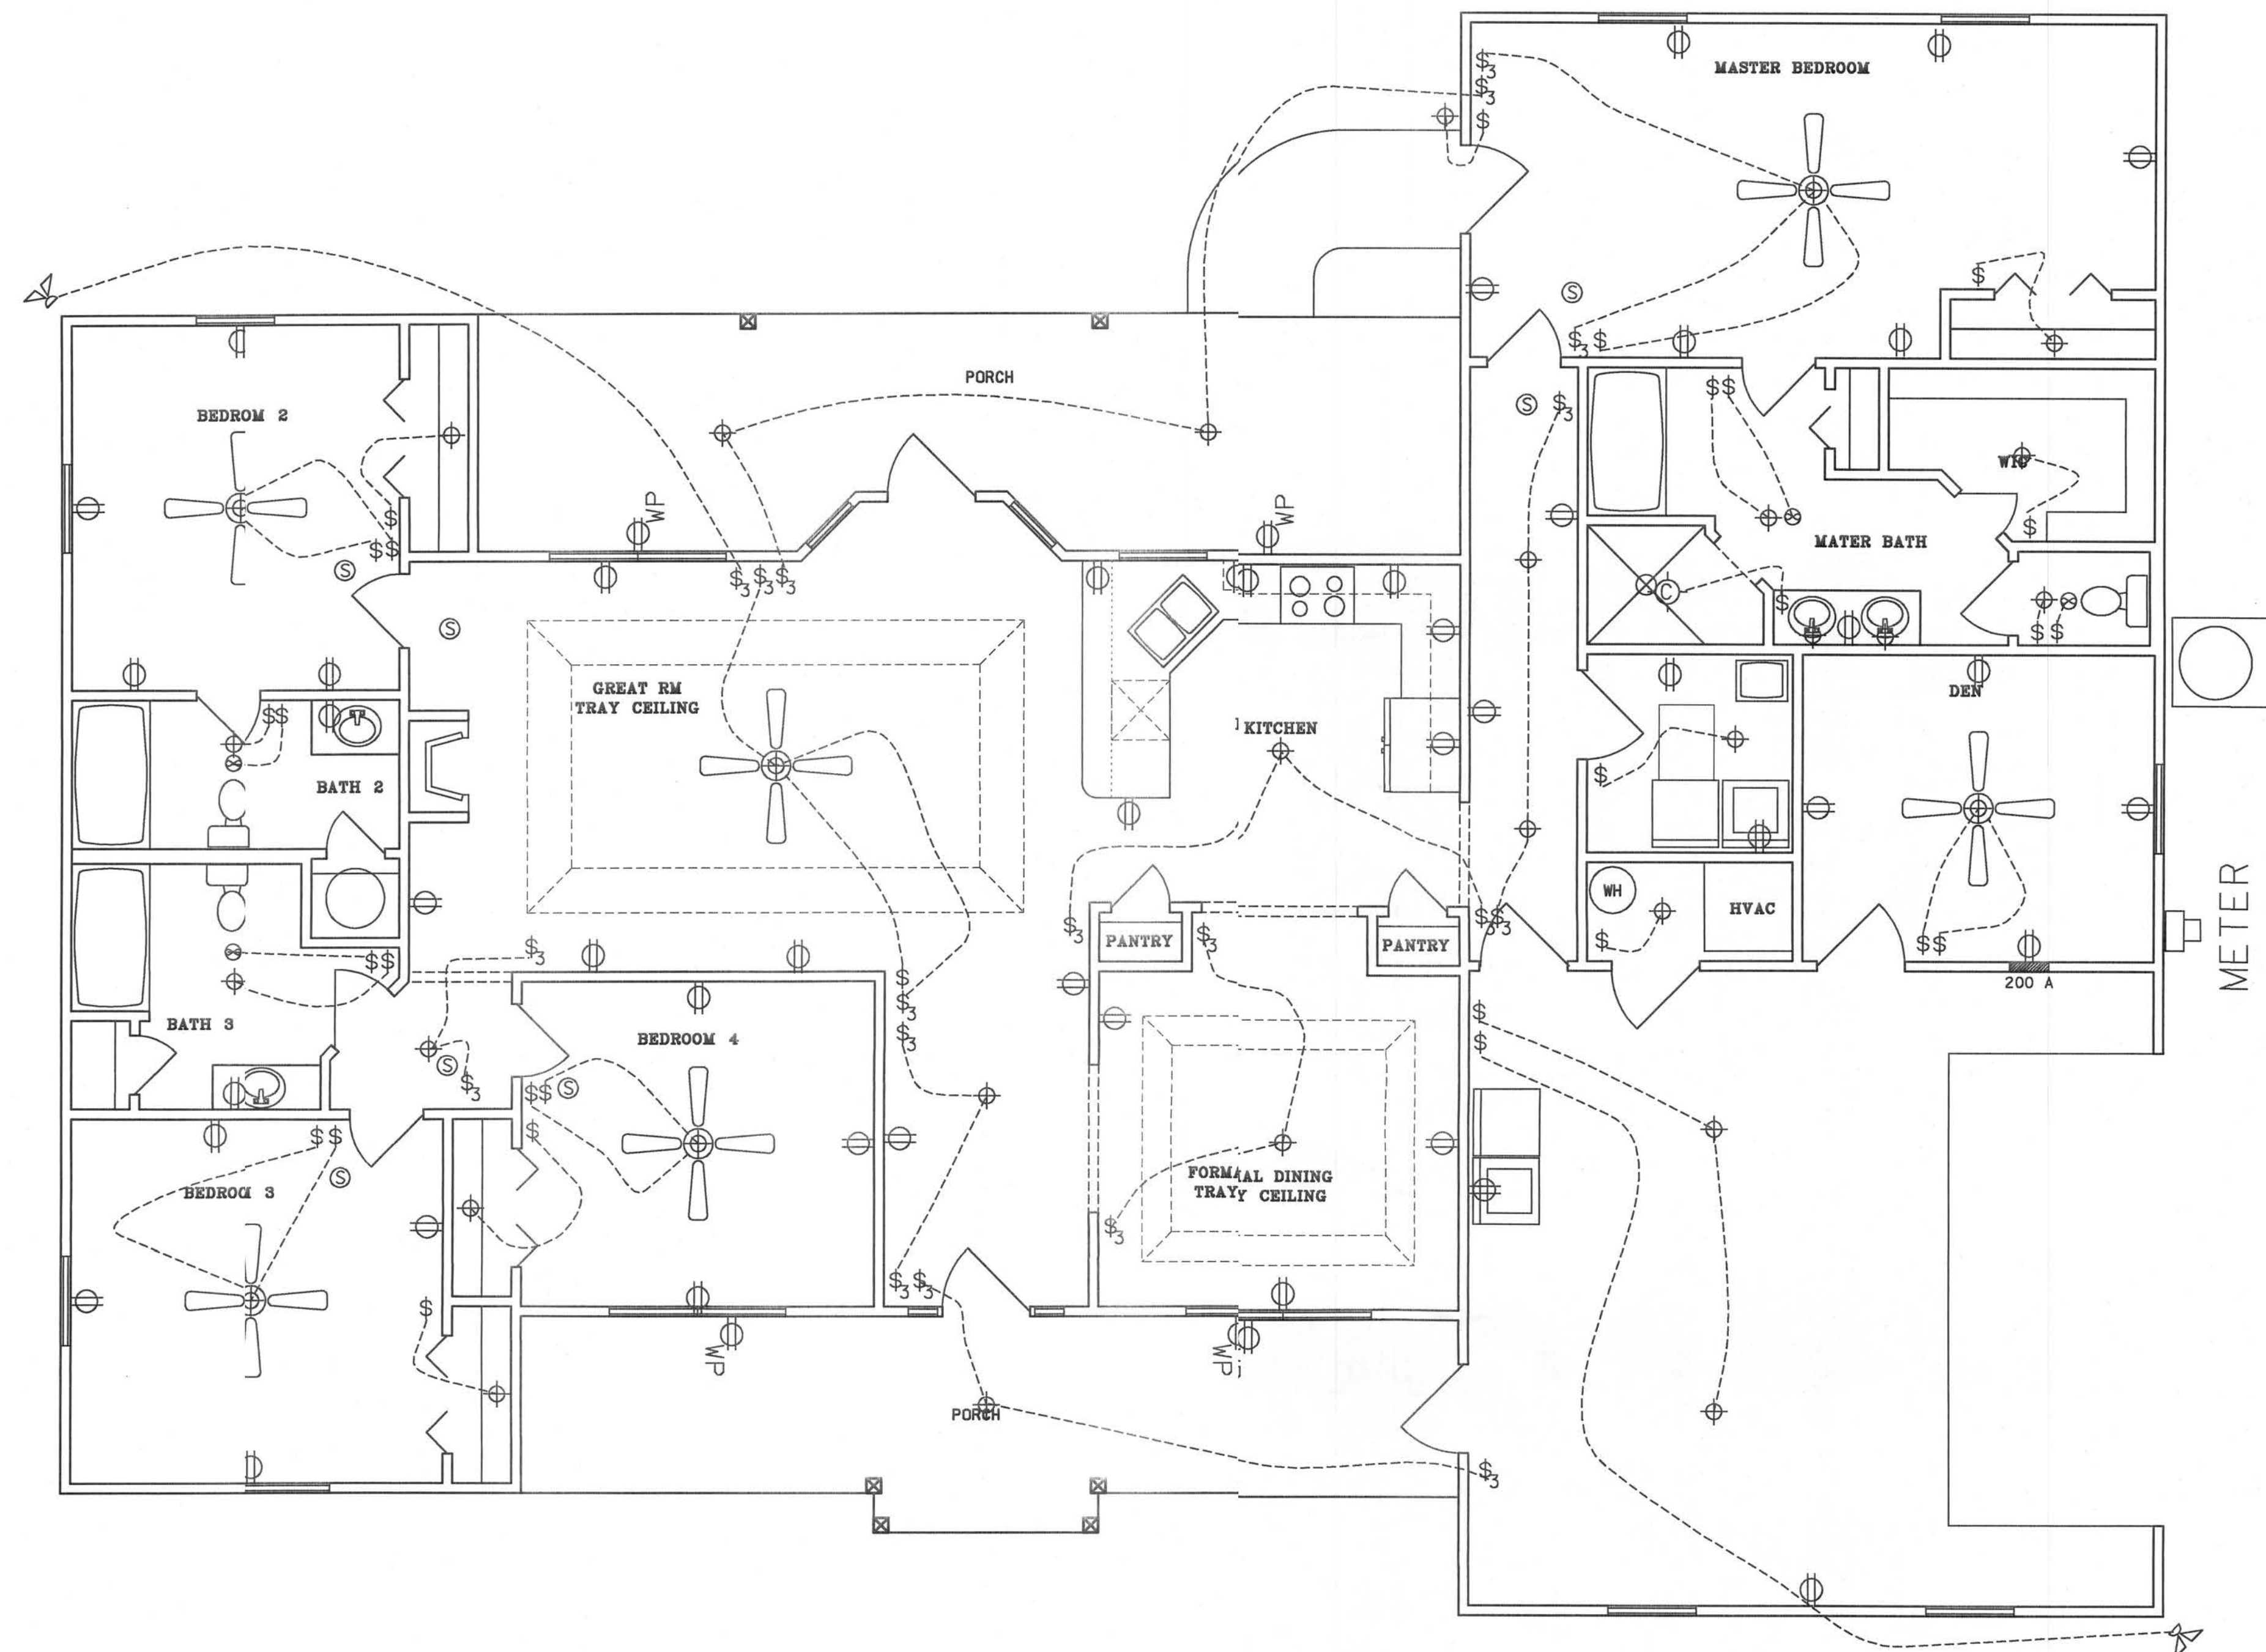

- ☐ - METER BASE
- - VANITY LIGHT AS SPECIFIED
- ⊕ - LIGHT FIXTURE
- ⊕ - CAN LIGHT FIXTURE
- \$ - SINGLE POLE SWITCH
- \$₃ - THREE-WAY SWITCH
- ⊕ - RECEPT.
- ⚡ - SECURITY LIGHT
- ⊗ - EXHAUST
- ⚡ - 220 V.
- Ⓢ - SMOKE DETECTOR (AC/DC and interconnected)
- ☎ - TELEPHONE
- ⚡ - TELEVISION

NOTE:

THE ELECTRICAL PLAN IS INTENDED TO SHOW SCHEMATICALLY THE LAYOUT OF THE ELECTRICAL COMPONENTS. FINAL LOCATIONS AND SIZING OF THE COMPONENTS SHALL BE THE RESPONSIBILITY OF A LICENSED ELECTRICAL CONTRACTOR. ALL WORK SHALL BE PERFORMED IN ACCORDANCE WITH ALL APPLICABLE CODES.

NOTES:

- 1.) PULL HOMERUNS OF TELEPHONE CABLE AND COAX CABLE TO COMMUNICATION PANEL (NO JUNCTIONS ALLOWED IN ATTIC)
- 2.) ALL EXTERIOR RECEPTACLES SHALL EITHER BE GFI RECPTS OR PART OF A GFI CIRCUIT. ALL EXTERIOR RECEPTACLES SHALL BE WEATHERPROOF.
- 3.) ALL BATHROOM, KITCHEN, AND GARAGE RECEPTS SHALL BE PART OF A GFI CIRCUIT.
- 4.) ALL BEDROOM RECEPTS SHALL BE PART OF AN AFI CIRCUIT.

THERES DRAWINGS, AS INSTRUMENTS OF SERVICE, ARE THE SOLE PROPERTY OF HAYGOOD HOMES, INC.. AND ARE MAY NOT BE USED, COPIED OR REPRODUCED IN WHOLE OR IN PART FOR USE ON OR INCORPORATED WITHIN ANY OTHER JOB WITHOUT SECIFIC AND INDIVIDUAL AUTHORIZATION BY HAYGOOD HOMES, INC..



HAYGOOD HOMES INC.


12592 So. U.S. HWY 441
LAKE CITY FL. 32025
OFFICE (386) 752-3496
MOBILE (386) 303-1981
CR-C1326715

DERICK AND VICKI TUELL


LAKE CITY FLORIDA

ELECTRICAL PLAN

PLAN No.	SCALE	DATE	SHEET NO.
P 0607	1/4" = 1'	04/02/06	4

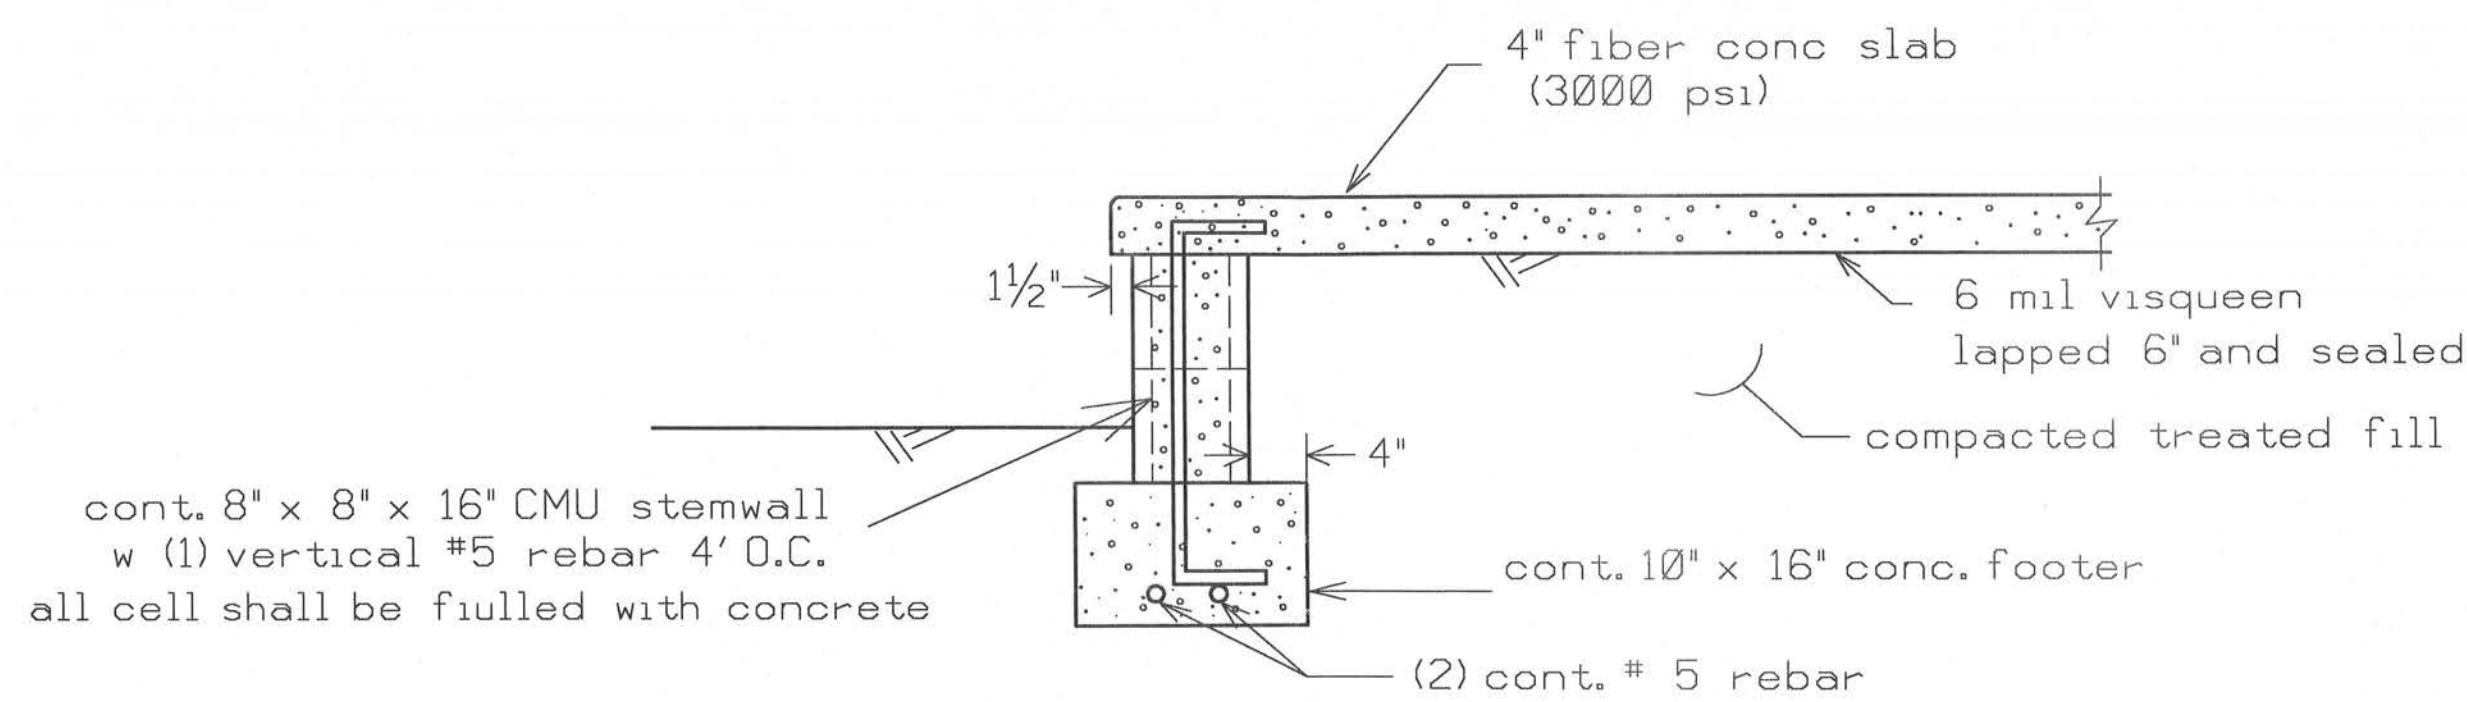

PORCH FOUNDATION(N.T.S.)

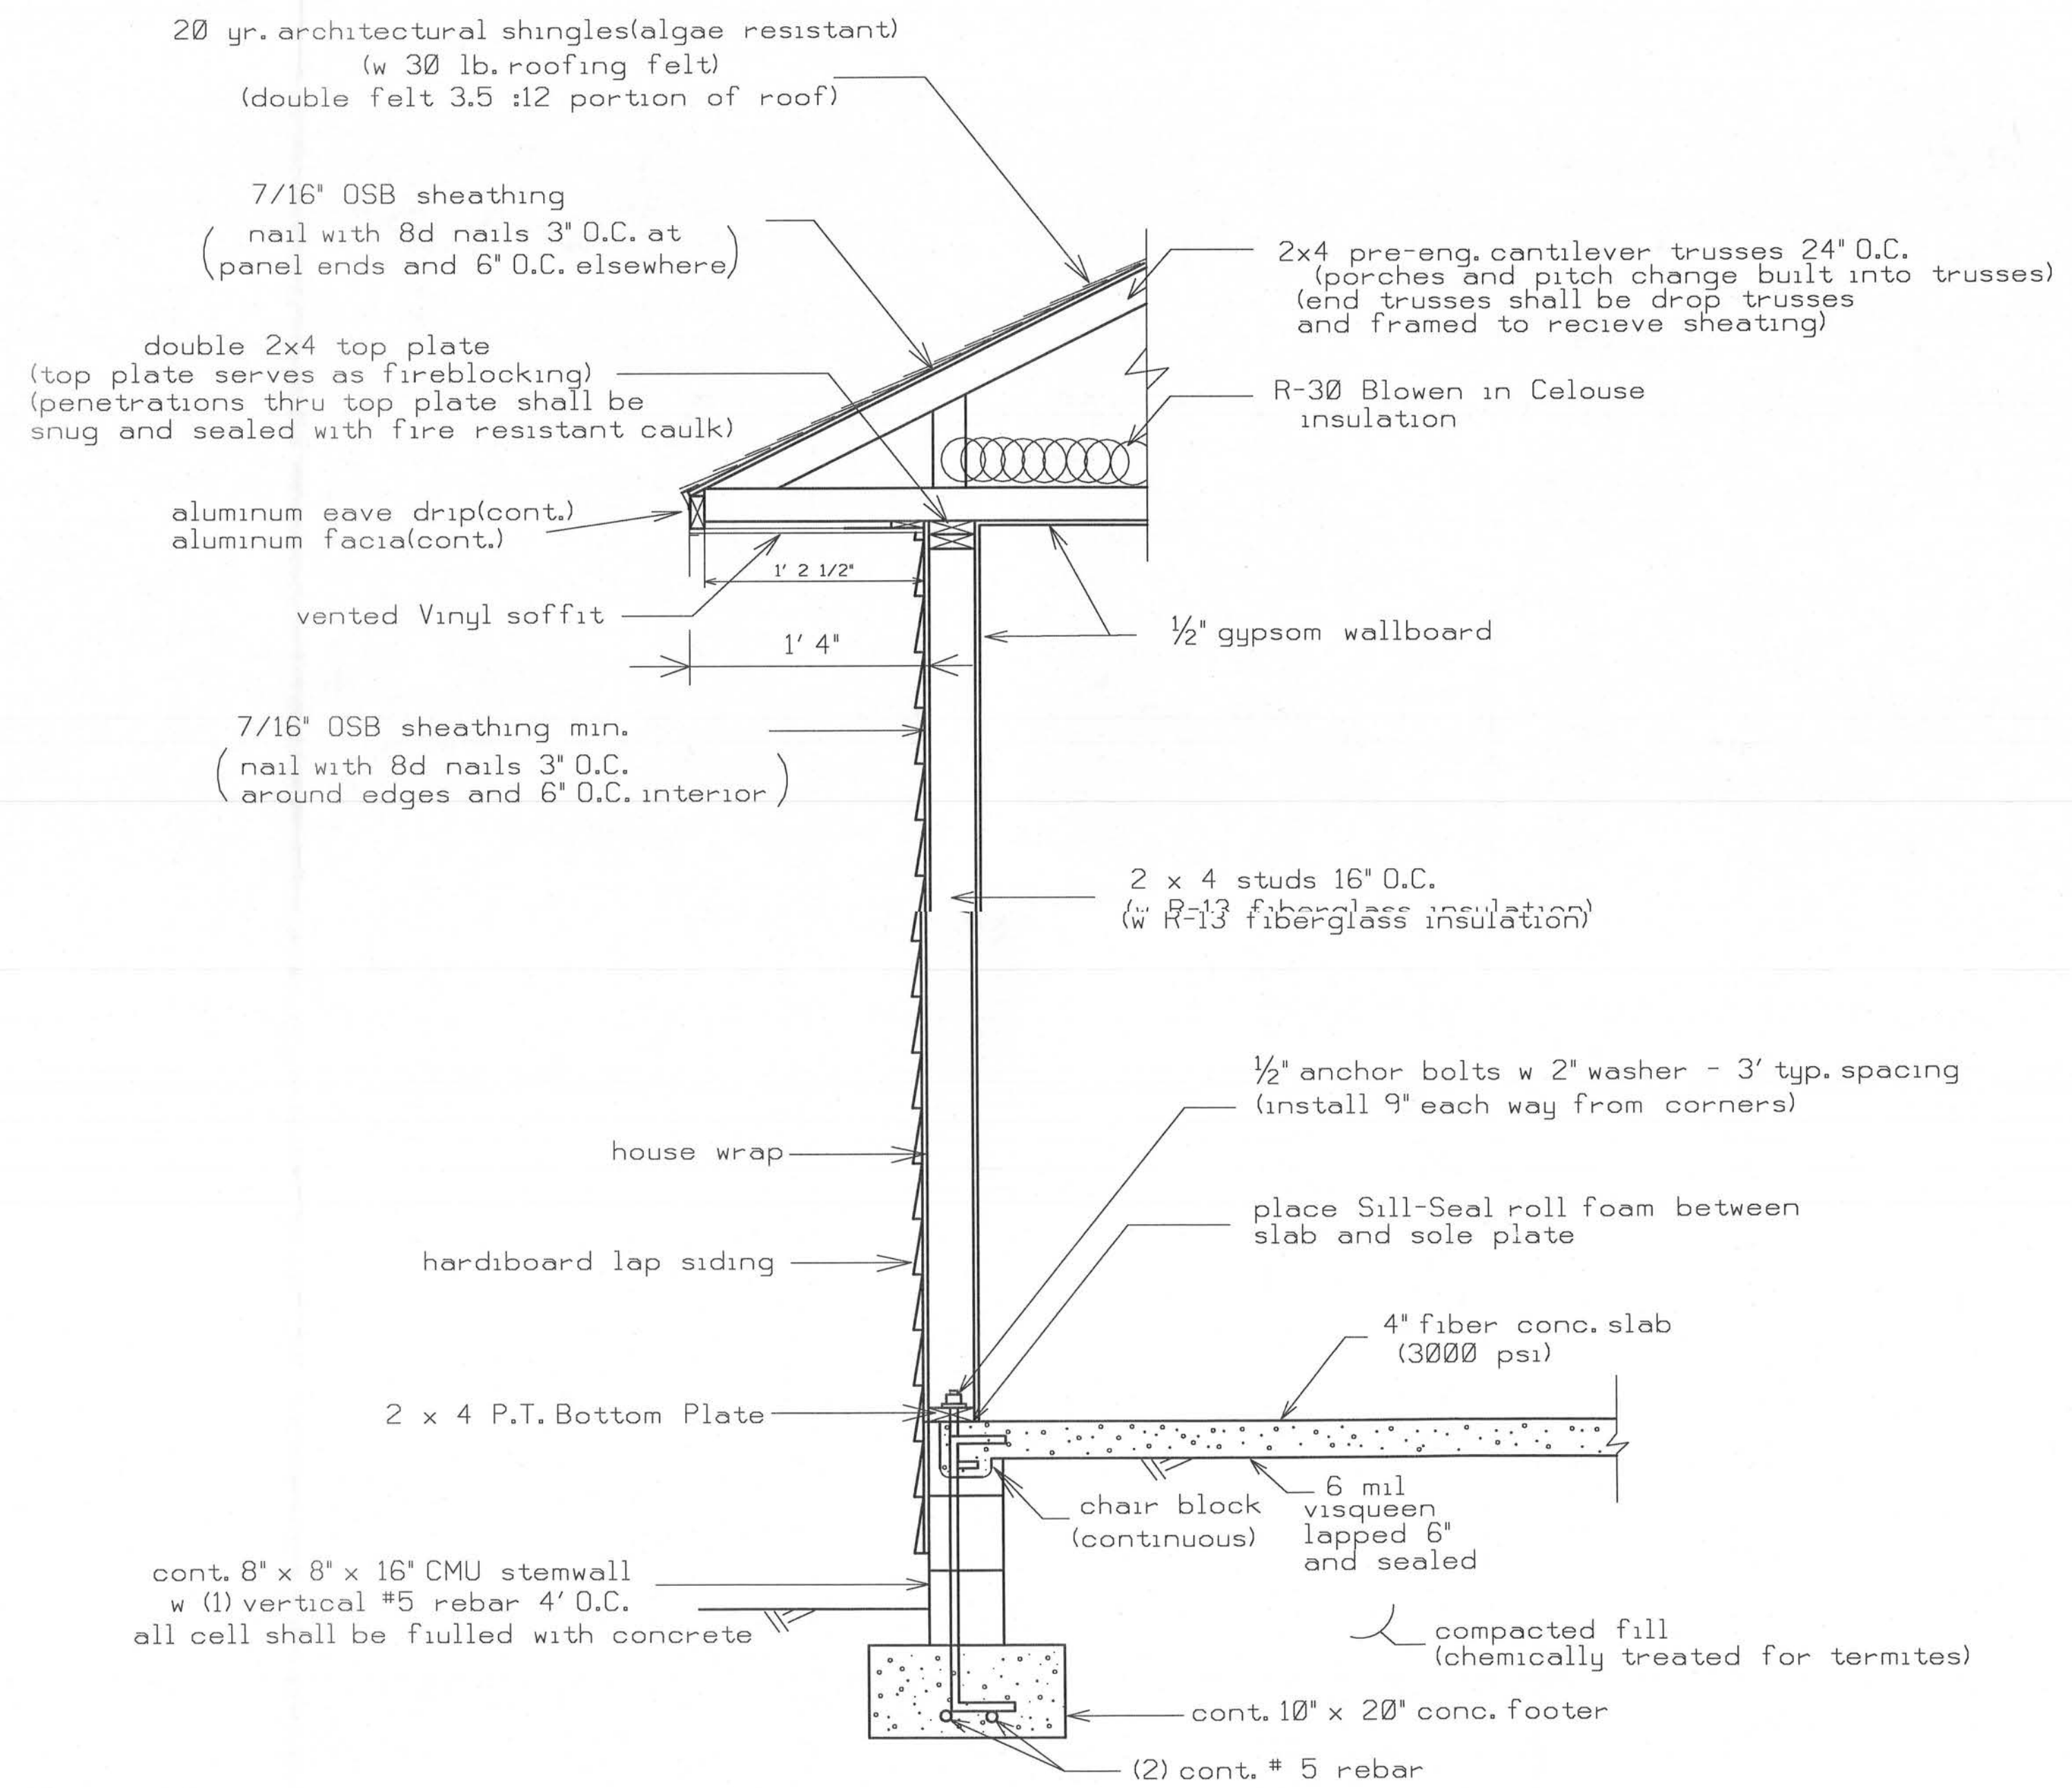

FOOTER DESIGN 1000 PSF

WALL DETAIL (TYP.) (N.T.S.)

HEADER SIZES/MATERIAL SHALL BE AS FOLLOWS:

WINDOW AND DOOR OPENINGS(2 - #2 SYP 2X12's with 1/2" plywood between)
PORCH BEAMS (2 - #2 SYP 2X10's with 1/2" plywood between)

THESE DRAWINGS, AS INSTRUMENTS OF SERVICE, ARE THE SOLE PROPERTY OF HAYGOOD HOMES, INC., AND ARE NOT TO BE USED, COPIED OR REPRODUCED IN WHOLE OR IN PART FOR USE ON OR INCORPORATED WITHIN ANY OTHER JOB WITHOUT SPECIFIC AND INDIVIDUAL AUTHORIZATION BY HAYGOOD HOMES, INC..



HAYGOOD HOMES INC.

12592 So. U.S. HWY 441
LAKE CITY FL. 32025
OFFICE (386) 752-3496
MOBILE (386) 303-1981
CR-C1326715

DERICK AND VICKI TUELL

LAKE CITY FLORIDA

DETAILS

PLAN No.	SCALE	DATE	SHEET NO.
P 0607	1/4" = 1'	04/09/06	5

...\\Project\\Tuell\\TUELL.dwg 6/13/2006 9:00:35 PM



LAKE CITY FLORIDA
DERICK AND VICKI TWEET

FOUNDATION PLAN

PLAN NO.	SCALE	DATE	SHEET NO.
P 0607	1/4" = 1'	04/02/06	6

THESE DRAWINGS, AS INSTRUMENTS OF SERVICE, ARE THE SOLE PROPERTY OF HAYGOOD HOMES, INC., AND ARE MAY NOT BE USED, COPIED OR REPRODUCED IN WHOLE OR IN PART FOR USE ON OR INCORPORATED WITHIN ANY OTHER JOB WITHOUT SPECIFIC AND INDIVIDUAL AUTHORIZATION BY HAYGOOD HOMES, INC..

