

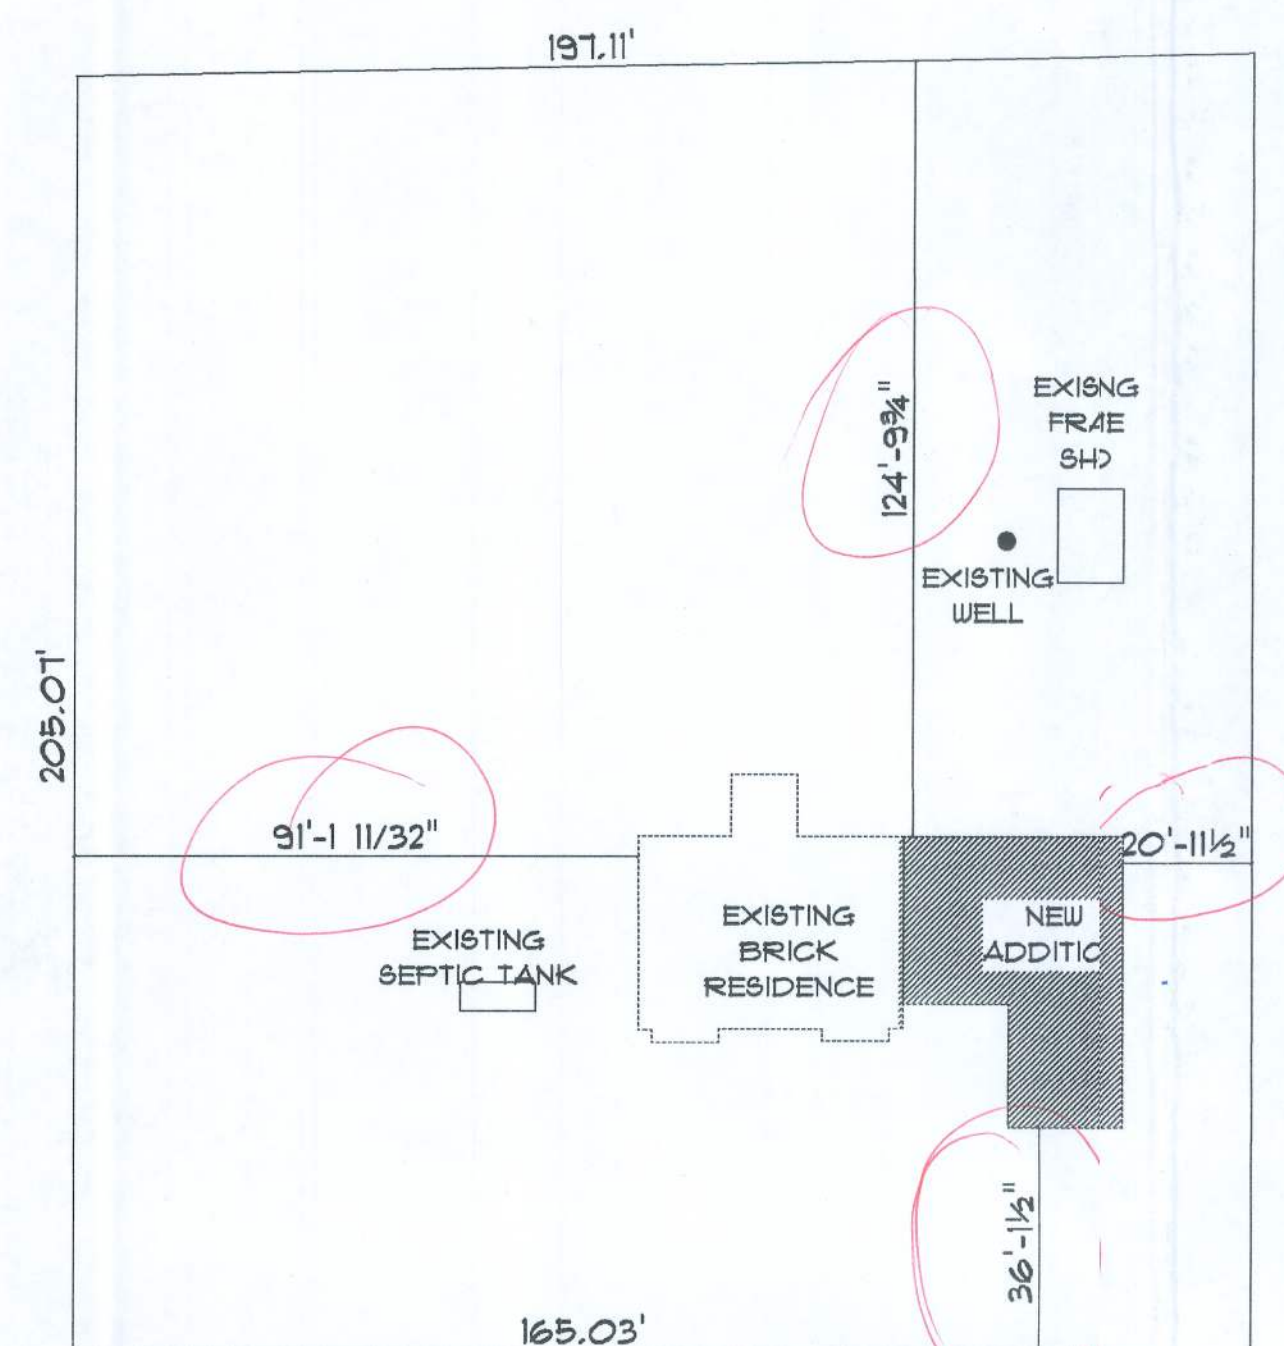


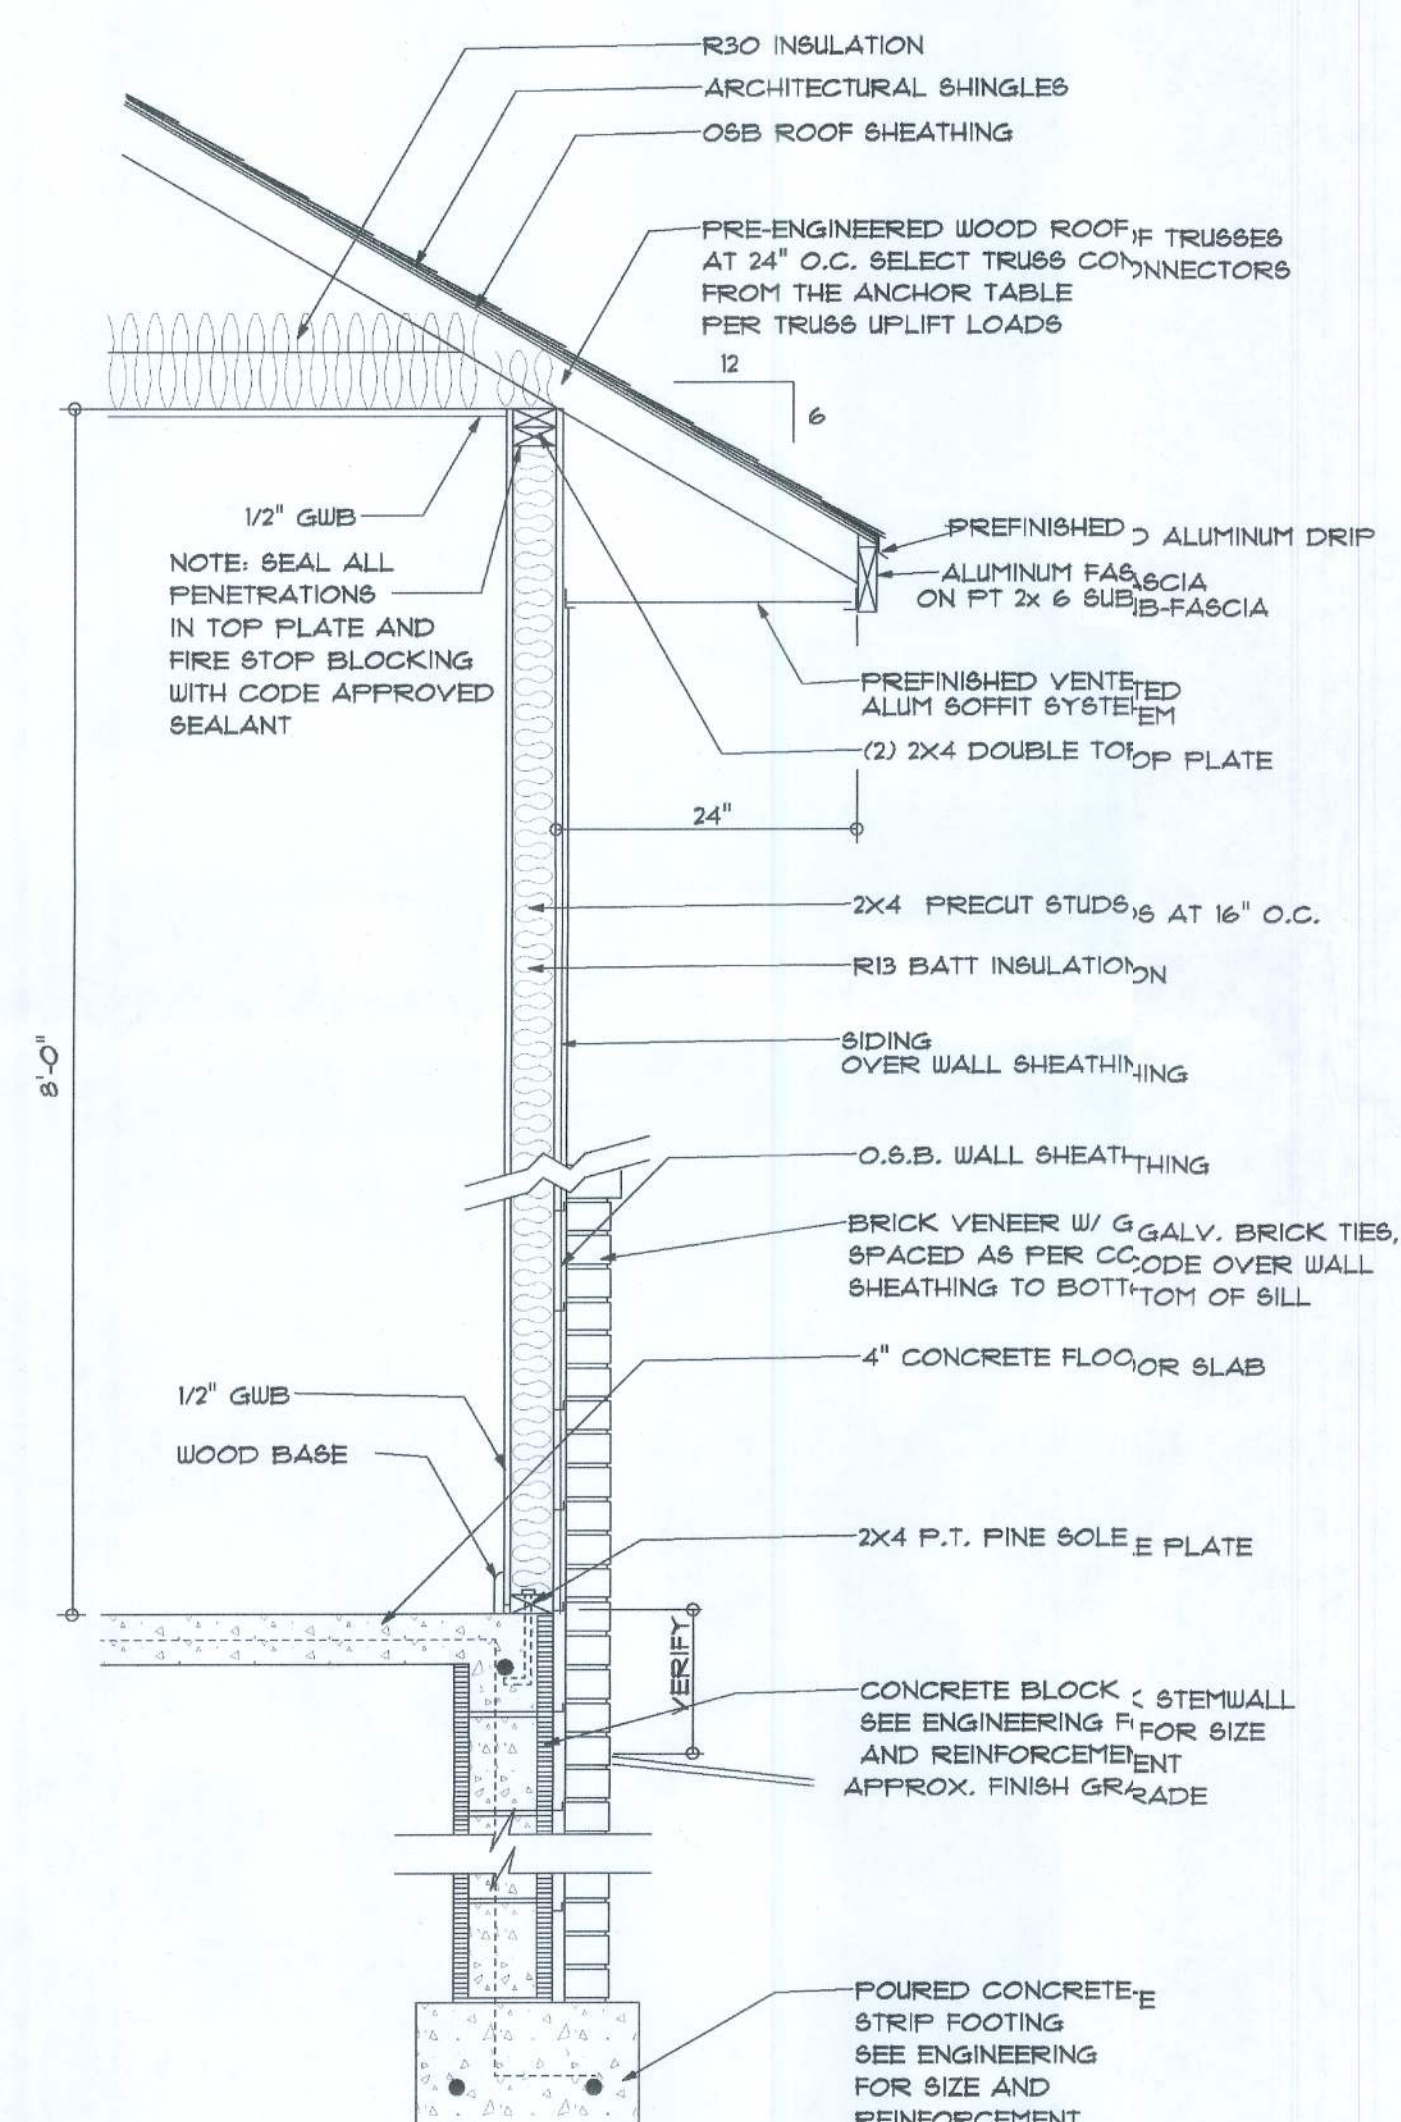

BOUNDARY SURVEY IN SECTION 14, TOWNSHIP 4 SOUTH
RANGE 16 EAST, COLUMBIA COUNTY FLORIDA

* SITE PLAN *


SCALE : 1" = 60'

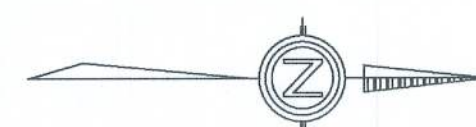

TYPICAL DESIGN WALL SECTION
NON - STRUCTURAL DATA

N.T.S.

EXISTING
FOUDATION

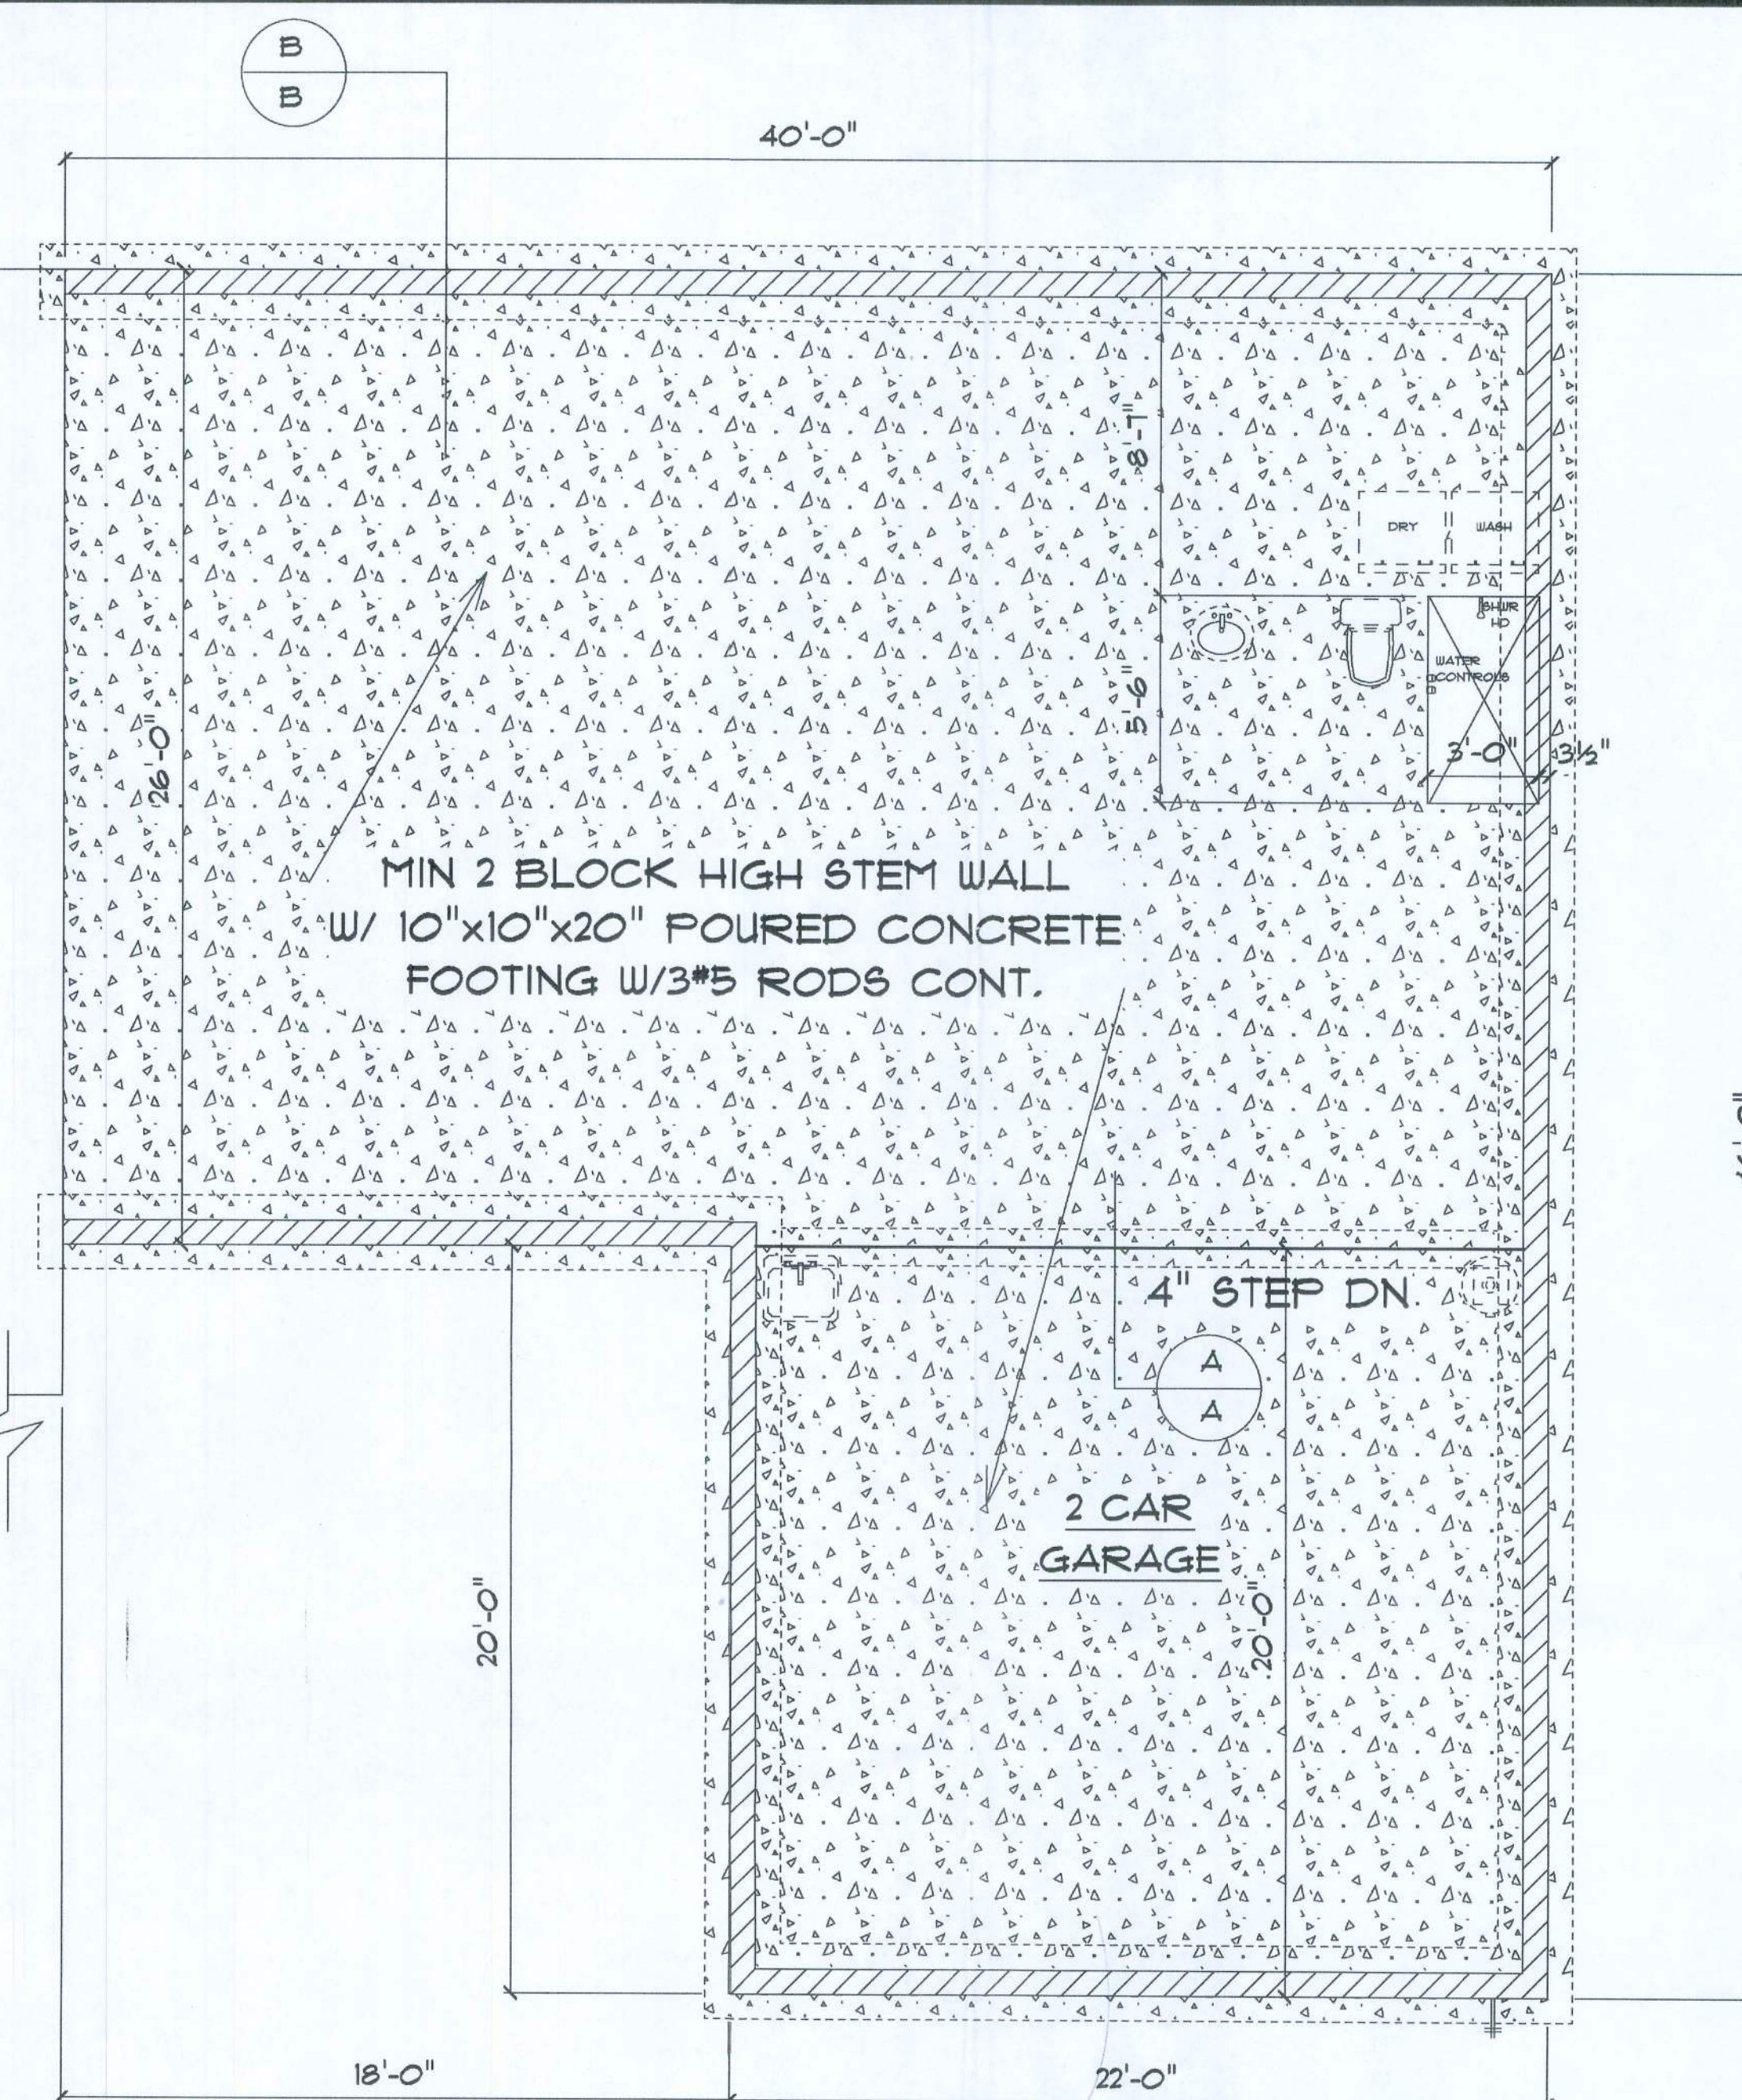


* PARTIAL FOUNDATION PLAN *


SCALE : 1/4" = 1'-0"

IMPORTANT NOTE:

1. IT IS THE BUILDERS RESPONSIBILITY TO VERIFY ALL GEOMETRY AND DIMENSIONS BEFORE ORDERING ANY MATERIALS OR BEGINNING CONSTRUCTION.
2. THESE PLANS ARE FOR LAYOUT AND DESIGN PURPOSES ONLY ALL STRUCTURAL NOTES AND DETAILS TO BE PROVIDED BY AN ENGINEER.

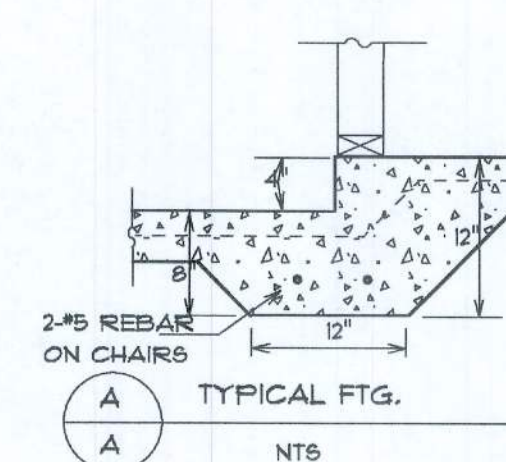

TYPICAL FTG.
N.T.S.

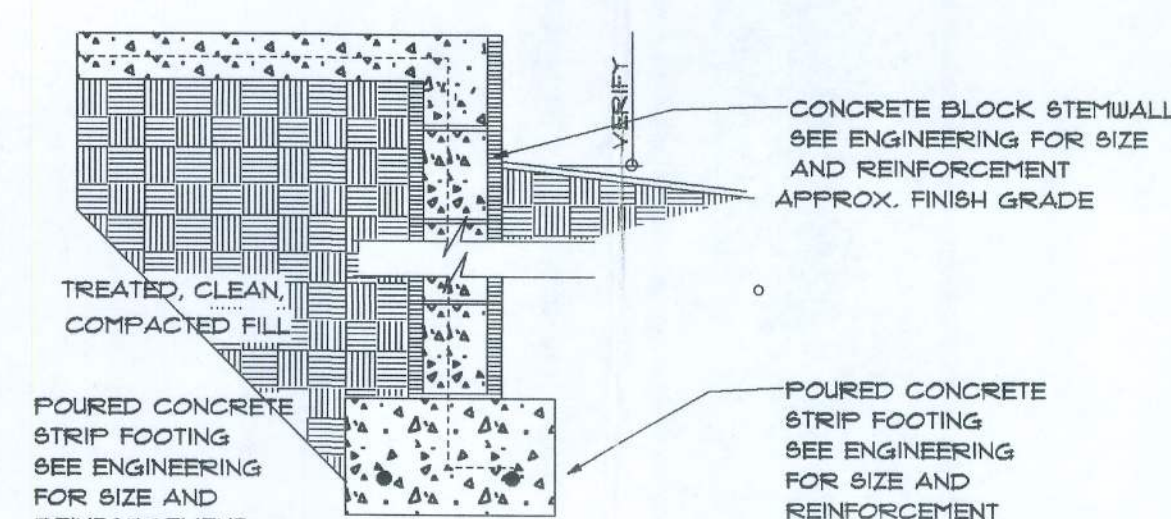

TYPICAL FTG.
N.T.S.

ADDITON
for
FRED PIERCE

IN

COLUMBIA COUNTY,
FLORIDA

Teena M. Ruffo
6429 NW Lake Jeffery Rd
Lake City, Florida 32025
Phone: (386) 73 - 4944
Cell: (386) 871 - 1191
Email: trarchdes@msn.com

PRINTED DATE:
July 30, 2011

DRAWN BY: Teena M. Ruffo
CHECKED BY:

BUILDING CONTRACTOR

FINALS DATE:


JOB NUMBER:

DRAWING NUMBER

A-1

OF 2 SHEETS







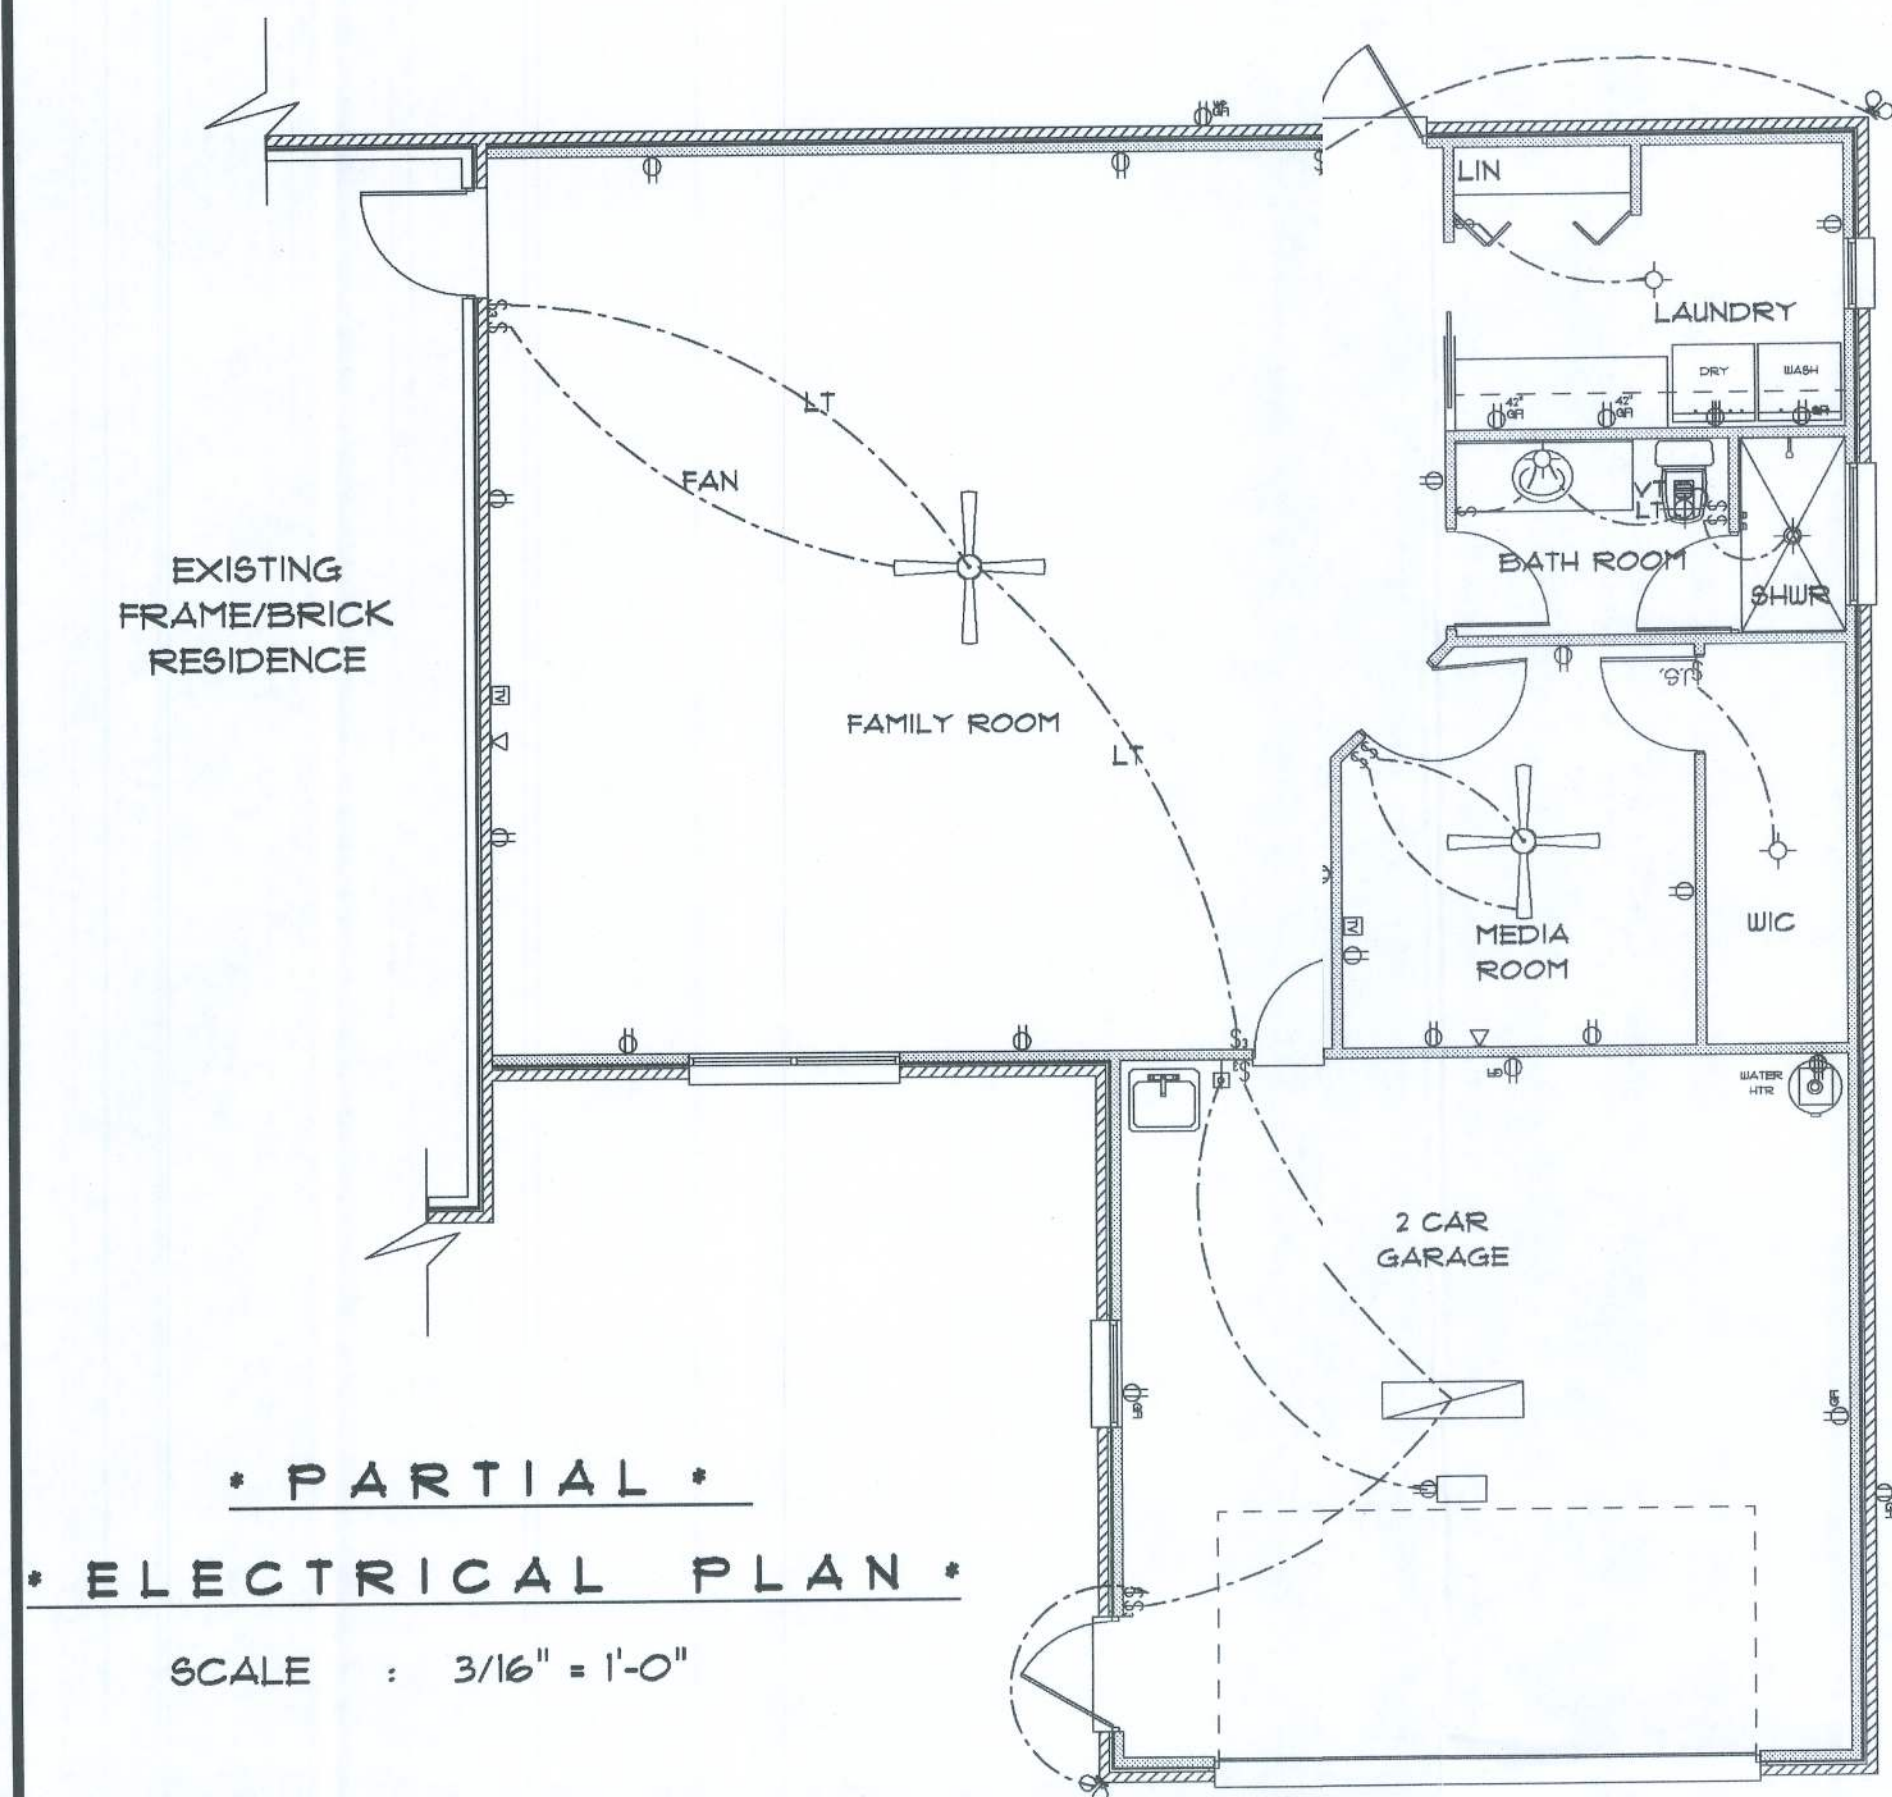

ELECTRICAL PLAN NOTES

- E-1 WIRE ALL APPLIANCES, HVAC UNITS AND OTHER EQUIPMENT PER MANUFACTURER'S SPECIFICATIONS.
- E-2 ALL INSTALLATIONS SHALL BE PER NATIONAL ELECTRIC CODE.
- E-3 TELEPHONE, TELEVISION AND OTHER LOW VOLTAGE DEVICES OR OUTLETS SHALL BE AS PER THE OWNER'S DIRECTION AND IN ACCORDANCE WITH APPLICABLE SECTIONS OF NATIONAL ELCT. CODE LATEST EDITION.
- E-4 ELECTRICAL CONTRACTOR SHALL BE RESPONSIBLE FOR THE DESIGN AND SIZING OF ELECTRICAL SERVICE AND CIRCUITS.

ELECTRICAL	COUNT	SYMBOL
ceiling fan globe 2	2	+
double spotlight	2	•
fluorescent fixture	1	⎓
automatic garage dr opener	1	⓪
cable tv outlet	2	•
garage dr opener	1	⓪
GFI waterproof outlet	2	•
lamp switch	1	•
light	3	•
outlet	14	•
outlet 220v	2	•
outlet GFI	6	•
recessed can light	1	•
switch	9	•
switch 3 way	4	•
telephone	2	•
vent light combo	1	•

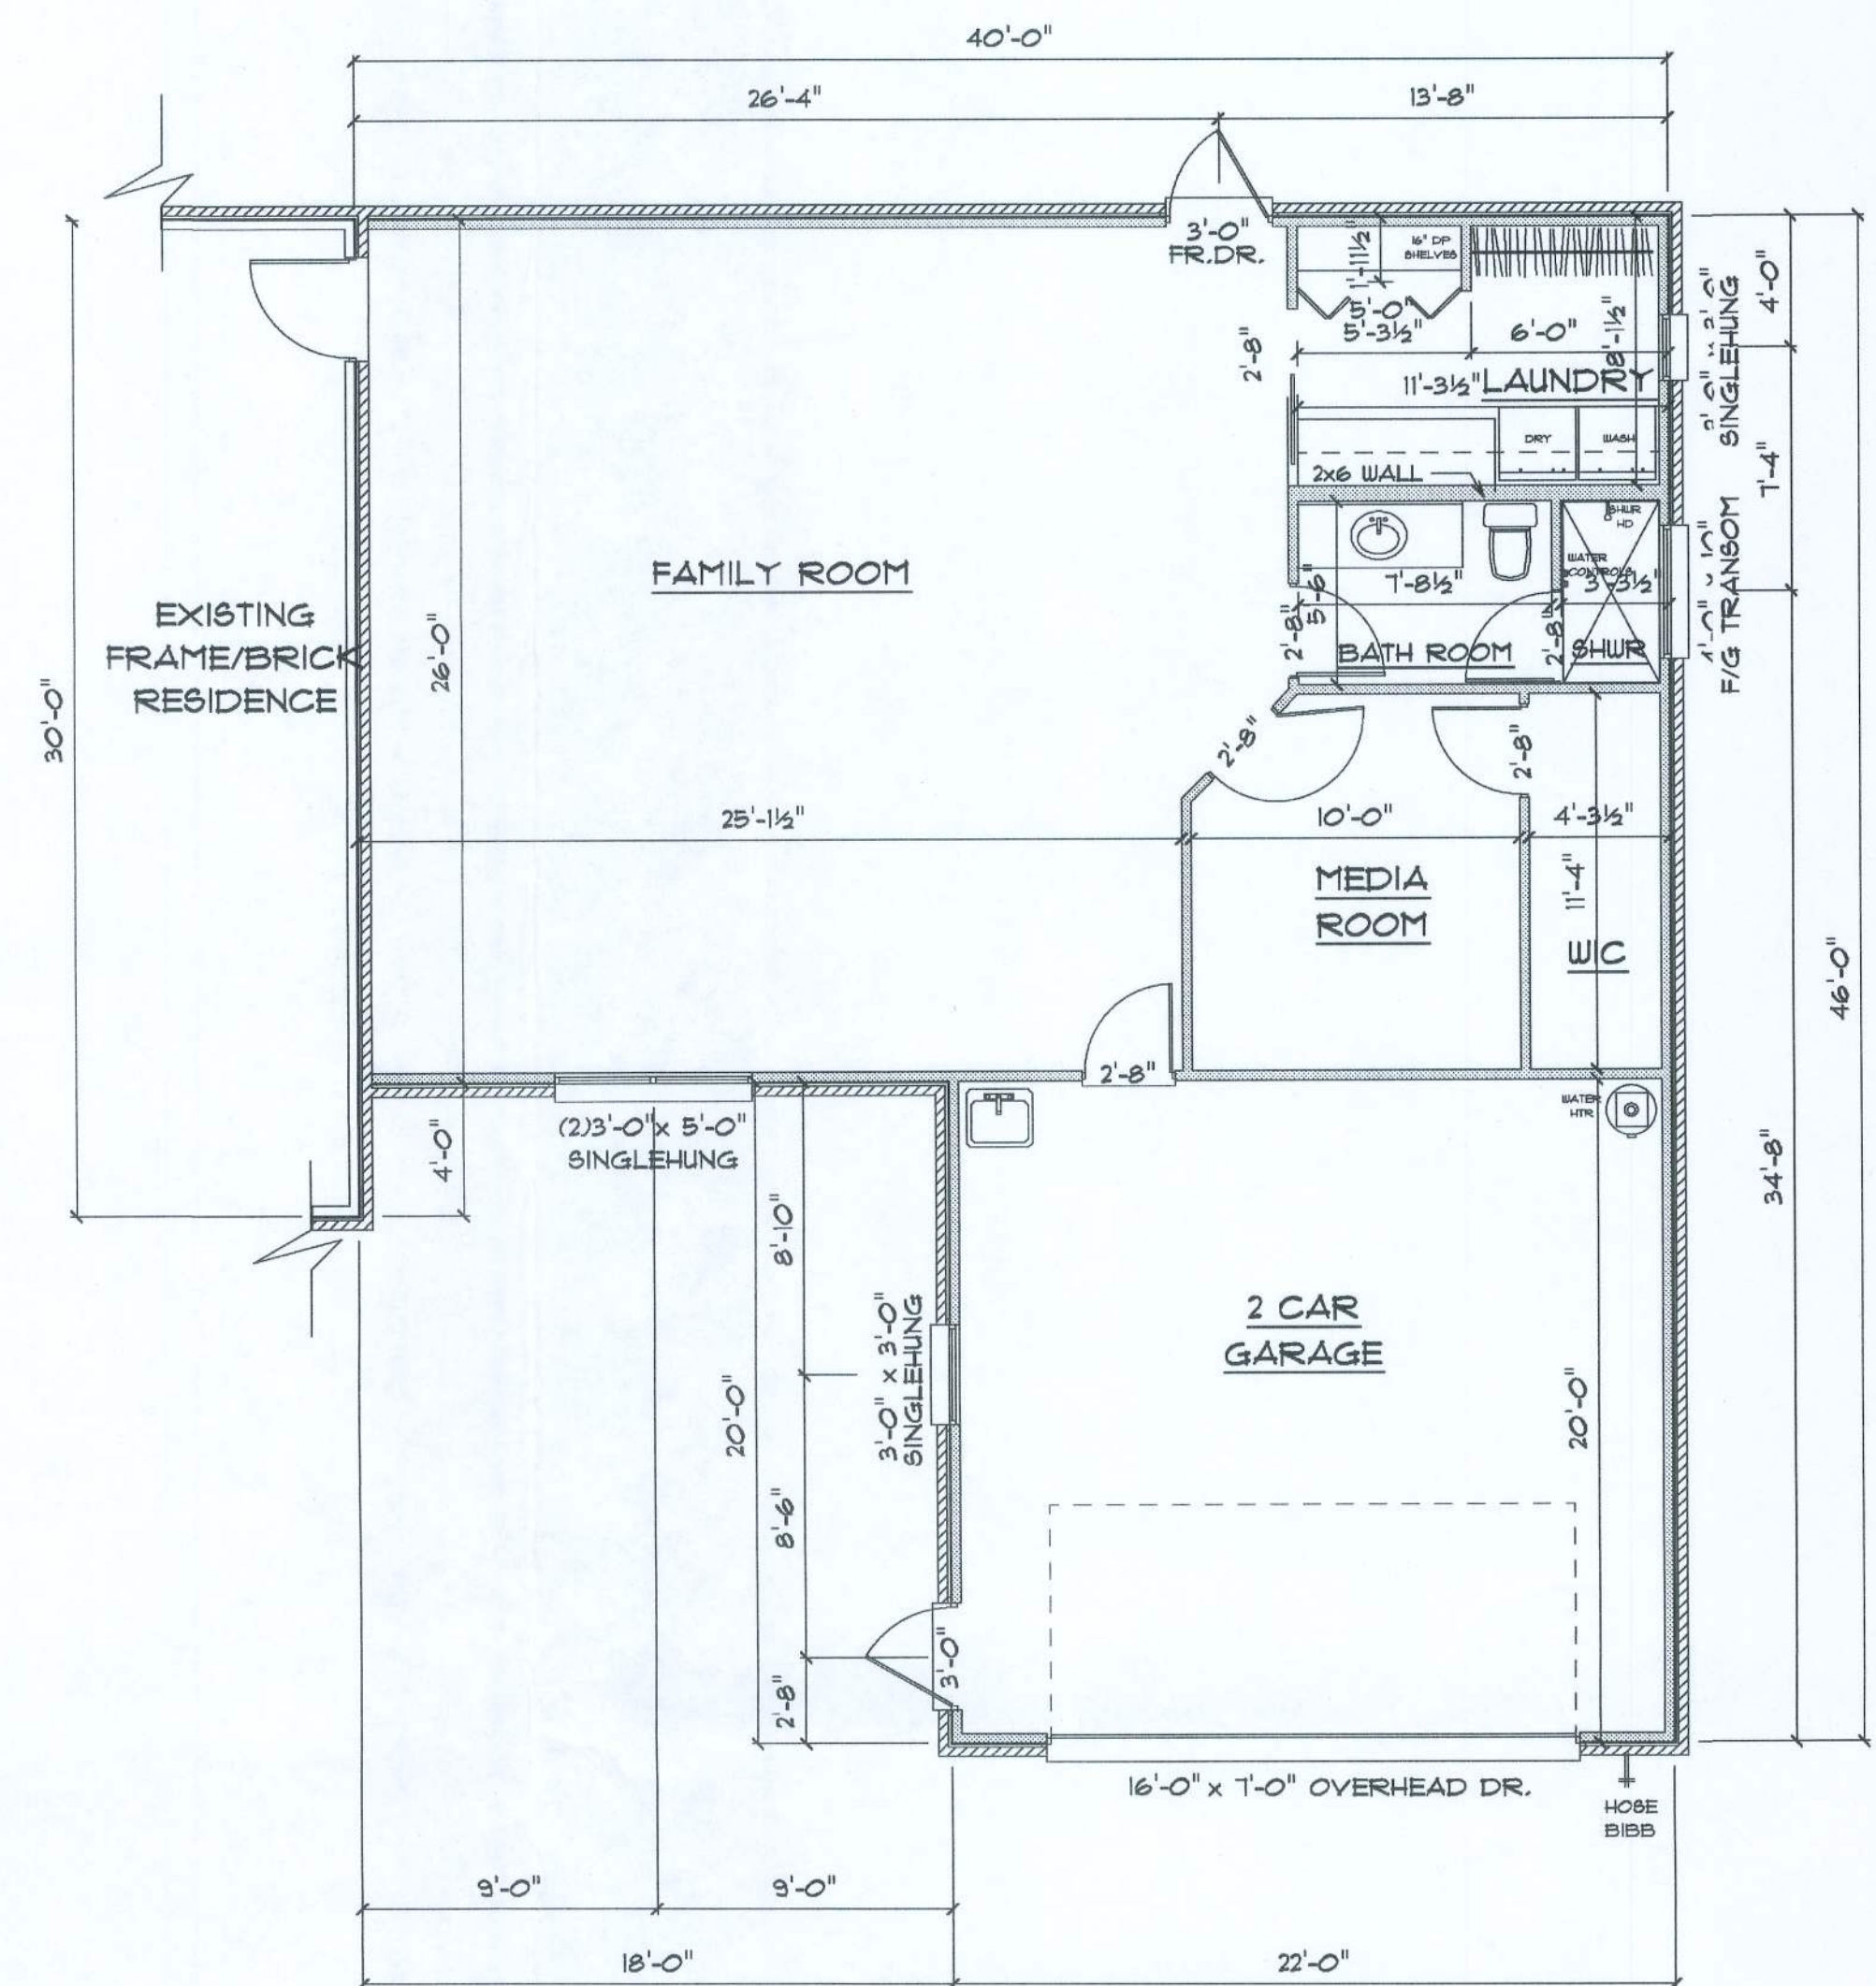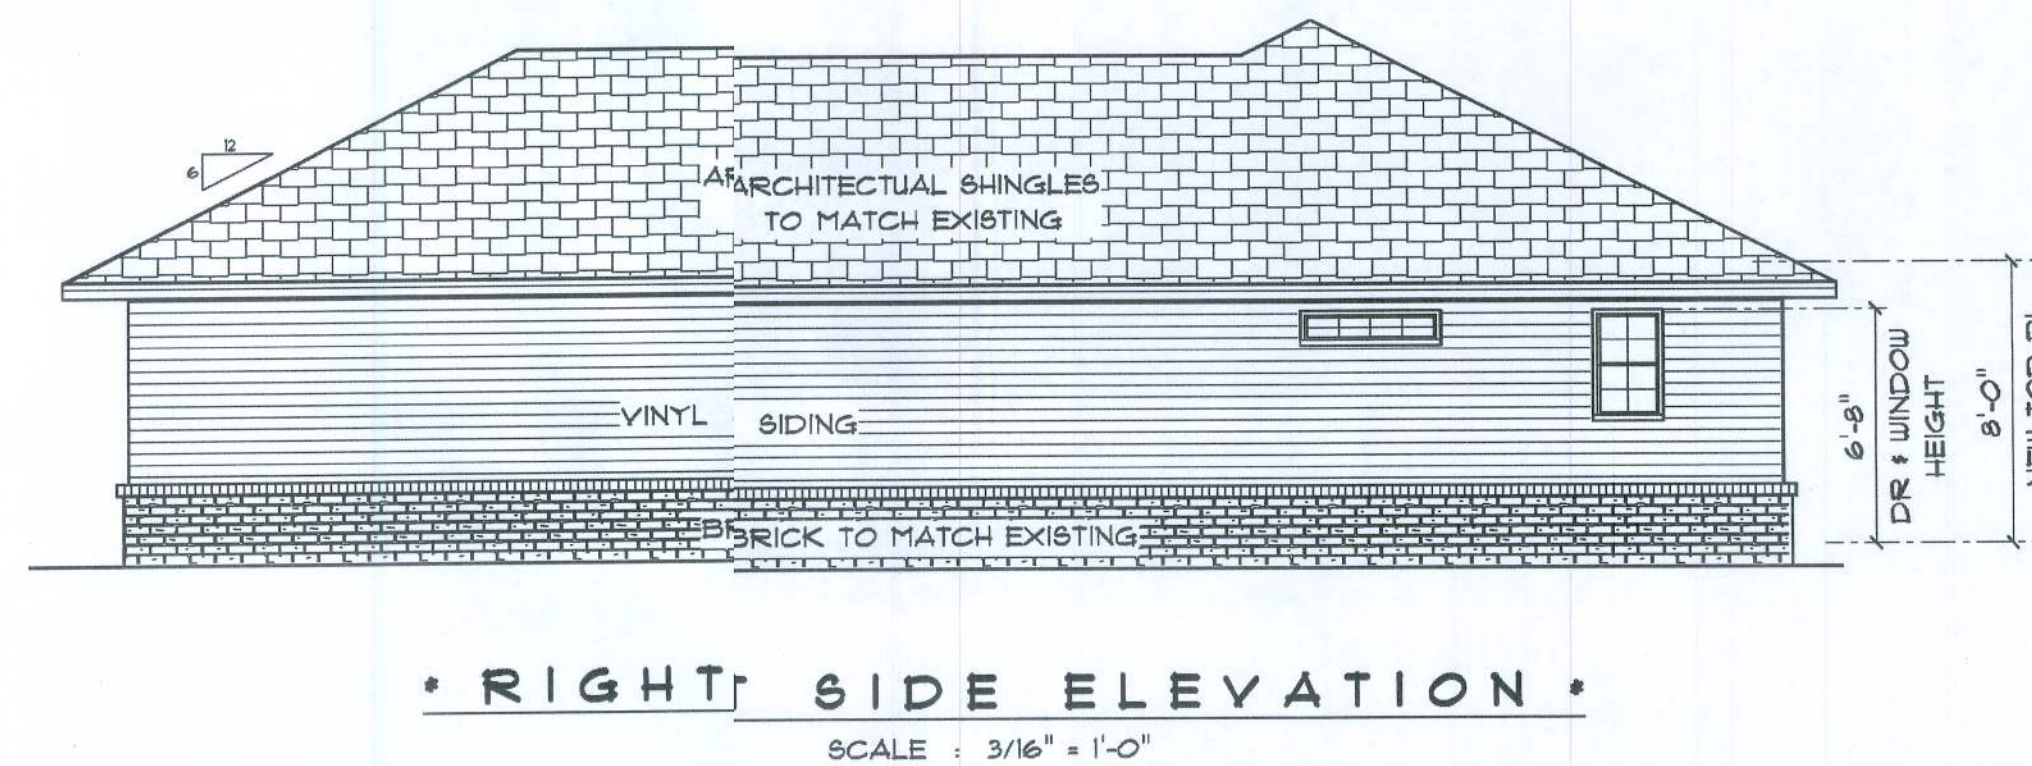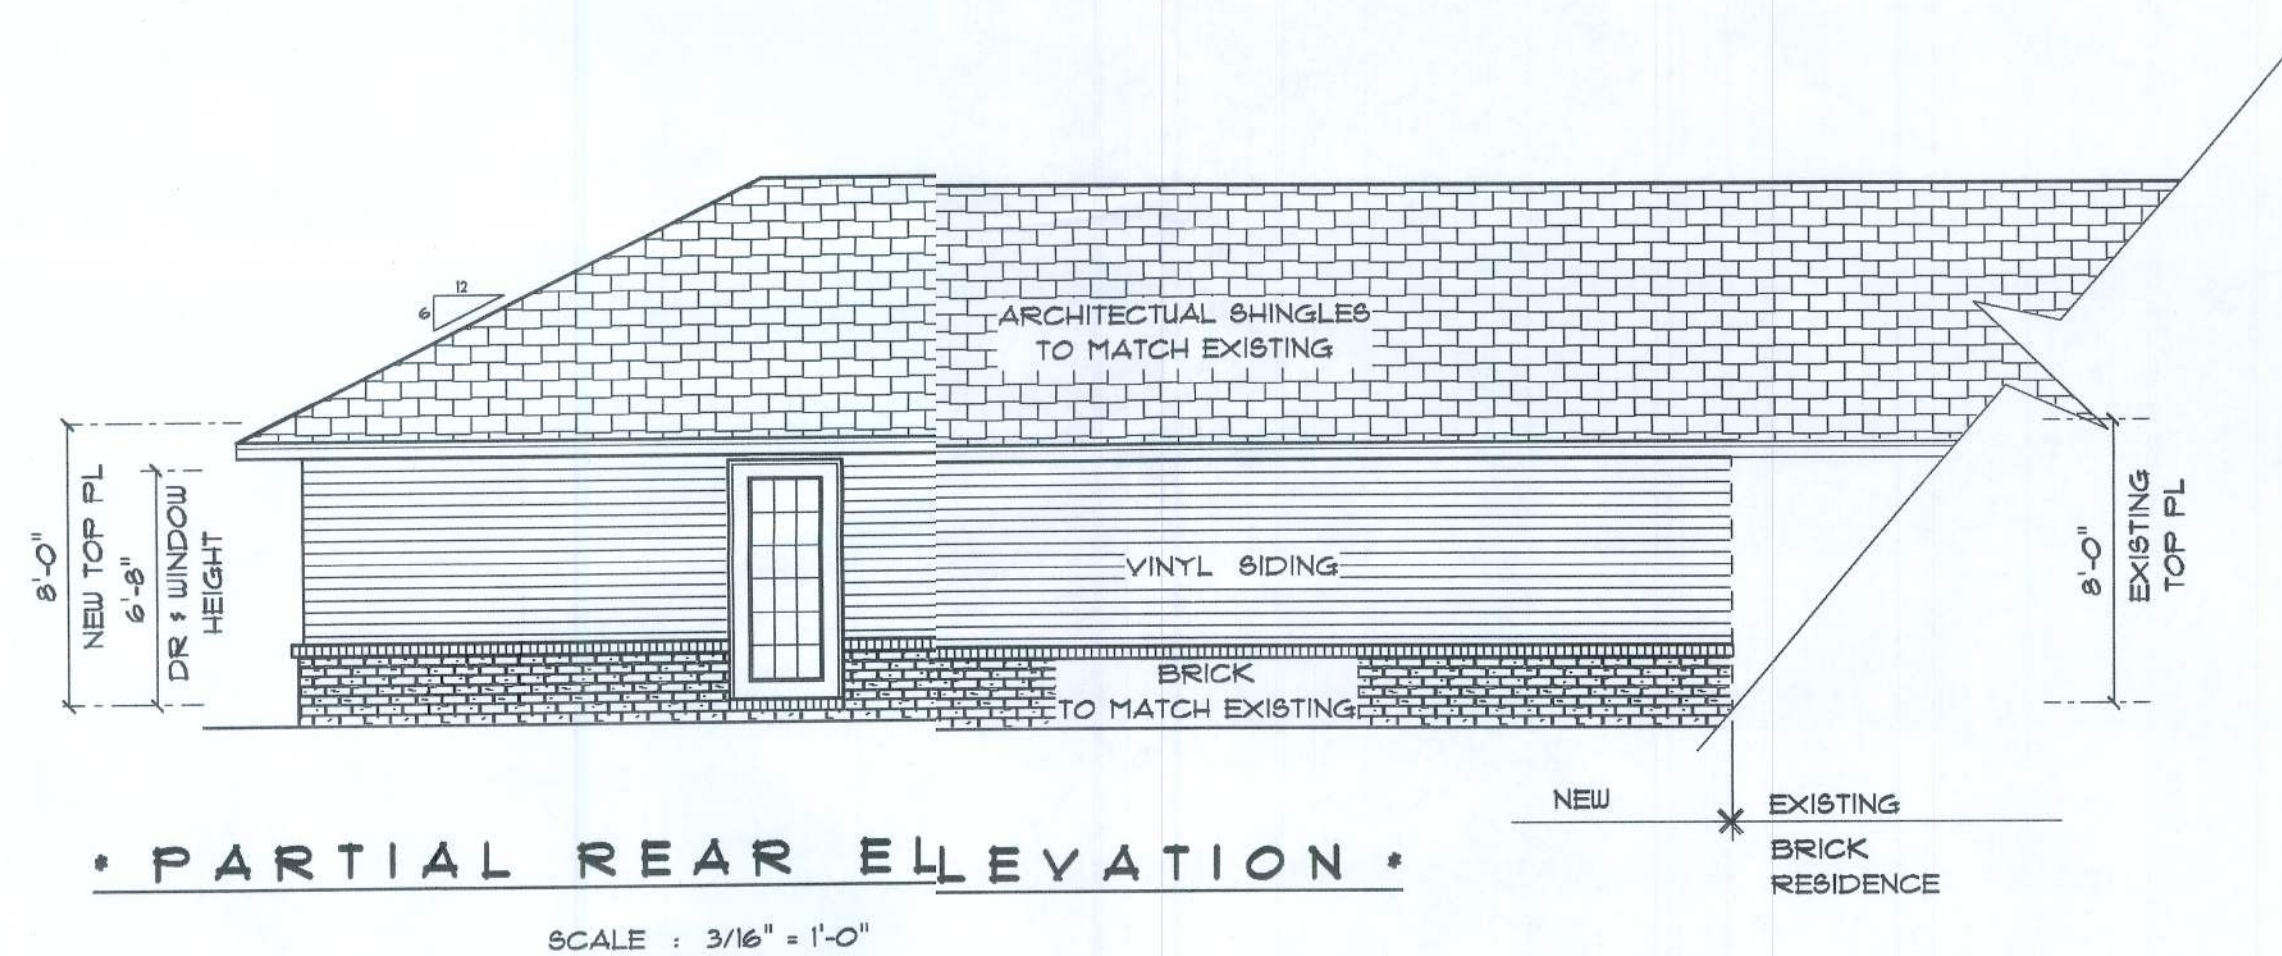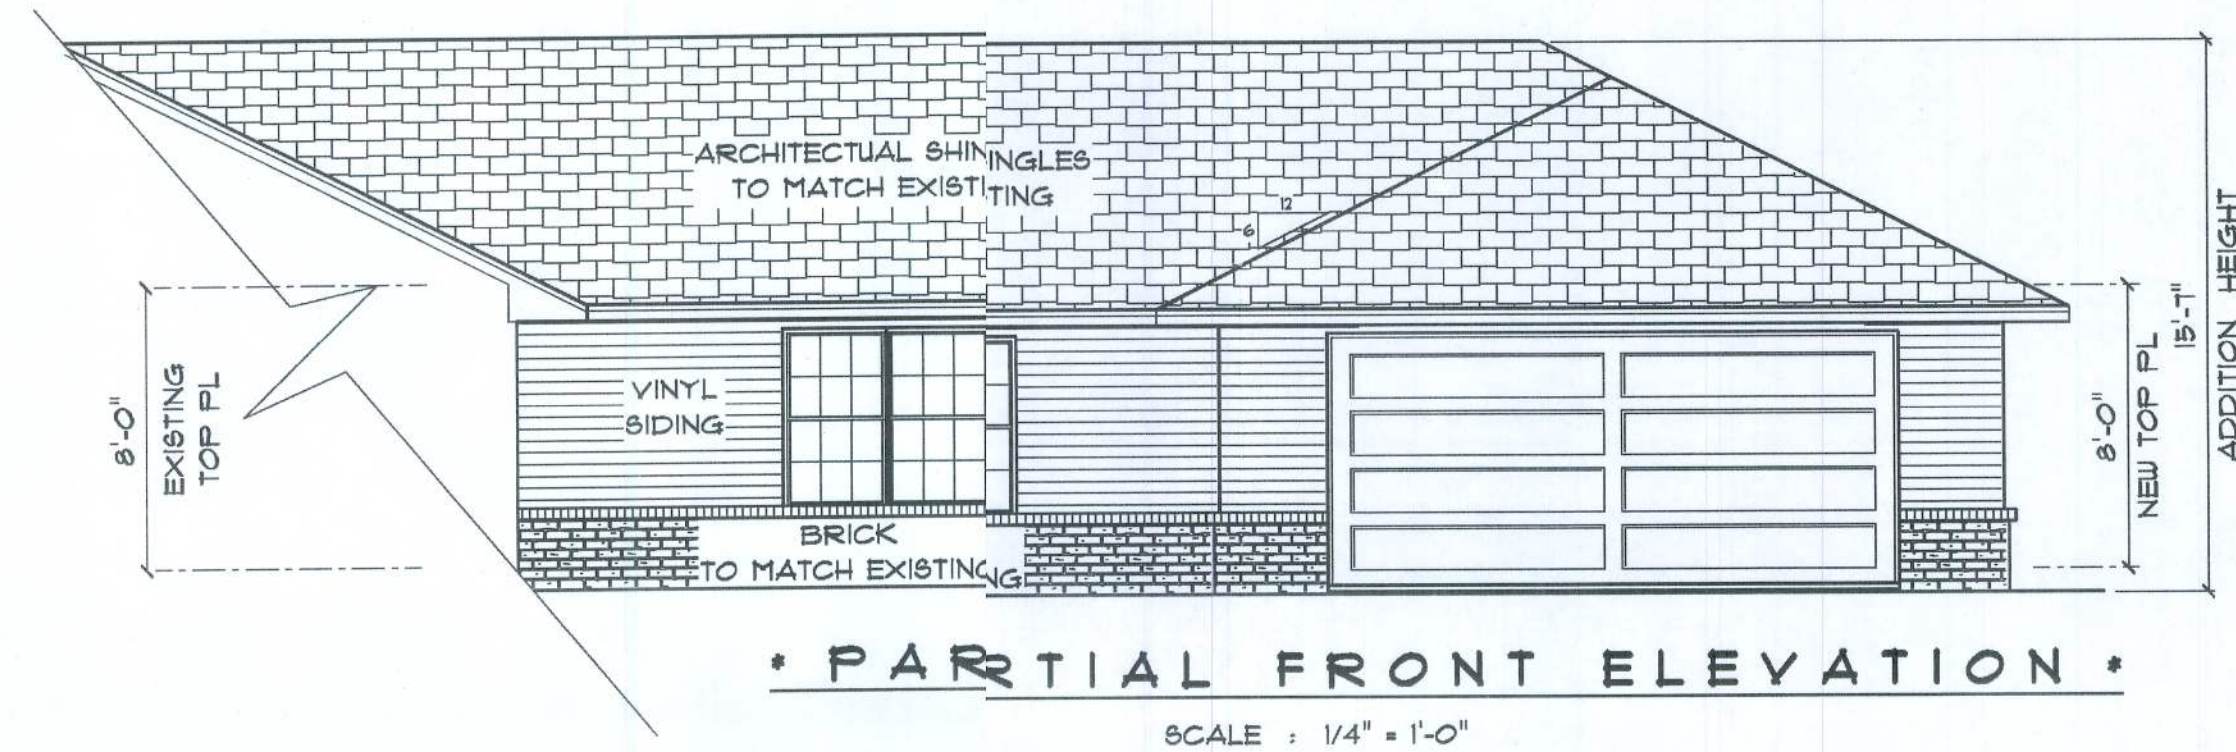

ADDITION for FRED PIERCE

IN
COLUMBIA COUNTY,
FLORIDA

TERRY M. RUFFO
6429 NW Lake Jeffery Rd
Lake City, Florida 32025
Phone: (386) 719-4944
Cell: (386) 861-1181
Email: mfrackdesign@aol.net

PRINTED DATE:
July 3, 2010

DRAWN BY: *Terry M. Ruffo* CHECKED BY:

BUILDING CONTRACTOR

FINALS DATE:

JOB NUMBER:

DRAWING NUMBER

A-2

OF 2 SHEETS