



©2021 CORAL DESIGN GROUP, INC.

Custom Residential Design for:
Grigoriy and Vera Khomich
 Columbia County, Florida

Drawing Index

C&I COVER SHEET, DRAWING INDEX	A&B WALL SECTIONS	D&E FLOOR TRAPING
G1 GENERAL NOTES	A7 TRIM DETAILS	E1 2nd FLOOR TRUSS LAYOUT
	A8 ROOF PLAN	E2 DETAILS AND SECTIONS
A1 BUILDING ELEVATIONS	B1 STRUCTURAL NOTES	E3 ROOF TRUSS LAYOUT
A2 BUILDING ELEVATIONS	B2 GEN'L INFORMATION	P1 PLUMBING PLAN
A3 1st FLOOR PLAN	B3 FOUNDATION PLAN	E1 ELECTRICAL PLAN
A4 2nd FLOOR PLAN	B4 FOUNDATION DETAILS	E2 GENERAL NOTES & DETAILS
A5 BUILDING SECTIONS	B5 LINTEL PLAN	

Digitally signed by N. P. GEISLER
 DN: CN = N. P. GEISLER C = US
 O = AR0007005 OU =
 ARCHITECT
 Date: 2022.01.07 12:19:36 -05'00'



Drawn by: CDG
 Checked by: TPB
 Date: 16 JUL 2018
 Scale: 1/4" = 1'-0"
 Job Number: 2K095-0
 Revised: 1
 Date: 1

CUSTOM RESIDENTIAL DESIGN For:
GRIGORIY & VERA KHOMICH
 COLUMBIA COUNTY, FLORIDA
COVER SHEET

N3
 NICHOLAS
 GEISLER
 ARCHITECT
 12589
 1000 N. W. 10th Ave., Suite 200
 Fort Lauderdale, FL 33304
 Phone: 954.561.1234
 Fax: 954.561.1235
 Email: ngeisler@n3architect.com

Celebrating
 46 Years of Service
 1973 - 2018
 N.P. Geisler, Architect
 12589

CORAL
 DESIGN GROUP
 EXCLUSIVE RESIDENTIAL DESIGNERS
 885 SENIA STREET • SUITE 200 • DODD, FLORIDA 33024
 954.344.1111

NOTICE
 This drawing is the property of Coral Design Group, Inc. and is to be used only for the project and location specified. It is not to be reproduced, stored in a retrieval system, or transmitted in any form or by any means, electronic, mechanical, photocopying, recording, or by any information storage and retrieval system, without the prior written permission of Coral Design Group, Inc. The user of this drawing is to be held responsible for any errors or omissions. The user of this drawing is to be held responsible for any errors or omissions. The user of this drawing is to be held responsible for any errors or omissions.


These drawings are the property of the architect and shall remain the property of the architect. No part of these drawings shall be reproduced or transmitted in any form or by any means electronic or mechanical, including photocopying, recording, or by any information storage or retrieval system, without the prior written permission of the architect.



©2001 CORAL DESIGN GROUP, Inc.

Rear Elevation
SCALE: 1/4" = 1'-0"

CORAL DESIGN GROUP, INC.
PURCHASE OF THIS BOOK ON A REPRODUCED VERSION OF THIS BOOK PLAN
ADVISES PURCHASER A CONTRACT VOLUME TO BUILD THIS PLAN AND
THE ONLY UNDER THE FOLLOWING CONDITIONS: ALL CONDITIONS AND
REVISIONS OF THIS BOOK PLAN ARE THE RESPONSIBILITY OF THE PURCHASER
AND/OR THE PURCHASER'S AGENT TO REVIEW PRIOR TO BUILDING.
CONSTRUCTION AND CONCERN OF MATERIALS EXISTING BOOK PLAN USE
UNDER REQUIREMENTS OR MODIFICATION TO YOUR AREA ON THE OF
DESIGNER AT ALL SIZES AND DATE AND THAT YOU MAY NOT REUSE THE BOOK
CONSTRUCTION AND CONCERN OF MATERIALS EXISTING BOOK PLAN USE
OF PLAN FOR REPRODUCTION. BOOK PLAN OR REPRODUCTION OF THIS
BOOK PLAN MAY BE USED FOR REPRODUCTION FOR LOCAL CODES.
MATERIALS AND/OR ENGINEERING THAT SHALL BE REQUIRED AND IS THE FULL
RESPONSIBILITY OF PURCHASER TO REVIEW AND ASSESS AS NEEDED.
THIS PLAN IS COPYRIGHTED. ALL RIGHTS RESERVED.

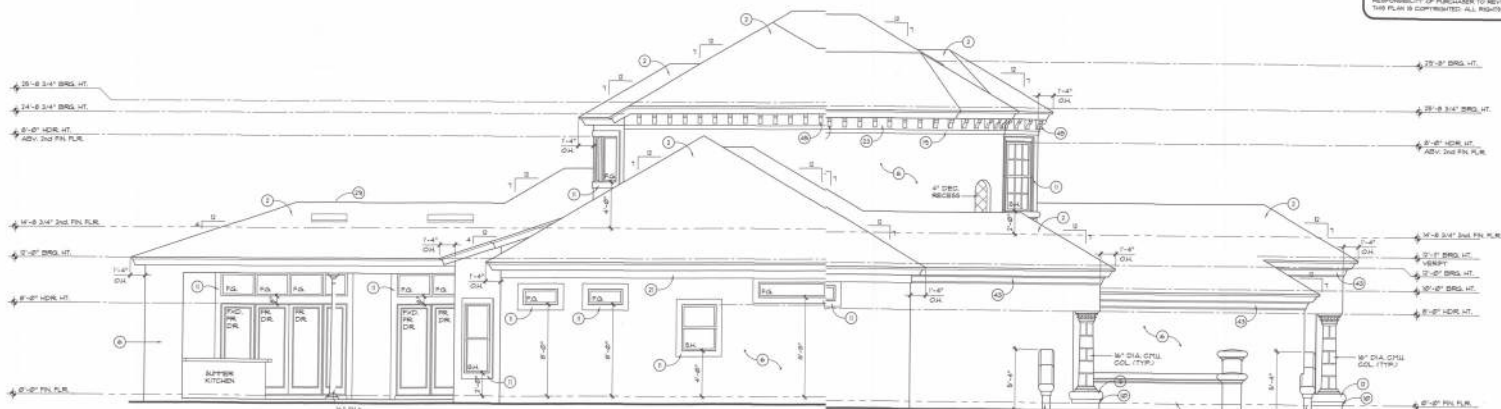

©2001 CORAL DESIGN GROUP, Inc.

Left Side Elevation
SCALE: 1/4" = 1'-0"

- EXTERIOR FINISHING NOTES**
1. Construction details over #10 rebar in 1/2"
 2. Concrete for roof finished as per manufacturer's
 3. Detail as condition req.
 4. Hard water
 5. Ceramic Logitech Interiors
 6. Tropical Teakwood Veneer
 7. Smooth Teakwood Veneer
 8. Smooth Teakwood Veneer
 9. Smooth Teakwood Veneer
 100. Smooth Teakwood Veneer

Digitally signed by: N. P. GIBLER
DN: cn=N. P. GIBLER, c=US
O=ARCHITECT, ou=ARCHITECT
Date: 2022.01.07 12:22:16 -0500

These drawings are the property of the architect and shall remain the property of the architect. No part of these drawings shall be reproduced or transmitted in any form or by any means electronic or mechanical, including photocopying, recording, or by any information storage or retrieval system, without the prior written permission of the architect.

Elevations
1/4" = 1'-0"

NOTICE

These drawings are the property of the architect and shall remain the property of the architect. No part of these drawings shall be reproduced or transmitted in any form or by any means electronic or mechanical, including photocopying, recording, or by any information storage or retrieval system, without the prior written permission of the architect.

CORAL DESIGN GROUP

EXCLUSIVE RESIDENTIAL DESIGNERS

885 BELLA STREET • SUITE 204 • BOKEE CUBA, FL 33134

Celebrating 46 Years in Service

1972-2018

N.P. GIBLER ARCHITECT

NICHOLAS PAUL ARCHITECT

ARCHITECT

11000 E. 11TH AVE. SUITE 100 BOKEE CUBA, FL 33134

CUSTOM RESIDENTIAL DESIGN FOR:

GRIGORY & VERA KHOMICH

COLUMBIA COUNTY, FLORIDA

ELEVATIONS

DESIGN BY: CDG

CHECKED BY: NPG

DATE: 16 JUL 2018

SCALE: 1/4" = 1'-0"


JOB NUMBER: 2K050

REVISIONS:

DRAW NO: A2 OF 8

ARCHITECT: ARCHITECT

These drawings are prepared by N.P. Geisler and may not be used, copied or reproduced in whole or in part for any other project without the written consent of N.P. Geisler.

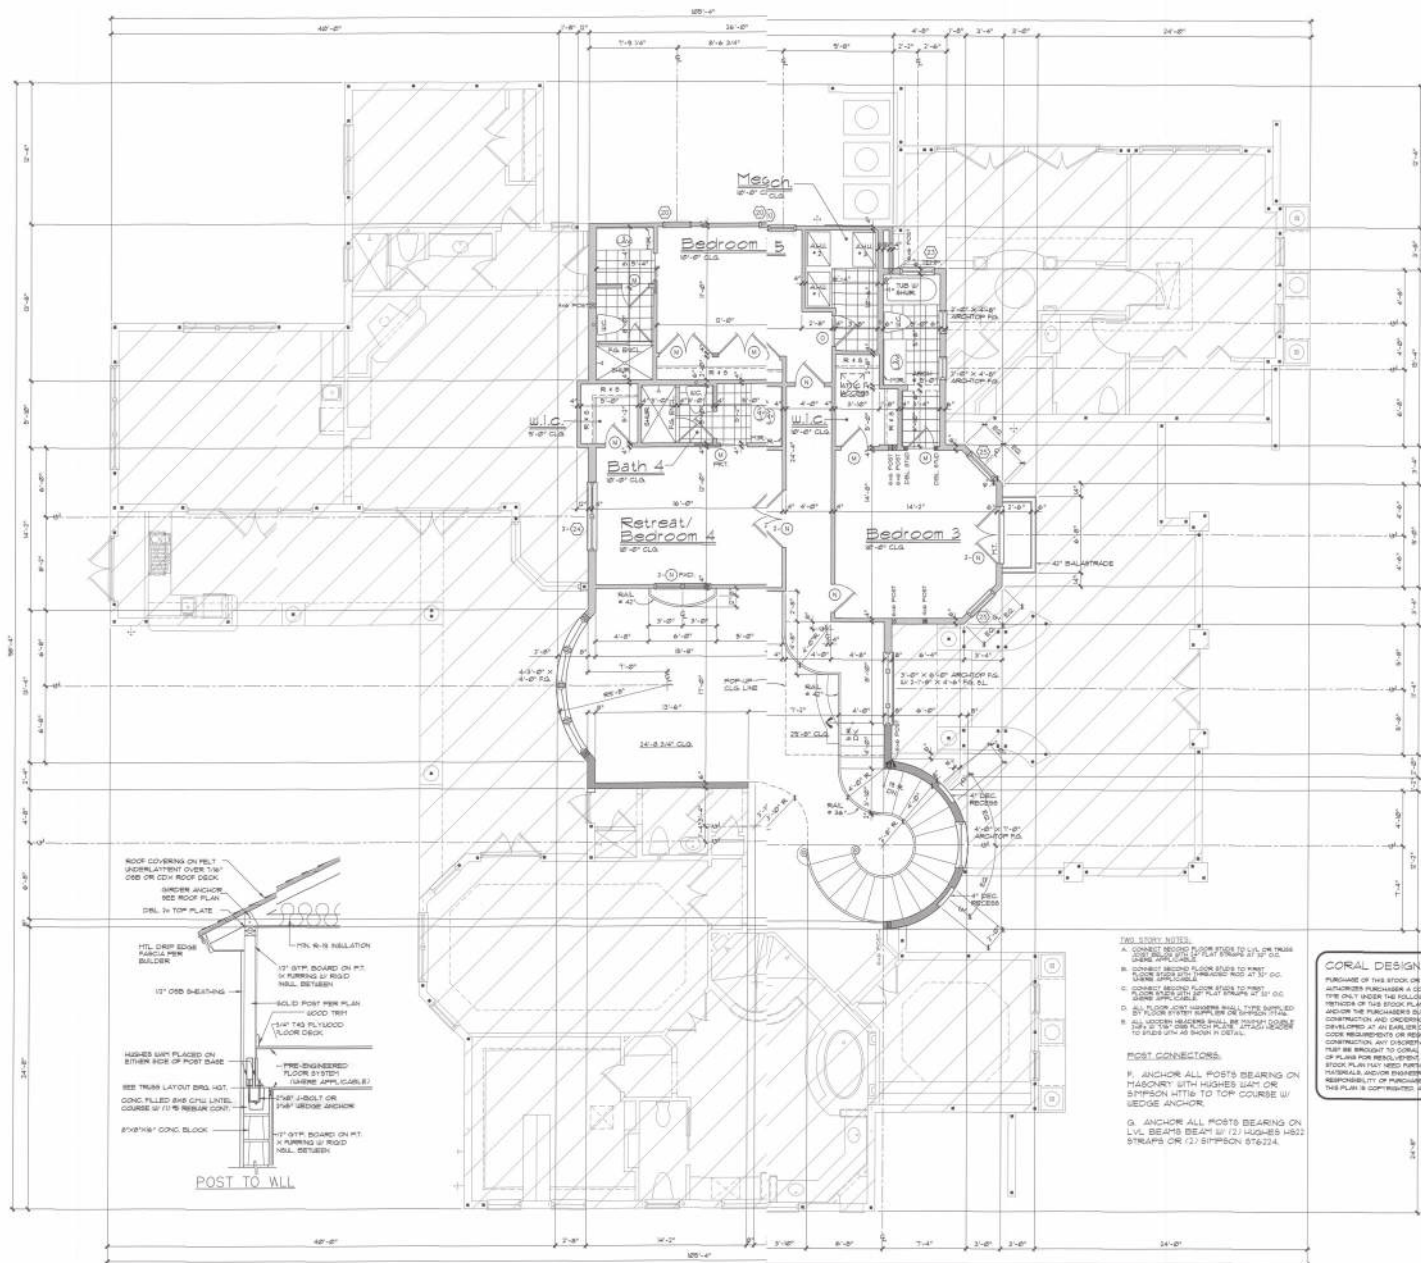

NOTES
1. ALL DIMENSIONS ARE TO FACE UNLESS NOTED OTHERWISE.
2. ALL WALLS ARE 8" THICK UNLESS NOTED OTHERWISE.
3. ALL FLOORS ARE 4" THICK UNLESS NOTED OTHERWISE.
4. ALL CEILINGS ARE 8" THICK UNLESS NOTED OTHERWISE.
5. ALL ROOFS ARE 12" THICK UNLESS NOTED OTHERWISE.
6. ALL STAIRS ARE 12" THICK UNLESS NOTED OTHERWISE.
7. ALL DOORS ARE 2' X 6' UNLESS NOTED OTHERWISE.
8. ALL WINDOWS ARE 2' X 4' UNLESS NOTED OTHERWISE.
9. ALL OPENINGS ARE TO BE FILLED WITH CONCRETE UNLESS NOTED OTHERWISE.
10. ALL REINFORCEMENT IS TO BE PLACED AS SHOWN ON THE PLAN.

DOOR SIZE KEY

MARK	SIZE
1	2' X 6'
2	2' X 6'
3	2' X 6'
100	2' X 6'

WINDOW SIZE KEY

MARK	MASONRY	FRAME
1	12" X 16"	12" X 16"
2	12" X 16"	12" X 16"
3	12" X 16"	12" X 16"
100	12" X 16"	12" X 16"

2ND STORY NOTES
A. CONCRETE FLOOR SHALL BE 4" THICK WITH 1/2" DIA. REINFORCING BARS AT 12" O.C.
B. CONCRETE FLOOR SHALL BE 4" THICK WITH 1/2" DIA. REINFORCING BARS AT 12" O.C.
C. CONCRETE FLOOR SHALL BE 4" THICK WITH 1/2" DIA. REINFORCING BARS AT 12" O.C.
D. CONCRETE FLOOR SHALL BE 4" THICK WITH 1/2" DIA. REINFORCING BARS AT 12" O.C.
E. CONCRETE FLOOR SHALL BE 4" THICK WITH 1/2" DIA. REINFORCING BARS AT 12" O.C.
F. ANCHOR ALL POSTS BEARING ON MASONRY WITH HIGHER SAYS OR SIMPSON HT10S TO TOP COURSE W/ WEDGE ANCHOR.
G. ANCHOR ALL POSTS BEARING ON LVL BEAMS WITH 1/2" DIA. HIGHER SAYS OR SIMPSON HT10S TO TOP COURSE W/ WEDGE ANCHOR.
H. ANCHOR ALL POSTS BEARING ON LVL BEAMS WITH 1/2" DIA. HIGHER SAYS OR SIMPSON HT10S TO TOP COURSE W/ WEDGE ANCHOR.

CORAL DESIGN GROUP, INC.
PURCHASE OF THIS BOOK OR A REPRODUCED VERSION OF THIS BOOK PLANS AUTHORIZES PURCHASER TO CONSTRUCT OR RECONSTRUCT THE PROJECT ONLY UNDER THE FOLLOWING CONDITIONS: ALL CONDITIONS AND RESTRICTIONS OF THIS BOOK PLAN ARE THE RESPONSIBILITY OF THE PURCHASER AND/OR THE PURCHASER'S DESIGNER TO REVIEW PRIOR TO RECORD. CONTRACTOR AND OWNER OF MATERIALS EXISTING AT THE PROJECT ARE DEVELOPED AT AN EARLY DATE AND MAY OR MAY NOT MEET THE EXACT CODE REQUIREMENTS OR REGULATIONS IN FORCE AT THE TIME OF CONSTRUCTION. ANY CHANGES TO THIS BOOK PLAN OR RECONSTRUCTION SHALL BE BROUGHT TO CORAL DESIGN GROUP'S ATTENTION PRIOR TO USE OF PLANS FOR RECONSTRUCTION. THIS BOOK PLAN OR RECONSTRUCTION OF THIS BOOK PLAN MAY BE USED FOR RECONSTRUCTION FOR LOCAL CODES. MATERIALS AND/OR ENGINEERING THAT COULD BE REQUIRED, AND IS THE FULL RESPONSIBILITY OF PURCHASER TO REVIEW AND ASSURE AS NEEDED. THIS PLAN IS COPYRIGHTED BY CORAL DESIGN GROUP, INC. ALL RIGHTS RESERVED.

2nd. Floor Plan
1/4"=1'-0"

NOTICE
These drawings are prepared by N.P. Geisler and may not be used, copied or reproduced in whole or in part for any other project without the written consent of N.P. Geisler.

CORAL DESIGN GROUP
EXCLUSIVE RESIDENTIAL DESIGNERS
1000 S. BAY STREET • SUITE 200 • BOKEE, FLORIDA 33686
(813) 881-1111

Celebrating
46 Years of Service
1972 - 2018
N.P. Geisler, Architect
AIA 100000000


N3
NICHOLAS
GEISLER
ARCHITECT
1000 S. BAY STREET • SUITE 200 • BOKEE, FLORIDA 33686
(813) 881-1111

CUSTOM RESIDENTIAL DESIGN FOR:
GRIGORY & YERA KHOMICH
COLLEGE COUNTY, FLORIDA
2nd FLOOR PLAN


DRAWN BY: CDG
CHECKED BY: MFB
DATE: 16 JUL 2018
SCALE: 1/4" = 1'-0"
JOB NUMBER: 200000
REVISIONS:
DRAWN BY: A.A. 8
PROJECT NUMBER: AR0007008

AR0007005

These drawings are preliminary in nature, and the user should not be used, copied, or reproduced in whole or in part for any other purpose without written permission by the architect.

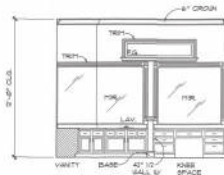


Elevation @
Master Bath
SCALE: 1/4" = 1'-0"

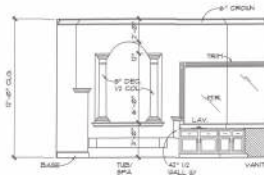

Elevation @
Master Bath
SCALE: 1/4" = 1'-0"




Elevation @
Master Bath
SCALE: 1/4" = 1'-0"

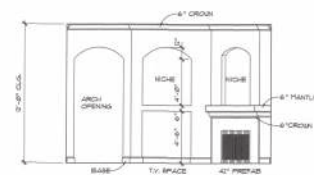

Elevation @
Family Rm.
SCALE: 1/4" = 1'-0"

NOTES:
VERIFY ALL GYP. BD. FINISHES,
TRIMS/MLDGS. & ANY BULLNOSE
EDGING W/ BLDG. PRIOR TO
CONSTRUCTION.

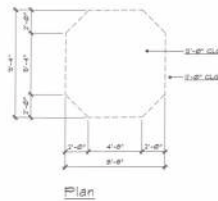


Plan




Profile

Clg. Detail @
Library
SCALE: 1/4" = 1'-0"

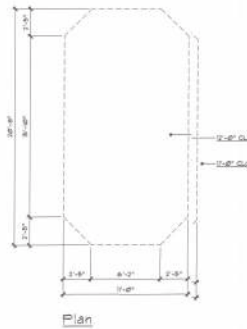


Plan

 

Profile

Clg. Detail @
Master Suite
SCALE: 1/4" = 1'-0"

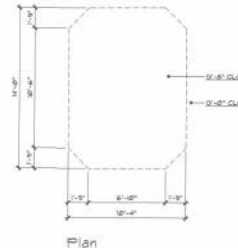


Plan



Profile

Clg. Detail @
Dining Rm.
SCALE: 1/4" = 1'-0"

 CORAL DESIGN GROUP, INC.
PURCHASE OF THIS BOOK OR A MODIFIED VERSION OF THIS BOOK PLAN
AUTHORIZES PURCHASER A LIMITED RELEASE TO BUILD THIS PLAN AND
THE ONLY UNDER THE FOLLOWING CONDITIONS: ALL CONSTRUCTION AND
DETAILS OF THIS BOOK PLAN ARE THE RESPONSIBILITY OF THE PURCHASER
AND/OR THE PURCHASER'S BUILDER TO REVIEW PRIOR TO BEGINNING
CONSTRUCTION AND CORRECTING OF MATERIALS. THE BOOK PLAN WAS
DEVELOPED AT AN EARLY DATE AND MAY OR MAY NOT MEET THE LATEST
CODE REQUIREMENTS OR REGULATIONS IN YOUR AREA OR THE DATE OF
CONSTRUCTION. ANY DISCREPANCIES POINTED IN THESE PLANS SHOWN
MAY BE SUBJECT TO CORAL DESIGN GROUP'S INTEREST PRIOR TO USE
OF PLANS FOR REBUILDING. BOOK PLANS OR MODIFIED VERSIONS OF THIS
BOOK PLAN THAT NEED FURTHER MODIFICATION FOR LOCAL CODES
MATERIALS AND/OR ENGINEERING THAT COULD BE REQUIRED, AND THE FULL
RESPONSIBILITY OF PURCHASER TO REVIEW AND ACQUIRE AS NEEDED.
THIS PLAN IS COPYRIGHTED. ALL RIGHTS RESERVED.



Section @
Counter Top
SCALE: NTS

Sections
1/4" = 1'-0"

Digitally signed by N.P. GEISLER
DN: cn = N.P. GEISLER, c = US
o = CORAL DESIGN GROUP, ou =
ARCHITECT
Date: 2022.01.07 12:28:28 -05'00'

NOTE:
This drawing is preliminary in nature and should not be used, copied, or reproduced in whole or in part for any other purpose without written permission by the architect.

CORAL
DESIGN GROUP
EXCLUSIVE RESIDENTIAL DESIGN
1100 SOUTH STREET, SUITE 100
MIAMI, FL 33130
407-791-2000

Calculating
46 Years
1972-2018
N.P. GEISLER
ARCHITECT


N
NICHOLAS
GEISLER
ARCHITECT
1100 SOUTH STREET, SUITE 100
MIAMI, FL 33130
407-791-2000

CUSTOM RESIDENTIAL DESIGN FOR:
GRIGORY & VERA KHOMICH
COLUMBIA COUNTY, FLORIDA
DETAILS

DRAWN BY: CDG
CHECKED BY: TPB
DATE: 16 JUL 2018
SCALE: 1/4" = 1'-0"
JOB NUMBER: 21C000
SHEET NO: 1
SHEET TOTAL: 8

AR0007008

These drawings are the property of the architect and may not be used, copied or reproduced in whole or in part for any other project without written permission of the architect.

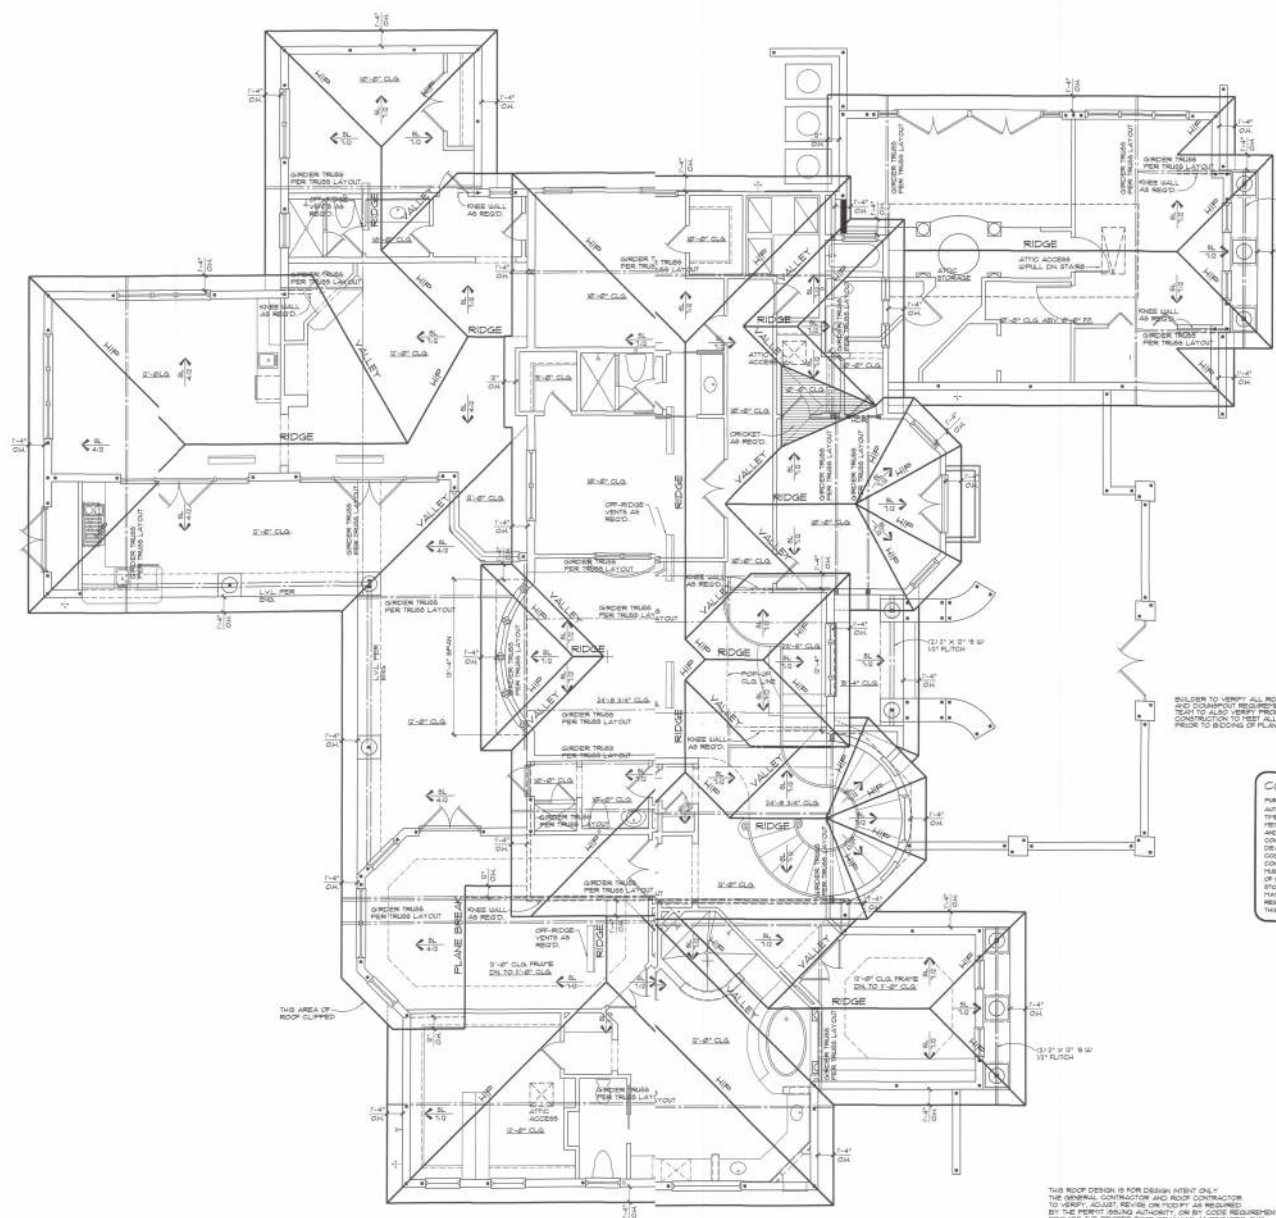

BUILDER TO VERIFY ALL ROOF DRAINAGE REQUIREMENTS. ALL UTILITY NOT CONFORMING REQUIREMENTS AS REQUIRED. ROOF AND DRAINAGE CONSTRUCTION TO MEET ALL LOCAL CODES AND REQUIREMENTS FOR AREA OF BUILD PRIOR TO BEGINS OF PLANS, ORDERING OF MATERIALS AND CONSTRUCTION.

CORAL DESIGN GROUP, INC.
PURCHASE OF THIS STOCK OR A MODIFIED VERSION OF THIS STOCK PLAN:
AUTHORIZED PURCHASER A CONTRACT RELEASE TO BUILD THIS PLAN OR
THE ONLY UNDER THE FOLLOWING CONDITIONS: ALL CONDITIONS AND
ATTACHMENTS OF THIS STOCK PLAN ARE THE RESPONSIBILITY OF THE PURCHASER
AND/OR THE PURCHASER'S AGENT TO REVIEW PRIOR TO BEGINS
CONSTRUCTION AND ORDERING OF MATERIALS. EXISTING STOCK PLAN WERE
DEVELOPED AT AN EARLY DATE AND MAY OF THAT NOT MEET THE EXACT
CODE REQUIREMENTS OR REGULATIONS IN YOUR AREA. ON THE
CONSTRUCTION, ANY DISCREPANCIES POINT TO THESE PLANS. PURCHASER
MAY BE SUBJECT TO LOCAL ORDINANCES. ATTENTION PRIOR TO USE
OF PLANS FOR REPAIR, UPGRADE, STOCK PLANS OR MODIFIED VERSIONS OF THIS
STOCK PLAN MUST HAVE THE PURCHASER'S AGENT REVIEW ALL LOCAL CODES
MATERIALS AND/OR ENGINEERING THAT COULD BE REQUIRED, AND IS THE FULL
RESPONSIBILITY OF PURCHASER TO REVIEW AND ACQUIRE AS REQUIRED.
THIS PLAN IS COPYRIGHTED. ALL RIGHTS RESERVED.

- - INDICATES LUMBERED STUDS QUANTITY PER PLAN
- - INDICATES 4" x 8" POST (UNLESS NOTED OTHERWISE)
- - INDICATES PULLED CELL (UNLESS NOTED OTHERWISE)
- - INDICATES BEARING WALL

NOTE: →
ALL ROOF SLOPES AT 1/2 UNLESS OTHERWISE NOTED.

Roof Plan
1/4"=1'-0"

THIS ROOF DESIGN IS FOR DESIGN INTENT ONLY. THE ORIGINAL CONTRACTOR AND ROOF CONTRACTOR TO VERIFY, ADJUST, REVISE OR MODIFY AS REQUIRED BY THE PERMIT ISSUING AUTHORITY. ON BY CODE REQUIREMENTS. PROVIDE THE PROPER ROOF DRAINAGE AS REQUIRED. THIS INCLUDES GUTTERS IF NEEDED, PLANS AND WATERPROOF AS REQUIRED PRIOR TO BUILDING AND ORDERING MATERIALS.

Digitally signed by N. P. GEISLER
DN: CN = N. P. GEISLER C = US
O = AR0007005 OU = ARCHITECT
Date: 2022.01.07 12:29:34 -0500

NOTES
1. THESE PLANS ARE THE PROPERTY OF CORAL DESIGN GROUP, INC. AND ARE NOT TO BE REPRODUCED OR COPIED IN ANY MANNER WITHOUT THE WRITTEN PERMISSION OF CORAL DESIGN GROUP, INC.
2. THESE PLANS ARE FOR INFORMATION ONLY AND ARE NOT TO BE USED FOR CONSTRUCTION WITHOUT THE WRITTEN PERMISSION OF CORAL DESIGN GROUP, INC.
3. THESE PLANS ARE FOR INFORMATION ONLY AND ARE NOT TO BE USED FOR CONSTRUCTION WITHOUT THE WRITTEN PERMISSION OF CORAL DESIGN GROUP, INC.
4. THESE PLANS ARE FOR INFORMATION ONLY AND ARE NOT TO BE USED FOR CONSTRUCTION WITHOUT THE WRITTEN PERMISSION OF CORAL DESIGN GROUP, INC.

CORAL DESIGN GROUP
EXCLUSIVE RESIDENTIAL DESIGNERS
800.500.0000 • 407.510.5500

Calculating 46 Years of Service
1972-2018
N. P. GEISLER
ARCHITECT

NE
NICHOLAS GEISLER
ARCHITECT
1125 W. 15TH AVE. SUITE 100
MIAMI, FL 33135
305.577.1000

CUSTOM RESIDENTIAL DESIGN FOR:
GRIGORY & VERA KHOMICH
COLUMBIA COUNTY, FLORIDA
ROOF PLAN

DESIGN BY: CDG
DRAWN BY: TPB
DATE: 16 JUL 2018
SCALE: 1/4" = 1'-0"
JOB NUMBER: 200802
REVISION:
THIS SET:
A B C

AR0007005