


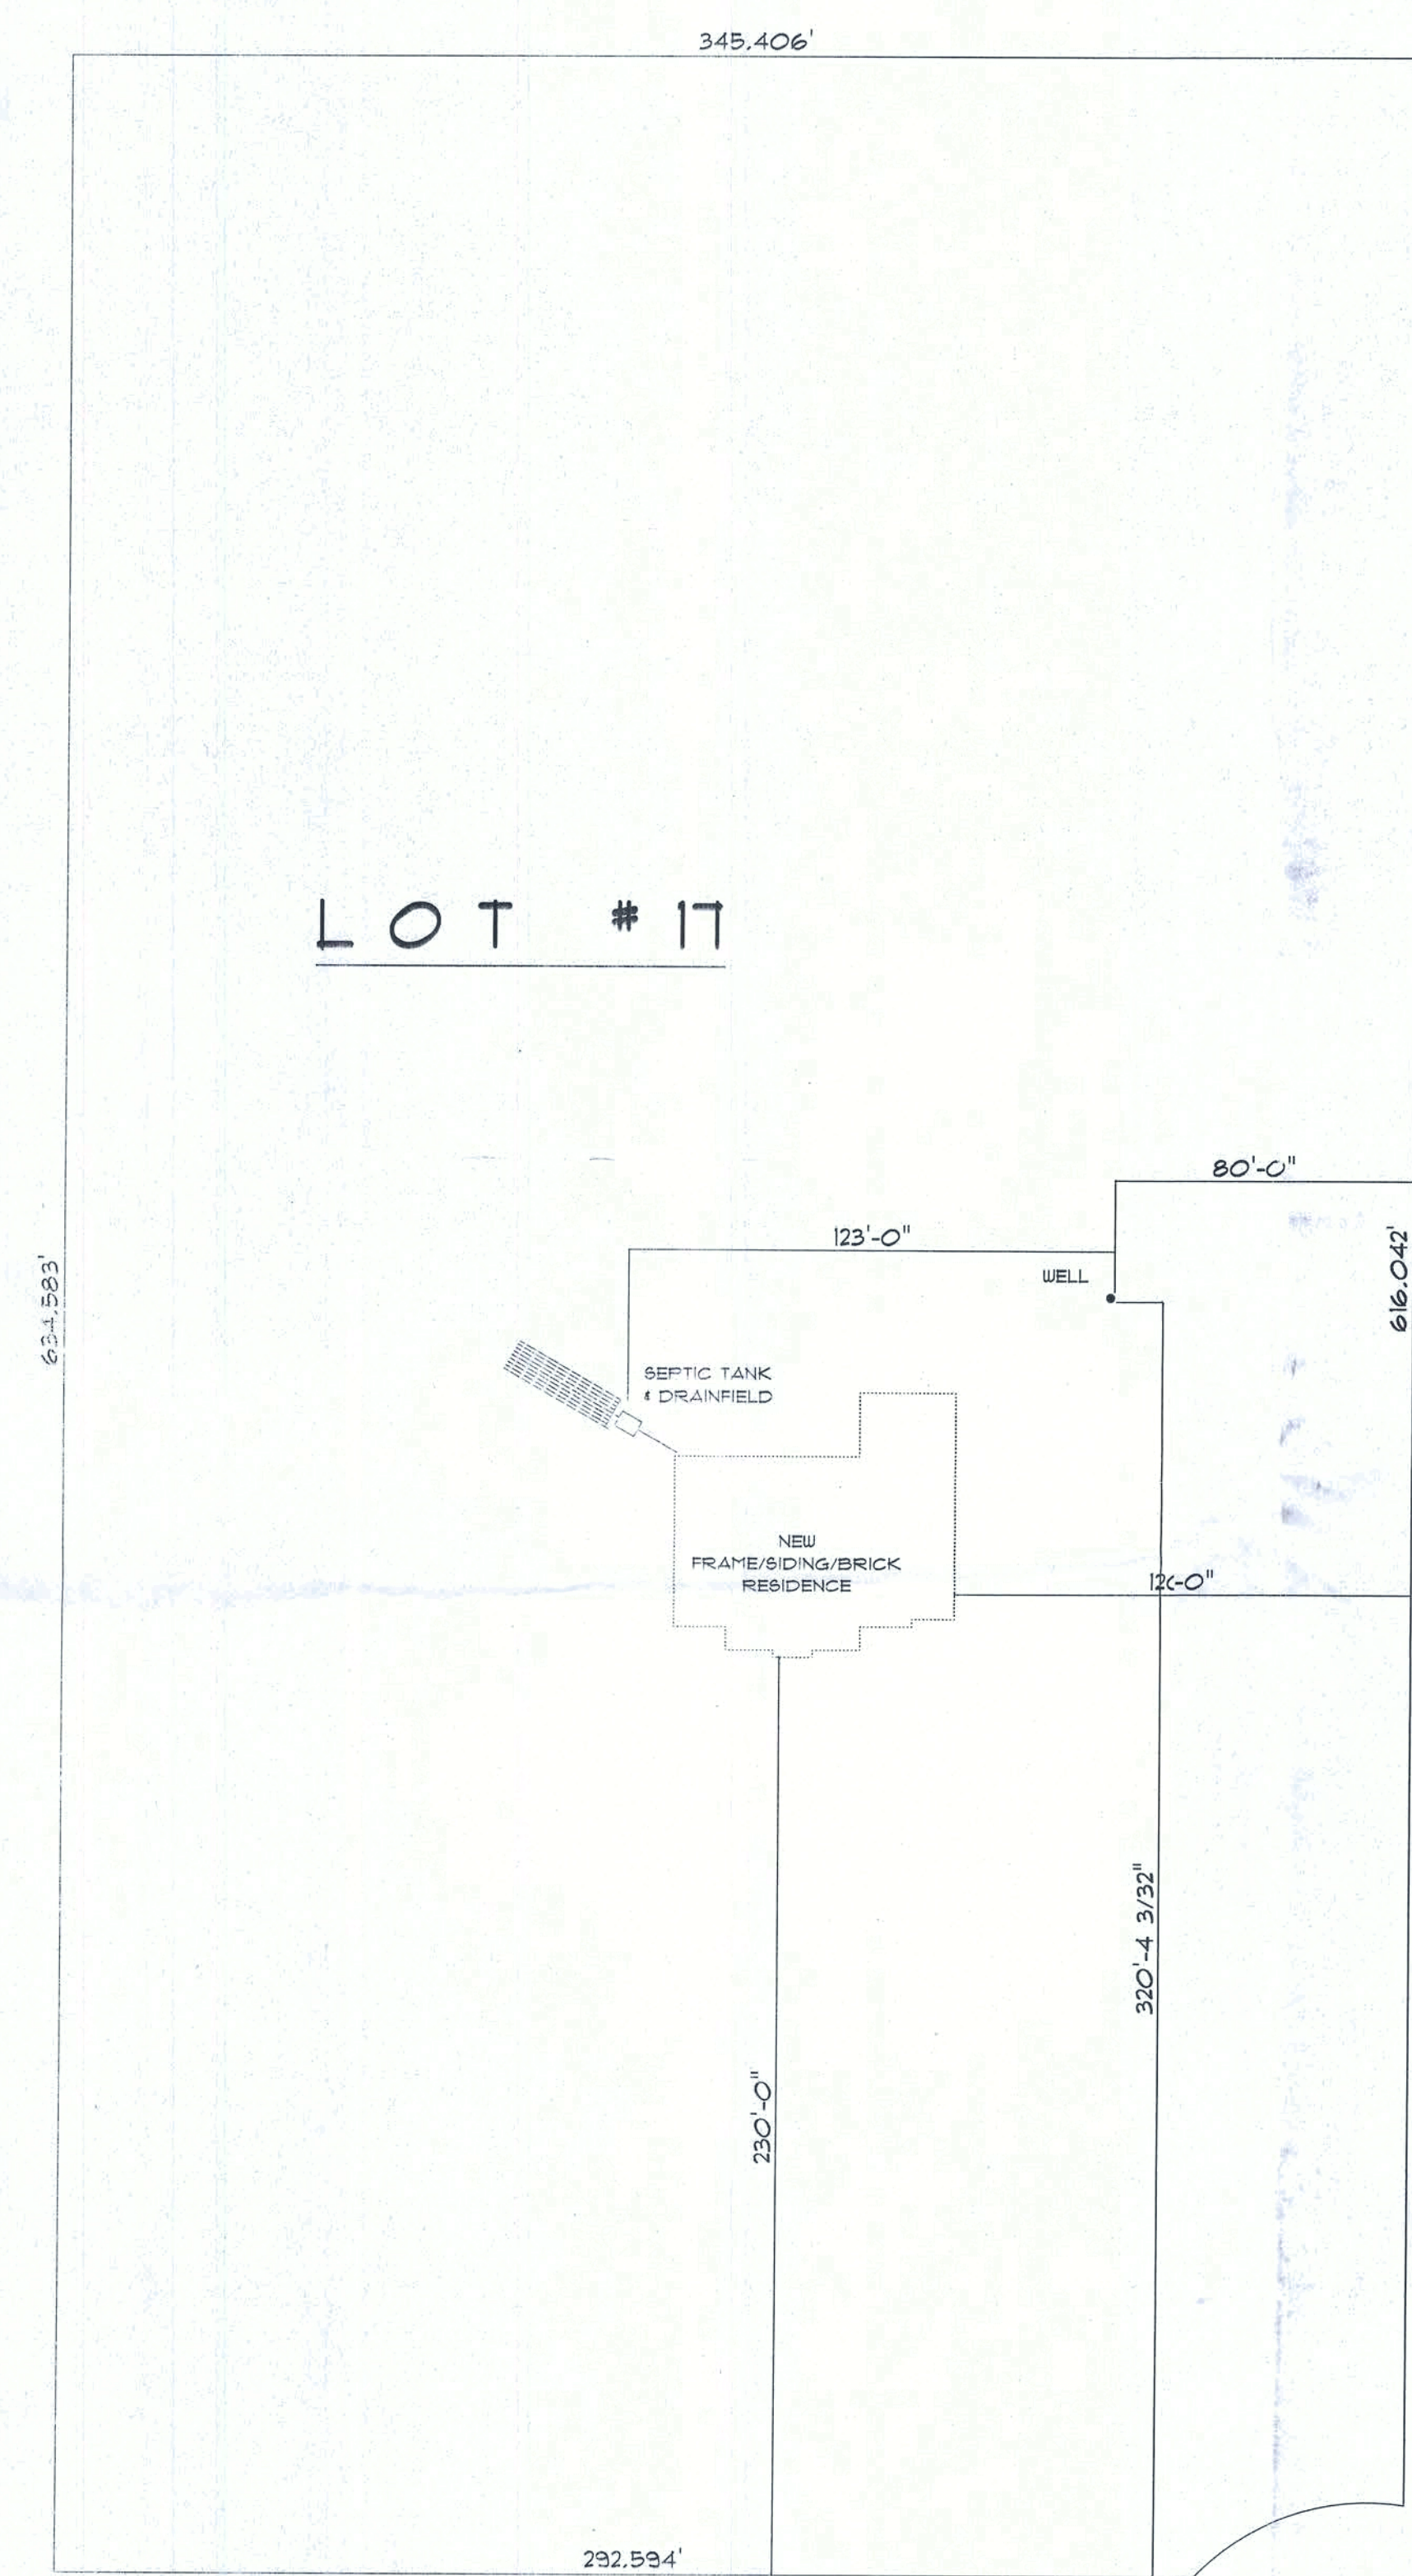


C/L S.W. MORNING STAR GLENN

* SITE PLAN *


SCALE: 1" = 40'-0"

IMPORTANT NOTE:
 IT IS THE BUILDER'S RESPONSIBILITY TO VERIFY ALL GEOMETRY AND DIMENSIONS BEFORE ORDERING ANY MATERIALS OR BEGINNING CONSTRUCTION.
 THESE PLANS ARE FOR LAYOUT AND DESIGN PURPOSES ONLY ALL STRUCTURAL NOTES AND DETAILS TO BE PROVIDED BY AN ENGINEER.

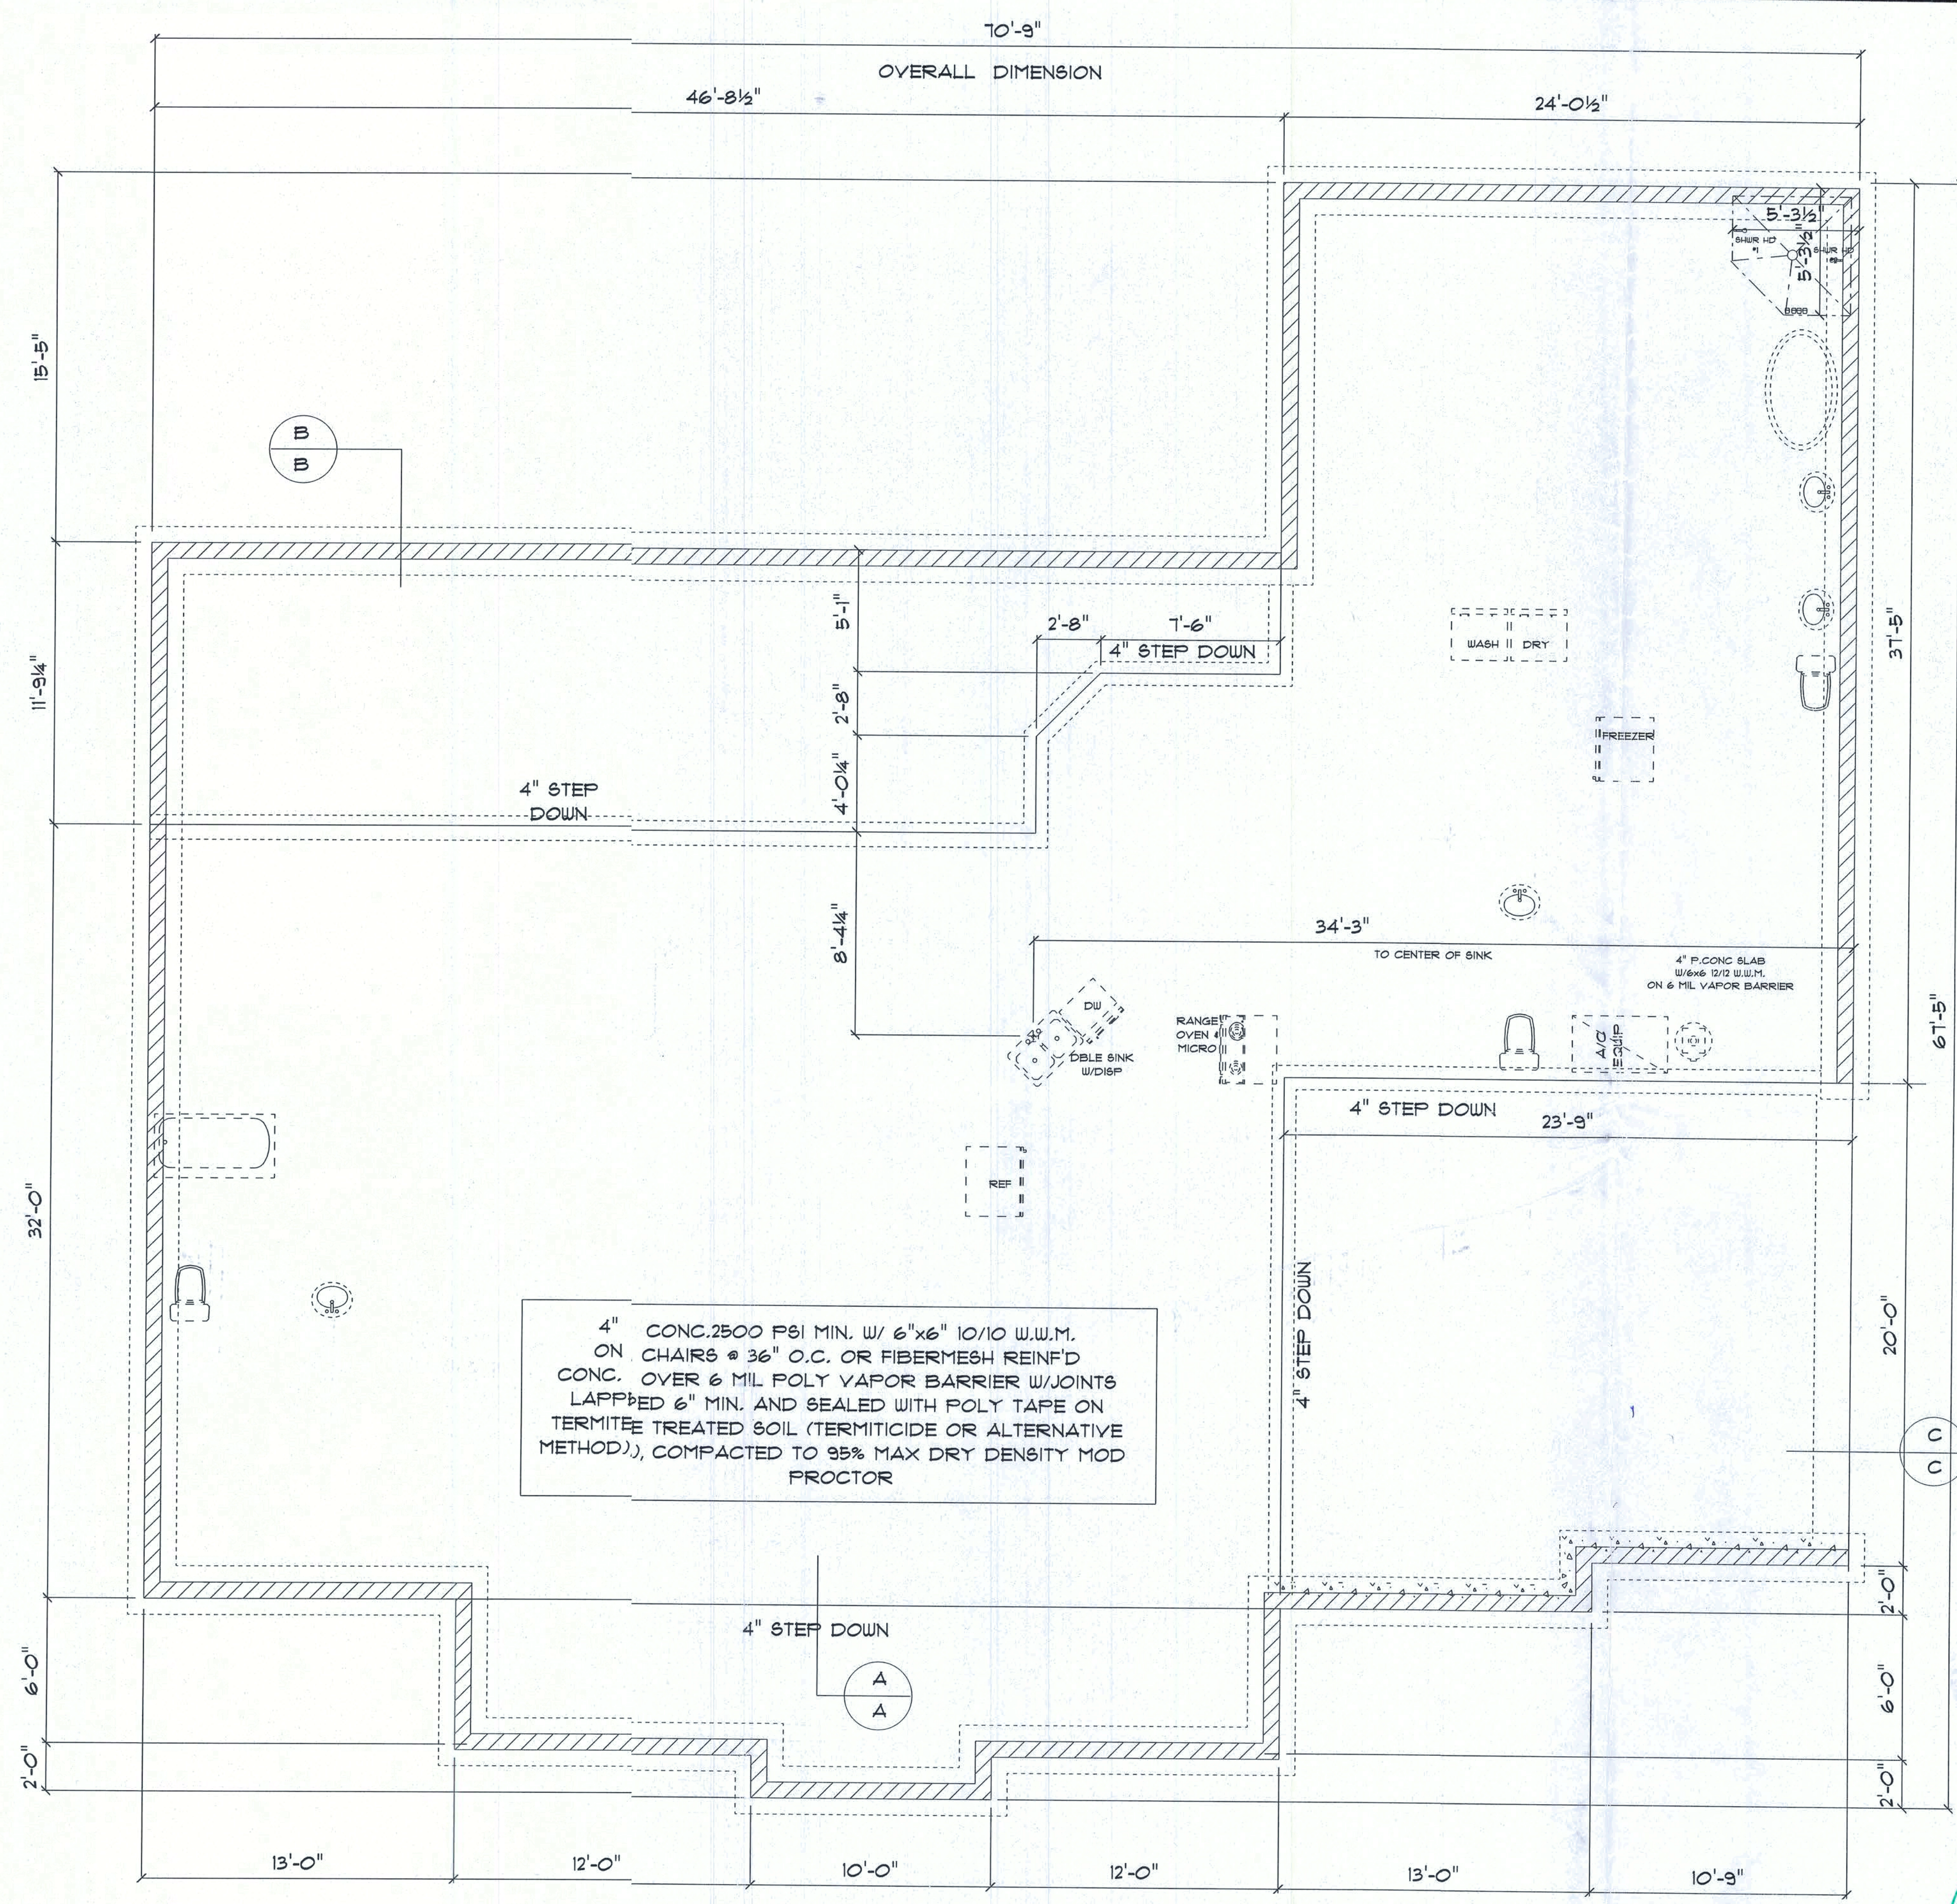


* FOUNDATION PLAN *

SCALE : 1/4" = 1'-0"

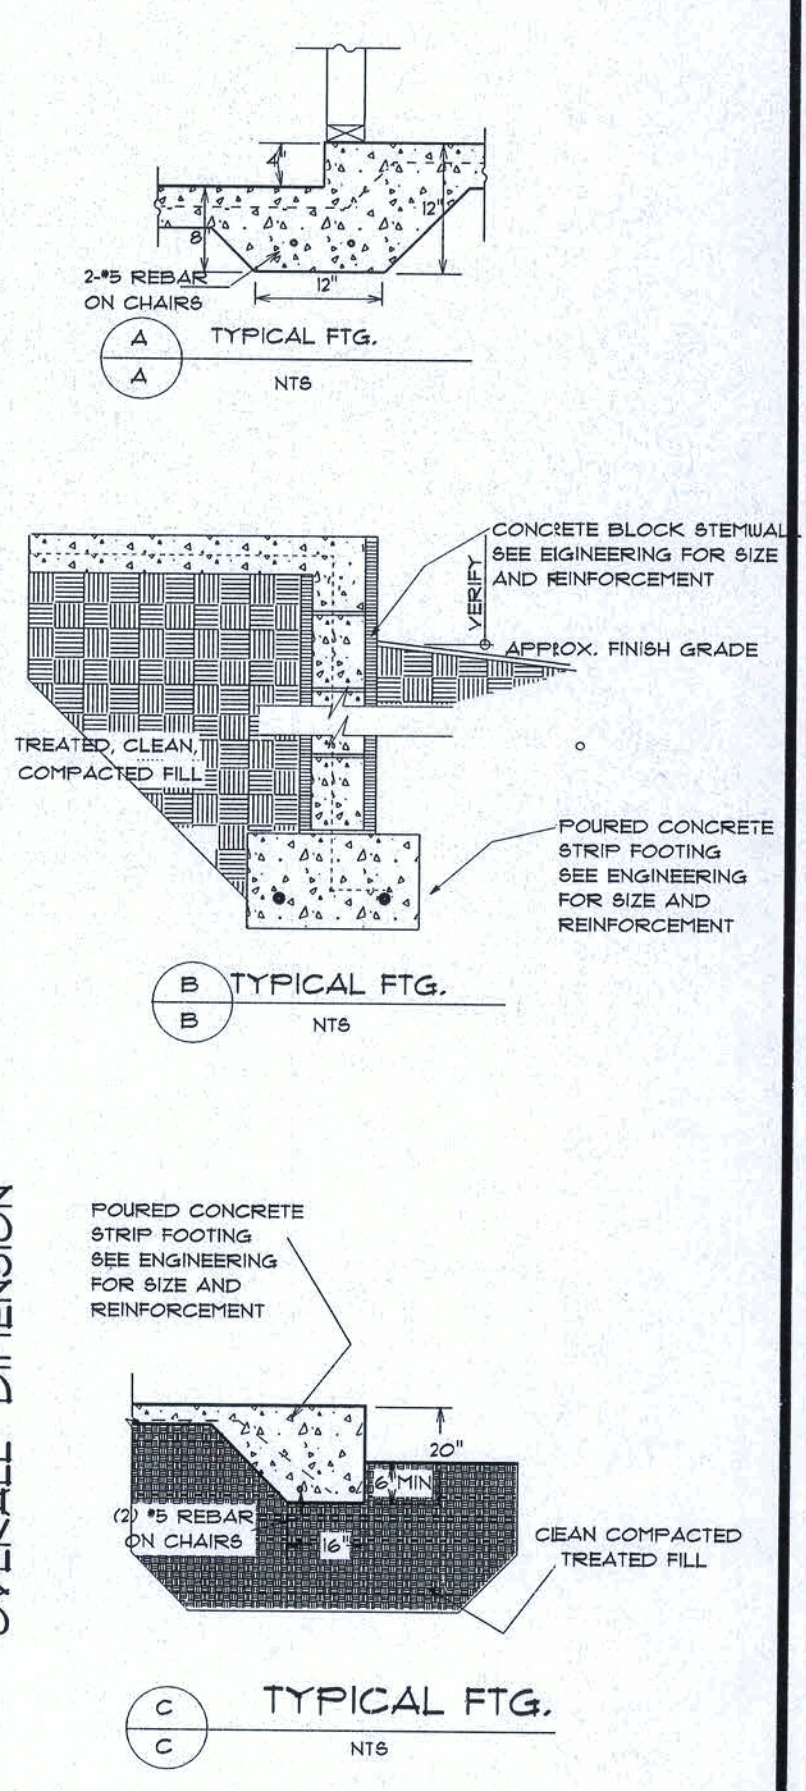

OVERALL DIMENSION

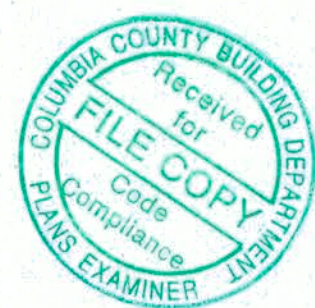

RESIDENCE
 for
RICKY & SUZANNE STEVART

450 SW MORNING STAR GLEN
 FOR WHITE
 FLORIDA, 32038

Teresa M. Ruffo
 2925 SW SR 41
 Lake City Florida, 32025
 Cell: (386.861-1181)
 Email: teranaruffo@gmail.com

PRINTED DATE:
 Friday, April 20, 2018

DRAWN BY: CHECKED BY:
 Teresa M. Ruffo

BUILDING CONTRACTOR



FINALS DATE:

JOB NUMBER:

DRAWING NUMBER

A-1

OF 4 SHEETS

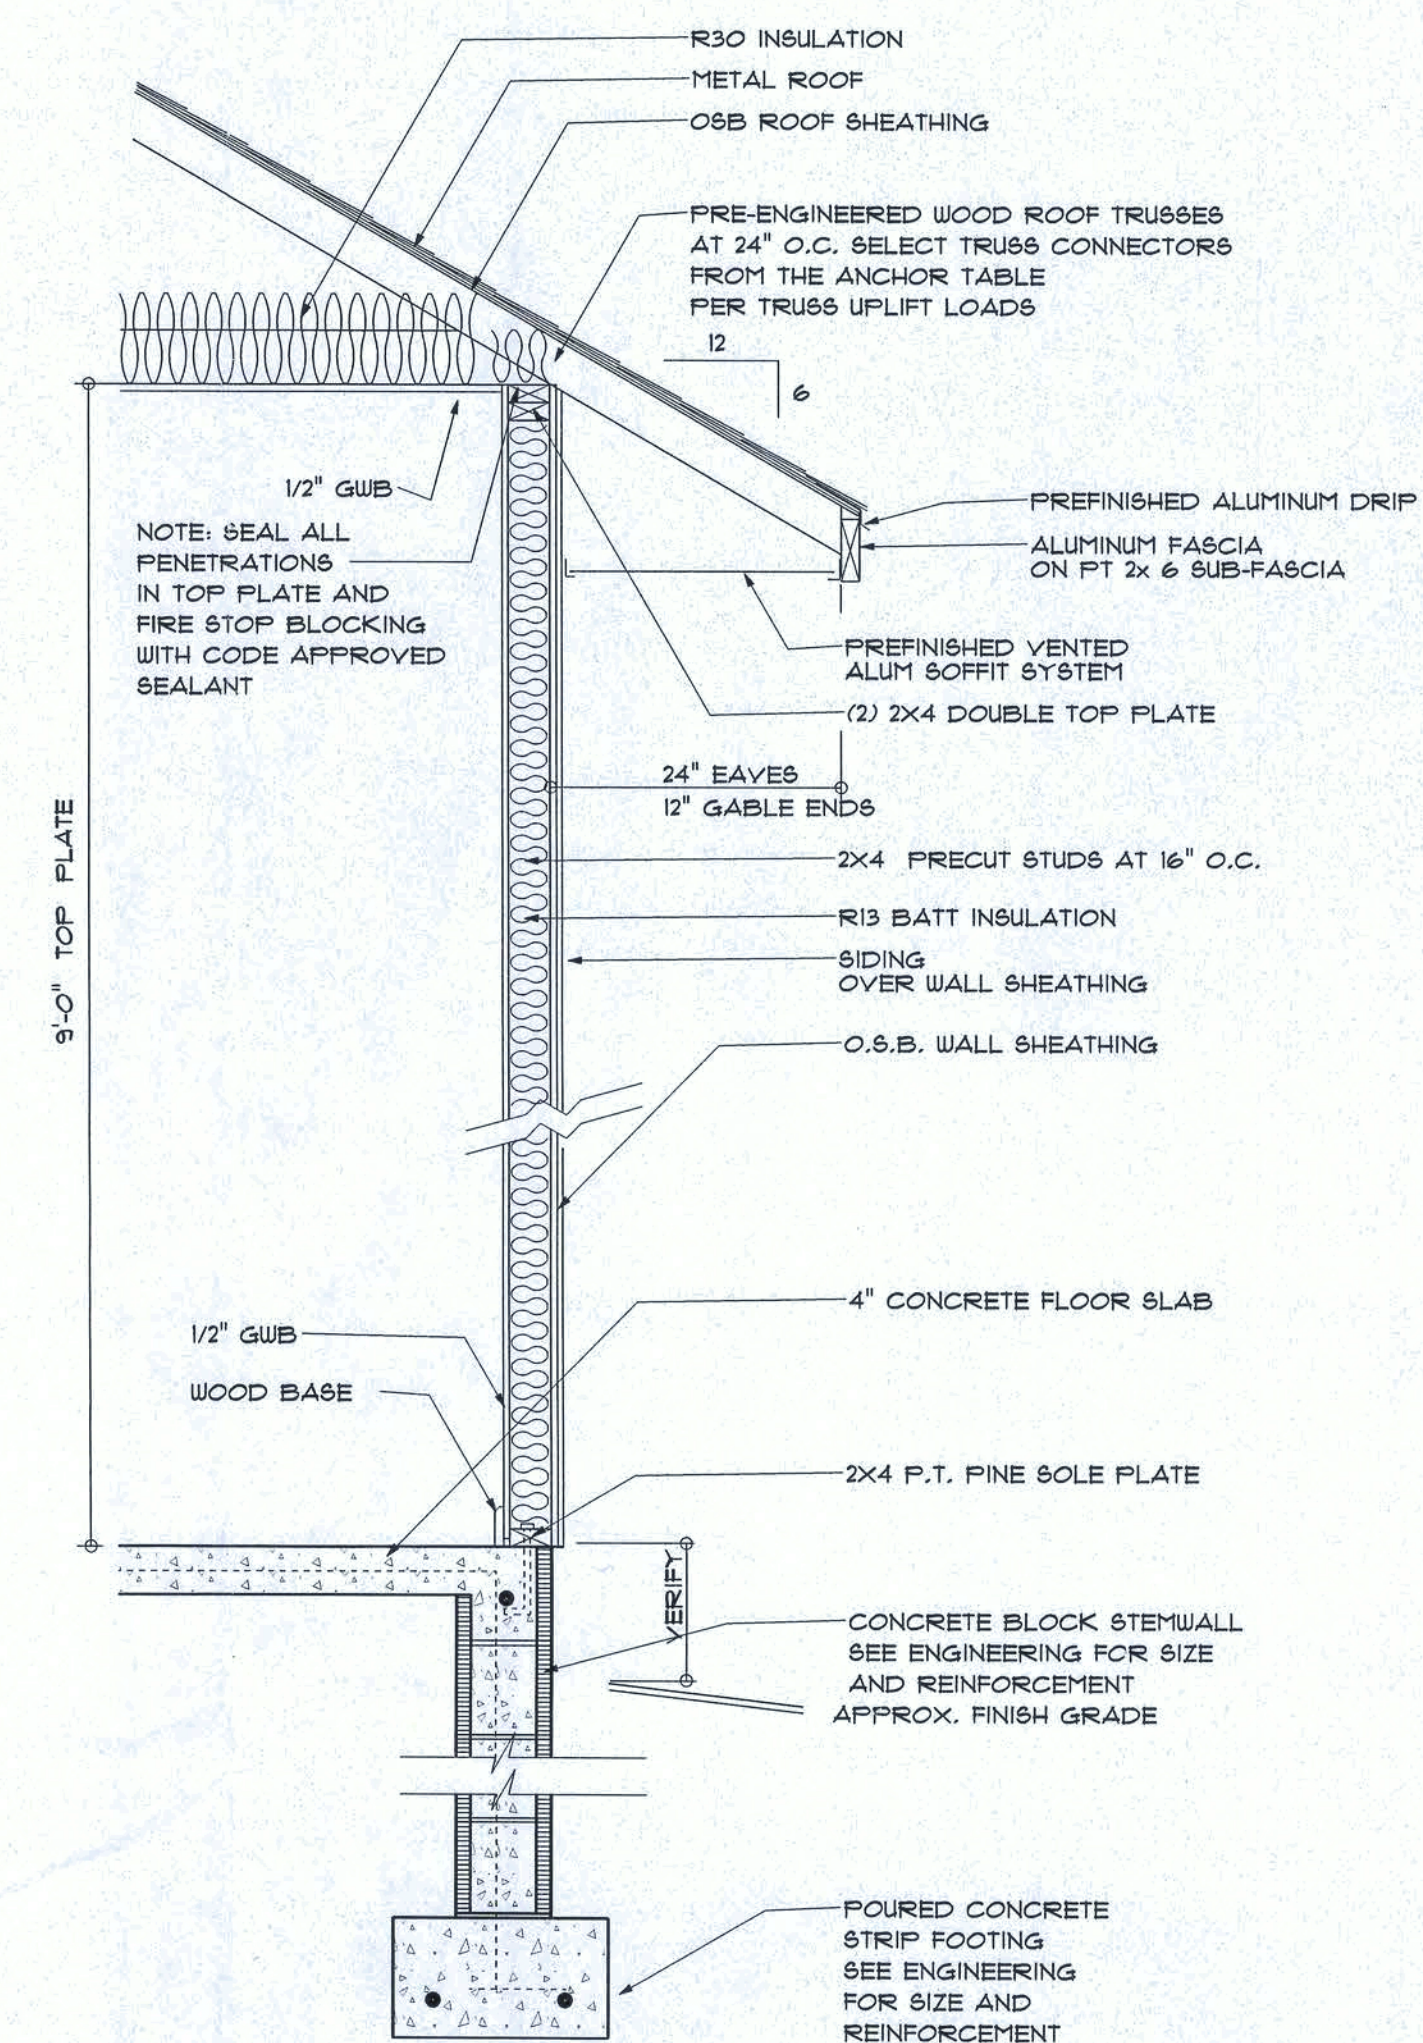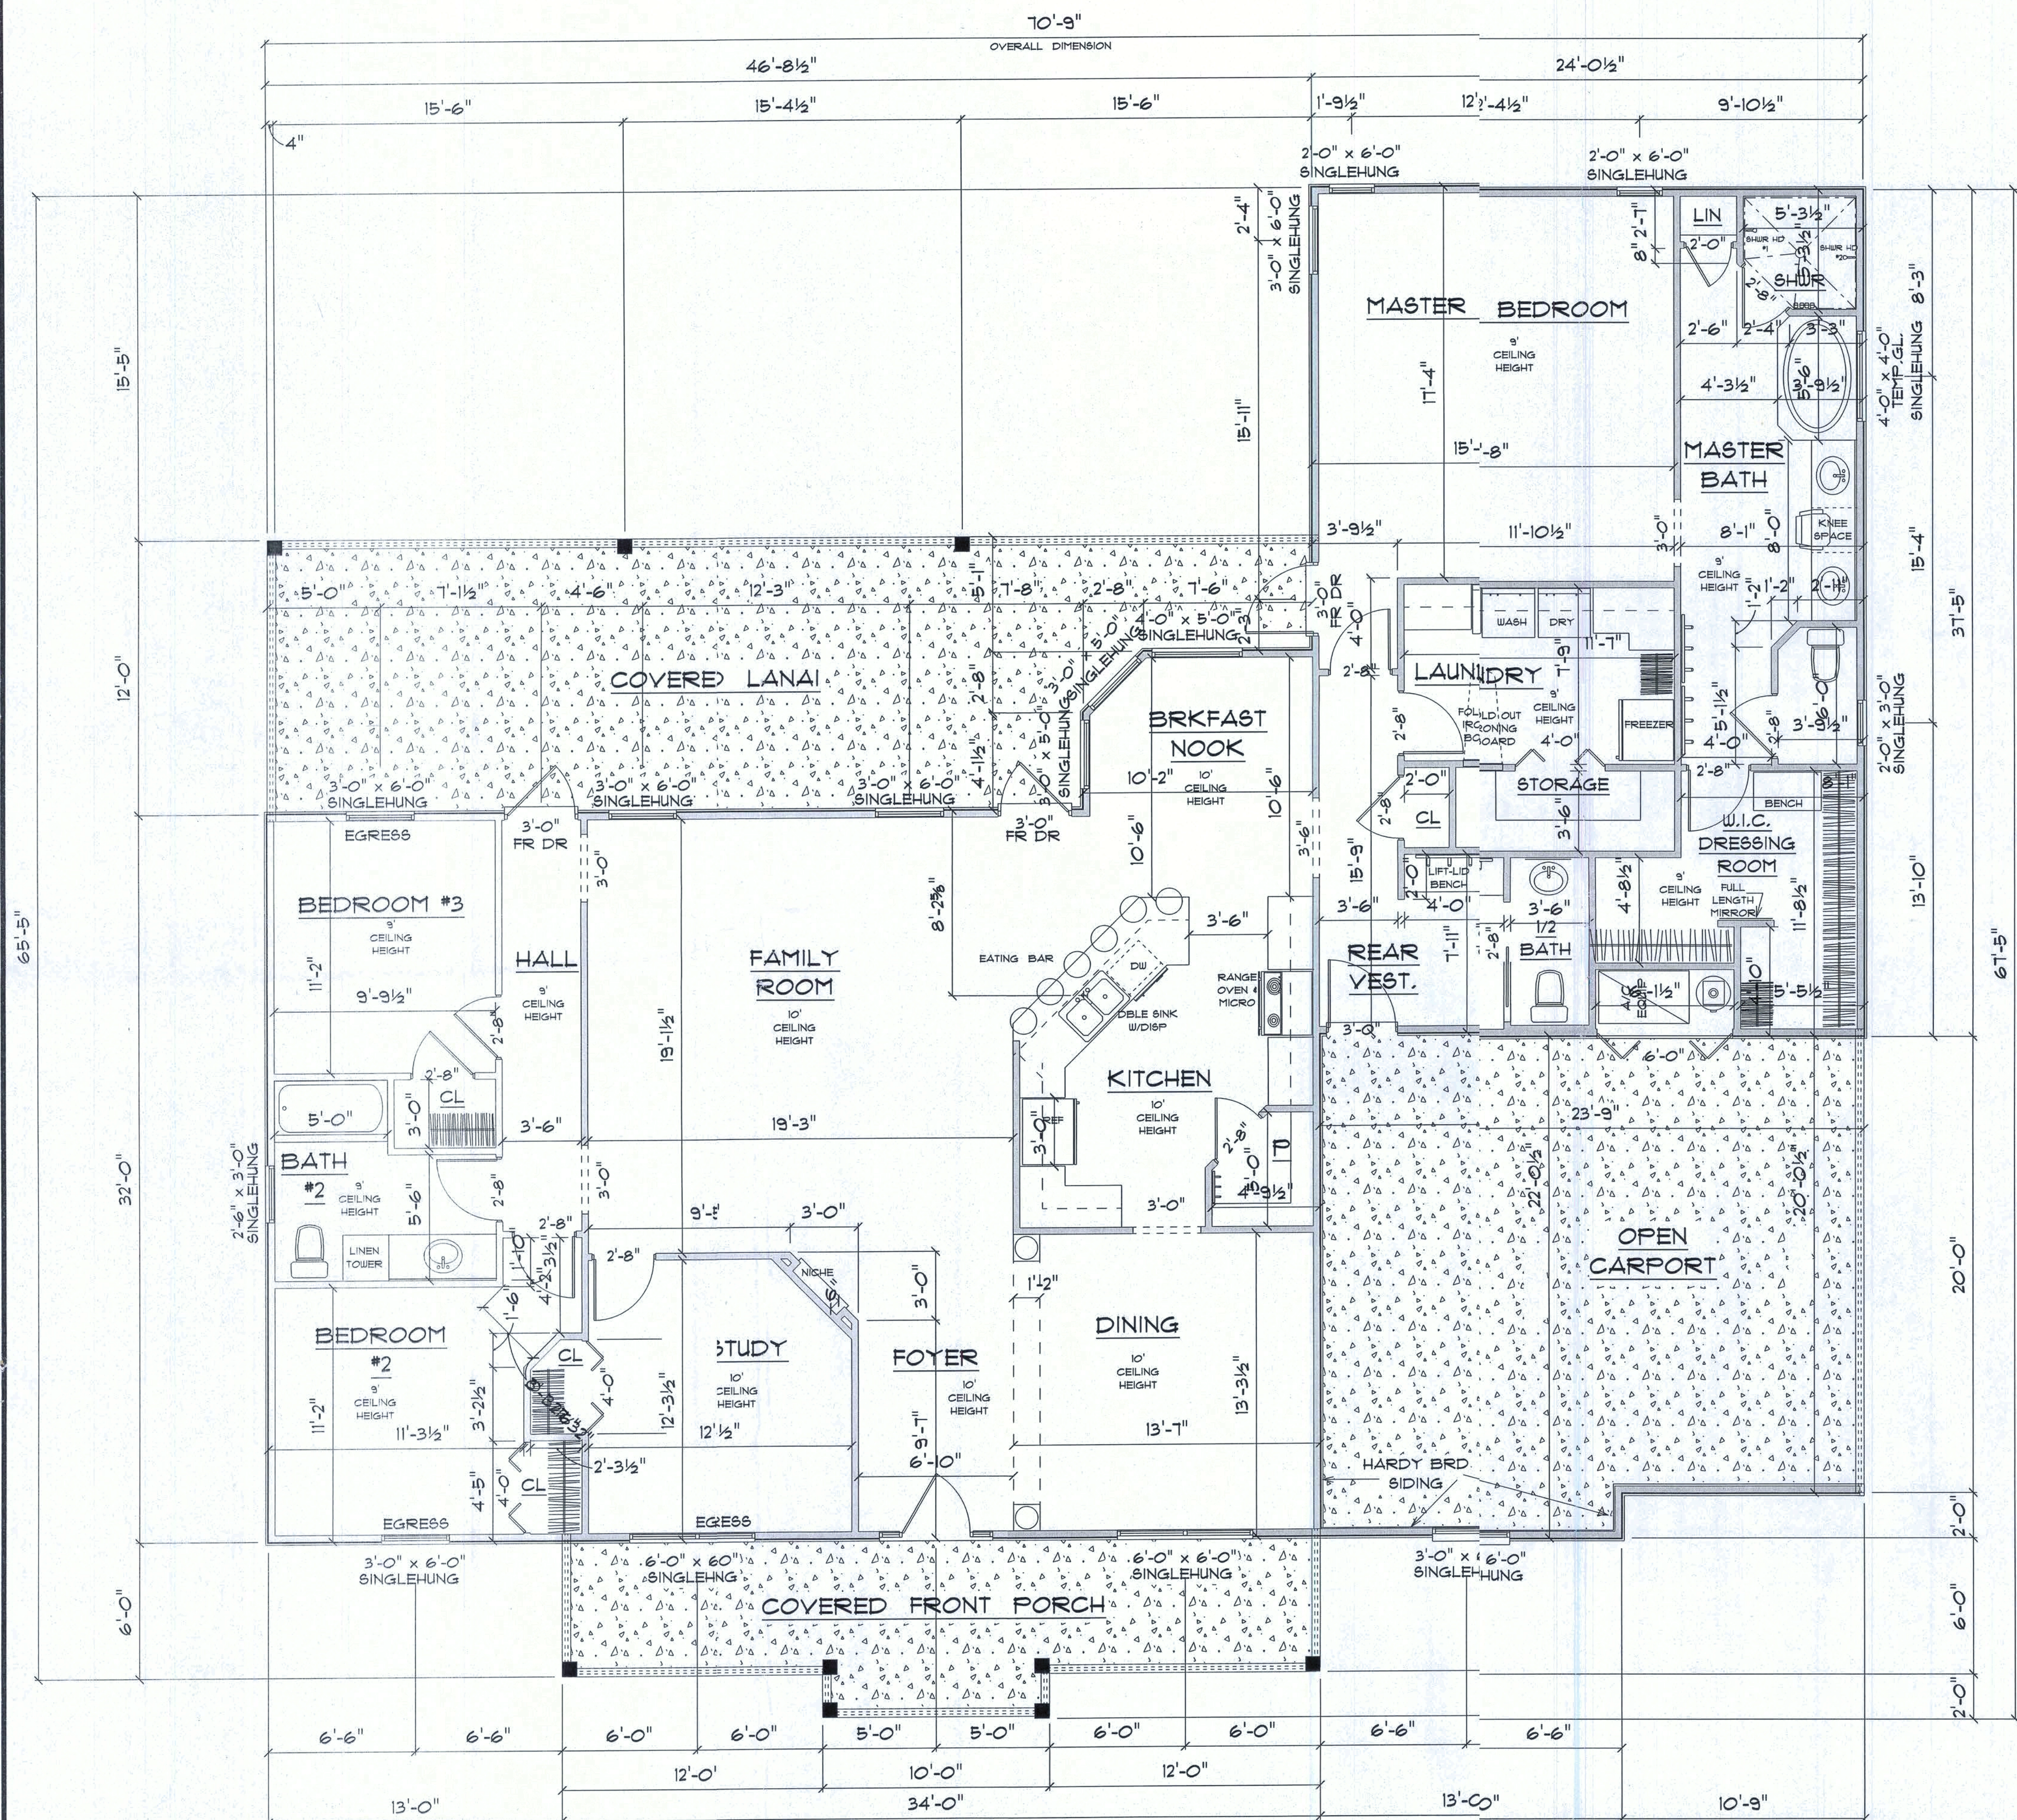

* FLOOR PLAN *

SCALE : $1/4" = 1' = 0"$

A/C LIVING AREA	=	2445 S.F.
COVERED LANAI	=	494 S.F.
COVERED FRONT PORCH	=	223 S.F.
CARPORT & MECH RM	=	527 S.F.
TOTAL AREA UNDER ROOF	=	3689 S.F.

RESIDENCE
for
RICKY & SIZANNE
STEWART

450 SW MORNING STAR GLEN
FORT WHITE
FLORIDA 32038

Teena M. Ruffo
2925 SW 47
Lake City Florida, 32025
Cell: (386) 867 - 1191
Email: teenaruffe@gmail.com

PRINTED DATE:
Friday, April 20, 2018

DRAIN BY:	CHECKED BY:
-----------	-------------

Teena M. Ruff

	BUILDING CONTRACTS
--	--------------------

FINAL 5 DATE

	JOB NUMBER
--	------------

DRAWING NUMBER

10


A-2
OF 4 SHEETS



* FRONT ELEVATION *


SCALE : 3/16" = 1'-0"

12" OVERHANG ON GABLE ENDS
24" OVERHANG ALL OTHER EAVES

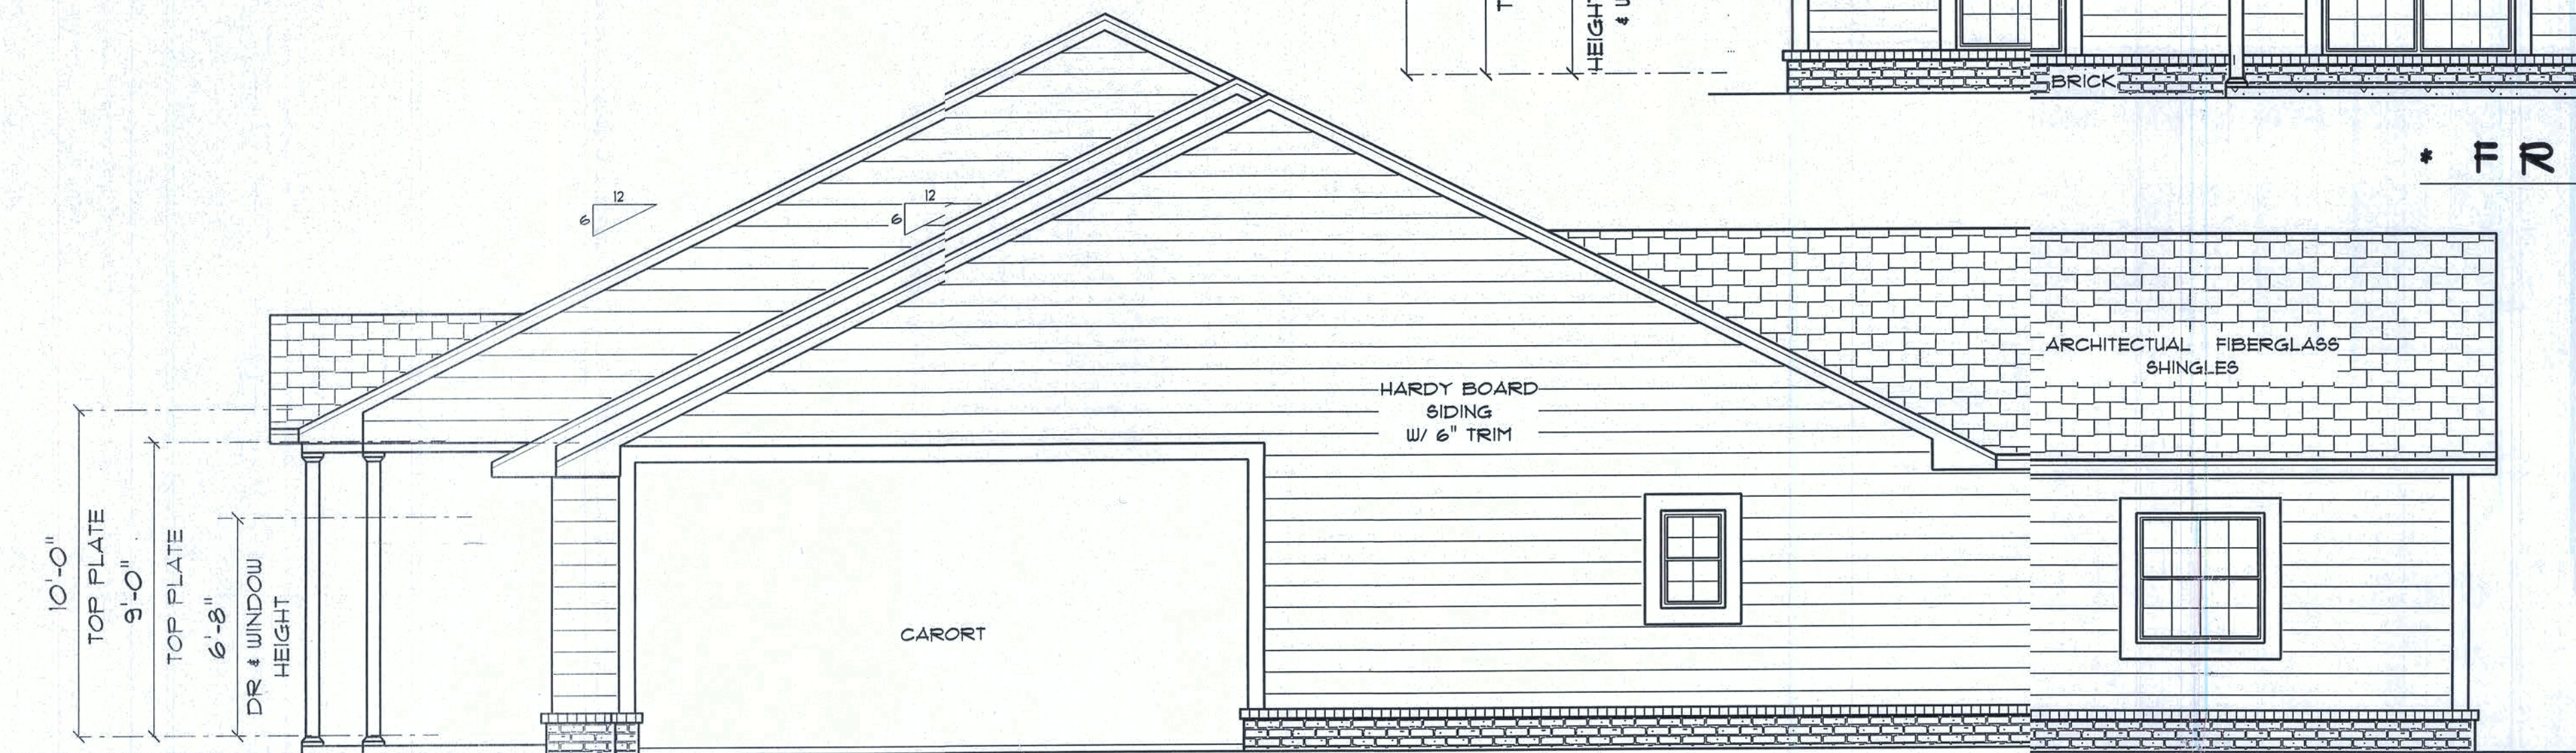

* RIGHT SIDE ELEVATION *

SCALE : 1/4" = 1'-0"

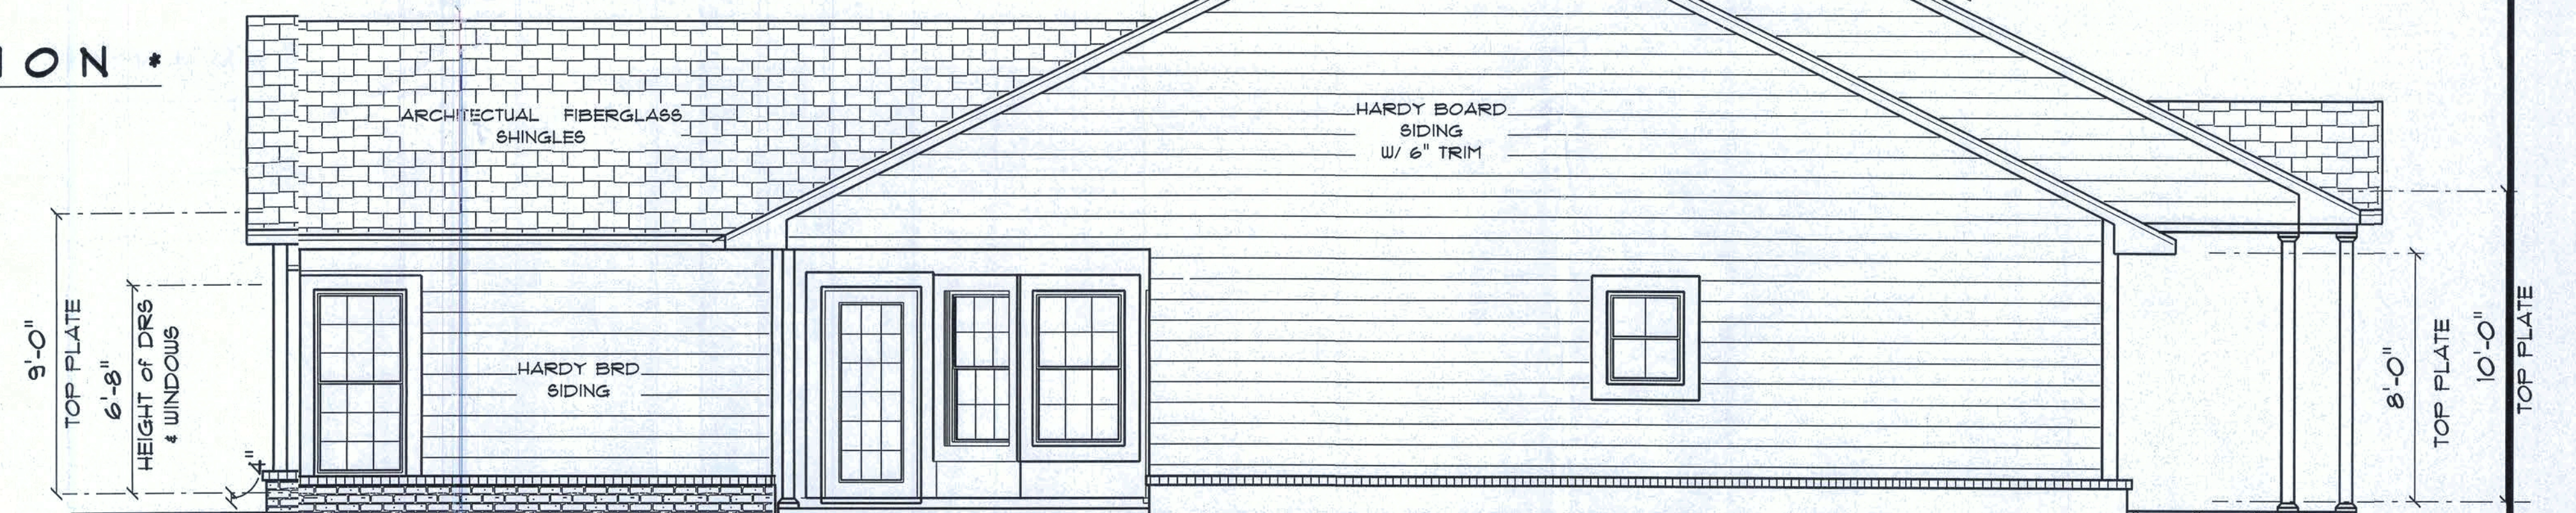

* LEFT SIDE ELEVATION *

SCALE : 1/4" = 1'-0"



* REAR ELEVATION *

SCALE : 1/4" = 1'-0"

RESIDENCE
for
RICKY & SUZANNE
STEWART

450 SW MORNING STAR GLEN
FORT WHITE
FLORIDA, 32038

Teena M. Ruffo
2325 SW 8th 41
Lake City, Florida, 32025
Cell: (386) 861-1191
Email: teenaruffo@gmail.com

PRINTED DATE:
Friday, April 20, 2018

DRAWN BY: TEENA M. RUFFO
CHECKED BY:
BUILDING CONTRACTOR

FINALS DATE:

JOB NUMBER:

DRAWING NUMBER


A-3

OF 4 SHEETS

ELECTRICAL PLAN NOTES

- E-1 WIRE ALL APPLIANCES, HVAC UNITS AND OTHER EQUIPMENT PER MANUFACTURER'S SPECIFICATIONS.
- E-2 CONSULT THE OWNER FOR THE NUMBER OF SEPERATE TELEPHONE LINES TO BE INSTALLED.
- E-3 ALL INSTALLATIONS SHALL BE PER NATIONAL ELECTRIC CODE.
- E-4 ALL SMOKE DETECTORS SHALL BE 120V W/BATTERY BACKUP OF THE PHOTOELECTRIC TYPE, AND SHALL BE INTERLOCKED TOGETHER. INSTALL INSIDE AND NEAR ALL BEDROOMS.
- E-5 TELEPHONE, TELEVISION AND OTHER LOW VOLTAGE DEVICES OR OUTLETS SHALL BE AS PER THE OWNER'S DIRECTION AND IN ACCORDANCE WITH APPLICABLE SECTIONS OF NATIONAL ELCT. CODE LATEST EDITION.
- E-6 ELECTRICAL CONTRACTOR SHALL BE RESPONSIBLE FOR THE DESIGN AND SIZING OF ELECTRICAL SERVICE AND CIRCUITS.
- E-7 ENTRY OF SERVICE UNDERGROUND OR OVERHEAD) IS TO BE DETERMINED BY THE POWER COMPANY.
- E-8 ALL BEDROOM RECEPTALS ARE TO BE AFCI (ARC FAULT CIRCUIT INTERRUPT)

ELECTRICAL LEGEND		
ELECTRICAL	COUNT	SYMBOL
chandelier	2	☼
double spotlight	1	☼
fluorescenifixture	2	☼
200 amp service panel	1	☼
cable tv outlet	2	☼
ceiling fan	9	☼
dimmer swith	1	☼
electric mder	1	☼
gfi waterpprof outlet	1	☼
jamb switcl	1	☼
light	6	☼
outlet	44	☼
outlet 220	2	☼
outlet gfi	12	☼
recessed an light	30	☼
smoke detector	5	☼
switch	27	☼
switch 3 wy	10	☼
switch 4 wy	3	☼
vent light:ombo	4	☼

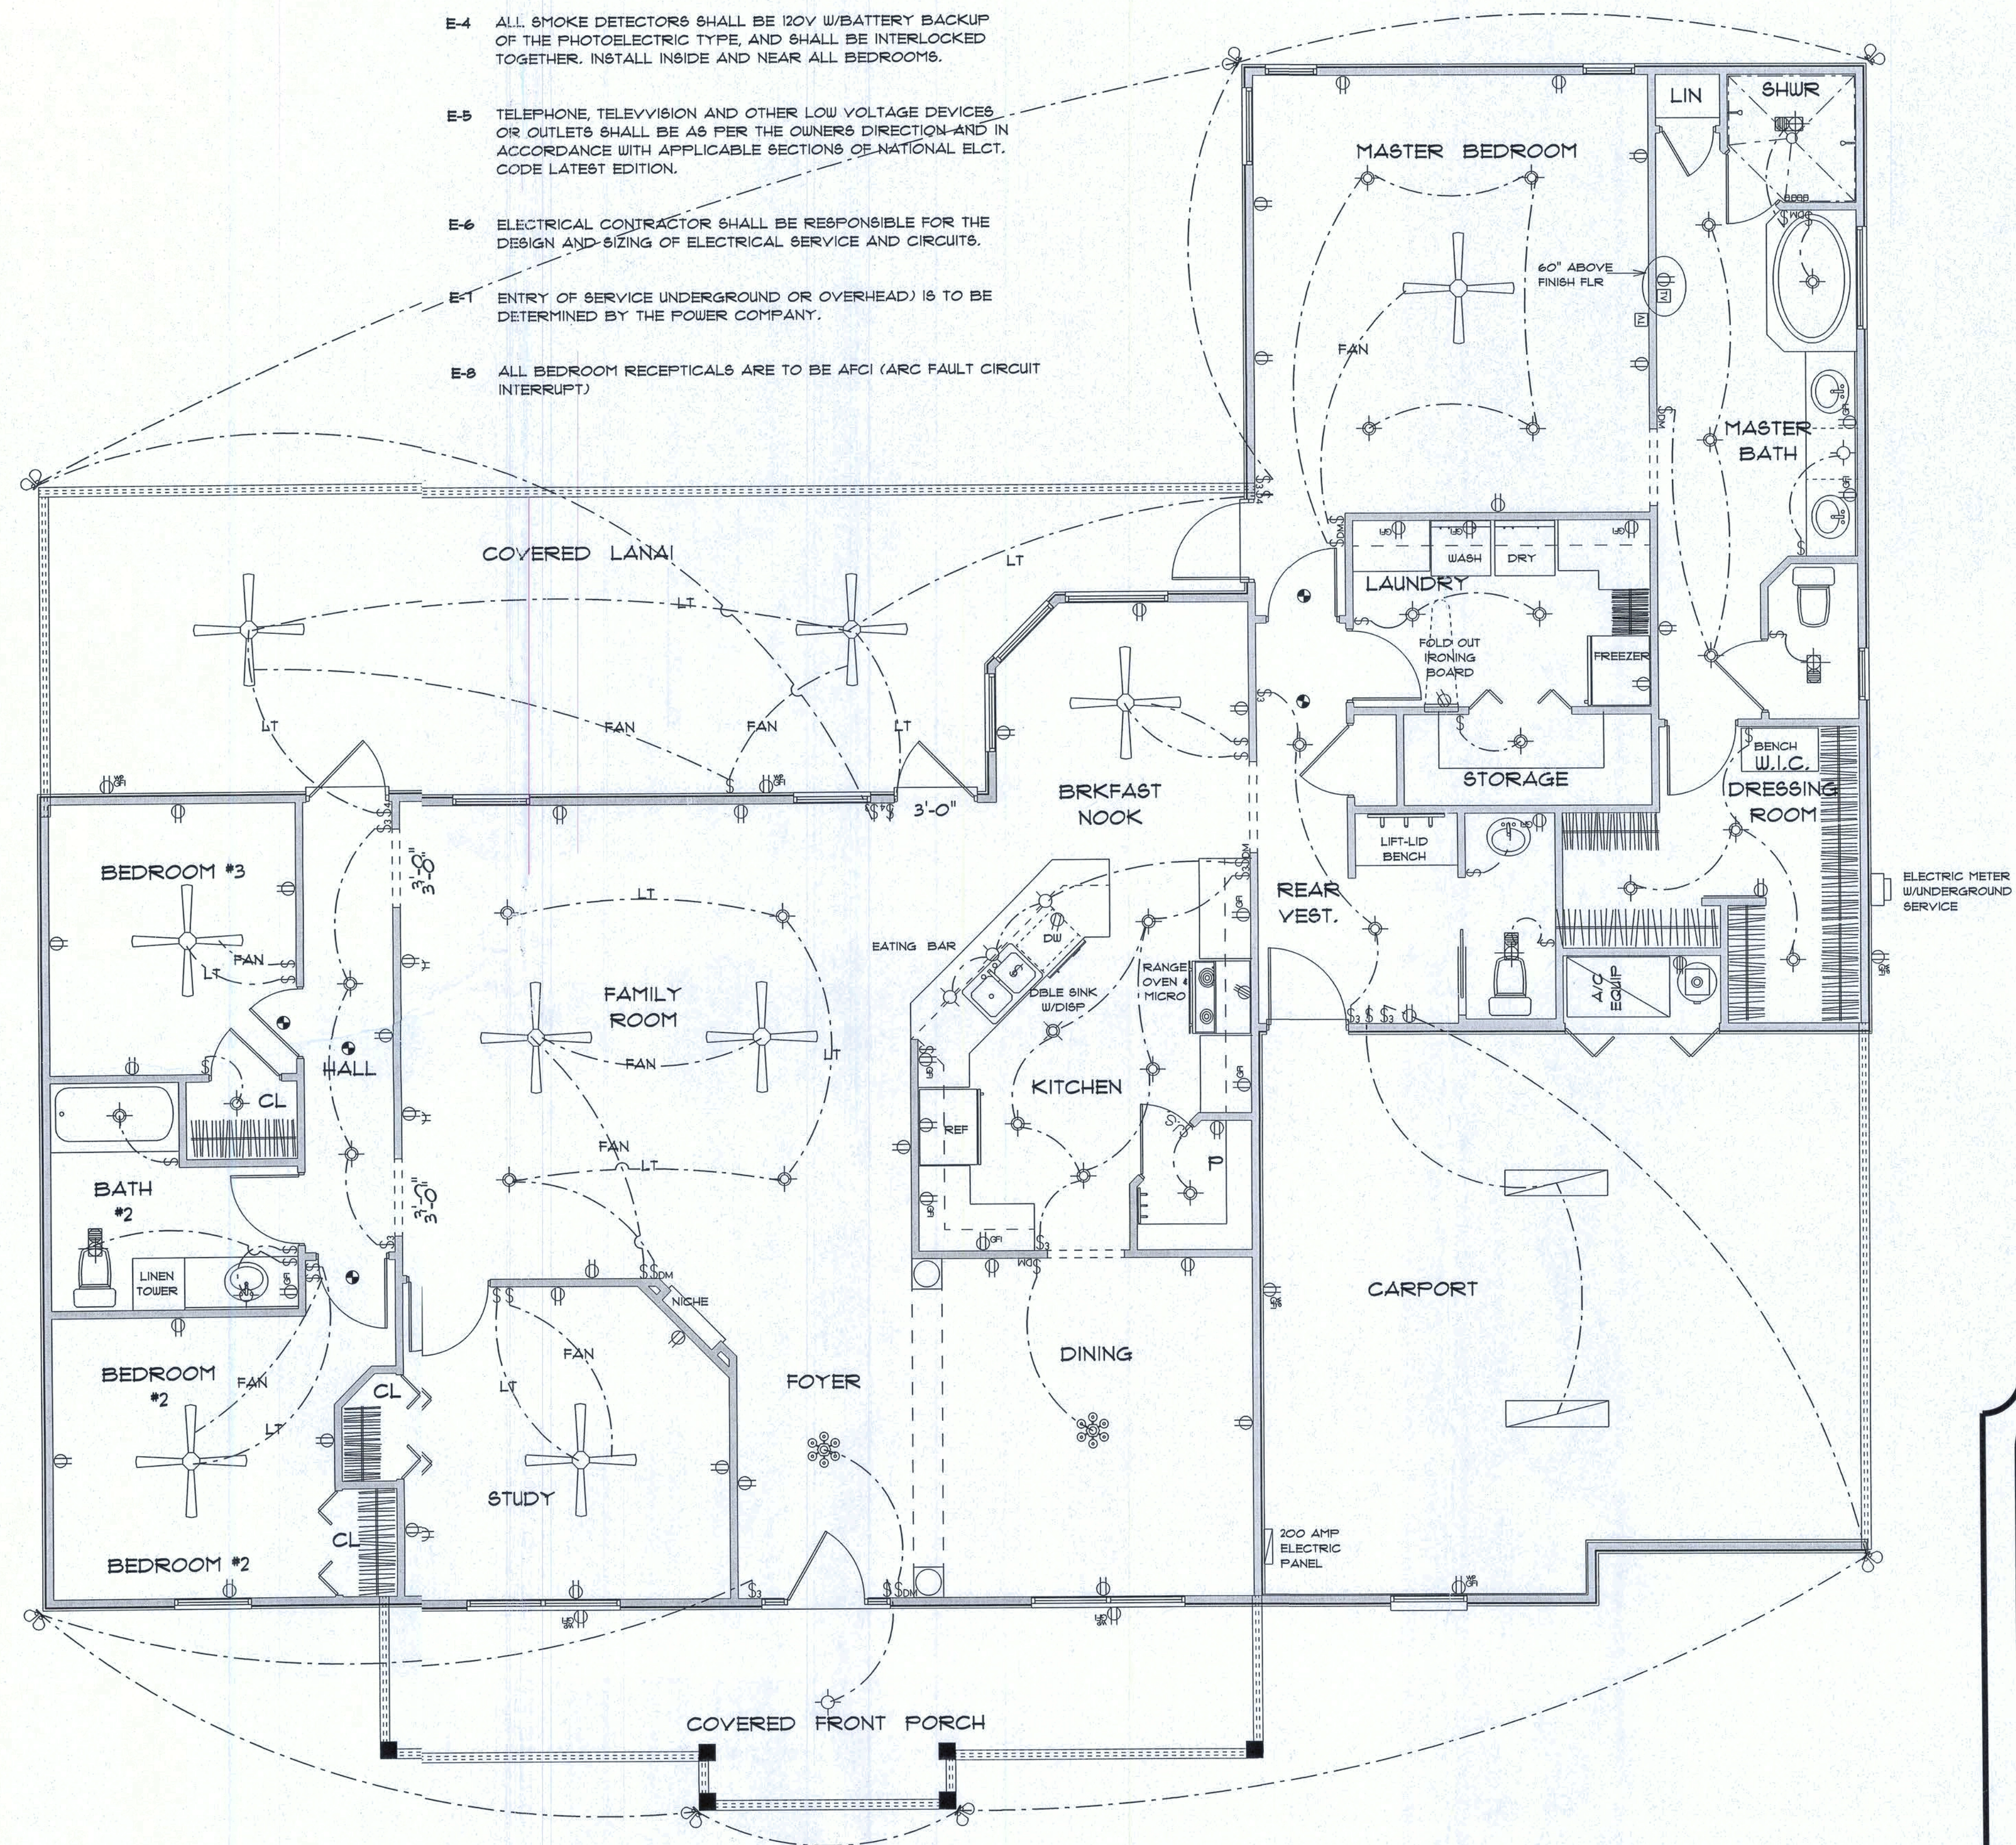

* ELECTRICAL PLAN *

SCALE : 1/4" = 1'-0"

RESIDENCE
for
RICKY & SULLANNE
STEWART450 SW MORNINGSTAR GLEN
FORT WHITE
FLORIDA, 32038Teresa M. Ruffo
2025 SW 5th St
Lake City, Florida, 32025
Cell: (386) 86-1181
Email: teraruffo@gmail.comPRINTED DATE:
Friday, April 21, 2018
DRAWN BY: (CHECKED BY):
Teresa M. Ruffo
BUILDING CONTRACTORFINALS DATE:
JOB NUMBER:DRAWING NUMBER
A-4
OF 4 SHEETS