



REVISIONS		
02 / MAY / 03	DMD	


SOFTPLAN
ARCHITECTURAL DESIGN SOFTWARE

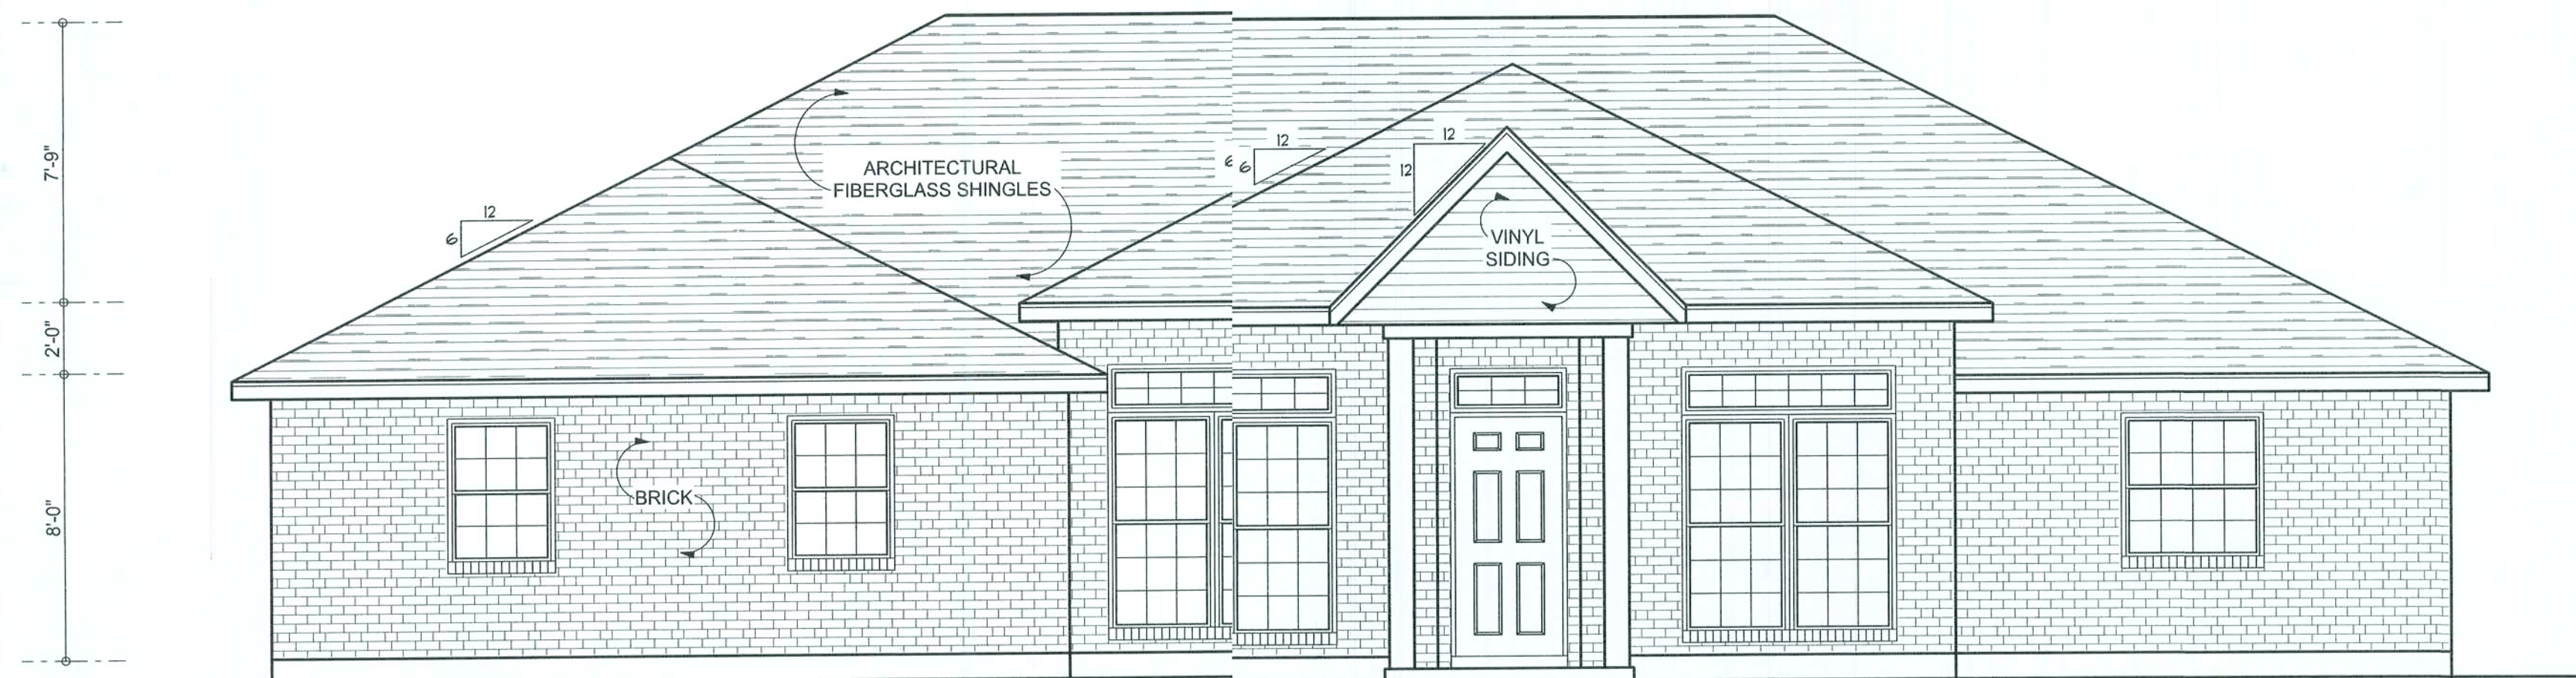

FRONT ELEVATION
SCALE: 1/4" = 1'-0"

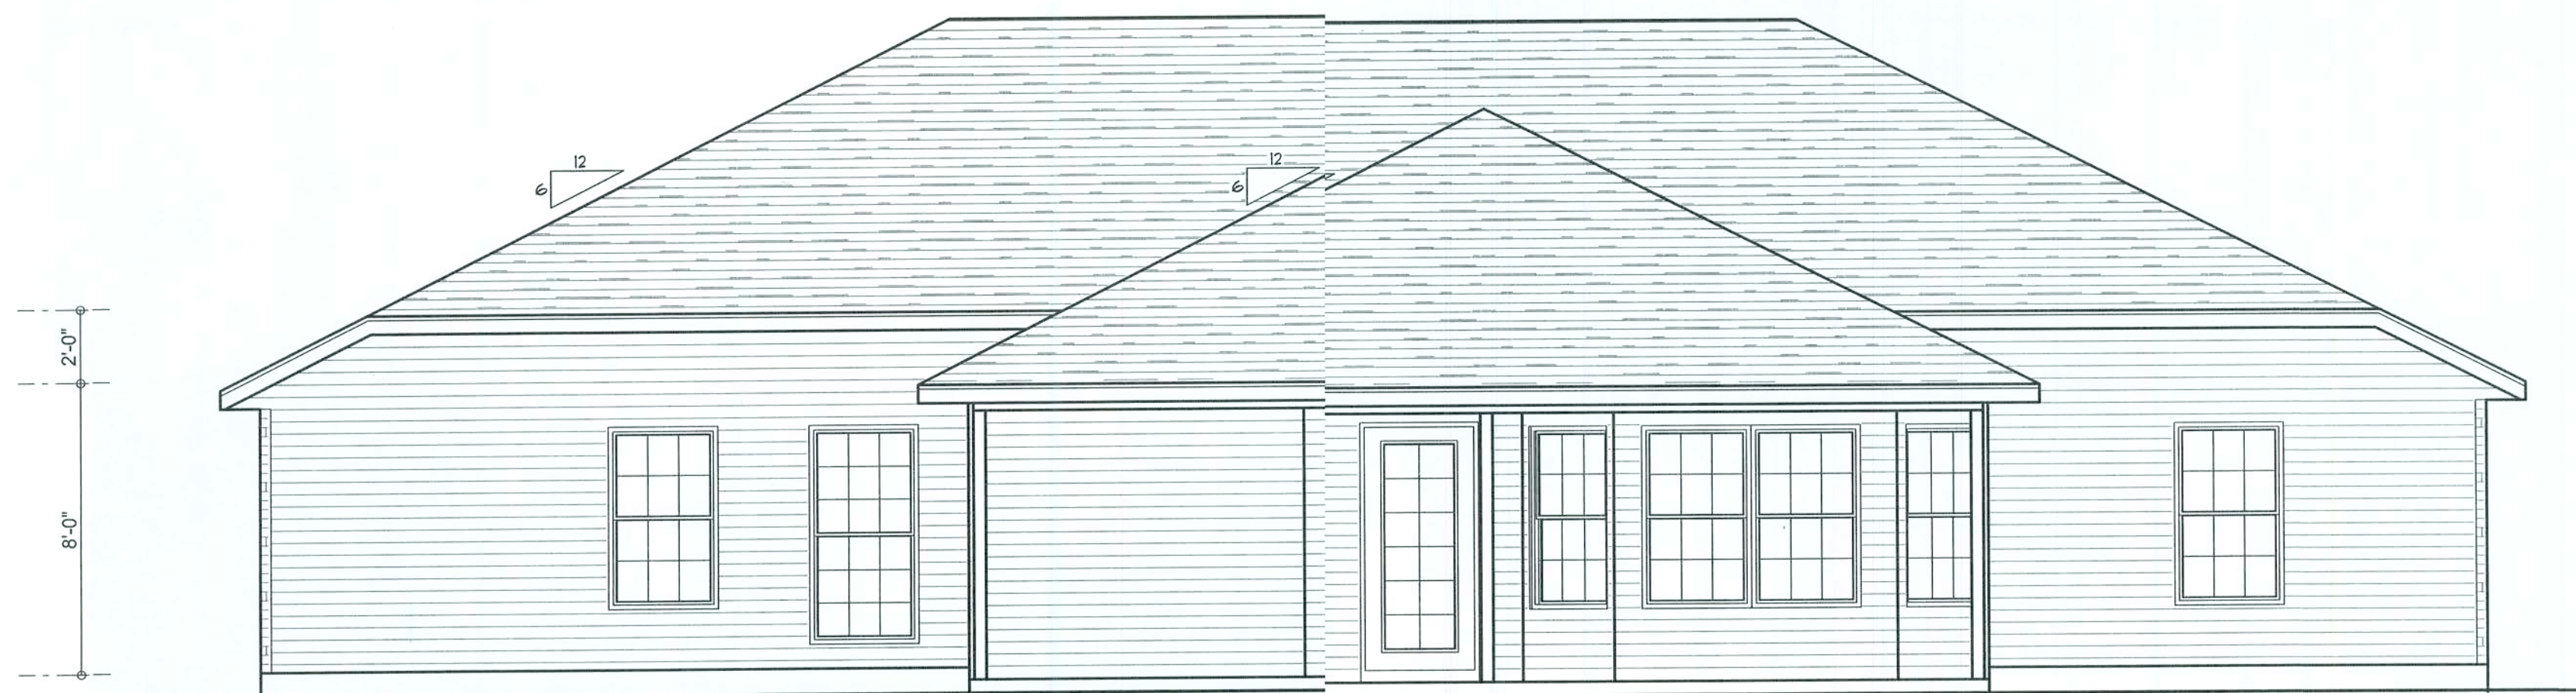

REAR ELEVATION
SCALE: 1/4" = 1'-0"

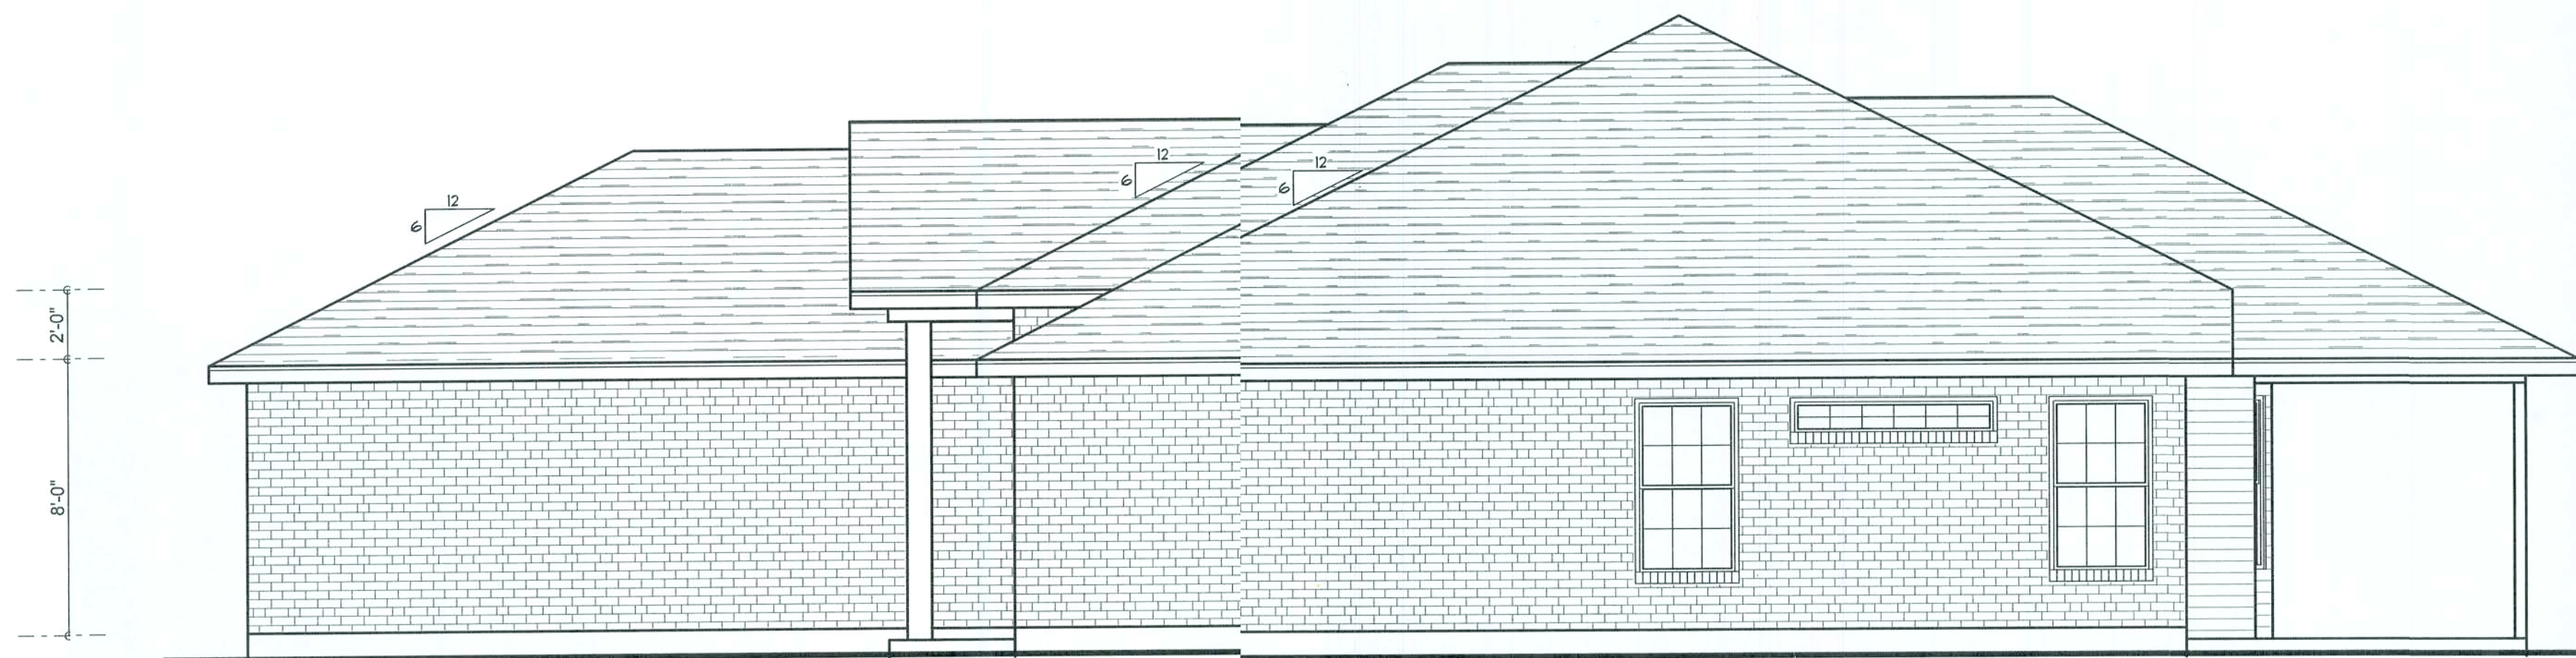

RIGHT ELEVATION
SCALE: 1/4" = 1'-0"



LEFT ELEVATION
SCALE: 1/4" = 1'-0"

WINDLOAD ENGINEER: Mark Disoway,
P.E. No. 53915, P.O. Box 88, Lake City, FL
32056, 386-754-5419

CERTIFICATION: These plans and
Windload Engineering, Sheet S-1, attached,
comply with Florida Building Code 2001,
Section 1606 wind load, to the best of my
knowledge.

LIMITATION: This design is valid for one
building, at specified location, permitted within
90 days of signature date. In case of conflict,
structural requirements, scope of work, and
builder responsibilities in sheet S-1 control.

MARK DISOWAY
P.E. 0815

Mark Disoway
02/05/03
S.E.

**SPEC HOUSE
FOR BRYAN
ZECHE
CONSTRUCTION**

ADDRESS:
Lot #3 Emerald Lakes,
Columbia County, FL

Mark Disoway P.E.
P.O. Box 888
Lake City, Florida 32026
Phone: (386) 754 - 5419
Fax: (386) 54 - 6144
Email: mdpe@bellsouth.net

PRINTED DATE:
May 02, 2003

DRAWN BY: Evan Beamsley CHECKED BY:

DESIGNED BY:
Teena Puffo


FINALS DATE:
29 / April 03

JOB NUMBER:
30-241

DRAWING NUMBER

A-1
OF 5 SHEETS

REVISIONS	
02 / MAY / 03	DMD

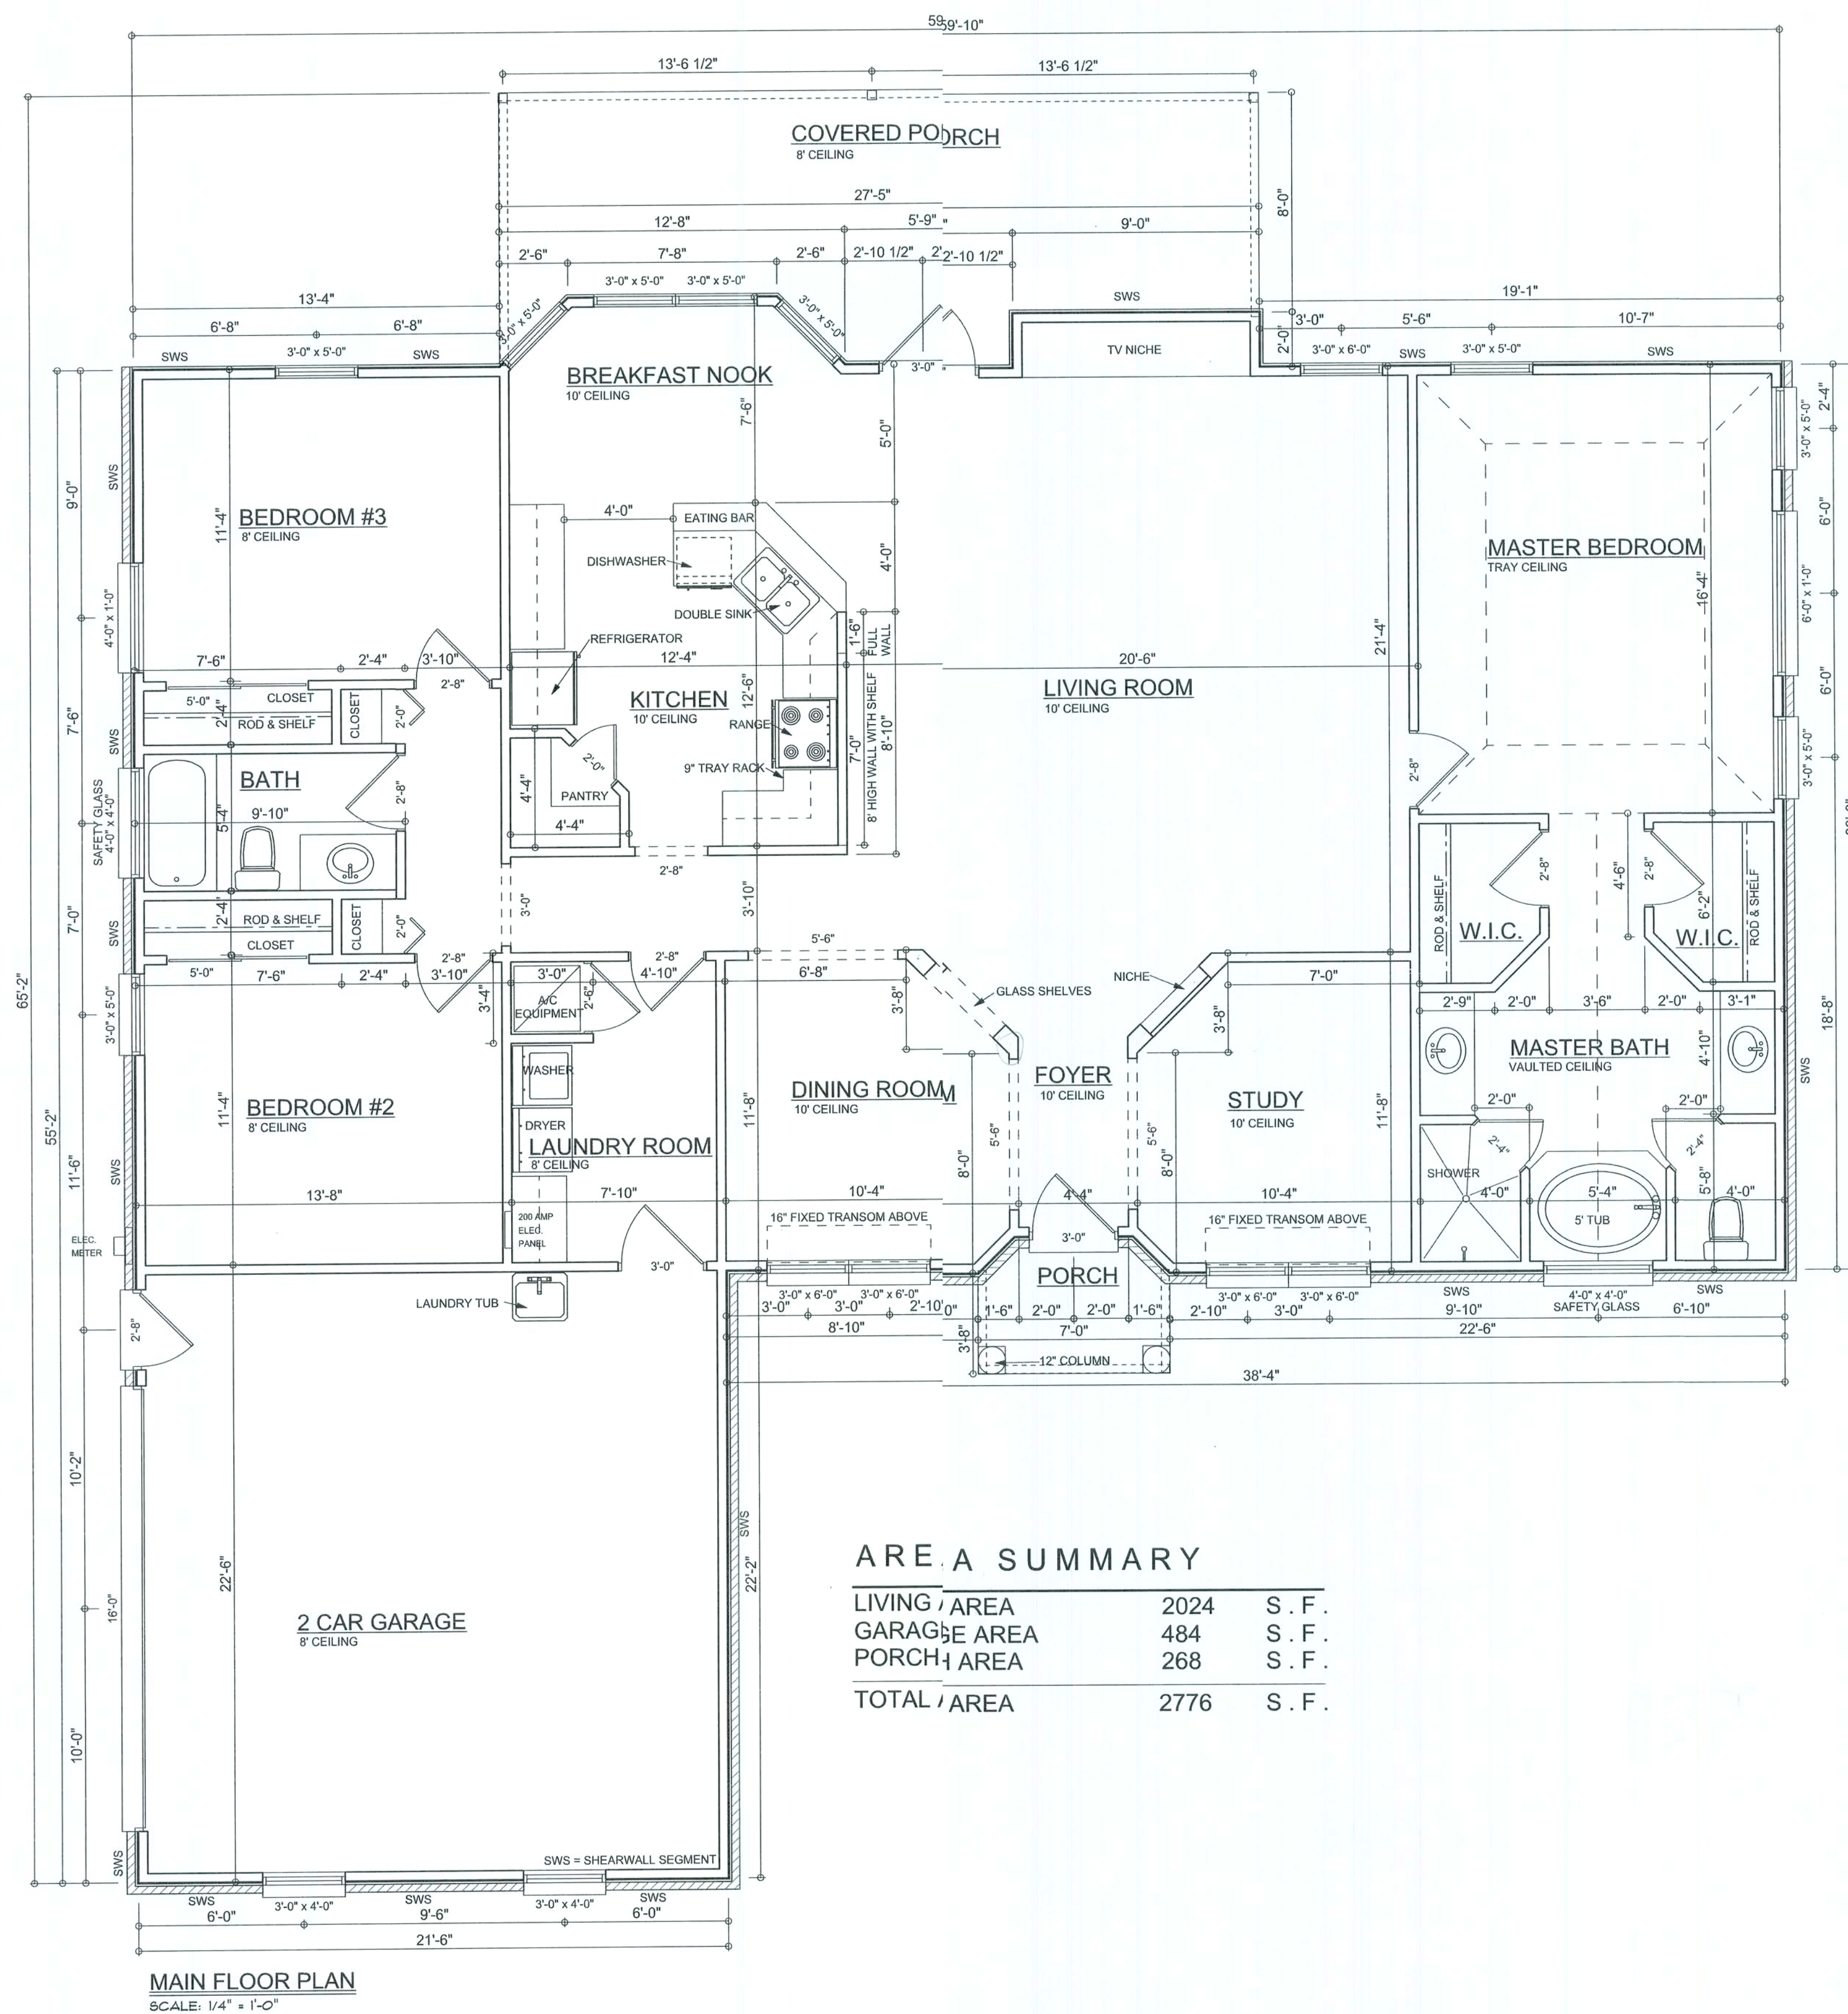

AREA SUMMARY

LIVING AREA	2024	S. F.
GARAGE AREA	484	S. F.
PORCH AREA	268	S. F.
TOTAL AREA	2776	S. F.

WINDLOAD ENGINEER: Mark Dismway,
PE No 53915, PGB68, Lake City, FL
32066, 386/754-6419

CERTIFICATION: These plans and
"Windload Engineering", Sheet S-1, attached,
comply with Florida Building Code 2001,
Section 1606 wind loads, to the best of my
knowledge.

LIMITATION: This design is valid for one
building, at specific location, permitted within
90 days of signature date. In case of conflict,
structural requirements, scope of work, and
builder responsibilities on sheet S-1 control.

MARK DISMWAY
P.E. 53915

**SPECHOUSE
FOR 3RYAN
ZETTER
CONSTRUCTION**

ADDRESS:
Lot #3 Emerald Lakes,
Columbia County, FL

Mark Dismway P.E.
P.O. Box 868
Lake City, Florida 32026
Phone: (386) 754 - 5419
Fax: (386) 754 - 6144
Email: mdp@bellsouth.net

PRINTED DATE:
May 02, 2003

DRAWN BY: Evan Beamley

CHECKED BY:
Teresa Ruffo


FINALS DATE:
29 / April / 03

JOB NUMBER:
304241

DRAWING NUMBER

A-2
OF 3 SHEETS

REVISIONS	
02 / MAY / 03	DMD

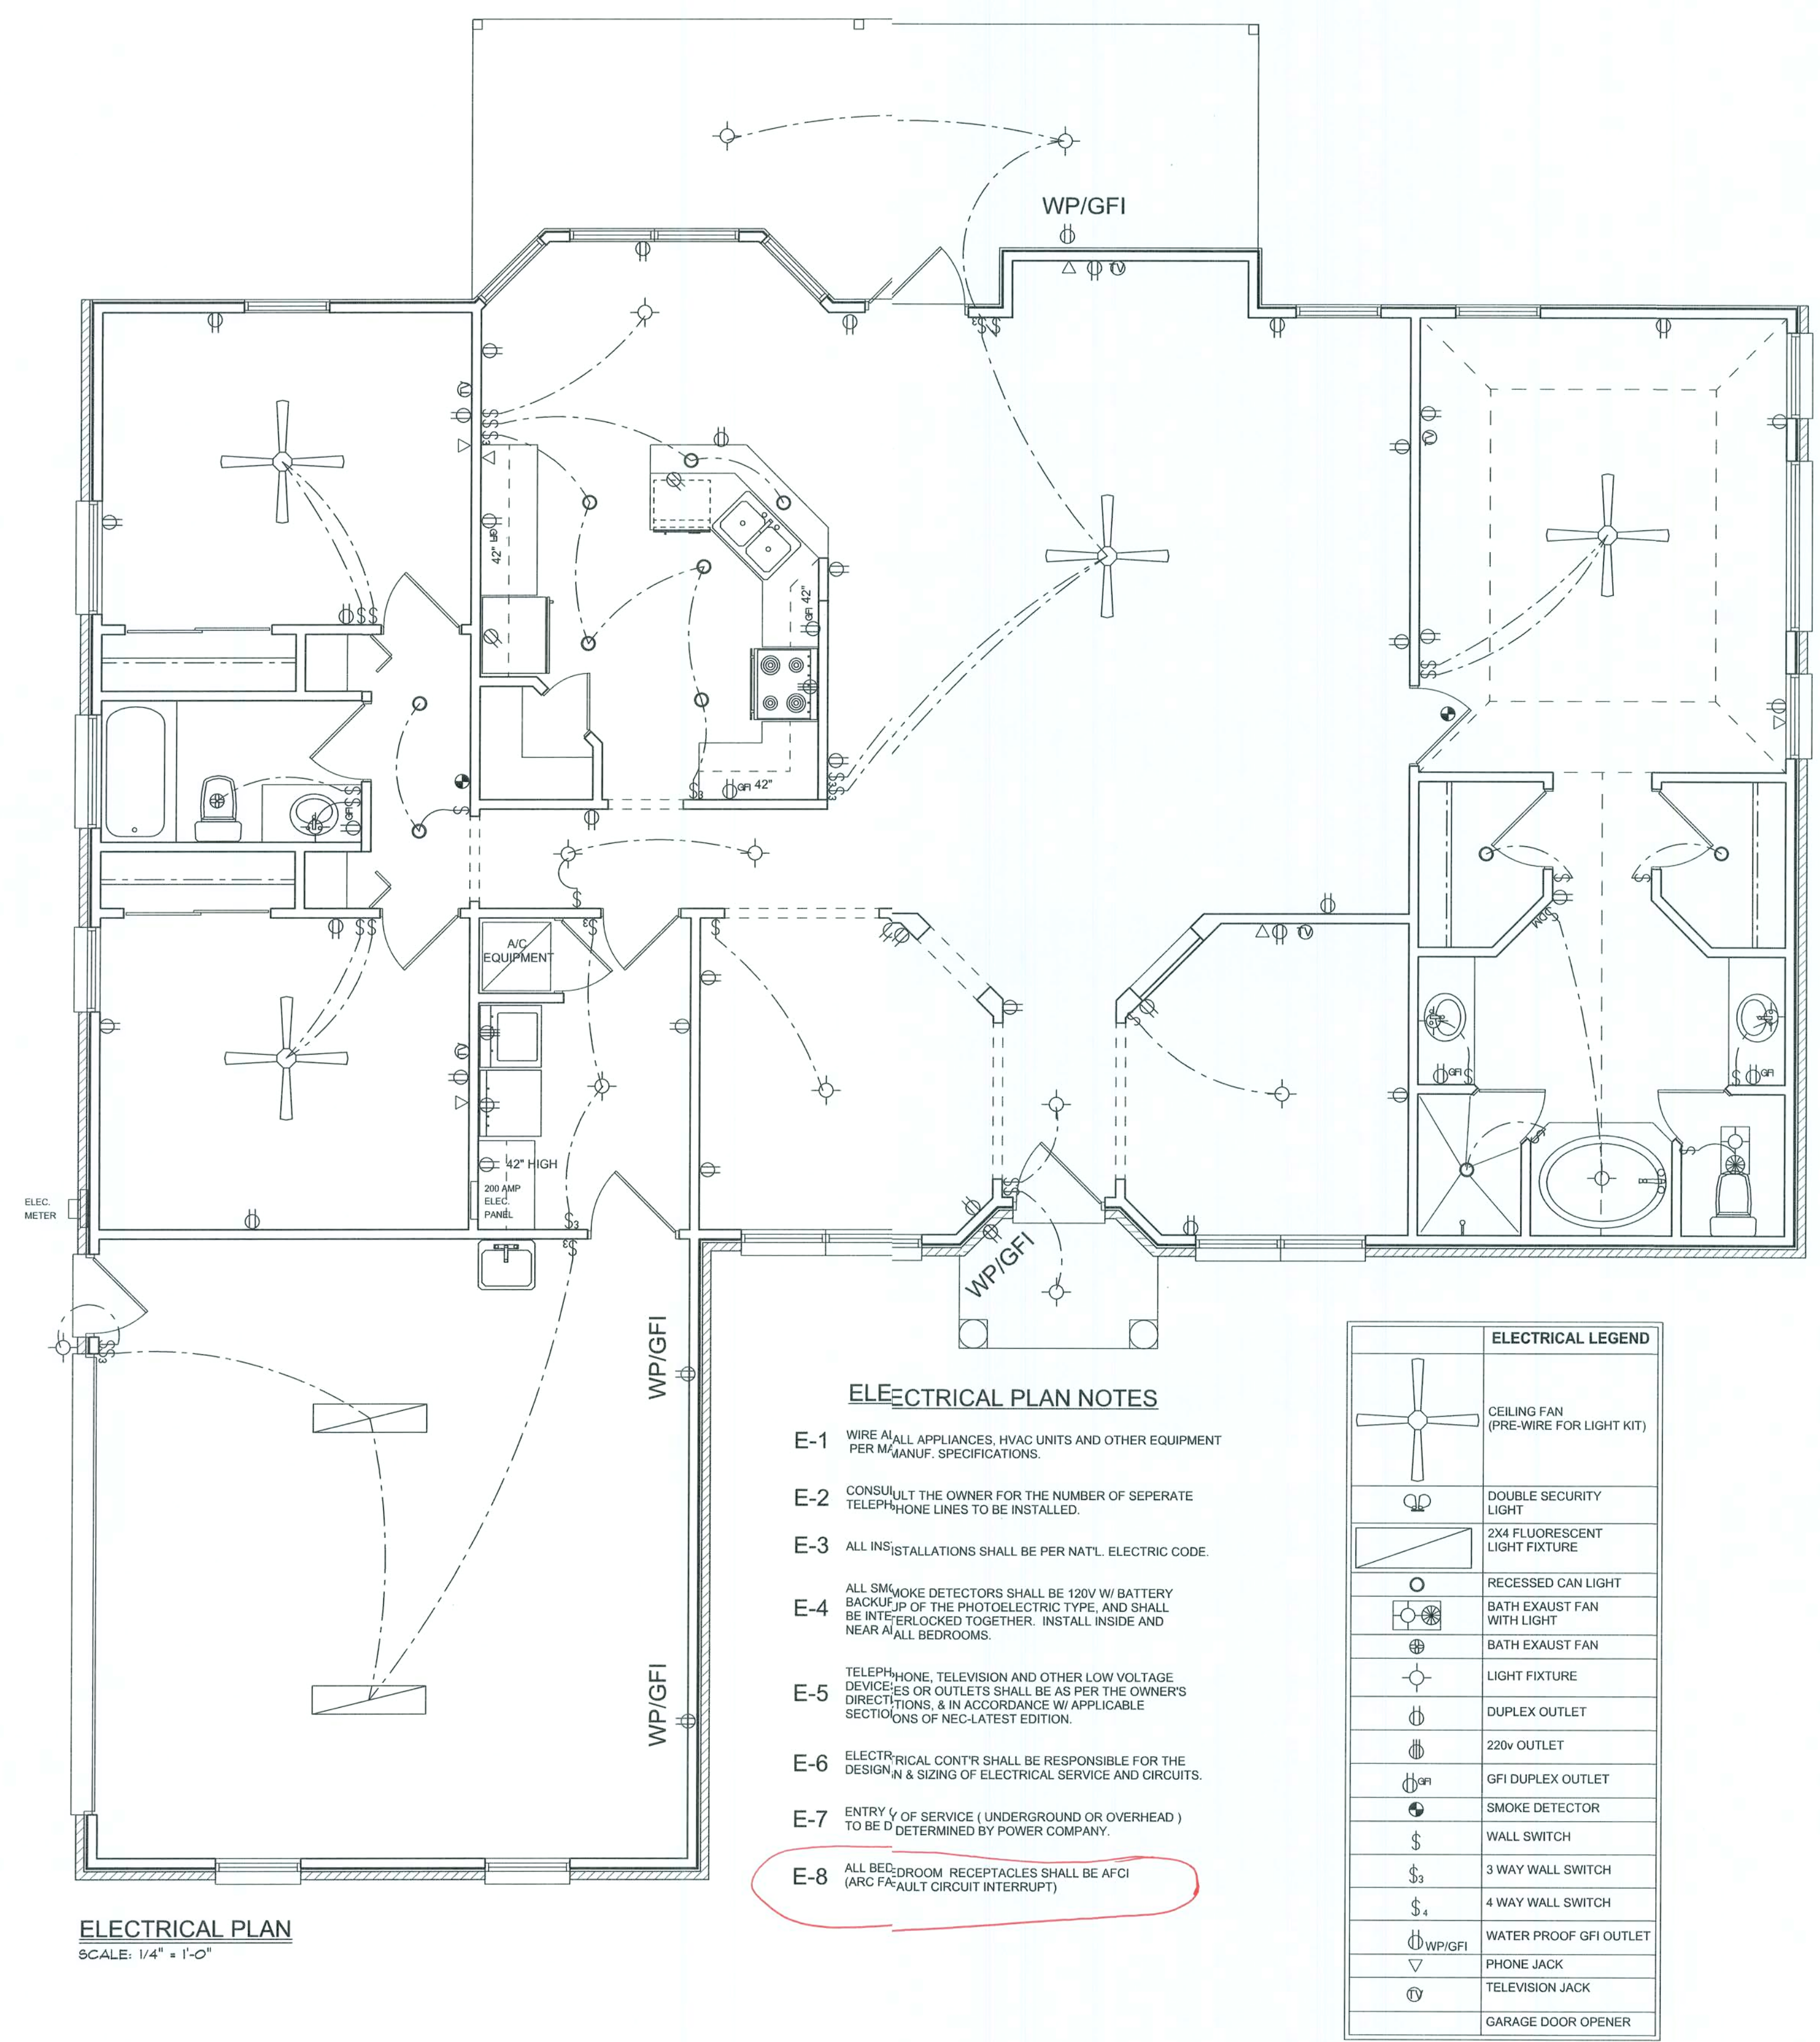

ELECTRICAL PLAN NOTES

- E-1 WIRE ALL APPLIANCES, HVAC UNITS AND OTHER EQUIPMENT PER MANUF. SPECIFICATIONS.
- E-2 CONSULT THE OWNER FOR THE NUMBER OF SEPARATE TELEPHONE LINES TO BE INSTALLED.
- E-3 ALL INSTALLATIONS SHALL BE PER NATL. ELECTRIC CODE.
- E-4 ALL SMOKE DETECTORS SHALL BE 120V W/ BATTERY BACKUP, JP OF THE PHOTOELECTRIC TYPE, AND SHALL BE INTERLOCKED TOGETHER. INSTALL INSIDE AND NEAR ALL BEDROOMS.
- E-5 TELEPHONE, TELEVISION AND OTHER LOW VOLTAGE DEVICES OR OUTLETS SHALL BE AS PER THE OWNER'S DIRECTIONS, & IN ACCORDANCE W/ APPLICABLE SECTIONS OF NEC-LATEST EDITION.
- E-6 ELECTRICAL CONTR SHALL BE RESPONSIBLE FOR THE DESIGN & SIZING OF ELECTRICAL SERVICE AND CIRCUITS.
- E-7 ENTRY OF SERVICE (UNDERGROUND OR OVERHEAD) TO BE DETERMINED BY POWER COMPANY.
- E-8 ALL BEDROOM RECEPTACLES SHALL BE AFCI (ARC FAULT CIRCUIT INTERRUPT)

ELECTRICAL LEGEND	
	CEILING FAN (PRE-WIRE FOR LIGHT KIT)
	DOUBLE SECURITY LIGHT
	2X4 FLUORESCENT LIGHT FIXTURE
	RECESSED CAN LIGHT
	BATH EXHAUST FAN WITH LIGHT
	BATH EXHAUST FAN
	LIGHT FIXTURE
	DUPLEX OUTLET
	220v OUTLET
	GFI DUPLEX OUTLET
	SMOKE DETECTOR
	WALL SWITCH
	3 WAY WALL SWITCH
	4 WAY WALL SWITCH
	WATER PROOF GFI OUTLET
	PHONE JACK
	TELEVISION JACK
	GARAGE DOOR OPENER

ELECTRICAL PLAN
SCALE: 1/4" = 1'-0"

WINDLOAD ENGINEER: Mark Disoway,
PE No. 53915, POB 88, Lake City, FL
32056, 386-754-5419

CERTIFICATION: These plans and
"Windload Engineering", Sheet S-1, attached,
comply with Florida Building Code 2001,
Section 1606 wind loads, to the best of my
knowledge.

LIMITATION: This design is valid for one
building, at specified location, permitted within
90 days of signature date. In case of conflict,
structural requirements, scope of work, and
builder responsibility on sheet S-1 control.

MARK DISOWAY
P.E. 53915


Mark Disoway
02/14/03
SAL

SPEC HOUSE
FOR BRYAN
ZECHE
CONSTRUCTION

ADDRESS:
Lot #3 Emerald Lakes,
Columbia County, FL.

Mark Disoway P.E.
P.O. Box 868
Lake City, Florida 32026
Phone: (386) 754 - 5419
Fax: (386) 754 - 5144
Email: mdpe@southnet.net

PRINTED DATE: May 02, 2003	CHECKED BY: Evan Beamsley
DESIGNED BY: <i>Teena Paffa</i>	
FINALS DATE: 29 / Apr / 03	
JOB NUMBER: 304241	
DRAWING NUMBER A-3 OF 5 SHEETS	

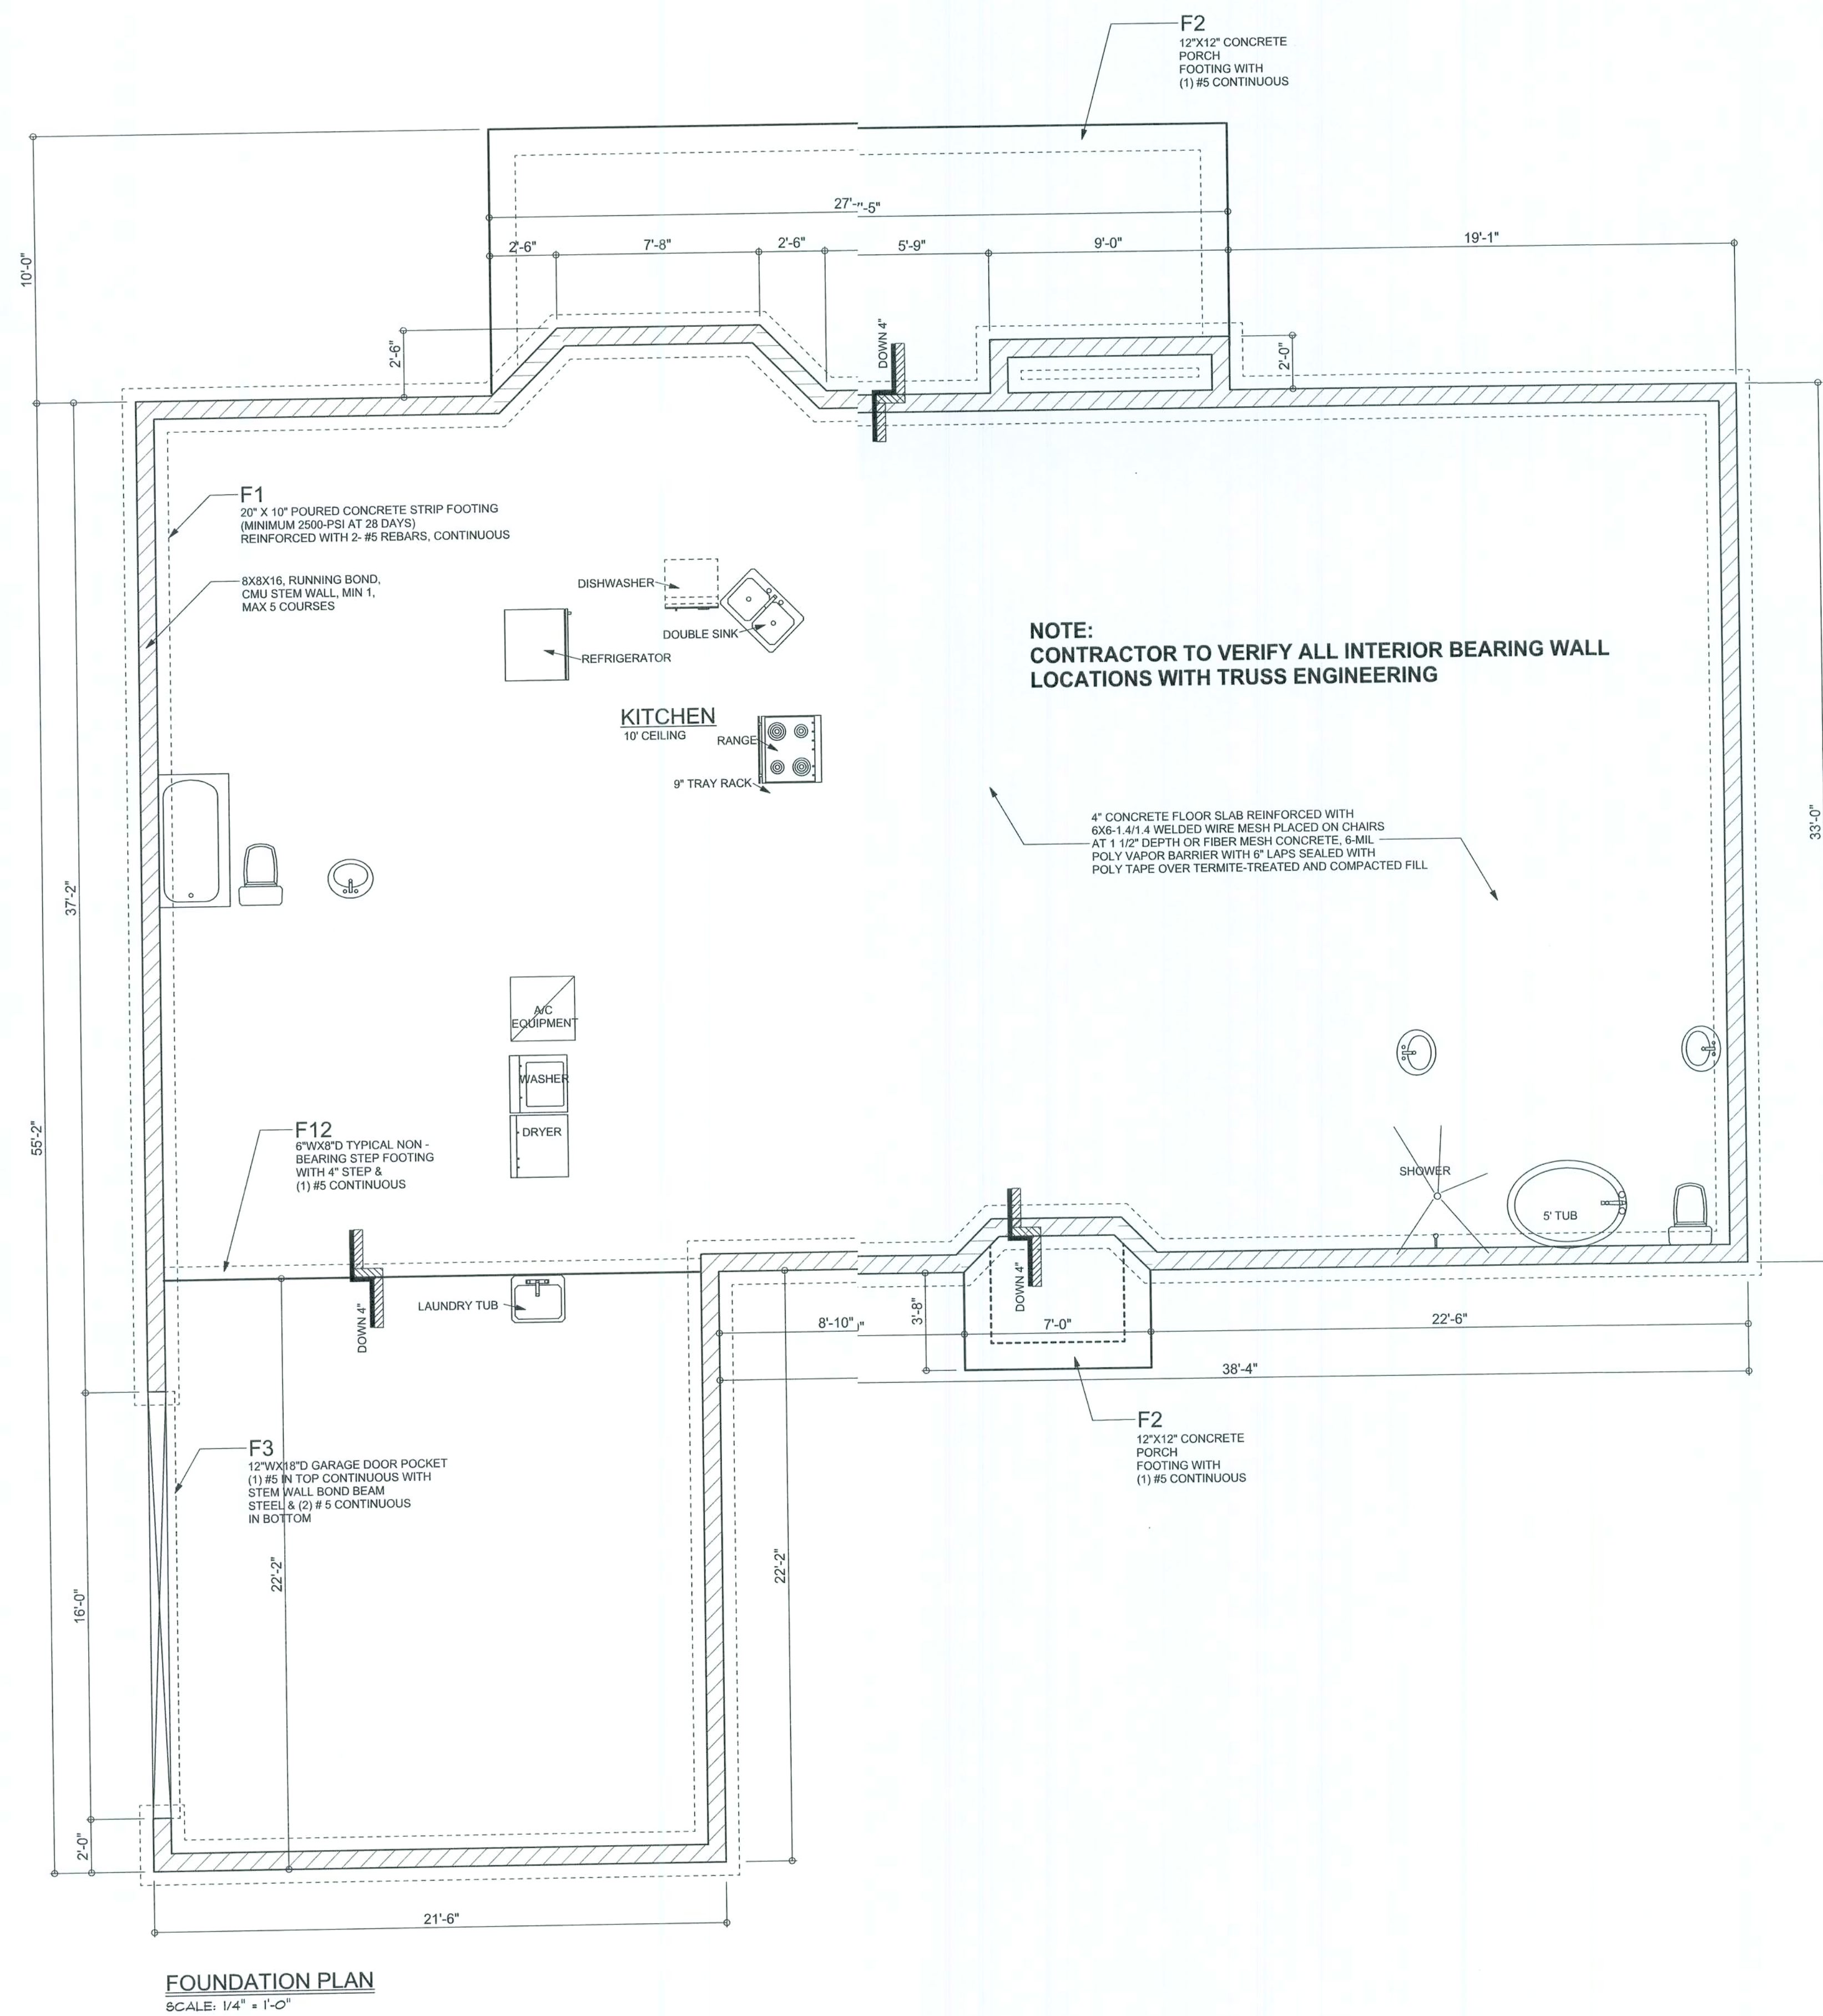

REVISIONS

SOFTPLAN
ARCHITECTURAL DESIGN SOFTWARE

WINDLOAD ENGINEER: Mark Disosway,
P.E. No. 53915, P.B. 868, Lake City, FL
32056, 386-7544419

CERTIFICATION: These plans and
"Windload Engineering", Sheet S-1, attached,
comply with Florida Building Code 2001,
Section 1606 wind loads, to the best of my
knowledge.

LIMITATION: This design is valid for one
building, at specified location, permitted within
30 days of signature date. In case of conflict,
structural requirements, scope of work, and
builder responsibilities on sheet S-1 control.

MARK DISOSWAY
P.E. 53915

SPIC HOUSE
FOR BRYAN
ZECHER
CONSTRUCTION

ADDRESS:
Lot 8 Emeralds Lakes,
Columbia County, FL

Mark Disosway P.E.
P.O. Box 868
Lake City, Florida 32026
Phone (386) 754 - 5419
Fax: (386) 754 - 6144
Email: mdpe@bellsouth.net

PRINTED DATE:
April 29, 2003

DRAWN BY: Evan Beamley CHECKED BY:

DESIGNED BY:
Teresa Ruffo

FINAL DATE:
29 / April / 03

JO3 NUMBER:
304241

DRAWING NUMBER

A-4

OF 5 SHEETS

