




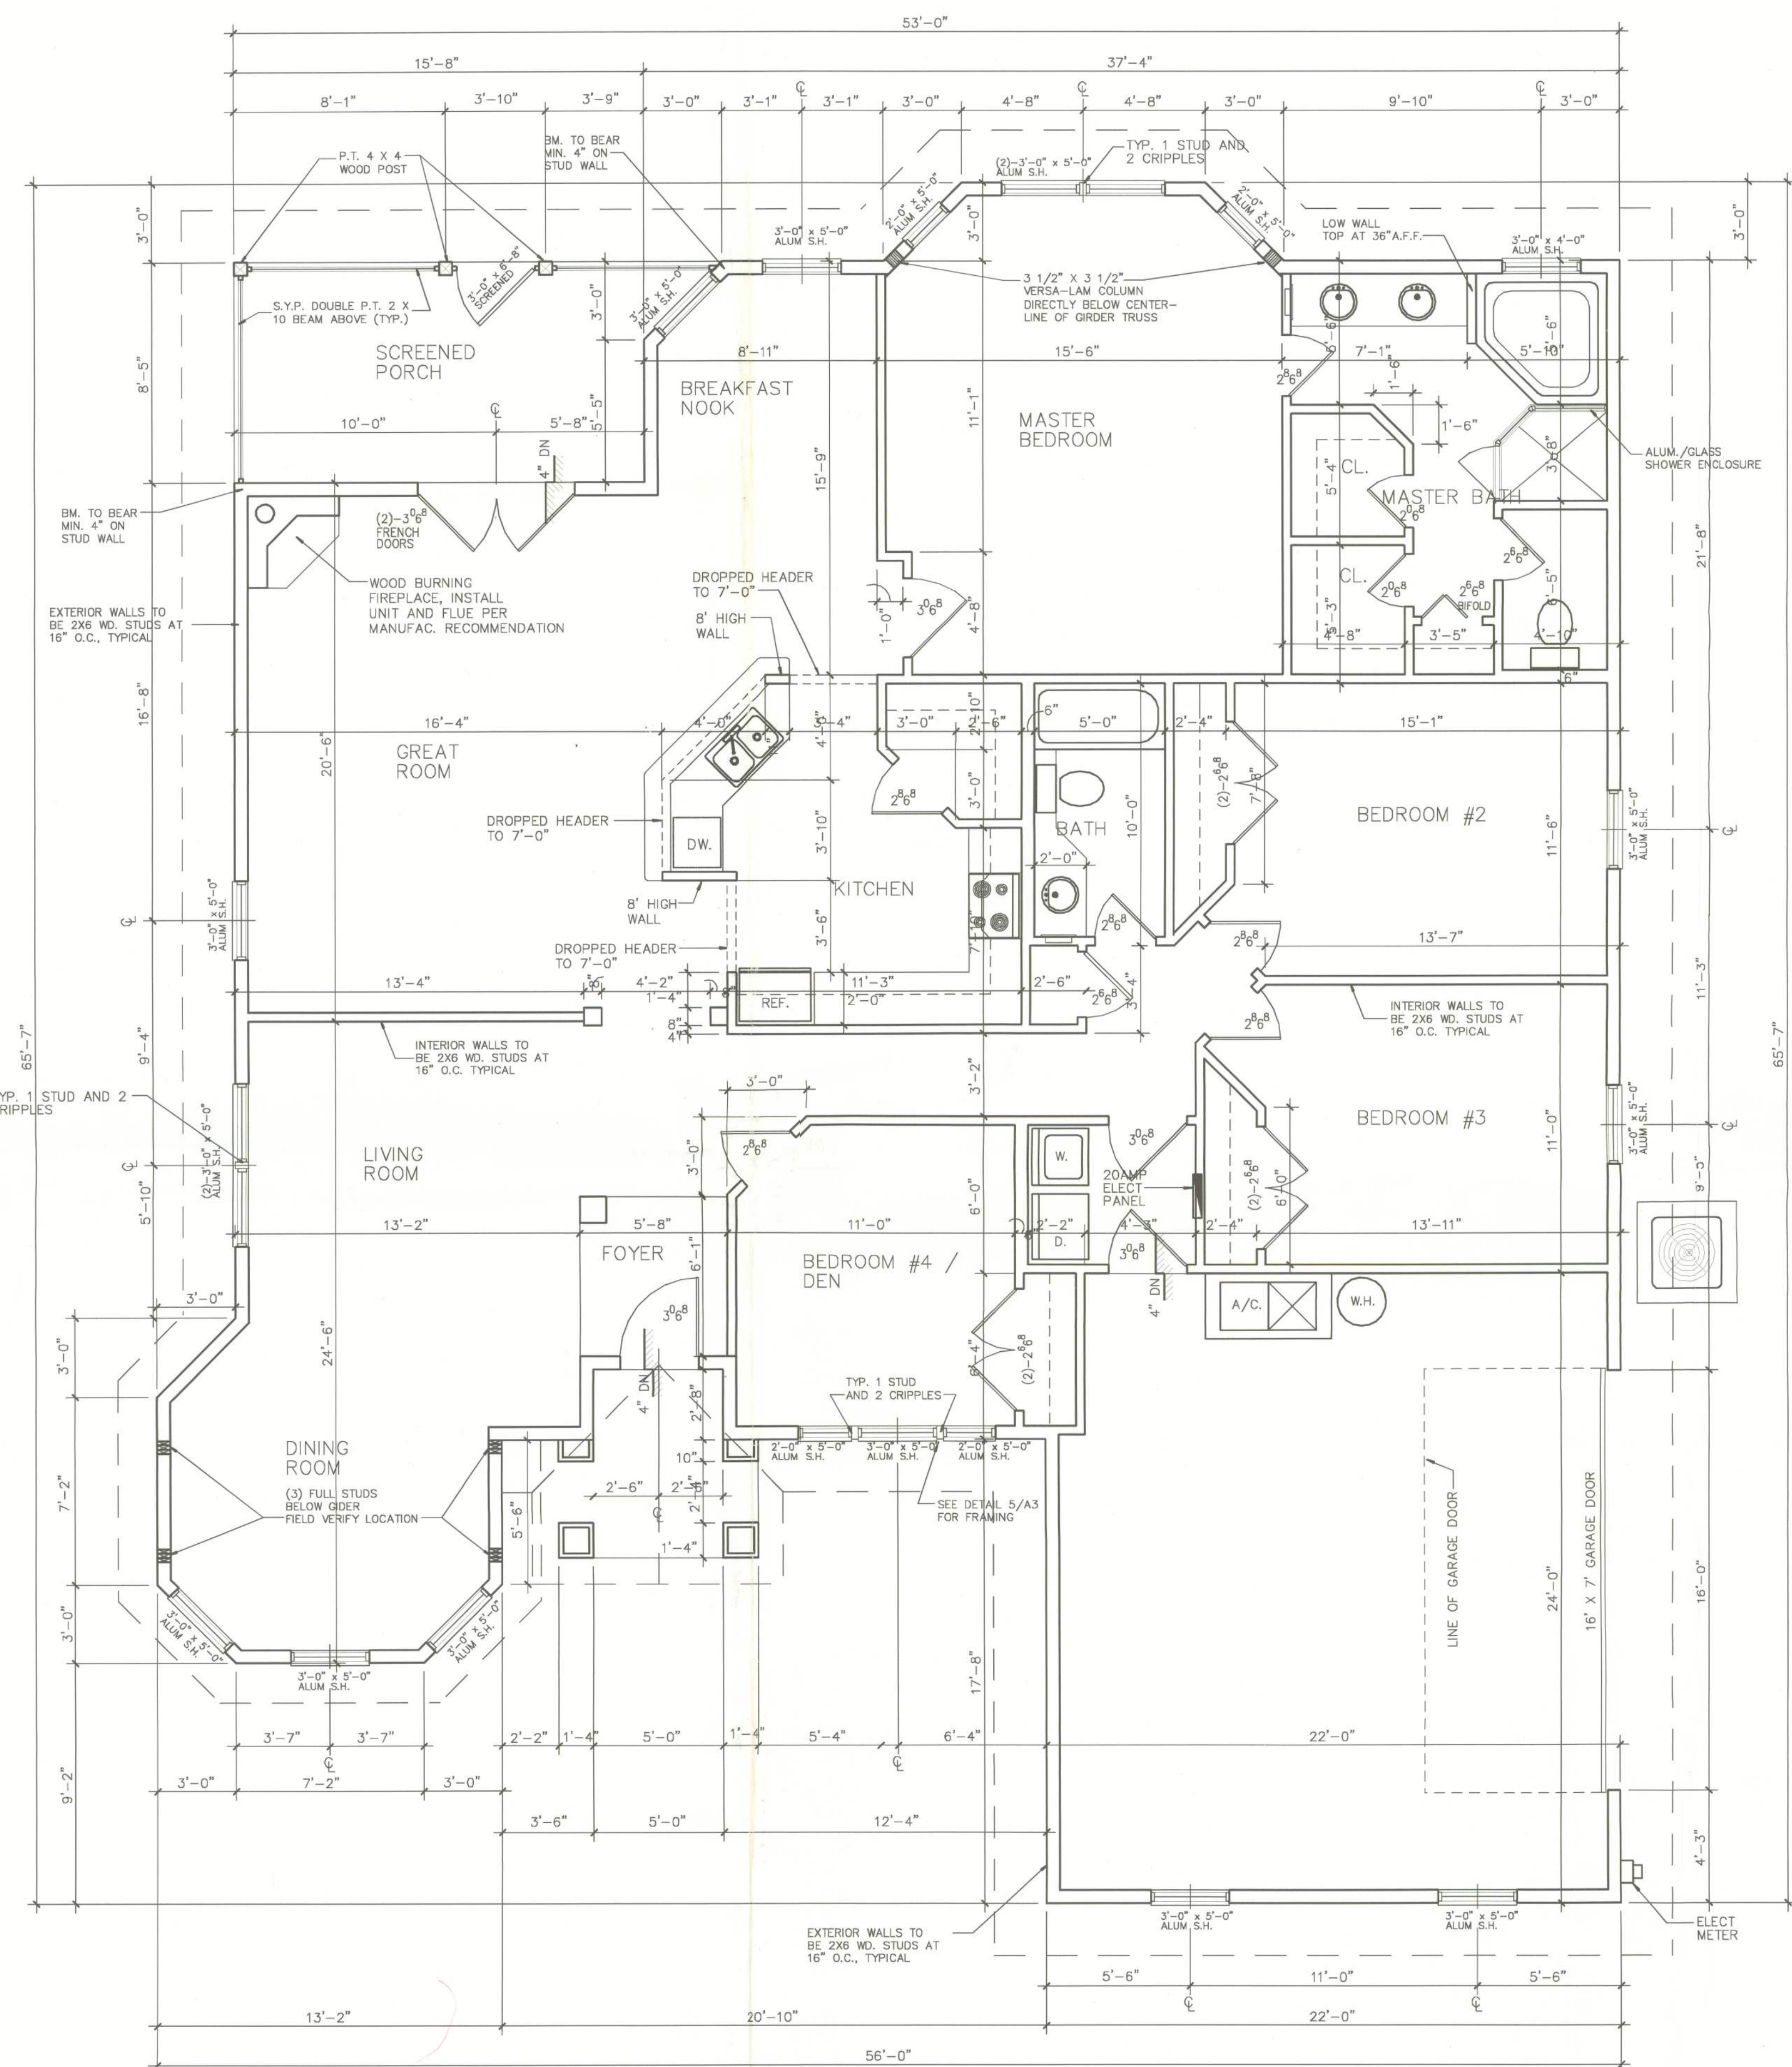

FLOOR PLAN
1/4"=1'-0"

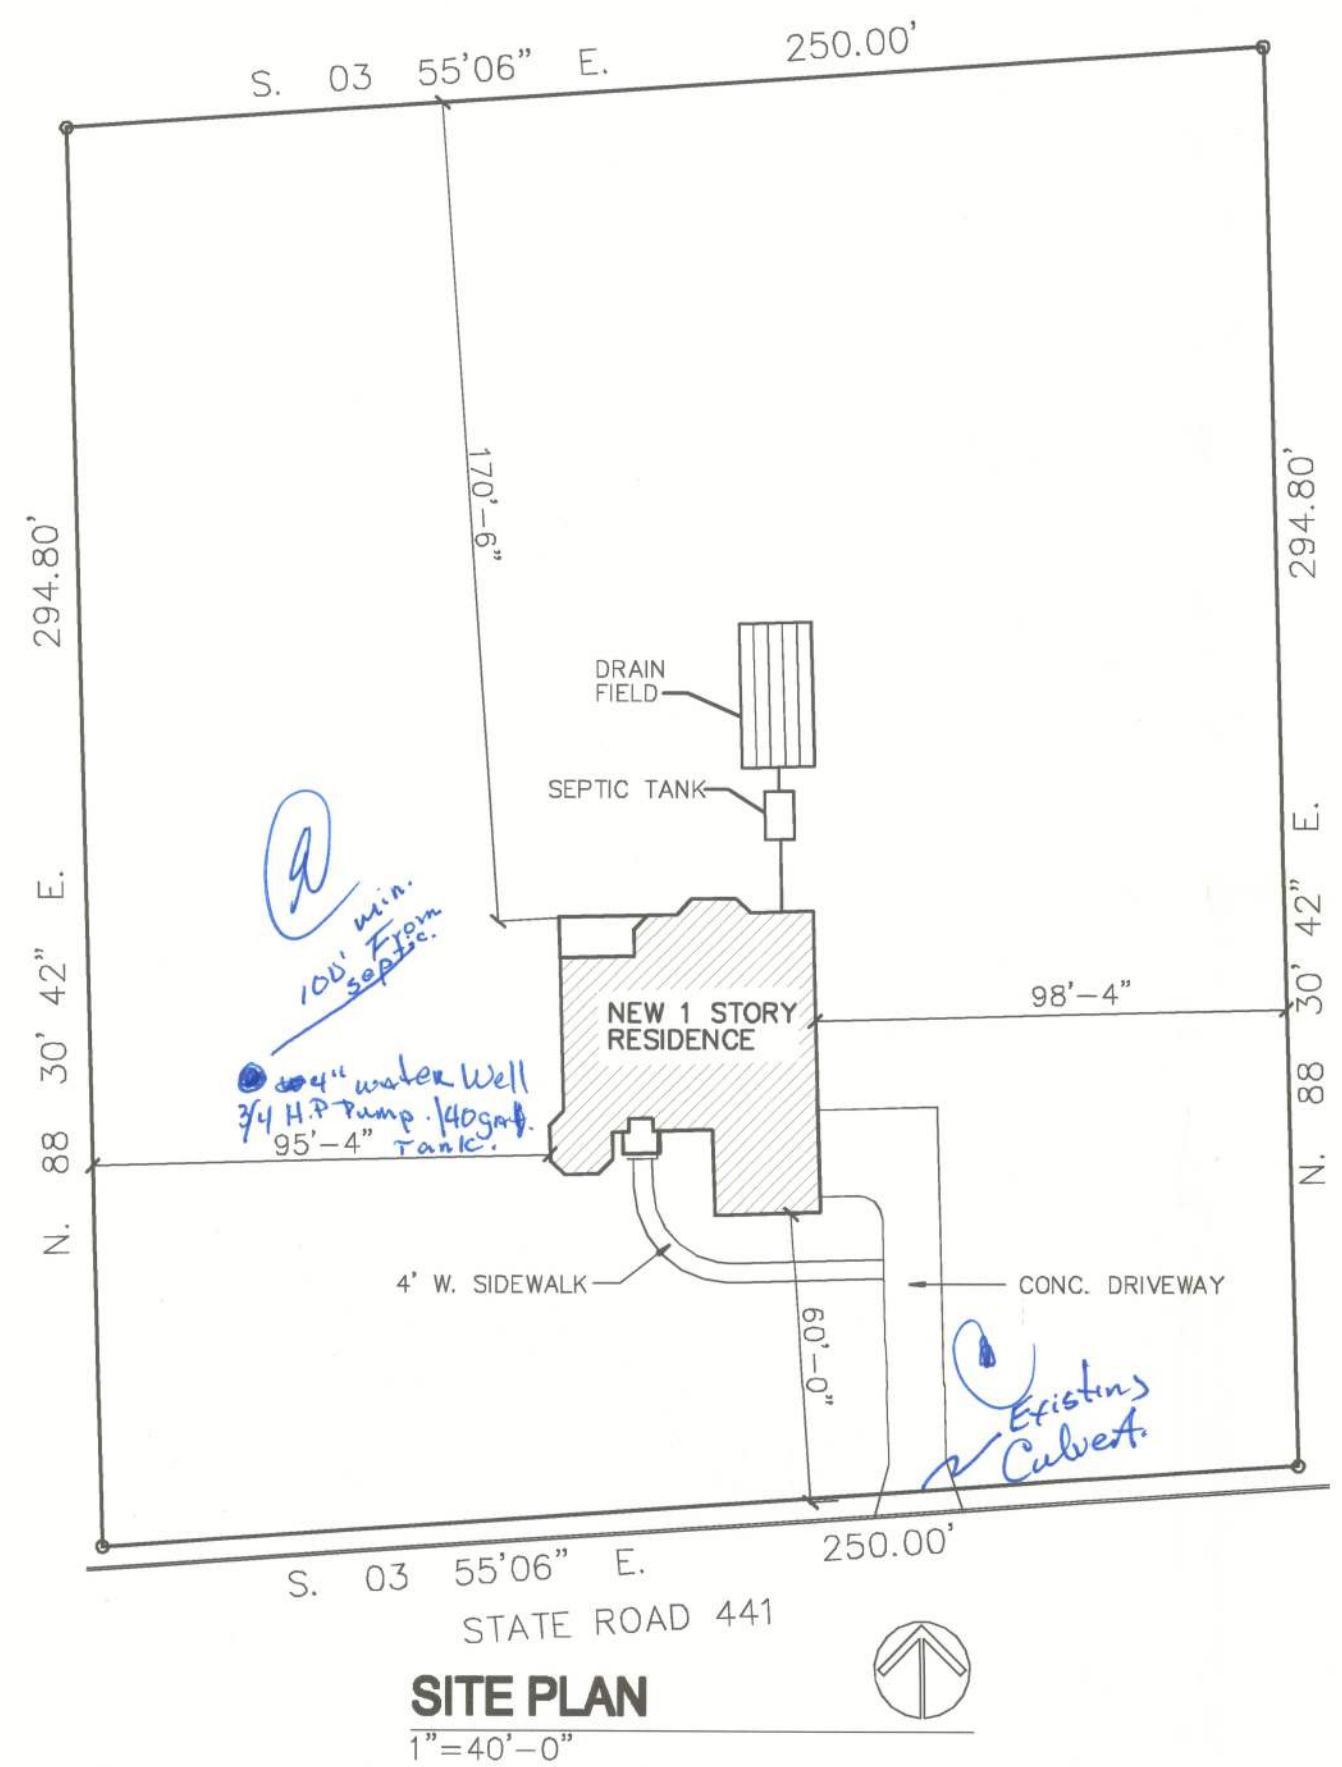

SITE PLAN
1"=40'-0"

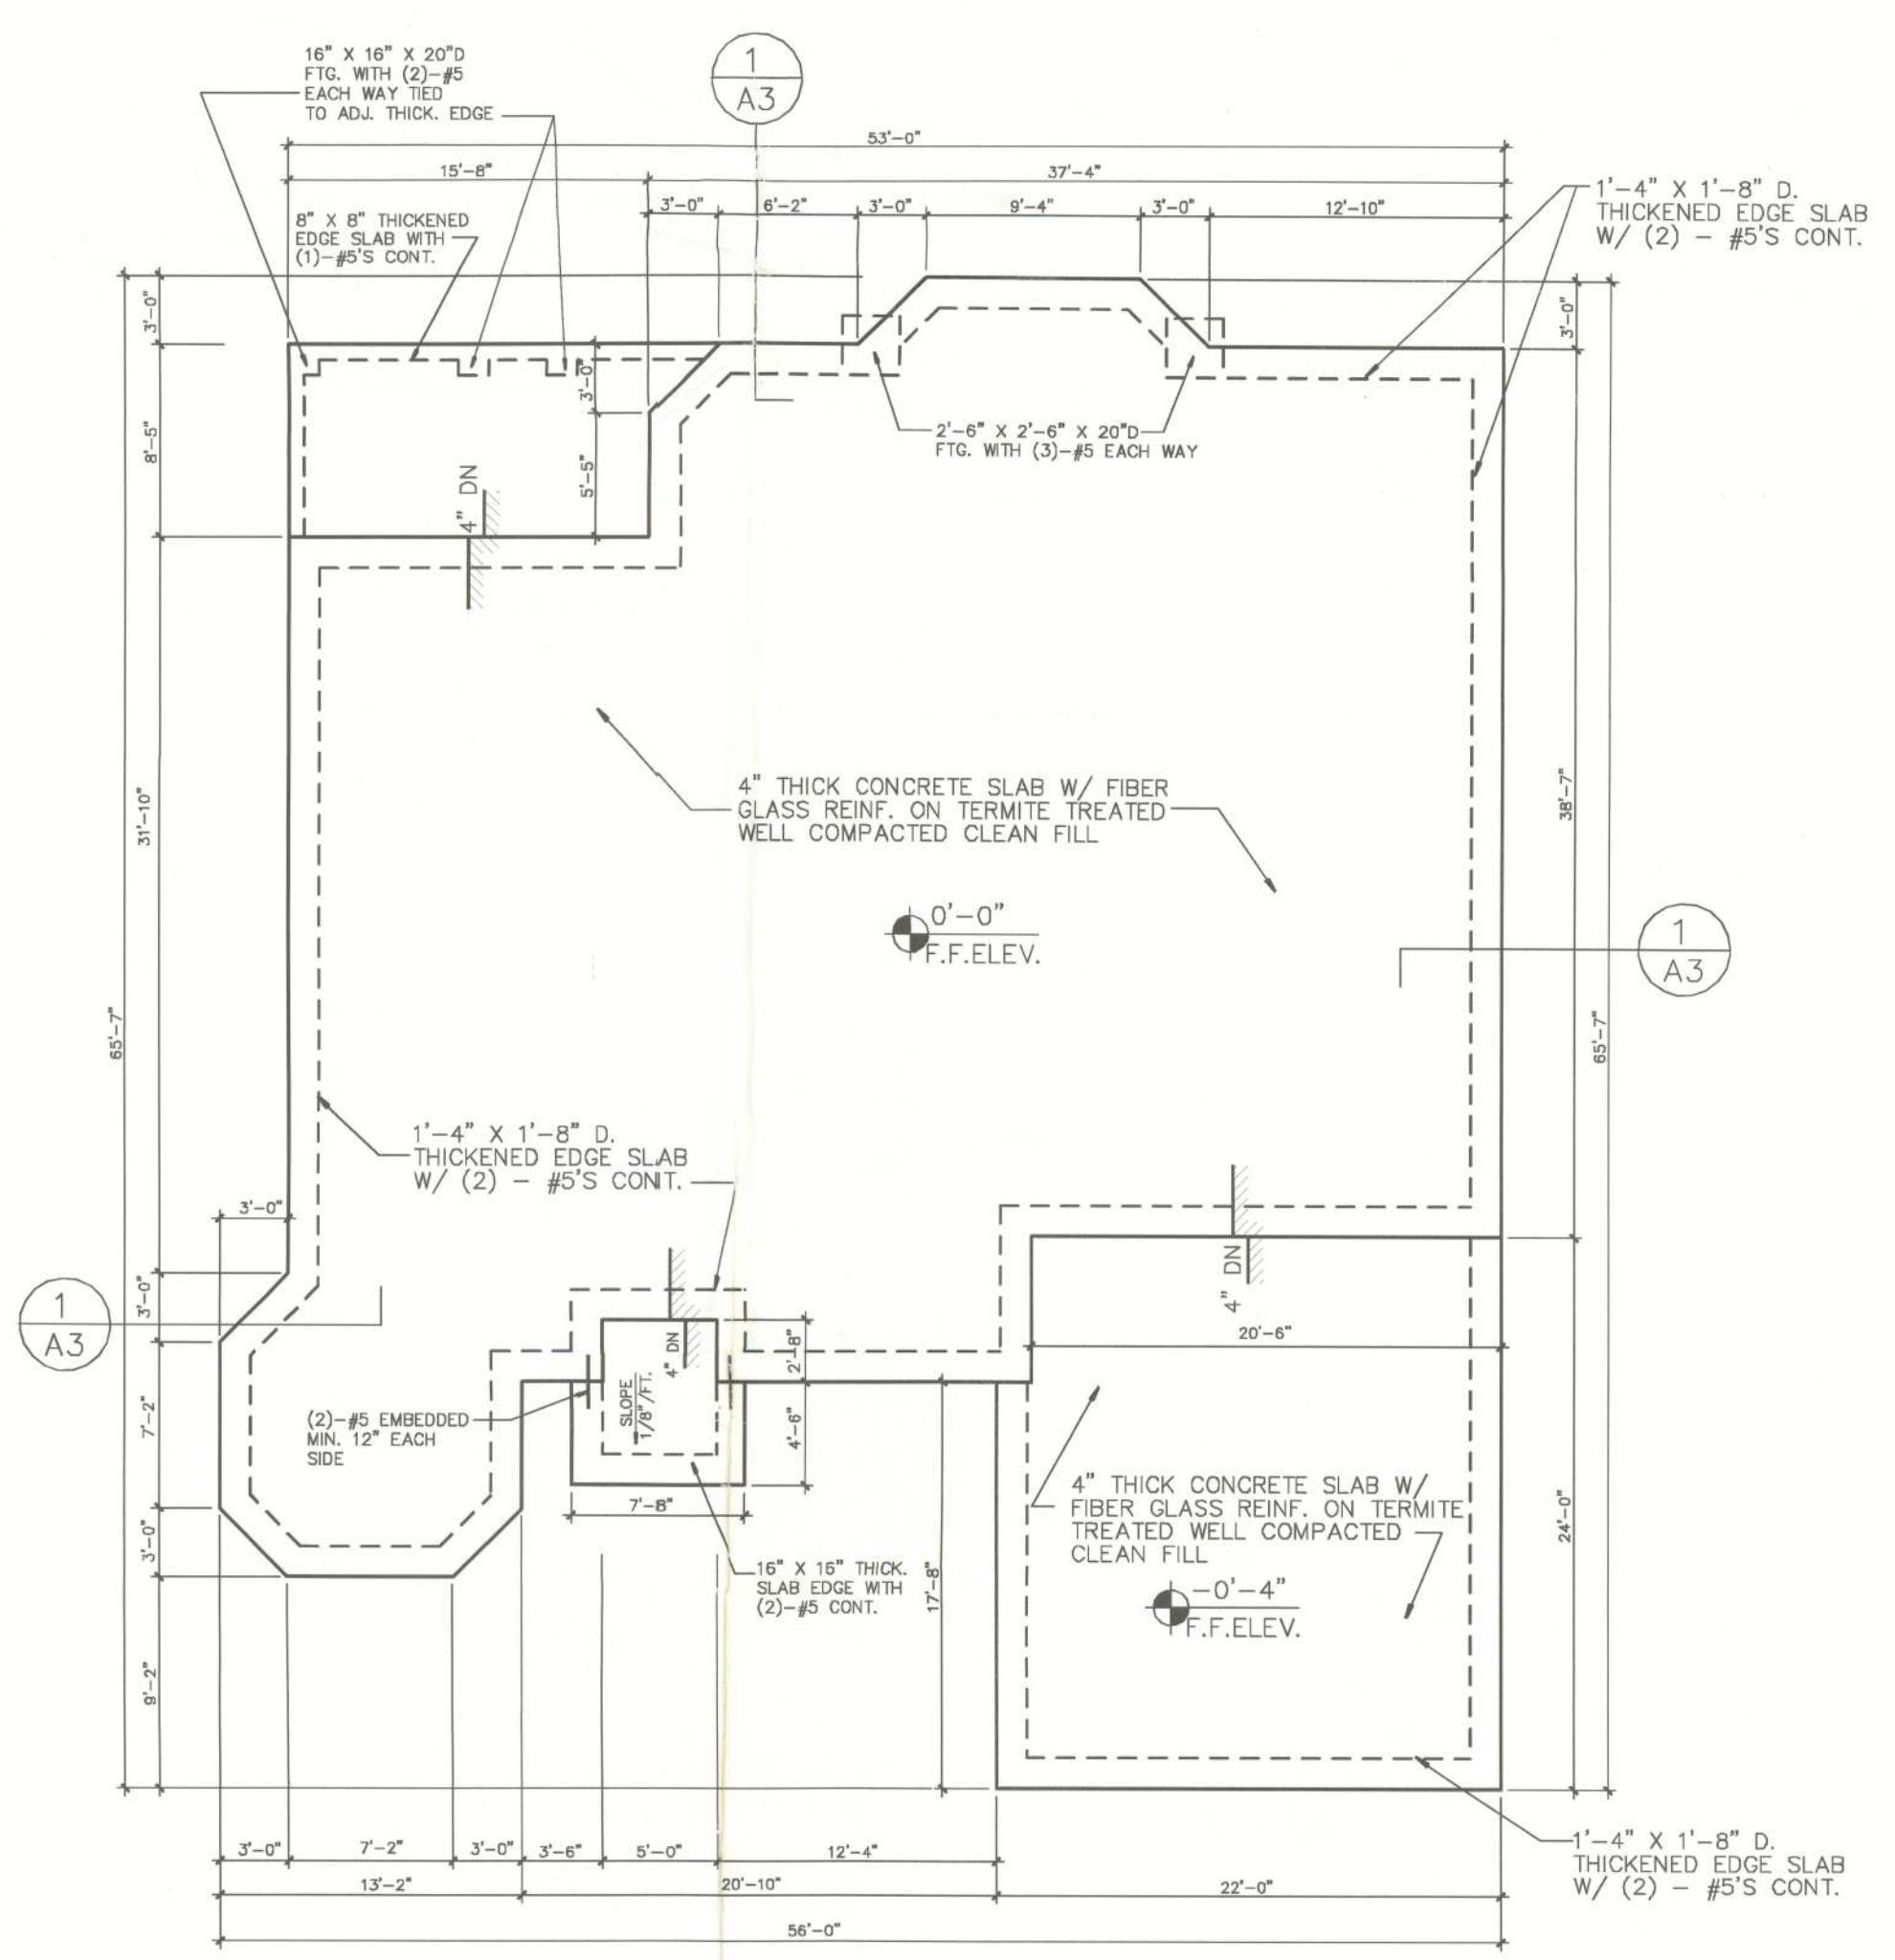

FOUNDATION PLAN
1/8"=1'-0"

SHEET INDEX

- A1. FLOOR PLAN
SITE PLAN
FOUNDATION PLAN
- A2. EXTERIOR ELEVATIONS
- A3. ROOF PLAN
CONSTRUCTION DETAILS
- A4. ELECTRICAL PLAN

GENERAL NOTES

1. THIS PROJECT CONSISTS OF A ONE-STORY SINGLE FAMILY RESIDENCE.
2. BUILDING AREAS
CONDITIONED: 2,249 S.F.
GARAGE: 519 S.F.
FRONT PORCH: 48 S.F.
REAR PORCH: 136 S.F.
TOTAL: 2,952 S.F.
3. ALL WORK SHALL COMPLY WITH THE FLORIDA BUILDING CODE, 2001 EDITION.
4. OCCUPANCY CLASS: RESIDENTIAL, R3
5. TYPE OF CONSTRUCTION:
TYPE V-B, UNPROTECTED, UNSPRINKLED
MAXIMUM HEIGHT: 22'-8"

**RICARDO CAVALLINO
AND ASSOCIATES, INC.**
ARCHITECTURE-PLANNING
22 SE FIFTH AVE.
GAINESVILLE, FL 32601
352-377-1751 (O)
352-377-1765 (F)

STEWART
S.R. 441, LAKE CITY, FLORIDA

A1

REVISIONS:

NO.	DESCRIPTION	DATE
1	ISSUED FOR PERMIT	9-19-2005

PROJECT: RCA-0528
DRAWN BY: R.L.A.
CHECKED BY: R.C.
DATE: 9-19-2005