


A Site Layout (Full Lot)

SCALE: 1/8" = 1'-0"



B Site Layout (Partial)

SCALE: 1/8" = 1'-0"

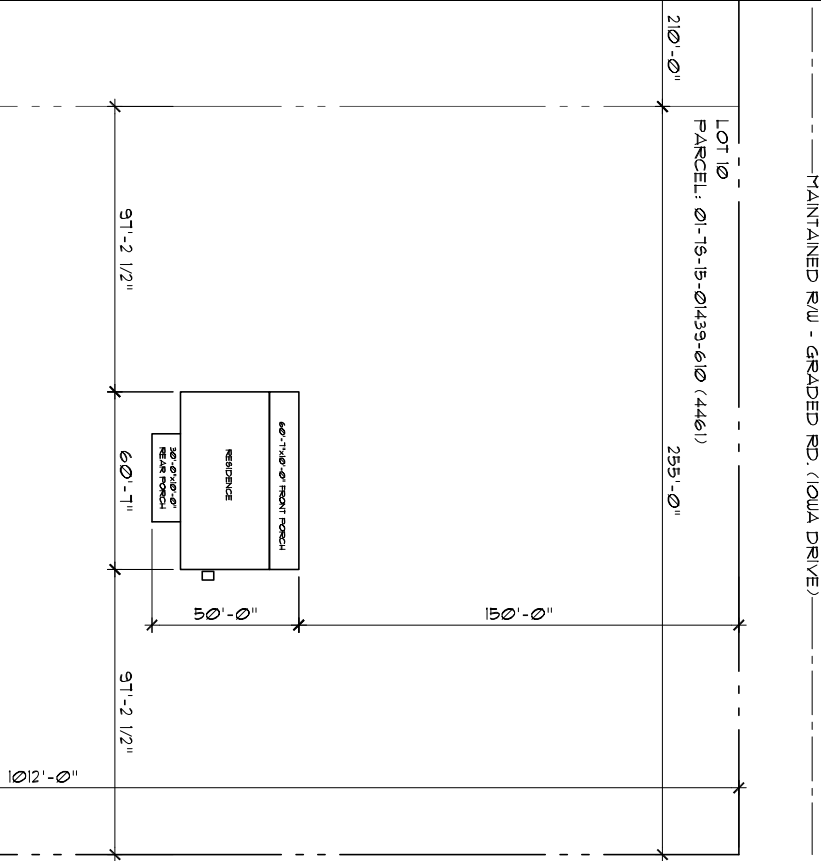

SP1

Job no.
Drawn by
Checked
Date
Scale
AS NOTED
Drawing No.

McCOY INTERIOR BUILDOUT
PARCEL: 01-15-15-01439-610 (4461)
PORT WHITE, FLORIDA



THE FINAL PLAN, INC.

WWW.THEFINALPLAN.COM
TEL. 352.410.2539

CUSTOM DESIGNS, SPACE PLANNING
TENANT BUILD OUTS, ADDITIONS, REMODELS


job no	
M0324	
drawn by	
DA	
checked	
date	
05/20/24	
scale	
AS NOTED	
drawing no.	



revisions	by

 **THE FINAL PLAN, INC.**
WWW.THEFINALPLAN.COM
TEL. 352.410.2539

**CUSTOM DESIGNS, SPACE PLANNING
TENANT BUILD OUTS, ADDITIONS, REMODELS**

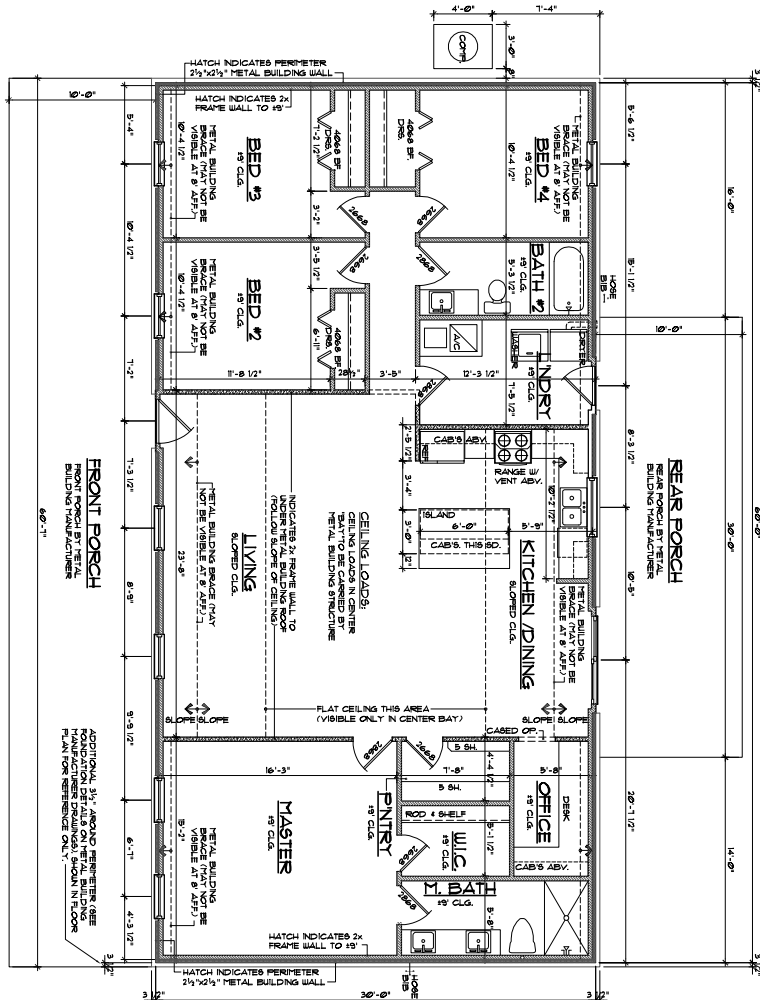

Floor Plan
SCALE: 1/4" = 1'-0"

CONSTRUCTION NOTES:

1. FOUNDATION TO BE 3/4" LARGER WIDTH & DEPTH THAN METAL BUILDING DIMENSIONS, SEE FOUNDATION DETAILS FROM METAL BUILDING MANUFACTURER
2. ALL INTERIOR FRAMES SHALL BE AT 8'-0" UNO.
3. ALL WINDOW & DOOR HEADER HEIGHTS TO BE AT 6'-8" UNO.
4. ALL BRACING & FRAMEWORK TO BE 2 S.F. OR BETTER

2A

job no	MO324
drawn by	DA
checked	
date	05/20/24
scale	AS NOTED
drawing no.	

McCOY INTERIOR BUILDOUT
PARCEL: 01-15-15-01439-610 (4461)
FORT WHITE, FLORIDA

 **THE FINAL PLAN, INC.**
WWW.THEFINALPLAN.COM
TEL. 352.410.2539

CUSTOM DESIGNS, SPACE PLANNING
TENANT BUILD OUTS, ADDITIONS, REMODELS

[illegible]

 THE FINAL PLAN, INC.
WWW.THEFINALPLAN.COM
TEL. 352.410.2539


**CUSTOM DESIGNS, SPACE PLANNING
TENANT BUILD OUTS, ADDITIONS, REMODELS**

McCOY INTERIOR BUILDOUT
PARCEL: 01-18-15-01433-610 (4461)
FORT WHITE, FLORIDA


job no	
M0324	
drawn by	
DA	
checked	
date	
05/20/24	
scale	
AS NOTED	
drawing no.	

$$\frac{\Delta}{\omega}$$

Window Opening
SCALE 1/2" = 1'-0"

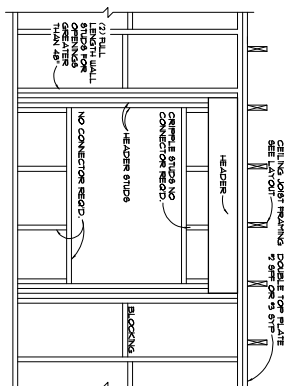

2 Bearing Opening Wood Frame
44 SCALE: 1/8" = 1'-0"
NO. 10 PL. FT.

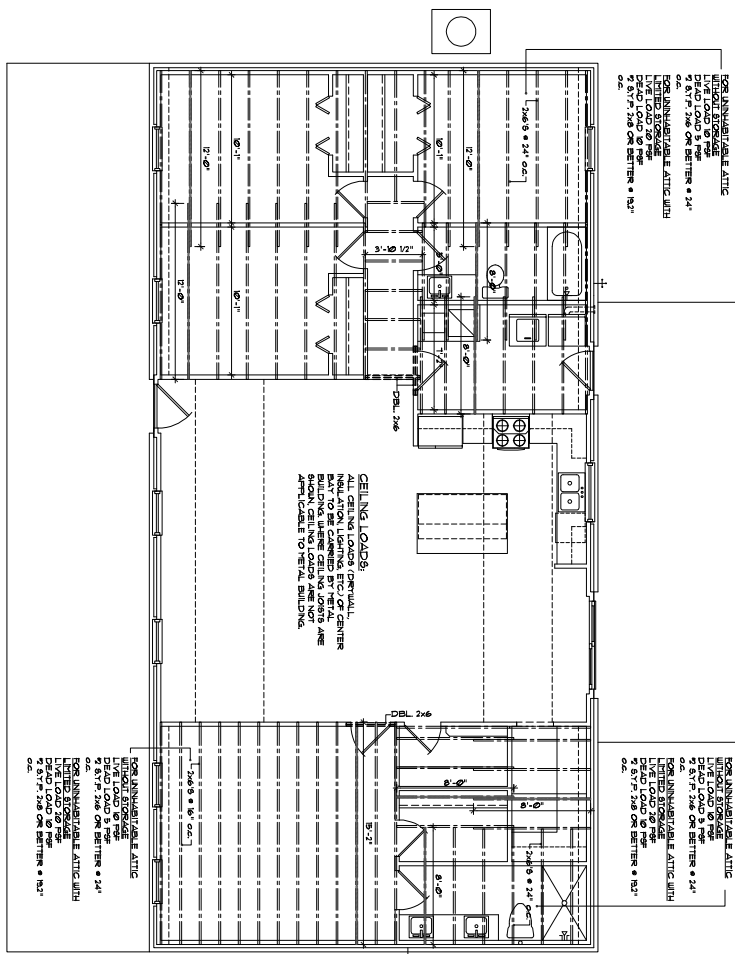

Ceiling Framing Plan
SCALE: 1/4" = 1'-0"

revisions	by

AS

PR no

DA

drawn by

checked


DATE

05/20/24


AS NOTED

drawing file


ELEVATION NOTE:
ELEVATIONS ARE BASED ON MANUFACTURER'S
ELEVATIONS AND ARE SUBJECT TO CHANGE
WITHOUT NOTICE. THESE ELEVATIONS
INTENDED AS FINAL CONSTRUCTION DOCUMENTS.

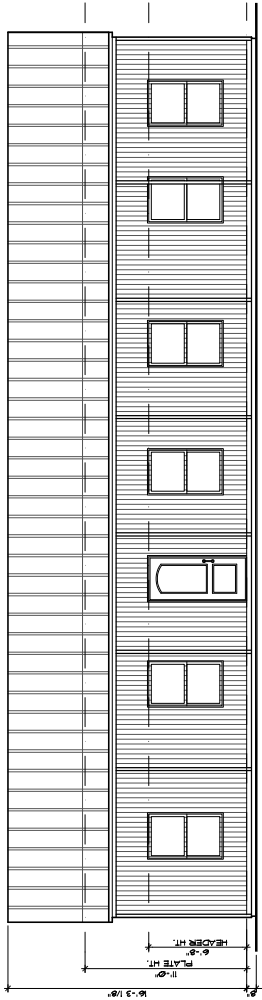


A Front Elevation
1/4"=1'-0"

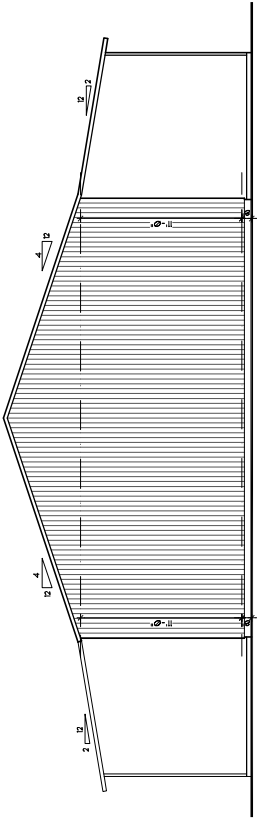


B Left Elevation
1/4"=1'-0"

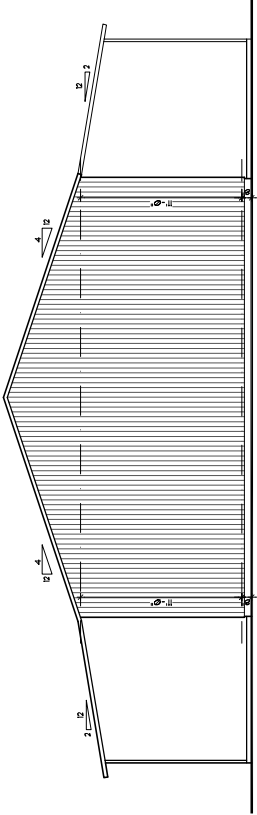

C Right Elevation
1/4"=1'-0"

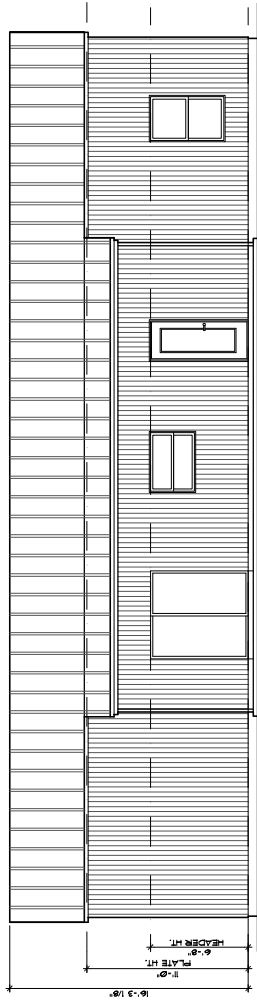

D Rear Elevation
1/4"=1'-0"

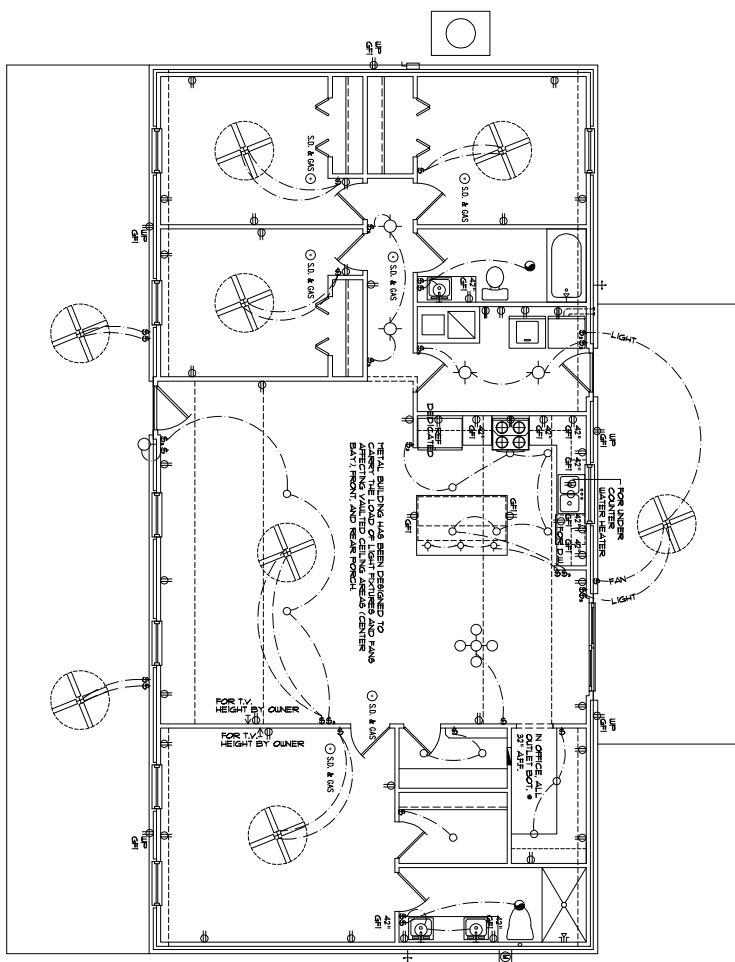

NOTES:

1. ALL ABOVE PRECAUTIONS ARE TO BE MAINTAINED AND INTERCONNECTED.
2. PROVIDE FIRE FIGHT PROTECTION IN ALL LIVING SPACES EXCEPT IN BATHROOMS, KITCHENS, LAUNDRY AND GARAGES.
3. PROVIDE SMOKE DETECTOR IN EACH ROOM.
4. PROVIDE ALARMS OR PROVIDE A CARBON MONOXIDE ALARM IN ADDITION TO SMOKE ALARMS IN EACH ROOM LEADING FROM BEDROOMS.
5. PROVIDE FIRE RESISTANT DOOR WITH GLASS VIEW PORT IN EACH ROOM.
6. ALL LIGHTS ARE MODERATED AND HEAT TREATMENT IS MODERATED.
7. LOCAL CODES REQUIREMENTS APPLICABLE ON DISBURSEMENT MAY BE PLACED BETWEEN OWNER AND BUILDERS IN THE FIELD.

ELECTRICAL LEGEND

	12, 16, 17 switched		3-phase switch		3-way switch		120 V AC
	220 V AC		240 V AC		277 V AC		480 V AC
	60 Hz		60 Hz		60 Hz		60 Hz
	120 V AC		240 V AC		277 V AC		480 V AC
	120 V AC		240 V AC		277 V AC		480 V AC
	120 V AC		240 V AC				

A	Electrical Fixture Layout
EI	SCALE: 1/4" = 1'-0"

job no	
M0324	
drown by	
DA	
checked	
date	
05/20/24	
scale	
AS NOTED	
drawing no.	

McCOY INTERIOR BUILDOUT
PARCEL: 01-18-15-01435-610 (4461)
FORT WHITE, FLORIDA

 **THE FINAL PLAN, INC.**
WWW.THEFINALPLAN.COM
TEL. 352.410.2539

**CUSTOM DESIGNS, SPACE PLANNING
TENANT BUILD OUTS, ADDITIONS, REMODELS**