

CONSTRUCTION DRAWINGS FOR THE MOFFITT RESIDENCE

PLANS PREPARED FOR:

**JIM & JERI MOFFITT
RIDGE STREET
LAKE CITY, FLORIDA 32024
(386) 867-0398**

SHEET INDEX

COVER SHEET	1
FLOOR PLAN	2
ELEVATIONS	3 - 4
FOUNDATION PLAN/DETAILS	5
ELECTRICAL PLAN	6




NORTH FLORIDA PROFESSIONAL SERVICES, INC.
P. O. BOX 3823
LAKE CITY, FL 32056-3823
PH. (386) 752-4675 FAX (386) 752-4674
ENGINEERING LICENSE No. 29011

**COVER SHEET
MOFFITT RESIDENCE
LAKE CITY, FLORIDA**


REVISIONS

JOB NO.
120904MOF
DATE
2/26/2013
SHEET NO.
1 of 6

Handwritten signature and date 4/16/2013

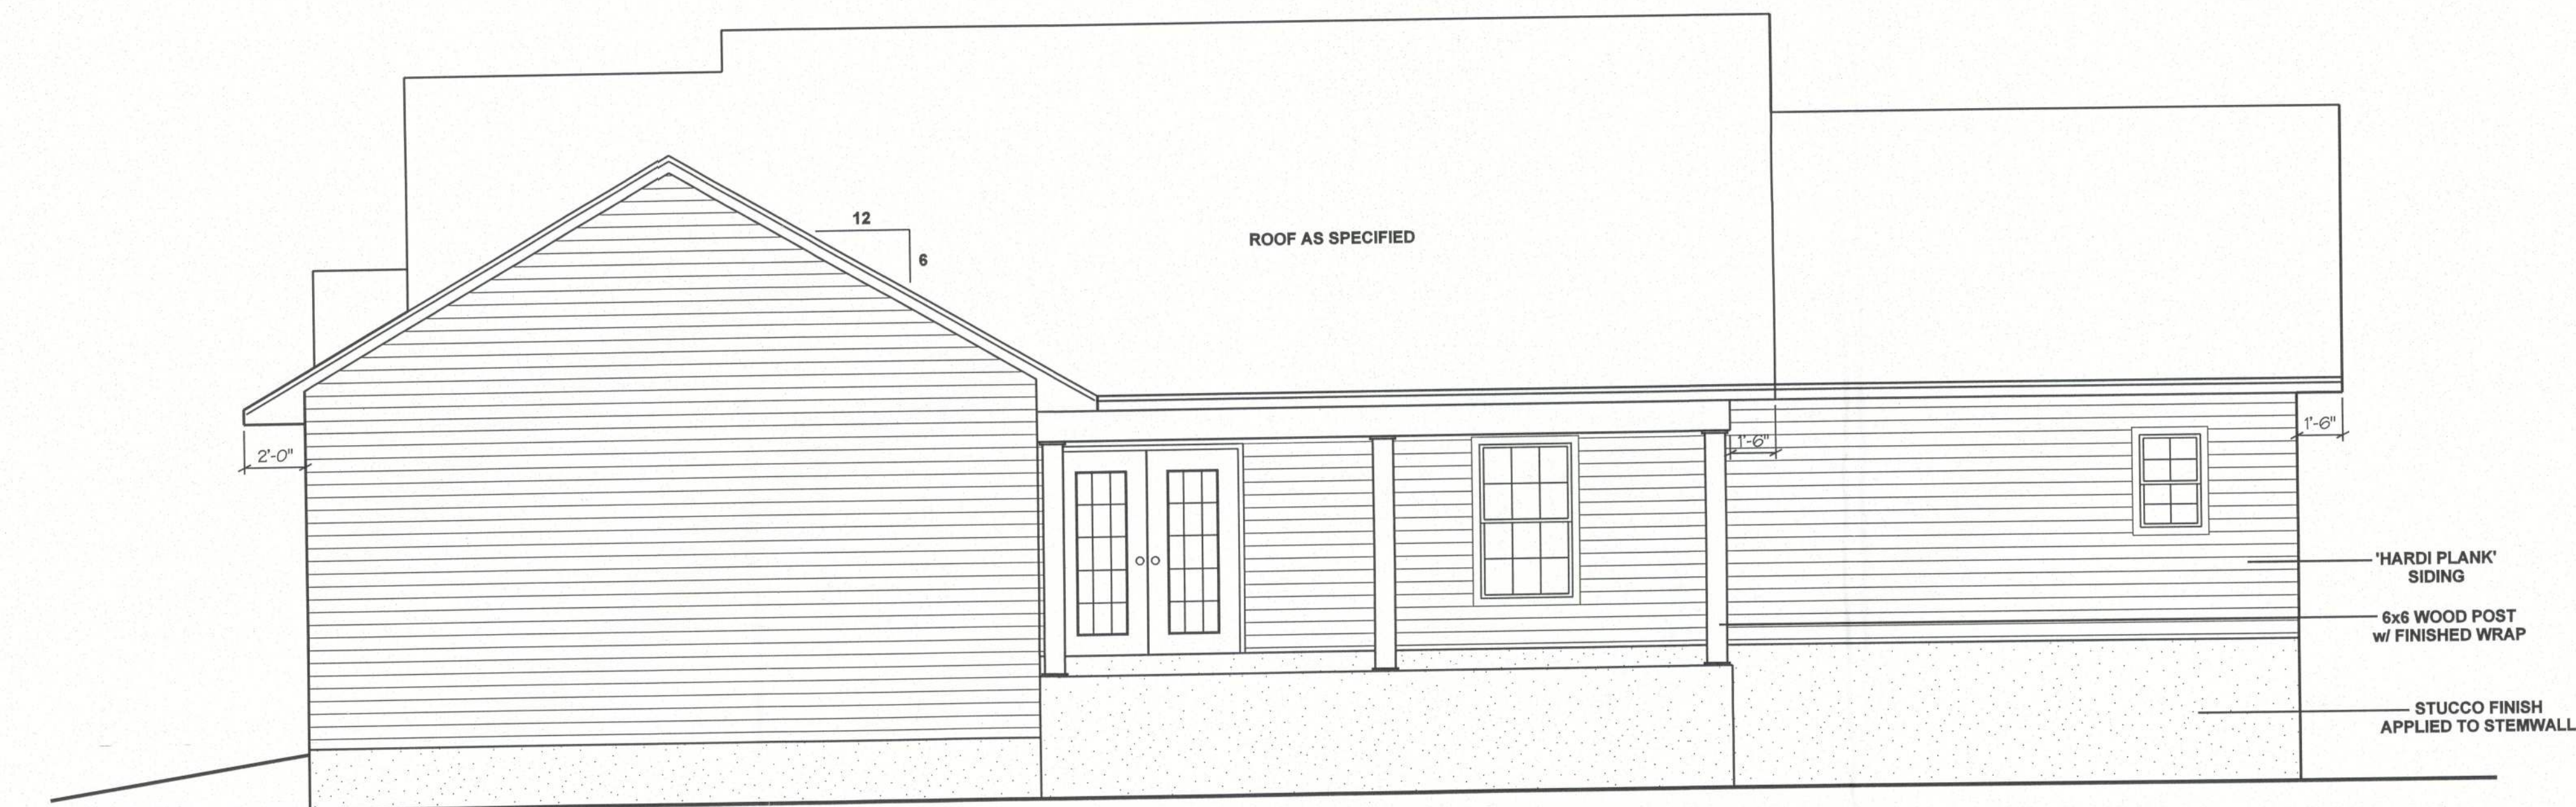

REAR ELEVATION

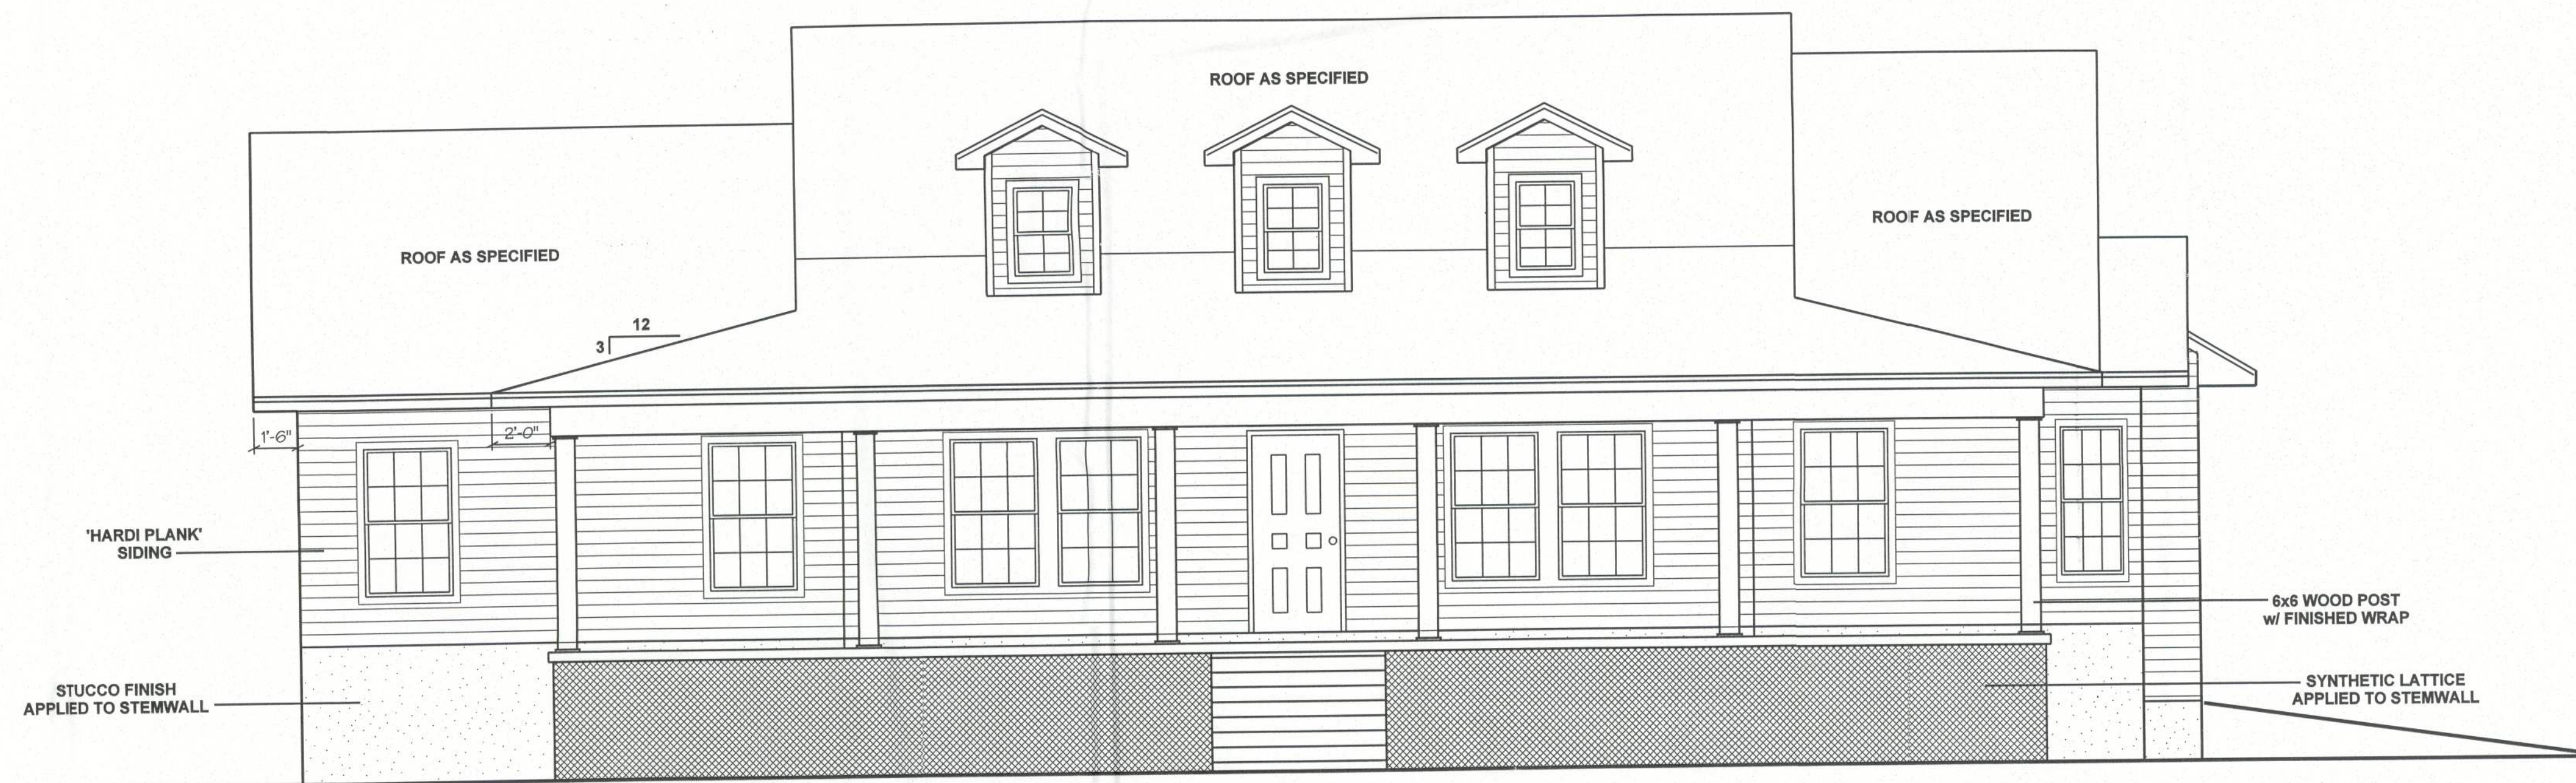

FRONT ELEVATION

NORTH FLORIDA PROFESSIONAL SERVICES, INC.
P. O. BOX 3823
LAKE CITY, FL 32056-3823
PH. (386) 752-4675 FAX (386) 752-4674
ENGINEERING LICENSE No. 29011


ELEVATIONS
MOFFITT RESIDENCE
LAKE CITY, FLORIDA

REVISIONS


JOB NO.
120904MOF
DATE
9/4/2012
SHEET NO.

3 of 5

Handwritten signature
4/16/2013

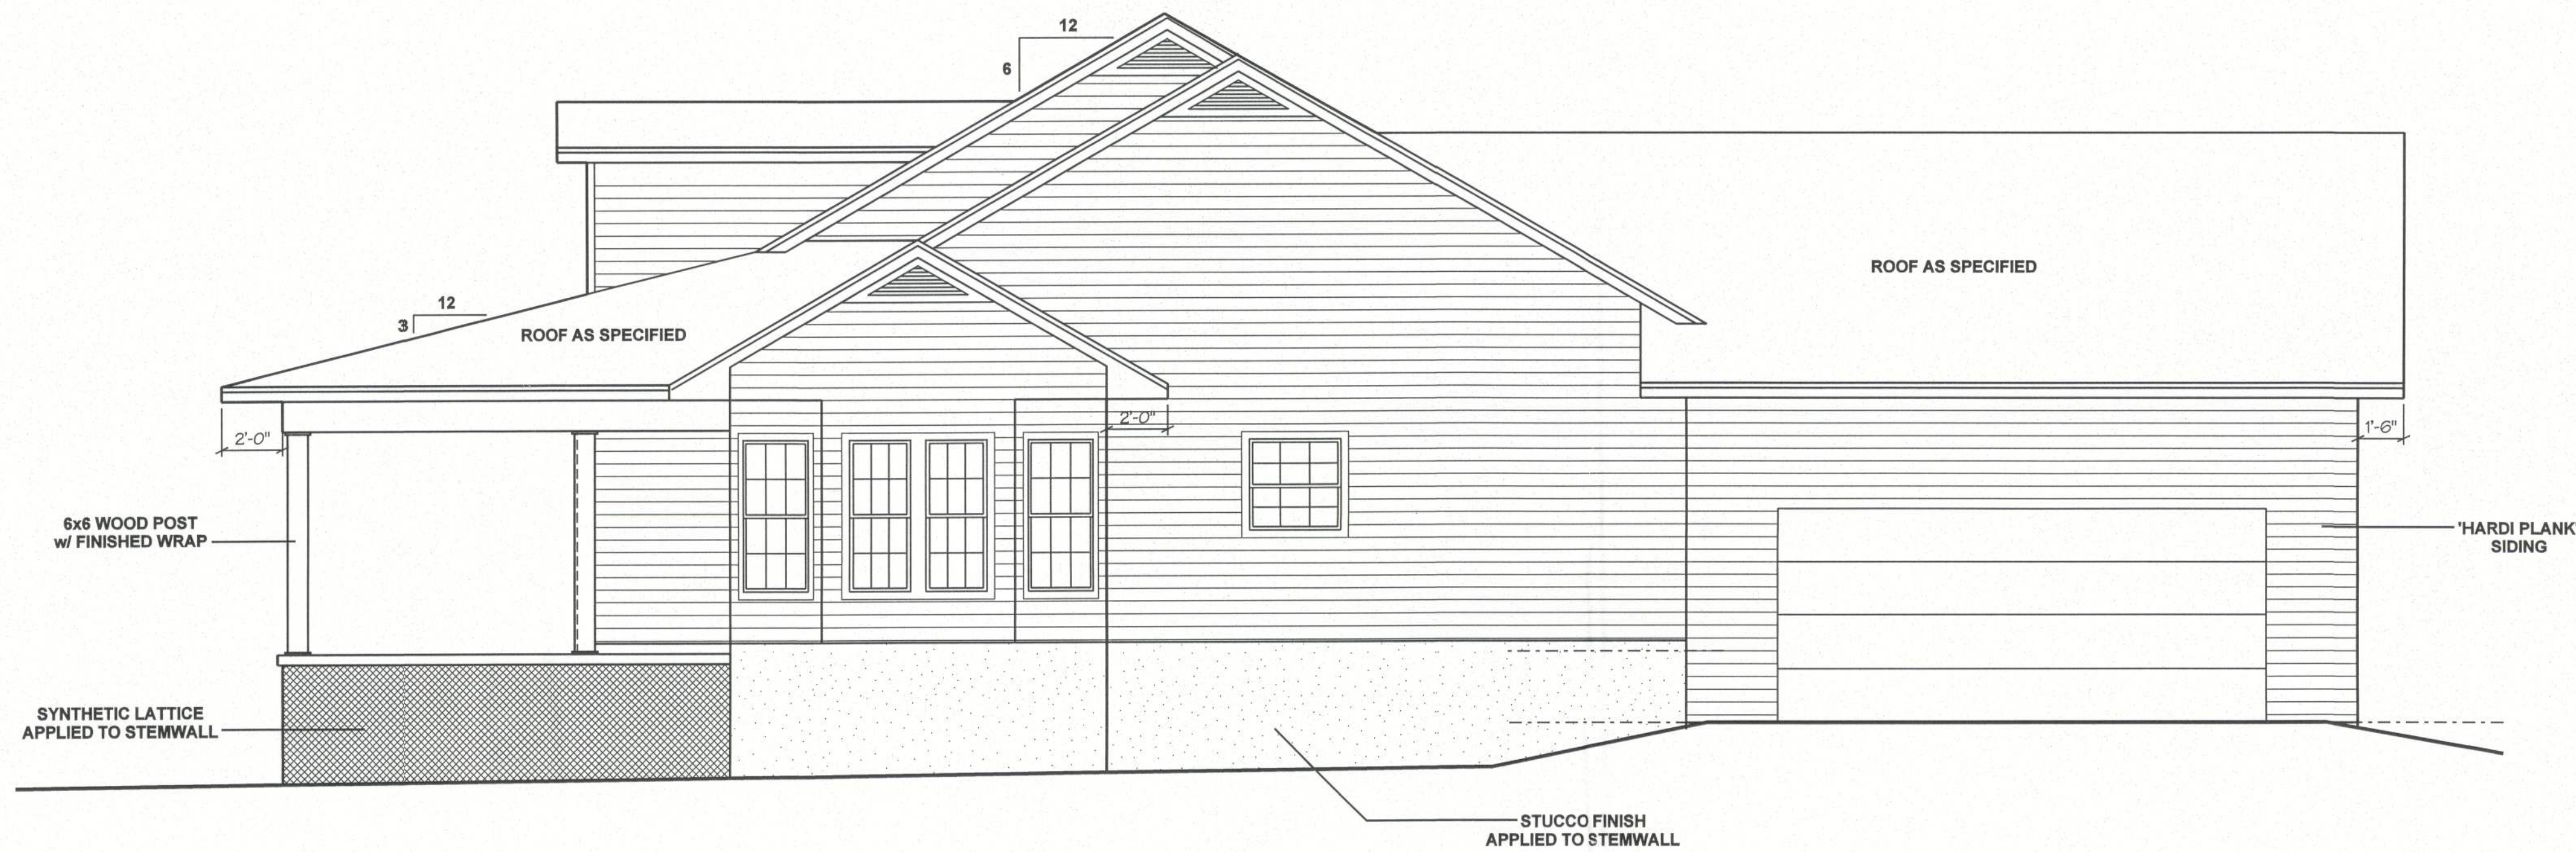

RIGHT SIDE ELEVATION

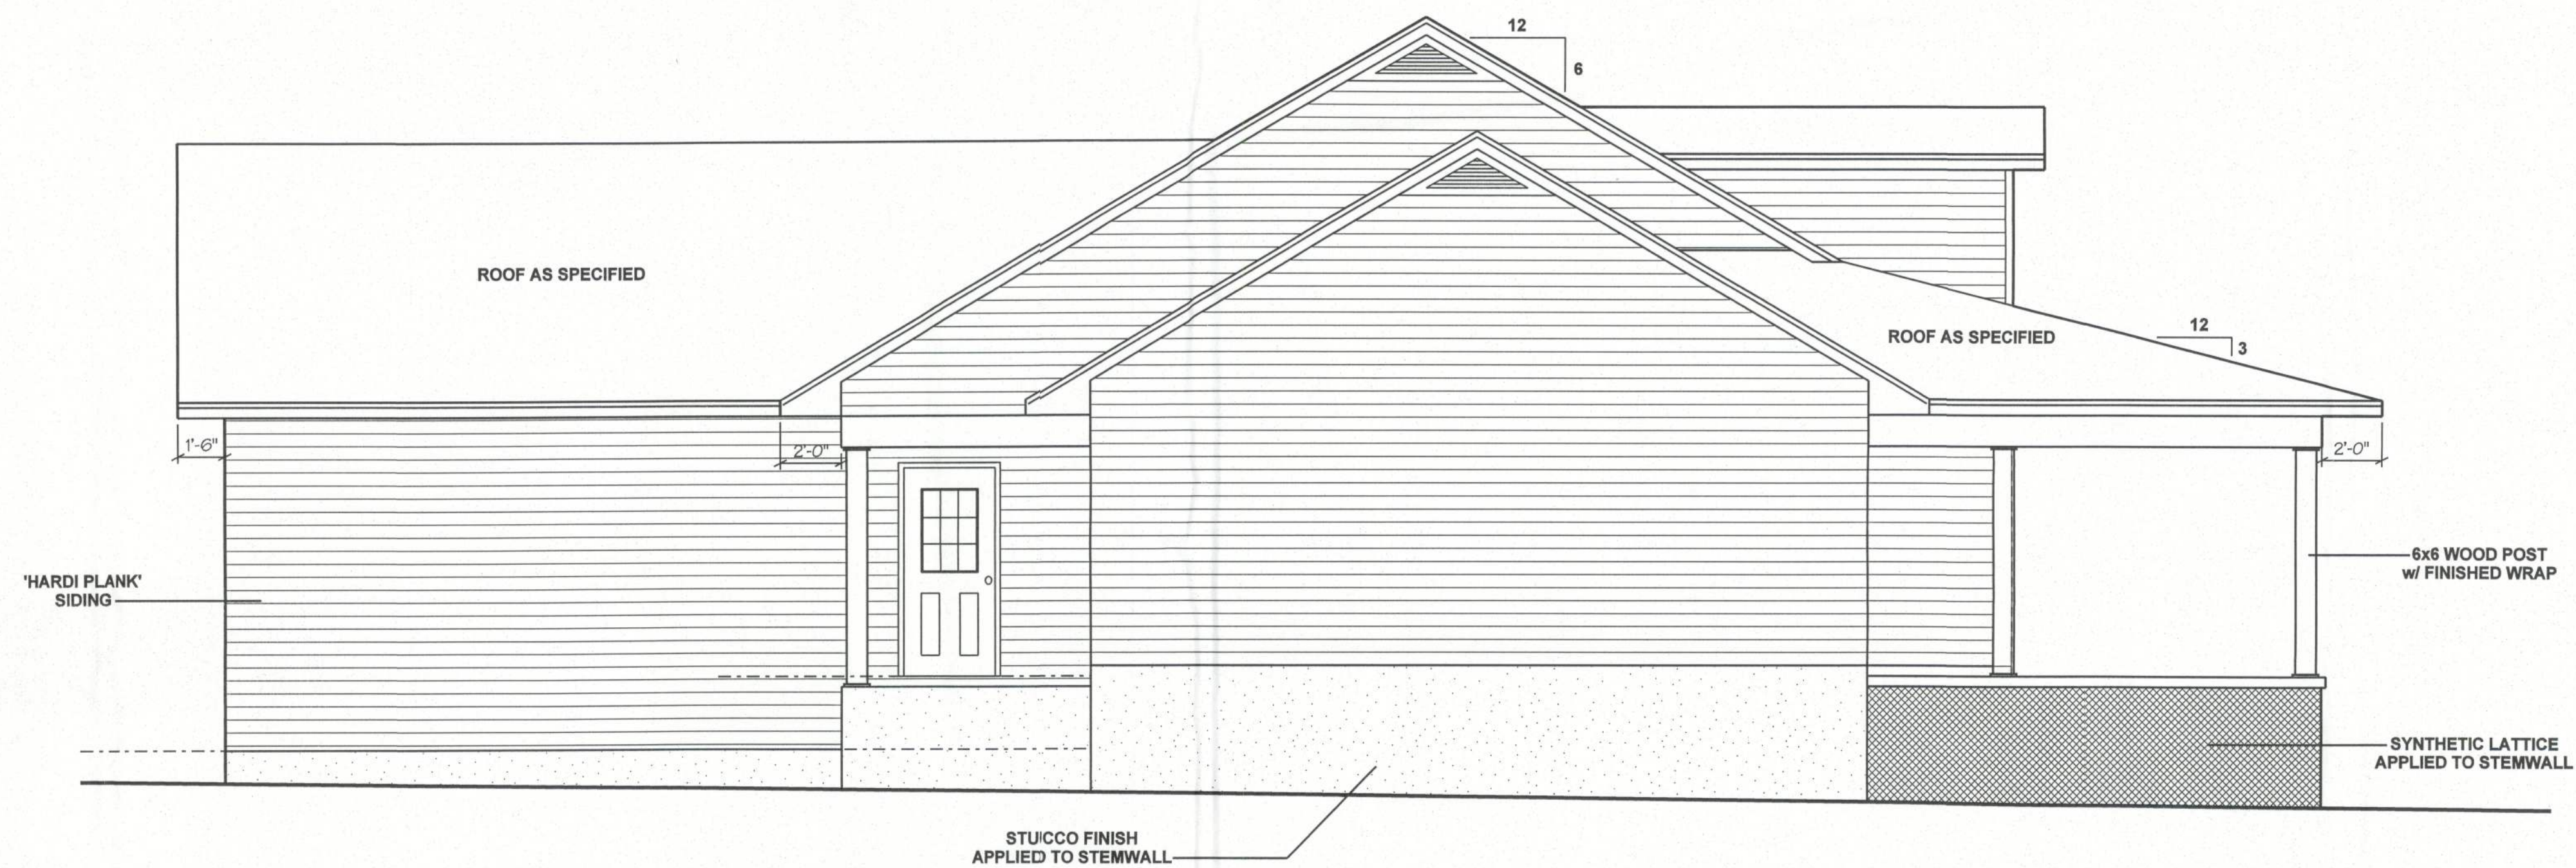

LEFT SIDE ELEVATION

NORTH FLORIDA PROFESSIONAL SERVICES, INC.
P. O. BOX 3823
LAKE CITY, FL 32056-3823
PH. (386) 752-4675 FAX (386) 752-4674
ENGINEERING LICENSE No. 29011





ELEVATIONS
MOFFITT RESIDENCE
LAKE CITY, FLORIDA

REVISIONS

JOB NO.
120904MOF
DATE
9/4/2012
SHEET NO.

4 of 6

JPM
4/16/2013

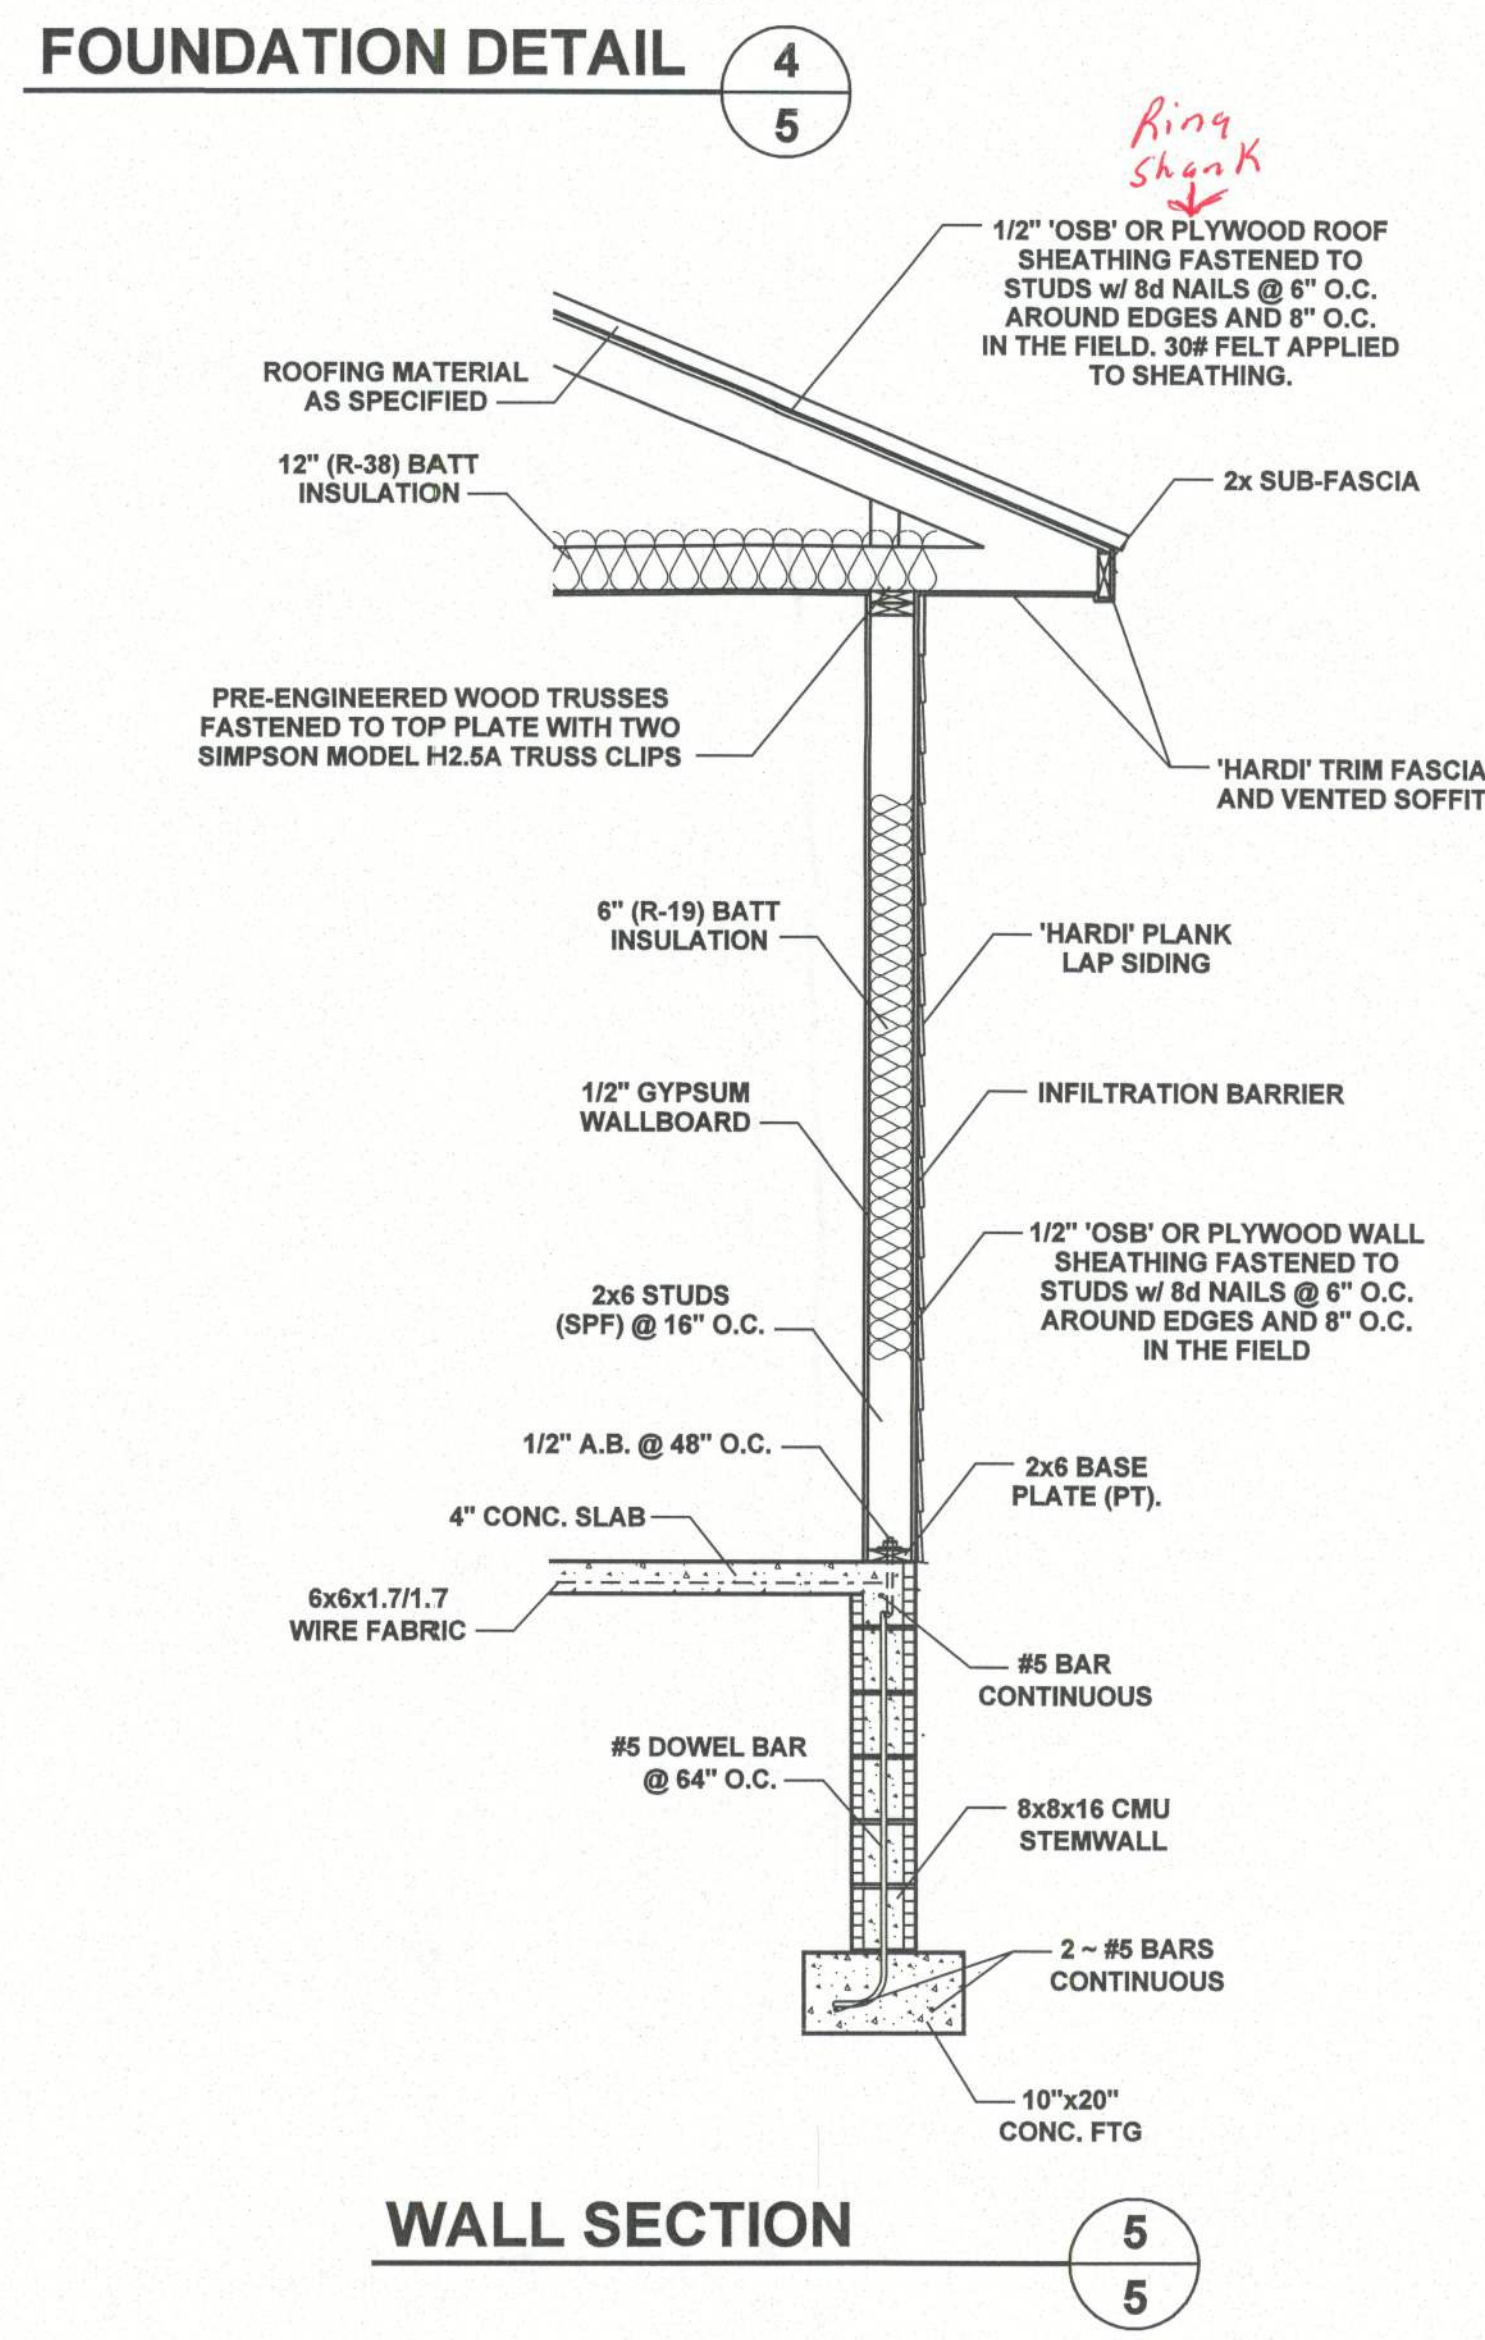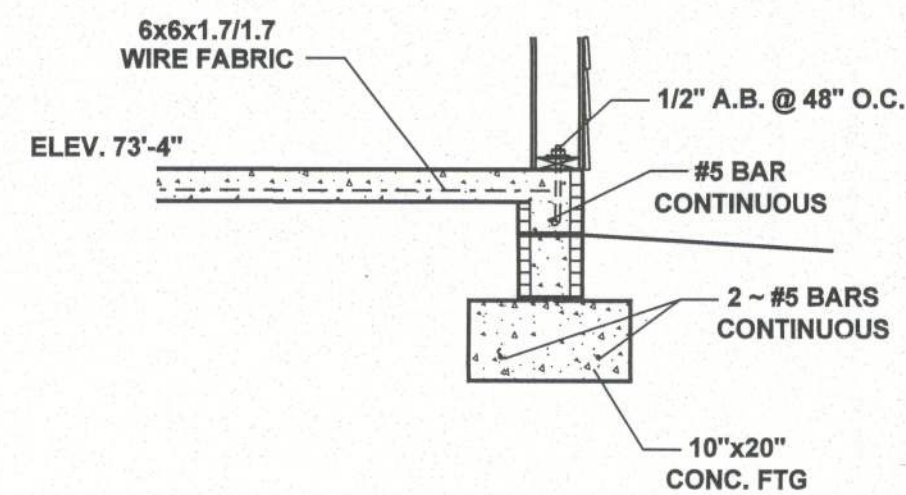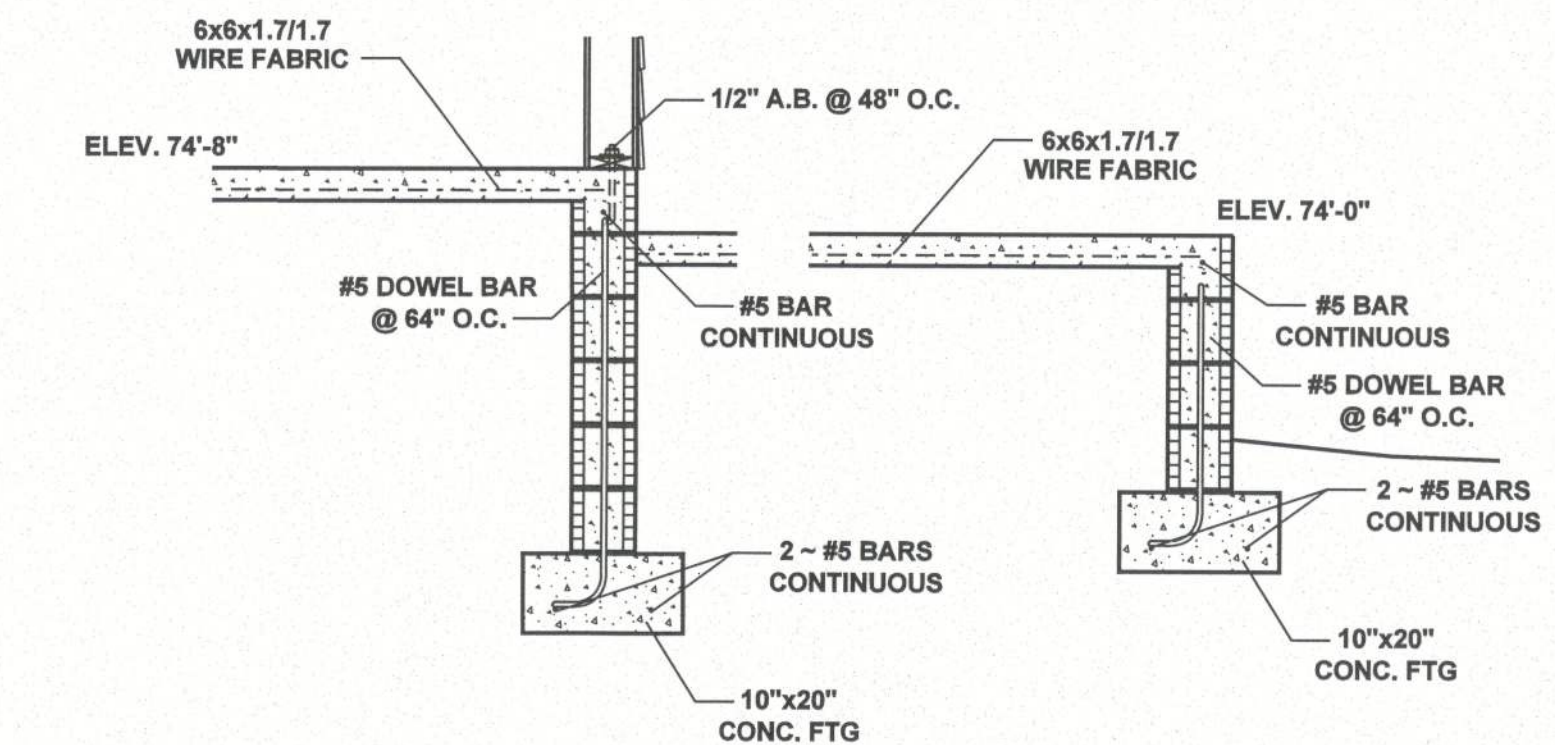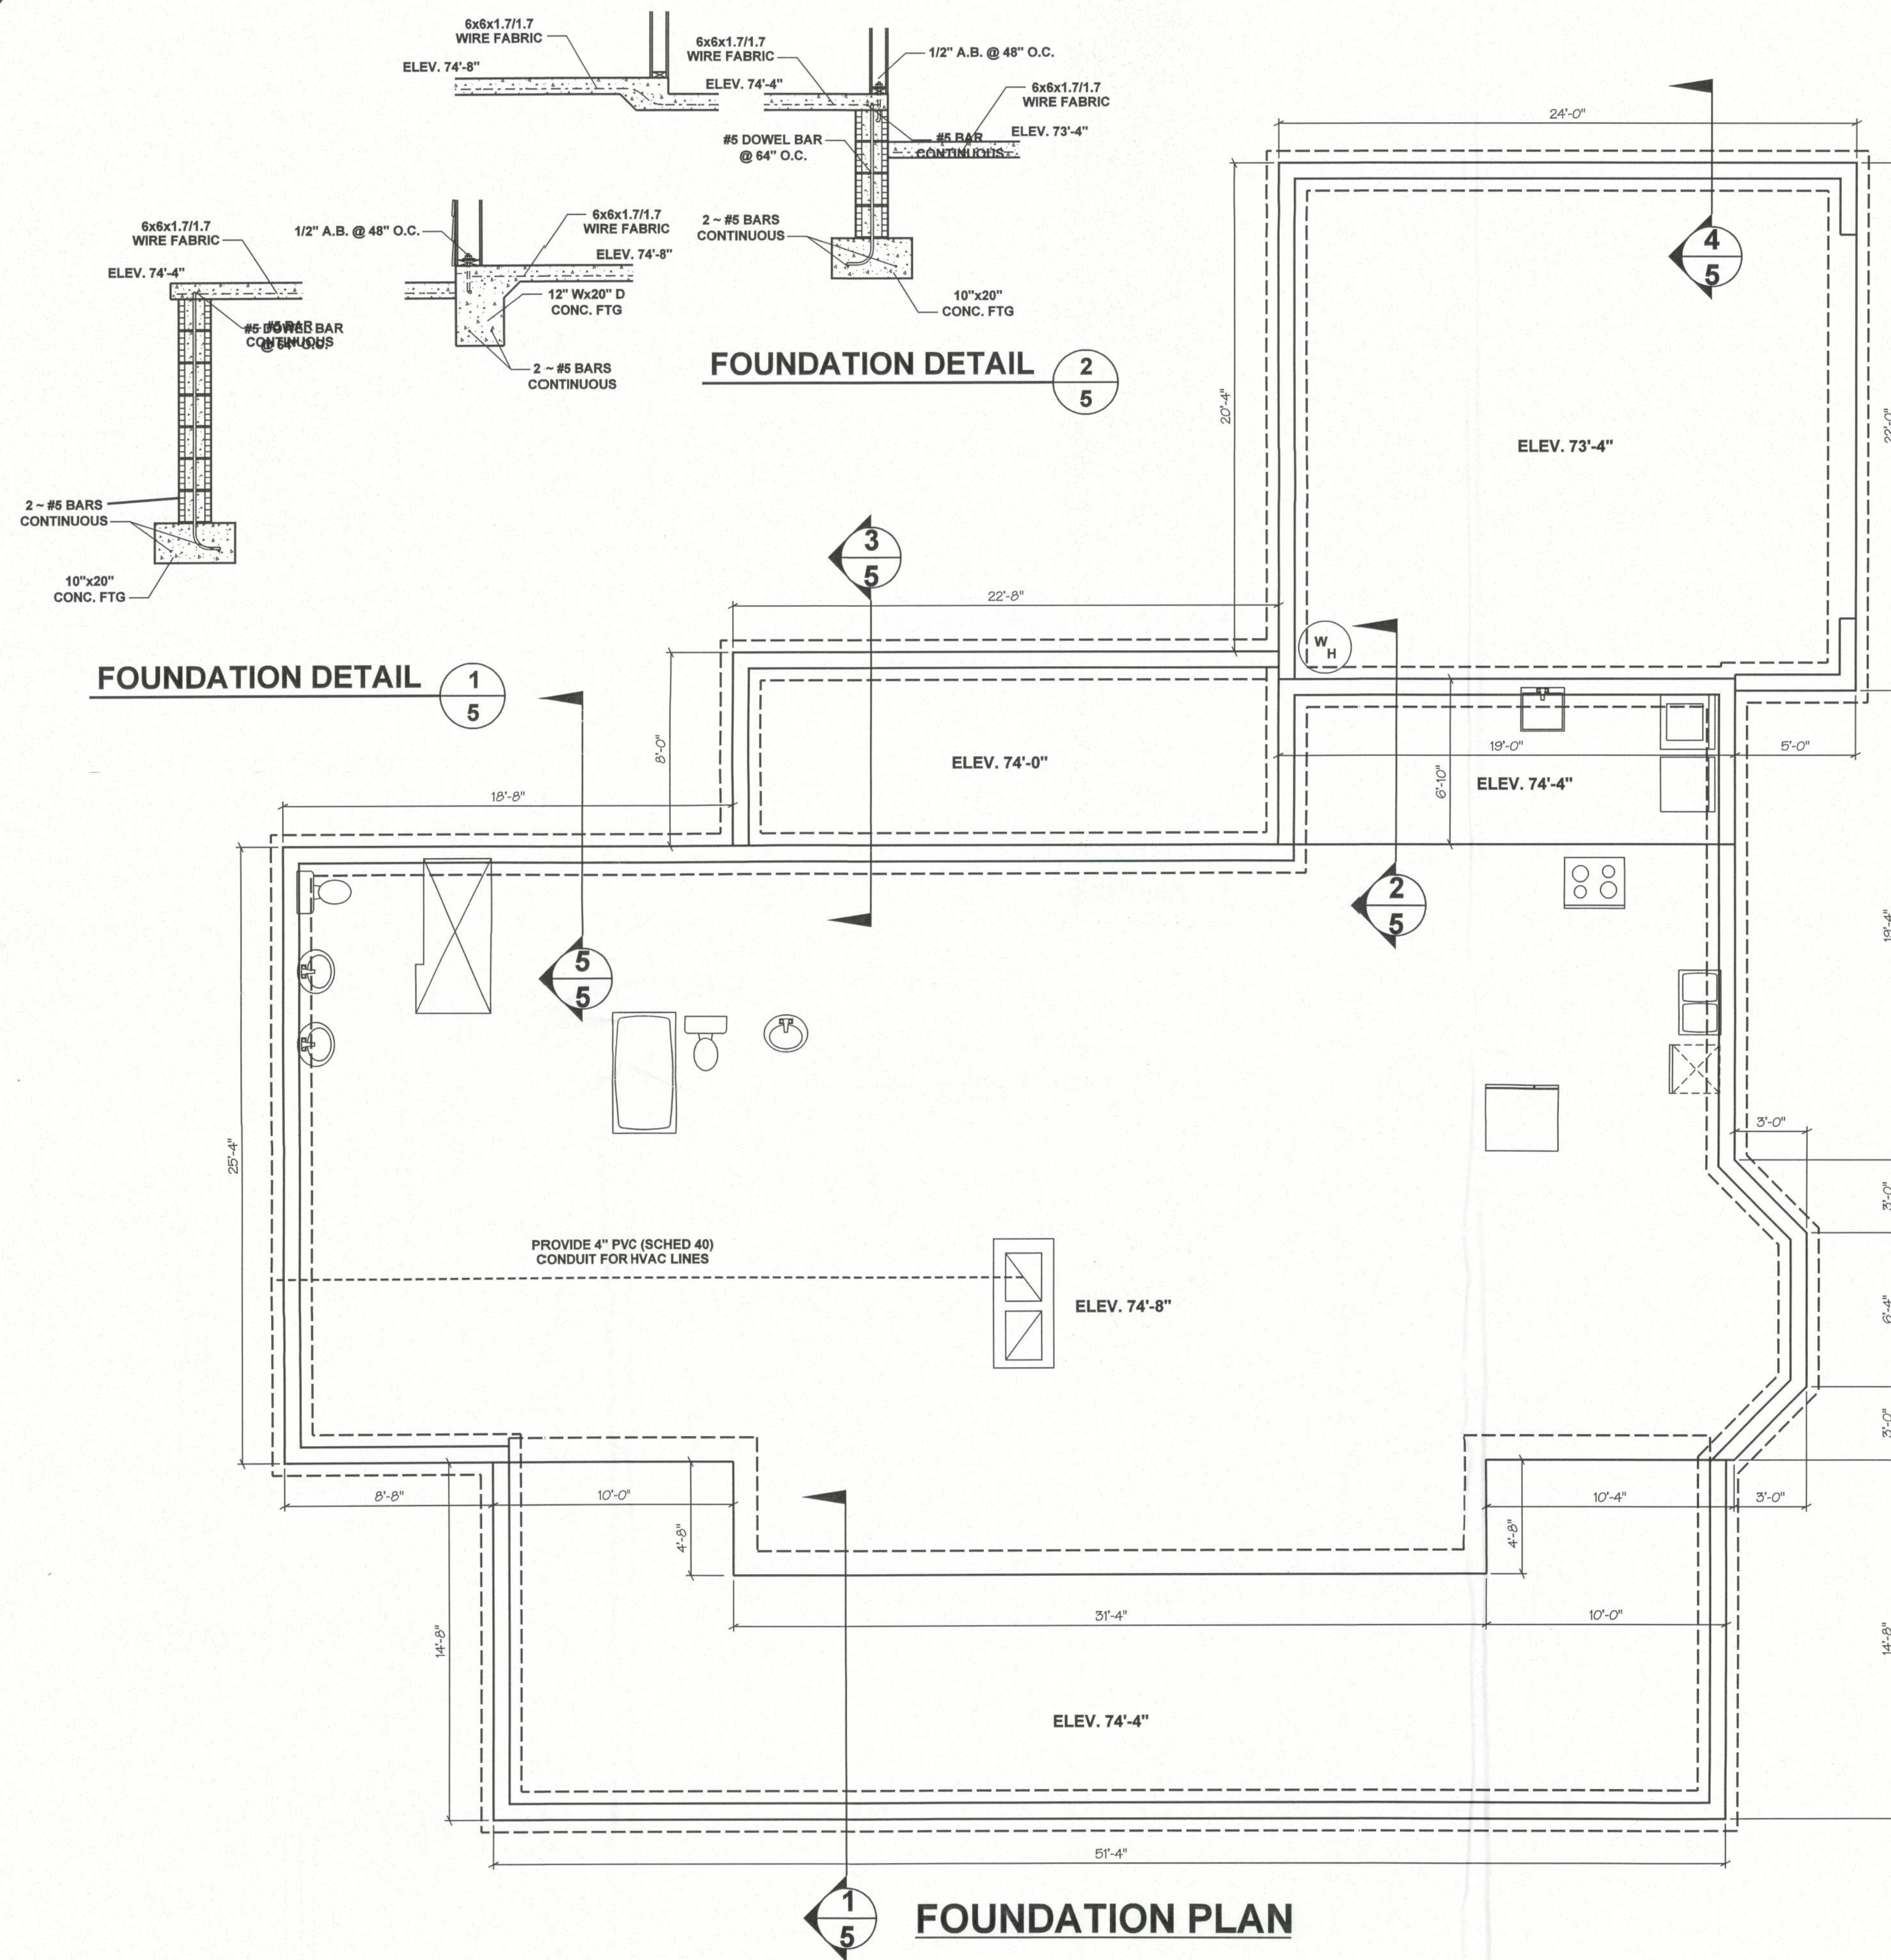

NORTH FLORIDA PROFESSIONAL SERVICES, INC.
P. O. BOX 3823
LAKE CITY, FL 32056-3823
PH. (386) 752-4675 FAX (386) 752-4674
ENGINEERING LICENSE NO. 29011


FOUNDATION PLAN **MOFFITT RESIDENCE** LAKE CITY, FLORIDA

REVISIONS

JOB NO.
120904MOF
DATE
2/6/2013
SHEET NO.

5 of 6

Handwritten signature and date:
4/16/2013

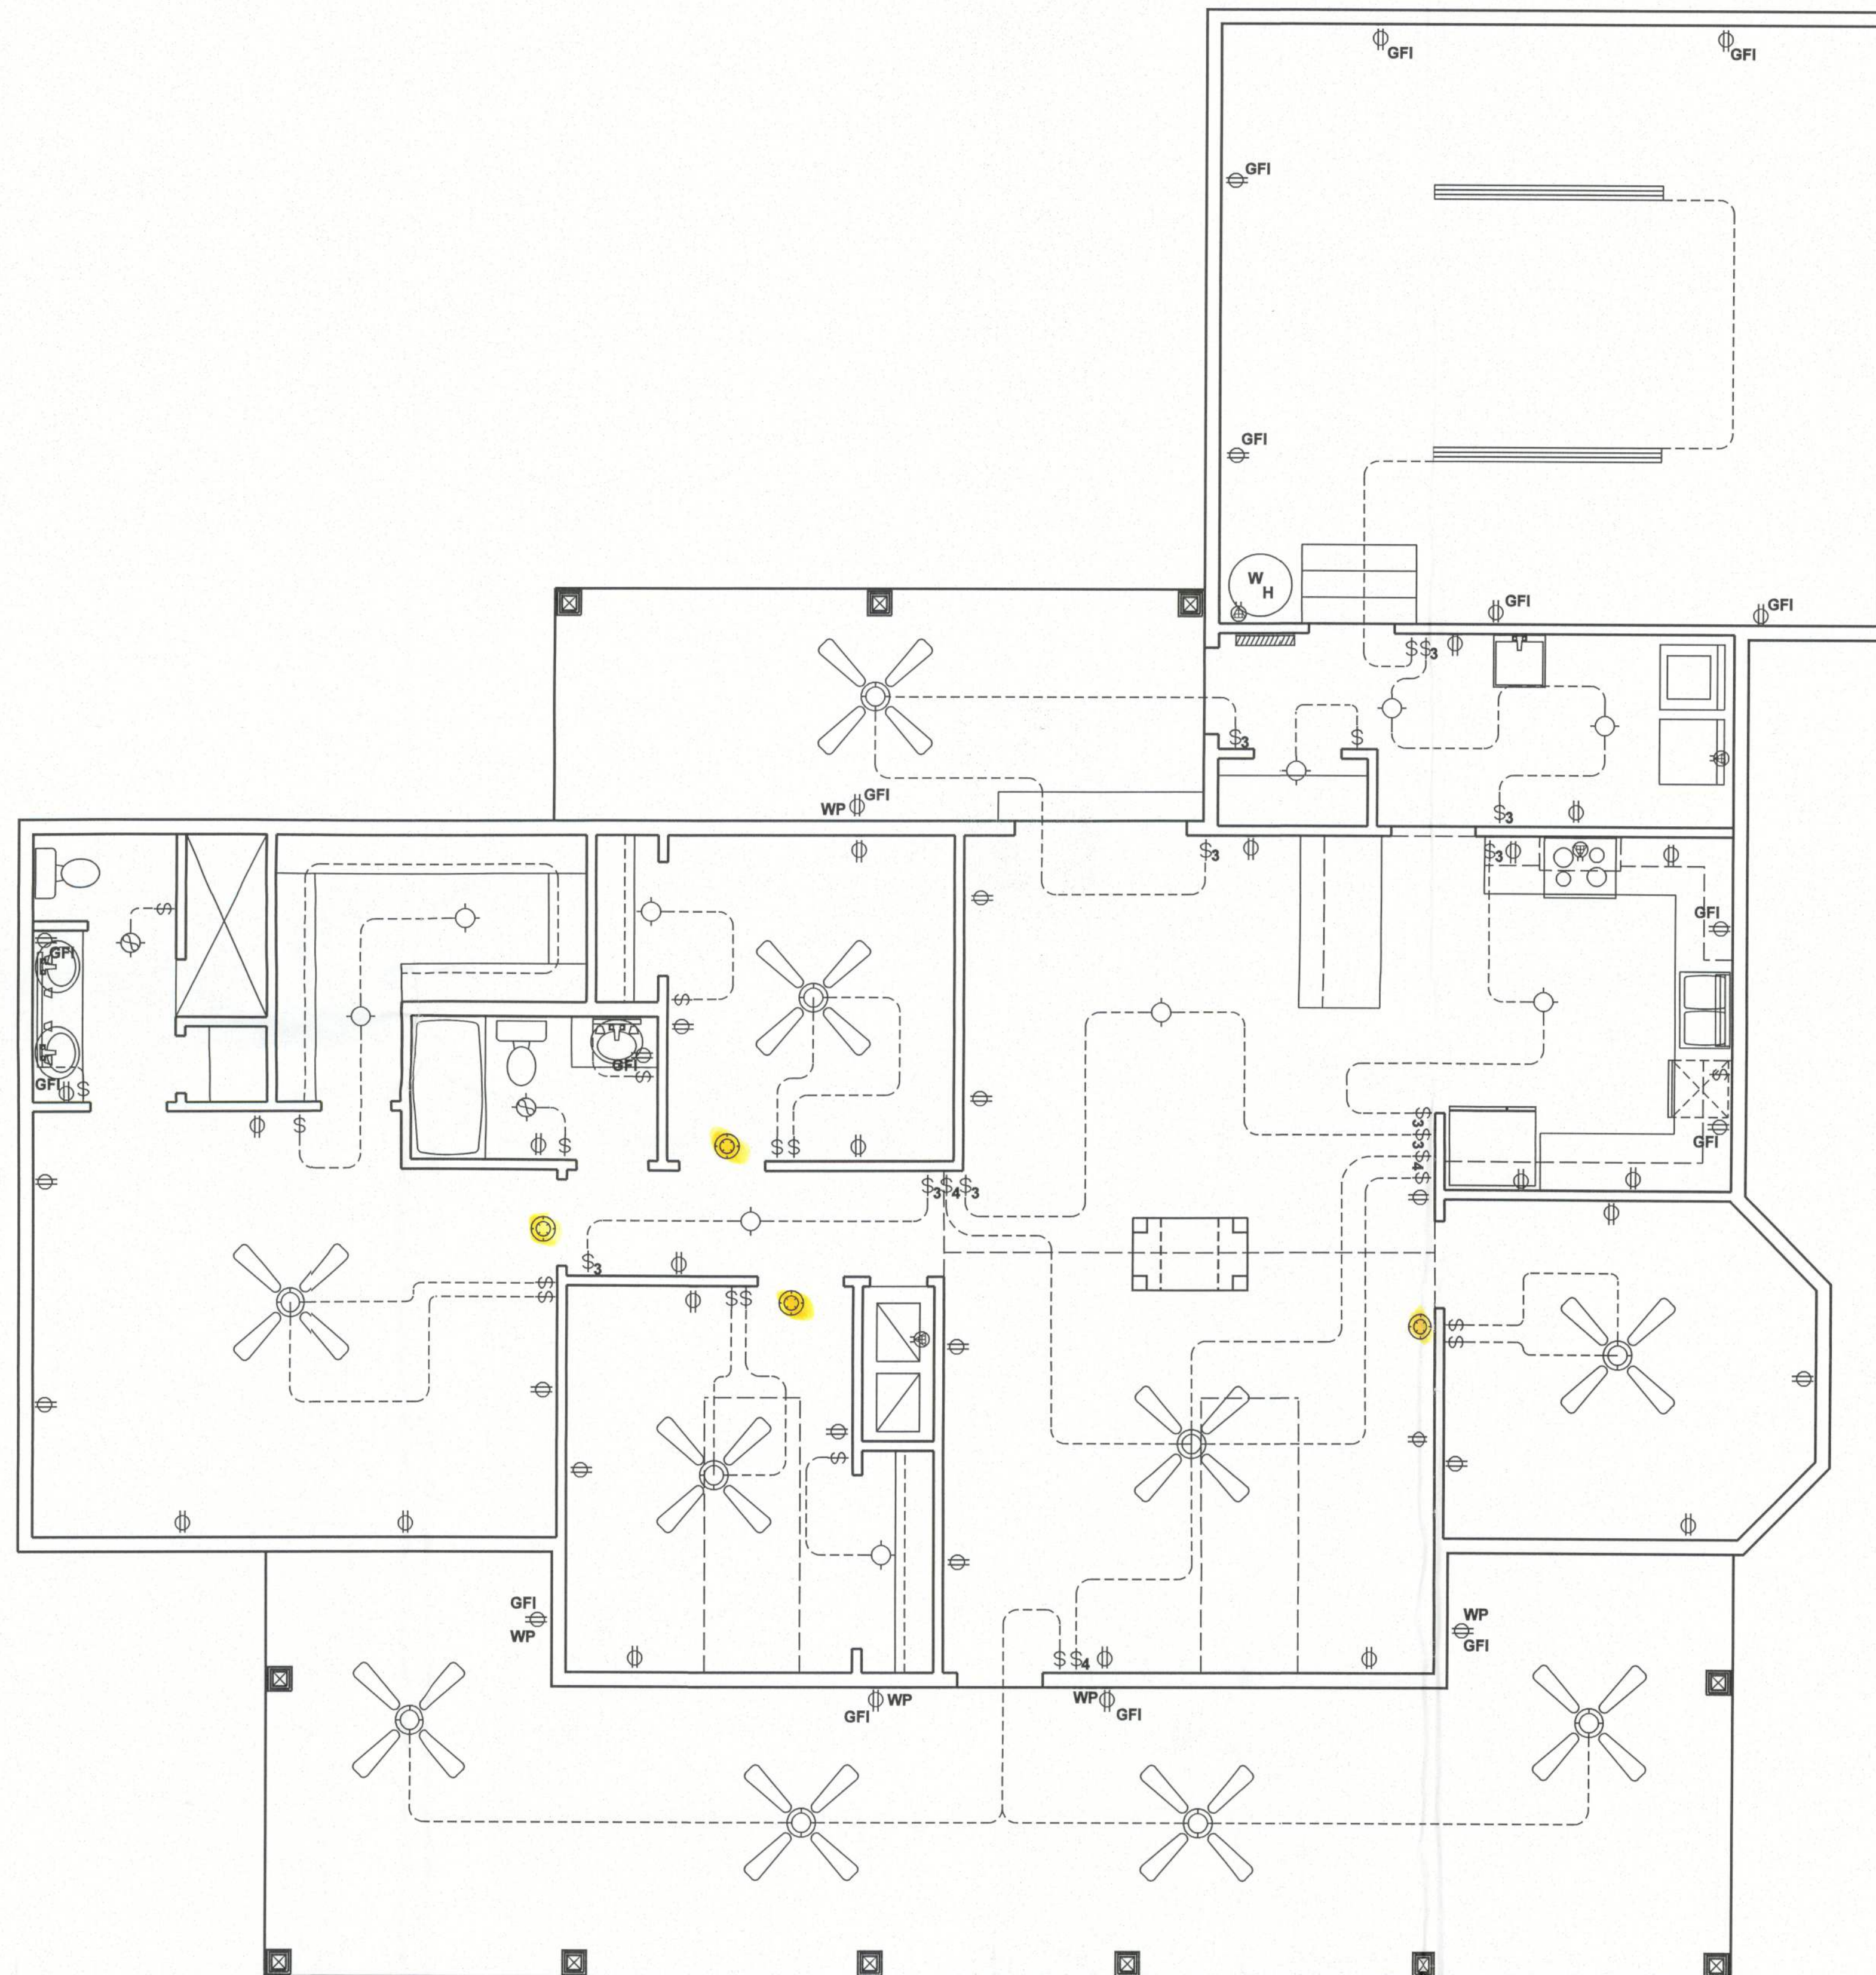

ELECTRICAL PLAN
TELEPHONE JACKS & CATV
RECEPTACLES TO BE PLACED
AS REQUIRED OWNERS.

ELECTRICAL SYMBOLS	
TYPE	DESCRIPTION
	STANDARD DUPLEX RECEPTACLE
	GROUND FAULT INTERRUPTER RECEPTACLE
	WEATHER PROOF RECEPTACLE
	STANDARD SINGLE POLE SWITCH
	THREE-WAY SWITCH
	FOUR-WAY SWITCH
	INCANDESCENT LIGHT FIXTURE
	CEILING FAN
	EXHAUST FAN
	SPECIAL PURPOSE RECEPTACLE (220)
	SMOKE DETECTOR
	VANITY LIGHT
	FLUORESCENT STRIP w/ COVER
	ELECTRICAL PANEL (200 AMP)

*C.O. Detector
Required within
1st of all sleeping
rooms.*

NOTE: THIS ELECTRICAL / MECHANICAL PLAN IS
INTENDED TO SHOW SCHEMATICALLY THE
LAYOUT OF THE ELECTRICAL COMPONENTS
AND THE HVAC SYSTEM. FINAL LOCATIONS
AND SIZING OF THE COMPONENTS SHALL
BE THE RESPONSIBILITY OF A LICENSED
ELECTRICAL / MECHANICAL CONTRACTOR.
ALL WORK SHALL BE PERFORMED IN
ACCORDANCE WITH ALL APPLICABLE CODES.

REVISIONS

JOB NO.
120904MOF
DATE
2/6/2013
SHEET NO.

6 of 6

ELECTRICAL PLAN
MOFFITT RESIDENCE
LAKE CITY, FLORIDA

NORTH FLORIDA PROFESSIONAL SERVICES, INC.
P. O. BOX 3823
LAKE CITY, FL 32056-3823
PH. (386) 752-4675 FAX (386) 752-4674
ENGINEERING LICENSE NO. 29011

[Signature]
4/16/2013