




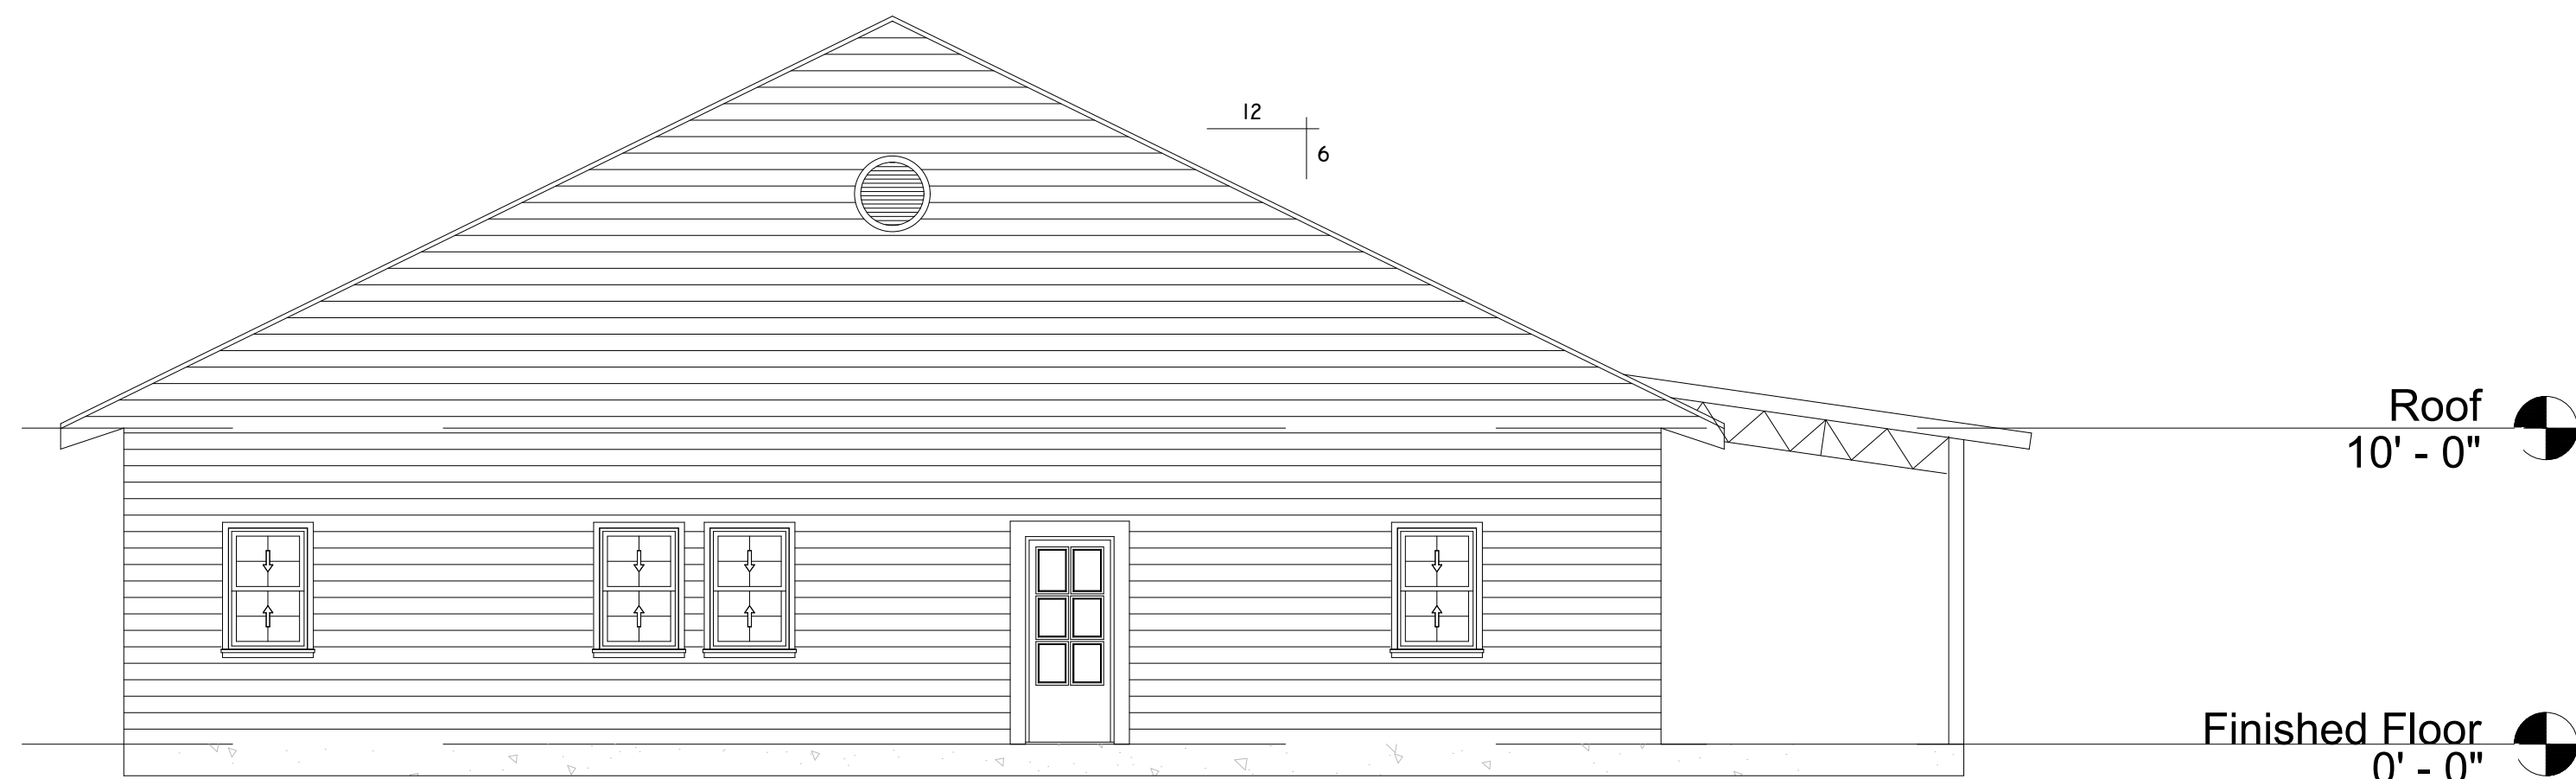


FRONT ELEVATION
SCALE: 3/16" = 1'-0"

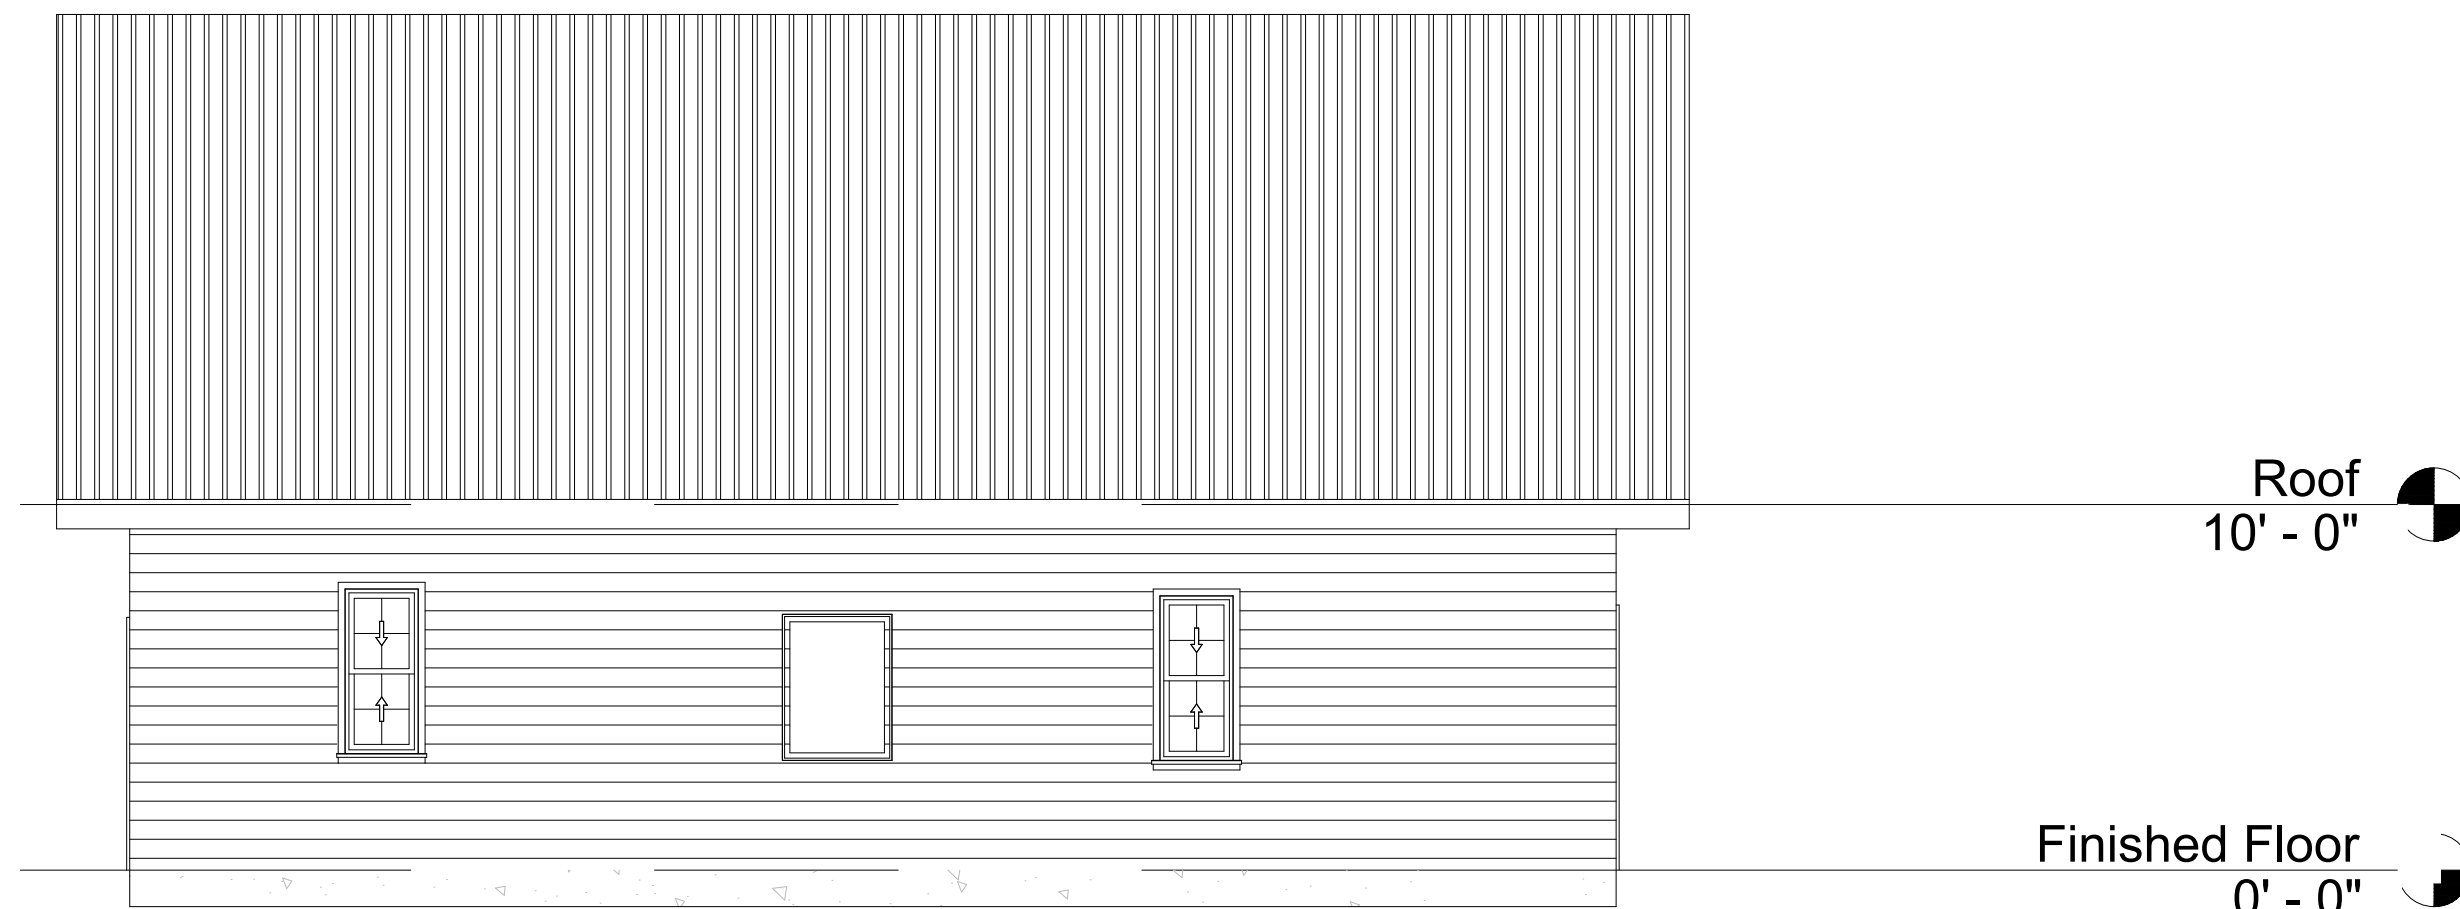

LEFT ELEVATION
SCALE: 3/16" = 1'-0"

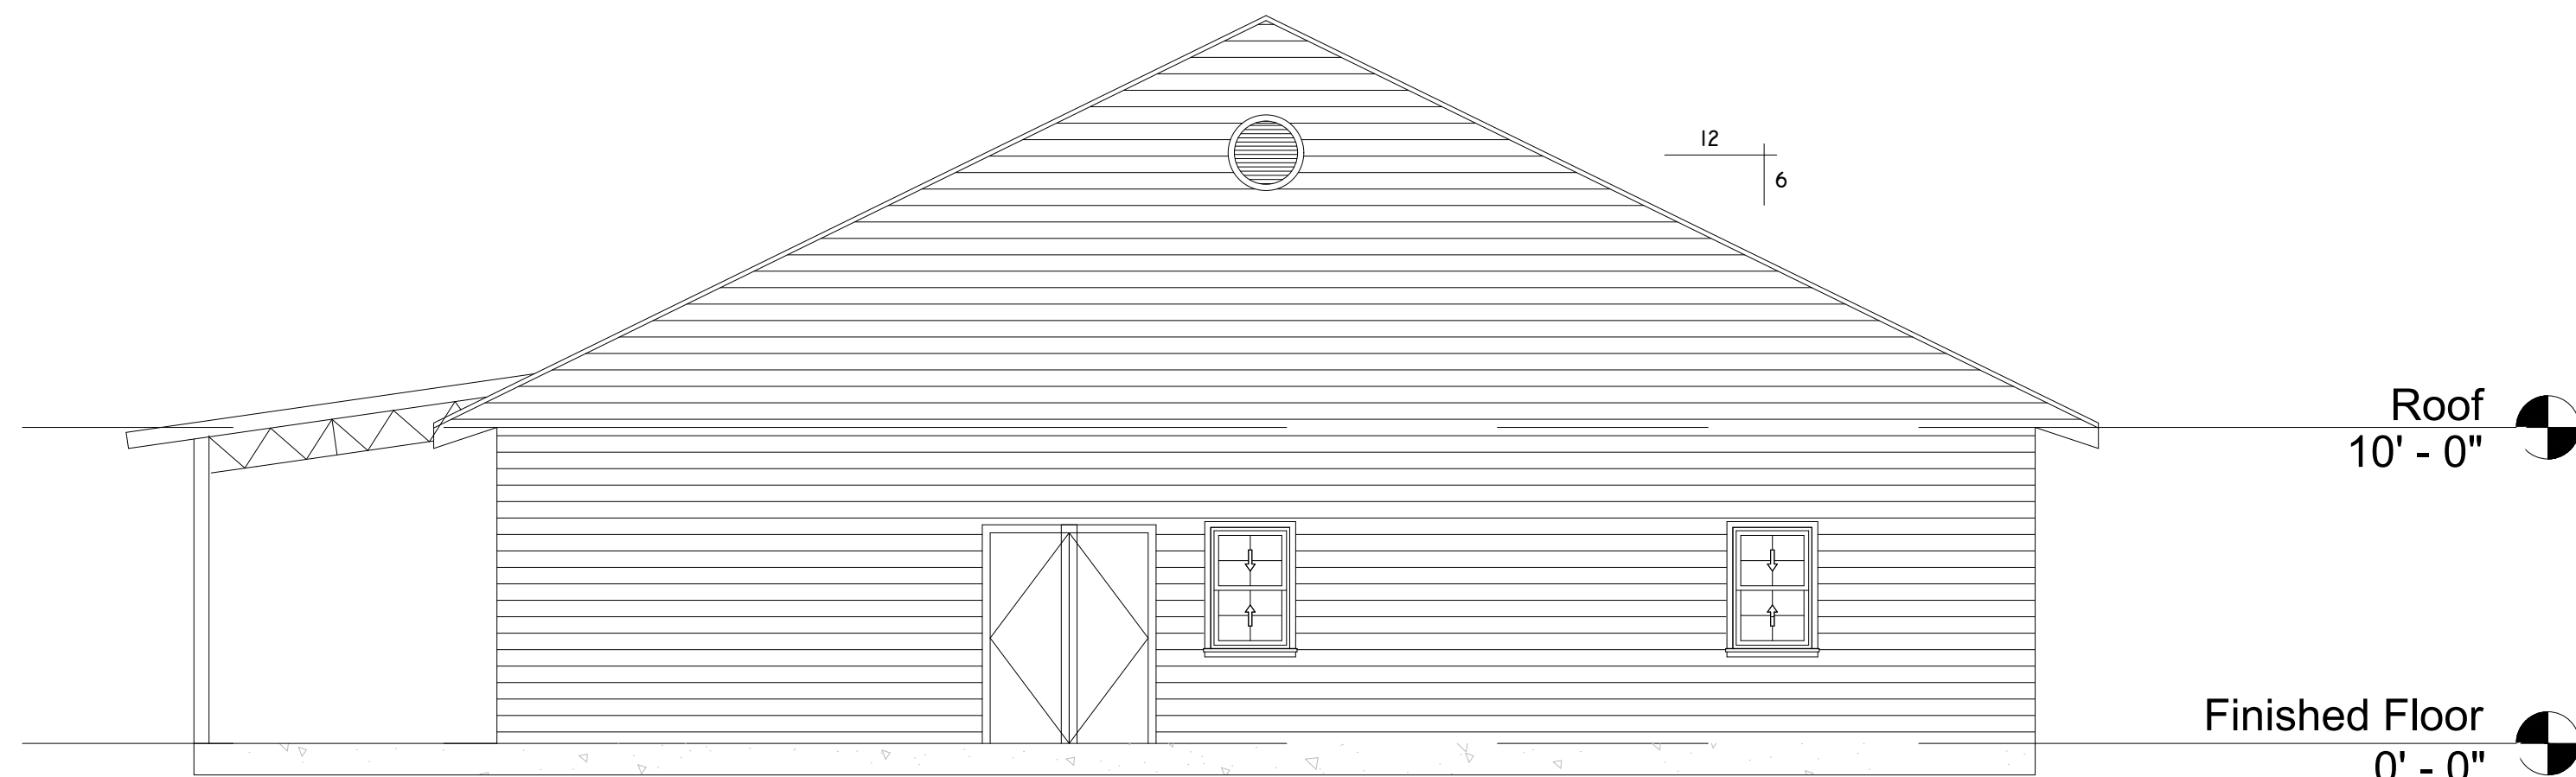

REAR ELEVATION
SCALE: 3/16" = 1'-0"

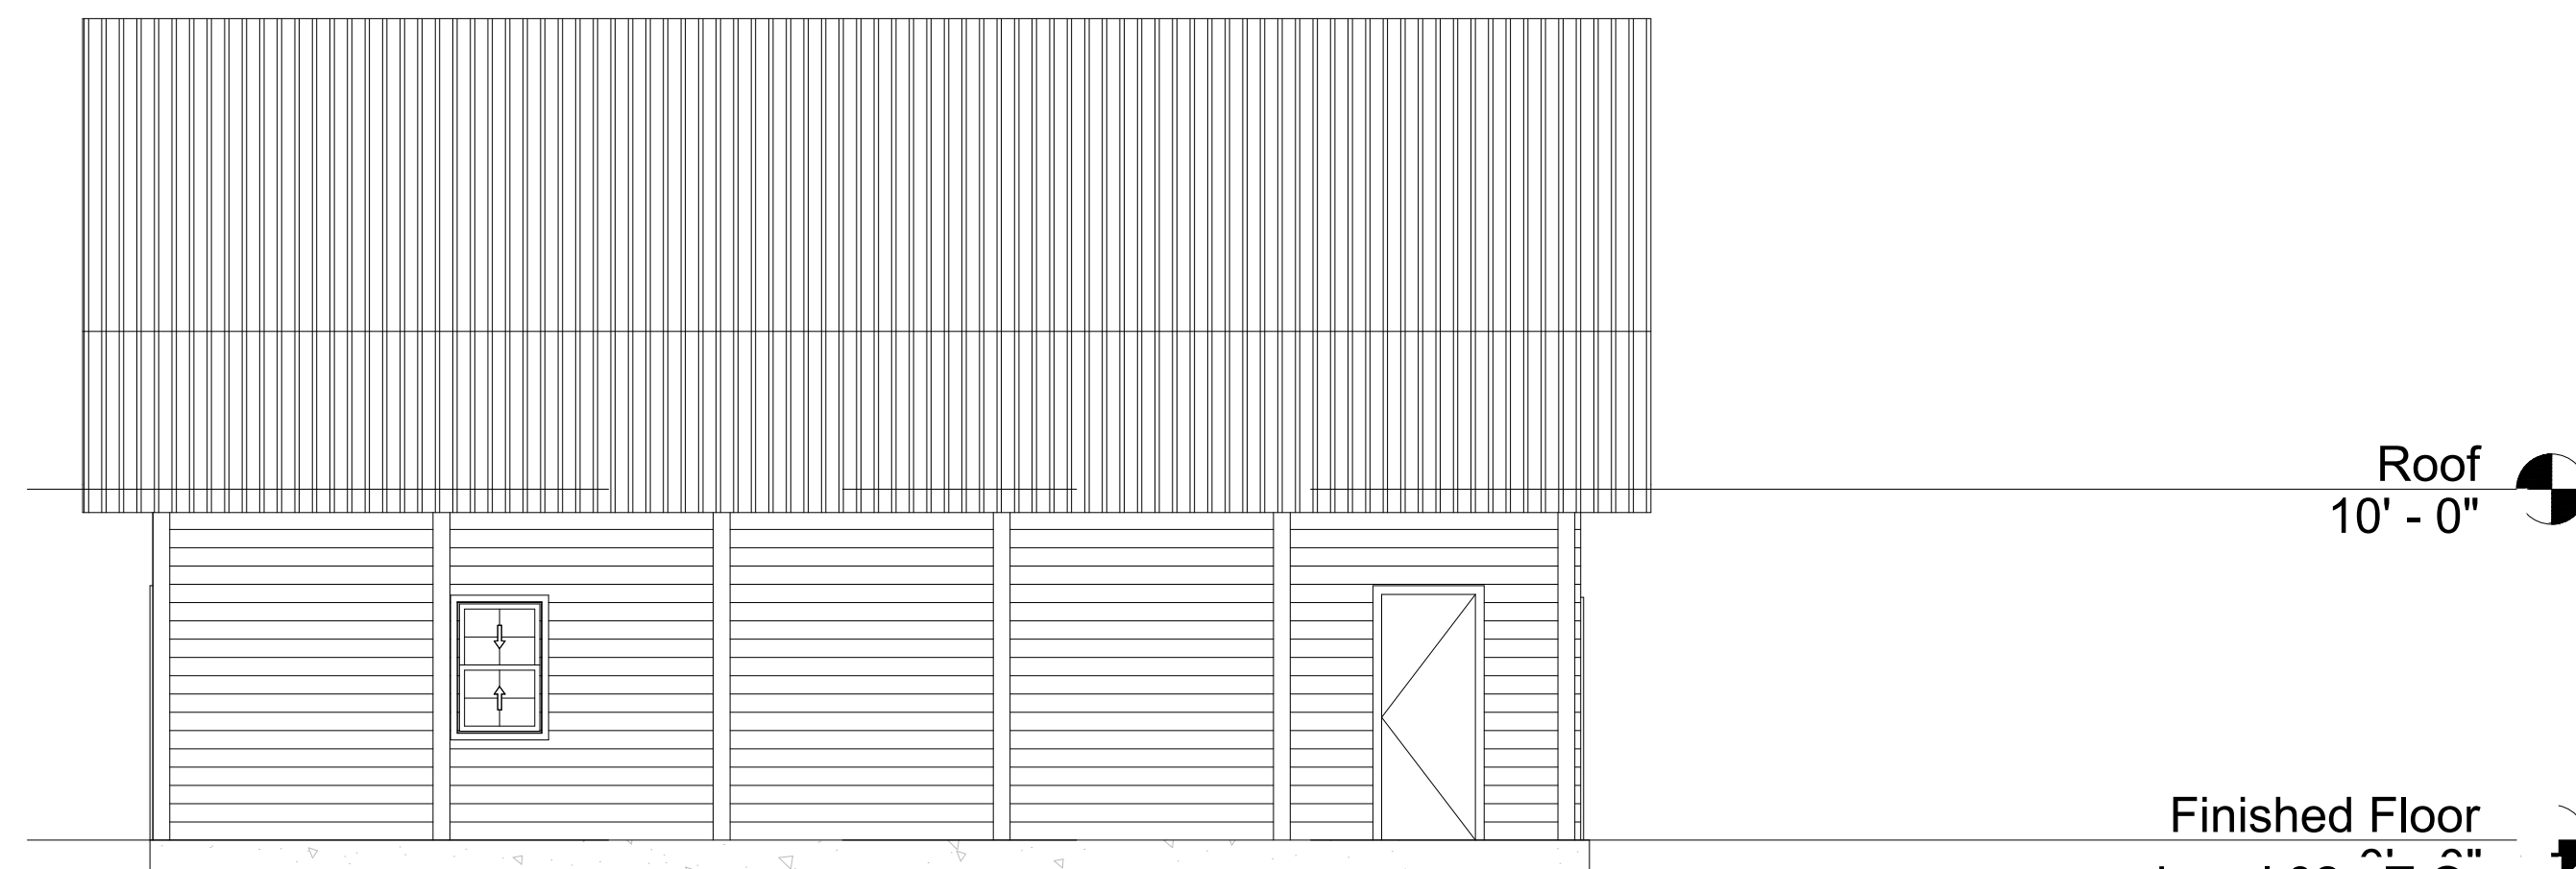

RIGHT ELEVATION
SCALE: 3/16" = 1'-0"

NOTES

1. ACTUAL SLOPE AND/OR VARIATIONS IN GRADE CONDITIONS TO BE DETERMINED ON SITE PRIOR TO CONSTRUCTION.

2. CHECK ALL DIMENSIONS FOR ACCURACY PRIOR TO CONSTRUCTION.

3. ALL CONSTRUCTION MUST CONFORM TO CURRENT STATE AND LOCAL CODES WHERE APPLICABLE:

- FLORIDA BUILDING CODE 2020, 7TH EDITION
- FLORIDA FIRE CODE
- NATIONAL ELECTRIC CODE (NEC)2017
- FLORIDA PLUMBING CODE (FBC)



This has been electronically signed and sealed by TOMAS BRENT WHITMAN, PE using a Digital Signature and date. Printed copies of this document are not considered signed and sealed and the signature must be verified on any electronic copies.

Tomas B
Whitman
2024.07.17
11:53:24 -04'00'

MADISON ENGINEERING, LLC
CONSULTING CIVIL & ENVIRONMENTAL ENGINEERING
268 NE Ridge Loop
Madison, Florida 32340
Work 850.973.7684
COA No.: 27216 www.madisonengineer.com

1157 SW PAUL PEARCE LANE, LAKE CITY, FL 32024

ELEVATIONS


© COPYRIGHT 2024 ME

SCALE: ONLY WHEN PRINTED

TOMAS BRENT WHITMAN, P.E.
FL. P.E. REG. NO. 63178

SHEET NO.

1

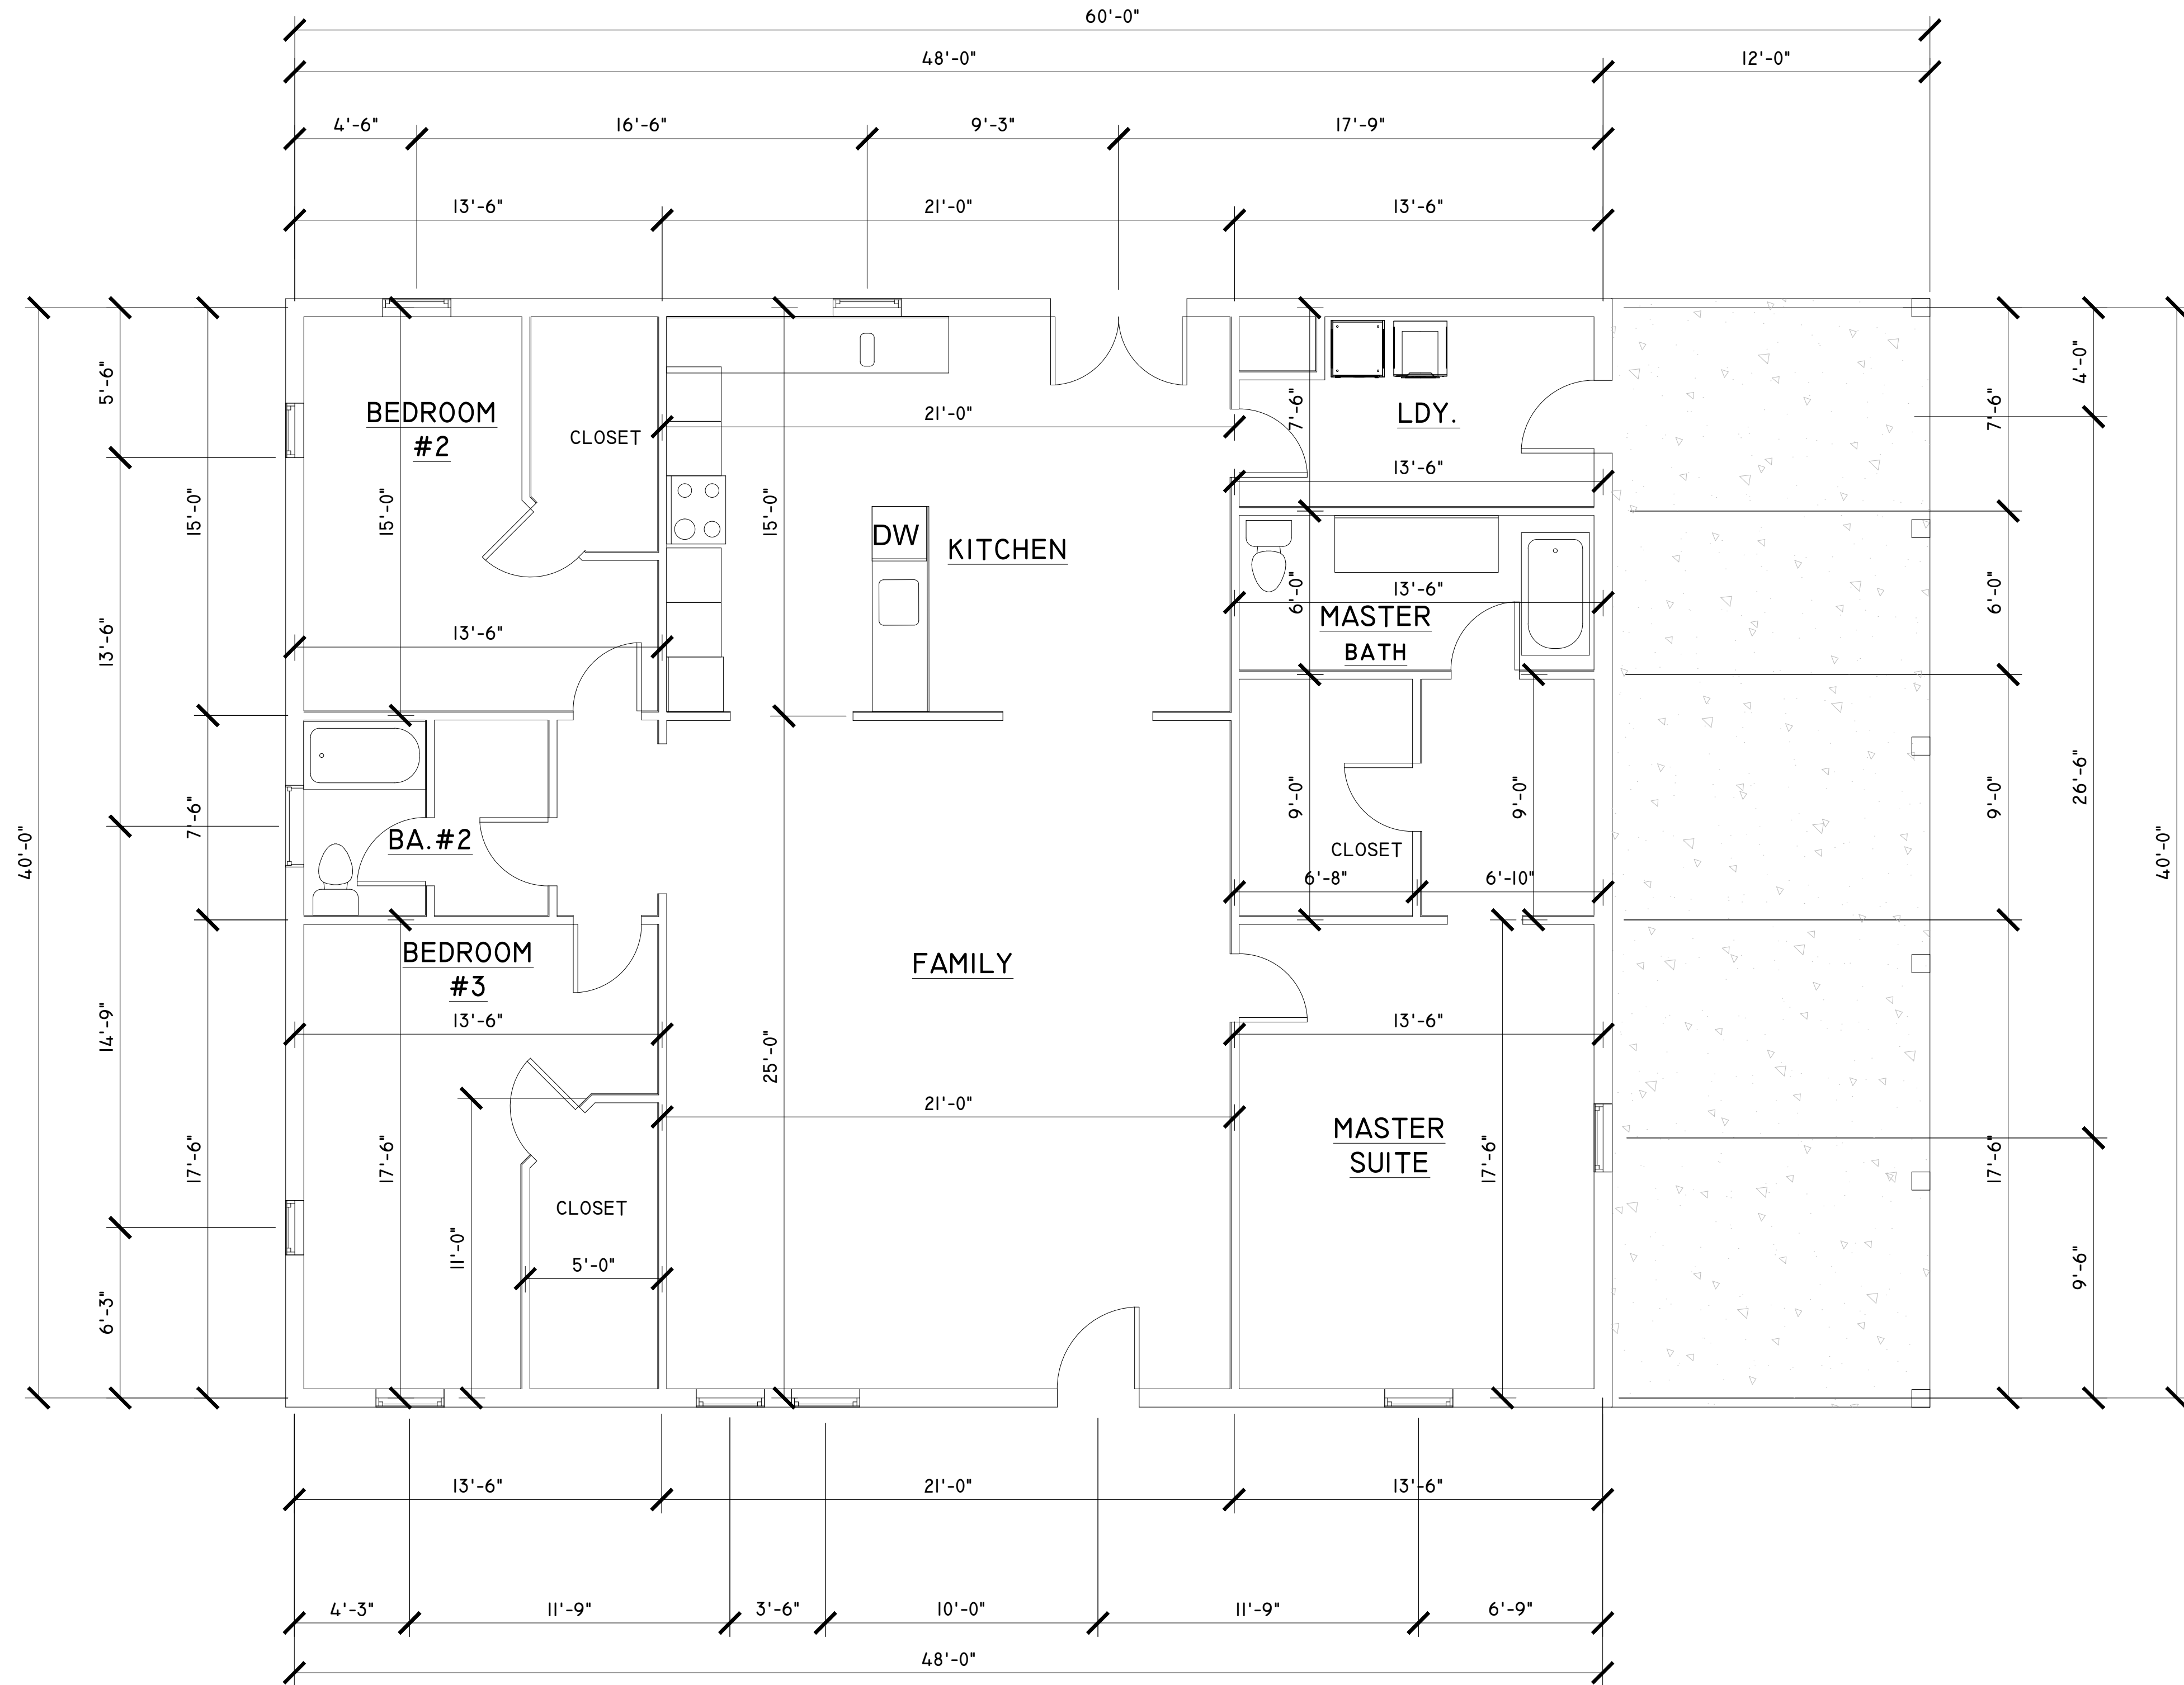

FLOOR PLAN


SCALE: 1/4" = 1'-0"

FOOTAGE	
AREA	SQ. FT.
LIVING	1,920
TOTAL	1,920



This has been electronically signed and sealed by TOMAS BRENT WHITMAN, P.E. using a Digital Signature and date. Printed copies of this document are not considered signed and sealed and the signature must be verified on any electronic copies.

Tomas B
Whitman
2024.07.17
11:54:09 -04'00'

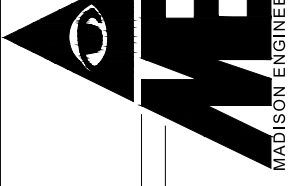

MADISON ENGINEERING, LLC
CONSULTING CIVIL & ENVIRONMENTAL ENGINEERING

268 NE Ridge Loop
Madison, Florida 32340
Phone 850.973.7884
COA No. 27216 www.madisonengineer.com

1157 SW PAUL PEARCE LANE, LAKE CITY, FL 32024

FIRST FLOOR PLAN

COLUMBIA COUNTY


© COPYRIGHT 2024 ME

THIS DOCUMENT IS THE PROPERTY OF MADISON ENGINEERING, LLC. IT IS TO BE USED ONLY FOR THE PROJECT AND DATE SPECIFIED HEREON. ANY OTHER USE IS PROHIBITED.

BRENT WHITMAN, P.E.
FL. P.E. REG. NO. 63178

SHEET NO.

DESIGNED	TEW
DRAWN	CTR
CHECKED	TEW
APPROVED	TEW
JOB NO.	25124101
DATE	APRIL 2024

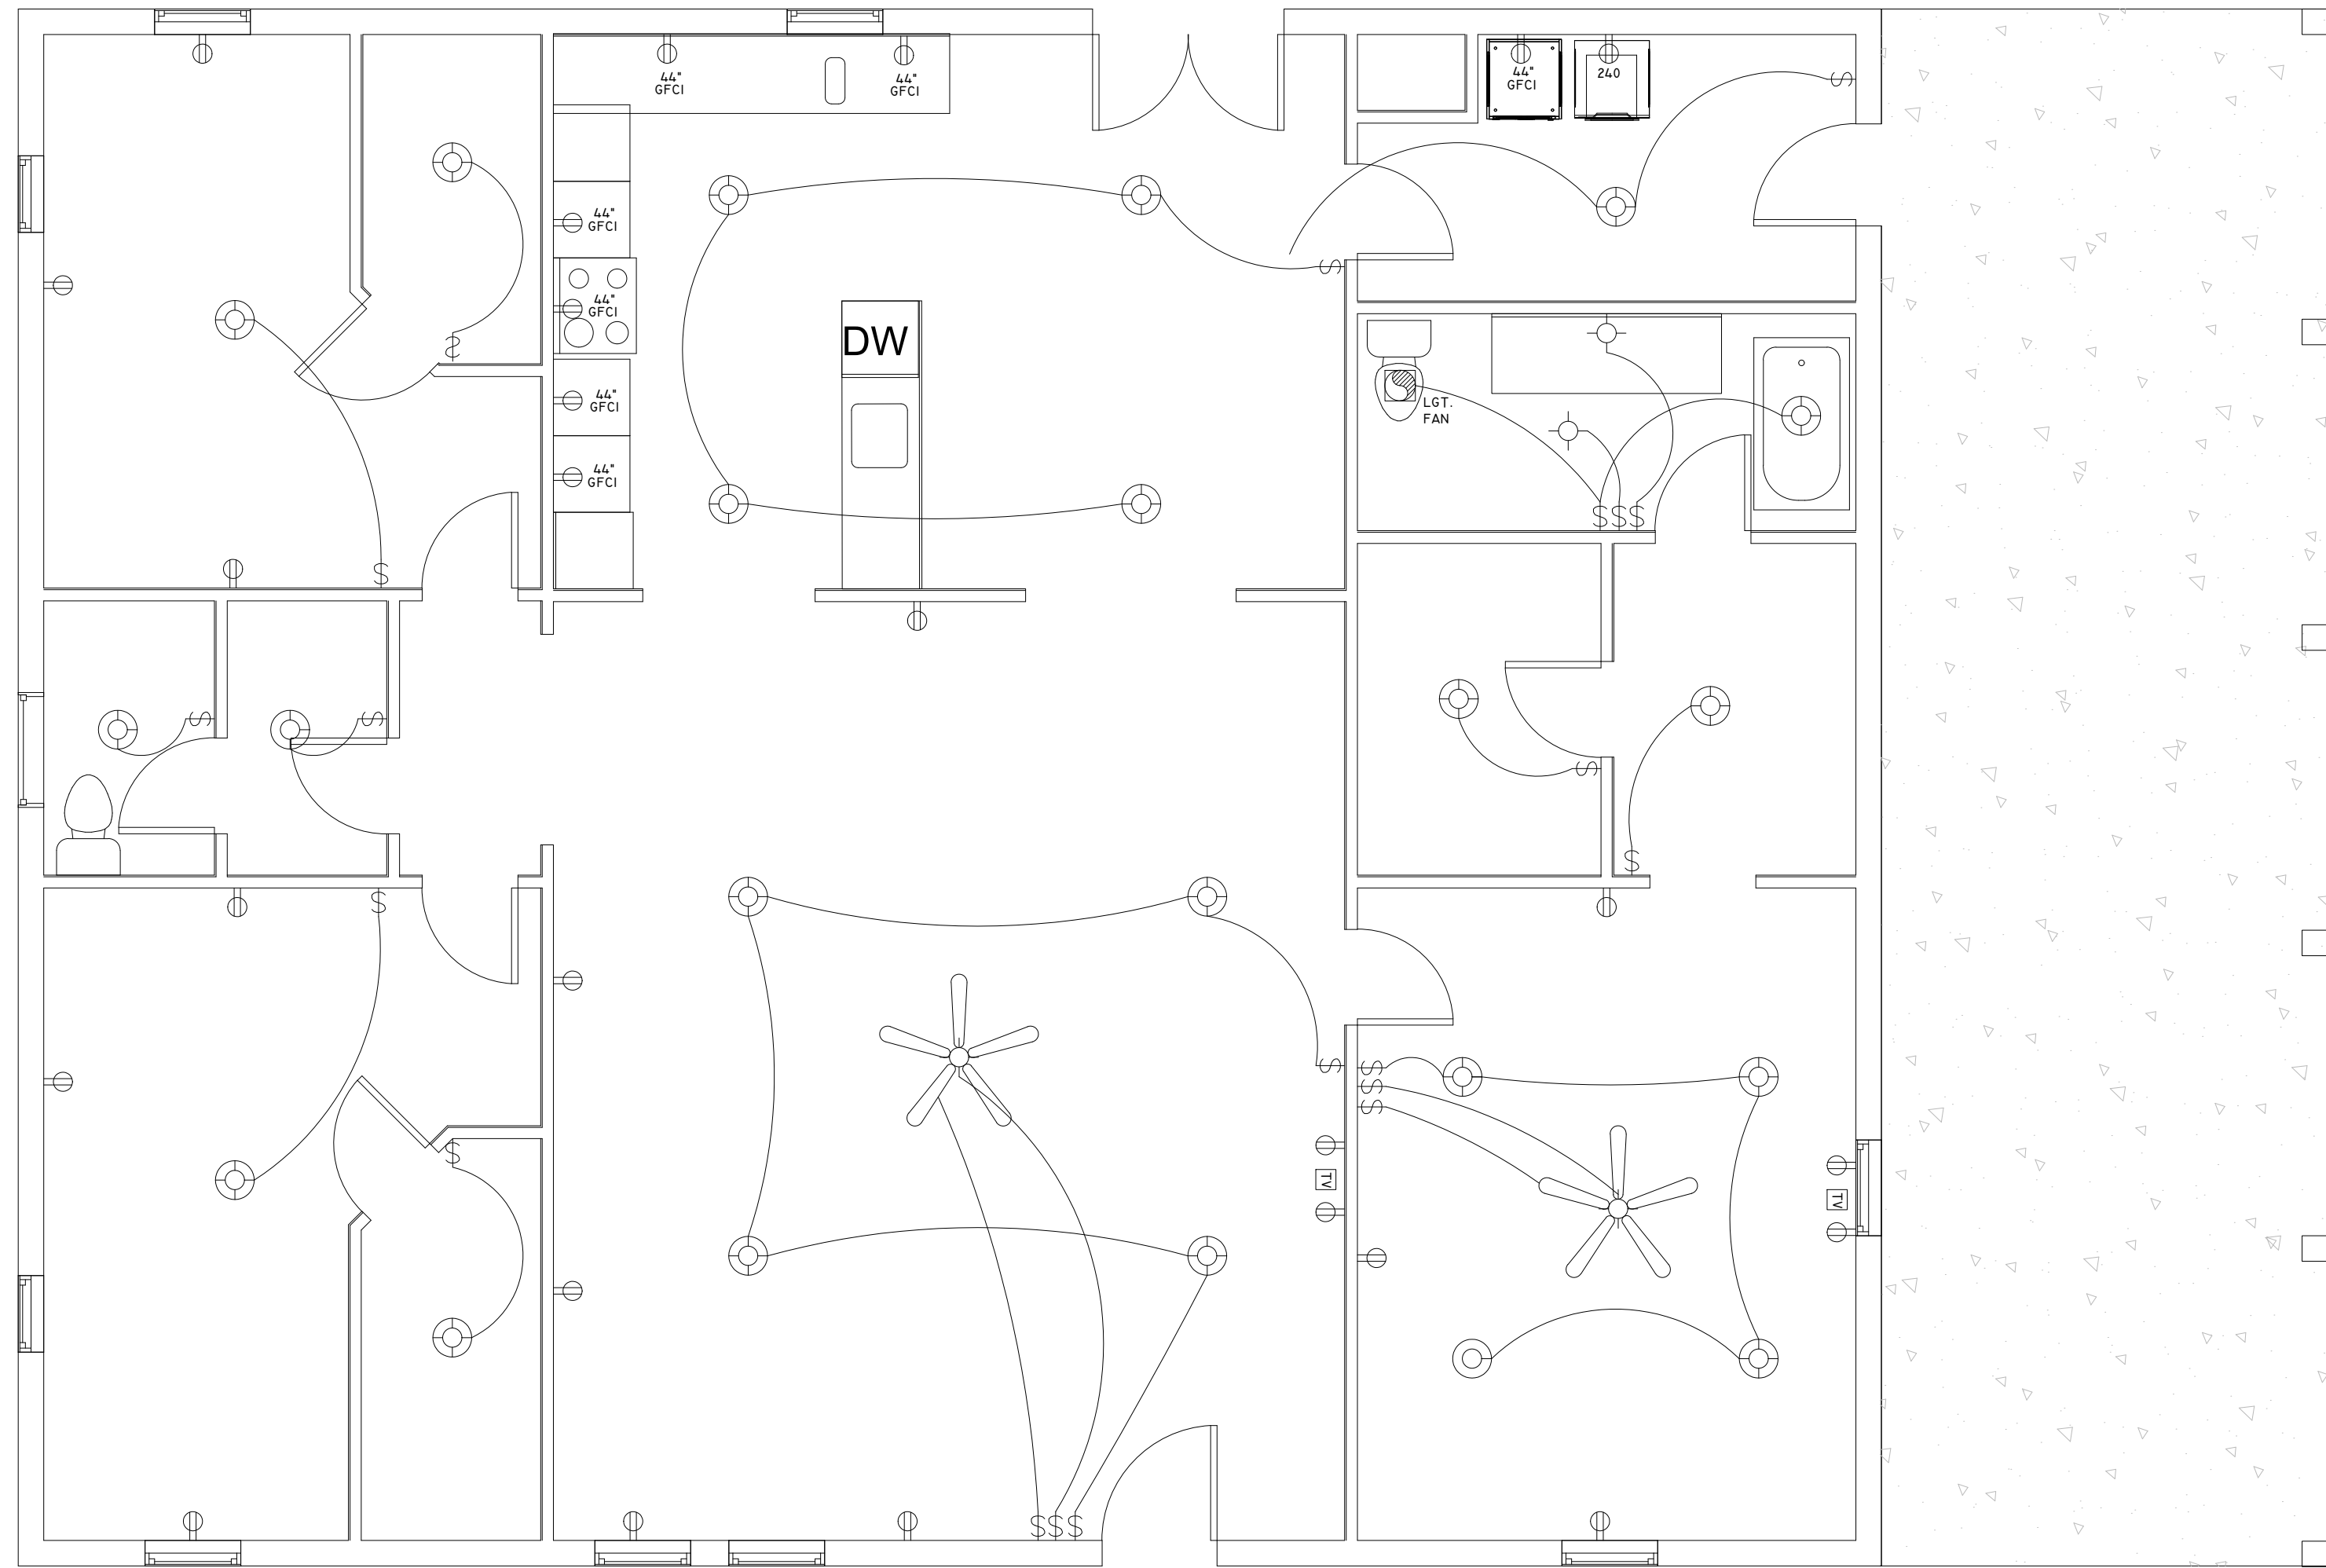

ELECTRICAL PLAN

SCALE: 1/4" = 1'-0"



This has been electronically signed and sealed by TCMAS BRENT WHITMAN, PE using a Digital Signature and date. Printed copies of this document are not considered signed and sealed and the signature must be verified on any electronic copies.

Tomas B Whitman
2024.07.17
11:54:37 -04'00'

1157 SW PAUL PEARCE LANE, LAKE CITY, FL 32024

ELECTRICAL PLAN

COLUMBIA COUNTY

© COPYRIGHT 2024 ME


VALID ONLY WITH EXISTING ORIGINAL, SCALE AND DIMENSIONS

BRENT WHITMAN, P.E.
FL, P.E. REG. NO. 63178

SHEET NO.


3

MADISON ENGINEERING, LLC
CONSULTING CIVIL & ENVIRONMENTAL ENGINEERING

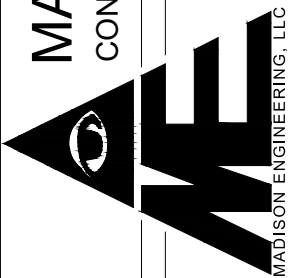

268 NE Ridge Loop
Madison, Florida 32340
Phone: 850.973.7884
COA No.: 27216 www.madisonengineer.com


DESIGNED: TEW
DRAWN: CTR
CHECKED: TEW
APPROVED: TEW
JOB NO.: 25124101
DATE: APRIL 2024

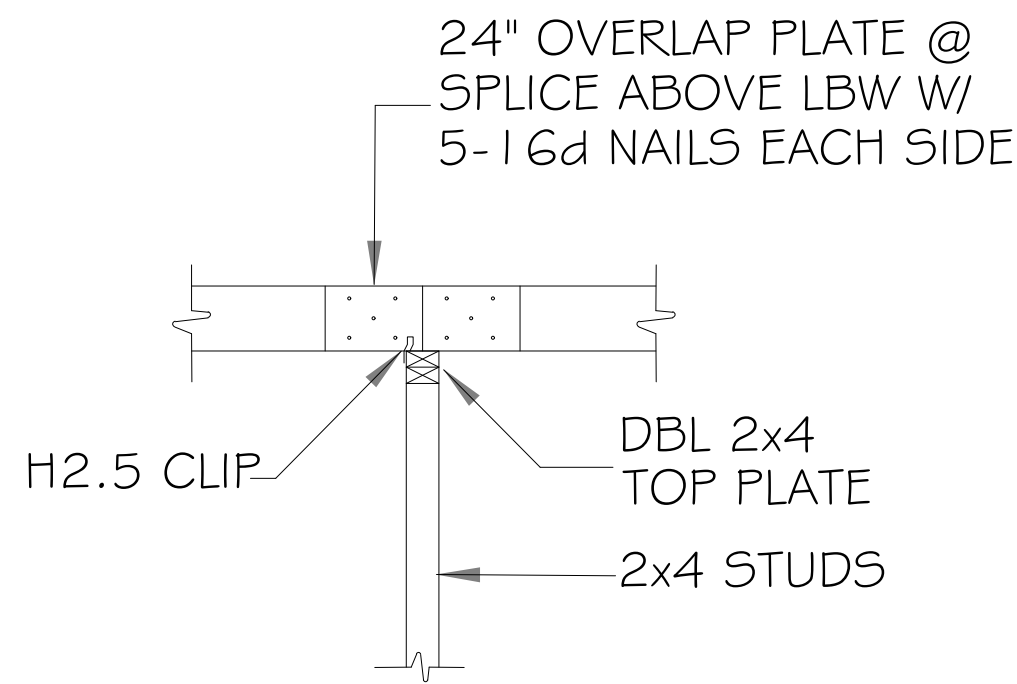

RAFTER OVERLAP DETAIL

SCALE: 1/2" = 1'-0"

NOTE: ROOF FRAMING SHOWN
ROTATED 90 DEGREES FOR CLARITY

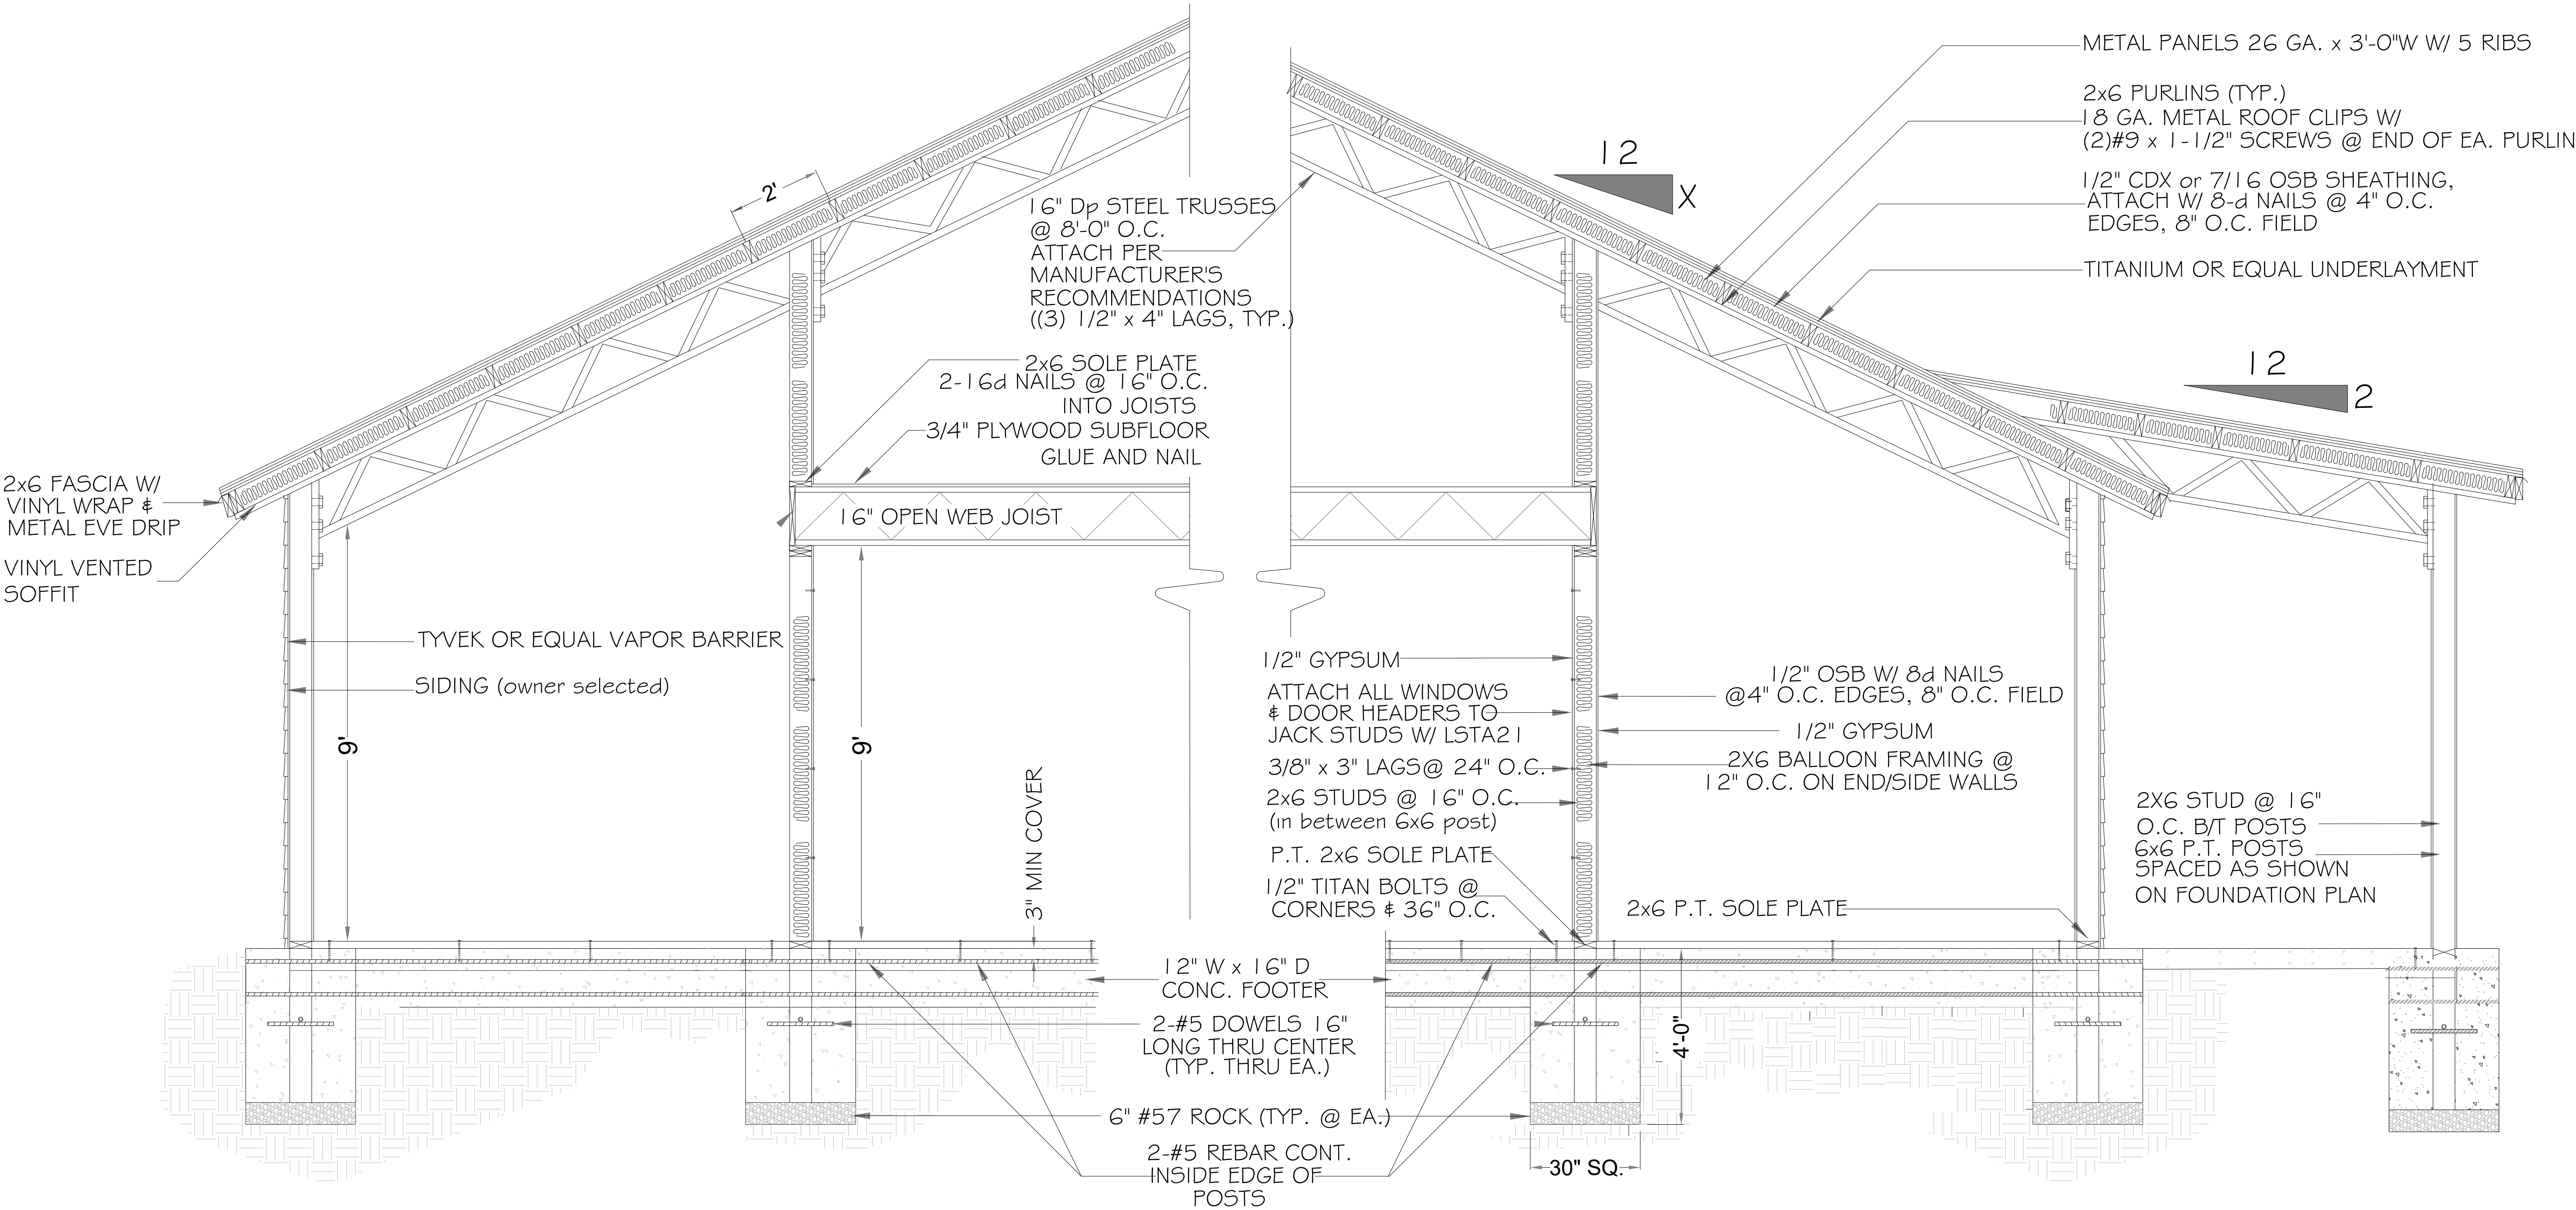



TYPICAL SECTION VIEW A-A'

SCALE: 1/2" = 1'-0"



This has been electronically signed and sealed by TOMAS BRENT WHITMAN, PE using a Digital Signature and date. Printed copies of this document are not considered signed and sealed and the signature must be verified on any electronic copies.

Tomas B
Whitman
2024.07.17
11:55:19 -04'00'

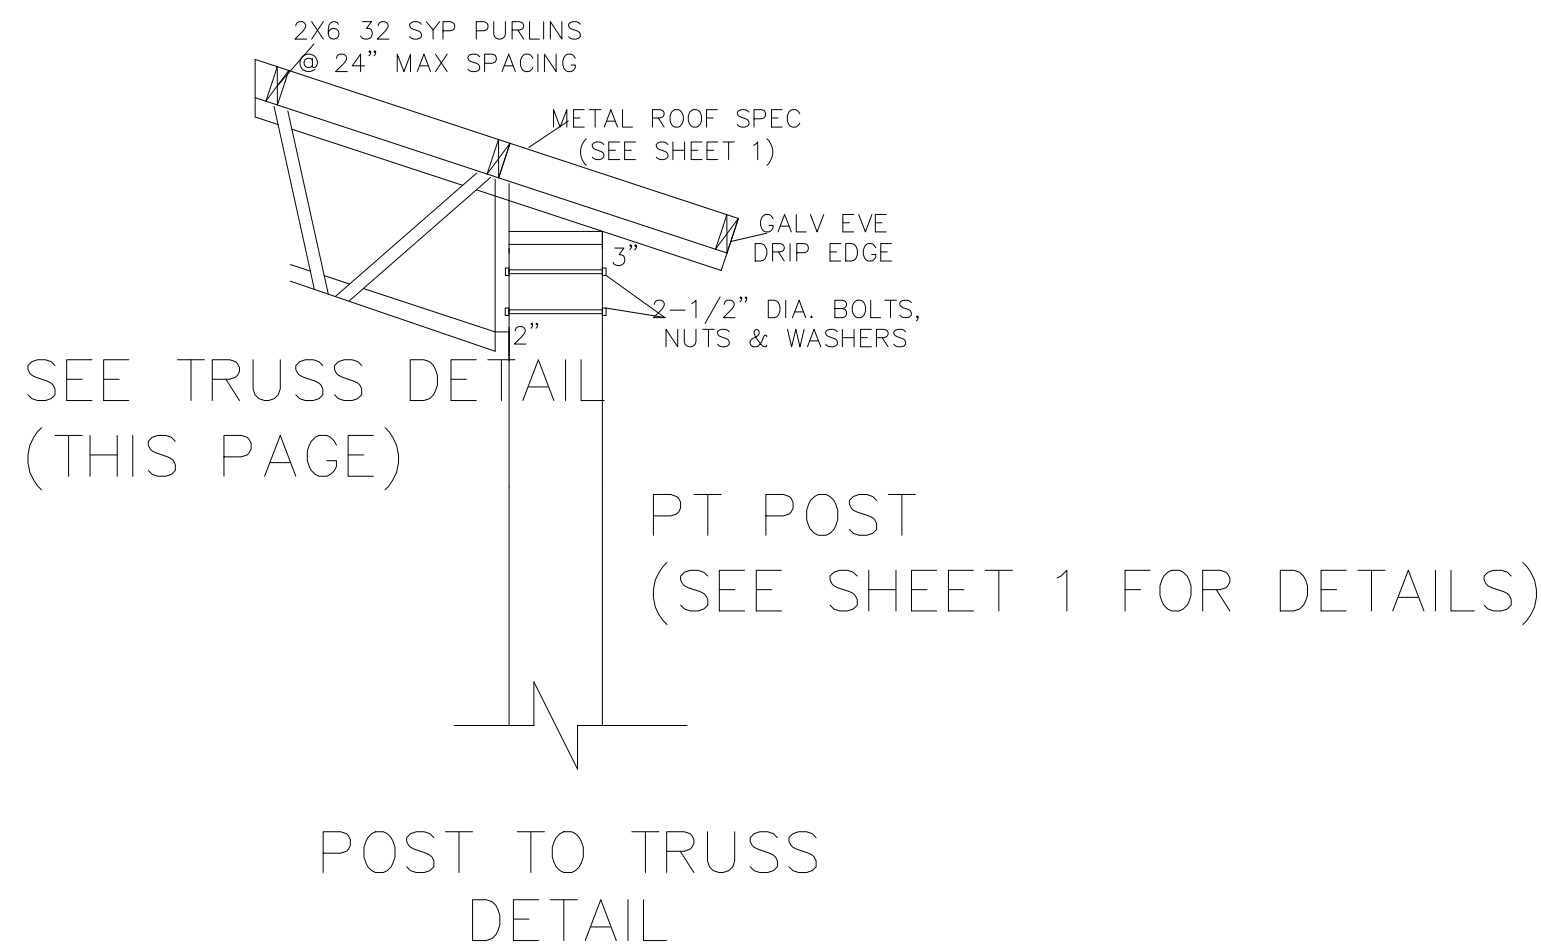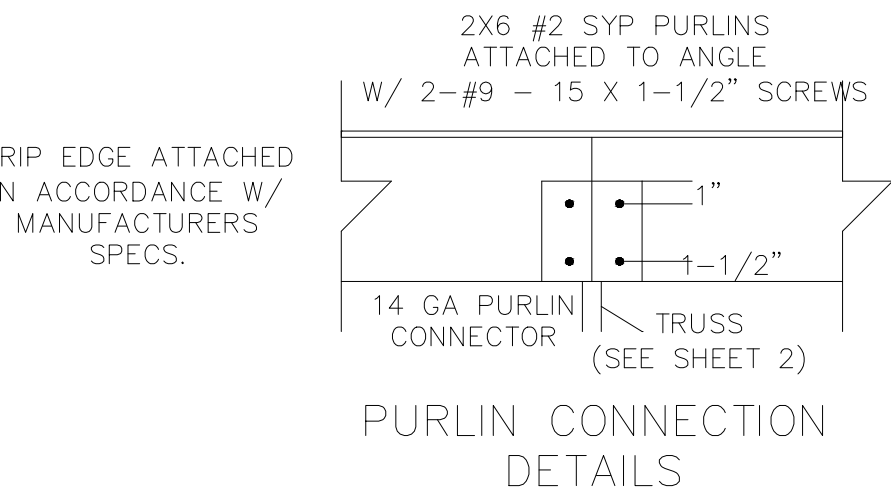


NOTES: TRUSS CROSS-SECTION

- 1- MATERIALS SHALL CONFORM TO STEEL ASTM 572.
- 2- ALL STEEL SHALL BE 50ksi IN ACCORD WITH CURRENT AISC MANUAL.
- 3- WELDING ELECTRODES SHALL BE TYPE E70XX
- 4- ALL WELDING SHALL BE IN ACCORD WITH CURRENT AWS REQUIREMENTS
- 5- ALL WELDING SHALL BE DONE BY A CERTIFIED WELDER.
- 6- BOL TS SHALL BE ASTM A325. w/ NUTS & WASHERS. TYP)
- 7- WELD STRENGTH 70 KSI MIN:
- 8- ALL POST SHALL BE #2 DENSE PRESSURE TREATED GROUND CONTACT.
- 9- PRIMING & PAINTING SHALL BE DONE BY TRUSS MANUFACTURER.
- 10- MIN EDGE DISTANCE FOR BOLTS HOLES SHALL BE 3/4" MIN
- 11- MAX TRUSS SPACING SHALL NOT EXCEED 12'-0" UNO.
- 12- THE DESIGNER DISCLAMS ANY RESPONSIBILITY FOR DAMAGES AS A RESULT OF POOR WORKMANSHIP, OR IMPROPER USE, AND ACCEPTS NO RESPONSIBIL TY OR EXERCISES NO CONTROL WITH REGARD TO FABRICATION, HANDLING, AND INSTALLATION OF TRUSSES.

BILL OF MATERIALS

ITEM NO.	DESCRIPTION	MATERIAL (50 KSI)
A1	TOP CHORD	LL 2 X 2 X 3/16*
A2	BOTTOM CHORD	LL 2 X 2 X 3/16*
A3	VERTICAL CHORD	LL 3 X 2 X 3/8*
A4	VERTICAL CHORD	L 1 1/2 X 1 1/2 X 3/16
A5	TIE	L 2 X 2 X 3/16
A6	TIE	L 3 X 2 X 3/16
W1	WEB	L 1-1/4 X 1-1/2 X 3/16
W2	WEB	L 1-1/4 X 1-1/2 X 3/16
B1	BASE	LL 2 X 2 X 3/16*

NOTE: LL * DENOTES DOUBLE ANGELS

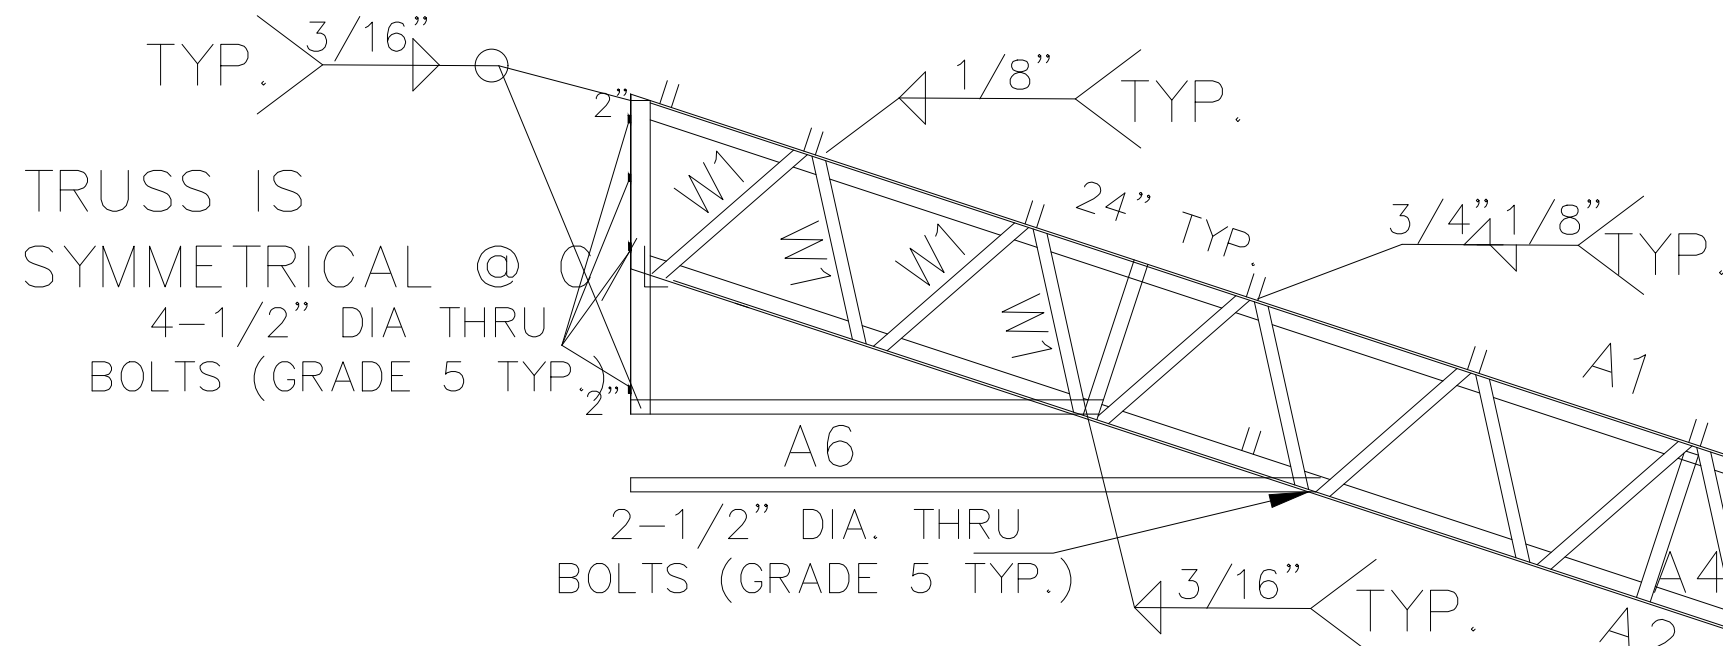

14 GA.
PURLIN CLIP
(TYP.)

LATERAL BRACE CLIPS
(6 LOCATIONS MIN.)




This has been electronically
signed and seal by TOMAS
BRENT WHITMAN, PE using
a Digital Signature and date.
Printed copies of this
document are not considered
signed and sealed and the
signature must be verified on
any electronic copies.


Tomas B
Whitman
2024.07.17
11:55:46 -04'00'

NOTES:

1. PURLINS SHALL BE 2X6 #2 SYP (MAX SPACE @2'-0" O.C.)
2. CONTRACTOR IS RESPONSIBLE FOR TEMPORARY & PERMANENT CONSTRUCTION BRACING.
3. ALL DEMINSIONS SHALL BE VERIFIED PRIOR TO FABRICATION.
4. ALL WELD PER AWS STANDARDS.
5. ALL STEEL AND FABRICATION PER ASCI STANDARDS.
7. ITEM DEMINSIONS ARE TO BE MODIFIED FOR SHORTER TRUSS LENGTHS.
8. ALL FASTNERS SHALL BE INSTALLED PER MANUFACTURES SPECIFICATIONS.
9. TRUSS DESIGN CAN BE USED FOR TRUSS LENGTHS SHORTER THAN 50 FEET.
10. WELDING ELECTRODES SHALL BE E70XX
11. ALL WELDS SHALL BE IN ACCORDANCE WITH AWS REQUIRMENTS.
12. ALL POST SHALL BE #2 DENSE PRESSURE TREATED.

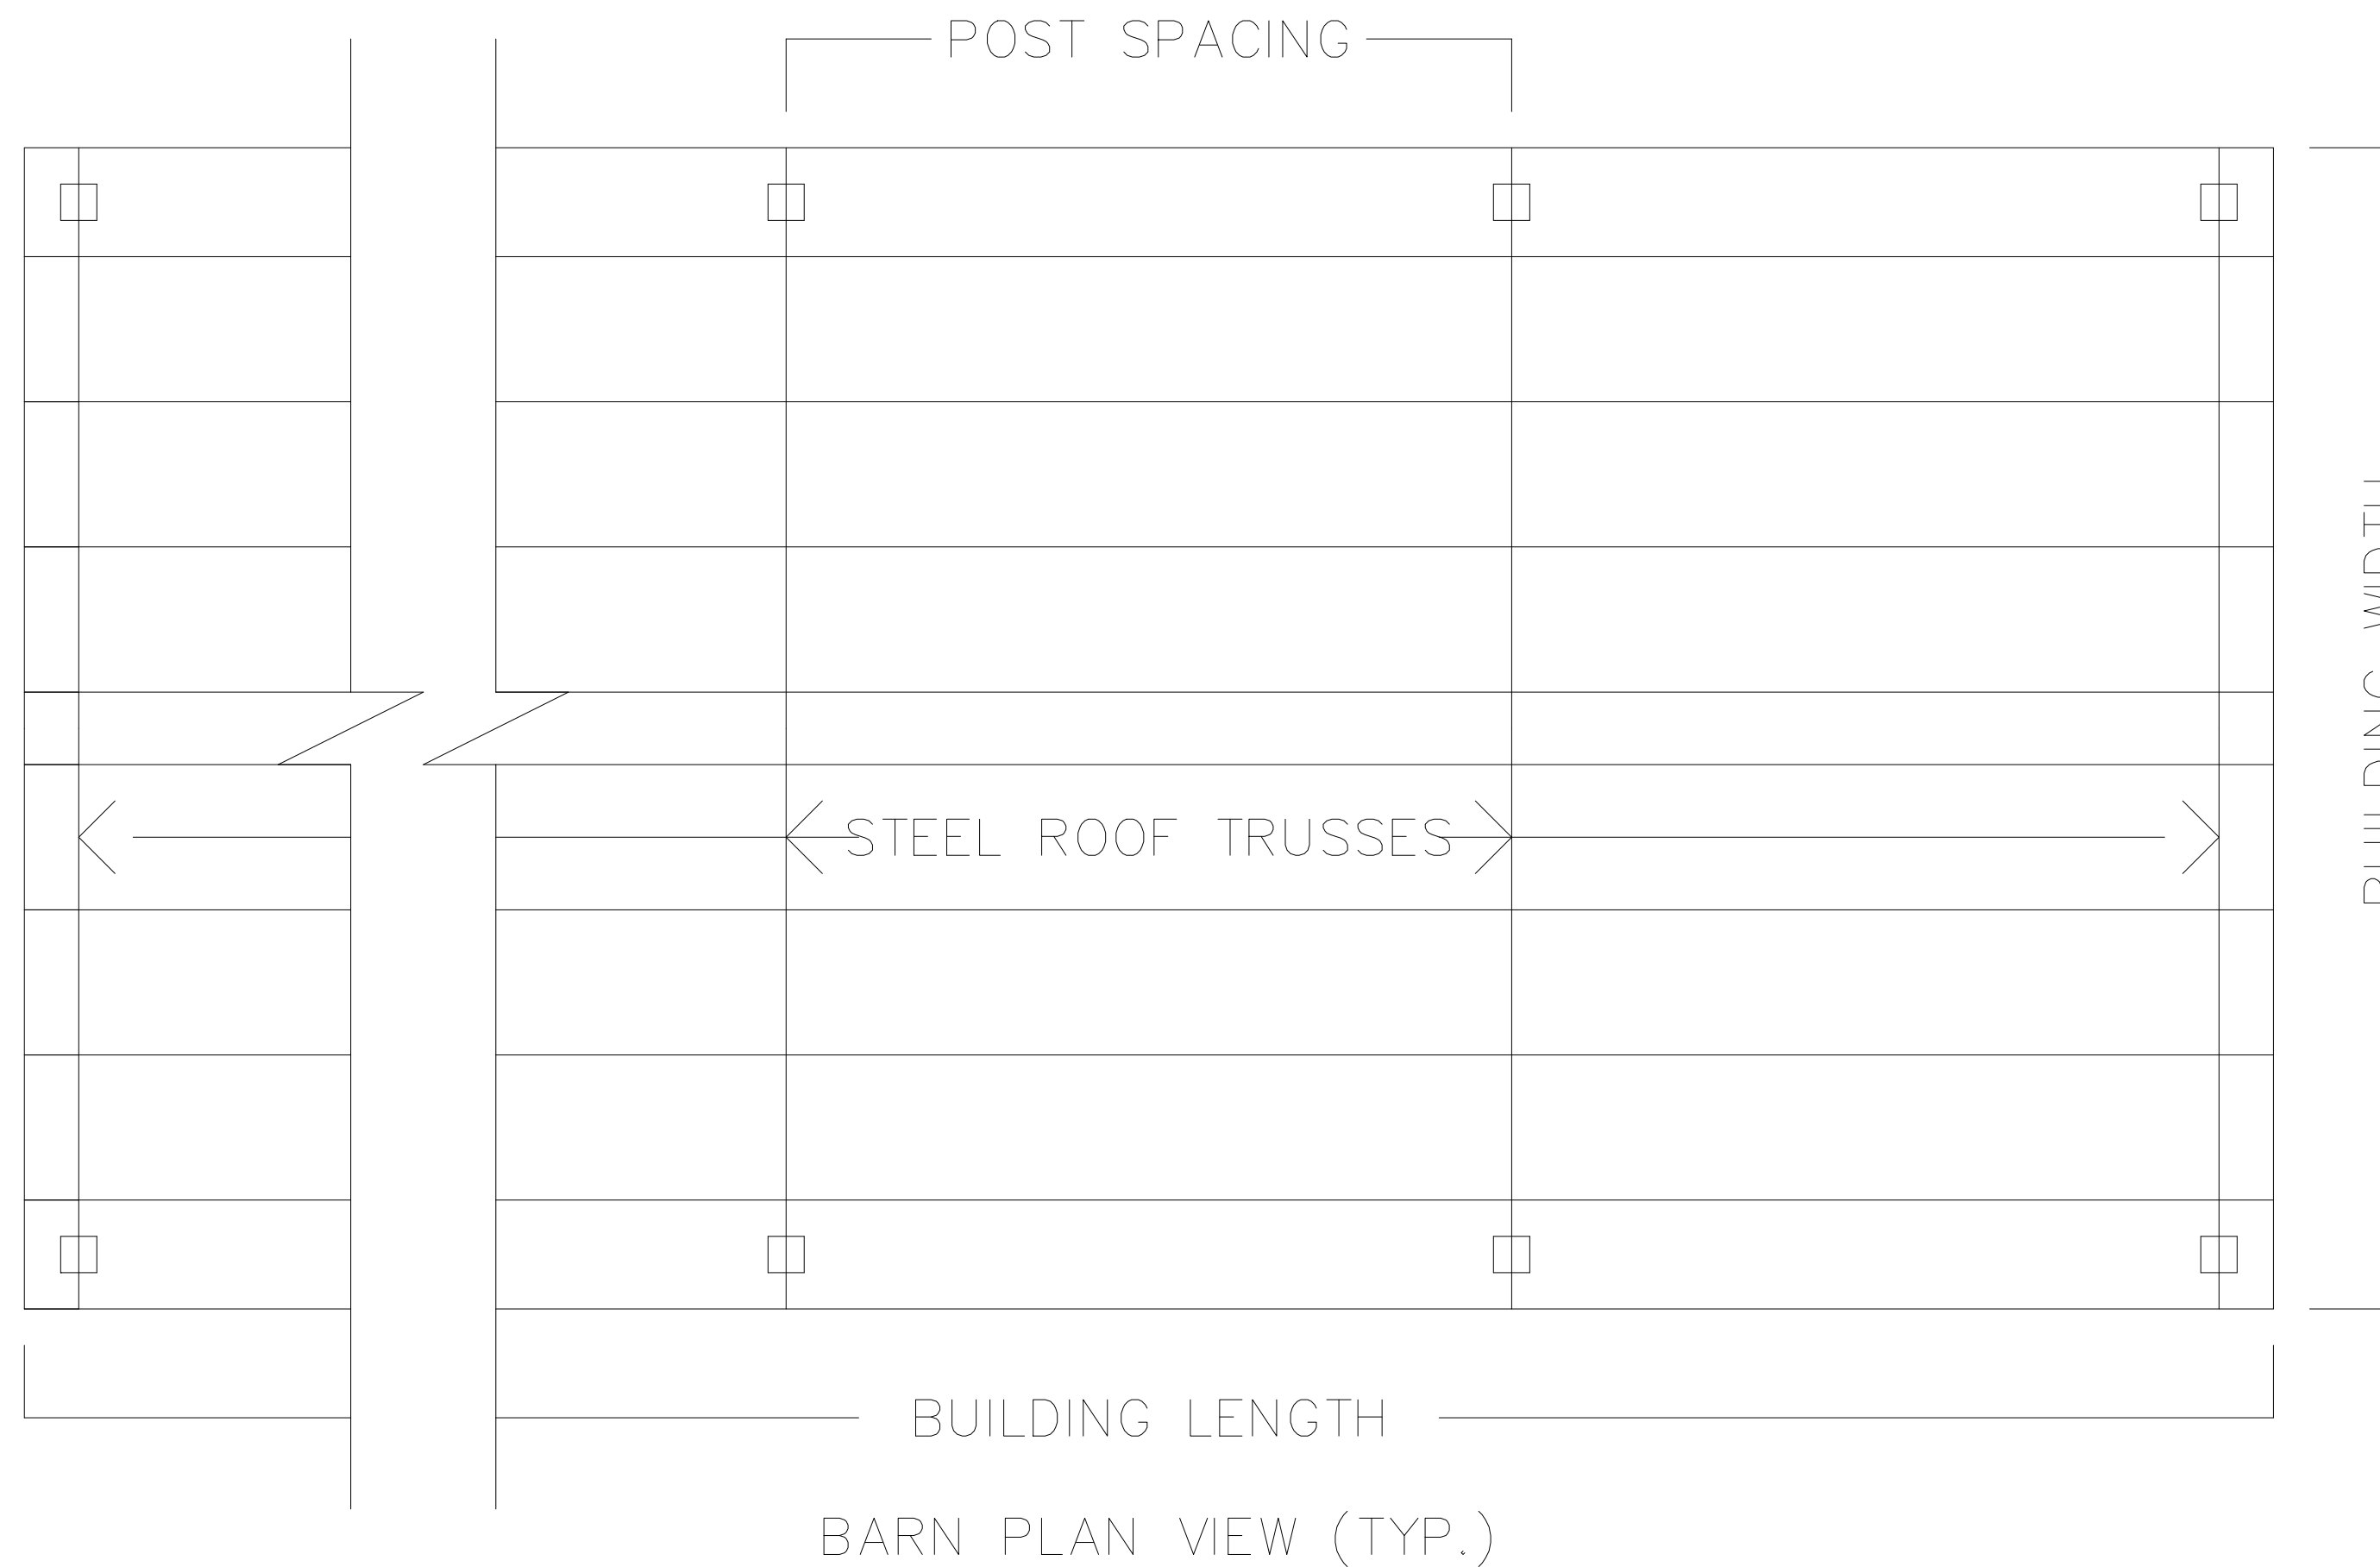

MADISON ENGINEERING, LLC
CONSULTING CIVIL & ENVIRONMENTAL ENGINEERING

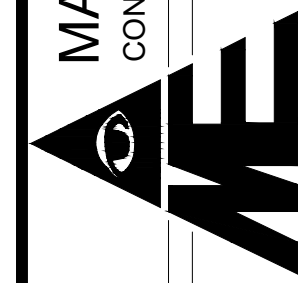

268 NE Ridge Loop
Madison, Florida 32340
Phone: 650.973.7884

COA No.: 27216 www.madisonengineer.com

1157 SW PAUL PEARCE LANE, LAKE CITY, FL 32024

TRUSS

COLUMBIA COUNTY

© COPYRIGHT 2024 ME

VALID ONLY WITH DATED
ORIGINAL SIGNATURE AND
EMPOWERED SEAL

TOMAS BRENT WHITMAN, P.E.
FL. P.E. REG. NO. 63178

SHEET NO.

5