



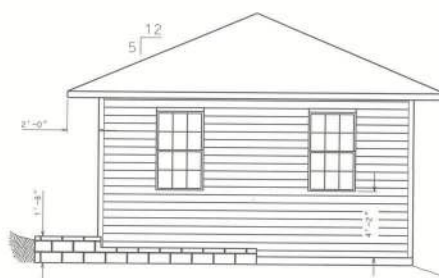

FRONT ELEVATION

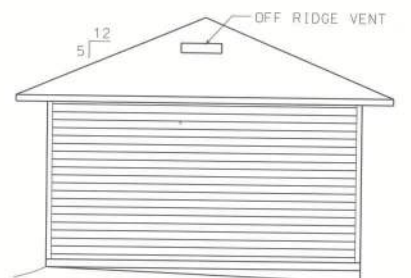

REAR ELEVATION




LEFT ELEVATION




RIGHT ELEVATION


- LIGHT FIXTURE
- 3 — THREE-WAY SWITCH
- 100A ELECTRICAL BREAKER BOX

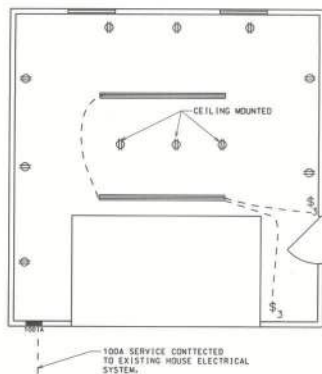


ELECTRICAL PLAN

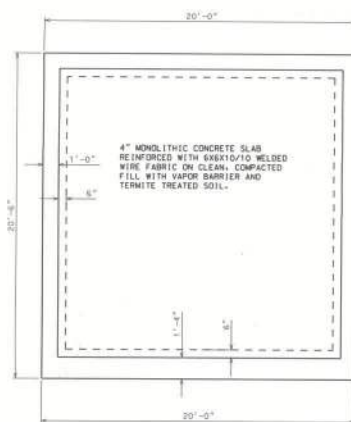

FOUNDATION PLAN

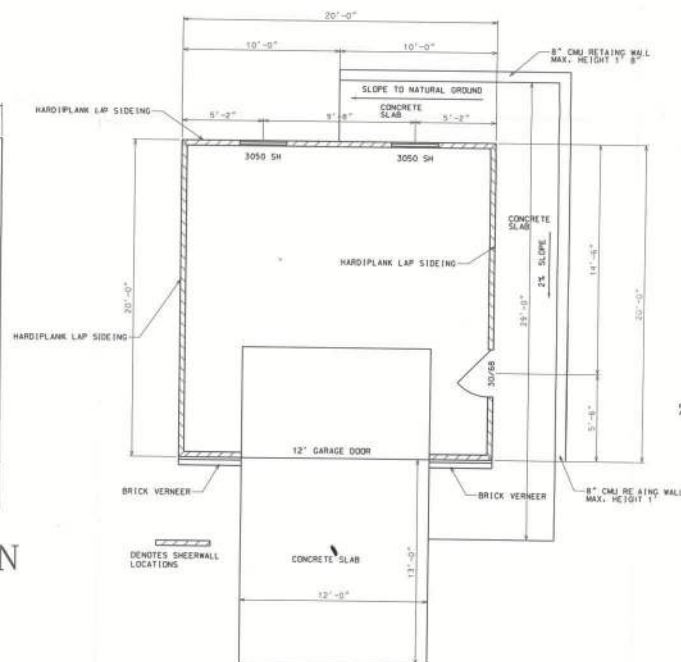

FLOOR PLAN

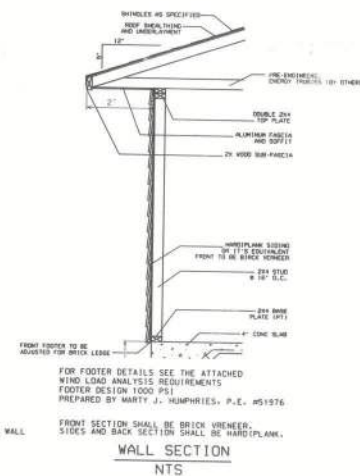

WALL SECTION
NTS

SQUARE FOOTAGE	
STORAGE BUILDING AREA	400 SF
TOTAL	400 SF



THESE DRAWINGS, AS INSTRUMENTS OF SERVICE, ARE THE SOLE PROPERTY OF HAYGOOD HOMES, INC., AND MAY NOT BE USED, COPIED OR REPRODUCED IN WHOLE OR IN PART FOR USE ON OR INCORPORATED WITHIN ANY OTHER JOB WITHOUT SPECIFIC AND INDIVIDUAL AUTHORIZATION BY HAYGOOD HOMES, INC.



HAYGOOD HOMES INC.

12592 So. U.S. HWY 441
LAKE CITY FL 32025
(386) 303-1981
CGC-1518157

IRA BELL
476 SW SWEETBREEZE DR.
LAKE CITY FLORIDA 32024

STORAGE BUILDING
PLANS

PLAN No.	SCALE	DATE	SHEET No.
P 1201	1/4" = 1'	09/20/12	1