

12523 U.S. Highway 441 - Alachua, FL 32615 Phone: (904) 462-5323/FAX: (904) 462-1509

Client Name: SWAYZE Model: GULF

BANK: COUNTRYWIDE LOAN TYPE: () Cash
(X) Conventional
() F.H.A.
() V.A.

CABINET COLOR SELECTIONS:

Kitchen:		Toilets	Color
Countertop	3525-58 AZULGRANITE MATTE	Master	WHITE
Cabinet Base	PARKWOOD NAT	Hall	WHITE
Master Bath:		Other	
Countertop	G-930 WHITE UNDERMOUNT BOWL		
Cabinet Base	PARKWOOD NAT		
Bath:			
Countertop	G-930 WHITE UNDERMOUNT BOWL		
Cabinet Base	PARKWOOD NAT		

NOTES: PLUMBER 50 GALLON HOT WATER HT
GARAGE DOOR OPENER
FLAT TOP RANGE VENT ALUM TO EXT
600 SQ FT CONCRETE, ALUM SC RM

BATHROOM TILE SELECTION:

Master Bath:		Color	Style	Pump
Shower CB02 8 X 10 BISCONTI				
Shower Floor 2 X 2 OR 4 X 4 MATCH	Master	WHITE		
Grout #05 CHAMOIS	Hall			
Hall Bath:				
Tub Surround WHITE	Bath 3			
Title Selection CB02 8 X 10 BISCONTI	Tub Surround			
Grout #5 CHAMOIS	Title Selection			
	Title Selection			

VAULTS:

DINING, LIVING, KITCHEN

CARPET	VINYL/TILE
BEDROOM #2 AND #3 585 REAL INDIGO	TILE LAUNDRY, DINING, KITCHEN,
LIVING ROOM AND MASTER BED	FOYER, BATHROOMS AS PER PLAN
#878 RUFFLE SHOP	18 X 18 RD05 RUST
	GROUT #37 TERA COTTA MAPEI

PAINT SELECTIONS:

Interior Wall Color STANDARD ☐ Wood
Interior Trim STANDARD ☒ Flatcut Marble
☐ Hardiplank Siding Wood Siding

RANGE SELECTIONS:

Range/Color WHITE FLAT TOP/ DISHWASHER
Hood/Color HOMEOWNER SUPPLYING

EXTERIOR FEATURE SELECTIONS:

Acrocote/Main House A-10 ACRO GREY
 Trim Package DESOTO
 Trim Color A-1 ARTIC RAIN
 Exterior Door Colors WHITE
 Siding _____
 Soffit CHARCOAL
 Shingles RUSTIC BLACK
 Style/Color _____
 Window Color WHITE
Trim Type Colonial w/Classique Doors Std.
Colonial Grills Front Windows Standard




 FRONT


 WINDOW

BATH WINDOWS:

Master	(*)	Obscure	()	Clear	Glass
Hall	()	Obscure	()	Clear	Glass

SUPER Energy Pac: Yes() No (X)

Extras: _____


Power Company: CLAY ELECTRIC () Overhead () Underground

Fireplace _____ Screenroom Color CHARCOAL IF POSSIBLE

We have reviewed this plan and all notes on it. All items we have discussed with House Craft and its representatives are indicated on this "Master Copy". We understand that any additional items that are not on this print can be done for a \$250.00 plan charge for plus the cost of the items.

Purchaser: * _____ Date: *


REV.	DESCRIPTION	DATE

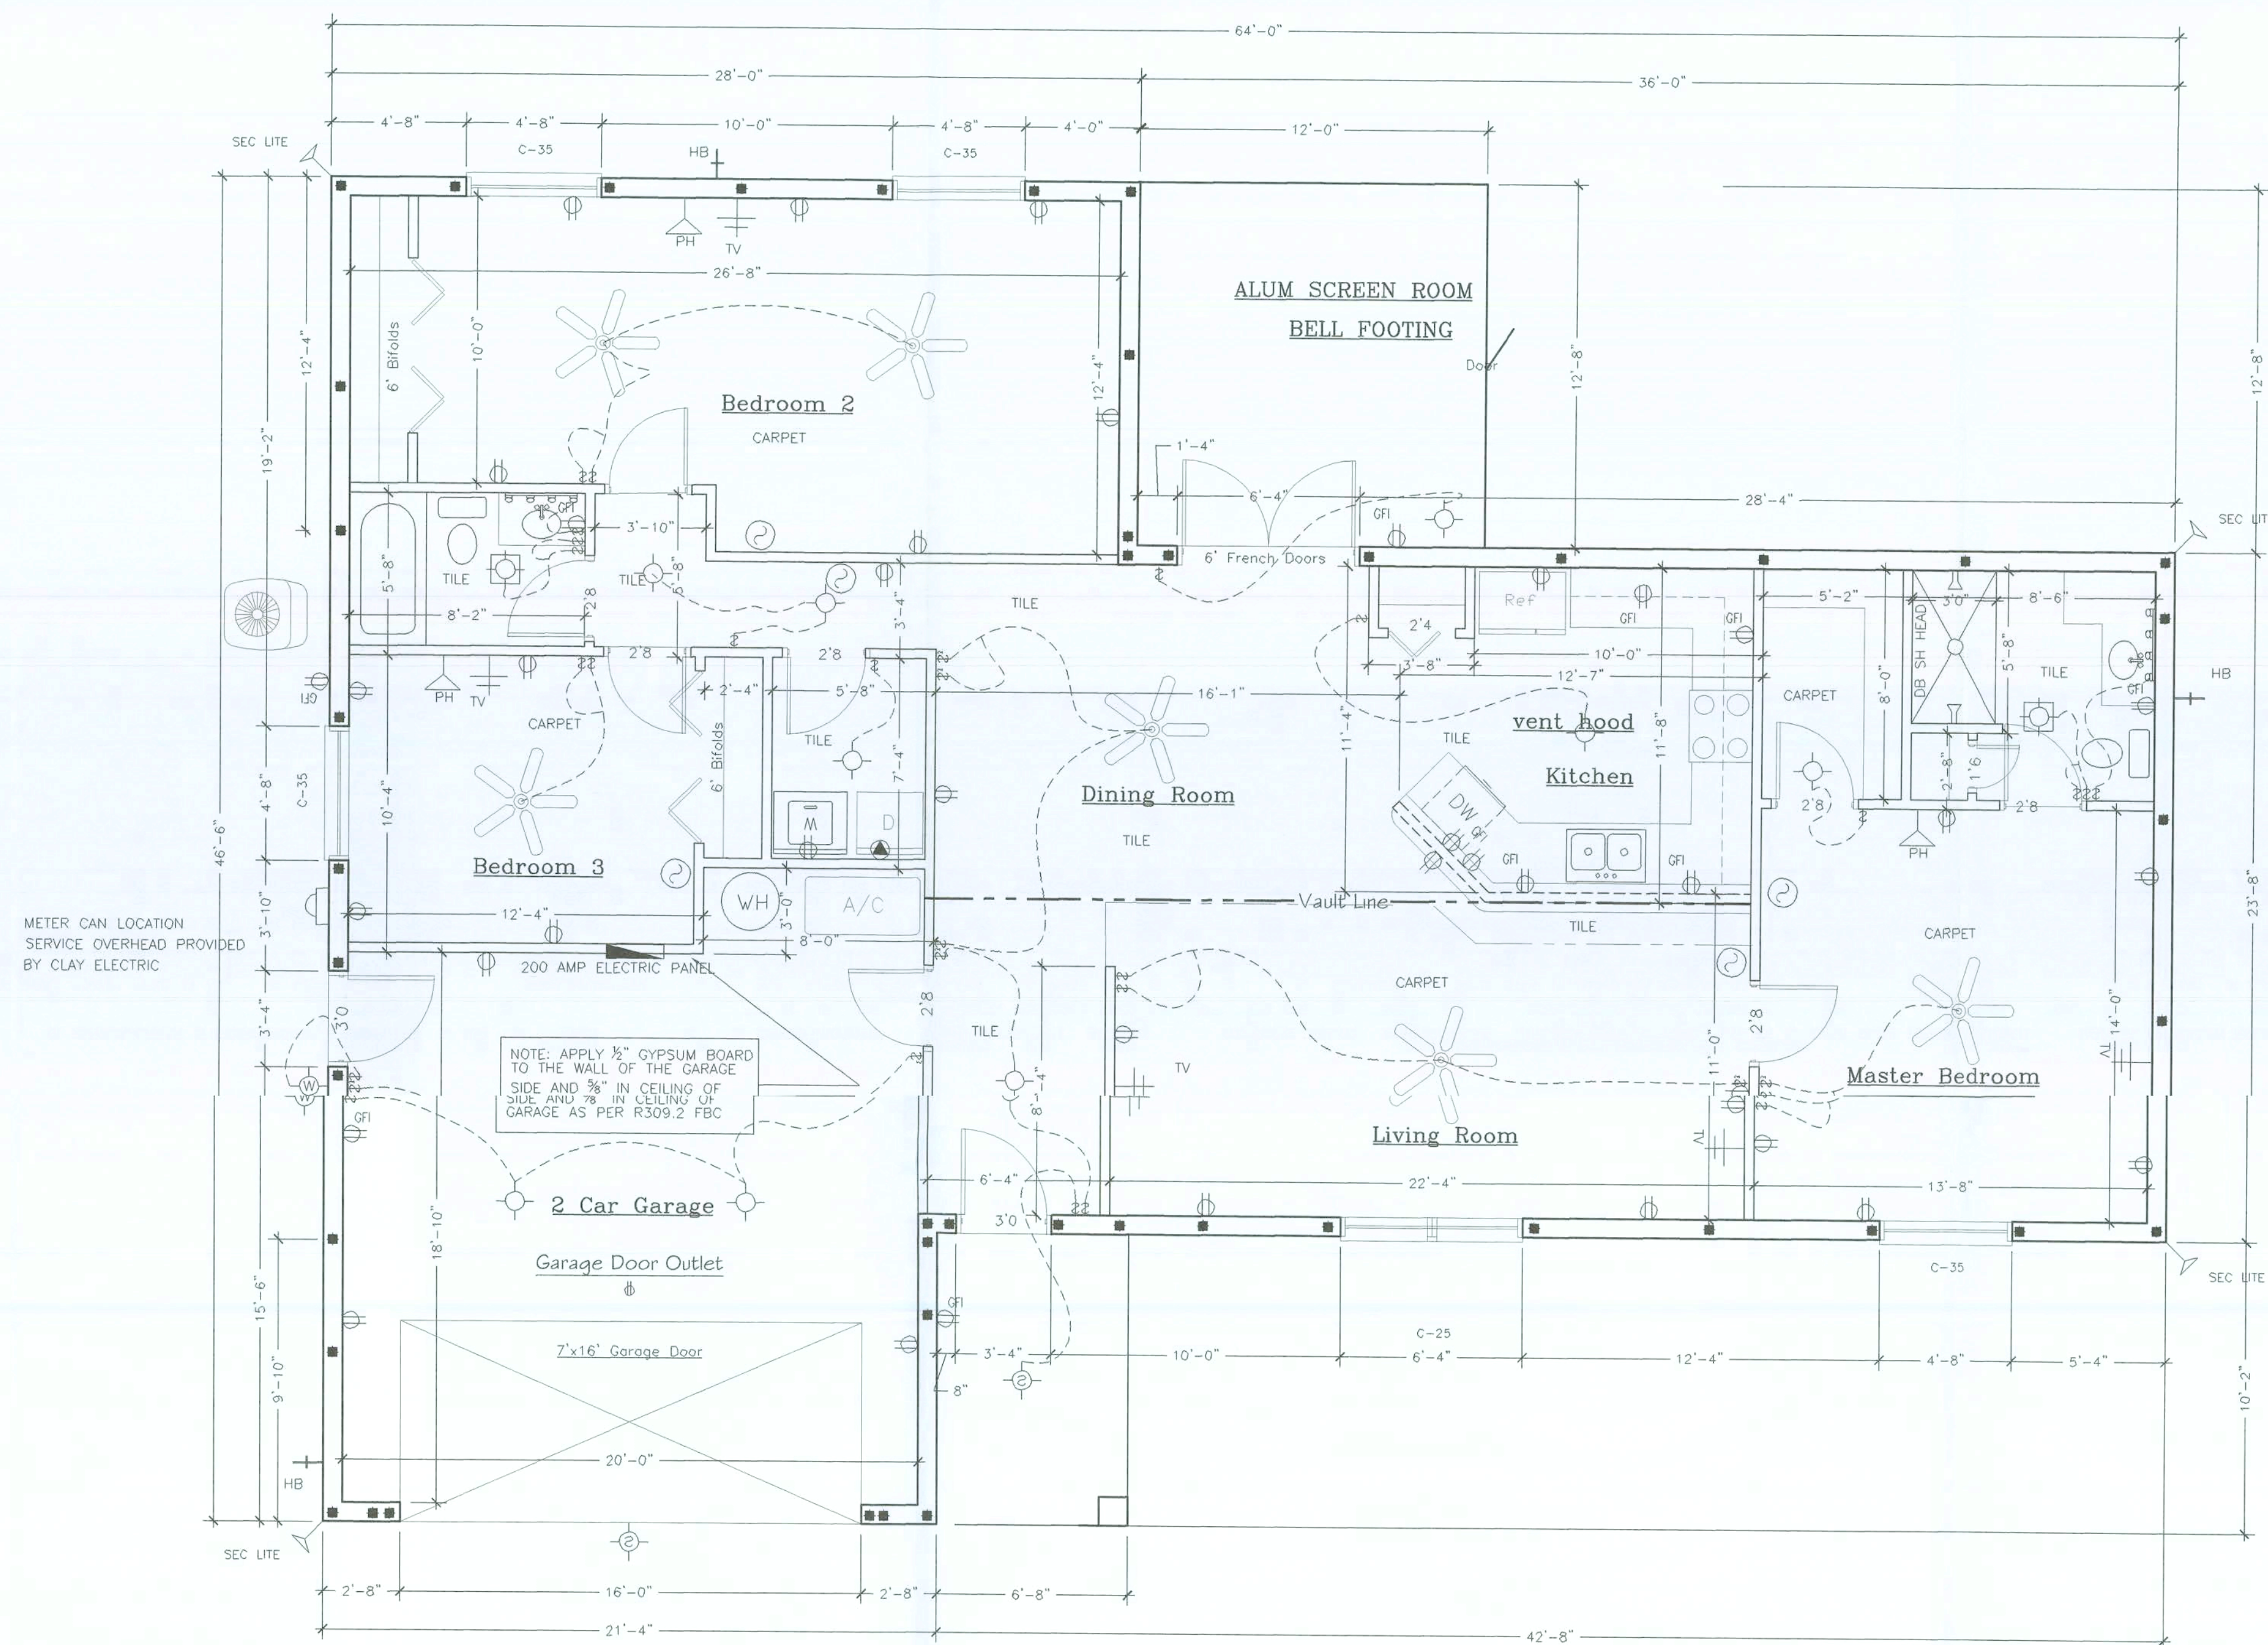

FLOOR PLAN

SCALE: 1/4"=1'-0"

LIGHTING FIXTURE SCHEDULE

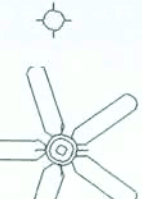FIXTURE	DESCRIPTION
	SURFACE MOUNTED INCANDESCENT FIXTURE PRE-WIRED CEILING FAN
	DOUBLE FLOOD LIGHT FIXTURE
	FAN LIGHT VENTED TO EXTERIOR
	SURFACE MOUNTED INCANDESCENT FIXTURE

TYPICAL SPECIAL CIRCUIT ELECTRIC SCHEDULE

TWO GFI'S CURCUITS IN KITCHEN
ONE OR TWO GFI'S IN BATHS LOOPED TOGETHER
GFI IN GARAGE, FRONT ENTRY, AND REAR PORCH LOOPED TOGETHER
TWO AFI CIRCUITS PROVIDED FOR BEDROOMS

CODE COMPLIANCE.- This building is designed in compliance with the requirements of the Florida Building Code, 2004. Structural members, cladding, fasteners and systems providing for the structural integrity of the building are designed to resist gravity loads prescribed Chapter 16 and wind loads prescribed in Section 16 and wind loads prescribed in Section 1609.6 Simplified Provisions for Low Rise Building

ELECTRICAL LEGEND

	DUPLEX CONVENIENCE RECEPTACLE WITH GROUND (44° DENOTES HEIGHT A.F.F., IF OTHER THAN STD.) (GFI/GFCI DENOTES GROUND FAULT CIRCUIT INTERRUPTER) (WP DENOTES WATER PROOF)
	SINGLE POLE SWITCH AT STANDARD HEIGHT
	THREE WAY SWITCH AT STANDARD HEIGHT
	TELEPHONE OUTLET
	CEILING MOUNTED EXHAUST FAN VENTED TO EXTERIOR
	CABLE TV OUTLET
	ELECTRICAL DISTRIBUTION PANEL
	SMOKE DETECTOR
	THERMOSTAT

Square Footage

Living...	1,676
Garage...	433
Entry...	61
Porch...	000
Total...	2,170




12523 NW U.S. Hwy. 441 - Alachua, FL 32615
Phone: (386) 462-5323/FAX: (386) 462-1509

Job name: SWAYZE

Model:	GULF	Type:	PLAN/ELECT
--------	------	-------	------------


Location:	Drawn By: J.D.H.
Designer: J.D.H.	Revision Date:

Scale: $1/4" = 1'-0"$ Date: 1/25/07 Sheet: 2 of 3

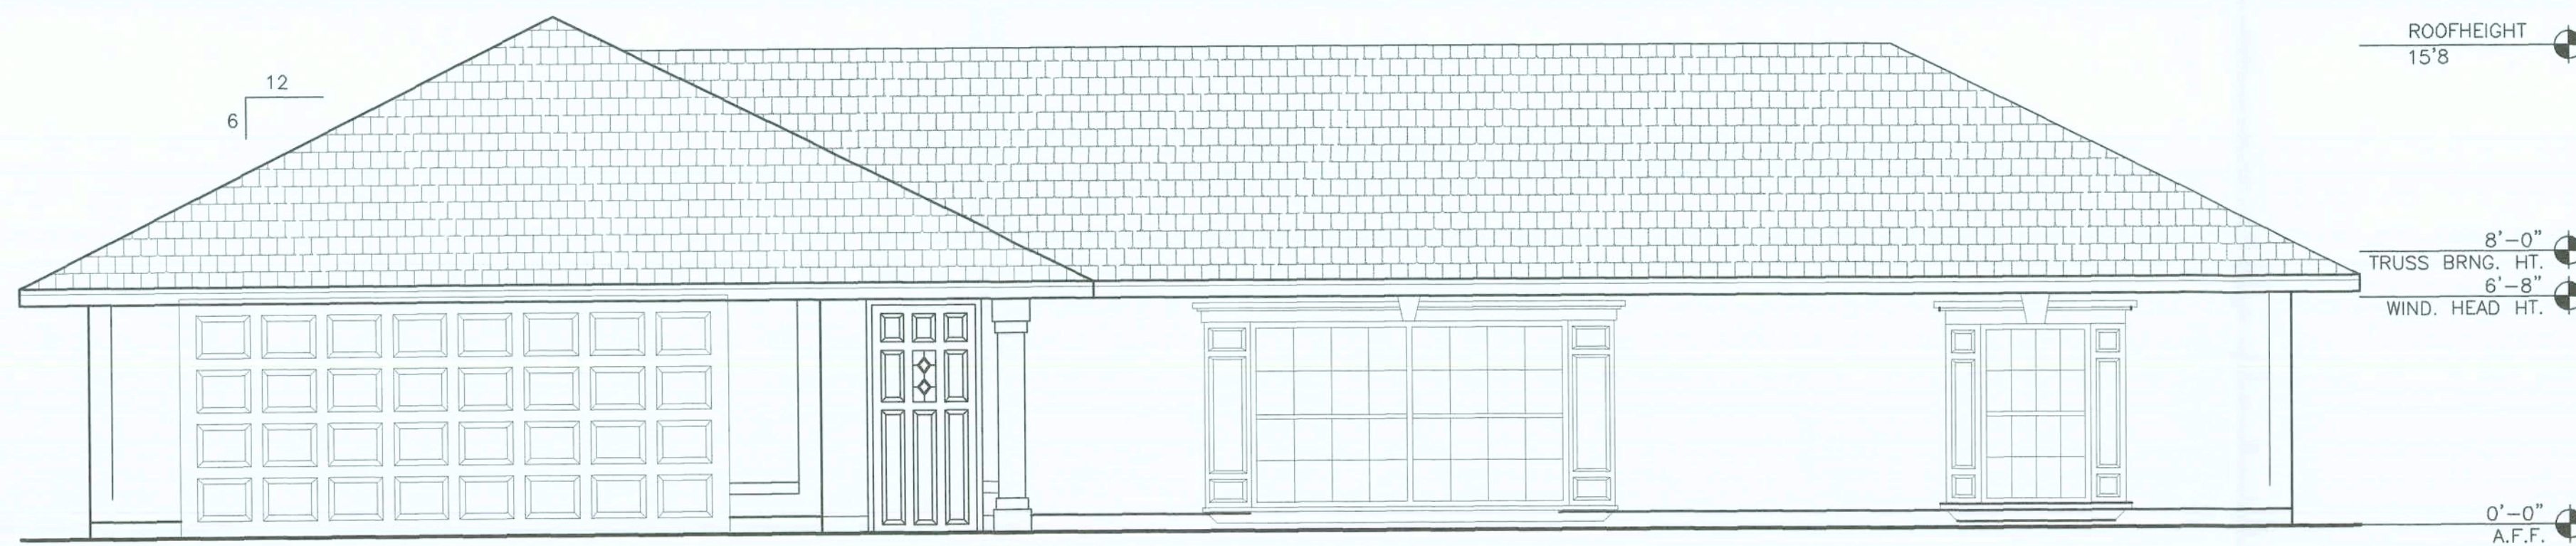


FRONT ELEVATION

SCALE: 1/4"=1'-0"

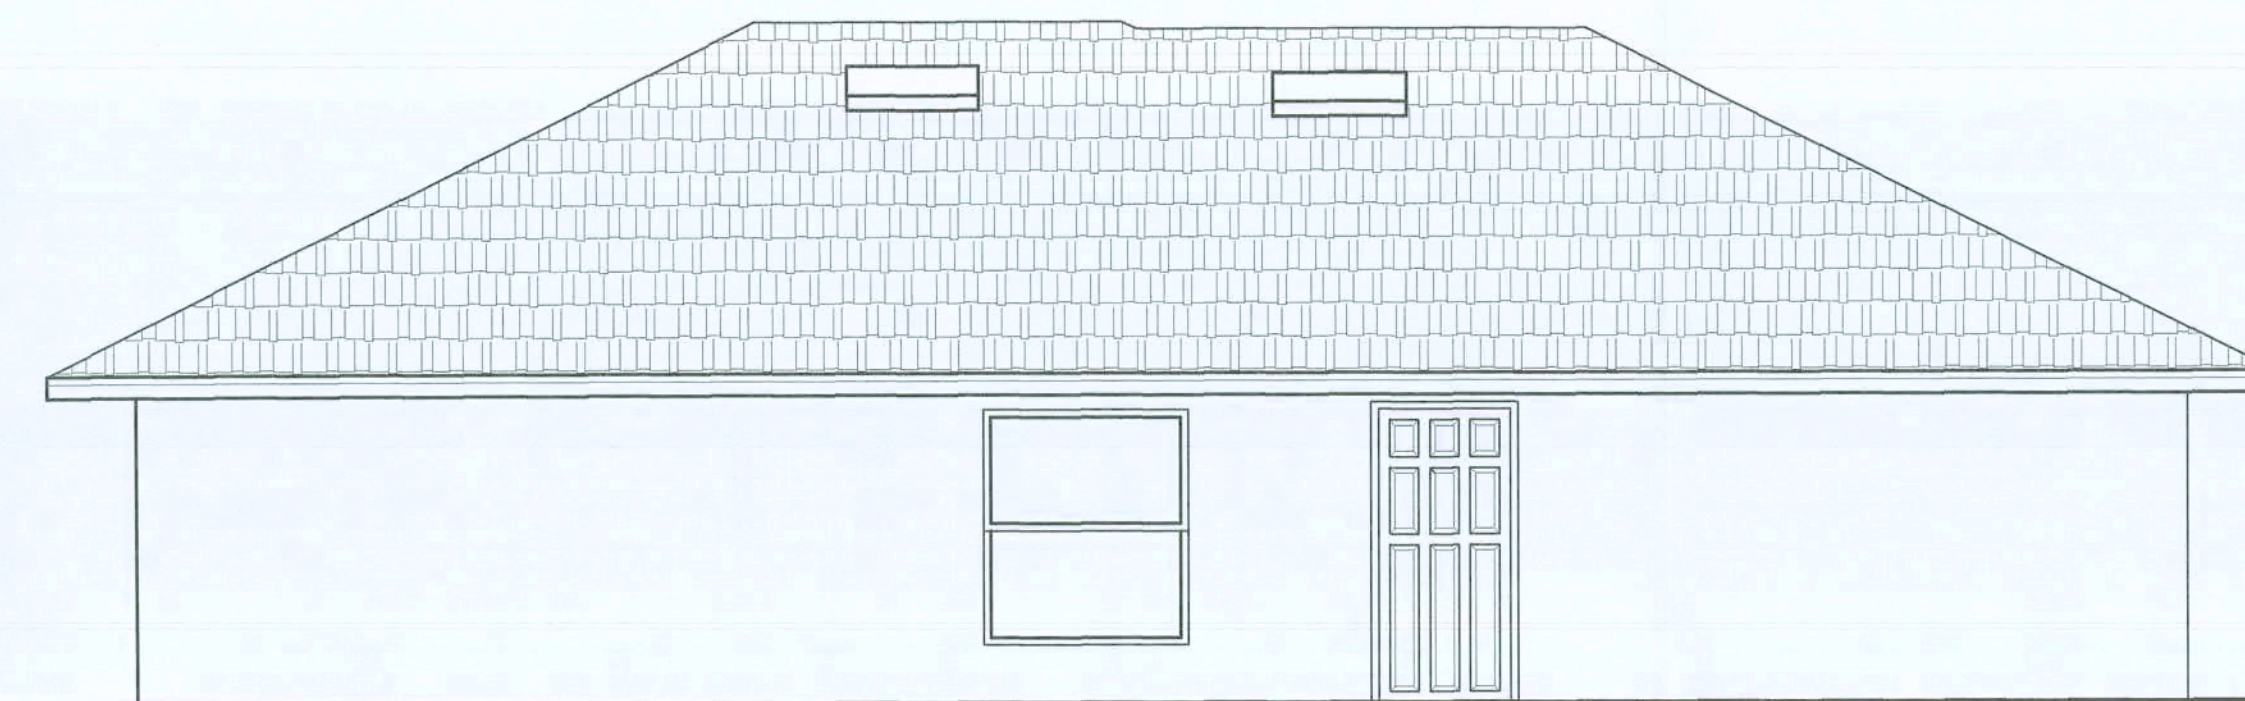


LEFT ELEVATION

SCALE: 1/4"=1'-0"

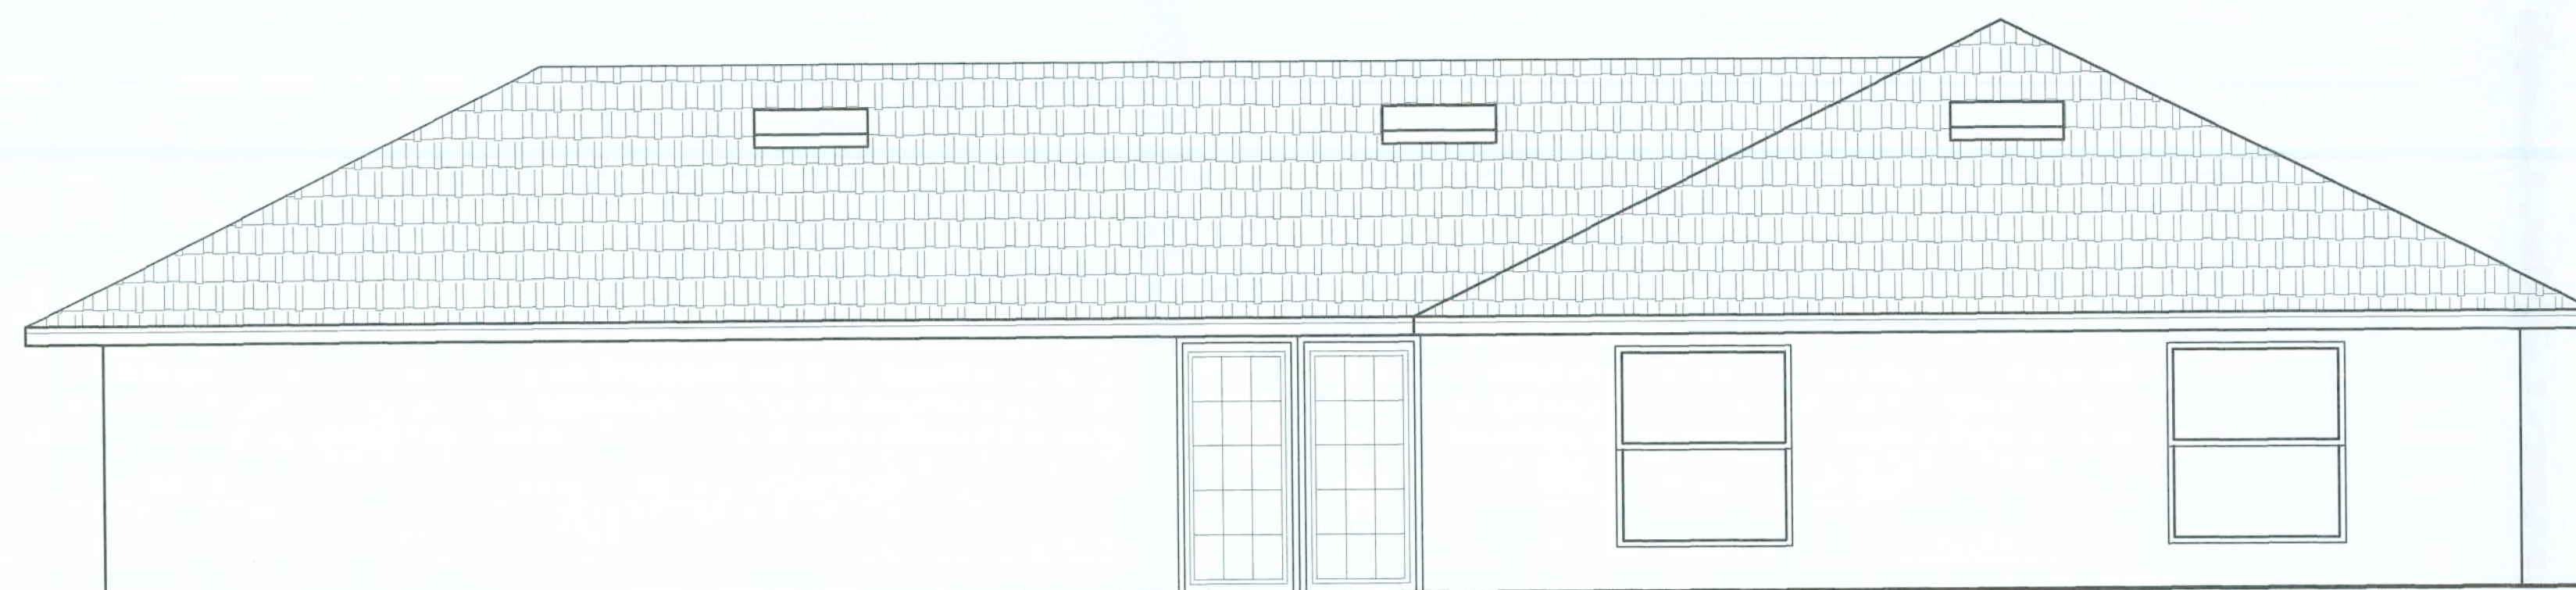

BACK ELEVATION

SCALE: 1/4"=1'-0"

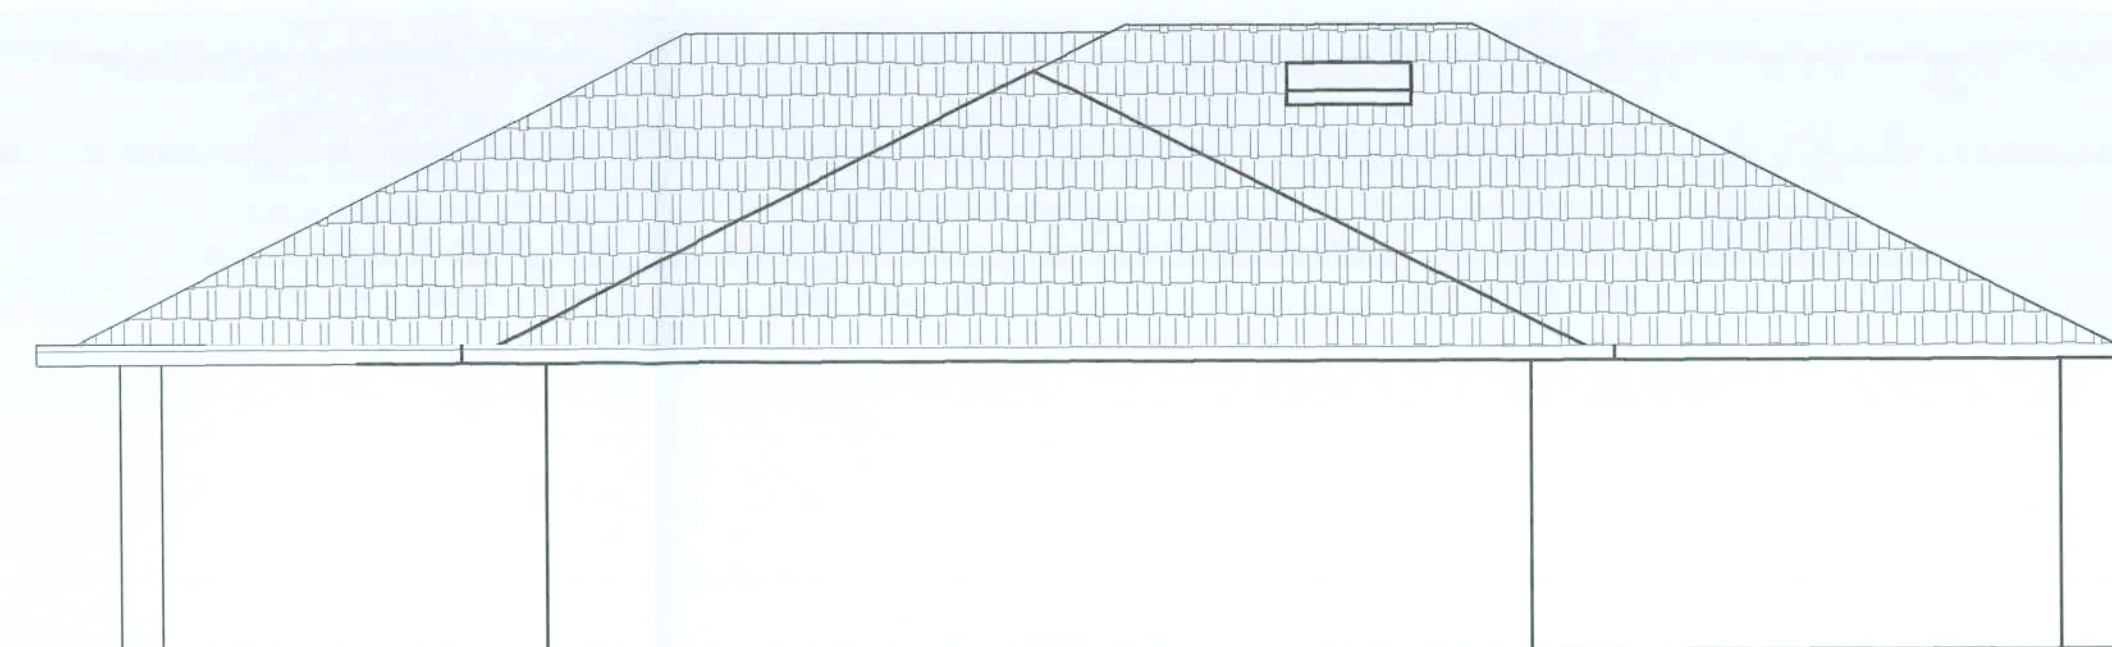

RIGHT ELEVATION

SCALE: 1/4"=1'-0"

ROOF VENT SCHEDULE

2,170 SQ. FT./300 = 7.23 SQ. FT. VENT REQUIRED
224 L. FT. x2/35 = 12.8 SQ. FT. VENT PROVIDED
6 STANDARD ROOF VENTS x 0.72 = 4.32 SQ. FT. PROVIDED
7.23 REQUIRED = 17.12 PROVIDED

REV.	DESCRIPTION	DATE

HOMES BY HOUSE CRAFT, L.L.C.
12523 NW U.S. Hwy. 441 - Alachua, FL 32615
Phone: (386) 462-5323/FAX: (386) 462-1509

Job name: SWAYZE		
Model: GULF	Type: ELEVATIONS	
Location: COLUMBIA CO	Drawn By: J.D.H.	
Designer: J.D.H.	Revision Date:	
Scale: 1/4" = 1'-0"	Date: 1/25/07	Sheet: 3 of 3