


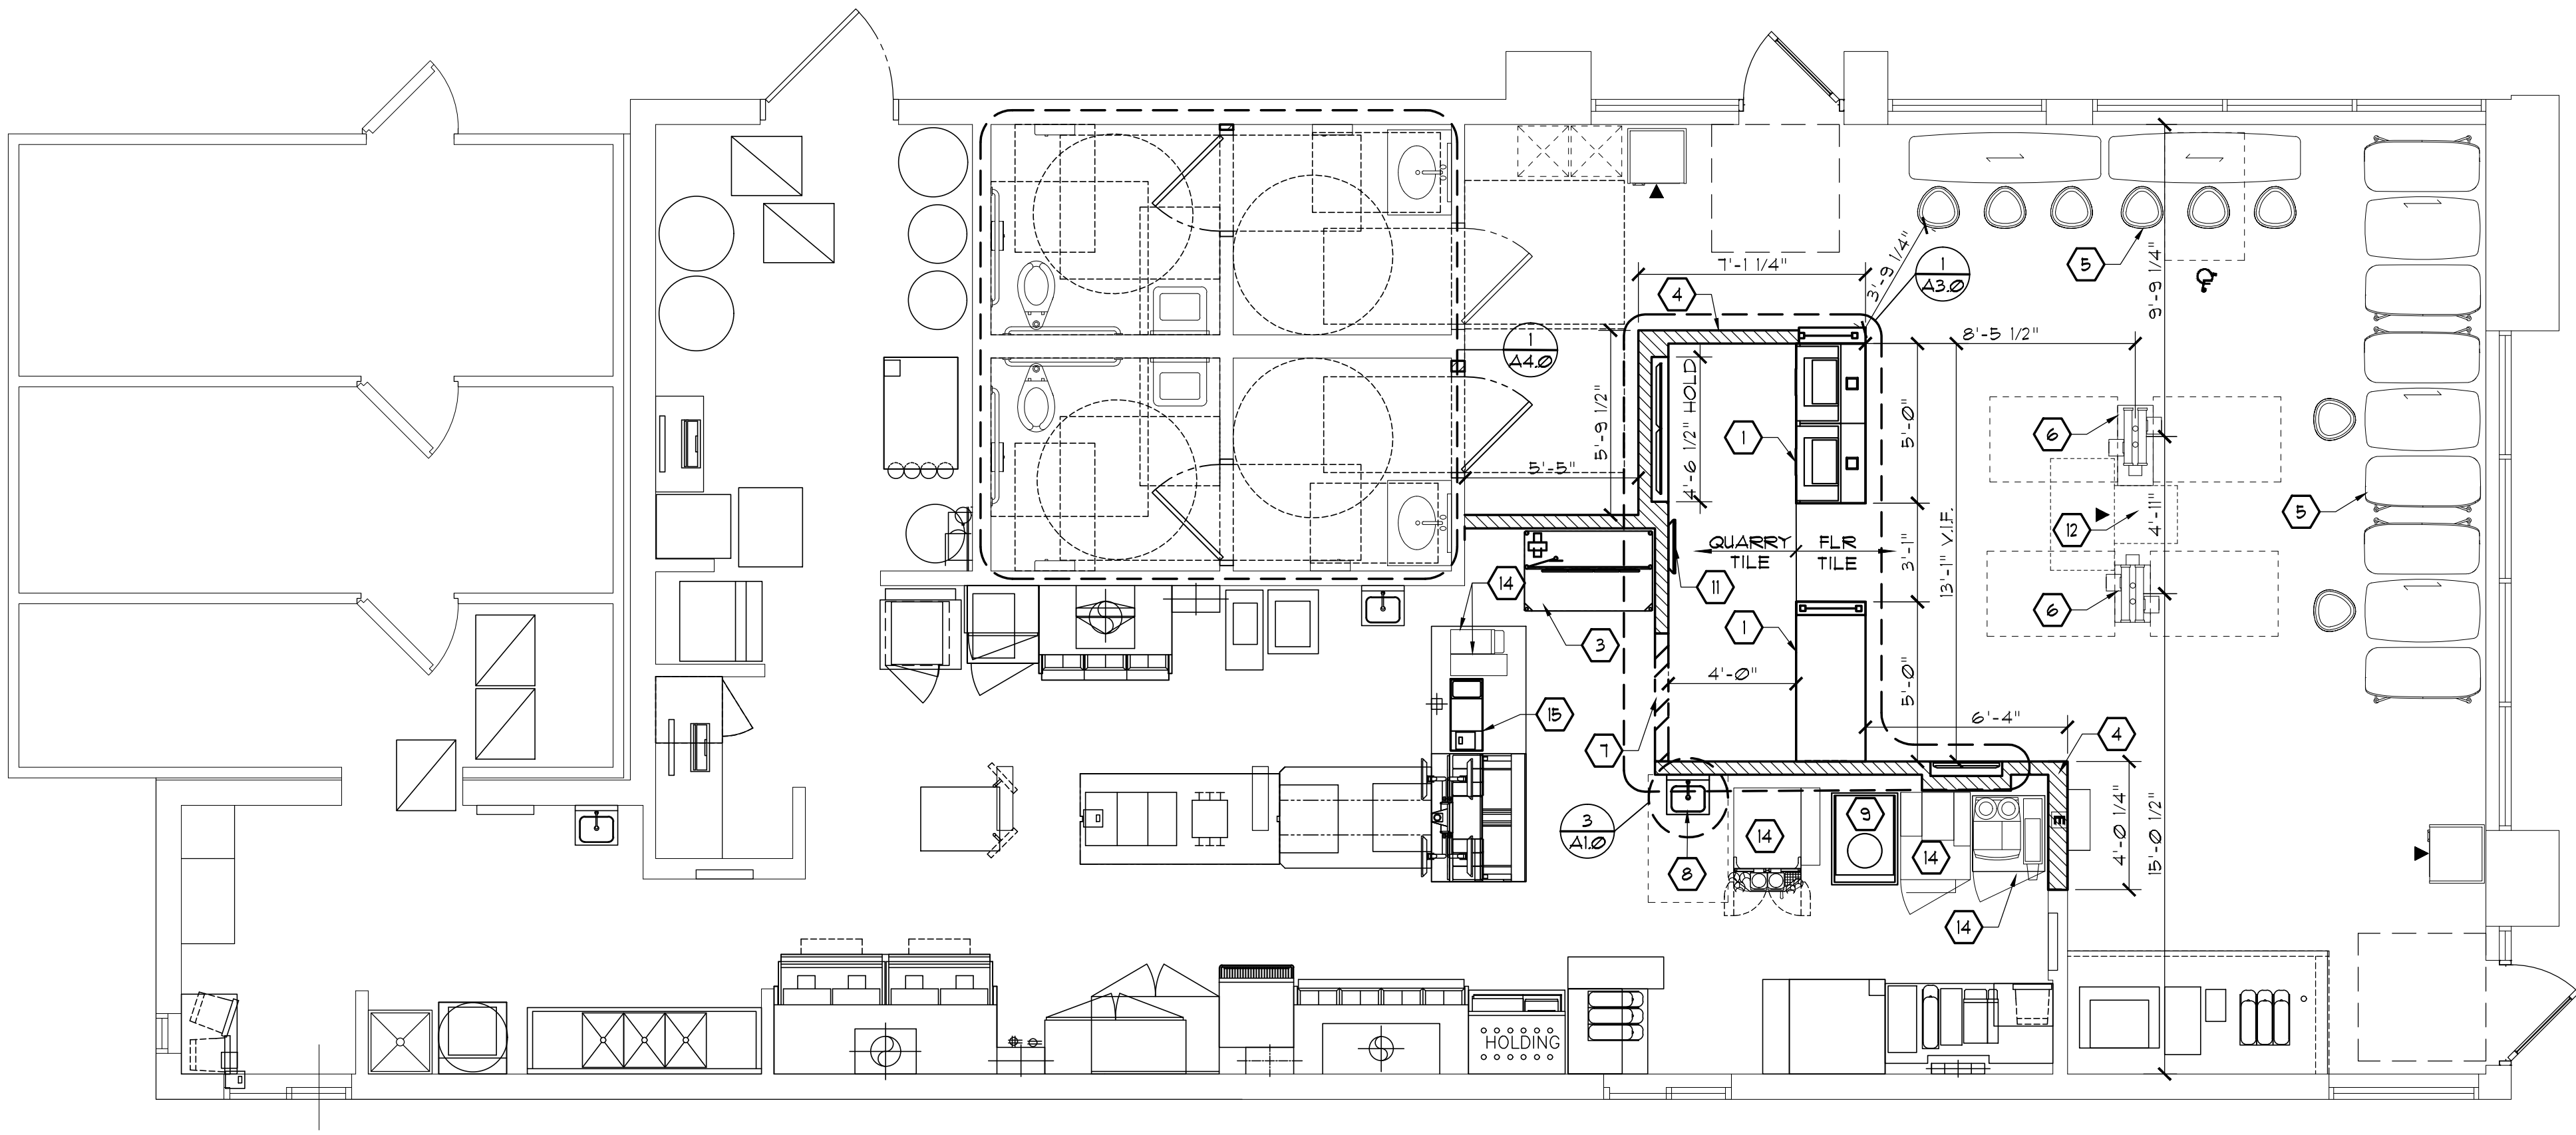

ENTIRE SHEET
CHANGED


1 FLOOR PLAN REMODEL WORK AREA 1051 SF
1/4"=1'-0"

NOTE: CONTRACTOR TO VERIFY AS-BUILT CONDITIONS DO NOT CONFLICT W/ PROPOSED DIAGRAM.

NOTE: CONTRACTOR TO VERIFY PLUMBING REQUIREMENTS W/ EQUIPMENT SUPPLIER.

EXTEND NEW H4CU LINES AS REQ. FROM NEAREST SUPPLY SOURCE TO NEW FIXTURES.


SAUCUT EXISTING FLOOR AS REQUIRED TO REMOVE EXISTING F8/FD AND TO INSTALL NEW HAND SINK. CONCRETE FLOOR SLAB REPLACEMENT SHALL BE 5" CONC. SLAB W/ 6x6-W/4XW/4 WUF ON 6 MIL. VAPOR BARRIER OVER 12" MIN. CLEAN COMPACTED FILL W/ TERMITTE TREATMENT. TIE NEW SLAB INTO EXISTING SLAB/STRUCTURE W/ #3 @ 2'-0". EPOXY W/ MIN. 6" EMBED.

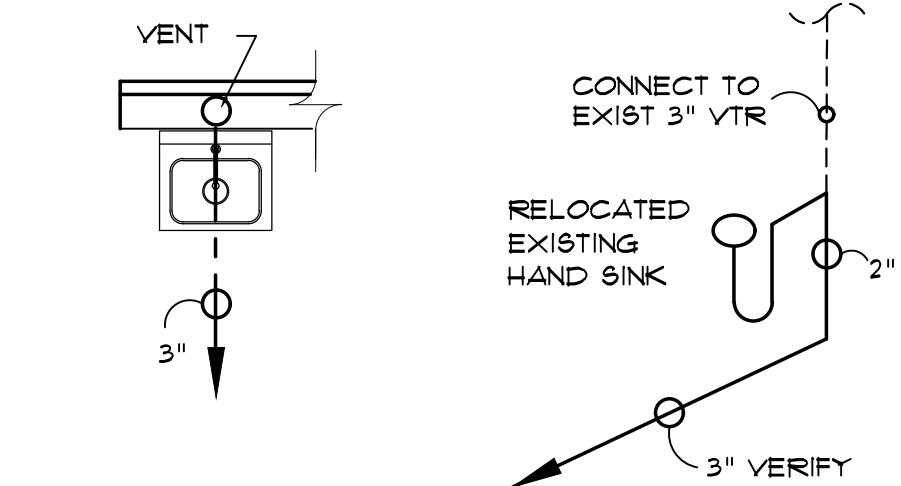

3 RELOCATED EXISTING HAND SINK RISER DIAGRAM
N.T.S.

KEY NOTES

ORDER/PAY-SELF ORDER KIOSK, REFER TO SHEET A2.0

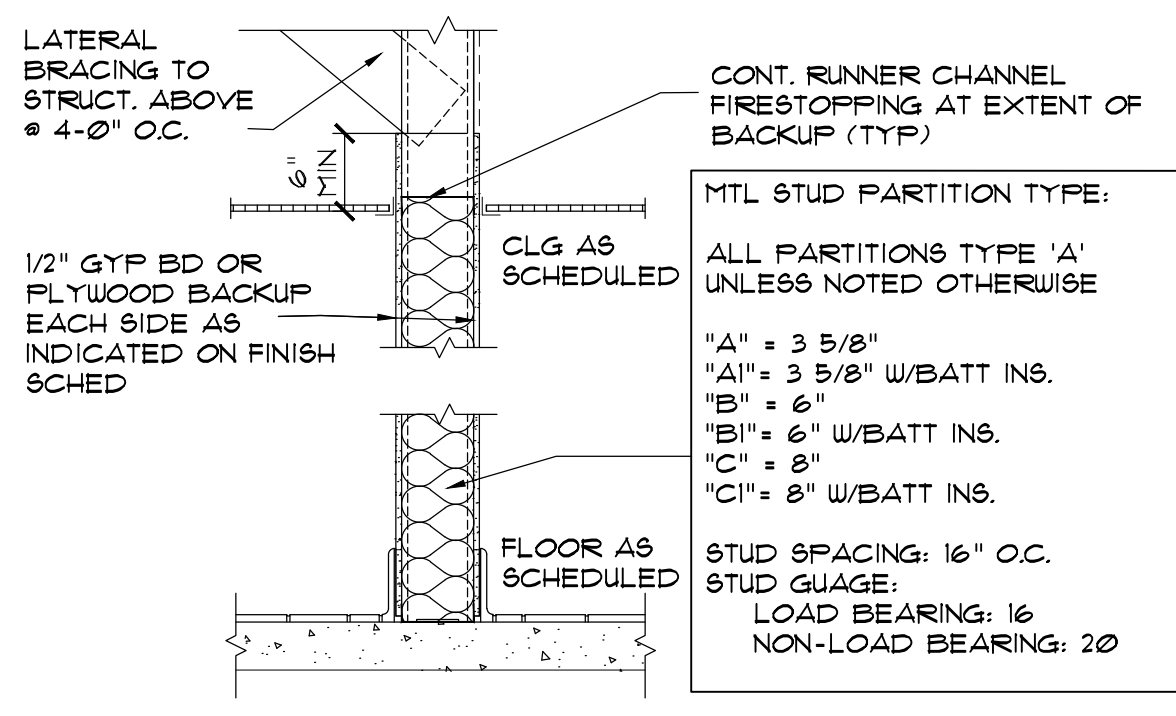

2 INTERIOR PARTITION
3/4"=1'-0"

NOTE: CONTRACTOR MAY USE WOOD OR METAL STUDS/FURRING

NOTES

- NEW SERVICE PODS SEE SHEET A2.0 DETAILS.
- NOT USED
- NEW 36" X 36" STAGING CART, BY KES
- EXTEND WALL AS REQUIRED. NEW WALL TO MATCH EXISTING IN HEIGHT & FINISHES
- NEW FLOOR, CEILING AND DECOR, REFER TO DECOR PLANS
- ADJUST LOCATION OF KIOSK SO TOP PLATE IS FULLY ON/OR OFF THE SOFFIT (AVOID CEILING CHANGE)
- NEW VALANCE TO ALIGN W/ FRONT FACE OF NEW DMB WALL
- RELOCATED EXISTING HAND SINK.
- NEW FROZEN CARBONATED BEVERAGE BY KES
- NOT USED
- ORB MONITOR TO BE CENTERED ON PICK UP COUNTER
- FUTURE CASK RECYCLER
- NOT USED
- RELOCATED EXISTING EQUIPMENT.
- NEW 30" ASSEMBLY, PROVIDE BY KES
- NOT USED

GENERAL NOTES

- EXTERIOR DIMENSIONS ARE TO COLUMN REFERENCE LINES AND/OR FACE OF FOUNDATION WALLS UNLESS NOTED OTHERWISE.
- INTERIOR DIMENSIONS ARE TO FACE OF FINISH WALL.
- DO NOT SCALE DRAWINGS.
- MINIMUM INTERIOR FINISH CLASSIFICATION:
OCCUPANCY A2 NONSPRINKLERED
EXIT ENCLOSURES AND EXIT PASSAGEWAYS: A
CORRIDORS: A ROOMS AND ENCLOSED SPACES: B
- GYP BD TO BE USED ON DINING SIDE OF INTERIOR PARTITIONS UNO
- MATCH EXISTING FINISHES UNO TYP.
- GC TO REQUEST & FOLLOW ADA REPORT WHEN AVAILABLE
- AS-BUILTS BASED ON PLANS FROM SEVAN MULTI-SITE SOLUTIONS
- SEATING LAYOUT / DIMENSIONS BASED ON PLANS PROVIDED BY CASABLANCA
- ADJUST LOCATION OF KIOSK SO TOP PLATE IS FULLY ON/OR OFF THE SOFFIT (AVOID CEILING CHANGE)
- NEW FLOOR, CEILING AND DECOR, REFER TO DECOR PLANS
- LOW VOLTAGE WIRING BY OWNER OPERATOR IF REQUIRED UNDER SEPARATE PERMIT TYP.

WALL LEGEND

- EXISTING CONSTRUCTION
- NEW CONSTRUCTION
- EXISTING CONSTRUCTION TO BE REMOVED

PREPARED BY:	McDonald's USA, LLC	DATE:	2019.08.19
DRAWN BY:	YB	STD. ISSUE DATE:	
REVIEWED BY:	SJP	DATE ISSUED:	2019.08.19
SHEET NO.	1802.471	A1.0	
EOTF PROGRAM DESCRIPTION		1802.471	
SITE ADDRESS		491 SW MAIN BLVD LAKE CITY, FL 32025-5207	
NAT. #		15440	
SITE ID		009-1231	
SHEET NO.		AA-0003276	

PREPARED BY: **Purdy+ Muroff** Architecture, Inc.

Digitally signed by **Scott J. Purdy**
Date: 2022.10.12 13:19:49 -04'00'

1711 North Himes Avenue, Tampa, Florida 33607
Ph: 813.353.0033 Fax: 813.353.4350 Web Site: www.purdy+muroff.com

REV	1	DATE	10.05.22	DESCRIPTION	Updated Decor
BY					DJ

CONFIGURATION: PERPENDICULAR TO WALL/PARTITION MULTIPLE UNITS 4



- Typical kiosk face quantity (4 faces), final quantity per restaurant to be determined by McDonald's Operations team
- 12" clear dimension highly recommended between front counter and kiosk
Existing conditions to be considered
- See table locator guideline on page 5 for placement
- Wall finish behind kiosk to coordinate with decor
- Power from above (with standard ceiling height). If ceiling is greater than 10', refer to Project Manager, see kiosk cut sheet for additional electrical information
- Ideal when placed in front of the service area, less likely to interfere with front counter queuing
- Ideal when trying to capture customers from two entrances
- Leverages existing decor elements typically seen in our standard decor layouts
- **This is the preferred placement configuration**



KIOSK GUIDELINES

5/21/18

LOCATION GUIDELINE

6


Figure 1 is a top-down schematic of the experimental setup. It depicts a rectangular environment measuring 48 inches in width and 32 inches in height. A central vehicle-like object is positioned, featuring a driver's seat and a 20-inch wide section. Dashed lines indicate the boundaries of the environment and the vehicle. Arrows at the top indicate movement directions.



KIOSK GUIDELINES


5/21/18

7

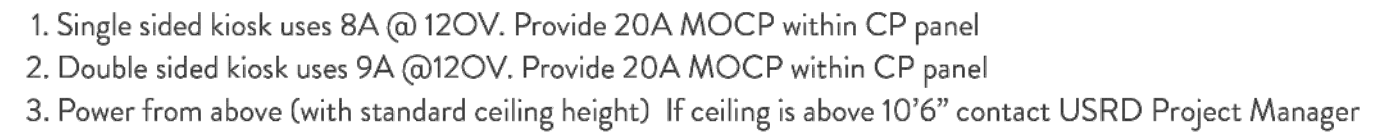


KIOSK GUIDELINES

5/21/18

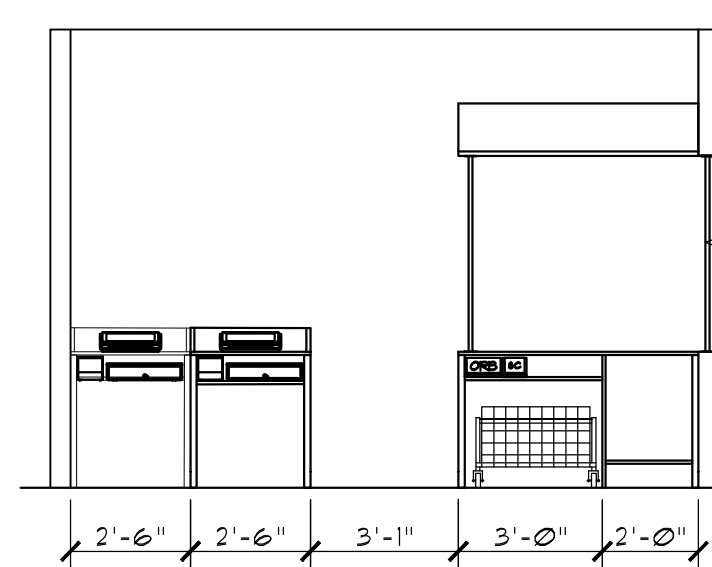

2
A2.0










FRONT COUNTER (CREW VIEW)
1/4"=1'-0"

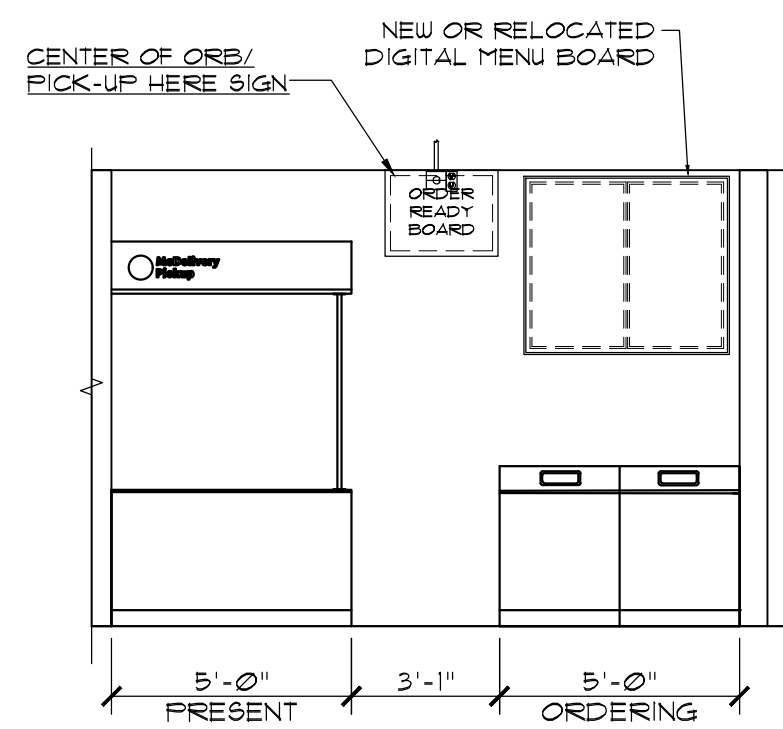

FRONT COUNTER (CUSTOMER)
1/4"=1'-0"


 ENTIRE SHEET
CHANGED

[illegible]

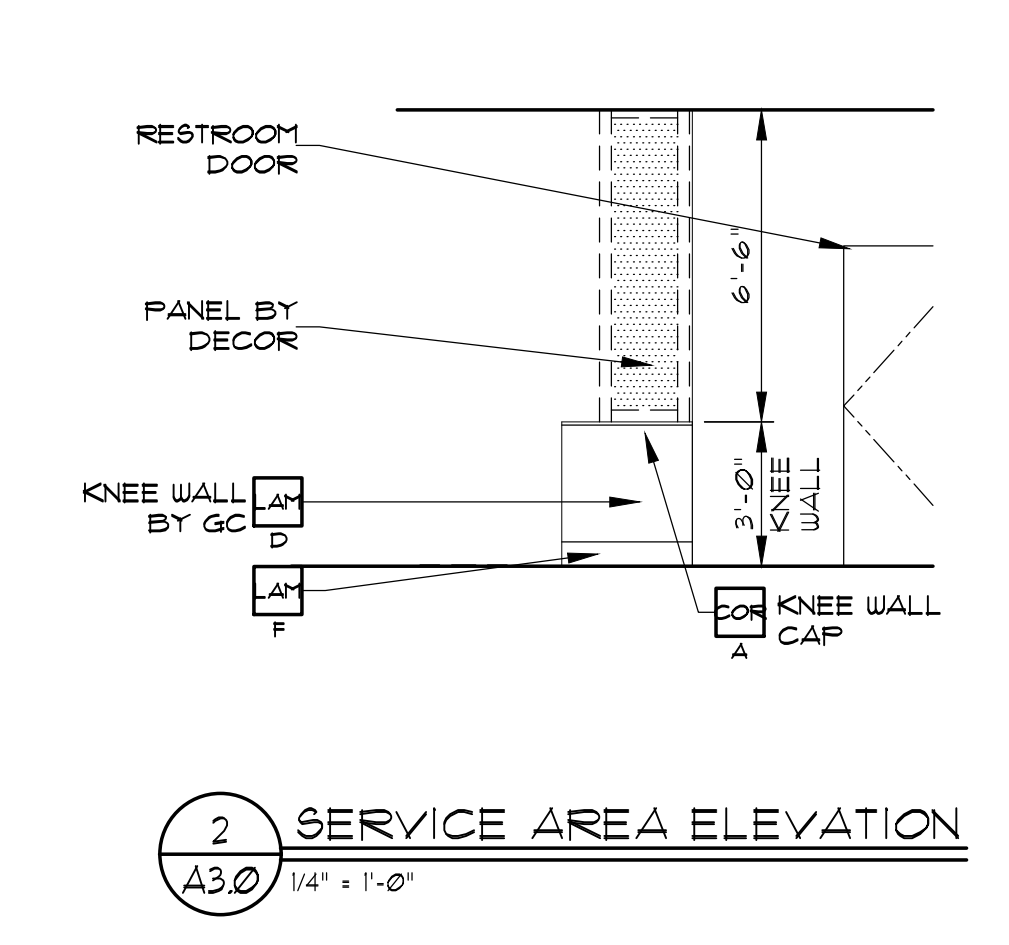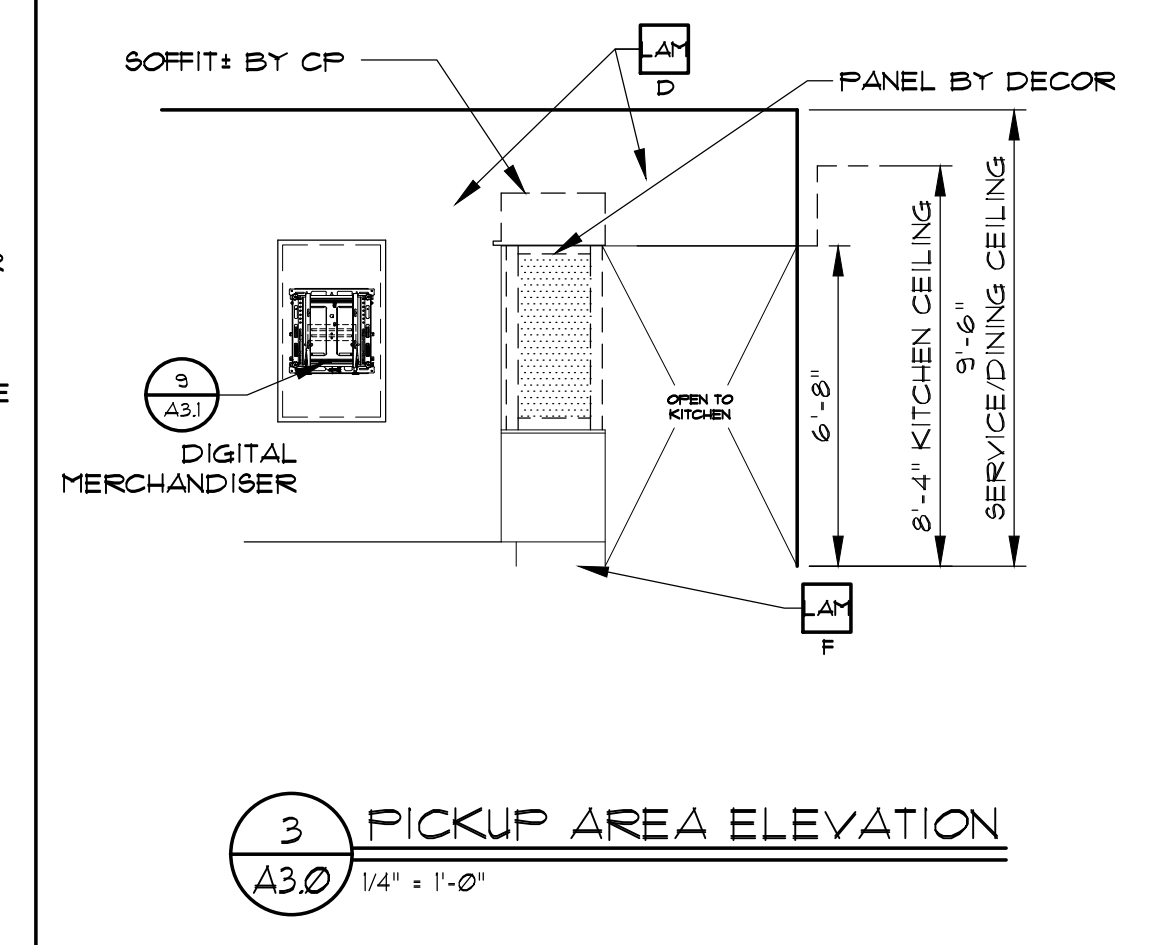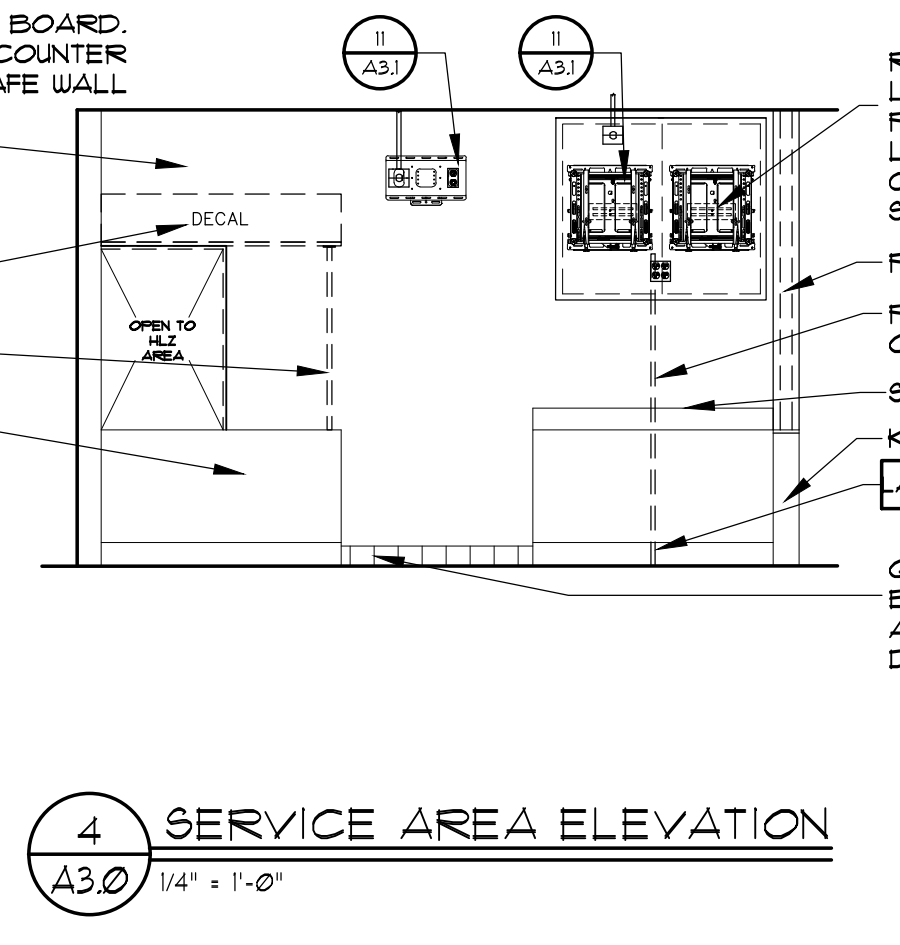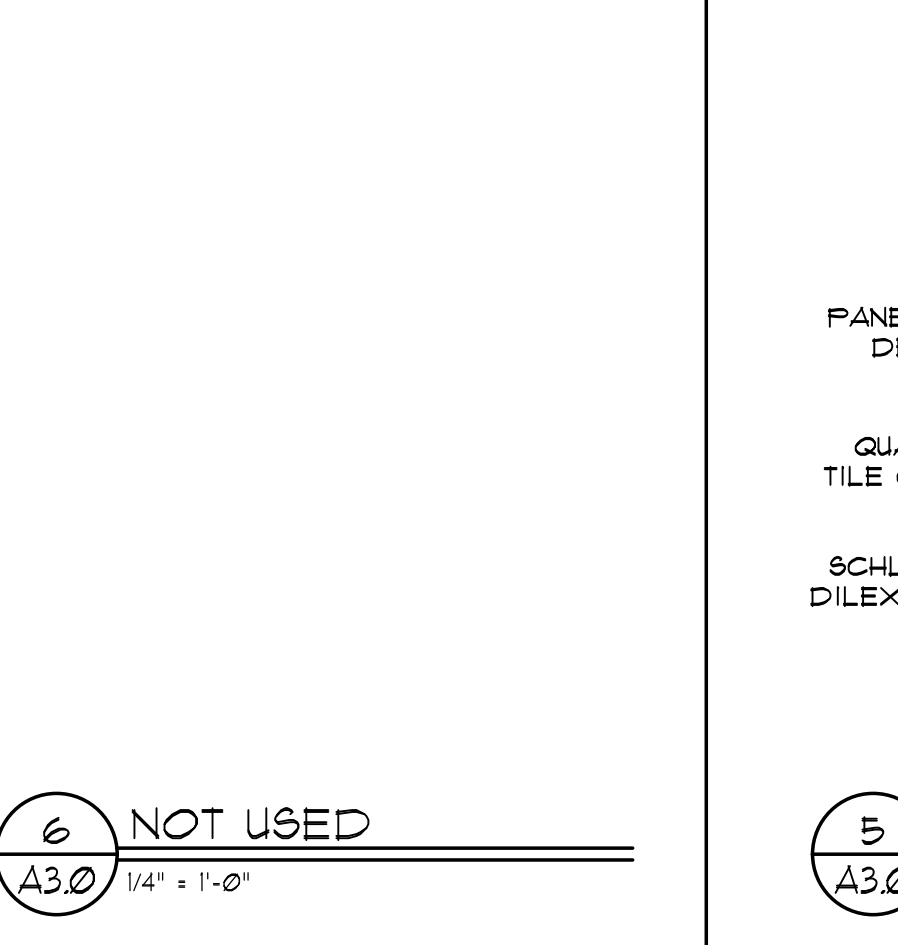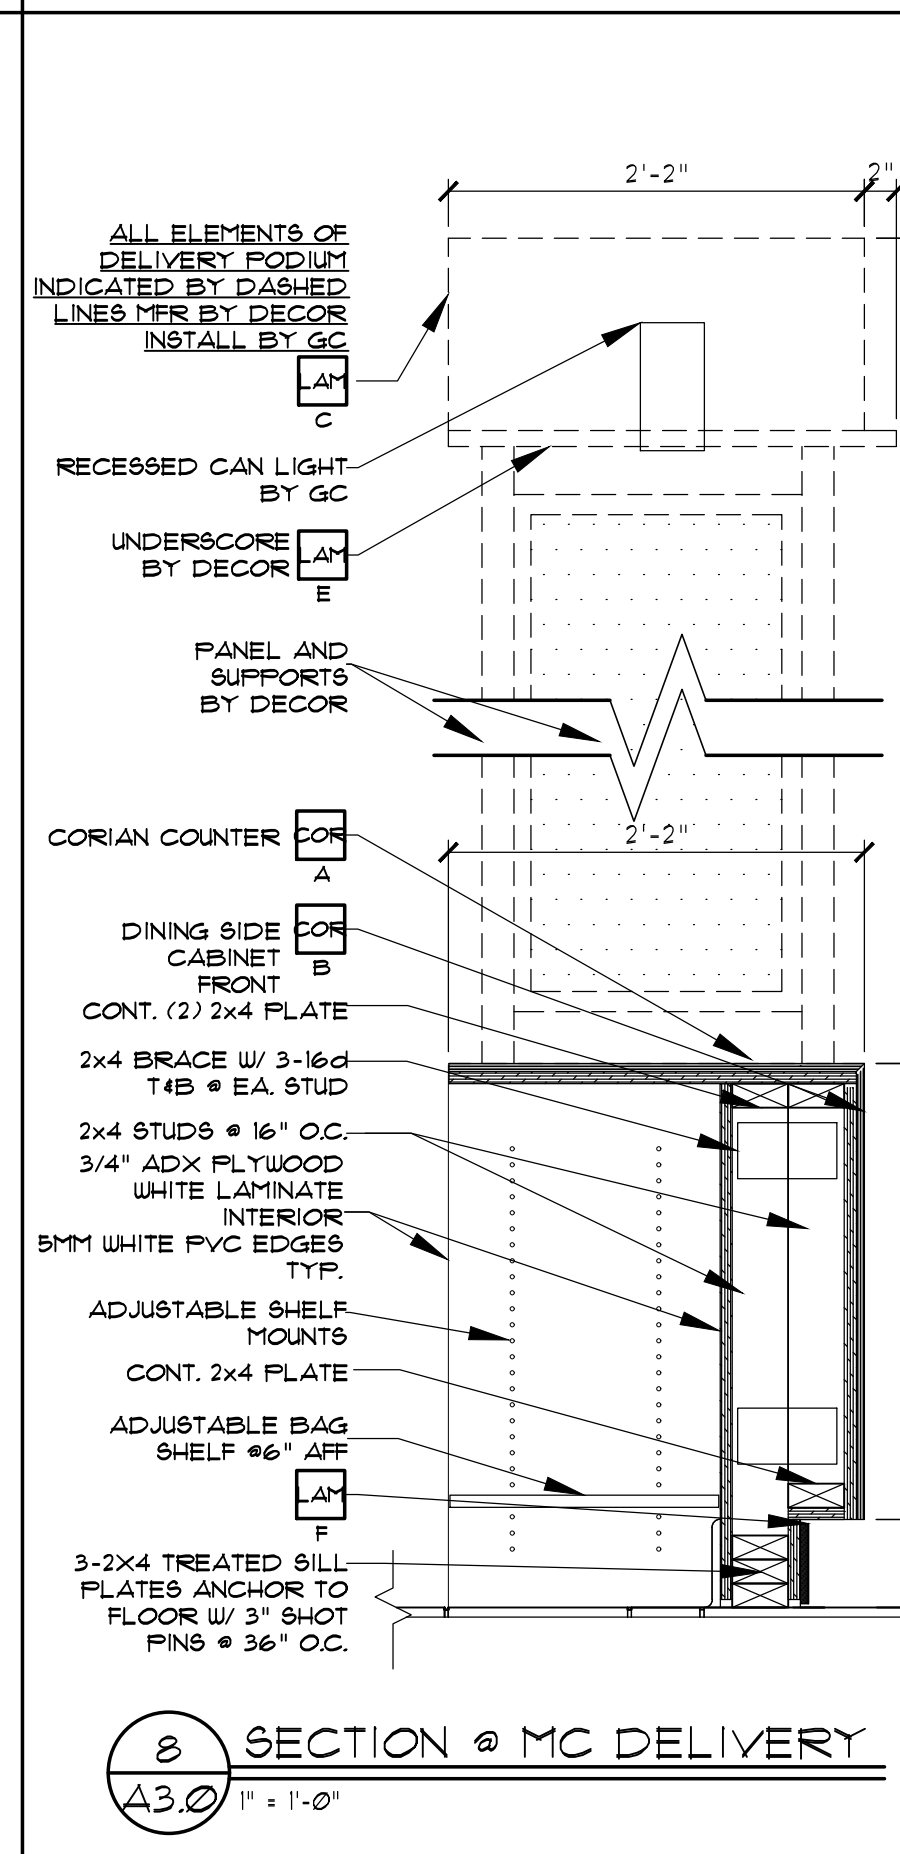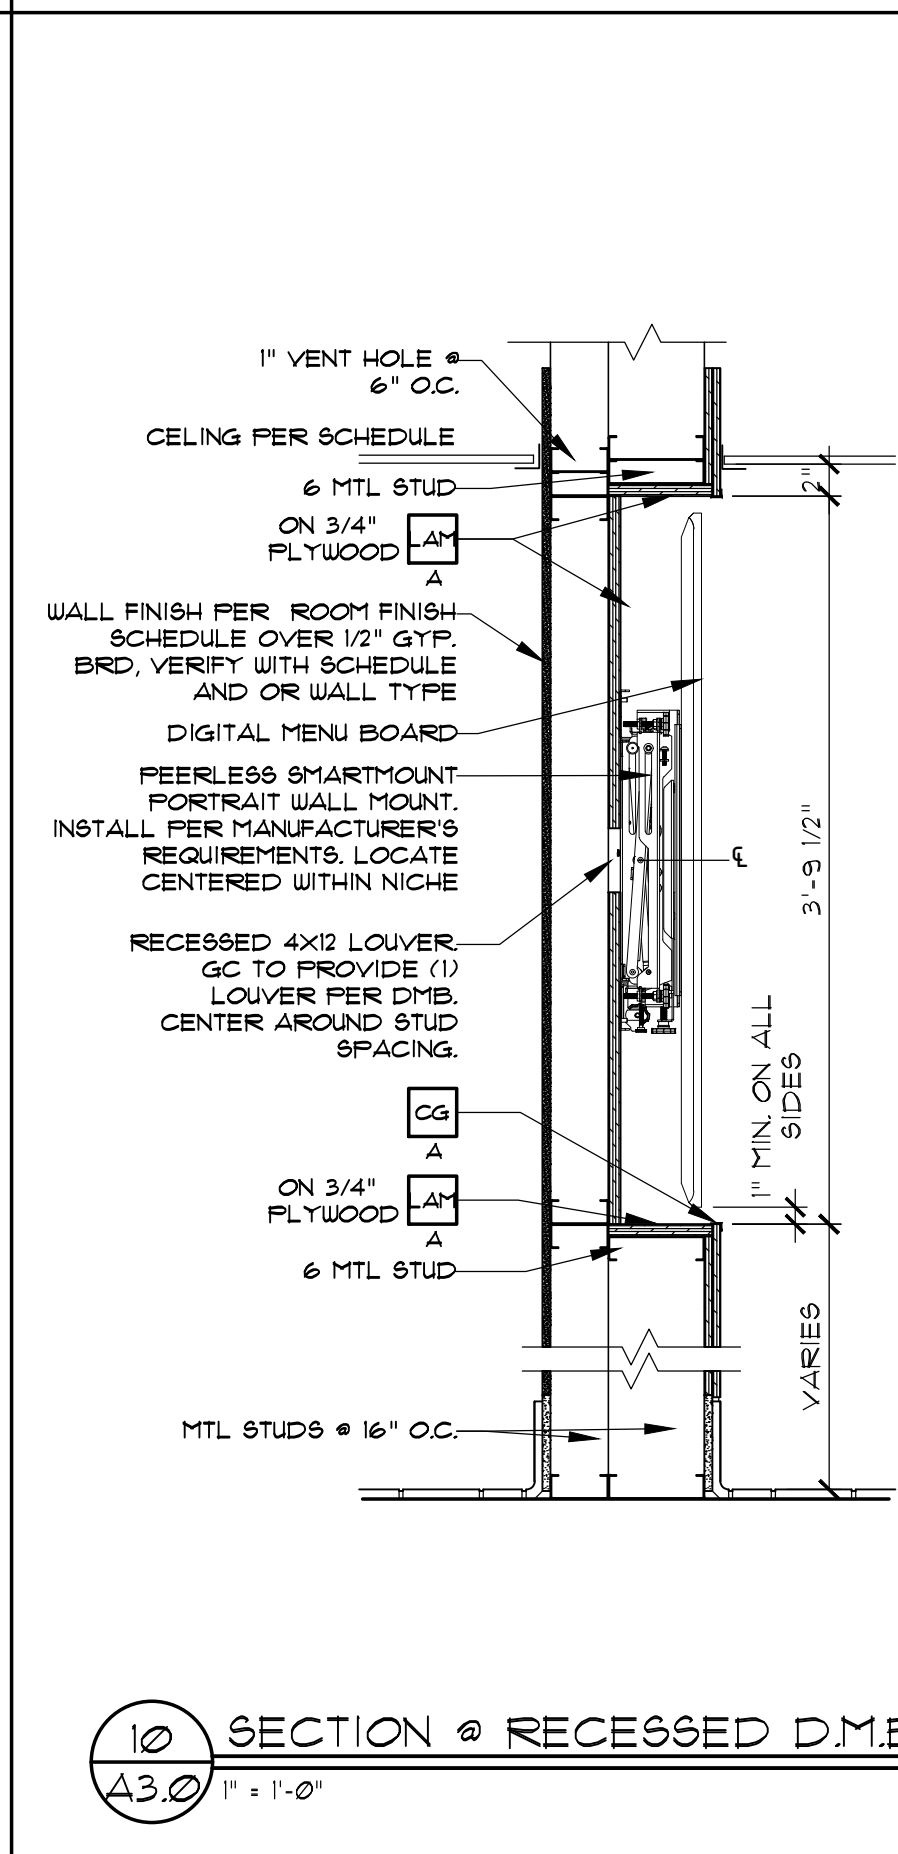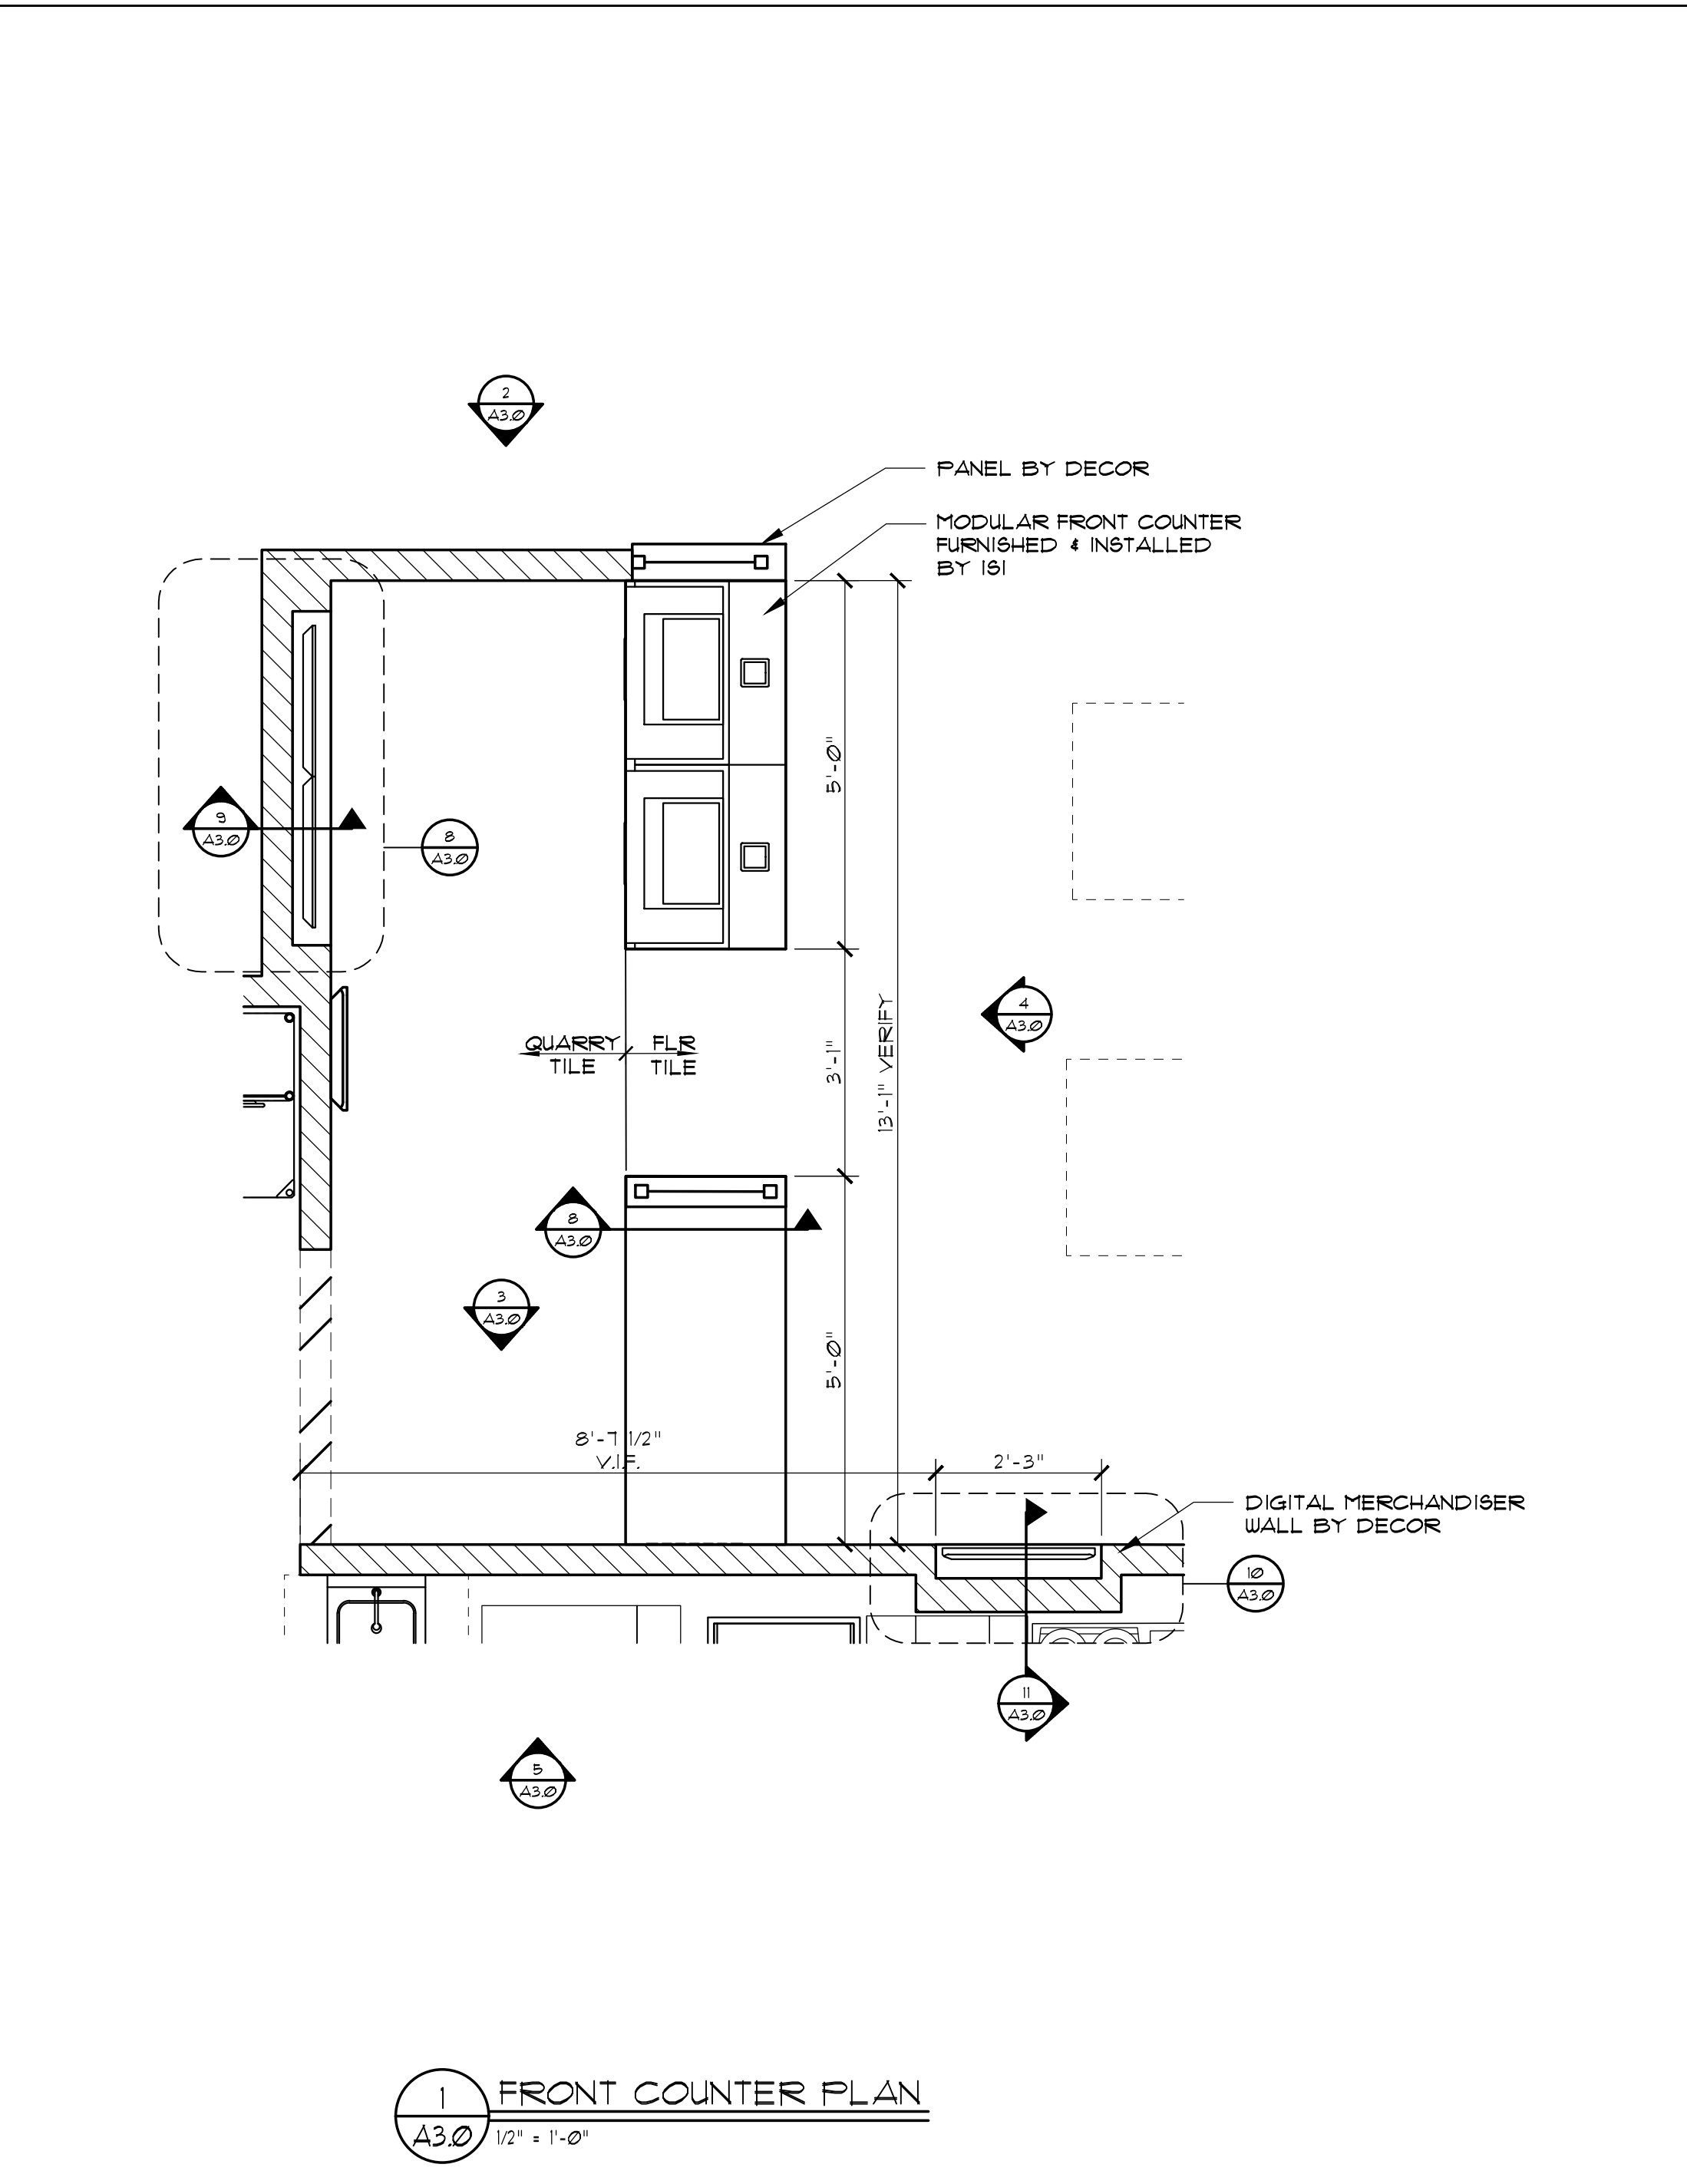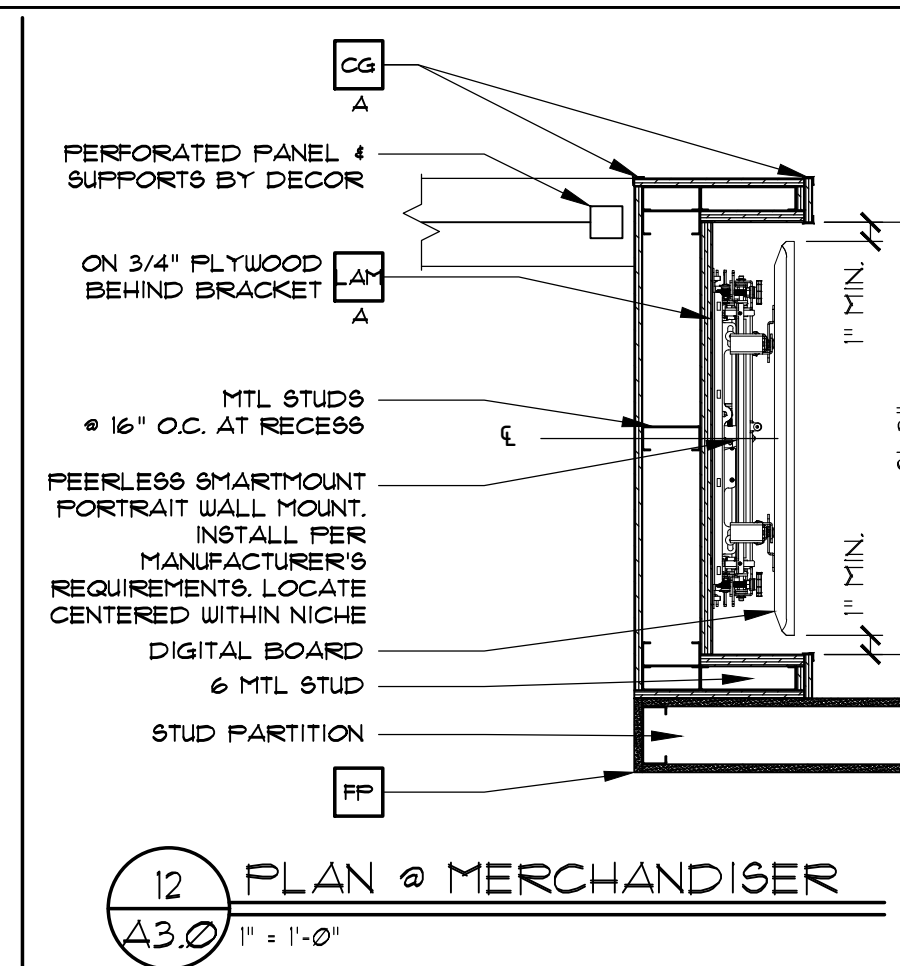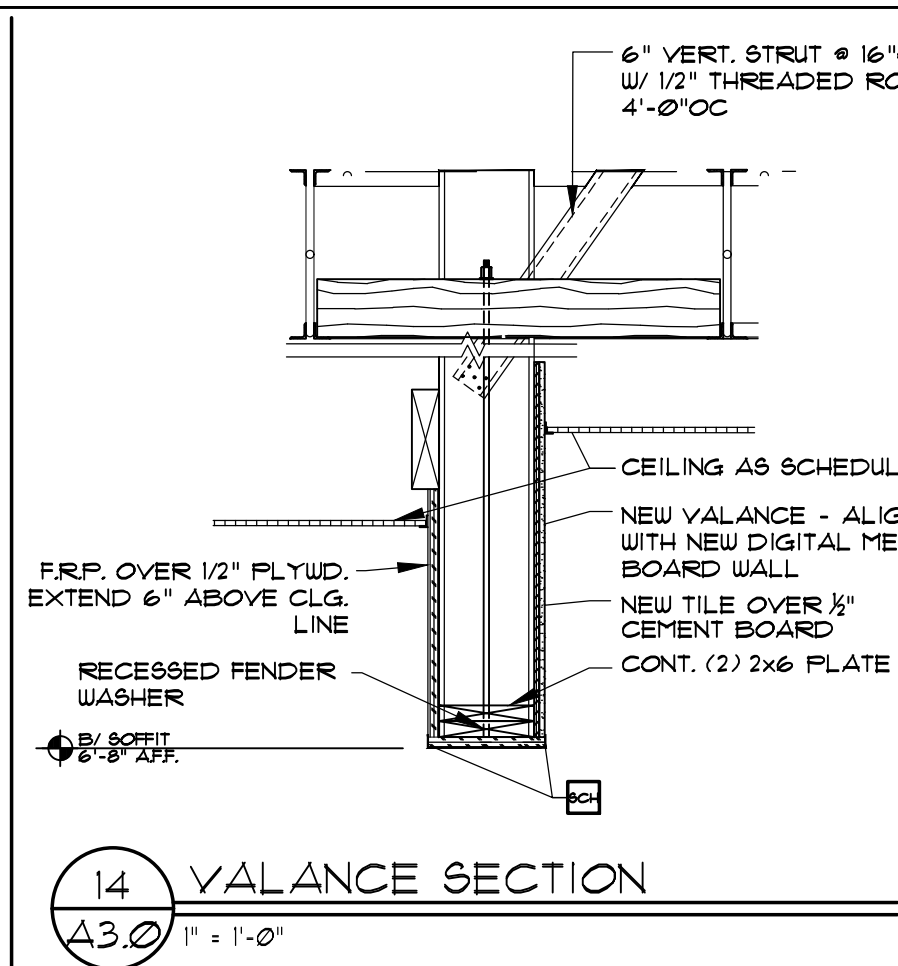

ENTIRE SHEET
CHANGED

[illegible]

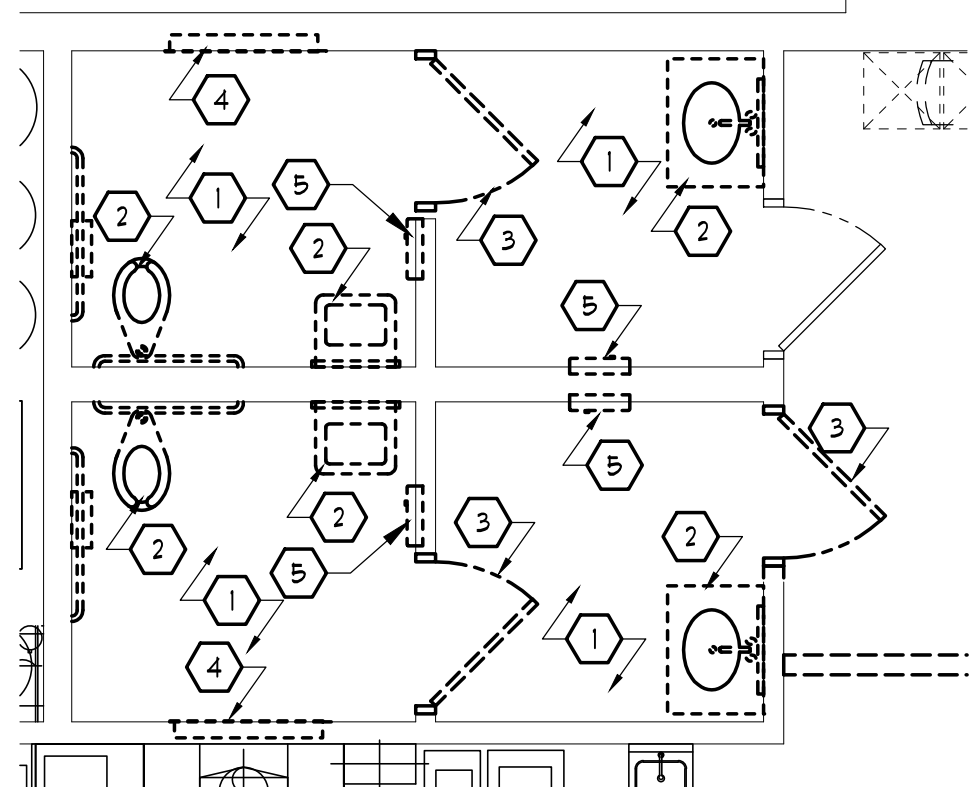


DEMO NOTES

- 1. PATCH FLOOR, WALL & CEILING AS REQUIRED FROM DEMO. PREPARE SUB-STRAIGHT FOR NEW FINISH, COORDINATE WITH ACM & DECOR
- 2. REMOVE EXISTING FIXTURES AND PREPARE SUPPORTS AND WALL AS REQUIRED FOR NEW FIXTURES, TYP
- 3. REMOVE EXISTING DOOR, FRAME AND WALL AS REQUIRED FOR NEW LOCATION, TYP
- 4. REMOVE EXISTING BABY CHANGING TABLE, INFILL WALL AS REQUIRED FOR NEW FINISH, REFER TO DECOR
- 5. REMOVE EXISTING HAND DRYER, INFILL WALL AS REQUIRED FOR NEW FINISH, REFER TO DECOR

5 DEMO RESTROOM PLAN


PROPOSED WORK NOTES

- 1. NEW FINISHES TO MATCH EXISTING OR SEE DECOR FOR NEW FINISHES
- 2. ADJUST ACCESSORIES AS REQUIRED DUE TO NEW CONSTRUCTION
- 3. REFER TO ADA REPORT AND ADJUST EXISTING ITEMS AS REQUIRED
- 4. NEW ADA TOILET
- 5. NEW TOILET
- 6. NEW ADA URINAL
- 7. NEW ADA HAND SINK
- 8. NEW ADA VANITY SINK
- 9. NEW ADA HAND DRYER, REUSE/RELOCATE EXISTING POWER AS REQUIRED

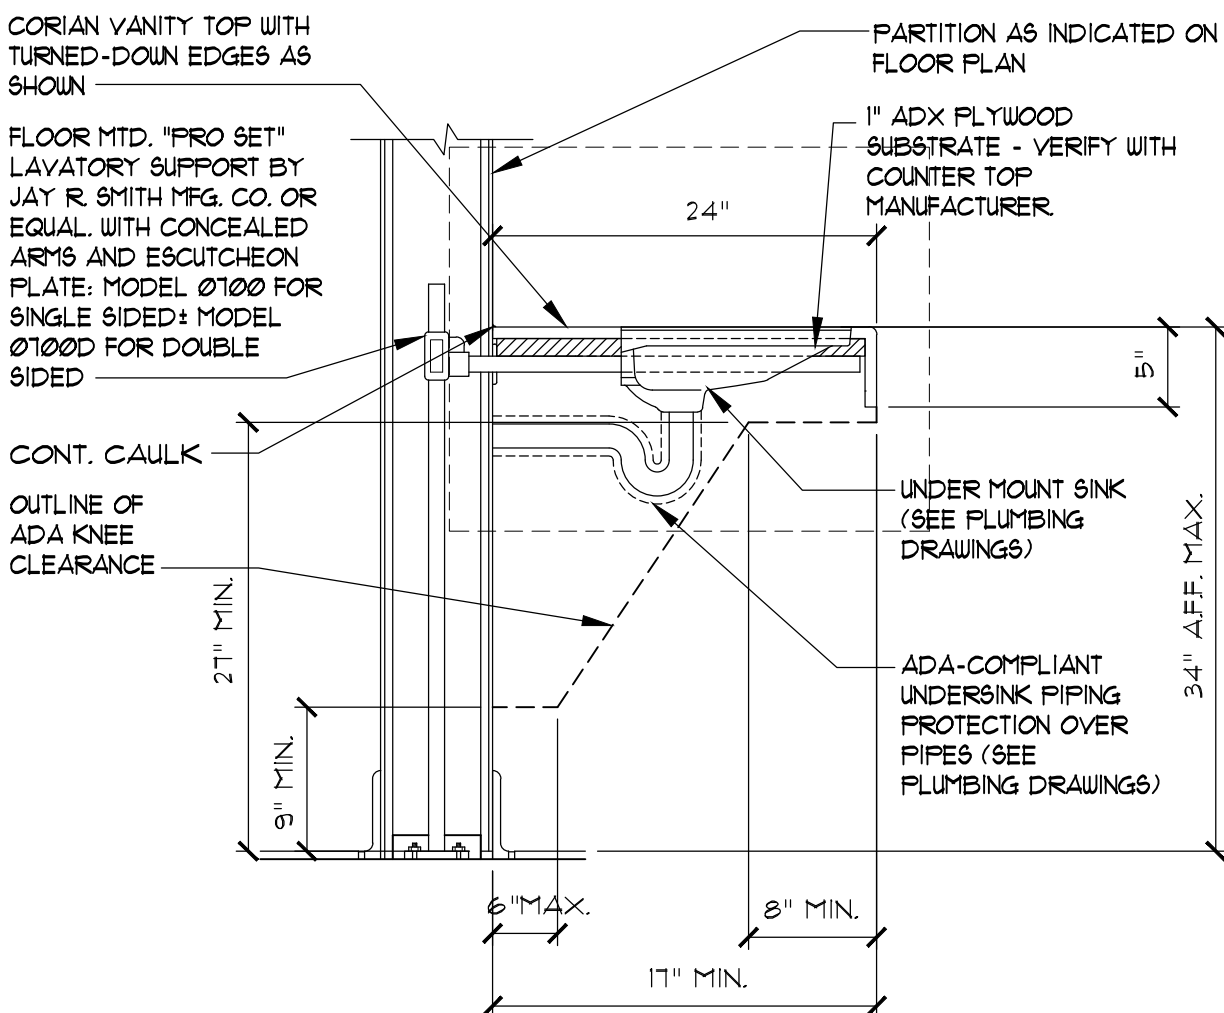

SECTION @ LAVATORY

1" = 1'-0"

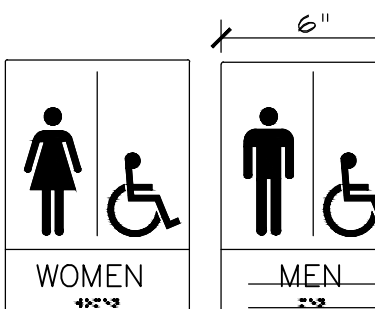


SIGNAGE NOTES:

- 1. EACH EXIT DOOR SHALL HAVE A TACTILE SIGN, INCLUDING RAISED LETTERS AND BRAILLE, STATING 'EXIT' AND SHALL COMPLY WITH CHAPTER 7. ALL SIGNAGE SHALL CONFORM WITH ACCESSIBILITY GUIDELINES AND LOCAL GUIDELINES INCLUDING BUT NOT LIMITED TO PROPORTION, COLOR CONTRAST AND RELIEF AND GRADE 2 BRAILLE REQUIREMENTS.
- 2. WHEN PERMANENT IDENTIFICATION IS PROVIDED FOR ROOMS AND SPACES, RAISED LETTERS SHALL BE PROVIDED AND SHALL BE ACCOMPANIED BY BRAILLE IN CONFORMANCE WITH CHAPTER 7. SIGNS SHALL BE INSTALLED ON THE WALL ADJACENT TO THE LATCH SIDE OF THE DOOR WHERE THERE IS NO WALL SPACE ON THE LATCH SIDE, INCLUDING AT DOUBLE LEAF DOORS, SIGNS SHALL BE PLACED ON THE NEAREST ADJACENT WALL. PREFERABLY ON THE RIGHT. MOUNTING HEIGHT SHALL BE 60" ABOVE THE FINISHED FLOOR TO THE CENTERLINE OF THE SIGN. MOUNTING LOCATION SHALL BE DETERMINED SO THAT A PERSON MAY APPROACH WITHIN 3" OF SIGNAGE WITHOUT ENCOUNTERING PROTRUDING OBJECTS OR STANDING WITHIN THE SWING OF A DOOR.

GRAPHICS SHOWN ARE FOR REFERENCE ONLY.

GC TO PROVIDE ADA SIGNAGE PACKAGE AND INSTALL SIGNS AT LOCATIONS AND POSITIONS INDICATED IN PACKAGE OR AS REQUIRED BY LOCAL CODES. SIGNAGE PACKAGE SUPPLIED BY:

FORREST PERMA-SIGN
9292 1ST ST., BOX 588
NEW ROCHELLE, NY 10802
www.forrestpermasigns.com
1-800-214-8165

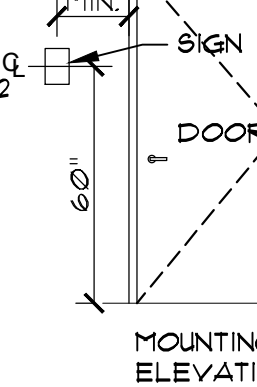

TOILET ROOM NOTES:

- 1. CONTROLS FOR FLUSH VALVES SHALL BE MOUNTED ON WIDE SIDE OF TOILET AREA
- 2. ALL DIMENSIONS SHOWN ARE TAKEN FROM FINISH MATERIAL
- 3. SEE SHEET A10 FOR PARTITION TYPES
- 4. NOT USED
- 5. X = RESTROOM ACCESSORY - SEE 3/A40
- 6. RESTROOM ENTRY DOORS SHALL CONFORM TO THE FOLLOWING: DOOR CLOSERS SHALL BE ADJUSTED SO THAT FROM AN OPEN POSITION OF 90 DEGREES, THE TIME REQUIRED TO MOVE THE DOOR TO A POSITION OF 12 DEGREES FROM THE LATCH IS 5 SECONDS MINIMUM.

- 7. INSULATE HOT WATER PIPES AND DRAIN PIPES TYPICAL
- 8. MOUNT H.C. SIGN 5'-0" AFF TO CENTER OF SIGN



- 9. ALL NEW TOILET ROOM & STALL DOORS TO HAVE FACEBC 2020 COMPLIANT HARDWARE

- 10. TOILET ROOM DOORS SHALL HAVE SELF-CLOSING HINGES & LEVER HARDWARE

- 11. TOILET STALL DOORS SHALL BE LINED W/ NON-ABSORBENT MATERIAL TO A HEIGHT MIN 4'-0" AFF

- 12. THE WALLS & FLOORS OF TOILET ROOMS & STALLS SHALL BE LINED W/ NON-ABSORBENT MATERIAL TO A HEIGHT MIN 4'-0" AFF

- 13. CONCRETE FLOOR SLAB REPAIR SHALL BE 5" CONC. SLAB W/ 6X6-W/4XU/4 WUF ON 6 MIL VAPOR BARRIER OVER 12" MIN. CLEAN COMPACTED FILL W/ TERMITE TREATMENT. TIE NEW SLAB INTO EXISTING SLAB/STRUCTURE W/ #3 @ 2'-0". EPOXY W/ MIN. 6" EMBED.

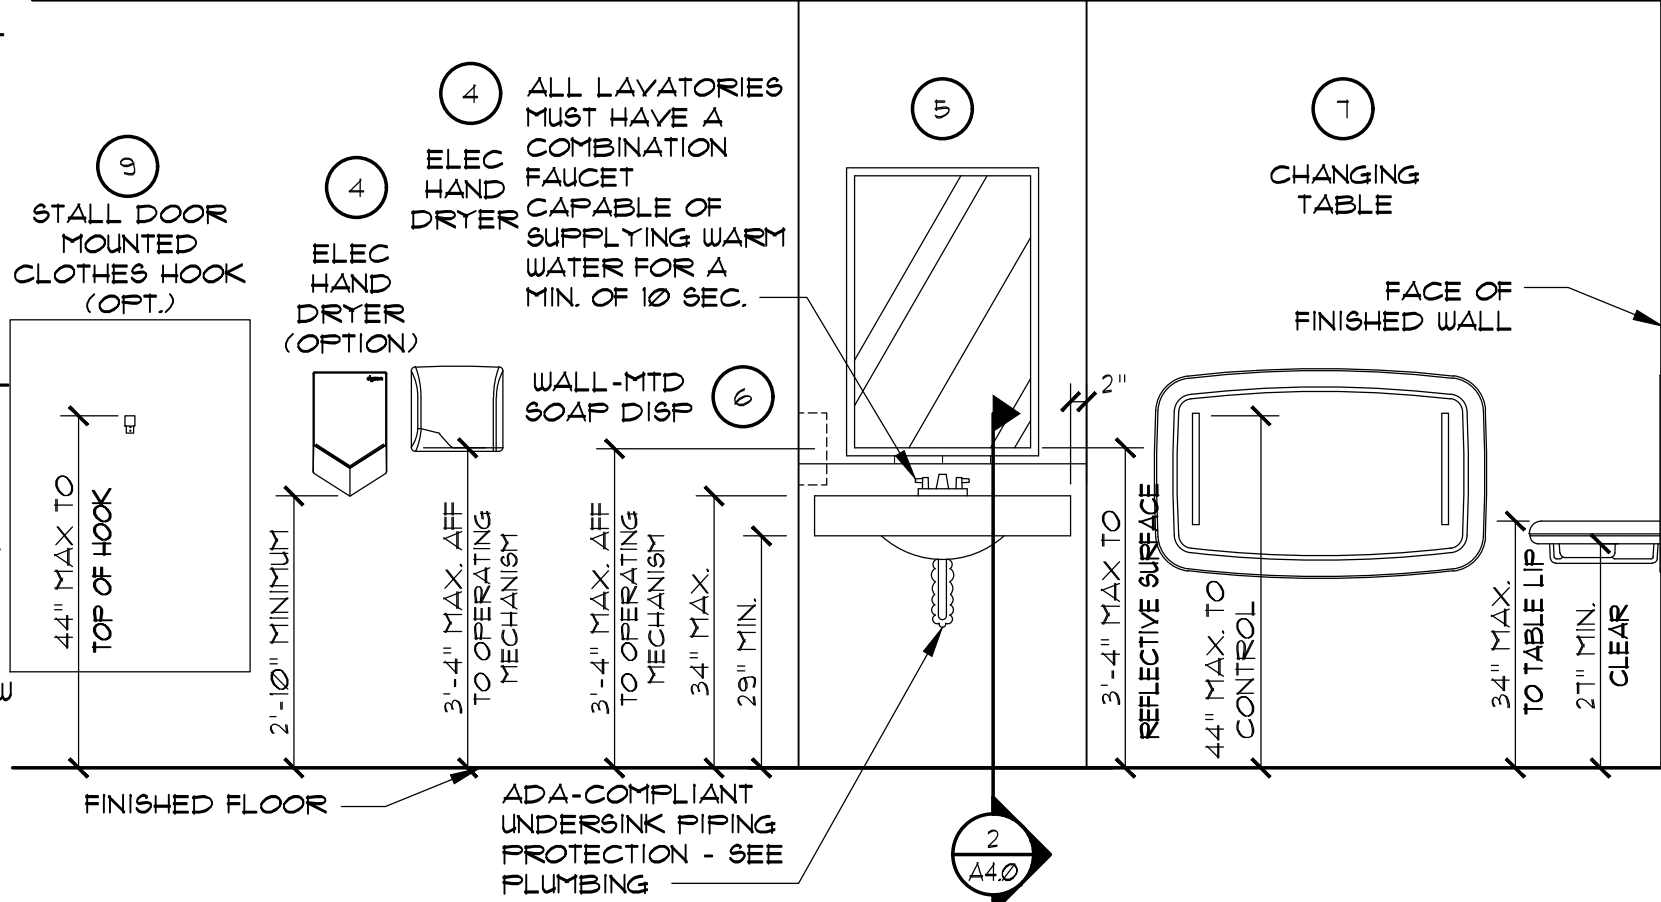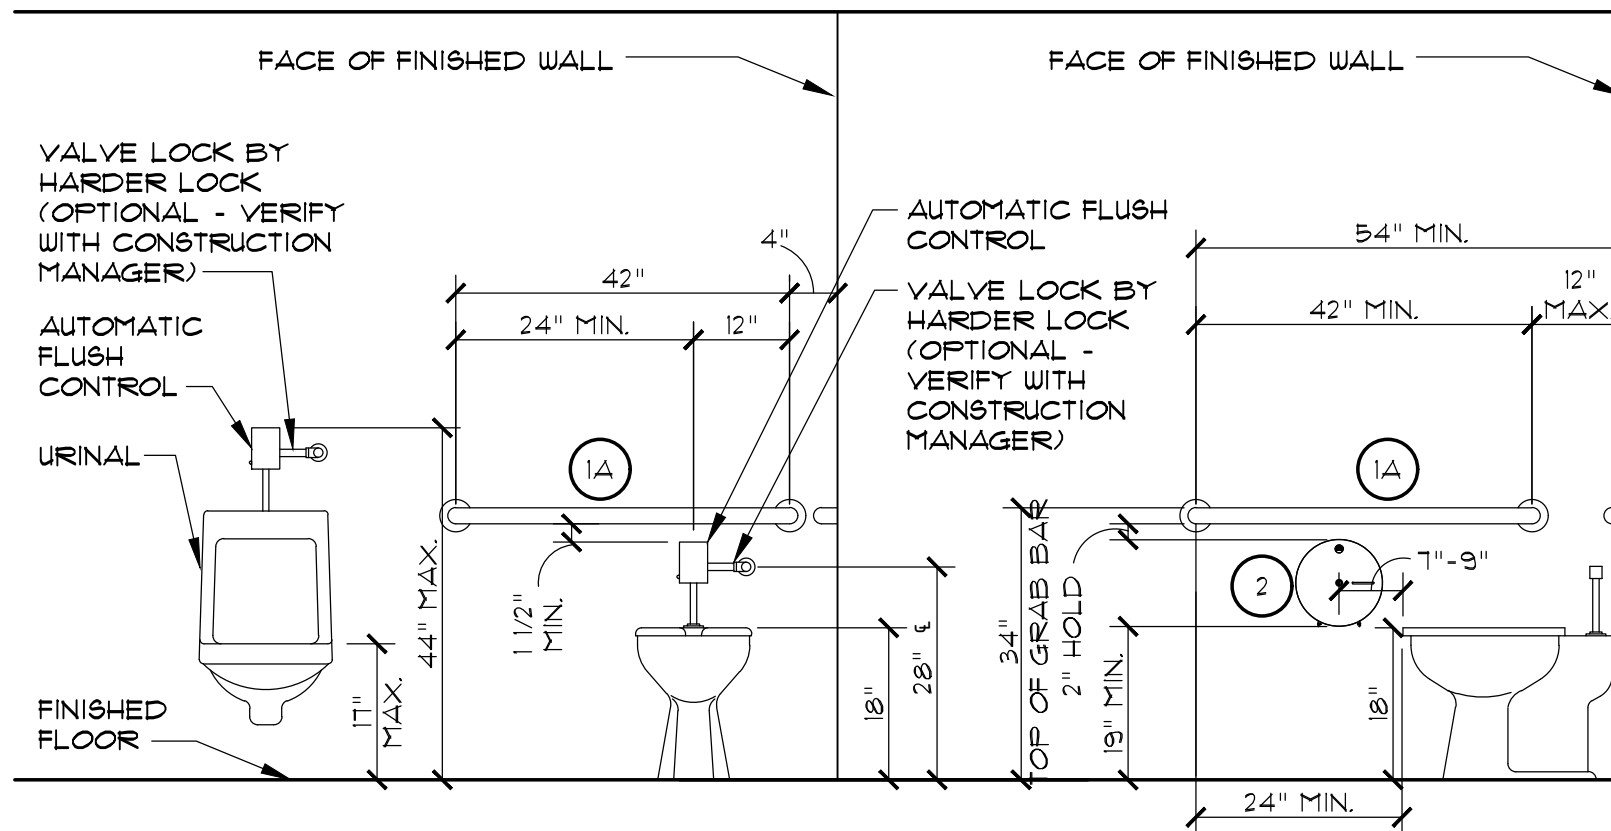

4 RESTROOM FIXTURE & ACCESSORY ELEVATIONS

1/2" = 1'-0"

GENERAL NOTES

- 1. INTERIOR DIMENSIONS ARE TO FACE OF FINISH WALL.
- 2. DO NOT SCALE DRAWINGS.
- 3. MINIMUM INTERIOR FINISH CLASSIFICATION: OCCUPANCY: A2 NONSPRINKLERED EXIT ENCLOSURES AND EXIT PASSAGEWAYS: A CORRIDORS: A ROOMS AND ENCLOSED SPACES: B
- 4. MATCH EXISTING FINISHES UNO TYP.
- 5. GC TO REQUEST & FOLLOW ADA REPORT WHEN AVAILABLE
- 6. GC TO PROVIDE ADA SIGNAGE PACKAGE AND INSTALL SIGNS AT LOCATIONS AND POSITIONS INDICATED IN PACKAGE OR AS REQUIRED BY LOCAL CODES. SIGNAGE PACKAGE SUPPLIED BY: FORREST PERMA-SIGN, 1-800-214-8165 9292 1ST ST., BOX 588, NEW ROCHELLE, NY 10802 www.forrestpermasigns.com

WALL LEGEND

- EXISTING CONSTRUCTION
- NEW CONSTRUCTION
- EXISTING CONSTRUCTION TO BE REMOVED

GC TO VERIFY EXISTING DIMENSIONS BEFORE CONSTRUCTION. ANY DISCREPANCIES NEED TO BE BROUGHT TO THE IMMEDIATE ATTENTION OF THE ARCHITECT OF RECORD.

1 PROPOSED RESTROOM PLAN

1/2" = 1'-0"

ITEM (SEE NOTE 2)	MANUF. MODEL #	SUPPLIER	BACKUP SUPPORT (SEE NOTE 3)
1A GRAB BAR 42"	BRADLEY B-6806X42	HUGHES SUPPLY (866) 310-3576	(1/2x6 4'-0" LONG CENTER MOUNTED
2 TOILET TISSUE DISPENSER JUMBO, SURFACE MOUNTED	BRADLEY 5424	HUGHES SUPPLY (866) 310-3576 MCDCOORD@HAJOCACOM	
3 NOT USED			
4 HAND DRYER, ENERGY EFFICIENT MODEL, ADA, ALUMINUM BRUSHED	WORLD DRYER L-911 911MDR1	HUGHES SUPPLY (866) 310-3576 MCDCOORD@HAJOCACOM	FRAME WALL OPENING PER MANUFACTURER'S RECOMMENDATIONS
4 HAND DRYER, ENERGY EFFICIENT MODEL, ADA, STAINLESS STEEL	DYSON AIRBLADE V	HUGHES SUPPLY (866) 310-3576 MCDCOORD@HAJOCACOM	
5 MIRROR, CHANNEL FRAME	BOBRICK B-165 2436	HUGHES SUPPLY (866) 310-3576 MCDCOORD@HAJOCACOM	
6 SOAP DISPENSER, WALL-MOUNTED	BOBRICK B-2112	HUGHES SUPPLY (866) 310-3576 MCDCOORD@HAJOCACOM	
7 BABY CHANGING TABLE, HORIZONTAL, RECESSED, ADA COMPLIANT, STAINLESS STEEL	KOALA KARE KB310-SSRE	HUGHES SUPPLY (866) 310-3576 MCDCOORD@HAJOCACOM	INSTALL PER MANUFACTURER'S RECOMMENDATIONS
7 BABY CHANGING TABLE, HORIZONTAL, SURFACE MOUNT, ADA COMPLIANT, STAINLESS STEEL	KOALA KARE KB310-SSUM	HUGHES SUPPLY (866) 310-3576 MCDCOORD@HAJOCACOM	INSTALL PER MANUFACTURER'S RECOMMENDATIONS
8 CLOTHES HOOK	BRADLEY 911	HUGHES SUPPLY (866) 310-3576 MCDCOORD@HAJOCACOM	

NOTES

- 1) SEE 4/A40 FOR ACCESSORY MOUNTING HEIGHTS
- 2) CUT BACK-UP SUPPORTS BETWEEN STUDS SO FACE OF SUPPORT IS FLUSH W/ WALL STUD
- 3) VERIFY WALL-MOUNTED SOAP DISPENSER MODEL # WITH McDONALD'S PROJECT MANAGER
- 4) TOILET TISSUE DISPENSER ALTERNATE - SCOTT JUMBO JRT. VERIFY W/ McDONALD'S PROJECT MANAGER. INSTALL PER FACEBC 2020 & MANUFACTURE'S SPECS
- 5) BACKING FOR GRAB BARS & CABINETS SHALL BE A 2x6 SCREWED TO METAL STUDS W/ DRYWALL SCREWS, COVERED W/ 1/2" PLYWOOD. DIMENSIONS SHALL BE THE WIDTH OF THE GRAB BARS & CABINETS AS SHOWN ON THE PLANS
- 6) SELECT ONE ITEM FROM ITEM GROUPS 4 & 7, VERIFY WITH AREA CONSTRUCTION MANAGER.

3 RESTROOM ACCESSORY SCHEDULE

1/2" = 1'-0"

ENTIRE SHEET CHANGED

Digitally signed by Scott Purdy
Date: 2022.10.12 13:18:49 -04'00'
Purdy+ Muroff Architecture, Inc.
1711 North Himes Avenue, Tampa, Florida 33607
PH: 813.353.0035 FAX: 813.353.4350 Web Site: www.purdy+muroff.com

McDonald's USA, LLC
These drawings and specifications are the confidential and proprietary property of McDonald's USA, LLC and shall not be copied or reproduced without written authorization. The contract documents were prepared by McDonald's USA, LLC and shall not be used for any other project. Use of these drawings for reference or example on another project requires the contract documents for reuse on another project is not authorized.

PREPARED FOR: McDonald's USA, LLC
DRAWN BY: CWS
STD. ISSUE DATE: 2019.08.19
REVIEWED BY: SJP
DATE ISSUED: 2019.08.19
SITE ADDRESS: 481 SW MAIN BLVD LAKE CITY, FL 32025-5207
NAT # 15440
SITE ID 009-1231
SHEET NO. 1802.471
A4.0
AA-0003276

GENERAL NOTES

1. ALL WORK SHALL CONFORM WITH THE LATEST ADOPTED EDITIONS OF THE FLORIDA BUILDING CODE, BUILDING (FBC-B) SEVENTH EDITION (2020), FLORIDA BUILDING CODE, PLUMBING (FBC-P) SEVENTH EDITION (2020), FLORIDA BUILDING CODE, MECHANICAL (FBC-M) SEVENTH EDITION (2020), FLORIDA BUILDING CODE, FUEL GAS (FBC-FG) SEVENTH EDITION (2020), FLORIDA FIRE PREVENTION CODE (FFPC) SEVENTH EDITION (2020), NATIONAL ELECTRICAL CODE (NEC) 2017 EDITION, NATIONAL FIRE PROTECTION ASSOCIATION (NFPA) 1 - FIRE CODE (2018), NFPA 101 - LIFE SAFETY CODE 2018, FLORIDA ACCESSIBILITY CODE SEVENTH EDITION (2020) & ALL OTHER APPLICABLE LOCAL, STATE, & FEDERAL CODES & ORDINANCES & ALL AUTHORITIES HAVING LOCAL JURISDICTION.
2. THESE CONSTRUCTION DOCUMENTS HAVE BEEN PREPARED FROM THE MOST COMPLETE INFORMATION AVAILABLE TO THE ARCHITECT. ALL DATA ON EXISTING CONSTRUCTION CONDITIONS ARE APPROXIMATE & SHALL BE VERIFIED PRIOR TO COMMENCING ANY WORK.
3. IT SHALL BE THE SUBCONTRACTOR'S RESPONSIBILITY TO PERSONALLY FIELD INSPECT THE JOB SITE PRIOR TO SUBMITTING HIS BID. THE INSPECTION IS REQUIRED SO THAT THE CONTRACTOR SHALL BE TOTALLY FAMILIAR W/ THE EXISTING CONDITIONS & THEIR INTERFACE W/ THE NEW CONSTRUCTION AS DEFINED IN THESE CONSTRUCTION DOCUMENTS.
4. THE SUBCONTRACTOR SHALL PERFORM ALL WORK IN ACCORDANCE W/ THE LATEST EDITION OF THE GENERAL CONDITIONS OF THE CONTRACT, AIA DOCUMENT A201, A COPY OF THIS DOCUMENT IS AVAILABLE @ THE CONTRACTORS OFFICE UPON REQUEST.
5. ANY ADJUSTMENT TO THE CONSTRUCTION CONTRACT, ADDITIONS, DELETIONS OR CHANGE ORDERS, SHALL BE APPROVED BY THE OWNER, GENERAL CONTRACTOR, & ARCHITECT IN WRITING.
6. DURING THE CONSTRUCTION PHASE, THE ADMINISTRATION OF THE CONSTRUCTION CONTRACT SHALL BE PERFORMED BY THE MCDONALD'S CONSTRUCTION MANAGER.
7. ALL WORK (EQUIPMENT, MATERIALS, & LABOR) SHALL HAVE A MINIMUM WRITTEN GUARANTEE FOR A PERIOD OF ONE (1) YEAR, UNLESS SPECIFIED OTHERWISE, FROM THE DATE OF SUBSTANTIAL COMPLETION AGAINST ANY DEFECTS IN SAID WORK, W/ APPROPRIATE REPAIR OR REPLACEMENT @ NO ADDITIONAL COST TO THE OWNER.
8. ALL MATERIALS & EQUIPMENT SHALL BE INSTALLED IN A NEAT & FIRST CLASS WORKMANLIKE MANNER. THE ARCHITECT RESERVES THE RIGHT TO DIRECT THE REMOVAL & REPLACEMENT OF ANY ITEM, IN HIS OPINION, THAT DOES NOT PRESENT AN ORDERLY & REASONABLY NEAT OR WORKMANLIKE APPEARANCE. THE REMOVAL & REPLACEMENT SHALL BE DONE WHEN DIRECTED BY THE GENERAL CONTRACTOR, & W/OUT ADDITIONAL COST TO THE OWNER.
9. THE CONTRACTOR SHALL COMPLY W/ THE MANUFACTURER'S INSTRUCTIONS & RECOMMENDATIONS TO THE EXTENT PRINTED INFORMATION IS MORE DETAILED OR STRINGENT THAN REQUIREMENTS CONTAINED DIRECTLY IN THE PLANS.
10. CONTRACTOR SHALL MAINTAIN ORDERLY HOUSEKEEPING DURING THE PROCESS OF CONSTRUCTION & UPON COMPLETION SHALL THOROUGHLY CLEAN ALL AREAS. FINAL CLEAN UP SHALL INCLUDE THE FOLLOWING:
A. SWEEPING FLOORING.
B. DUSTING & REMOVAL OF DIRT, PAINT DRIPPINGS, OIL, GREASE, & OTHER BLEMISHES FROM ALL SURFACES, INCLUDING PIPING & EQUIPMENT.
C. WINDOWS, GLASS LIGHTS, & MIRRORS SHALL BE WASHED & CLEANED.
D. PAINT OVERLAPS & PUTTY SMEARS SHALL BE REMOVED.
E. HARDWARE SHALL BE CLEANED & POLISHED W/ FLANNEL CLOTH.
11. WORK TO BE DONE CONSISTS OF FURNISHING ALL MATERIALS, LABOR, EQUIPMENT, TOOLS, & ALL ITEMS & SERVICES REQUIRED FOR CONSTRUCTION IN CONFORMITY W/ GENERAL NOTES & PLANS.
12. THE PLANS SHOW THE LOCATION OF ALL FIXTURES & EQUIPMENT & ARE INTENDED TO CONVEY THE GENERAL INTENT OF THE WORK IN SCOPE & LAYOUT. THEY ARE NOT INTENDED TO SHOW IN MINUTE DETAIL EVERY & ALL OF THE ACCESSORIES INTENDED FOR THE PURPOSE OF EXECUTION OF THE WORK, BUT IT IS UNDERSTOOD THAT SUCH DETAILS ARE PART OF THIS WORK.
13. THE SUBCONTRACTORS SHALL REMOVE ALL CONSTRUCTION RUBBISH, SCAFFOLDING, EQUIPMENT, TEMPORARY PROTECTION, TEMPORARY FIELD STRUCTURES, & OTHER COMPONENTS WHICH WERE REQUIRED IN CONNECTION W/ THE CONSTRUCTION, BUT NOT A PERMANENT PART THEREOF.
14. THE CONTRACTOR SHALL OBTAIN ALL NECESSARY PERMITS & INSPECTIONS REQUIRED FOR THE WORK & PAY ALL CHARGES INCIDENTAL THERETO.
15. PROVIDE DOOR HARDWARE IN CONFORMANCE W/ ADA REQUIREMENTS.
16. THE SUBCONTRACTOR SHALL FURNISH ALL MISCELLANEOUS FACILITIES AS NEEDED, INCLUDING TEMPORARY STAIRS, TEMPORARY RAMPS, LADDERS, RUNWAYS, STAGING, SHORING, SCAFFOLDING, BRIDGES, RAILING, BRACING, BARRIERS, CLOSURES, PLATFORMS, TEMPORARY PARTITIONS, WASTE CHUTES, & SIMILAR ITEMS.
17. THE SUBCONTRACTOR SHALL PROTECT ALL CONSTRUCTION COMPONENTS DURING THE COURSE OF PAINTING & SHALL PROMPTLY CLEAN ALL RESIDUE, SPLATTER OR OVERSPRAY UPON COMPLETION OF HIS WORK. THE CONTRACTOR SHALL USE DROP CLOTHS, MASKING, & OTHER SHIELDING DEVICES TO THE GREATEST EXTENT PRACTICAL TO PROTECT ALL ITEMS NOT TO BE PAINTED OR THOSE ITEMS WHICH HAVE ALREADY RECEIVED FINAL FINISH COATS.
18. ALL PAINTING REQUIRED FOR THIS PROJECT SHALL BE PERFORMED IN ACCORDANCE W/ THE MANUFACTURER'S SPECS FOR PRODUCT HANDLING, SURFACE PREPARATION, PAINTING APPLICATION, CURING/DRYING TIME BETWEEN COATS, CLEANING & PROTECTION OF PAINTED SURFACES UNTIL THE SOURCE OF CONSTRUCTION IS COMPLETE. PAINT COLORS TO BE SELECTED FOR THESE DOCUMENTS ARE AS MANUFACTURED BY BY GILDED DIVISION OF SCM CORP. ALTERNATE ACCEPTABLE MFR ARE AS FOLLOWS: BENJAMIN MOORE, D.P.I., RUSTOLEUM, PRATT LAMBERT, SHERWIN-WILLIAMS.
19. ALL DRYWALL PARTITIONS ARE DIMENSIONED CENTERLINE TO CENTERLINE UNLESS OTHERWISE NOTED. ALL MASONRY PARTITIONS ARE DIMENSIONED OUT TO OUT.
20. ELECTRICAL PANELS, FIRE EXTINGUISHER CABINETS, ETC., LOCATED IN RATED PARTITIONS SHALL BE BACKED W/ DRYWALL AS REQUIRED TO MAINTAIN RATING. CONTRACTOR TO VERIFY WALL THICKNESSES REQUIRED FOR ALL ELECTRICAL PANELS, FIRE EXTINGUISHER PANELS, ETC.
21. PROVIDE DOUBLE STUDS & BLOCKING WHERE REQUIRED TO SUPPORT MISCELLANEOUS ITEMS, I.E. TYPICAL CASEWORK, CABINETS, GRAB BARS, ETC. CONTRACTOR SHALL FURNISH & INSTALL ALL BACK-UP SUPPORTS.
22. DO NOT SCALE DRAWINGS. IF DIMENSIONS ARE IN QUESTION, THE CONTRACTOR SHALL BE RESPONSIBLE FOR OBTAINING CLARIFICATION FROM THE OWNER'S REPRESENTATIVE BEFORE CONTINUING W/ CONST.
23. CONTRACTOR SHALL VERIFY ALL DIMENSIONS & COORDINATE ALL TRADES.
24. CONTRACTOR SHALL VERIFY ALL EQUIPMENT LOCATIONS & DIMENSIONS OF EQUIPMENT.
25. REVIEW ALL ELECTRICAL LOCATIONS W/ OWNER BEFORE SIGN OFF FOR DRYWALL.
26. ALL THRESHOLDS & FLOOR FINISH CHANGES TO BE PLACED UNDER CENTERLINE OF DOOR UNLESS OTHERWISE NOTED.
27. COORDINATE TELEPHONE & SECURITY W/ OWNER BEFORE PROCEEDING.
28. ROOF CONSTRUCTION IS NOT LIGHT FRAME TRUSS
29. A SEPARATE PERMIT SHALL BE REQUIRED FOR THE FIRE SUPPRESSION SYSTEM
30. ALL INSULATION MATERIALS TO HAVE A FLAME SPREAD INDEX OF NOT MORE THAN 25 AND A SMOKE-DEVELOPED INDEX OF NOT MORE THAN 450 PER THE FBC 719.2
31. CONCRETE FLOOR SLAB REPLACEMENT SHALL BE 5" CONC. SLAB W/ 6X6-W/4XW/4 WUF ON 6 MIL VAPOR BARRIER OVER 12" MIN. CLEAN COMPACTED FILL W/ TERMIT TREATMENT. TIE NEW SLAB INTO EXISTING SLAB/STRUCTURE W/ "3 @ 2'-0". EPOXY W/ MIN. 6" EMBED.

SYMBOLS & IDENTIFICATION LEGEND

ROOM IDENTIFICATION	ROOM NAME 201	FLOOR / LEVEL ROOM NUMBER
DRAWING IDENTIFICATION	2 A6	DRAWING NUMBER SHEET NUMBER
INTERIOR/CASEWORK ELEVATION IDENTIFICATION	2-A4	DRAWING NUMBER INDICATION OF DIRECTION SHEET NUMBER
SECTION CUT INDICATION	3 A6	DRAWING NUMBER INDICATION OF DIRECTION SHEET NUMBER
PLAN OR SECTION DETAIL INDICATION	3 A4	DRAWING NUMBER DETAILED AREA SHEET NUMBER
SUPPLEMENTARY DRAWING INDICATION (BOUND IN PROJECT MANUAL), ELEVATION, SECTION CUT, & PLAN DETAIL NOTATIONS SIMILAR TO ABOVE	SD-1 22	DRAWING NUMBER PAGE NUMBER
DOOR IDENTIFICATION	22	SEE SCHEDULE
WINDOW/GLAZING IDENTIFICATION	7	SEE SCHEDULE
SPECIFIC NOTES	8	NOTES WHICH APPLY TO SPECIFIC ITEM OR ITEMS ON THE DRAWING WHERE INDICATED
GENERAL NOTES	10	NOTES WHICH APPLY TO ALL DRAWINGS
FURNITURE &/OR EQUIPMENT IDENTIFICATION	101	SEE SCHEDULE
ELEVATION SYMBOL	FIN FLOOR ELEV 100'-0"	ELEVATION HEIGHT SURFACE DESCRIPTION
REVISION SYMBOL		REVISION NUMBER DATE REVISED
PARTITION TAG	A1	DRAWING NUMBER

FLORIDA BUILDING CODE DATA

CLASSIFICATION BY OCCUPANCY	ASSEMBLY	GROUP	A-2
MIXED OCCUPANCY	NO	SEPARATION BY OCCUPANCY	NONE
TYPE OF CONSTRUCTION	PROTECTED SPRINKLERED	HR YES	UNPROTECTED V (B) NO
BUILDING VARIABLES	REQUIRED & ALLOWED	PROVIDED	
BUILDING HEIGHT & HEIGHT INCREASES	40'	21'-4"	
NUMBER OF STORIES	1	1	
BUILDING AREA / FLOOR AREA INCREASES	6,000 GSF	2,408 GSF±	
OCCUPANT LOAD / FLOOR AREA / PERSON	FIXED SEATS	20	
EGRESS WIDTH / PERSON	1ST FLR 2 / 40"	12"	
LENGTH OF DEAD END	20'	0'	
MAXIMUM DISTANCE TO AN EXIT	200'	48'	
MINIMUM NUMBER OF EXITS	2	2	
FIRE PROTECTION REQUIREMENTS			
STRUCTURAL FRAME - INCLUDING COLUMNS, GIRDERS, TRUSSES	0	0	
BEARING WALLS - EXTERIOR INTERIOR	0 0	0 0	
NONBEARING WALLS AND PARTITIONS - EXTERIOR	≥ 30 0	0	
NONBEARING WALLS AND PARTITIONS - INTERIOR	0	0	
FLOOR CONSTRUCTION - INCLUDING SUPPORTING BEAMS & JOISTS	0	0	
ROOF CONSTRUCTION - INCLUDING SUPPORTING BEAMS & JOISTS	0	0	

INDEX OF DRAWINGS ARCHITECTURAL

- C5 COVER SHEET
A1 ARCHITECTURAL REFERENCE SHEET
D10 DEMOLITION PLAN & NOTES
A10 FLOOR PLAN & GENERAL NOTES
A20 ELEVATIONS, KIOSK INFO & MONITOR DETAIL
A30 DNE WALL ELEVATIONS, SECTION & DETAILS
A40 TOILET PLAN

ELECTRICAL

- E10 ELECTRICAL LIGHTING PLAN
E20 ELECTRICAL POWER PLAN
E30 ELECTRICAL EQUIPMENT SCHEDULE
E40 ELECTRICAL ELEVATION & DETAIL

MATERIAL DESIGNATIONS

ELEVATION / PLAN	SECTION
CERAMIC TILE / QUARRY TILE	GLAZING
MASONRY RUNNING BOND	CONCRETE BLOCK
CONCRETE / STUCCO / GROUT	ROCK
BRICK	CONT WOOD BLOCKING
	CUT STONE
	FINISHED WOOD
	METAL (LARGE SCALE)
	GRANULAR FILL
	STRUCTURAL CONCRETE
	WOOD BLOCKING

ARCHITECTURAL ABBREVIATIONS

AFB ABOVE FINISHED FLOOR	CI CAST IRON	DN DOWN	FT FEET	HC HANDICAPPED	MECH MECHANICAL	OD OUTSIDE DIAMETER	SCH SCHEDULE	TH THRESHOLD
ADJ ADJUSTABLE	CB CATCH BASIN	DUG DRAWING	FND FEMININE NAFKIN DISPOSAL	HUD HARDWARE	MT METAL		SNT SEALANT	TKBD TACKBOARD
AC AIR CONDITIONER	CLG CEILING	DF DRINKING FOUNTAIN	FNV FEMININE NAFKIN VENDOR	HT HEIGHT	MF METAL FRAME	FBML PAPER-BACKED METAL LATH	SHT SHEET	TFH TOILET PAPER HOLDER
ALT ALTERNATE	CEM CEMENT		FIN FINISH	HORIZ HORIZONTAL	MRD METAL ROOF DECK	FTD PAPER TOWEL DISPENSER	SHO SHOWER	T & G TONGUE & GROOVE
ALUM ALUMINUM	CE CENTERLINE	EA EACH	FE FIRE EXTINGUISHER		MIN MINIMUM	PTH PAPER TOWEL HOLDER	SHOC SHOWER CONTROLS	TB TOWEL BAR
AB ANCHOR BOLT	CHBD CHALKBOARD	E EAST	FECR FIRE EXTINGUISHER CABINET RECESSED		MIR MIRROR	PLAS PLASTER	SHOH SHOWER HEAD	TYP TYPICAL UNLESS OTHERWISE NOTED
& AND	CH COAT HOOK	ELEC ELECTRICAL		INCL INCLUDE	MISC MISCELLANEOUS	PLYWD PLYWOOD	SIM SIMILAR	U URINAL
∠ ANGLE	COL COLUMN	EHD ELECTRIC HAND DRYER	FH FIRE HYDRANT	ID INSIDE DIAMETER	MR MOISTURE RESISTANT	PT PRESSURE TREATED	SD SOAP DISPENSER	
APPROX APPROXIMATELY	CONC CONCRETE	EUC ELECTRIC WATER COOLER	FL FLOOR	JT JOINT	MBH MOP & BROOM HOLDER		SH SOAP HOLDER	
@	CONST CONSTRUCTION	ELEV ELEVATION	FD FLOOR DRAIN	LAM LAMINATE	MTD MOUNTED		S SOUTH	VERT VERTICAL
	CONTR CONTINUOUS	ENCL ENCLOSED / ENCLOSURE	FM FRAMED MIRROR	LAV LAVATORY		R RADIUS	SPECS SPECIFICATIONS	
BD BOARD	CONTR CONTRACTOR	EQ EQUIP				RECT RECESSED PAPER TOWEL DISPENSER	SQ SQUARE	WR WASTE RECEPTICAL
BM BEAM	CJ CONTROL JOINT	EXIST EXISTING	GALV GALVANIZED			REIN RECTANGULAR REINFORCEMENT	SS STAINLESS STEEL	WC WATER CLOSET
BLK BLOCK		EJ EXPANSION JOINT	GA GAUGE	MH MAN HOLE		REQD REQUIRED	STD STANDARD	WH WATER HEATER
BRK BRICK		EXP EXPOSED	GB GRAB BAR	MFR MANUFACTURER		ROOF ROOF DRAIN	STL STEEL	W WEST
BLDG BUILDING		EXT EXTERIOR	GWB GYPSUM WALLBOARD	MO MASONRY OPENING		RM ROOM	STR STRUCTURAL	W/ WITH
CAB CABINET		EGCB EXTERIOR GYPSUM CEILING BOARD	GYP GYPSUM	MATL MATERIAL		RO ROUGH OPENING	STUD STRUCTURAL METAL STUD	W/O WITHOUT
CPT CARPET				MAX MAXIMUM				

PREPARED BY:
Purdy+ Muroff
Architecture, Inc.
1711 North Himes Avenue, Tampa, Florida 33607
Ph: 813.353.0035 Fax: 813.353.4350 Web Site: www.purdymuroff.com

Digitally signed by
Scott Purdy
Date: 2022.10.12 12:51:25 -0400

PREPARED FOR:
McDonald's USA, LLC
These drawings and specifications are the confidential and proprietary property of McDonald's USA, LLC and shall not be copied or reproduced without written authorization. The contract documents were prepared by McDonald's USA, LLC and shall not be used for any other project not suitable for use on a different site or at a later time. Use of these drawings for reference or example on another project requires the contract documents for reuse on another project is not authorized.

DRAWN BY
YB
STD
ISSUE DATE
REVIEWED BY
SJP
DATE ISSUED
2019.08.19

McDonald's USA, LLC
EOTF PROGRAM
DESCRIPTION
1802.471
AR1
AA-0003276

SITE ADDRESS
491 SW MAIN BLVD LAKE CITY, FL 32025-5207

SHEET NO.
009-1231

NAT #
15440



DATE
10.05.22

REV
1

Updated Decor

DESCRIPTION

DJ
BY

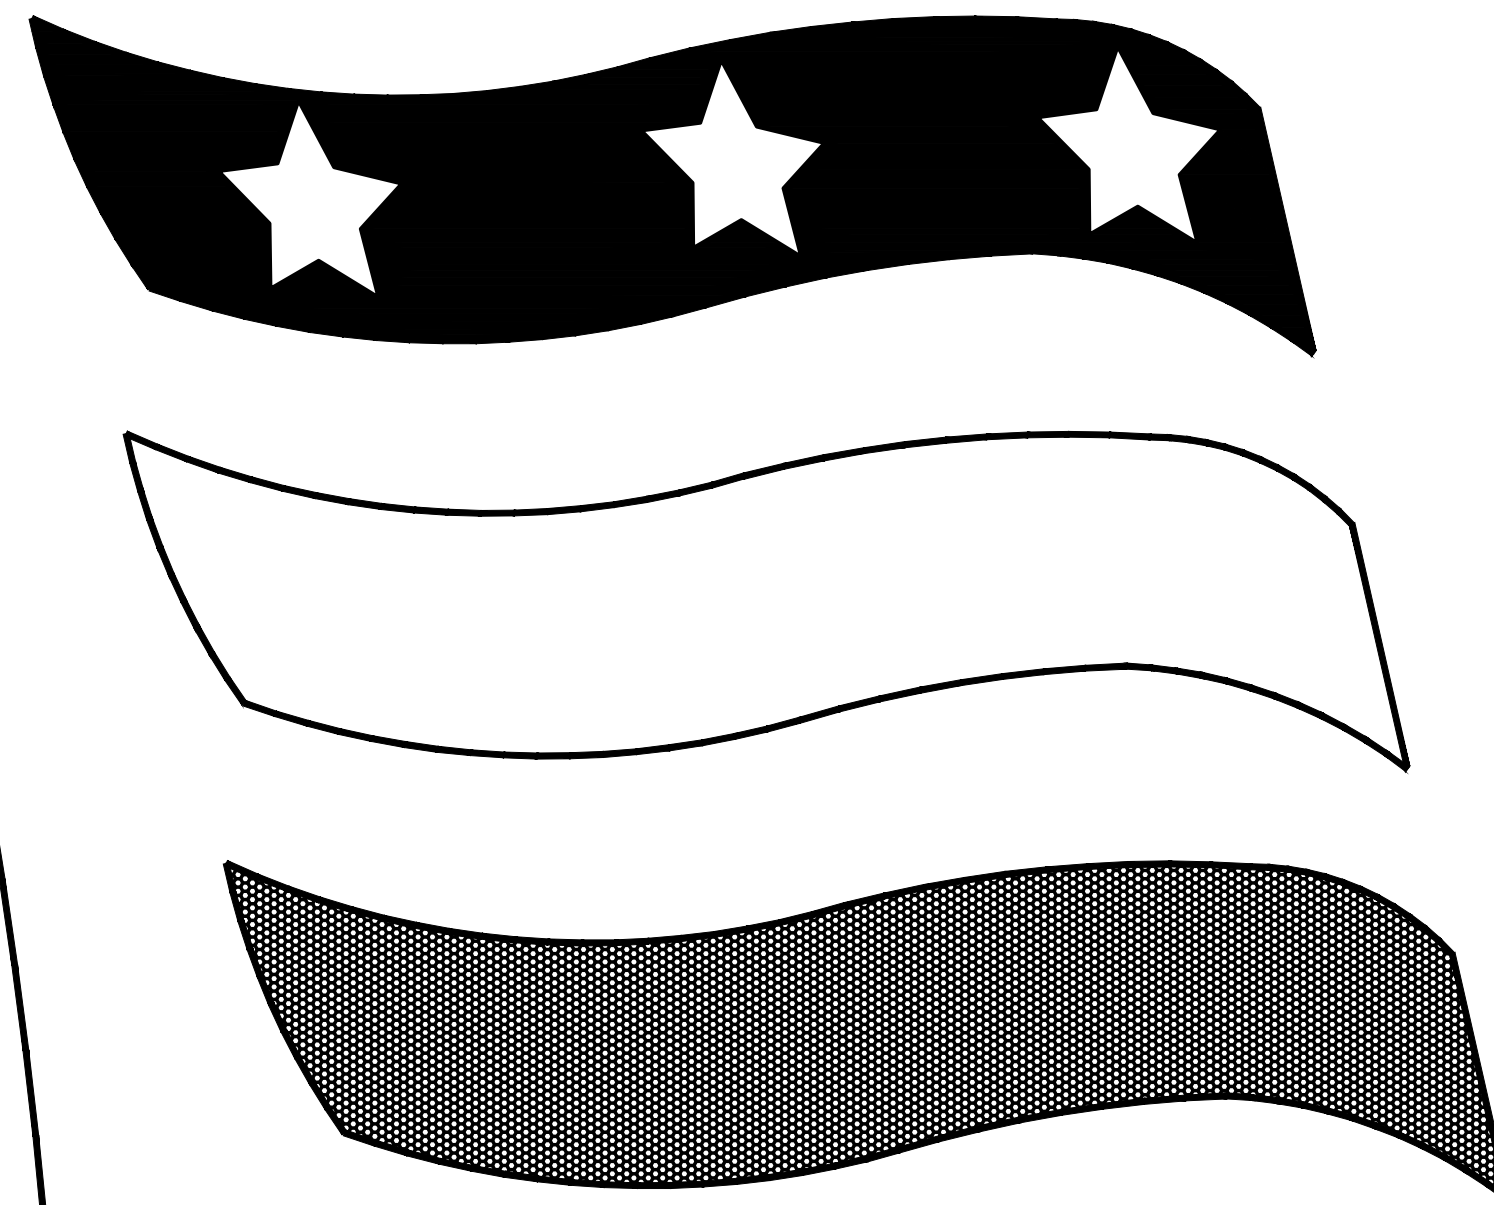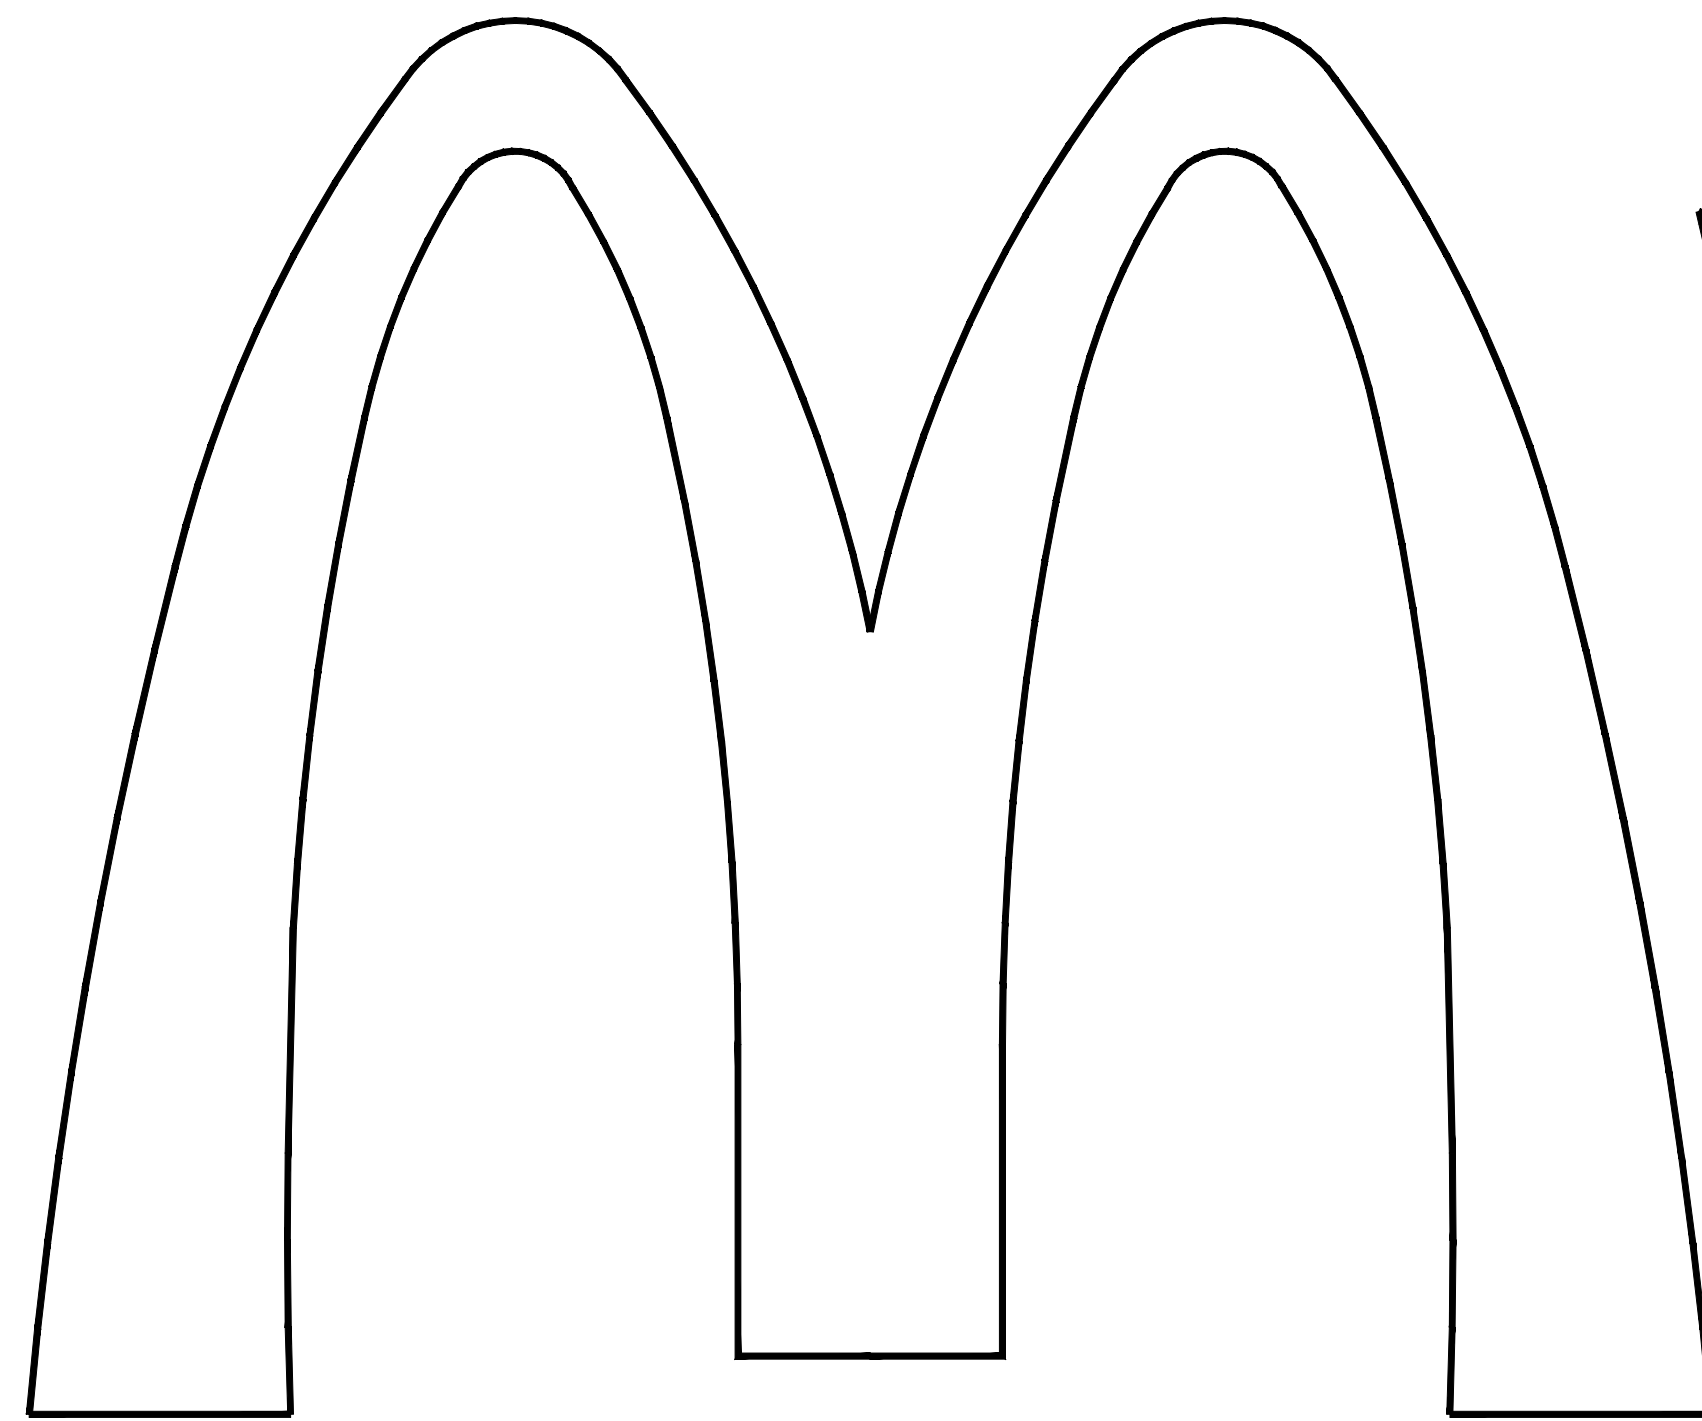

1802.471

McDonald's USA, LLC

TITLE: CYT EOTF PROGRAM

SITE ADDRESS: 491 SW MAIN BLVD LAKE CITY, FL 32025-5207

ST/SITE#: 009-1231, NAT# 15440

Purdy+Muroff Architecture, Inc.

1711 North Himes Avenue, Tampa, Florida 33607, Ph 813/353-0035 Fax 813/353-4350 Website: www.purdymuroff.com

EMERALD ENGINEERING, INC. 
9942 CURRIE DAVIS DR., STE H
TAMPA, FLORIDA 33619 (813) 995-0300

DESIGNER OF RECORD:				
DISCIPLINE:	NAME:	EMAIL ADDRESS:	PHONE #:	LICENSE #:
ARCHITECT:	SCOTT J. PURDY	SPURDY@PURDYMUROFF.COM	813-353-0035	FL AR 91876
ELECTRICAL:	ADAM POWELL	APOWELL@EMERALDMEP.COM	813-995-0300	FL PE 13853
				
DESIGNER OF RECORD:				
NAME:	MAILING ADDRESS:	EMAIL ADDRESS:	PHONE #:	
MANAGER: DJ PRIETO	1711 N HIMES AVE, TAMPA, FL 33607	DPRIETO@PURDYMUROFF.COM	813-353-0035	



Digitally signed by Scott Purdy
Date: 2022.10.12 12:52:21 -04'00'

SCOTT J. PURDY
AR 91876

DATE
ISSUE 08/19/19
REV 1 10/25/22
REV 2

LAKE CITY II
1802.471



GENERAL DEMOLITION NOTES

1. REPAIR & PATCH WALLS WHERE NECESSARY TO MATCH & TO RECEIVE PAINT/WALLPAPER
2. FIELD VERIFY ELECTRICAL DEMOLITION W/ MCDONALDS CONSTRUCTION MGR.
3. THE CONTRACTOR MAY DETERMINE THAT THE COST OF REMOVAL & REPLACEMENT OF EXISTING WALLS IS LESS EXPENSIVE THAN KEEPING EXISTING WALLS. IT IS THE CONTRACTORS PREROGATIVE TO DEMO EXISTING WALLS @ NO ADDITIONAL EXPENSE TO THE OWNER.
4. CONTRACTOR TO FIELD VERIFY SUBSTRATES BELOW FLOOR FINISHES FOR ANY CONDITIONS THAT MAY AFFECT THE COST OF INSTALLATION OF THE SPECIFIED MATERIAL.
5. CLEAN & LEVEL FLOOR AS REQUIRED IN DEMO OR SPECIFIED AREAS.
6. CONTRACTOR TO DISPOSE OF ANY ITEMS THE OWNER DETERMINES ARE NOT ACCEPTABLE FOR REUSE.
7. REMOVE ALL ASSOCIATED ELECTRICAL, MECHANICAL & PLUMBING BACK TO ADJACENT WALL TO REMAIN AS REQUIRED FROM DEMO WALL. CEILING TO BE MODIFIED AS REQUIRED.

 EXISTING CONSTRUCTION
 NEW CONSTRUCTION
 EXISTING CONSTRUCTION TO BE REMOVED

PREPARED FOR:  **McDonald's USA, LLC**

© 2016 McDonald's USA, LLC

These drawings and specifications are the confidential and proprietary property of McDonald's USA, LLC and shall not be copied or reproduced without written authorization. The contract documents were prepared for use on this specific site in conjunction with its issue date and are not to be used on any other project. Reproduction of these drawings for licensed architects and engineers. Reproduction of the contract documents for reuse on another project is not authorized.

PREPARED BY:

Purdy + Muroff
Architecture, Inc.

1711 North Himes Avenue, Tampa, Florida 33607
Ph 813/531-0035 Fax 813/531-4350 Web Site: www.purdy+muroff.com

© COPYRIGHT
PURDY-MUNRO ARCHITECTURE, INC.
ALL RIGHTS RESERVED. PRINTED 2019


STATE OF FLORIDA
REGISTERED ARCHITECT
ANNUITY

Digitally signed by
Scott Purdy
Date: 2022.10.12
13:20:43 -04'00'

SCOTT J. PURDY
AR 91876

[illegible]

M:\PROJECTS\36\CDONALD\252038M McDONALD LANE CITYDRAWING\252038M ELECTRICAL LIGHTING LEVEL 1.DWG (Bn) Oct 12,2022 - 8:0am

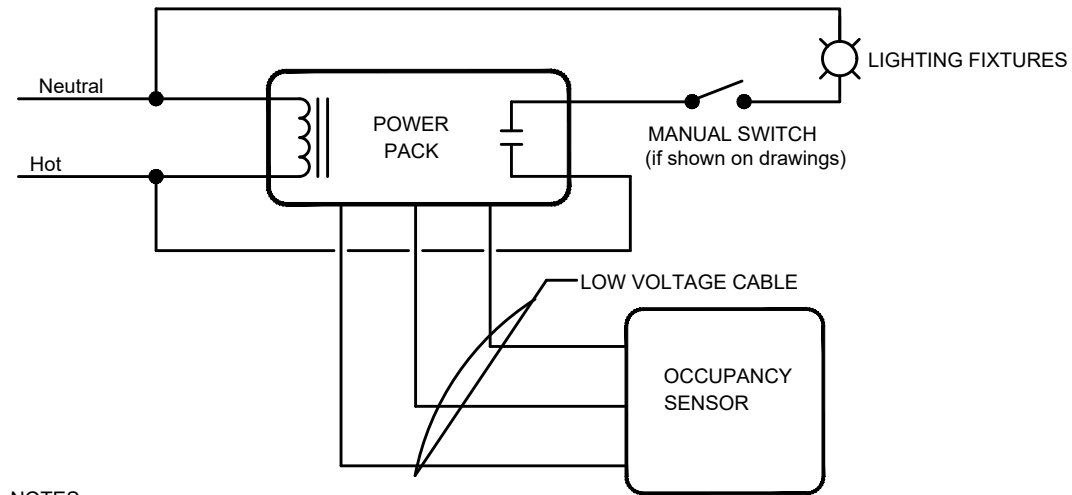

NOTES:
REFER TO LIGHTING PLAN FOR OCCUPANCY SENSOR LOCATIONS AND QUANTITIES.


OCCUPANCY SENSOR CONTROL DETAIL

EMERGENCY LIGHTNG NOTES

- CONNECT ALL EXIT SIGNS, EMERGENCY LIGHTS, INVERTER AND NIGHT LIGHTS TO THE EXISTING EXIT/EMERGENCY LIGHTING CIRCUIT.
- CONNECT ALL EXIT SIGNS, EMERGENCY LIGHTS AND NIGHT LIGHTS TO ONE CIRCUIT BREAKER.
- LIGHTING INDICATED WITH A "NL" ARE NIGHTLIGHTS AND SHALL BE CONNECTED TO THE UNSWITCHED LEG THE CIRCUIT.
- EMERGENCY LIGHTING HAS BEEN DESIGNED PER NFPA 101 TO MAINTAIN 1 FC IN PATH OF EGRESS. IF FIELD CONDITIONS REQUIRE ANY CHANGES TO LIGHTING DESIGN, EMERGENCY LIGHTING, SHALL BE INSTALLED TO MEET THE ABOVE REQUIREMENTS.
- ALL FIXTURES DENOTED AS NIGHT LIGHTING FIXTURES SHALL BE PROVIDED WITH BATTERY INVERTER EMERGENCY TYPE BALLAST IF NOT INSTALLED BY MANUFACTURER, E.C. SHALL BE RESPONSIBLE FOR THE COMPLETE INSTALLATION OF THE EMERGENCY INVERTER BALLAST IN NIGHT LIGHTING FIXTURES SHOWN ON THIS SHEET.

GENERAL NOTES

- EC SHALL FIELD VERIFY THAT ALL LIGHT FIXTURES SHOWN ON THIS PLAN DO NOT OBSTRUCT OR CONFLICT WITH THE WORK OF OTHER TRADES. IF A DISCREPANCY IS FOUND, THE EC SHALL IMMEDIATELY NOTIFY THE GC BEFORE THE INSTALLATION OF SUCH FIXTURE(S).
- IF PC-POS CASH REGISTER SYSTEM IS INSTALLED, RELOCATE FIXTURES ABOVE FRONT COUNTER TO AVOID GLARE ON THE CASH REGISTER SCREENS. INSTALL CABLE WHIP TO FIXTURES SO THAT FIXTURE CAN BE RELOCATED FOUR FEET WITHOUT DISCONNECTING CABLE WHIP.
- THE USE OF "MC" CABLE WHERE PERMITTED BY LOCAL CODES WILL BE ALLOWED FOR ALL WIRING TO THE LIGHT FIXTURES. "ROMEX" & "BX" ARE NOT ACCEPTABLE.
- LIGHTING FIXTURES AND LAMPS HAVE BEEN CHOSEN TO ACHIEVE MAXIMUM ENERGY CONSERVATION WHILE MAINTAINING ADEQUATE LEVELS OF ILLUMINATION. LAMP SPECIFICATIONS MUST BE STRICTLY FOLLOWED. ANY DEVIATION FROM LAMP SPECIFICATIONS MUST BE APPROVED IN WRITING BY McDONALD'S CORPORATION.
- ALL BRANCH CIRCUIT WIRING TO 120 VOLT LIGHTING FIXTURES AND RECEPTACLES SHALL BE AS FOLLOWS.
MAXIMUM LENGTH 85FT. - 2 #12, 1 #12 E.G.
MAXIMUM LENGTH 140FT. - 2 #10, 1 #10 E.G.
MAXIMUM LENGTH 225FT. - 2 #8, 1 #8 E.G.
MAXIMUM LENGTH 350FT. - 2 #6, 1 #6 E.G.

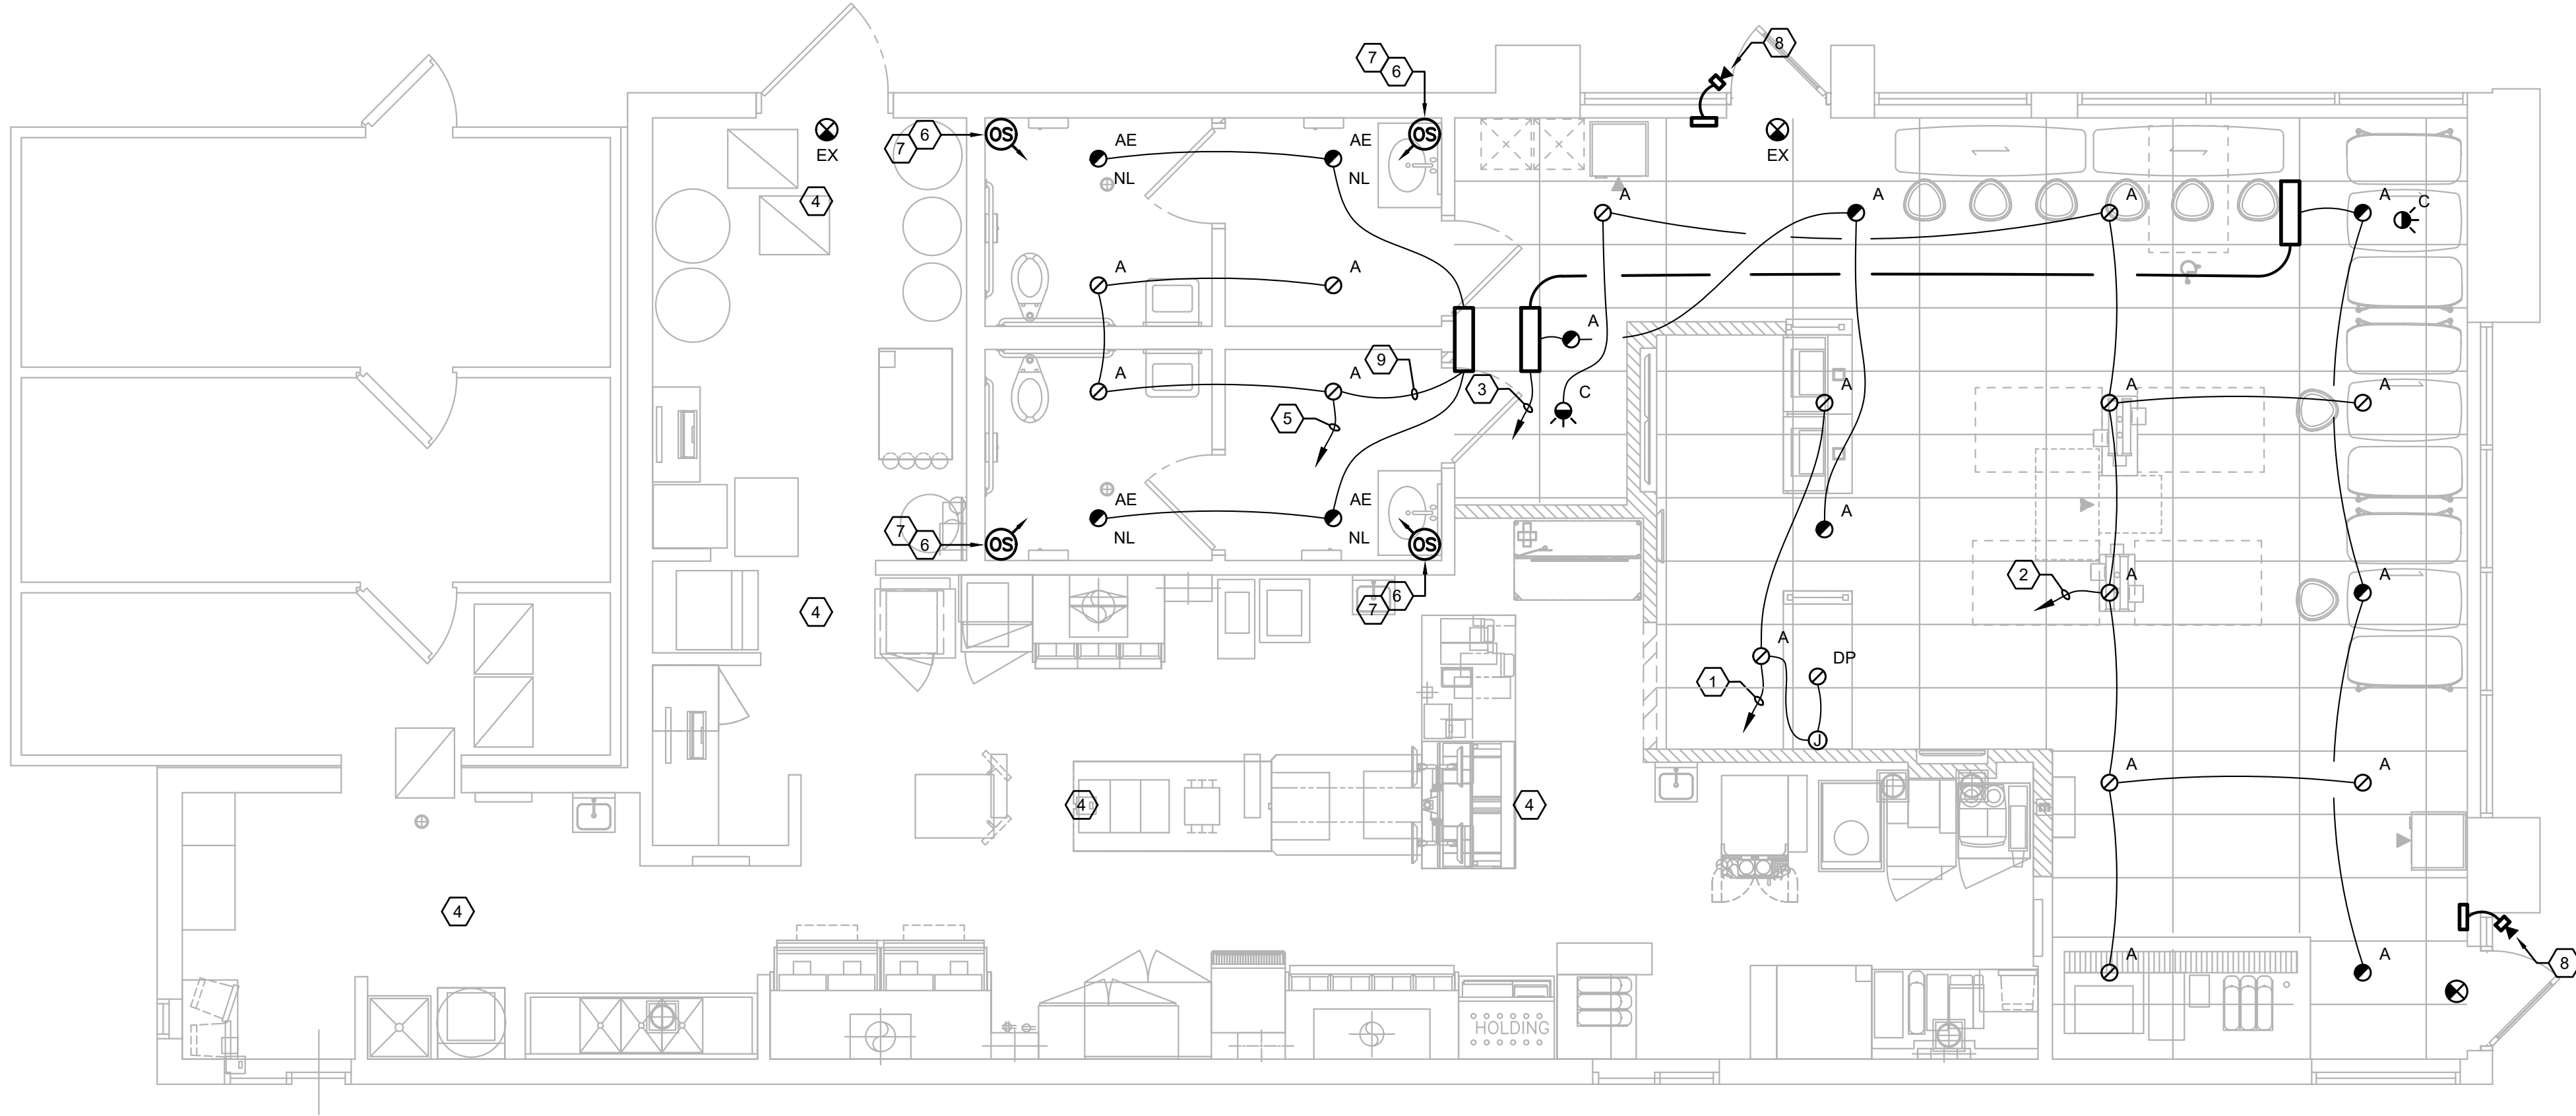

LIGHTING PLAN

SCALE: 1/4" = 1'-0"

LIGHTING FIXTURE SCHEDULE

SYMBOL	DESCRIPTION	MANUFACTURES CAT. NO.	VOLTAGE	WATTS	MOUNTING
A	LED CAN LIGHT	SECURITY LIGHTING SYSTEMS NO.: RDA-136LM-30-FL-SIRDA-136-H	120	16	CEILING RECESSED
AE NL	LED CAN LIGHT FED FROM UNSWITCHED INVERTER PANEL FOR USE AS NIGHT LIGHT AND EMERGENCY LIGHT	SECURITY LIGHTING SYSTEMS NO.: RDA-60LM-30-NF-SIRDA-60-H	120	16	CEILING RECESSED
C	SINGLE DIRECTIONAL SPOTLIGHT	SECURITY LIGHTING SYSTEMS NO.: RDA-60LM-30-NF-SIRDA-60-H REFER TO DECOR DRAWINGS FOR EXACT FIXTURE TYPE	120	12	WALL MOUNTED
EX	EXIT SIGN COMBO WITH BATTERY BACK-UP	SECURITY LIGHTING SYSTEMS NO.: SEE LIGHTING FIXTURE SCHEDULE NOTE	120	WITH UNIT	CEILING SURFACE
INVERTER	EMERGENCY BATTERY AND 2 REMOTE HEAD	DUAL LITE EV4D-02L-0IEV0DB WHEN CONNECTED TO TWO REMOTE HEADS (FOR SINGLE GANG JUNCTION BOX)	120	2-5	SURFACE TO WALL OR SOFFIT
EX	CEILING-MOUNTED LIGHTING INVERTER WITH MAINTENANCE FREE SEALED LEAD CALCIUM BATTERY. SECURITY LIGHTING SYSTEMS LG1 SERIES MAXIMUM OF FOUR 12.5 WATT CAN LIGHTS PER INVERTER				
EX	EXISTING DEVICE TO REMAIN				

ORDER ALL LIGHT FIXTURES FROM:

SECURITY LIGHTING SYSTEMS, INC.
PHONE: 1-800-LIGHT-IT
EMAIL: QUOTATIONS@SECURITYLIGHTING.COM

NOTE:
VERIFY LIGHTING FIXTURE CATALOGUE NUMBERS
WITH INTERIOR DESIGNER AND THAT THEY ARE THE
CURRENT McDONALDS STANDARD PRIOR TO
ORDERING FIXTURES.

LOAD SUMMARY
NO ADDITIONAL LOAD ADDED.
LOADS ADDED ARE OFFSET BY
LOADS REMOVED BY DEMOLITION.

THIS ITEM HAS BEEN ELECTRONICALLY
SIGNED AND SEALED BY ADAM T.
POWELL, PE USING A DIGITAL
SIGNATURE AND DATE. PRINTED COPIES
OF THIS DOCUMENT ARE NOT
CONSIDERED SIGNED AND SEALED AND
THE SIGNATURE MUST BE VERIFIED ON
ANY ELECTRONIC COPIES.

EMERALD
ENGINEERING INC.
9942 CURRIE DRIVE DR. STE H, TAMPA, FL 33619
TEL (813) 995-0300
WWW.EMERALDMEP.COM EET PROJECT# 22093H

ENTIRE
SHEET
CHANGED

PREPARED BY:
Purdy+ Muroff
Architecture, Inc.
1711 North Himes Avenue, Tampa, Florida 33607
Ph: 813-355-0607 Fax: 813-355-4250 Web Site: www.pgmurff.com

APPROVED:
Adam T. Powell, P.E.
Professional Engineer
No. 12500
Date: 2022.10.12 08:18:25 049097

FL REG. NO. PE73553

© 2016 McDonald's USA, LLC
McDonald's USA, LLC
These drawings and specifications are the confidential and proprietary information of McDonald's USA, LLC and shall not be reproduced, copied, or transmitted in any form or by any means, electronic or mechanical, including photocopying, recording, or by any information storage and retrieval system, without written authorization. The contract documents were prepared for use on this specific site in conjunction with its issue date and are not to be used for any other project. These drawings or reference or example on another project requires the service of properly licensed architects and engineers. Reproduction of the contract documents for reuse on another project is not authorized.

PREPARED FOR:
McDonald's USA, LLC

DRAWN BY
STD
ISSUE DATE
REVIEWED BY
DATE ISSUED
2019.08.19

TITLE
EOTIF PROGRAM
DESCRIPTION

SITE ADDRESS
491 SW 34th AVE
BUD LANE CITY, FL 33025-5307

SHEET NO.
1802.471
E1.0
AA-0003276

DATE ID
009-1231
REV #
15440

REV

DATE

DESCRIPTION

1

10.05.22

UPDATED DECOR

BP

BY

M:\PROJECTS\MCDONALD\B22093M MCDONALD LANE CITYDRAWING\B22093M ELECTRICAL POWER LEVEL 1.DWG (Rev. 12.2022 - 8.10am)

GENERAL NOTES:

- ALL WORK SHALL BE IN ACCORDANCE WITH THE 2017 NATIONAL ELECTRICAL CODE AND SHALL ALSO COMPLY WITH ALL APPLICABLE RULES AND REGULATIONS OF LOCAL AND STATE LAWS AND ORDINANCES.
- CONTRACTOR SHALL MAKE A THOROUGH EXAMINATION OF THE SITE AND THE CONTRACT DOCUMENTS. NO CLAIM FOR EXTRA COMPENSATION WILL BE RECOGNIZED IF DIFFICULTIES ARE ENCOUNTERED WHICH AN EXAMINATION OF SITE CONDITIONS AND CONTRACT DOCUMENTS PRIOR TO EXECUTING CONTRACT WOULD HAVE REVEALED.
- ELECTRICAL CONTRACTOR SHALL ARRANGE FOR ALL NECESSARY PERMITS, LICENSES, UTILITY COORDINATION AND INSPECTIONS AS REQUIRED BY THE CITY OR UTILITY COMPANY. OWNER WILL PAY FEES. CONTRACTOR IS RESPONSIBLE FOR ALL EQUIPMENT REQUIRED BY UTILITY COMPANY AND SHOULD INCLUDE NECESSARY COSTS IN BID.
- CONTRACTOR SHALL LEGIBLY MARK-UP A SET OF 24"x36" DRAWINGS TO REFLECT AS-BUILT CONDITIONS AND TURN OVER TO THE ARCHITECT.
- PANELBOARD MANUFACTURER SHALL PROVIDE ARC-FLASH WARNING LABELS FOR MDP AND ALL BRANCH PANELBOARDS IN ACCORDANCE WITH NEC 110.

GROUNDING:

- THE INTERIOR ELECTRICAL SYSTEMS SHALL BE COMPLETELY AND EFFECTIVELY GROUNDED AS REQUIRED BY NATIONAL ELECTRICAL CODE ALL METALLIC RACEWAYS SHALL BE MECHANICALLY AND ELECTRICALLY SECURE AT ALL JOINTS AND AT ALL BOXES, CABINETS, FITTINGS AND EQUIPMENT.

OUTLET BOXES/DEVICES:

- ALL OUTLET BOXES SHALL BE RIGIDLY MOUNTED AND SHALL BE EQUIPPED WITH SUITABLE SCREW FASTENED COVERS. OPEN KNOCKOUTS OR HOLES IN BOXES SHALL BE PLUGGED WITH SUITABLE BLANKING DEVICE.
- OUTLET BOXES SHALL BE 4 INCH SQUARE x 2-1/8" DEEP. OUTLET BOXES LOCATED ABOVE THE CEILING SHALL BE LEGIBLY IDENTIFIED WITH BRANCH CIRCUIT NUMBER OF CIRCUIT TERMINATED WITHIN BY MEANS OF BLACK PERMANENT MARKER.

SWITCHGEAR:

- PANELBOARD DIRECTORY CARDS SHALL BE TYPEWRITTEN WITH ACCURATE AND CURRENT INFORMATION BY THE CONTRACTOR AT THE END OF CONSTRUCTION.

WIRE/RACEWAY:

- ALL CONDUCTORS SHALL BE COPPER, CONDUCTOR INSULATION SHALL BE DUAL TYPE THHN/THWN 75°C (167°F) FOR DRY, DAMP, AND WET LOCATIONS. CONDUCTOR INSULATION WITH SINGLE TYPE MARKING THHN 90°C (194°F) MAY BE USED FOR DRY LOCATIONS ONLY. ALL CONDUCTORS SHALL BE COLOR CODED AS REQUIRED BY NEC AND FURTHER IDENTIFIED AND CODED AS SPECIFIED HEREINAFTER. COLOR CODING SHALL BE BY MEANS OF COLORED INSULATING MATERIAL, COLORED BRAID OR JACKET OVER THE INSULATION OR BY MEANS OF SUITABLE COLORED, PERMANENT, NON-AGING, INSULATING TAPE APPLIED TO CONDUCTORS AT EACH CABINET OR JUNCTION POINT. THE COLOR CODING SHALL BE ACCOMPLISHED AS THE CONDUCTORS ARE INSTALLED. THE FOLLOWING SYSTEMS OF COLOR CODING SHALL BE STRICTLY ADHERED TO:

A) GROUND LEADS: GREEN

B) 120/208 VOLT UNGROUNDED PHASE WIRES:
 PHASE A: BLACK
 PHASE B: RED
 PHASE C: BLUE
 NEUTRAL: WHITE


THE COLOR CODE ASSIGNED TO EACH PHASE WIRE SHALL BE CONSISTENTLY FOLLOWED THROUGHOUT

A) GROUND LEADS: GREEN

B) 120/208 VOLT UNGROUNDED PHASE WIRES:
 PHASE A: BLACK
 PHASE B: RED
 PHASE C: BLUE
 NEUTRAL: WHITE

THE COLOR CODE ASSIGNED TO EACH PHASE WIRE SHALL BE CONSISTENTLY FOLLOWED THROUGHOUT

- ALL BRANCH CIRCUIT WIRING TO 120 VOLT LIGHTING FIXTURES AND RECEPTACLES SHALL BE AS FOLLOWS.
 MAXIMUM LENGTH 85FT. - 2 #12, 1 #12 E.G.
 MAXIMUM LENGTH 140FT. - 2 #10, 1 #10 E.G.
 MAXIMUM LENGTH 225FT. - 2 #8, 1 #8 E.G.
 MAXIMUM LENGTH 350FT. - 2 #6, 1 #6 E.G.
- UNLESS OTHERWISE NOTED ALL CONDUCTORS SHALL BE RUN IN THIN WALL CONDUIT AND THIN WALL CONDUIT SHALL BE UNDERWRITERS' APPROVED GALVANIZED ELECTRICAL METALLIC TUBING. COUPLINGS AND CONNECTORS SHALL BE STEEL SET-SCREW TYPE, ZINC OR CADMIUM PLATED. MC CABLE MAY BE USED WHERE CONCEALED IN WALLS.
- ALL RACEWAYS SHALL BE PROPERLY ALIGNED, GROUPED, AND SUPPORTED BY MECHANICAL TYPE "CADDY" CLIPS AT INTERVALS NOT EXCEEDING 8 FEET.
- ALL RACEWAYS WITH NO. 10 OR 12 AWG PHASE CONDUCTORS FOR RECEPTACLES, LIGHTING FIXTURES AND SIMILAR CIRCUITS SHALL BE PROVIDE WITH A PARITY SIZED GREEN EQUIPMENT GROUND CONDUCTOR. GROUND CONDUCTOR SHALL BE INSTALLED IN ENTIRE RACEWAY SYSTEM INCLUDING WALL SWITCHES AND FLEXIBLE CONDUIT TO LIGHT FIXTURES. EQUIPMENT GROUND CONDUCTOR SIZES FOR CIRCUITS WITH PHASE CONDUCTORS LARGER THAN NO. 12 AWG ARE INDICATED ON DRAWINGS. GROUND CONDUCTORS SHALL BE CONNECTED TO GROUND BUSES IN PANELBOARDS.
- RACEWAY PENETRATIONS OF FIRE RATED WALLS AND/OR FLOORS SHALL BE SEALED TO MAINTAIN INTEGRITY OF CONSTRUCTION. ALL PRODUCTS, MATERIALS AND METHODS OF INSTALLATION SHALL BE UL APPROVED AND MEET NFPA.
- ALL ELECTRICAL CONDUITS SHALL BE CONCEALED IN WALLS UNLESS AS-BUILT CONDITIONS PROHIBITS. GO TO NOTIFY ARCH/ACM OF AS-BUILT CONDITIONS.

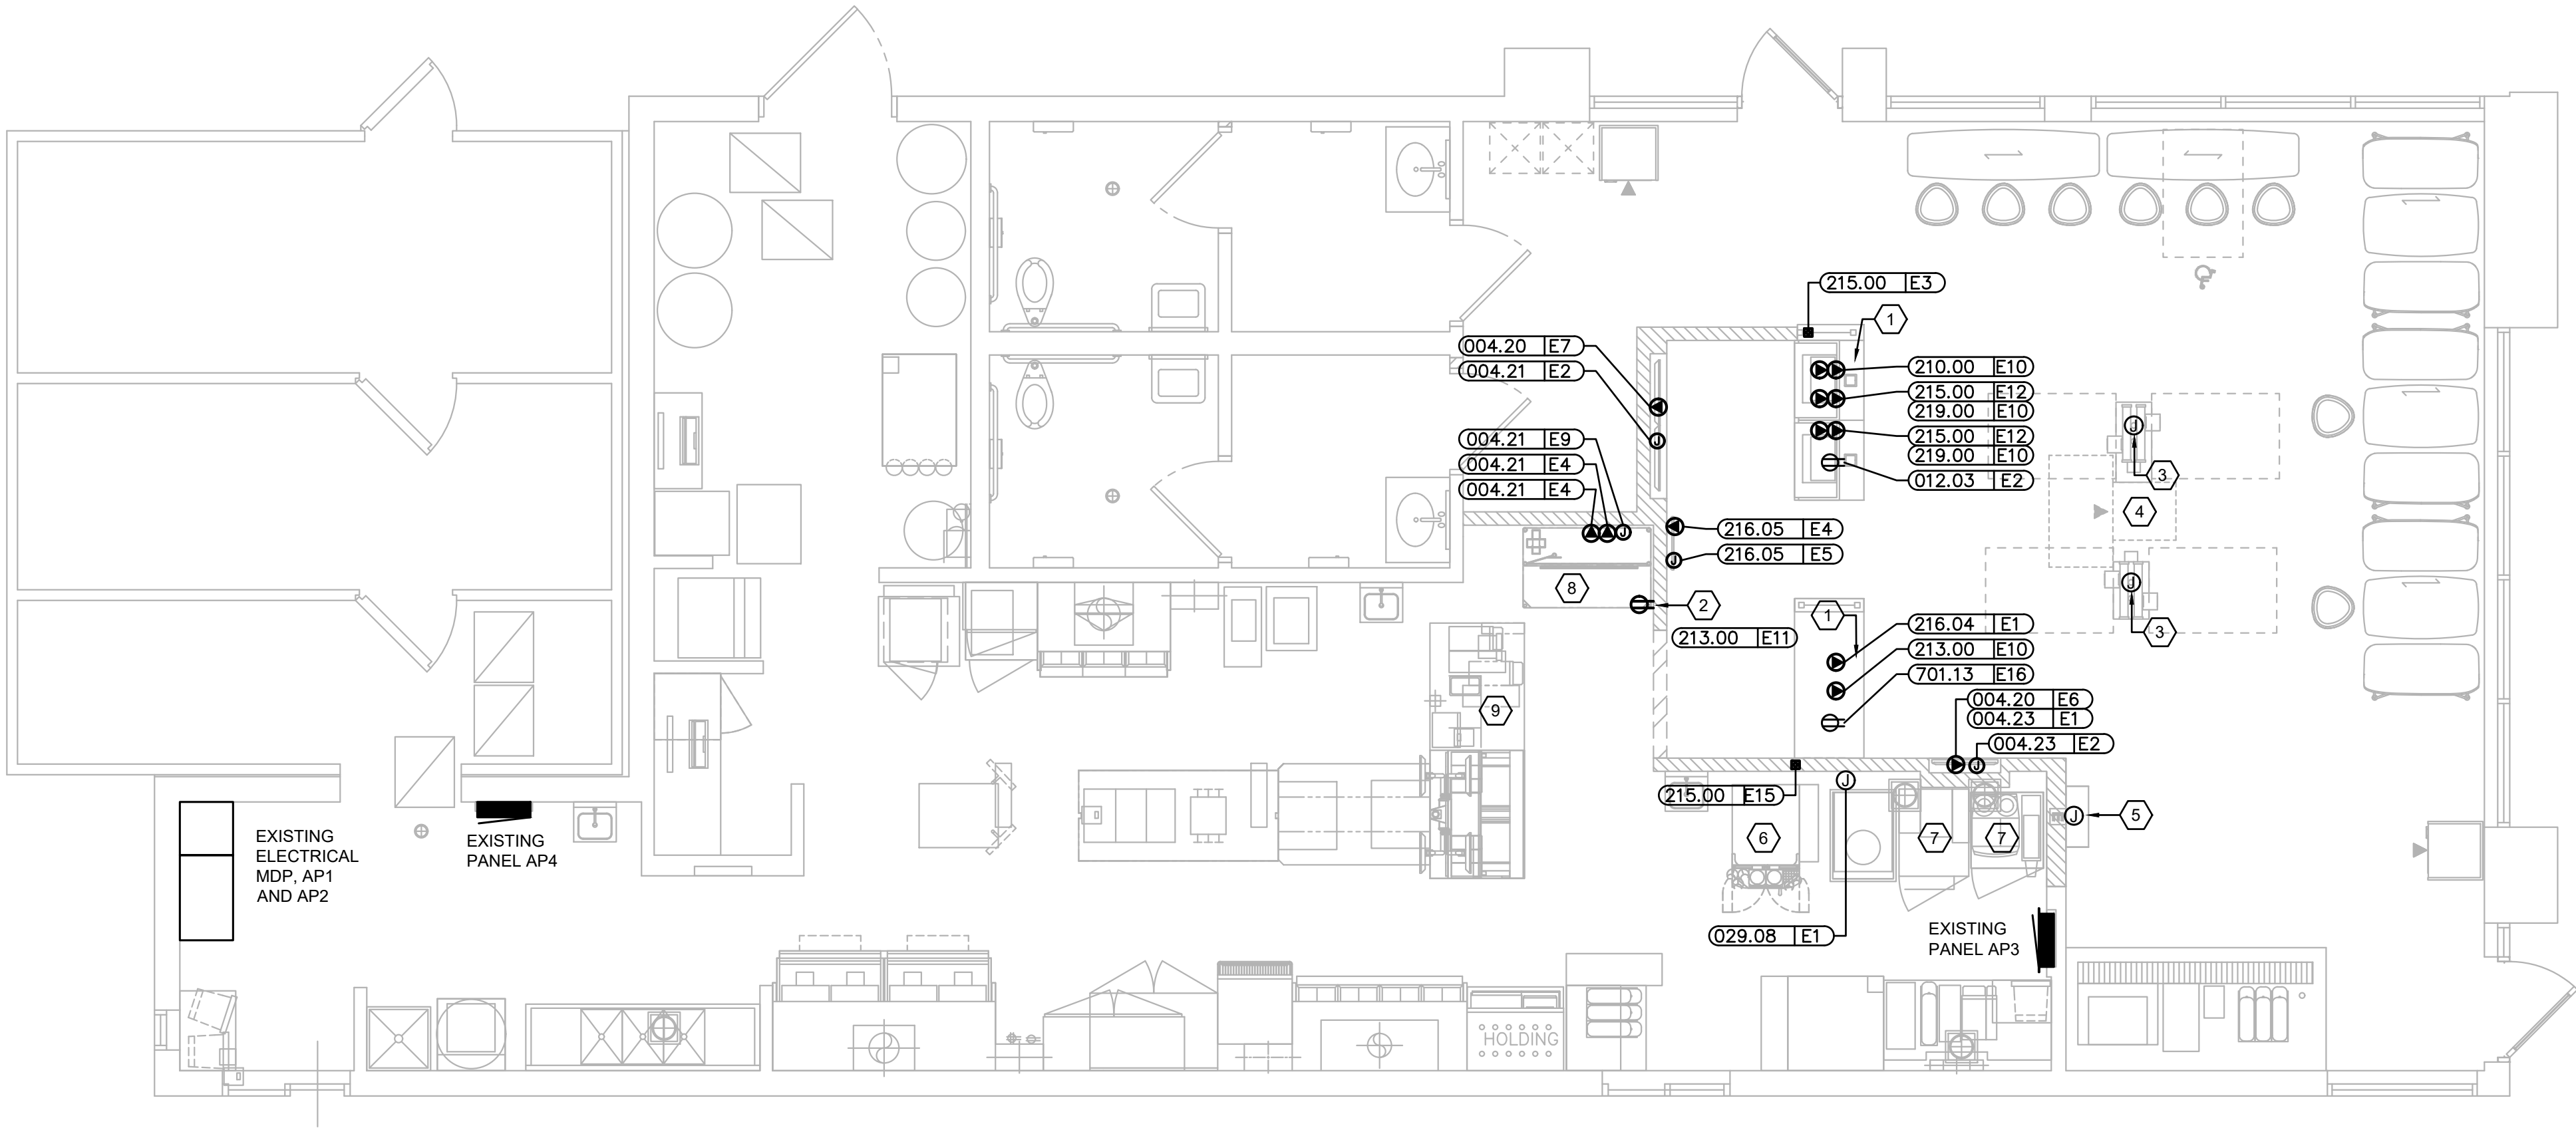

POWER PLAN

SCALE: 1/4" = 1'-0"

KEYNOTE LEGEND

- RACEWAY KIT PROVIDED WITH COUNTER, INSTALLED BY EC.
- IF OPTIONAL TABLE TRACKER SYSTEM IS TO BE USED. IF USED, PROVIDE 2 #12 AND 1 #12 GROUND TO AVAILABLE SPARE 20A/1P BREAKER. CONNECT CIRCUIT TO (3) 5-20R RECEPTACLES, (1) RECEPTACLE FOR MODEM/GATEWAY (TYPICALLY LOCATED BEHIND VALENCE AT 7'-9" AFF), (1) RECEPTACLE FOR LOCATOR CHARGER (TYPICALLY LOCATED IN MANAGERS OFFICE) AND (1) RECEPTACLE FOR MONITOR (TYPICALLY LOCATED AT PICKUP COUNTER). COORDINATE EXACT LOCATION(S) IN THE FIELD.
- RELOCATED ORDERING KIOSK. COORDINATE EXACT LOCATION AND REQUIREMENTS WITH ARCHITECT AND OWNER PRIOR TO RELOCATIONS. EXTEND CIRCUITRY AND CONDUCTOR AS REQUIRED. VERIFY THAT EACH KIOSK IS POWERED BY A 1 POLE 20 AMP CIRCUIT BREAKER.
- COORDINATE LOCATION AND REQUIREMENTS OF FUTURE CASH HANDLER WITH DECOR COMPANY. POWER IS FED FROM ORDERING KIOSK BASE PLATE. IF NOT LOCATED NEXT TO THE WALL. IF LOCATED NEXT TO A WALL THEN FEED FROM WALL POWER.
- COORDINATE LOCATION AND REQUIREMENTS OF HAPPY MEAL DISPLAY WITH DECOR COMPANY. TIE INTO LIGHTING CIRCUIT SERVING THIS AREA, 2 #12 AND 1 #12 E.G. IN 1/2" CONDUIT.
- RELOCATED SHAKE MACHINE. COORDINATE EXACT LOCATION AND REQUIREMENTS WITH ARCHITECT AND OWNER PRIOR TO RELOCATIONS. EXTEND CIRCUITRY AND CONDUCTORS AS REQUIRED.
- RELOCATED EQUIPMENT. COORDINATE EXACT LOCATION AND REQUIREMENTS WITH ARCHITECT AND OWNER PRIOR TO RELOCATIONS. EXTEND CIRCUITRY AND CONDUCTORS AS REQUIRED.
- NEW STAGING CART WITH MONITORS. COORDINATE EXACT LOCATION AND REQUIREMENTS WITH ARCHITECT AND OWNER TO INSTALLATION. 2 #12 AND 1 #12 E.G. IN 1/2" CONDUIT, CONNECT TO SPARE 20A-1P, 120 VOLT BREAKER. FURNISH AND INSTALL BREAKER IF A SPARE IS NOT AVAILABLE. AP4-35.
- NEW ASSEMBLY CART WITH REFRIGERATOR. COORDINATE EXACT LOCATION AND REQUIREMENTS WITH ARCHITECT AND OWNER TO INSTALLATION. 2 #12 AND 1 #12 E.G. IN 1/2" CONDUIT, CONNECT TO SPARE 20A-1P, 120 VOLT BREAKER. FURNISH AND INSTALL BREAKER IF A SPARE IS NOT AVAILABLE. AP4-37.

SEE SHEET E3.0
FOR REQUIREMENTS

CONTRACTOR TO FIELD VERIFY CIRCUIT NUMBERS
AND EXACT NUMBER OF SPARES AVAILABLE.

THIS ITEM HAS BEEN ELECTRONICALLY
SIGNED AND SEALED BY ADAM T.
POWELL, PE USING A DIGITAL
SIGNATURE AND DATE. PRINTED COPIES
OF THIS DOCUMENT ARE NOT
CONSIDERED SIGNED AND SEALED AND
THE SIGNATURE MUST BE VERIFIED ON
ANY ELECTRONIC COPIES.

EMERALD
ENGINEERING INC.
9942 CURRIE DR. DR. STE H, TAMPA, FL 33619
TEL (813) 995-0300
WWW.EMERALDMEP.COM EEE PROJECT# 22093M

SHEET NO.	TITLE	DRAWN BY	5TH ISSUE DATE	REVIEWED BY	DATE ISSUED	DATE	REV	DATE	DESCRIPTION
1802.471	EOTIF PROGRAM	ADAM T. POWELL, PE	2019.08.19	2019.08.19	2019.08.19	2019.08.19	1	10.05.22	UPDATED DECOR
AA-0003276	DESCRIPTION	ADAM T. POWELL, PE	2019.08.19	2019.08.19	2019.08.19	2019.08.19	1	10.05.22	UPDATED DECOR
BP									
BY									

PREPARED BY: **Purdy+ Muroff Architecture, Inc.**
1711 North Himes Avenue, Tampa, Florida 33607
Ph: 813.355.0617 Fax: 813.355.4258 Web Site: www.purdymuroff.com
FL REG. NO. PE73553
Date: 2022.10.12 08:17:51 -0400
Digitally signed by Adam Powell
DN: cn=US, o=Purdymuroff, ou=Adam Powell
c=US, email=adam@purdymuroff.com, ou=Adam Powell
Date: 2022.10.12 08:17:51 -0400

<u>EXISTING MDP (800 AMP MAIN BREAKER)</u>	
EXISTING LOAD @ 125%	
PER NEC 220.87	152,000
NEW ADDITIONAL LOAD	7,275
NEW TOTAL	159,275
	(442 AMP)

PANEL "AP4"				208Y/120V, 3Ø, 4W		225A MLO		NEMA-1		SERIES RATED		COPPER BUS SOLID NEUTRAL		
POWER-LINE			VOLTAGE/PHASE			225A BUS		SURFACE						
CKT	AMPS	POLE	DESCRIPTION	NOTES	LOAD VA	CKT	AMPS	POLE	DESCRIPTION	NOTES	LOAD VA	CKT	AMPS	
1			EX SHUNT-TRIP		0	2					0			
3					4700	4	60	3	EX FRYER		4700			
5	60	3	EX FRYER		4700	6					4700			
7					4700	8			EX SHUNT-TRIP		0			
9			EX SHUNT-TRIP		0	10					0			
11					4700	12	20	3	EX TVSS		0			
13	60	3	EX FRYER		4700	14					0			
15					4700	16					1352			
17	20	2	SPARE		0	18			EX WORKTOP COOLER		1352			
19					0	20	20	2			0			
21	20	1	EX CDMB 1		1000	22			SPARE		0			
23	20	1	EX GFI OUTLET		1080	24	20	1	EX WALL MOUNTED FREEZER		720			
25	20	1	EX TEA BREWER		1352	26	20	1	EX FAN INTERLOCK		1500			
27	20	1	EX TEA BREWER		1352	28					0			
29	30	2	EX MUFFIN TOASTER		2496	30	30	2	SPARE		0			
31					2496	32					0			
33	20	1	EX CDMB 2		1000	34	20	2	SPARE		0			
35	20	1	STAGING CART W/MONITOR	1	696	36					2496			
37	20	1	ASSEMBLY CART W/REFRIG	1, 2	696	38	30	2	FROZEN BEVERAGE DISP	1, 2	2496			
39	20	1	FC CASH RECYCLER	1	528	40	20	1	BAKED GOODS/DCO	1	360			
41			SPACE		0	42			SPACE		0			
43			SPACE		0	44			SPACE		0			
45			SPACE		0	46			SPACE		0			
47			SPACE		0	48			SPACE		0			
NOTES					LOAD	CONNECTED		DEMAND		DEMAND				
1. NEW BREAKER TO MATCH TYPE AND AIC RATING OF OTHER EXISTING BREAKERS IN THIS PANEL					DESCRIPTION	LOAD (VA)		FACTOR		LOAD (VA)				
2. GFI PER NEC 210.8					LIGHTING	0		0.00		0				
3.					HVAC - COOL	0		0.00		0				
4.					HVAC - HEAT	0		0.00		0				
5.					RECEPTACLE	65,272		1.00		65,272				
6.					MISC	0		1.00		0				
7.					TOTAL	65,272				65,272				
8.					TOTAL DEMAND CURRENT @ 208Y/120V, 3Ø									181.2 AMP

PB = Pullbox JB = Junction Box EC = Electrical Contractor			VIF = Verify in Field		ELECTRICAL SCHEDULE									
TAG #	QTY	DESCRIPTION	VOLT/PH	FLA	BRK SIZE	COND/WIRE	PNL/CCT	RECEP TYPE	HGHT AFF	REQUIREMENTS & REMARKS				
004.20E6	1	MENU BOARD - DIGITAL	120/1 ISOLATED	2.6	20A	2 #12 1 #12 IG AND 1 #12 EG - 1/2"C	NOTE 1	IG5262	6'-6"	-				
004.20E7	1	MENU BOARD - DIGITAL	120/1 ISOLATED	2.6	20A	2 #12 1 #12 IG AND 1 #12 EG - 1/2"C	NOTE 1	(2) IG5262	6'-2"	-				
004.21E4	2	MENU BOARD - DIGITAL - MEDIA PLAYER	120/1 ISOLATED	1.0	20A	2 #12 1 #12 IG AND 1 #12 EG - 1/2"C	NOTE 1	IG5262	7'-9"	-				
004.21E2	1	MENU BOARD - DIGITAL - MEDIA PLAYER	DATA CABLE	-	-	-	-	JB	9'-0"	JB W/ 2 1/2" C. TO TERMINATE ABOVE CEILING W/ BUSHINGS FOR DATA CABLES. SUPPLY W/ GROMMETED OPENING IN COVER PLATE				
004.21E9	1	MENU BOARD - DIGITAL - MEDIA PLAYER	DATA CABLE	-	-	-	-	JB	7'-9"	JB W/ 2 1/2" C. TO TERMINATE ABOVE CEILING W/ BUSHINGS FOR DATA CABLES. SUPPLY W/ GROMMETED OPENING IN COVER PLATE				
004.23E1	1	DIGITAL MERCHANDISER - MEDIA PLAYER	120/1 ISOLATED	3.6	20A	2 #12 1 #12 IG AND 1 #12 EG - 1/2"C	NOTE 1	IG5262	6'-6"	MEDI PLAYER MOUNTS BEHIND SCREEN AND USES SAME RECEPTACLE				
004.23E2	1	DIGITAL MERCHANDISER - MEDIA PLAYER	DATA CABLE	-	-	-	-	JB	6'-6"	JB W/ 1" C. TO FULL HEIGHT WALL AND TO ABOVE CEILING W/ BUSHING FOR DATA CABLES. SUPPLY W/ GROMMETED OPENING IN COVER PLATE.				
012.03E2	1	BAKED GOODS DISPLAY CASE	120/1	1.5	20A	2 #12 1 #12EG - 1/2"C	NOTE 2 - AP4-40	5-15R	SEE RMKS	PROVIDE RECEPT. IN COUNTER-MOUNTED RACEWAY				
029.08E1	1	FROZEN CARBONATED BEVERAGE DISPENSER	208/1	24.0	30A	2 #10 1 #10EG - 3/4"C	NOTE 3 - AP4-36,38	L6-30P	18"	PLUGS INTO KES PORFIED CHASE				
210.00E10	1	FUTURE CASH RECYCLER	120/1 ISOLATED	4.4	20A	2 #12 1 #12 IG AND 1 #12 EG - 1/2"C	NOTE 2 - AP4-39	(2) IG4700	SEE RMKS	PROVIDE RECEPTACLE IN COUNTER-MOUNTED RACEWAY				
213.00E10	1	TABLET BRACKET	120/1 ISOLATED	2.6	20A	2 #12 1 #12 IG AND 1 #12 EG - 1/2"C	NOTE 1	SEE RMKS	SEE RMKS	PROVIDE IG RECEPTACLE IN COUNTER-MOUNTED RACEWAY				
213.00E11	1	TABLET BRACKET	120/1	1.5	20A	2 #12 1 #12EG - 1/2"C	SEE RMKS	5-20R	SEE RMKS	EXTEND NEARBY APPLIANCE PANEL CIRCUIT TO NEW RECEPTACLE. FEED FROM SAME CIRCUIT AS 21-10E1.				
215.00E3	1	POS REGISTER - FRONT COUNTER	DATA CABLE	-	-	-	-	PB	10"	EXTEND 2" CONDUIT TO ABOVE CEILING FOR POS DATA CABLES				
215.00E12	1	POS REGISTER - FRONT COUNTER	120/1 ISOLATED	3.0	20A	2 #12 1 #12 IG AND 1 #12 EG - 1/2"C	NOTE 1	IG4700	SEE RMKS	PROVIDE IG RECEPTACLE IN COUNTER-MOUNTED RACEWAY				
215.00E15	1	POS REGISTER - FRONT COUNTER	DATA CABLE	-	-	-	-	PB	10"	EXTEND TWO 1" CONDUITS TO ABOVE CEILING FOR POS DATA CABLES				
216.04E1	1	ORB MONITOR (MINI) & SCANNER	120/1 ISOLATED	1.5	20A	2 #12 1 #12 IG AND 1 #12 EG - 1/2"C	NOTE 1	IG4700	SEE RMKS	PROVIDE RECEPTACLE IN COUNTER-MOUNTED RACEWAY				
216.05E4	1	ORB MONITOR	120/1 ISOLATED	1.5	20A	2 #12 1 #12 IG AND 1 #12 EG - 1/2"C	NOTE 1	IG4700	8'-1"	-				
216.05E5	1	ORB MONITOR	120/1 ISOLATED	1.5	20A	2 #12 1 #12 IG AND 1 #12 EG - 1/2"C	NOTE 1	IG4700	8'-1"	JB W/ 1-1/2"C. TO TERMINATE ABOVE CEILING W/ BUSHINGS FOR DATA CABLE SUPPLY W/ GROMMETED OPENING IN COVER PLATE.				
219.00E10	2	POS - RECEIPT PRINTER	120/1 ISOLATED	0.7	20A	2 #12 1 #12 IG AND 1 #12 EG - 1/2"C	NOTE 1	IG4700	SEE RMKS	PROVIDE IG RECEPTACLE IN COUNTER-MOUNTED RACEWAY				
701.13E16	1	DCO - GENERAL PURPOSE	120/1	1.5	20A	2 #12 1 #12EG - 1/2"C	NOTE 2 - AP4-40	5-20P	SEE RMKS	PROVIDE RECEPTACLE IN COUNTER-MOUNTED RACEWAY				

ALL SINGLE-PHASE RECEPTACLES RATED 150 VOLTS TO GROUND OR LESS, 50 AMPERES OR LESS AND THREE-PHASE RECEPTACLES RATED 150 VOLTS TO GROUND OR LESS, 100 AMPERES OR LESS INSTALLED SHALL HAVE GROUND-FAULT CIRCUIT-INTERRUPTER PROTECTION FOR PERSONNEL.

SYMBOL	DESCRIPTION
	JUNCTION BOX WITH DUPLEX (20A; 125V.) RECEPTACLE
	JUNCTION BOX
	JUNCTION BOX WITH SPECIAL PURPOSE
	JUNCTION BOX WITH ISOLATED GROUND RECEPTACLE
TP	TAMPER RESISTANT GFCI DUPLEX RECEPTACLE/USB COMBO MOUNTED AT 18" AFF. IN PUBLIC AREAS. EC SHALL PROVIDE PASS AND SEYMOUR "SAFELOCK" 2095-TR-2 (*** IVORY, W=WHITE, GR=GRAY, BK=BLACK, RED=RED, LA=LIGHT ALMOND). SPECIFIED RECEPTACLE BECOMES DE-ENERGIZED UPON FAILURE OF GFI DEVICE. NO SUBSTITUTIONS. (TYPICAL)
	RACEWAY CONCEALED IN WALL OR CEILINGS
	HOMERUN TO PANEL

THIS ITEM HAS BEEN ELECTRONICALLY
SIGNED AND SEALED BY ADAM T.
POWELL, PE USING A DIGITAL
SIGNATURE AND DATE. PRINTED COPIES
OF THIS DOCUMENT ARE NOT
CONSIDERED SIGNED AND SEALED AND
THE SIGNATURE MUST BE VERIFIED ON
ANY ELECTRONIC COPIES.



9942 CURRIE DAVIS DR. STE H, TAMPA, FL 33615
TEL (813) 995-0300
WWW.EMERALDMEP.COM EEI PROJECT# 220936

ENTIRE
SHEET
CHANGE

TITLE
EOTF PROGRAM

1802.471
E3.0
AA-0003276

[illegible]

© 2015 McDonald's USA, LLC

PREPARED FOR: **McDonald's USA, LLC**

These drawings and specifications are the confidential and proprietary property of McDonald's USA, LLC and shall not be copied or reproduced in whole or in part without the express written permission of McDonald's USA, LLC. The drawings are prepared for use on this specific site in conjunction with its issuance date and are not suitable for use on a different site or at a later time. Use of these drawings for reference or copying on another project requires the express written permission of McDonald's USA, LLC. The drawings are prepared for the specific project and the contract documents for another project is not authorized.

DRAWN BY	STD ISSUE DATE	REVIEWED BY	DATE ISSUED
			2019.08.19


TITLE	
EOTF PROGRAM	
DESCRIPTION	
.	
.	
.	
SITE ID	SITE ADDRESS
1	
2	

1802.471
E3.0
AA-0003276

Ph 813/353-0035 Fax 813/353-4350 Web Site: www.purdymuroff.com

07

009-1231 15440 491 SW MAIN BLVD LAKE CITY, FL 32025-5207

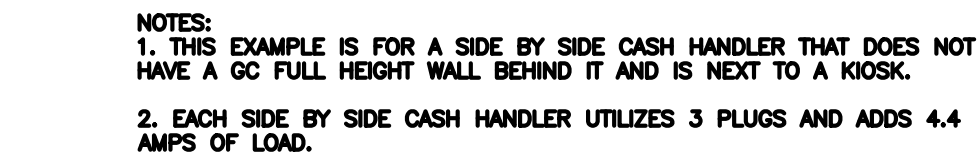

ENTIRE SHEET CHANGED

[illegible]