

ABBREVIATION LEGEND:

FRONT VIEW

REAR VIEW

GENERAL NOTES:

- MINIMUM 9'-1 1/8" CEILING HEIGHT ON FIRST FLOOR U.N.O.
- ALL LOAD BEARING WALLS AND EXTERIOR OPENINGS TO HAVE (2) 2x10 HEADERS U.N.O.
- STANDARD FIRST FLOOR WINDOW HEADER HEIGHTS SHALL BE FRAMED DOWN 2'-2" FROM T.O.P., U.N.O.
- WINDOW HEADERS FOR WINDOWS LOCATED ABOVE KITCHEN SINK SHALL BE FRAMED DOWN 1'-5" FROM T.O.P., U.N.O.
- 7/16" O.S.B. AND HOUSEWRAP REQUIRED.
- DIMENSIONS ARE TO SHEATHING EXTERIOR; SUBTRACT 1/2" FROM DIMENSIONS FOR EXTERIOR WINDOW AND DOOR FRAMING LOCATION IF OPENINGS ARE FRAMED BEFORE SHEATHING INSTALLATION.
- ALL INTERIOR DOORS ARE EITHER CENTERED ON WALLS OR ROUGH OPENING STARTED MINIMUM OF 4" FROM ADJOINING WALL UNLESS OTHERWISE DIMENSIONED.
- NUMBER OF STAIR TREADS AND RISERS MAY VARY AS A RESULT OF LOCAL BUILDING CODES, STANDARDS AND FINAL GRADE.
- ALL SHELVES TO BE 12" DEEP U.N.O.
- HEIGHT OFF FLOOR TO BE:
 - 1. SINGLE 68"
 - 2. DOUBLE 42" AND 84"

- ALL PLUMBING FIXTURES SHOWN ARE A REPRESENTATION OF SIZE AND LOCATION ONLY. ACTUAL STYLE AND BRAND OF FIXTURES MAY VARY PER OFFICE LOCATION.
- ALL TUBS / SHOWERS TO HAVE NAILERS AT FLANGE.
- INSTALL A 24" WIDE WALKWAY FROM ATTIC ACCESS TO FURNACE PLATFORM.
- PORCH, STOOP, & DECK HANDRAILS NOT INCLUDED W/ SLAB FOUNDATION.
- RAILINGS ARE A FORCED OPTION WHEN PORCH IS OVER 30" HIGH FROM FINISHED GRADE.
- **PORCH, STOOP & DECK HANDRAILS NOT INCLUDED WITH SLAB FOUNDATION AND RAILING IS A FORCED OPTION WHEN THE PORCH IS OVER 30" HIGH**

FOUNDATION NOTES:

- SEE ENGINEERING PLAN DETAIL FOR FINAL CONSTRUCTION METHOD
- TURN OUT REBAR AT THE POWER METER FOR ELECTRICAL GROUNDING AS REQUIRED BY CODE
- PORCH, STOOP & DECK HANDRAILS NOT INCLUDED WITH SLAB FOUNDATION AND RAILING IS A FORCED OPTION WHEN THE PORCH IS OVER 30" HIGH

TERMITE PROTECTION

TERMITE PROTECTION SHALL BE PROVIDED BY REGISTERED TERMITICIDES, INCLUDING SOIL APPLIED PESTICIDES, BAITING SYSTEMS, AND PESTICIDES APPLIED TO WOOD, OR OTHER APPROVED METHODS OF TERMITE PROTECTION LABELED FOR USE AS A PREVENTATIVE TREATMENT TO NEW CONSTRUCTION.

FOR DIGITAL SIGNATURES/SEAL: This item has been digitally signed and sealed by JAMES ZALESKI P.E. 51544 on the date adjacent to the seal. Printed copies of this document are not considered signed and sealed and the signature must be verified on electronic copies.

OPT. PAPER SIZE: for 1/4" = 1'-0" on 24" x 36" PAPER SIZE ENLARGE PRINTS TO 200%


James Zaleski P.E 51544 2305 Haverhill Rd Tallahassee,Fl 32312 PH 850-766-7778

FINAL REVIEW CONSTRUCTION PLANS

TO REPORT COPYRIGHT VIOLATIONS CALL (770) 532-1128 THE USE OF THIS PLAN BY ANYONE OTHER THAN AN AGENT OF "AMERICA'S HOME PLACE, INC." IS IN VIOLATION OF THE FEDERAL COPYRIGHT VIOLATION ACT. \$1000 REWARD FOR RECOVERING AN ACTUAL COPYRIGHT INFRINGEMENT.
© COPYRIGHT-ALL RIGHTS RESERVED NOTE: VIOLATORS OF THE COPYRIGHT WILL BE PROSECUTED TO THE FULLEST EXTENT OF THE LAW. THIS WORK IS THE INTELLECTUAL PROPERTY OF AMERICA'S HOME PLACE AND SHALL NOT BE REPRODUCED WITHOUT PERMISSION.

PAPER SIZE: 11" x 17"


E-0	SCALE: As indicated	SHEET #	PROPERTY OF:	DRAWN BY: MARYORIE G.	JOB # 59-24-022	THE: ASHLEY 'A'		
	 © COPYRIGHT - 2024	CHECKED BY: J. DABNEY	2x6 EXTERIOR WALLS	FOR: WILLIAM E. & TRACY R. SAULS JR. 432 SE STARDUST PL. LAKE CITY FL 32024 COLUMBIA - FL	AREAS:	REVISION SCHEDULE		
		PRINTED: 1/2/2025 11:50:26 AM	FOUNDATION TYPE: MONOSLAB	OFFICE: GAINESVILLE SC	FIRST FLOOR HEATED	REV #	DESCRIPTION	DATE
					FRONT PORCH			
					TOTAL UNDER ROOF			
					8'x4' STD. STOOP			
				TOTAL UNCOVERED				
COVER SHEET								

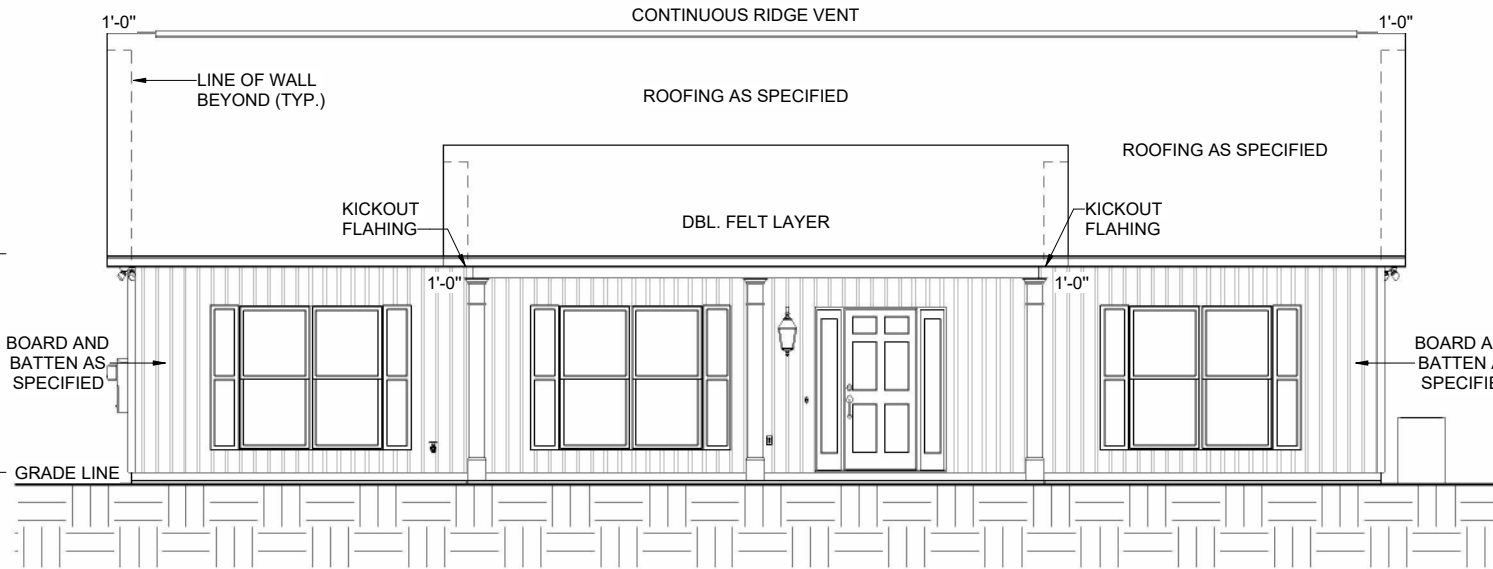


1 FRONT ELEVATION
1/8" = 1'-0"

General:
Reference Abbreviations: T: Table, F: Figure, E: Equation, S: Section
Wind Load Standard = ASCE 7-22 Basic Wind Speed = 130.0 mph
Exposure Classification = B Risk Category = II
Structure Type = Building Design Basis for Wind Pressures = ASD
MWFRS Analysis Method = Ch 27 C&C Analysis Method = Ch 30 Pt 1
Dynamic Type of Structure = Rigid Show Advanced Options = False

Building:
Roof = Roof Type = Gabled Encl = Enclosure Classification = Enclosed

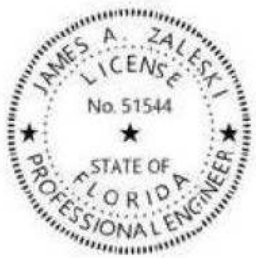

James Zaleski P.E 51544 2305 Haverhill Rd Tallahassee, FL 32312 PH 850-766-7778

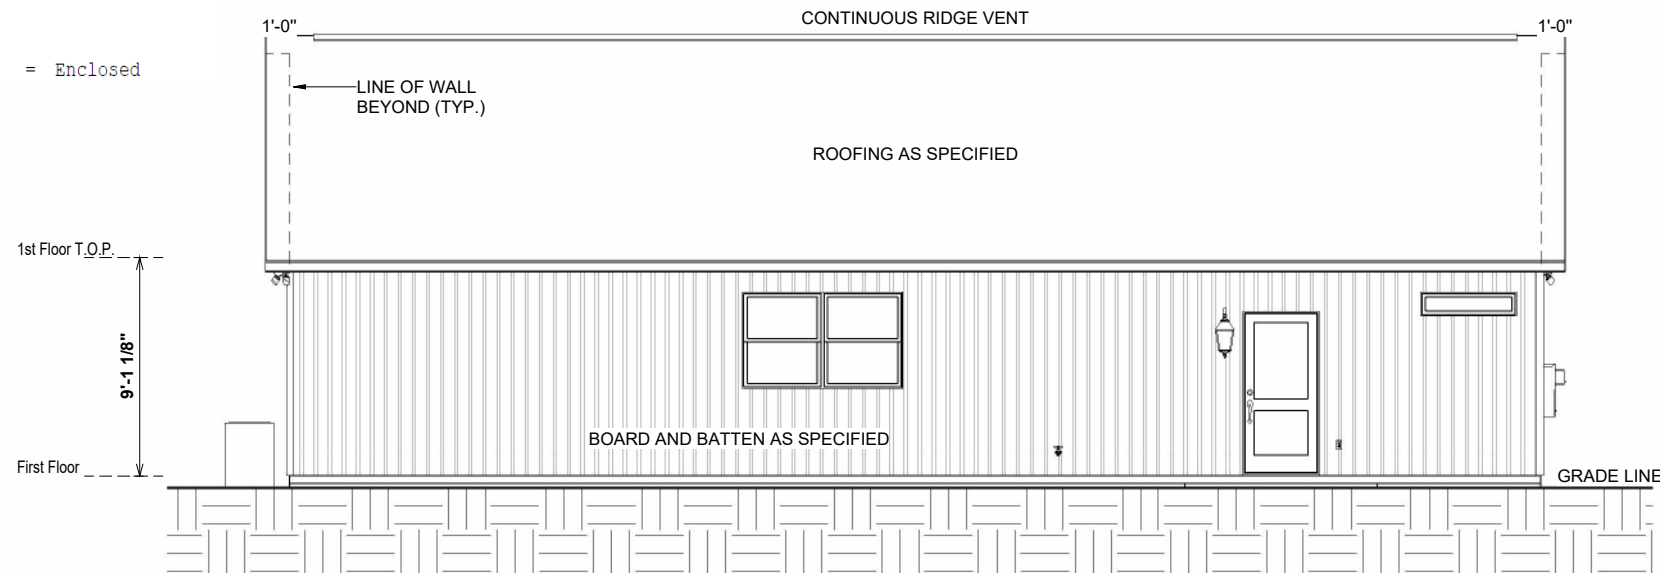

2 REAR ELEVATION
1/8" = 1'-0"

FOR DIGITAL SIGNATURES/SEAL: This item has been digitally signed and sealed by JAMES ZALESKI P.E. 51544 on the date adjacent to the seal. Printed copies of this document are not considered signed and sealed and the signature must be verified on electronic copies.

James A Zaleski
Digitally signed by James A Zaleski
Date: 2025.01.04 23:19:58 -05'00'

ELEVATION NOTES:

- MIN 9'-1 1/8" CEILING HEIGHT ON FIRST FLOOR U.N.O.
- 7/16" O.S.B AND HOUSEWRAP REQUIRED.
- ROOF OVERHANGS, AS NOTED, ARE FROM WALL SHEATHING TO OUTSIDE OF FASCIA.
- FINAL GRADE TO BE DETERMINED ON SITE.
- FOUNDATION DRAWN AS REPRESENTATION ONLY.

7:12 O.W.H. = 7 1/8"
4:12 O.W.H. = 4 1/4"

UNLESS OTHERWISE NOTED ON ROOF OVERVIEW

13,725 CUBIC FEET

REVISION SCHEDULE			
REV #	DESCRIPTION	DATE	
1	1,525 SF		
2	1,525 SF		
3	144 SF		
4	144 SF		
5	1,669 SF		
6	32 SF		
7	32 SF		

AREAS:

FIRST FLOOR HEATED

FRONT PORCH

TOTAL UNDER ROOF

8'x4' STD. STOOP


TOTAL UNCOVERED

THE:	ASHLEY 'A'
FOR:	WILLIAM E. & TRACY R. SAULS JR.
432 SE STARDUST PL. LAKE CITY FL 32024 COLUMBIA - FL	
OFFICE:	SOLD BY: L. HALLER
OFFICE:	GAINESVILLE SC

JOB #	59-24-022
DRAWN BY:	MARYORIE G.
CHECKED BY:	J. DABNEY
PRINTED:	1/2/2025 11:50:28 AM
FOUNDATION TYPE:	MONOSLAB
2X6 EXTERIOR WALLS	



PROPERTY OF:	AMERICA'S HOME PLACE
SHEET #	E-1
FRONT & REAR ELEVATIONS	

 [illegible]

2 RIGHT ELEVATION
1/8" = 1'-0"

OPT. PAPER SIZE: for 1/4" = 1'-0" on 24" x 36" PAPER SIZE ENLARGE PRINTS TO 200%

FINAL REVIEW CONSTRUCTION PLANS

7:12 O.W.H. = 7 1/8"
4:12 O.W.H. = 4 1/4"

James A Zaleski



Digitally signed by
James A Zaleski
Date: 2025.01.04
23:20:23 -05'00'

3" x 17"		200%		13,725 CUBIC FEET															
SHEET #		PROPERTY OF:		DRAWN BY:		JOB #		THE:		AREAS:		REVISION SCHEDULE							
E-2		 © COPYRIGHT - 2024		MARYORIE G.		59-24-022		ASHLEY 'A'		FIRST FLOOR HEATED		1,525 SF		REV #		DESCRIPTION		DATE	
				J. DABNEY		2x6 EXTERIOR WALLS		FOR: WILLIAM E. & TRACY R. SAULS JR.		FRONT PORCH		144 SF							
				PRINTED: 1/2/2025 11:50:30 AM		FOUNDATION TYPE: MONOSLAB		432 SE STARDUST PL. LAKE CITY FL 32024 COLUMBIA - FL		TOTAL UNDER ROOF		1,669 SF							
										8'x4' STD. STOOP		32 SF							
												TOTAL UNCOVERED		32 SF					
LEFT & RIGHT ELEVATION				OFFICE:		GAINESVILLE SC		SOLD BY:											
								L. HALLER											

TO REPORT COPYRIGHT VIOLATIONS CALL (770) 532-1128 THE USE OF THIS PLAN BY ANYONE OTHER THAN AN AGENT OF "AMERICA'S HOME PLACE, INC." IS IN VIOLATION OF THE FEDERAL COPYRIGHT VIOLATION ACT. \$1000 REWARD FOR RECOVERING AN ACTUAL COPYRIGHT INFRINGEMENT.
© COPYRIGHT-ALL RIGHTS RESERVED NOTE:VIOLATORS OF THE COPYRIGHT WILL BE PROSECUTED TO THE FULLEST EXTENT OF THE LAW. THIS WORK IS THE INTELLECTUAL PROPERTY OF AMERICA'S HOME PLACE AND SHALL NOT BE REPRODUCED WITHOUT PERMISSION.

PAPER SIZE: 11" x 17"

SCALE: 1/8" = 1'-0"

UNLESS OTHERWISE NOTED ON ROOF OVERVIEW

[illegible]

MAX OVERHANG 2.0 FT

Roof Slope = -7/12
Two SIMPSON SDWC 15600 6" SCREW PER TRUSS BEARING MAY BE USED IN LIEU OF H10A
1 SIMPSON SDWC 15600 6" SCREW PER TRUSS BEARING MAY BE USED IN LIEU OF H2.5A

NAILING PATTERN
EDGES-
6" O.C **FIELD - 6" O.C**
EDGE SPACING TO BE 4" O.C ON THE FIRST PANEL AT ALL EAVES

A circular professional engineer license seal for the State of Florida. The outer ring contains the text "JAMES A. ZALESKI" at the top and "PROFESSIONAL ENGINEER" at the bottom, separated by three stars. The inner circle contains the word "LICENSE" at the top, the license number "No. 51544" in the center, and "THE STATE OF FLORIDA" at the bottom, also separated by three stars.

FOR DIGITAL SIGNATURES/SEAL: This item has been digitally signed and sealed by JAMES ZALESKI P.E. 51544 on the date adjacent to the seal. Printed copies of this document are not considered signed and sealed and the signature must be verified on electronic copies.

OPT. PAPER SIZE: for 1/4" = 1'-0" on 24" x 36" PAPER SIZE ENLARGE PRINTS TO 200%

FINAL REVIEW CONSTRUCTION PLANS

TO REPORT COPYRIGHT VIOLATIONS CALL (770) 532-1128 THE USE OF THIS PLAN BY ANYONE OTHER THAN AN AGENT OF "AMERICA'S HOME PLACE, INC." IS IN VIOLATION OF THE FEDERAL COPYRIGHT VIOLATION ACT. \$1000 REWARD FOR RECOVERING AN ACTUAL COPYRIGHT INFRINGEMENT.
© COPYRIGHT-ALL RIGHTS RESERVED NOTE:VIOLATORS OF THE COPYRIGHT WILL BE PROSECUTED TO THE FULLEST EXTENT OF THE LAW. THIS WORK IS THE INTELLECTUAL PROPERTY OF AMERICA'S HOME PLACE AND SHALL NOT BE REPRODUCED WITHOUT PERMISSION.

PAPER SIZE: 11" x 17"

SCALE: 1/8" = 1'-0"

ROOF OVERVIEW

[illegible]


Digitally signed
by James A
Zaleski
Date:
2025.01.04
23:21:31 -05'00'

FOUNDATION NOTES:

- CONSTRUCTION METHOD
- TURN OUT REBAR AT THE POWER METER FOR ELECTRICAL GROUNDING AS REQUIRED BY CODE
- PORCH, STOOP & DECK HANDRAILS NOT INCLUDED WITH SLAB FOUNDATION AND RAILING IS A FORCED OPTION WHEN THE PORCH IS OVER 30" HIGH

TERMITE PROTECTION

TERMITE PROTECTION SHALL BE PROVIDED BY REGISTERED TERMITICIDES, INCLUDING SOIL APPLIED PESTICIDES, BAITING SYSTEMS, AND PESTICIDES APPLIED TO WOOD, OR OTHER APPROVED METHODS OF TERMITE PROTECTION LABELED FOR USE AS A PREVENTATIVE TREATMENT TO NEW CONSTRUCTION.

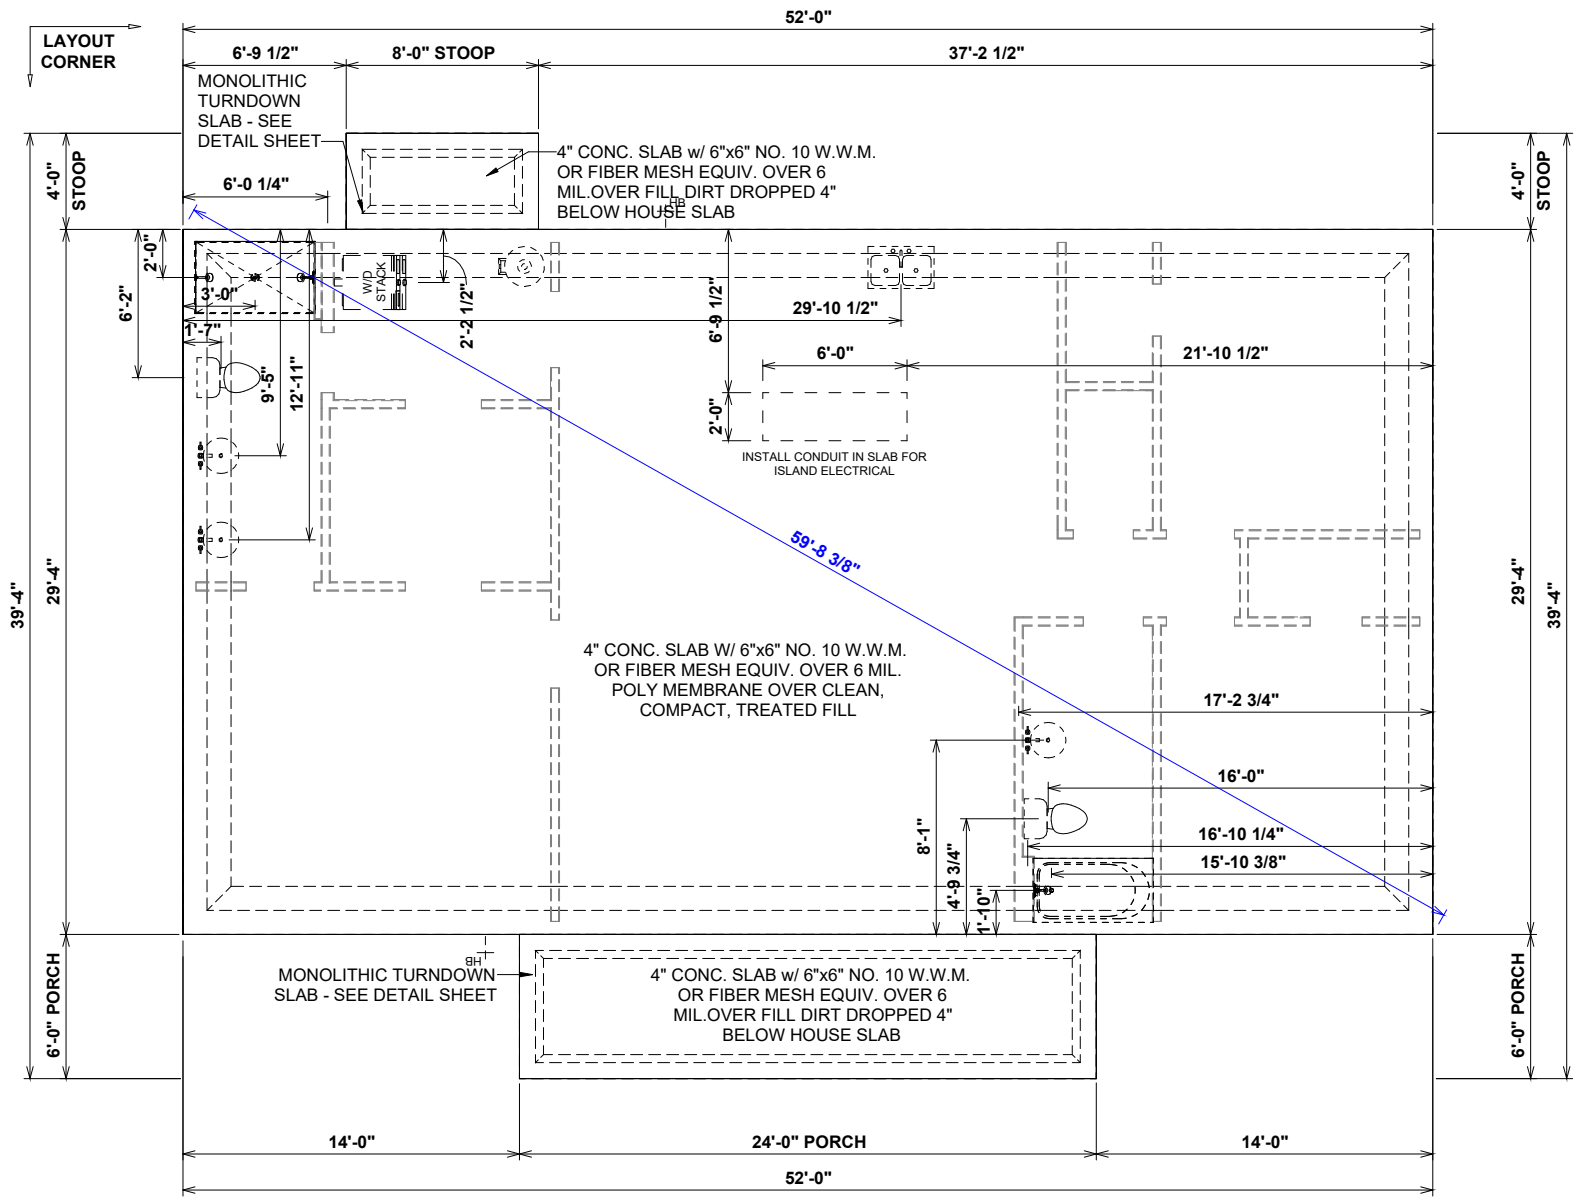

1. CONCRETE REQUIREMENTS:

ALL CONCRETE SHALL BE OF AT LEAST 3000PSI 28-DAY COMPRESSIVE STRENGTH.
ALL CONCRETE GRADE BEAMS AND SLABS SHALL BE RUN CONTINUOUSLY AS TO
BEHAVE IN A MONOLITHIC FASHION.

CONCRETE SLAB THICKNESS SHALL BE 4" ABOVE THE FOOTERS, AS SHOWN IN THE DETAILS.

STEP DOWNS AND LEDGES IN THE CONCRETE SHALL NOT REDUCE THE CONCRETE COVER REQUIREMENT FOR STEEL REINFORCEMENT.

A 6 MIL VAPOR BARRIER SHALL BE PLACED PRIOR TO CONCRETE POUR, AS SHOWN IN THE DETAILS.

2- REINFORCEMENT REQUIREMENTS:

ALL STEEL REINFORCEMENT SHALL BE GRADE 60 (60 KSI).
3" OF PROPER, MINIMUM COVER OVER REBAR SHALL BE MAINTAINED FROM ALL
CONCRETE SURFACES, AS SHOWN IN THE DETAILS.

NO. 2 WIRE TIES SHALL BE PLACED 48" ON CENTER WITH A MINIMUM OF THREE TIES PER BAR, AS SHOWN IN THE DETAILS.

ALL LONGITUDINAL REBAR SHALL BE RUN CONTINUOUSLY SUCH THAT THE FOUNDATION SYSTEM ACTS IN A MONOLITHIC FASHION.

ALL REBAR OVERLAPS (LAP SPLICES) SHALL BE AT LEAST 40".

① FOUNDATION PLAN
1/8" = 1'-0"

FOR DIGITAL SIGNATURES/SEAL: This item has been digitally signed and sealed by JAMES ZALESKI P.E. 51544 on the date adjacent to the seal. Printed copies of this document are not considered signed and sealed and the signature must be verified on electronic copies.



James Zaleski P.E 51544 2305 Haverhill Rd Tallahassee,Fl 32312 PH 850-766-7778

OPT. PAPER SIZE: for 1/4" = 1'-0" on 24" x 36" PAPER SIZE ENLARGE PRINTS TO 200%

FINAL REVIEW CONSTRUCTION PLANS

TO REPORT COPYRIGHT VIOLATIONS CALL (770) 532-1128. THE USE OF THIS PLAN BY ANYONE OTHER THAN AN AGENT OF "AMERICA'S HOME PLACE, INC." IS IN VIOLATION OF THE FEDERAL COPYRIGHT VIOLATION ACT. \$1000 REWARD FOR RECOVERING AN ACTUAL COPYRIGHT INFRINGEMENT.
© COPYRIGHT ALL RIGHTS RESERVED. NOTE: VIOLATORS OF THE COPYRIGHT WILL BE PROSECUTED TO THE FULLEST EXTENT OF THE LAW. THIS WORK IS THE INTELLECTUAL PROPERTY OF AMERICA'S HOME PLACE AND SHALL NOT BE REPRODUCED WITHOUT PERMISSION.


PAPER SIZE: 11" x 17"

SCALE: 1/8" = 1'-0"


FOUNDATION PLAN

James A
Zaleski


Digitally signed by
James A Zaleski
Date: 2025.01.04
23:21:47 -05'00'

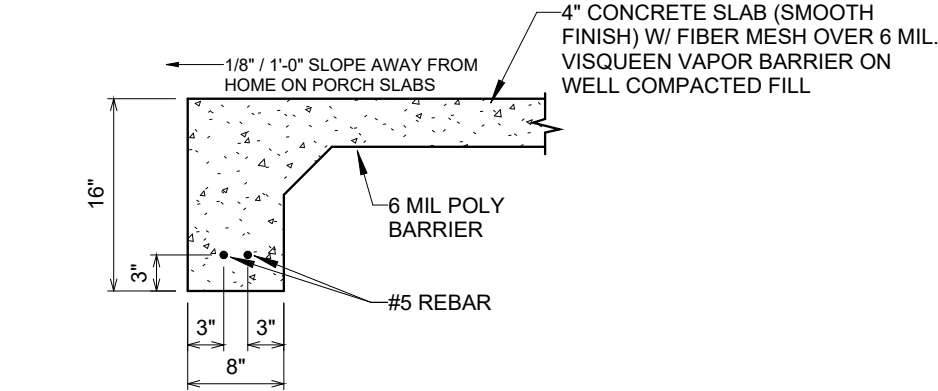

2 EDGE OF TURNED DOWN PATIO SLAB
3/4" = 1'-0"

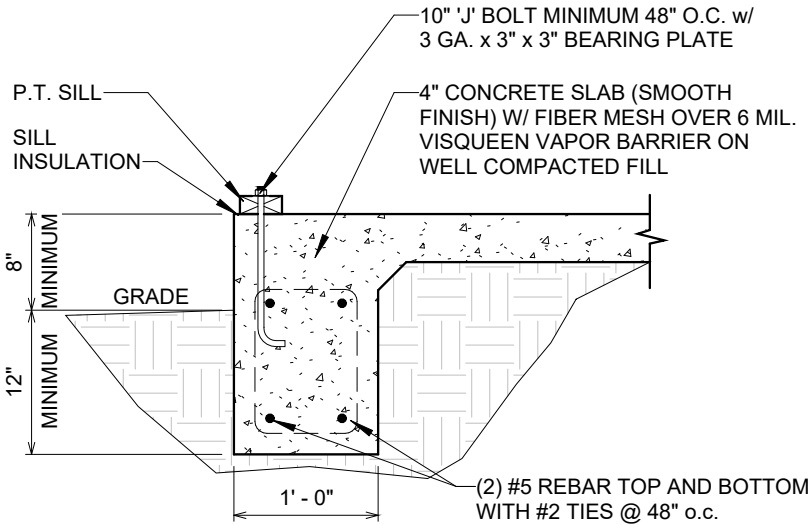

1 1 STORY MONOSLAB DETAIL
3/4" = 1'-0"

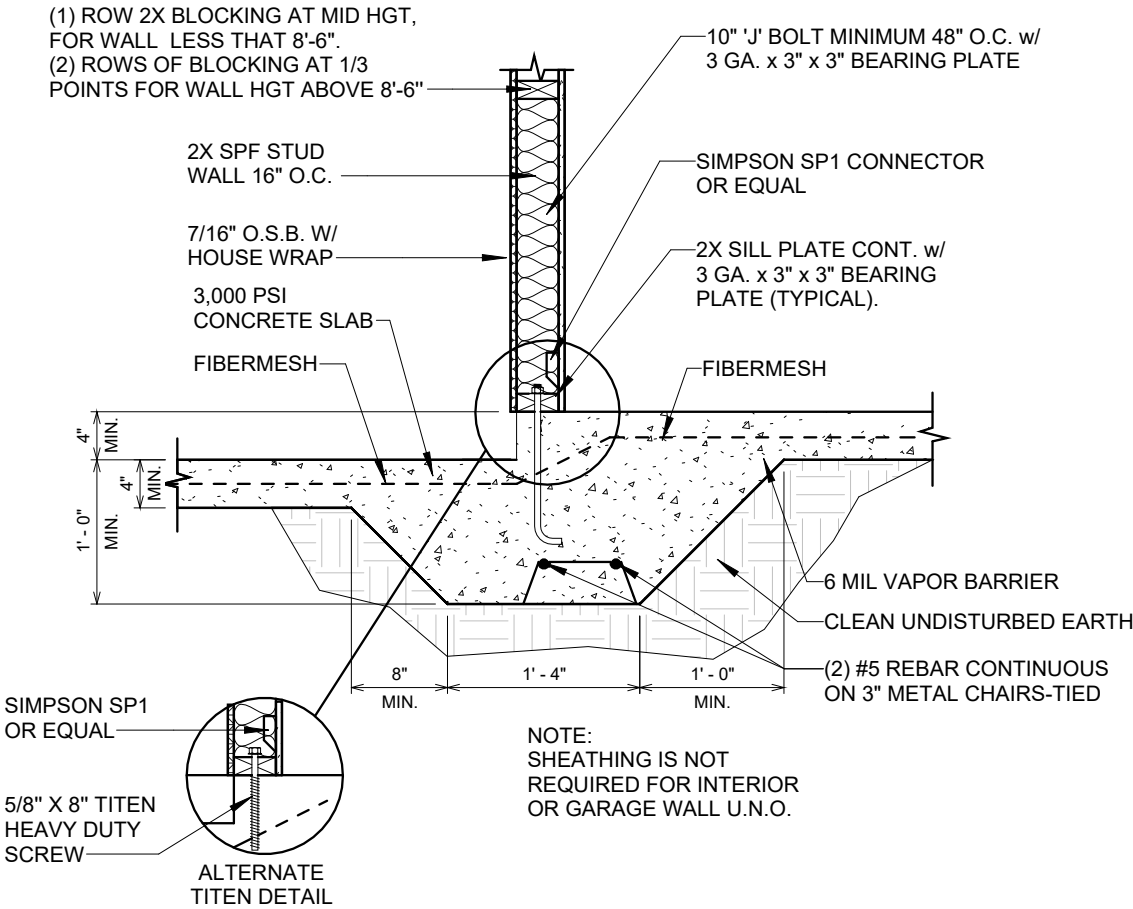

3 BEARING WALL AT STEP
3/4" = 1'-0"

REVISION SCHEDULE				13,725 CUBIC FEET	
REV #	DESCRIPTION	DATE	AREA:	FIRST FLOOR HEATED	1,525 SF
				FRONT PORCH	144 SF
				TOTAL UNDER ROOF	1,669 SF
				8'x4' STD. STOOP	32 SF
				TOTAL UNCOVERED	32 SF
THE: ASHLEY 'A'				SOLD BY: L. HALLER	
FOR: WILLIAM E. & TRACY R. SAULS JR.				OFFICE: GAINESVILLE SC	
JOB # 59-24-022				432 SE STARDUST PL. LAKE CITY FL 32024 COLUMBIA - FL	
2x6 EXTERIOR WALLS				FOUNDATION TYPE: MONOSLAB	
DRAWN BY: MARYORIE G.				PRINTED: 1/2/2025 11:50:31 AM	
CHECKED BY: J. DABNEY				© COPYRIGHT - 2024	
PROPERTY OF: AMERICA'S HOME PLACE				MONOSLAB FOUNDATION DETAILS	
SHEET # F-1.1				SCALE: 3/4" = 1'-0"	

FOR DIGITAL SIGNATURES/SEAL: This item has been digitally signed and sealed by JAMES ZALESKI P.E. 51544 on the date adjacent to the seal. Printed copies of this document are not considered signed and sealed and the signature must be verified on electronic copies.



James Zaleski P.E 51544 2305 Haverhill Rd Tallahassee,FI 32312 PH 850-766-7778

FINAL REVIEW CONSTRUCTION PLANS

TO REPORT COPYRIGHT VIOLATIONS CALL (770) 532-1128 THE USE OF THIS PLAN BY ANYONE OTHER THAN AN AGENT OF "AMERICA'S HOME PLACE, INC." IS IN VIOLATION OF THE FEDERAL COPYRIGHT VIOLATION ACT. \$1000 REWARD FOR RECOVERING AN ACTUAL COPYRIGHT INFRINGEMENT.

PAPER SIZE: 11" x 17"

SCALE: 3/4" = 1'-0"

MONOSLAB FOUNDATION
DETAILS

FOR DIGITAL SIGNATURES/SEAL: This item has been digitally signed and sealed by JAMES ZALESKI P.E. 51544 on the date adjacent to the seal. Printed copies of this document are not considered signed and sealed and the signature must be verified on electronic copies.



GENERAL NOTES:


- MINIMUM 9'-1 1/8" CEILING HEIGHT ON FIRST FLOOR U.N.O.
- ALL LOAD BEARING WALLS AND EXTERIOR OPENINGS TO HAVE (2) 2x10 HEADERS U.N.O.
- STANDARD FIRST FLOOR WINDOW HEADER HEIGHTS SHALL BE FRAMED DOWN 2'-2" FROM T.O.P., U.N.O.
- WINDOW HEADERS FOR WINDOWS LOCATED ABOVE KITCHEN SINK SHALL BE FRAMED DOWN 1'-5" FROM T.O.P., U.N.O.
- 7/16" O.S.B. AND HOUSEWRAP REQUIRED.
- DIMENSIONS ARE TO SHEATHING EXTERIOR; SUBTRACT 1/2" FROM DIMENSIONS FOR EXTERIOR WINDOW AND DOOR FRAMING LOCATION IF OPENINGS ARE FRAMED BEFORE SHEATHING INSTALLATION.
- ALL INTERIOR DOORS ARE EITHER CENTERED ON WALLS OR ROUGH OPENING STARTED MINIMUM OF 4" FROM ADJOINING WALL UNLESS OTHERWISE DIMENSIONED.
- NUMBER OF STAIR TREADS AND RISERS MAY VARY AS A RESULT OF LOCAL BUILDING CODES, STANDARDS AND FINAL GRADE.
- ALL SHELVES TO BE 12" DEEP U.N.O.
- HEIGHT OFF FLOOR TO BE:
 - SINGLE 68"
 - DOUBLE 42" AND 84"

- ALL PLUMBING FIXTURES SHOWN ARE A REPRESENTATION OF SIZE AND LOCATION ONLY. ACTUAL STYLE AND BRAND OF FIXTURES MAY VARY PER OFFICE LOCATION.
- ALL TUBS / SHOWERS TO HAVE NAILERS AT FLANGE.
- INSTALL A 24" WIDE WALKWAY FROM ATTIC ACCESS TO FURNACE PLATFORM.
- PORCH, STOOP, & DECK HANDRAILS NOT INCLUDED W/ SLAB FOUNDATION.
- RAILINGS ARE A FORCED OPTION WHEN PORCH IS OVER 30" HIGH FROM FINISHED GRADE.
- PORCH, STOOP & DECK HANDRAILS NOT INCLUDED WITH SLAB FOUNDATION AND RAILING IS A FORCED OPTION WHEN THE PORCH IS OVER 30" HIGH

	MASTER	EDO	SHOULD BE	SHOWN	NEED ON EDO
BASE CAB.	171	+72	243	243	0
WALL CAB.	171	-69	102	141	CREDIT OF 30
COUNTER	39 SF	0	39 SF	53 SF	+14 SF

SPECIAL NOTES:

- SCHLUTER DITRA UNCOUPLING AND WATERPROOFING MEMBRANE TO BE USED ON ALL TILE SHOWER INSTALLATIONS.

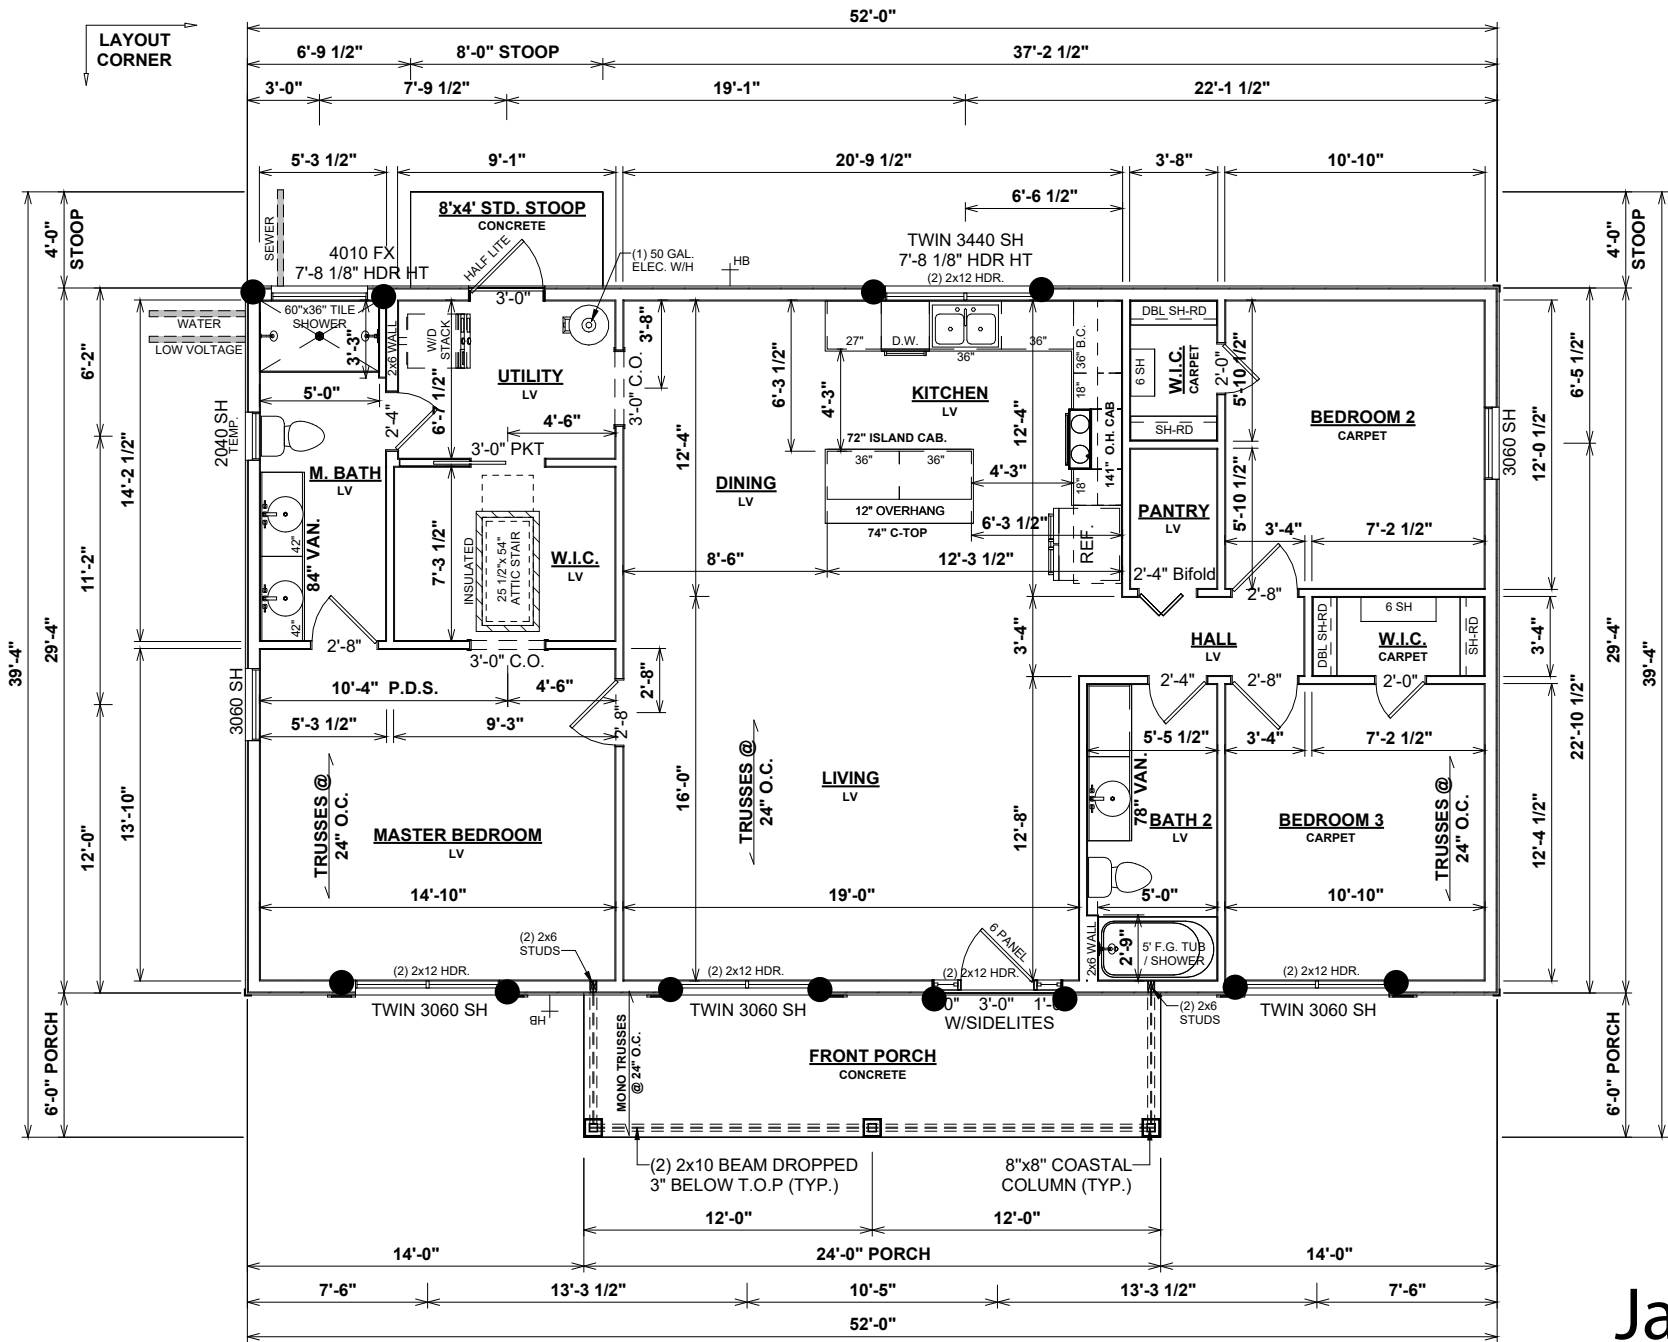

1 FIRST FLOOR PLAN
1/8" = 1'-0"

● INDICATES SIMPSON HDU2 HOLD DOWN TO DOUBLE STUD MIN WTH 8" ANCHOR

SHEATH EXTERIOR 100%

James Zaleski PE #51544 2305 Haverhill Rd Tall Fl 32312 ph 850-766-7778

Digitally signed by James A Zaleski
Date: 2025.01.04 23:22:05
-05'00'

13,725 CUBIC FEET

REVISION SCHEDULE			
REV #	DESCRIPTION	DATE	
1	FIRST FLOOR HEATED	1,525 SF	
2	FRONT PORCH	144 SF	
3	TOTAL UNDER ROOF	1,669 SF	
4	8'x4' STD. STOOP	32 SF	
5	TOTAL UNCOVERED	32 SF	

THE:	ASHLEY 'A'
FOR:	WILLIAM E. & TRACY R. SAULS JR.
	432 SE STARDUST PL. LAKE CITY FL 32024 COLUMBIA - FL
OFFICE:	SOLD BY: L. HALLER GAINESVILLE SC

JOB #	59-24-022
DRAWN BY:	MARYORIE G.
CHECKED BY:	J. DABNEY
PRINTED:	1/2/2025 11:50:32 AM
FOUNDATION TYPE:	MONOSLAB

PROPERTY OF:	AMERICA'S HOME PLACE
SHEET #	F-2
FIRST FLOOR PLAN	

Digitally signed by James A
Zaleski
Date: 2025.01.04 23:22:21
-05'00'




A circular professional engineer seal for James A. Zaleski. The outer ring contains the text "JAMES A. ZALESKI" at the top and "PROFESSIONAL ENGINEER" at the bottom, separated by three stars. The inner circle contains the text "LICENSE" at the top, "No. 51544" in the center, and "STATE OF FLORIDA" at the bottom, also separated by three stars.

FIRST FLOOR ELEC & HVAC

- 2 X 6 STUDS AT 16" O.C. UP TO 16 FEET

Digitally signed by
James A Zaleski
Date: 2025.01.04
23:22:38 -05'00'


BEAM TO WALL/CORNER CONNECTION - POCKET AND NAIL INTO WALL W/ (10) 16
PENNY NAILS, STRAP W/ SIMPSON H7Z.

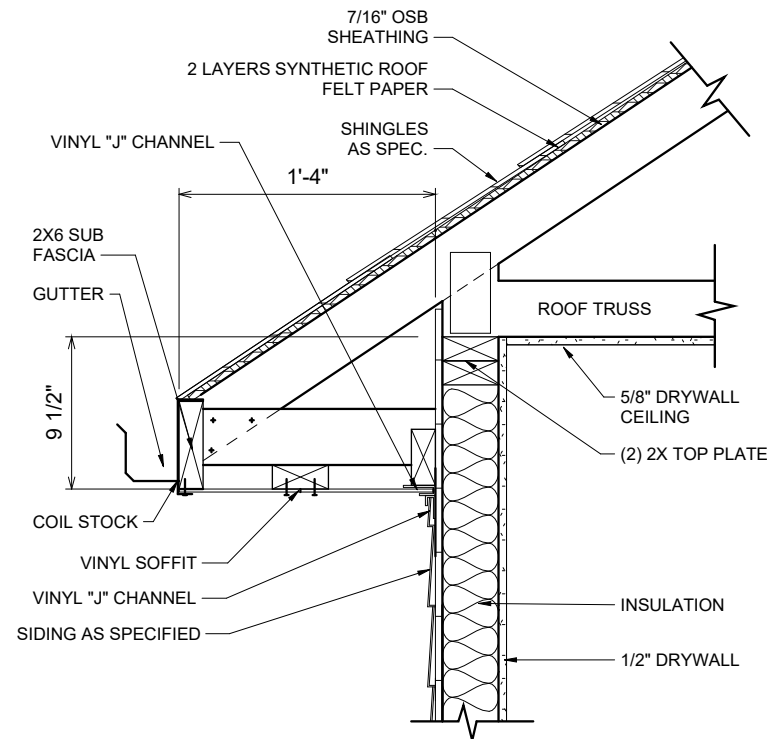

① RAFTER TAIL AT CONC. SIDING WALL - FL
1" = 1'-0"

NOTE:
1/2" X 10"ANCHOR BOLTS W/WASHERS,
WITHIN 6" OF ALL CORNERS, PLATE ENDS
AND EACH SIDE OF AN OPENING.
THEN SPACED A MINIMUM OF 4'-0" O.C. OR
AS REQUIRED.

② 1 STORY WALL SECTION ON SLAB - FL
1/2" = 1'-0"

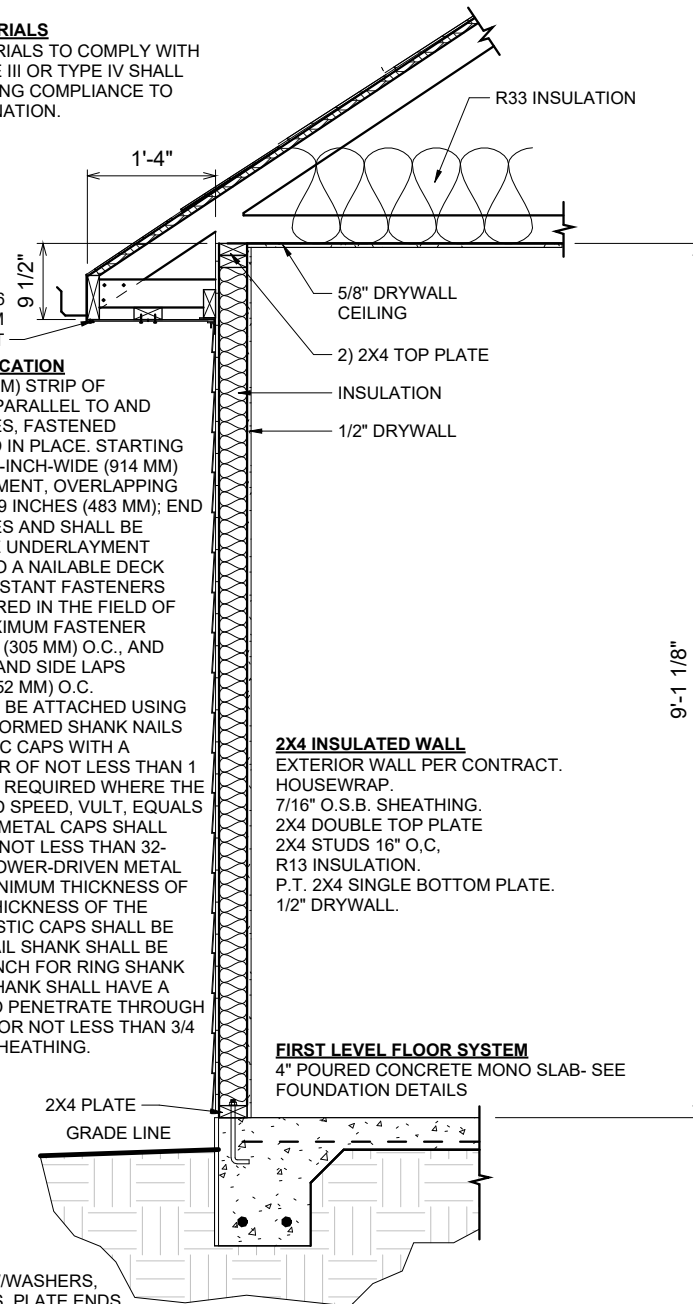

2X4 INSULATED WALL
EXTERIOR WALL PER CONTRACT.
HOUSEWRAP.
7/16" O.S.B. SHEATHING.
2X4 DOUBLE TOP PLATE
2X4 STUDS 16" O.C,
R13 INSULATION.
P.T. 2X4 SINGLE BOTTOM PLATE.
1/2" DRYWALL.

FIRST LEVEL FLOOR SYSTEM
4" POURED CONCRETE MONO SLAB- SEE
FOUNDATION DETAILS



17" x		200%	
S-1		PROPERTY OF:  © COPYRIGHT - 2024	
SHEET #		DRAWN BY: MARYORIE G.	
MONOSLAB WALL SECTIONS		CHECKED BY: J. DABNEY	
		PRINTED: 1/2/2025 11:50:33 AM	
		FOUNDATION TYPE: MONOSLAB	
		THE: ASHLEY 'A'	
FOR: WILLIAM E. & TRACY R. SAULS JR.		JOB # 59-24-022	
13,725 CUBIC FEET		AREAS:	
FIRST FLOOR HEATED		1,525 SF	
FRONT PORCH		1,525 SF	
TOTAL UNDER ROOF		144 SF	
8'x4' STD. STOOP		1,669 SF	
TOTAL UNCOVERED		32 SF	
32 SF		32 SF	
REVISION SCHEDULE		REV #	
DESCRIPTION		DATE	

James Zaleski P.E 51544 2305 Haverhill Rd Tallahassee, FL 32312 PH 850-766-7778

OPT. PAPER SIZE: for 1/4" = 1'-0" on 24" x 36" PAPER SIZE ENLARGE PRINTS TO 200%

 
FINAL REVIEW CONSTRUCTION PLANS

TO REPORT COPYRIGHT VIOLATIONS CALL (770) 532-1128 THE USE OF THIS PLAN BY ANYONE OTHER THAN AN AGENT OF "AMERICA'S HOME PLACE, INC." IS IN VIOLATION OF THE FEDERAL COPYRIGHT VIOLATION ACT. \$1000 REWARD FOR RECOVERING AN ACTUAL COPYRIGHT INFRINGEMENT.
© COPYRIGHT-ALL RIGHTS RESERVED NOTE:VIOLATORS OF THE COPYRIGHT WILL BE PROSECUTED TO THE FULLEST EXTENT OF THE LAW. THIS WORK IS THE INTELLECTUAL PROPERTY OF AMERICA'S HOME PLACE AND SHALL NOT BE REPRODUCED WITHOUT PERMISSION.


PAPER SIZE: 11" x 17"

SCALE: As indicated


MONOSLAB WALL SECTIONS



RAFTER WITH NO STUD BELOW
WHEN H2 ARE NOT USED PROVIDE
SIMPSON CS16 @ 48" O.C. STRAP OVER
TOP PLATE AND MIN. 10" LAP ON STUDS U.N.O.

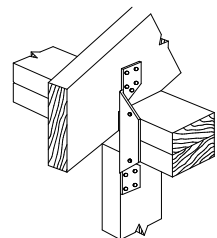

 RAFTER ABOVE STUD
 WHEN H2 ARE USED EVERY OTHER JOIST
 SIMPSON CS16 STRAP OVER TOP PLATE
 & MIN. 10" LAP ON STUDS ARE NOT REQUIRED U.N.O.



USP #SPT4
UPLIFT - 735#

USP #RT7
UPLIFT - 585#

USP #FA3
UPLIFT = 760#

BP582

USP #SPT22
UPLIFT - 595#

USP #RT3
UPLIFT - 475#

OPTIONAL SLAB/BOTTOM PLATE/WALL CONNECTIONS UPLIFT - 1105#
SIMPSON H2.5, H3, OR SSP OR DSP BOTTOM PLATE TO STUDS

James A
Zaleski

Digitally signed
by James A
Zaleski
Date: 2025.01.04
23:22:57 -05'00'

FULL DEPTH BLOCKING @ 4'-0"
O.C. FIRST (4) SPACES FROM
END. NOTCH FIRST BLOCK
AROUND NAILER

1/2" GYPSUM DRYWALL
(SEE GENERAL NOTES)

1-1/4" TYPE S OR W #6 DRYWALL
SCREWS @ 7" (TYP. THROUGHOUT)

8d COMMON NAILS @ 4" O.C.

ENDWALL CEILING CONNECTION

NOTE: DETAIL ABOVE NOT REQUIRED
FOR CONTINUOUS TRUSSES.

USP RT16 STRAP AT
ALL BEARING POINTS

RT16 MUST BE INSTALLED ON OUTSIDE OF STUD WALL. IF INSTALLED ON INSIDE OF WALL, STUDS ON EITHER SIDE OF RT16 MUST BE ANCHORED TO TOP PLATE USING RT7 STRAPS.

INTERIOR LOAD BEARING WALLS--
STRAP TRUSSE/RAFTERS TO TOP PLATES
WITH USP RT16. ANCHOR TOP PLATES TO
STUDS WITH USP SPT24 STRAPS ON SAME
SIDE AS RT16 STRAPS. CONNECT 2ND
FLOOR WALL STUDS TO 1ST FLOOR WALL
STUDS OR BEAMS USING USP RS200
STRAPS @ 48" O.C. (MIN. 11 8d NAILS EACH
END). ATTACH 1ST FLOOR STUDS TO
SUPPORTING GIRDERS IN SIMILAR MANNER.
ANCHOR FLOOR JOISTS TO DROPPED
GIRDERS WITH USP RT 17. SEE DETAIL I
FOR DROPPED GIRDER ANCHORING.

OPTIONAL RAFTER OR STUD/POST
TO DBL PLATE/HEADER CONNECTION:
6" FASTENMASTER TIMBERLOK
INSTALLED AT 22.5 DEGREE
MIN. 2.5" FROM CONNECTION
WWW.FASTENMASTER.COM

TRUSS/RAFTER
(SHOWN @ 16" oc)
1/2" MIN. PLYWOOD:
MAINTAIN 2'-0" DISTANCE
BETWEEN CENTER OF TOP
PLATE AND SHEATHING
JOINT (SEE DETAIL B)

ENDWALL OR GABLE
TRUSS/JOIST

USP RS200 STRAP--WRAP AROUND TOP PLATES AND 4TH CEILING JOIST/TRUSS FROM END. NAIL WITH MIN. (8) 8d NAILS EACH END AND (2) 8d NAILS AT EACH INTERMEDIATE JOIST. TYP. WITHIN 6" OF EACH ROW OF BLOCKING. STRAP MAY BE PLACED ABOVE OR BELOW BLOCKING

BELOW GABLE END TRUSS/RAFTER/JOIST
(BALLOON FRAME VAULTED GABLE END)

STRAP OVERBUILT VALLEY
SET) TRUSSES/RAFTERS OVER
MAIN TRUSSES/RAFTERS WITH
USP MTW12 OR MTW18

USP STRAP RS200 -- WRAP
OVER TOP OF EVERY PIGGY
BACK RAFTER/TRUSS AND FASTEN
WITH (4) 8d COMMON NAILS
AT EACH MEMBER

OPTIONAL RAFTER TIEDOWN IS:
6" FASTENMASTER TIMBERLOK
2"-3" IN TOP AND 3"-4" IN BOTTOM

MIN. (4) 8d COMMON NAILS
ON EACH SIDE OF 2 MEMBER
CONNECTION

RAFTER TO HIP CONNECTION:
SIMPSON LS50 OR
(2) 1/4"X3.5" WOOD SCREWS PLACED
AT 1/3 DEPTH POINTS AND PASS
THROUGH THE INSIDE CORNER OF CONNECTION

OPTIONAL TIEDOWN IS THE QUICK TIE SYSTEM
WWW.QUICKTIEPRODUCTS.COM
CONTRACTOR SHALL SUBMIT TIEDOWN PLAN
FOR ENGINEER'S APPROVAL



USP RS200 STRAP--OVERLAP
TOP AND BOTTOM HEADER (USE
BLOCKING BETWEEN STUDS WHERE
HEADERS DON'T ALIGN) 12" MIN.
EACH SIDE. TYP. WITH CORNER
WALLS SHEATHED LESS THAN 3'-6"
EITHER WAY AND ALL BAY WINDOWS.

SEE WALL SECTIONS FOR VERICAL TIEDOWN

HORIZONTAL STRAPPING DETAIL @ CORNERS

OPT. PAPER SIZE: for 1/4" = 1'-0" on 24" x 36" PAPER SIZE ENLARGE PRINTS TO 200%

TO REPORT COPYRIGHT VIOLATIONS CALL (770) 532-1128 THE USE OF THIS PLAN BY ANYONE OTHER THAN AN AGENT OF "AMERICA'S HOME PLACE, INC." IS IN VIOLATION OF THE FEDERAL COPYRIGHT VIOLATION ACT. \$1000 REWARD FOR RECOVERING AN ACTUAL COPYRIGHT INFRINGEMENT.
© COPYRIGHT-ALL RIGHTS RESERVED NOTE:VIOLATORS OF THE COPYRIGHT WILL BE PROSECUTED TO THE FULLEST EXTENT OF THE LAW. THIS WORK IS THE INTELLECTUAL PROPERTY OF AMERICA'S HOME PLACE AND SHALL NOT BE REPRODUCED WITHOUT PERMISSION.

PAPER SIZE: 11" x 17"


SCALE: As indicated

[illegible]


BEAM TO WALL/CORNER CONNECTION - POCKET AND NAIL INTO WALL W/ (10) 16 PENNY NAILS, STRAP W/ SIMPSON H7Z.

Digitally signed by James A
Zaleski


Date: 2025.01.04 23:23:17 -05'00'

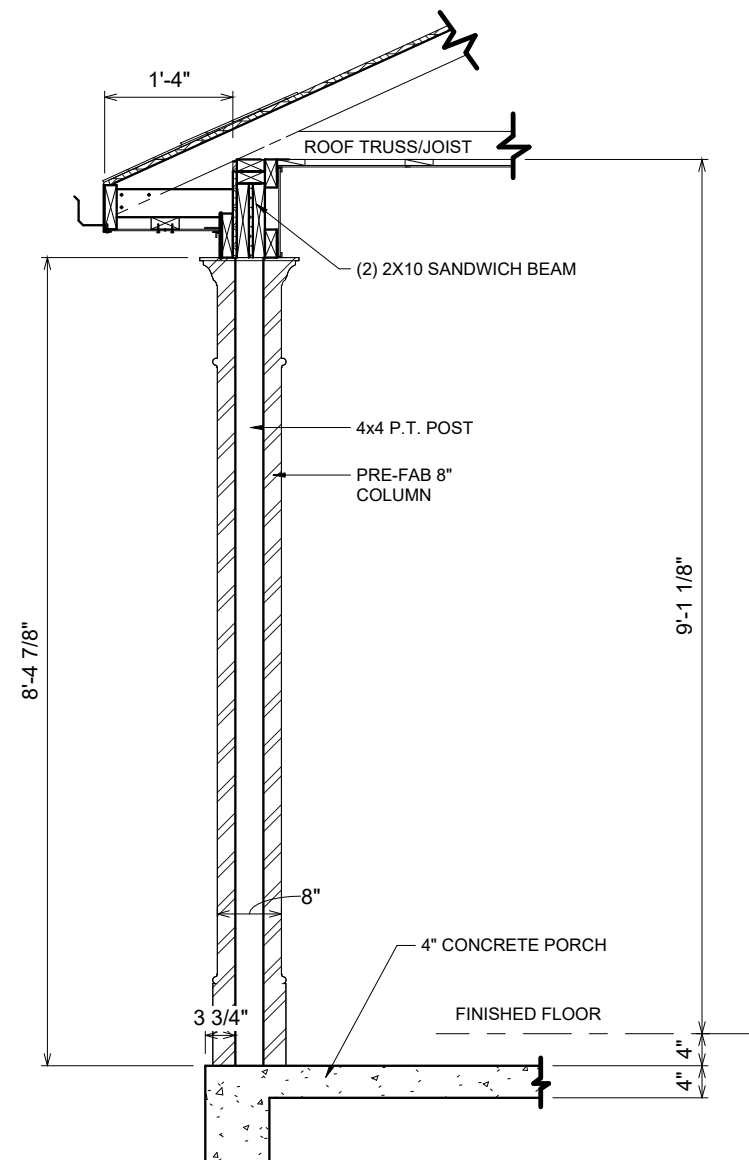

② 820.1 8" PORCH COLUMN - FL - ON CONC
1/2" = 1'-0"

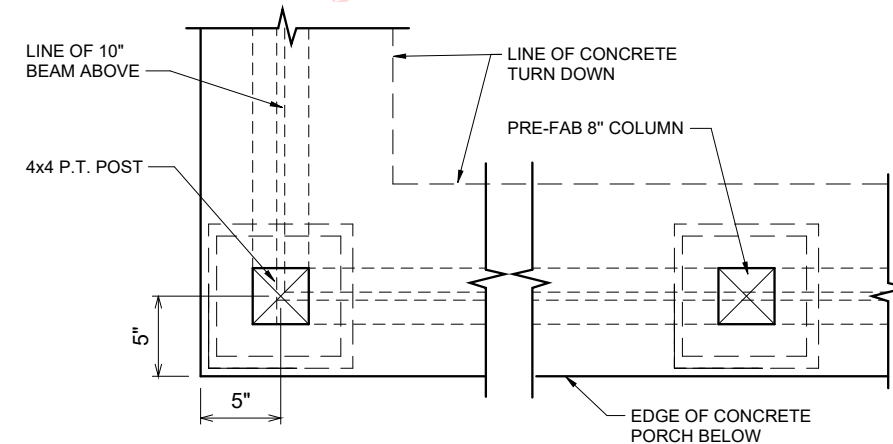

① 820.2 PORCH 8" COLUMN FRAMING ON SLAB
1" = 1'-0"

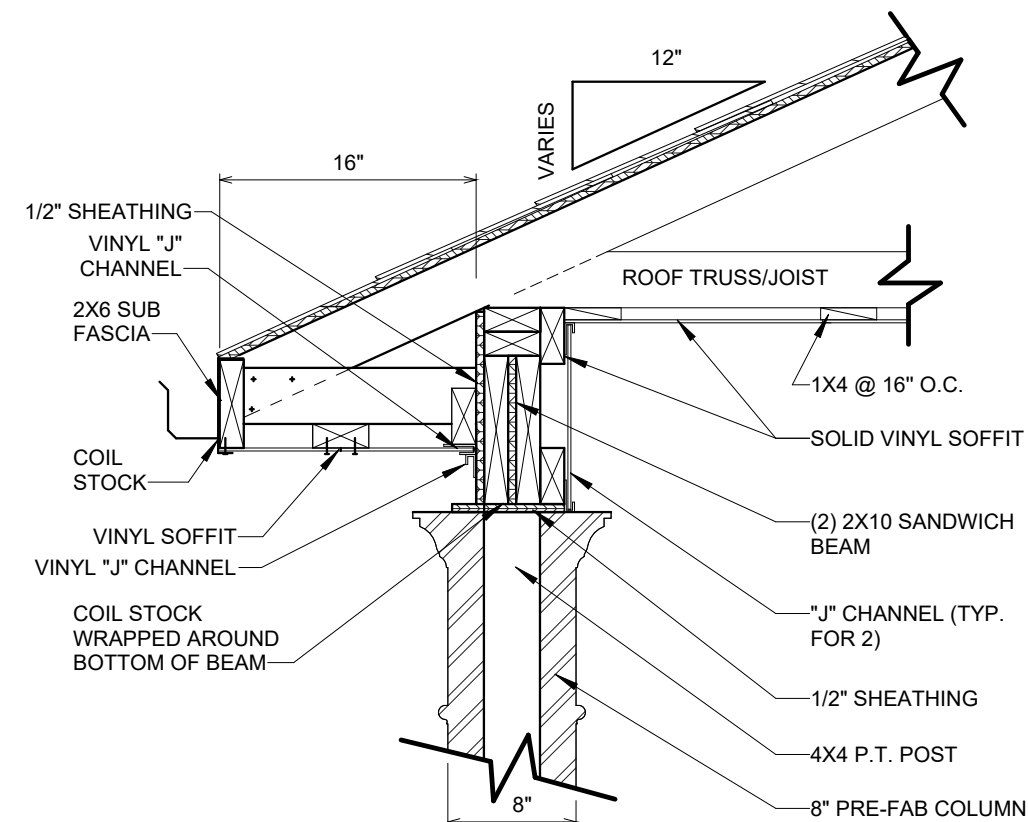

3 8" COLUMN PORCH SOFFIT DETAIL - FL
1" = 1'-0"

FOR DIGITAL SIGNATURES/SEAL: This item has been digitally signed and sealed by JAMES ZALESKI P.E. 51544 on the date adjacent to the seal. Printed copies of this document are not considered signed and sealed and the signature must be verified on electronic copies.

James Zaleski P.E 51544 2305 Haverhill Rd Tallahassee, FL 32312 PH 850-766-7778

OPT. PAPER SIZE: for 1/4" = 1'-0" on 24" x 36" PAPER SIZE ENLARGE PRINTS TO 200%

FINAL REVIEW CONSTRUCTION PLANS


TO REPORT COPYRIGHT VIOLATIONS CALL (770) 532-1128 THE USE OF THIS PLAN BY ANYONE OTHER THAN AN AGENT OF "AMERICA'S HOME PLACE, INC." IS IN VIOLATION OF THE FEDERAL COPYRIGHT VIOLATION ACT. \$1000 REWARD FOR RECOVERING AN ACTUAL COPYRIGHT INFRINGEMENT.
© COPYRIGHT-ALL RIGHTS RESERVED NOTE:VIOLATORS OF THE COPYRIGHT WILL BE PROSECUTED TO THE FULLEST EXTENT OF THE LAW. THIS WORK IS THE INTELLECTUAL PROPERTY OF AMERICA'S HOME PLACE AND SHALL NOT BE REPRODUCED WITHOUT PERMISSION.

PAPER SIZE: 11" x 17"

SCALE: As indicated


COLUMN DETAILS

13,725 CUBIC FEET	AREAS:		REVISION SCHEDULE	
	FIRST FLOOR HEATED	1,525 SF	REV #	DESCRIPTION
	FRONT PORCH	144 SF		
	TOTAL UNDER ROOF	1,669 SF		
	8'x4' STD. STOOP	32 SF		
	TOTAL UNCOVERED	32 SF		

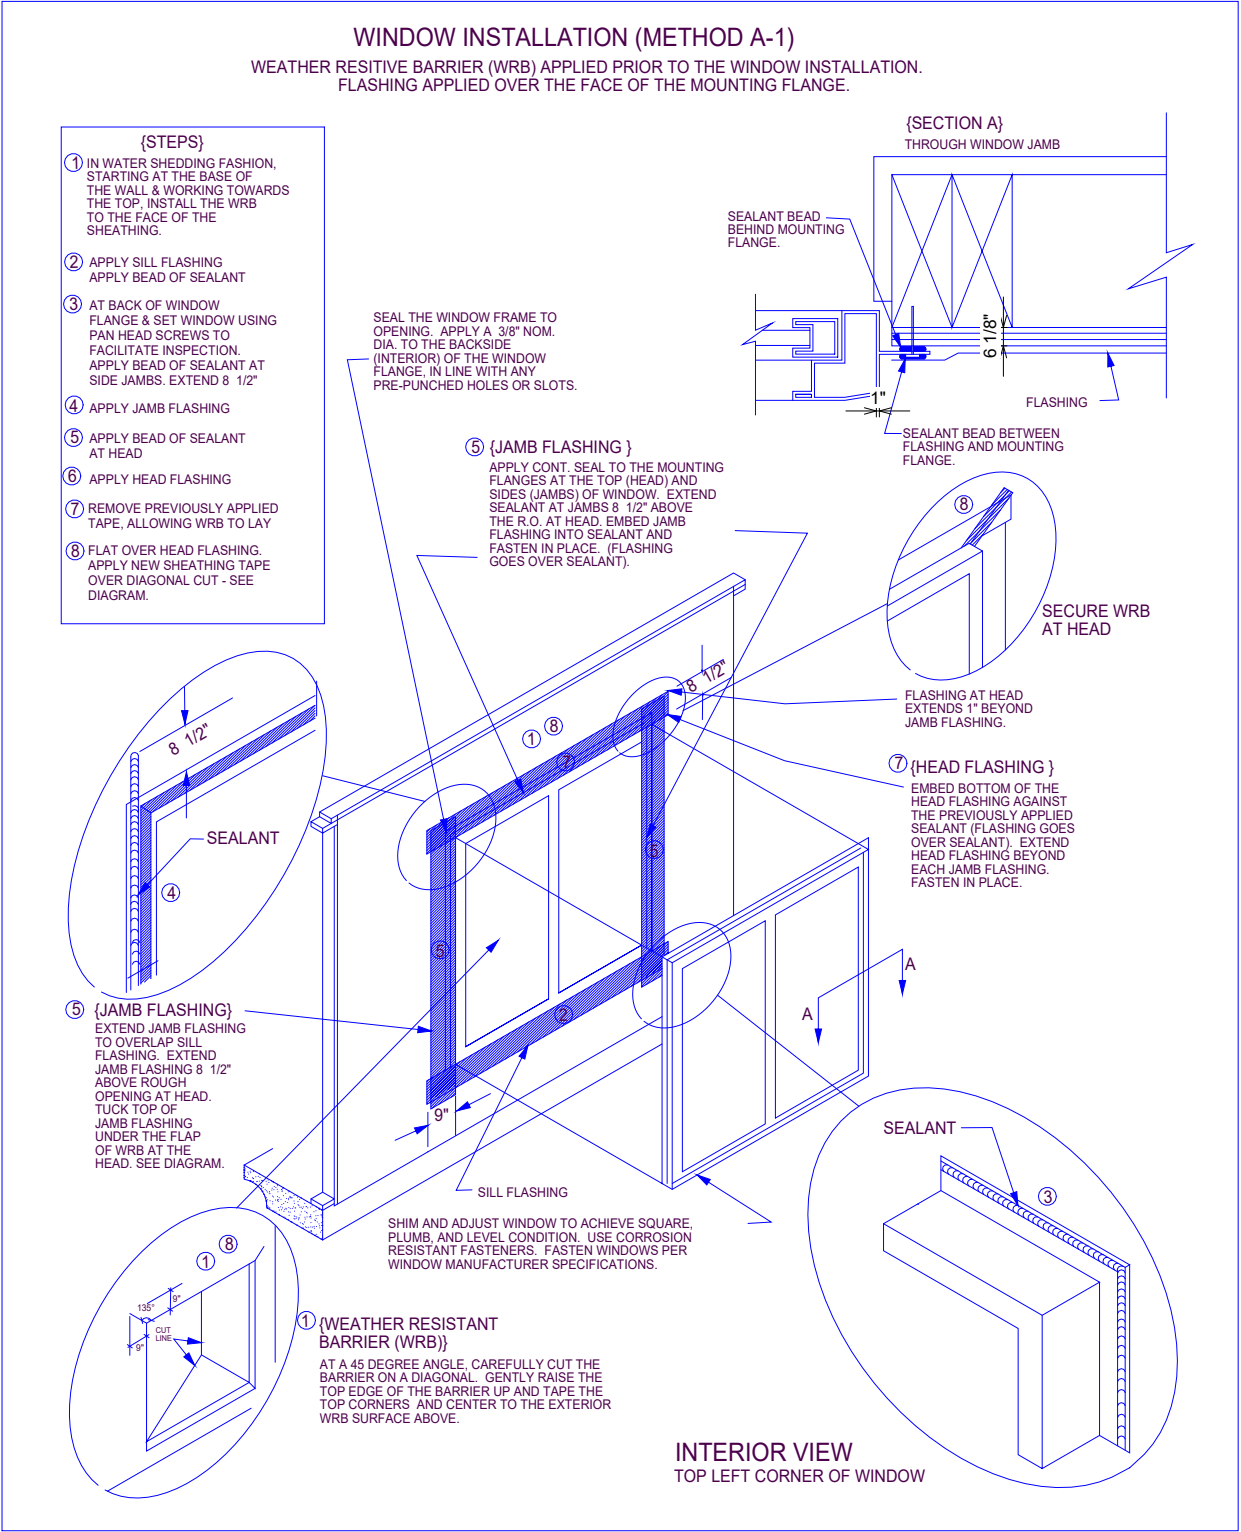

2 WINDOW INSTALLATION (TYPICAL)
3/16" = 1'-0"



James Zaleski P.E 51544 2305 Haverhill Rd Tallahassee, FL 32312 PH 850-766-7778

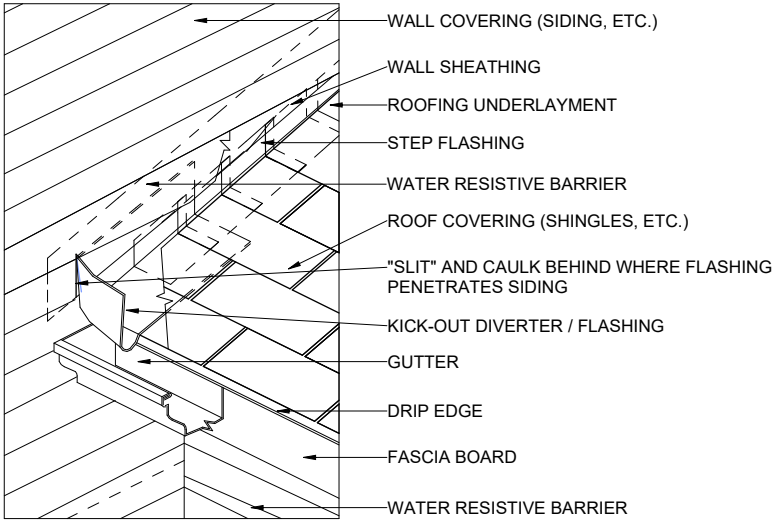

4 480.3 KICK OUT FLASHING DETAIL
6" = 1'-0"


James A Zaleski

Digitally signed by James A Zaleski
Date: 2025.01.04 23:23:38 -05'00'

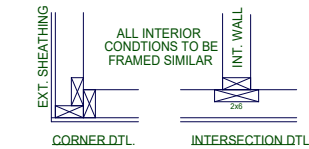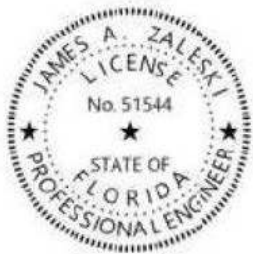

TYPICAL FRAMING DETAILS

1 CORNER T FRAMING DETAIL
1/2" = 1'-0"

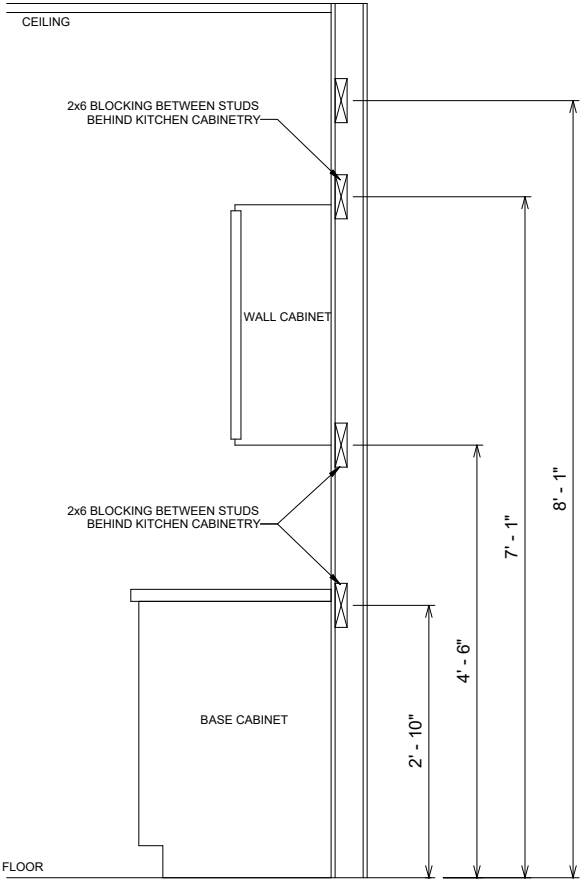

3 KITCHEN CABINET WALL BLOCKING
1/2" = 1'-0"

FOR DIGITAL SIGNATURES/SEAL: This item has been digitally signed and sealed by JAMES ZALESKI P.E. 51544 on the date adjacent to the seal. Printed copies of this document are not considered signed and sealed and the signature must be verified on electronic copies.

OPT. PAPER SIZE: for 1/4" = 1'-0" on 24" x 36" PAPER SIZE ENLARGE PRINTS TO 200%

FINAL REVIEW CONSTRUCTION PLANS

SHEET #		PROPERTY OF:		DRAWN BY:		JOB #		THE:		AREAS:		13,725 CUBIC FEET			
S-4		 © COPYRIGHT - 2024		MARYORIE G.		59-24-022		ASHLEY 'A'		FIRST FLOOR HEATED		1,525 SF		REVISION SCHEDULE	
				CHECKED BY:		2x6 EXTERIOR WALLS		FOR:		FRONT PORCH		1,525 SF		DESCRIPTION	
				J. DABNEY		FOUNDATION TYPE:		R. SAULS JR.		TOTAL UNDER ROOF		144 SF		DATE	
				PRINTED:		MONOSLAB		432 SE STARDUST PL. LAKE CITY FL 32024 COLUMBIA - FL		8'x4' STD. STOOP		144 SF			
				1/2/2025 11:50:36 AM						TOTAL UNCOVERED		1,669 SF			
SCALE: As indicated								OFFICE:		8'x4' STD. STOOP		32 SF			
								GAINESVILLE SC		TOTAL UNCOVERED		32 SF			
								L. HALLER							
MISC DETAILS															