



12
6


VENT AT RIDGE

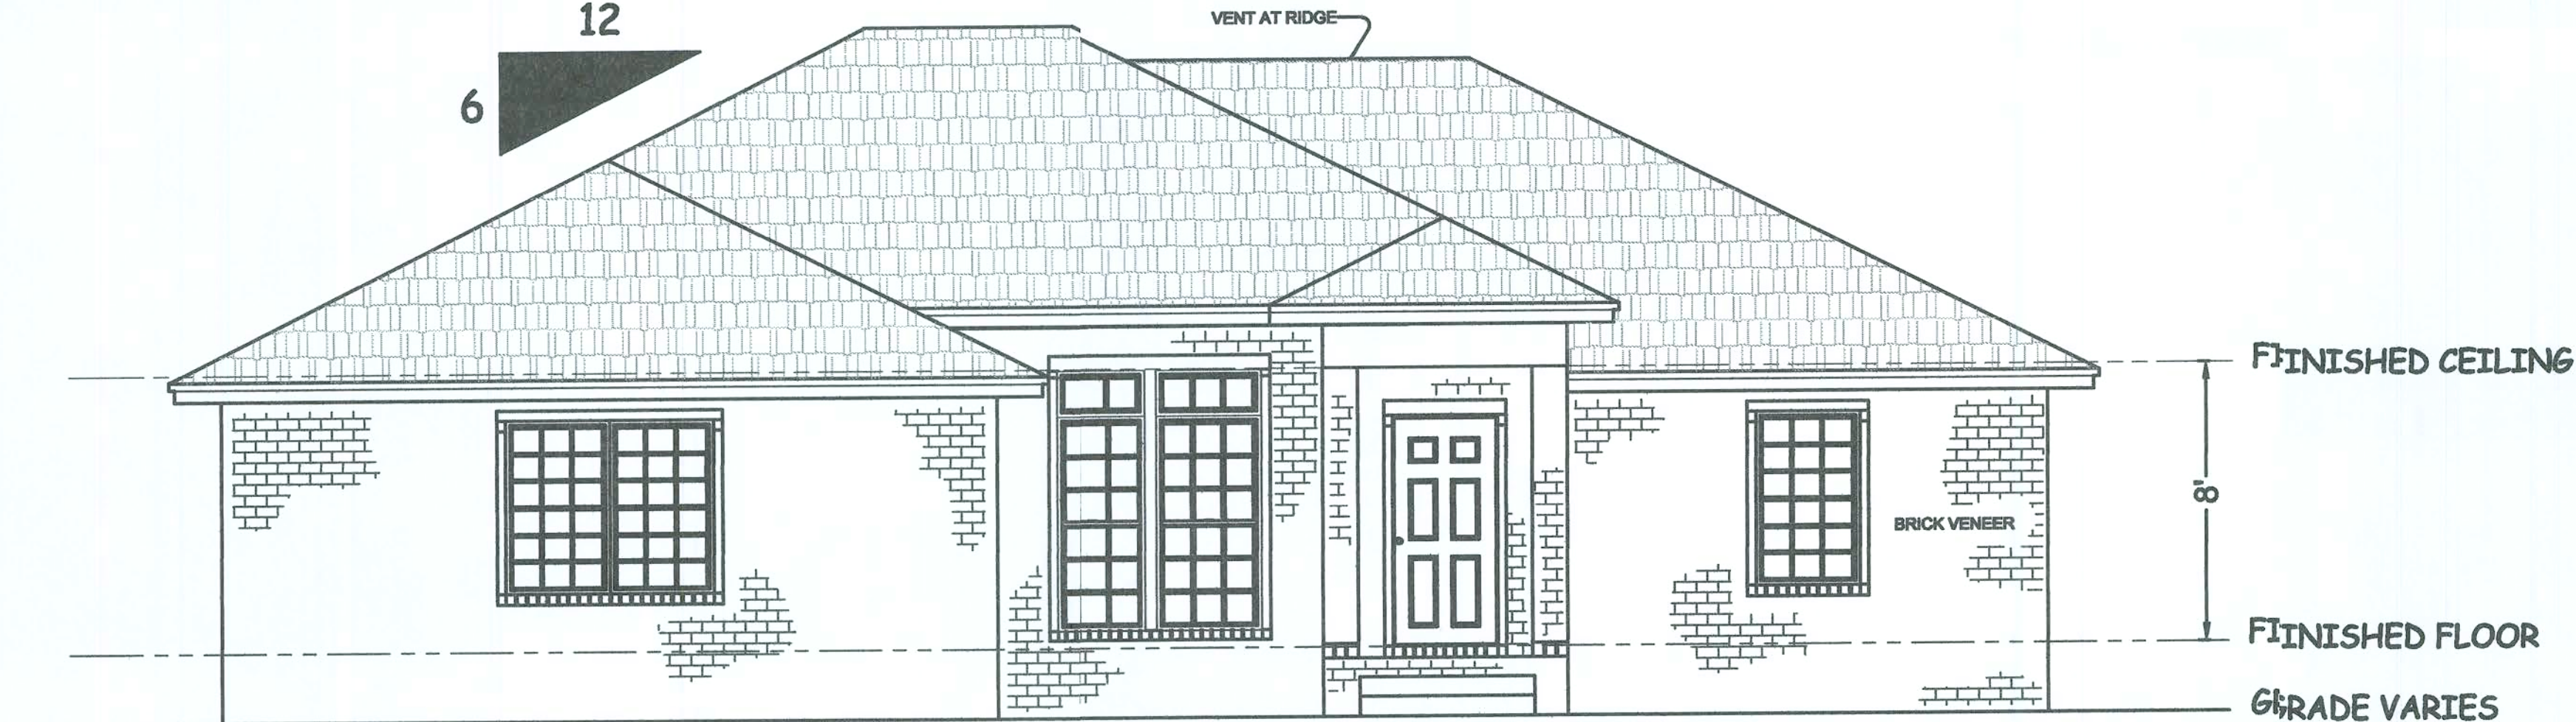


FRONT ELEVATION

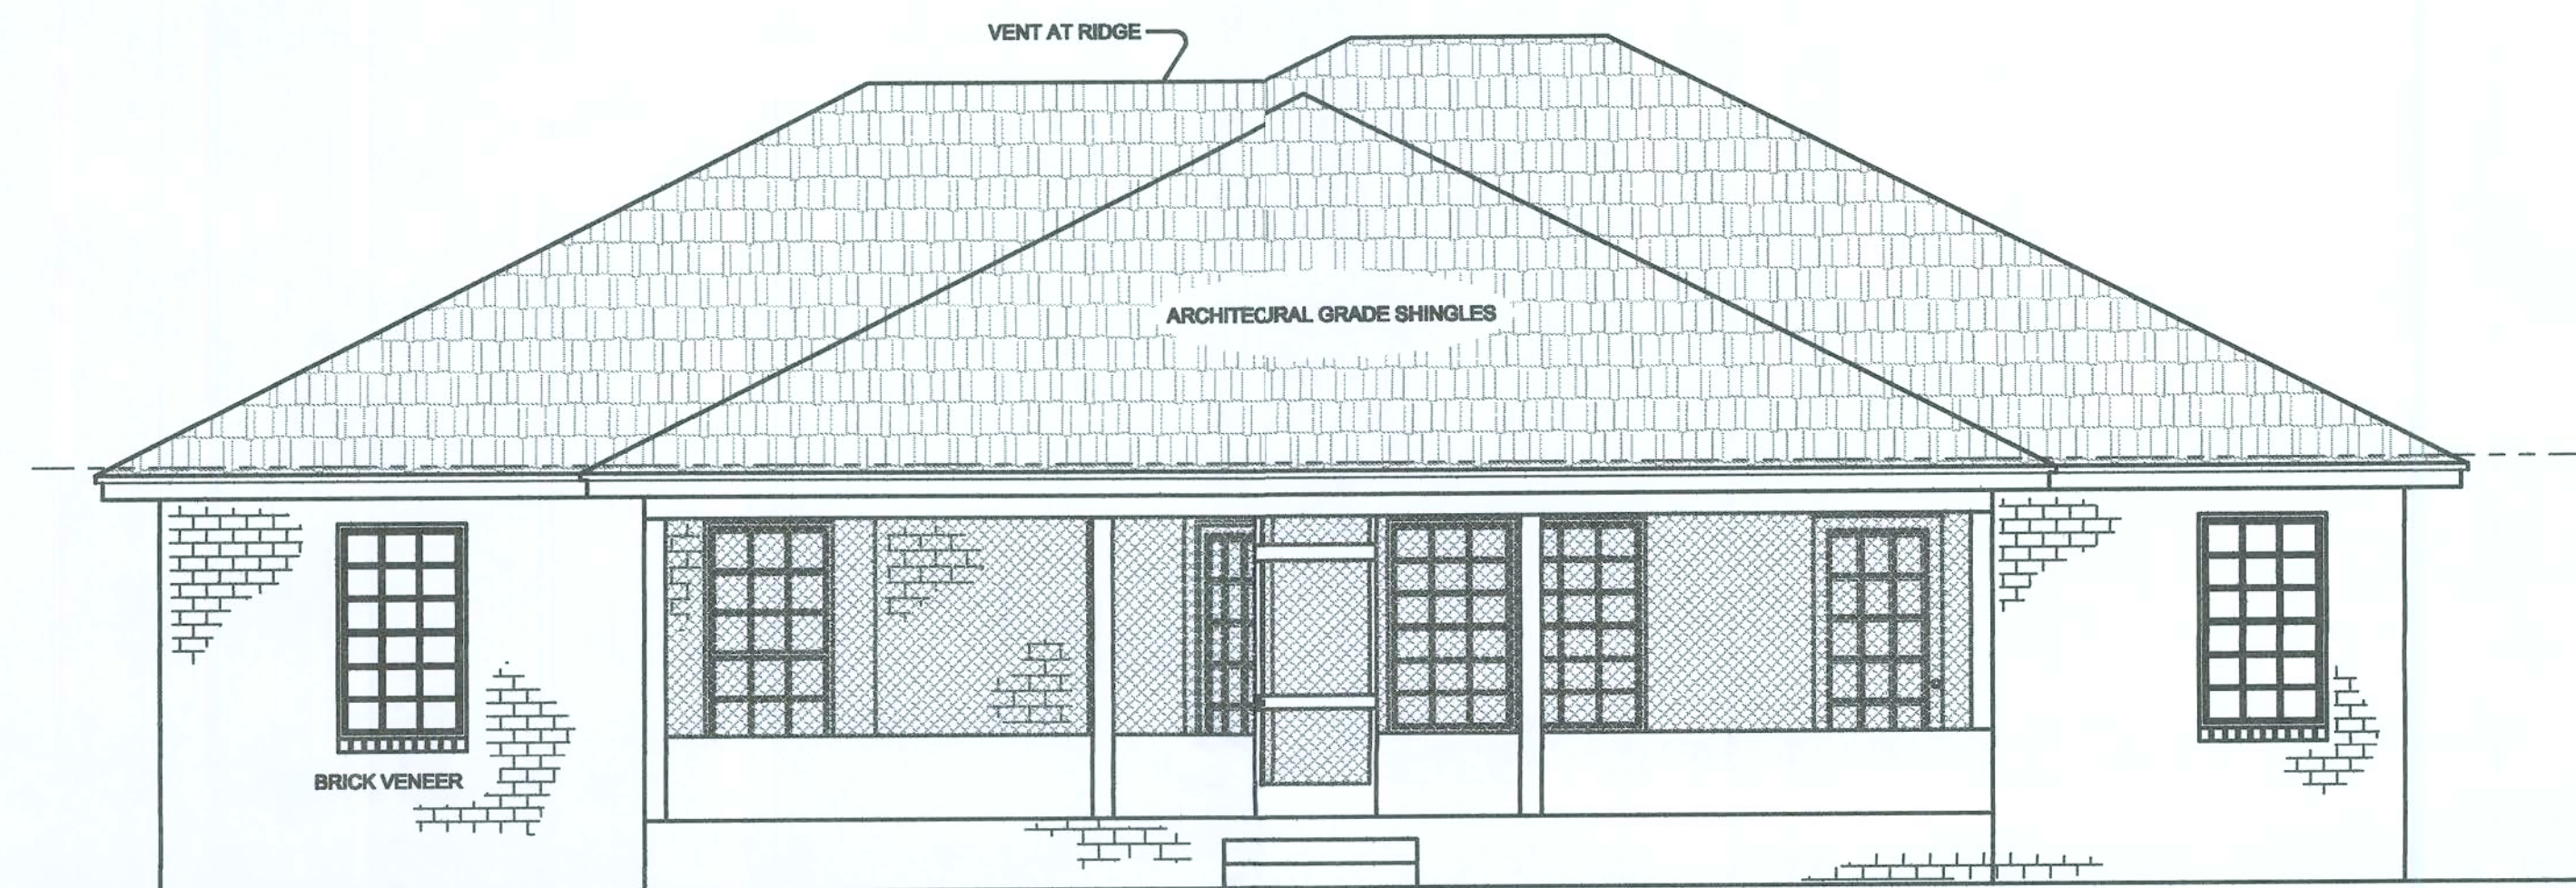

REAR ELEVATION

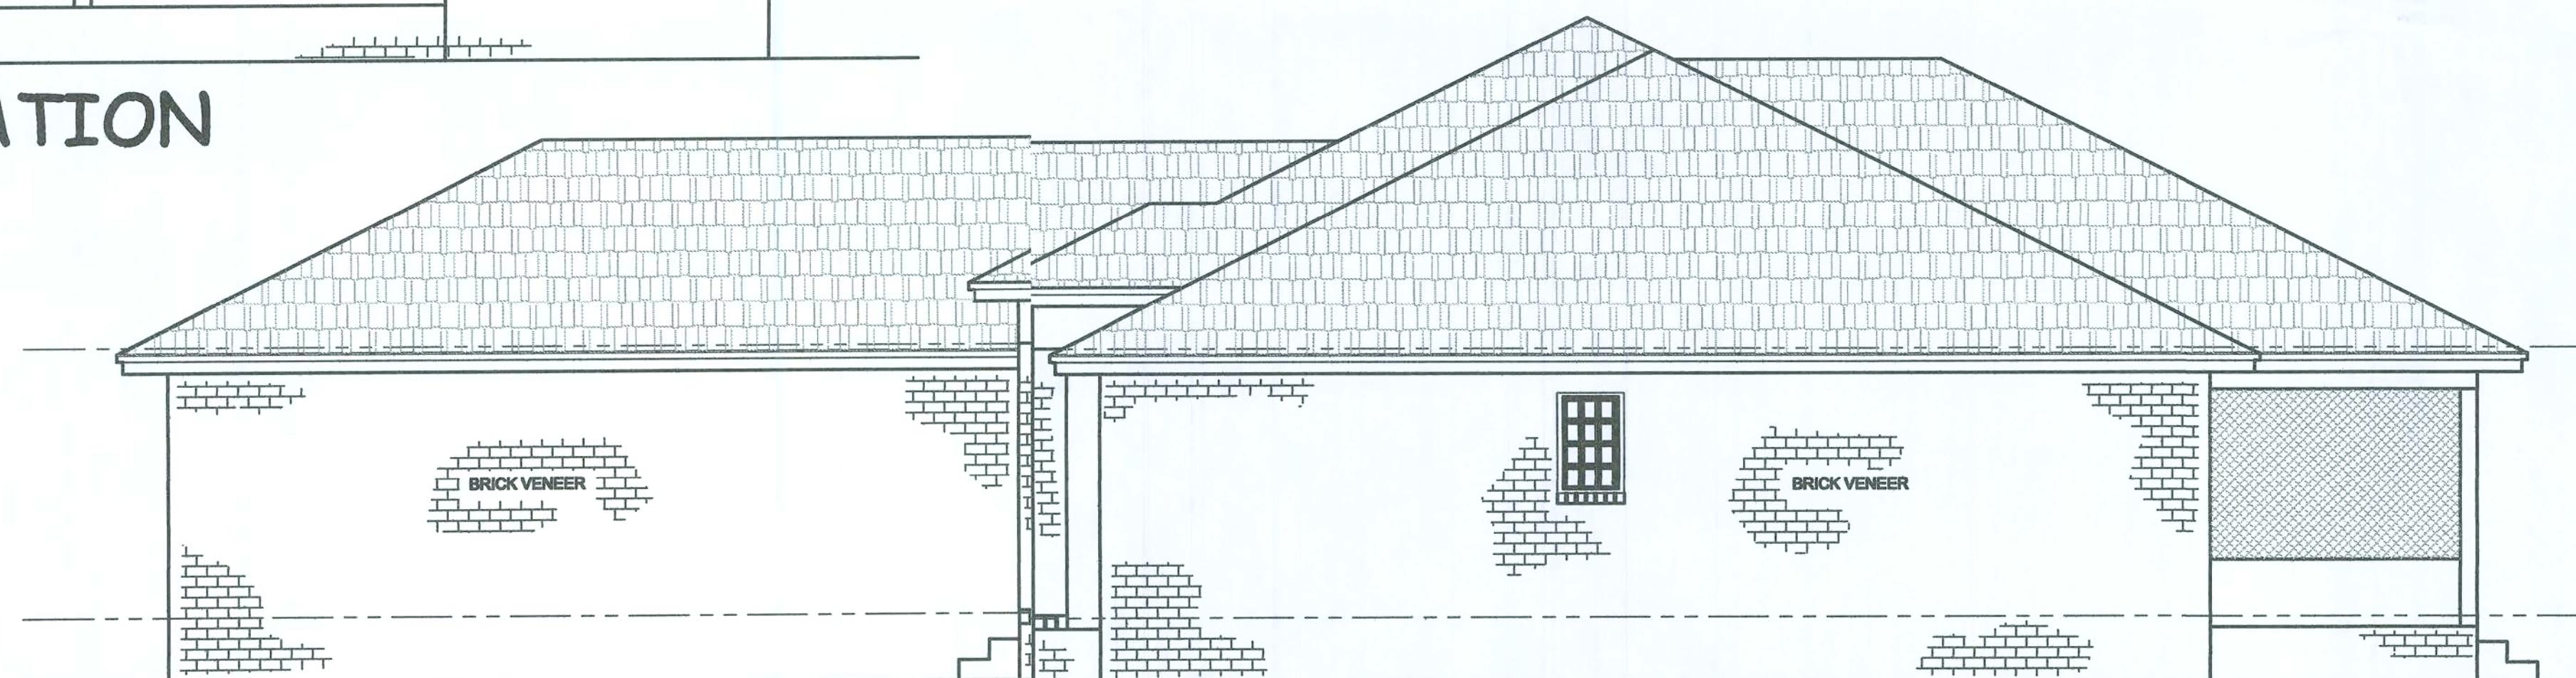

RIGHT ELEVATION

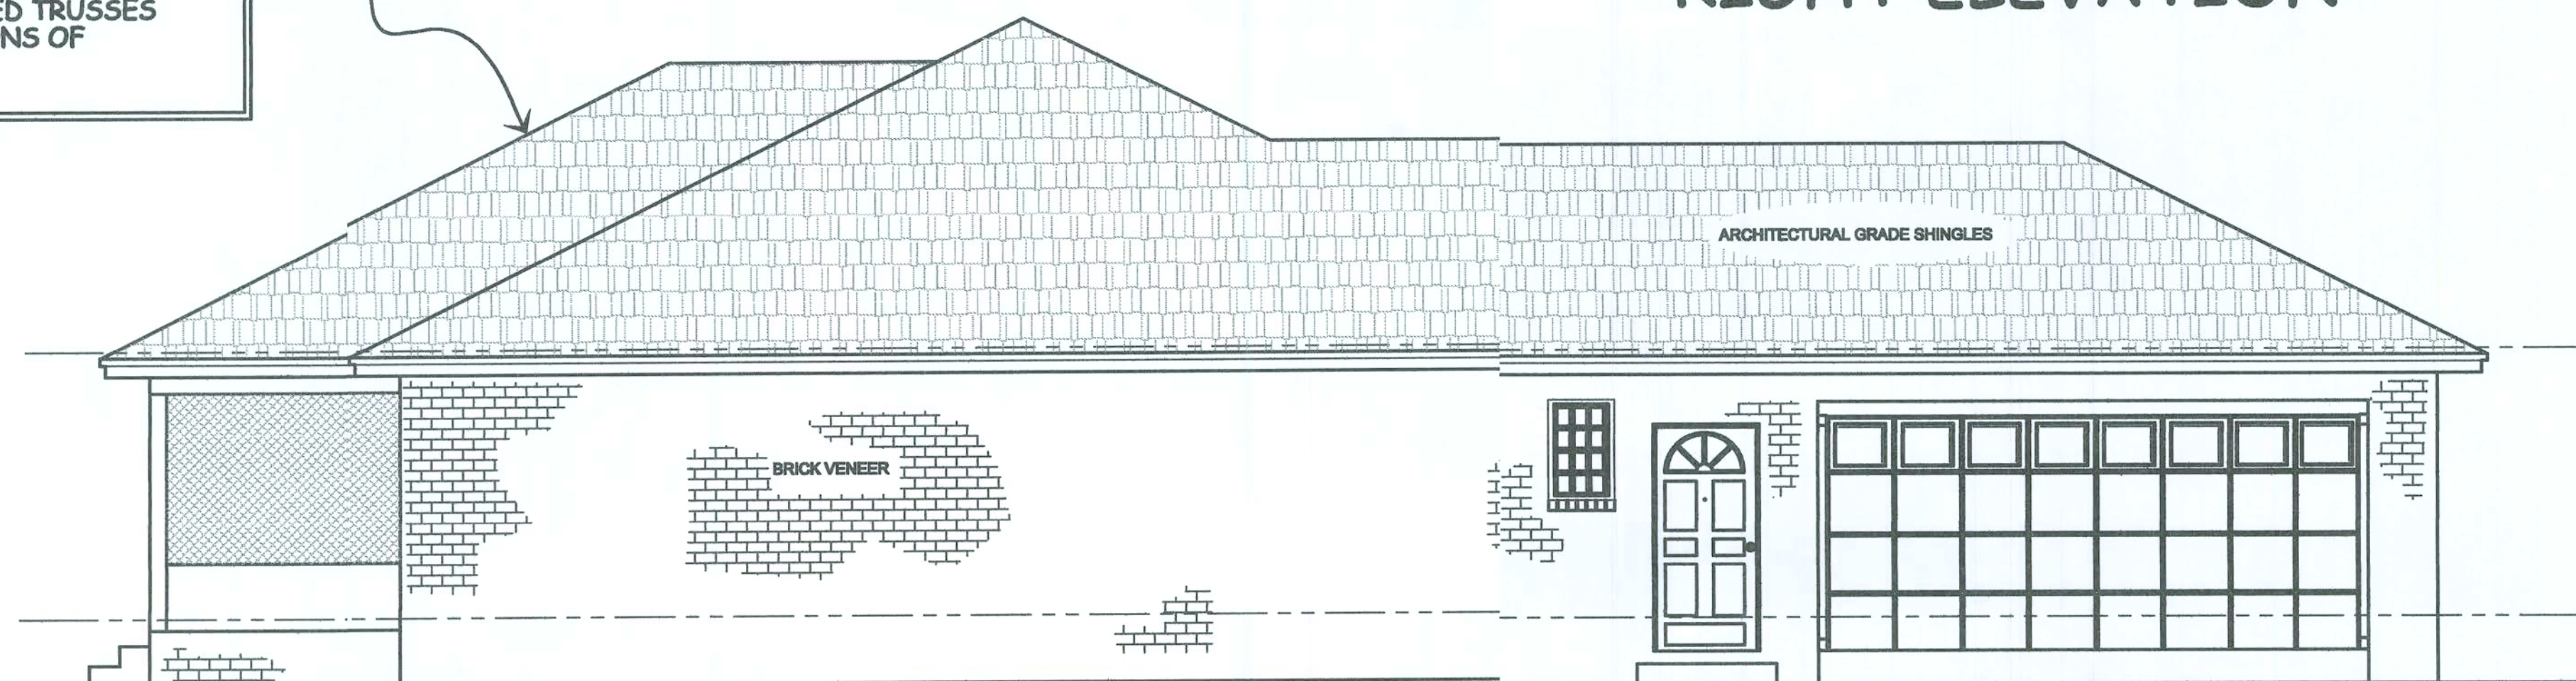

LEFT ELEVATION

ELEVATIONS

SCALE: 1/4" = 1'-0"

NOTE:

ALL EXTERIOR WINDOWS AND GLASS DOORS SHALL BEAR AAMA OR WDMA OR OTHER APPROVED LABEL IDENTIFYING THE MANUFACTURER, PERFORMANCE CHARACTERISTICS AND APPROVED PRODUCT EVALUATION TO INDICATE COMPLIANCE WITH CURRENT WINDLOADING. O/C WINDOW & DOOR PRESSURE = -30 psf

TRUSS-NOTE:

THE DESIGN AND FABRICATION CRITERIA OF ALL WOOD TRUSSES SHALL BE IN ACCORDANCE WITH THE NATIONAL DESIGN SPECIFICATION FOR STRESS GRADE LUMBER AND ITS FASTENINGS BY THE NATIONAL FOREST PRODUCTS ASSOCIATIONS LATEST REVISION; TIMBER CONSTRUCTION STANDARDS BY THE AMERICAN INSTITUTE OF TIMBER CONSTRUCTION, LATEST REVISION; AND DESIGN SPECIFICATIONS FOR LIGHT METAL PLATE CONNECTED WOOD TRUSSES BY THE TRUSS PLATE INSTITUTE, LATEST REVISION.

HANDLING, ERECTION AND BRACING OF FABRICATED TRUSSES SHALL BE IN ACCORDANCE WITH RECOMMENDATIONS OF THE TRUSS PLATE INSTITUTE.

July 2, 2008

1 4

GENERAL NOTES

1-CHECK ALL DIMENSIONS FOR ACCURACY PRIOR TO CONSTRUCTION.

2-ALL ELECTRICAL, PLUMBING AND MECHANICAL (HVAC) TO BE INSTALLED BY CURRENTLY LICENCED CONTRACTORS CONFORMING TO STATE AND LOCAL CODES WHERE APPLICABLE.

3-ENERGY CALCULATIONS TO BE PROVIDED BY MECHANICAL CONTRACTOR.

4-EXACT DESCRIPTION AND/OR SPECIFICATIONS NOT NOTED ON PLANS TO BE PROVIDED BY OWNER AND/OR CONTRACTOR.(DOORS, WINDOWS, ETC.)

5-ALL CONSTRUCTION MUST CONFORM TO CURRENT STATE AND LOCAL CODES WHERE APPLICABLE.

6-ALL WINDOW & DOOR HEADERS SHALL BE CONSTRUCTED IN ACCORDANCE W/ TABLE R502.5 (1), (2) 2004 FLORIDA BUILDING CODE



POST OFFICE BOX 1034
PERRY, FLORIDA 32348
(850) 672-0145

LEGEND

PREPARED FOR :

Paul & Allison Dyal
Columbia Co., Florida

PREPARED BY :

Jodi Cooper
1772 N.E. CHERVIL DRIVE
LEE, FLORIDA 32059
850-971-5607
e-mail: jodiccooper62@yahoo.com

PROJECT

DYAL HOME

THESE PLANS WILL COMPLY WITH THE FLORIDA BUILDING CODE FOR A 110 MILE PER HOUR WINDLOAD (THREE SECOND INTERVAL)

John K. Gentry
JOHN K. GENTRY

P.E. #16990 — ENGINEERING BUSINESS #25590

2 July-08

ENGINEERING LLC.

COASTAL RESOURCES




Heated Sq Ft	1648
Garage	577
Porches	346
TOTAL AREA	2571

THE DOOR OPENING BETWEEN THE GARAGE AND THE HALLWAY MUST BE EQUIPPED WITH A SOLID WOOD OR SOLID OR HONEYCOMB STEEL DOOR NOT LESS THAN 1-3/8" THICK, OR A 20-MINUTE FIRE RATED DOOR. DUCTS IN THE GARAGE, AND DUCTS PENETRATING THE WALLS OR CEILINGS SEPARATING THE DWELLING THE GARAGE SHALL BE CONSTRUCTED OF A MINIMUM NO. 26 GAGE SHEET STEEL OR OTHER APPROVED MATERIAL AND SHALL NOT HAVE OPENINGS INTO THE GARAGE. THE GARAGE SHALL BE SEPARATED FROM THE RESIDENCE AND ITS ATTIC AREA BY NOT LESS THAN 1/2" GYPSUM BOARD TO THE GARAGE WALL.

5-ALL CONSTRUCTION MUST CONFORM TO CURRENT STATE AND LOCAL CODES WHERE APPLICABLE.

6-ALL WINDOW & DOOR HEADERS SHALL BE CONSTRUCTED IN ACCORDANCE W/ TABLES R502.5 (1), (2) 2004 FLORIDA BUILDING CODE

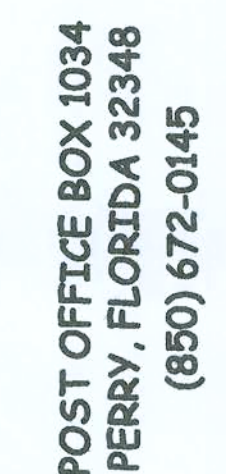


Jodi Cooper
1772 N.E. CHERVIL DRIVE
LEE, FLORIDA 32059
850-971-5607
e-mail: jodicoooper62@yahoo.com

THESE PLANS WILL COMPLY WITH THE
FLORIDA BUILDING CODE FOR A 110 MILE
PER HOUR WINDLOAD (THREE SECOND INTERVAL)

John K. Gentry
JOHN K. GENTRY
P.E. #16990 — ENGINEERING BUSINESS #25890
2-July-08

ENGINEERING LLC.

COASTAL RESOURCES

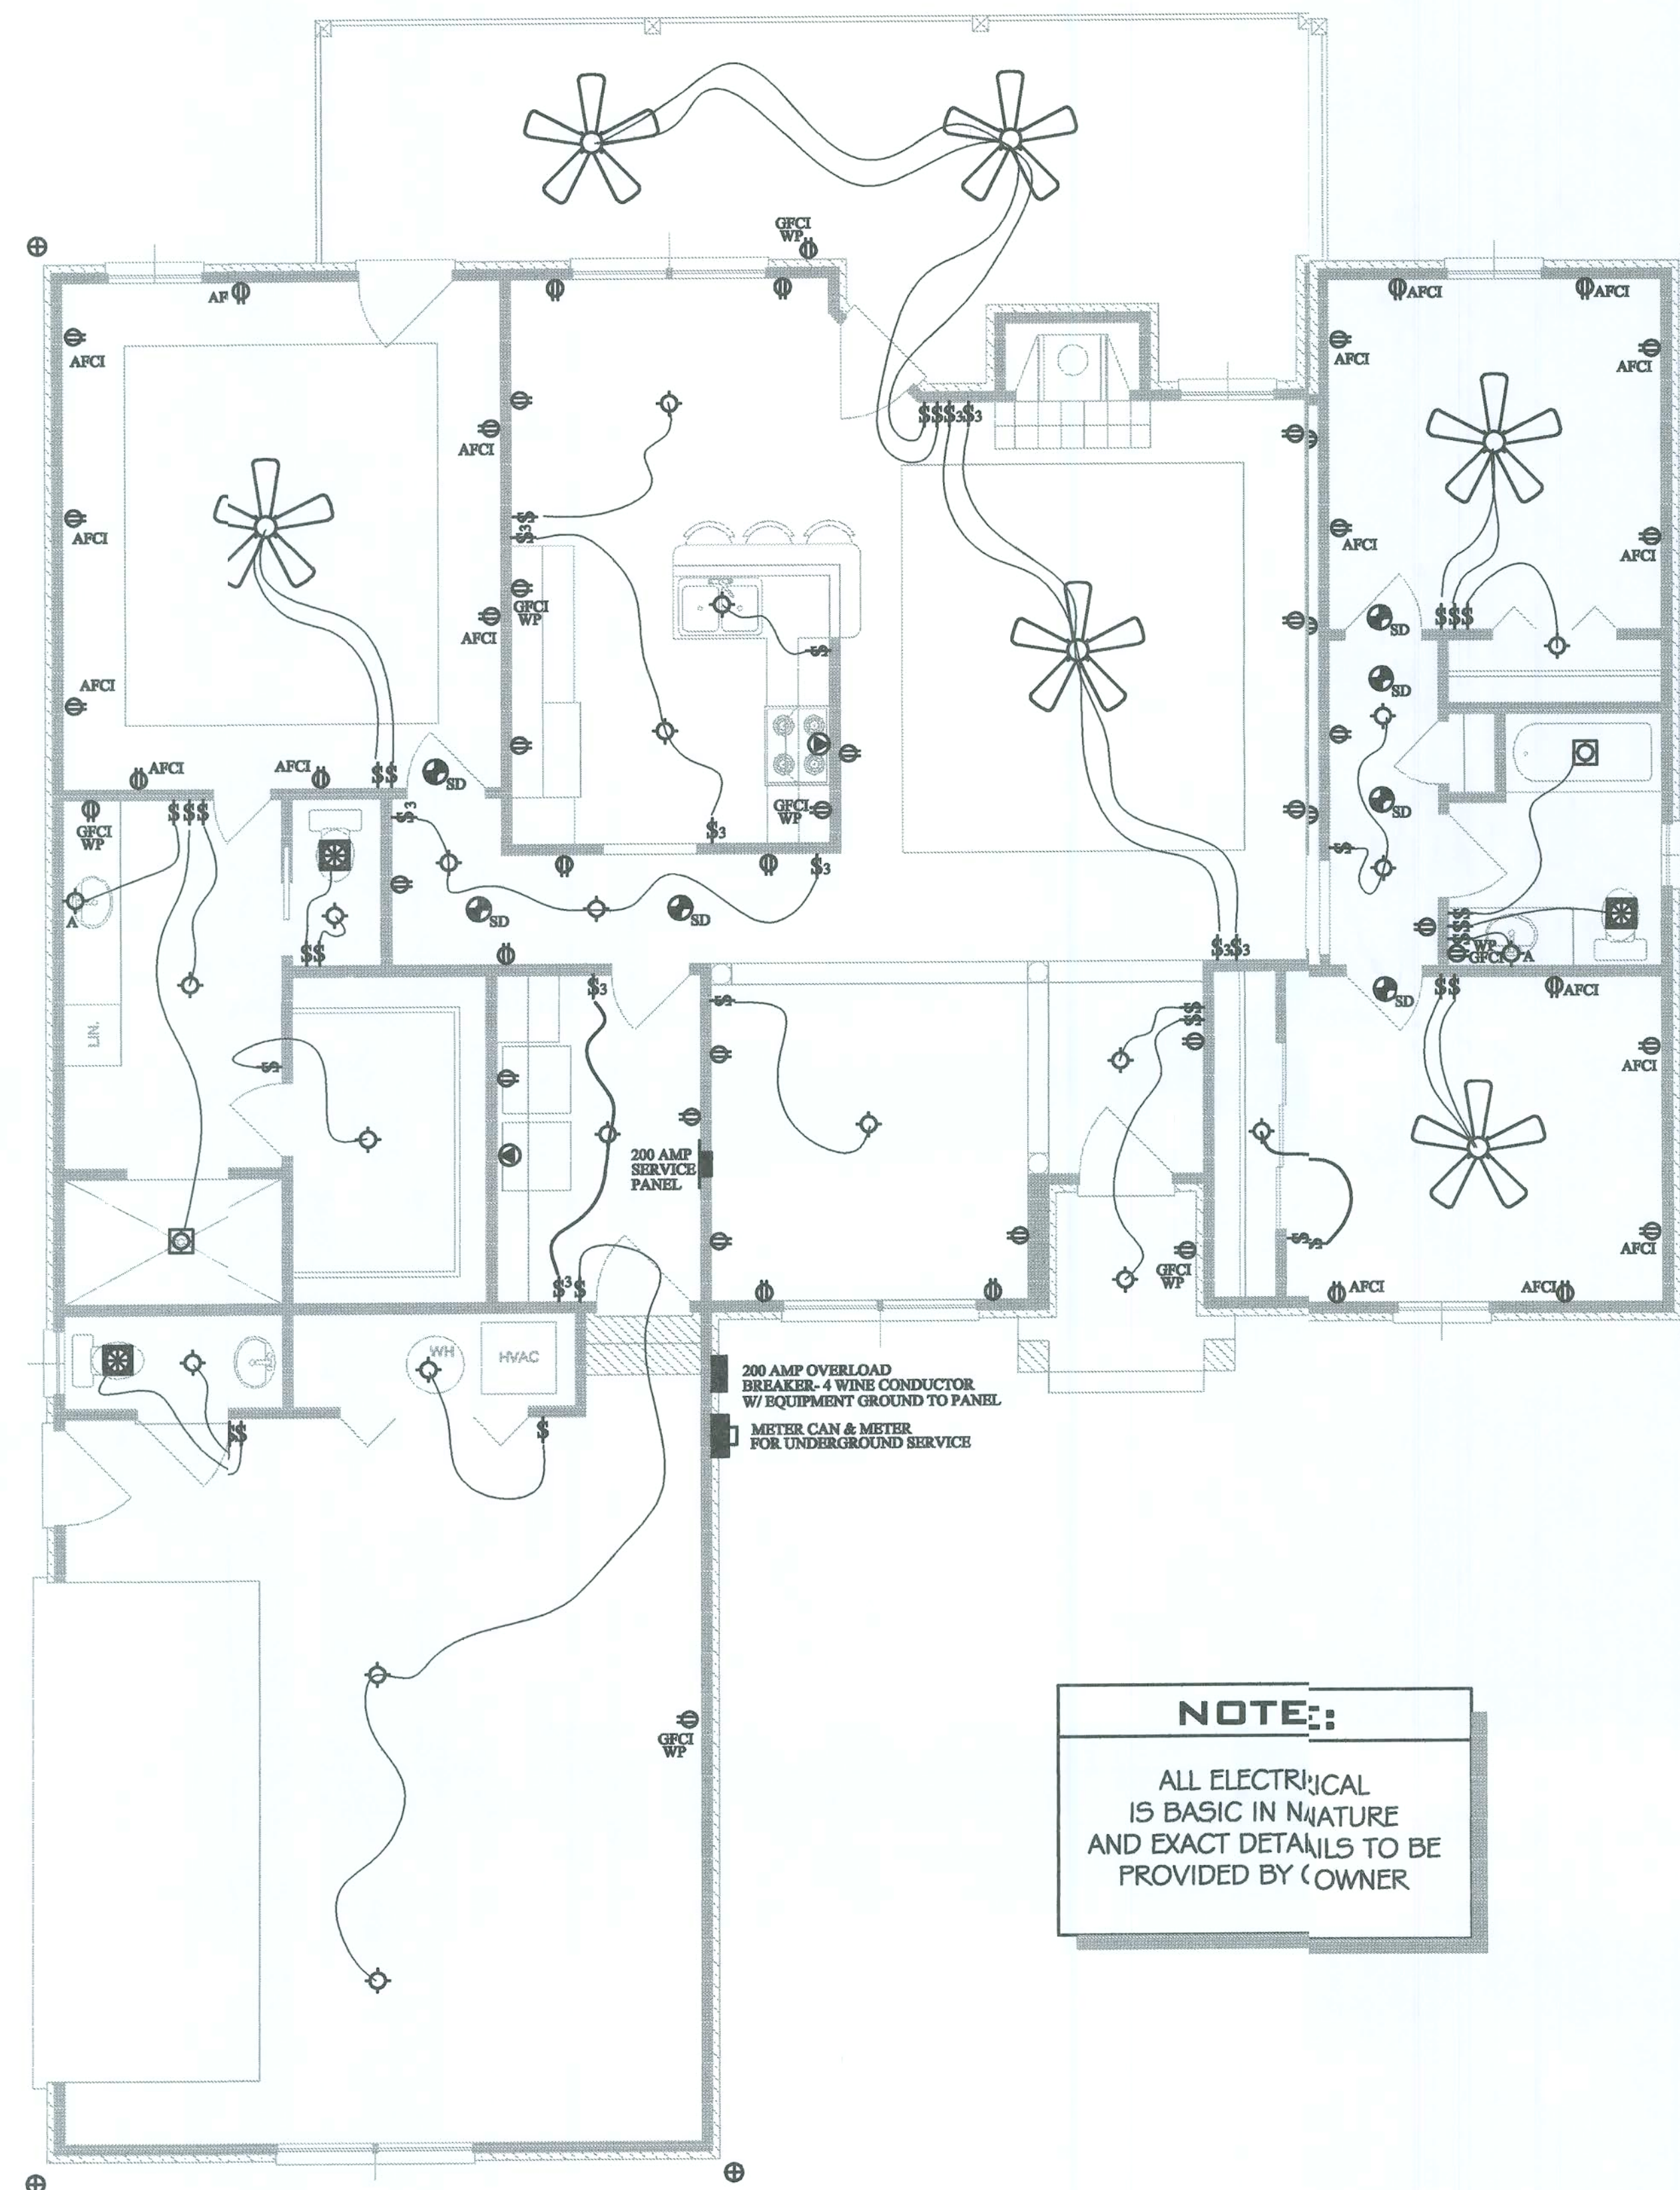

NOTE:
ALL ELECTRICAL IS BASIC IN NATURE AND EXACT DETAILS TO BE PROVIDED BY OWNER

ELECTRICAL LEGEND	
	LIGHT FIXTURE, CEILING MOUNTED
	LIGHT FIXTURE, WALL MOUNTED
	LIGHT FIXTURE, CEILING MOUNTED, WATERPROOF
	LIGHT FIXTURE, WALL MOUNTED, WATERPROOF
	LIGHT FIXTURE, RECESSED
	LIGHT FIXTURE WITH PULL SWITCH
	LIGHT FIXTURE, VAPOR PROOF
	FLUORESCENT LIGHT FIXTURE, 2-BULB, 0'-0"
	SWITCH, 2-WAY
	SWITCH, 3-WAY
	SWITCH, 4-WAY
	SWITCH, DIMMER
	RECEPTACLE, DUPLEX OUTLET
	RECEPTACLE, DUPLEX, GROUND FAULT CIRCUIT INTERRUPTER OUTLET
	RECEPTACLE, DUPLEX, WATERPROOF, GROUND FAULT CIRCUIT INTERRUPTER OUTLET
	RECEPTACLE, 230 VOLT OUTLET
	EXHAUST FAN, 90 CFM
	TV
	PHONE JACK
	THERMOSTAT
	SMOKE DETECTOR
	DOOR BELL
	CHIMES
	METER
	FLUSH MOUNTED PANEL BOX
	FLOOD LIGHT
	CEILING FAN, 52" 5-BLADE

ELECTRICAL PLAN NOTES

WIRE ALL APPLIANCES, HVAC UNITS AND OTHER EQUIPMENT PER MANUF. SPECIFICATIONS.

ALL INSTALLATIONS SHALL BE PER NAT'L ELECTRIC CODES.

ELECTRICAL CONTRACTOR SHALL BE RESPONSIBLE FOR THE DESIGN & SIZING OF ELECTRICAL SERVICE AND CIRCUITS.

ALL BEDROOM RECEPTACLES SHALL BE AFCI (ARC FAULT CIRCUIT INTERRUPT)

PROVIDE PHONE AND TV OUTLETS- VERIFY LOCATIONS

RUN HVAC WIRES AS REQUIRED

ALL BATH, GARAGE, EXTERIOR, AND KITCHEN OUTLETS, WHERE NOTED TO HAVE GROUND FAULT CIRCUIT INTERRUPTERS

MICROWAVE TO HAVE DEDICATED CIRCUIT

PROVIDE LEGIBLE DIRECTORY AT PANEL INDICATING INDIVIDUAL CIRCUITS

ALL WORK DONE SHALL COMPLY WITH ALL LOCAL, STATE, AND NATIONAL CODES

SMOKE ALARMS MUST BE INSTALLED IN THE FOLLOWING LOCATIONS:

IN EACH SLEEPING ROOM.

OUTSIDE EACH SEPARATE SLEEPING AREA IN THE IMMEDIATE VICINITY OF THE BEDROOM.

ALL SMOKE ALARMS SHALL BE 120v W/ BATTERY BACKUP OF THE PHOTOELECTRIC TYPE,

THE ALARMS MUST BE INTERCONNECTED IN SUCH A MANNER THAT THE ACTUATION OF ONE ALARM WILL ACTIVATE ALL THE ALARMS IN THE INDIVIDUAL UNIT. THE ALARMS SHALL BE CLEARLY AUDIBLE OVER BACKGROUND NOISES.

DATE
July 2, 2008

SHEET
3 OF 4

GENERAL NOTES

1-CHECK ALL DIMENSIONS FOR ACCURACY PRIOR TO CONSTRUCTION.

2-ALL ELECTRICAL, PLUMBING AND MECHANICAL (HVAC) TO BE INSTALLED BY CURRENTLY LICENCED CONTRACTORS CONFORMING TO STATE AND LOCAL CODES WHERE APPLICABLE.

3-ENERGY CALCULATIONS TO BE PROVIDED BY MECHANICAL CONTRACTOR.

4-EXACT DESCRIPTION AND/OR SPECIFICATIONS NOT NOTED ON PLANS TO BE PROVIDED BY OWNER AND/OR CONTRACTOR.(DOORS, WINDOWS, ETC.)

5-ALL CONSTRUCTION MUST CONFORM TO CURRENT STATE AND LOCAL CODES WHERE APPLICABLE.

6-ALL WINDOW & DOOR HEADERS SHALL BE CONSTRUCTED IN ACCORDANCE W/ TABLES R502.5 (1), (2) 2004 FLORIDA BUILDING CODE

LEGEND

PREPARED FOR :
Paul & Allison Dyal
Columbia Co., Florida

PREPARED BY :
Jodi Cooper
1772 N.E. CHERVIL DRIVE
LEE, FLORIDA 32059
850-971-5607
e-mail: jodicoper62@yahoo.com






PROJECT
DYAL HOME

THESE PLANS WILL COMPLY WITH THE FLORIDA BUILDING CODE FOR A 110 MILE PER HOUR WINDLOAD (THREE SECOND INTERVAL)


JOHN K. GENTRY
P.E. #16990 — ENGINEERING BUSINESS #25990
2-July-08

COASTAL RESOURCES ENGINEERING LLC.

POST OFFICE BOX 1034
PERRY, FLORIDA 32348
(850) 672-0145

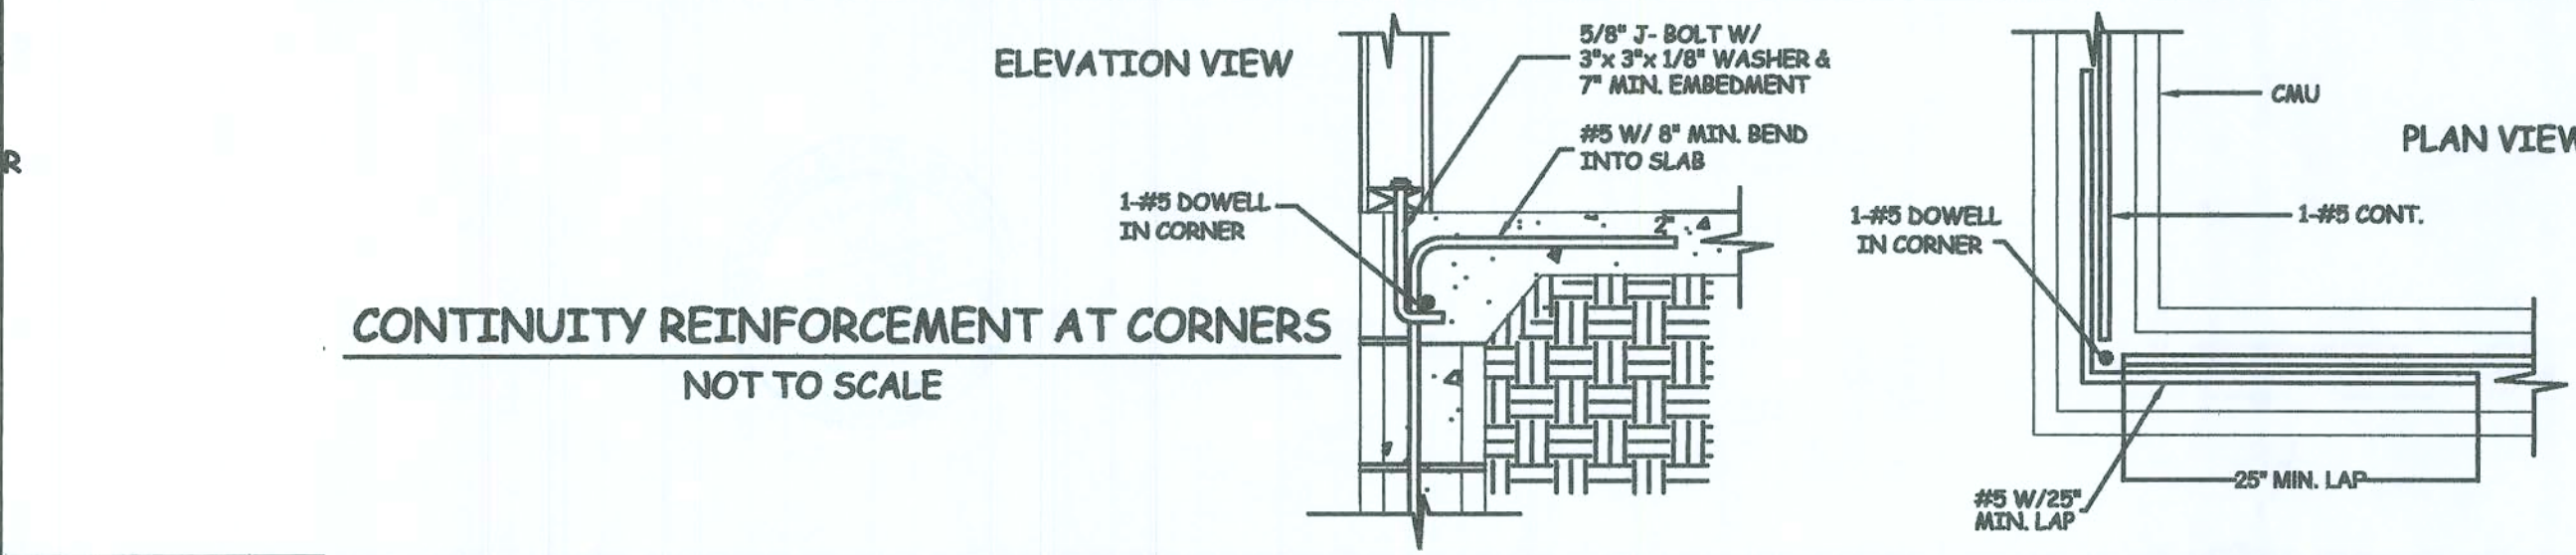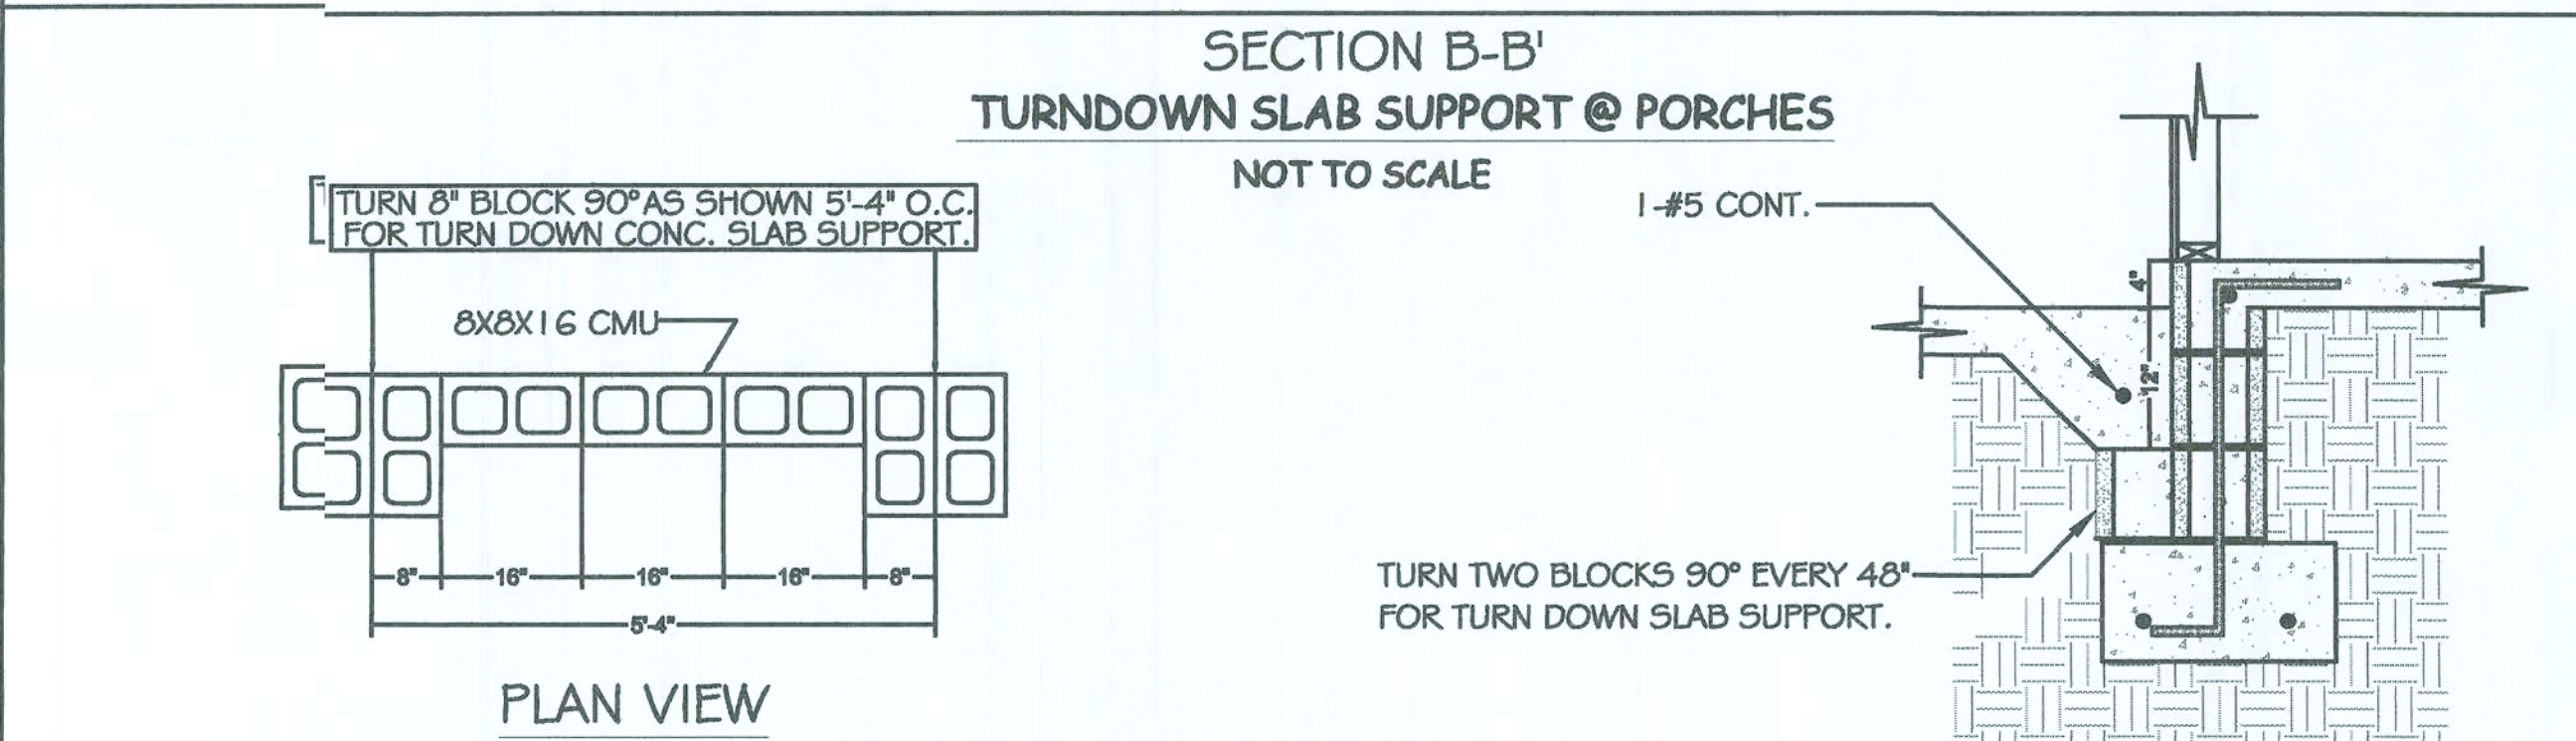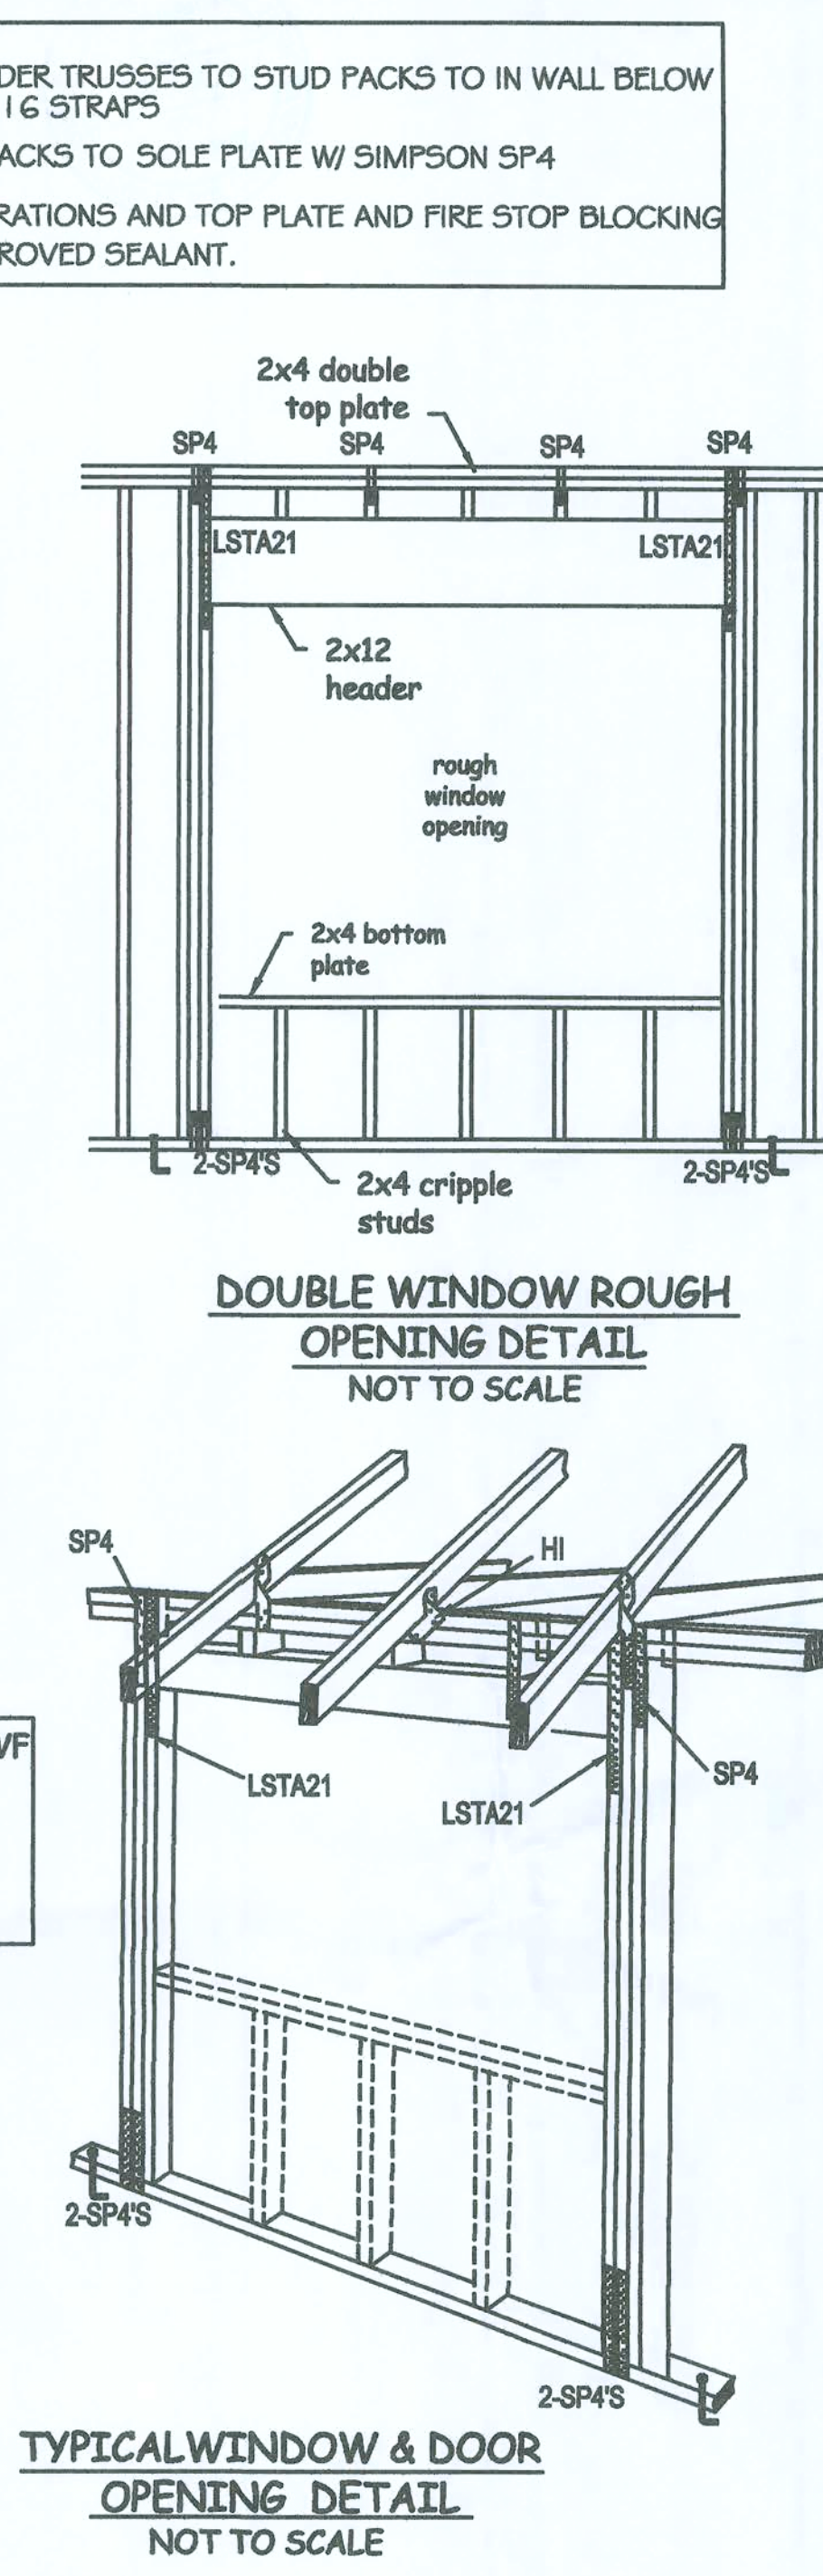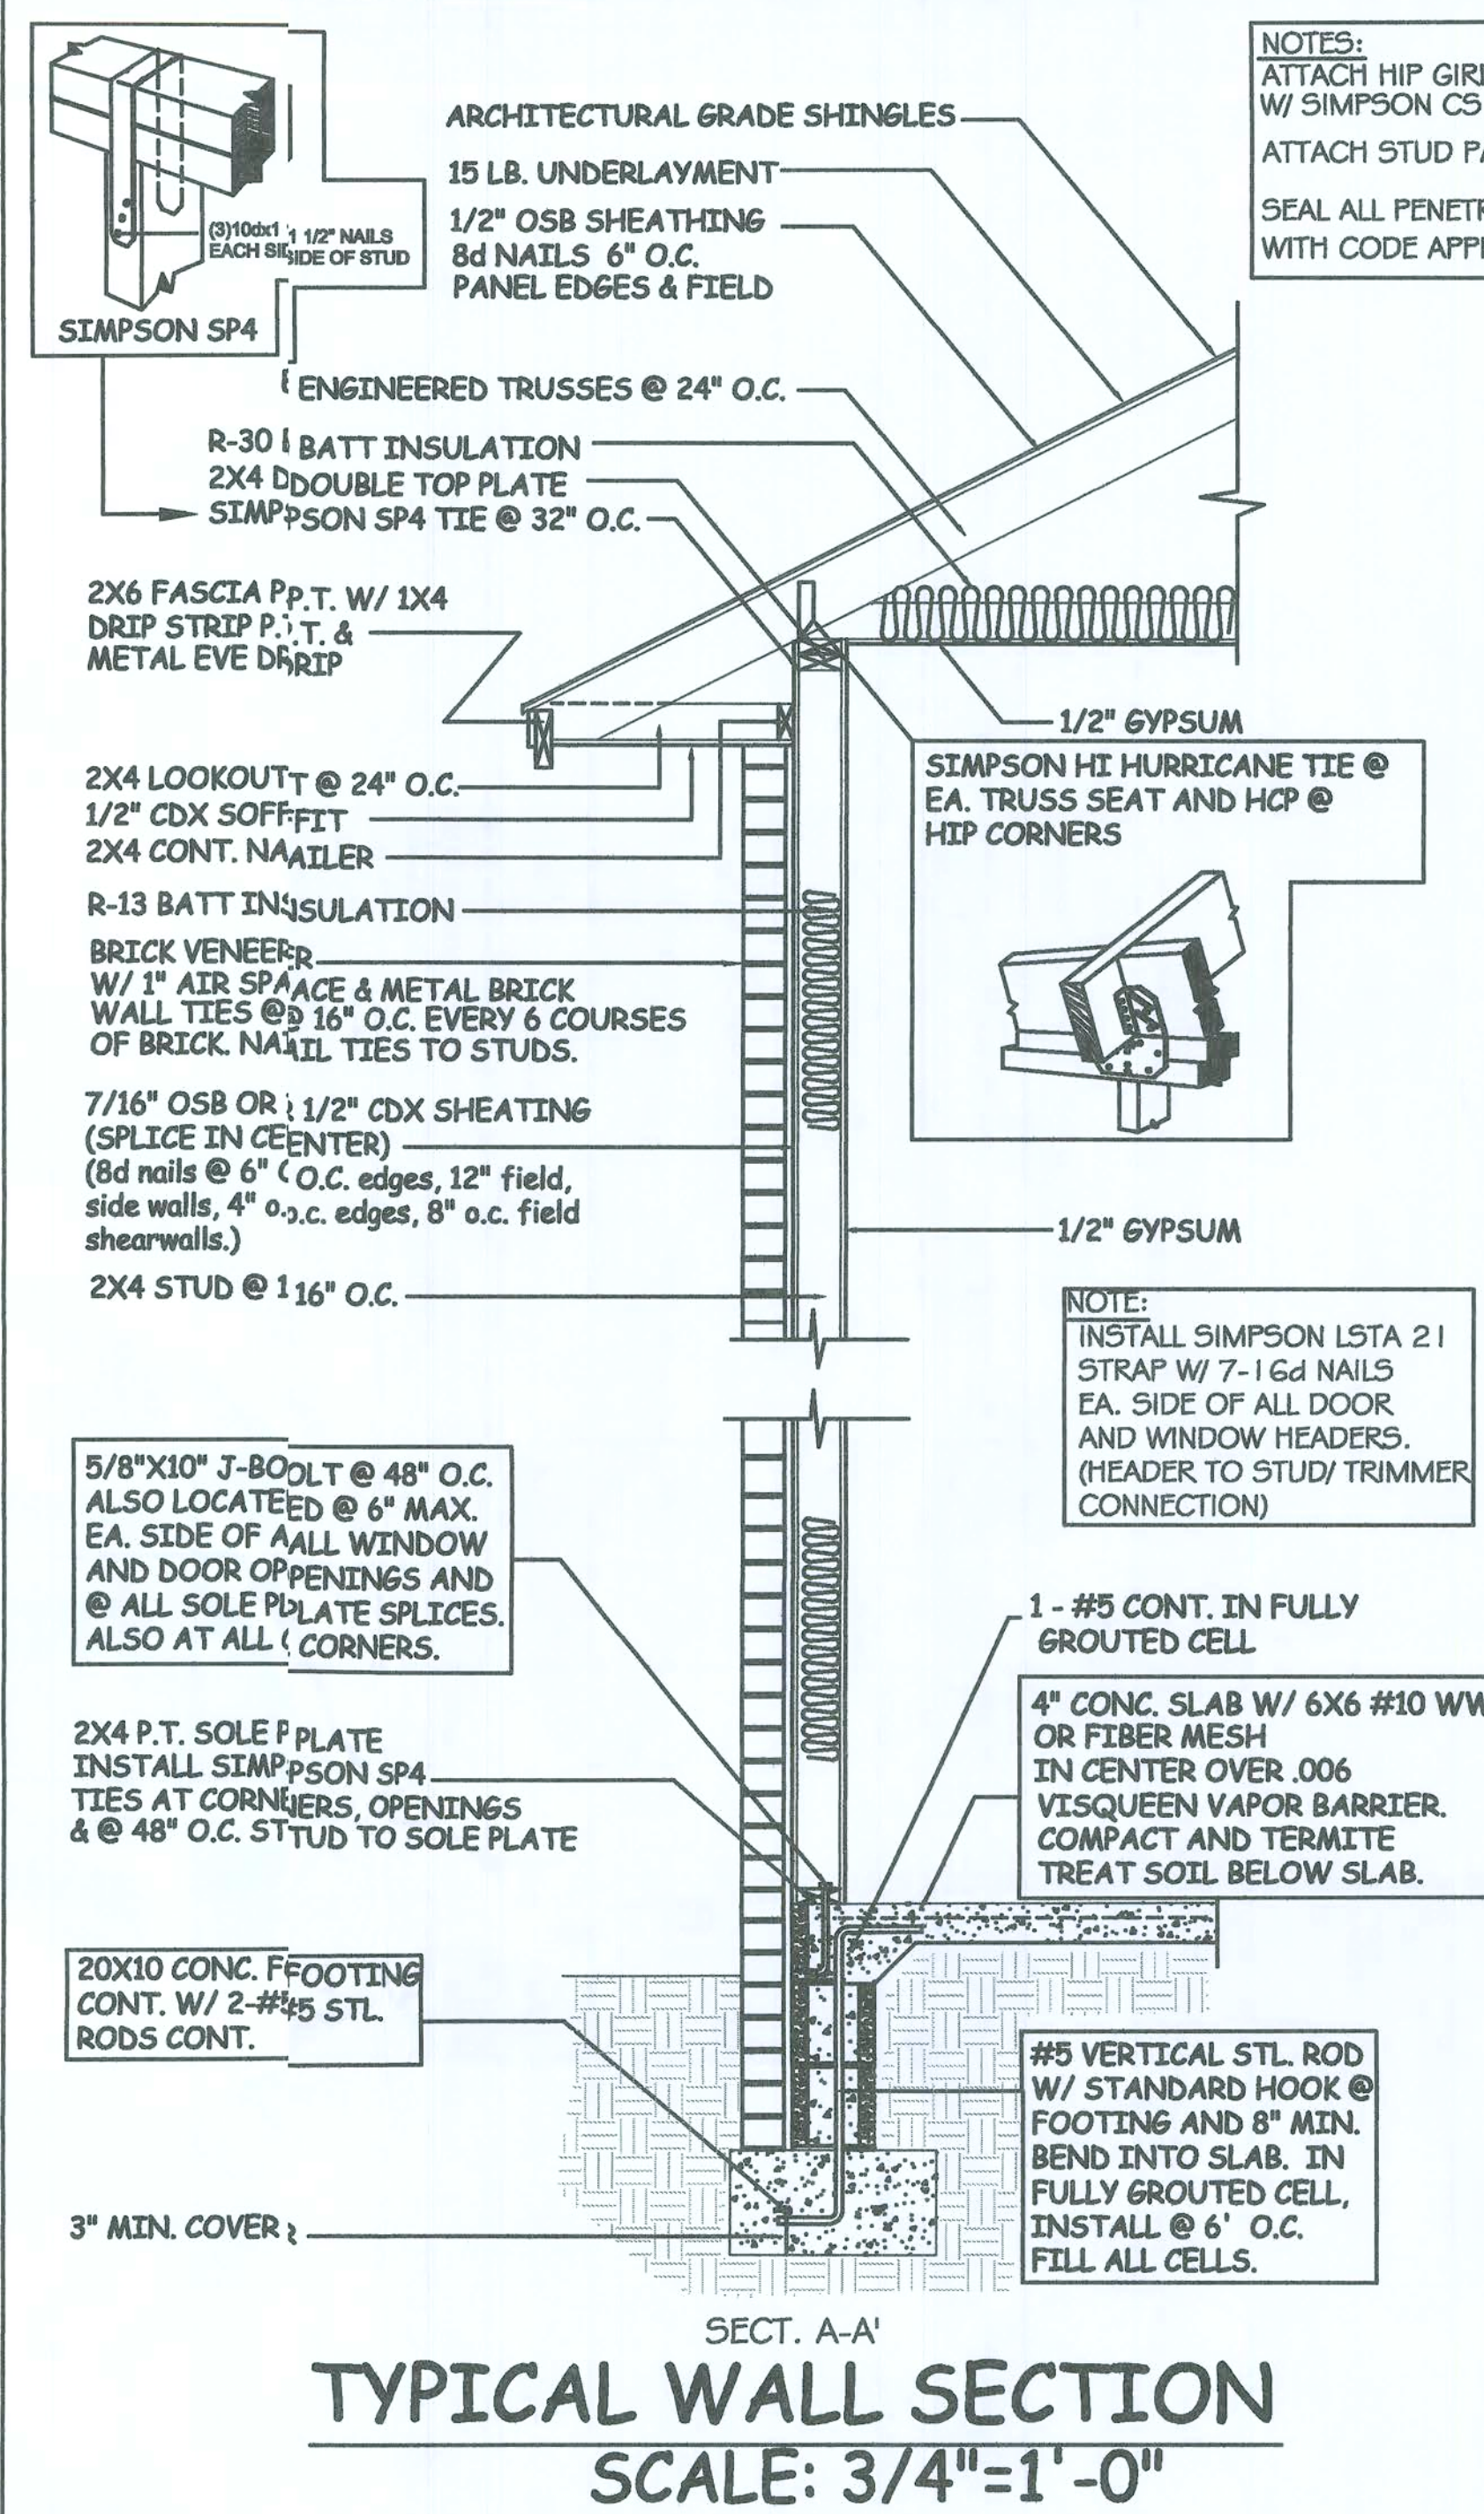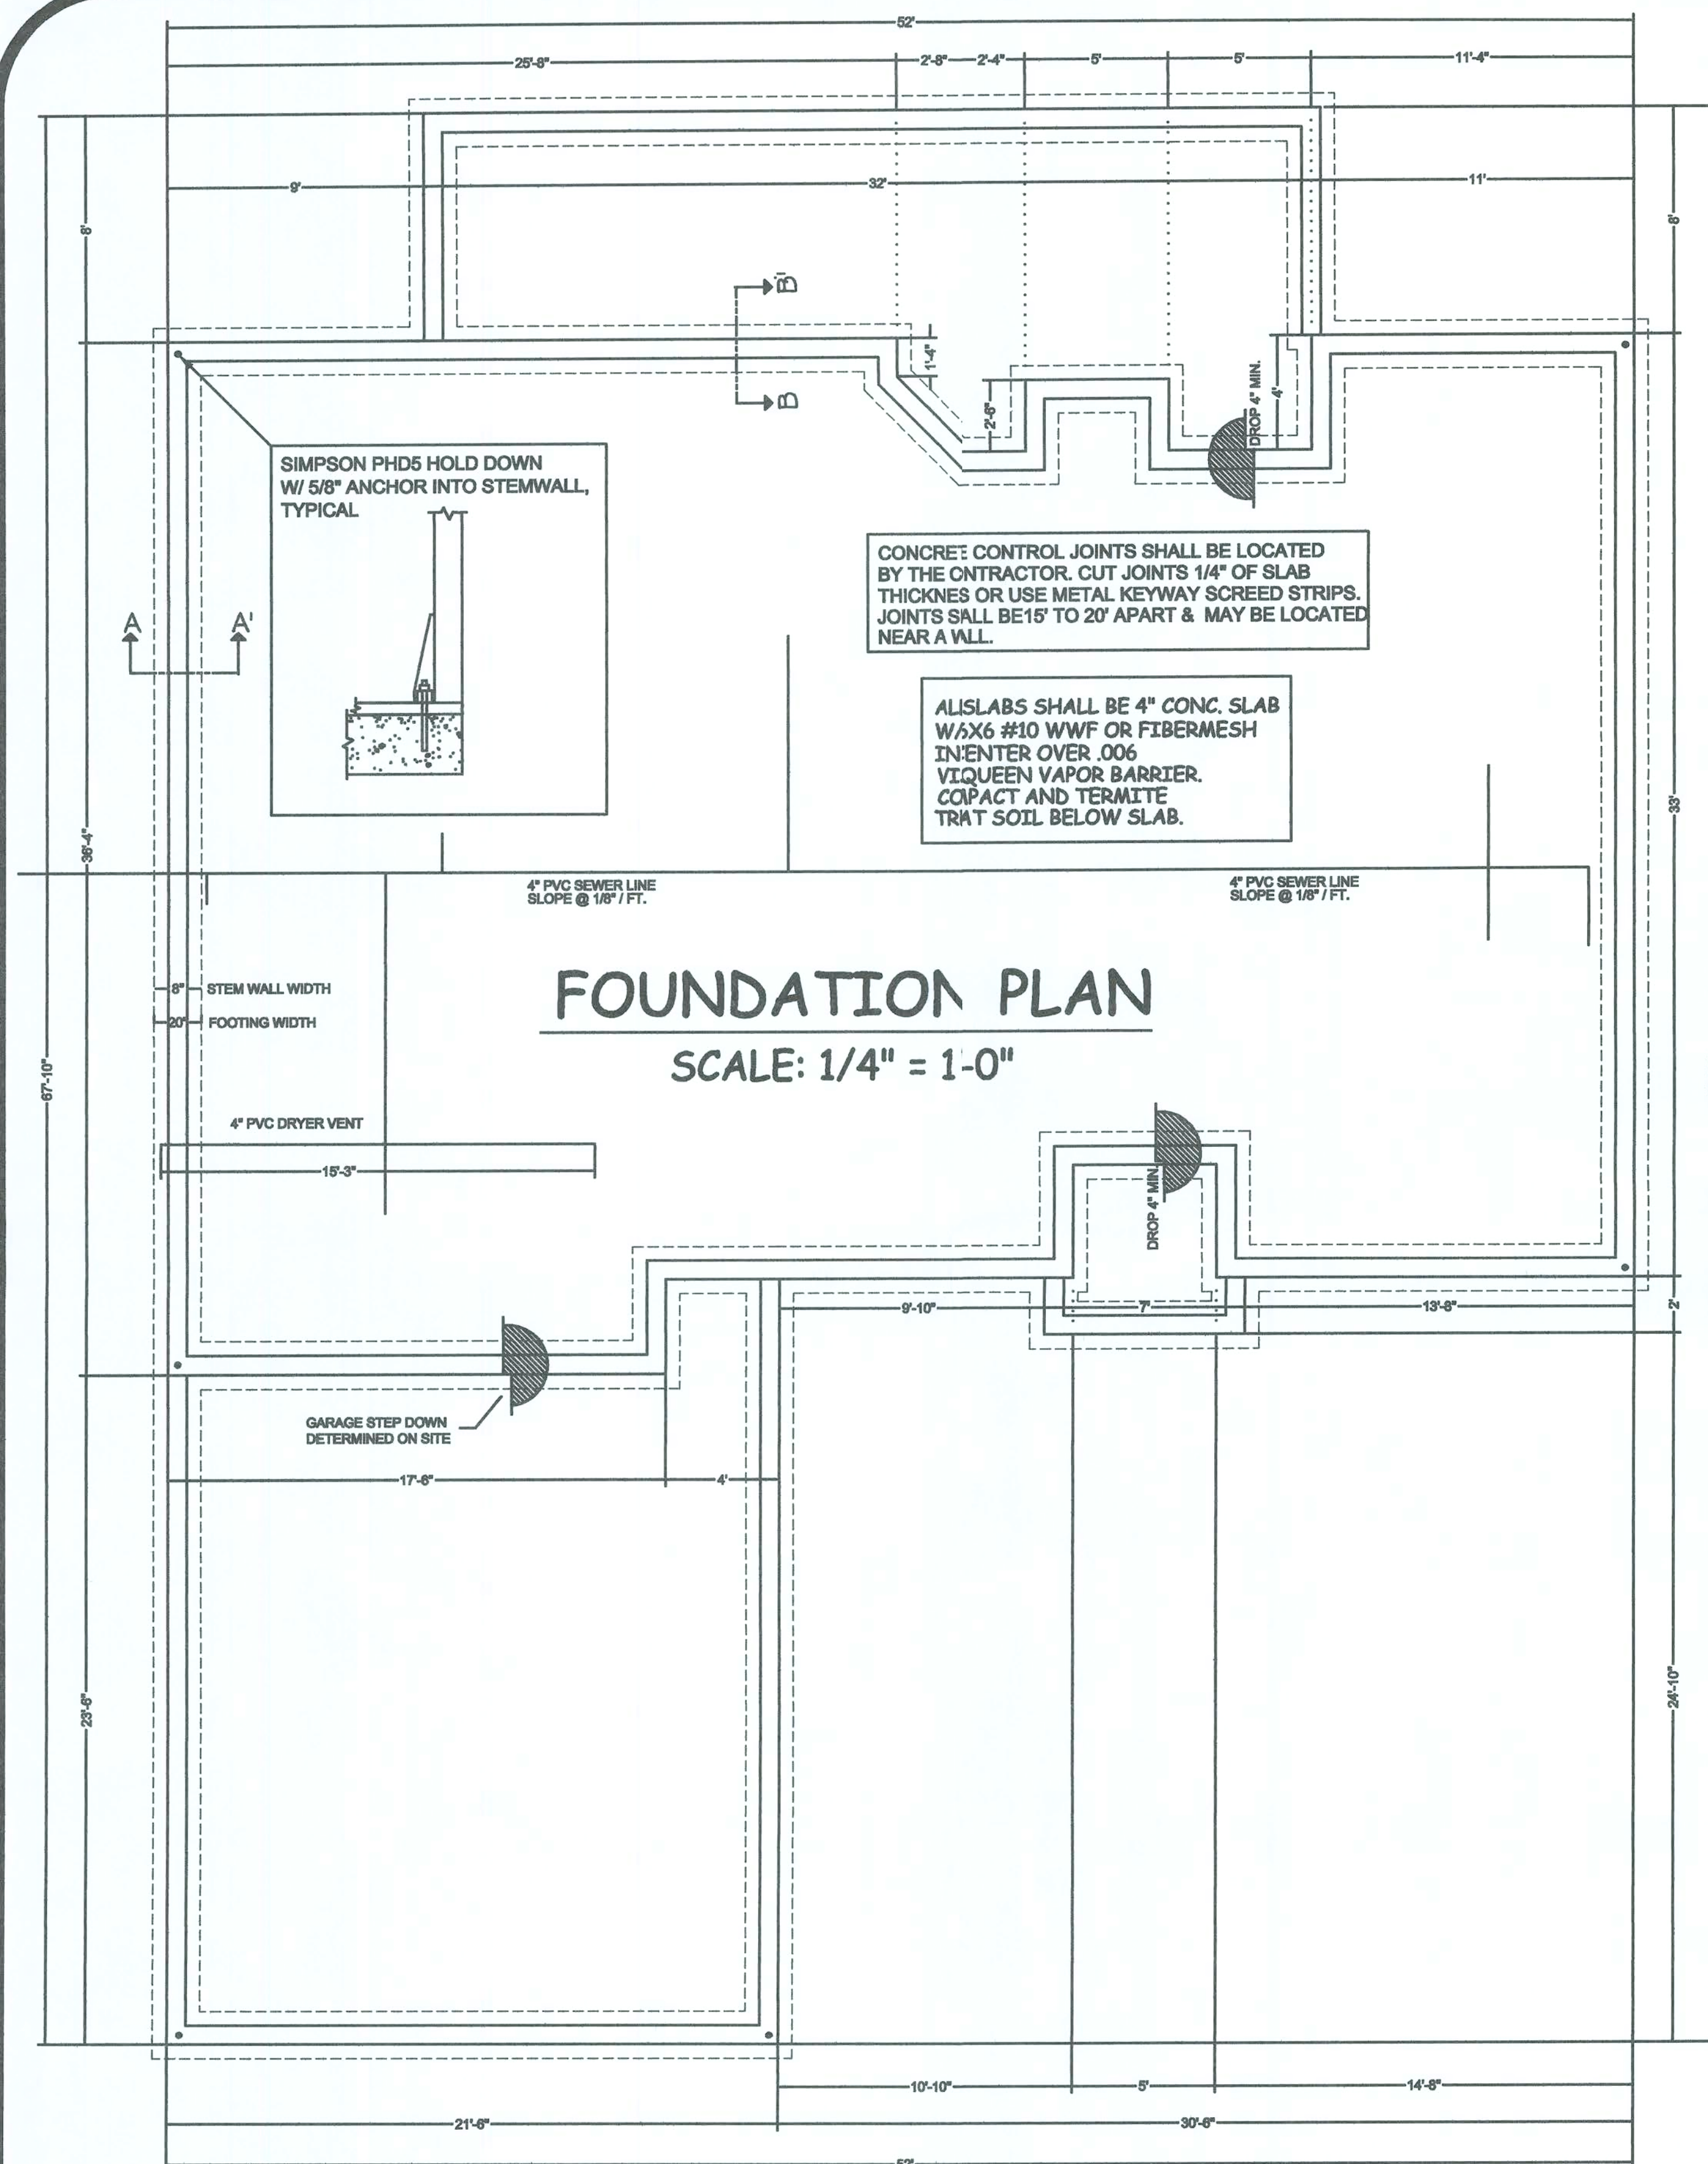

NOTE:
INTERIOR BEARING WALLS ARE AT DISCRETION OF CONTRACTOR TO FACILITATE INSTALLATION OF ROOF TRUSSES AND/OR ROOF FRAMING. CONTRACTOR SHALL USE INTERIOR FOOTING DETAIL AT INTERIOR BEARING WALLS

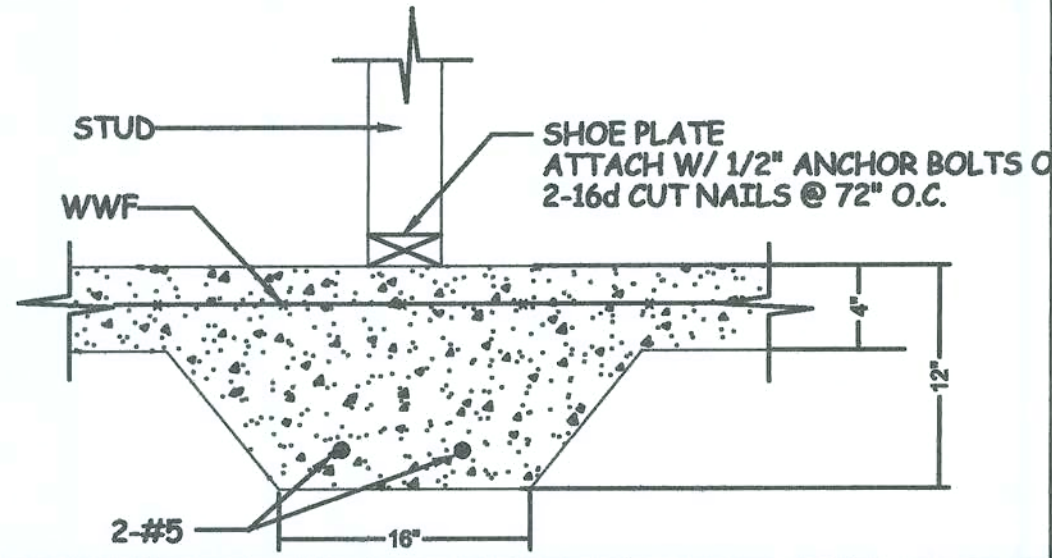


NOTES:
ATTACH HIP GIRDER TRUSSES TO STUD PACKS TO IN WALL BELOW W/ SIMPSON CS16 STRAPS
ATTACH STUD PACKS TO SOLE PLATE W/ SIMPSON SP4
SEAL ALL PENETRATIONS AND TOP PLATE AND FIRE STOP BLOCKING WITH CODE APPROVED SEALANT.

DATE: July 2, 2008
SHEET: 4 OF 4

GENERAL NOTES

- 1-ELEVATIONS INDICATE LEVEL SITE CONDITIONS. ACTUAL SLOPE AND/OR VARIATIONS IN GRADE CONDITIONS TO BE DETERMINED ON SITE PRIOR TO CONSTRUCTION.
- 2-CHECK ALL DIMENSIONS FOR ACCURACY PRIOR TO CONSTRUCTION
- 3-ALL CONSTRUCTION MUST CONFORM TO CURRENT STATE AND LOCAL CODES WHERE APPLICABLE (2004 FBC)
- 4-ALL CONCRETE 3000 PSI. ALL REBAR GRADE 40.
- 5-OVERLAP ALL REINFORCING REBAR SPLICES 30" MIN.

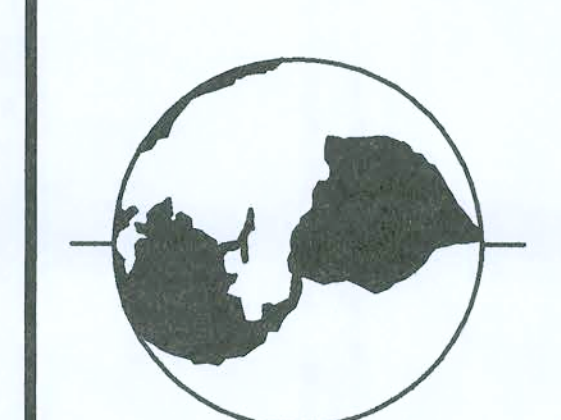

LEGEND

PREPARED FOR:
Paul & Allison Dyal
Columbia Co., Florida

PREPARED BY:
Jodi Cooper
1772 N.E. CHERVIL DRIVE
LEE, FLORIDA 32059
850-971-5607
e-mail: jodicoper62@yahoo.com

DYAL HOME

THESE PLANS WILL COMPLY WITH THE FLORIDA BUILDING CODE FOR A 110 MILE PER HOUR WINDLOAD (THREE SECOND INTERVAL)

John K. Gentry
JOHN K. GENTRY
P.E. #16990 — ENGINEERING BUSINESS #25890
2-July-08

ENGINEERING LLC.

POST OFFICE BOX 1034
PERRY, FLORIDA 32348
(850) 672-0145

COASTAL RESOURCES