




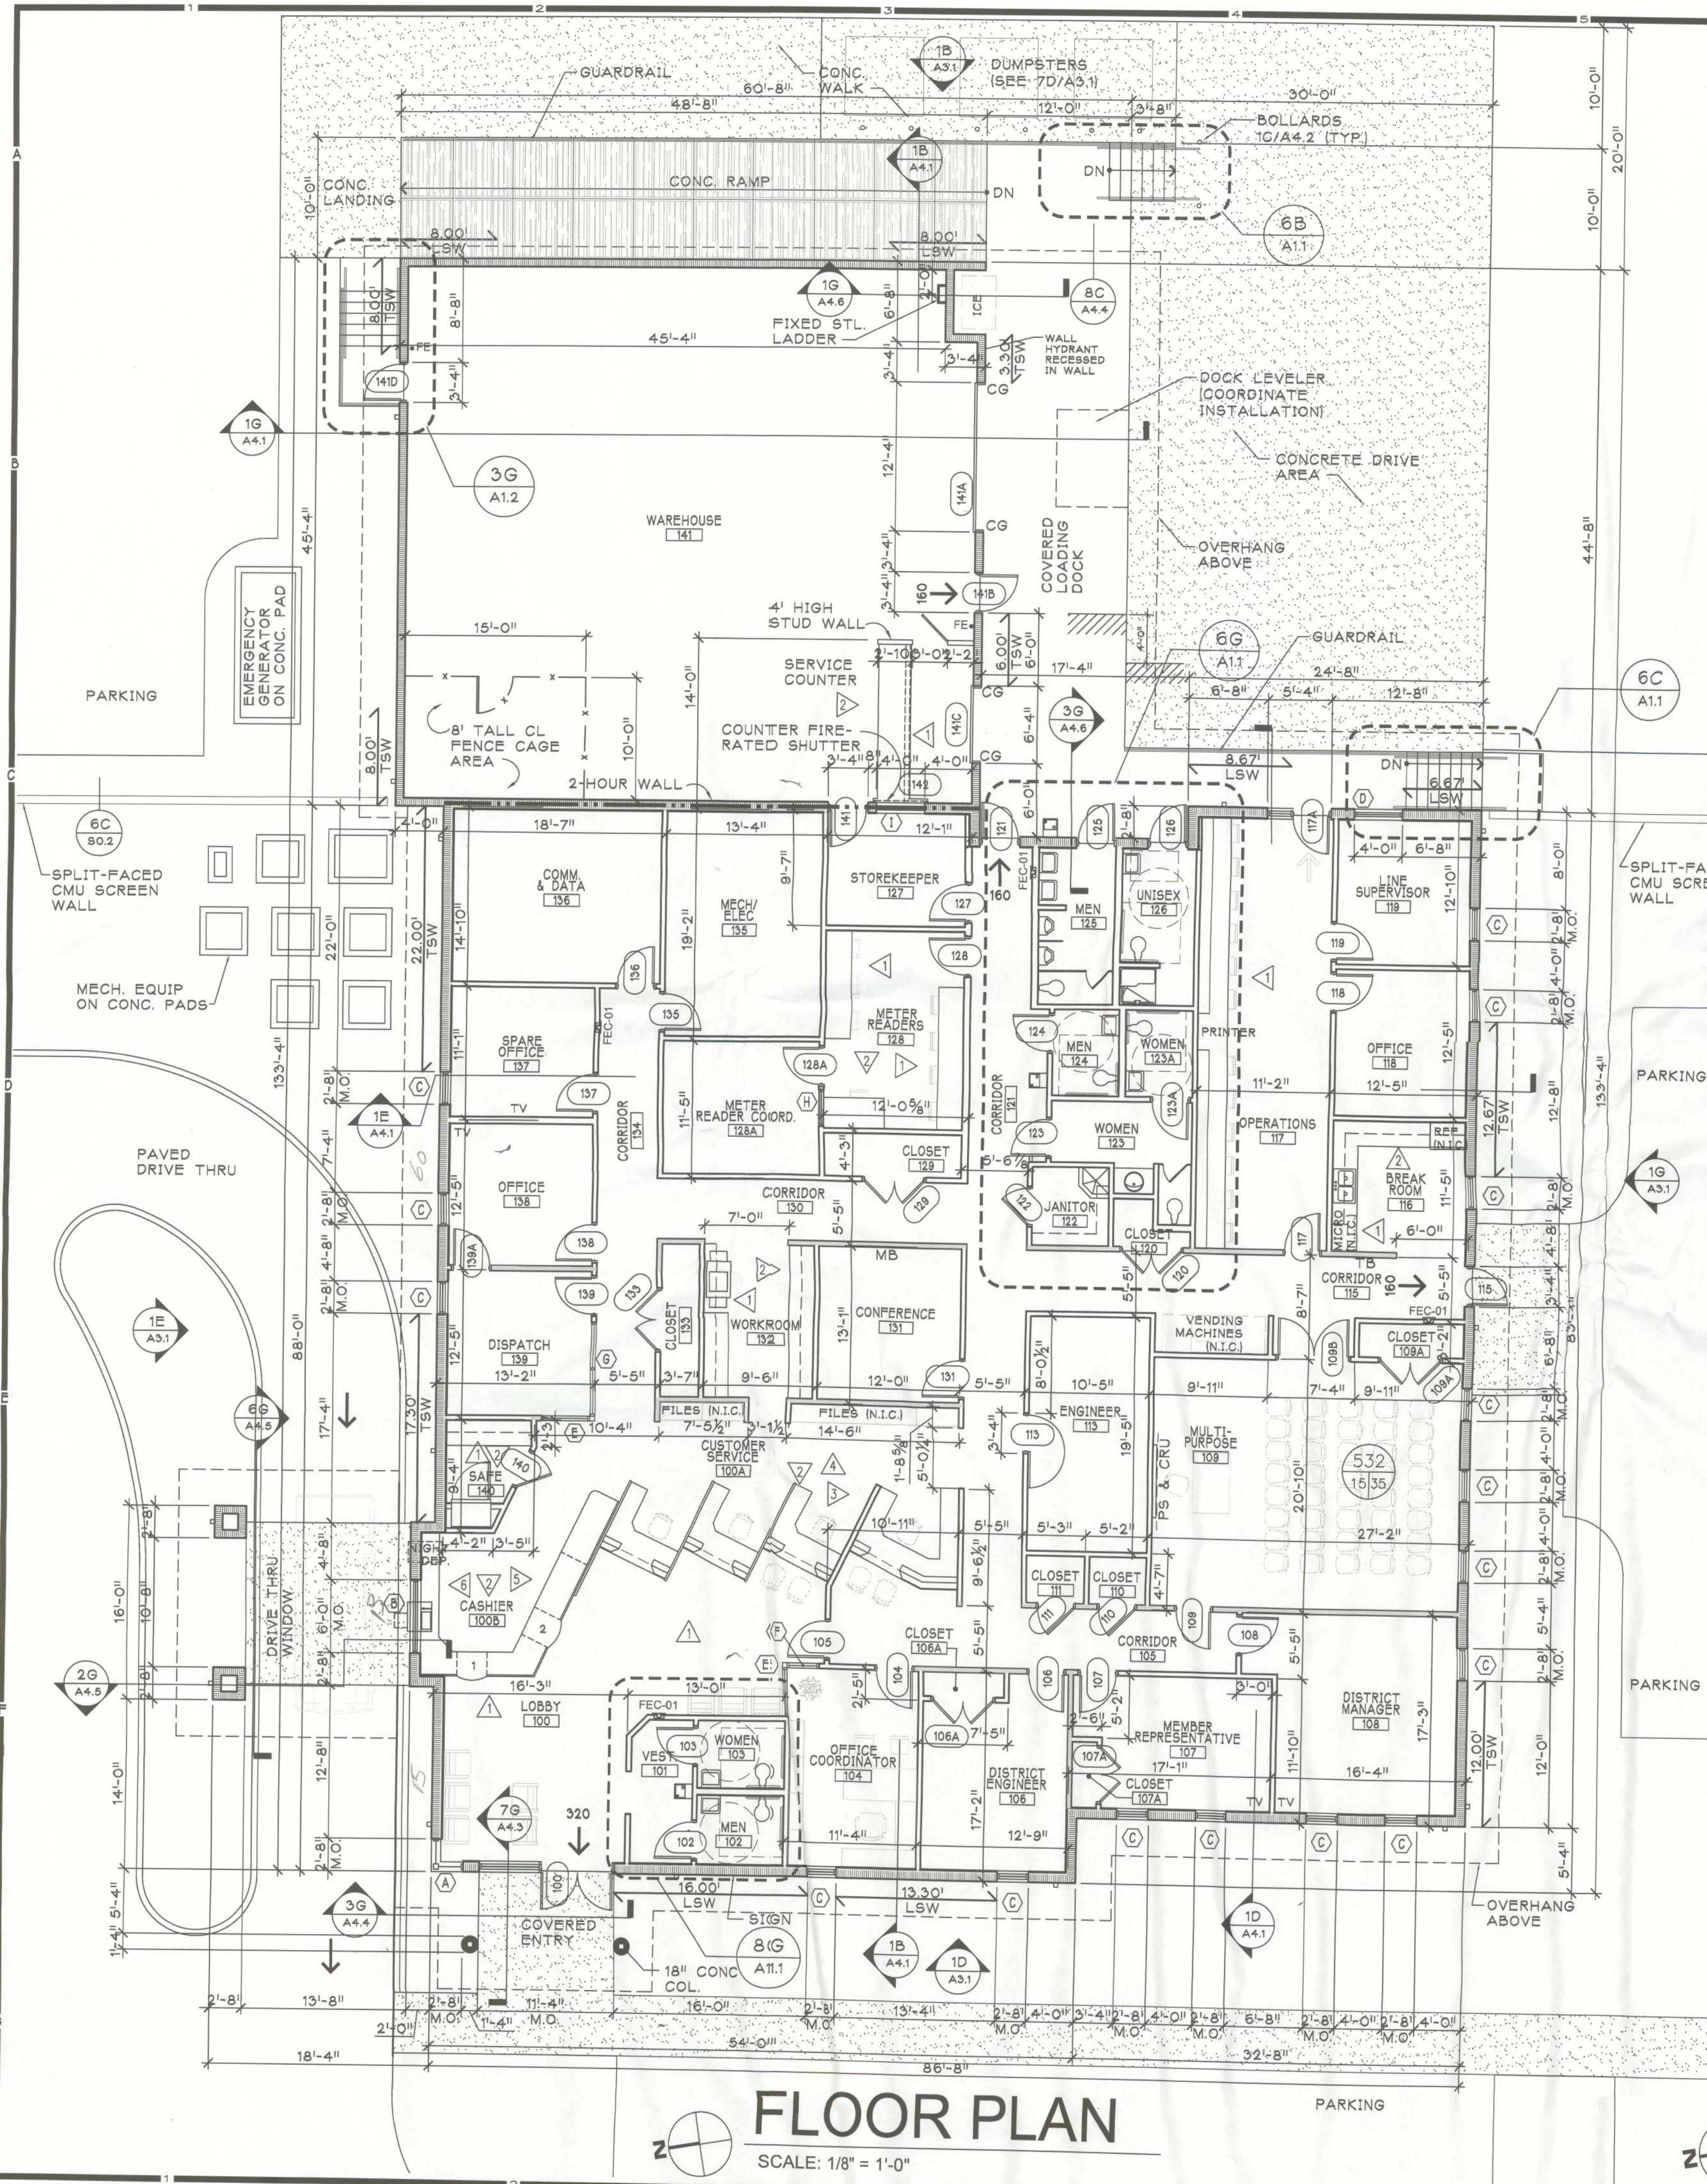

FLOOR PLAN
SCALE: 1/8" = 1'-0"

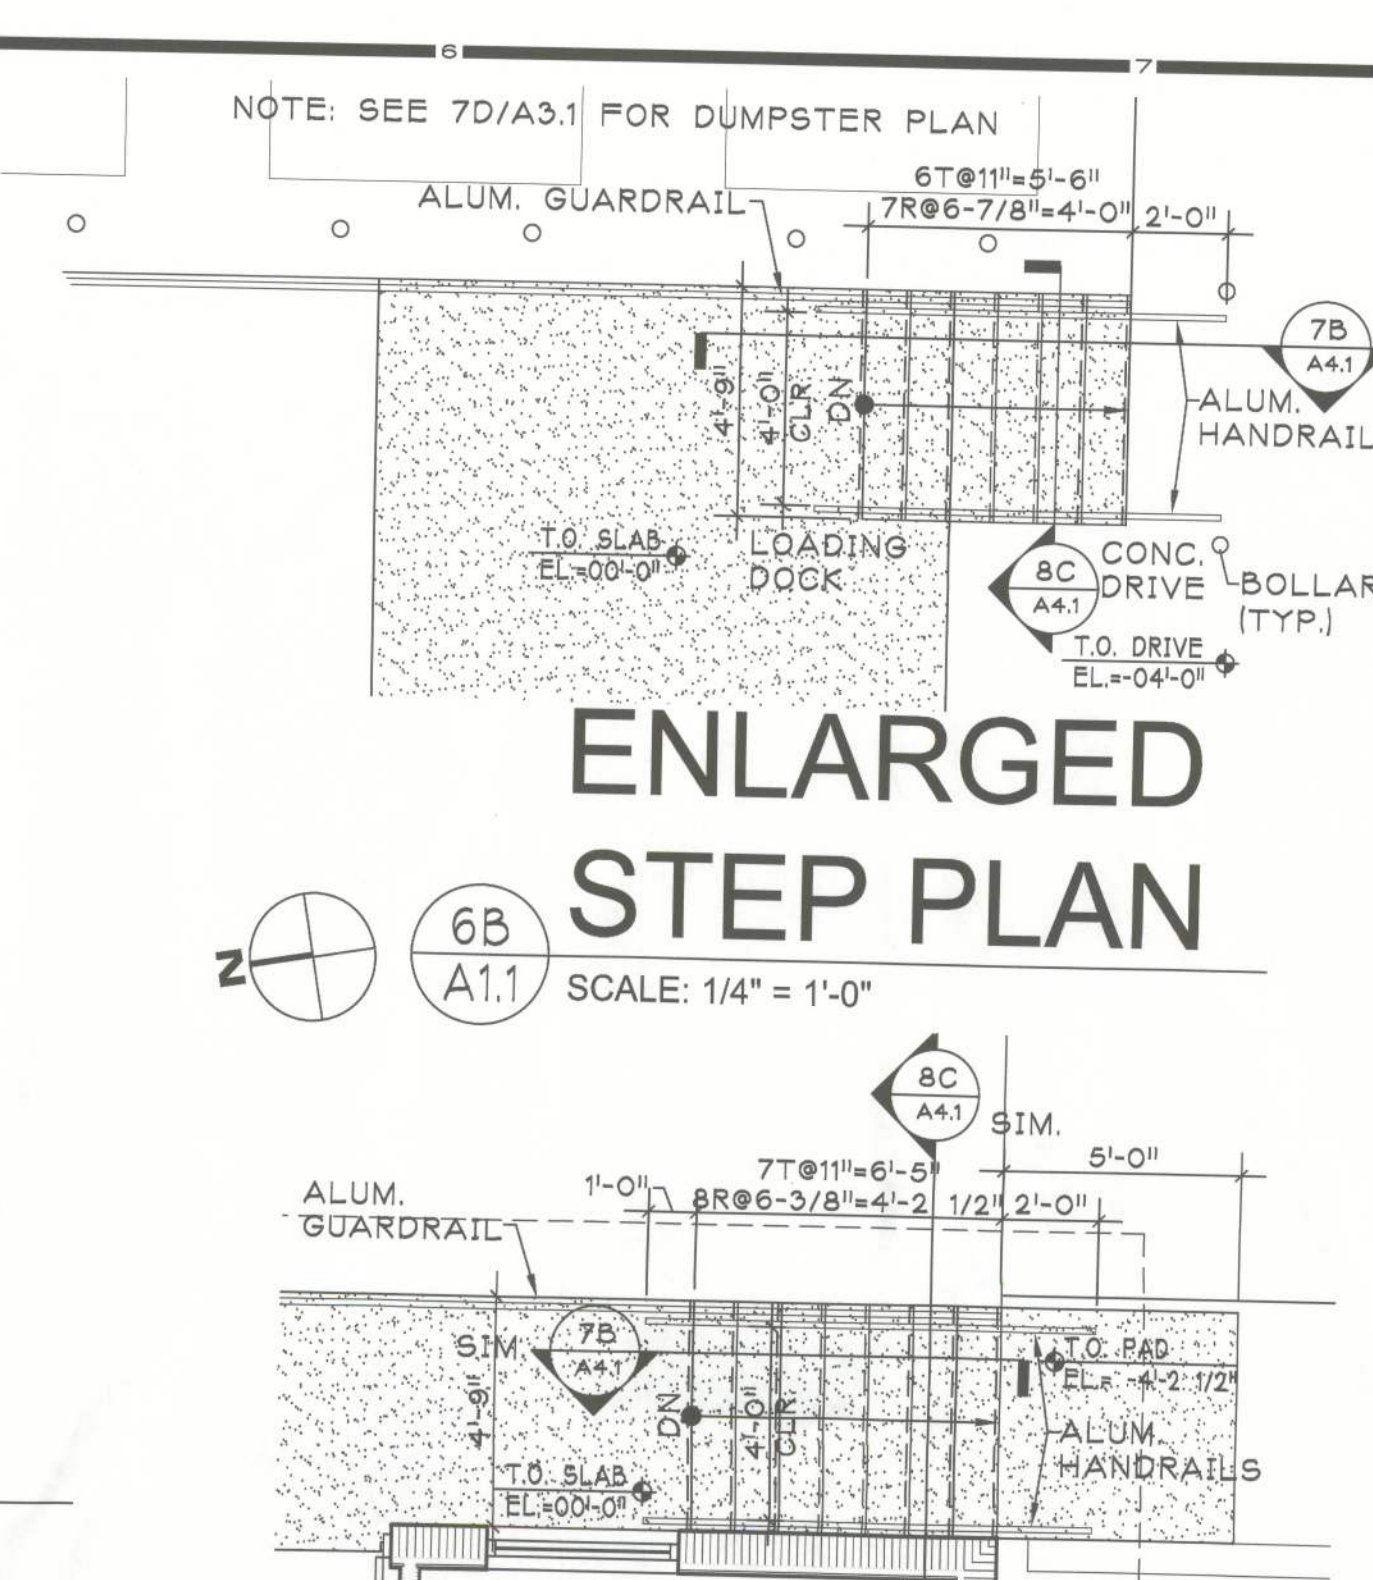

ENLARGED STEP PLAN
SCALE: 1/4" = 1'-0"

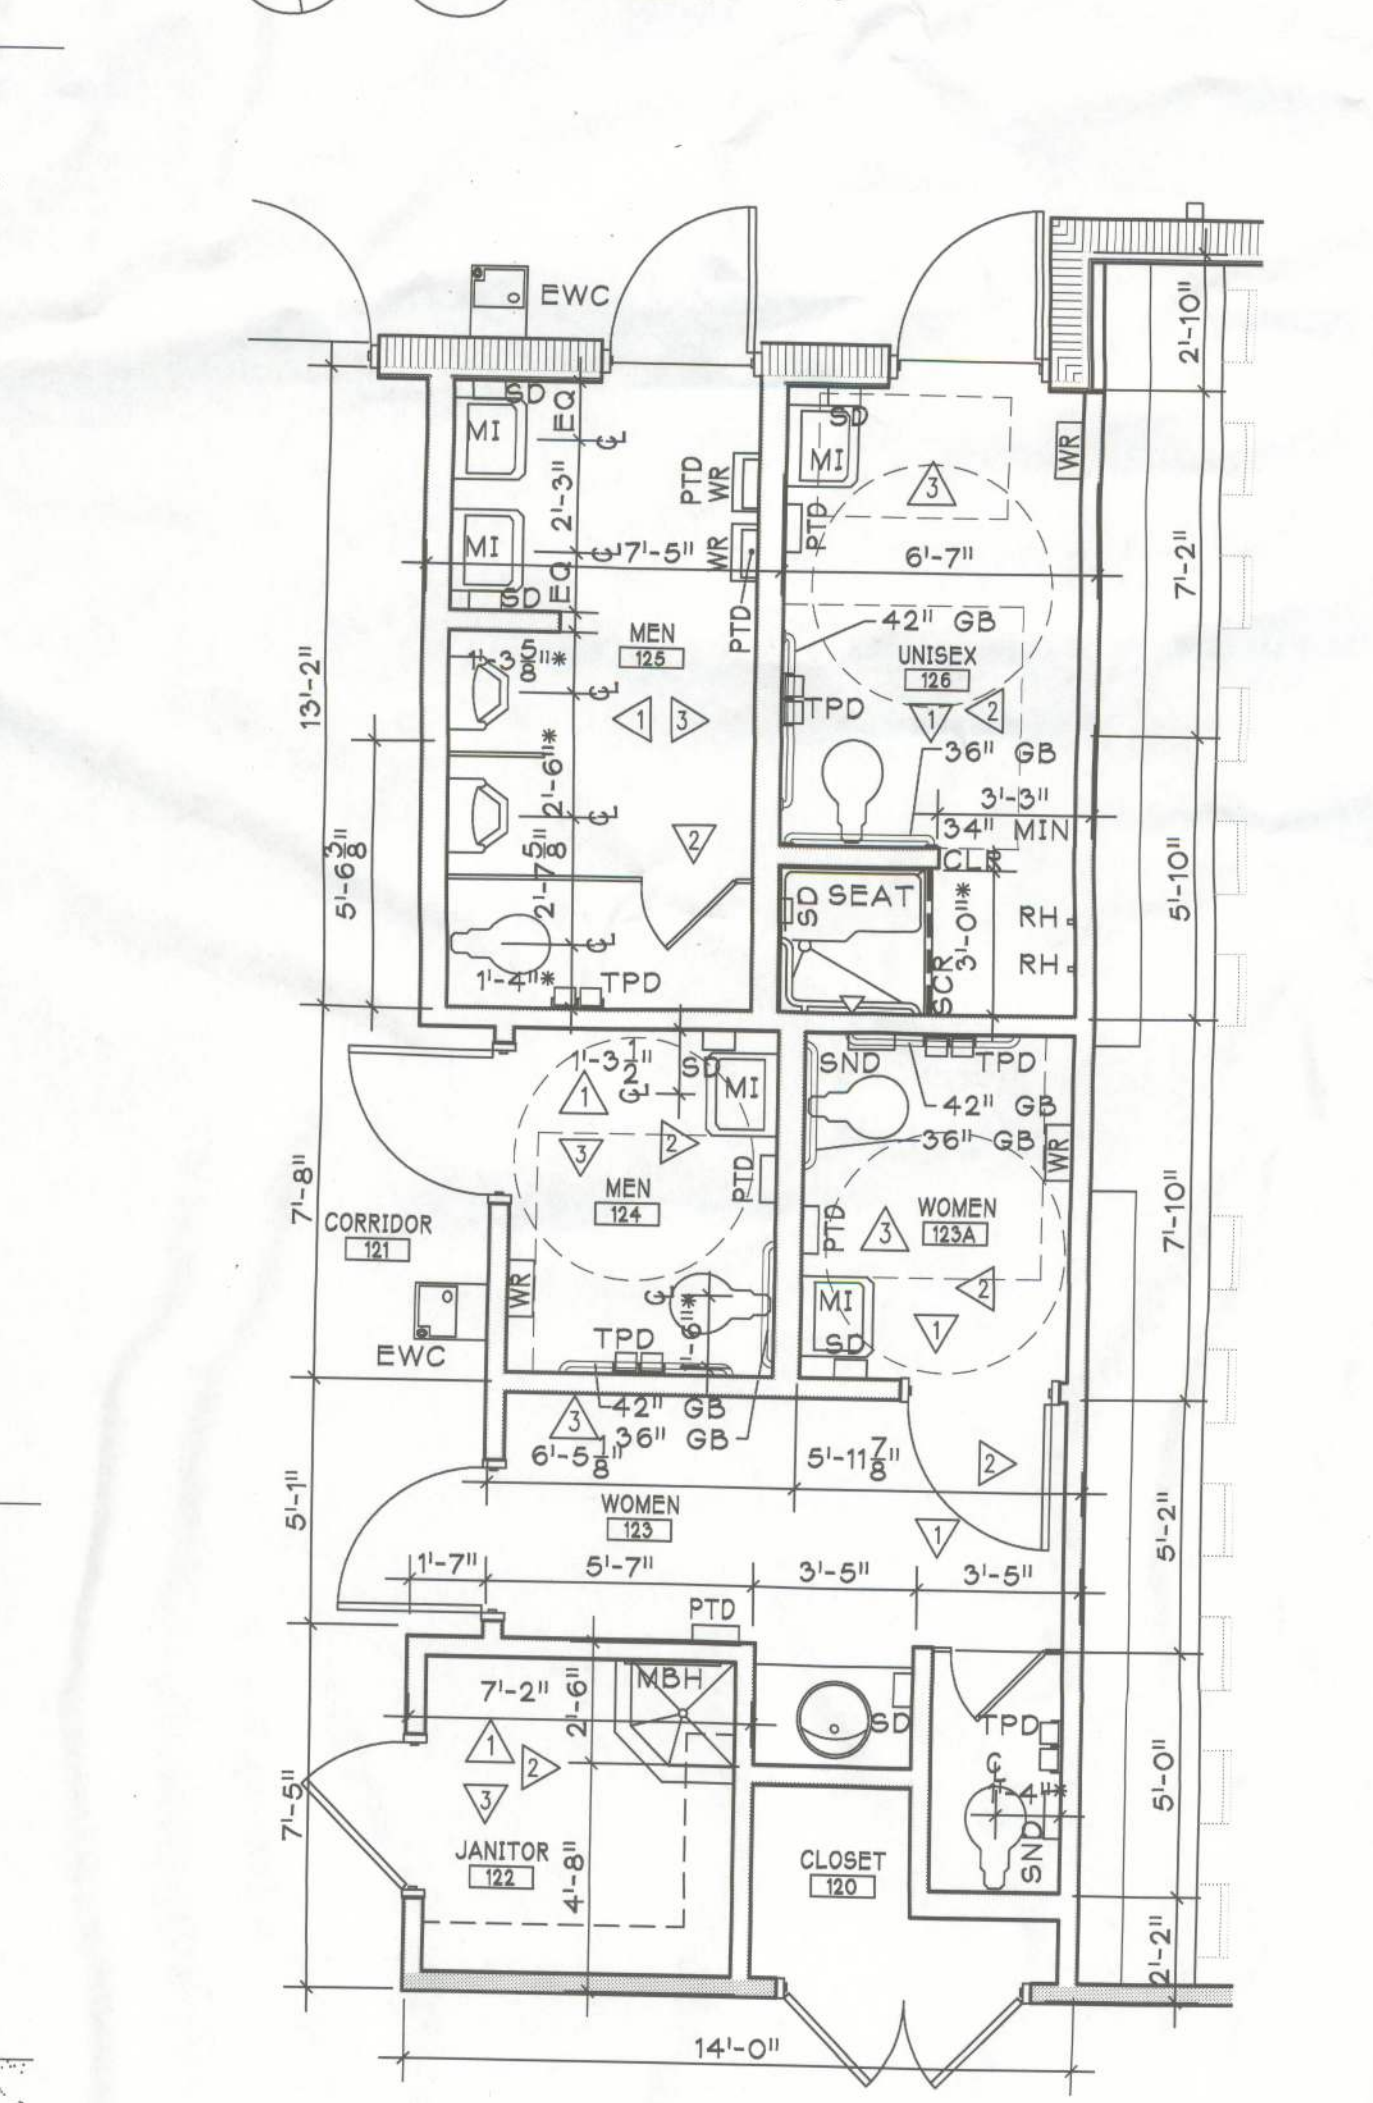

ENLARGED PLAN
SCALE: 1/4" = 1'-0"

FLOOR PLAN LEGEND:

2-HR FIRE RATED WALL	WD STUD PARTITION W/ 5/8" GYP. BD. EA. SIDE & SOUND ATTENUATION BLANKETS AT CAVITY
LOAD BEARING WALL	TB 4'-0" LONG TACK BOARD (SEE SHEET A0.1 FOR MTG HGT)
CMU (SIZE & TYPES VARIES - SEE DETAILS)	MB 6'-0" LONG MARKER BOARD (SEE SHEET A0.1 FOR MTG HGT)
CMU (SIZE & TYPES VARIES) W/ 2" MTL Z FURRING @ 24" O.C. W/ 2" RIGID INSULATION	CRU CONFERENCE ROOM UNIT
WALL SECTION OR DETAIL TAG	PS PROJECTION SCREEN
BUILDING ELEVATION TAG	NAME ROOM NAME & NUMBER
FEC FIRE EXTINGUISHER CABINET VERIFY EXACT LOCATION W/ FIRE MARSHAL	DOOR NUMBER
FE WALL MOUNTED FIRE EXTINGUISHER	WINDOW TYPE
CG 3"x3" STEEL CORNER GUARD (FULL HGT OF OPENING)	ALUM. STOREFRONT TYPE
	INTERIOR ELEVATION TAG SEE SHEETS A5.1 & A5.4

- GENERAL CONSTRUCTION NOTES:**
- INTERIOR PARTITIONS TO BE WD STUDS @ 16" O.C. WITH 5/8" GYPSUM BD. BOTH SIDES AND SOUND BATTS AT CAVITY BETWEEN STUDS.
 - INTERIOR DOOR FRAMES IN WD. STUD WALLS ARE TYPICALLY SET 4" OFF ADJACENT WALL, UNLESS OTHERWISE SHOWN.
 - THE CONTRACTOR SHALL REPORT ANY DISCREPANCIES WITHIN CONTRACT DOCUMENTS TO THE ARCHITECT IMMEDIATELY.
 - ESTABLISHING THE TOP OF SLAB ELEVATION AT 0'-0" IS FOR REFERENCE ONLY. REFER TO CIVIL DRAWINGS FOR ACTUAL ELEVATION OF FLOOR.
 - ALL FURNITURE SHOWN IS FOR OWNER'S REFERENCE ONLY AND IS NOT IN CONTRACT.
 - DIMENSIONS ARE TO THE FACE OF STUDS AND FACE OF CMU UNLESS OTHERWISE DENOTED WITH ASTERISK WHICH INDICATES FINISHED FACE OF WALL.
 - ALL INTERIOR PARTITION WALLS TO RECEIVE SOUND ATTENUATION BLANKETS BETWEEN STUDS.

SHEARWALLS (SW)

LONGITUDINAL SW


TRANSVERSE SW

SPUTO & LAMMERT ENGINEERING, LLC
STRUCTURAL ENGINEERS
10 SW 1st AVENUE
GAINESVILLE, FLORIDA 32601
PHONE 352-378-0448 FAX 352-373-1331
THOMAS SPUTO, PH.D., P.E.
CA6855 PE 39142

(STRUCTURAL ENGINEER RESPONSIBLE FOR SHEARWALLS ONLY)

LIFE SAFETY LEGEND:

000 SPACE SQUARE FOOTAGE	000 NUMBER INDICATES EXIT CAPACITY
0/00 CALCULATED OCCUPANT LOAD	EXIT LIGHT (COORDINATE WITH ELECTRICAL DRAWINGS)
AREA/OCCUPANT	FE FIRE EXTINGUISHER TO BE PROVIDED PER NFPA 101 LIFE SAFETY CODE
PRIMARY EGRESS / EXIT	
SECONDARY EGRESS / EXIT	

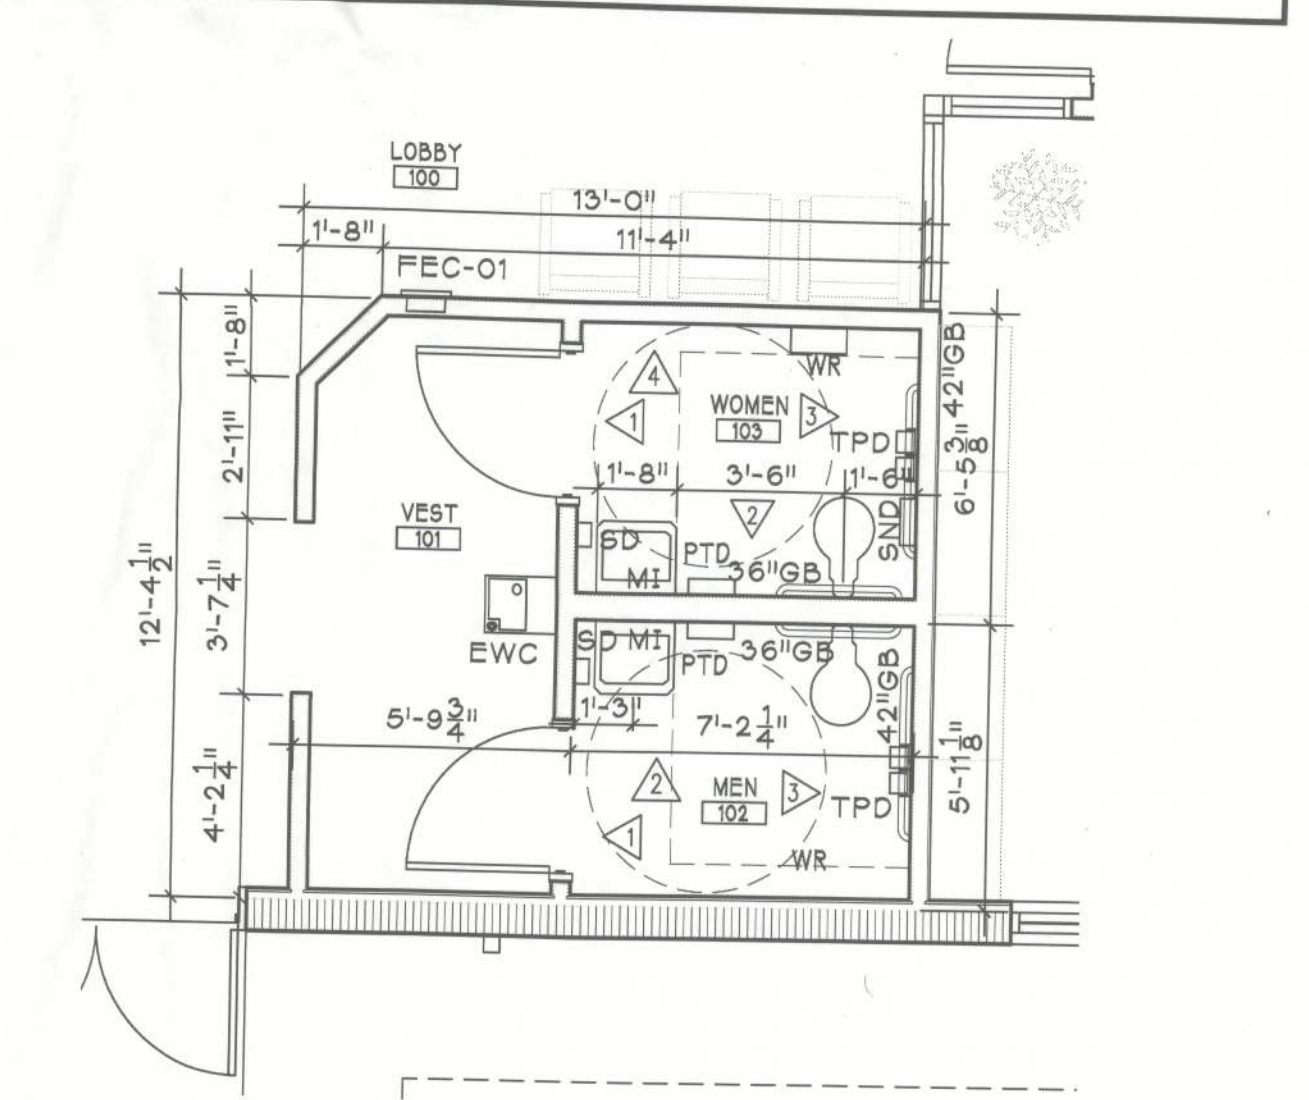

ENLARGED PLAN
SCALE: 1/4" = 1'-0"

NEW DISTRICT OFFICE

CLAY ELECTRIC COOPERATIVE, INC.

WILLIAM W. BRAM
REGISTRATION # AR-00070
CORP. LIC. NO. AA-00000

FLOOR PLAN

DRAWN BB, MD
CHECKED E
DATE 02/07/2017
CAD 3702060/C
REVISIONS
FILE NO. 3702.06
SHEET
A1.1

Bid Documents