

12523 U.S. Highway 441 - Alachua, FL 32615 Phone: (904) 462-5323/FAX: (904) 462-1509

Client Name: WINGFIELD Model: CUSTOM

BANK: TBD LOAN TYPE: () Cash
(X) Conventional
() F.H.A.
() V.A.

CABINET COLOR SELECTIONS:

Kitchen: Countertop IC02 6x6 ARROW HEAD INCLUDE SPLASH, GROUT 01 ALABASTER MAPEI
Cabinet Base BRUNSWICK WHEAT CHOCOLATE

Master Bath: Countertop SANDS OF ACAPULCO
Cabinet Base FLORENCE WHEAT A.H.

Hall Bath: Countertop SANDS OF ACAPULCO
Cabinet Base FLORENCE WHEAT A.H.

Toilets: Color BISQUE
Master: Color BISQUE
Hall: Color BISQUE
Other: Color HALL BATH

NOTES:
HALL BATH (DECOS-SC40 ACCENT STRIP)
MASTER BATH (DECOS-SC42 WALNUT ACCENT STRIP)
GENE MEET W/HOMEOWNER FOR STAIN COLOR
MASTER BATH SC42 12x12 FLORAL BORDER SC 42 (MEET W/ OWNER)

BATHROOM TILE SELECTION:

Master Bath: Color BISQUE Tub Choices STEEL Pump
Shower SC 42 WALNUT 8x10
Shower Floor SC 42 6x6
Grout BUSQUIT # 14

Hall Bath: Bath 3 Tub Surround *
Tile Selection
Grout BUSQUIT # 14

VAULTS:

KITCHEN, GREAT ROOM

CARPET
MASTER BED & BEDROOM 2
LWF MAM 301 MAINE MAPLE NATURAL
DINING ROOM GGO301 GOERSIA RED OAK

VINYL/FLOOR TILE
RUST RD05 18x18
GREAT ROOM
RUST RD05
KITCHEN 3 74 CAMEL

PAINT SELECTIONS:

Interior Wall Color GENE MEET W/ HOMEOWNER
Interior Trim SW 6378 CRISP LINEN- WALLS AND CEILING

Window Sills:
(X) Wood
() Flatcut Marble
() Hardiplank Siding Wood Sill

RANGE SELECTIONS:

Range/Color
Hood/Color

EXTERIOR FEATURE SELECTIONS:

Hardiplank Color SW 6660 HONEBLUSH
Trim Package
Trim Color SW6662 SUMMER DAY
Exterior Door Colors
Siding CHOCOLATE BROWN A1
Soffit
Shingles 1)ORIFWOOD, 2)RUSTIC CEDAR, 3)PAINTED DESERT
Style/Color
Window Color BRONZE
Trim Type Colonial w/Classique Doors Std.
Colonial Grills ALL AROUND HOUSE

BATH WINDOWS:
Master (X) Obscure () Clear Glass
Hall (X) Obscure () Clear Glass

SUPER Energy Pac: Yes() No (X)

Extras:

Power Company: CLAY ELECTRIC () Overhead (X) Underground
Fireplace RUST RD 05 2 BLOCK HT HEARTH Screenroom Color N/A

OPTIONAL APPLIANCES:

640CE 1090P 660CL


684IM 686IM15

Well Allowance Yes (+) No ()
Septic Allowance Yes (+) No ()

We have reviewed this plan and all notes on it. All items we have discussed with House Craft and its representatives are indicated on this "Master Copy". We understand that any additional items that are not on this print can be done for a \$250.00 plan change fee plus the cost of the change.

Purchaser: * Date: *

REV.	DESCRIPTION	DATE

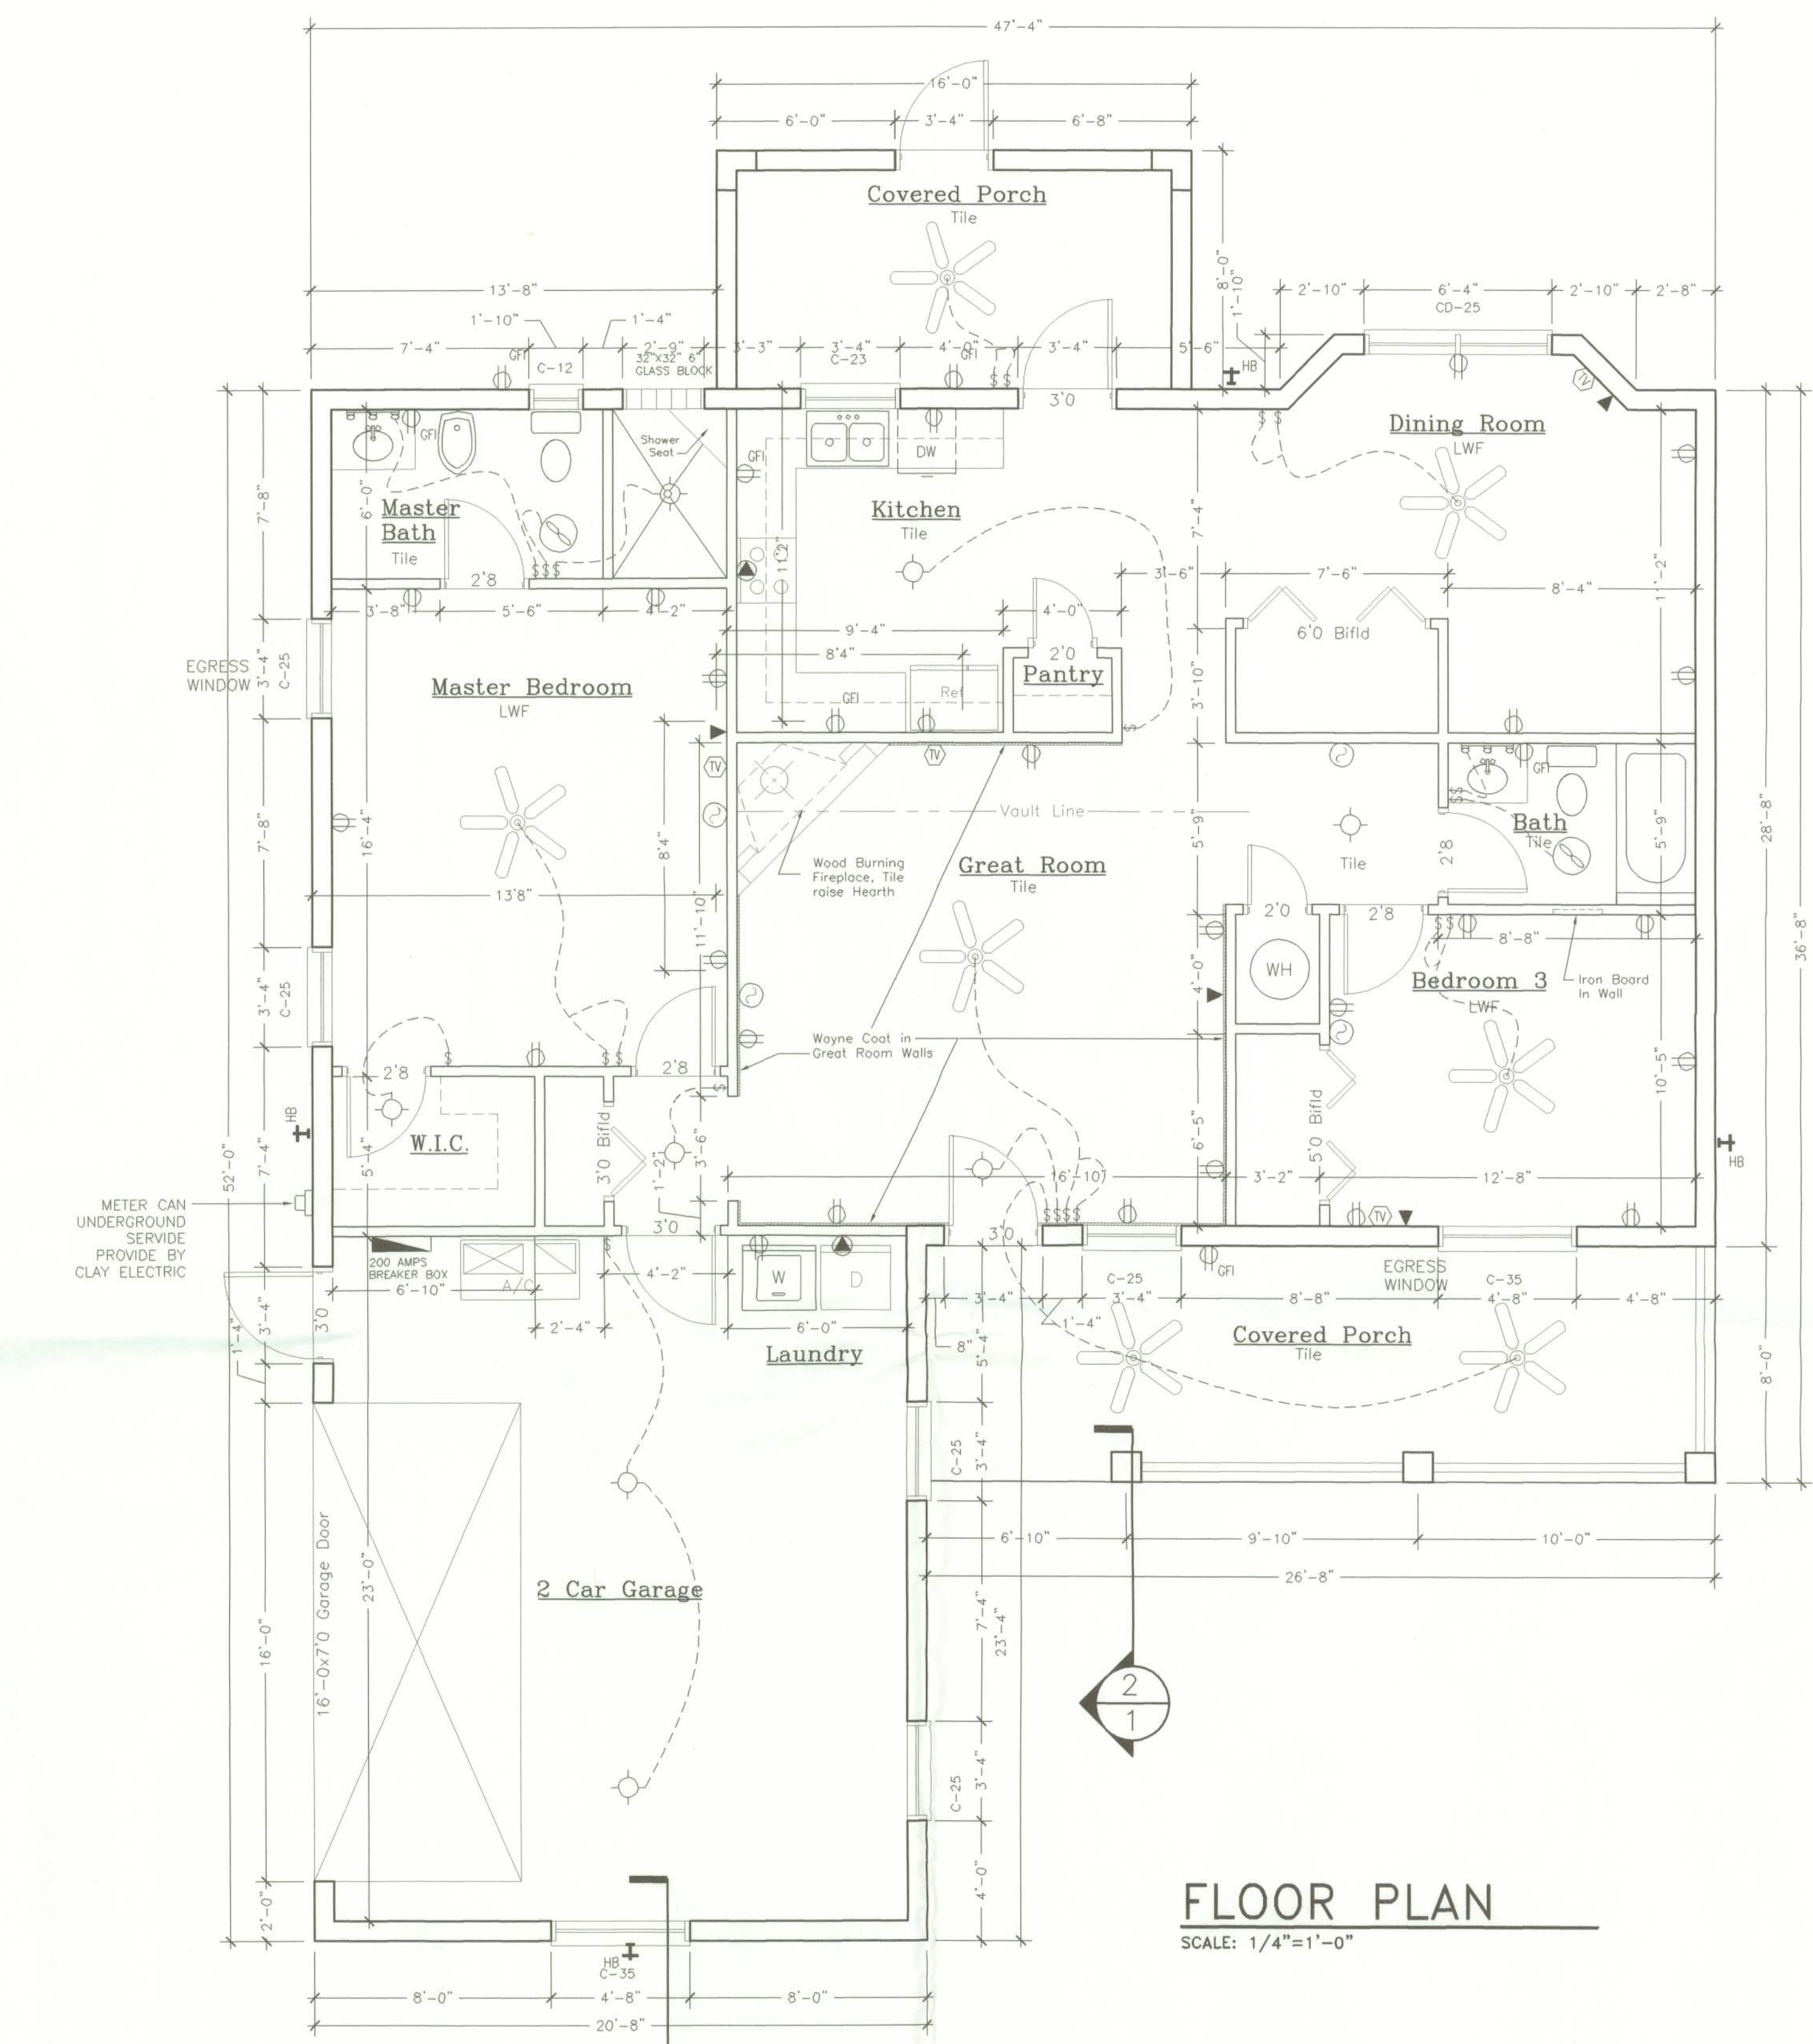

FLOOR PLAN
SCALE: 1/4"=1'-0"

LIGHTING FIXTURE SCHEDULE	
FIXTURE	DESCRIPTION
	SURFACE MOUNTED INCANDESCENT FIXTURE
	PRE-WIRED CEILING FAN
	DOUBLE FLOOD LIGHT FIXTURE
	FAN LIGHT VENTED TO EXTERIOR
	SURFACE MOUNTED INCANDESCENT FIXTURE

TYPICAL SPECIAL CIRCUIT ELECTRIC SCHEDULE	
TWO GFI's CIRCUITS IN KITCHEN ONE OR TWO GFI's IN BATHS LOOPED TOGETHER GFI IN GARAGE, FRONT ENTRY, AND REAR PORCH LOOPED TOGETHER ONE GFI FOR JETTED TUB (OPTIONAL) TWO AFI CIRCUITS PROVIDED FOR BEDROOMS	

ELECTRICAL LEGEND	
	DUPLEX CONVENIENCE RECEPTACLE WITH GROUND (44" DENOTES HEIGHT A.F.F. IF OTHER THAN STD.) (GF/GFCI DENOTES GROUND FAULT CIRCUIT INTERRUPTER) (WP DENOTES WEATHER PROOF)
	SPECIAL RECEPTACLE WITH GROUND, SEE SPECIFICATIONS
	SINGLE POLE SWITCH AT STANDARD HEIGHT
	THREE WAY SWITCH AT STANDARD HEIGHT
	TELEPHONE OUTLET
	CEILING MOUNTED EXHAUST FAN VENTED TO EXTERIOR
	CABLE TV OUTLET
	ELECTRICAL DISTRIBUTION PANEL
	SMOKE DETECTOR
	THERMOSTAT

NOTES:

- * GRILL IN ALL WINDOWS
- * STAIN GRADE DOORS, TRIM WINDOW SILL, AND WAYNE COAT
- * HOMEOWNER WILL WIRE ALL TELEPHONES, SPEAKERS COMPUTERS

Square Footage	
Living...	1,369
Garage...	490
Entry...	128
Porch...	212
Total...	2,199

Job name: WINGFIELD

Model: CUSTOM Type: FLOOR PLAN

Location: J.D.H. Drawn By: M.A.B.

Checked By: J.D.H. Revision Date: 7/06/2005

Scale: 1/4" = 1'-0" Date: 7/06/2005 Sheet: 2 of 3