


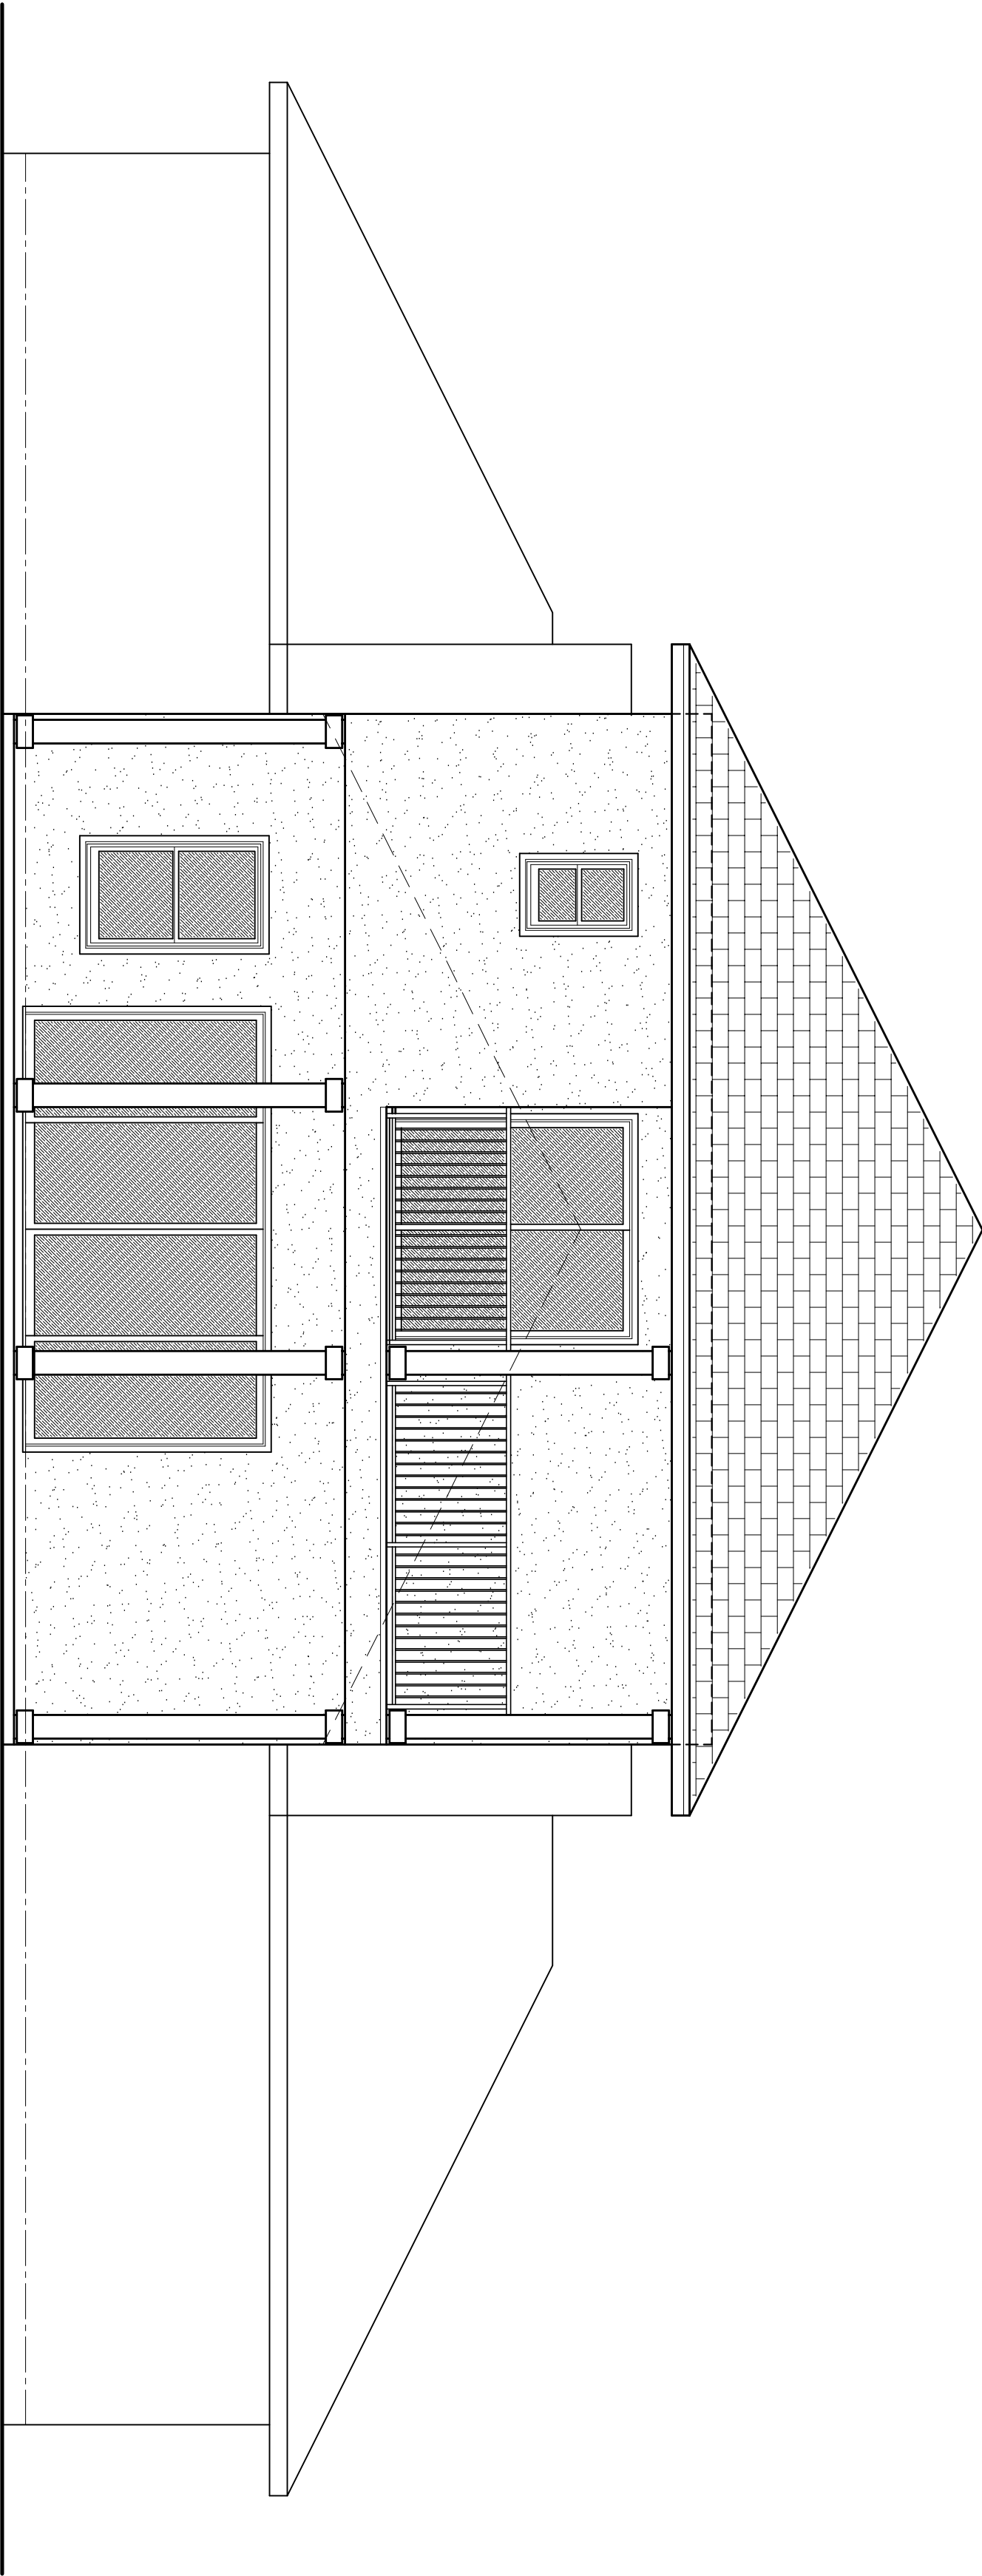

Alterations and Additions to Residence for:

Mr. and Mrs. Janik Patel

Lake City, Florida


Drawing Index

SHT N°.	DRAWING TITLE	ISSUED	LATEST REV'N	SHT N°.	DRAWING TITLE	ISSUED	LATEST REV'N
CS.1	COVER SHEET	01 SEP 2021	09 AUG 2022	A.4	ARCHITECTURAL DETAILS	01 SEP 2021	.
SD.1	DEPO PLAN and HVAC PLAN	01 SEP 2021	21 SEP 2021	A.5	STRUCTURAL INFORMATION	01 SEP 2021	.
A.1	ELEVATIONS	01 SEP 2021	.	A.6	STRUCTURAL PLANS	01 SEP 2021	29 SEP 2021
A.2	FLOOR PLANS	01 SEP 2021	.	A.7	STRUCTURAL DETAILS	01 SEP 2021	.
A.3	WALL SECTIONS	01 SEP 2021	.	A.8	GENERAL NOTES	01 SEP 2021	.



Digitally signed by: N. P. GEISLER
DN: CN = N. P. GEISLER
C = US O = AR0007005
OU = ARCHITECT
Date: 2022.08.09 17:10:
37 -05'00'

N. P.
GEISLER

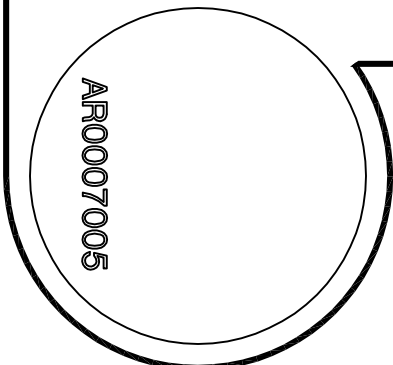

REVISION

Drawn: 2022
N.P. Geisler, Architect
AR0007005

DRAWN:

128

ALTERATIONS & ADDITIONS TO RESIDENCE for:
MR. & MRS. JANAK PATEL
LAKE CITY, FLORIDA
COVER SHEET



DATE:

01 SEP 2021


CONTRACT:

2K2091

SHEET:

CS.1

1 of 1

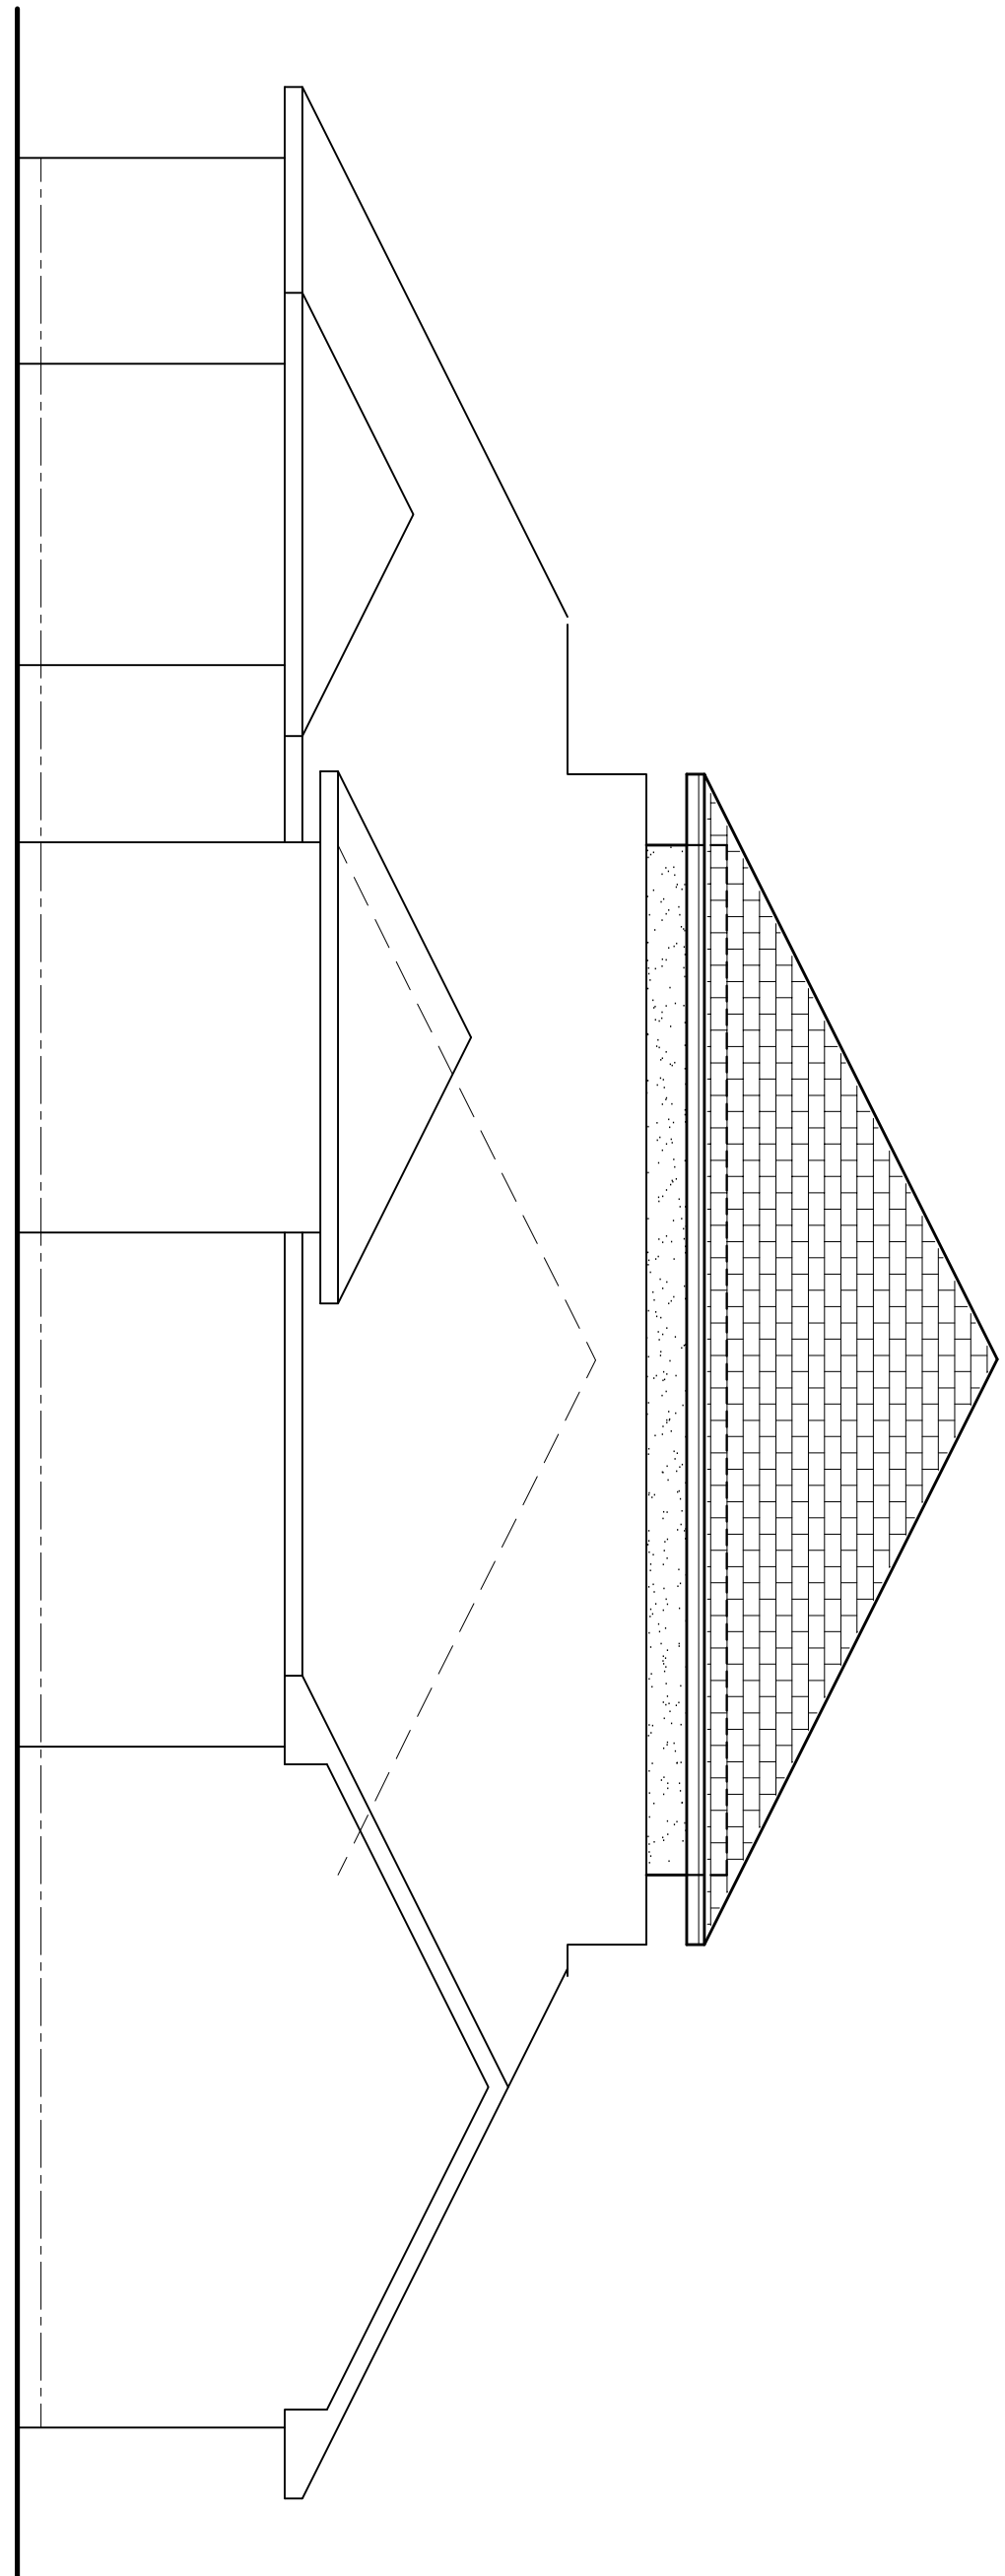

FRONT ELEVATION

WINDOW SCHEDULE			
MARK	DESCRIPTION	MODEL	NOTES
2020	3"X6" E LING ALUMI BASH W/ NEUL GL-485	SHERRS 650	
3060	3"X6" E LING ALUMI BASH W/ NEUL GL-485	SHERRS 650	
2-3060	3"X6" E LING ALUMI BASH W/ NEUL GL-485	SHERRS 650	-
	1" ROOFING VAL-9 - 3 SHERRS FL-482 MAX @ OC		
	1" ROOFING VAL-9 - 3 SHERRS FL-482 MAX @ OC		

ALL UNDOORS ARE QUALITATED AND WEATHERSTRIPPED AS MANUFACTURED BY "H HOME PRODUCTS, INC."
 - OTHER MANUFACTURES/PRODUCTS SHALL BE CONSIDERED AS EQUAL IF THEIR WIND DESIGN PERFORMANCE MEETS OR EXCEEDS THESE UNITS

NOTE!!!
EXTERIOR DOORS SHALL MEET OR EXCEED THE WIND
RESISTANCE OF THE FOLLOWING PRODUCT:

SERIES ENTERGY 6-8 W/ INSUL OPaque RESIDENTIAL
INSULATED STEEL DOOR W/ STEEL FRAME AS MFG'D BY
"PREMDOR ENTRY SYSTEMS"

NOTE !!!
WINDOW ASSEMBLIES SHALL MEET OR EXCEED THE WIND
RESISTANCE OF THE FOLLOWING PRODUCTS:

TM HOME PRODUCTS, INC.'S SERIES 450/650 ALUMINUM WINDOWS, SINGLE HUNG, 1, 2 & 3 MILLED UNITS, PICTURE WINDOWS & SLIDING GLASS DOORS PER ASTM E 283, ASTM E 330 & ASTM E 541

NOTE!!!

ROOF SHINGLES SHALL BE OF THE FOLLOWING
MANUFACTURERS AND MODELS:
TAMKO ROOFING PRODUCTS

HERITAGE 30 AR
HERITAGE 40 AR
HERITAGE 50 AR

GAF MATERIALS CORP

ROYAL SOVEREIGN
MARGULIS
WEATHER MAX
SLATE LINE

GRAND CANYON
GRAND SEQUOIA
COUNTRY MANSION
COUNTRY EAST ALE

TIMBERLINE 30
TIMBERLINE SELECT 40
TIMBERLINE ULTRA

GAF REQUIRED NAILS/SHINGLE = 4

THESE SHINGLES MEET THE REQUIREMENTS OF ASTM D-316 TYPE I MODIFIED TO 120 MPH WINDS & FBC TAS 100, USING THE SPECIFIED NAILS

TEMPERED GLASS NOTES:

THE FOLLOWING SHALL BE CONSIDERED SPECIFIC HAZARDOUS LOCATIONS FOR THE PURPOSES OF GLAZING:

1. GLAZING IN SWINGING DOORS AND FIXED AND SLIDING PANELS OF SLIDING (PATIO) DOOR ASSEMBLIES.

2. GLAZING IN ROOMS AND WALLS OF ENCLOSURES FOR HOT TUBS, JACUZZI POOL, SAUNAS, STEAM ROOMS, BATHINGS ENCLOSURES AND OTHER SUCH FACILITIES, WHERE SUCH GLAZING IS LOCATED 36 INCHES (91.4 MM) OR LESS MEASURED HORIZONTALLY FROM A STANDING OR WALKING SURFACE WITHIN THE ENCLOSURE AND WHERE THE BOTTOM EDGE OF THE EXPOSED GLAZING IS LESS THAN 60 INCHES (1524 MM), MEASURED VERTICALLY ABOVE SUCH STANDING OR WALKING SURFACE.

3. GLAZING IN AN INDIVIDUAL FIXED OR OPERABLE PANEL, ADJACENT TO A DOOR, WHERE THE NEAREST VERTICAL EDGE IS WITHIN A 24-INCH (609 MM) RADIUS OF THE DOOR IN A CLOSED POSITION AND WHOSE BOTTOM EDGE IS LESS THAN 60 INCHES (1524 MM) ABOVE THE FLOOR OR WALKING SURFACE.

EXCEPTION: GLAZING IN WALLS PERPENDICULAR TO THE PLANE OF THE DOOR IN A CLOSED POSITION IN GROUP R3 OR WITHIN DWELLING UNITS IN GROUP R2 SHALL BE SUBJECT TO 2004 FBC 2405.2(14).

4. GLAZING IN AN INDIVIDUAL FIXED OR OPERABLE PANEL, OTHER THAN THOSE LOCATIONS DESCRIBED IN ITEMS 2 AND 3 ABOVE, THAT MEETS ALL OF THE FOLLOWING CONDITIONS:

4.1 EXPOSED AREA OF AN INDIVIDUAL PANE GREATER THAN 9 SQ FT (0.84 M²).


4.2 BOTTOM EDGE LESS THAN 18 INCHES (457 MM) ABOVE THE FLOOR

4.4 ONE OR MORE WALKING SURFACES WITHIN 36 INCHES (914 MM) HORIZONTALLY OF THE PLANE OF THE GLAZING.

EXTERIOR FINISH MATERIALS:

- 1 CONT. RIDGE VENT TO MATCH ROOFING
- 2 FINISH ROOFING AS SELECTED BY OWNER
- 3 MTL FLASHING ON MTL UNRAPIED 2X6 P/T FL
- 4 PORCH BEAM - SEE PLAN FOR SIZE
- 5 SLIDING GLASS DOORS w/ TEMPERED GLASS AS SELECTED BY THE OWNER
- 6 STUCCO - COLOR/TEXTURE AS PER OWNER
- 7 CONCRETE PORCH DECK w/ WOOD FLOAT FINISH & TOOLED EDGES
- 8 1" GLAZING ALUMINUM UNICOLS w/ DBL. GLAZE AS SELECTED BY OWNER
- 9 ALUMINUM PORCH RAILING - SEE DETAIL
- 10 P/T WOOD PORCH ROOFING - PAINTED
- 11 CONCRETE FOUNDATION - FINISH AS DIRECTED BY OWNER

Simulation

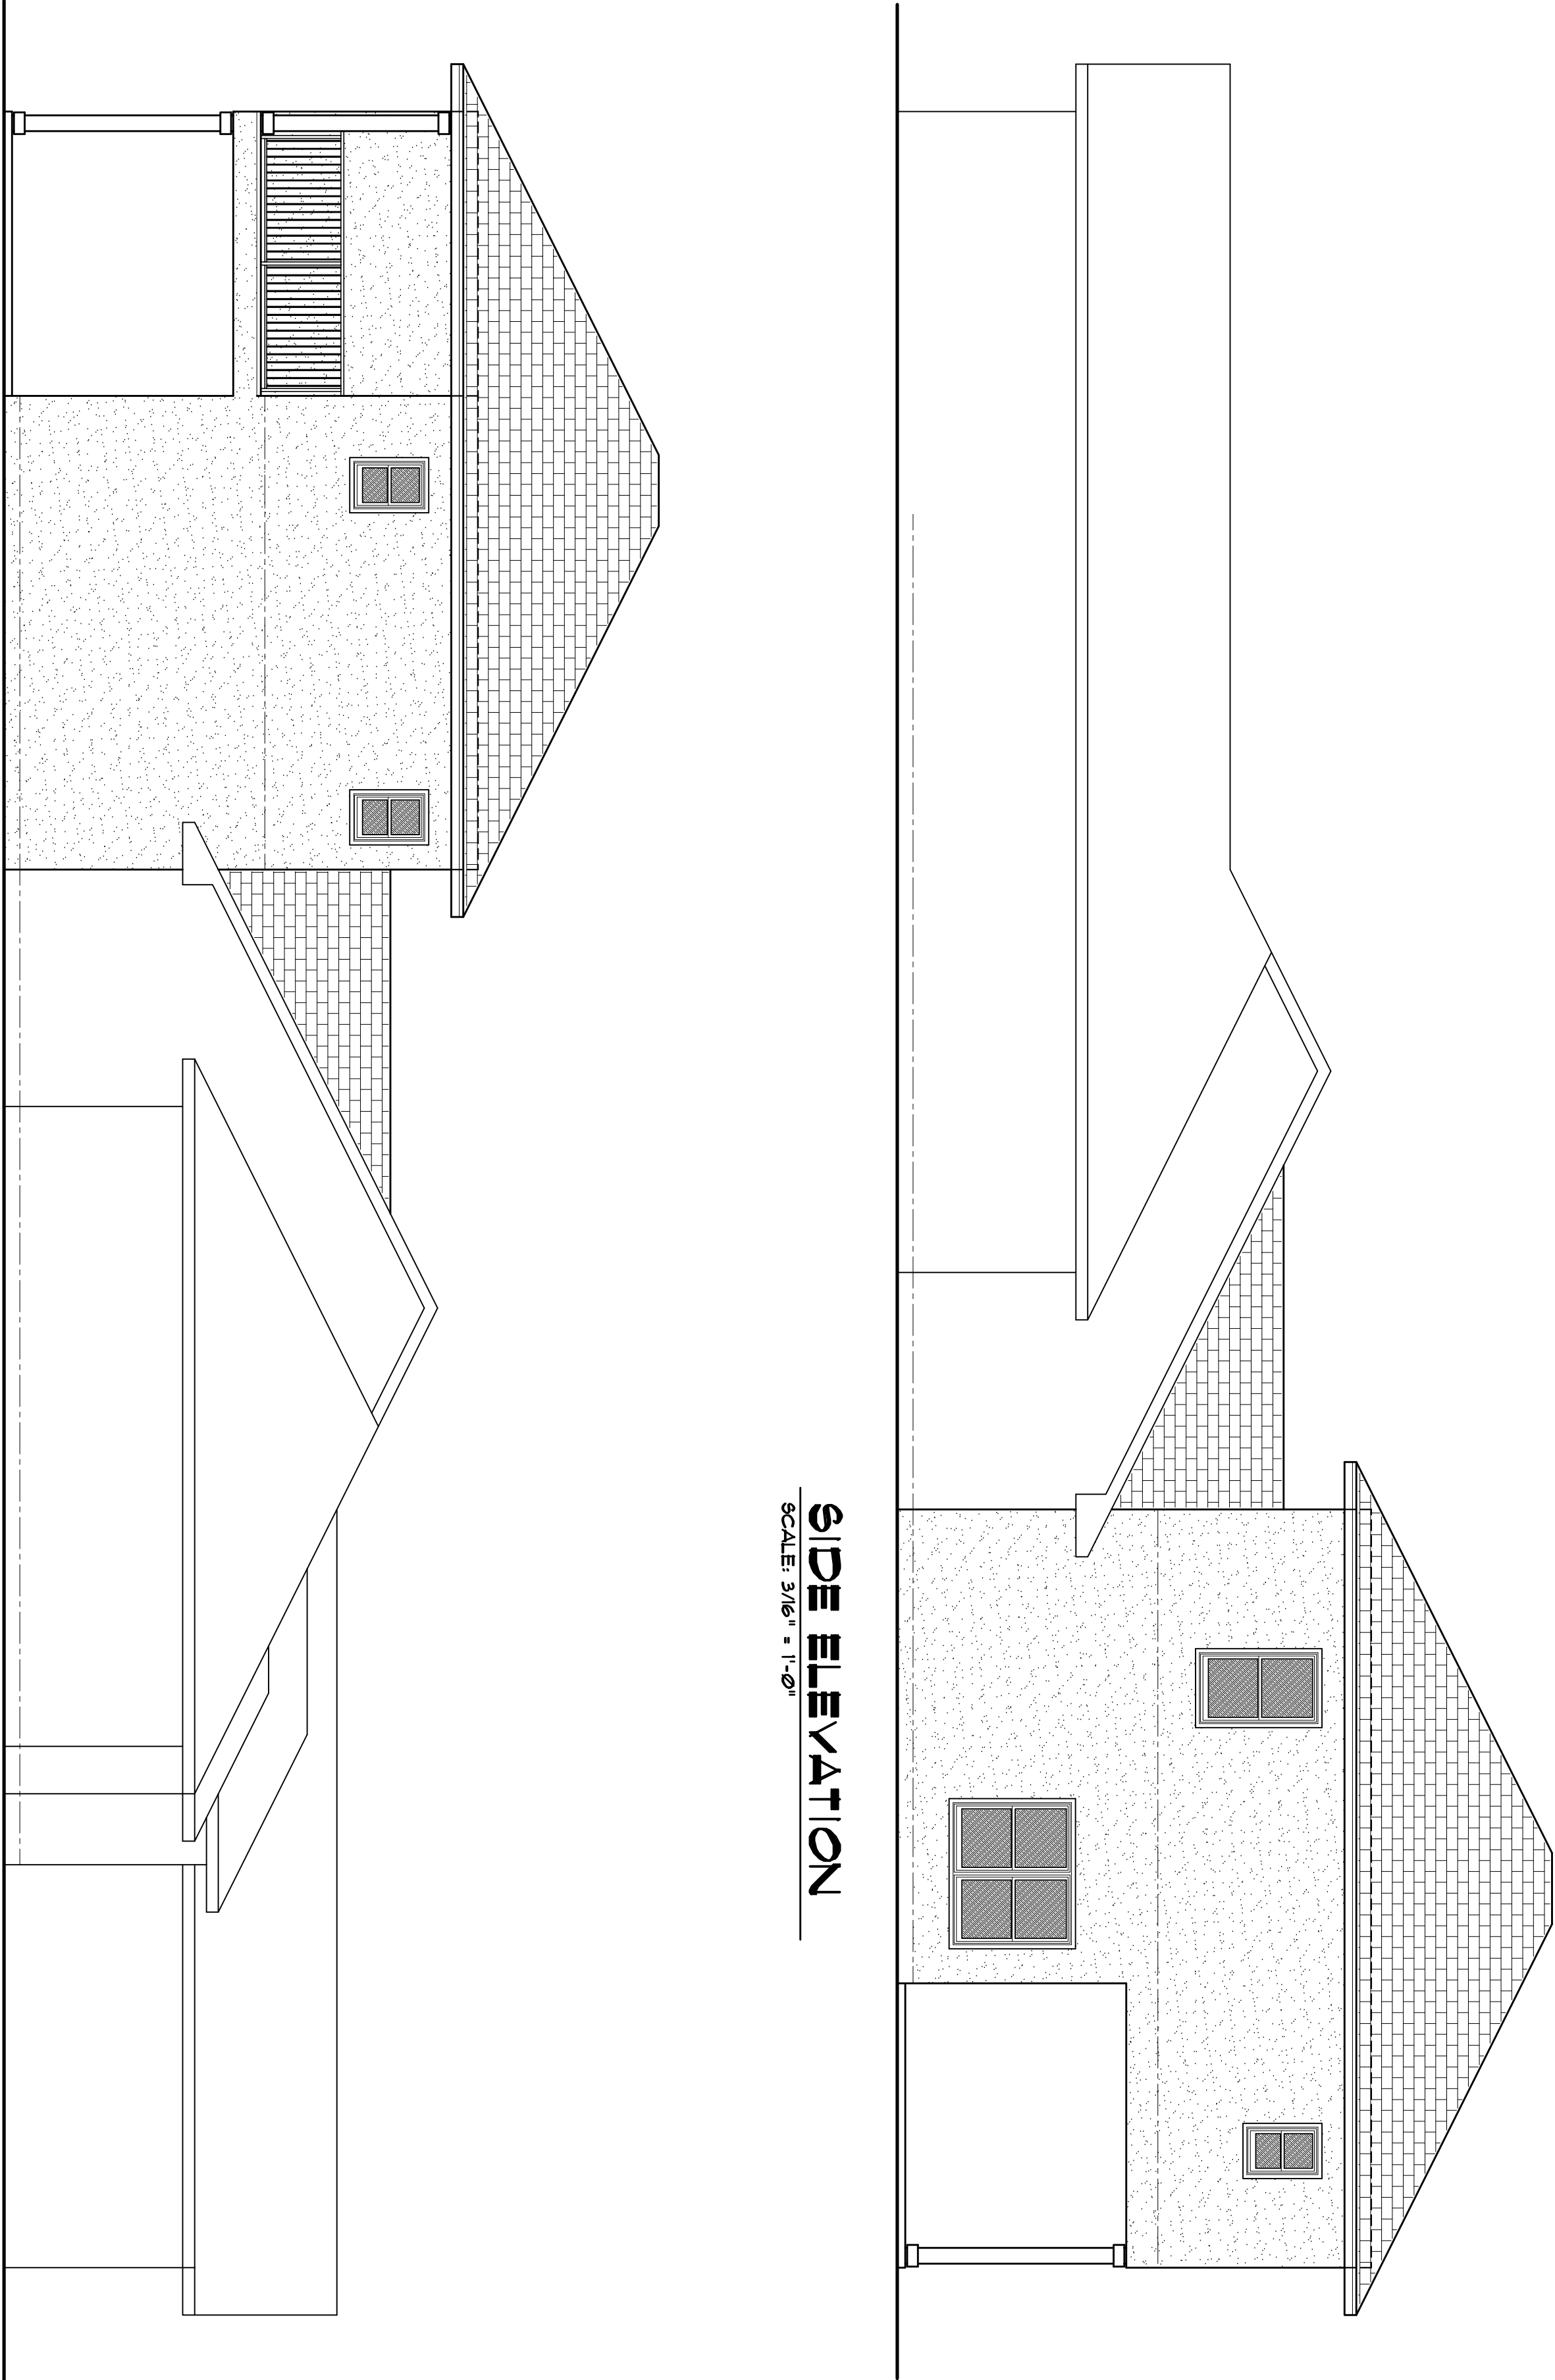

ELECTRICAL PLAN NOTES
INSTALLATION SHALL BE PER 2008 N.A.T.L. ELECTRIC CODE.
WIRE ALL APPLIANCES, HVAC UNITS AND OTHER EQUIPMENT PER MAINE SPECIFICATIONS.
CONSULT THE OWNER FOR THE NUMBER OF SEPARATE TELEPHONE LINES TO BE INSTALLED.
ALL SMOKE DETECTORS SHALL BE 120V W/ BATTERY BACKUP OF THE PHOTOELECTRIC TYPE AND SHALL BE INTERLOCKED TOGETHER. INSTALL INSIDE AND NEAR ALL BEDROOMS.
PROVIDE 4 INSTALL CARBON MONOXIDE DETECTORS IN ALL BEDROOMS, 8 12" ADV FIN FL., INTERLOCKED TOGETHER.
TELEPHONE, TELEVISION AND OTHER LOW VOLTAGE DEVICES OR OUTLETS SHALL BE AS PER THE OWNER'S DIRECTIONS & IN ACCORDANCE W/ APPLICABLE SECTIONS OF NEC-LATEST EDITION.
ALL RECEPTICALS, NOT OTHERWISE DESIGNATED, SHALL BE ARC-FULT INTERRUPTER TYPE, EXCEPT DEDICATED OUTLETS, ALL RECEPTICALS IN KITCHEN AND BATHS SHALL BE GROUND FAULT INTERRUPTER TYPE (GFI).
ALL EXTERIOR RECEPTICALS SHALL BE WEATHER-PROOF GROUND FAULT INTERRUPTER TYPE (WPGFI).

ELECTRICAL CONTR SHALL PREPARE "AS-BUILT" SHOP DRAWG INDICATING ALL ELECTRICAL WORK INCLUDING ANY CHANGES TO THE FOUNDATION, WALLS, CEILING, FLOOR, RISERS, AND THE BUILDING SHALL BE MAINTAINED AS SHOWN. ALL IDENTIFIED W/ COT N. DESCRIPTION & BRKR SERVICE ENT. & ALL UNDERGROUND WIRE LOCATION/ROUTING/DEPTH, RISER DIA SHALL INCLUDE WIRE SIZE/TYPE & EQUIPMENT TYPE W/ RATINGS & LOADS.
CONTRACTOR SHALL PROVIDE 1 COPY OF AS-BUILT DWGS TO OWNER & 1 COPY TO THE PERMIT ISSUING AUTHORITY.

CONSTRUCTION NOTES


1. FIELD VERIFY ALL DIMENSIONS AND MATERIALS. ALL OUTSIDE DIMENSIONS ARE TO FACE OF FOUNDATION.
2. ALL NAILING CONSTRUCTION MATERIALS SHALL BE AS PER 2020 PEC.
3. N/A
4. N/A
5. CONTRACTOR SHALL CALL ATTENTION TO THE DESIGNER ANY DISCREPANCIES IN DRAWINGS AND/OR SPECIFICATIONS AND SHALL RECEIVE INSTRUCTIONS OR CLARIFICATIONS BEFORE PROCEEDING WITH THE PORTION OF THE WORK IN QUESTION.
6. ROOF & FLOOR TRUSS FRAMING PLANS ARE FOR GENERAL INFORMATION ONLY. THE TRUSS MANUFACTURER SHALL PROVIDE A DETAILED LAYOUT FOR TRUSSES AND FRAMING MEMBERS.
1. SHOULD CONDITIONS AT THE SITE BE FOUND MATERIALLY DIFFERENT FROM THOSE INDICATED BY THE DRAWINGS AND/OR SPECIFICATIONS, AND THE CONDITIONS USUALLY INHERENT IN THE WORK OF THE CHARACTER SHOWN AND SPECIFIED BE DIFFERENT FROM THE DESIGNER'S INTENT, THE CONTRACTOR SHALL BE RESPONSIBLE FOR BRINGING ATTENTION TO SUCH CONDITIONS BEFORE PROCEEDING.
8. N/A
9. DO NOT SCALE DRAWINGS. USE PRINTED DIMENSIONS ONLY.

GENERAL INTERIOR FINISH SCHEDULE:

FLOOR AREA	CARPET AND PAD PATTERN & COLOR AS PER THE OWNER OR LAMINATE STRIP WOOD - SEE OWNER FOR CHANGES
BEDROOM FLOOR	THINSET CERAMIC TILE OR NATURAL STONE, PAT. & COLOR AS SELECTED BY THE OWNER
BASE:	TRIM AS PER DETAIL. ON A3 COLOR AS SELECTED BY THE OWNER OR CERAMIC TILE OR STONE - MATCH WITH FLOORING
TRIM:	COVERS CROWN, CABINGS, CHAIRS,LS AND THE LIKE. AS PER DETAIL. ON A3, STAIN & VARNISH OR PAINT COLOR AS SELECTED BY THE OWNER
WALLS:	1/2" GIBB, PRIMEED AND PAINTED 2 COATS LATEX WALL PAINT, COLOR & GLOSS AS SELECTED BY THE OWNER
MAIN CEILING:	5/8" GIBB DIRECT HANG, TAPED & FINISHED W/ 2 COATS OF LATEX CEILING PAINT, COLOR & GLOSS AS SELECTED BY THE OWNER
APPLIED FINISHES:	APPLIED FINISHED TO GIBB, 16 GREY, ROCK-DOON SKI-TROUEL AND SIMILAR TREATMENTS AS DIRECTED BY THE OWNER
CABINETS:	AS SELECTED BY THE OWNER. MINIMUM 40" GRADE: "CUSTOM" - ALL COUNTERTOPS SHALL BE AS SELECTED BY THE OWNER

2nd FLOOR PLAN

SCALE: 1/4" = 1'-0"

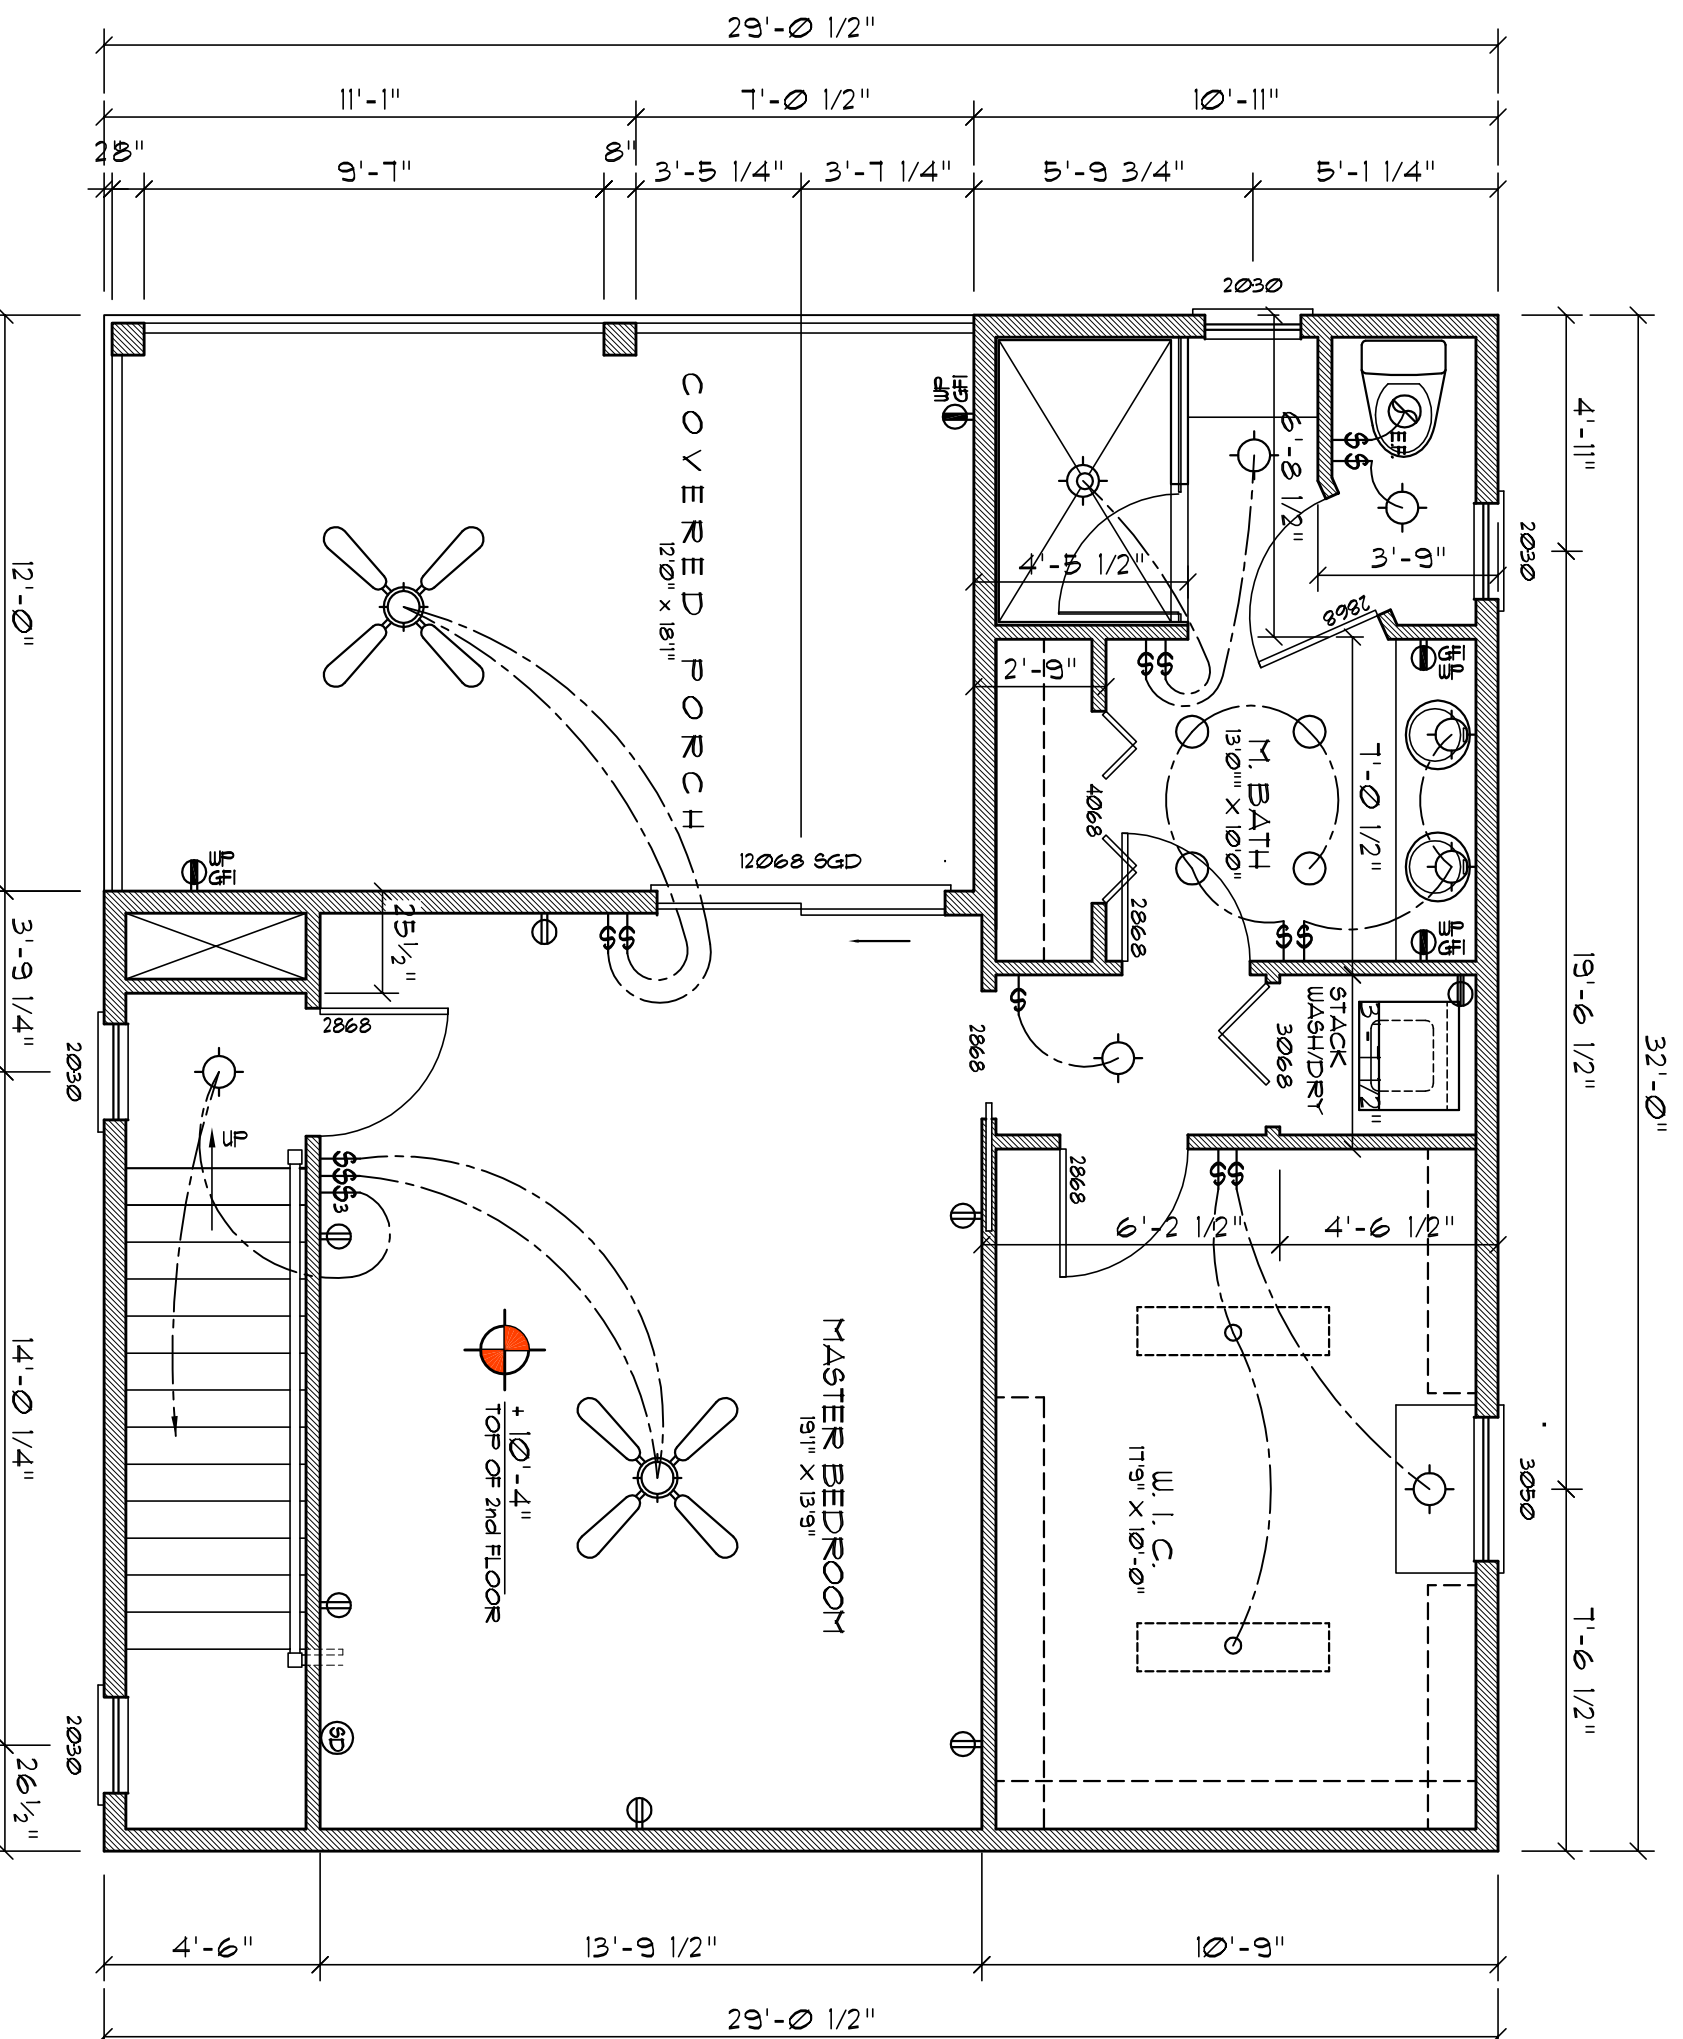


AREA CALCULATION

GROSS 1st FLOOR AREA:	5800 SF
GROSS 2nd FLOOR AREA:	1100 SF
COVERED PORCH AREA:	3480 SF
OPEN DECK AREA:	2180 SF
TOTAL AREA:	18560 SF
GROSS CONDITIONED VOLUME:	116098 CF

1st FLOOR PLAN


SCALE: 1/4" = 1'-0"

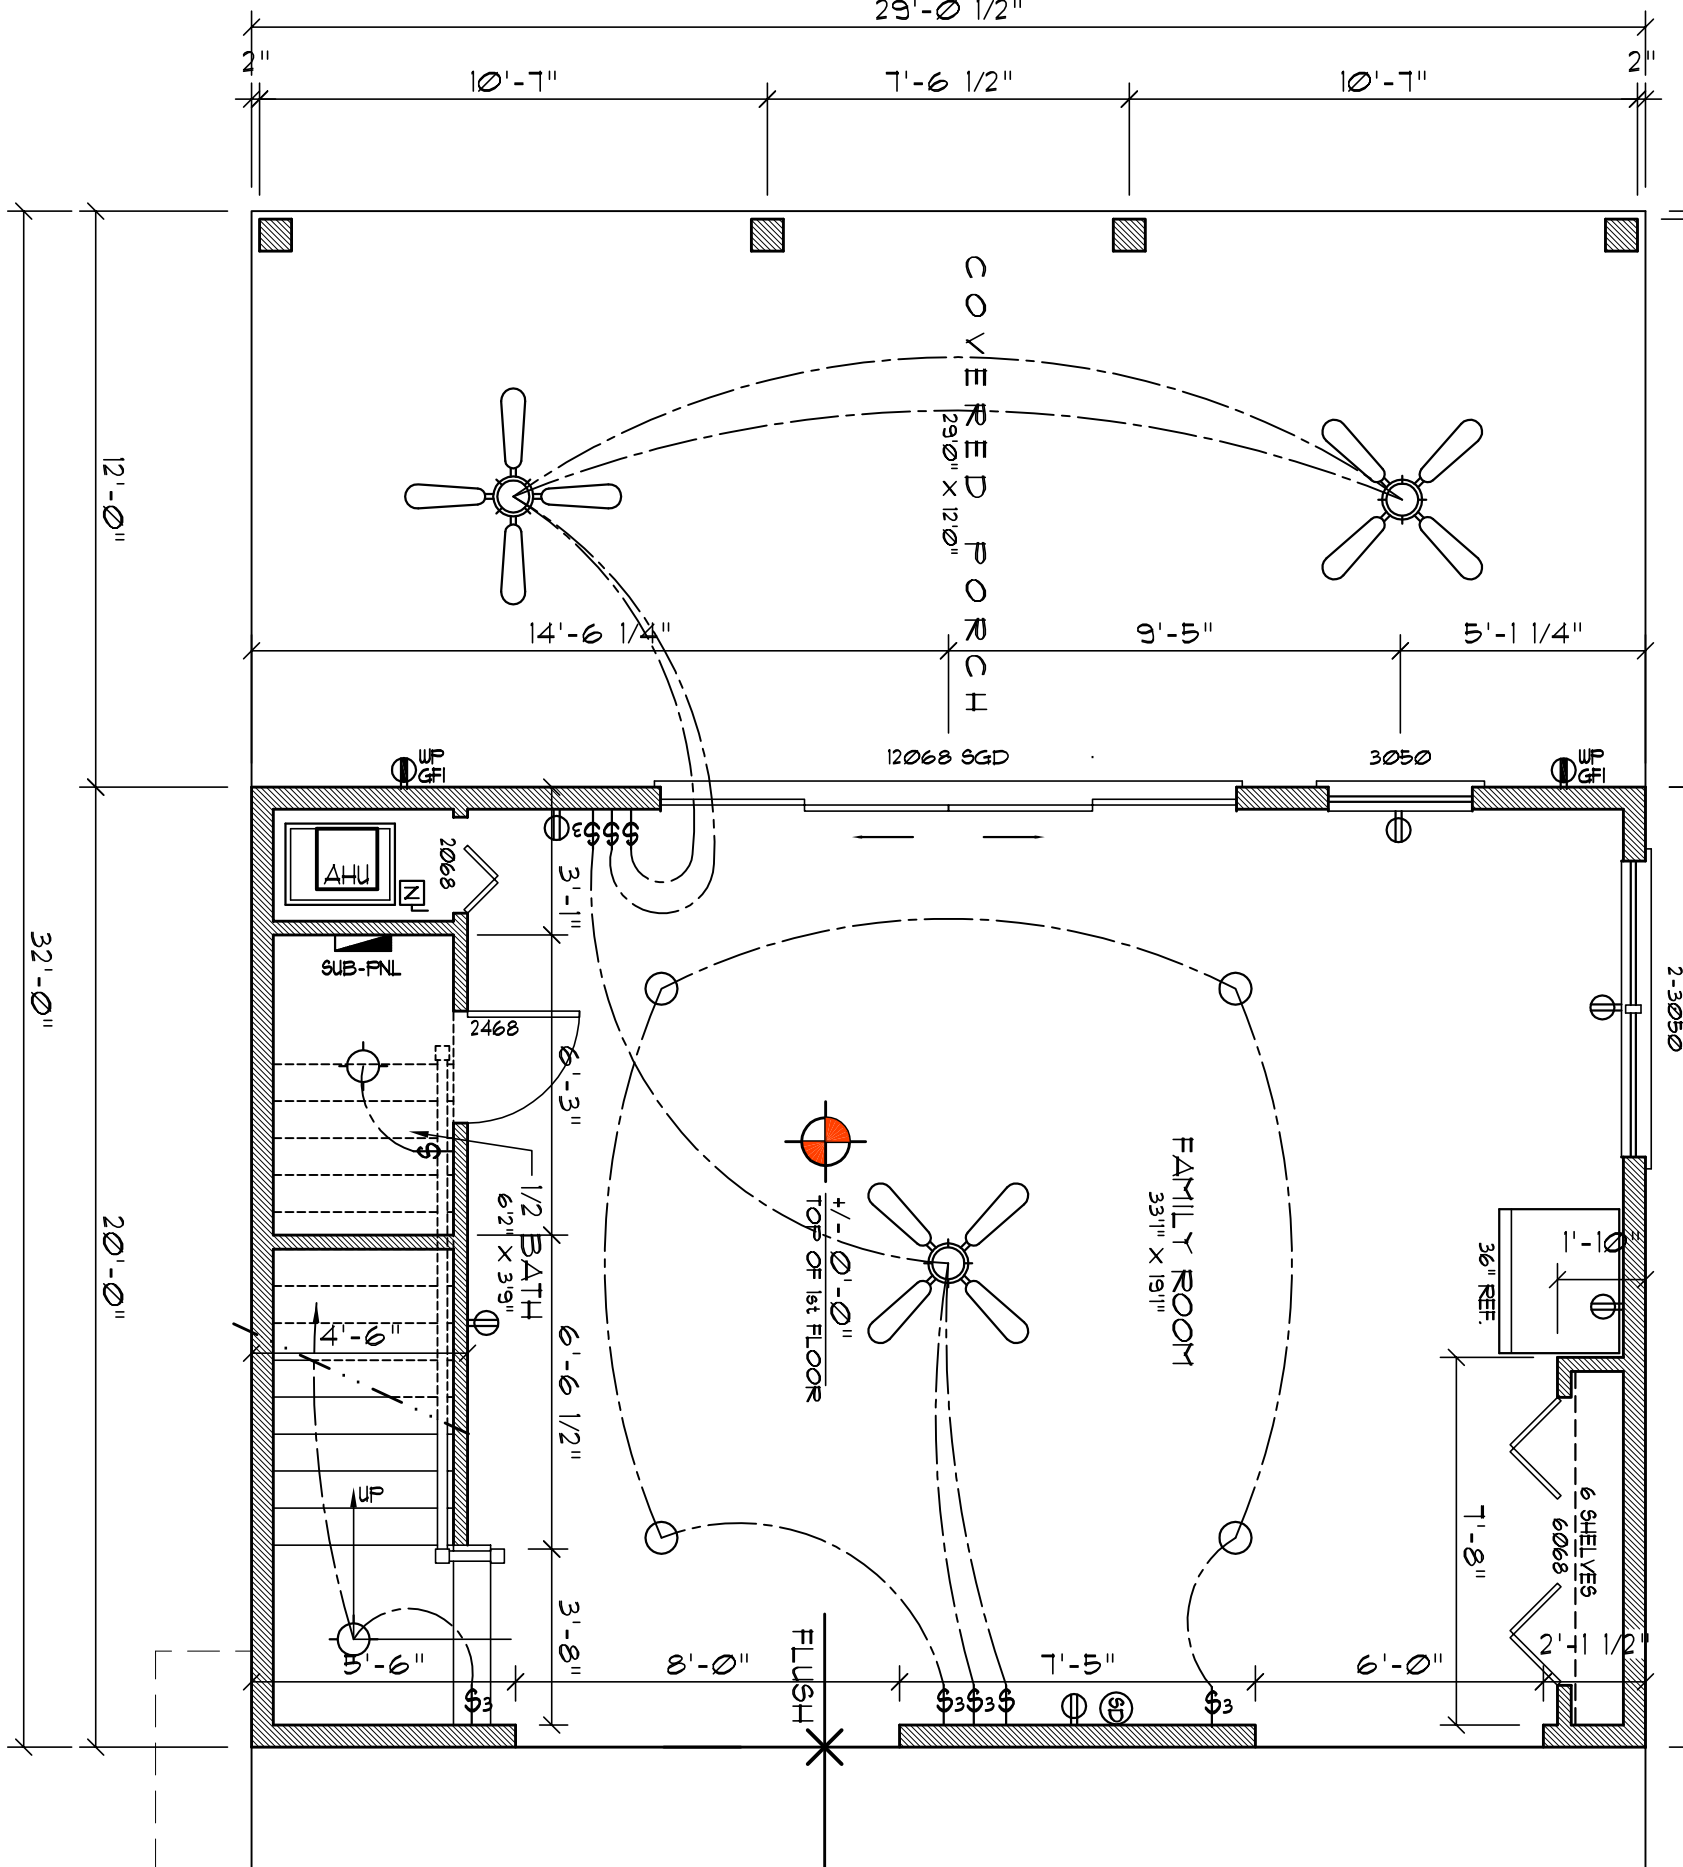


NOTE: PROVIDE NEW SUB-PNL. POWERED VIA SPARE CIRCUITS IN EXISTING HOUSE PANEL OR VIA NEW 80A LUG TIE-IN. REFER TO AS-BUILT RECORDS FOR ELECTRICAL WORK.


NOTE: CABINETS, COUNTERTOPS, SINKS, AND THE LIKE SHOWN ON THIS PLAN SHALL BE CONSTRUCTED IN ACCORDANCE WITH THE STANDARDS OF QUALITY AS OUTLINED IN THE NOTES TITLED "GENERAL MILLWORK NOTES". AND SHALL INCLUDE SUCH FEATURES, HARDWARE AND FINISHES AS DIRECTED BY THE OWNER. THE PLAN VIEWS INDICATED ARE FOR GENERAL LOCATION AND EXTENT OF THE WORK - UNLESS DETAILED CABINET PLANS ARE INCLUDED WITH THIS PLAN PACKAGE ALL OTHER PHYSICAL CHARACTERISTICS SHALL BE AS DIRECTED BY THE OWNER.

NOTE: PROVIDE 2X6 BACKING AT ALL OVERHEAD CABINET LOCATIONS, FLUSH WITH FACE OF FRAMING - TOP OF BACKING TO BE 1'-0" AFF.

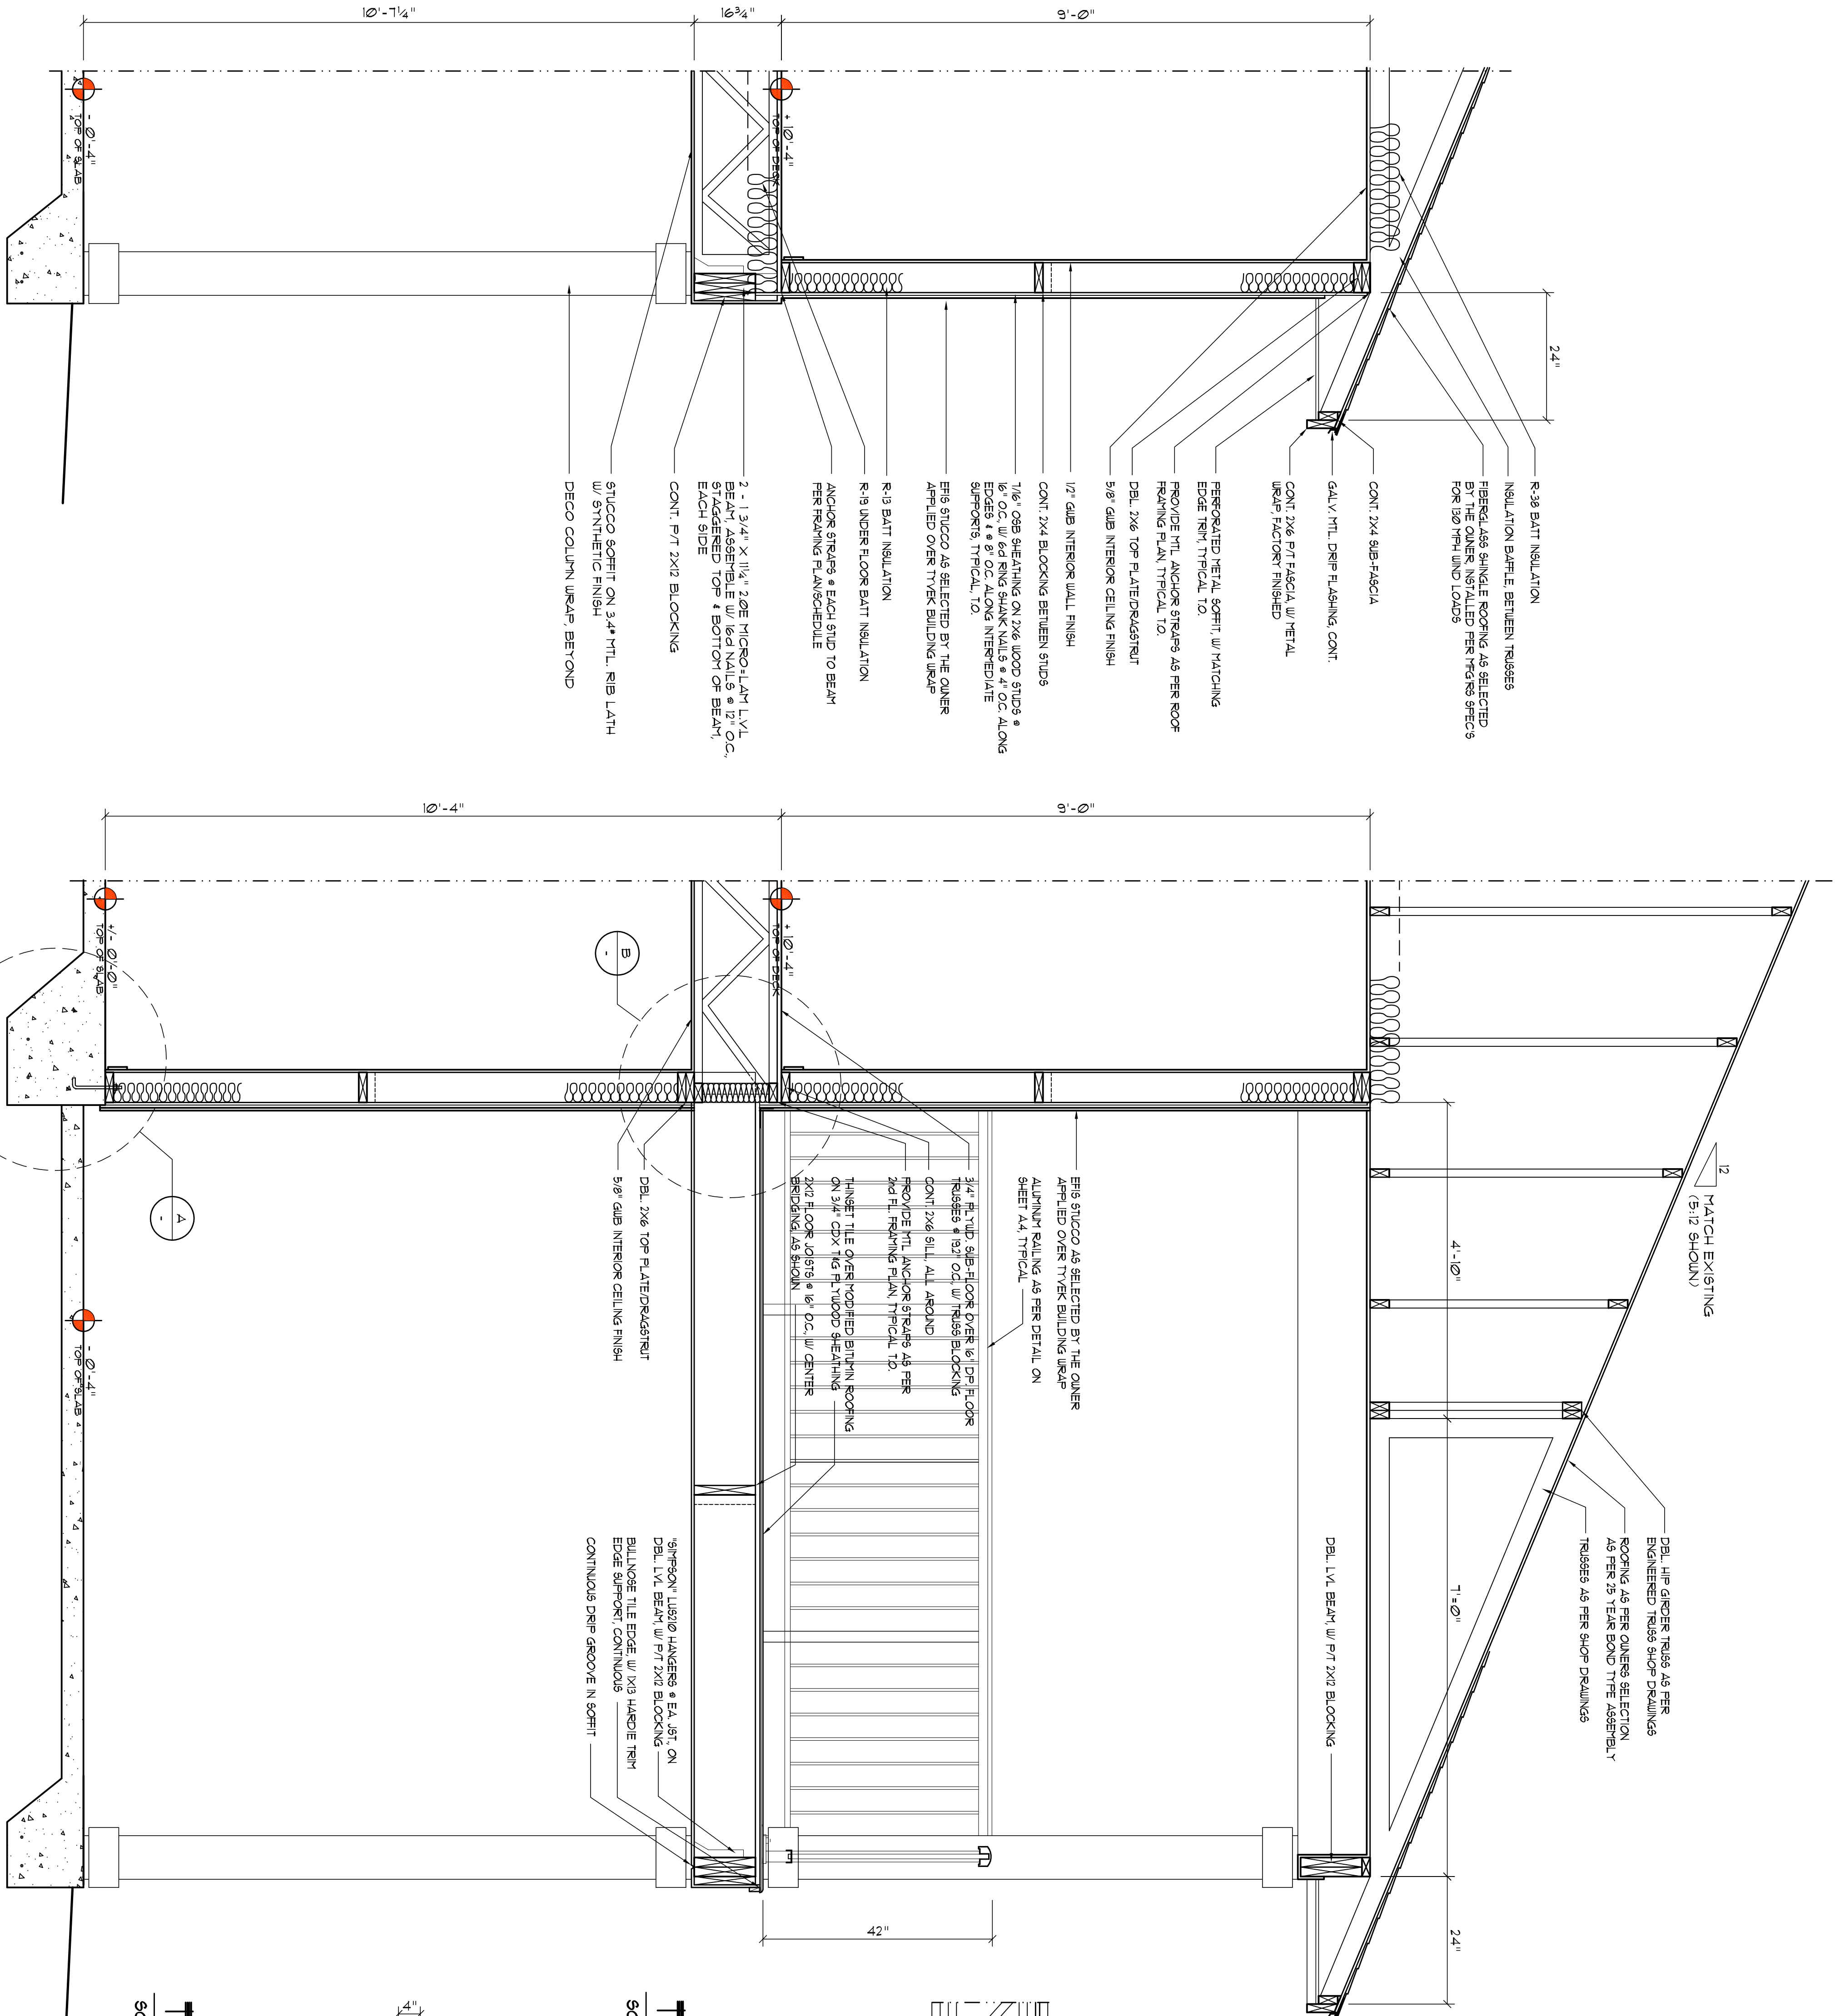


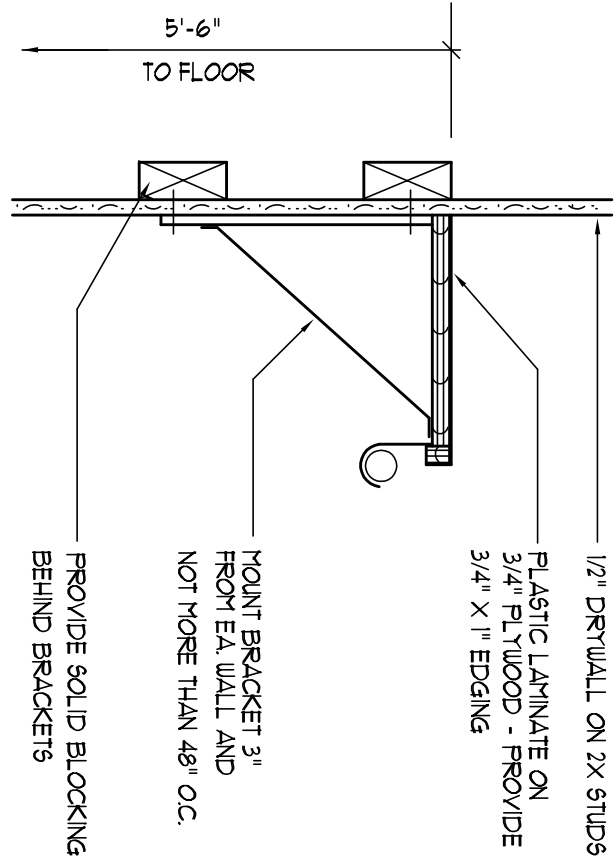


Closest Rod & Shelf Detail
SCALE: NONE

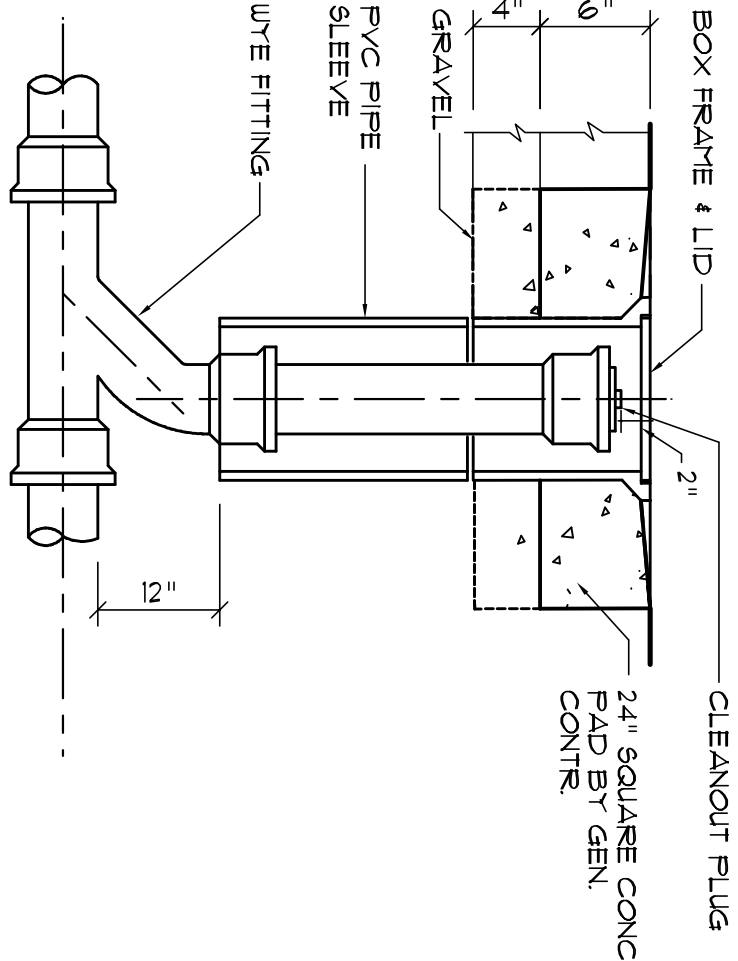

Outdoor Cleanout Detail
N.T.S.

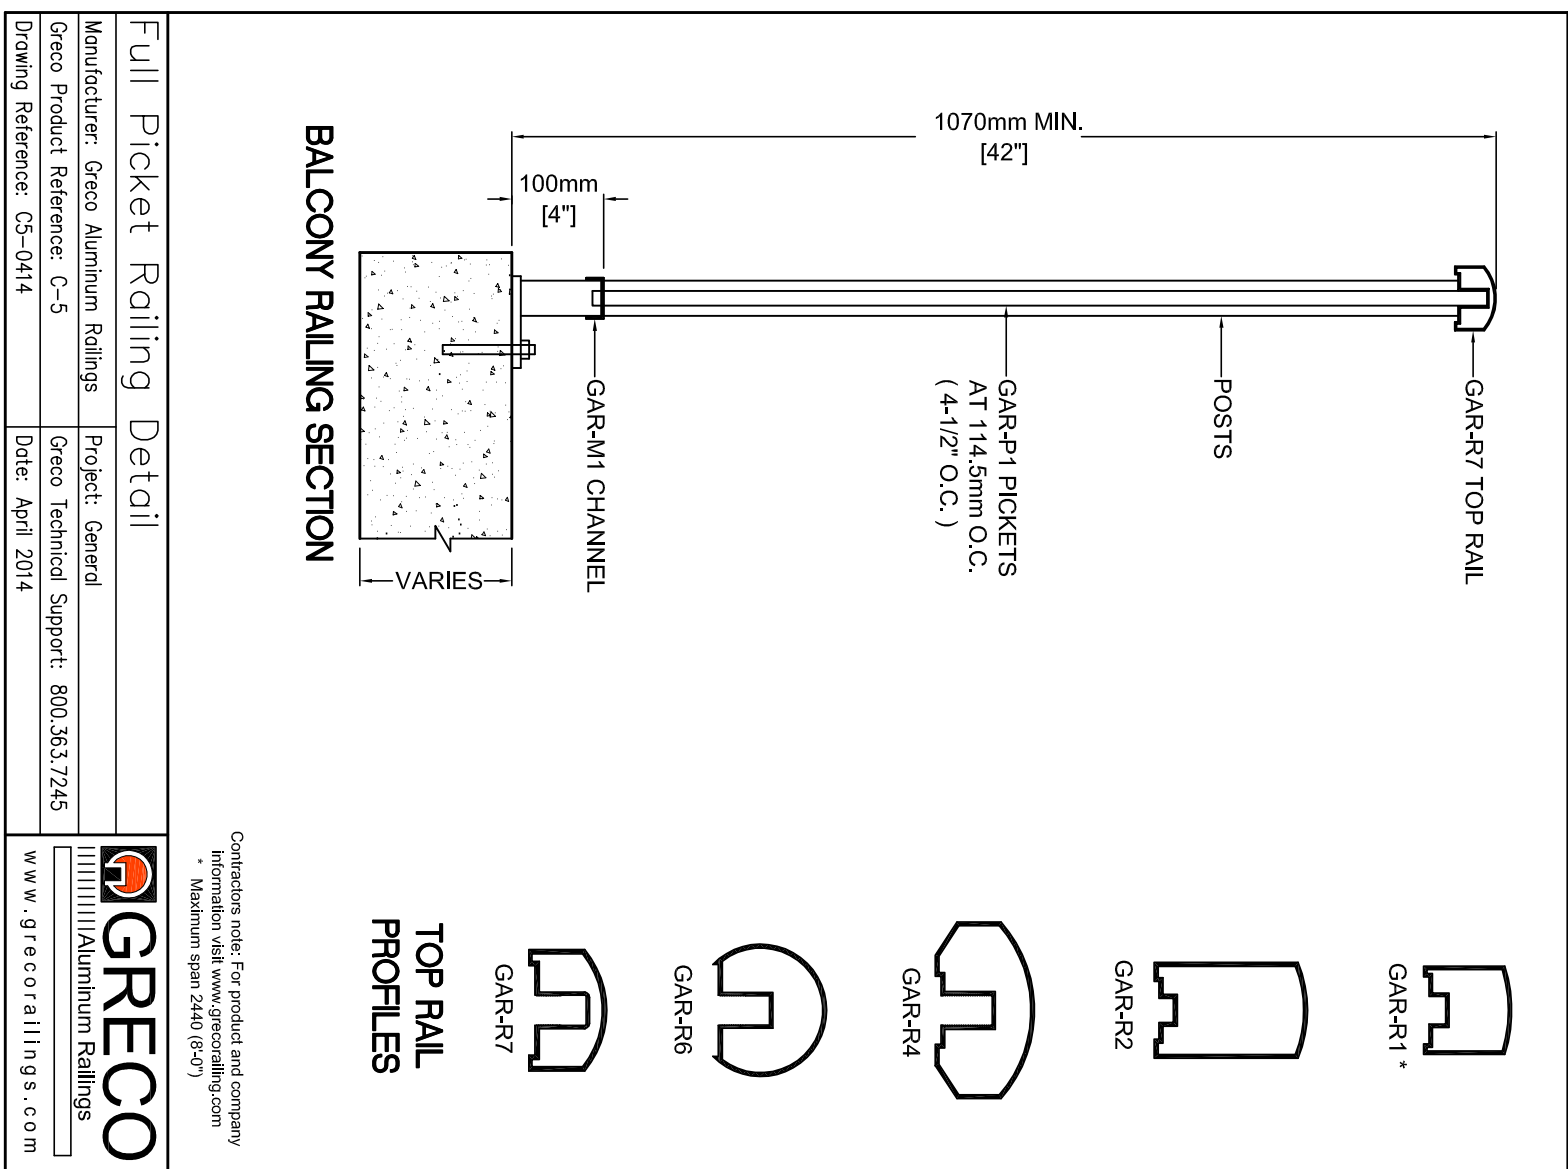


BALCONY RAILING
SCALE: 1/4" = 1'-0"
NOTE: ENGINEERED SHOP DRAWINGS REQUIRED

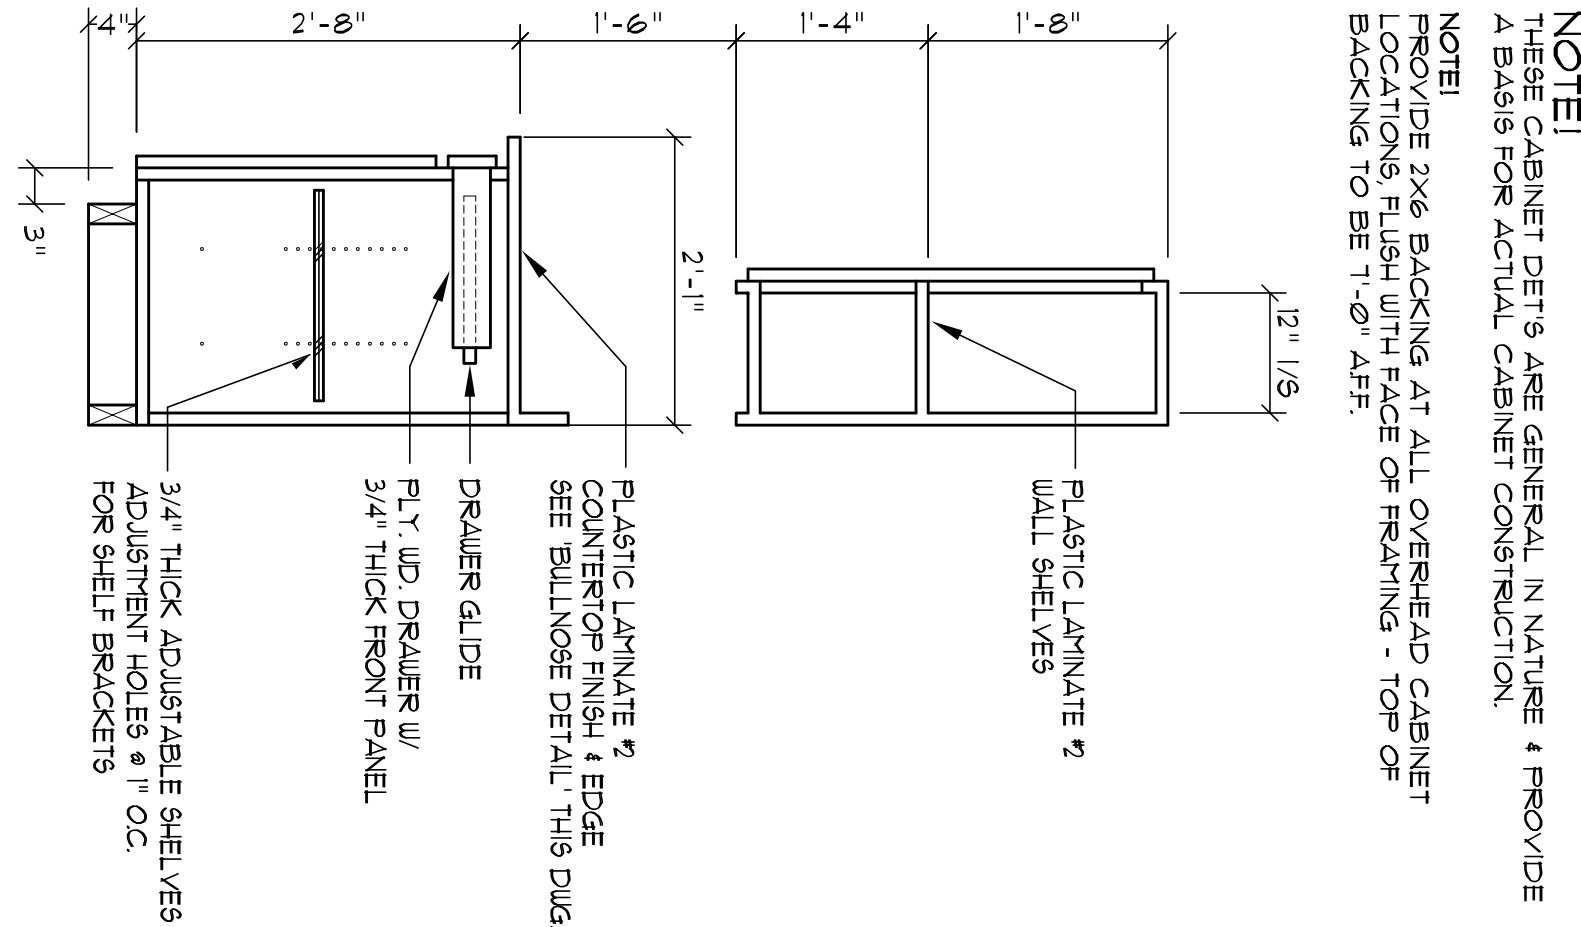


Base & O/H Cab.
SCALE 3/4" = 1'-0"

NOTE: CABINET'S COUNTERS, SHELVES AND THE LIKE SHOWN ON THIS PLAN SHALL BE CONSTRUCTED IN ACCORDANCE WITH THE STANDARDS OF QUALITY AS OUTLINED IN THE NOTES TITLED "GENERAL MILLWORK NOTES", AND SHALL INCLUDE THE FOLLOWING: ALL MILLWORK SHALL BE FINISHED BY THE OTHER TRADES INDICATED AS POSITIVE BY LOCATION AND EXTENT OF THE WORK - UNLESS DETAILED CABINET PLANS ARE INCLUDED WITH THIS PLANS PACKAGE ALL OTHER PHYSICAL CHARACTERISTICS SHALL BE AS DIRECTED BY THE OWNER.

Typ. Cabinet Dets
SCALE 3/4" = 1'-0"

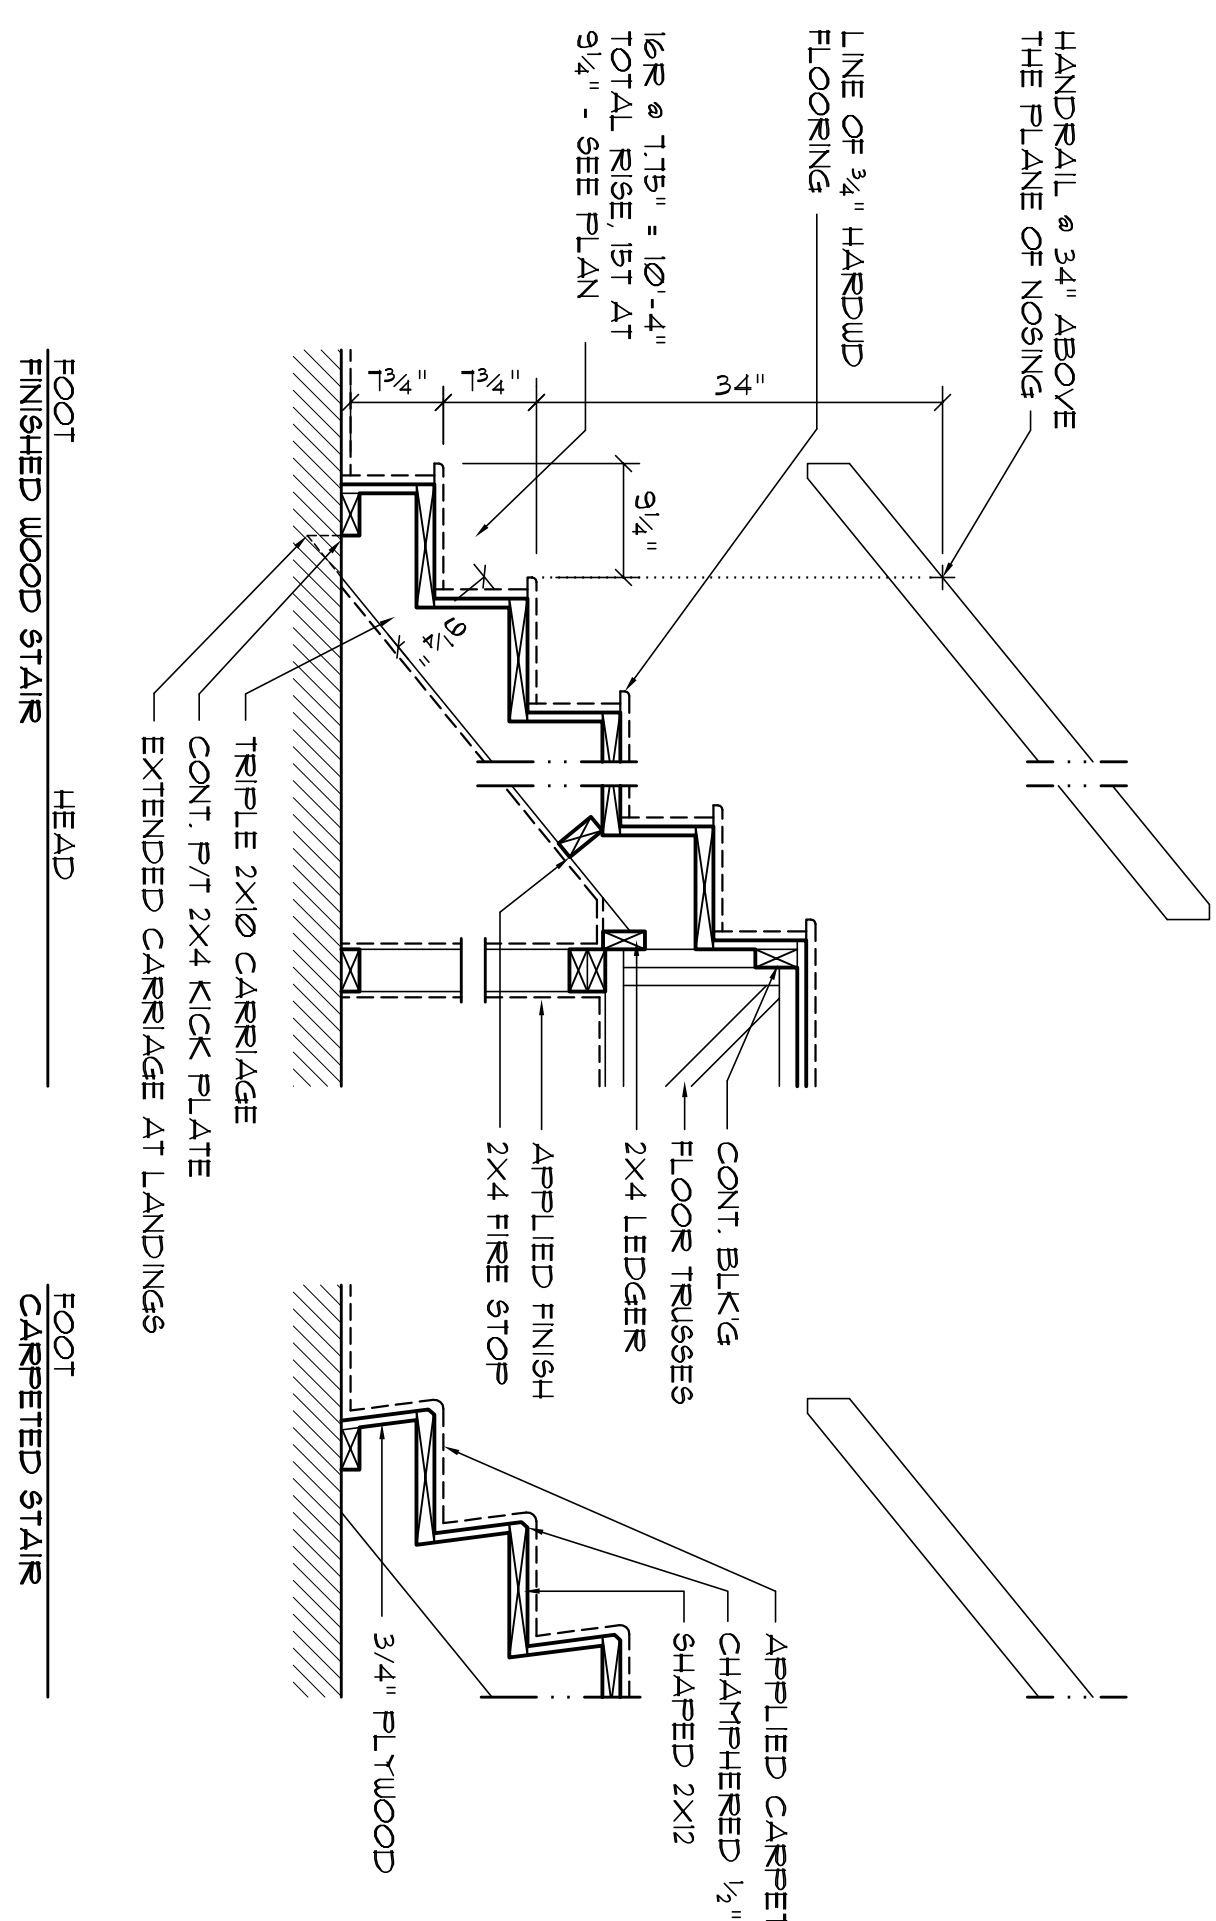


Typical Stair Detail
SCALE: 3/4" = 1'-0"

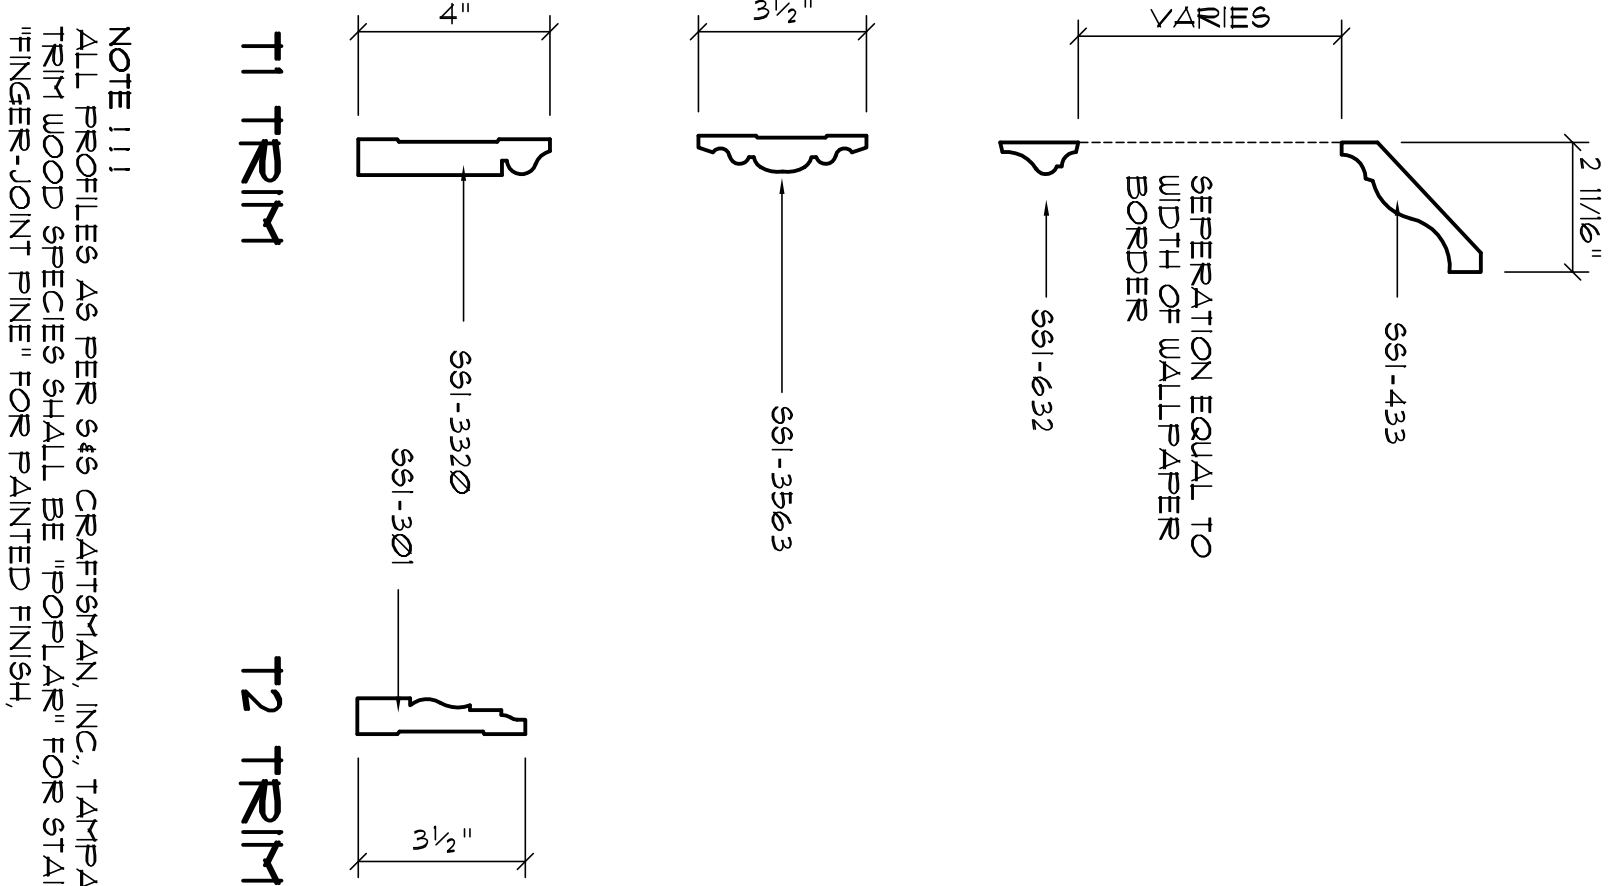


Wall/Ceiling Trim Detail
SCALE: 3" = 1'-0"


NOTE: ALL PROFILES AS PER 646 CRAFTSMAN INC., TAMP A, FLORIDA TRIM WOOD SPECIES SHALL BE "POP LAM" FOR STAIN FINISH, OR "FINGER-JOINT FINE" FOR PAINTED FINISH.

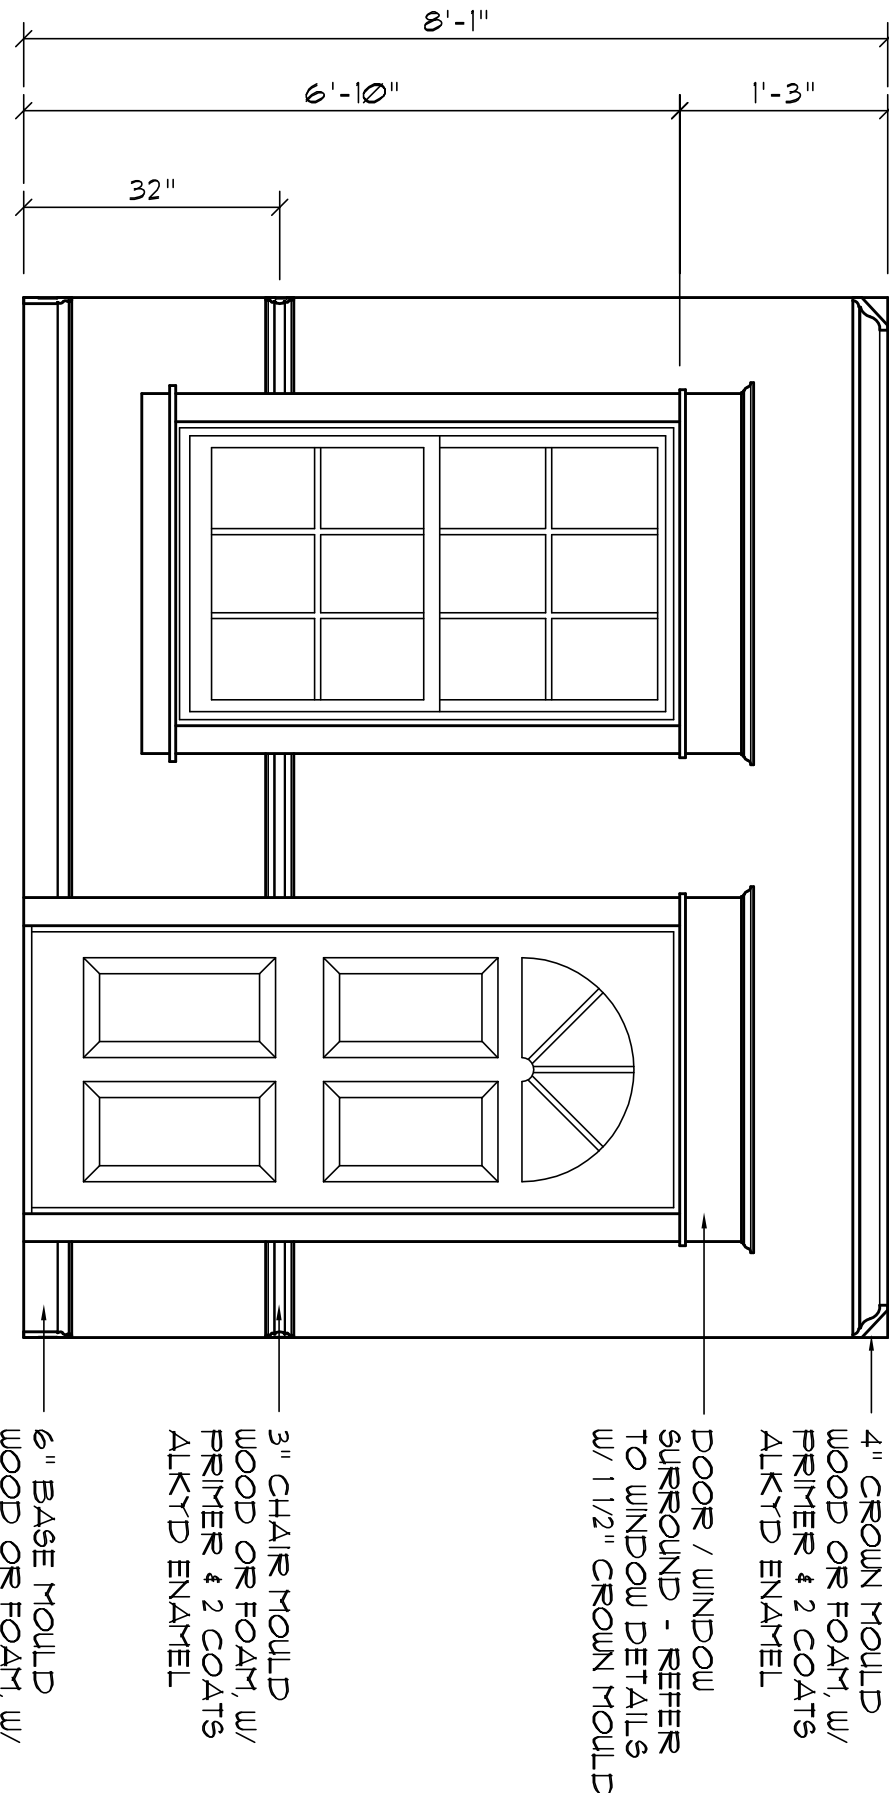


Int. Wall Trim Detail
SCALE: 1/2" = 1'-0"

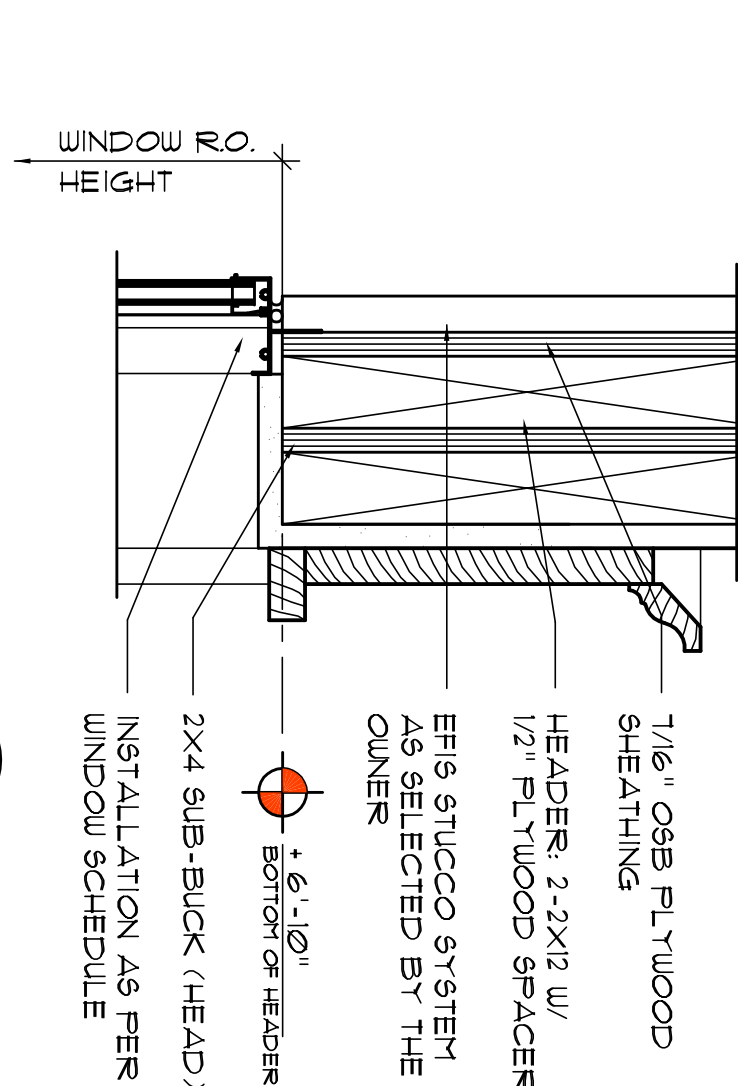

**HEAD DETAIL
MTL. SASH**
1

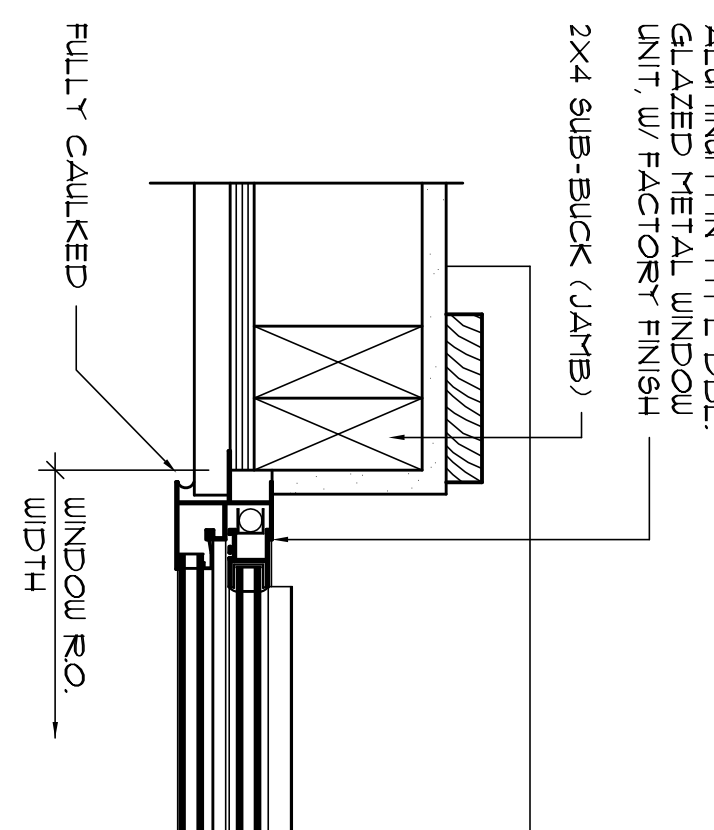


**JAMB DETAILS
MTL. SASH**
2

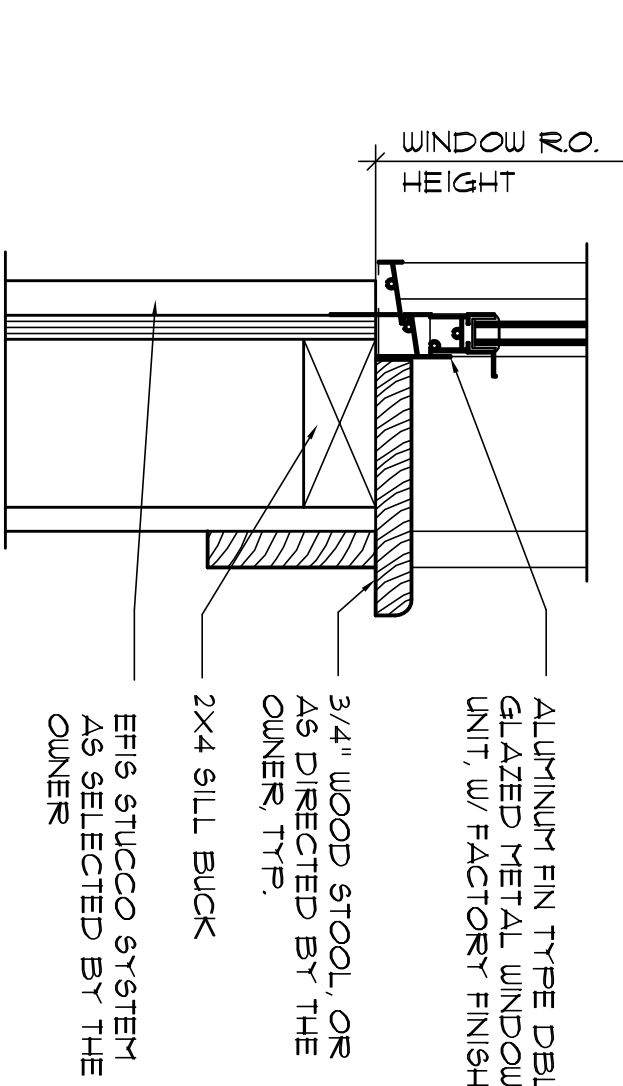


**SILL DETAIL
MTL. SASH**
3


Typical Window Dets
SCALE: 3" = 1'-0"

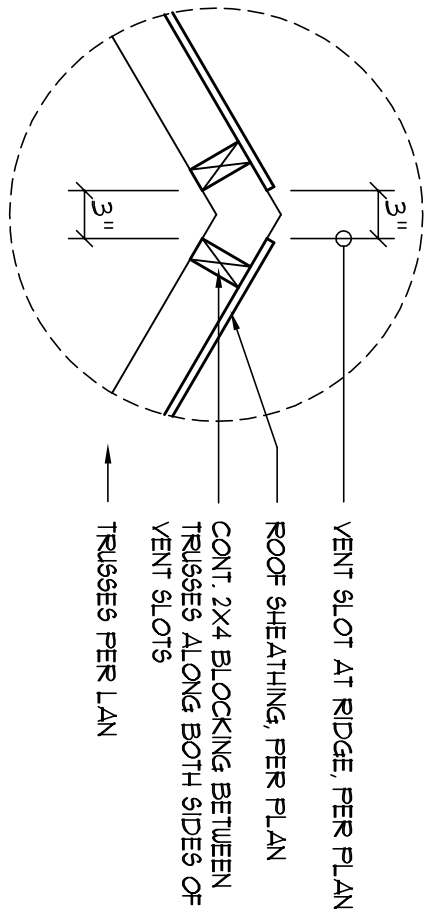

Vent Detail
SCALE: 1" = 1'-0"


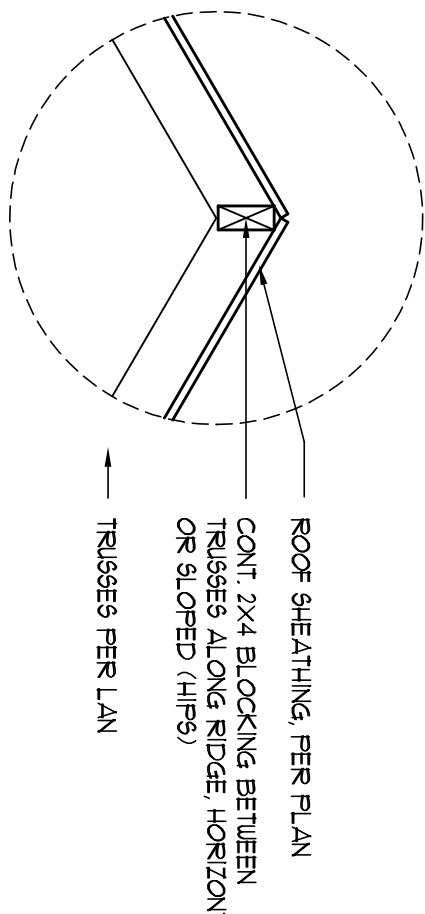


Ridge Detail
SCALE: 1" = 1'-0"

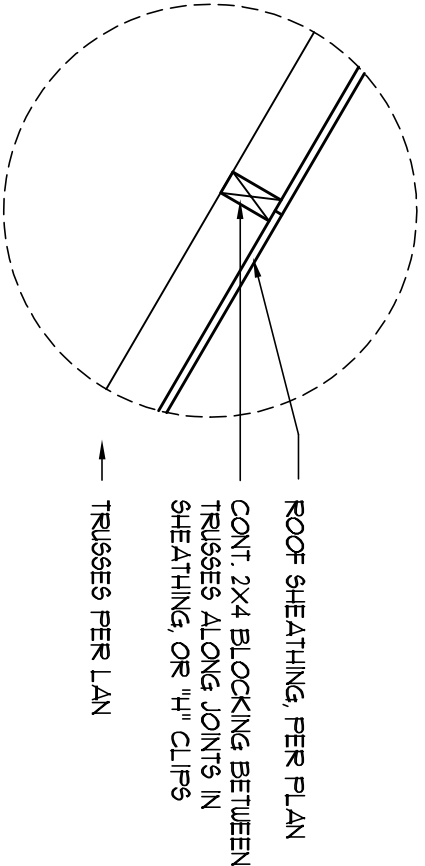


Joint Detail
SCALE: 1" = 1'-0"

ROOF SHEATHING FASTENINGS			
NAILING ZONE	SHEATHING TYPE	FASTENER	SPACING
1			6" o.c. EDGE
2	1 1/8" OASB OR 5/8" CDX	6d COMMON OR 6d HOT DIPPED GALVANIZED BOX NAILS	2" o.c. FIELD
3			6" o.c. FIELD

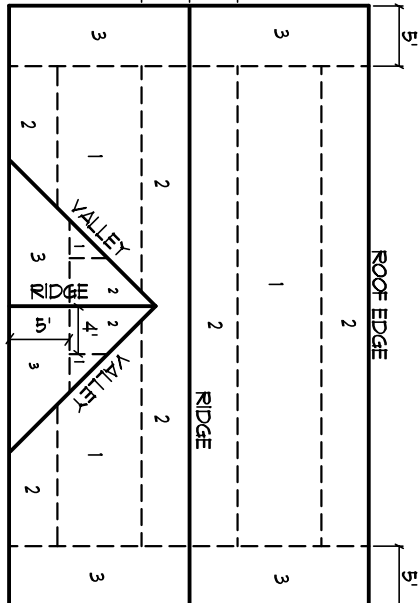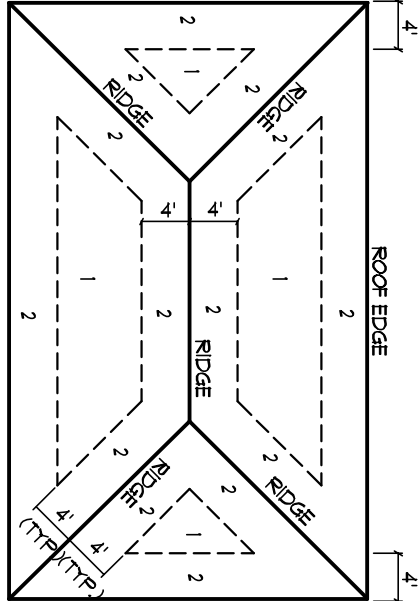


Roof Nail Pattern Det.
SCALE: NONE

HEADER SPANS FOR EXTERIOR BEARING WALLS				
HEADERS SUPPORTING:	HEADER SIZE	BUILDING WIDTH (FT)		
		20'	28'	36'
ROOF, CEILING	2-2x4	3'-6"	3'-2"	2'-10"
	2-2x6	5'-5"	4'-8"	4'-2"
	2-2x8	6'-10"	5'-11"	5'-4"
	2-2x10	8'-5"	7'-3"	6'-6"
	2-2x12	9'-9"	8'-5"	7'-6"
	3-2x8	8'-4"	7'-5"	6'-8"
	3-2x10	10'-6"	9'-11"	8'-2"
	3-2x12	12'-2"	10'-11"	9'-5"
	4-2x8	9'-2"	8'-4"	9'-2"
	4-2x10	11'-8"	10'-6"	9'-5"
		14'-1"	12'-2"	10'-11"




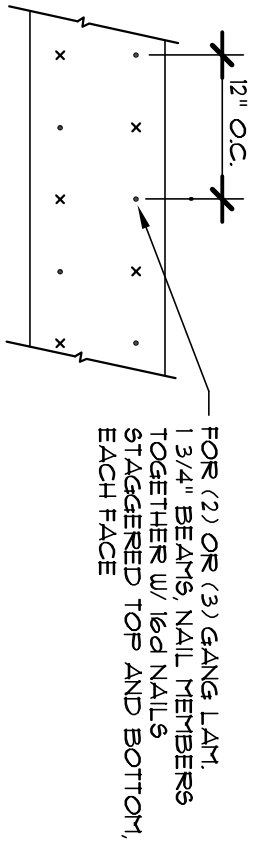


MULTIPLE GANG LAM. DETAIL
NOT TO SCALE

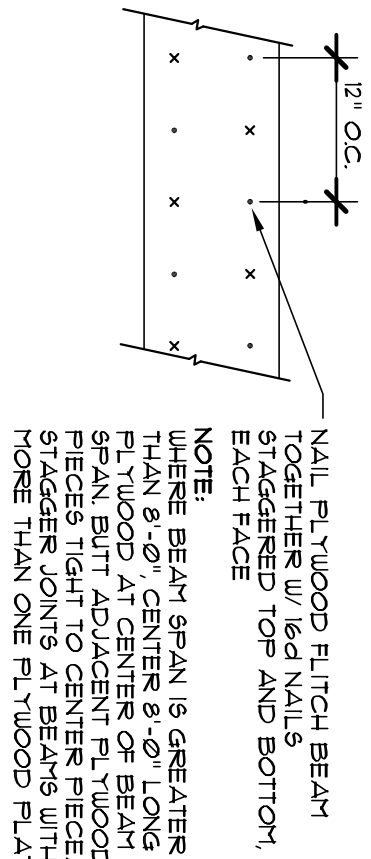


PLYWOOD FLITCH BEAM DETAIL
NOT TO SCALE


Beam Details
SCALE: NONE

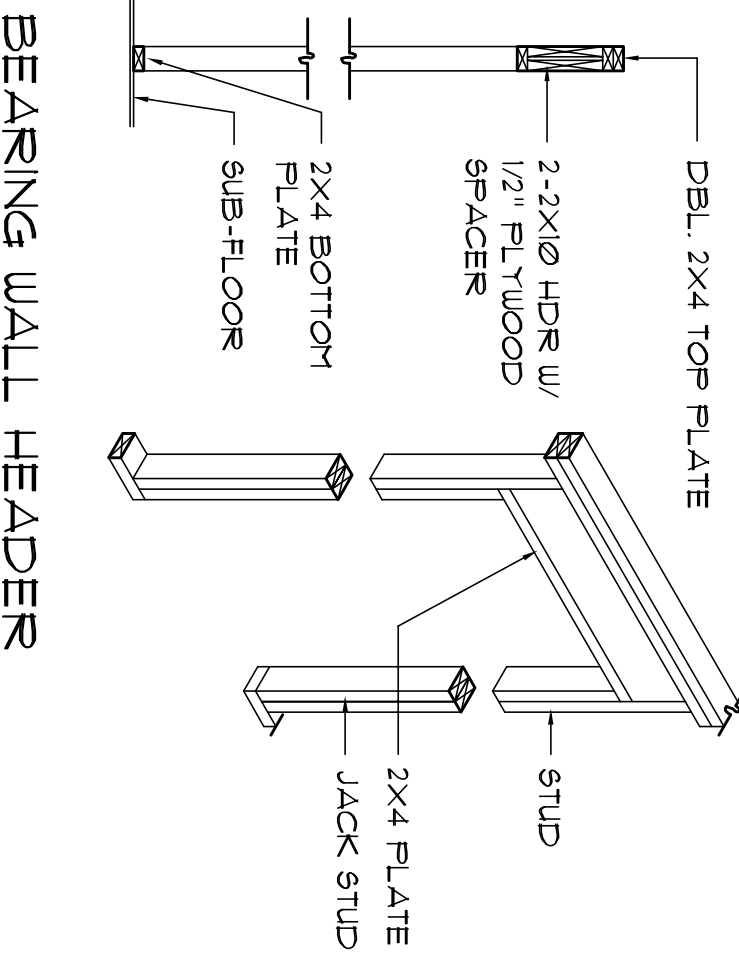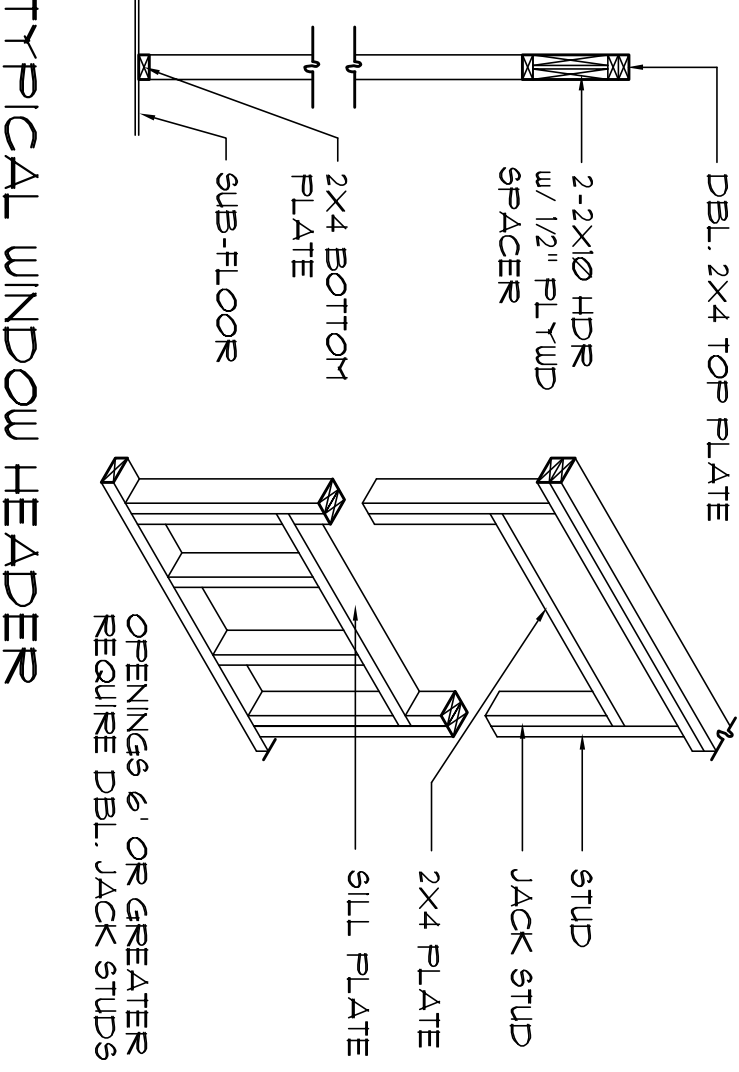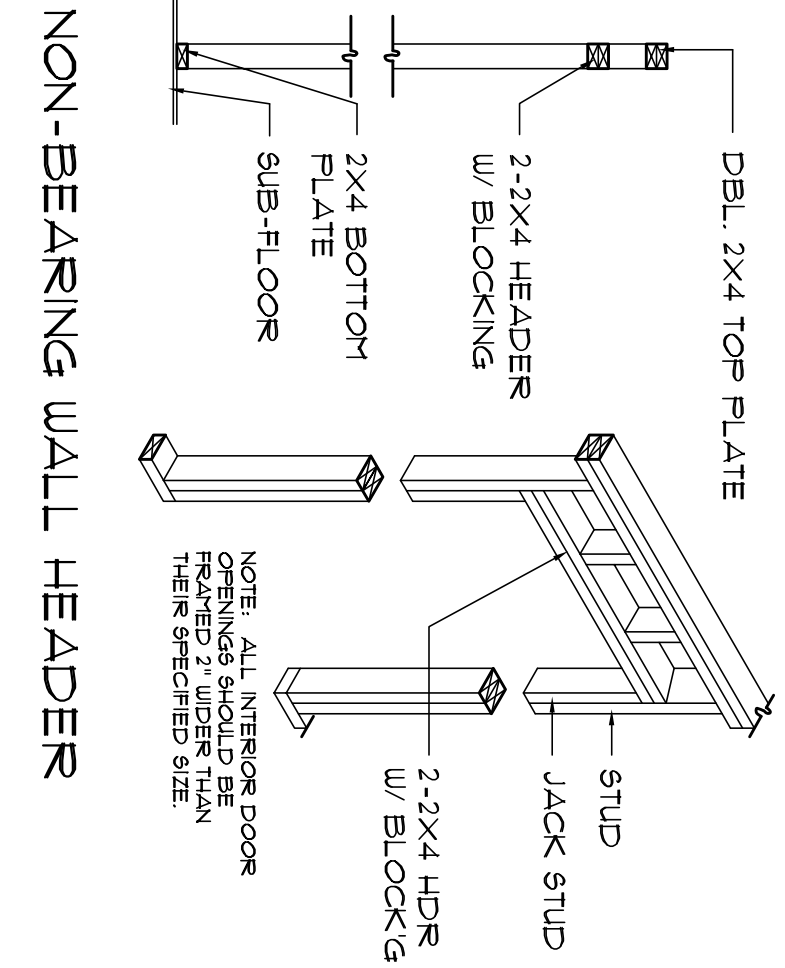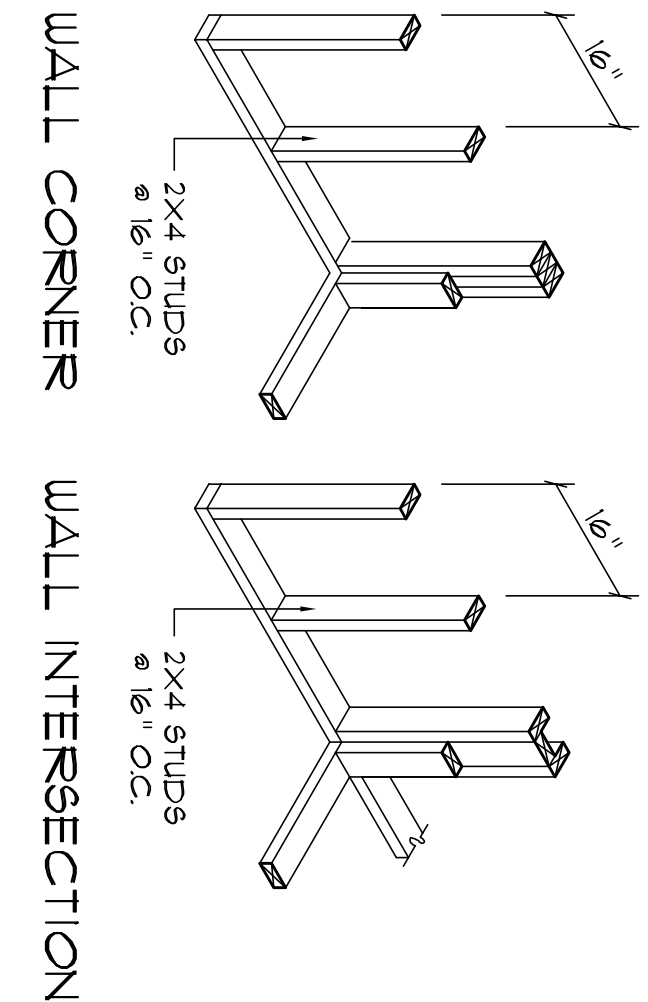


Wall Framing/Header Details
SCALE: NONE

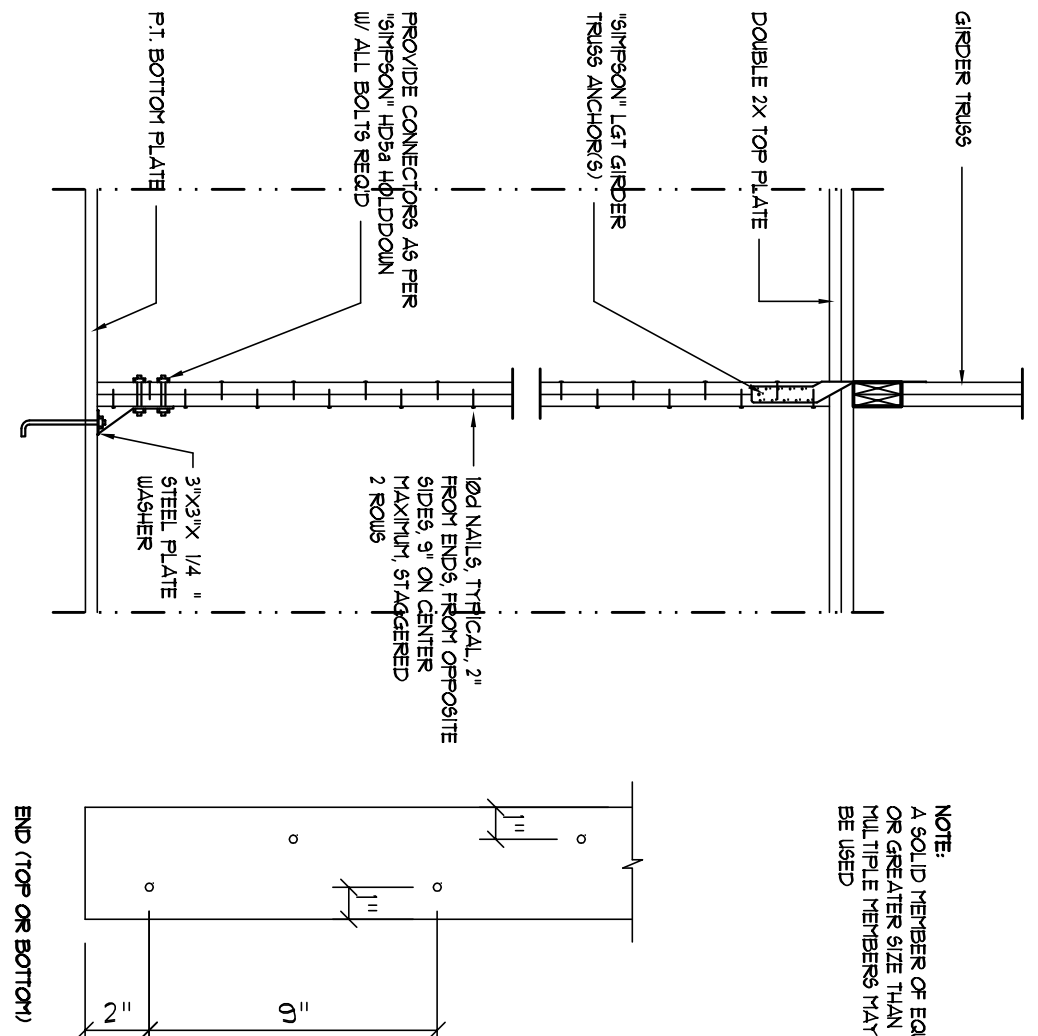

Girder Truss Column Det.
SCALE: 1/2" = 1'-0"

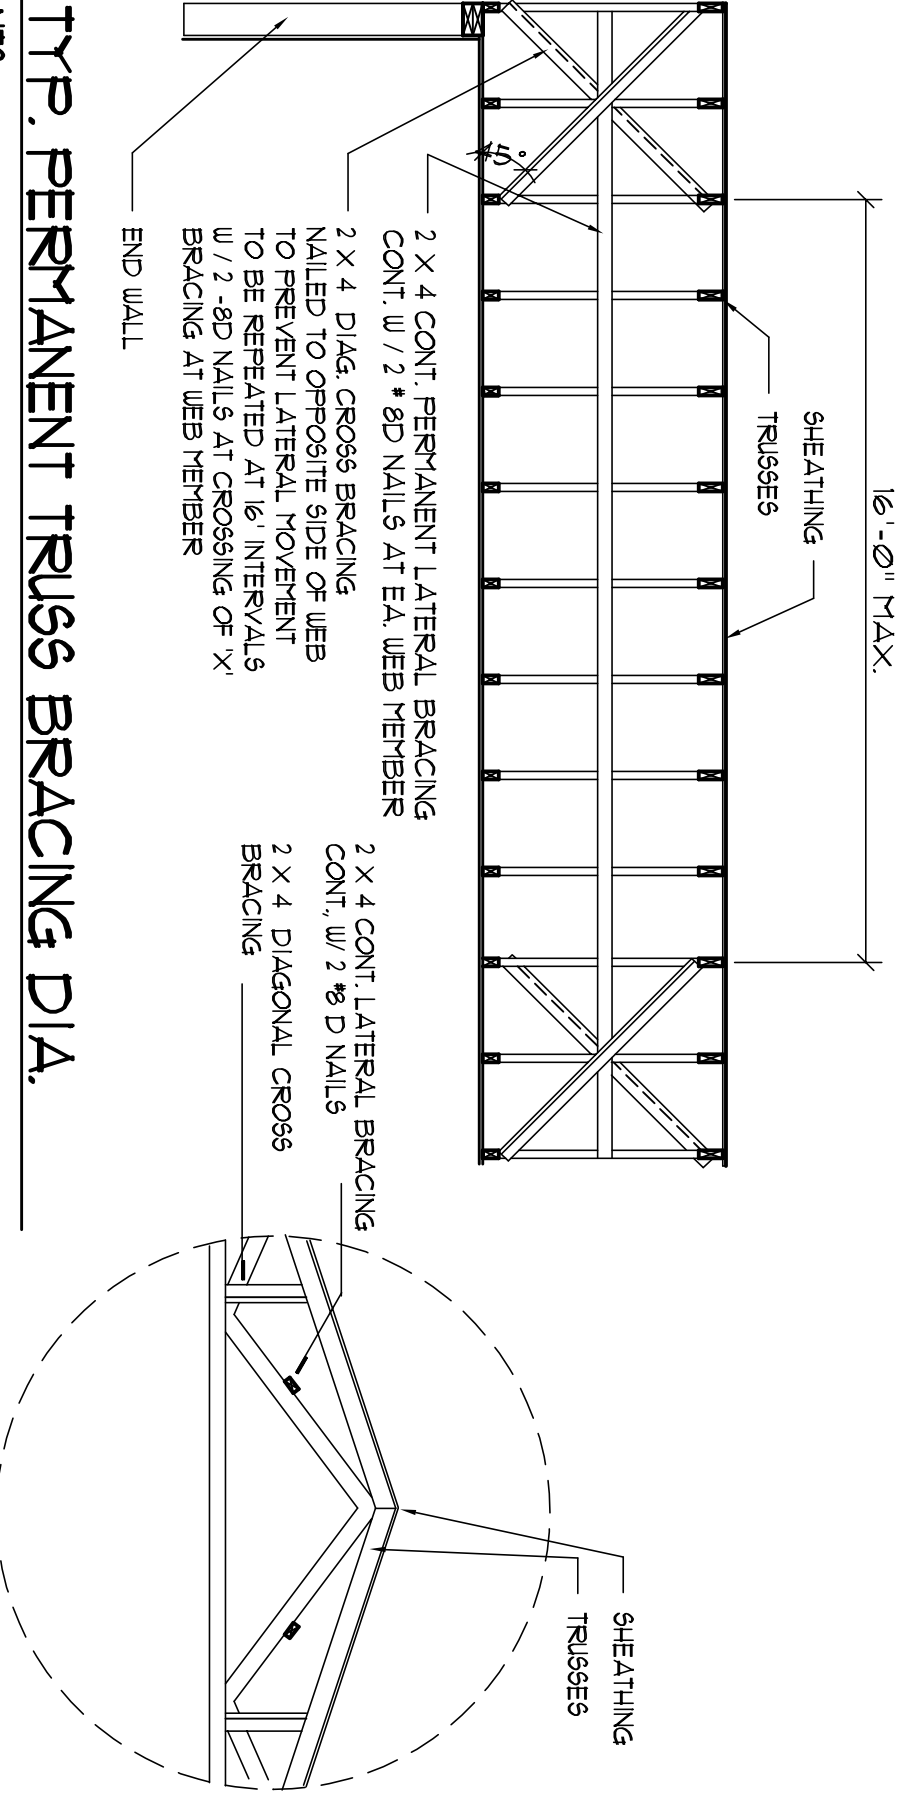

Typ. Permanent Truss Bracing Dia.
NOTE: ALL WOOD TO BE NUMBER 2 GRADE SOUTHERN YELLOW PINE
SCALE: AS NOTED

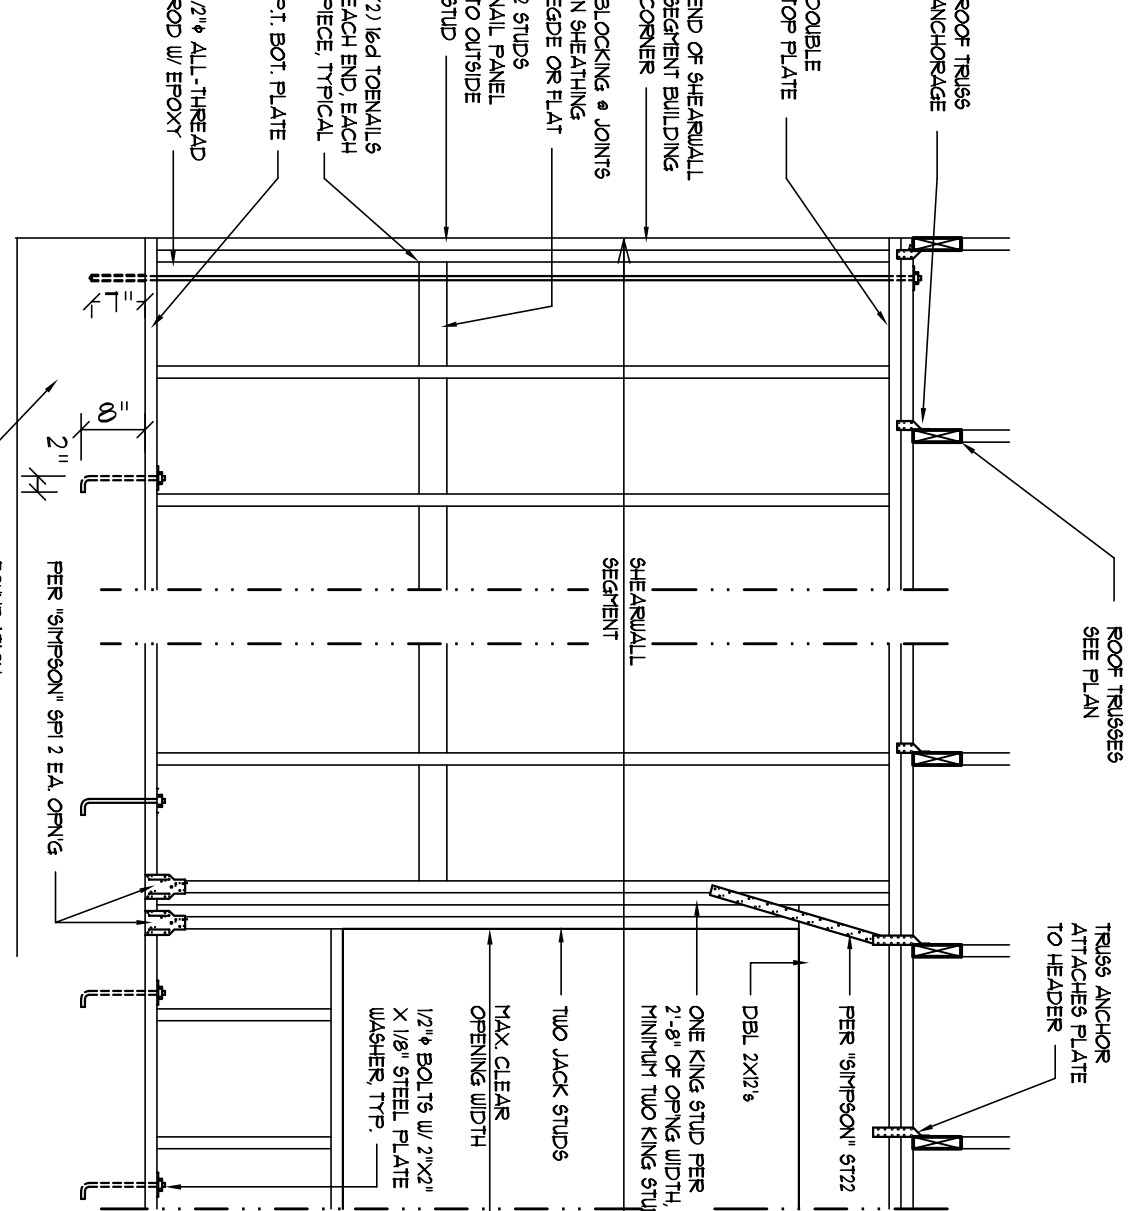

SHEATHING NOTES			
1.	ALL SHEATHING SHALL BE TYPE 1 SHEATHING AS DEFINED BY STD. 91 SBC 309.43.		
2.	THE WALL SHALL BE ENTIRELY SHEATHED WITH 1/2\"/>		
3.	ALL SHEATHING SHALL BE ATTACHED TO RAINING FANES OCCURRING OVER COMMON RAISING VEBERS OR ALONG BLOCKING.		
4.	WALL BRACING SHALL BE 4\"/>		
5.	TYPE 1 SHEATHING IS REQUIRED FOR THE OPENING IT CONTAINS. HAZARDY HEIGHT OF OPENING SHALL BE 5'6\"/>		
6.	FOR 6\"/>		

OPENING WIDTH	ALL PLAYS	16d TOP NAILS EACH END
6\"/>	(1) 2x4 OR (1) 2x6	1
8\"/>	(1) 2x4 OR (1) 2x6	1
10\"/>	(1) 2x4 OR (1) 2x6	1
12\"/>	(1) 2x4 OR (1) 2x6	1
14\"/>	(1) 2x4 OR (1) 2x6	1
16\"/>	(1) 2x4 OR (1) 2x6	1
18\"/>	(1) 2x4 OR (1) 2x6	1
20\"/>	(1) 2x4 OR (1) 2x6	1
22\"/>	(1) 2x4 OR (1) 2x6	1
24\"/>	(1) 2x4 OR (1) 2x6	1
26\"/>	(1) 2x4 OR (1) 2x6	1
28\"/>	(1) 2x4 OR (1) 2x6	1
30\"/>	(1) 2x4 OR (1) 2x6	1
32\"/>	(1) 2x4 OR (1) 2x6	1
34\"/>	(1) 2x4 OR (1) 2x6	1
36\"/>	(1) 2x4 OR (1) 2x6	1
38\"/>	(1) 2x4 OR (1) 2x6	1
40\"/>	(1) 2x4 OR (1) 2x6	1
42\"/>	(1) 2x4 OR (1) 2x6	1
44\"/>	(1) 2x4 OR (1) 2x6	1
46\"/>	(1) 2x4 OR (1) 2x6	1
48\"/>	(1) 2x4 OR (1) 2x6	1
50\"/>	(1) 2x4 OR (1) 2x6	1
52\"/>	(1) 2x4 OR (1) 2x6	1
54\"/>	(1) 2x4 OR (1) 2x6	1
56\"/>	(1) 2x4 OR (1) 2x6	1
58\"/>	(1) 2x4 OR (1) 2x6	1
60\"/>	(1) 2x4 OR (1) 2x6	1
62\"/>	(1) 2x4 OR (1) 2x6	1
64\"/>	(1) 2x4 OR (1) 2x6	1
66\"/>	(1) 2x4 OR (1) 2x6	1
68\"/>	(1) 2x4 OR (1) 2x6	1
70\"/>	(1) 2x4 OR (1) 2x6	1
72\"/>	(1) 2x4 OR (1) 2x6	1
74\"/>	(1) 2x4 OR (1) 2x6	1
76\"/>	(1) 2x4 OR (1) 2x6	1
78\"/>	(1) 2x4 OR (1) 2x6	1
80\"/>	(1) 2x4 OR (1) 2x6	1
82\"/>	(1) 2x4 OR (1) 2x6	1
84\"/>	(1) 2x4 OR (1) 2x6	1
86\"/>	(1) 2x4 OR (1) 2x6	1
88\"/>	(1) 2x4 OR (1) 2x6	1
90\"/>	(1) 2x4 OR (1) 2x6	1
92\"/>	(1) 2x4 OR (1) 2x6	1
94\"/>	(1) 2x4 OR (1) 2x6	1
96\"/>	(1) 2x4 OR (1) 2x6	1
98\"/>	(1) 2x4 OR (1) 2x6	1
100\"/>	(1) 2x4 OR (1) 2x6	1

SHEATHING NOTES			
1.	ALL SHEATHING SHALL BE TYPE 1 SHEATHING AS DEFINED BY STD. 91 SBC 309.43.		
2.	THE WALL SHALL BE ENTIRELY SHEATHED WITH 1/2\"/>		
3.	ALL SHEATHING SHALL BE ATTACHED TO RAINING FANES OCCURRING OVER COMMON RAISING VEBERS OR ALONG BLOCKING.		
4.	WALL BRACING SHALL BE 4\"/>		
5.	TYPE 1 SHEATHING IS REQUIRED FOR THE OPENING IT CONTAINS. HAZARDY HEIGHT OF OPENING SHALL BE 5'6\"/>		
6.	FOR 6\"/>		

OPENING WIDTH	ALL PLAYS	16d TOP NAILS EACH END
6\"/>	(1) 2x4 OR (1) 2x6	1
8\"/>	(1) 2x4 OR (1) 2x6	1
10\"/>	(1) 2x4 OR (1) 2x6	1
12\"/>	(1) 2x4 OR (1) 2x6	1
14\"/>	(1) 2x4 OR (1) 2x6	1
16\"/>	(1) 2x4 OR (1) 2x6	1
18\"/>	(1) 2x4 OR (1) 2x6	1
20\"/>	(1) 2x4 OR (1) 2x6	1
22\"/>	(1) 2x4 OR (1) 2x6	1
24\"/>	(1) 2x4 OR (1) 2x6	1
26\"/>	(1) 2x4 OR (1) 2x6	1
28\"/>	(1) 2x4 OR (1) 2x6	1
30\"/>	(1) 2x4 OR (1) 2x6	1
32\"/>	(1) 2x4 OR (1) 2x6	1
34\"/>	(1) 2x4 OR (1) 2x6	1
36\"/>	(1) 2x4 OR (1) 2x6	1
38\"/>	(1) 2x4 OR (1) 2x6	1
40\"/>	(1) 2x4 OR (1) 2x6	1
42\"/>	(1) 2x4 OR (1) 2x6	1
44\"/>	(1) 2x4 OR (1) 2x6	1
46\"/>	(1) 2x4 OR (1) 2x6	1
48\"/>	(1) 2x4 OR (1) 2x6	1
50\"/>	(1) 2x4 OR (1) 2x6	1
52\"/>	(1) 2x4 OR (1) 2x6	1
54\"/>	(1) 2x4 OR (1) 2x6	1
56\"/>	(1) 2x4 OR (1) 2x6	1
58\"/>	(1) 2x4 OR (1) 2x6	1
60\"/>	(1) 2x4 OR (1) 2x6	1
62\"/>	(1) 2x4 OR (1) 2x6	1
64\"/>	(1) 2x4 OR (1) 2x6	1
66\"/>	(1) 2x4 OR (1) 2x6	1
68\"/>	(1) 2x4 OR (1) 2x6	1
70\"/>	(1) 2x4 OR (1) 2x6	1
72\"/>	(1) 2x4 OR (1) 2x6	1
74\"/>	(1) 2x4 OR (1) 2x6	1
76\"/>	(1) 2x4 OR (1) 2x6	1
78\"/>	(1) 2x4 OR (1) 2x6	1
80\"/>	(1) 2x4 OR (1) 2x6	1
82\"/>	(1) 2x4 OR (1) 2x6	1
84\"/>	(1) 2x4 OR (1) 2x6	1
86\"/>	(1) 2x4 OR (1) 2x6	1
88\"/>	(1) 2x4 OR (1) 2x6	1
90\"/>	(1) 2x4 OR (1) 2x6	1
92\"/>	(1) 2x4 OR (1) 2x6	1
94\"/>	(1) 2x4 OR (1) 2x6	1
96\"/>	(1) 2x4 OR (1) 2x6	1
98\"/>	(1) 2x4 OR (1) 2x6	1
100\"/>	(1) 2x4 OR (1) 2x6	1

